

Design Architect:


Architect of Record:

Project Manager:

Consultants:

Seal & Signature:

Issue No.	Description	Date
1	ISSUED FOR SCHEMATIC DESIGN	02-16-04
2	BUDGET VERIFICATION	02-20-04
3	ISSUED FOR PRE-APPLICATION	04-22-04
4	IN PROGRESS	04-22-04
5	ISSUED FOR SCHEMATIC DESIGN	05-06-04
6	SD CONFORMANCE	05-19-04
7	DEVELOPMENT REVIEW SUBMISSION	07-19-04
8	DEVELOPMENT REVIEW SUBMISSION	09-15-04
9	IN PROGRESS	11-05-04
10	DESIGN DEVELOPMENT	12-17-04
11	DESIGN DEVELOPMENT CONFORMANCE	03-01-05

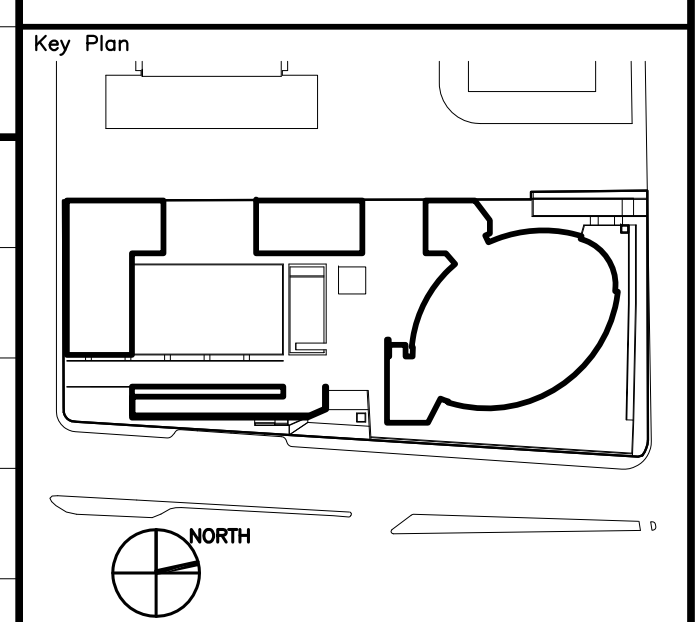


SITE PLAN

Project No.: 203234
 Sheet No.: A1.1
 Drawn By: DFM
 Checked By: DMO
 Scale: 1/8"=1'-0"

SITE PLAN 1
 Scale: 1/8"=1'-0"

DF

X1
 AF

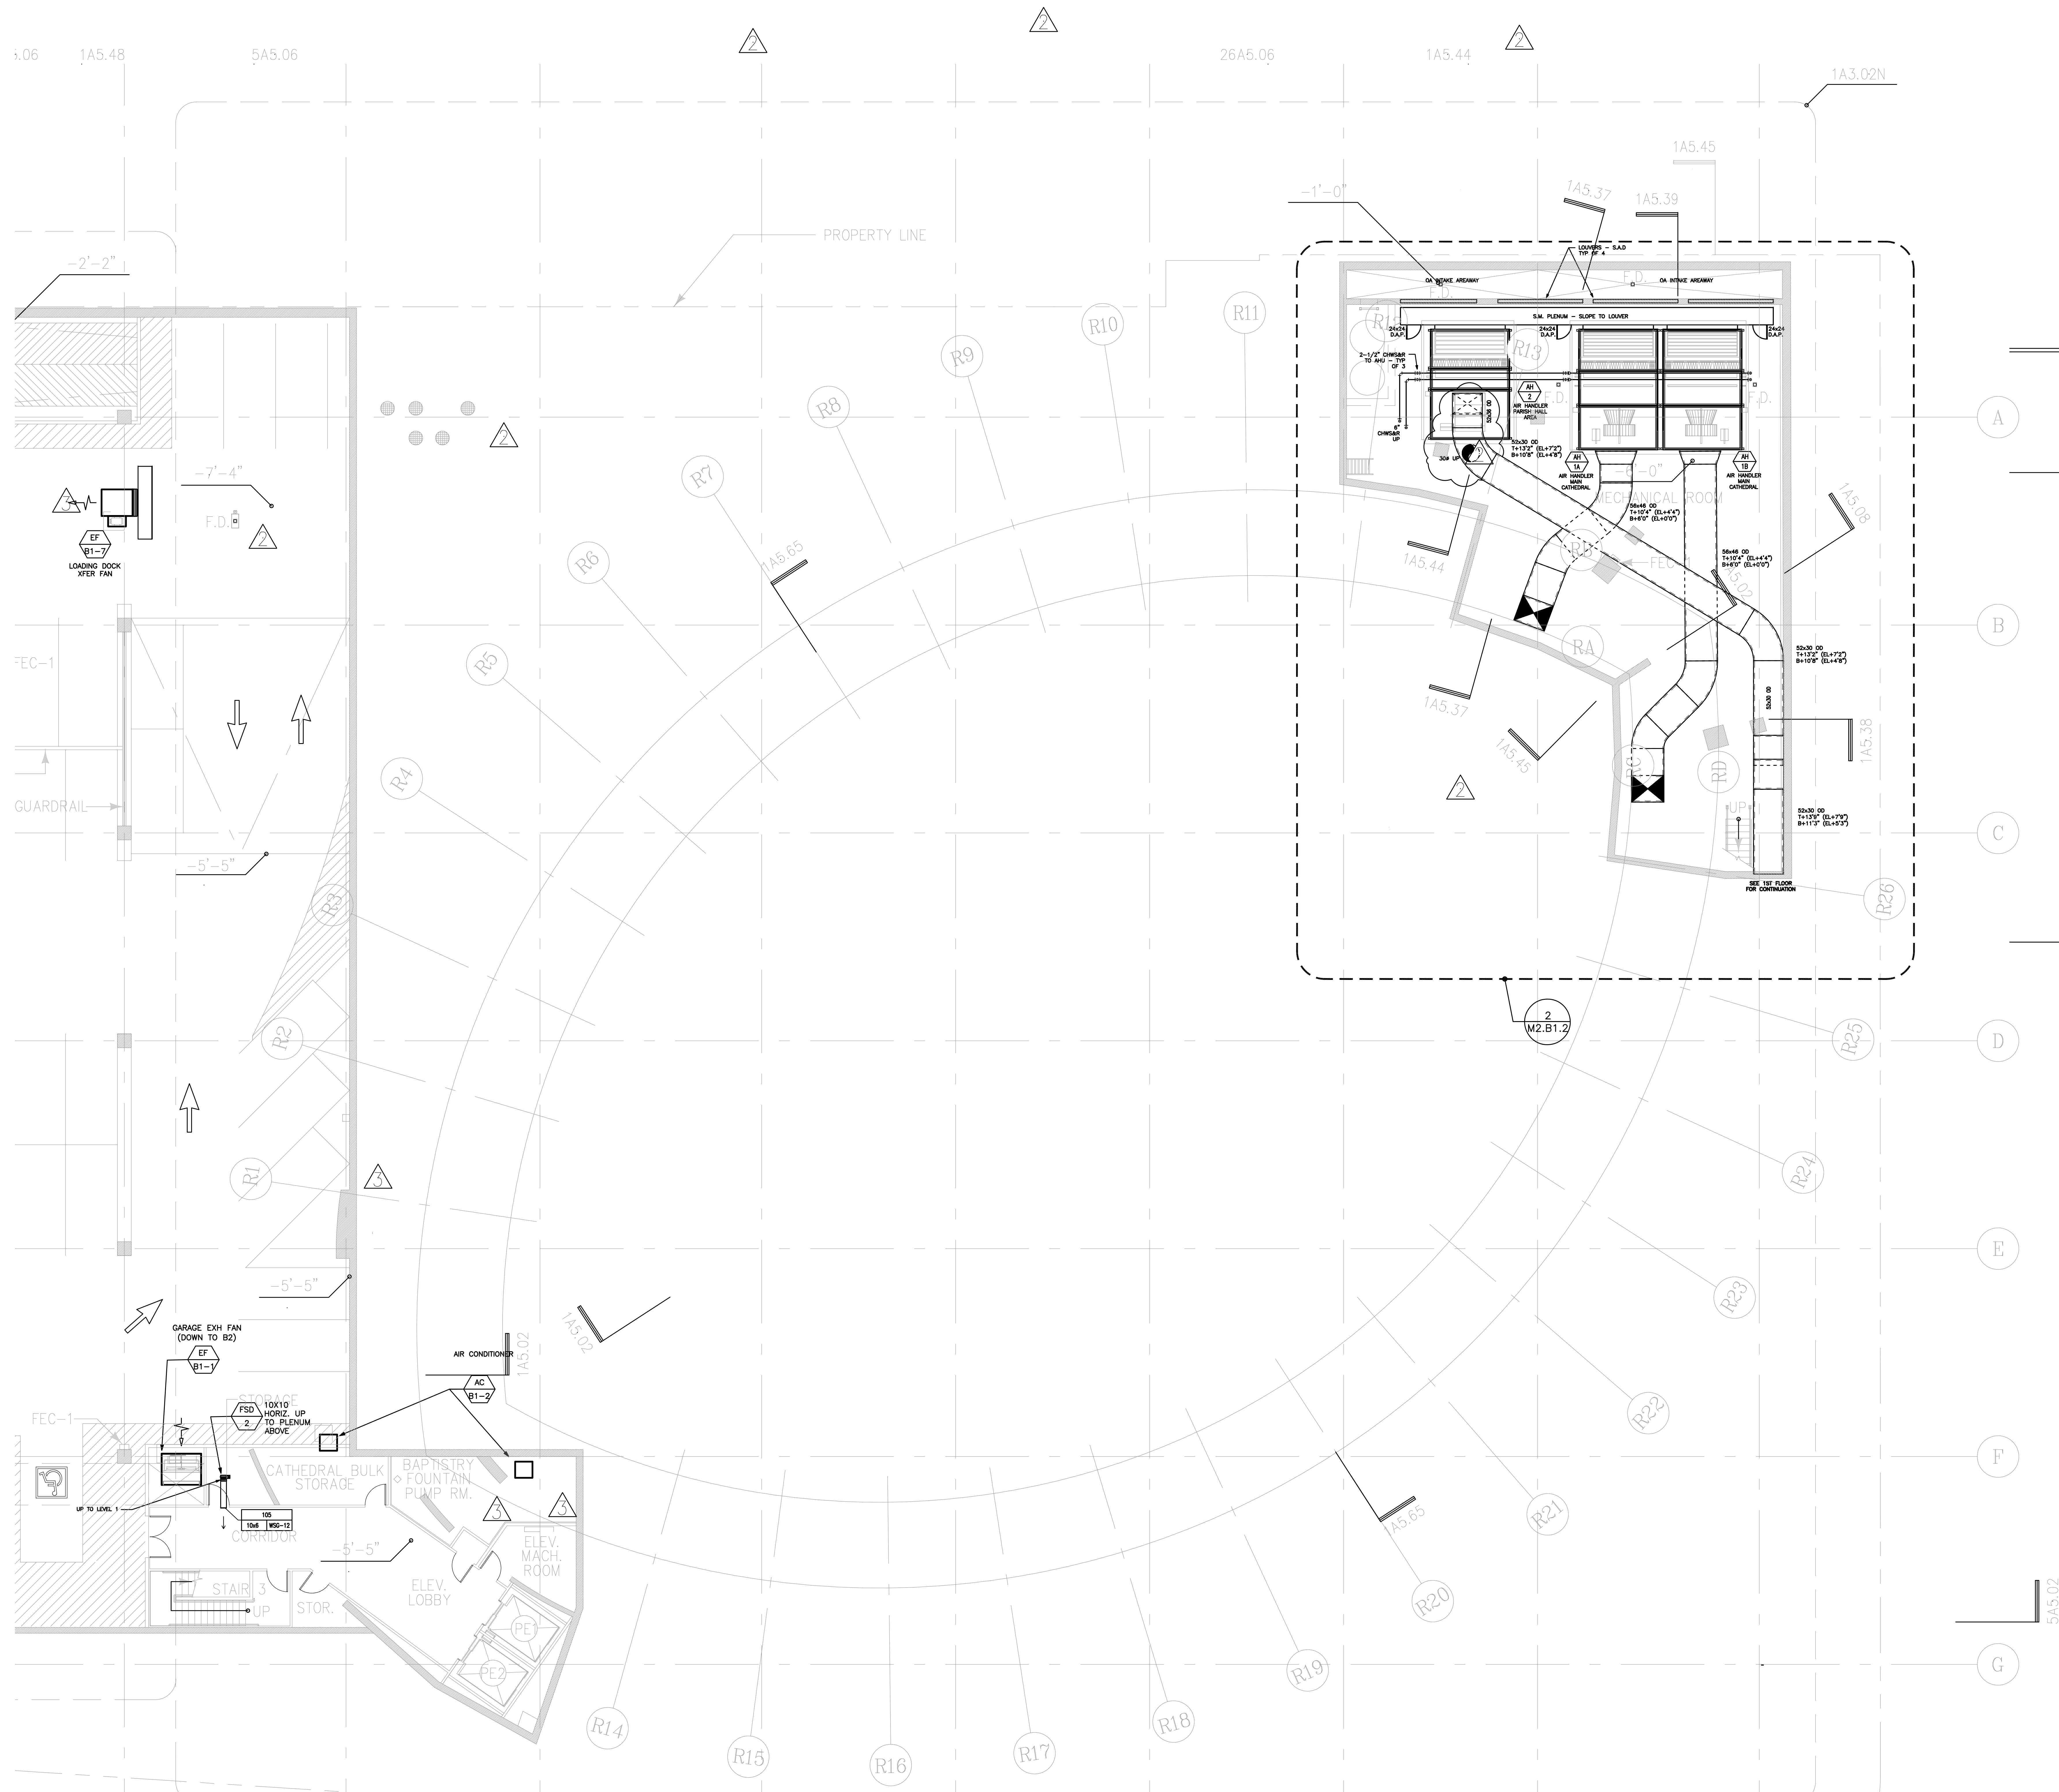


No.	Date	Issue
03-01-2005		ISSUED FOR BID PACKAGE NO.1
03-24-2005		BID PACKAGE NO.1-ADDENDUM NO. 2
05-06-2005		MAUSOLEUM DESIGN DEVELOPMENT

FILE NAME
-

Drawing Title
PARTIAL BASEMENT
HVAC FLOOR
LEVEL B1

Project Number
KHA 03044

Drawing No.
M2.B1.1

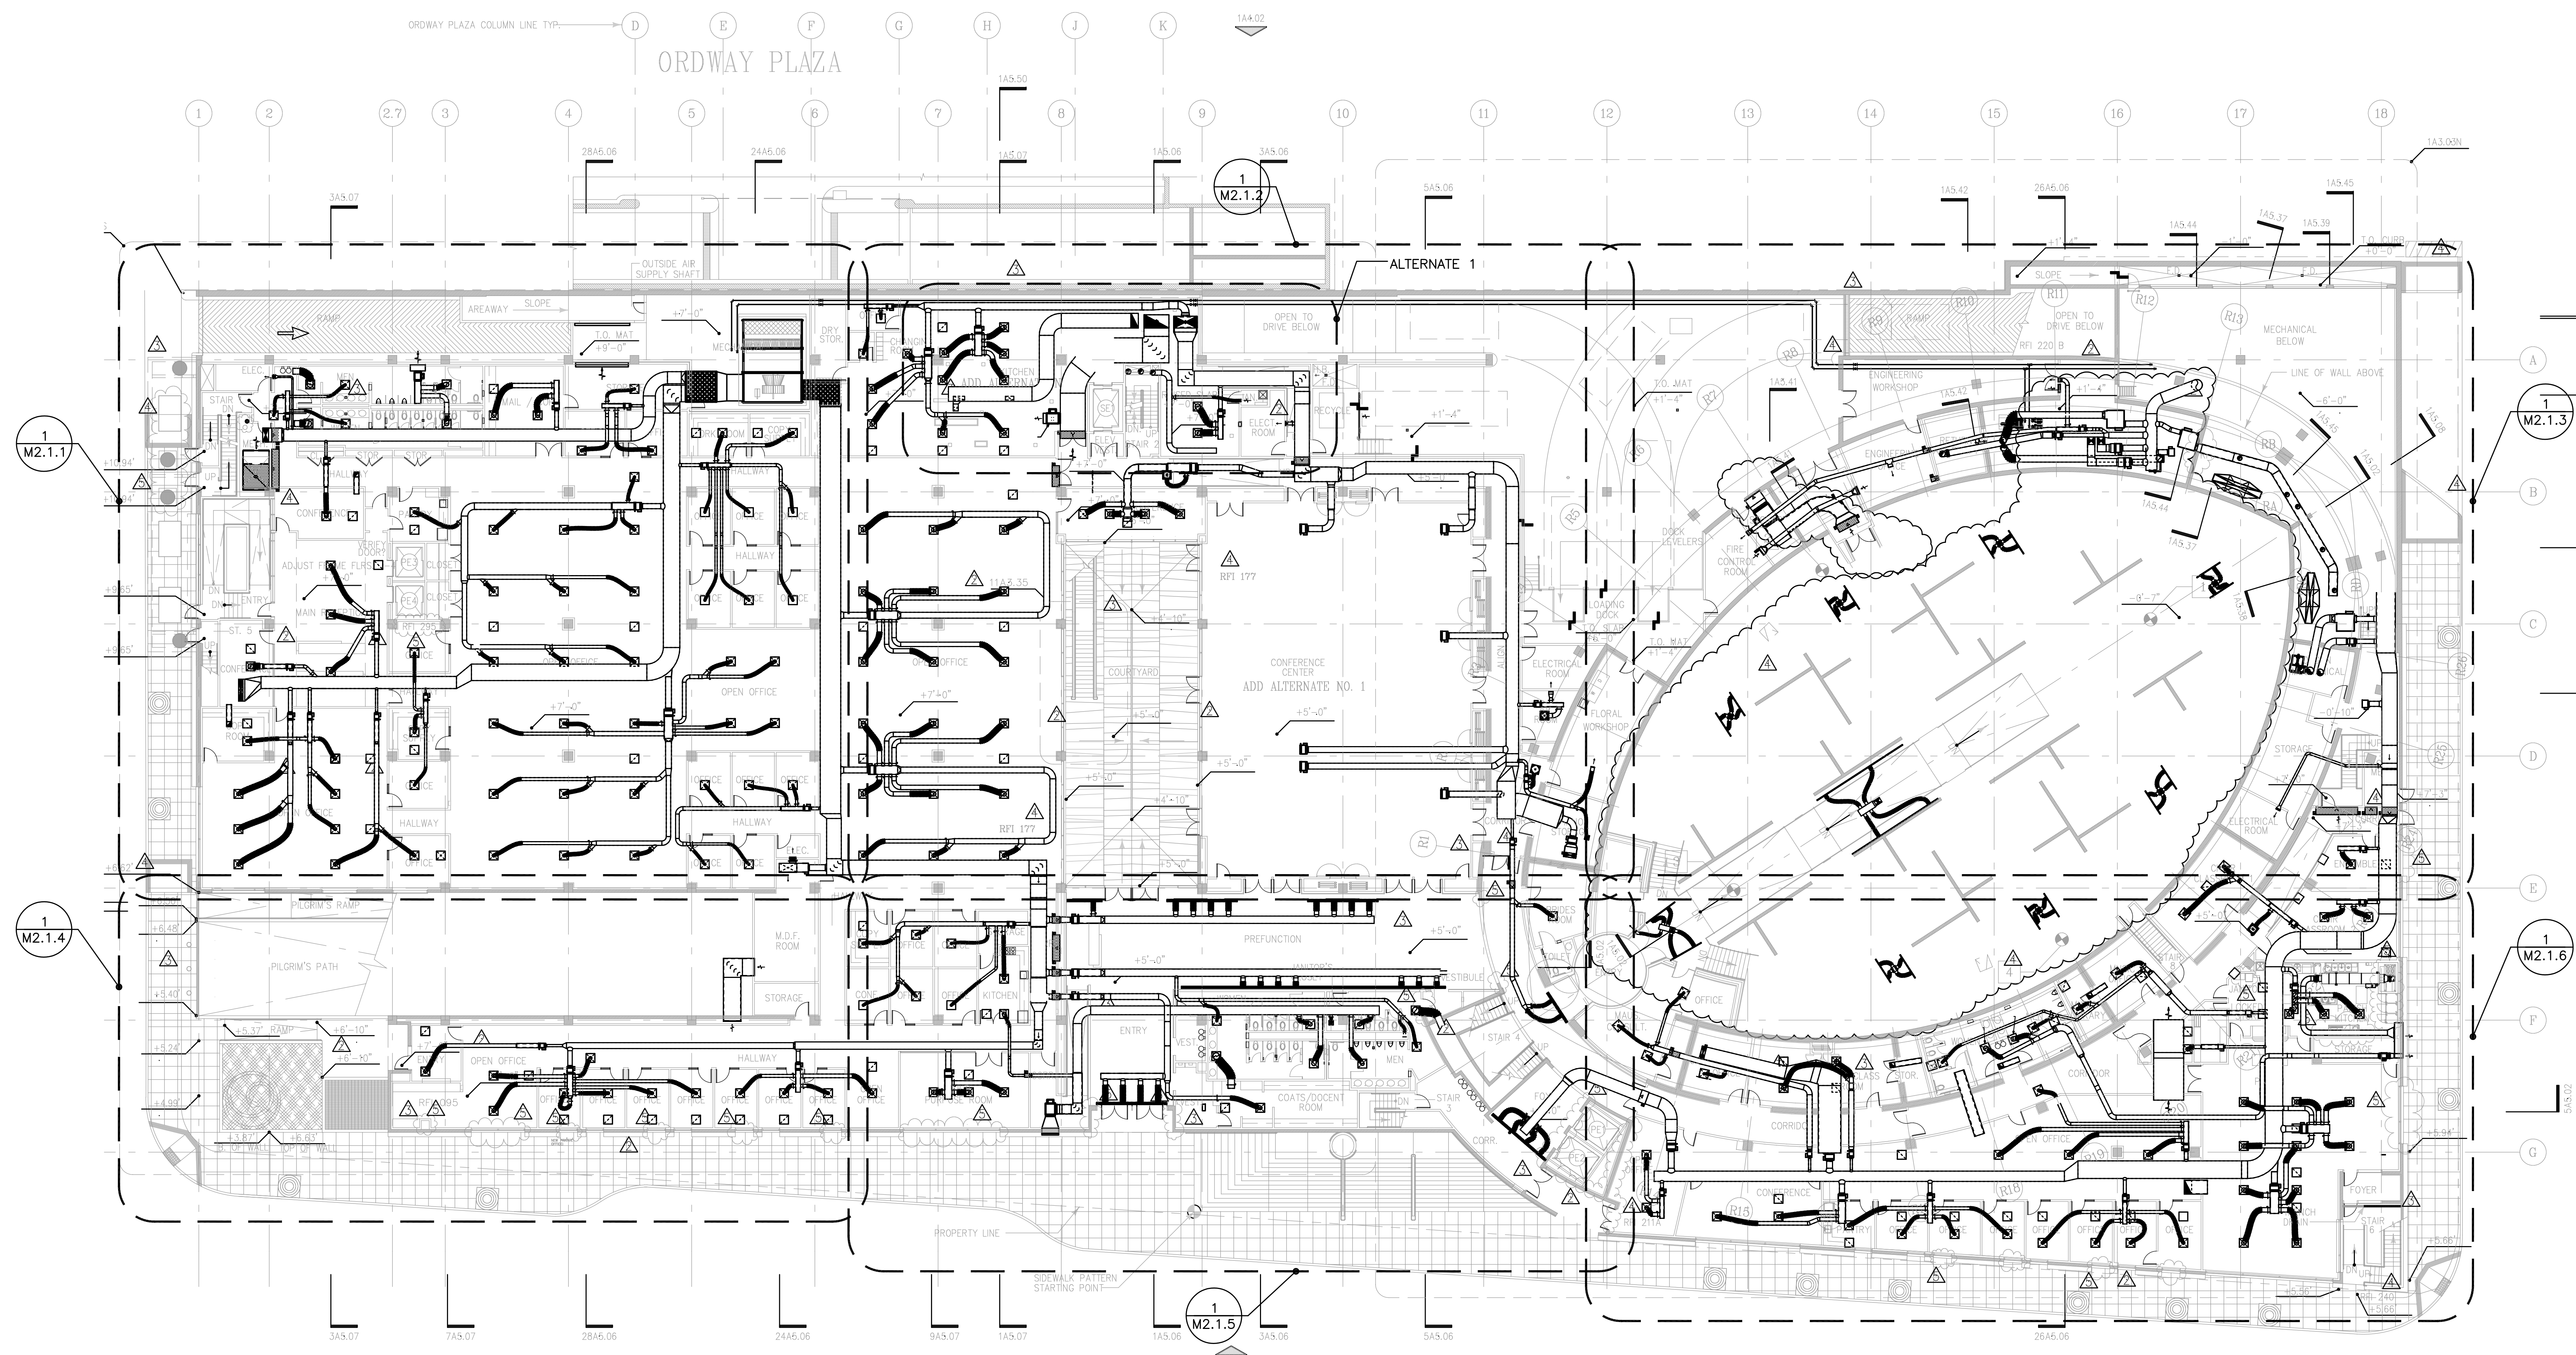

No.	Date	Issue
03-01-2005		ISSUED FOR BID PACKAGE NO.1
03-24-2005		BID PACKAGE NO.1-ADDENDUM NO. 2
05-06-2005		MAUSOLEUM DESIGN DEVELOPMENT

FILE NAME
-


Drawing Title
**1ST FLOOR
HVAC PLAN**

Project Number
KHA 03044

Drawing No.
M2.1

1/16"=1'-0"


1

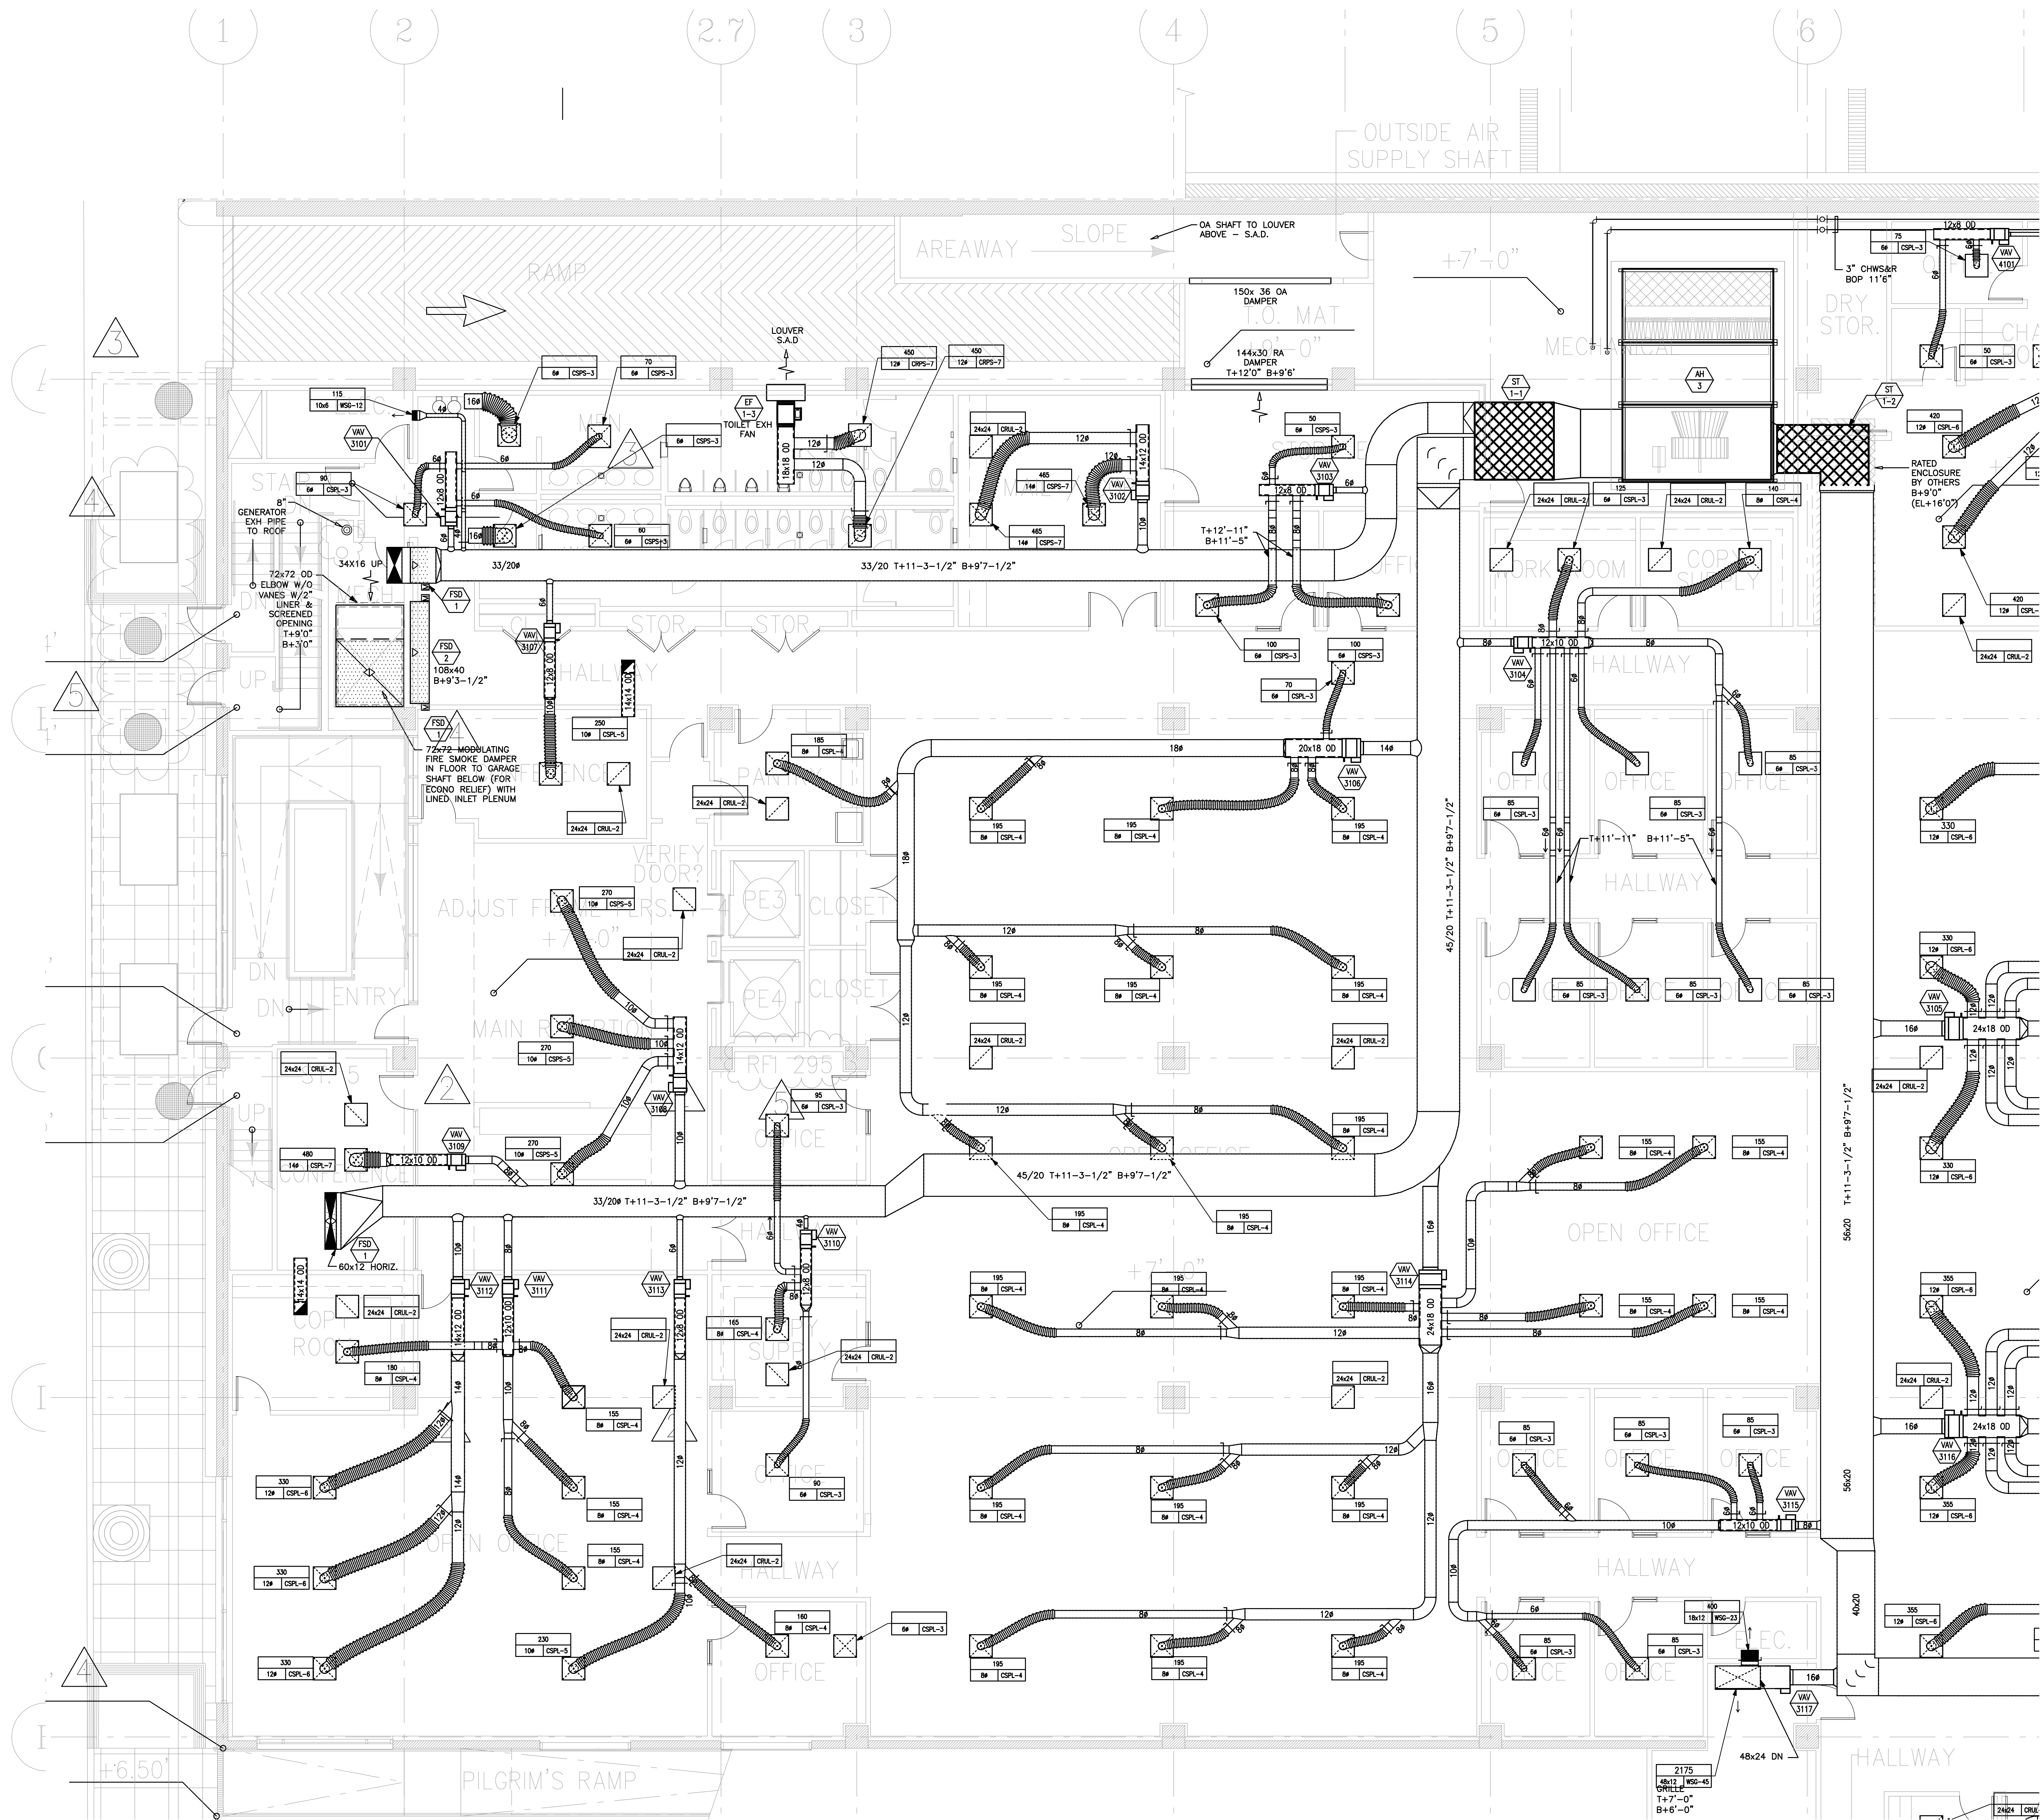

No.	Date	Issue
03-01-2005		ISSUED FOR BID PACKAGE NO.1
03-24-2005		BID PACKAGE NO.1-ADDENDUM NO. 2
05-06-2005		MAUSOLEUM DESIGN DEVELOPMENT


FILE NAME	
Drawing Title	PARTIAL 1ST FLOOR HVAC PLAN
Project Number	KHA 03044
Drawing No.	M2.1.1

3/16"=1'-0" 1

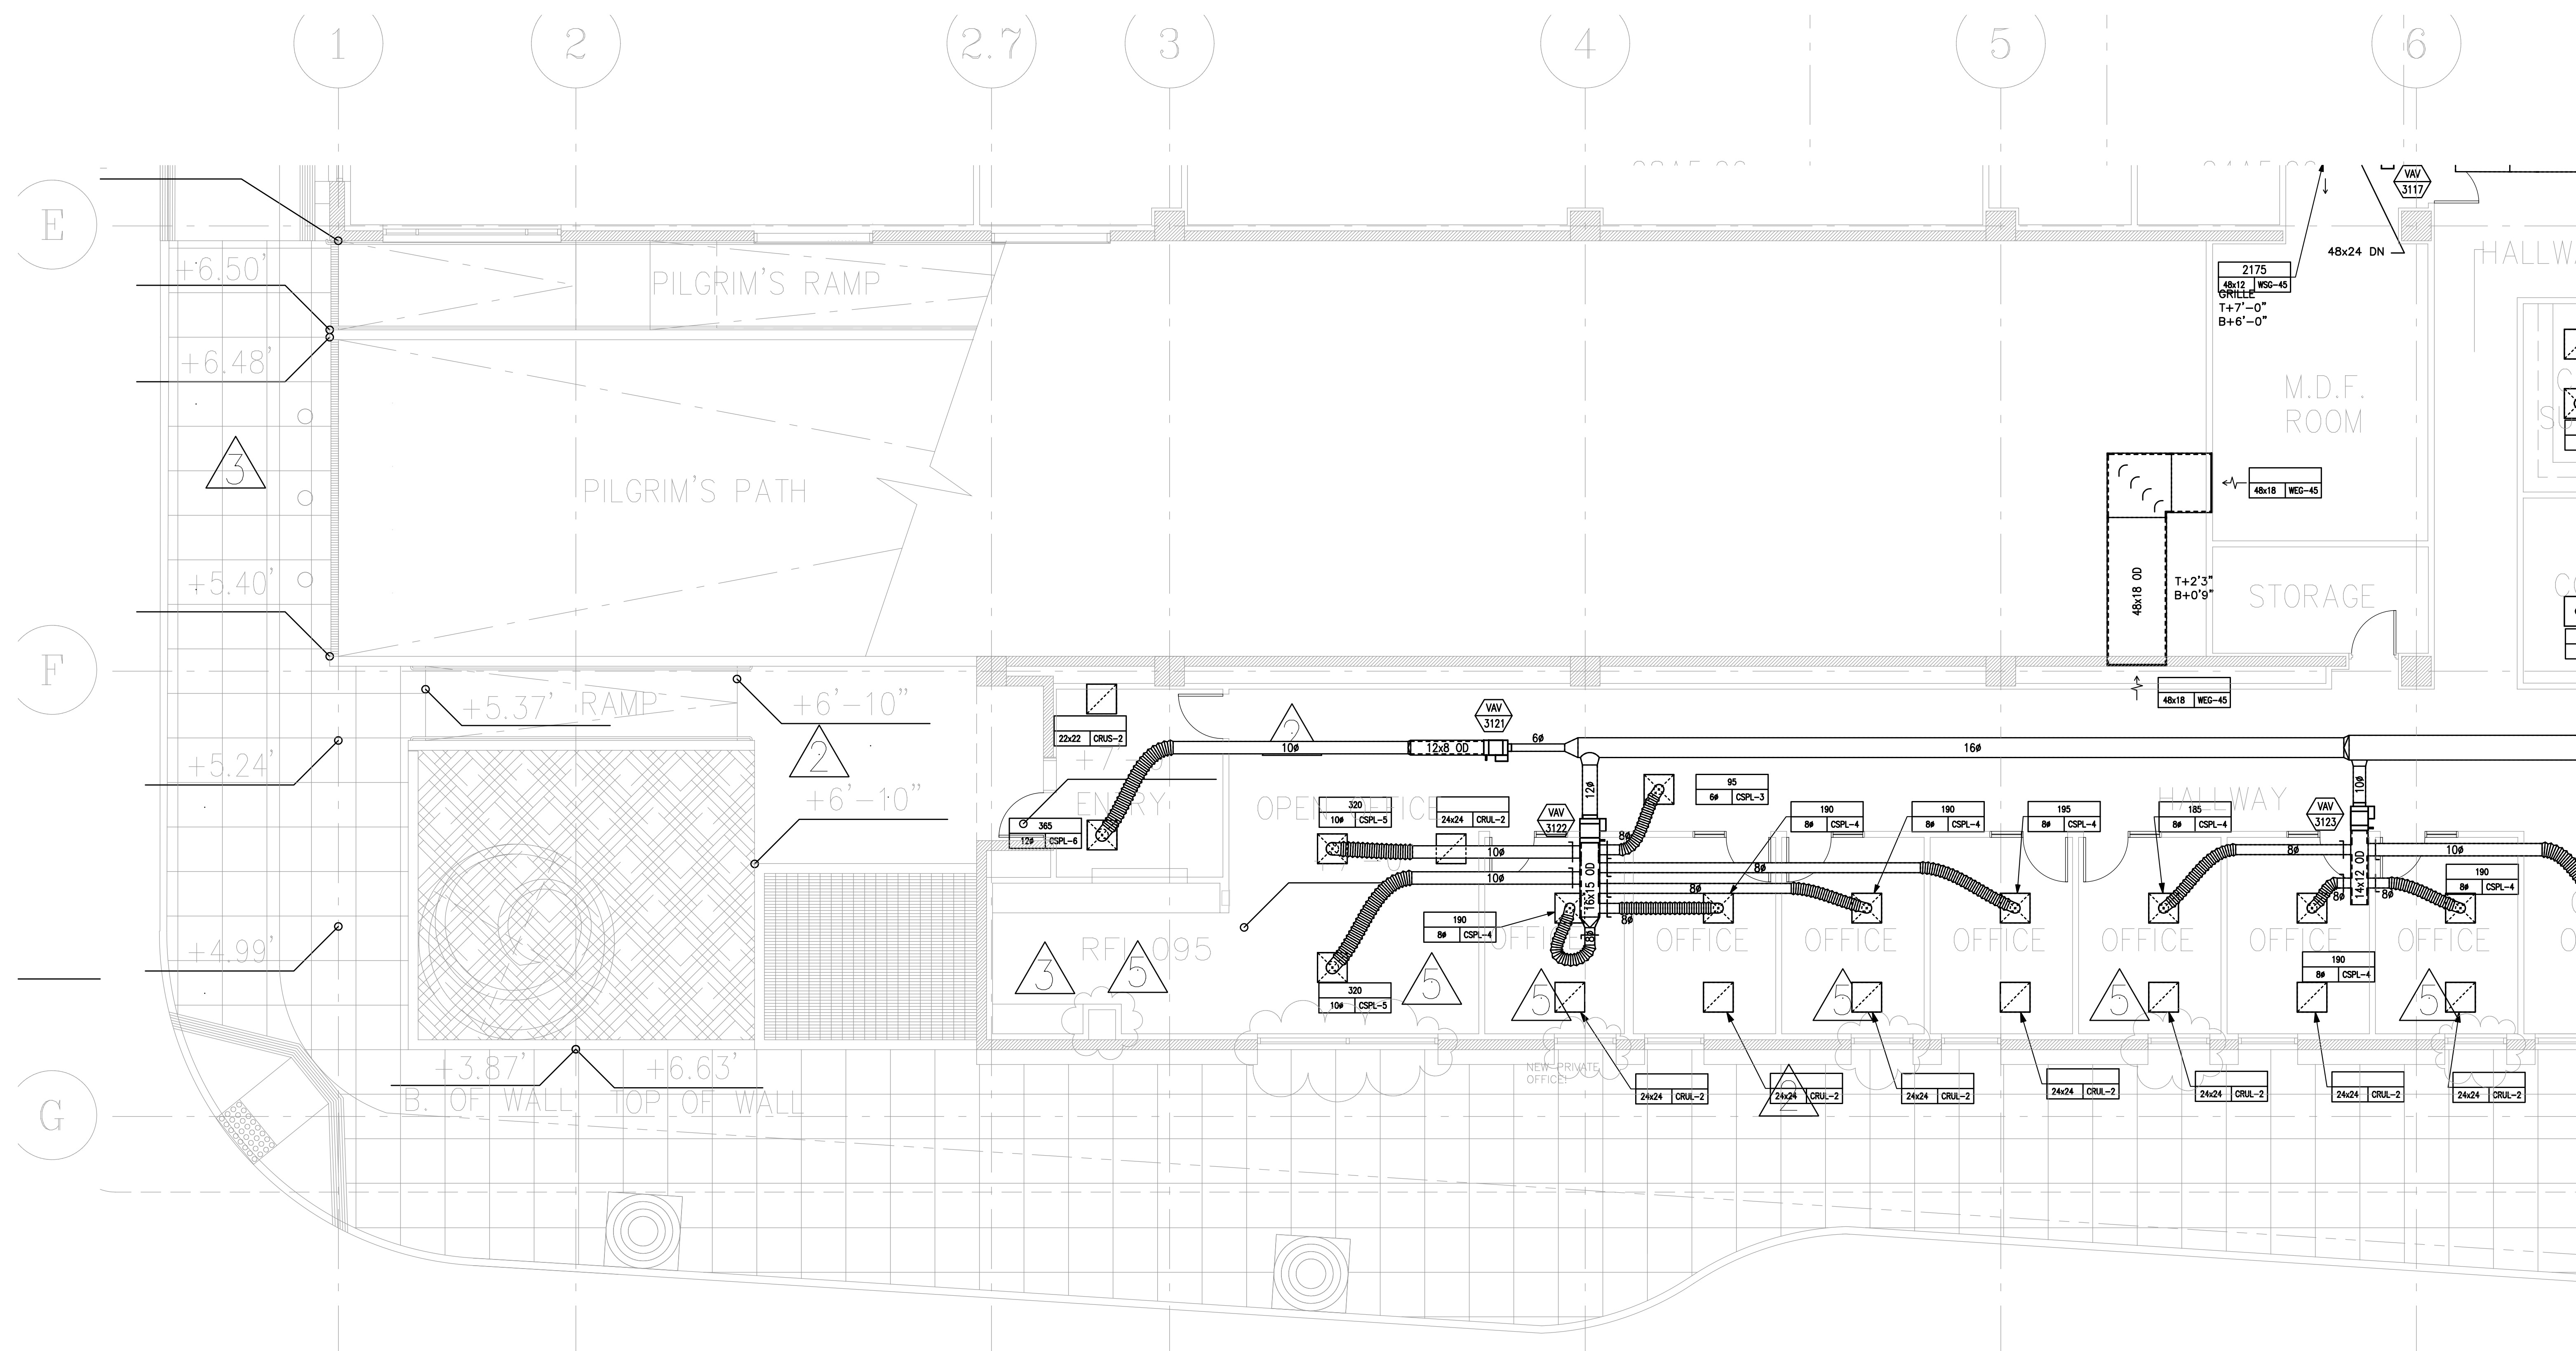


No.	Date	Issue
03-01-2005		ISSUED FOR BID PACKAGE NO.1
03-24-2005		BID PACKAGE NO.1-ADDENDUM NO. 2
05-06-2005		MAUSOLEUM DESIGN DEVELOPMENT
-	-	-
-	-	-
-	-	-
-	-	-
-	-	-
-	-	-
-	-	-

FILE NAME	
-	
Drawing Title	
PARTIAL 1ST FLOOR HVAC PLAN	
Project Number	Drawing No.
KHA 03014	M2.1.4

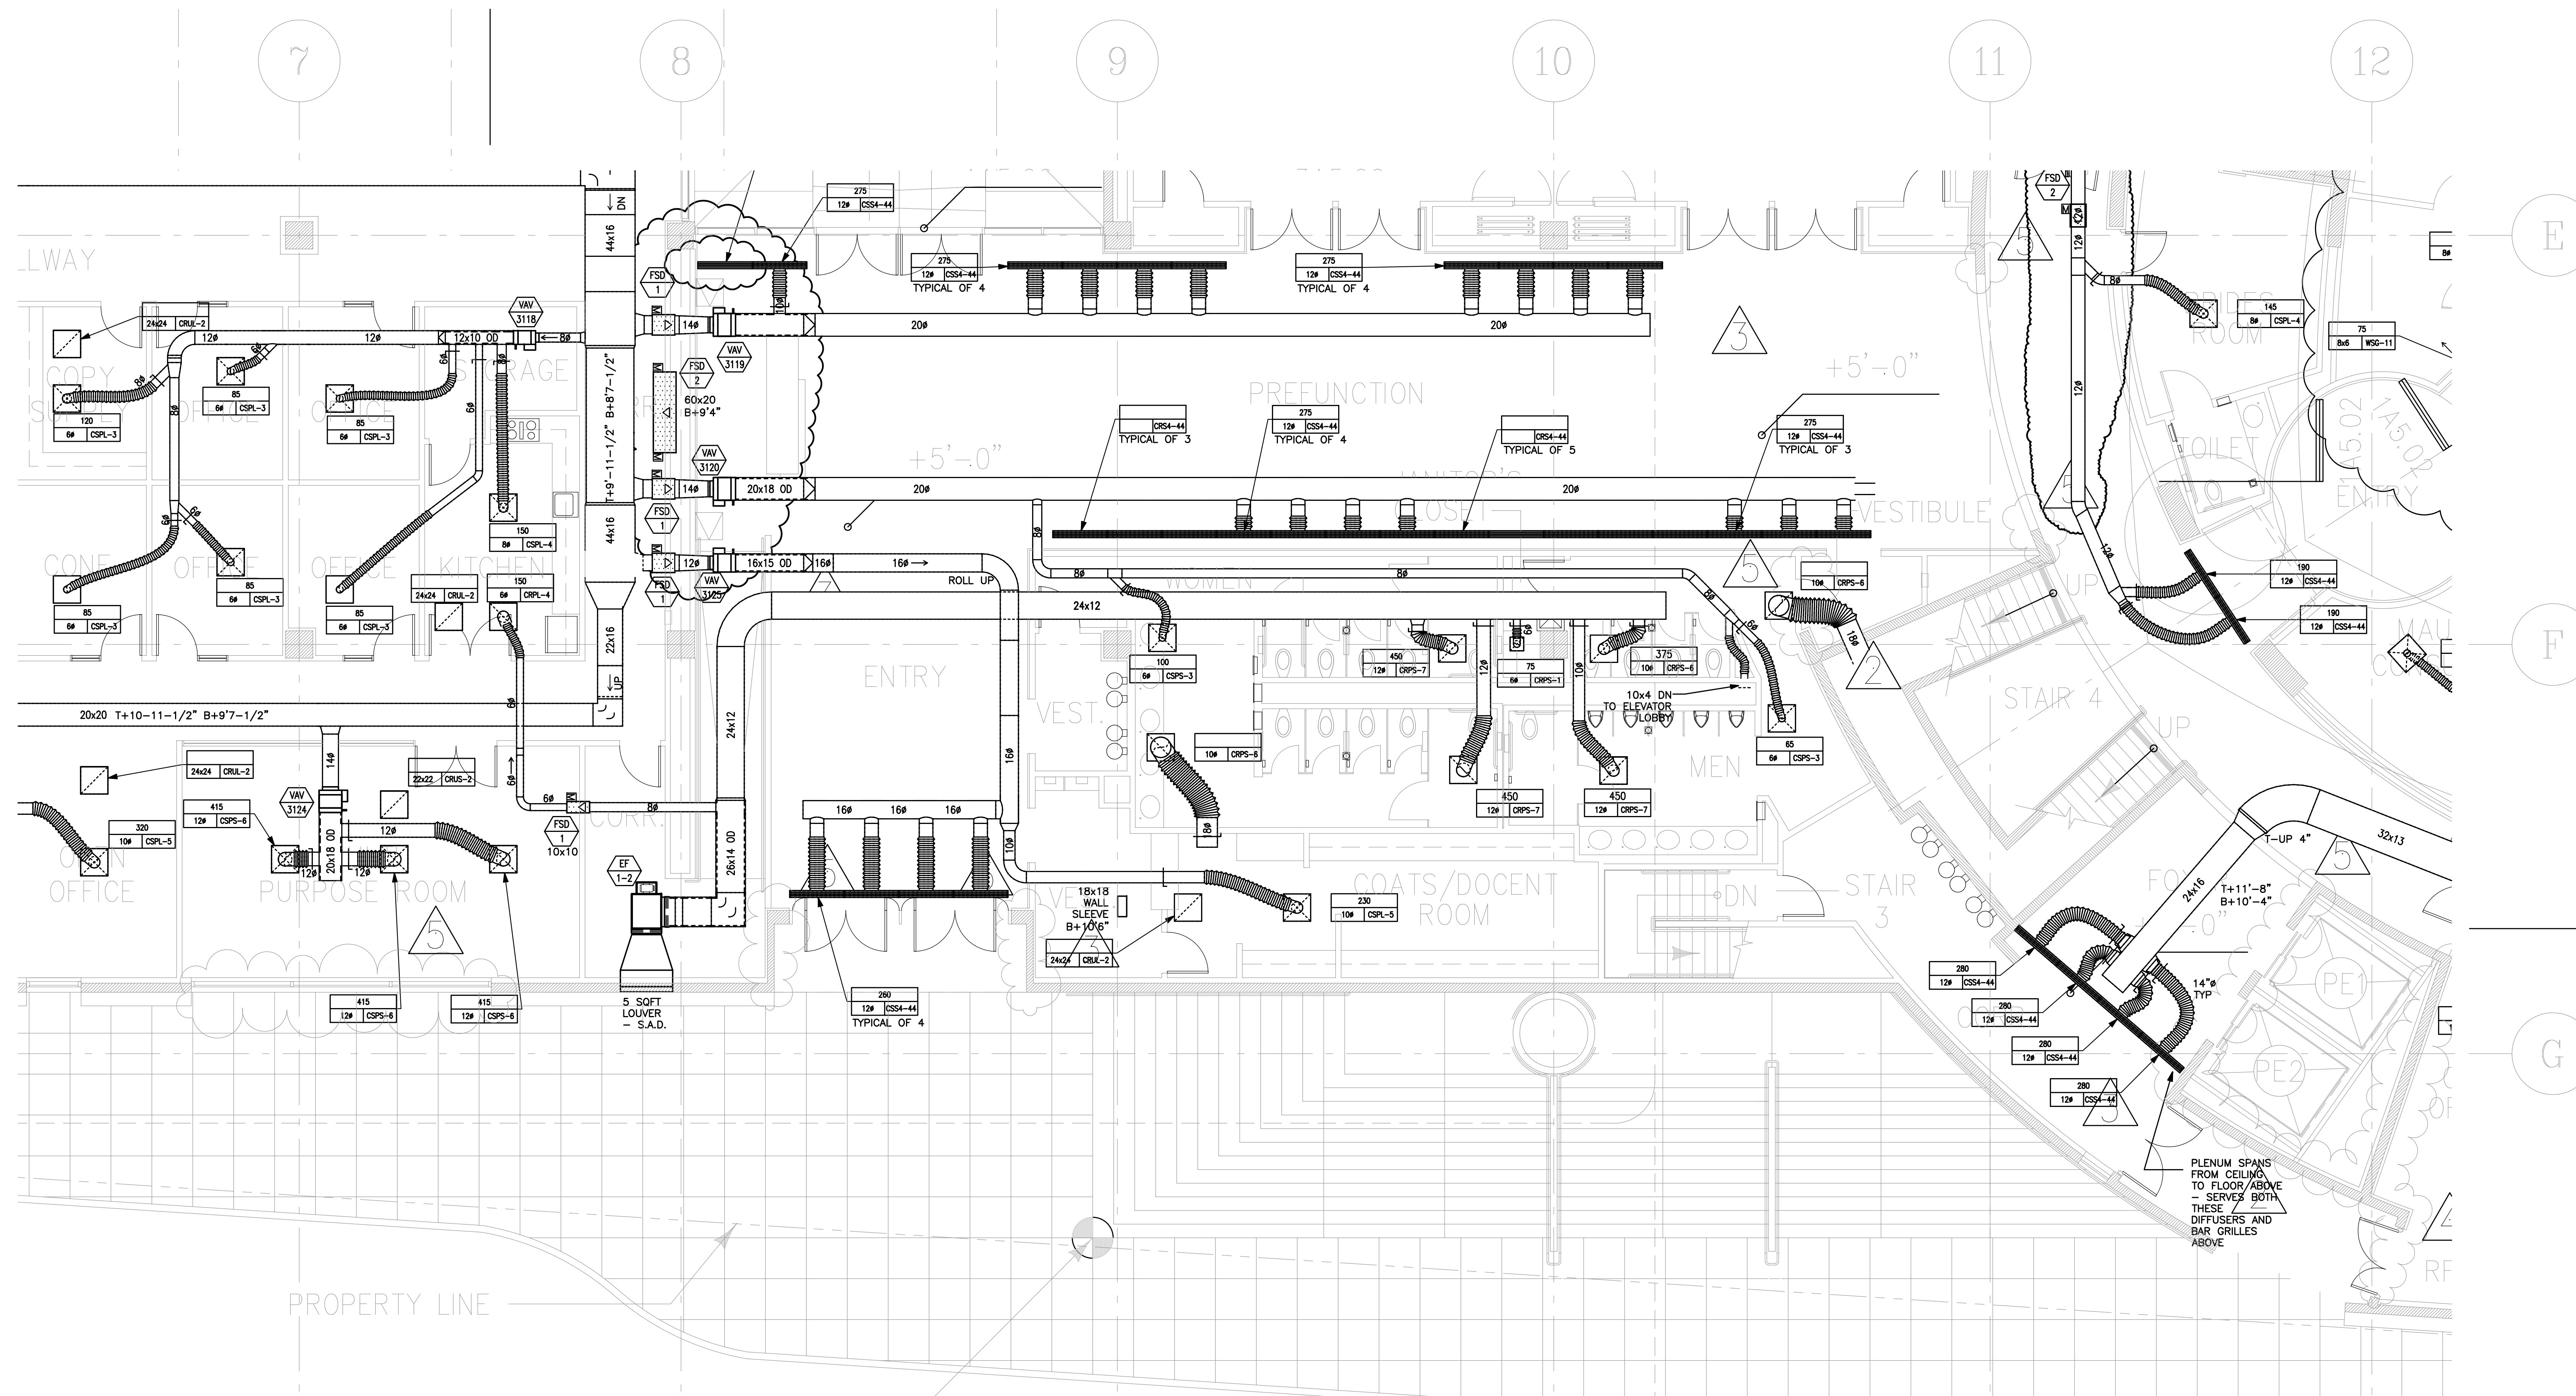

No.	Date	Issue
03-01-2005		ISSUED FOR BID PACKAGE NO.1
03-24-2005		BID PACKAGE NO.1-ADDENDUM NO. 2
05-06-2005		MAUSOLEUM DESIGN DEVELOPMENT

FILE NAME
 Drawing Title
**PARTIAL
 1ST FLOOR
 HVAC PLAN**
 Project Number
 KHA 03044
 Drawing No.
M2.1.5

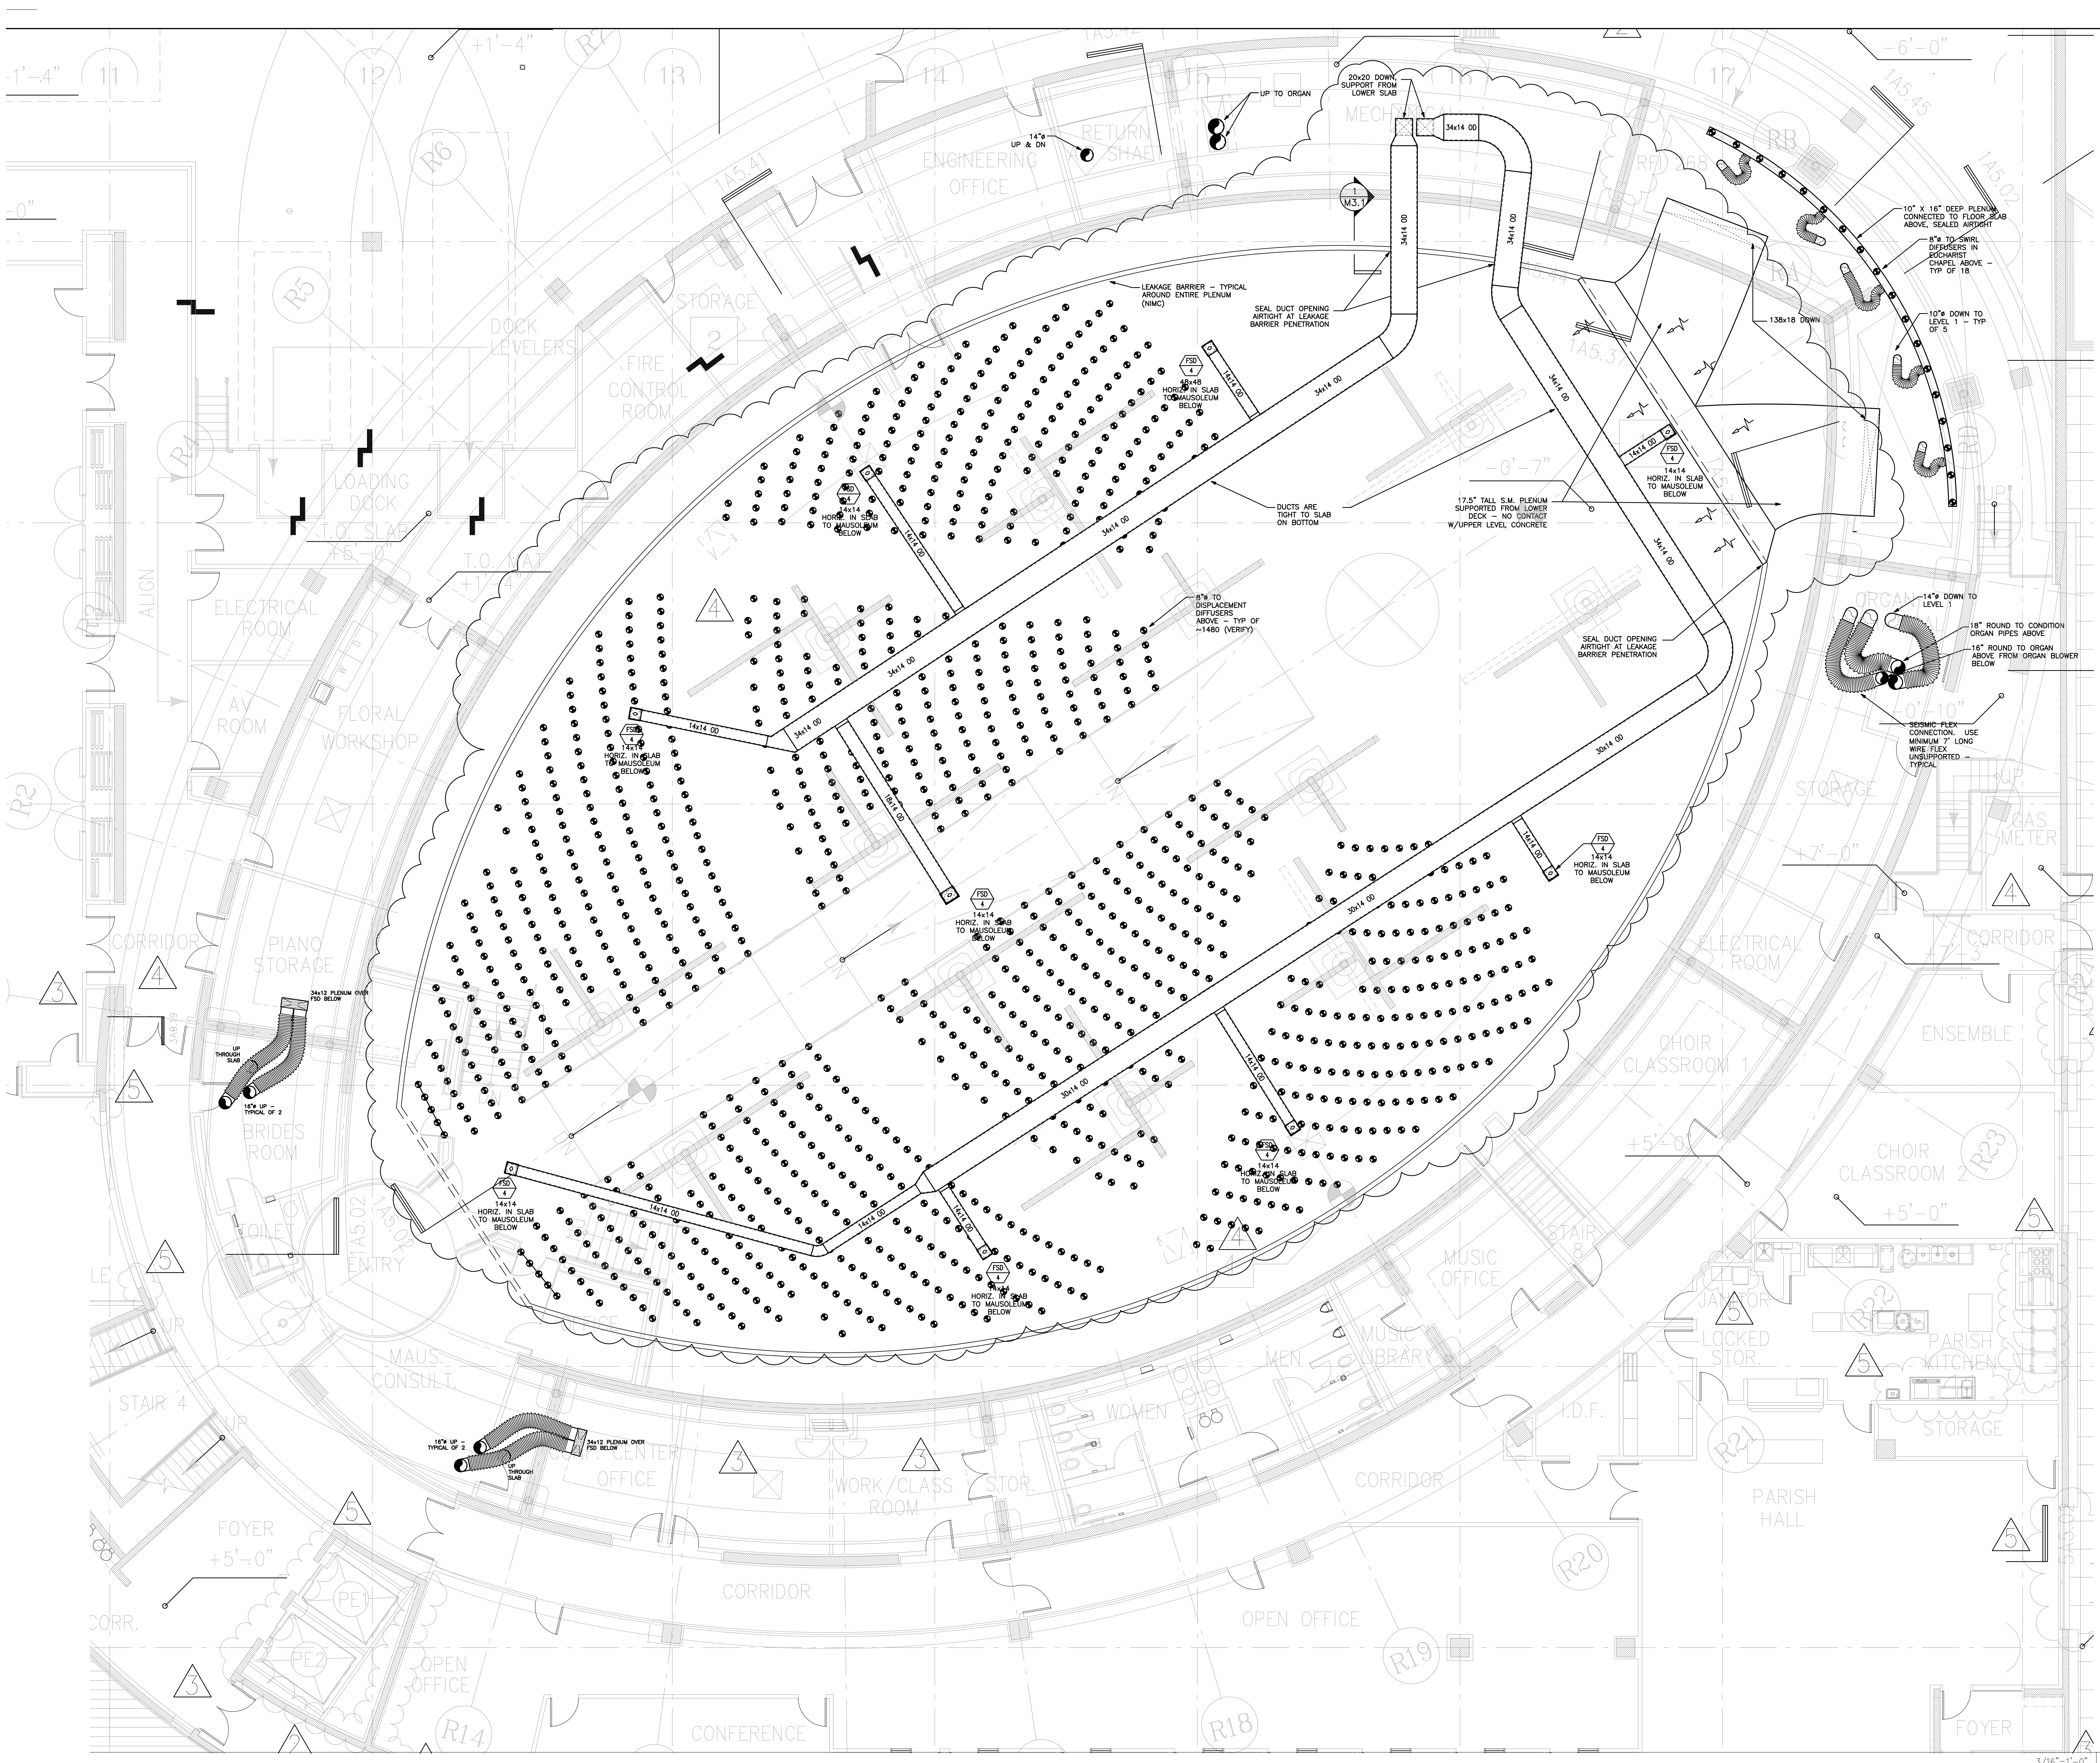


No.	Date	Issue
03-01-2005		ISSUED FOR BID PACKAGE NO.1
03-24-2005		BID PACKAGE NO.1-ADDENDUM NO. 2
05-06-2005		MAUSOLEUM DESIGN DEVELOPMENT

FILE NAME: _____

Drawing Title: **UNDERFLOOR PLENUM HVAC PLAN**

Project Number: KHA 03044 Drawing No. M2.1.F

3/16"=1'-0" 1

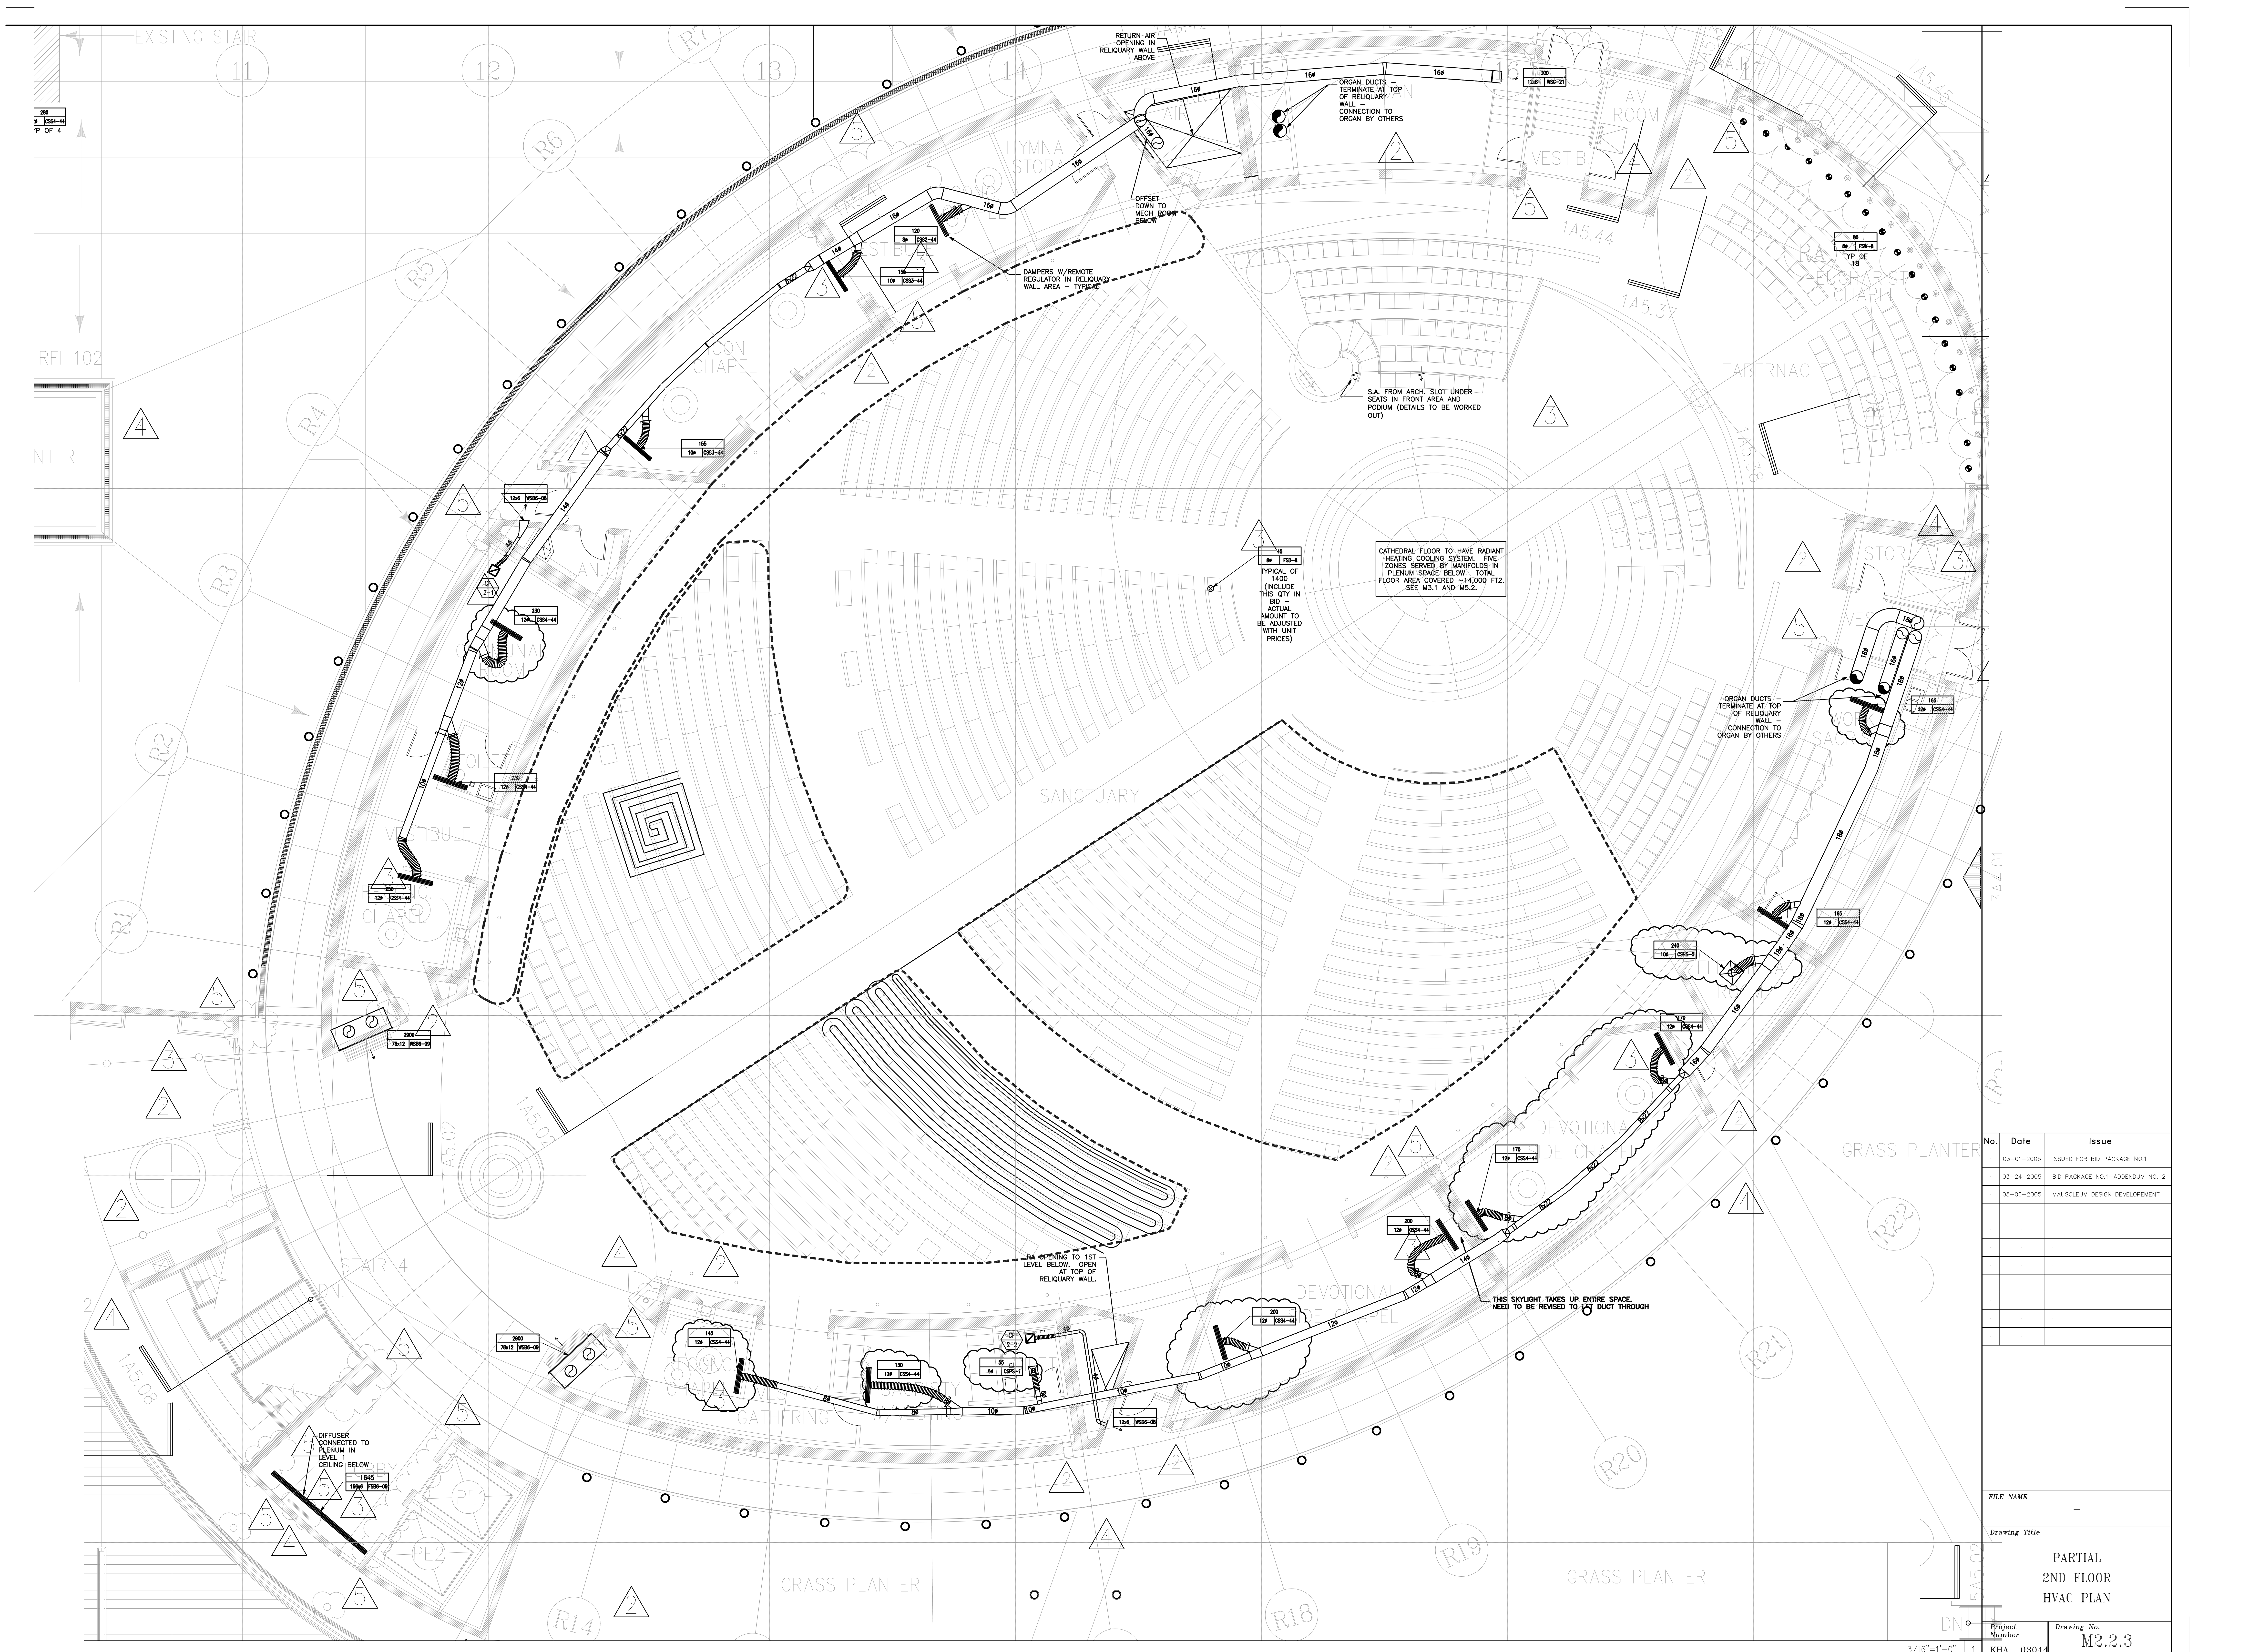

EXISTING STAIR

HYMNAL STORAGE

AV ROOM

TABERNACLE

SANCTUARY

DEVOTIONAL CHAPEL

GRASS PLANTER


GRASS PLANTER

GRASS PLANTER

No.	Date	Issue
03-01-2005		ISSUED FOR BID PACKAGE NO.1
03-24-2005		BID PACKAGE NO.1-ADDENDUM NO. 2
05-06-2005		MAUSOLEUM DESIGN DEVELOPMENT

FILE NAME	
Drawing Title	PARTIAL 2ND FLOOR HVAC PLAN
Project Number	KHA 03044
Drawing No.	M2.2.3

3/16"=1'-0" 1

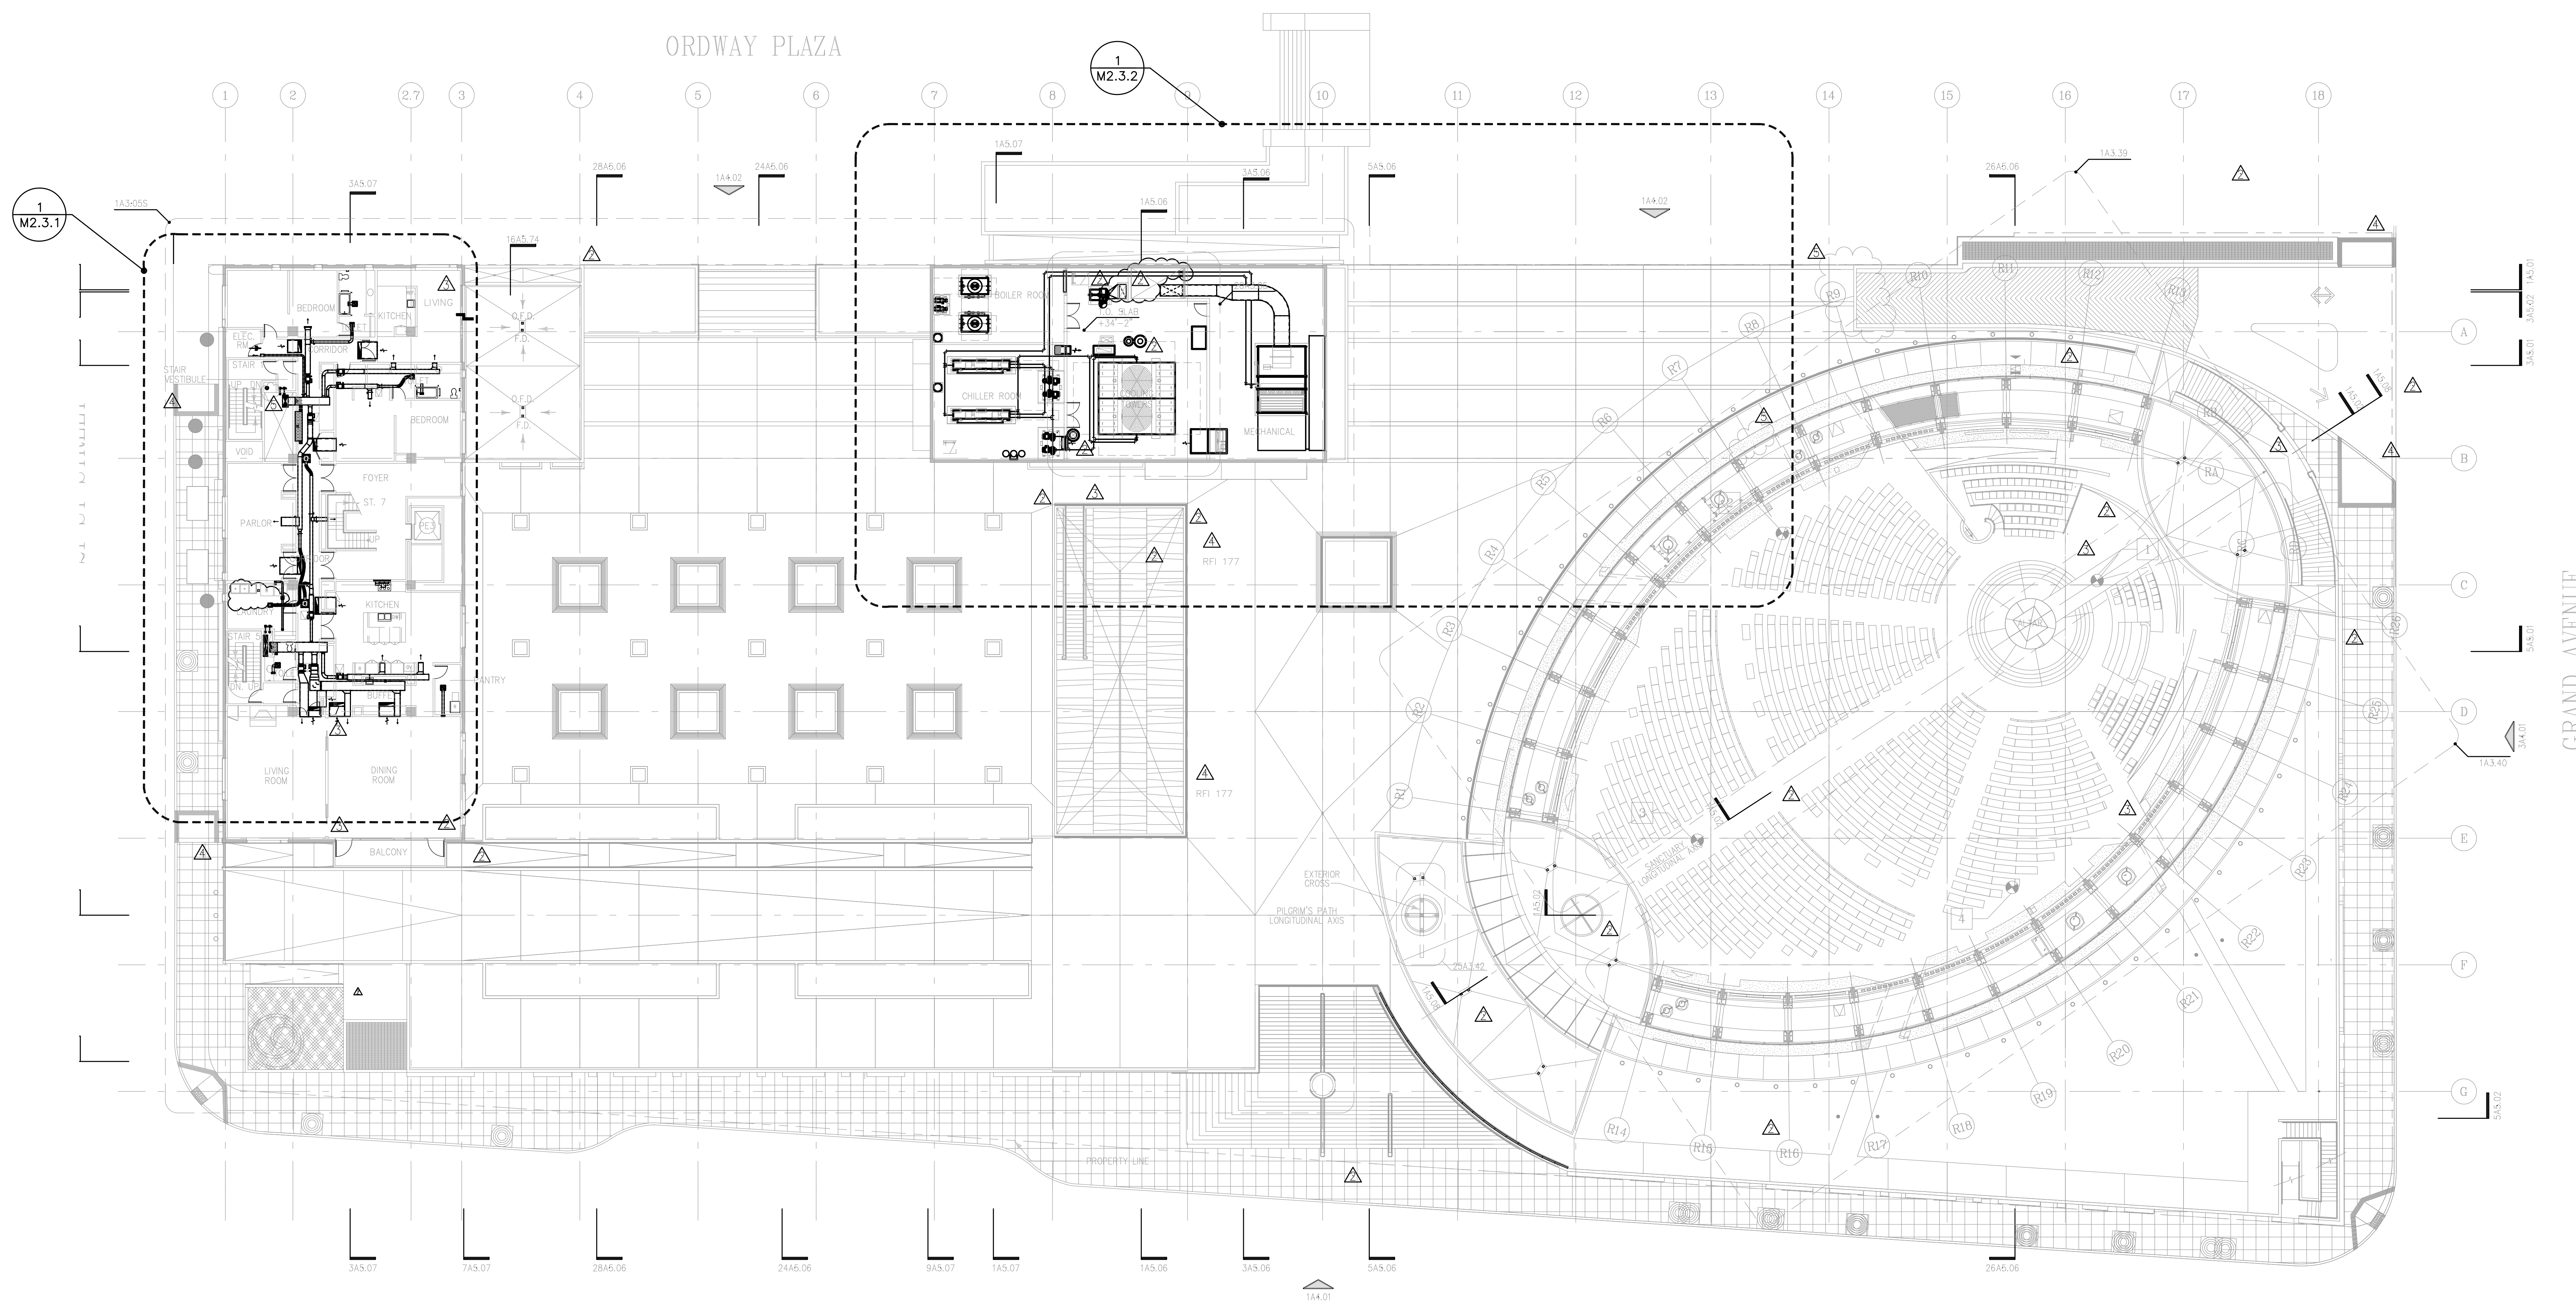


No.	Date	Issue
03-01-2005		ISSUED FOR BID PACKAGE NO.1
03-24-2005		BID PACKAGE NO.1-ADDENDUM NO. 2
05-06-2005		MAUSOLEUM DESIGN DEVELOPMENT
-	-	-
-	-	-
-	-	-
-	-	-
-	-	-
-	-	-
-	-	-

FILE NAME -

Drawing Title
**3RD FLOOR
 HVAC PLAN**

Project Number
 KHA 03014

Drawing No.
M2.3

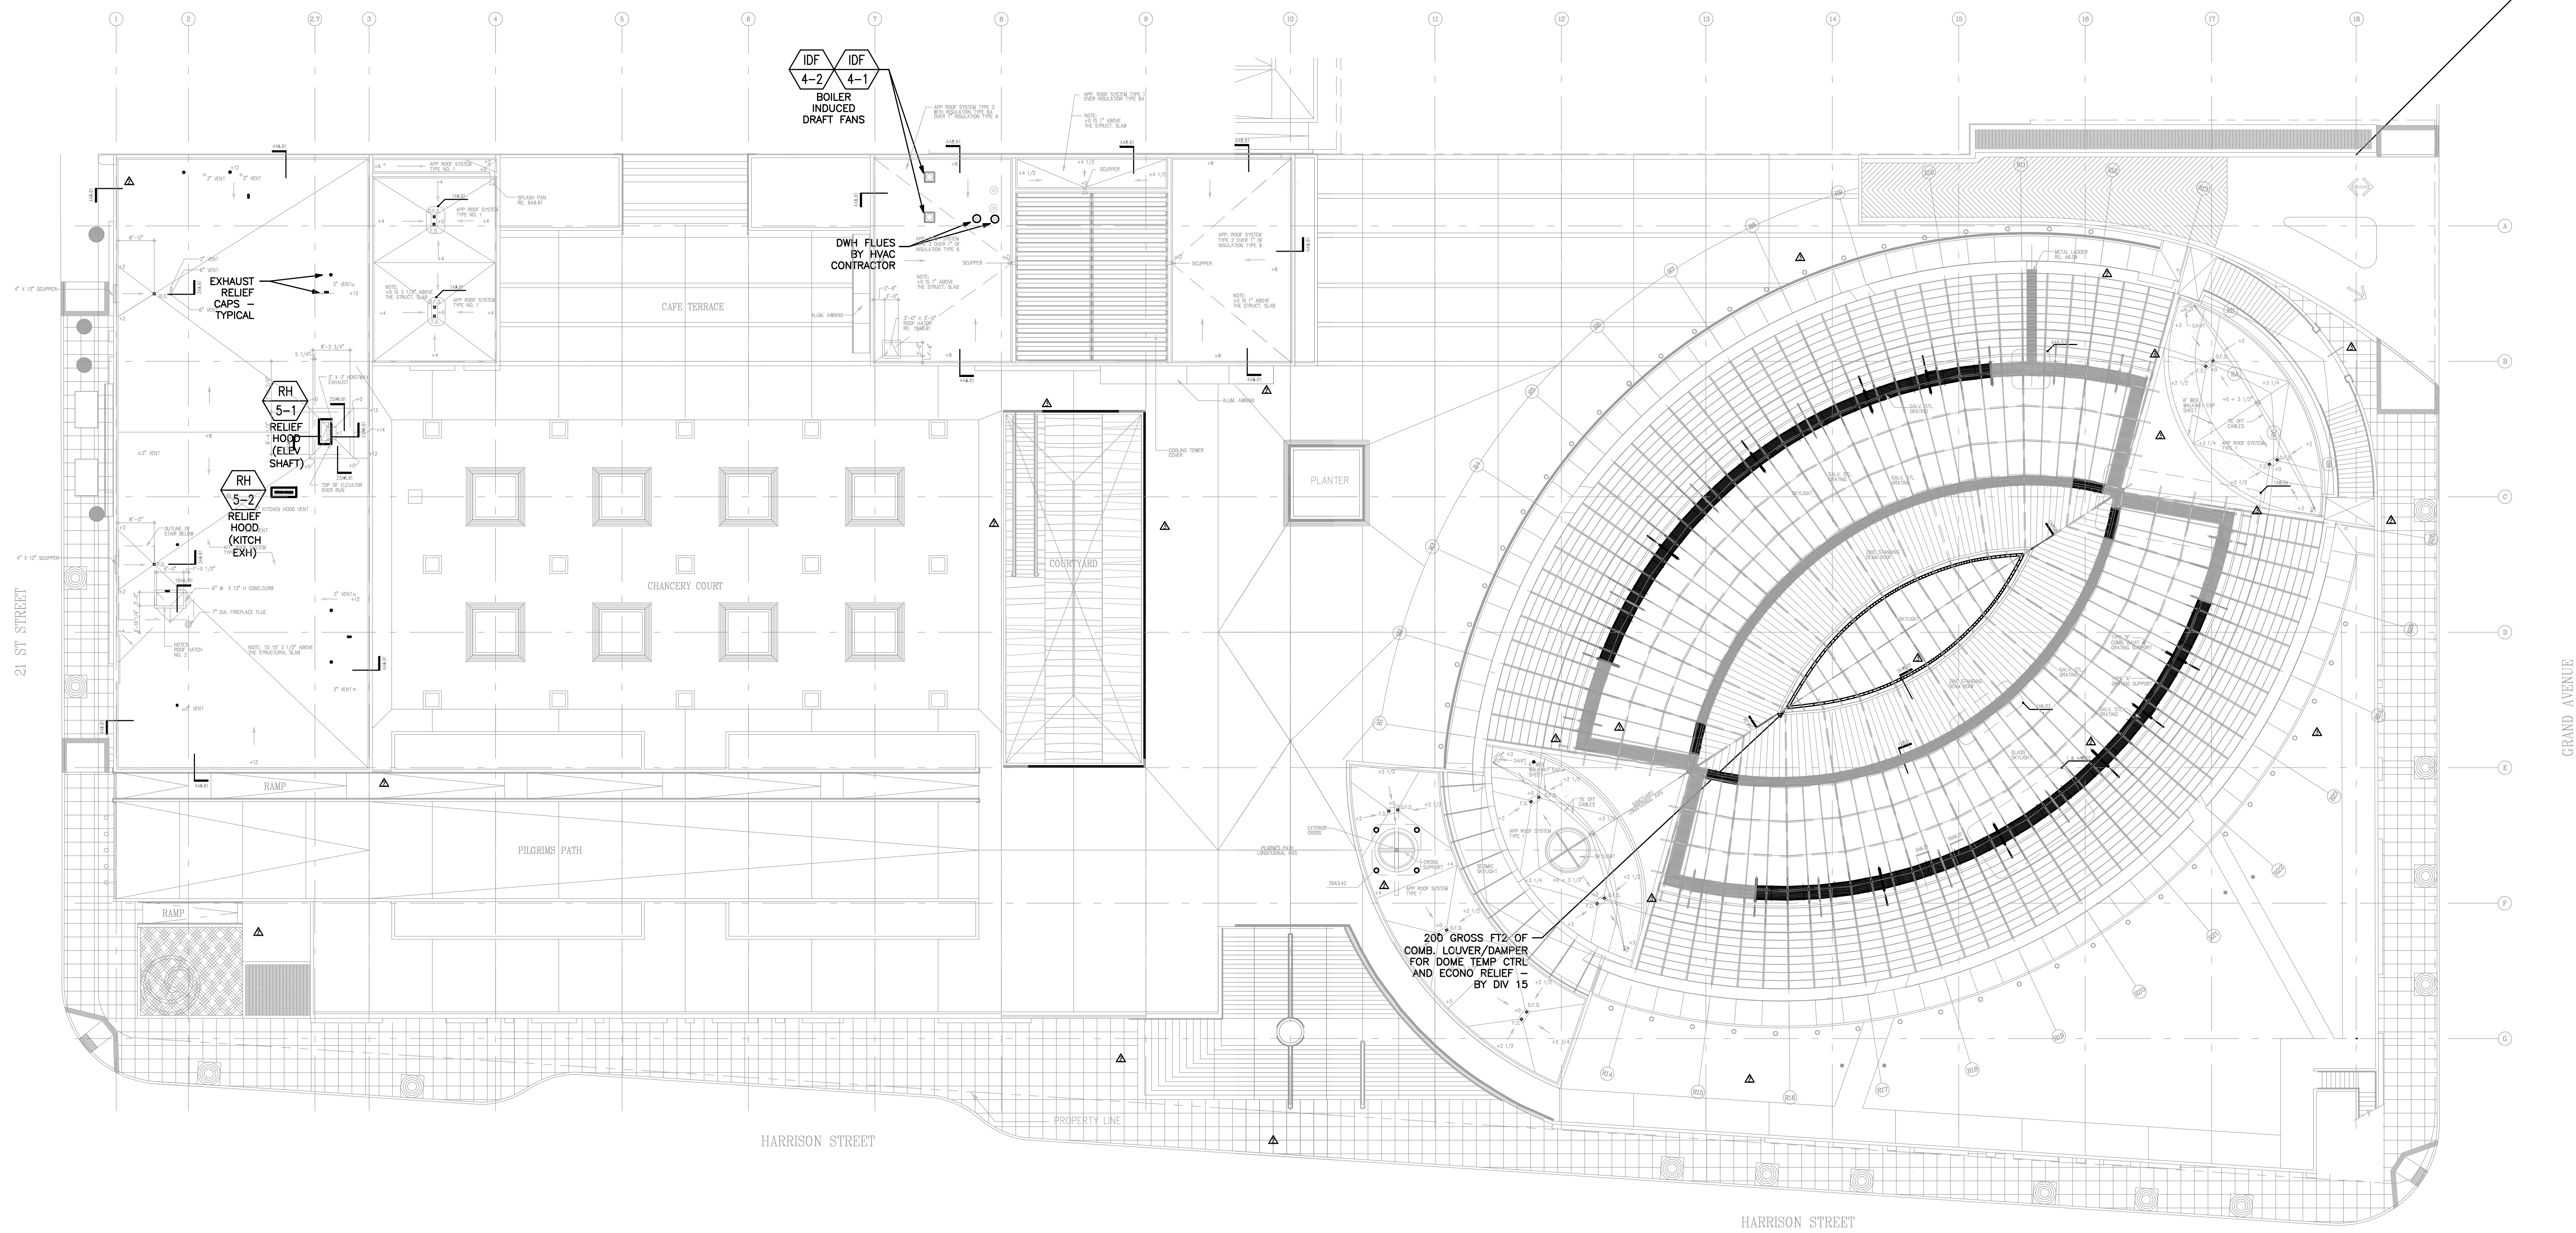

No.	Date	Issue
03-01-2005		ISSUED FOR BID PACKAGE NO.1
03-24-2005		BID PACKAGE NO.1-ADDENDUM NO. 2
05-06-2005		MAUSOLEUM DESIGN DEVELOPMENT


FILE NAME
-

Drawing Title
**ROOF
HVAC PLAN**


Project Number
KHA 03044

Drawing No.
M2.5


1/16"=1'-0" 1

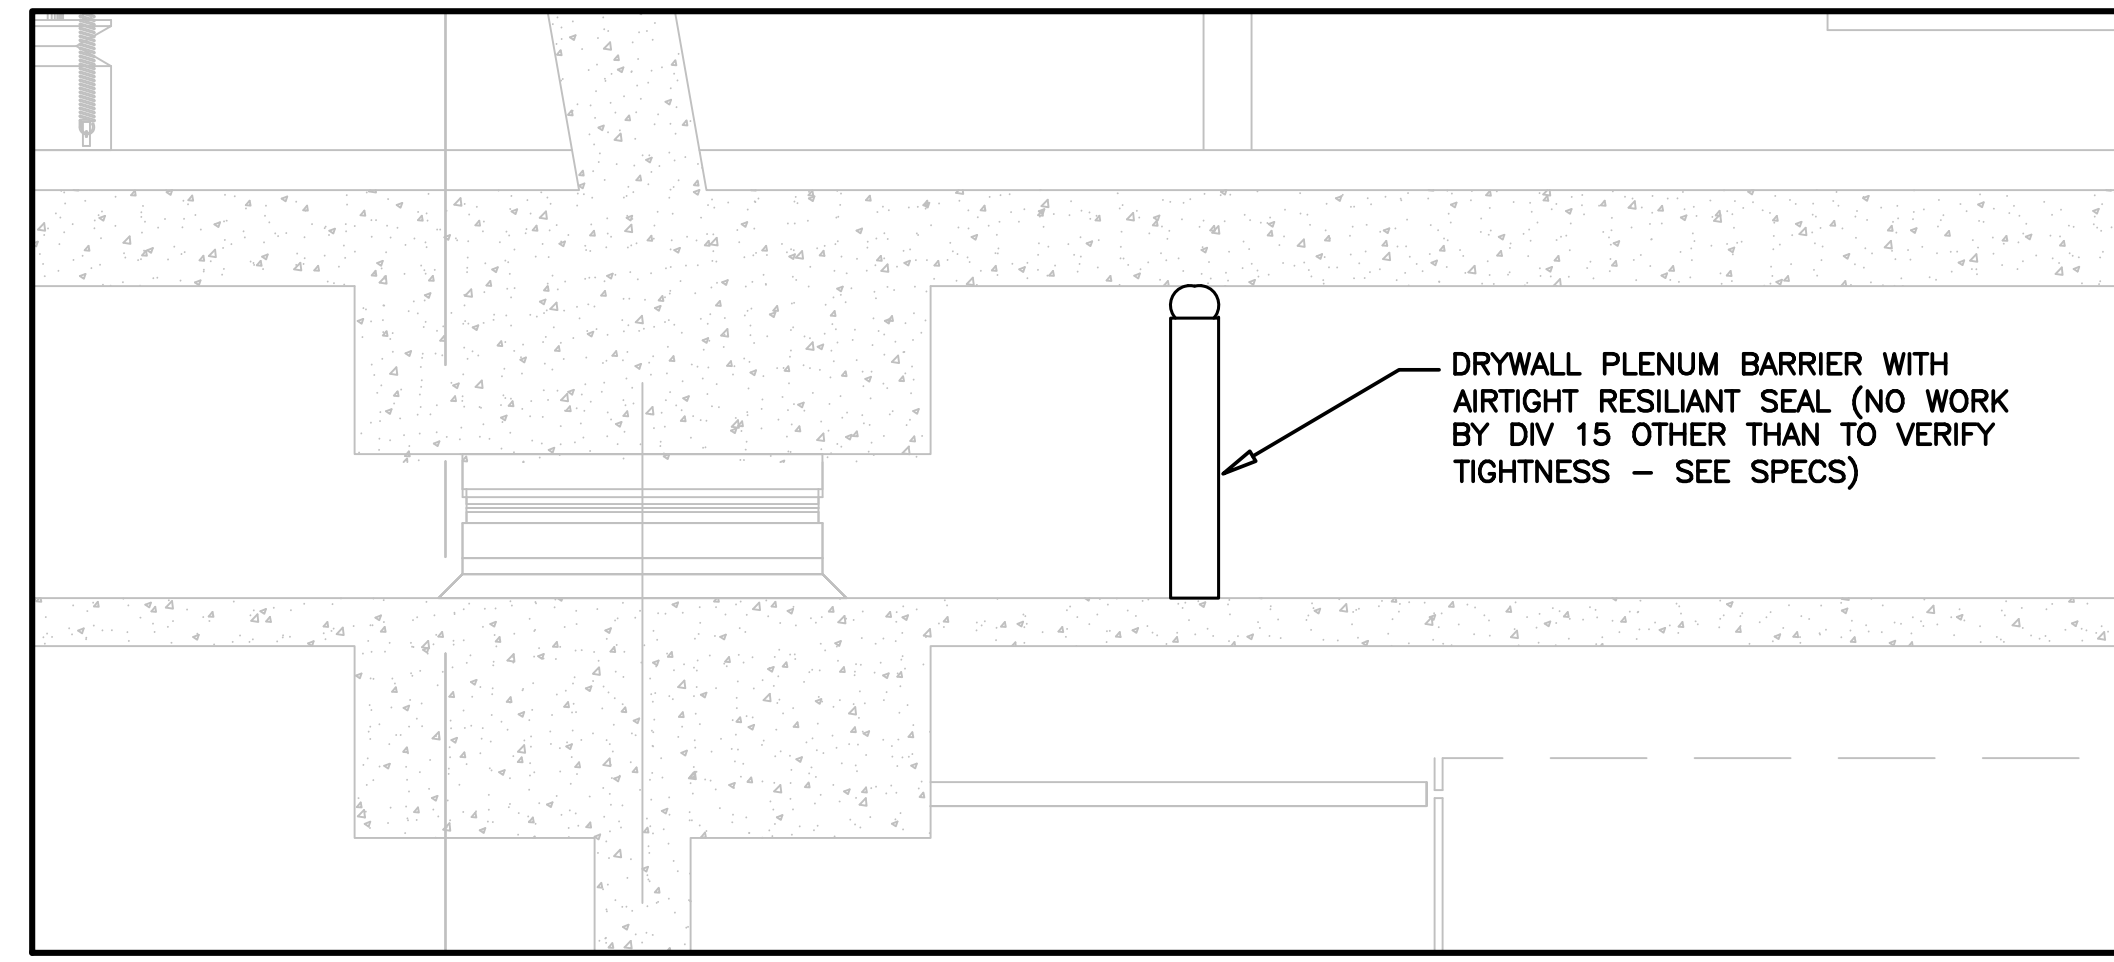


1 SECTION AT PLENUM ENCLOSURE
M3.1 1/2"=1'0"

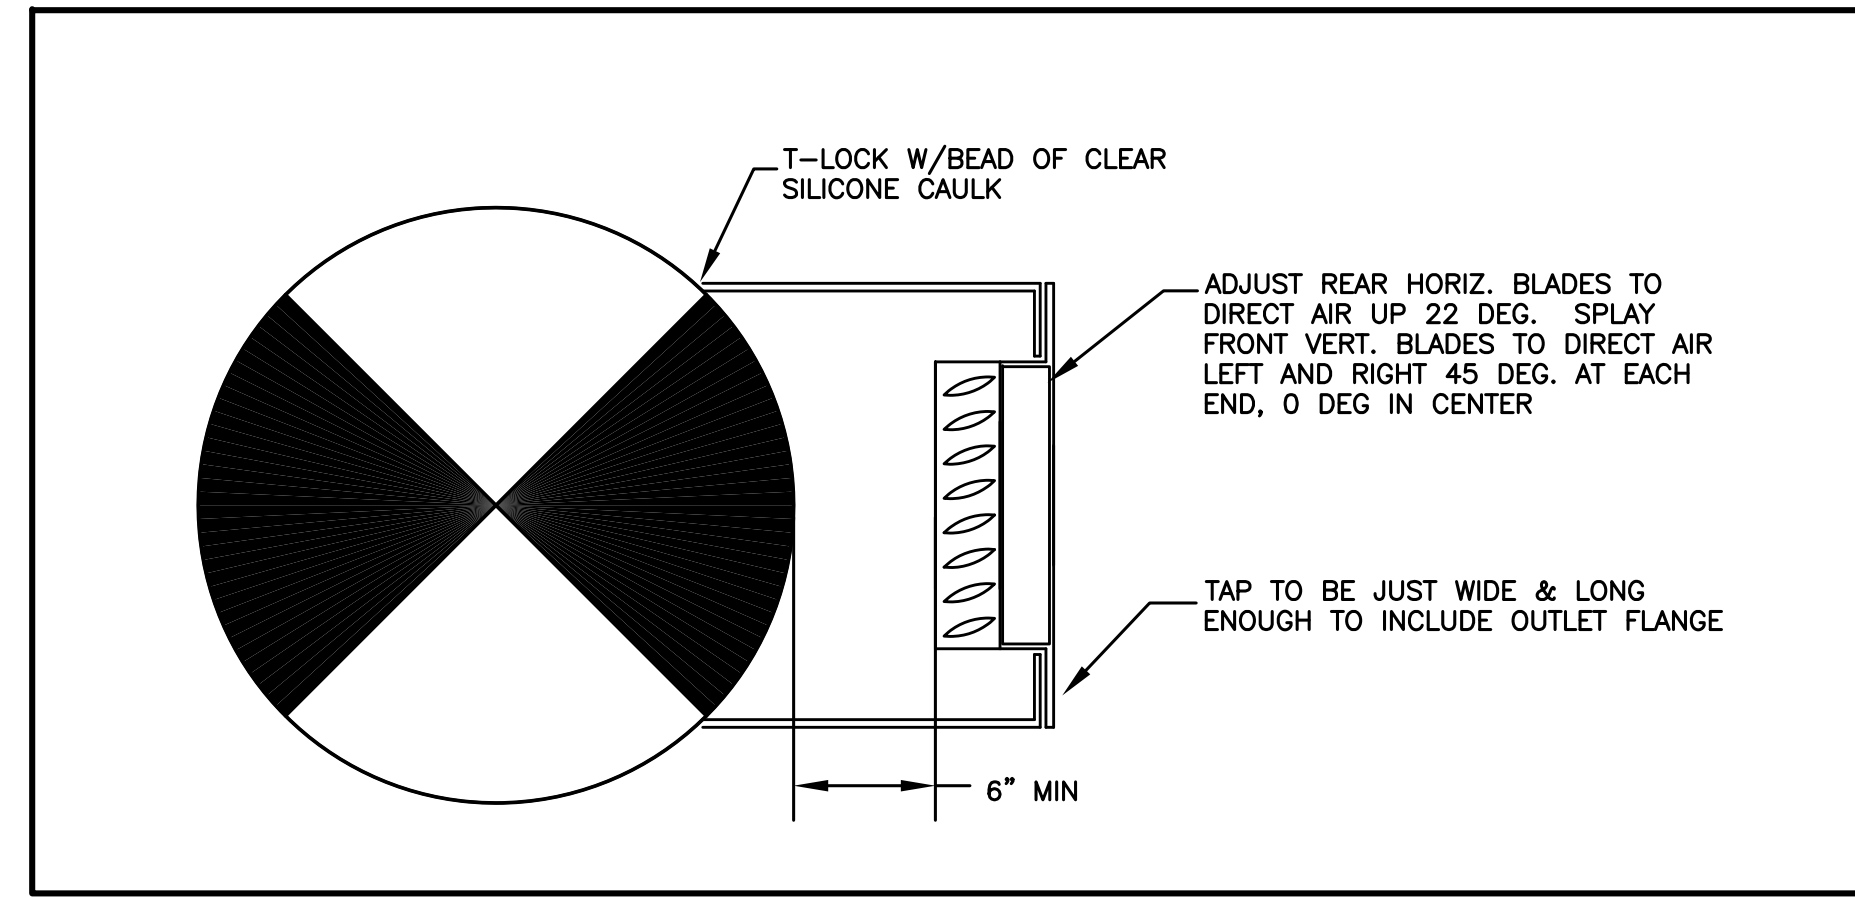


2 EXPOSED SIDEWALL GRILLE DETAIL
M3.1 NTS

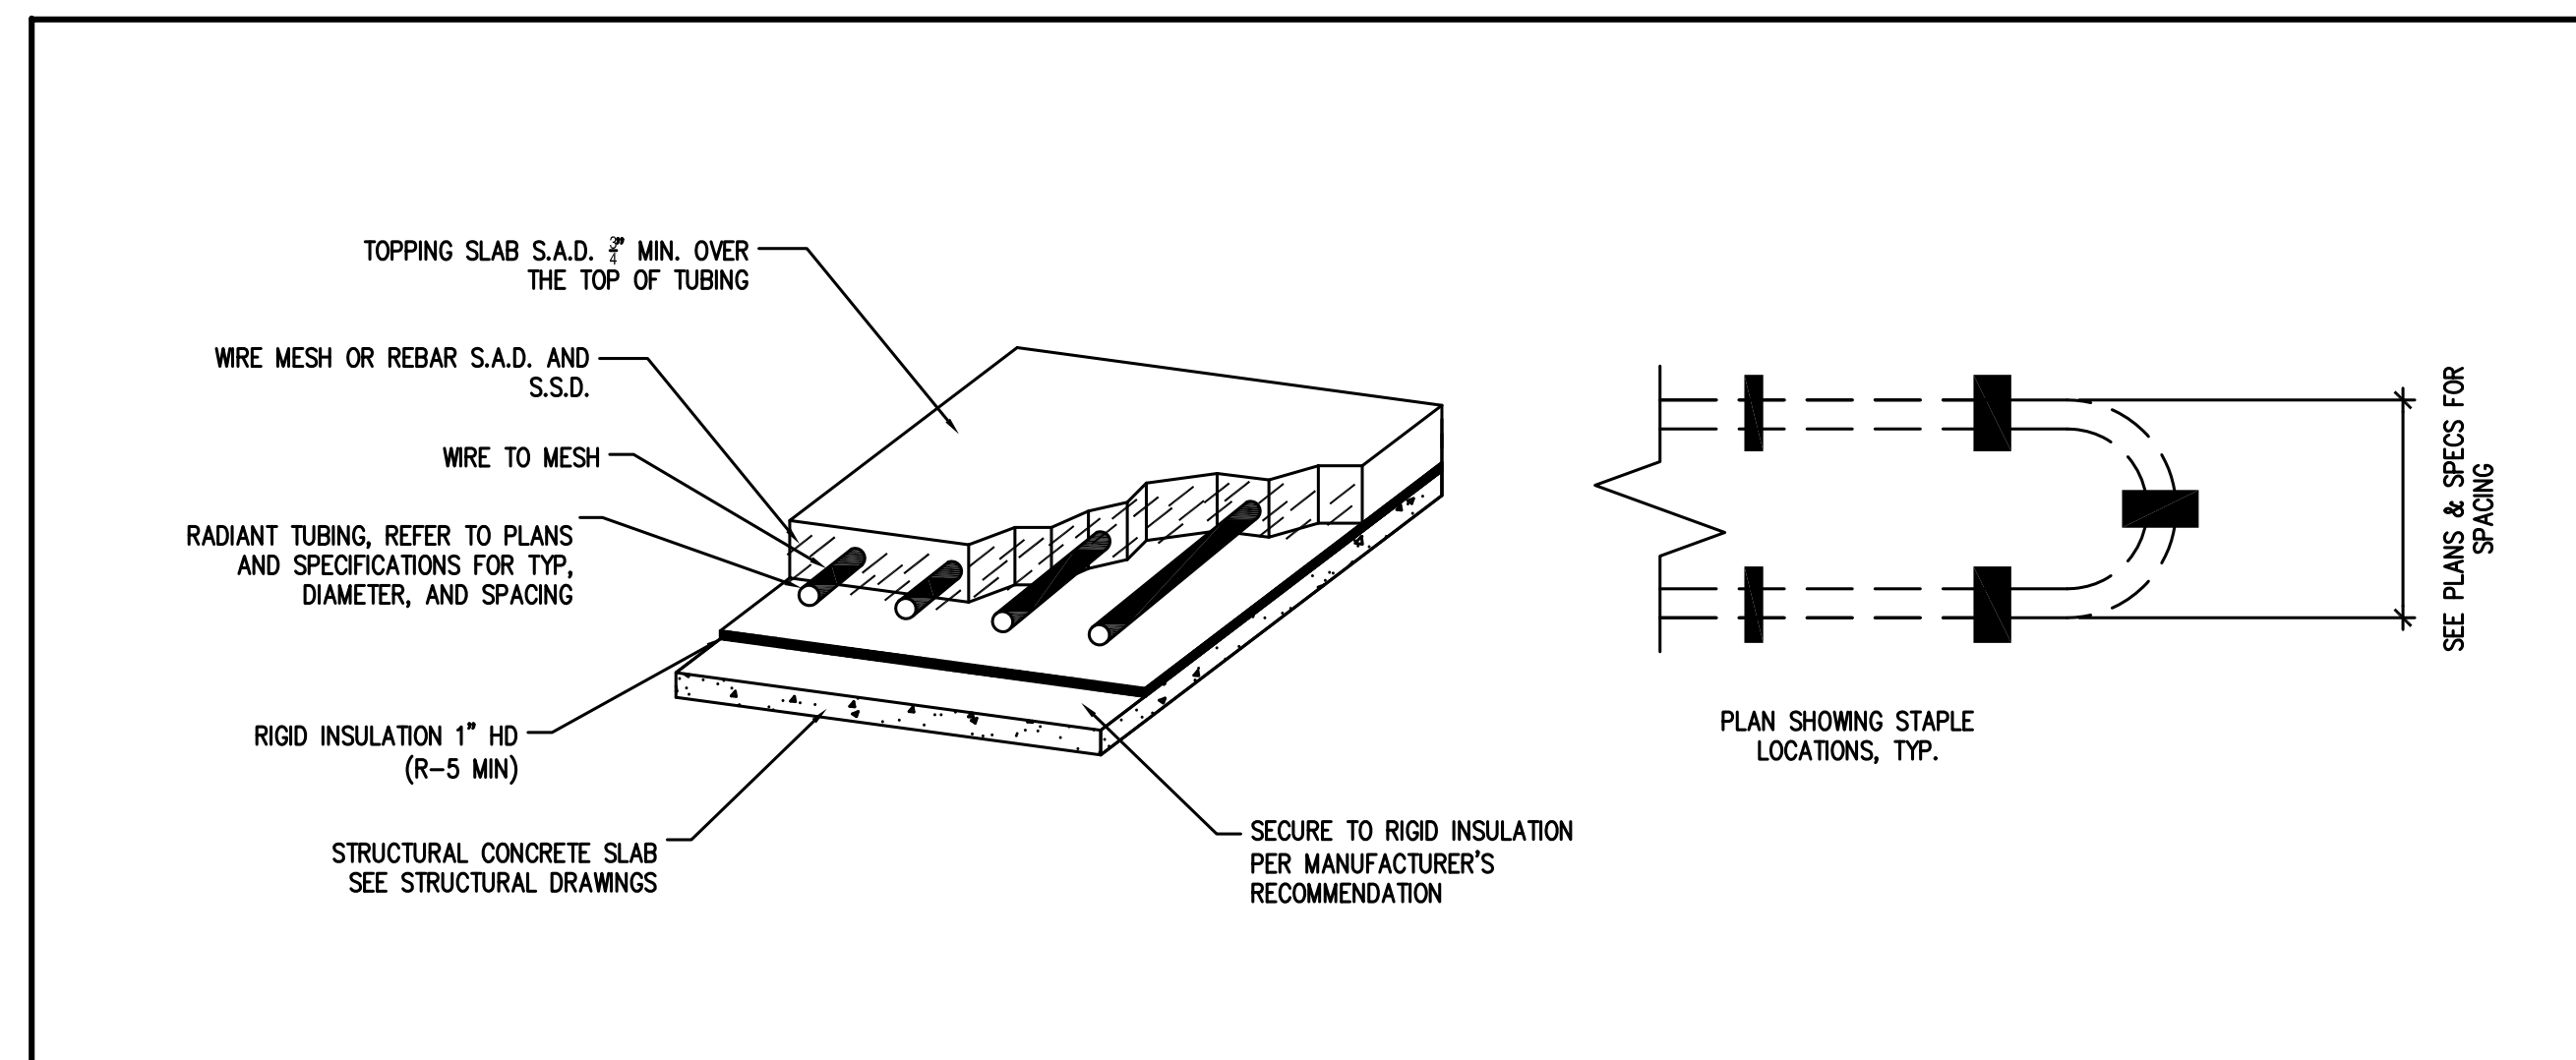


3 RADIANT SLAB DETAIL
M3.1 NTS

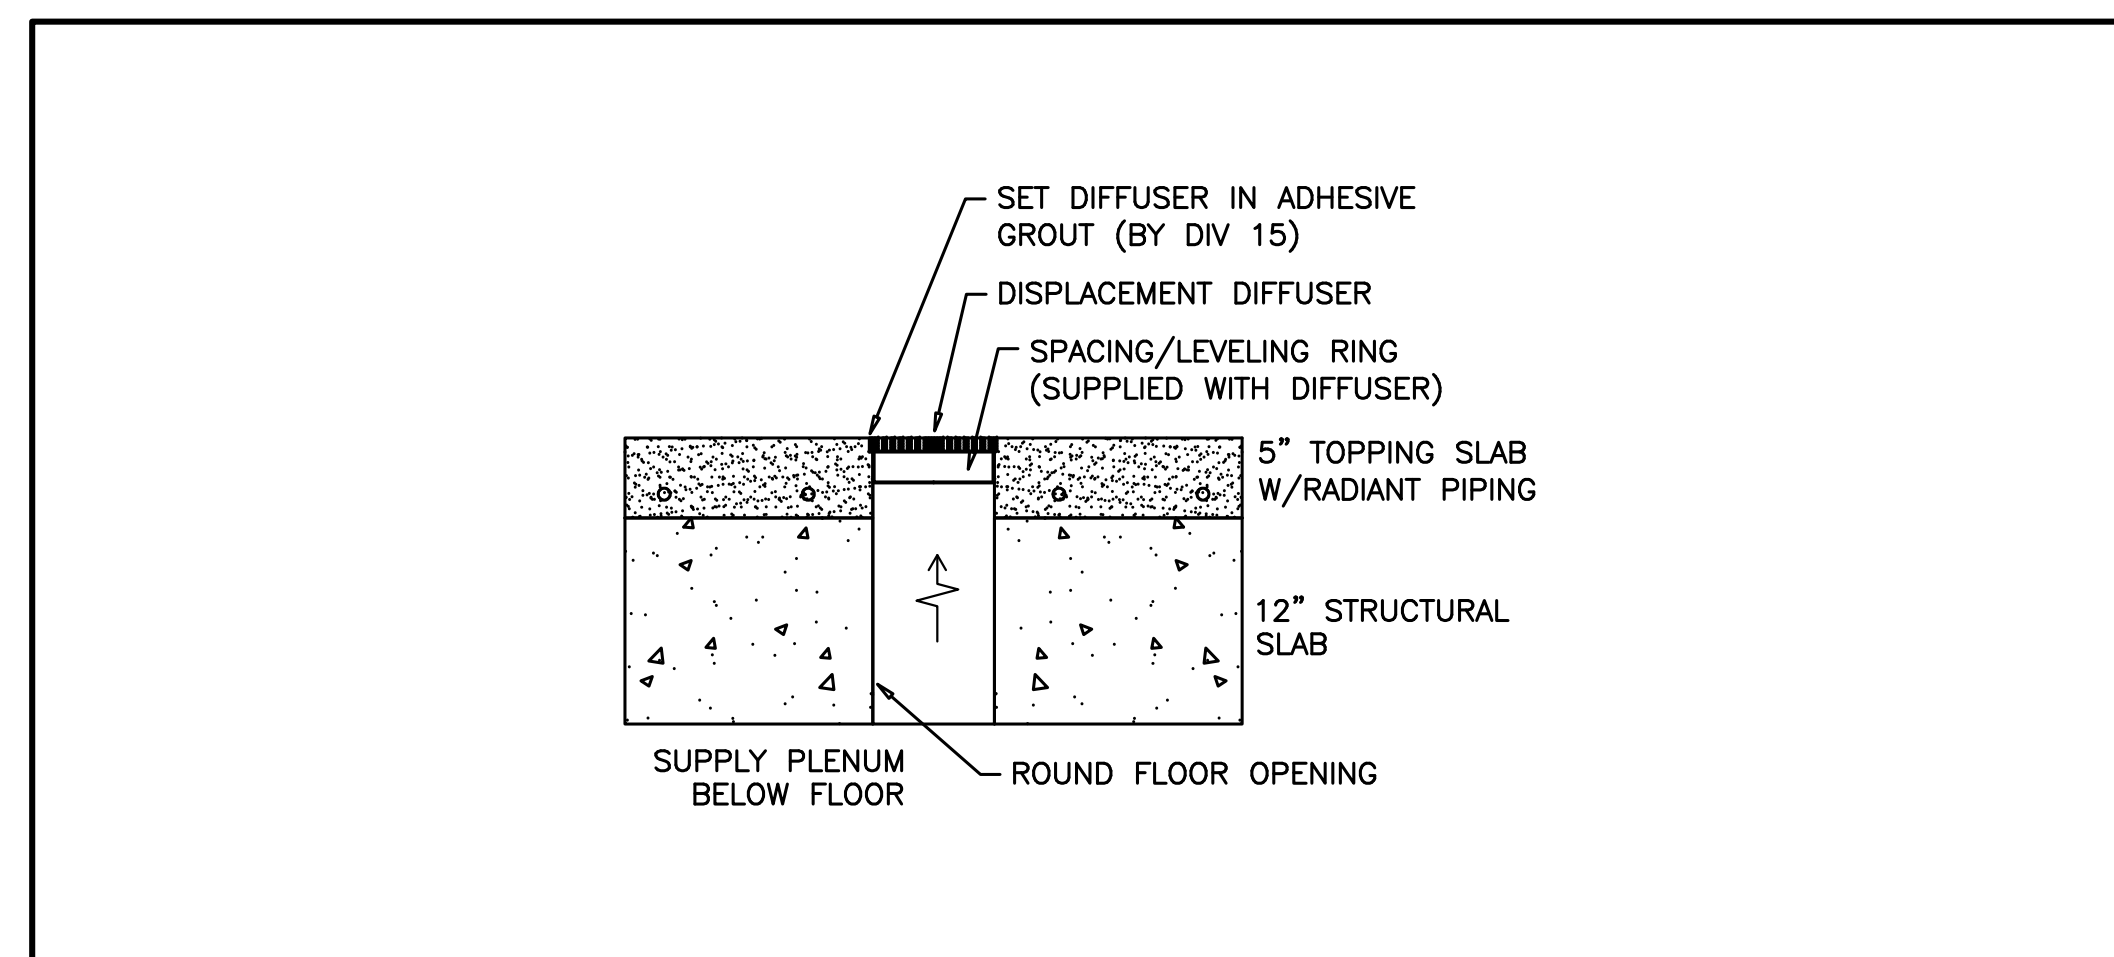

4 CATHEDRAL FLOOR DIFFUSER
M3.1 1"=1'0"

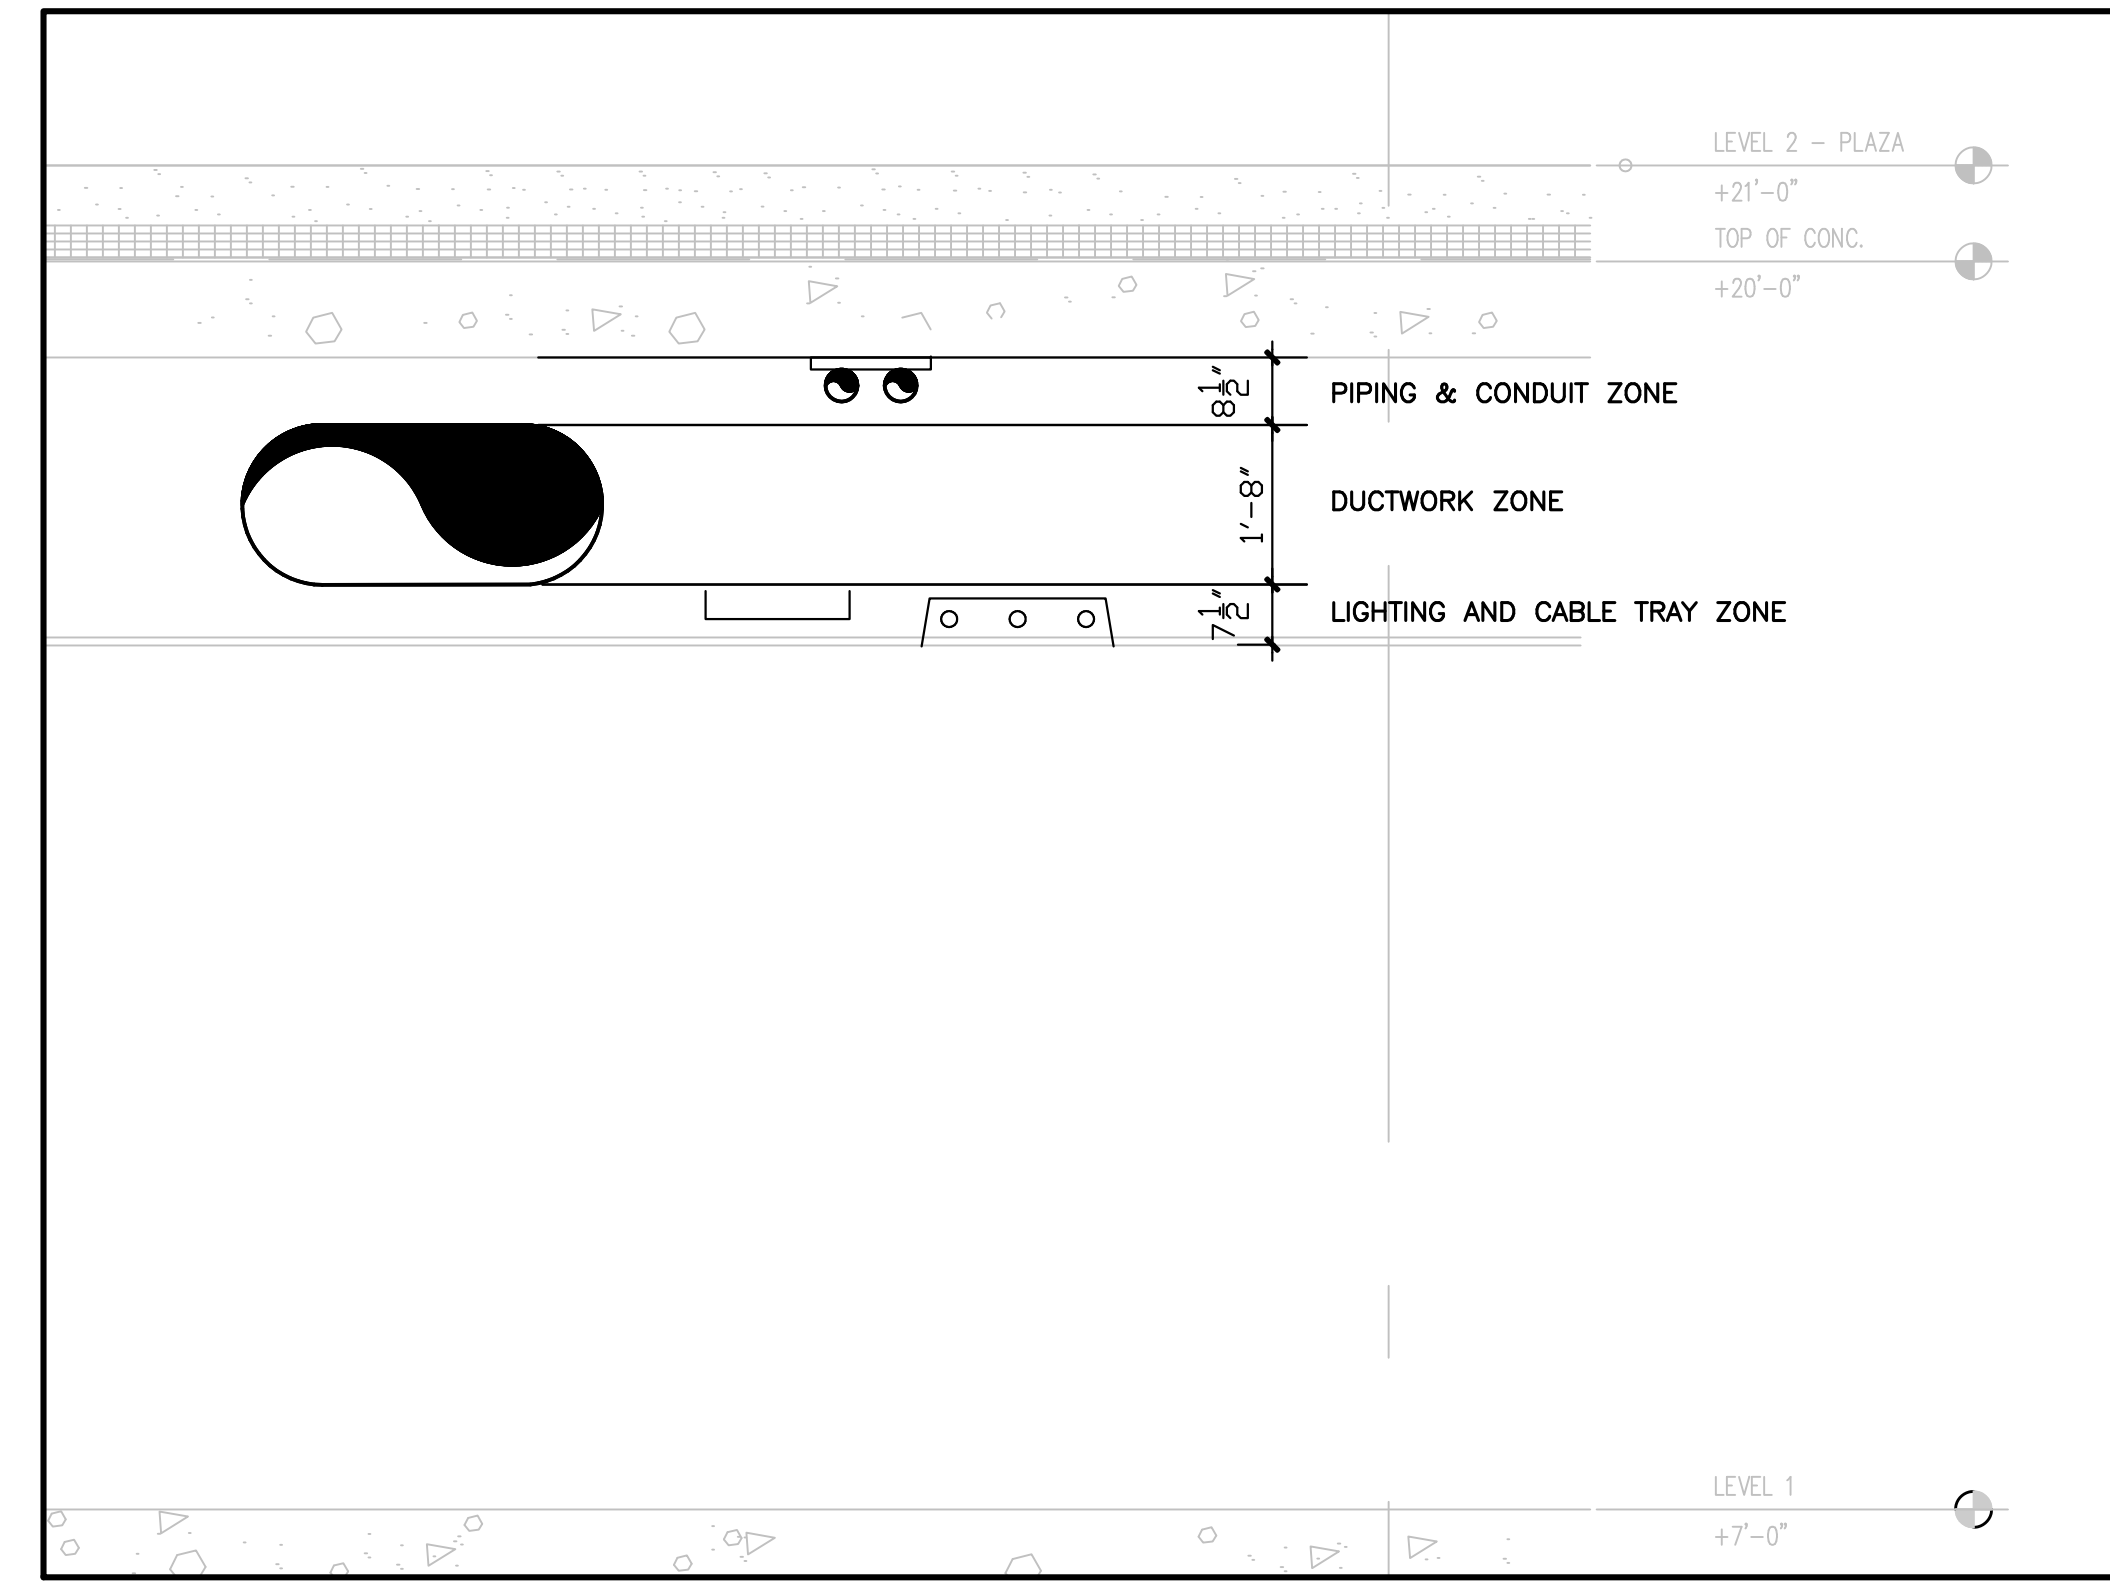

5 TYPICAL CEILING COORDINATION SECTION
M3.1 1/2"=1'0"

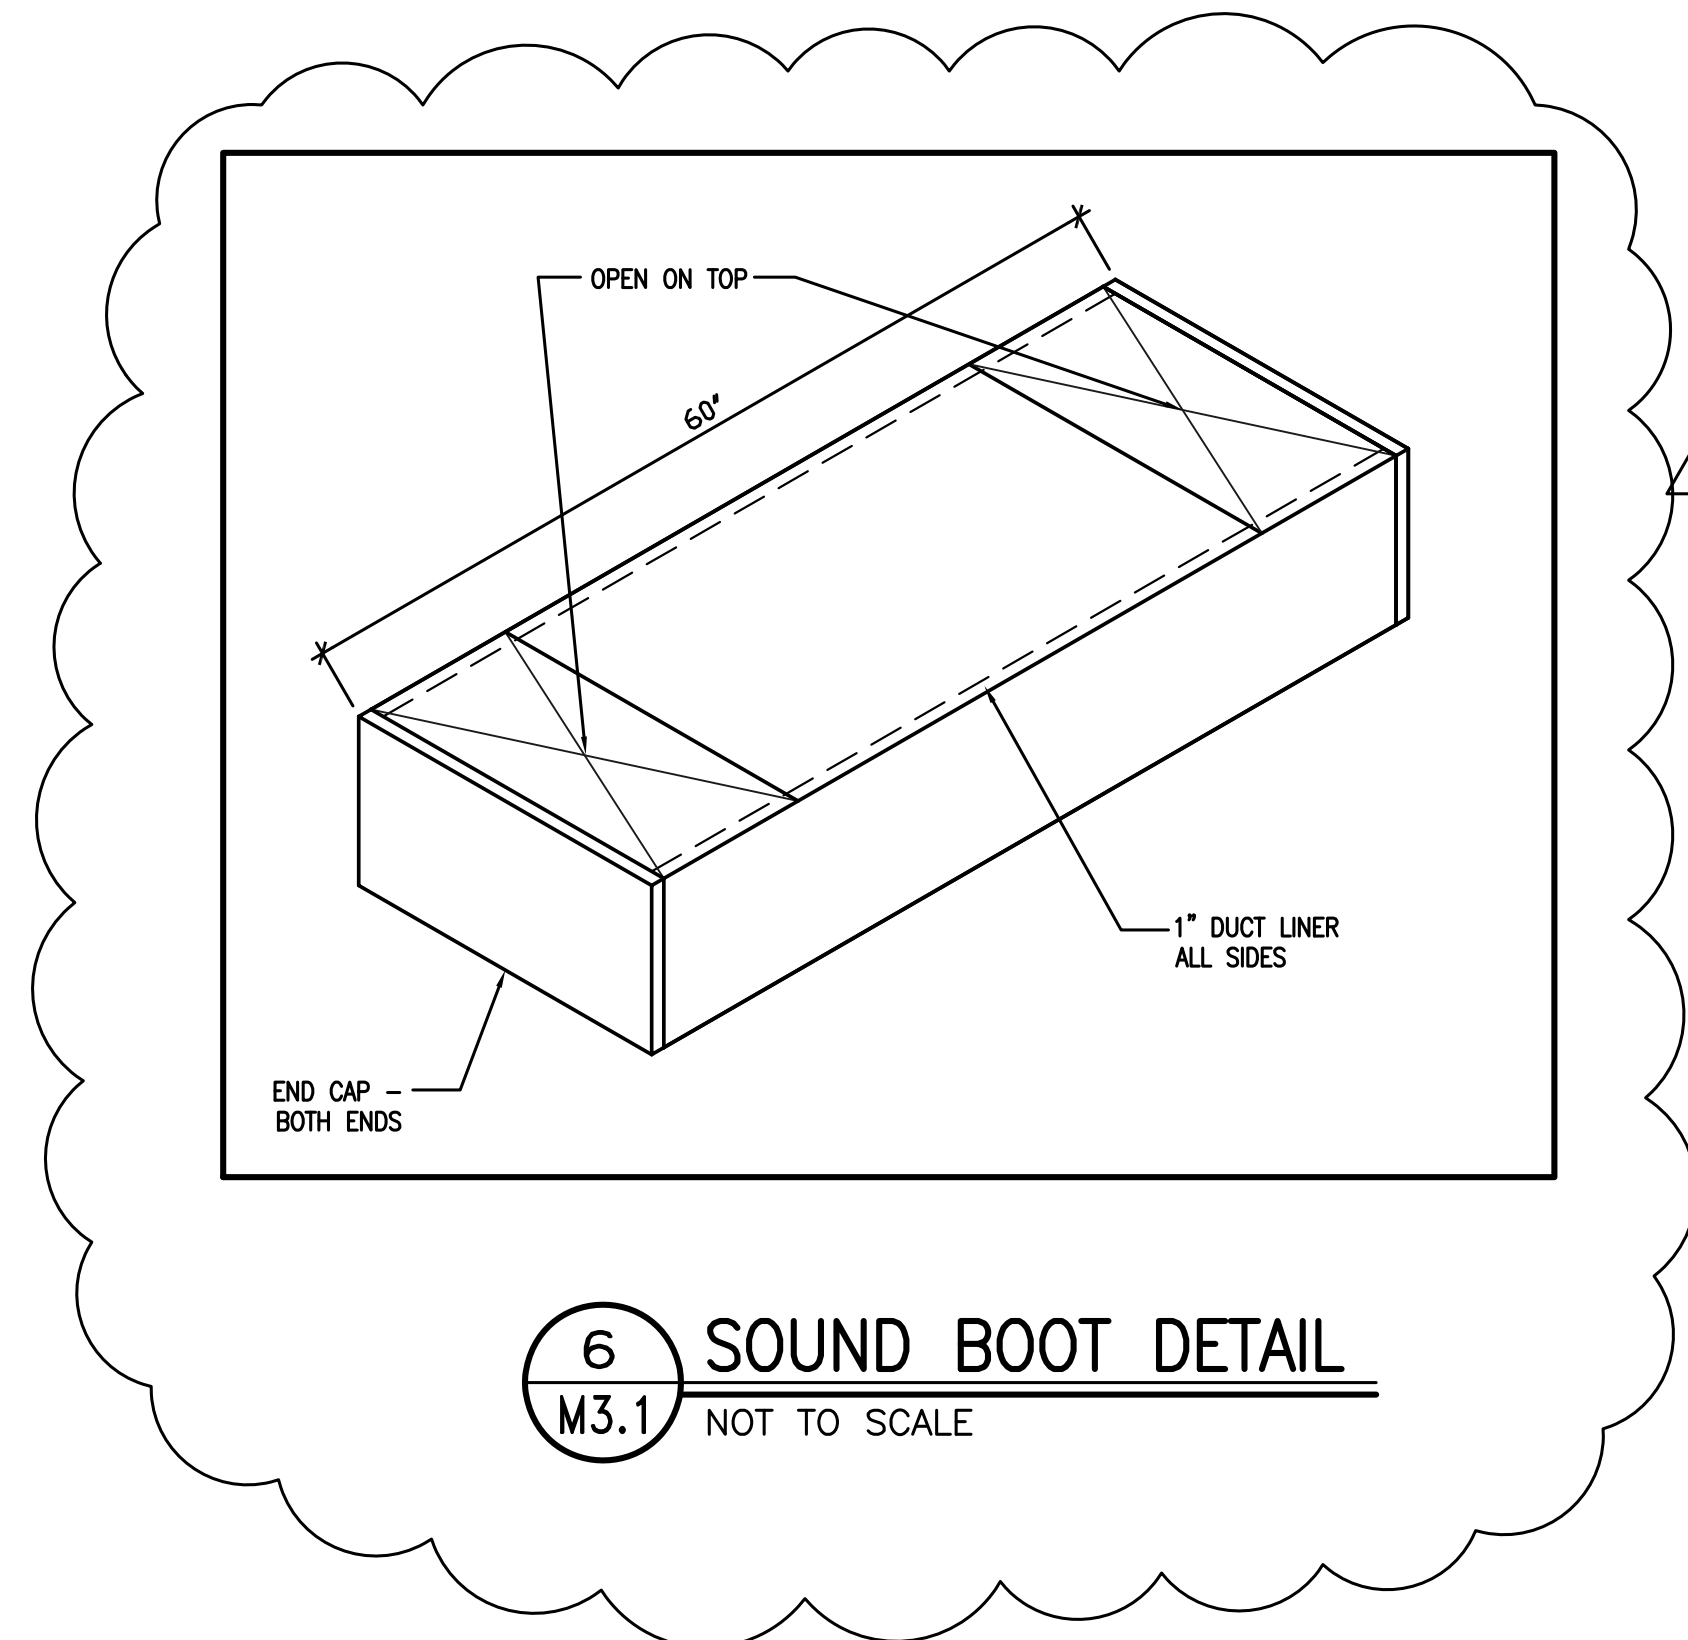

6 SOUND BOOT DETAIL
M3.1 NOT TO SCALE

No.	Date	Issue
03-01-2005		ISSUED FOR BID PACKAGE NO.1
03-24-2005		BID PACKAGE NO.1-ADDENDUM NO. 2
05-06-2005		MAUSOLEUM DESIGN DEVELOPMENT


FILE NAME

Drawing Title

SECTIONS & DETAILS


Project Number: KHA 03044
Drawing No.: M3.1

PM, Adobe PDF.

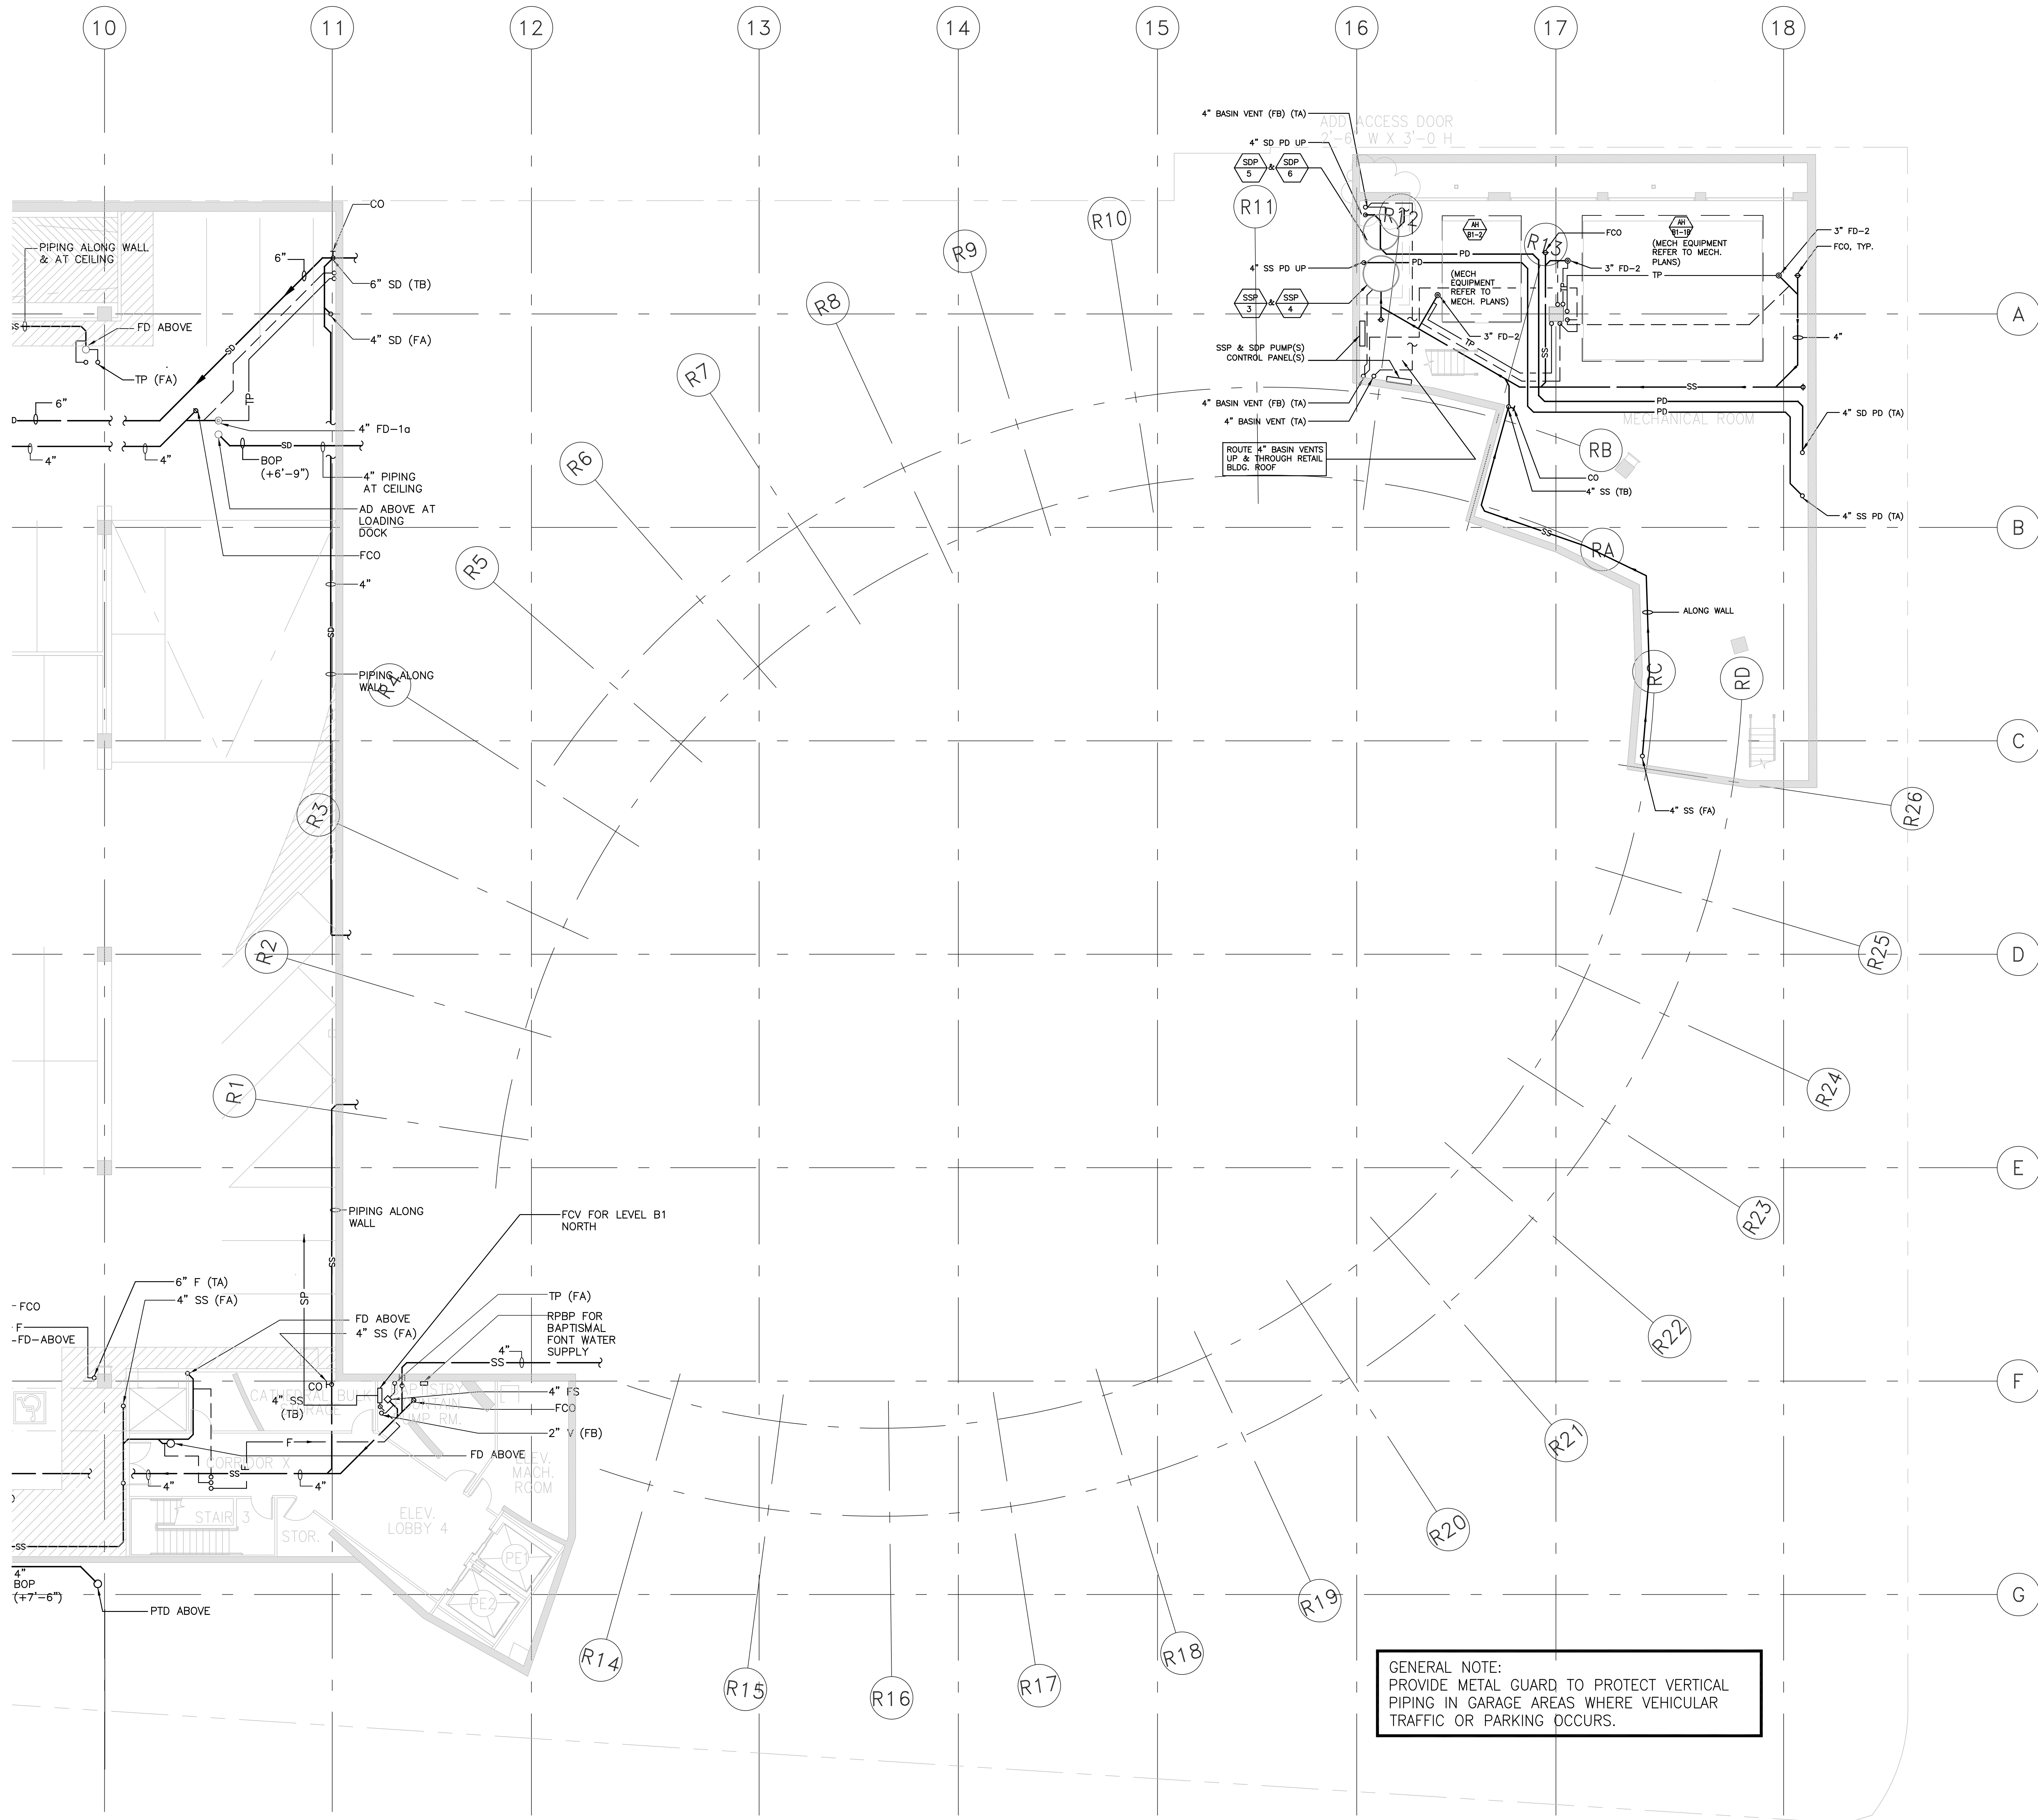

1 PARTIAL LEVEL B1 PLUMBING PLAN
 P2.B1.1 1/8" = 1'-0"

No.	Date	Issue
03-01-2005		ISSUED FOR BID PACKAGE NO.1
03-24-2005		BID PACKAGE NO.1-ADDENDUM NO. 2

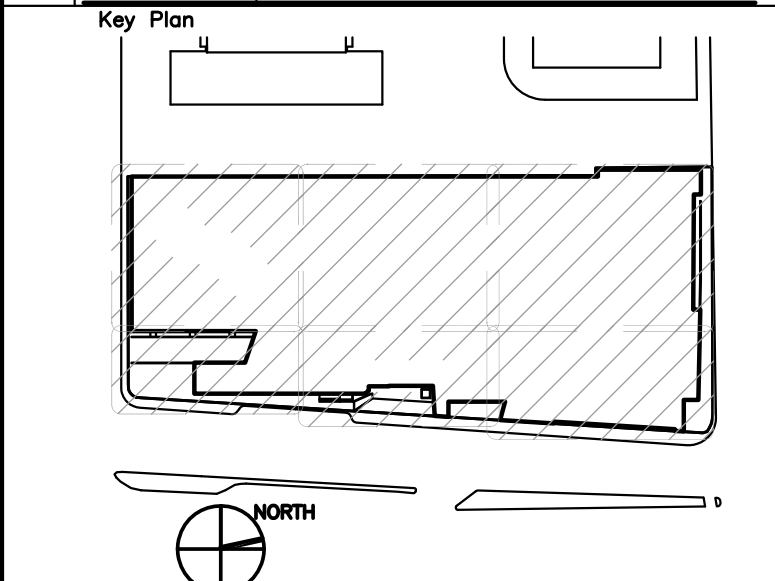

Drawing Title
 PARTIAL BASEMENT
 PLUMBING PLAN
 LEVEL B1


Project Number
 KHA 03044

Drawing No.
 P2.B1.1

1/8" = 1'-0" 1

NAME


Xref

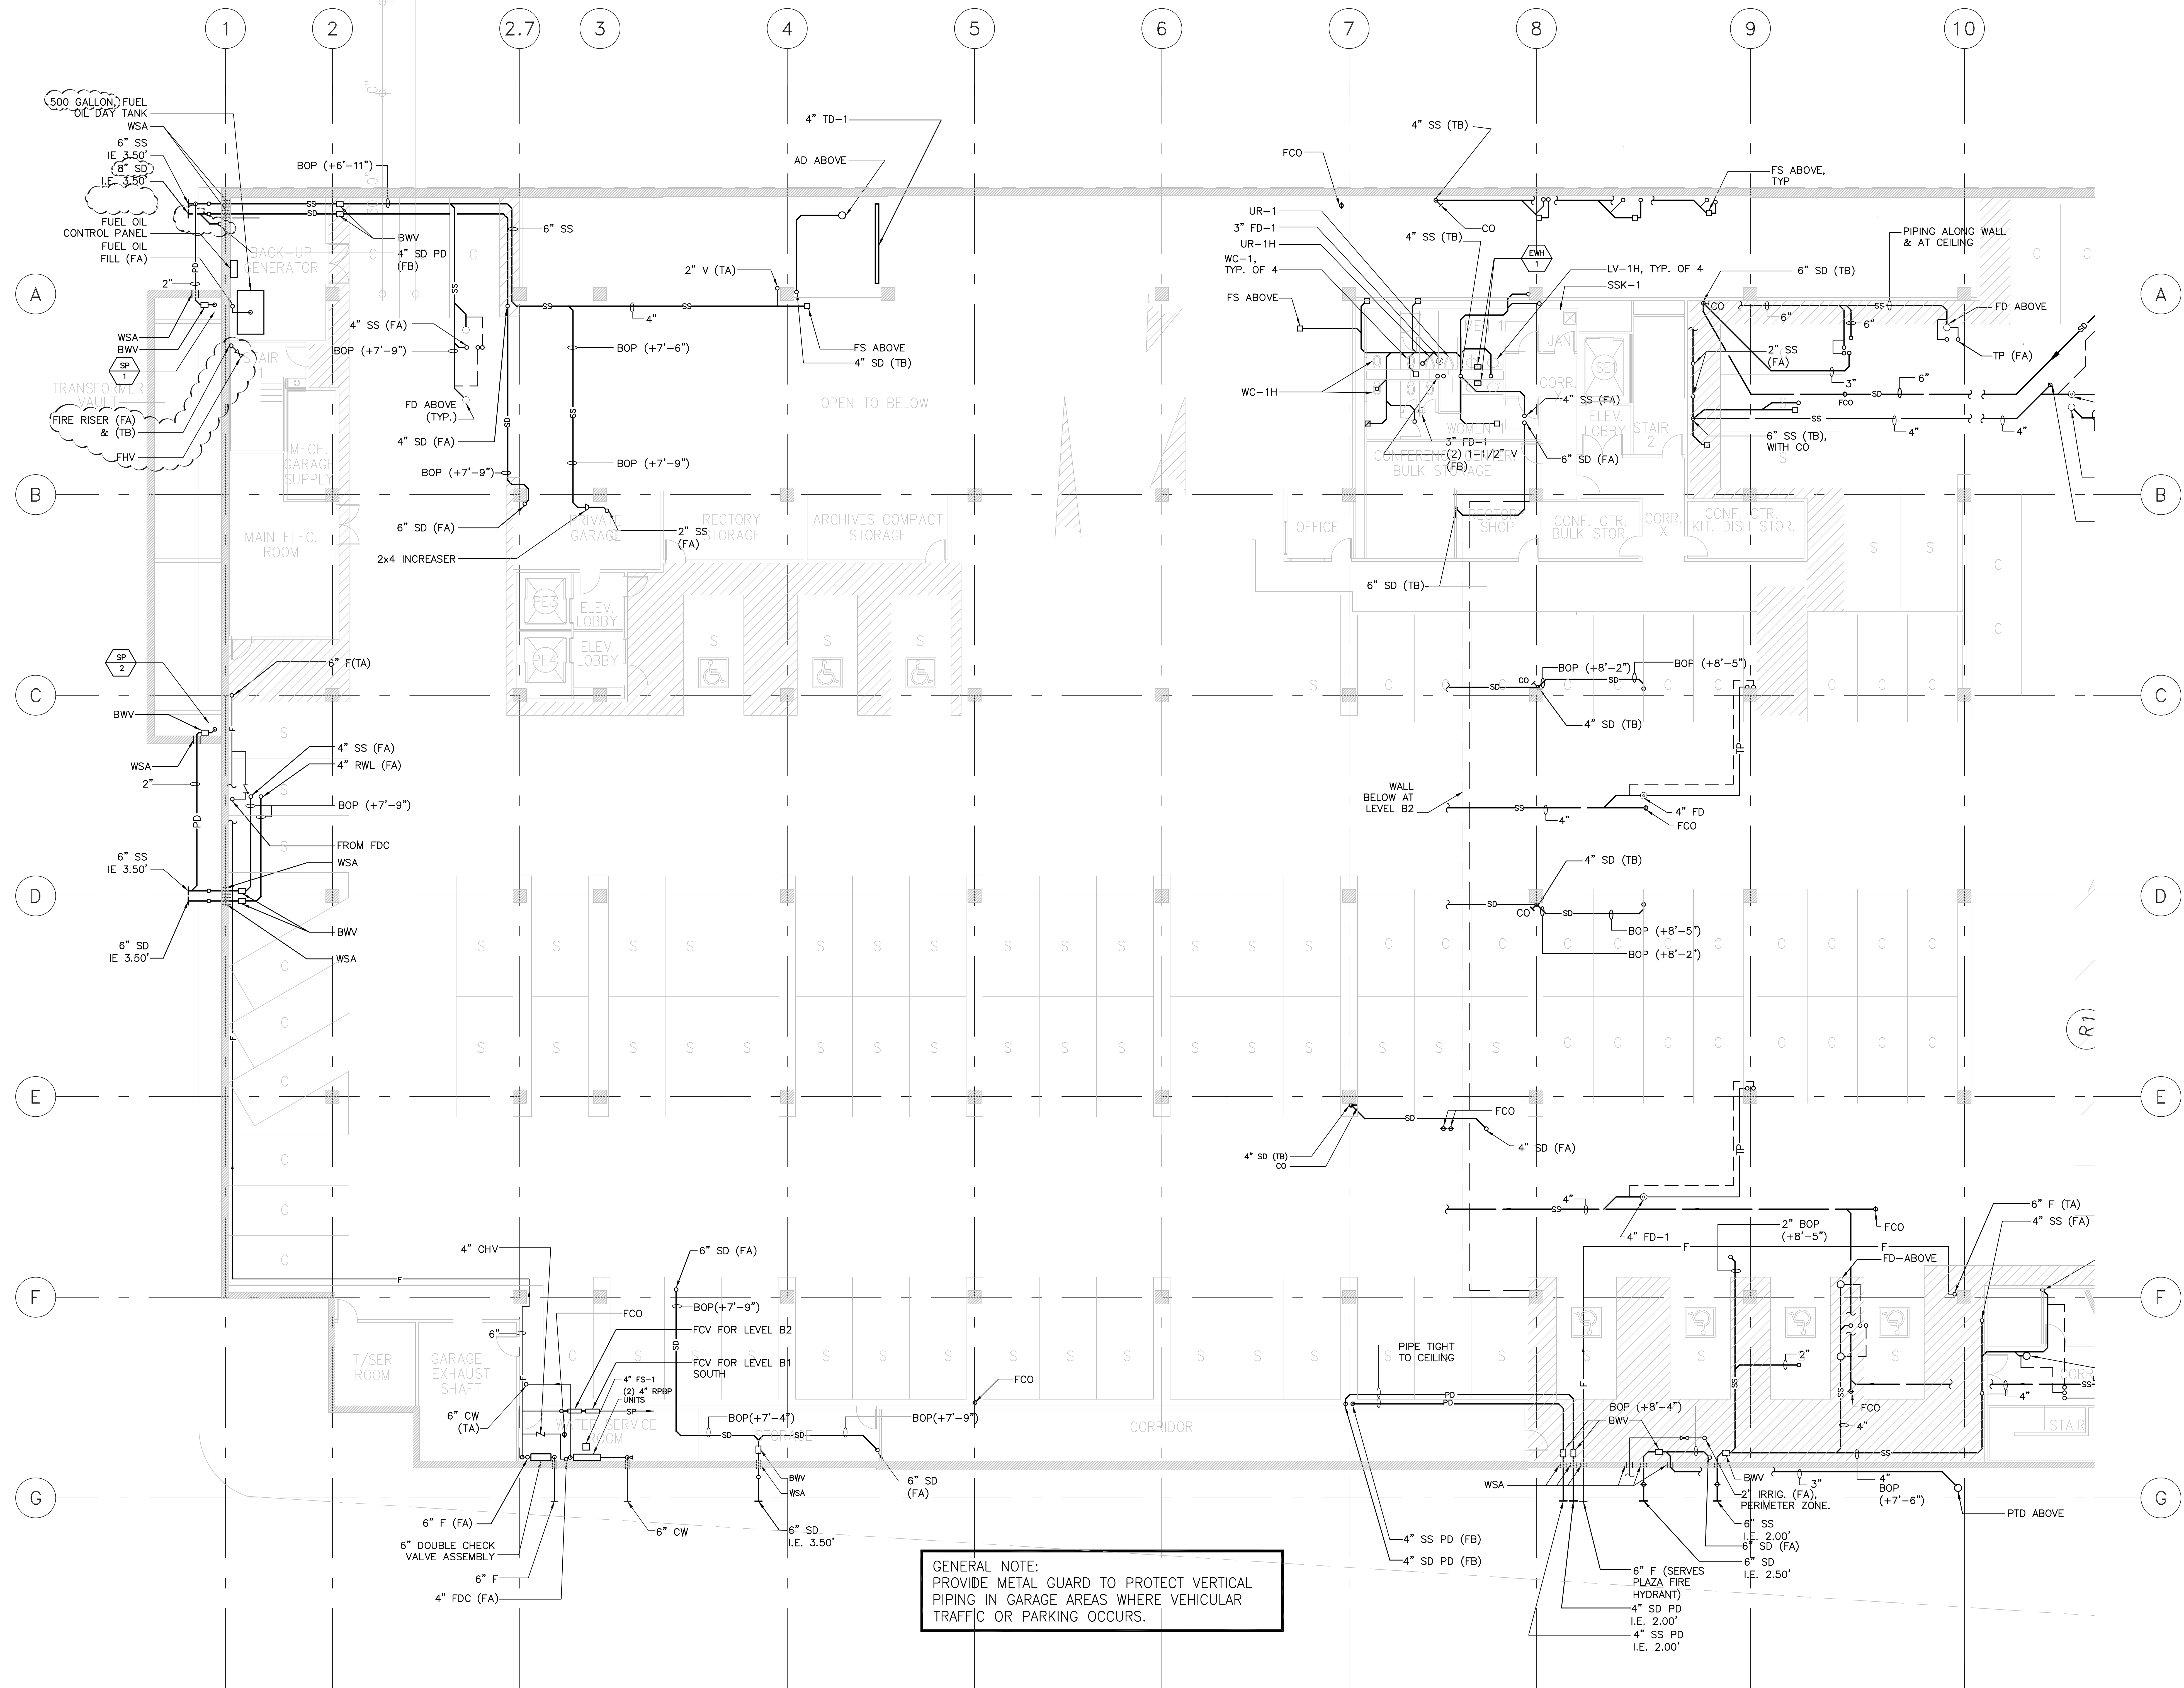

GENERAL NOTE:
 PROVIDE METAL GUARD TO PROTECT VERTICAL
 PIPING IN GARAGE AREAS WHERE VEHICULAR
 TRAFFIC OR PARKING OCCURS.

1 PARTIAL LEVEL B1 PLUMBING PLAN
 P2.B1.1 1/8" = 1'-0"

No.	Date	Issue
03-01-2005		ISSUED FOR BID PACKAGE NO.1
03-24-2005		BID PACKAGE NO.1-ADDENDUM NO. 2

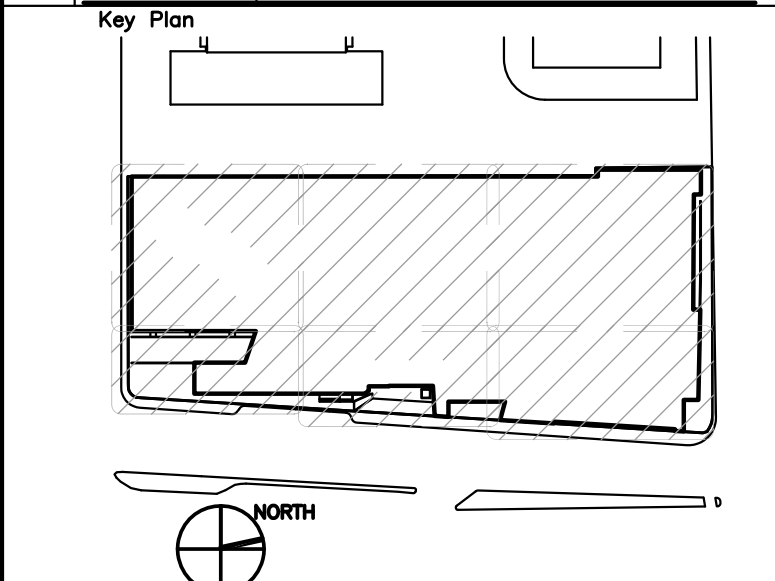


FILE NAME

Drawing Title
**PARTIAL BASEMENT
 PLUMBING PLAN
 LEVEL B1**

Project Number
 KHA 03044


Drawing No.
P2.B1.2

1/8"=1'-0" 1

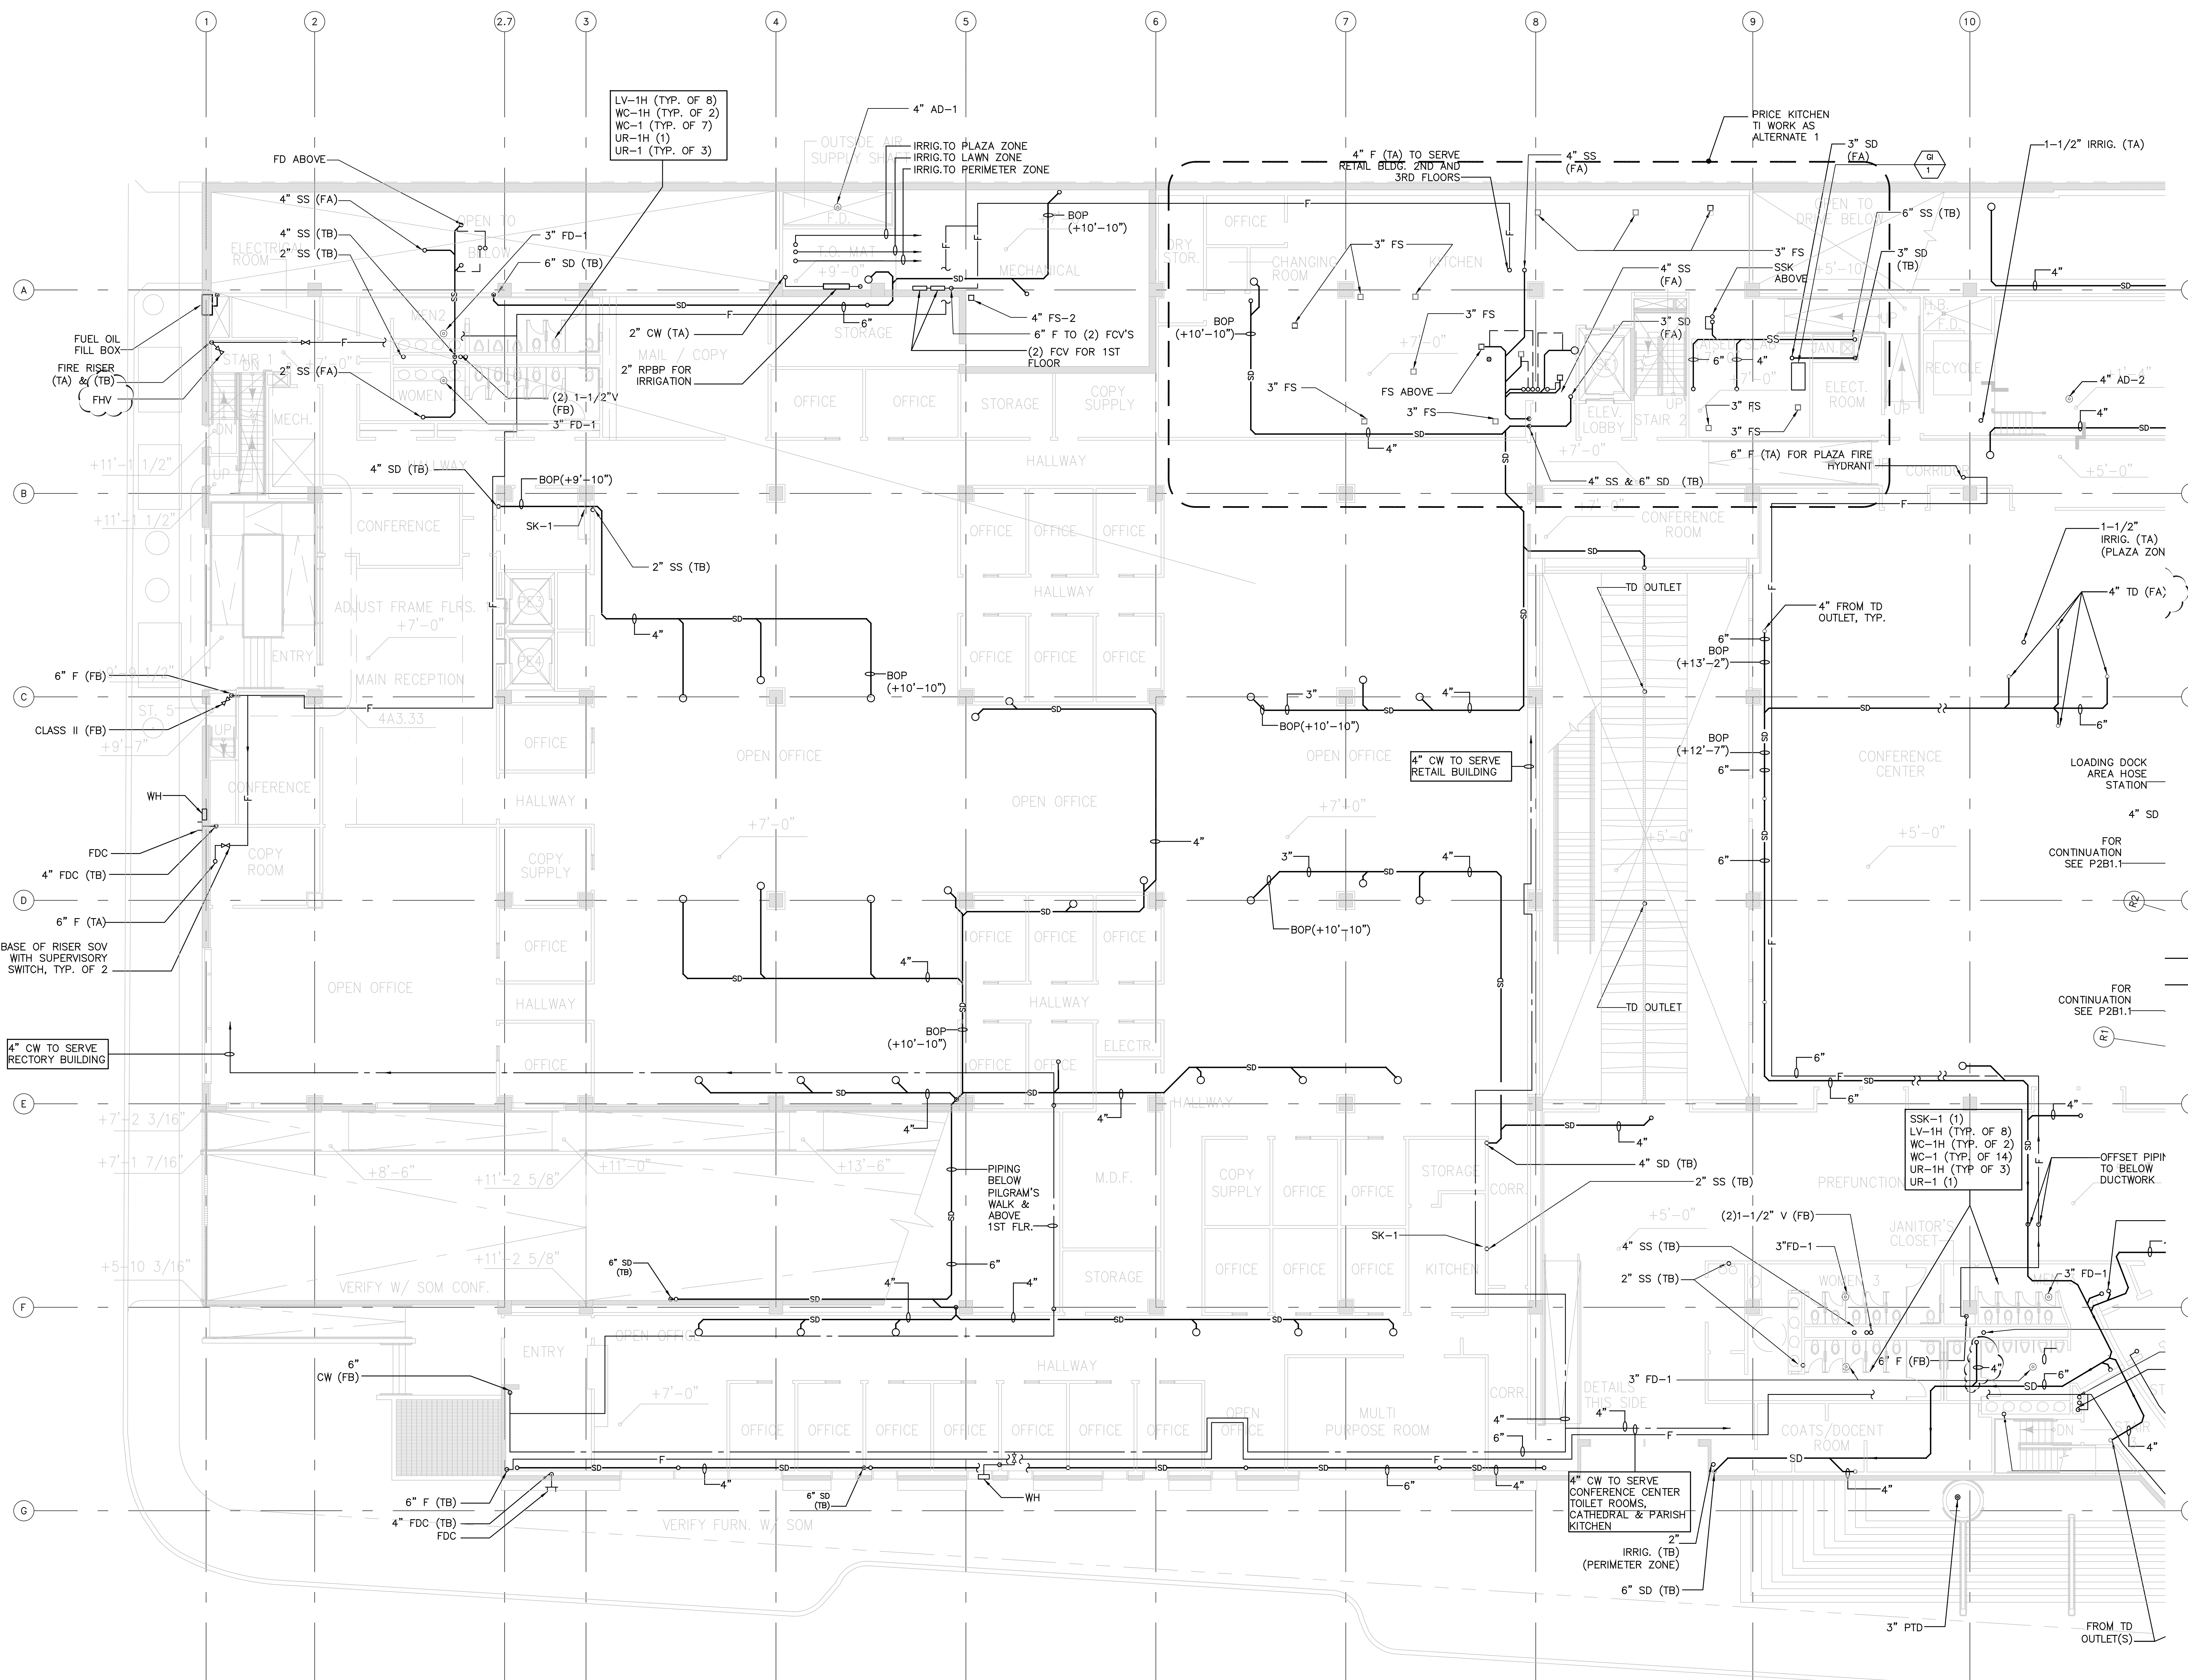

1 PARTIAL FIRST FLOOR PLUMBING PLAN
 P2.1.3 1/8" = 1'-0"


No.	Date	Issue
03-01-2005		ISSUED FOR BID PACKAGE NO.1
03-24-2005		BID PACKAGE NO.1-ADDENDUM NO. 2

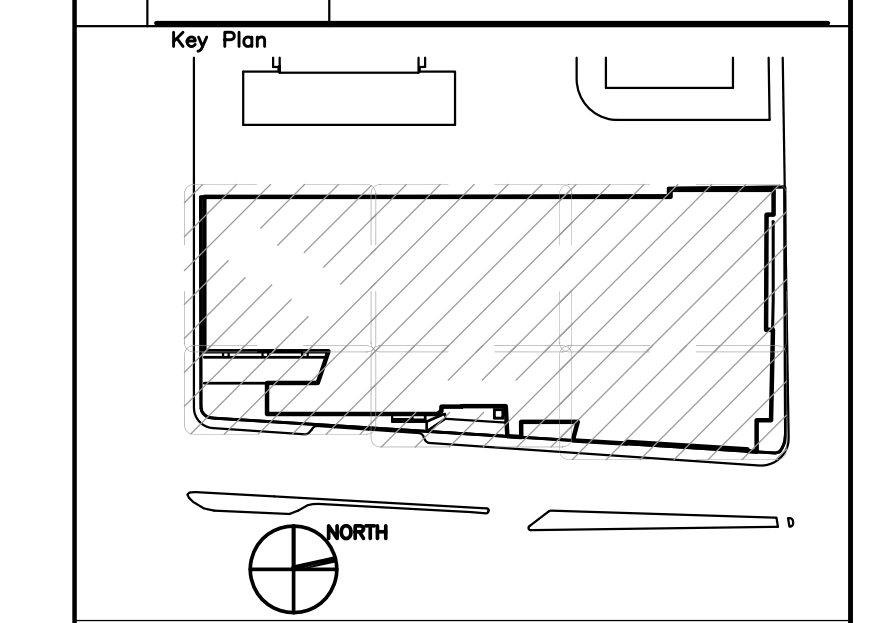

Drawing Title	
PARTIAL 1ST FLOOR PLUMBING PLAN	
Project Number	Drawing No.
KHA 03044	P2.1.3

M. Adobe PDF.

XFA

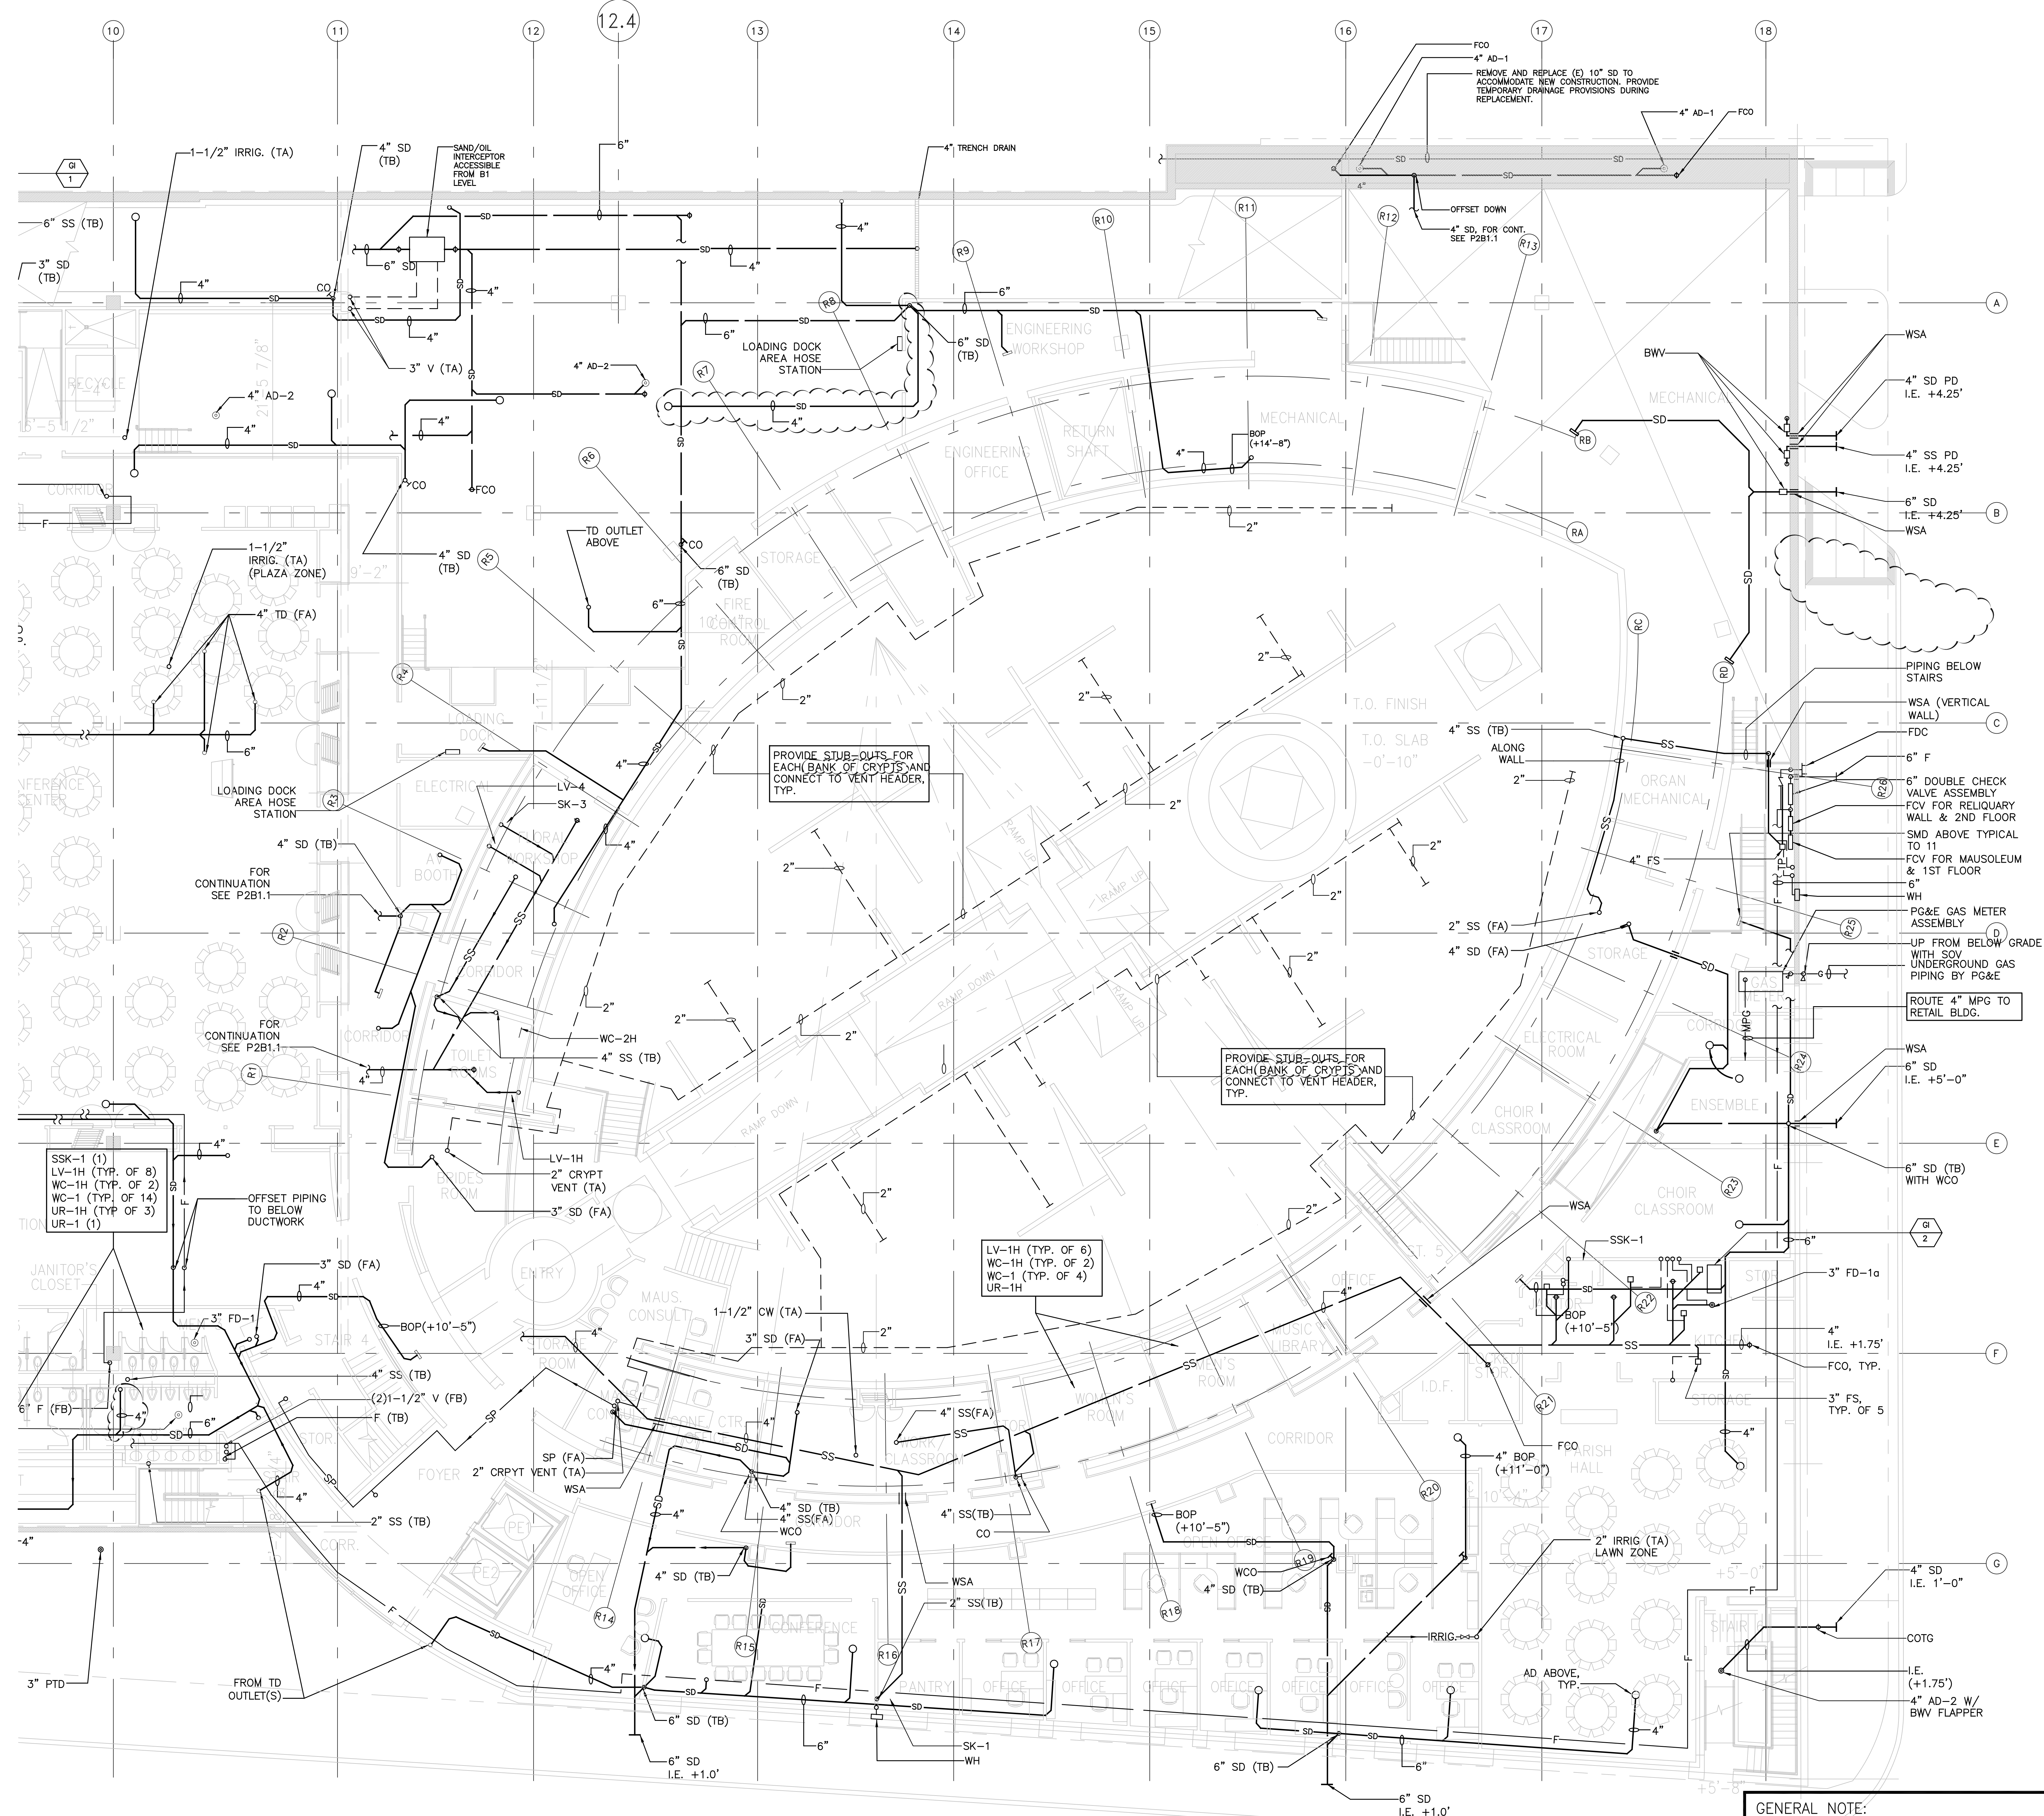

PROVIDE STUB-OUTS FOR EACH BANK OF CRYPTS AND CONNECT TO VENT HEADER, TYP.


PROVIDE STUB-OUTS FOR EACH BANK OF CRYPTS AND CONNECT TO VENT HEADER, TYP.

SSK-1 (1)
LV-1H (TYP. OF 8)
WC-1H (TYP. OF 2)
WC-1 (TYP. OF 14)
UR-1H (TYP. OF 3)
UR-1 (1)

LV-1H (TYP. OF 6)
WC-1H (TYP. OF 2)
WC-1 (TYP. OF 4)
UR-1H

GENERAL NOTE:
PROVIDE METAL GUARD TO PROTECT VERTICAL PIPING IN LOADING DOCK AREAS WHERE VEHICULAR TRAFFIC OR PARKING OCCURS.

No.	Date	Issue
03-01-2005		ISSUED FOR BID PACKAGE NO.1
03-24-2005		BID PACKAGE NO.1-ADDENDUM NO. 2

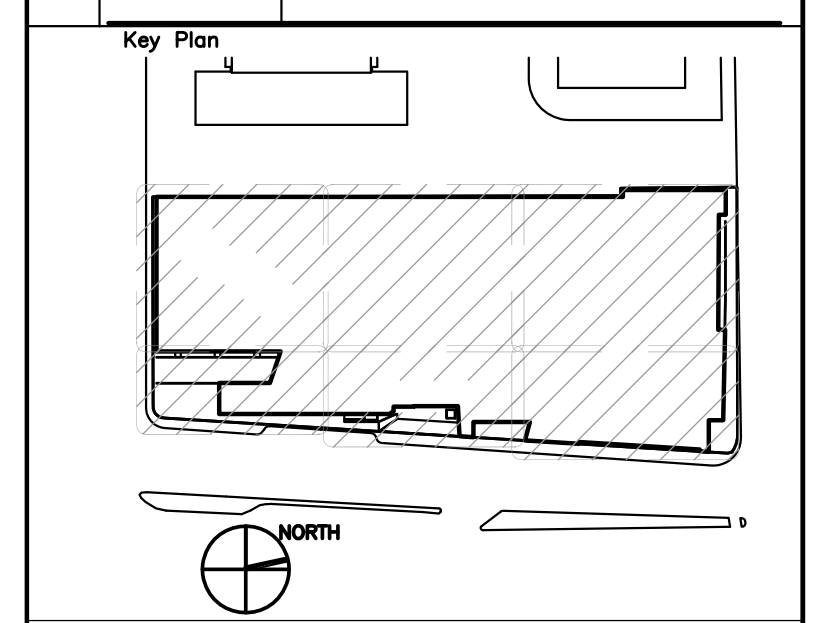

1 PARTIAL FIRST FLOOR PLUMBING PLAN
P2.1.4 1/8" = 1'-0"

FILE NAME


Drawing Title

PARTIAL 1ST FLOOR PLUMBING PLAN

Project Number: KHA 03044

Drawing No.: P2.1.4


1/8" = 1'-0" 1

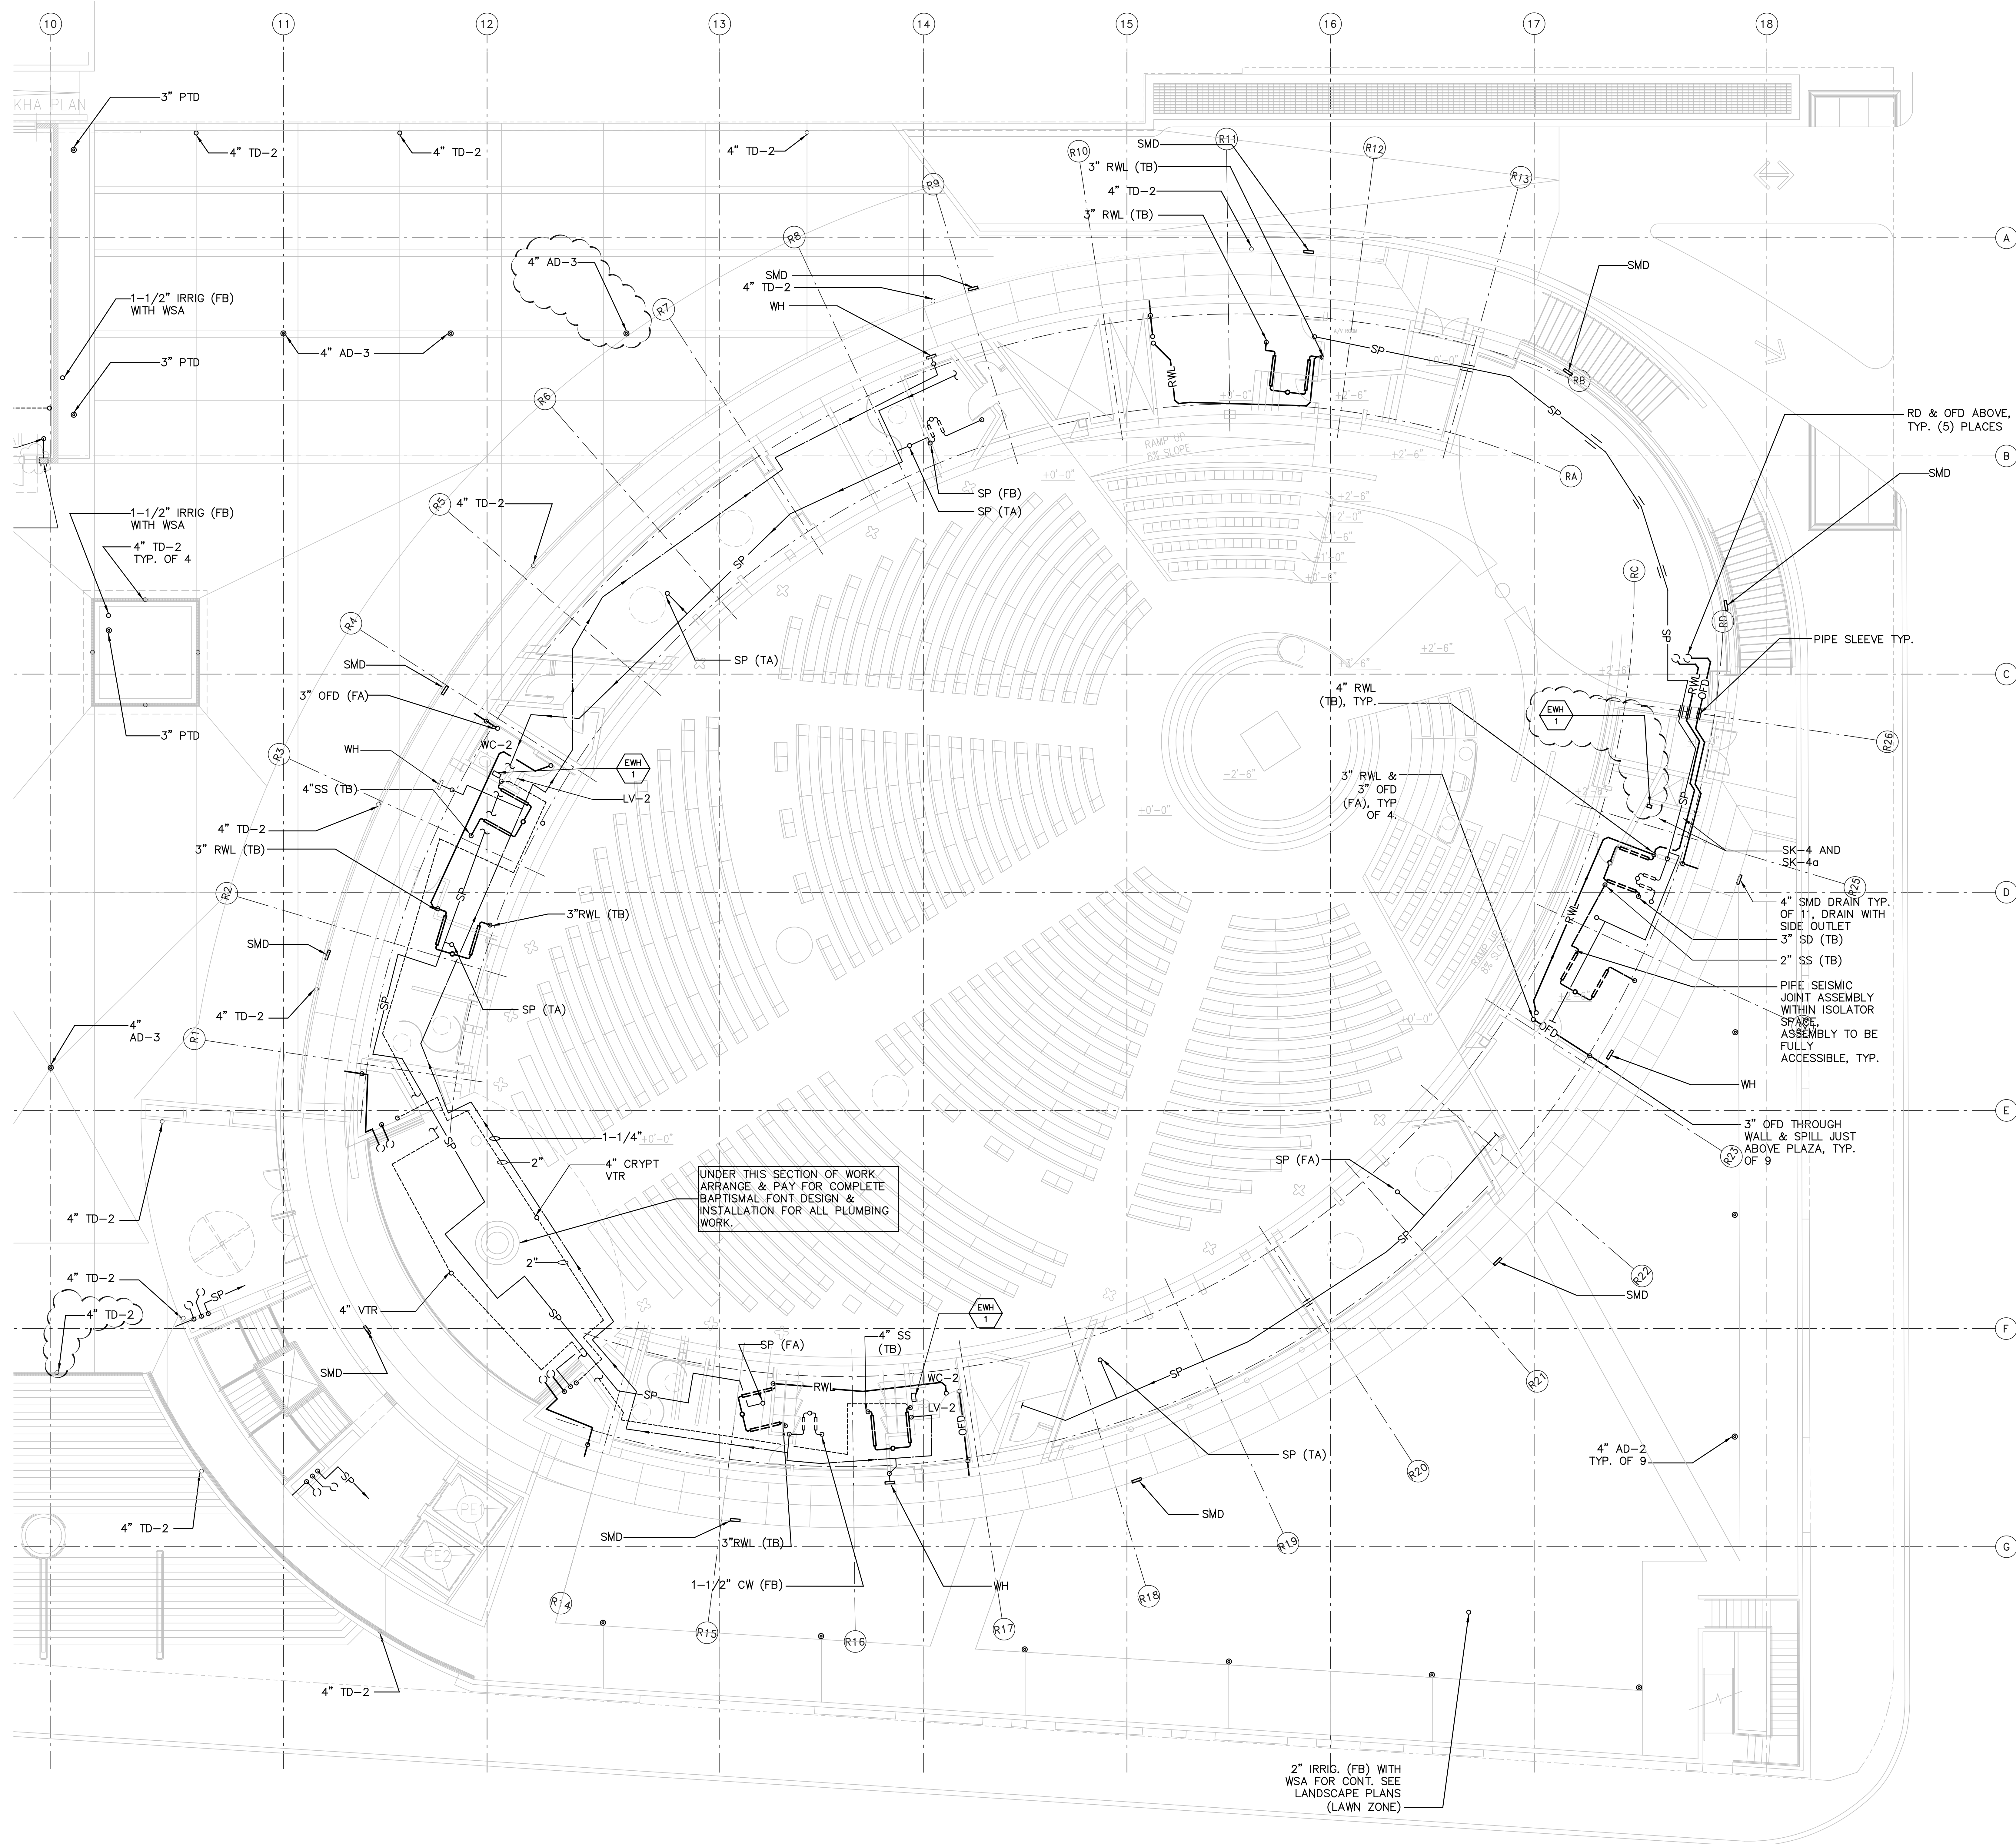

UNDER THIS SECTION OF WORK
ARRANGE & PAY FOR COMPLETE
BAPTISMAL FONT DESIGN &
INSTALLATION FOR ALL PLUMBING
WORK.

1 PARTIAL SECOND FLOOR PLUMBING PLAN
P2.2.4 1/8" = 1'-0"

No.	Date	Issue
03-01-2005		ISSUED FOR BID PACKAGE NO.1
03-24-2005		BID PACKAGE NO.1-ADDENDUM NO. 2

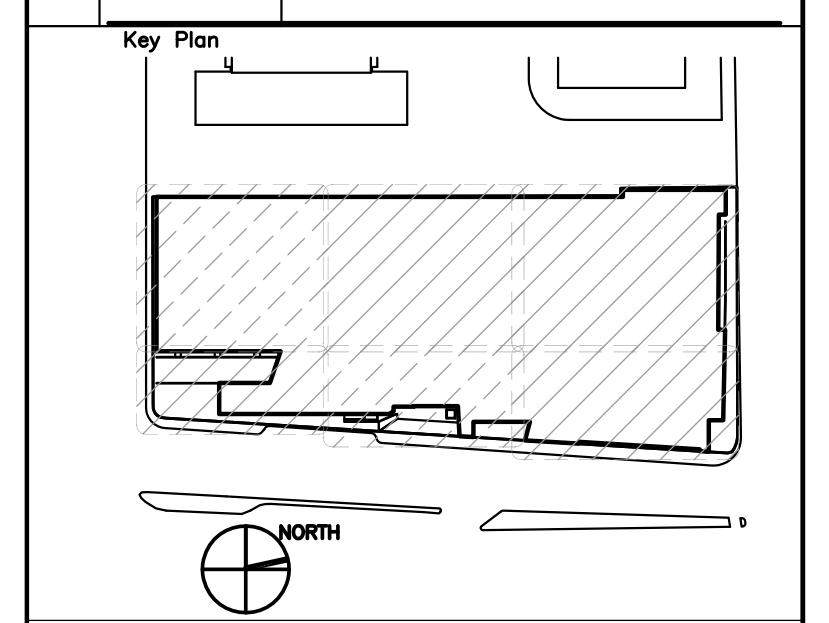


Drawing Title
**PARTIAL
2ND FLOOR
PLUMBING PLAN**

Project Number
KHA 03044


Drawing No.
P2.2.4

Ordway Building

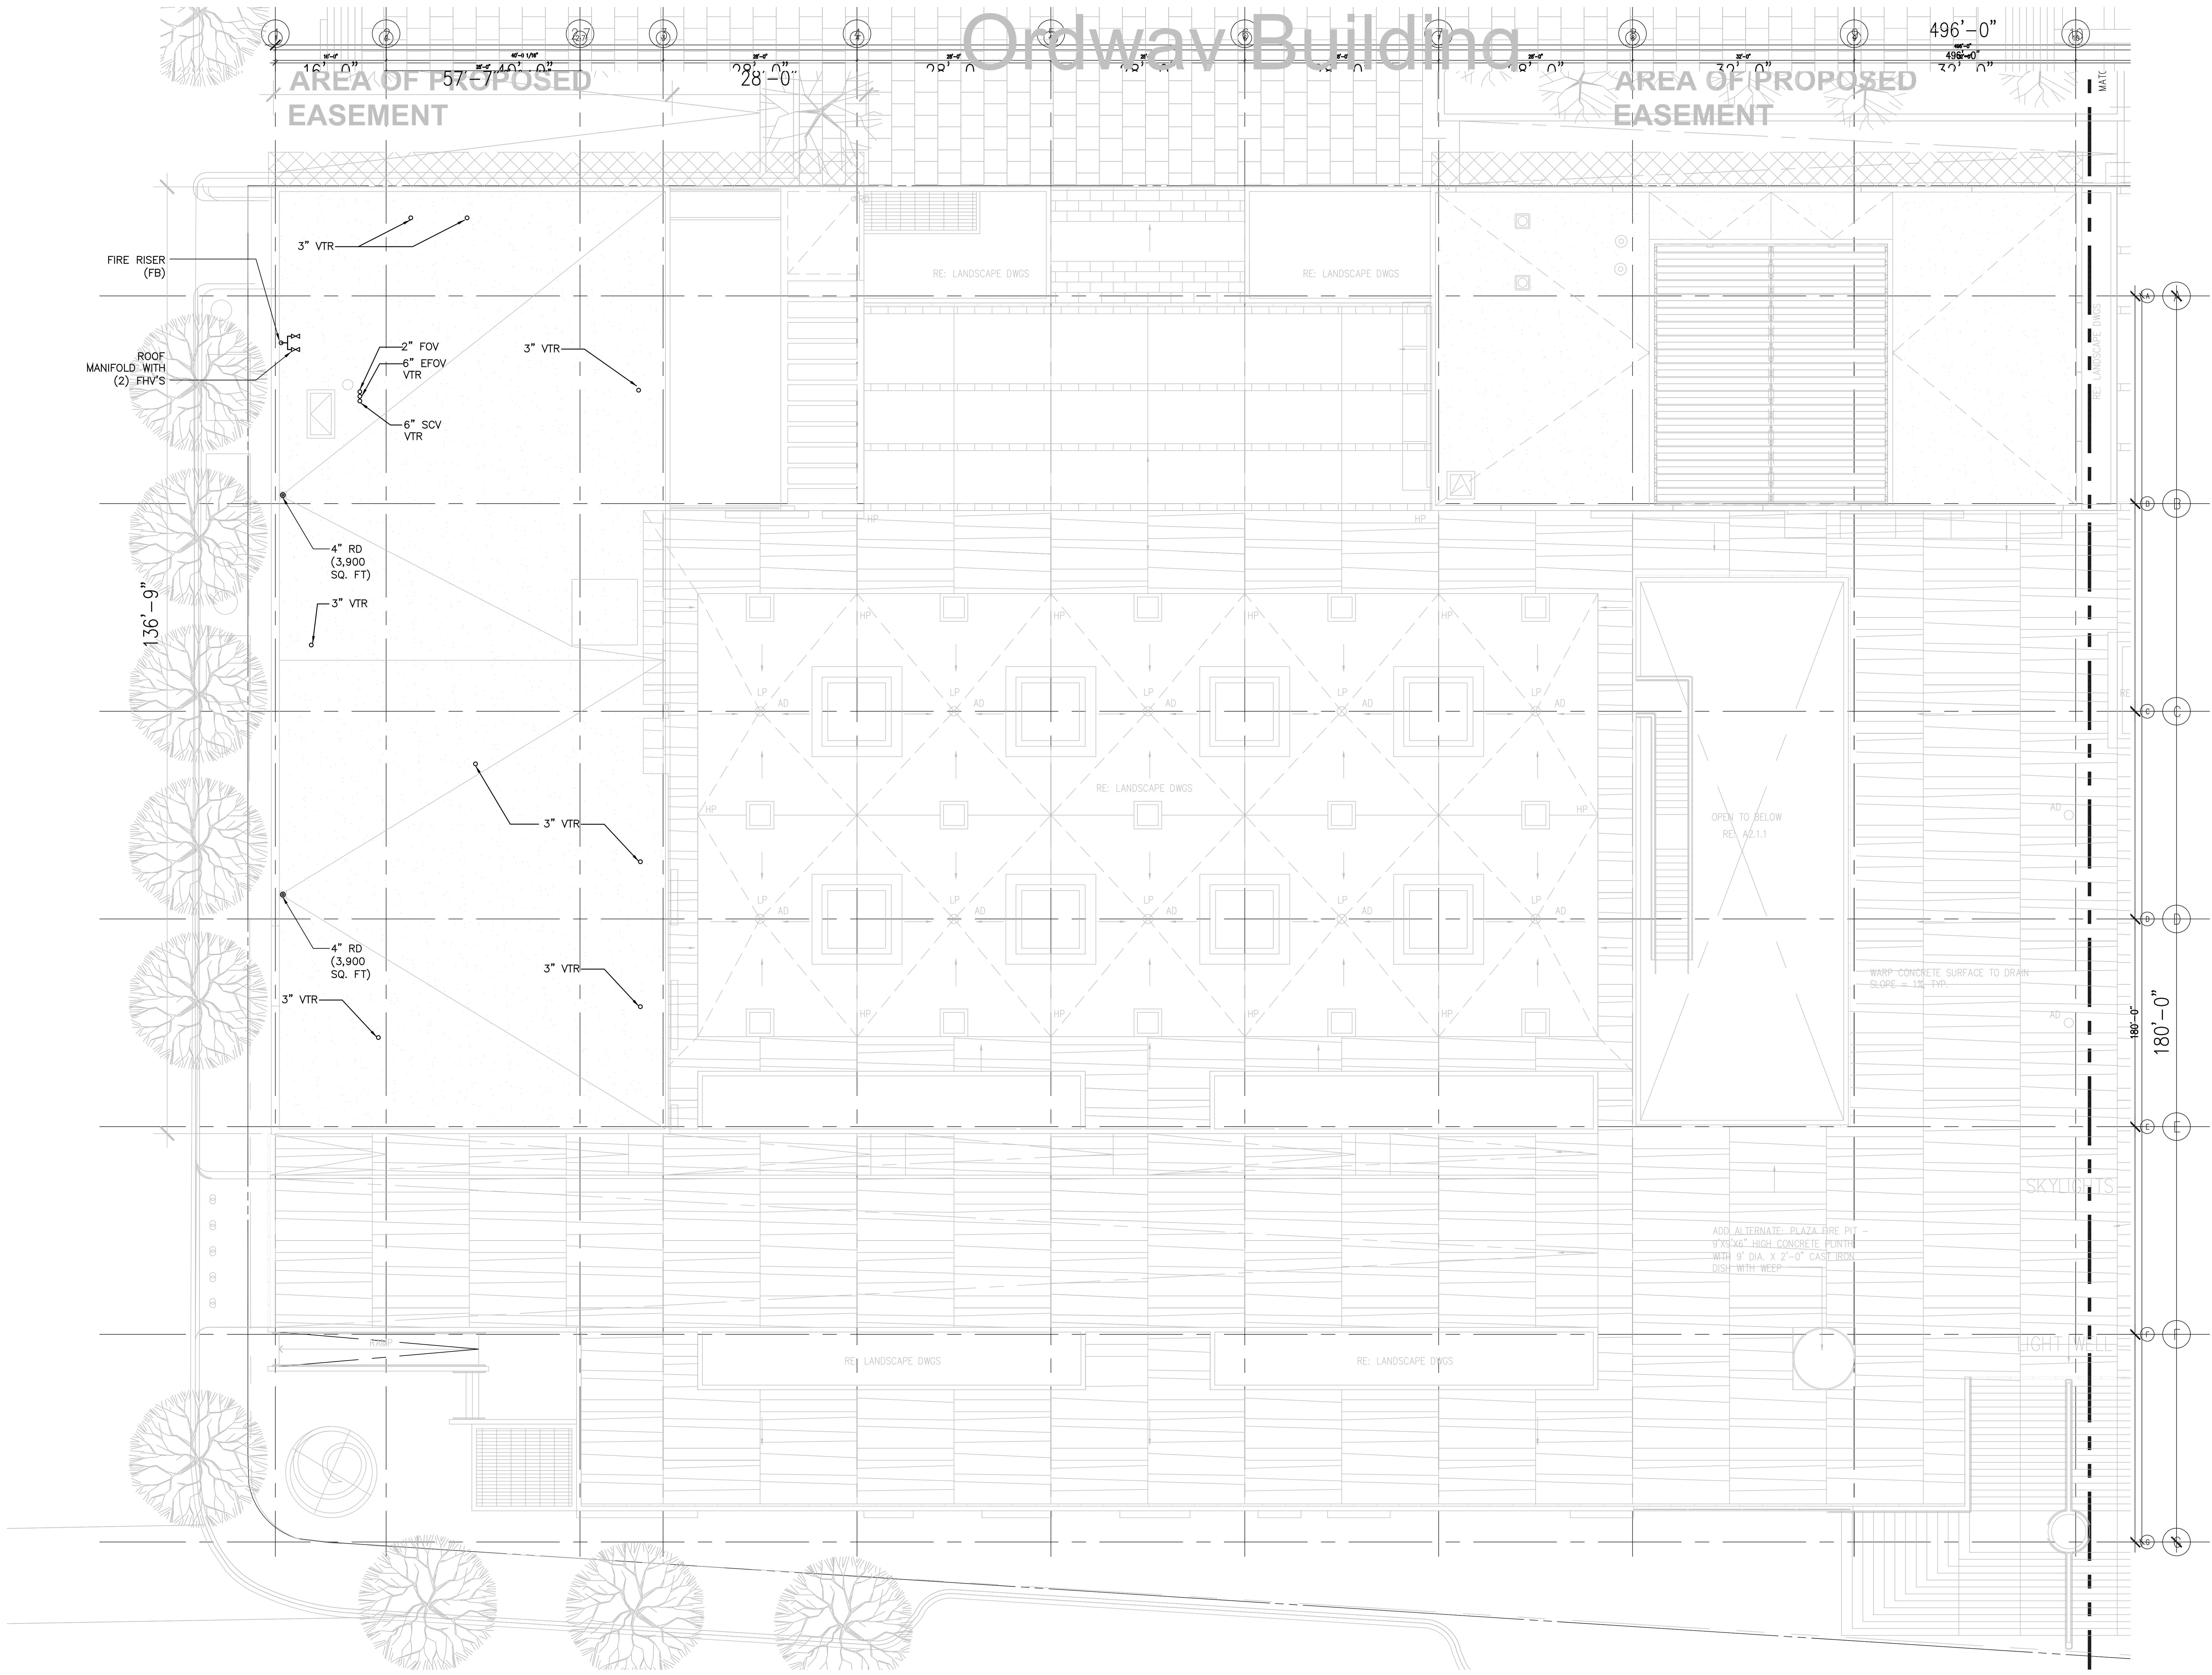

1 PARTIAL ROOF PLUMBING PLAN
 P2.5.3 1/8" = 1'-0"


No.	Date	Issue
03-01-2005		ISSUED FOR BID PACKAGE NO.1
03-24-2005		BID PACKAGE NO.1-ADDENDUM NO. 2

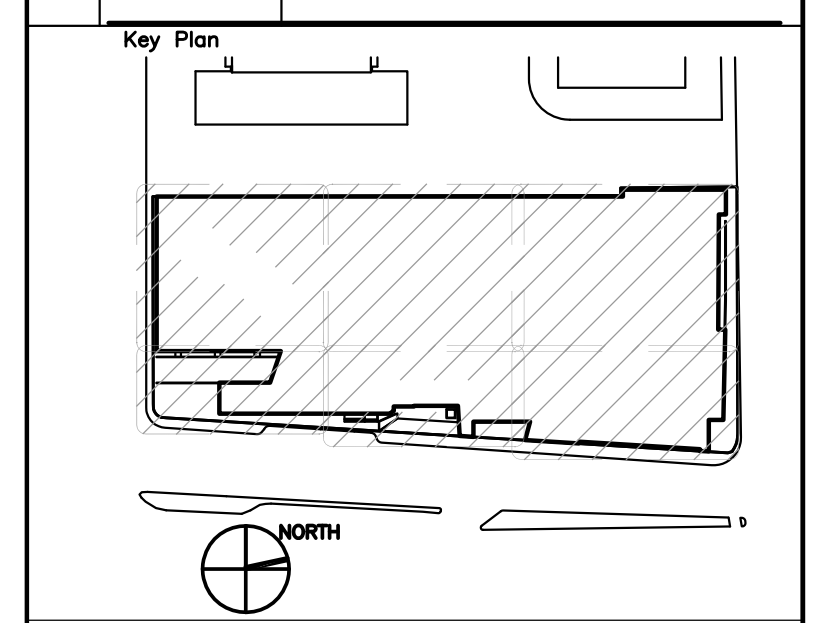


FILE NAME

Drawing Title
PARTIAL ROOF PLUMBING PLAN


Project Number: KHA 03044
 Drawing No.: P2.5.3

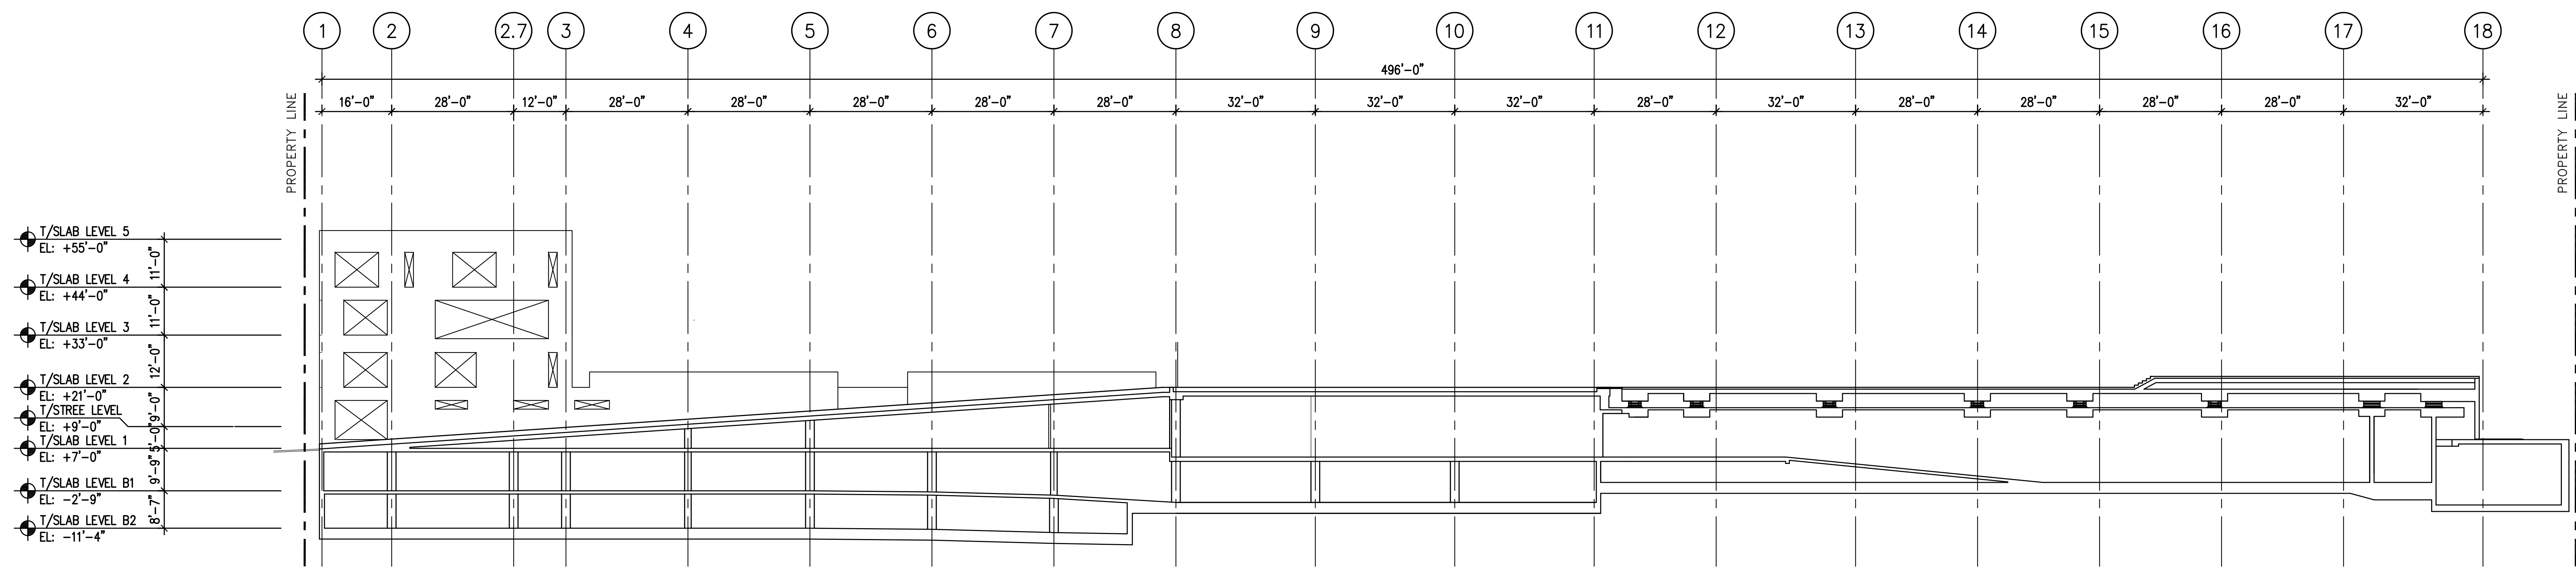


OVERALL SITE SECTION THROUGH PILGRIMS WALK
SCALE: 1/16" = 1'-0"
S300-01-04 05

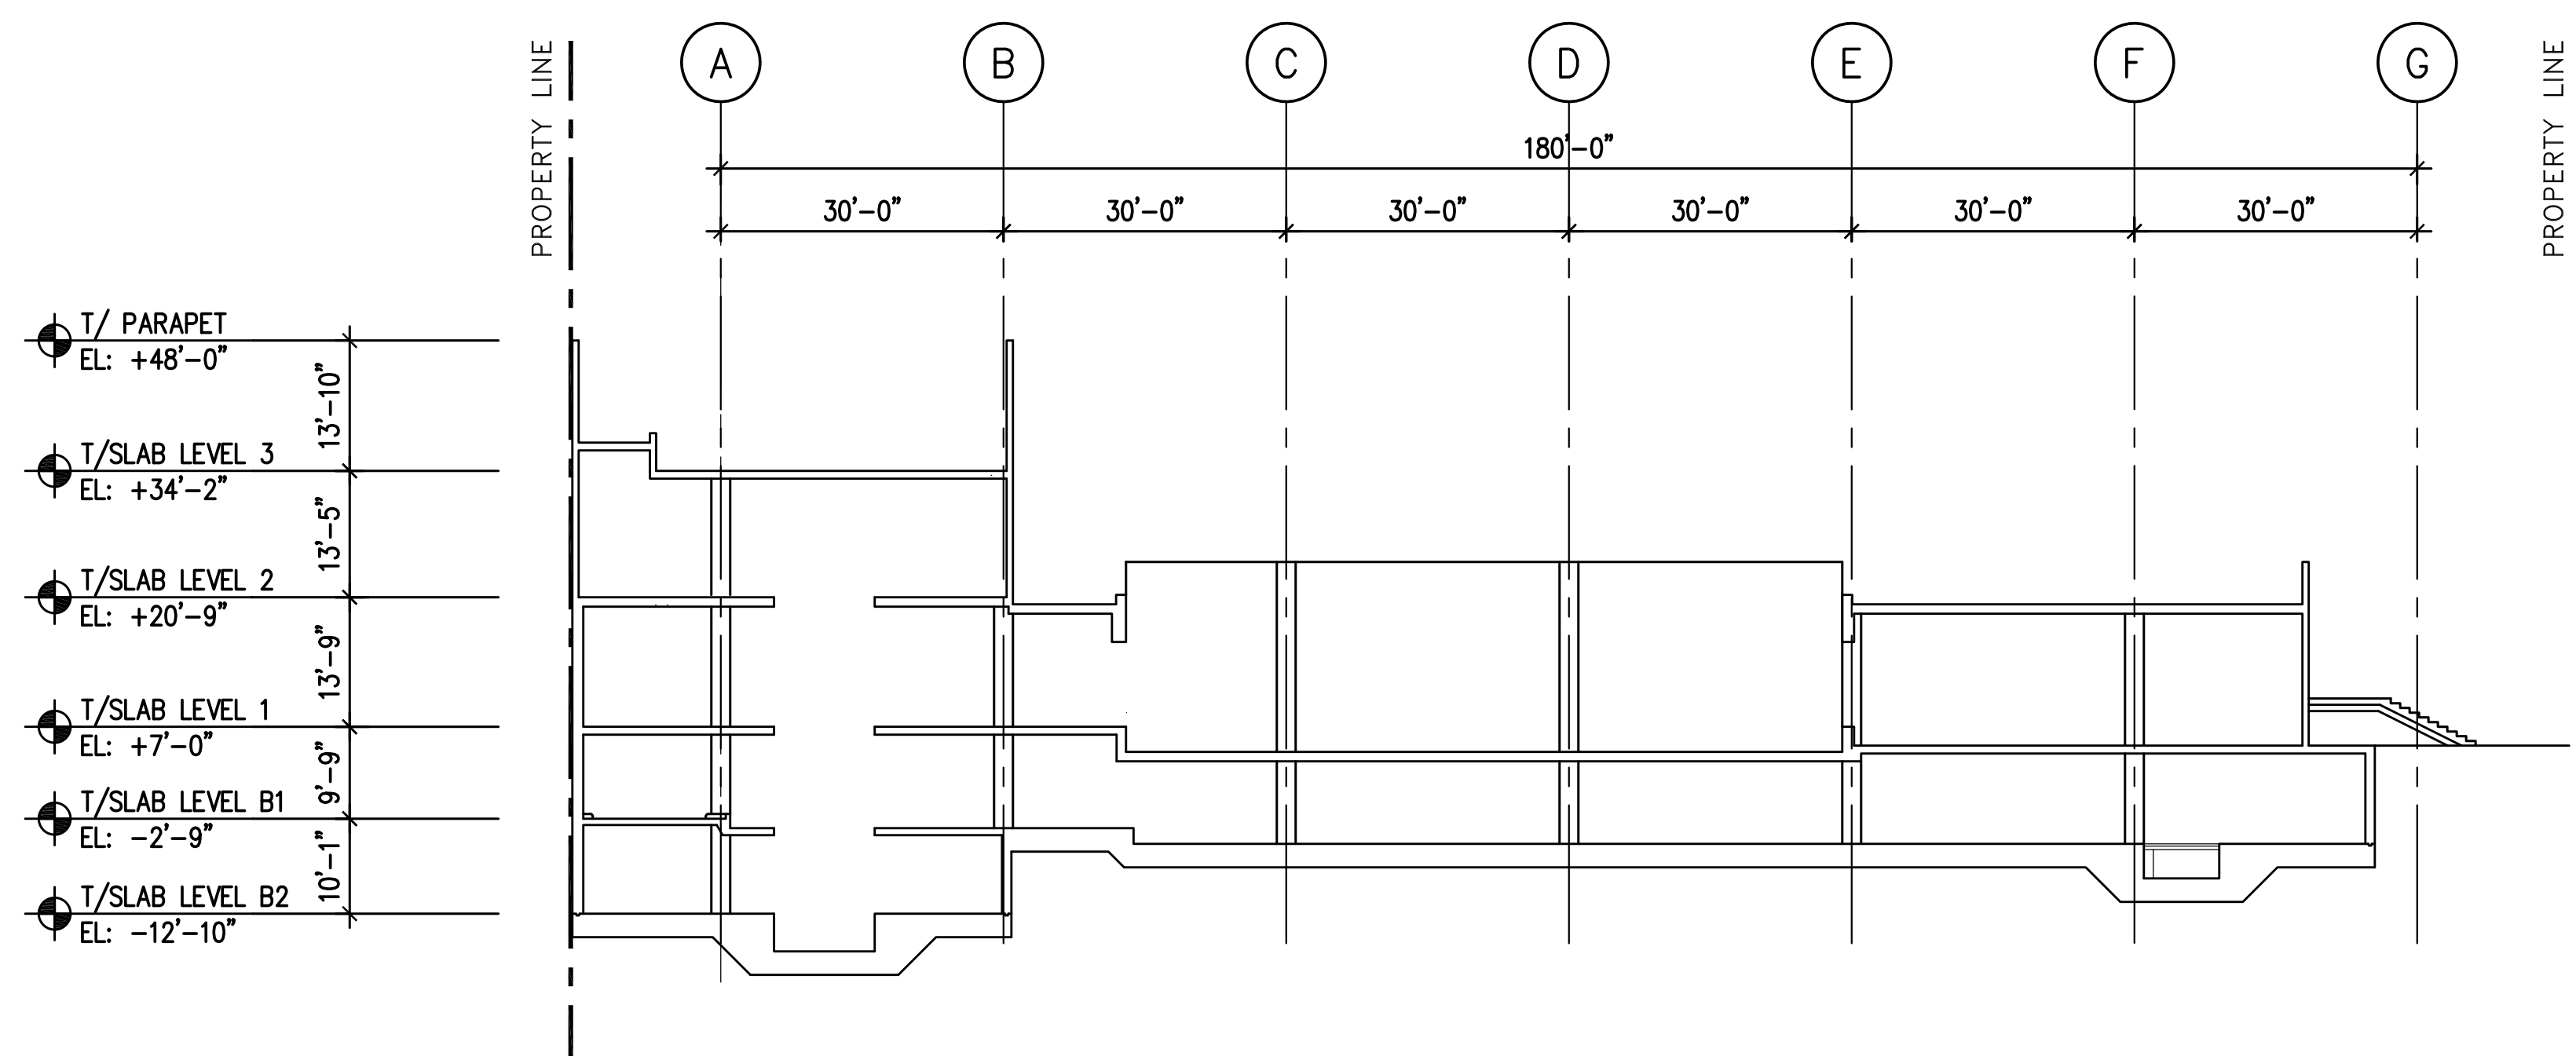


OVERALL SITE SECTION BETWEEN GRIDLINE 8 AND 9
SCALE: 1/16" = 1'-0"
S300-01-04 21

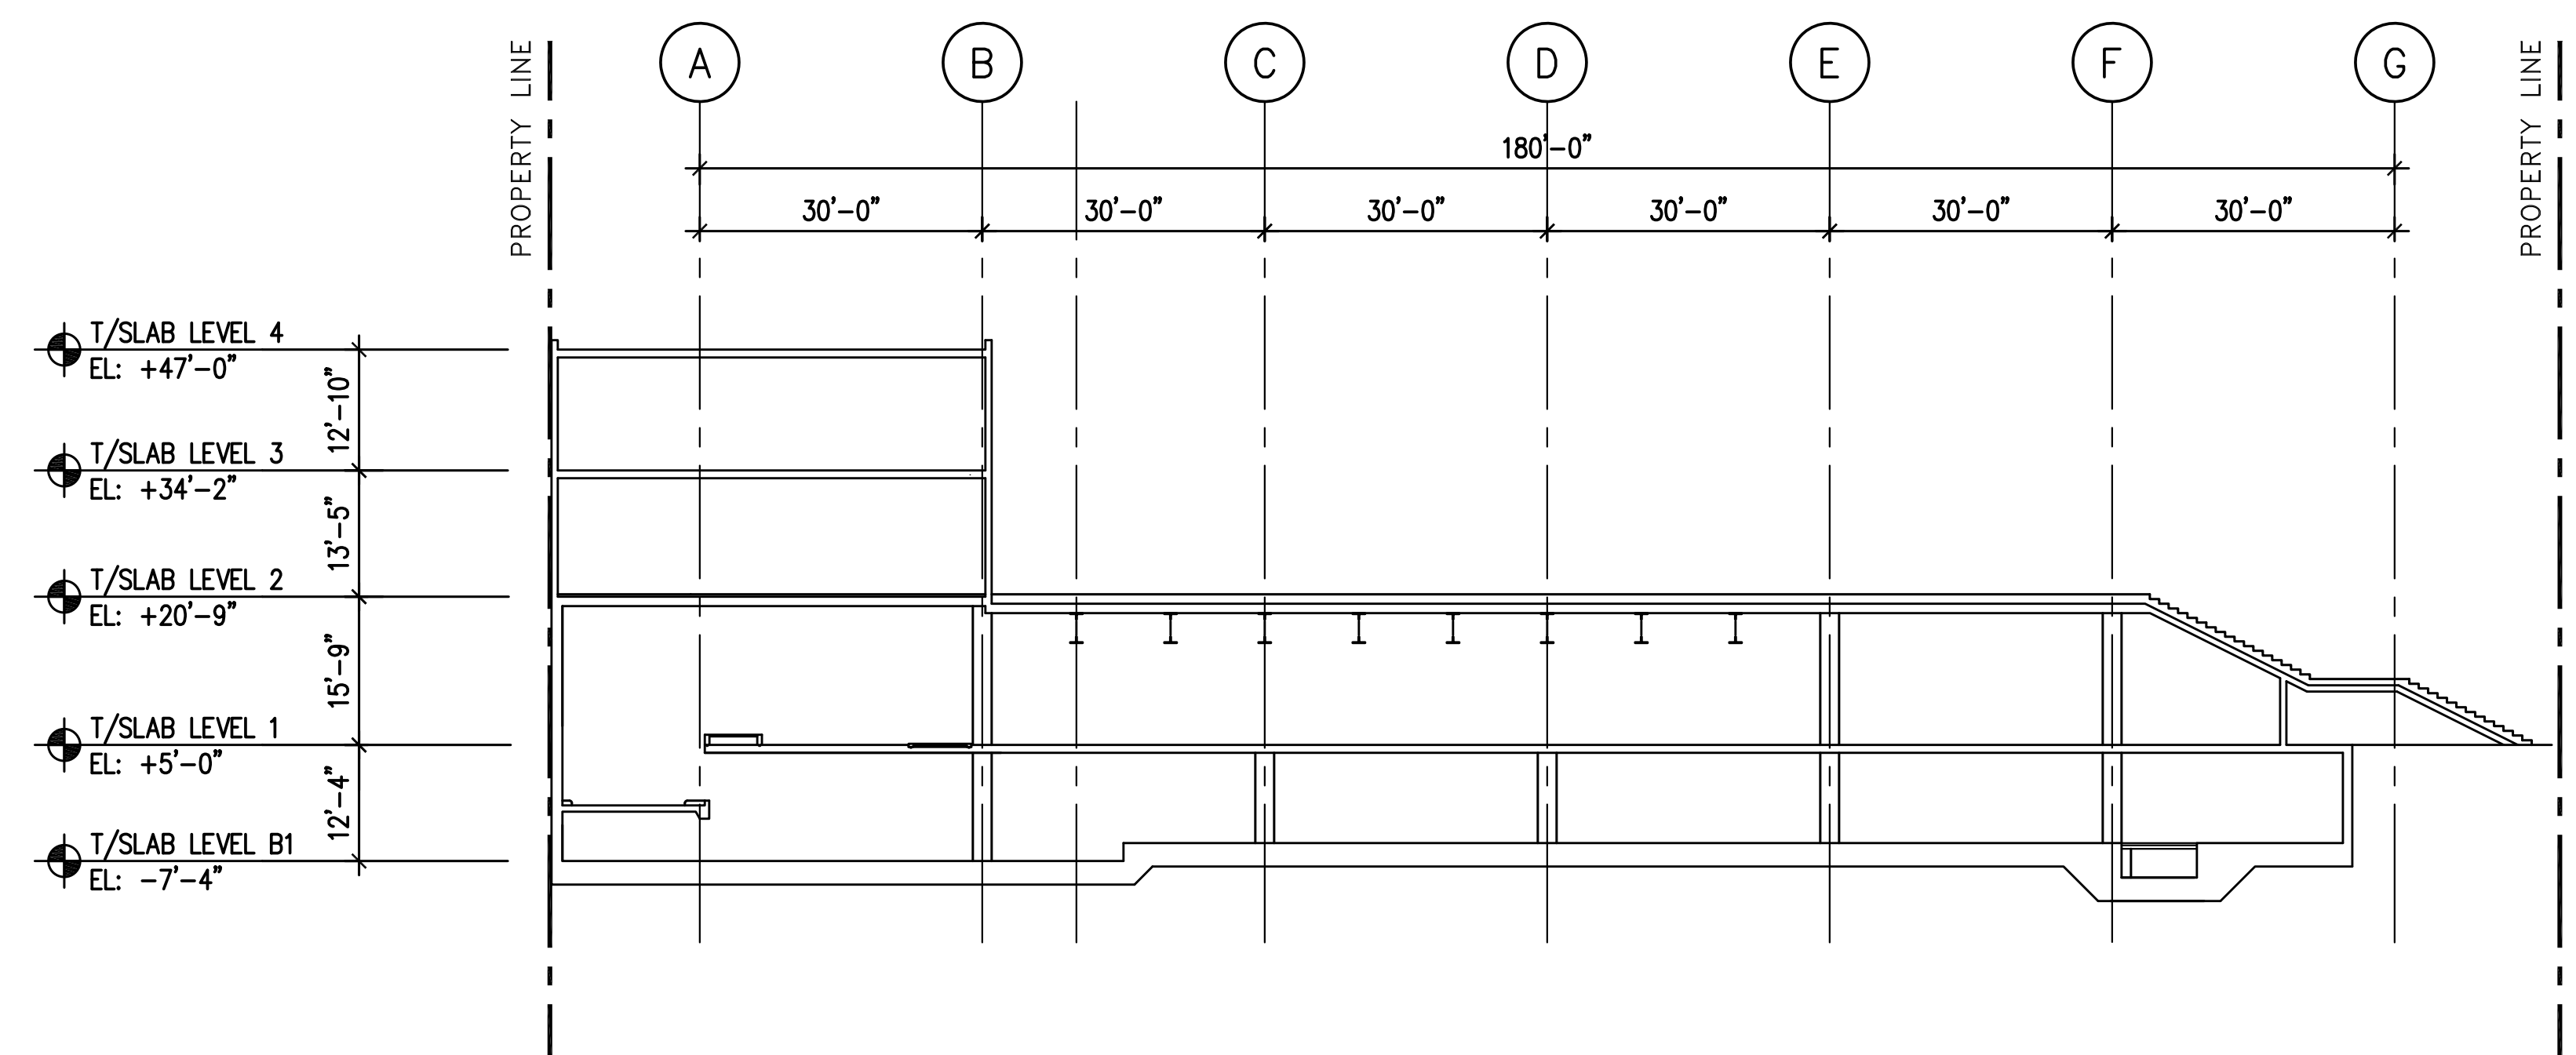

OVERALL SITE SECTION BETWEEN GRIDLINE 9 AND 10
SCALE: 1/16" = 1'-0"
S300-01-04 03

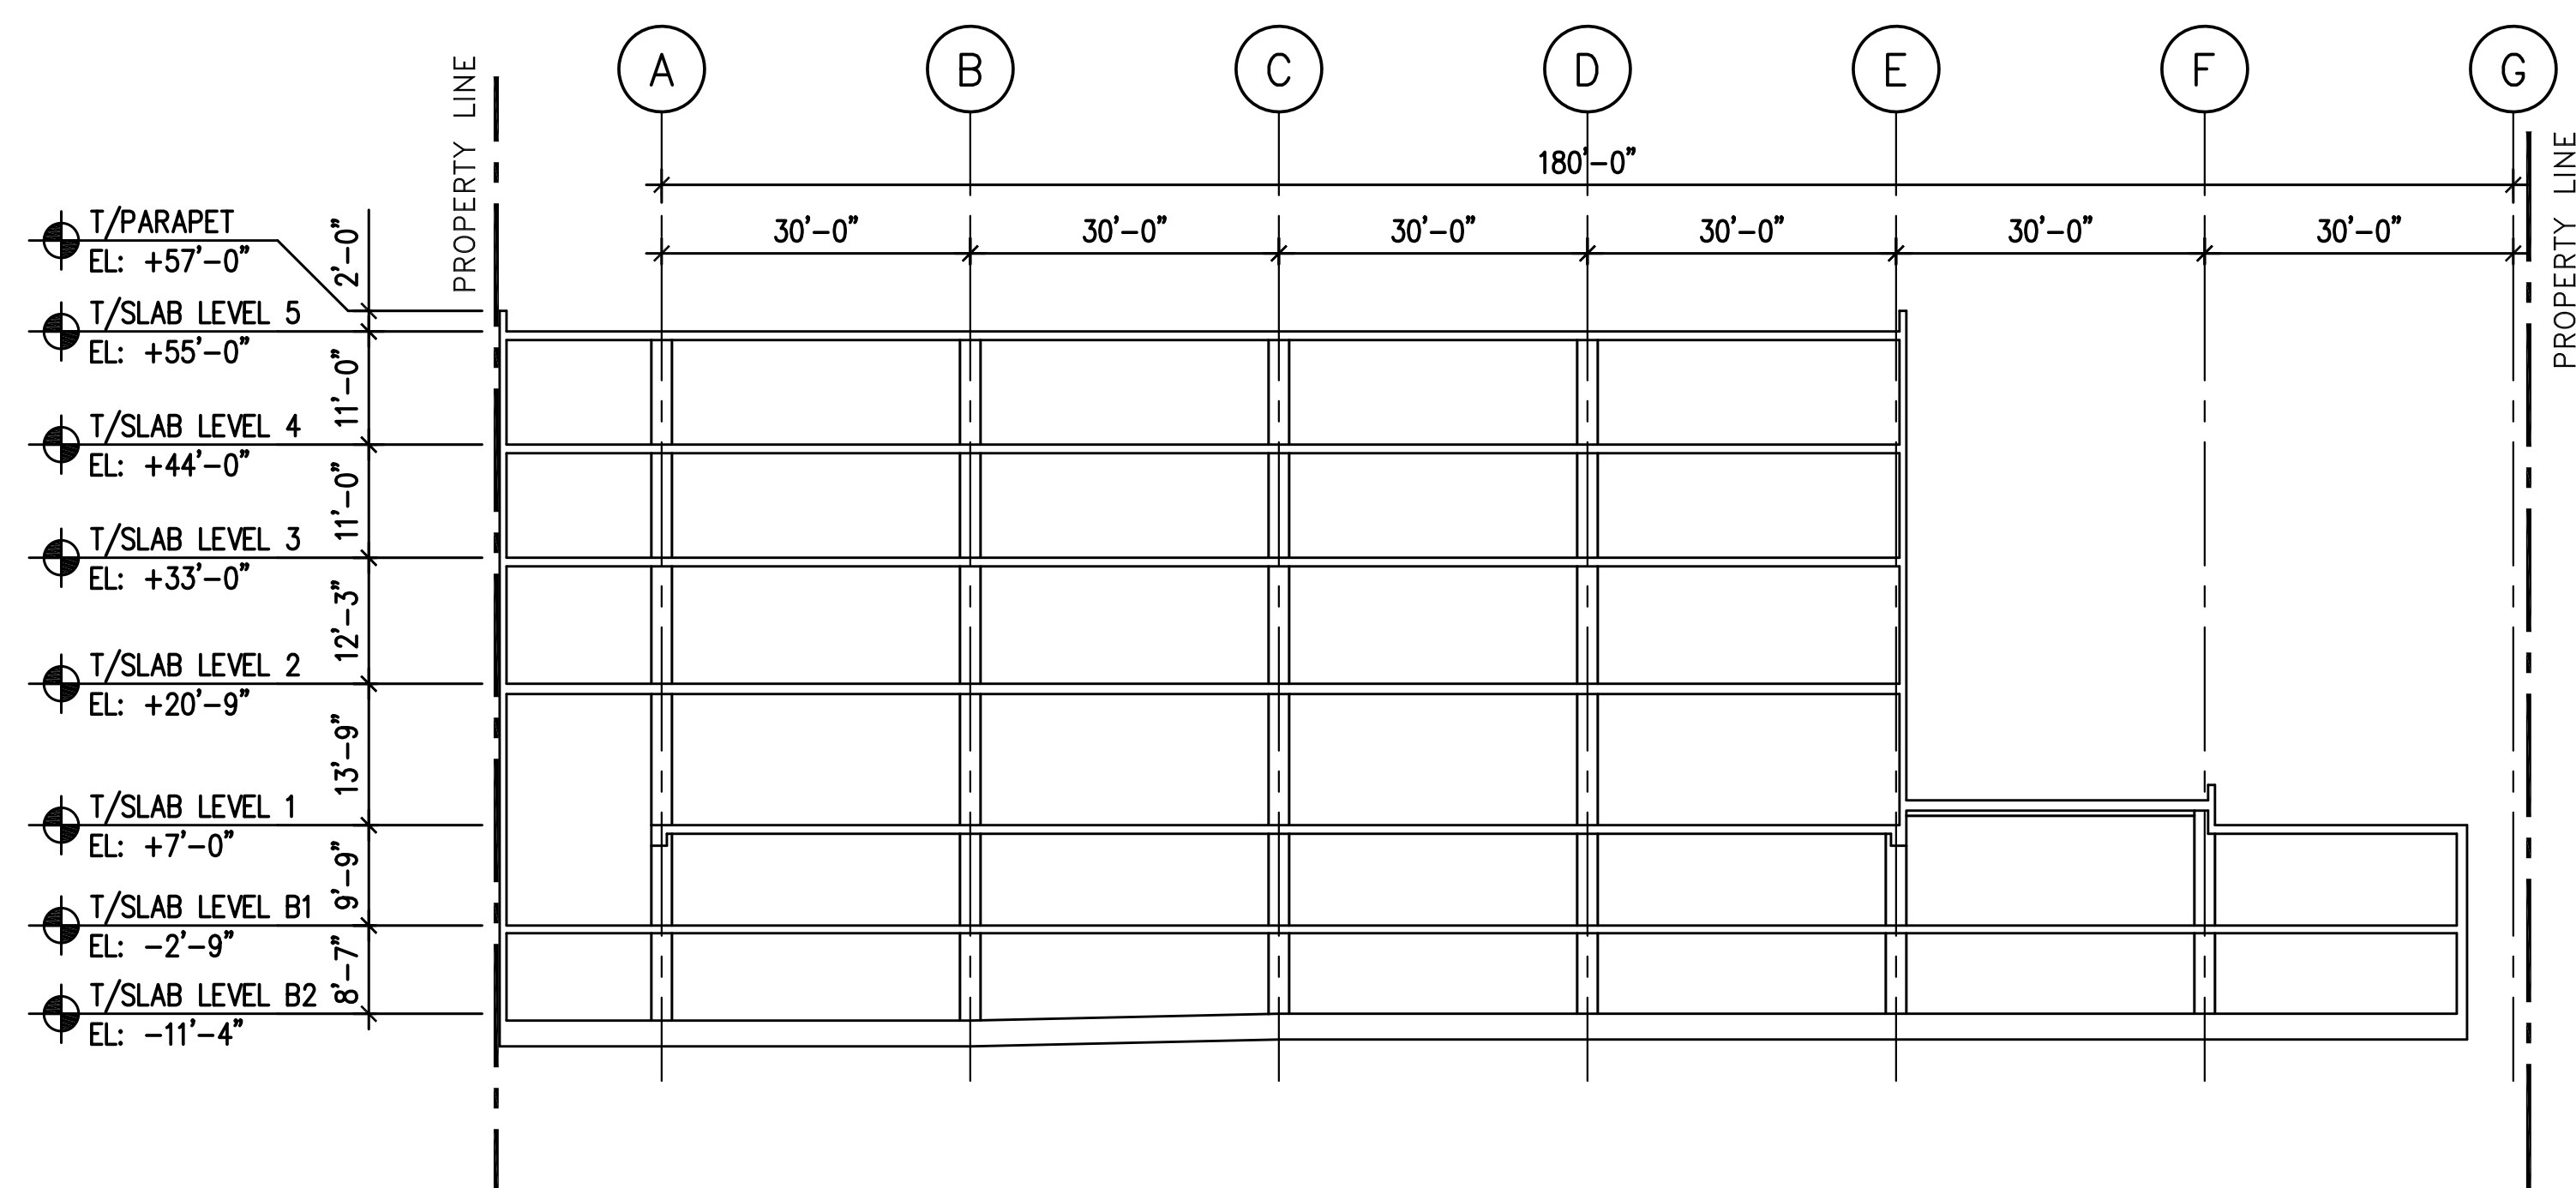


OVERALL SITE SECTION BETWEEN GRIDLINE 2 AND 2.7
SCALE: 1/16" = 1'-0"
S300-01-04 19

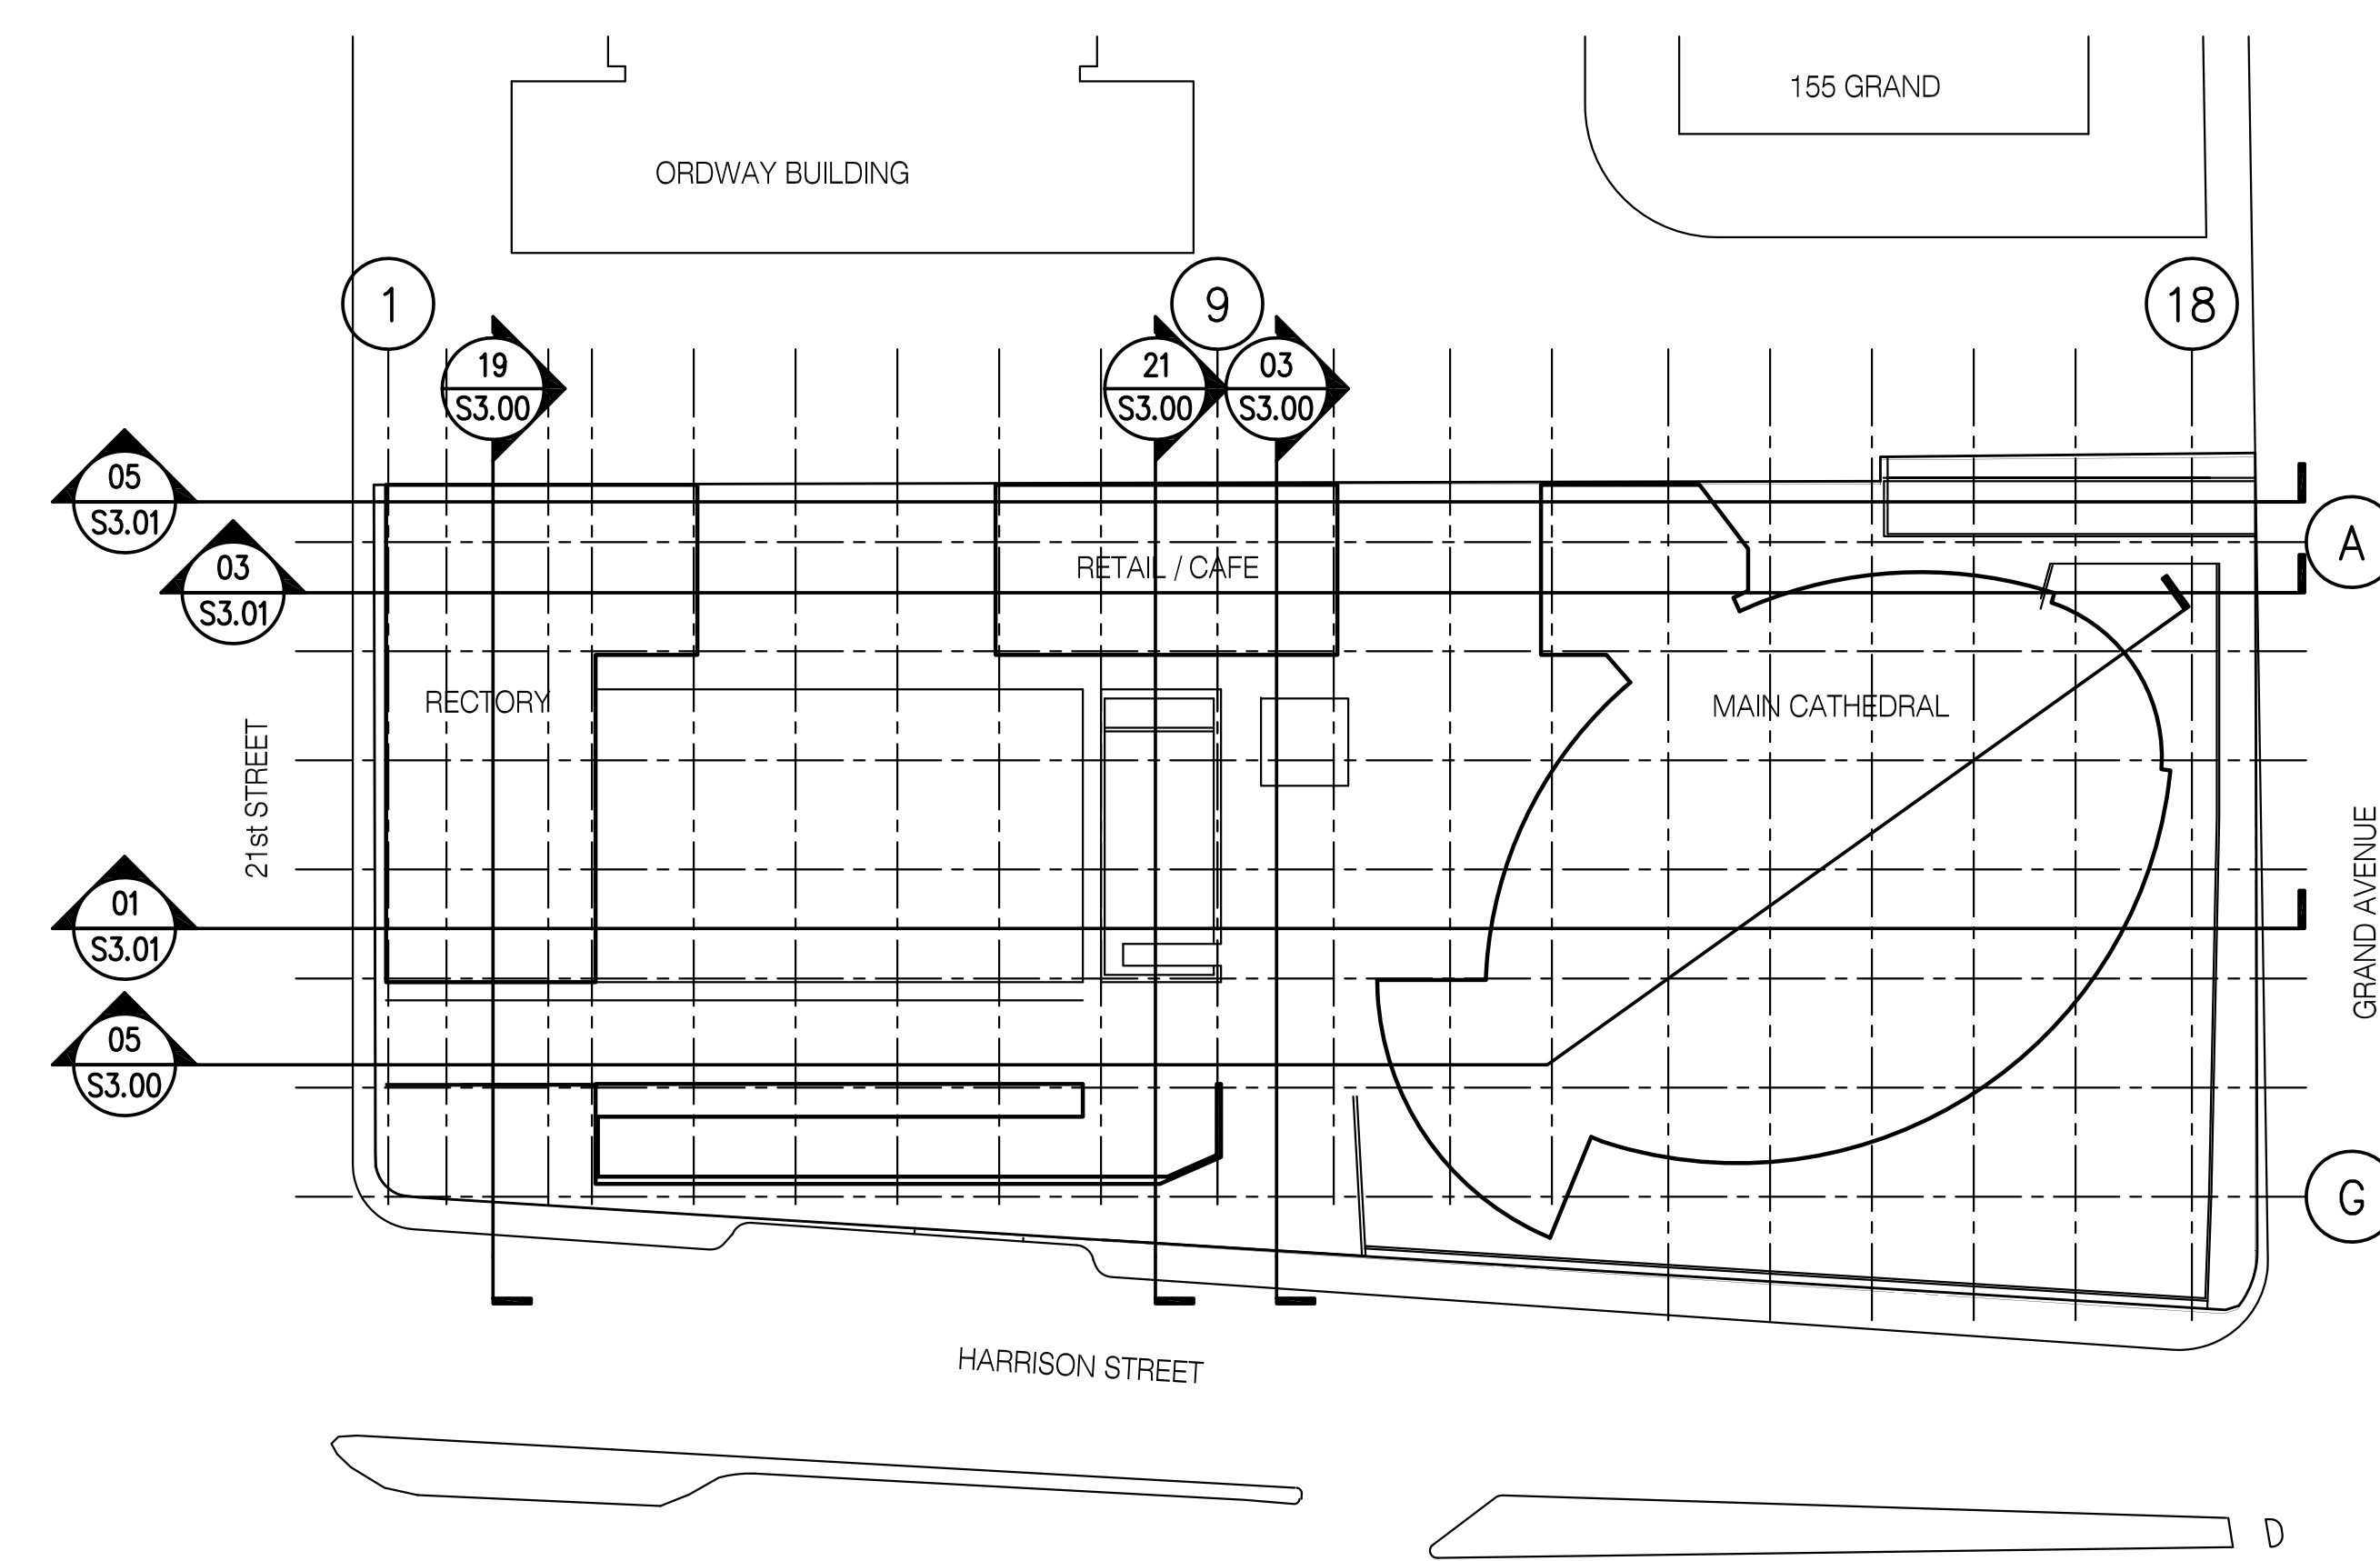


KEY PLAN FOR SECTIONAL VIEWS
SCALE: NONE
S300-01-04 01

No.	Date	Issue
1	31 JAN 05	ISSUED FOR FOUNDATION PERMIT
2	1 MAR 05	BID PACKAGE NO. 1
3	31 MAR 05	ISSUED FOR SUPERSTRUCTURE PERMIT

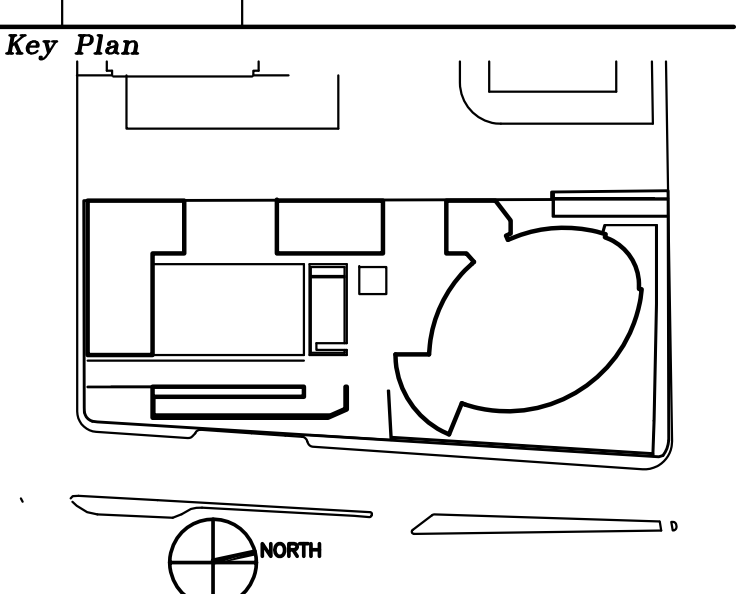


FILE NAME
S3000.dwg
Drawing Title
OVERALL SITE SECTIONS I


V:\DATA\AVP\S-PE-STAMP-41P

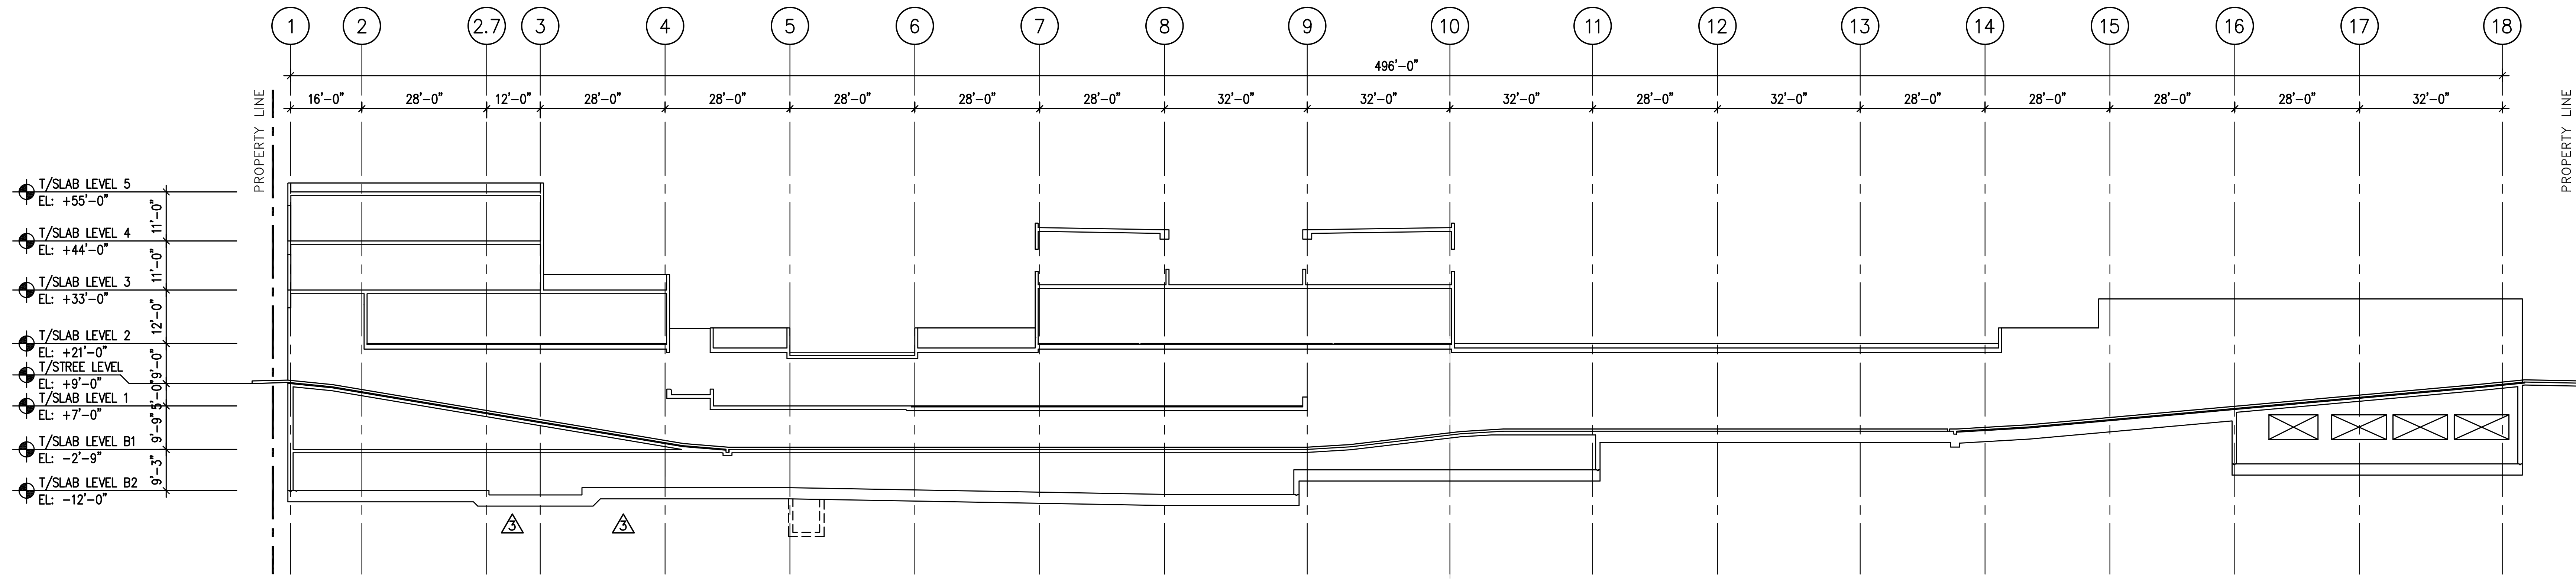

OVERALL SITE SECTION WEST OF GRIDLINE A
SCALE: 1/16" = 1'-0"
S301-01.dwg 05

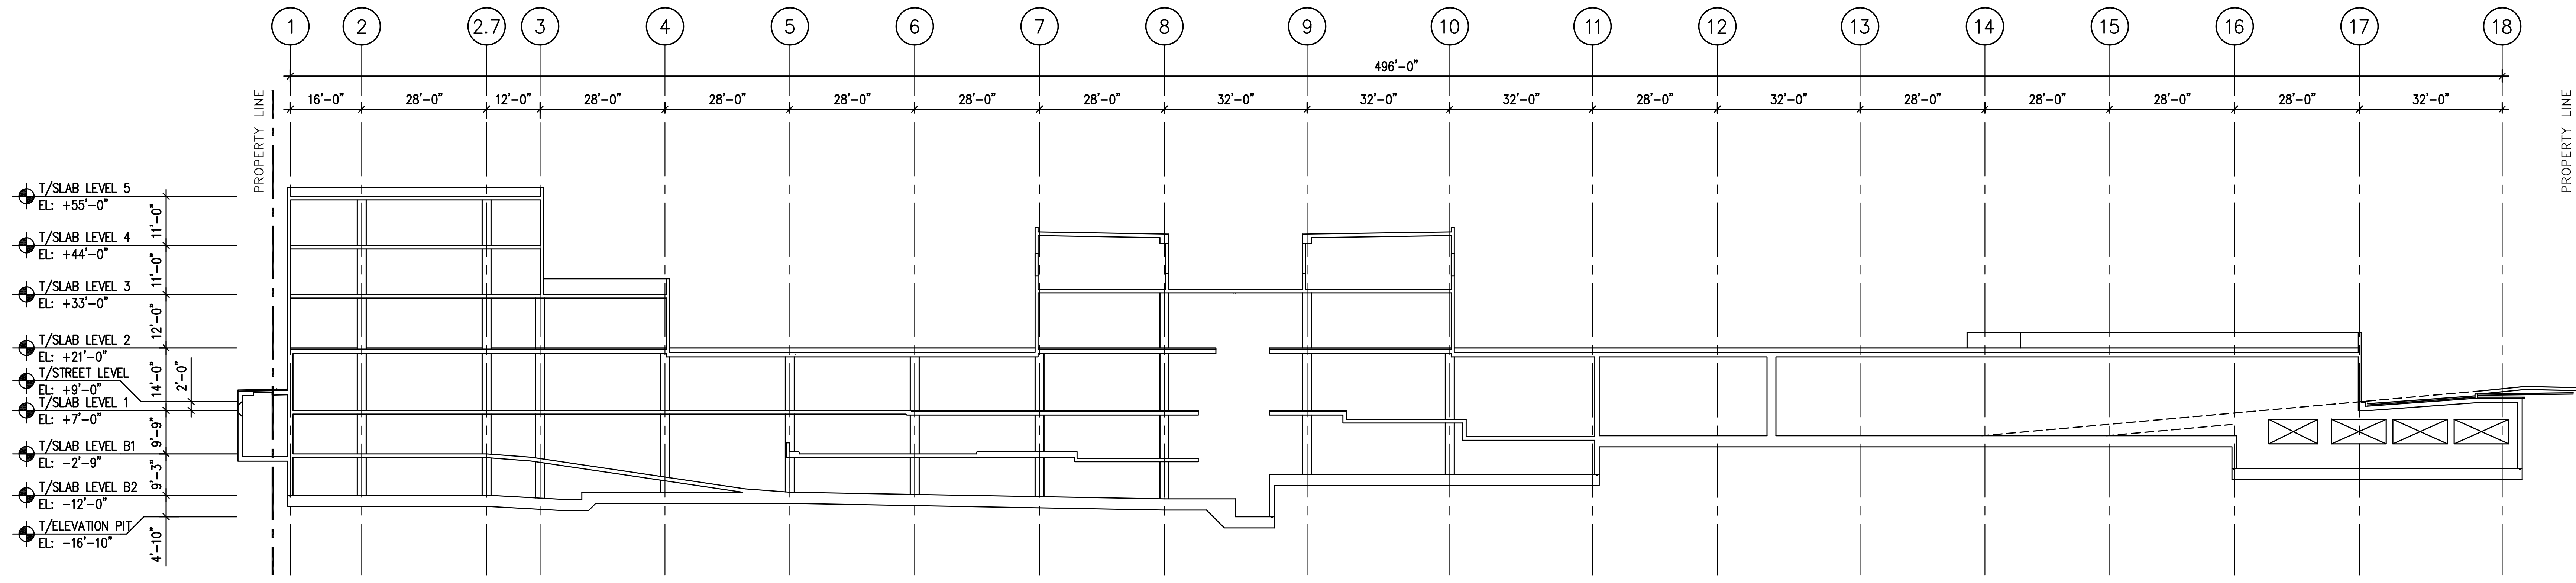


OVERALL SITE SECTION BETWEEN GRIDLINE A AND B
SCALE: 1/16" = 1'-0"
S301-01.dwg 03

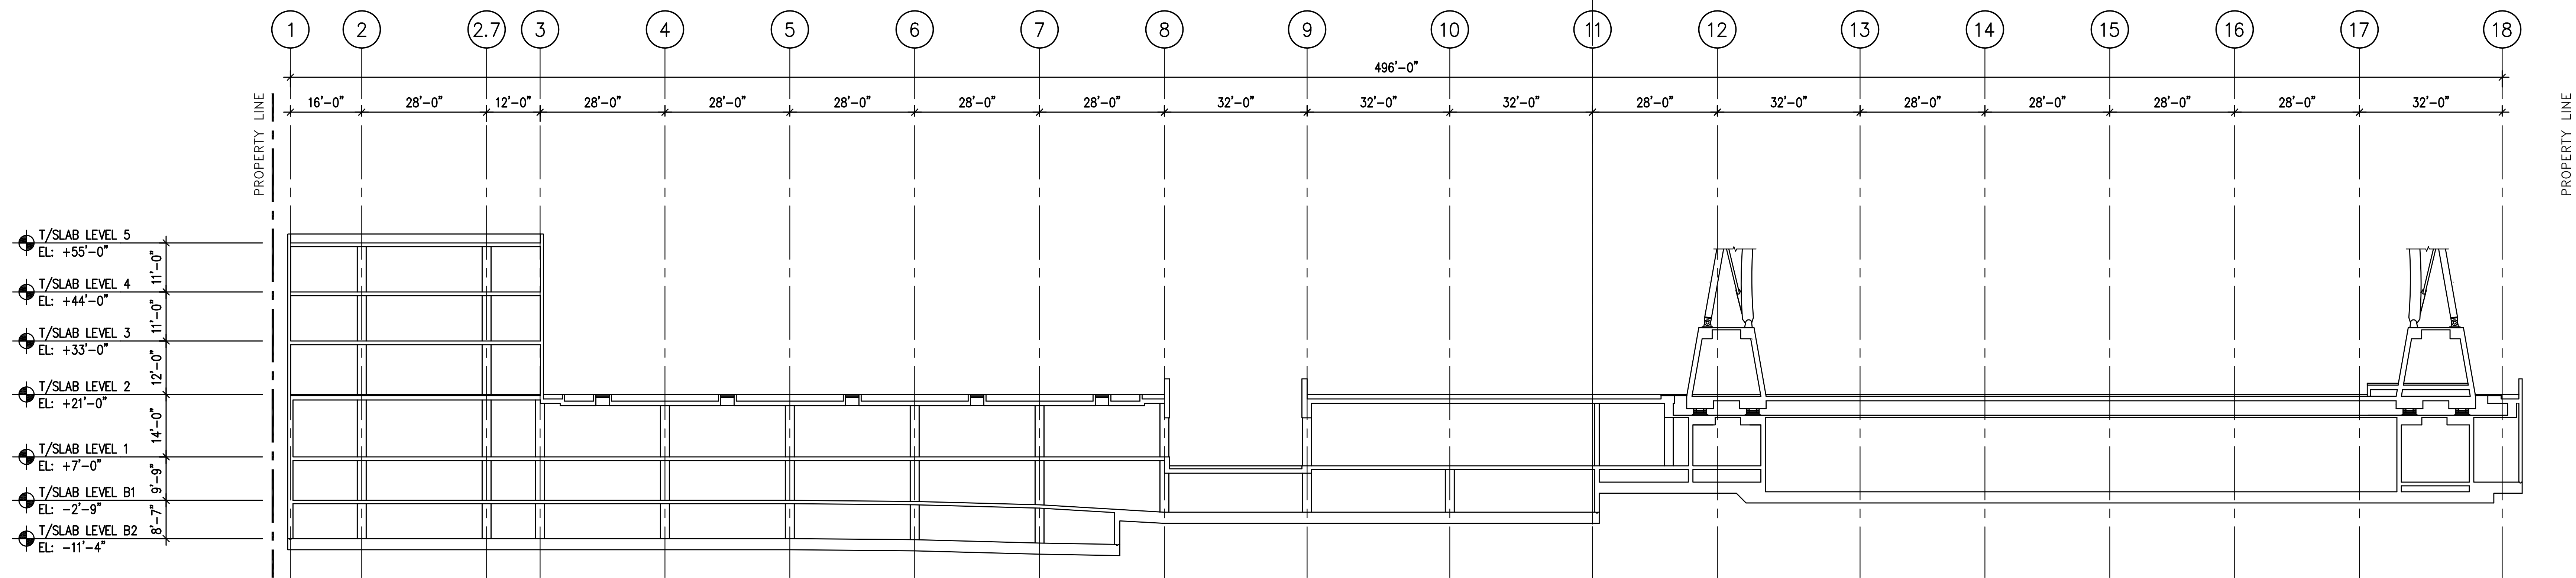


OVERALL SITE SECTION BETWEEN GRIDLINE C AND D
SCALE: 1/16" = 1'-0"
S301-01.dwg 01

No.	Date	Issue
1	31 JAN 05	ISSUED FOR FOUNDATION PERMIT
2	1 MAR 05	BID PACKAGE NO. 1
3	24 MAR 05	BID PACKAGE NO. 1 ADDENDUM 2
4	31 MAR 05	ISSUED FOR SUPERSTRUCTURE PERMIT

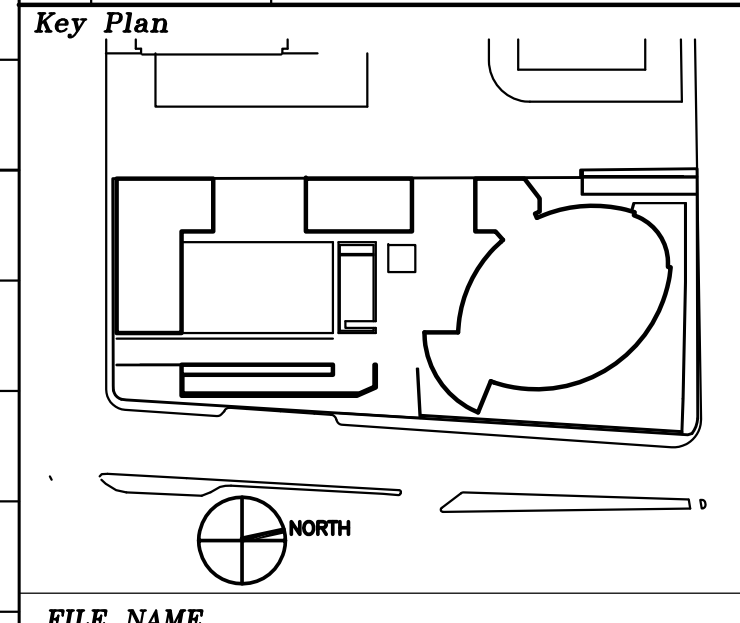


FILE NAME: S3001.dwg
Drawing Title: OVERALL SITE SECTIONS II
Project Number: SOM 204045
Drawing No.: S3.01

V:\DATA\NAPS-PE-STAMP.dwg

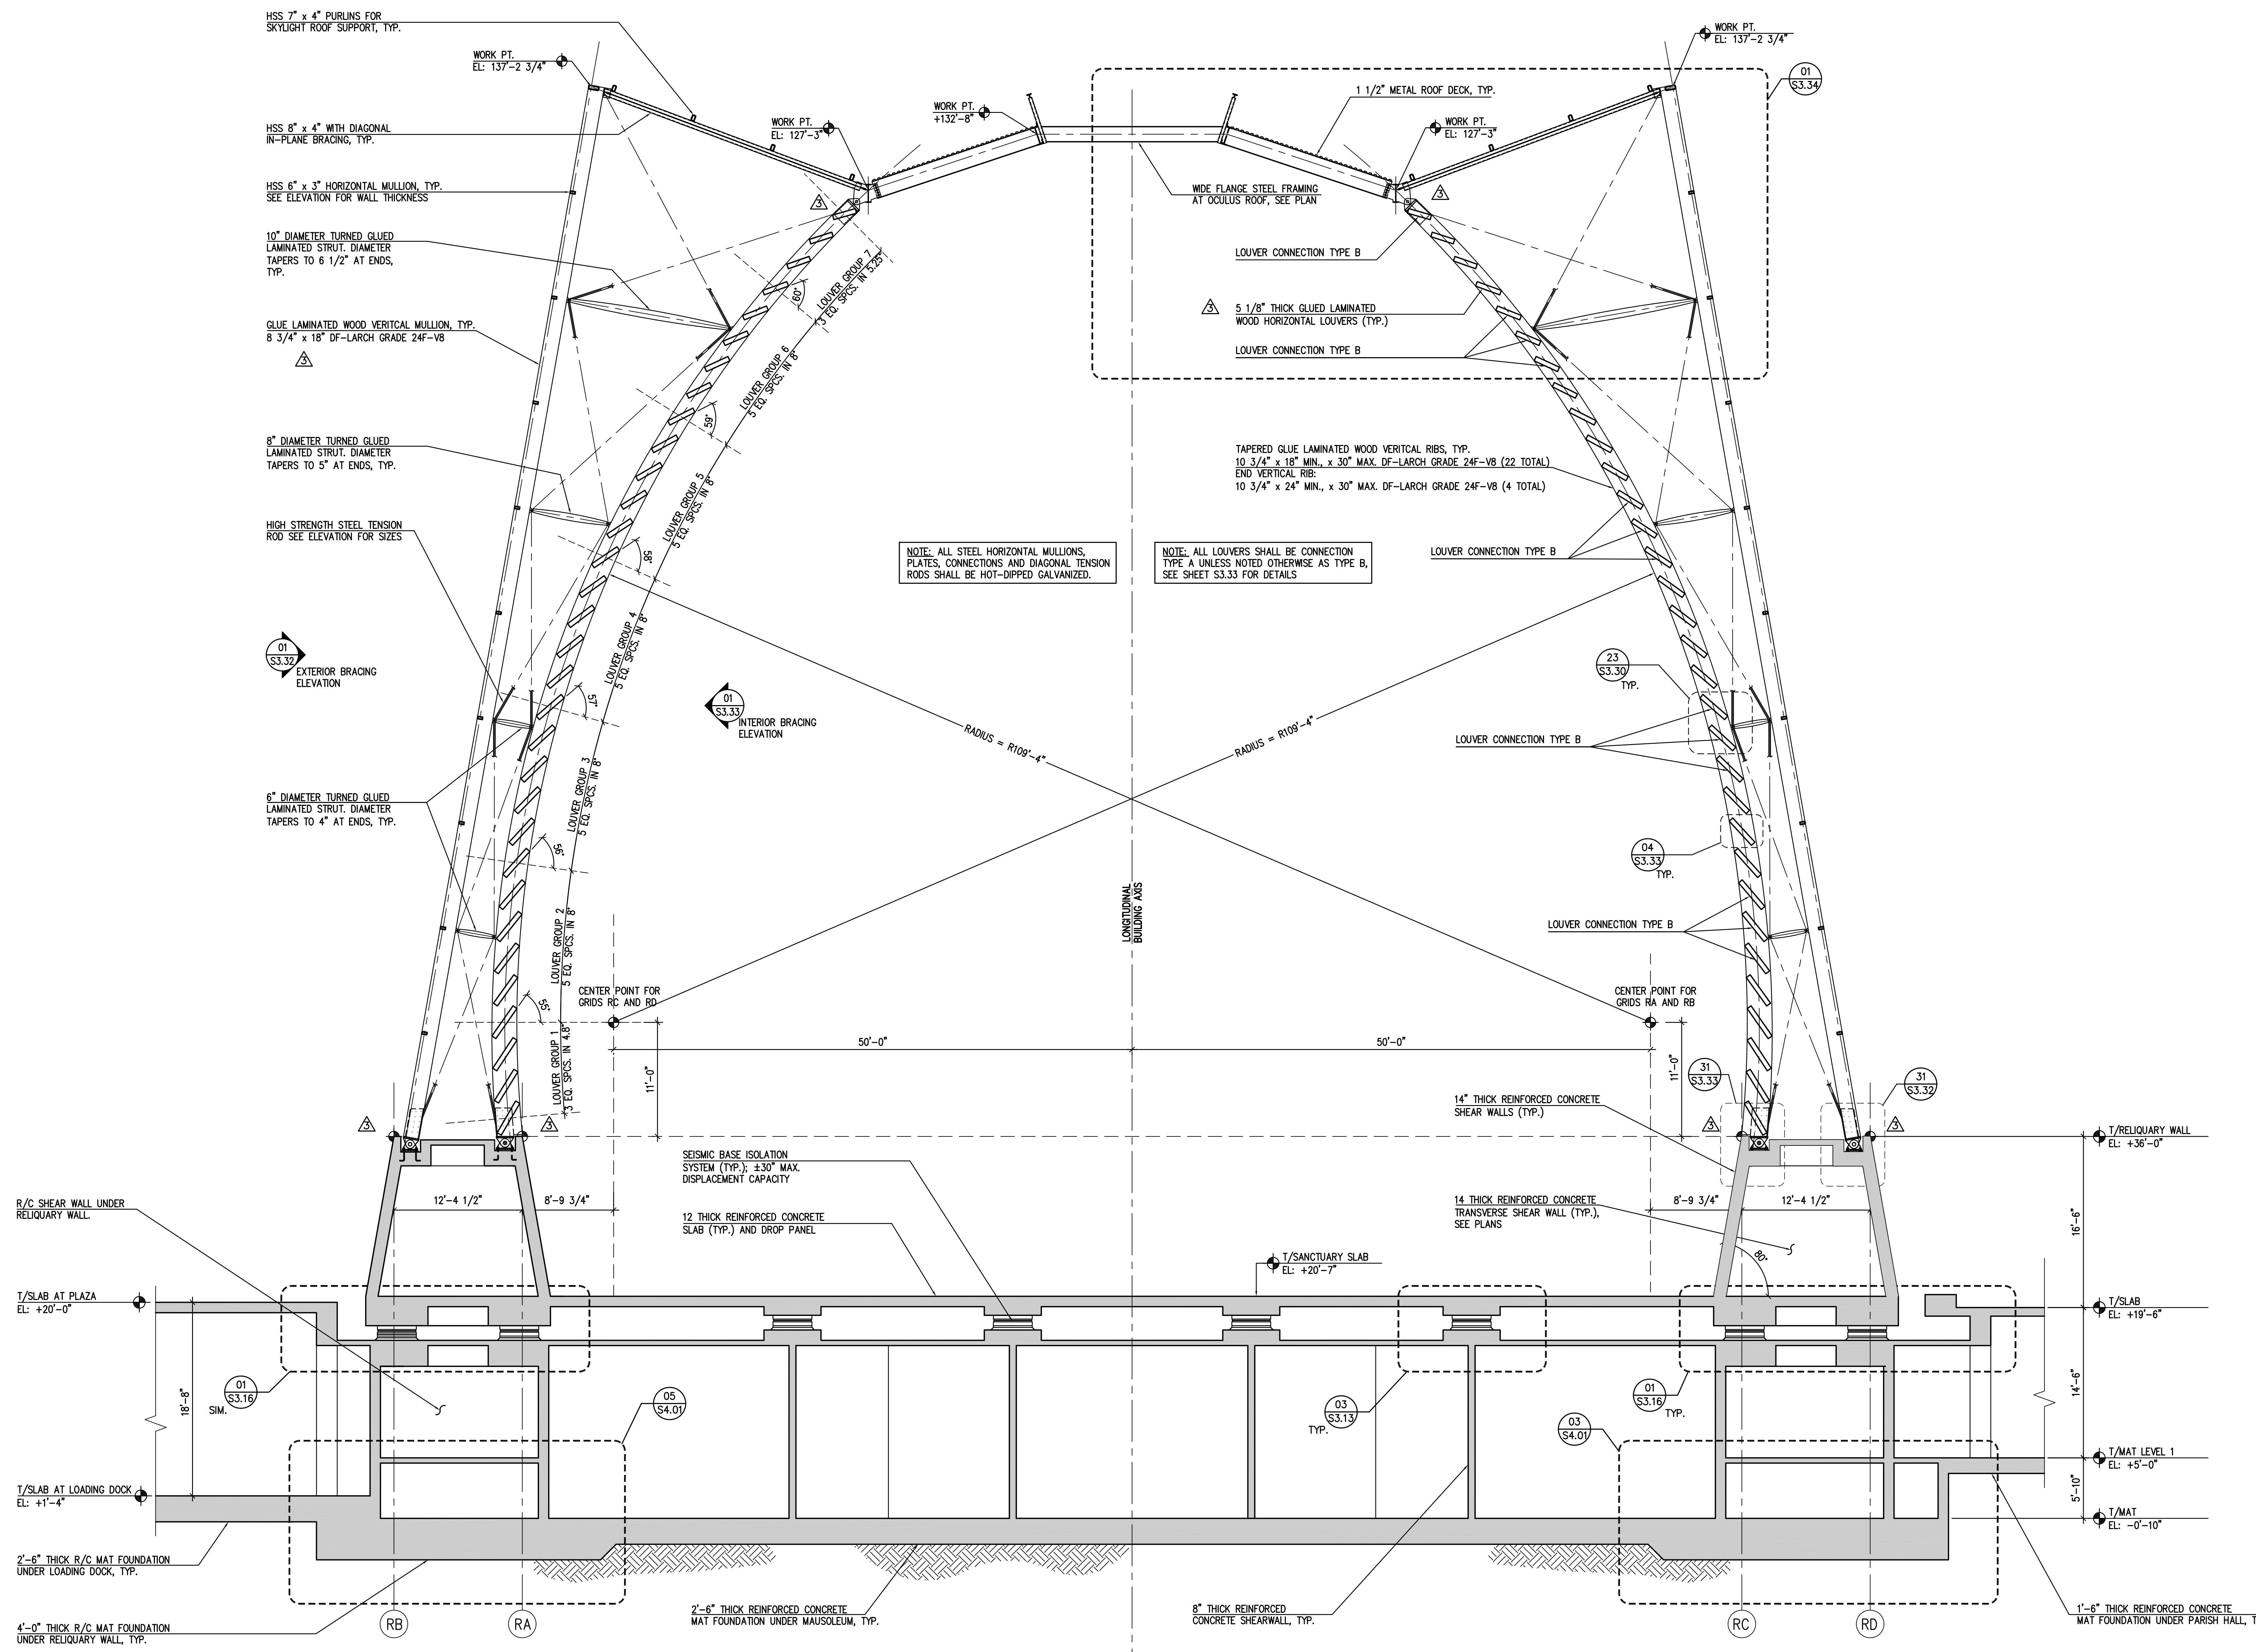

No.	Date	Issue
1	31 JAN 05	ISSUED FOR FOUNDATION PERMIT
2	1 MAR 05	RED PACKAGE NO. 1
3	24 MAR 05	RED PACKAGE NO. 1 ADDENDUM 2
4	31 MAR 05	ISSUED FOR SUPERSTRUCTURE PERMIT

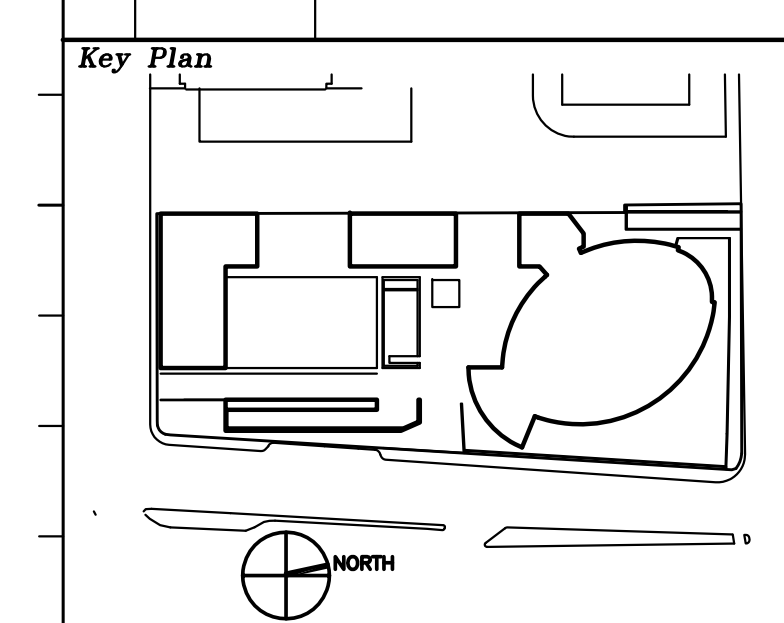

FILE NAME
S3002.dwg

Drawing Title
OVERALL CATHEDRAL SECTIONS I