



SYSTEM NAME FOR ROOF LEVEL - BRKBP69-V004-RL19
SYSTEM NAME FOR SECOND LEVEL - BRKBP69-V002-RL19

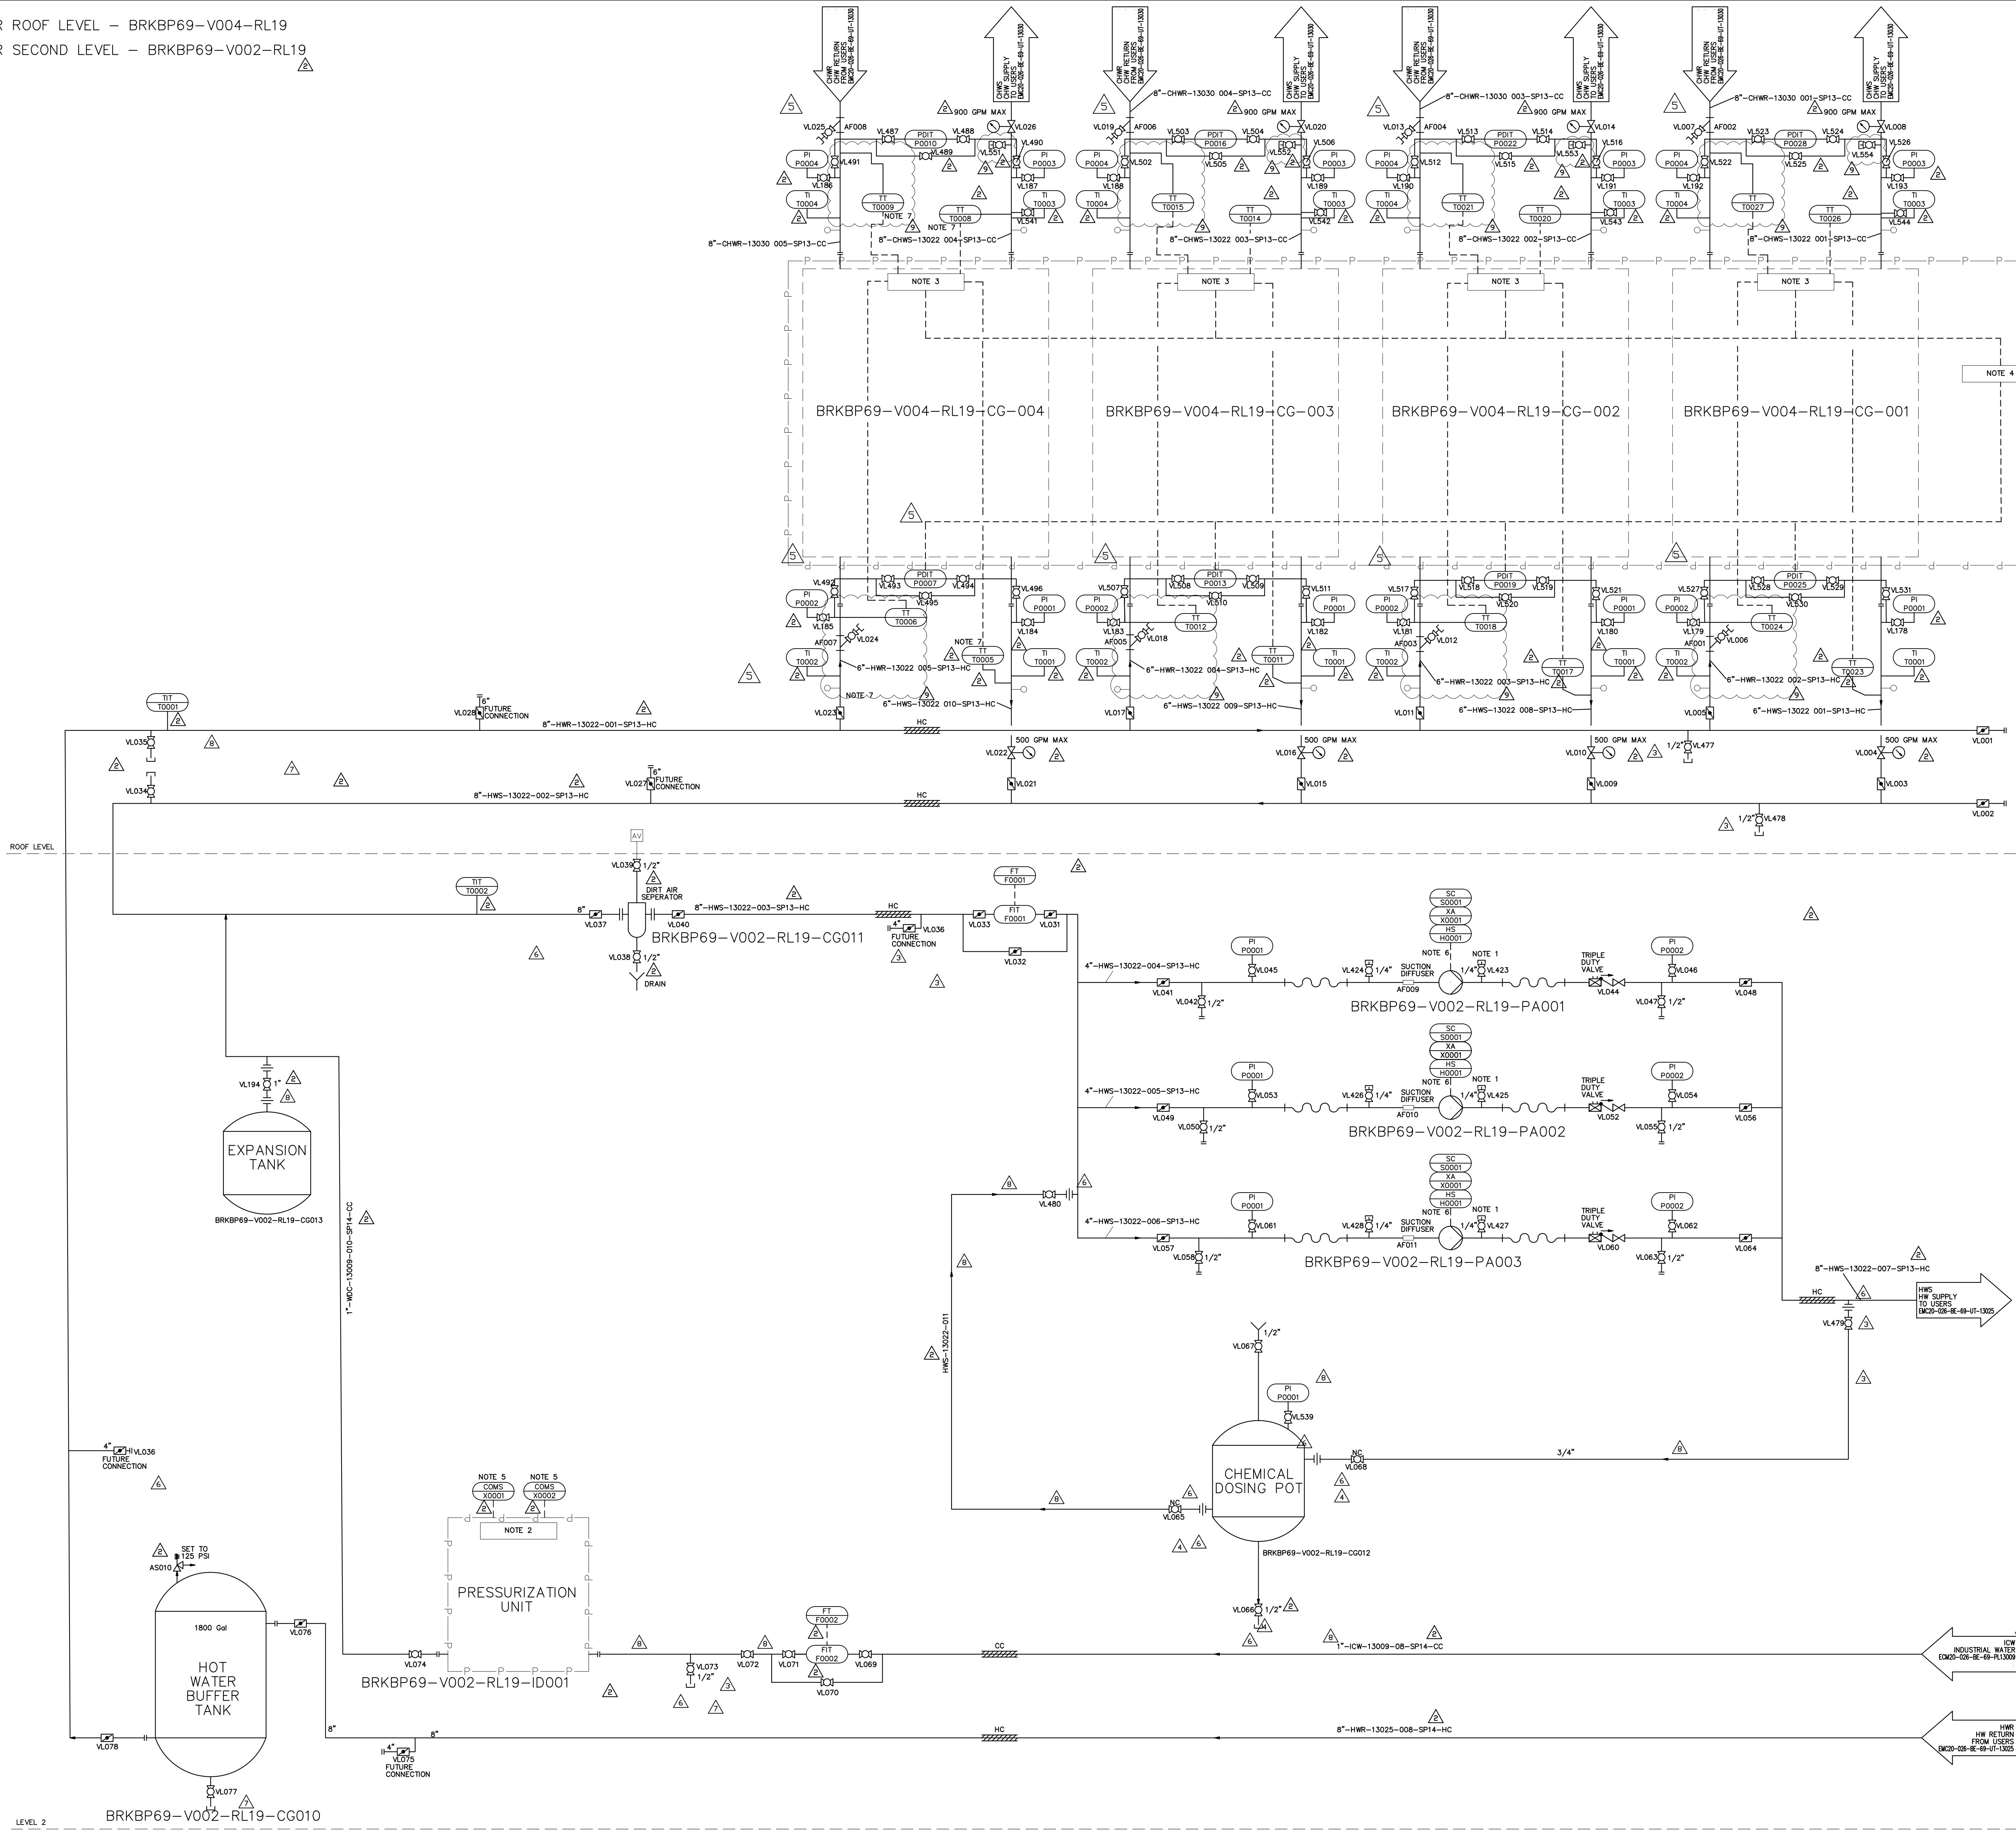

- KEYNOTES
1. PROVIDE 1/4" NPT PETE'S PLUG WITH CAP.
 2. CONTROL PANEL INCLUDED IN PRESSURIZATION SKID. PRESSURE SENSOR INSTALLED. PROVIDE COMMUNICATION WITH BAS.
 3. UNIT CONTROLLER MOUNTED. CONNECT TO MULTIPRO CONTROLLER LOCATED INSIDE THE PENTHOUSE.
 4. MULTIPRO CONTROLLER MOUNTED AND LOCATED INSIDE THE PENTHOUSE. CONNECT TO BAS.
 5. COMMS LINK SHOULD PROVIDE STATUS AND ENABLE SIGNALS TO BAS.
 6. MULTI-PRO CONTROLLER TO CONTROL ALL HEAT PUMP UNITS SEQUENCING, CHILLED WATER & HEATING HOT WATER PUMPS VIA THE SYSTEM DIFFERENTIAL PRESSURES, AND BY-PASS VALVES FOR CHILLED WATER AND HEATING HOT WATER SYSTEMS.
 7. LOCATE AS CLOSE TO 30" FROM INTERFACE OF HEAT PUMP AS REASONABLE.

- GENERAL NOTES
1. SEE DRAWING ECM20-026-BE-69-UT-13080, EQUIPMENT SCHEDULES FOR EQUIPMENT MODEL AND CAPACITIES.
 2. INSTALL ALL EQUIPMENT AND ACCESSORIES PER MANUFACTURER'S INSTRUCTIONS.

Level 2

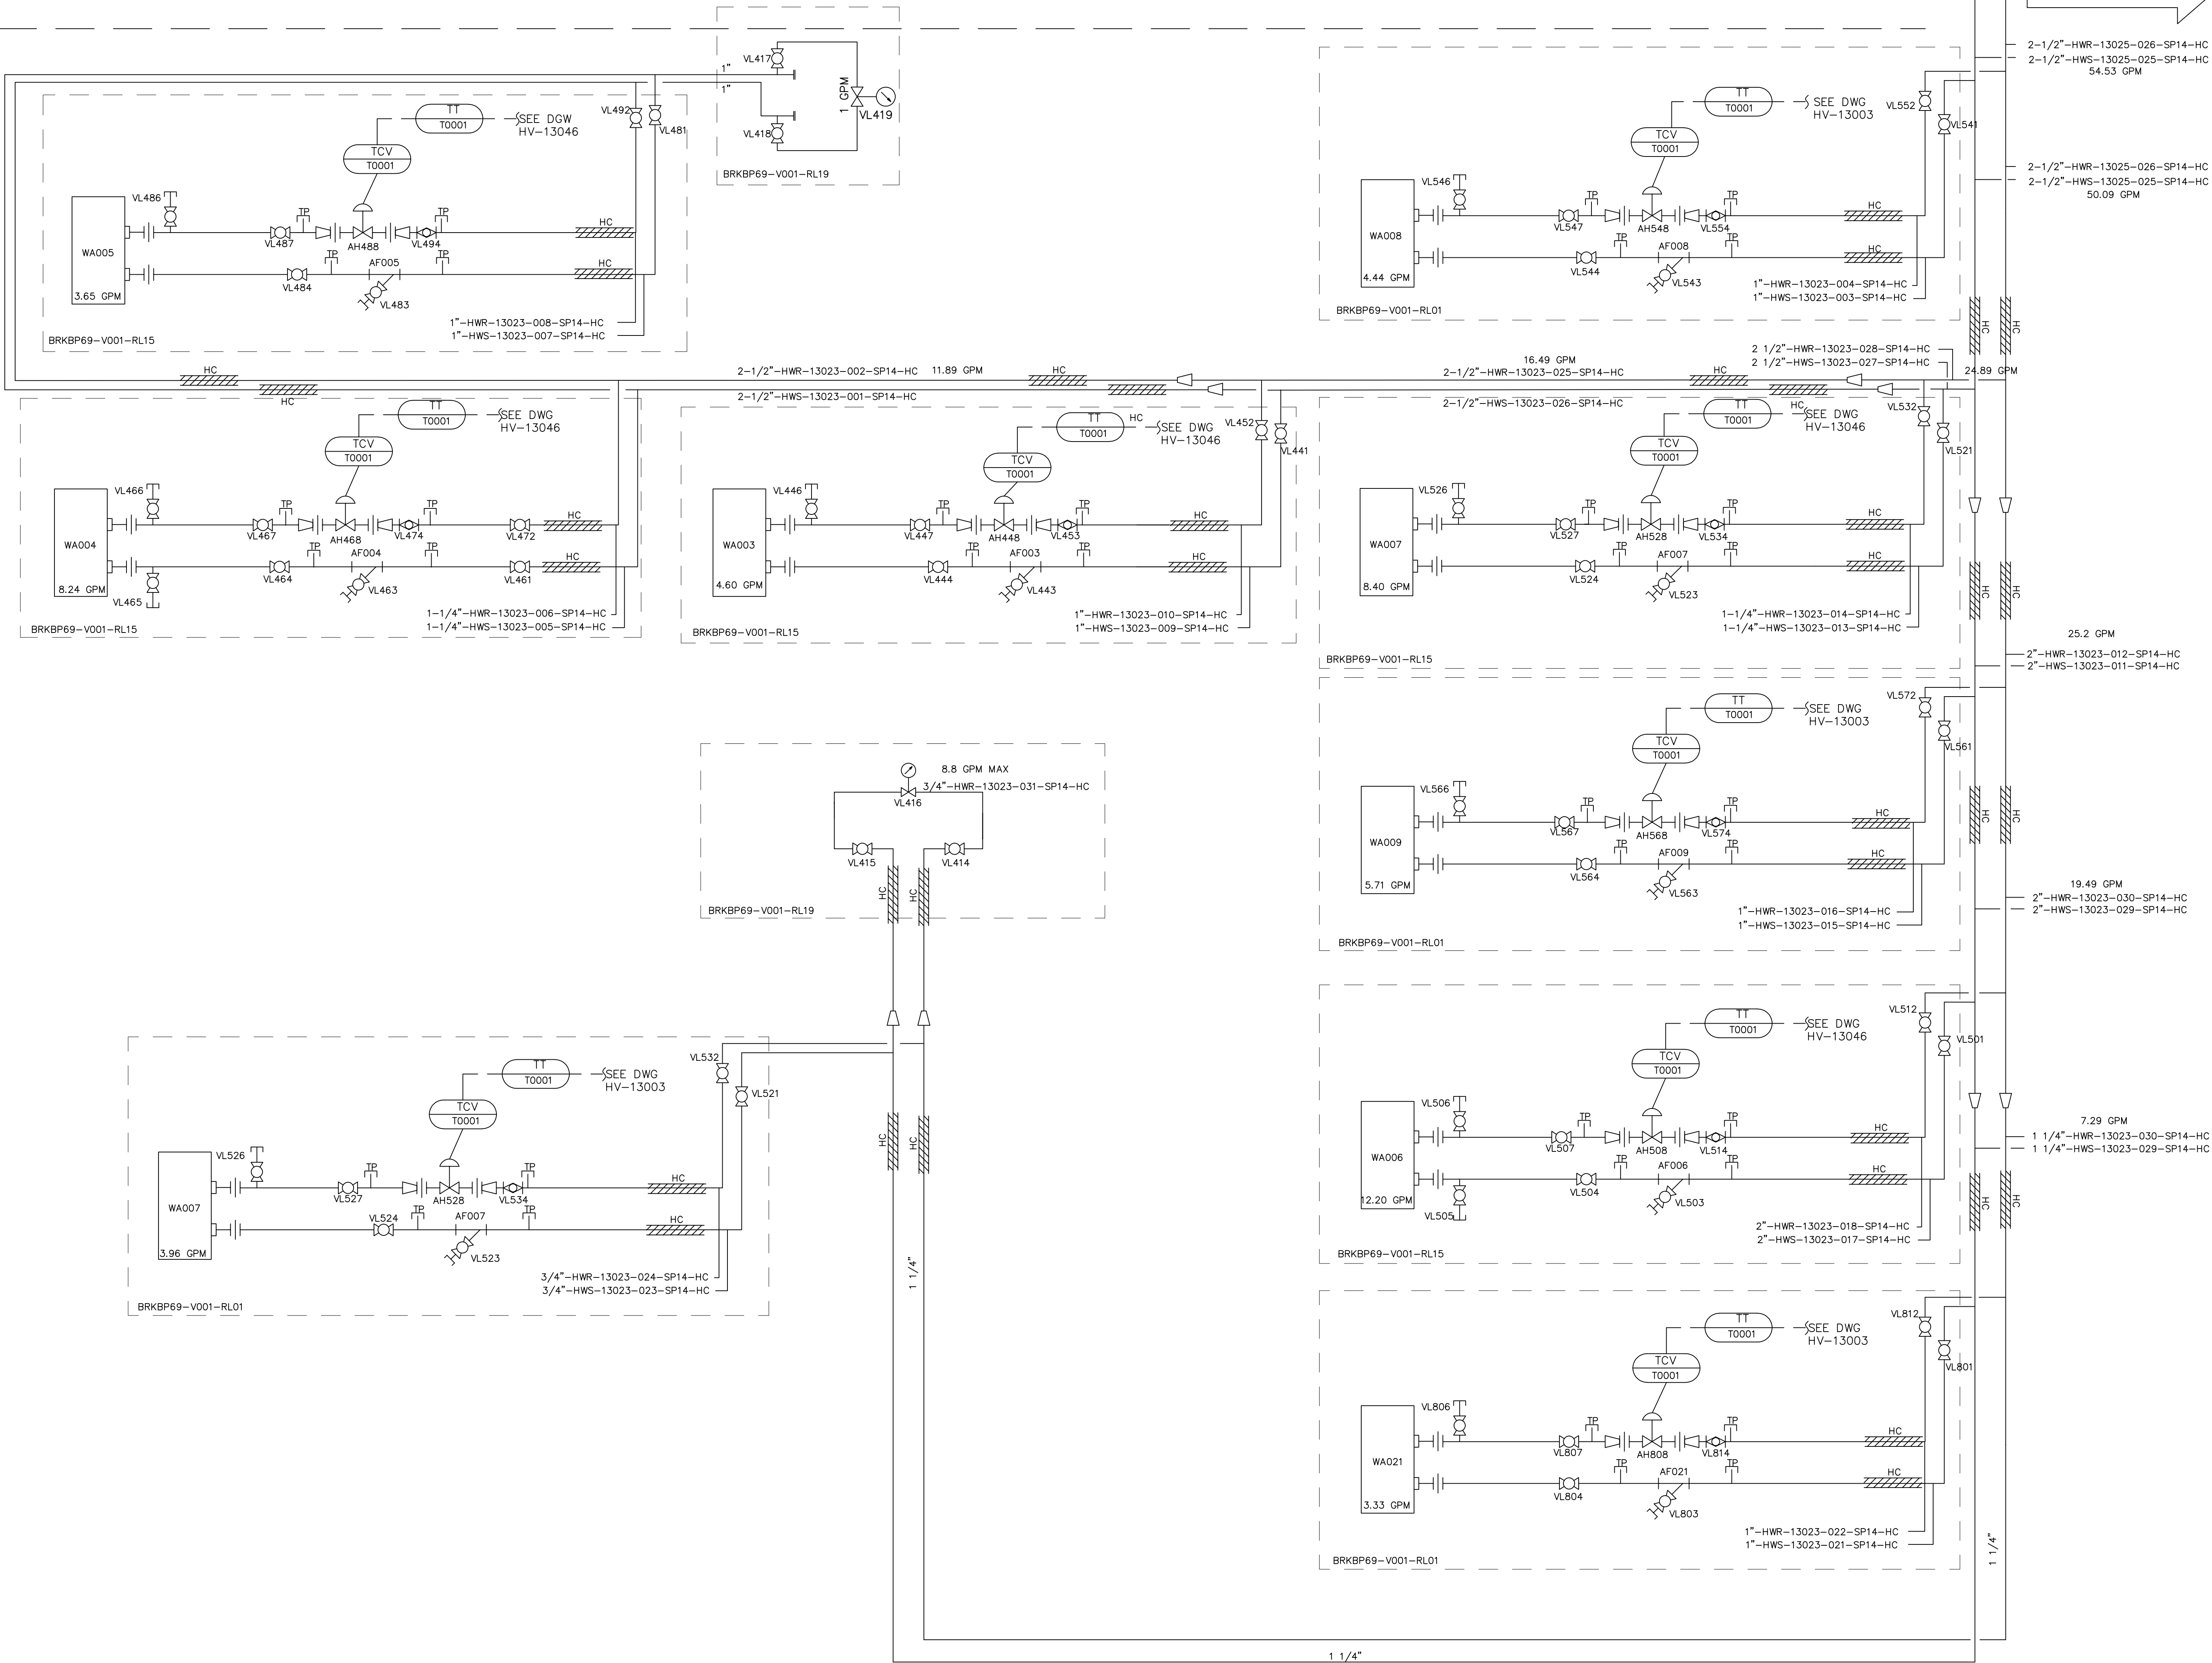

Level 1

Title: Level 1
HEATING HOT WATER SYSTEM
P&ID


Drawing Number: ECM20-026-BE-69-UT-13023
Scale: N.T.S.

As-Built Project
Revision No. 3

US3810086_46_DR_001

KEYNOTES

- 1 CONNECT TO MULTIPRO CONTROLLER.
2 HPV - HIGH POINT VENT.

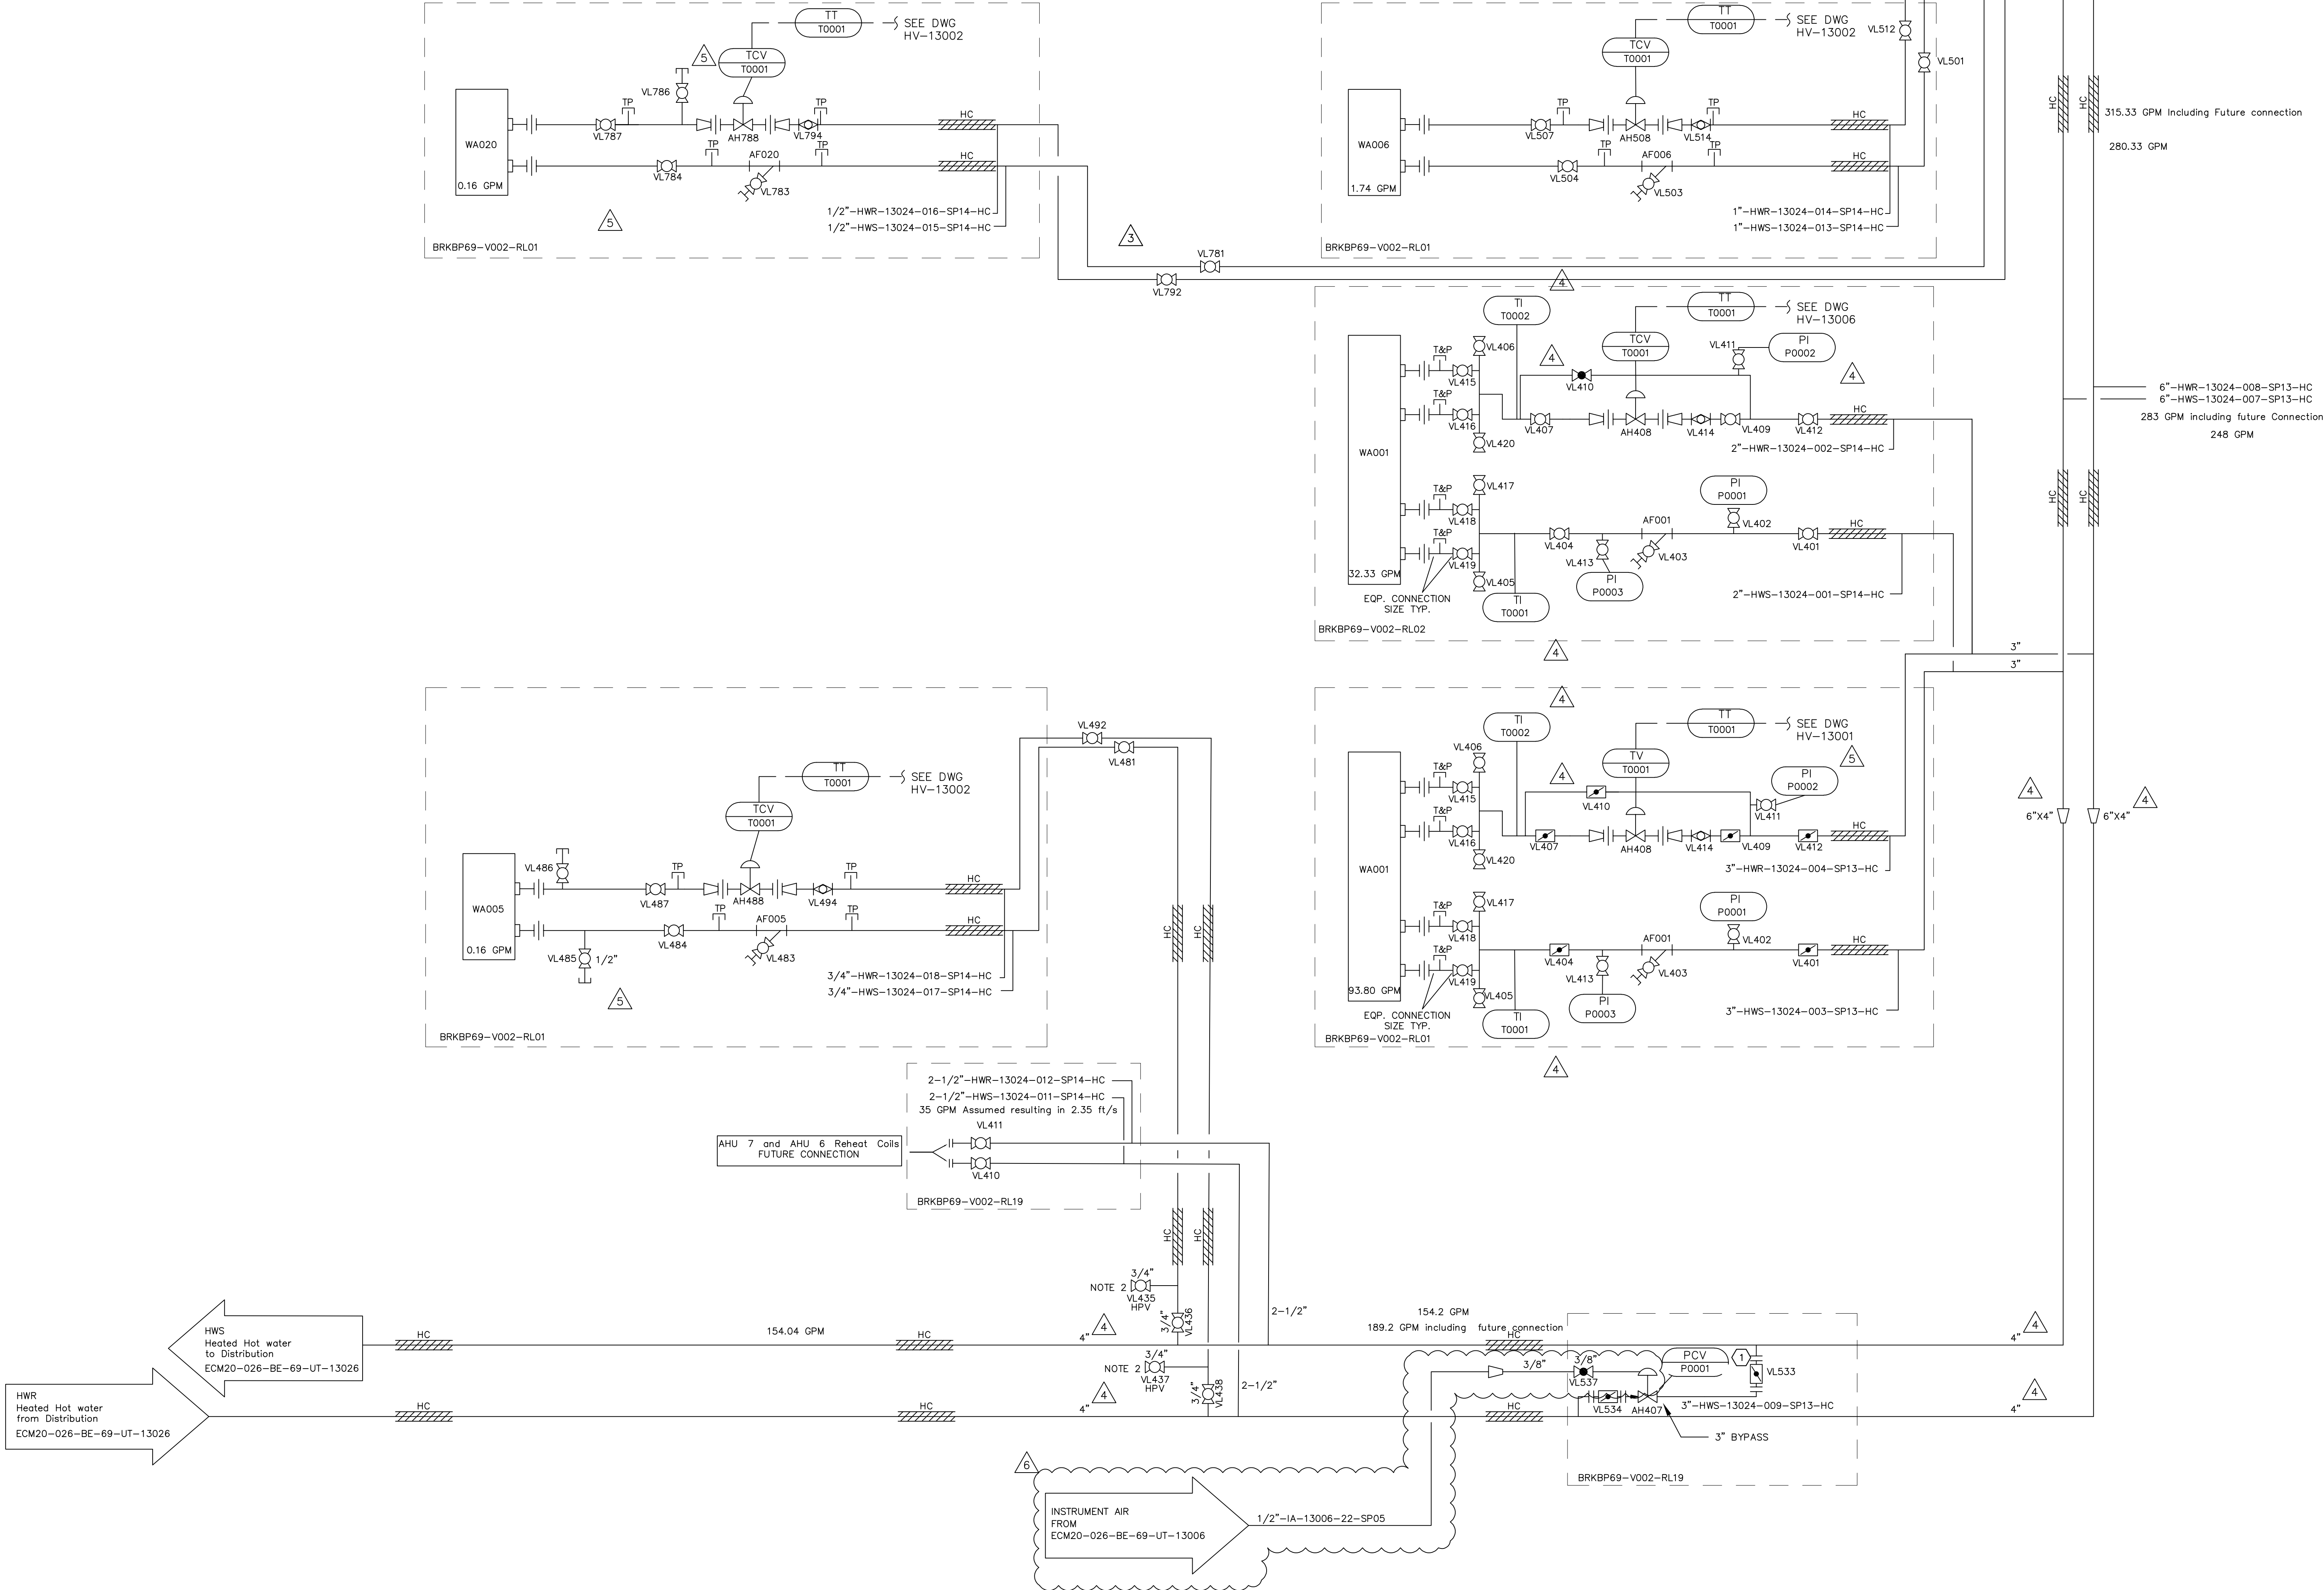

Level 2

FORMAL ISSUE
CODE

Title: LEVEL 2
HEATING HOT WATER SYSTEM
P&ID


Drawing Number: ECM20-026-BE-69-UT-13024
Scale: N.T.S.

As-Built Project
Revision No. 6

US3810086_46_DR_0002

KEYNOTES

1. HPV - HIGH POINT VENT.

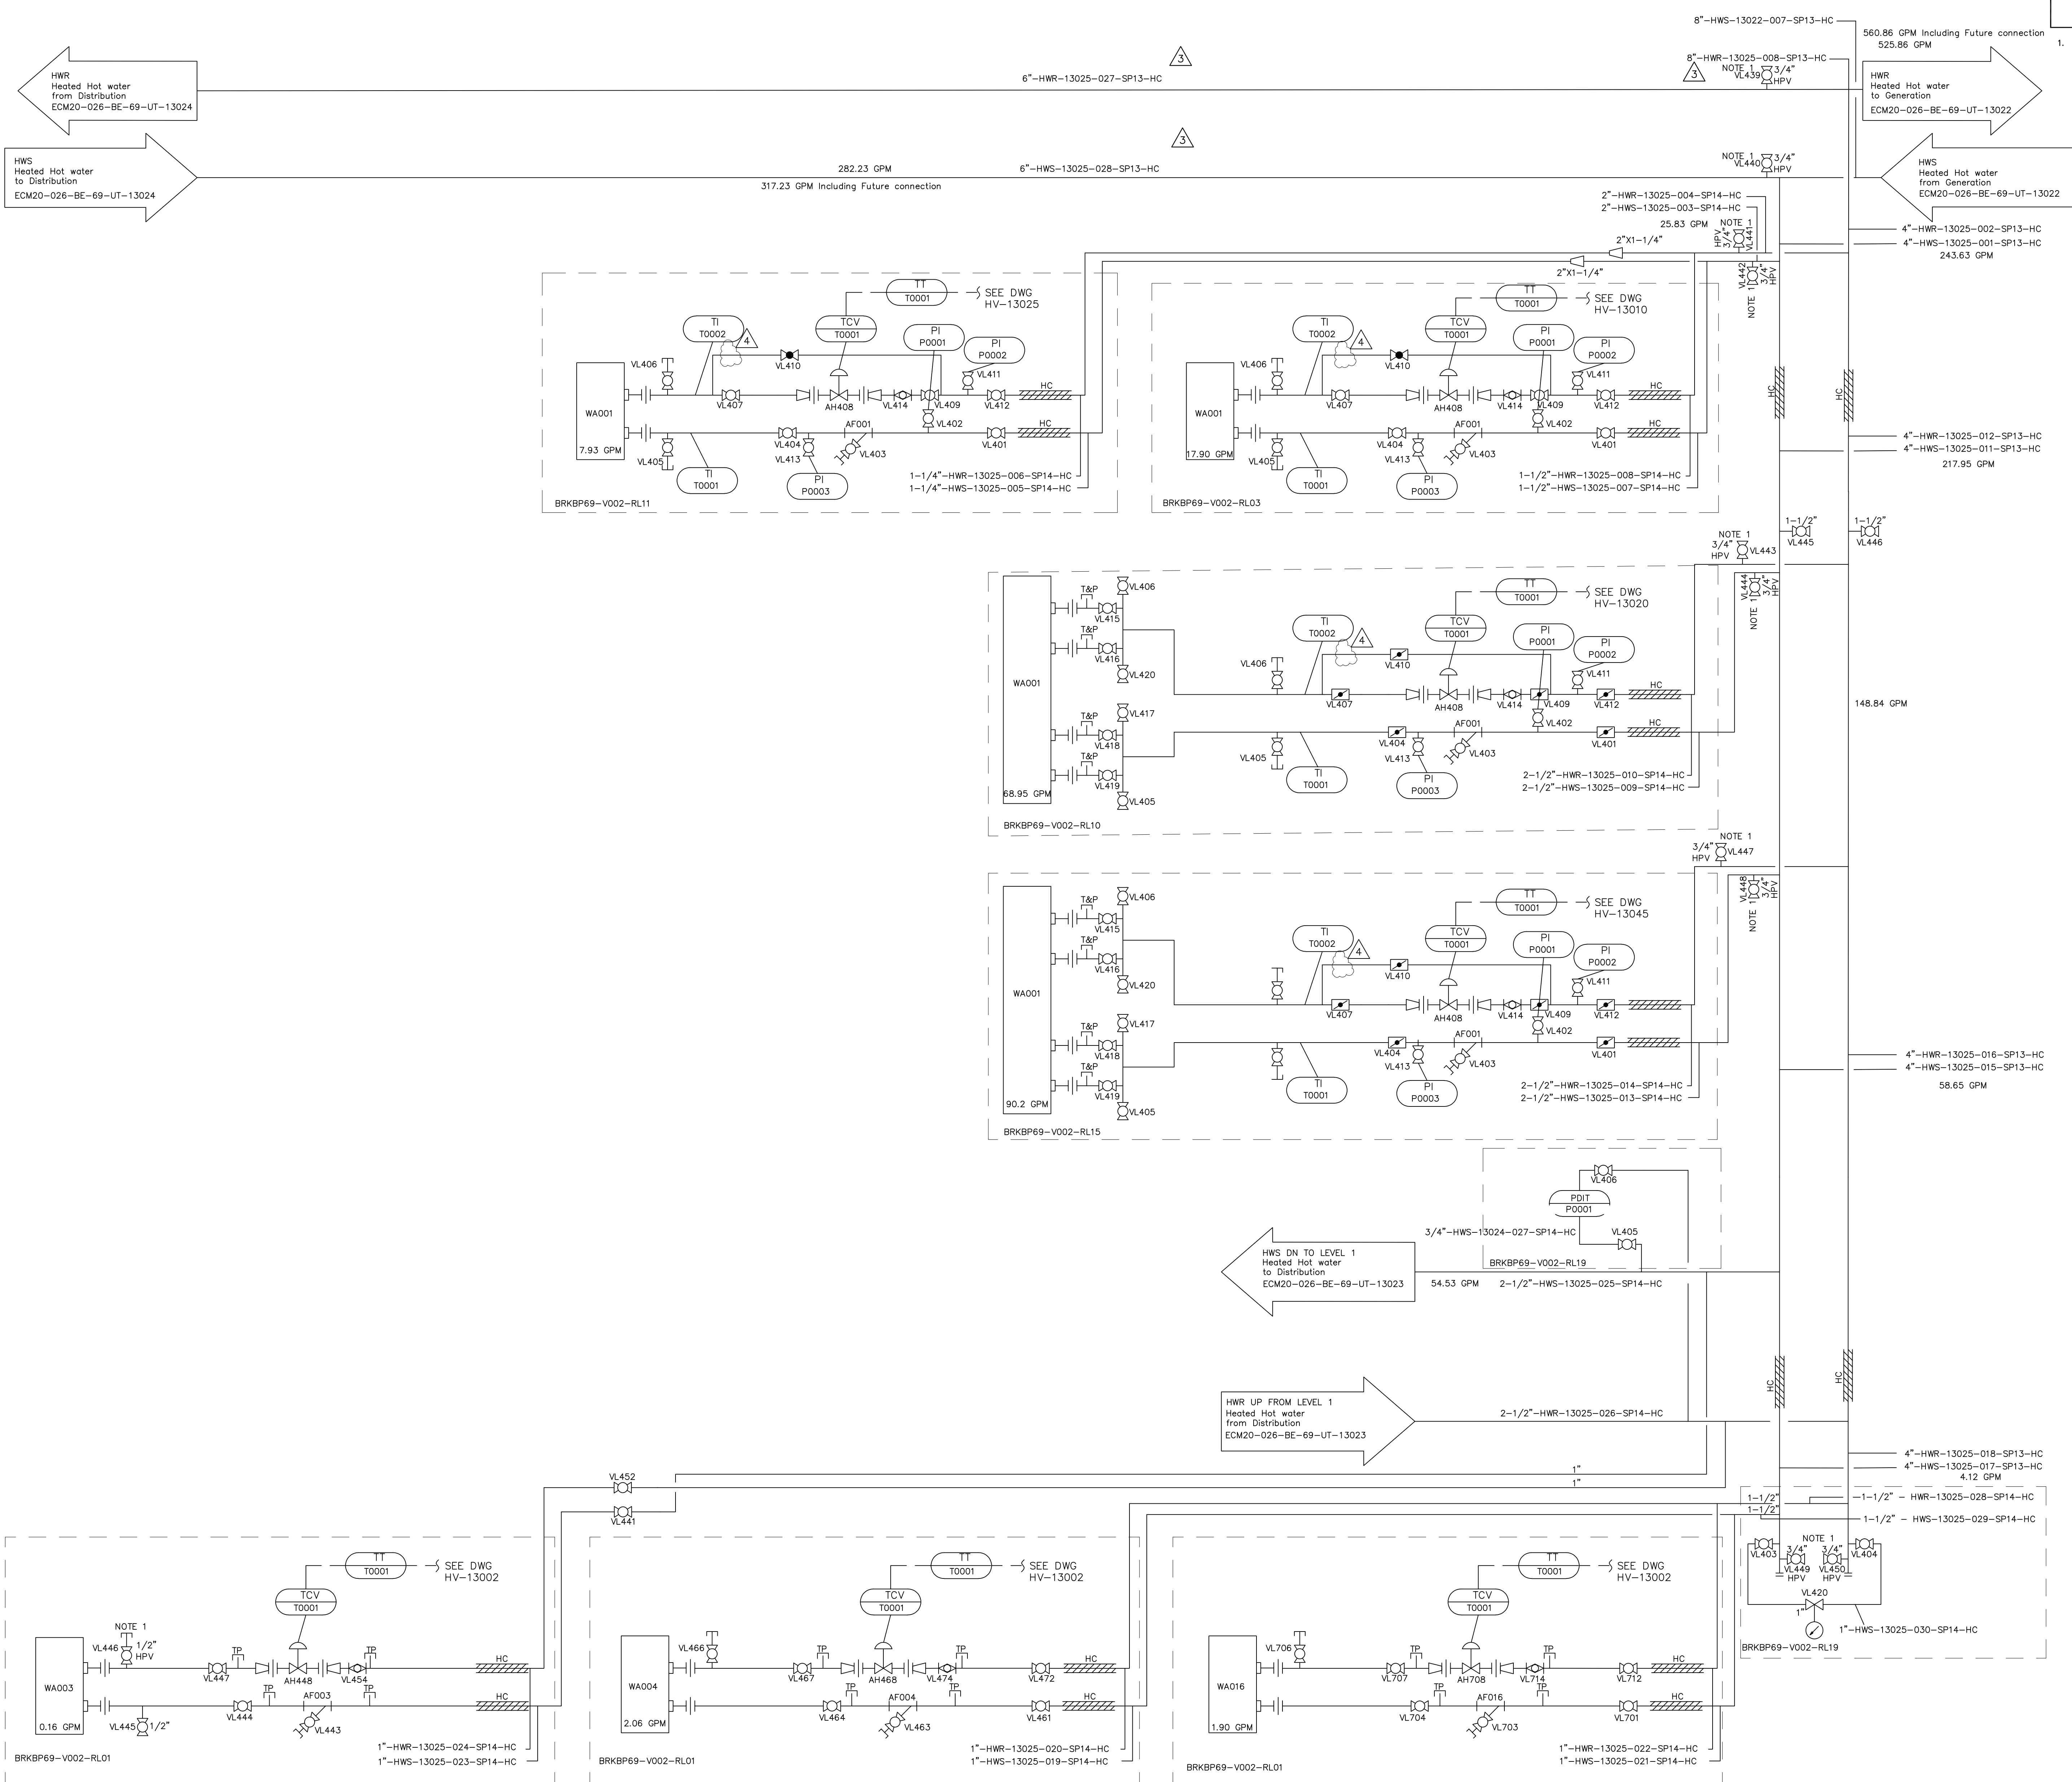

Level 2


FORMAL ISSUE
CODE

Title: LEVEL 2
HEATING HOT WATER SYSTEM
P&ID

Drawing Number: ECM20-026-BE-69-UT-13025
Scale: N.T.S.

As-Built Project
Revision No. 4


US381088_A6_DR_003

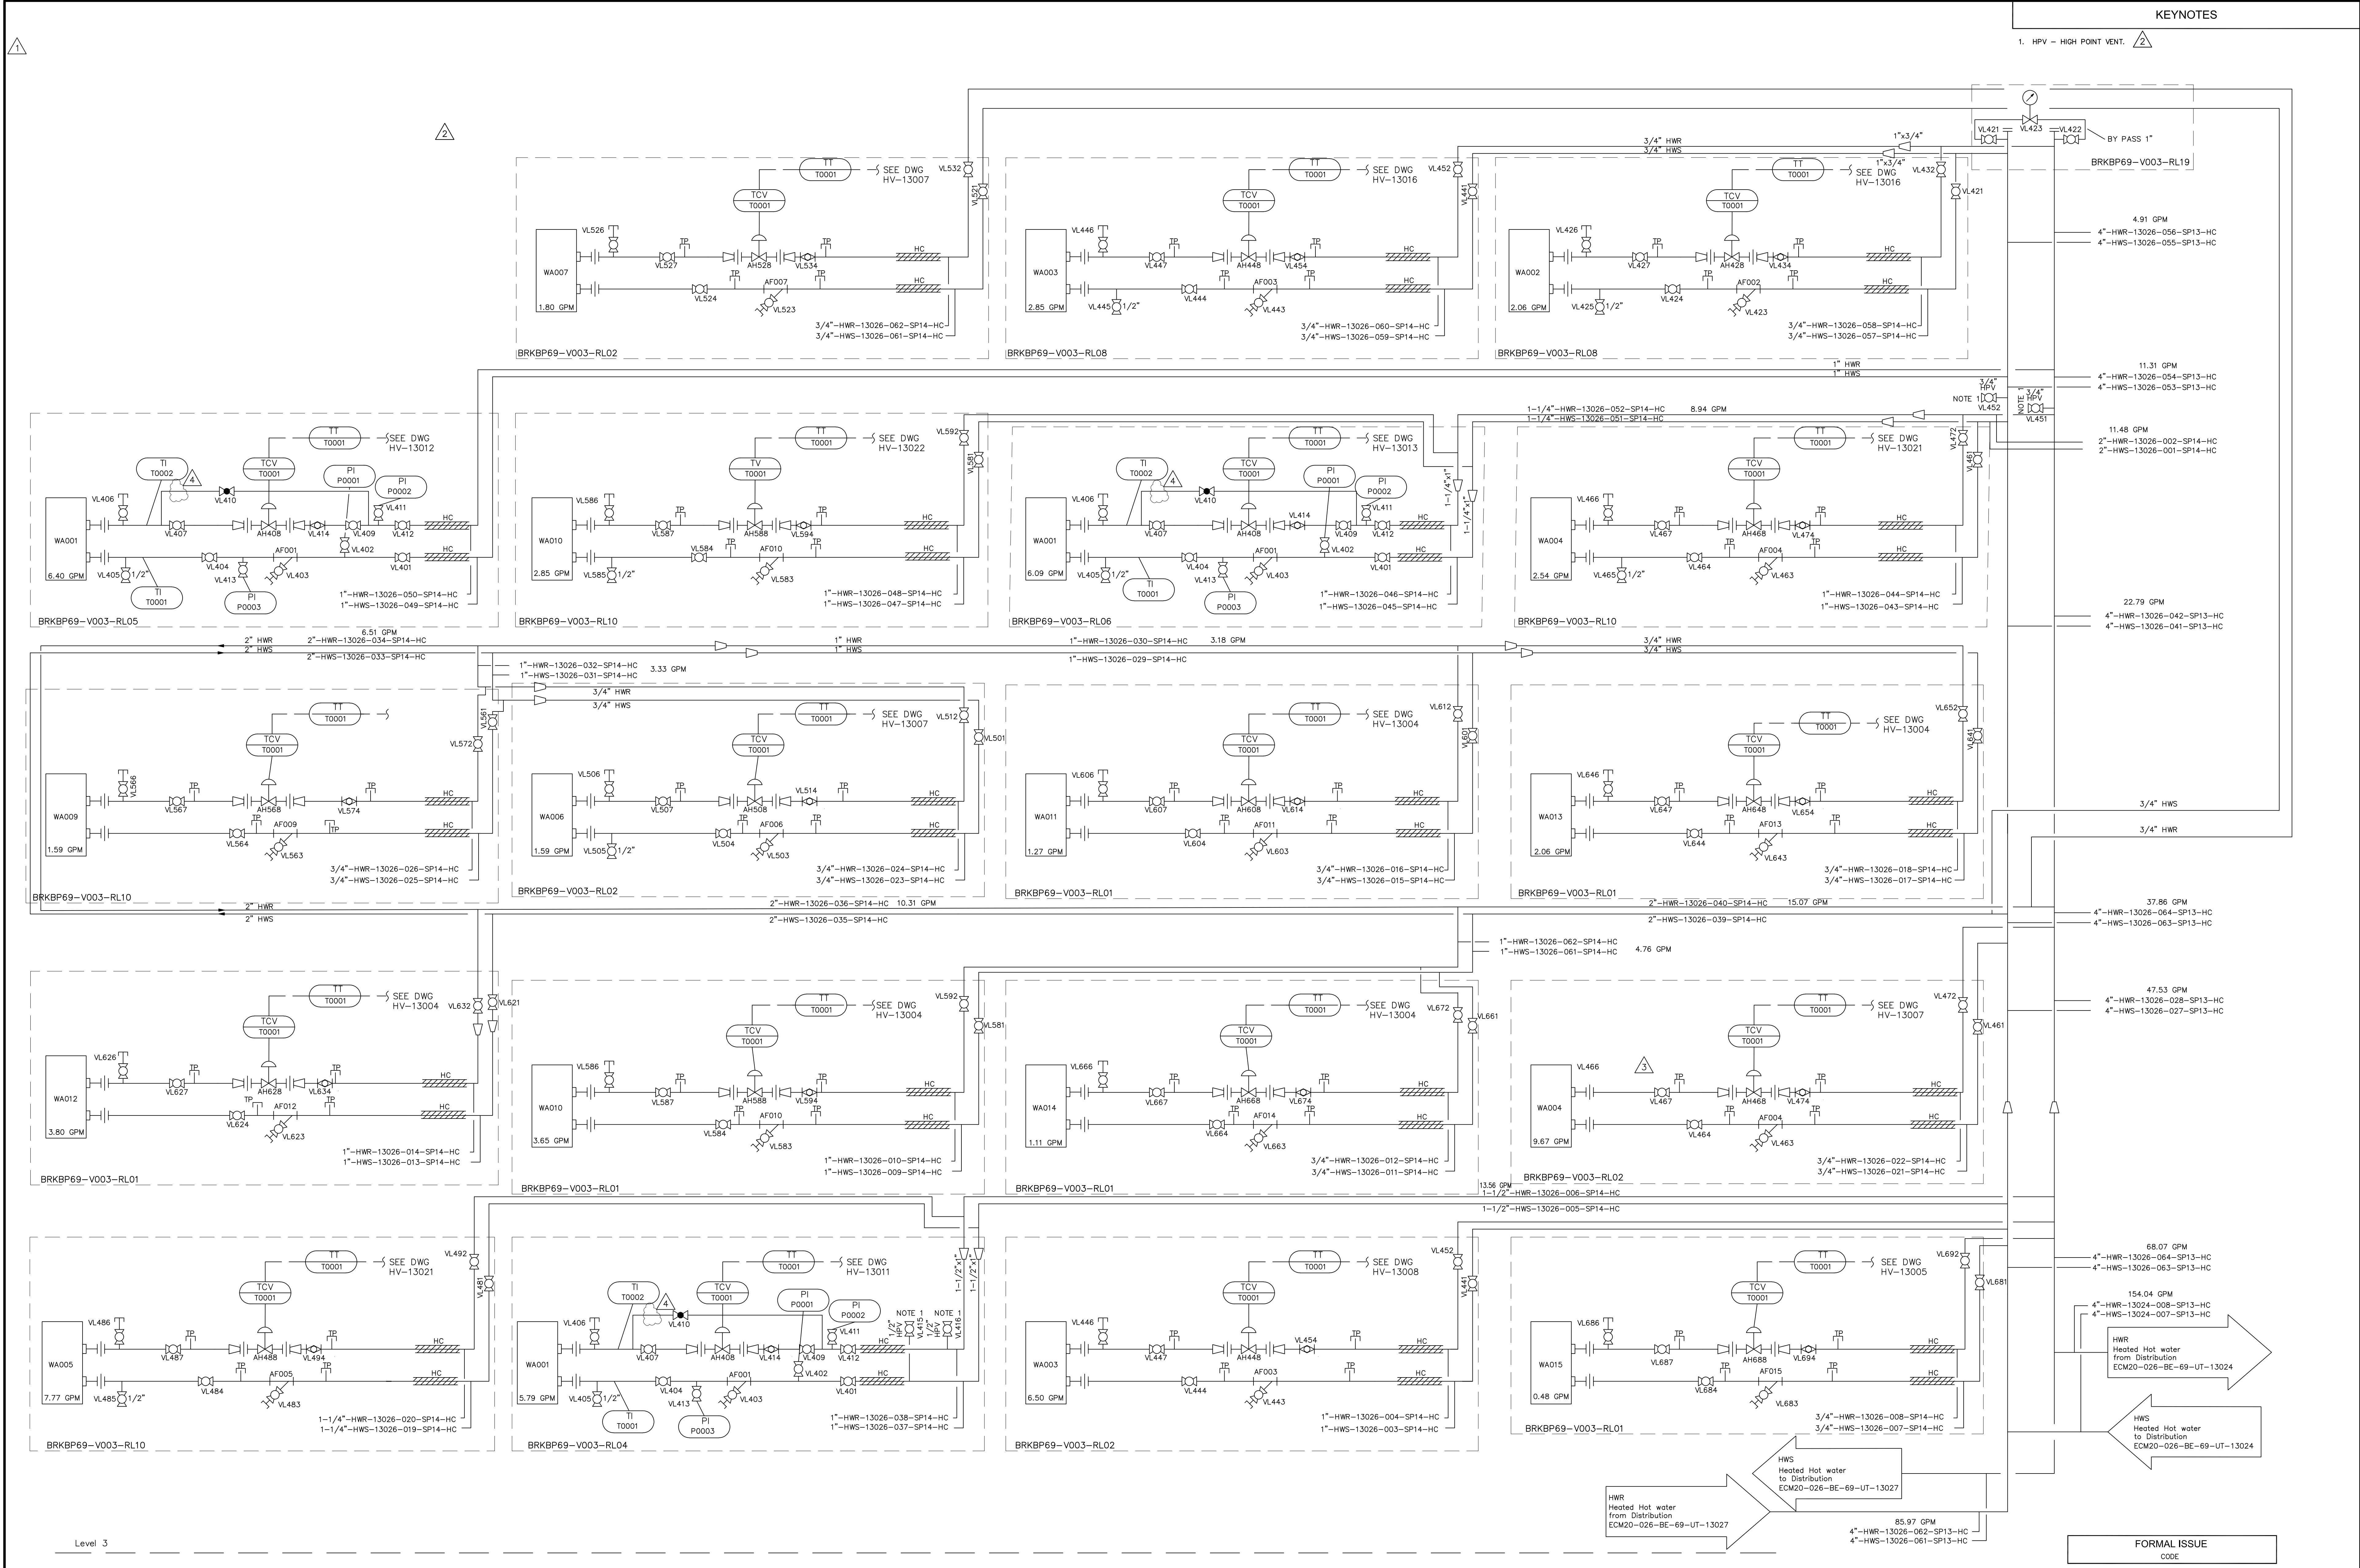



KEYNOTES

1. HPV - HIGH POINT VENT.

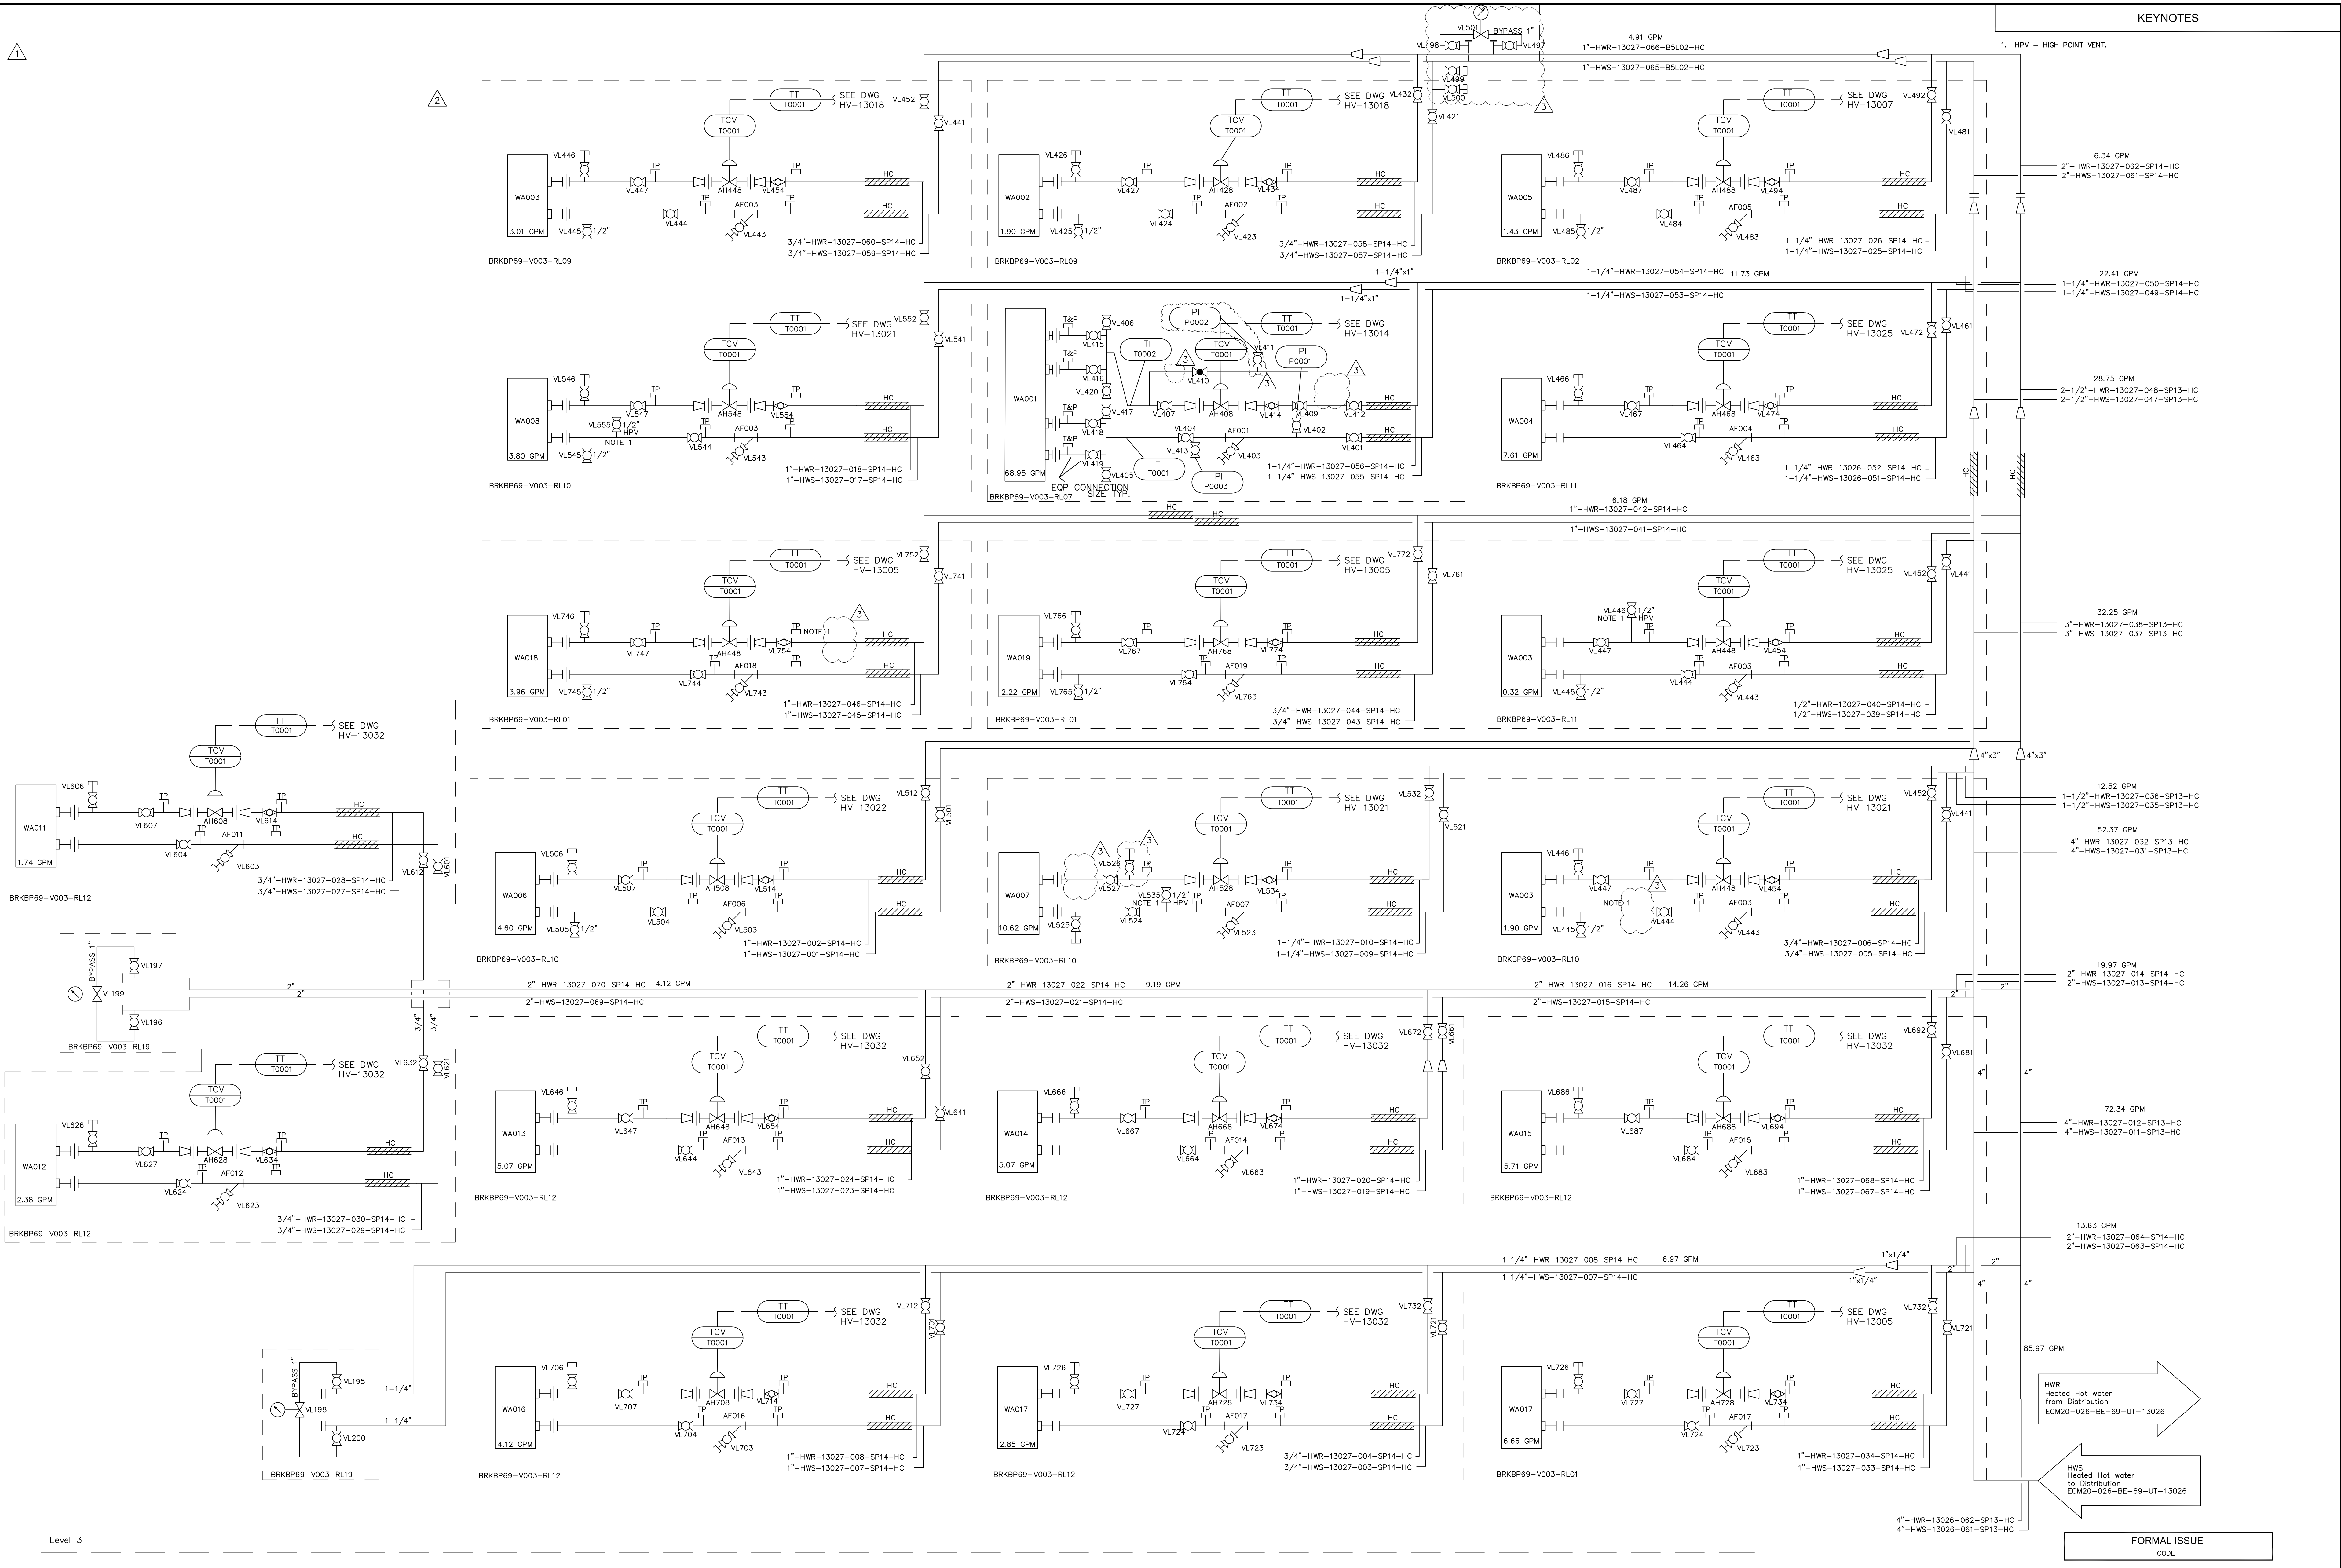

HWR
Heated Hot water
from Distribution
ECM20-026-BE-69-UT-13026

HWS
Heated Hot water
to Distribution
ECM20-026-BE-69-UT-13026

FORMAL ISSUE

CODE

Title: LEVEL 3 HEATING HOT WATER SYSTEM P&ID			
Drawing Number: ECM20-026-BE-69-UT-13027	As-Built	Project	3
Scale: N.T.S.	Revision No.		

US310086_A6_DR_0005

GENERAL NOTES


A. SPOOL PIECE TO BE LEFT FOR FUTURE FLOW/ENERGY METER INSTALLATION.

KEYNOTES

- 1

TEMPORARY SPOOL PIECE SHALL BE REMOVED UPON FUTURE USE WHEN GLYCOL IS LIVE. PURPOSE OF SPOOL PIECE IS FOR PNEUMATIC PRESSURE TESTING FOR B69 CT MOD.
- 2

GAUGE TO REMAIN FOR MONITORING PRESSURE FOR NITROGEN HOLDING CHARGE.

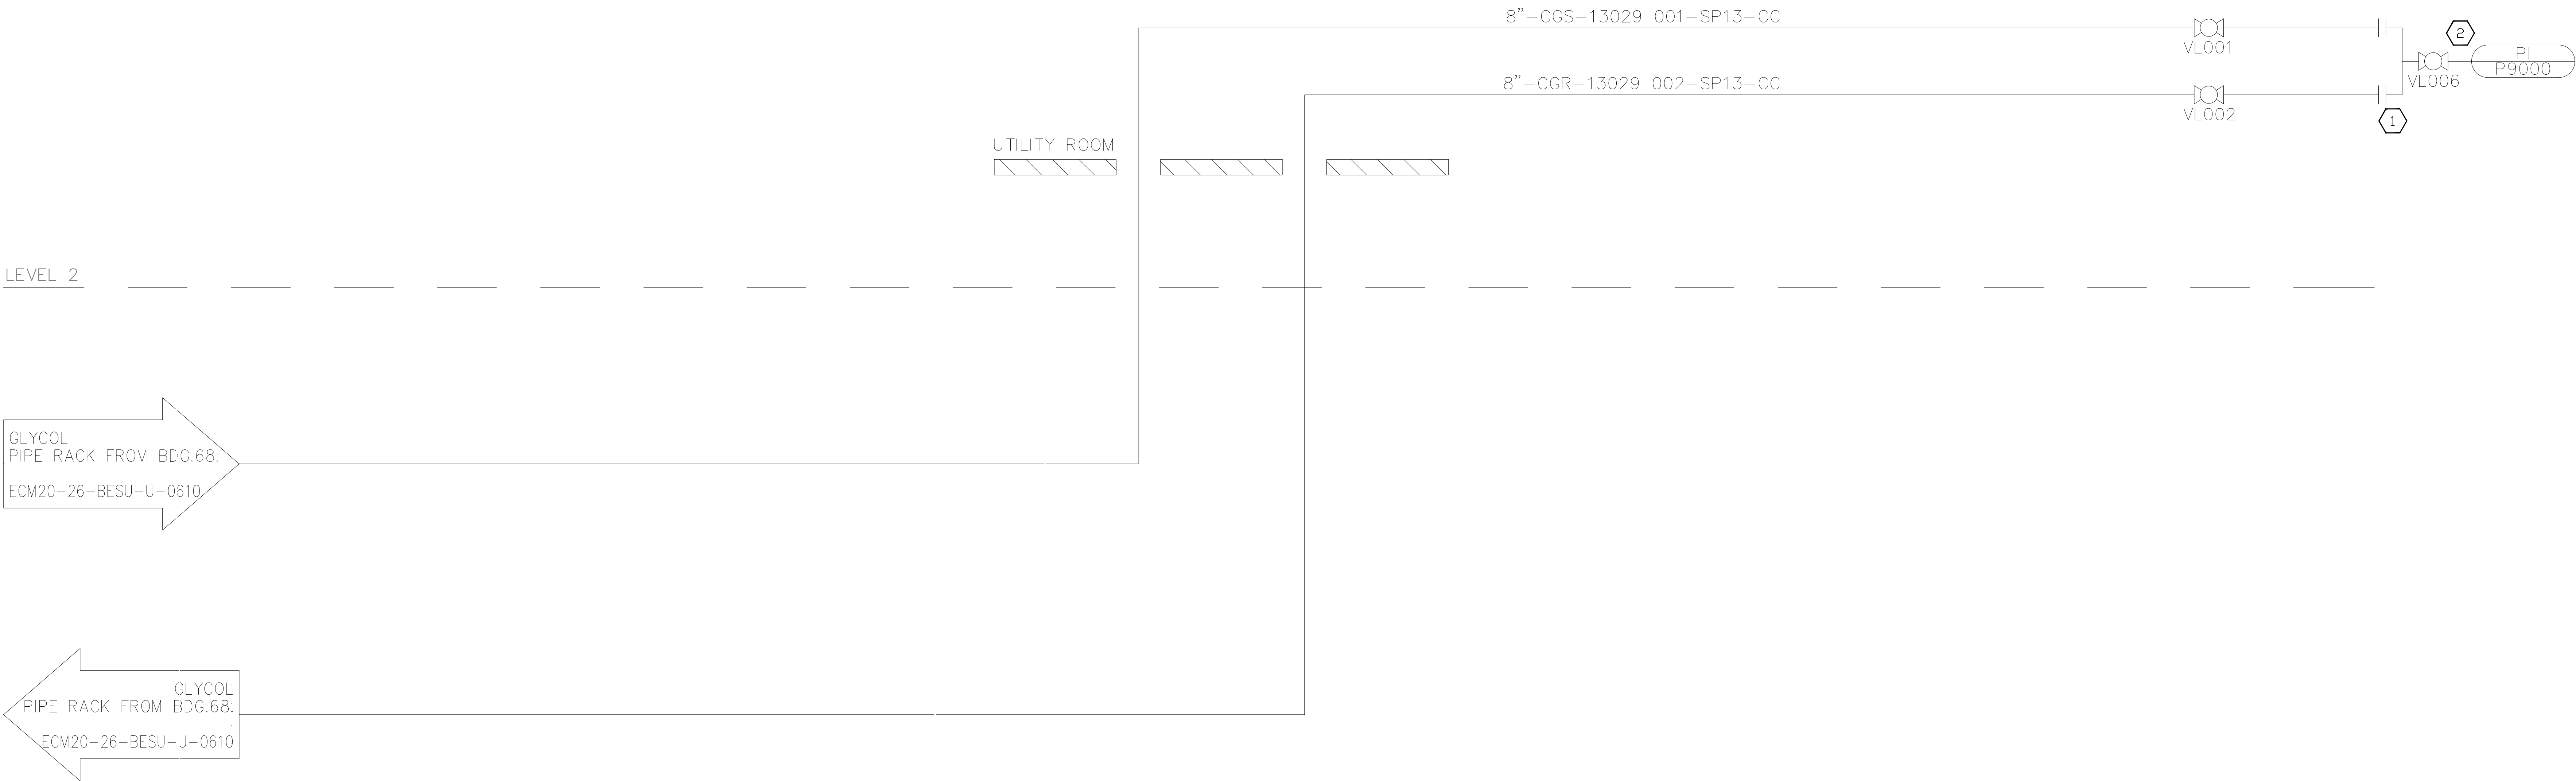


FORMAL ISSUE

20221005.102305 - SANDRO BARRIENTOS

Title: LEVEL 1 & 2 GLYCOL SCHEMATIC			
Drawing Number: ECM20-026-BE-69-UT-13029	As-Built	Project	1
Scale: N.T.S.	Revision No.		

SYSTEM NAME FOR ROOF LEVEL - BRKBP69-V004-RL19
SYSTEM NAME FOR SECOND LEVEL - BRKBP69-V002-RL19

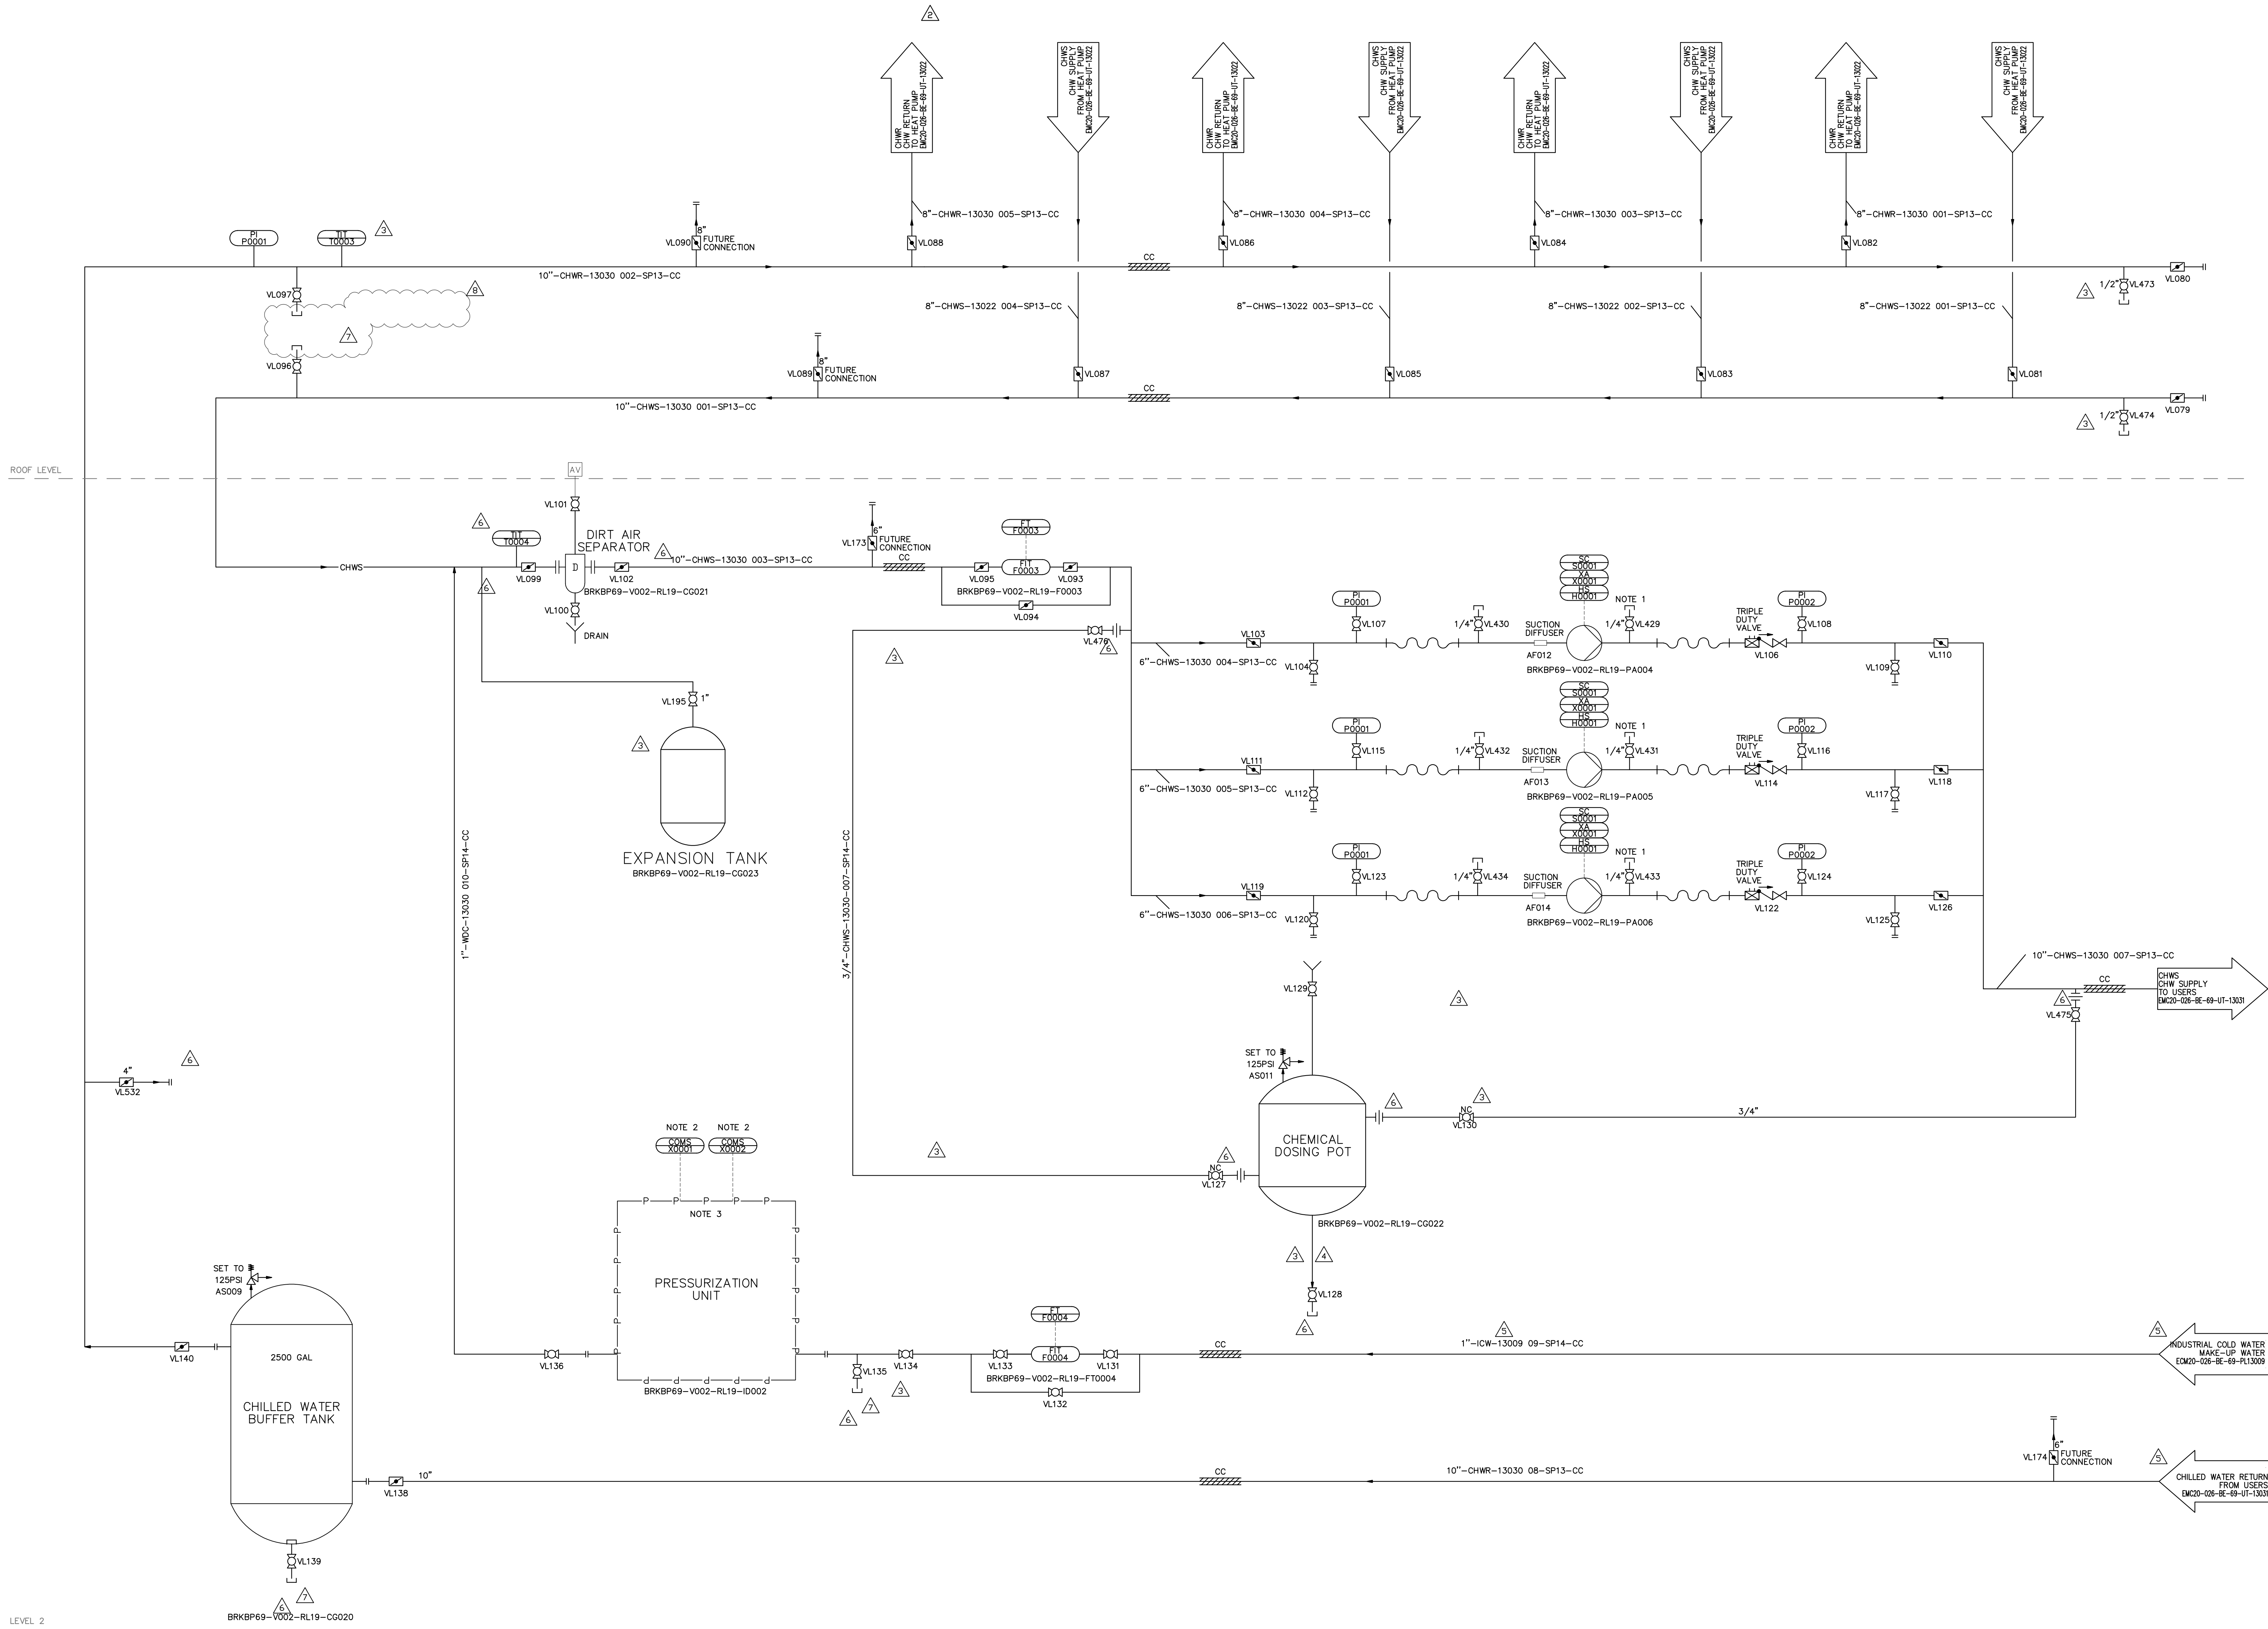

- KEYNOTES**
- MULTI-PRO CONTROLLER TO CONTROL ALL HEAT PUMP UNITS SEQUENCING, CHILLED WATER & HEATING HOT WATER PUMPS VIA THE SYSTEM DIFFERENTIAL PRESSURES, AND BY-PASS VALVES FOR CHILLED WATER AND HEATING HOT WATER SYSTEMS.
 - CDMS LINK SHOULD PROVIDE STATUS AND ENABLE SIGNALS TO BAS.
 - CONTROL PANEL INCLUDED IN PRESSURIZATION SKID. PRESSURE SENSOR INSTALLED. PROVIDE COMMUNICATION WITH BAS.


- GENERAL NOTES**
- SEE DRAWING ECM20-026-BE-69-UT-13080, EQUIPMENT SCHEDULES FOR EQUIPMENT MODEL AND CAPACITIES.
 - INSTALL ALL EQUIPMENT AND ACCESSORIES PER MANUFACTURER'S INSTRUCTIONS.

FORMAL ISSUE
CODE

Title: LEVEL 1,2,3 CHILLED WATER GENERATION P&ID			
Drawing Number: ECM20-026-BE-69-UT-13030	As-Built	Project	8
Scale: N.T.S.	Revision No.		

US3810086_A6_DR_0070

1. HPV - HIGH POINT VENT.

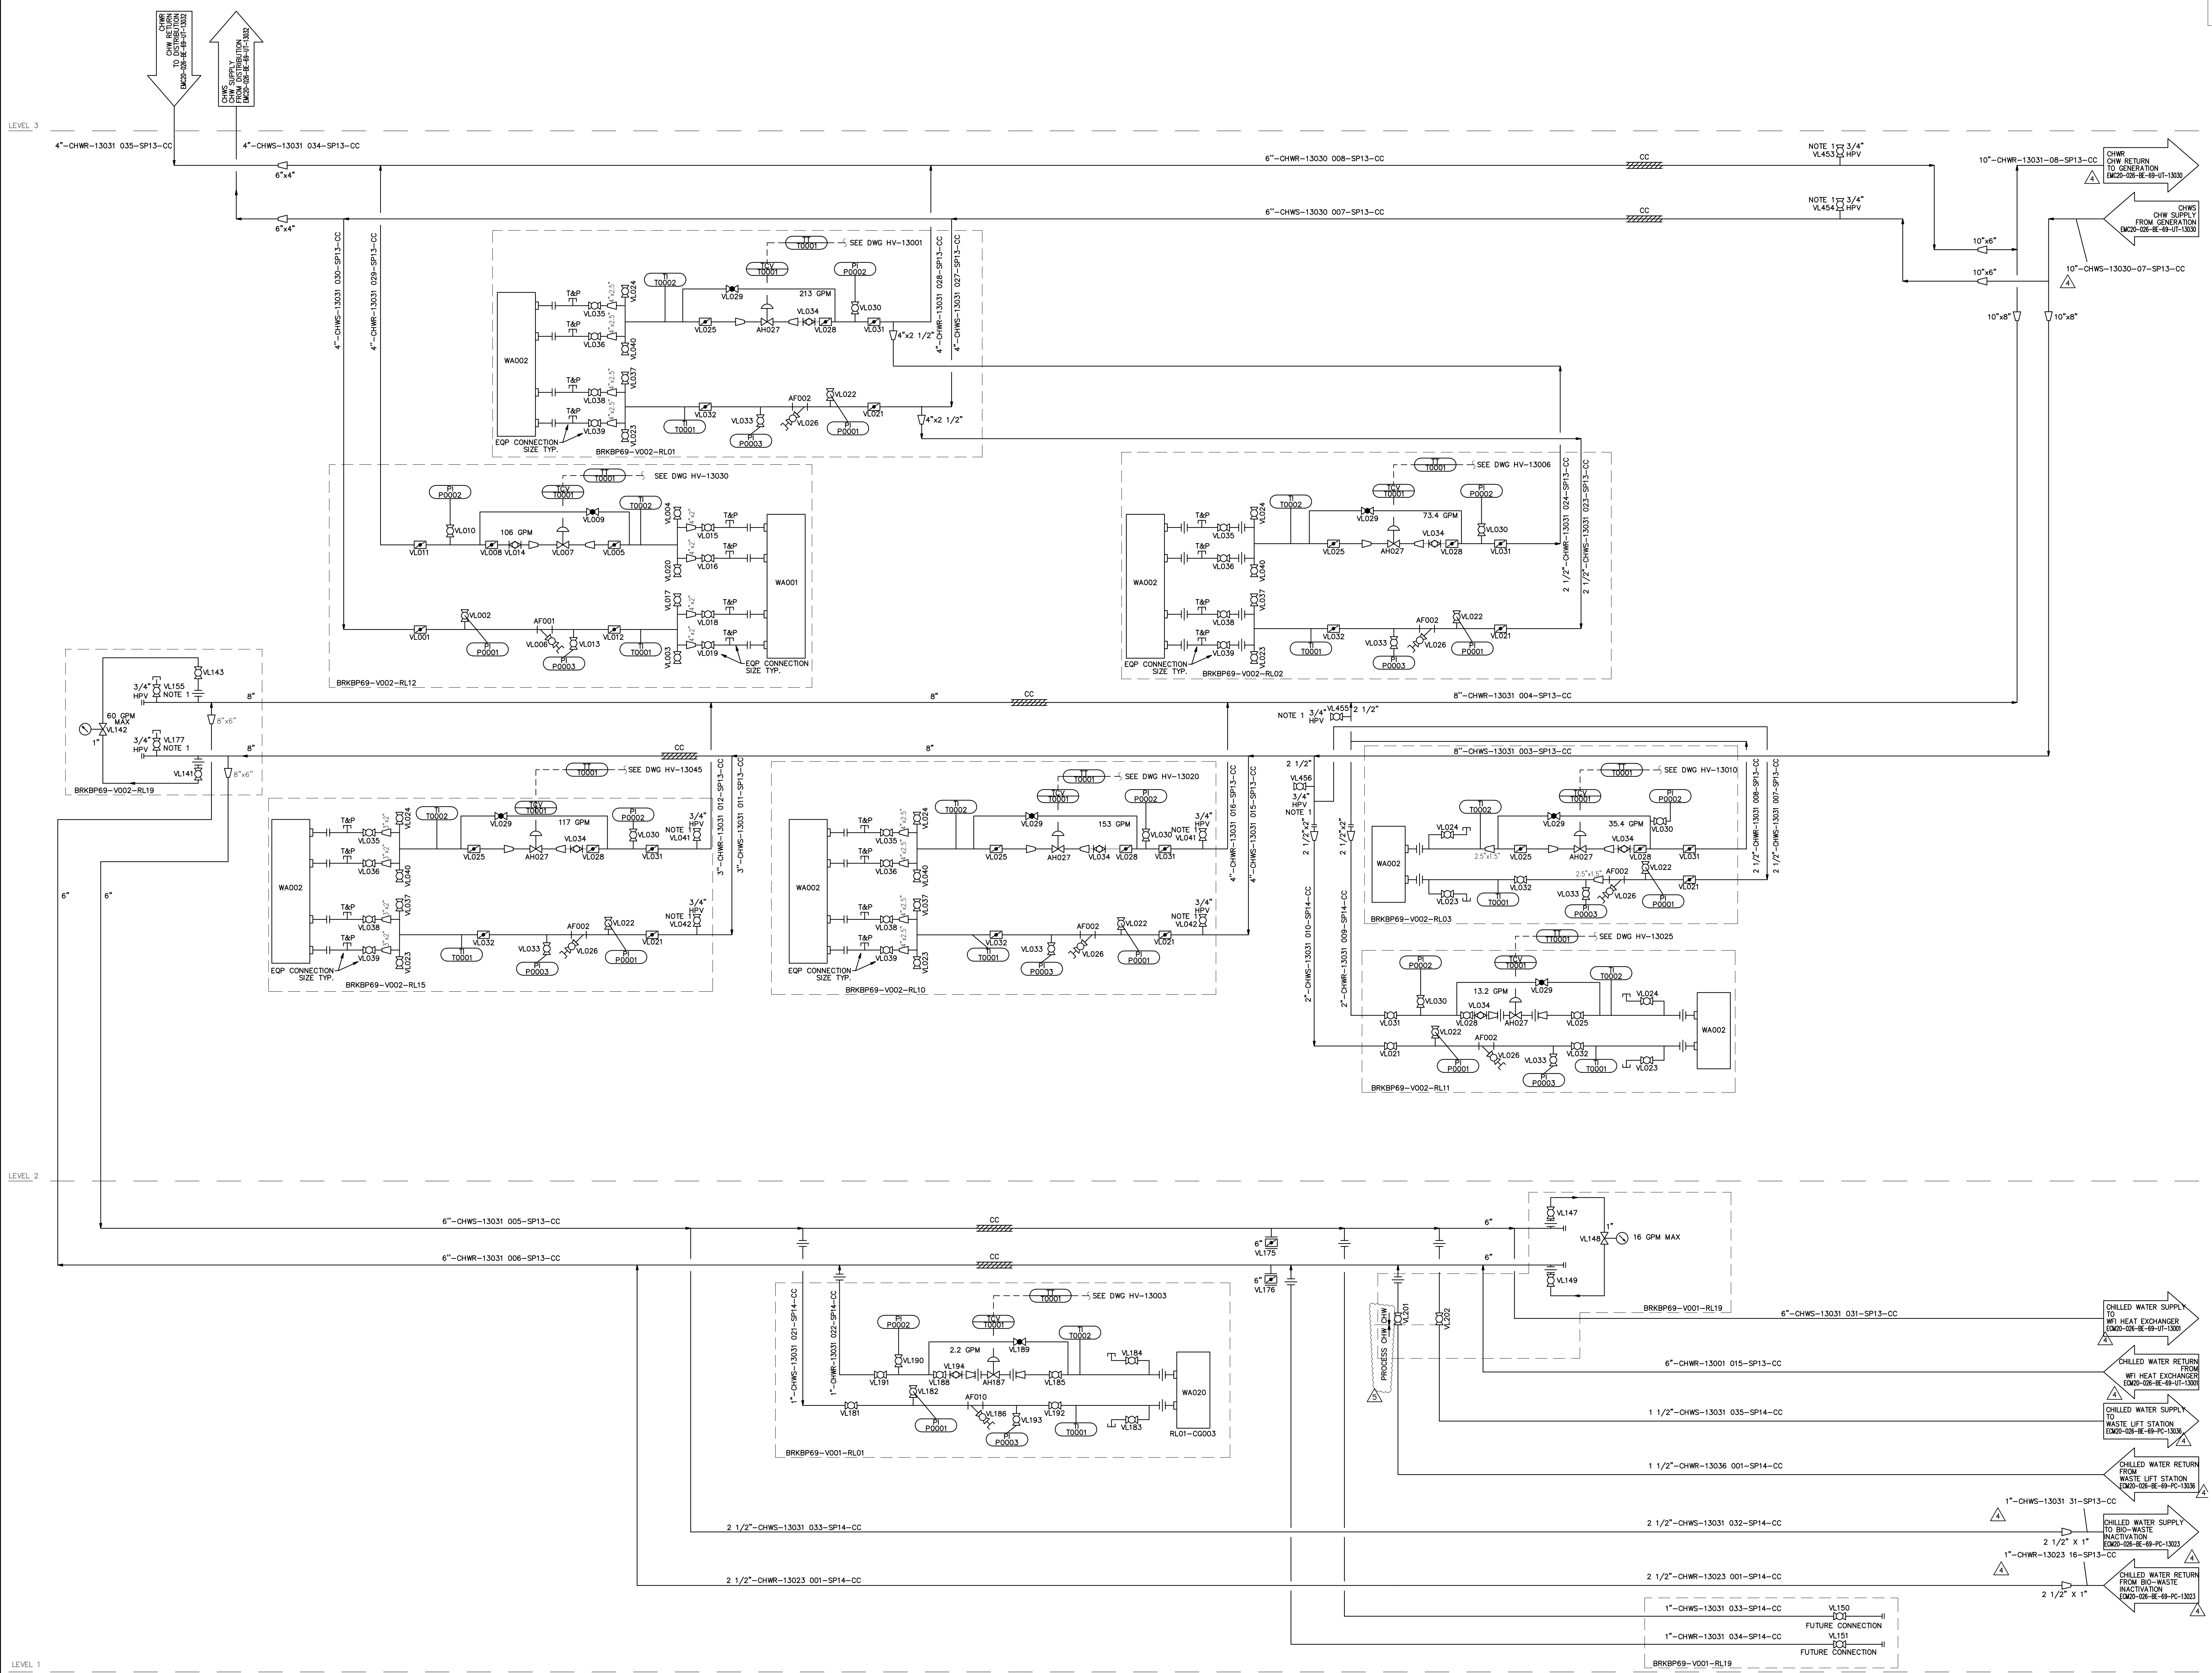

FORMAL ISSUE
CODE

Title: LEVEL 1.2.3 CHILLED WATER DISTRIBUTION P&ID			
Drawing Number: ECM20-026-BE-69-UT-13031	As-Built	Project	5
Scale: N.T.S.	Revision No.		

KEYNOTES


1. ATTACHED TO THE RETURN AIR DUCT. SEE AIR FLOW DIAGRAM.
2. HPV - HIGH POINT VENT.

HOLDS

- 1 FLOWRATE TO BE CONFIRMED BY PROCESS

FORMAL ISSUE
CODE

Title: LEVEL 3 CHILLED WATER DISTRIBUTION P&ID			
Drawing Number: ECM20-026-BE-69-UT-13032	As-Built	Project	7
Scale: N.T.S.	Revision No.		

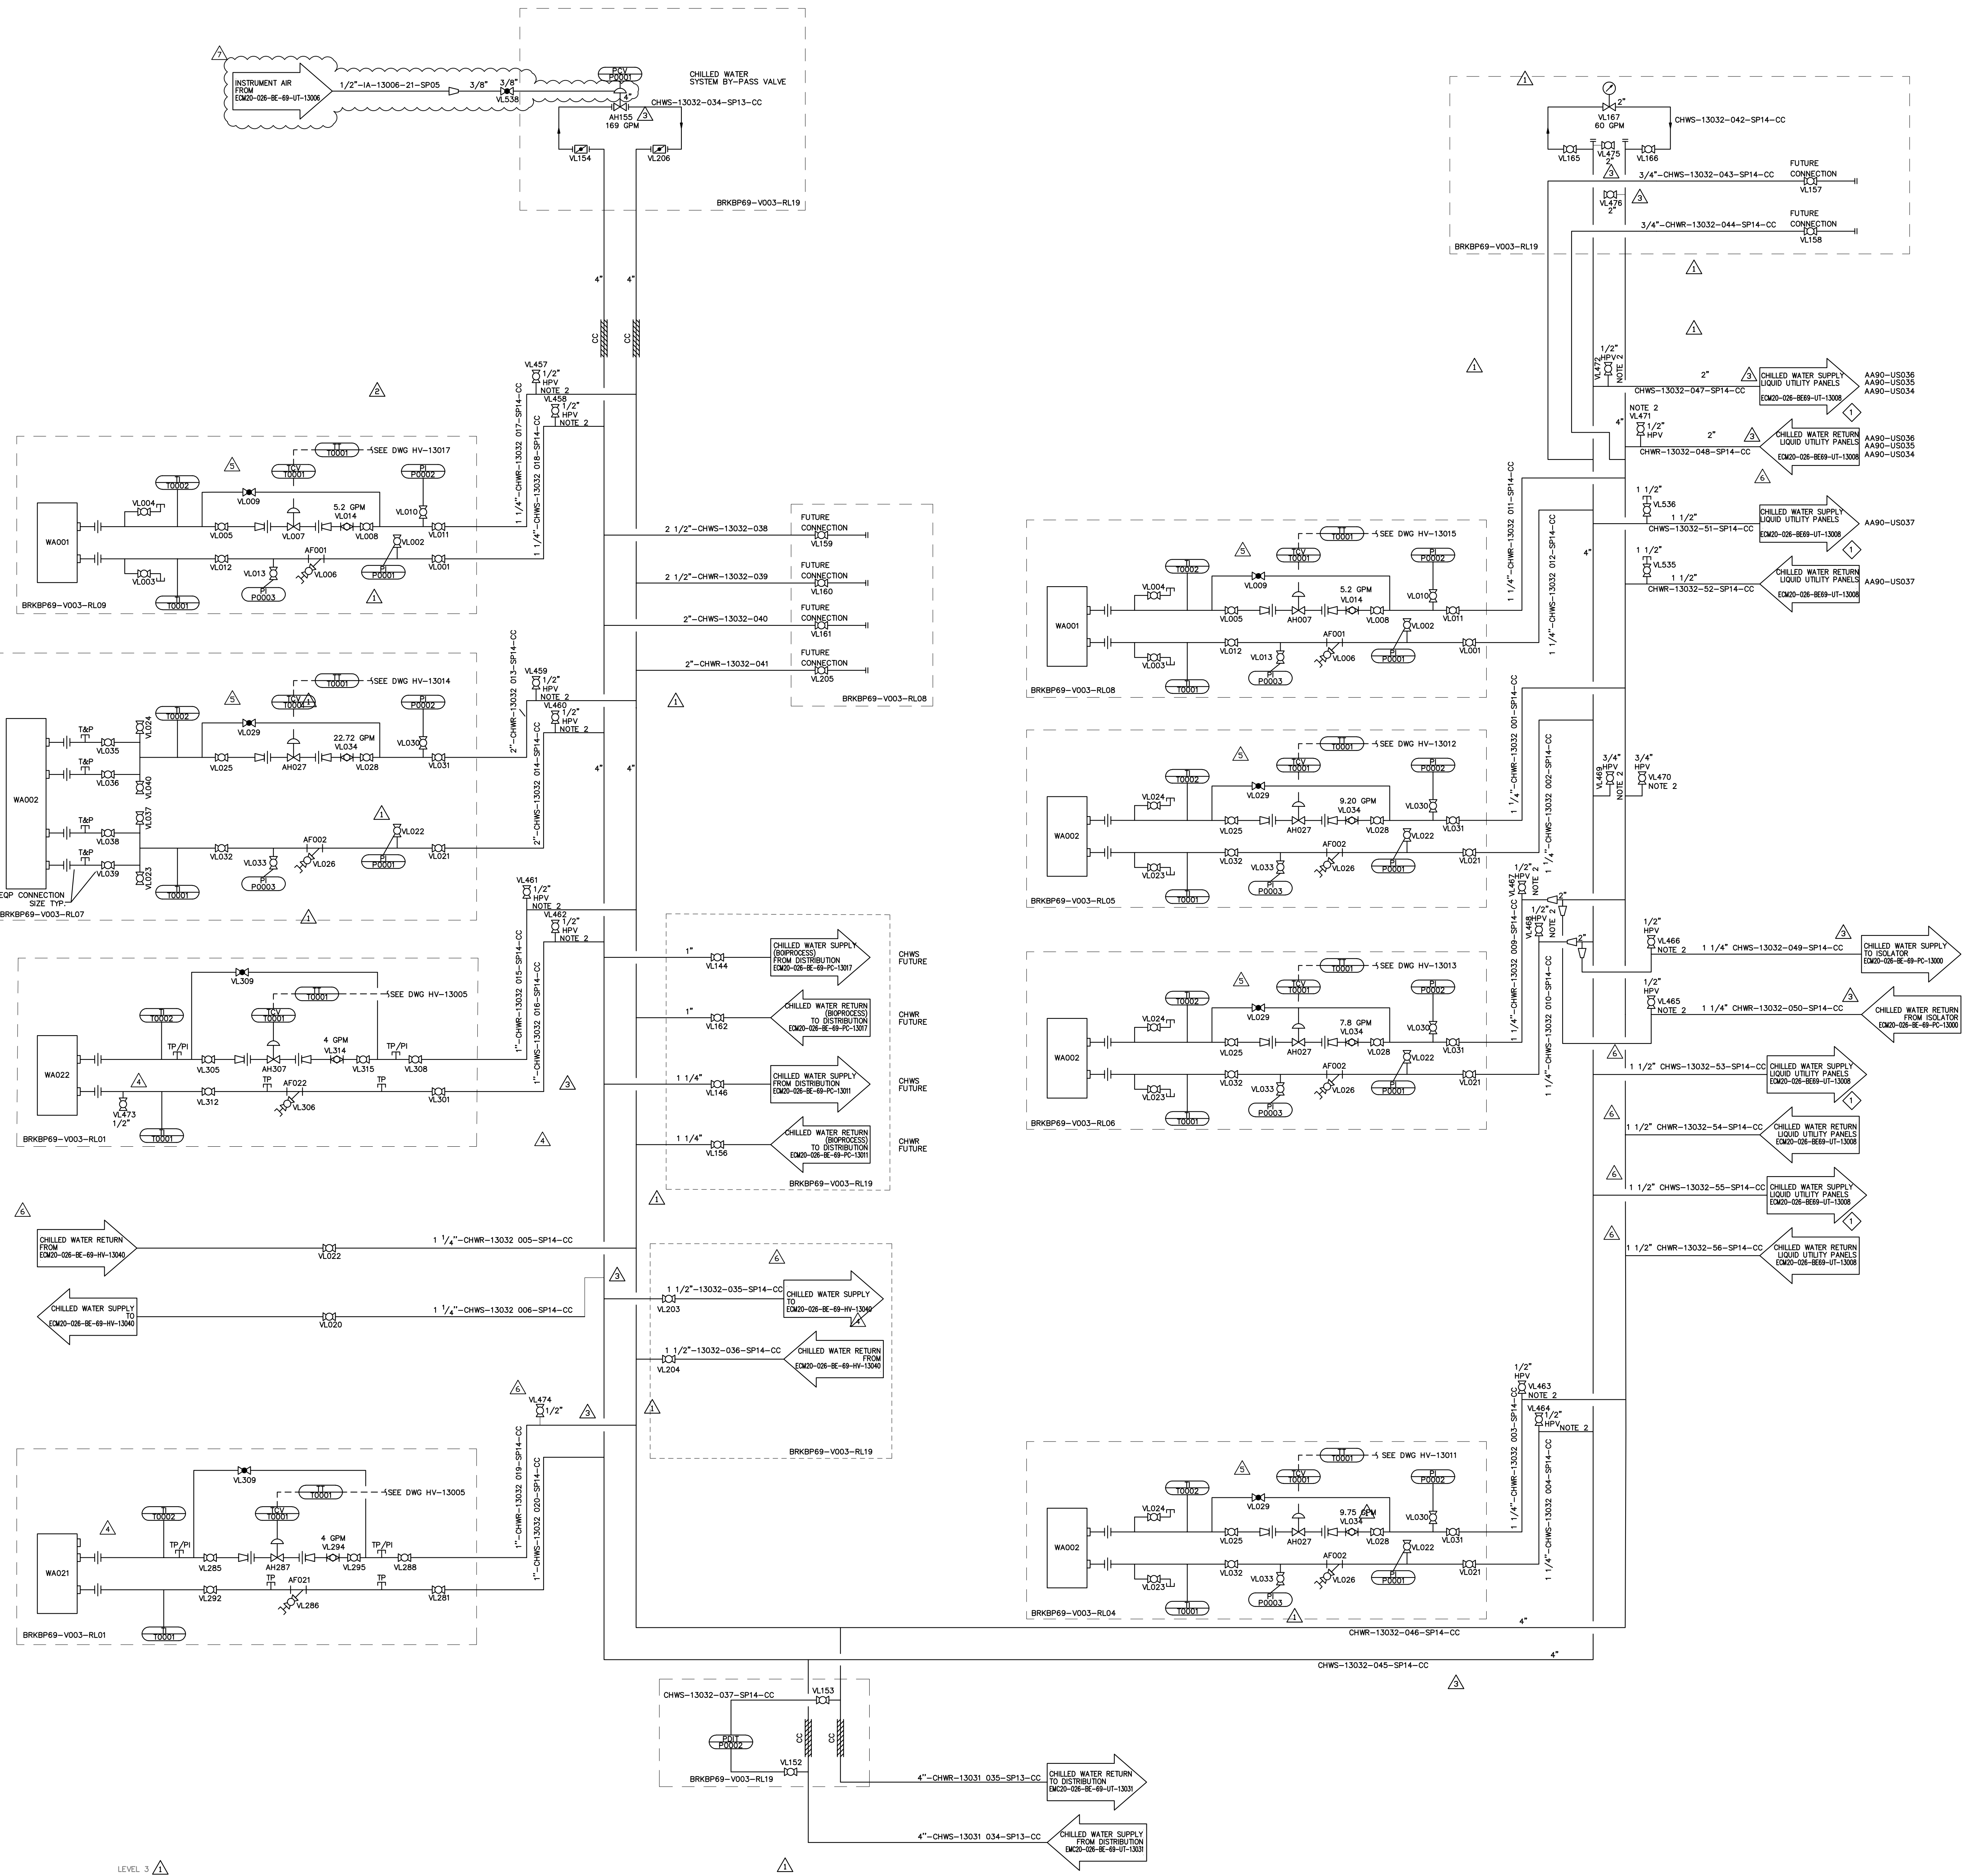

KEYNOTES

1. ALL PIPING MUST COMPLY WITH ASME, B31-1 POWER PIPING.
2. NO GALVANIZED PIPING FOR THESE SERVICES.
- PLEASE REFER TO THE BOILER INSTRUCTION MANUAL FOR BOILER FEED WATER SPECIFICATION.

GENERAL NOTES

- HC

-

PRESSURE HIGH LIMIT CONTROL.
- LGI

-

LEVEL GLASS BLOWDOWN TANK.
- LGR

-

LEVEL GLASS CONDENSATE RETURN TANK.
- LC1

-

AUTOMATIC WATER REFILL & PRIMARY LDW WATER CUT OFF CONTROLLER W/ LEVEL GLASS.
- LC2


-

SECONDARY LDW WATER CUT OFF SENSOR FOR BOILER CONTROLLER.
- BDV

-


AUTOMATICALLY OPERATING FLUSH AND DRAIN VALVE.

HOLDS

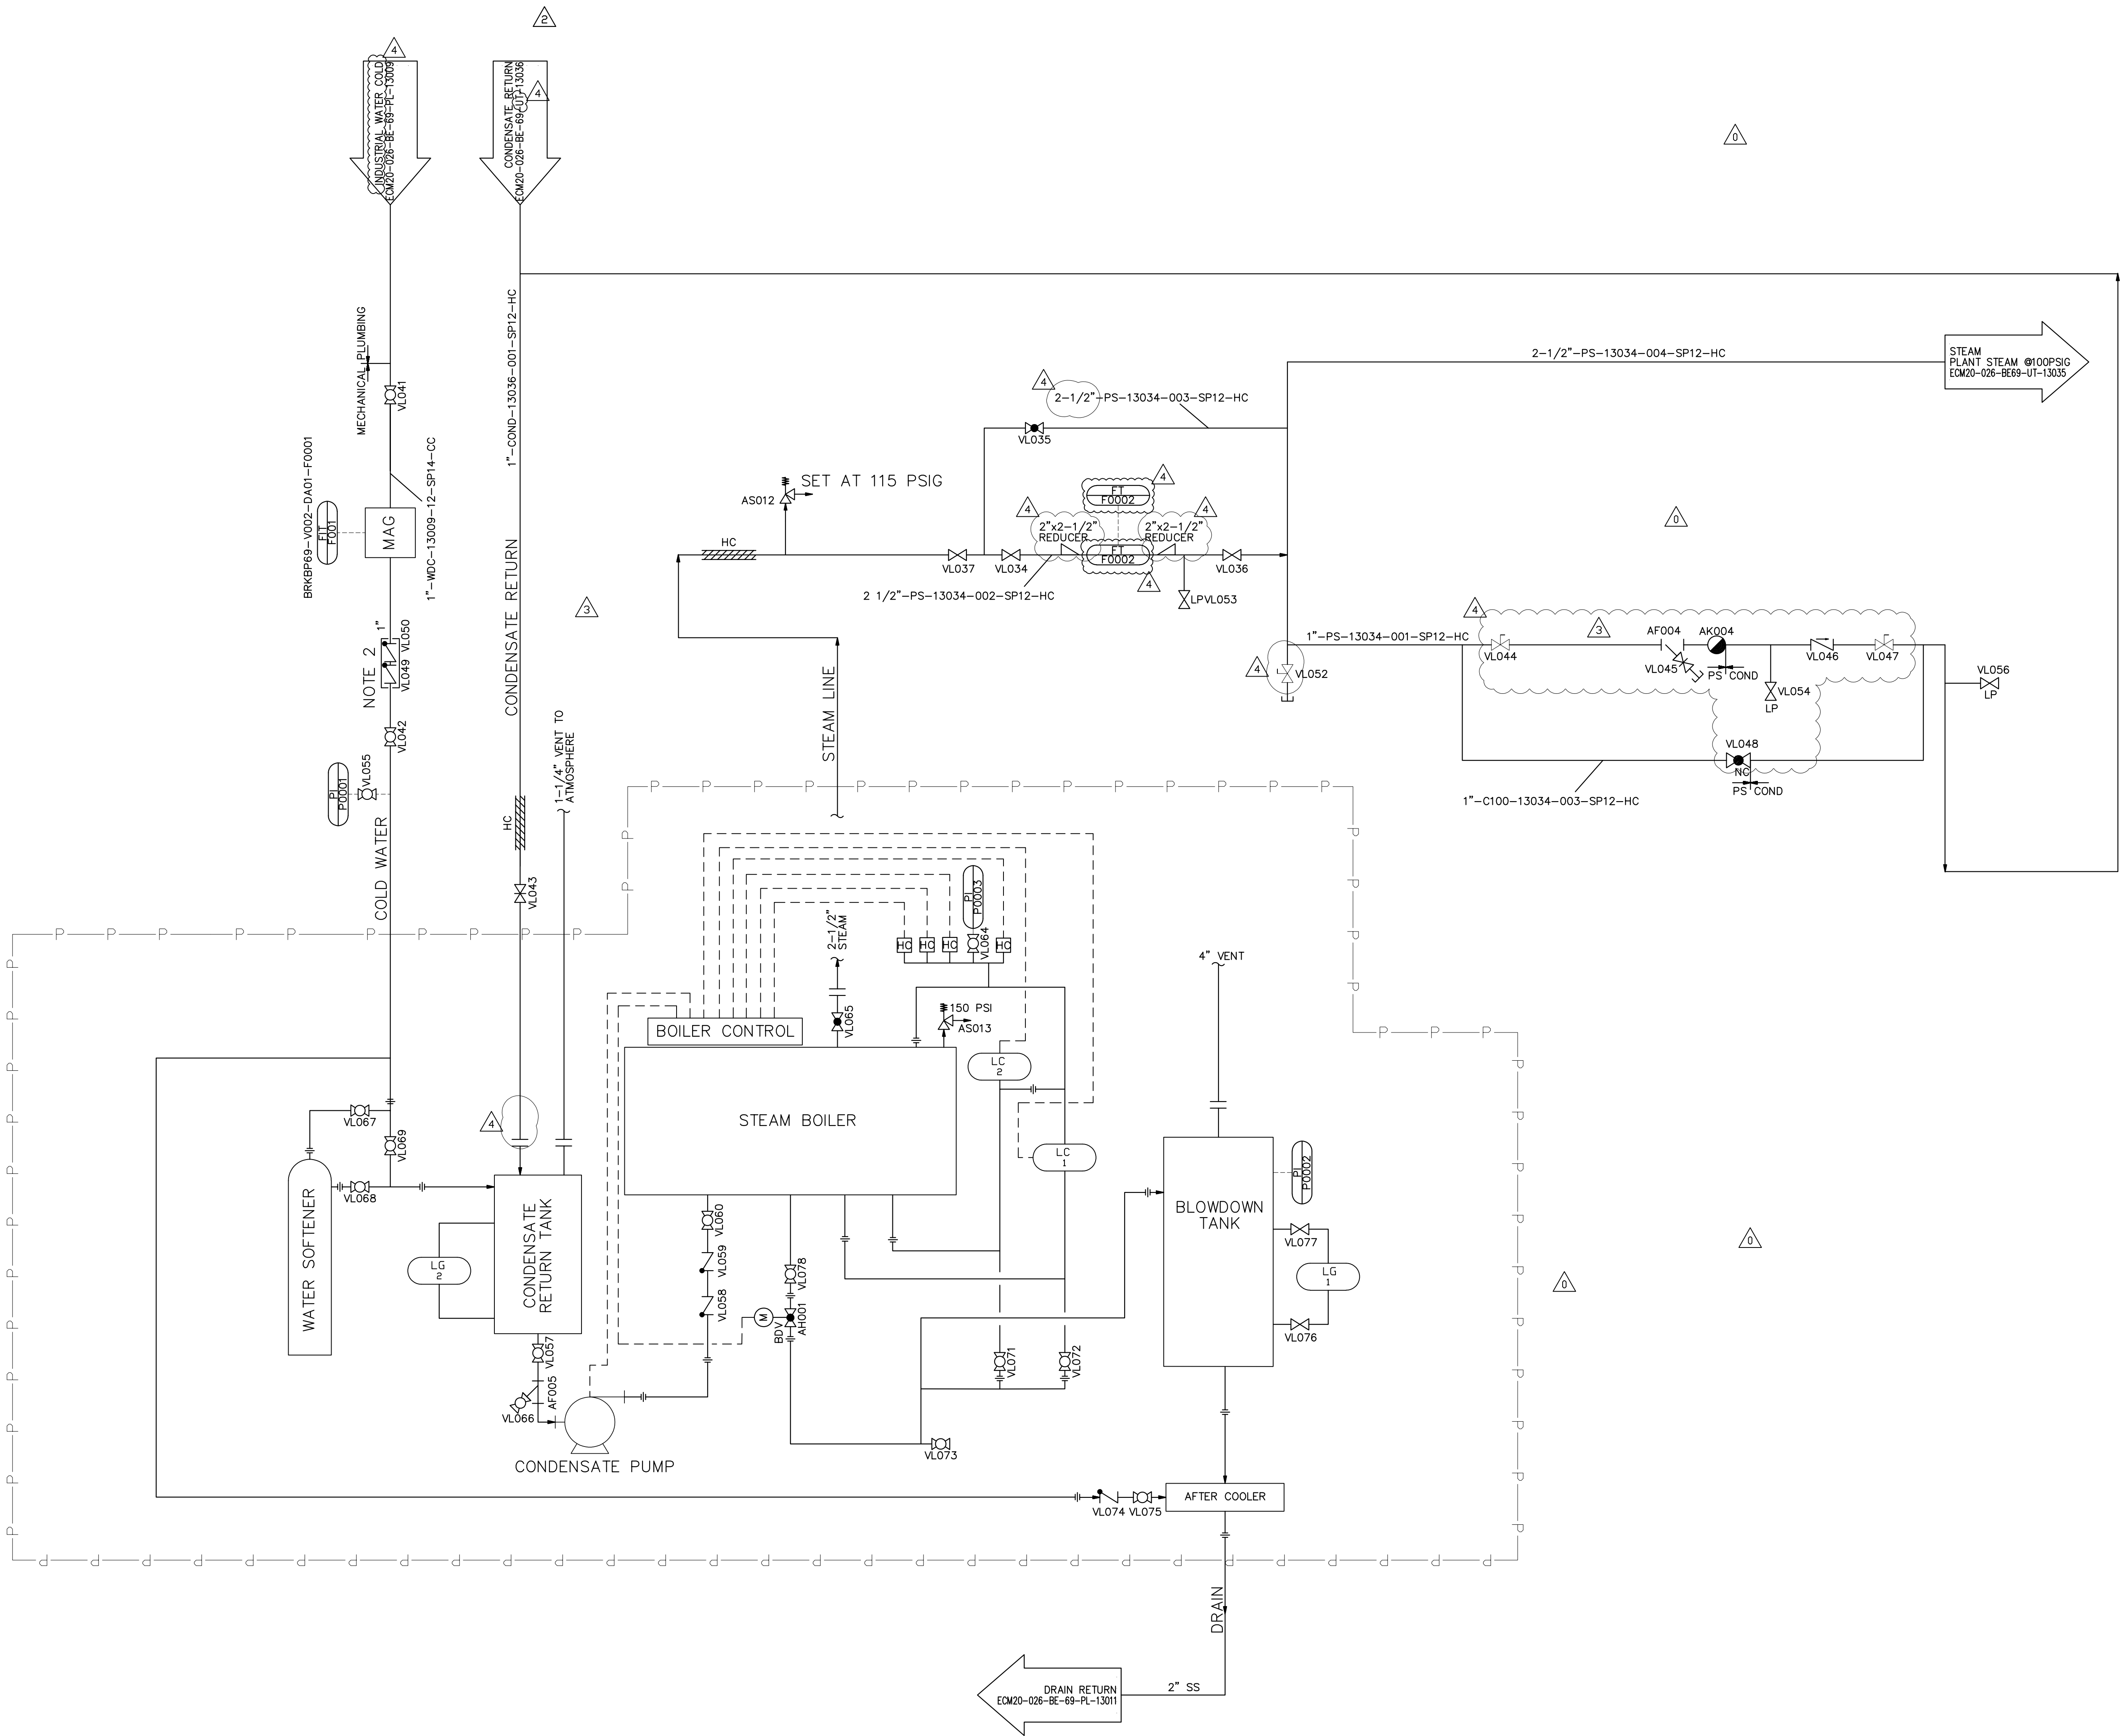

FORMAL ISSUE
CODE

Title: PLANT STEAM GENERATION P&ID			
Drawing Number: ECM20-026-BE-69-UT-13034	As-Built	Project	4
Scale: N.T.S.	Revision No.		

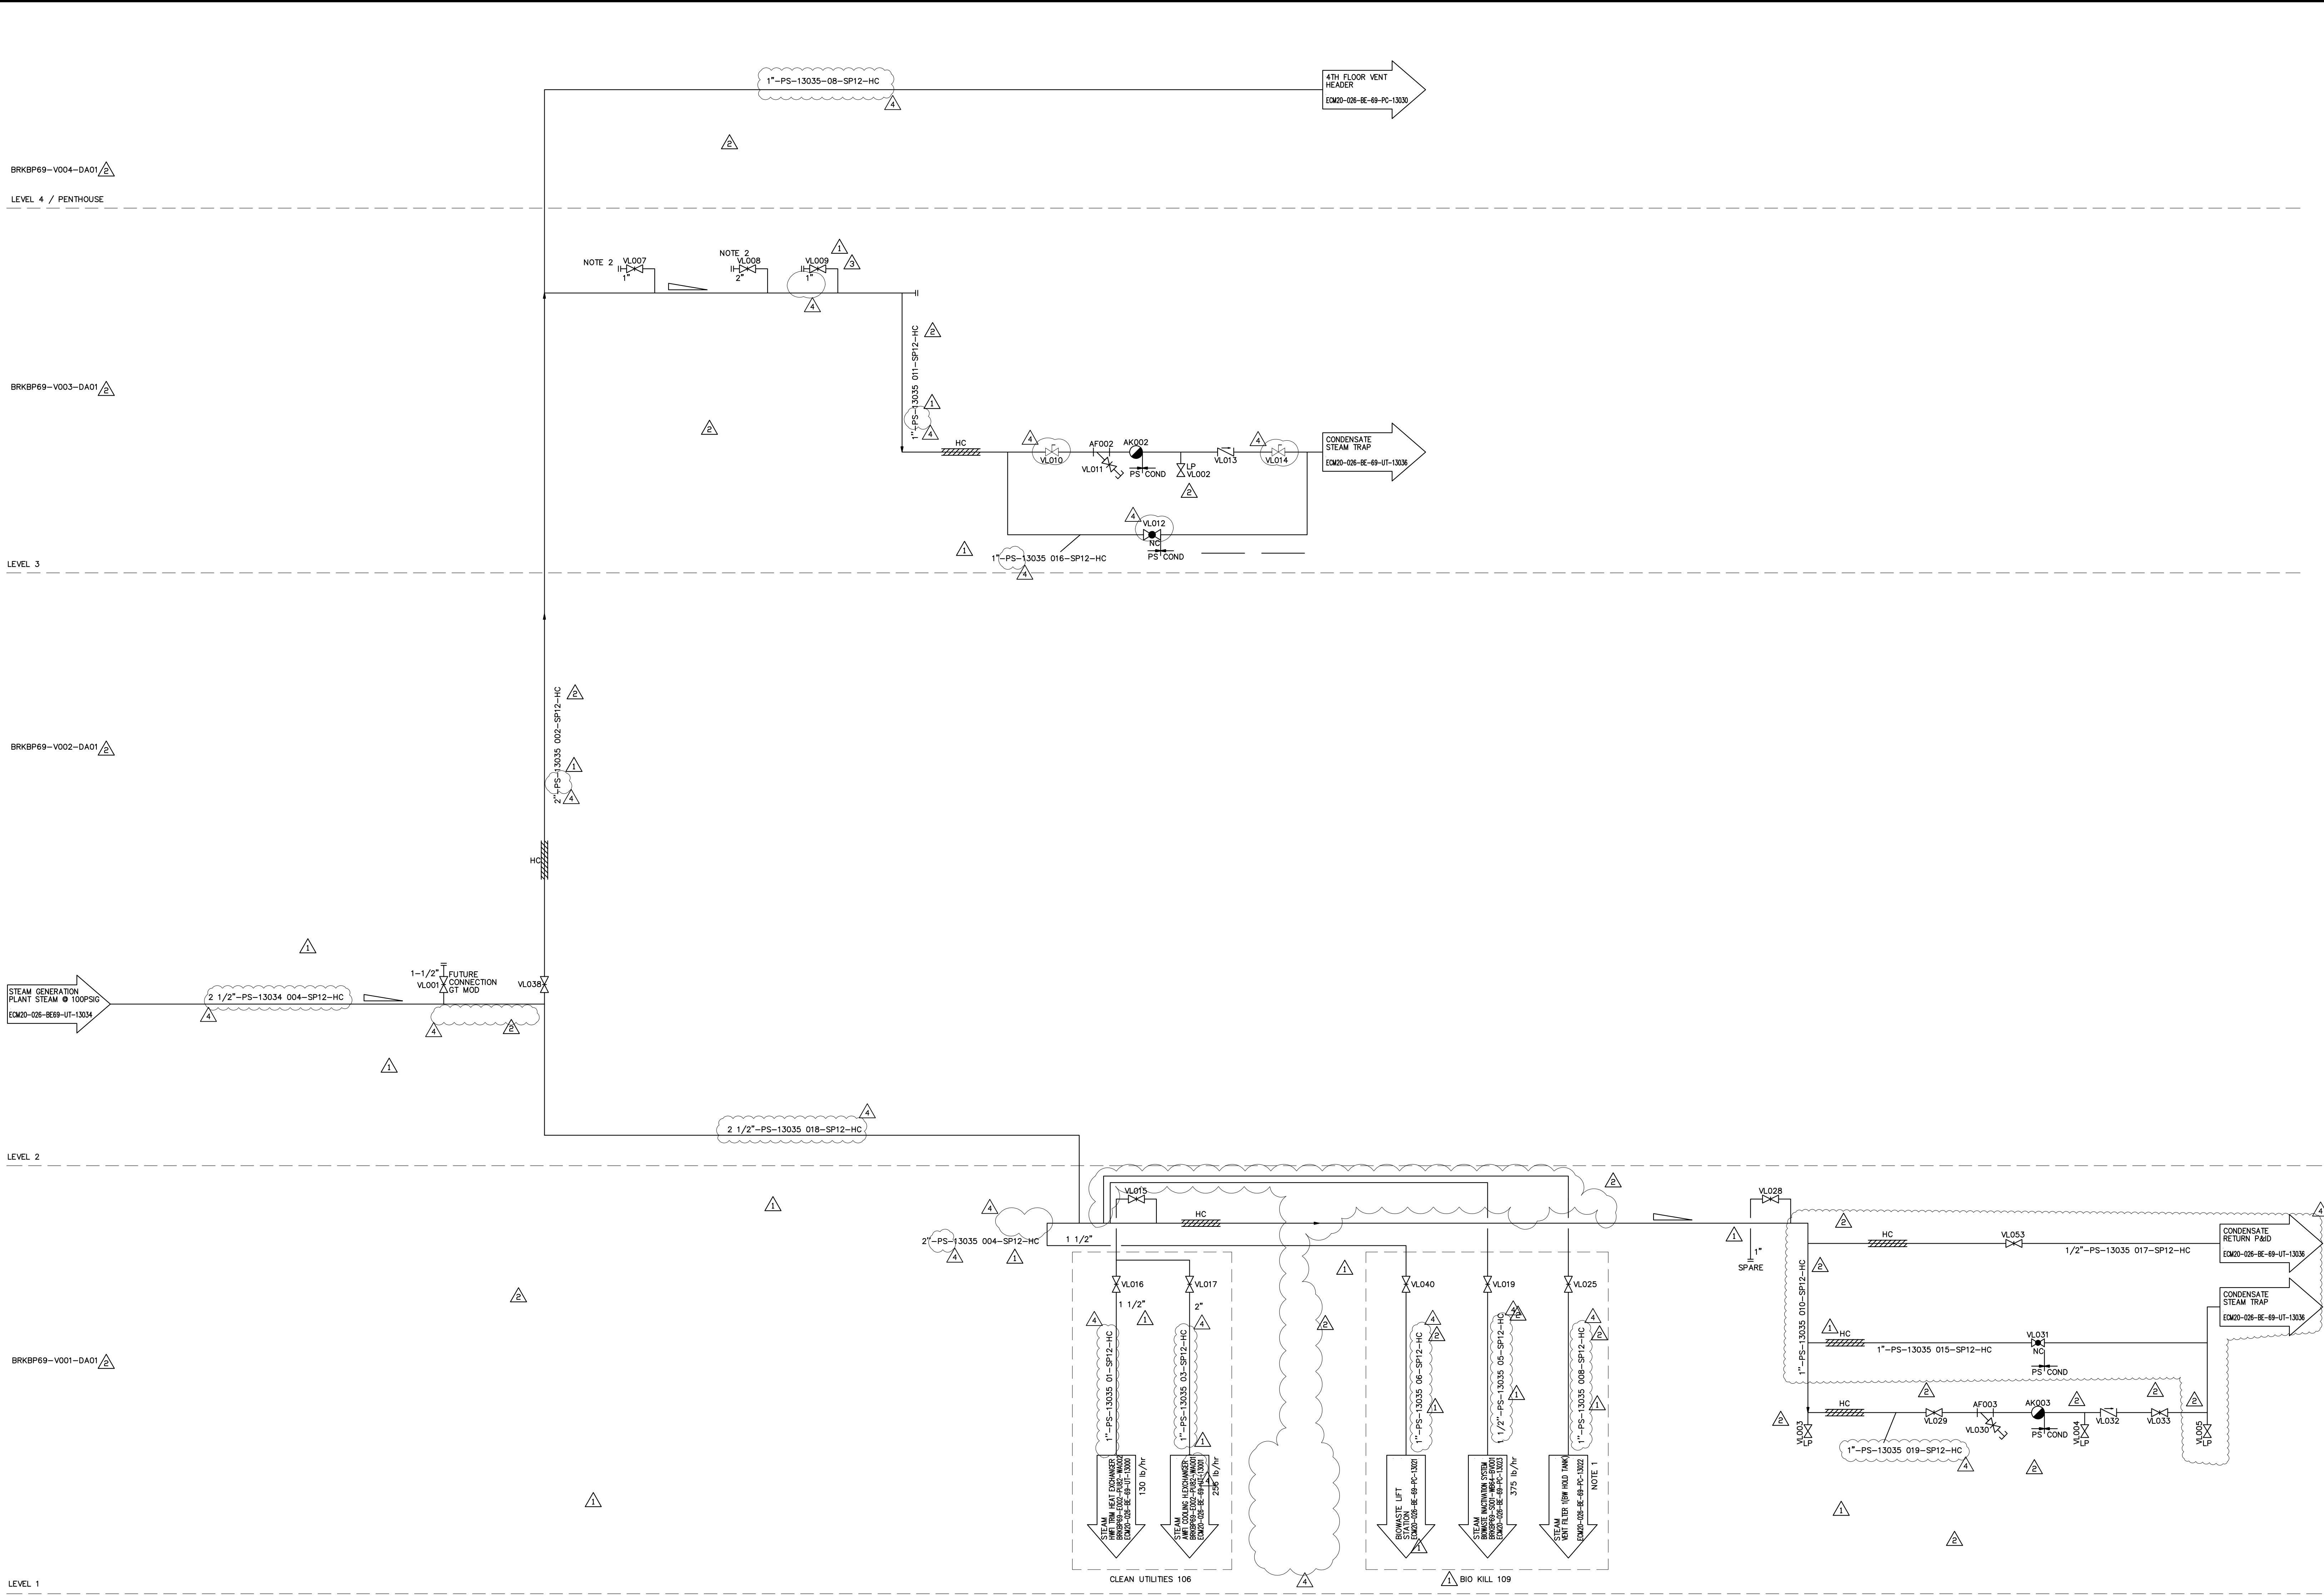


- KEYNOTES
1. PEAK LOAD IS MINIMAL.

2. FUTURE CONNECTIONS FOR PARTS WASHER & AUTOCLAVE.
- GENERAL NOTES
- HOLDS

FORMAL ISSUE
CODE

Title: PLANT STEAM DISTRIBUTION P&ID		
Drawing Number: ECM20-026-BE-69-UT-13035	As-Built	Project
Scale: N.T.S.	Revision No.	4

US3510586_46_DR_0075

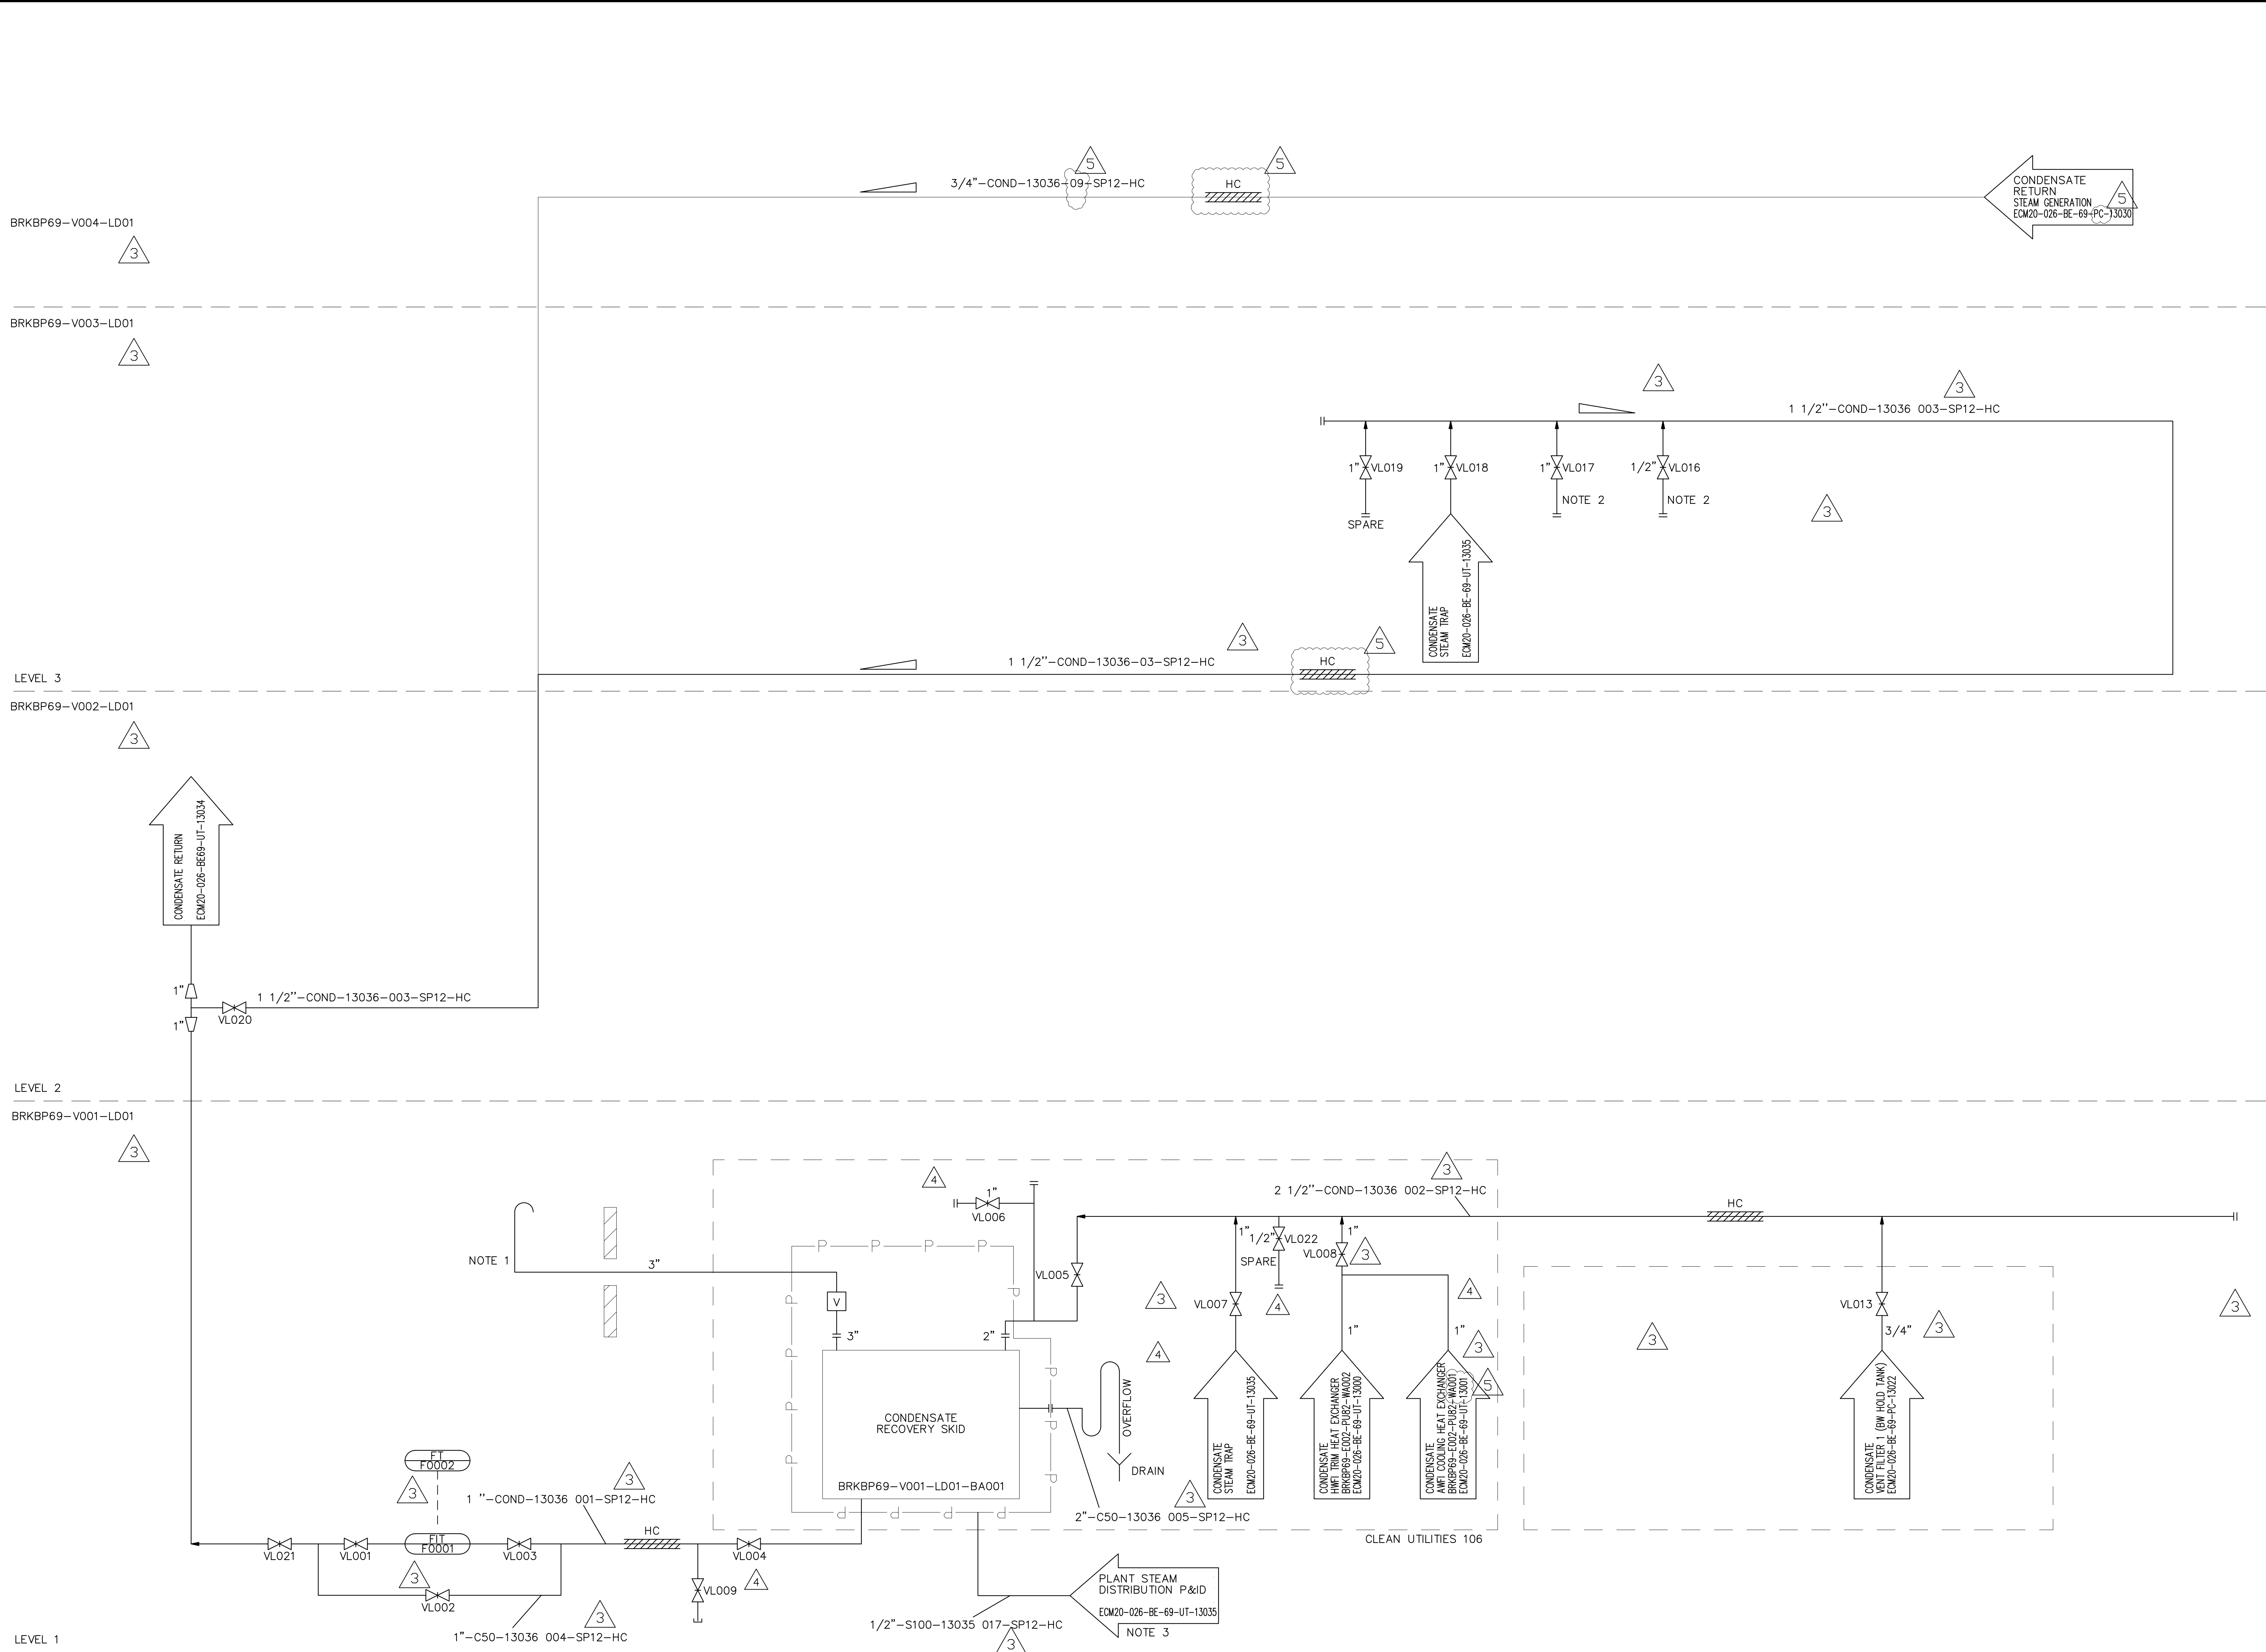

KEYNOTES

GENERAL NOTES

HOLDS

FORMAL ISSUE

CODE

Title:

CONDENSATE RETURN P&ID

Drawing Number:
ECM20-026-BE-69-UT-13036

As-Built Project
5

Scale: N.T.S.

Revision No.

US3810086_A6_DR_0076

HEAT PUMPS																																
				EVAPORATOR (COOLING ONLY MODE)								CONDENSER (HEATING ONLY MODE)								EVAPORATOR (SIMULTANEOUS HEATING AND COOLING MODE)						CONDENSER (SIMULTANEOUS HEATING AND COOLING MODE)						
TAG NO.	LOCATION	MANUFACTURER AND MODEL NUMBER	TYPE	REFRIGERANT TYPE & CHARGE PER UNIT (LBS)	COOLING CAPACITY (TONS)	FLUID TYPE	COOLING ONLY COP	ENTERING TEMP (F)	LEAVING TEMP (F)	FLOW RATE (GPM)	MINIMUM FLOW RATE (GPM)	dP (FT H2O)	HEATING CAPACITY (MBH)	FLUID TYPE	HEATING ONLY COP	ENTERING TEMP(F)	LEAVING TEMP(F)	FLOWRATE (GPM)	MINIMUM FLOWRATE (GPM)	dP (FT H2O)	COOLING CAPACITY (TONS)	SIMULTANEOUS COOLING COP	ENTERING TEMP(F)	LEAVING TEMP(F)	MAX FLOWRATE (GPM)	dP (FT H2O)	HEATING CAPACITY (MBH)	SIMULTANEOUS HEATING COP	ENTERING TEMP(F)	LEAVING TEMP(F)	FLOWRATE (GPM)	dP (FT H2O)
BRKBP69-V004-RL19-CG001	ROOF	MULTISTACK ARA060XNHCNABAR21--DLAGAAIWCA-A(3MODULES)	MODULAR SCROLL	R410A/645 LBS (215 LBS / MODULE)	180	WATER	3.1	58	45	340.5	45	8.23	1758	WATER	2.4	100	115	234.3	60	7.35	185.9	8.3	58	45	342.9	8.23	2842	8.3	100	115	378.9	7.35
BRKBP69-V004-RL19-CG002	ROOF	MULTISTACK ARA060XNHCNABAR21--DLAGAAIWCA-A(3MODULES)	MODULAR SCROLL	R410A/645 LBS (215 LBS / MODULE)	180	WATER	3.1	58	45	340.5	45	8.23	1758	WATER	2.4	100	115	234.3	60	7.35	185.9	8.3	58	45	342.9	8.23	2842	8.3	100	115	378.9	7.35
BRKBP69-V004-RL19-CG003	ROOF	MULTISTACK ARA060XNHCNABAR21--DLAGAAIWCA-A(3MODULES)	MODULAR SCROLL	R410A/645 LBS (215 LBS / MODULE)	180	WATER	3.1	58	45	340.5	45	8.23	1758	WATER	2.4	100	115	234.3	60	7.35	185.9	8.3	58	45	342.9	8.23	2842	8.3	100	115	378.9	7.35
BRKBP69-V004-RL19-CG004	ROOF	MULTISTACK ARA060XNHCNABAR21--DLAGAAIWCA-A(3MODULES)	MODULAR SCROLL	R410A/645 LBS (215 LBS / MODULE)	180	WATER	3.1	58	45	340.5	45	8.23	1758	WATER	2.4	100	115	234.3	60	7.35	185.9	8.3	58	45	342.9	8.23	2842	8.3	100	115	378.9	7.35
NOTE:															⚠		⚠															
1. EACH UNIT REQUIRES SEPARATE POWER SUPPLY (ONE FOR THREE MODULES)																																

HEAT PUMPS SCHEDULE CONT.																				
		AIR-SOURCE COIL DATA										ELECTRIC SERVICE								
TAG NO.	FLUID	COOLING MODE AMBIENT		HEATING MODE AMBIENT		MIN. FLOW (GPM)		COIL	FINS	COATING	FAN MOTOR ECM (Y/N)	INPUT KW	STANDBY POWER (Y/N)	MCA	MOCP	V / PH / HZ	VFD	OPERATING WEIGHT (LBS)	A- WEIGHTED SPL (dBA)	NOTES
		MIN (°F)	MAX (°F)	MIN (°F)	MAX (°F)	COND.	EVAP.													
BRKBP69-V004-RL19-CG001	AIR	60	95	33	55	77	112.5	COPPER	COPPER	HERESITE	Y	211.7	N	440	500	480 / 3 / 60	N	22440	89 @ 3.28 FT	SEE DATA SHEETS, MATERIAL REQUISITION AND HEAT PUMP SPECIFICATIONS FOR ADDITION INFORMATION.
BRKBP69-V004-RL19-CG002	AIR	60	95	33	55	77	112.5	COPPER	COPPER	HERESITE	Y	211.7	N	440	500	480 / 3 / 60	N	22440	89 @ 3.28 FT	SEE DATA SHEETS, MATERIAL REQUISITION AND HEAT PUMP SPECIFICATIONS FOR ADDITION INFORMATION.
BRKBP69-V004-RL19-CG003	AIR	60	95	33	55	77	112.5	COPPER	COPPER	HERESITE	Y	211.7	N	440	500	480 / 3 / 60	N	22440	89 @ 3.28 FT	SEE DATA SHEETS, MATERIAL REQUISITION AND HEAT PUMP SPECIFICATIONS FOR ADDITION INFORMATION.
BRKBP69-V004-RL19-CG004	AIR	60	95	33	55	77	112.5	COPPER	COPPER	HERESITE	Y	211.7	N	440	500	480 / 3 / 60	N	22440	89 @ 3.28 FT	SEE DATA SHEETS, MATERIAL REQUISITION AND HEAT PUMP SPECIFICATIONS FOR ADDITION INFORMATION.
0																				
0																				

HEAT PUMP NOTES:

1.

SEE HEAT PUMP DATA SHEETS (US3510580-46-DS-101), MATERIAL REQUISITION (US3510580-46-MR-101), AND SPECIFICATIONS (US3510580-46-SP-101).

2.

EACH UNIT HAS THREE MODULES AT 60-TON COOLING CAPACITY PER MODULE.

3.

PROVIDE EACH UNIT WITH UNIT CONTROLS.

4.

PROVIDE ONE MASTER CONTROLLER TO CONTROL THE 5 UNITS (1 ADDITIONAL UNIT FOR FUTURE), INCLUDING THE CHILLED WATER AND HEATING HOT WATER PUMPS. PROVIDE MODBUS COMMUNICATIONS LINK TO BMS.

5.

HEAT PUMP WILL USE WATER AS HEAT EXCHANGE FLUID. PROVIDE FREEZE PROTECTION CONTROL SEQUENCE.

6.

SET-UP CONTROL TO ALLOW MAXIMUM OF ONE MODULE ON DEFROST MODE AT A TIME.

7.

PROVIDE EACH UNIT ON A SKID COMPLETE WITH ELECTRICAL AND CONTROL PANELS. PROVIDE SINGLE POINT OF CONNECTION FOR ELECTRICAL PER UNIT.

*

VENDOR TO CONFIRM UNIT POWER REQUIREMENT

PUMPS.																		
							FLUID			PUMP			ELECTRICAL					
PRODUCT TAG.	P&ID NO.	LOCATION	SERVICE	MANUFACTURER	MODEL	TYPE	FLOW RATE (GPM)	WORKING FLUID	TDH (FT)	EFFICIENCY (%)	DOE BASIC MODEL	CONSTRUCTION	BHP	MOTOR SPEED (RPM)	MOTOR HP	V / PH / HZ	VFD (Y/N)	NOTES
RL19-PA001	US3510580-46-DR-0060	LEVEL-2	HEATING HOT WATER	TACO (Note 9)	FI4009D	BASE-MOUNTED END SUCTION PUMPS	480	WATER	78	79%	FI4009D-4P-PM	IRON	11.9	1760	20	460/3/60	Y	1,2,8,10
RL19-PA002	US3510580-46-DR-0060	LEVEL-2	HEATING HOT WATER	TACO (Note 9)	FI4009D	BASE-MOUNTED END SUCTION PUMPS	480	WATER	78	79%	FI4009D-4P-PM	IRON	11.9	1760	20	460/3/60	Y	1,2,8,10
RL19-PA003	US3510580-46-DR-0060	LEVEL-2	HEATING HOT WATER	TACO (Note 9)	FI4009D	BASE-MOUNTED END SUCTION PUMPS	480	WATER	78	79%	FI4009D-4P-PM	IRON	11.9	1760	20	460/3/60	Y	1,2,8,10
RL19-PA004	US3510580-46-DR-0070	LEVEL-2	CHILLED WATER	TACO (Note 9)	FI4011C	BASE-MOUNTED END SUCTION PUMPS	555	WATER	118	80%	FI4011C-4P-PM	IRON	20.61	1760	30	460/3/60	Y	1,2,8,10
RL19-PA005	US3510580-46-DR-0070	LEVEL-2	CHILLED WATER	TACO (Note 9)	FI4011C	BASE-MOUNTED END SUCTION PUMPS	555	WATER	118	80%	FI4011C-4P-PM	IRON	20.61	1760	30	460/3/60	Y	1,2,8,10
RL19-PA006	US3510580-46-DR-0070	LEVEL-2	CHILLED WATER	TACO (Note 9)	FI4011C	BASE-MOUNTED END SUCTION PUMPS	555	WATER	118	80%	FI4011C-4P-PM	IRON	20.61	1760	30	460/3/60	Y	1,2,8,10
RL19-ID001-PA001	US3510580-46-DR-0070	LEVEL-2	MAKE-UP WATER-CHW	TACO (Note 9)	DFM060400CVA00HVAAJ1AAA00	VERTICAL MULTI-STAGE PUMPS (DUPLX ON SKID)	25	WATER	34	60%	6VR04-00316SS	STAINLESS STEEL	0.4	2303	1.5	115/1/60	Y	2,3,5,6,8
RL19-ID001-PA002	US3510580-46-DR-0070	LEVEL-2	MAKE-UP WATER-CHW	TACO (Note 9)		VERTICAL MULTI-STAGE PUMPS (DUPLX ON SKID)	25	WATER	34	60%	6VR04-00316SS	STAINLESS STEEL	0.4	2303	1.5	115/1/60	Y	2,3,5,6,8
RL19-ID002-PA001	US3510580-46-DR-0060	LEVEL-2	MAKE-UP WATER-HW	TACO (Note 9)	DFM060400CVA00HVAAJ1AAA00	VERTICAL MULTI-STAGE PUMPS (DUPLX ON SKID)	25	WATER	34	60%	6VR04-00316SS	STAINLESS STEEL	0.4	2303	1.5	115/1/60	Y	2,3,5,6,8
RL19-ID002-PA002	US3510580-46-DR-0060	LEVEL-2	MAKE-UP WATER-HW	TACO (Note 9)		VERTICAL MULTI-STAGE PUMPS (DUPLX ON SKID)	25	WATER	34	60%	6VR04-00316SS	STAINLESS STEEL	0.4	2303	1.5	115/1/60	Y	2,3,5,6,8
NOTE : 1. PROVIDE WITH DRAIN PAN. 2. PROVIDE WITH TEFC PREMIUM EFFICIENT MOTOR FOR VFD USE. 3. RL19-ID001-PA001 AND RL19-ID001-PA002 ARE ON ONE SKID. 4. RL19-ID002-PA001 AND RL19-ID001-PA002 ARE ON ONE SKID. 5. CONSTANT PRESSURE MODE. ONE PUMP DUTY, THE OTHER PUMP STANDBY. 6. PROVIDE CONTROLS AND CONNECTION TO BAS (MODBUS). 7. NOT USED. 8. INSTALL PER MANUFACTURER'S INSTRUCTIONS. 9. MANUFACTURE BASED ON INITIAL SELECTION TO BE CONFIRMED DURING TENDER PROCESS. 10. SUCTION DIFFUSER PROVIDED BY VENDOR.																		


AIR SEPARATOR										
PRODUCT TAG.	P&ID NO.	LOCATION	SERVICE	MANUFACTURER	MODEL	FLUID			PHYSICAL	NOTES
						FLOW RATE (GPM)	ACTUAL HEAD(FT)	CONNECTION SIZE (IN)	DIA. / HEIGHT (IN)	
RL19-CG021	US3510580-46-DR-0070	LEVEL 2	CHILLED WATER	TACO	4910A-125	1110	2.77	10	24.00 x 47.75	1,2,3
RL19-CG011	US3510580-46-DR-0060	LEVEL 2	HEATING HOT WATER	TACO	4908AH-125	960	1.42	8	24.00 x 47.50	1,2,3
NOTE 1: PROVIDE WITH 304SS PALL RINGS. NOTE 2: PROVIDE WITH FLUSH VALVE. NOTE 3: PROVIDE WITH AUTO AIR VENT.										
CHEMICAL POT FEEDER										
PRODUCT TAG.	P&ID NO.	SERVICE		MANUFACTURER	MODEL	VOLUME (GAL)	CONSTRUCTION	CONNECTION SIZE (IN)	WEIGHT (LBS)	NOTES
RL19-CG012	US3510580-46-DR-0060	HEATING HOT WATER		JL WINGERT	12 HD	12.76	CARBON STEEL	0.75	58	1,2
RL19-CG023	US3510580-46-DR-0070	CHILLED WATER		JL WINGERT	5 HD	5.79	CARBON STEEL	0.75	58	1,2
NOTE 1: PROVIDE WITH VALVE PACKAGE AND FILL FUNNEL. NOTE 2: RATED FOR 200 PSI @ 200F MAX.										

GENERAL NOTES
1. INSTALL ALL EQUIPMENT PER MANUFACTURER'S INSTALLATION INSTRUCTIONS.
2. PROVIDE ANCHORS AS NEEDED TO SEISMICALLY SUPPORT HYDRONIC EQUIPMENT ON FLOOR/STRUCTURE. PROVIDE STRUCTURAL CALCULATION SIGNED BY A CALIFORNIA LICENSED CIVIL OR STRUCTURAL ENGINEER.
3. PROVIDE EQUIPMENT COMPLETE WITH CONTROLS TO DELIVER COMPLETE WORKING SYSTEMS TO BAYER.

SUCTION DIFFUSER (FOR CHILLED & HEATING HOT WATER PUMPS)								
PRODUCT TAG.	MANUFACTURER	MODEL	TYPE	BODY CONSTRUCTION	FLUID		PHYSICAL	NOTES
					FLOW RATE (GPM)	HEAD LOSS (FT)		
RL19-PA001	TACO	SD060050-5	FLANGED	DUCTILE IRON	480	24	6X5	
RL19-PA002	TACO	SD060050-5	FLANGED	DUCTILE IRON	480	24	6X5	
RL19-PA003	TACO	SD060050-5	FLANGED	DUCTILE IRON	480	24	6X5	
RL19-PA004	TACO	SD060050-5	FLANGED	DUCTILE IRON	555	30	6X5	
RL19-PA005	TACO	SD060050-5	FLANGED	DUCTILE IRON	555	30	6X5	
RL19-PA006	TACO	SD060050-5	FLANGED	DUCTILE IRON	555	30	6X5	

EXPANSION TANK										
PRODUCT TAG.	P&ID NO.	MANUFACTURER	MODEL	TYPE	FLUID		MAXIMUM ALLOWABLE WORKING PRESSURE (PSI)	DIA./HEIGHT (IN)	NPT FITTING (IN)	NOTES
					WORKING FLUID	VOLUME (GAL)				
RL19CG013	US3510580-46-DR-0060	TACO	CA215-125	BLADEER TYPE	WATER (CHW)	57	125	20X64	1"	
RL19CG023	US3510580-46-DR-0070	TACO	CA215-125	BLADEER TYPE	WATER (HW)	57	125	20X64	1"	

BUFFER TANK SCHEDULE										
PRODUCT TAG.	P&ID NO.	SERVICE	MANUFACTURER	MODEL	VOLUME (GAL)	CONSTRUCTION	THERMAL INSULATION	CONNECTION SIZE (IN)	WEIGHT (LBS)	NOTES
RL19-CG010	US3510580-46-DR-0060	HW	TACO	BTH1750F08-125HA	1750	CARBON STEEL	HEATING WATER 1" SILICON BLANKET	8	3340	1,3
RL19-CG020	US3510580-46-DR-0070	CHW	TACO	BTH2500F10-125CA	2500	CARBON STEEL	CHILLED WATER 1/2" ARMAFLEX	10	5340	1,3

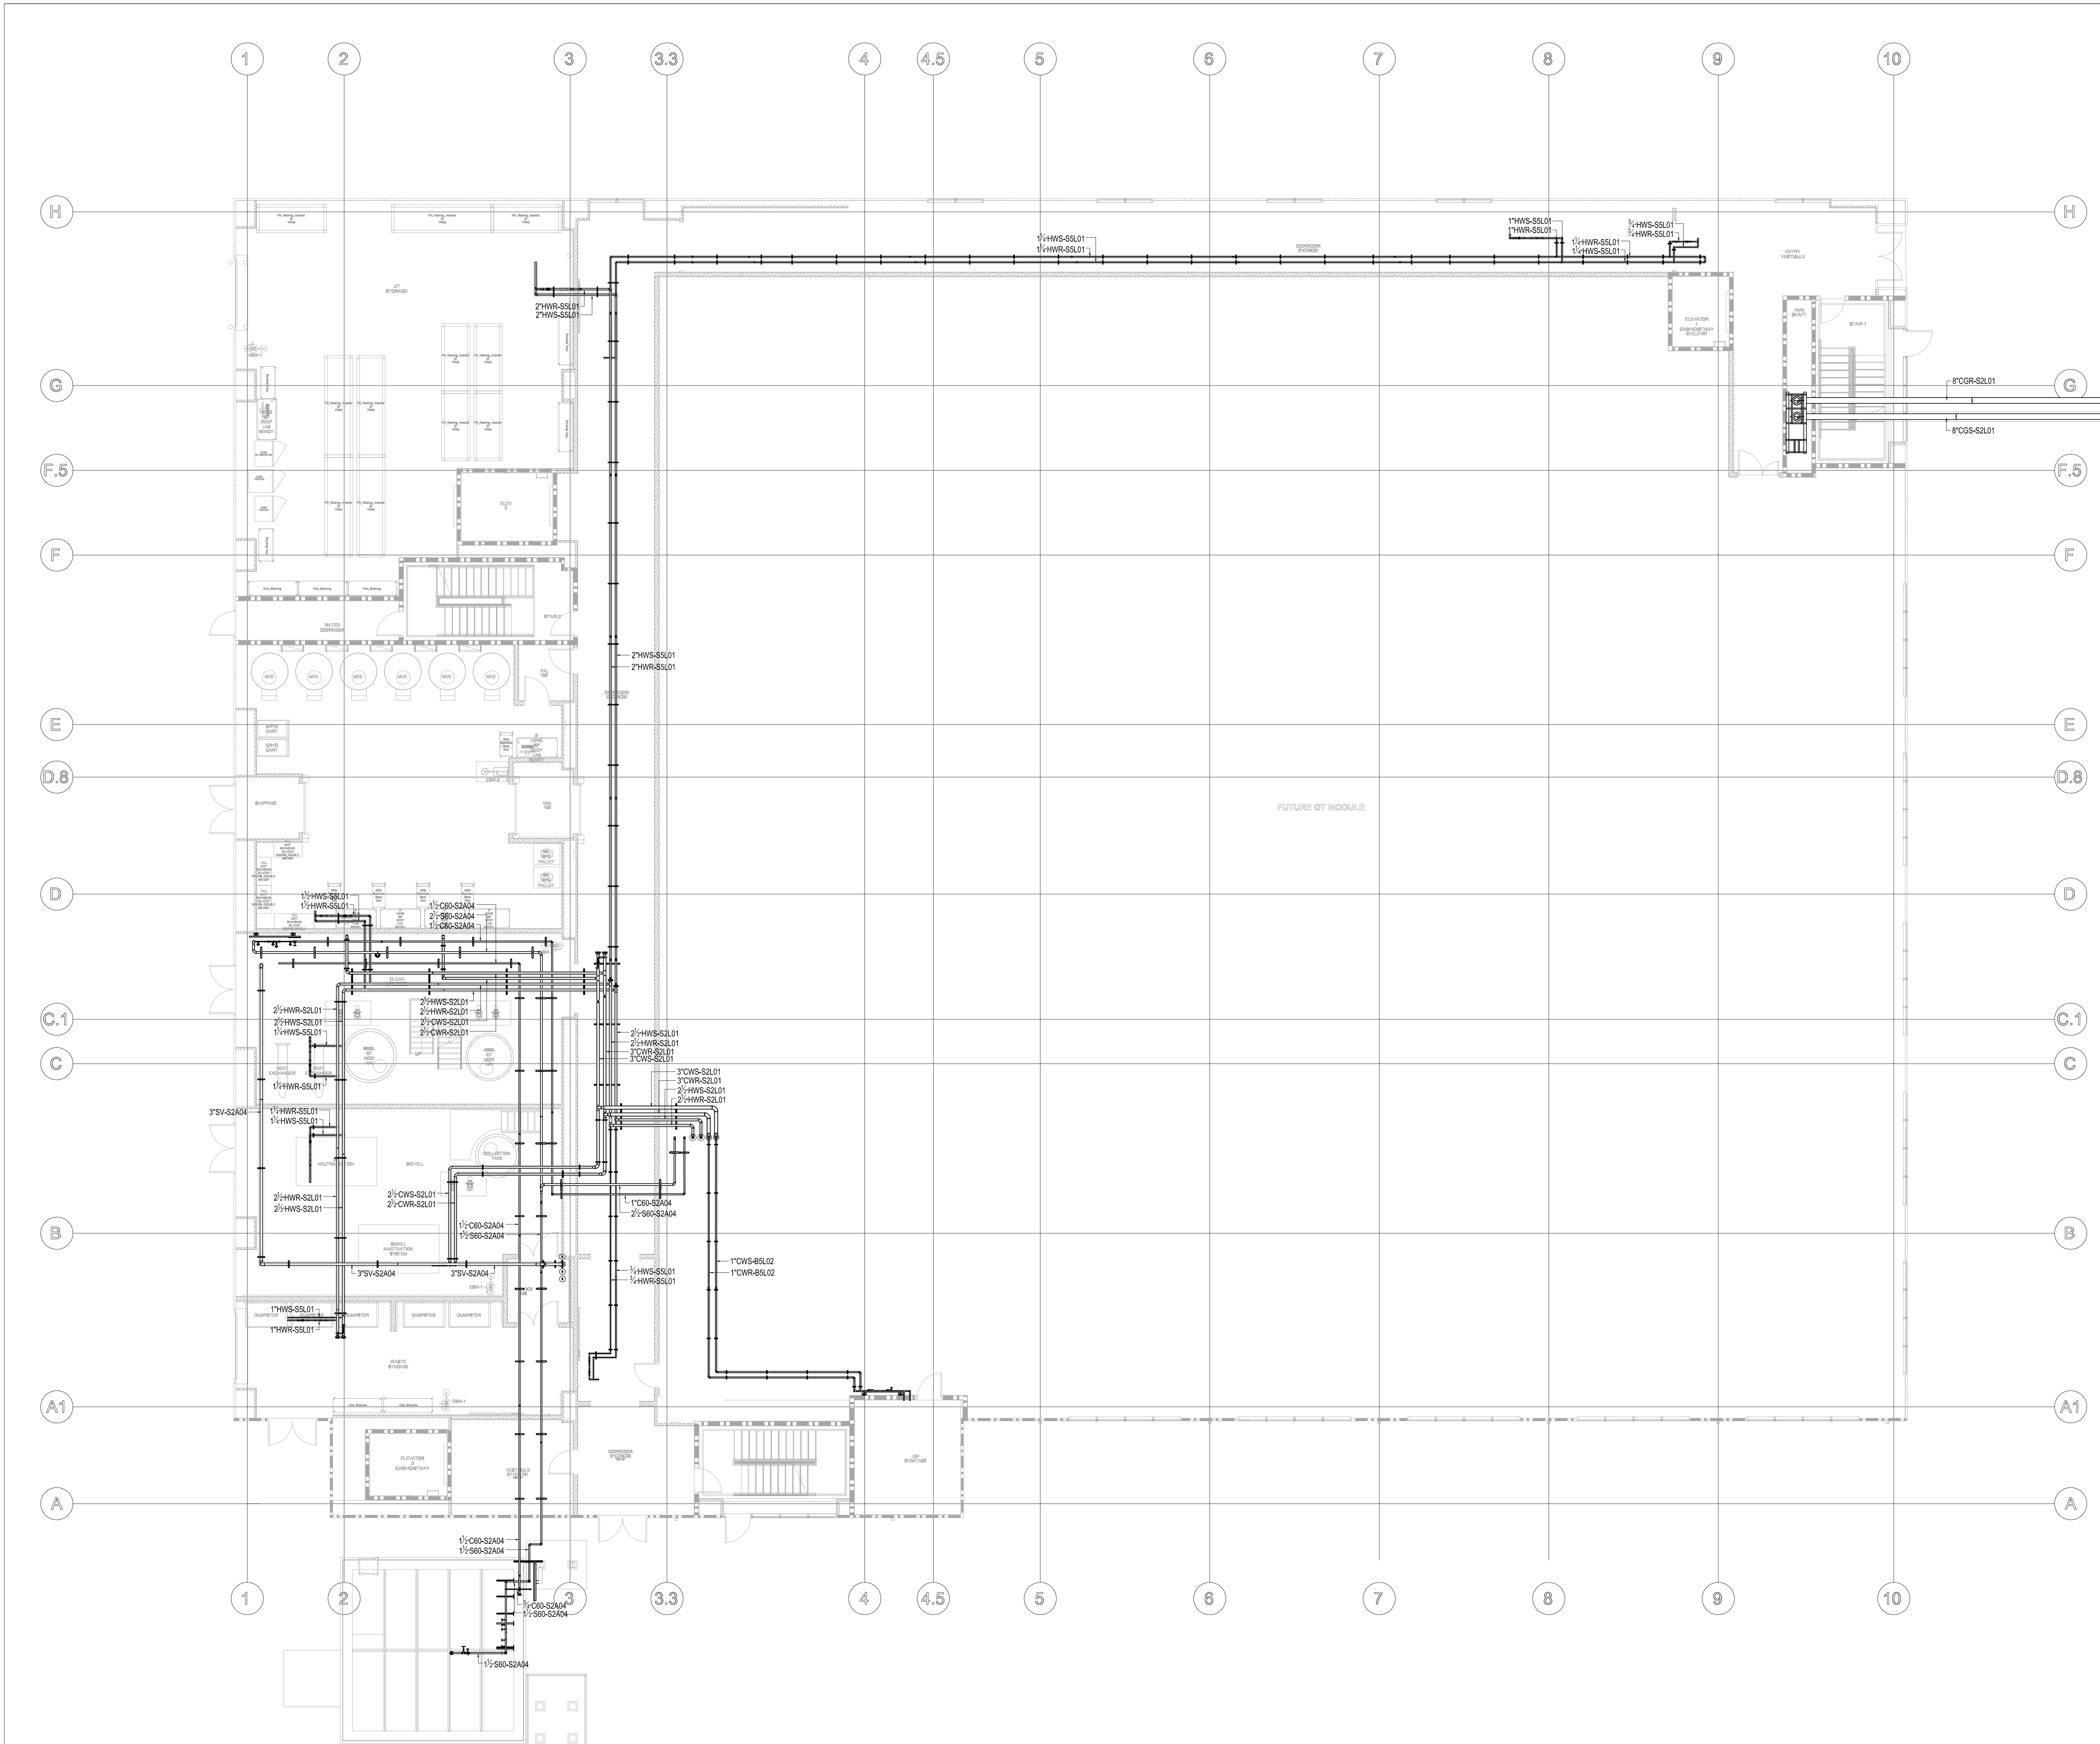

NOTES

1. SEAL PIPE PENETRATIONS THROUGH FLOORS
2. SLOPES FOR PIPEWORK TO BE 1/8" PER 100 FEET.
3. ALL PIPEWORK TO BE CO-ORDINATED WITH OTHER TRADES.

LEGEND

PLANT STEAM (S00)
PLANT CONDENSATE (C00)
CHILLED WATER SUPPLY (CWS)
CHILLED WATER RETURN (CWR)
HEATED HOT WATER SUPPLY (HWS)
HEATED HOT WATER RETURN (HWR)
CHILLED GLYCOL SUPPLY (CGS)
CHILLED GLYCOL RETURN (CGR)




NOTES

- 1. SEAL PIPE PENETRATIONS THROUGH FLOORS
- 2. SLOPES FOR PIPEWORK TO BE 1/8" PER 100 FEET.
- 3. ALL PIPEWORK TO BE CO-ORDINATED WITH OTHER TRADES.

LEGEND

- PLANT STEAM (S90)
- PLANT CONDENSATE (C90)
- CHILLED WATER SUPPLY (CWS)
- CHILLED WATER RETURN (CWR)
- HEATED HOT WATER SUPPLY (HWS)
- HEATED HOT WATER RETURN (HWR)
- CHILLED GLYCOL SUPPLY (CGS)
- CHILLED GLYCOL RETURN (CGR)

Title: LEVEL 2 HIGH LEVEL HYDRONIC SYSTEM LAYOUT PIPING FLOOR PLAN			
Drawing Number: ECM-20-026-BE-69-UT-13082	As-Built	Project 0	
Scale:	Revision No.		

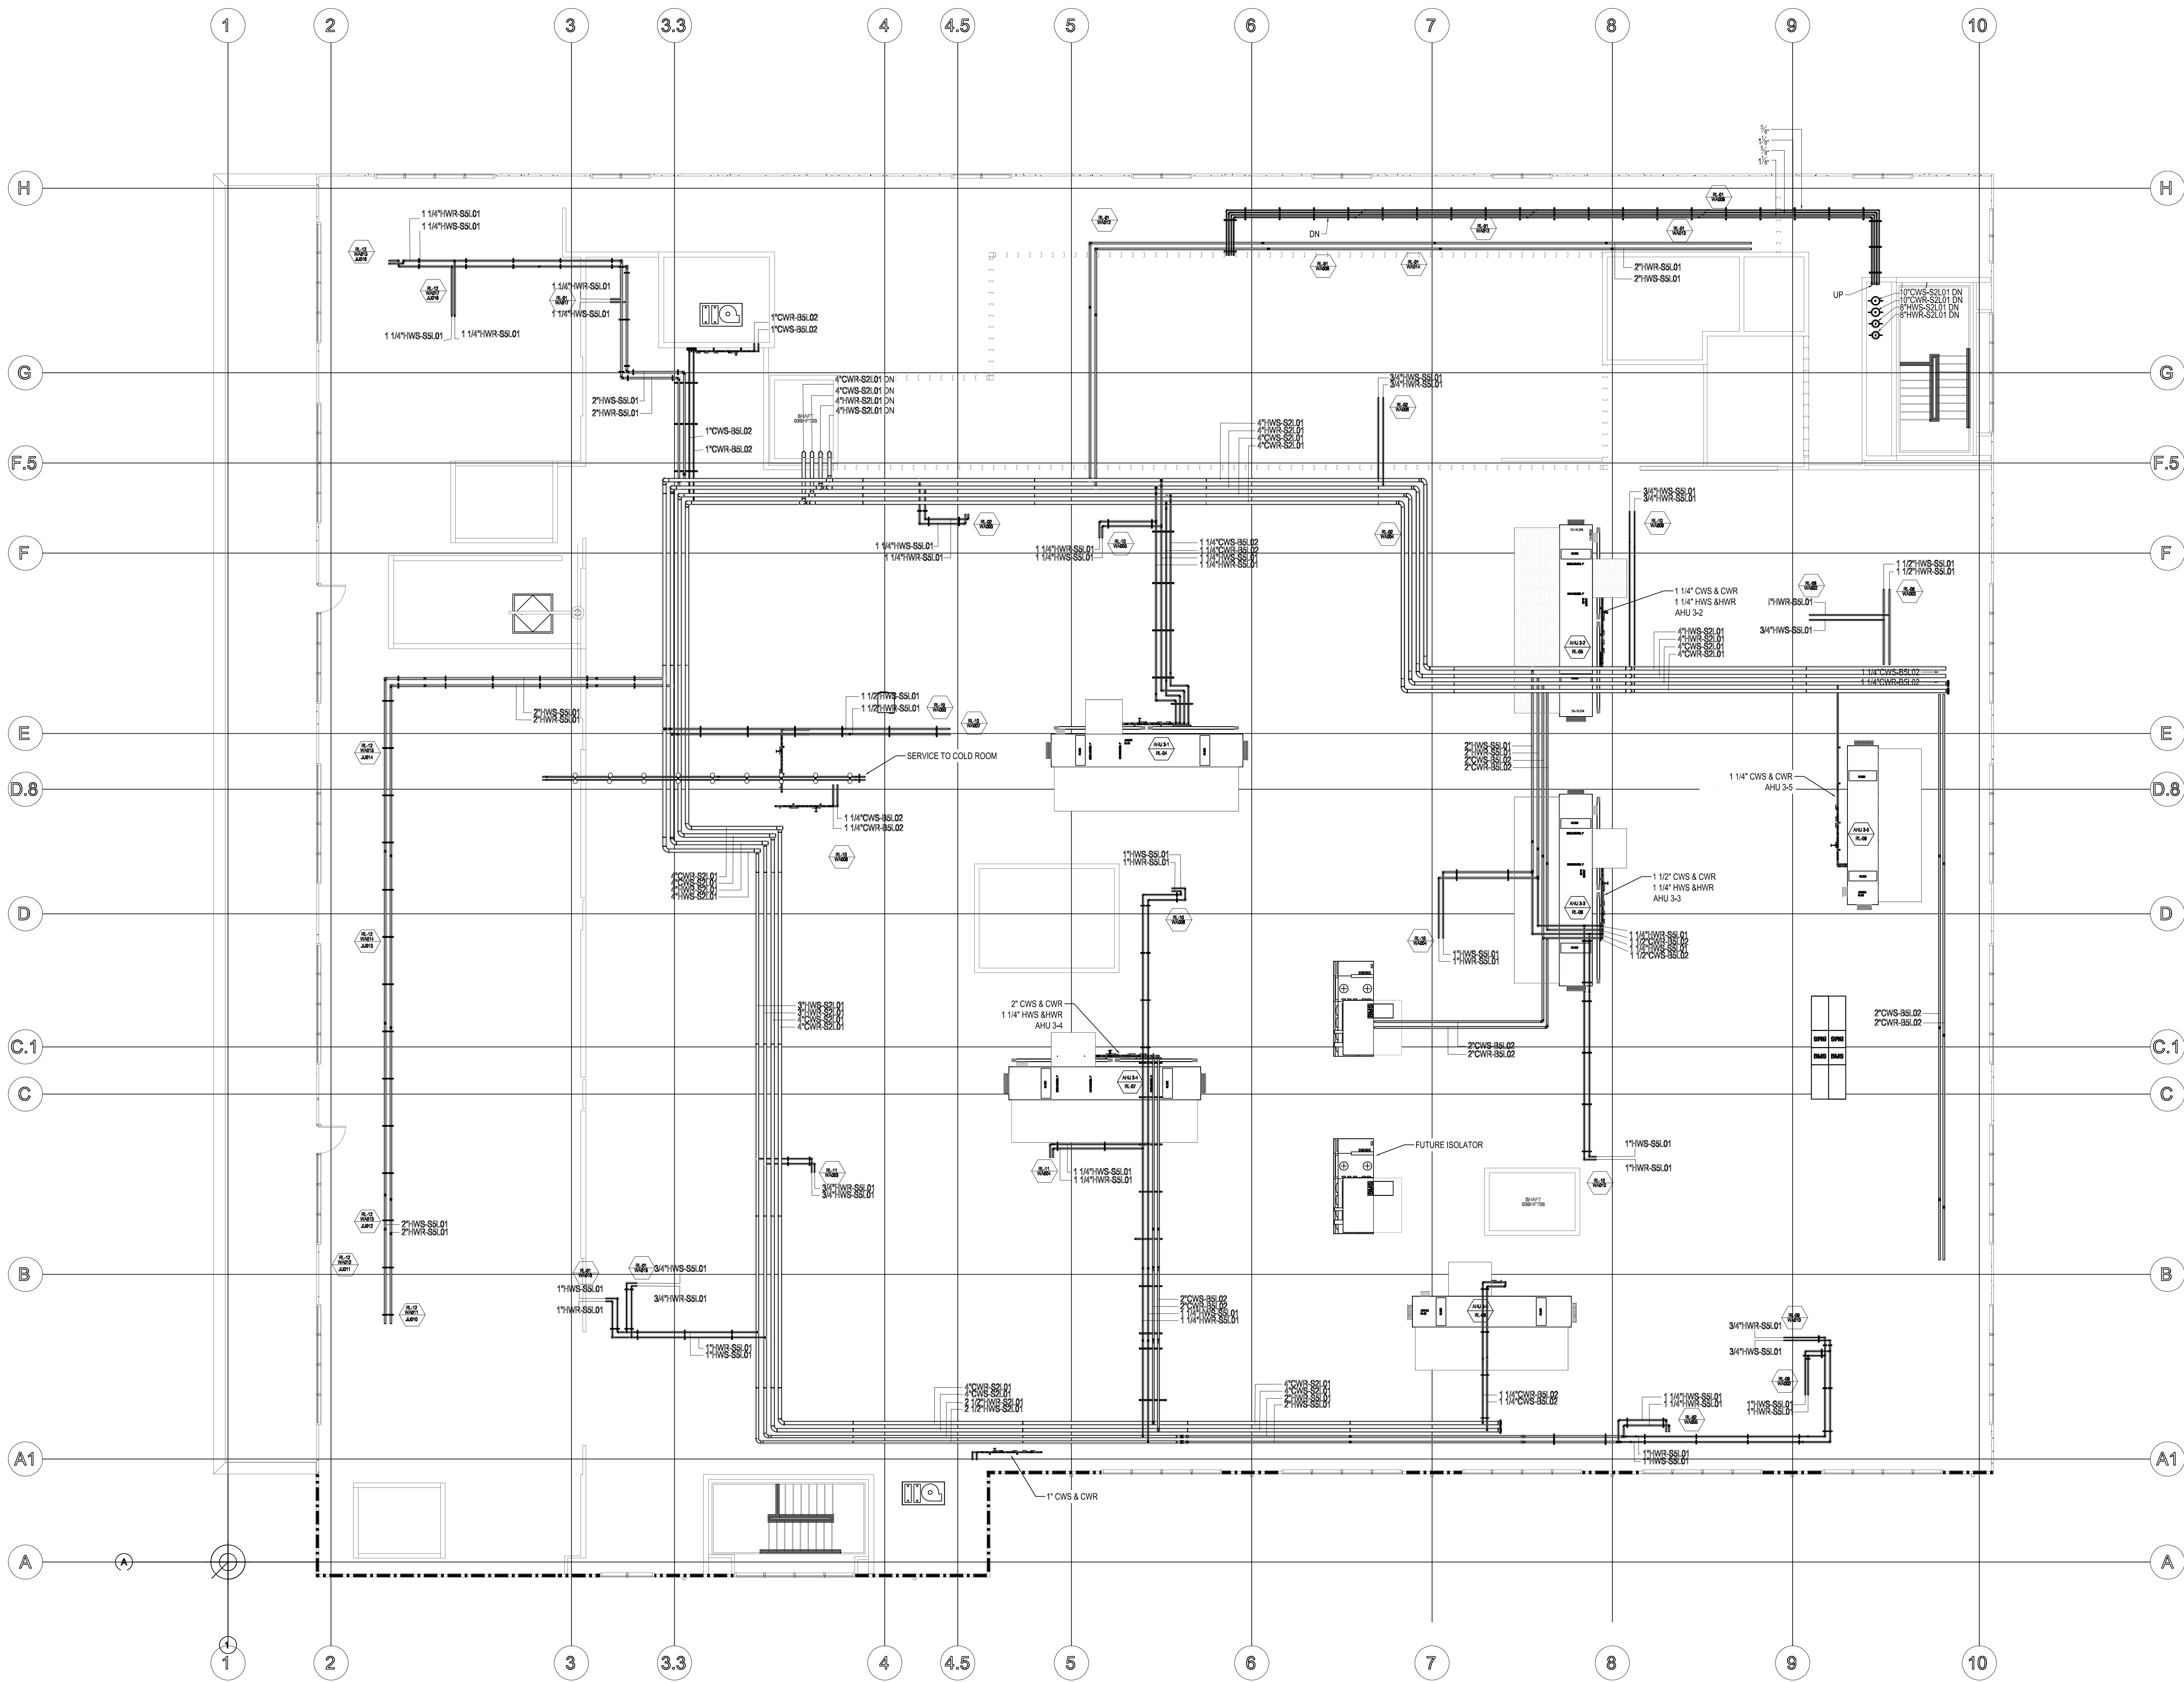

NOTES

1. SEAL PIPE PENETRATIONS THROUGH FLOORS
2. PROVIDE PIPE SUPPORTS PER LATEST
SMACNA SEISMIC
RESTRAINT MANUAL GUIDELINES FOR
MECHANICAL SYSTEM.

LEGEND

- PLANT STEAM (S60)
PLANT CONDENSATE (C60)
CHILLED WATER SUPPLY (CWS)
CHILLED WATER RETURN (CWR)
HEATED HOT WATER SUPPLY (HWS)
HEATED HOT WATER RETURN (HWR)
CHILLED GLYCOL SUPPLY (CGS)
CHILLED GLYCOL RETURN (CGR)

Title: LEVEL 3.5 HIGH LEVEL HYDRONIC SYSTEM LAYOUT PIPING FLOOR PLAN			
Drawing Number:	ECM-20-026-BE-69-UT-13083	As-Built	Project 0
Scale:	1/8" = 1'-0"	Revision No.	

