

A


B

C


D

E

F

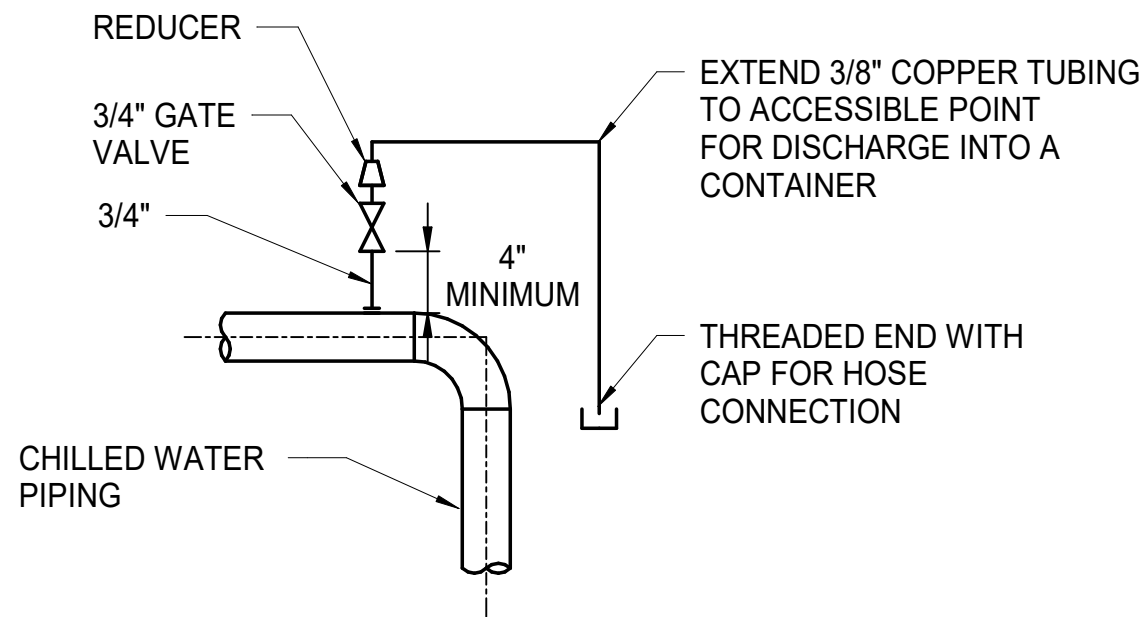


C3 MANUAL AIR VENT
M-503 SCALE: NO SCALE SHOWN

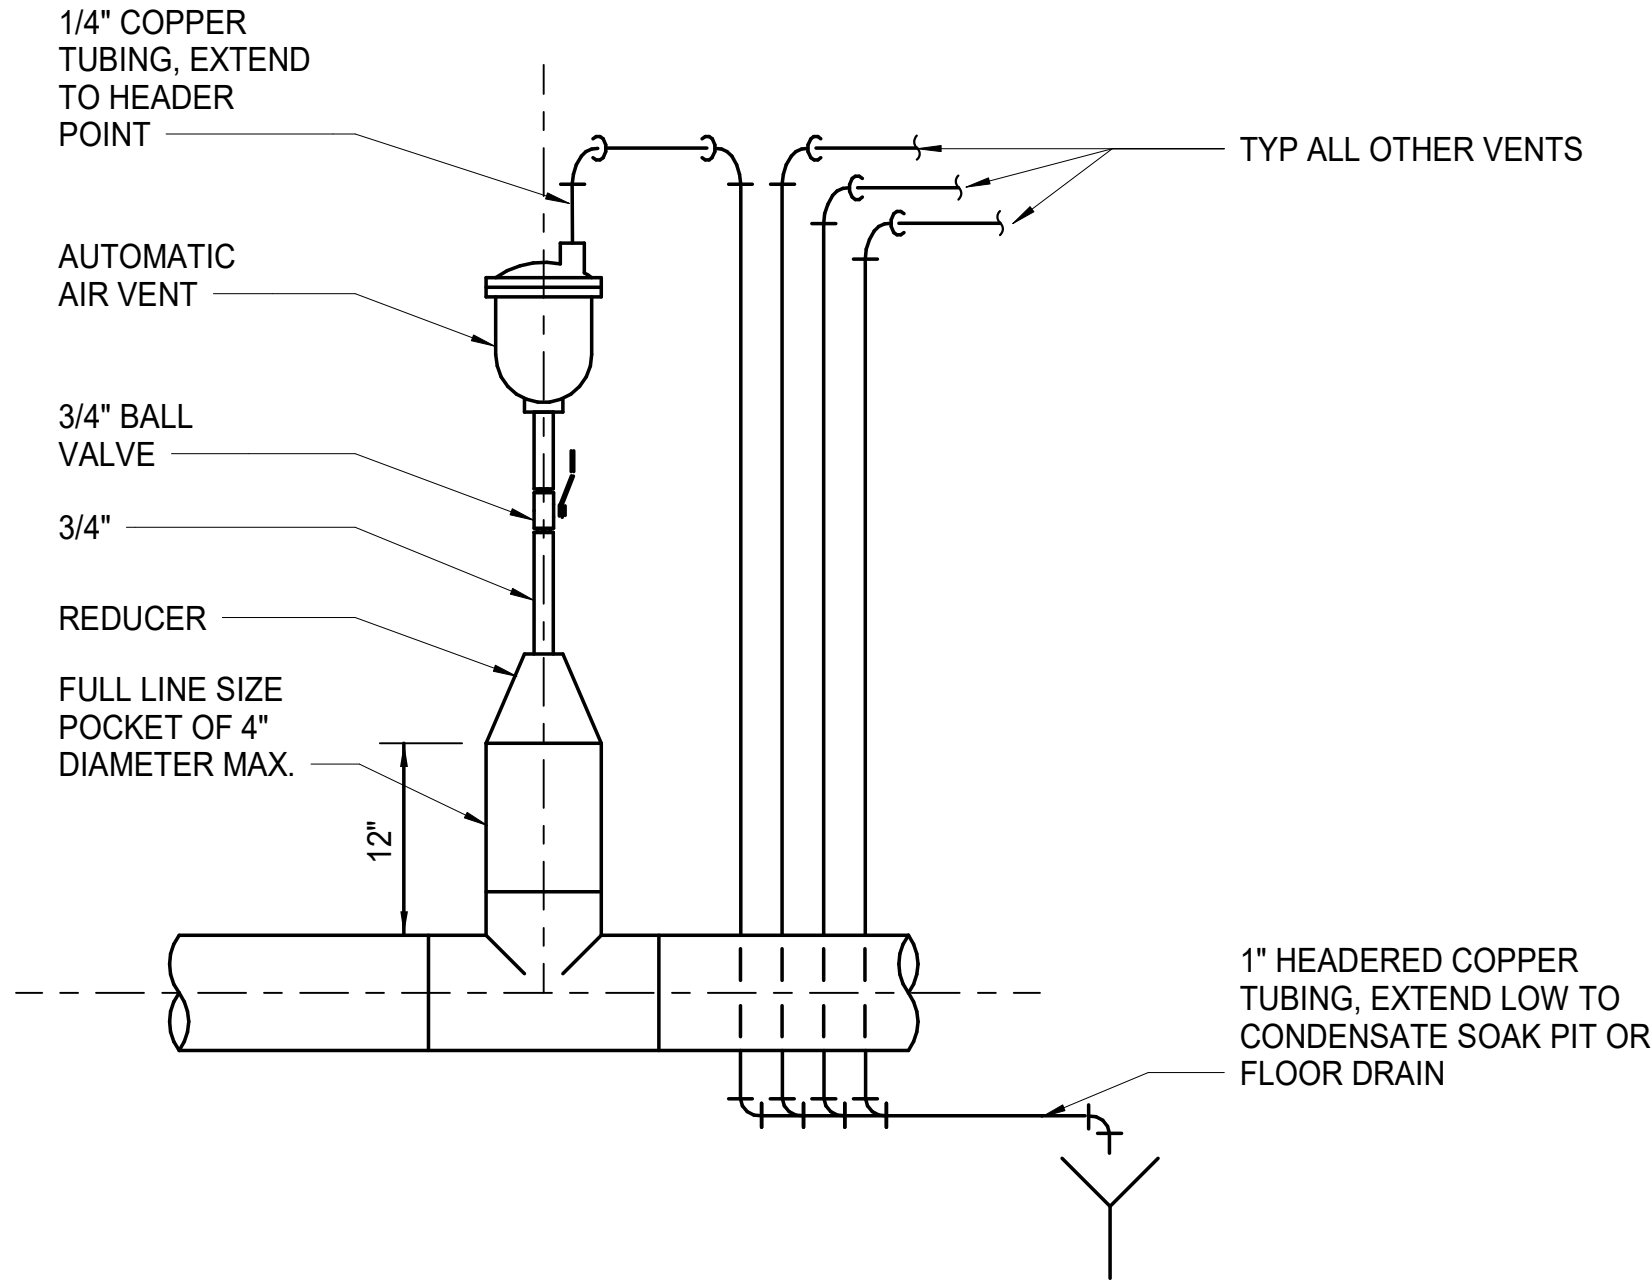


- NOTE:**
- ALL AV 1/4" VENT TUBING IN SAME AREA MUST HEADER INTO 1" LINE AT FLOOR. HEADERED LINE MUST ROUTE TO (N) SOAK PIT OR (E) FLOOR DRAIN AS COMBINED DRAIN LINE.

C6 AUTOMATIC AIR VENT
M-503 SCALE: NO SCALE SHOWN

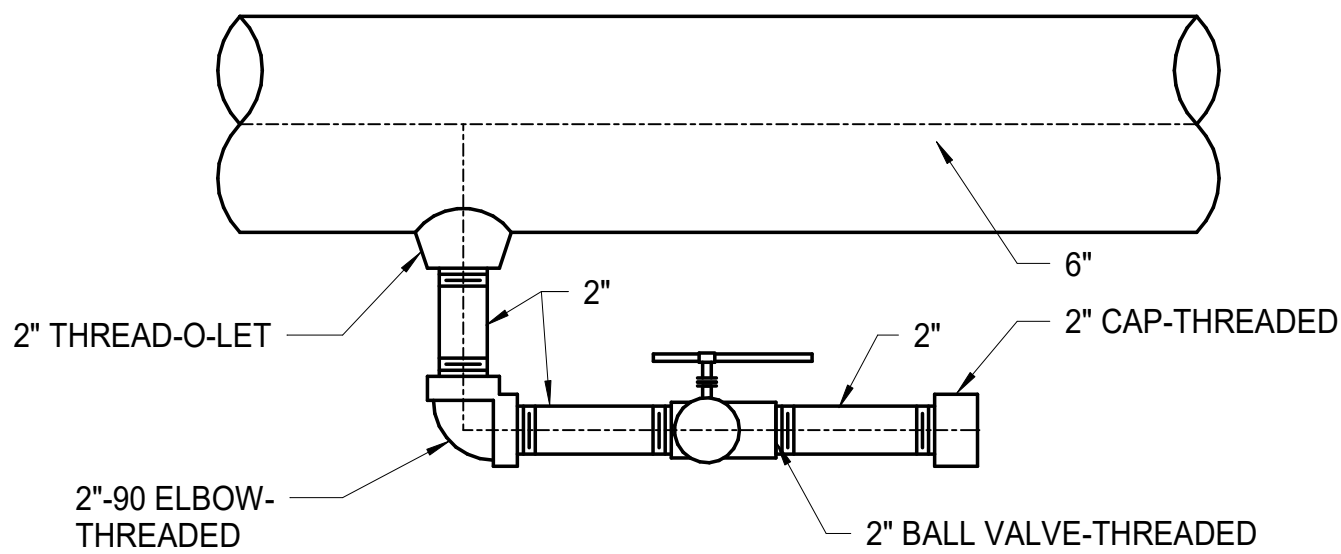

F3 LINE DRAIN AT CHILLER
M-503 SCALE: NO SCALE SHOWN

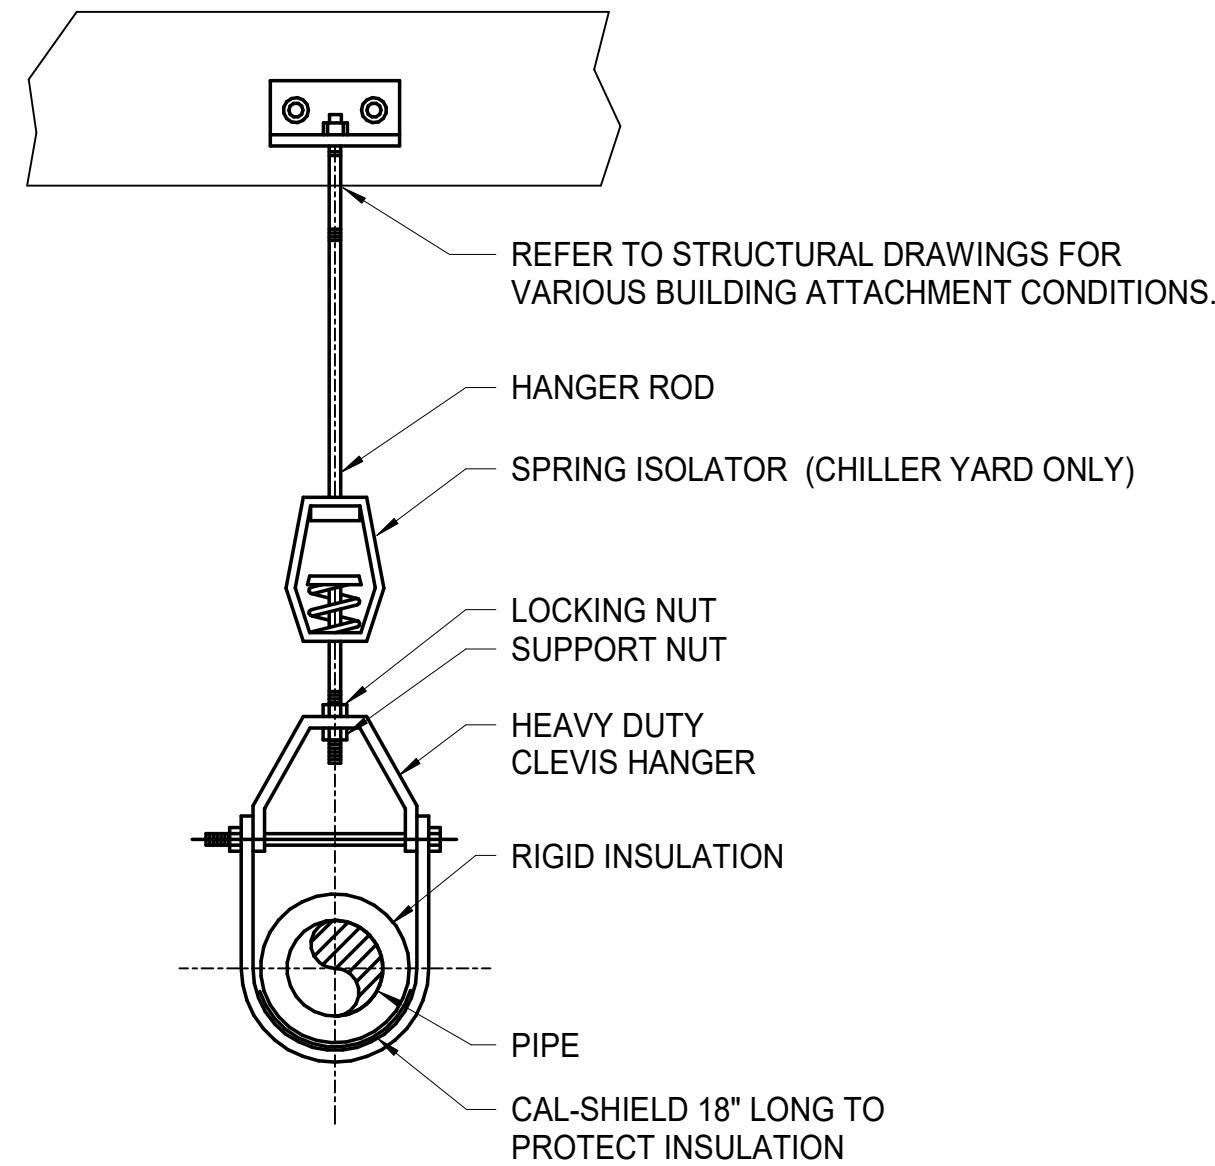

- NOTES:**
- ALL CHILLED WATER PIPE HANGERS IN CHILLER YARD MUST INCLUDE SPRING-TYPE VIBRATION ISOLATION ASSEMBLY REFER TO 23 05 48; PIPE HANGERS FOR ALL OTHER SYSTEMS DO NOT REQUIRE VIBRATION ISOLATION.
 - REFER TO SPEC. SECTION 23 05 48 FOR PIPE SWAY BRACING.
 - INSTALL SEISMIC BRACING PER ASCE 7 AND PROJECT SPECIFICATION 23 05 48. SUBMIT SHOP DRAWINGS AND CALCULATIONS FOR SUPPORTS, ANCHORAGE, AND BRACING FOR APPROVAL AS A DELEGATED DESIGN SUBMITTAL.

F6 PIPE HANGER-CLEVIS TYPE
M-503 SCALE: NO SCALE SHOWN

Sheet Title
MECHANICAL DETAILS

Dwg. No.
PLM2021-0432-0025D

Sht. No.
M-503