

A


B

C

D


E

F

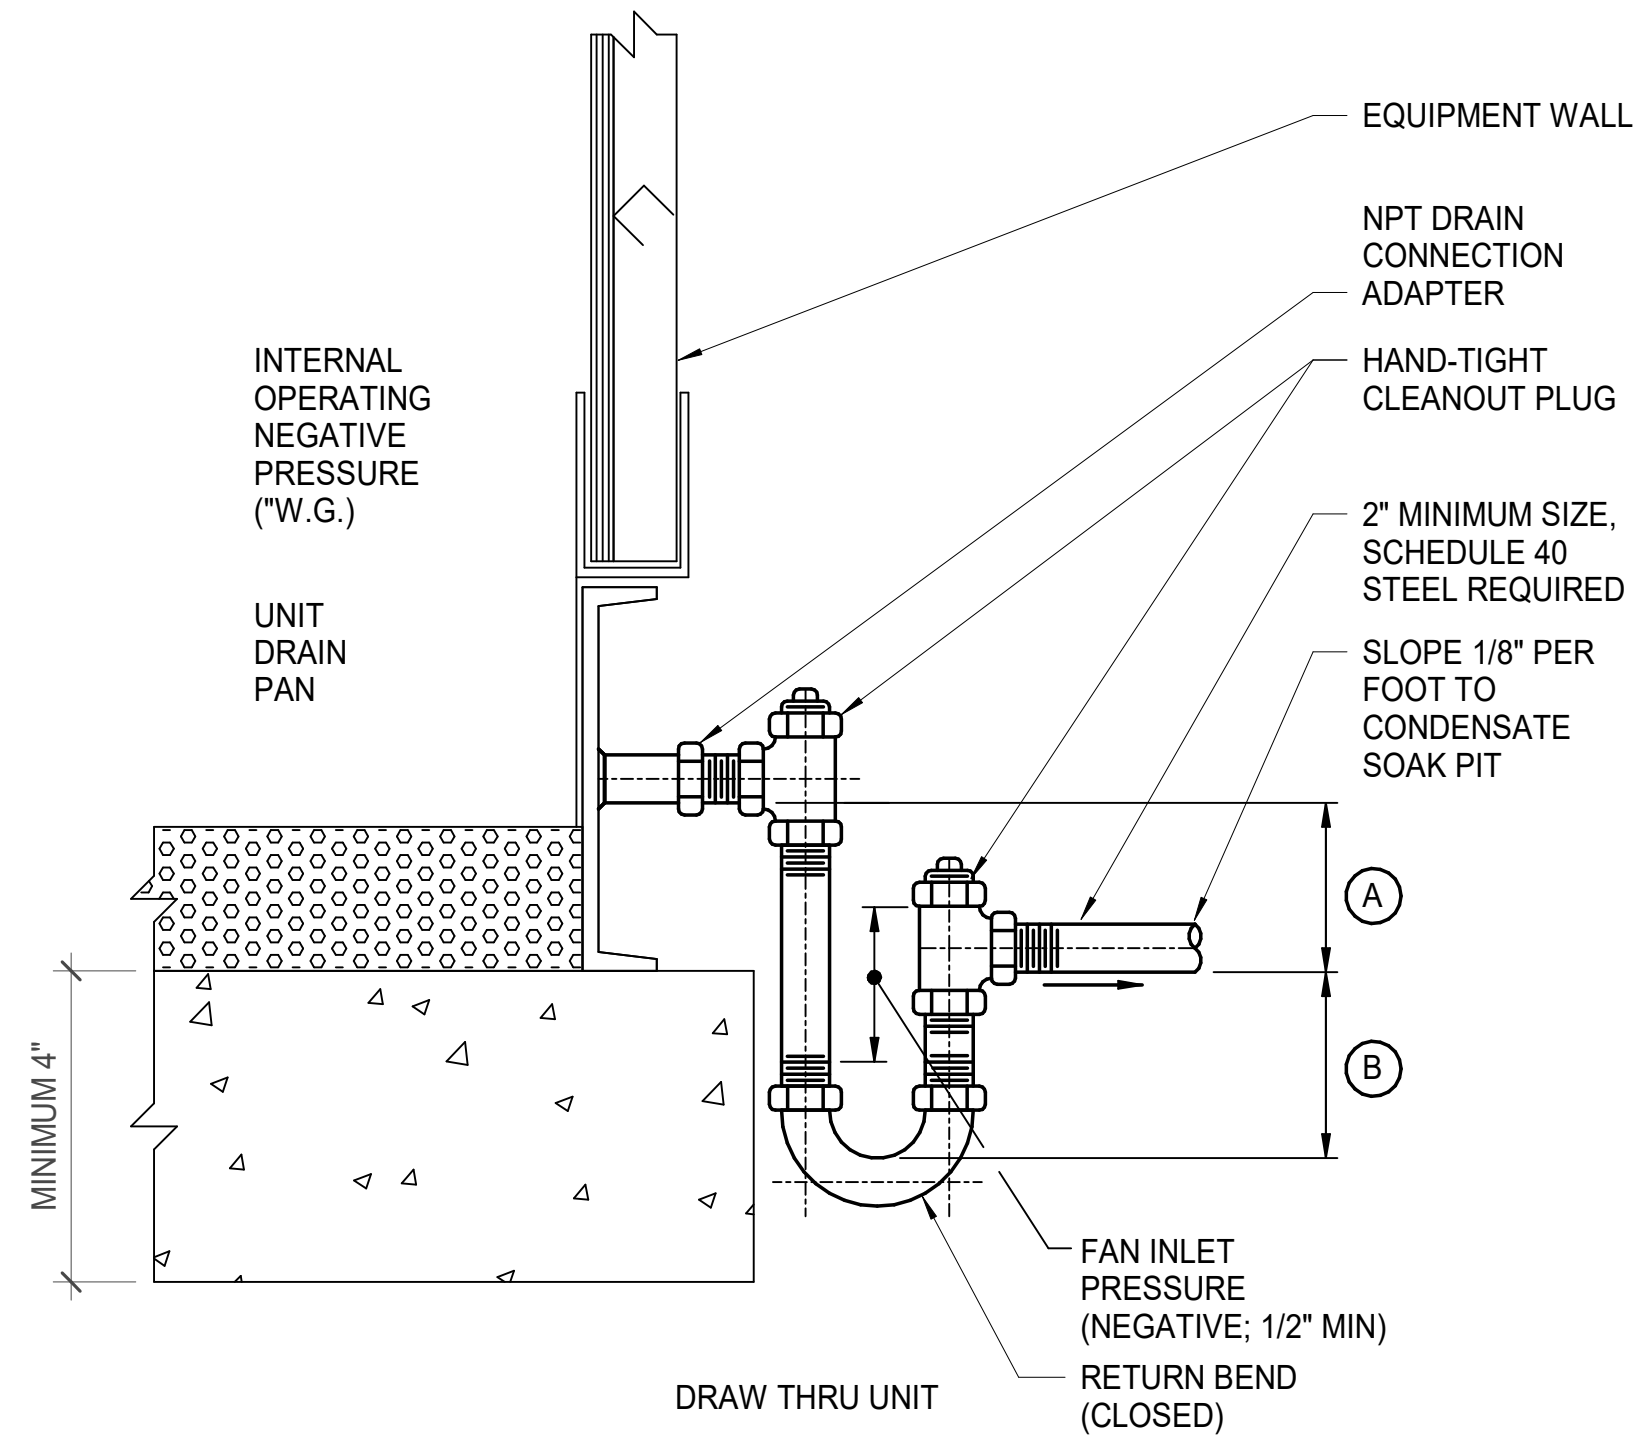
**NOTES:**

1. (A) DIMENSION EQUAL TO MAXIMUM FAN INLET PRESSURE (INCH WC) + 1/2" (MIN)
2. (B) DIMENSION EQUAL TO (A) /2 (MIN)


**D3** EQUIPMENT CONDENSATE TRAP DRAIN  
M-505 SCALE: NO SCALE SHOWN

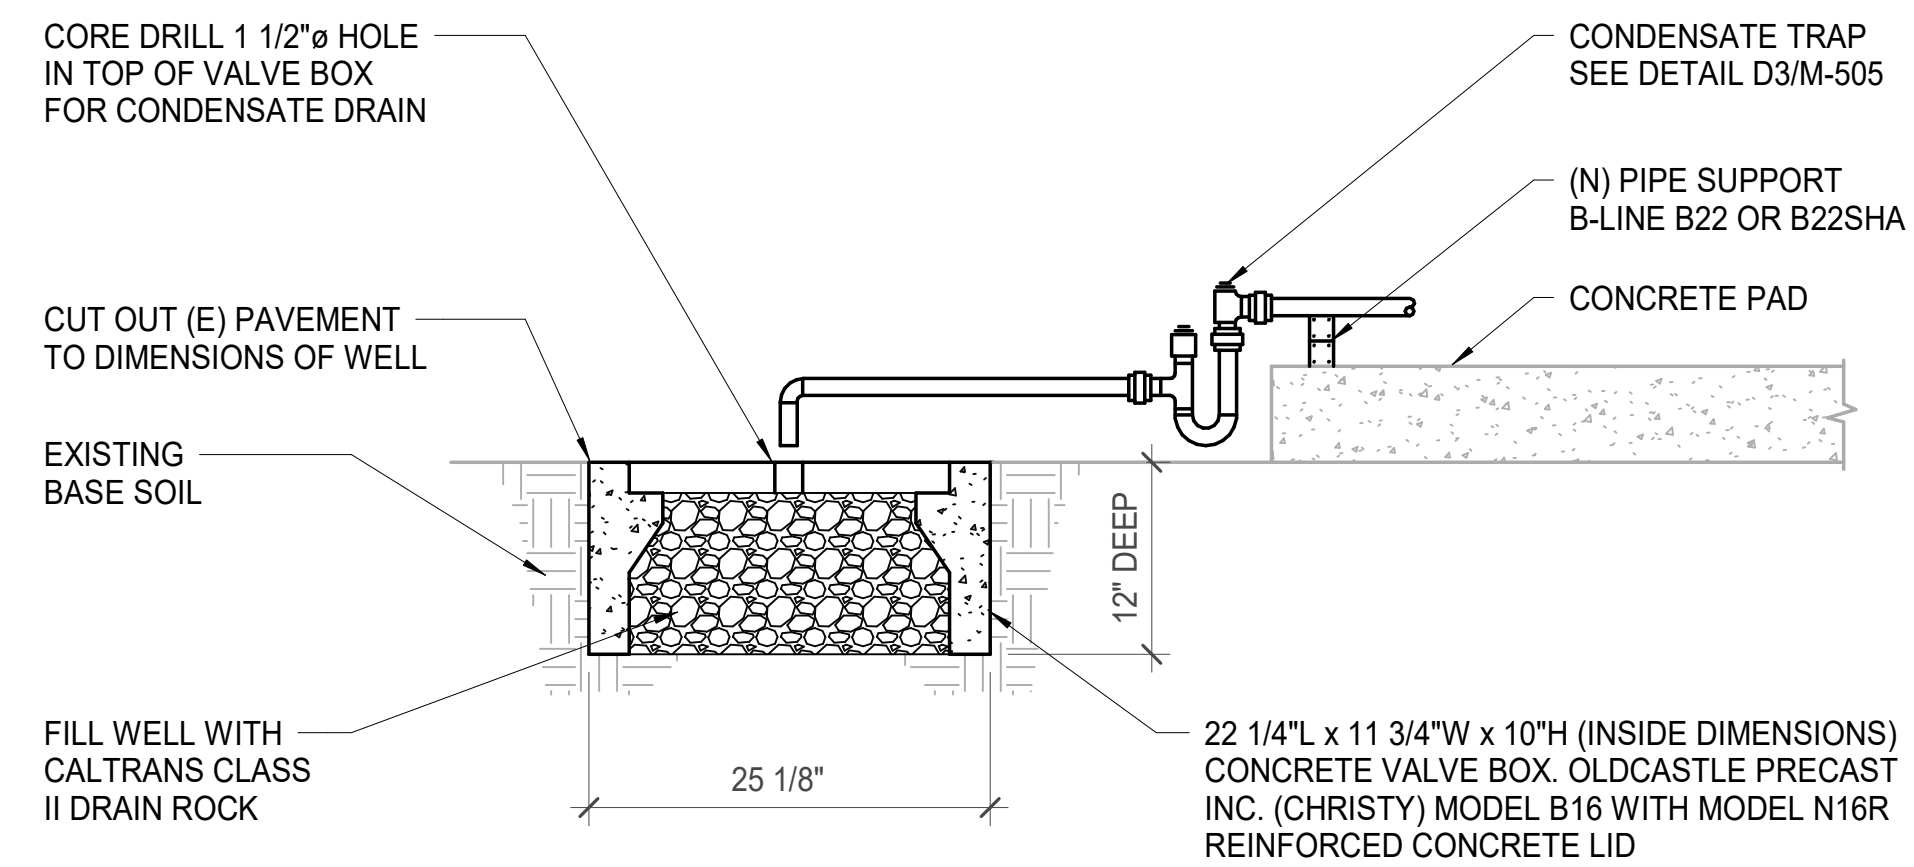

**D6** CONDENSATE SOAK PIT  
M-505 SCALE: NO SCALE SHOWN

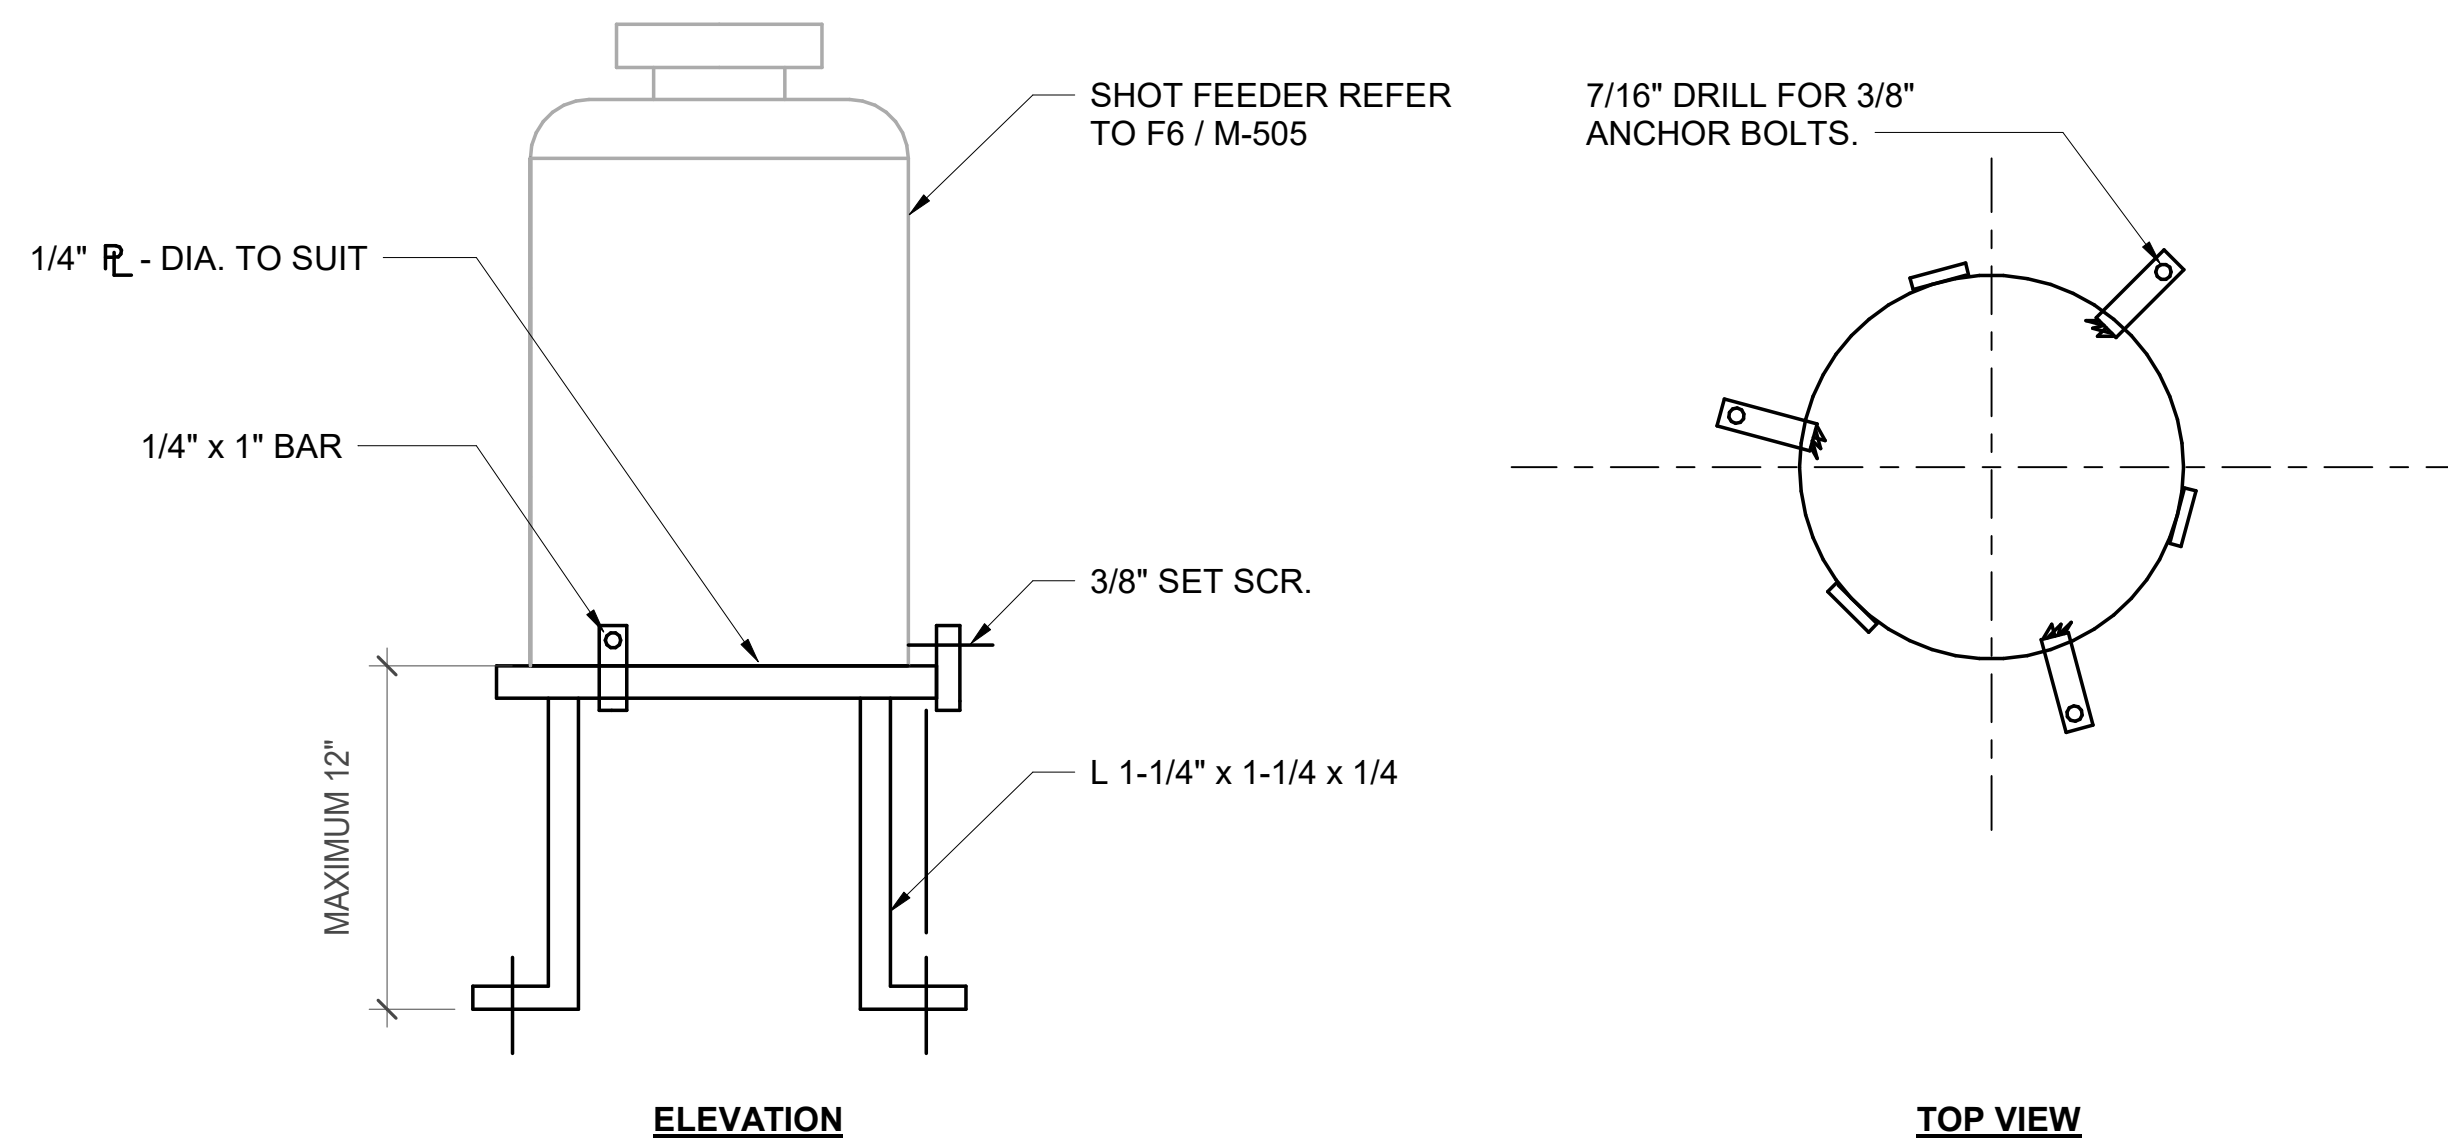

**F3** SHOT FEEDER SUPPORT  
M-505 SCALE: NO SCALE SHOWN

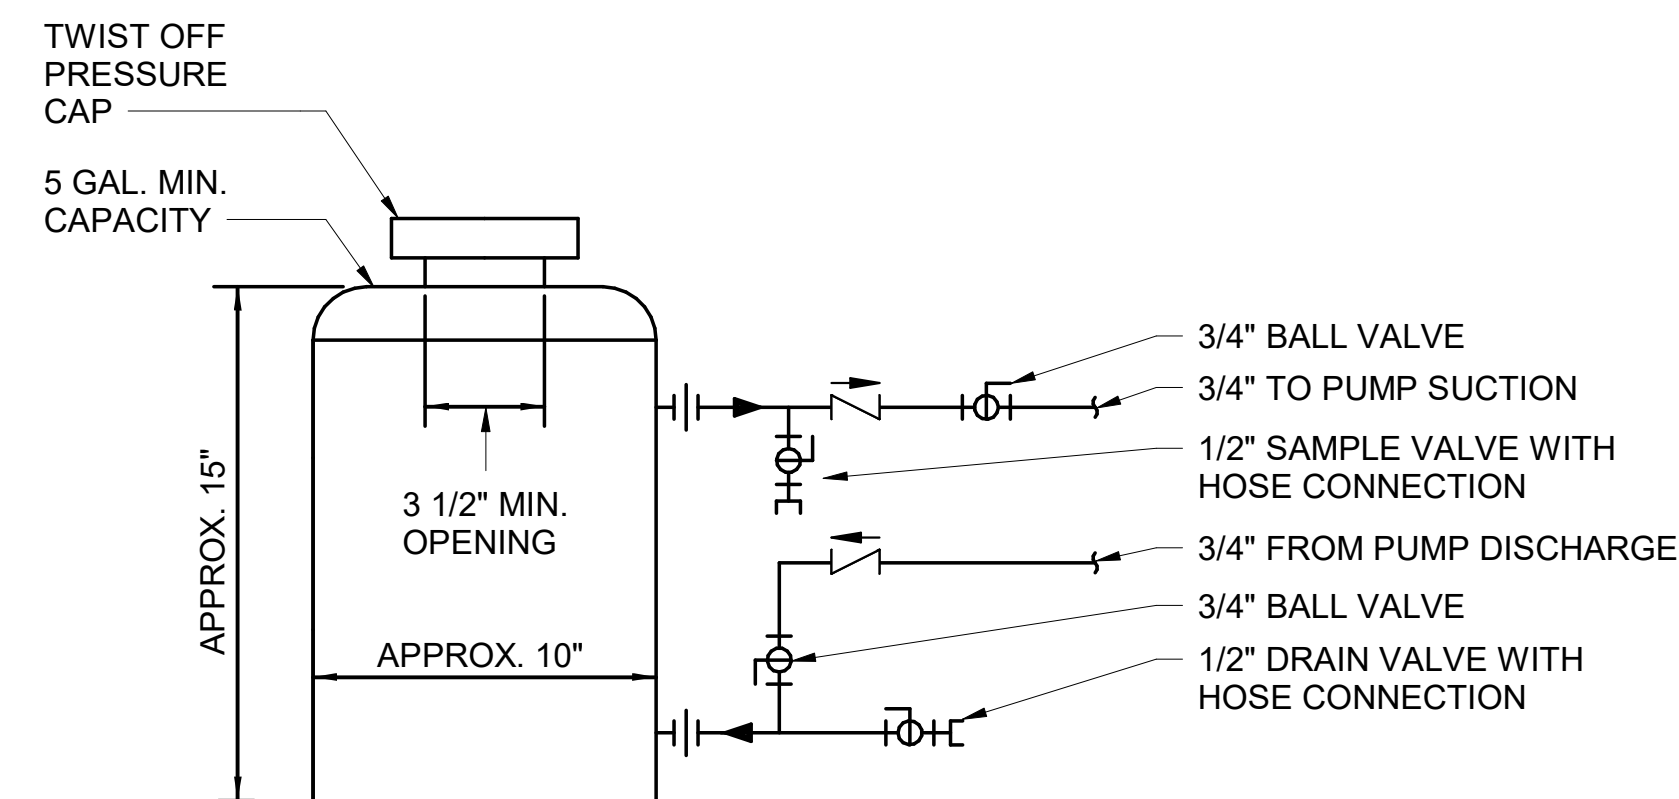

**F6** SHOT FEEDER  
M-505 SCALE: NO SCALE SHOWN

Sheet Title  
**MECHANICAL DETAILS**

Dwg. No.  
**PLM2021-0432-0027D**

Sht. No.  
**M-505**

1

2

3

4

5

6

7

8