

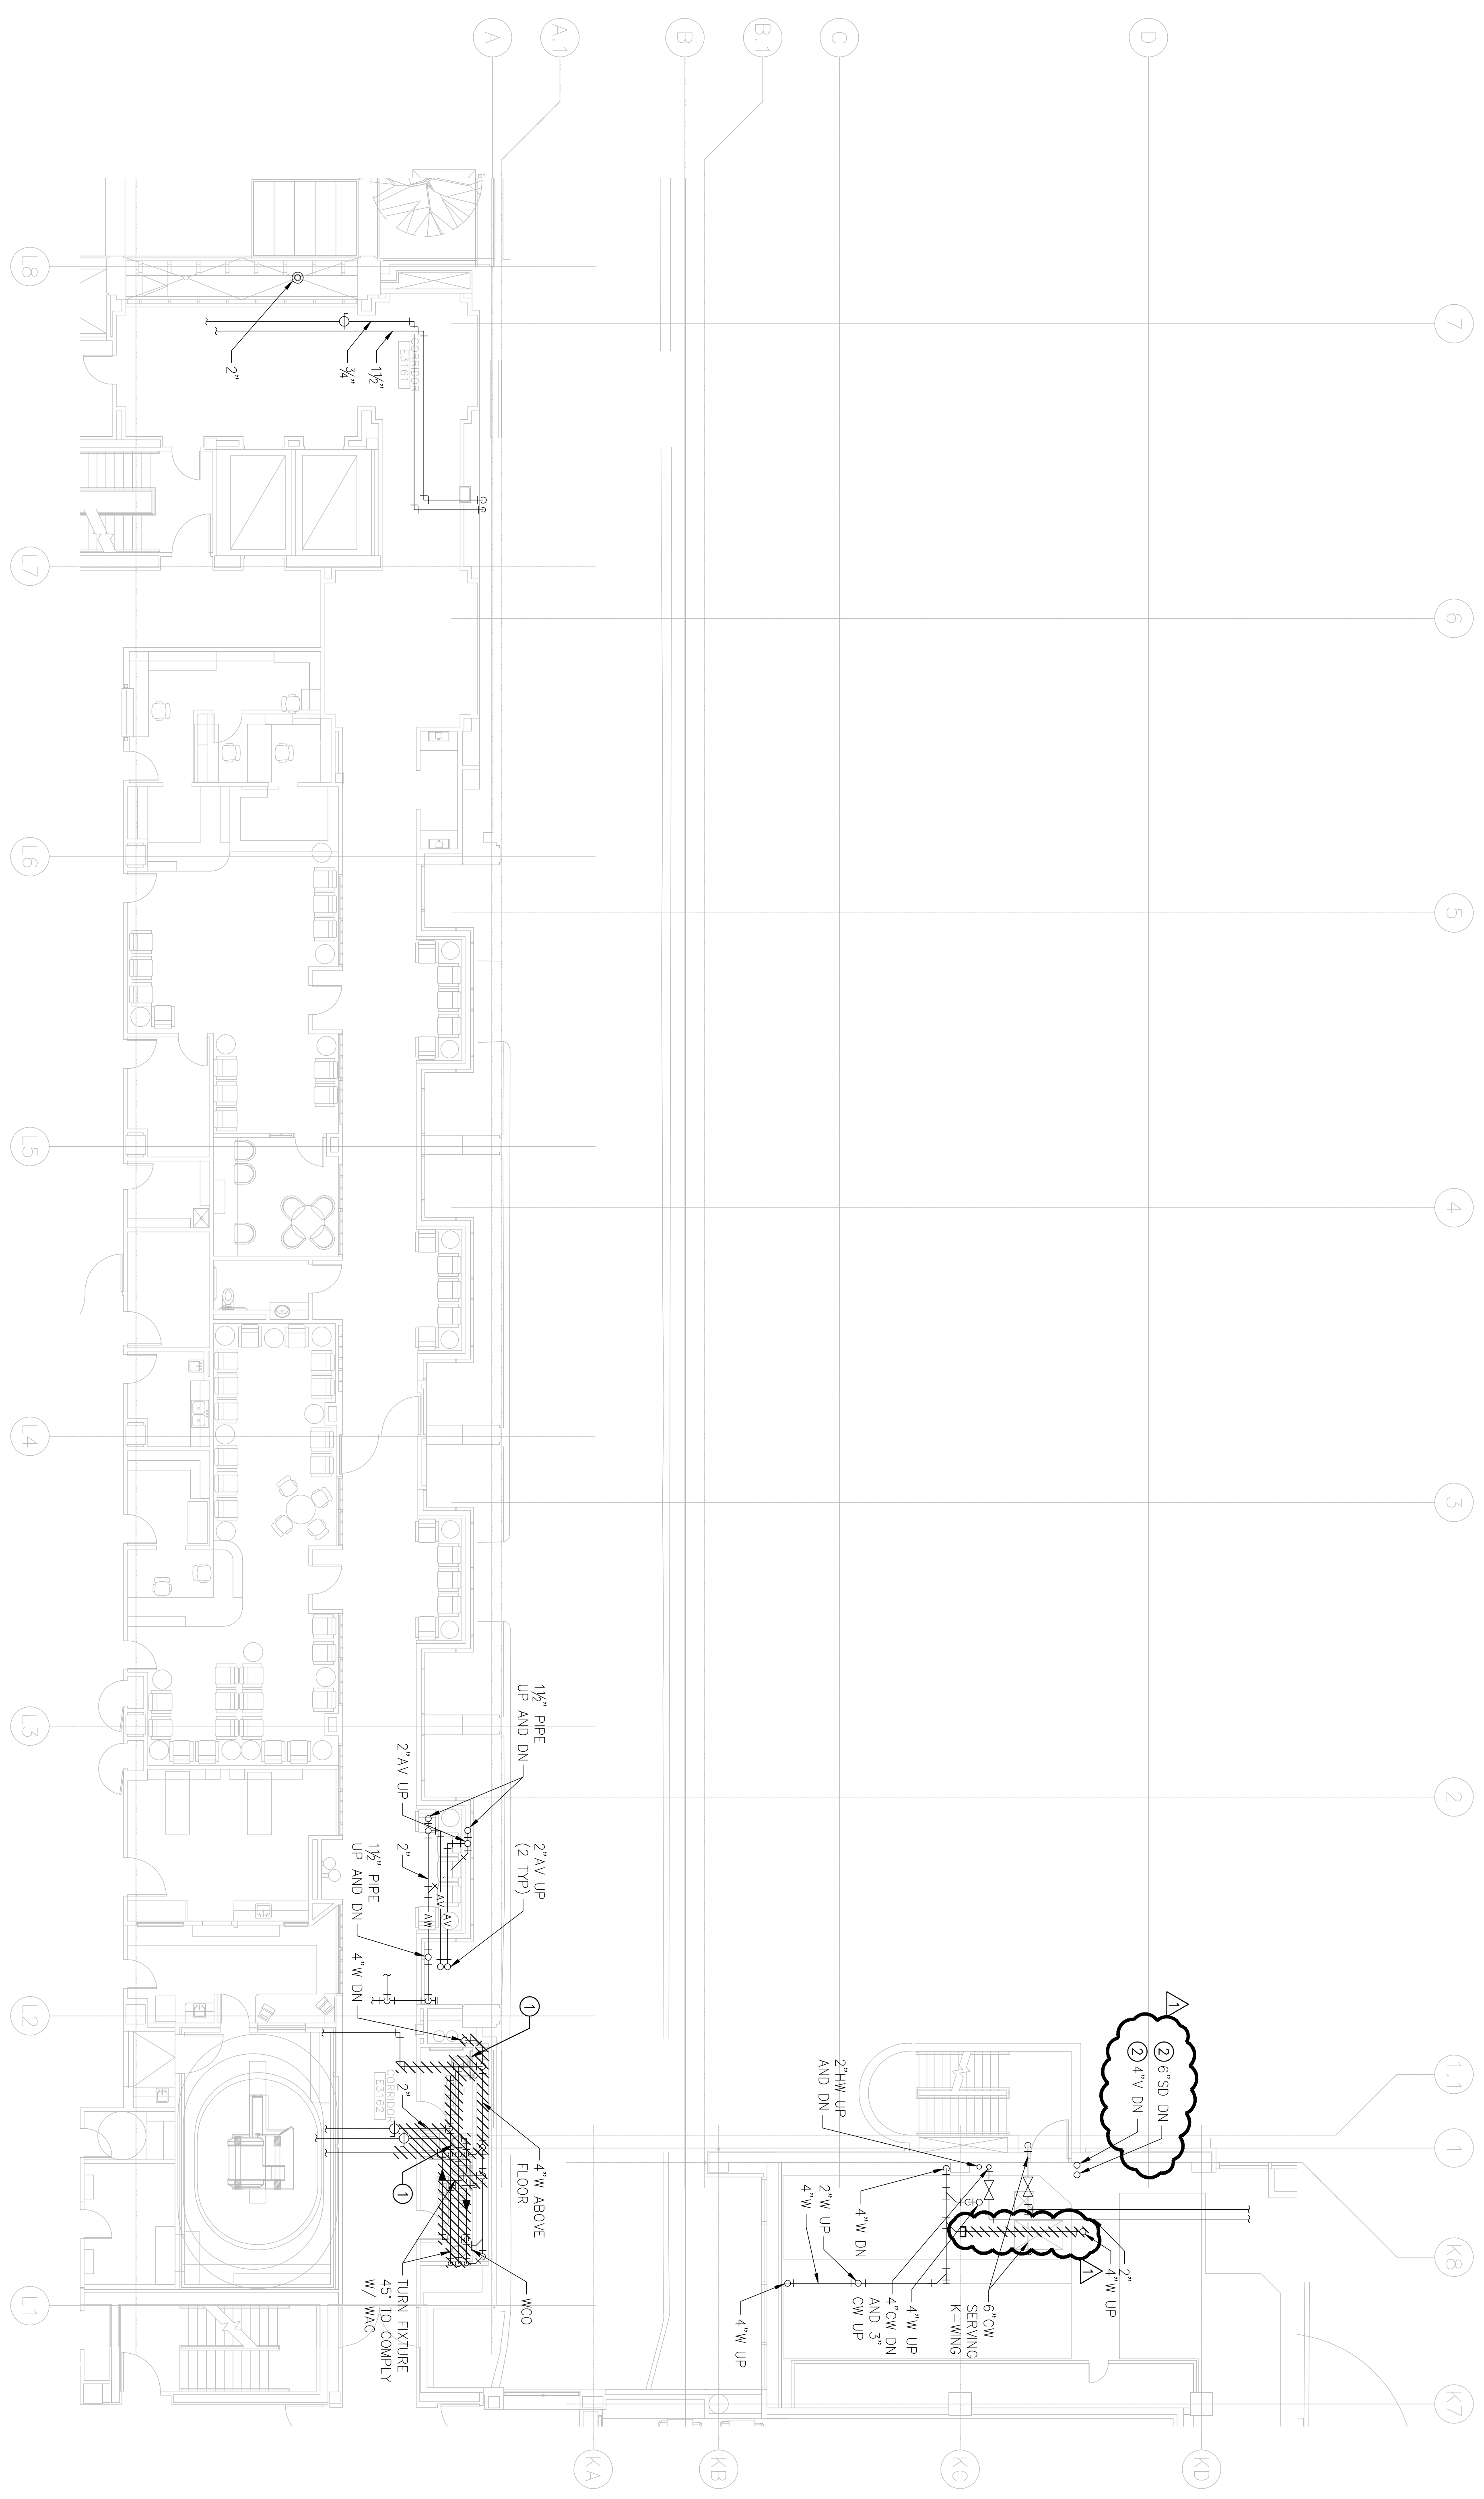


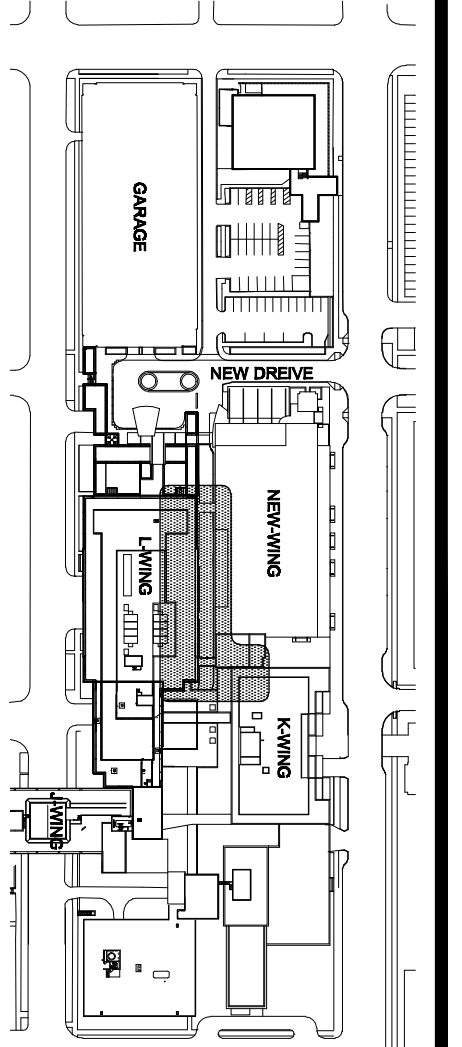

3RD FLOOR PLAN - L & K WING REMODEL - PLUMBING DEMOLITION
SCALE: 1/8"=1'-0"

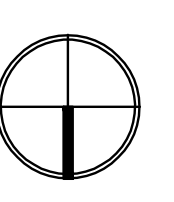

- KEY NOTES:**
- ① REMOVE EXISTING FIXTURE, CAP WASTE BELOW FLOOR
 - ② DEMOLISH 6"SD UP AND 4"V UP

GIFFIN • BOLTE • JURGENS P.C.
ARCHITECTS
815 E. W. SECOND AVENUE, PORTLAND, OREGON 97204
(503) 233-5992 www.gbj-arch.com

CDI ENGINEERS
4200 - 14th St SW, Suite 200
Burien, OR 97149
T: 503.872.1071 F: 503.778.8786
www.CDIENGINEERS.com



Multicare
EMERGENCY DEPARTMENT & CANCER CENTER EXPANSION
TACOMA, WASHINGTON

CCD 011	04-10-09

Date 09-26-2008
Scale 1/8"=1'-0"
Drawn By CBJ
Job No. 4034

3RD FLOOR
PLAN - L & K WING
REMODEL -
PLUMBING DEMO

M1
03