
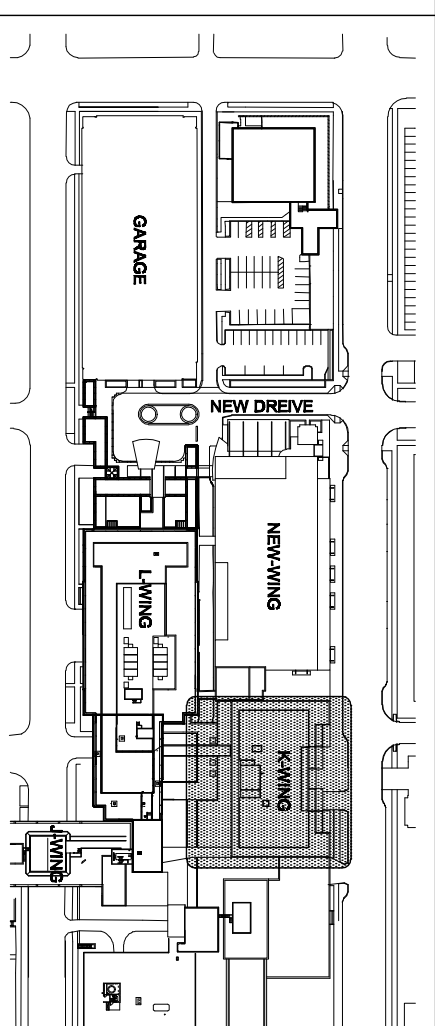
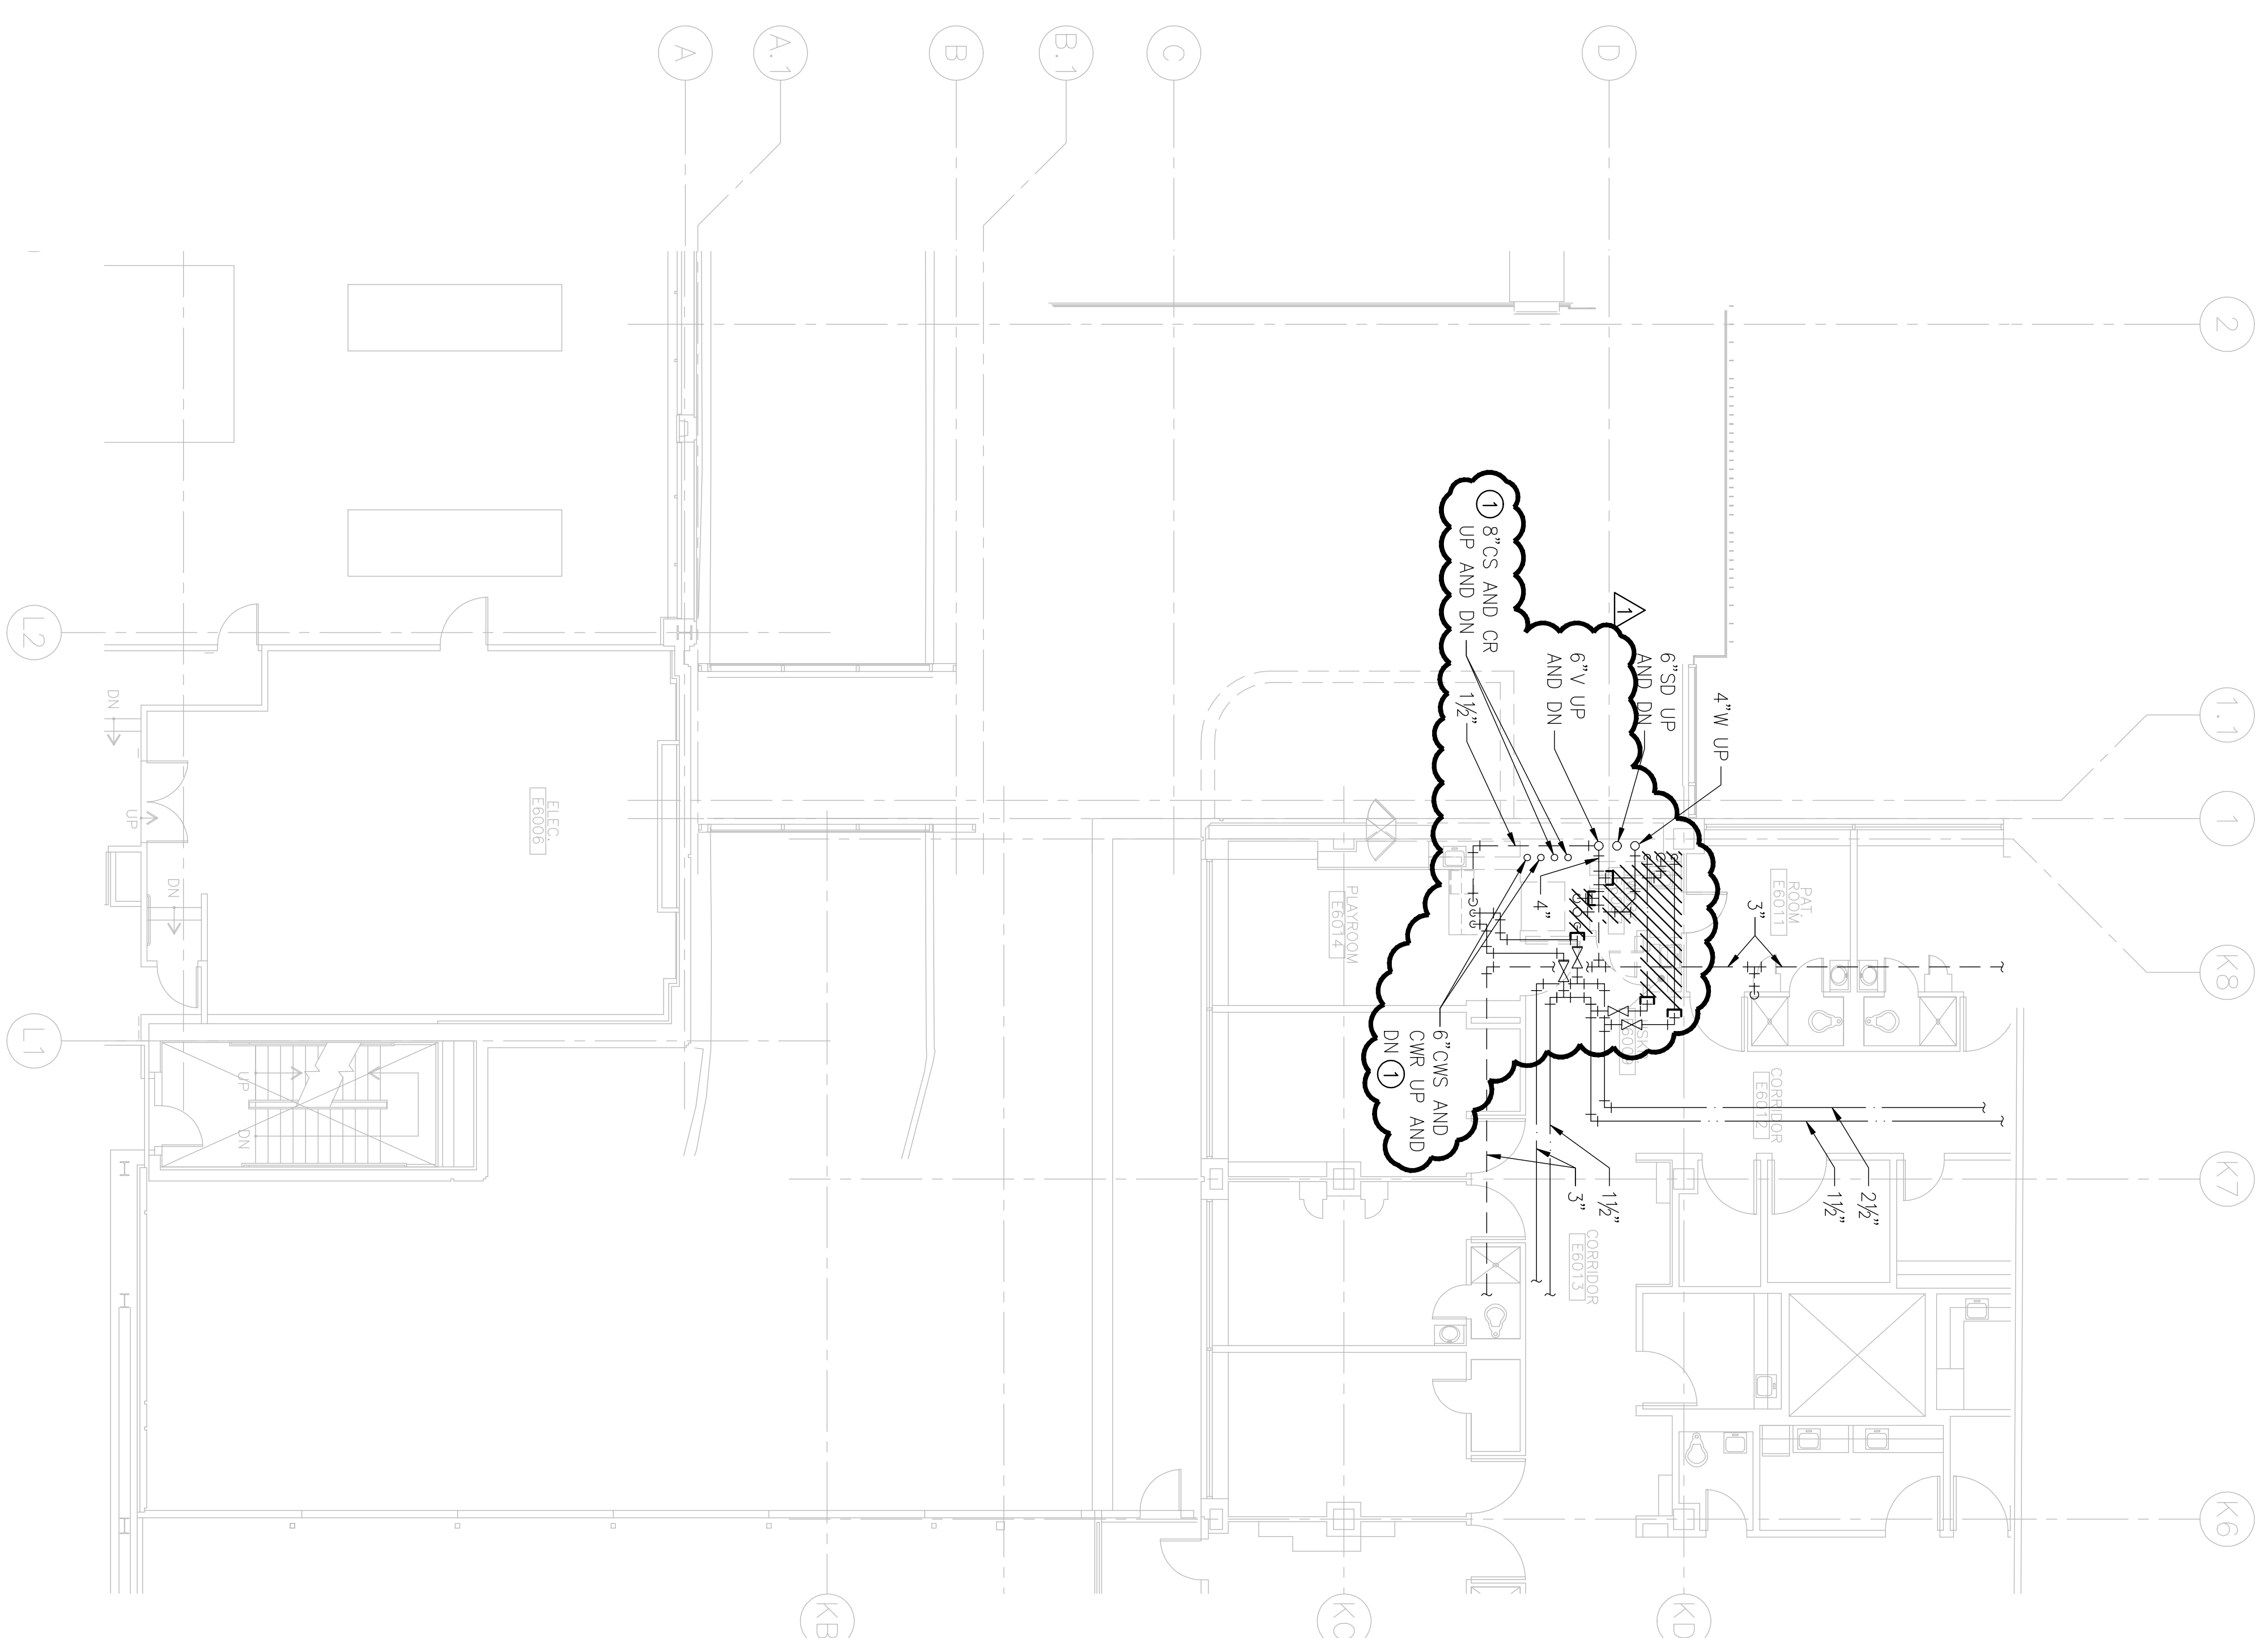


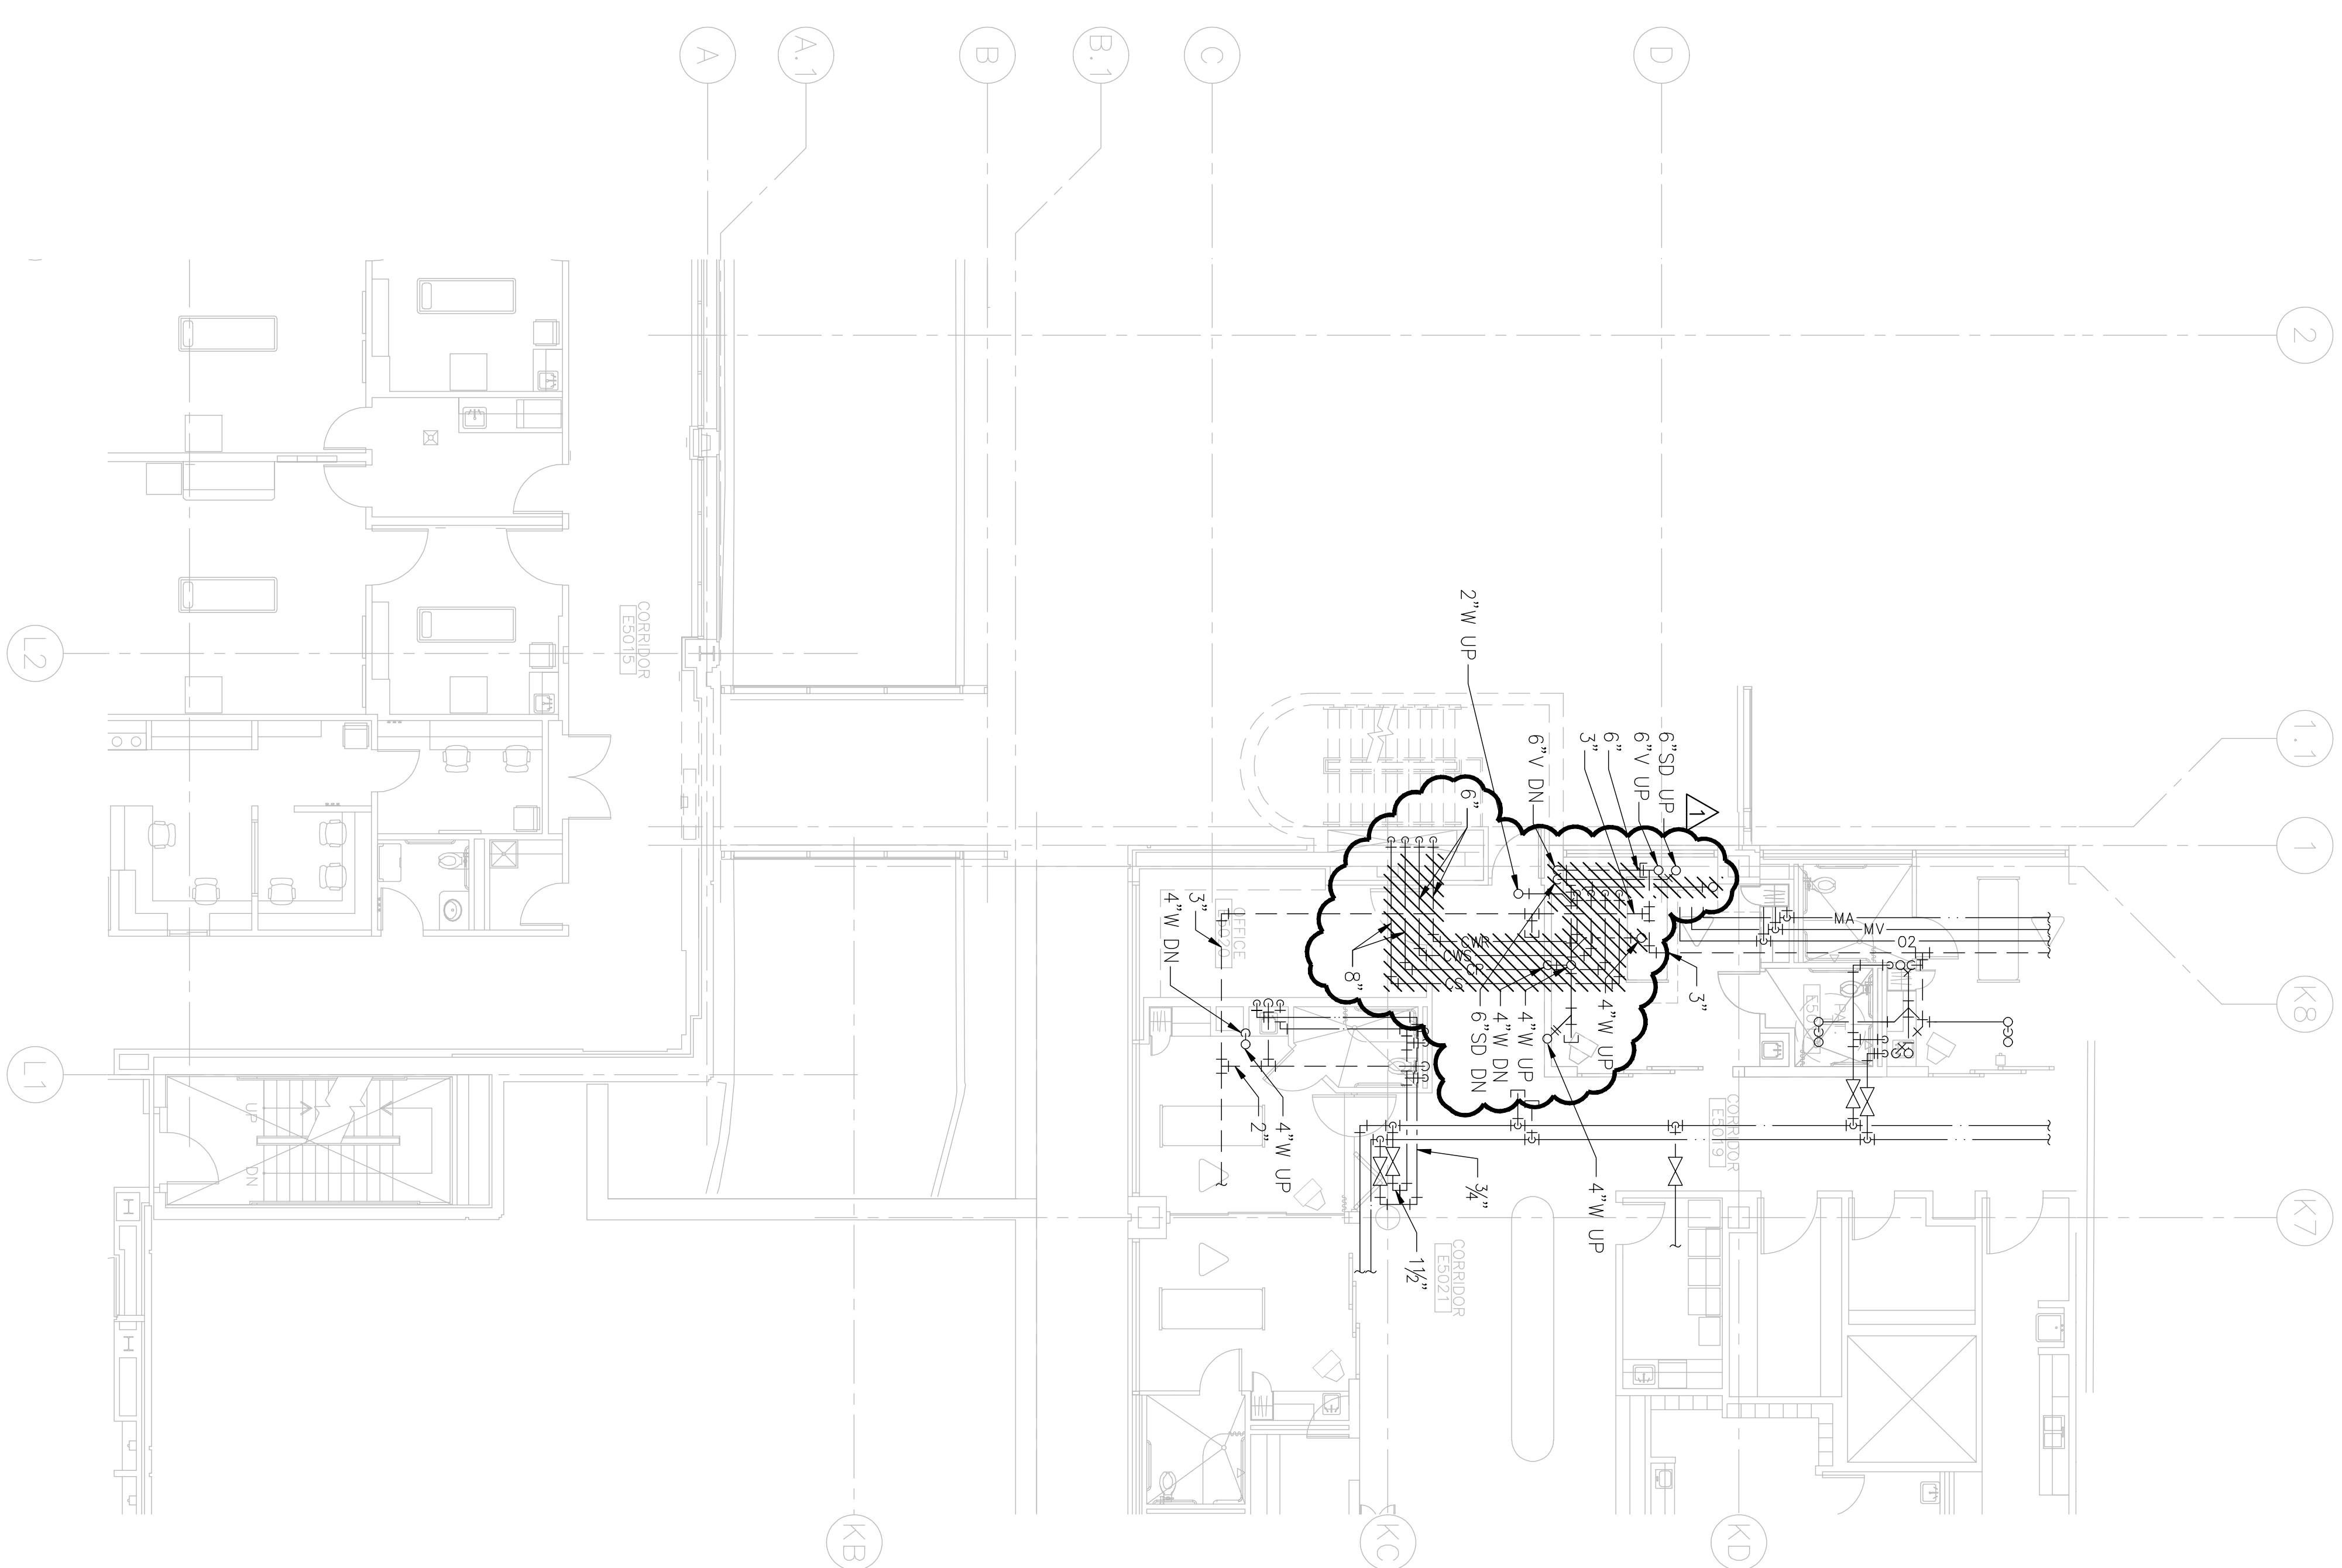

**PARTIAL 5TH FLOOR PLAN - L & K WING REMODEL { PIPING AND PLUMBING DEMOLITION**


SCALE: 1/8"=1'-0"

**PARTIAL 6TH FLOOR PLAN - L & K WING REMODEL { PIPING AND PLUMBING DEMOLITION**

SCALE: 1/8"=1'-0"

### KEY NOTES:

① DEMOLISH CHILLED AND CONDENSER WATER DOWN TO FIFTH FLOOR. PIPING UP TO SEVENTH FLOOR TO REMAIN.

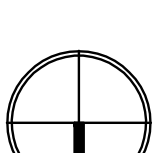


GIFFIN • BOLTE • JURGENS  
ARCHITECTS P.C.

815 S.W. SECOND AVENUE • PORTLAND, OREGON 97204  
(503) 223-0992 [www.gbjarch.com](http://www.gbjarch.com) FAX (503) 294-3961

CDiENGINEERS

4200 - 194th St SW, Suite 200  
Lynnwood, WA 98036  
T 425.672.1071 F 425.778.8766  
www.CDIENGINEERS.com

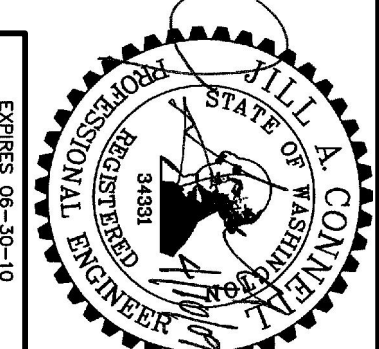

EXP RES 06-30-10



## EMERGENCY DEPARTMENT & CANCER CENTER EXPANSION

TACOMA, WASHINGTON

**CCD 011**

04-10-09

Date 09-26-2008

Scale 167-170

**Drawn By** **CD**

Job No. 4034

## 5TH & 6TH FLOOR PLAN - L & K WING REMODEL - PIPING AND PLUMBING DEMO

M1  
05