

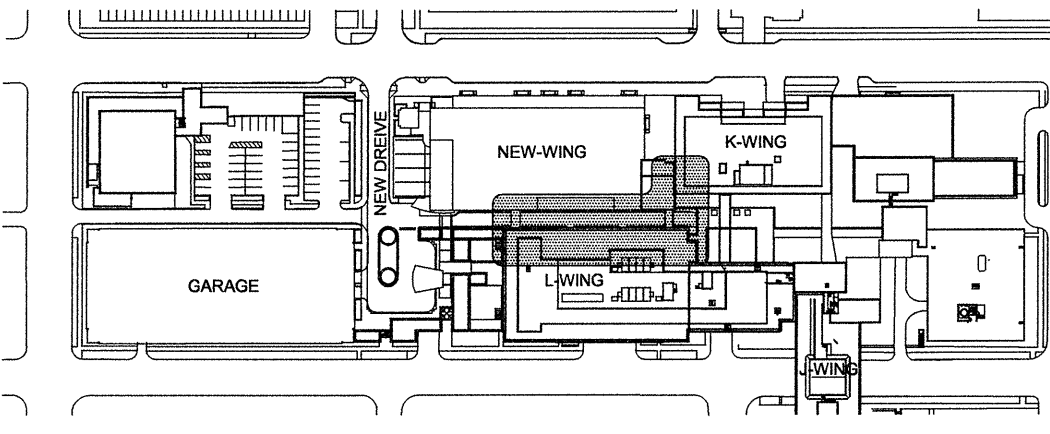


3RD FLOOR PLAN - L WING REMODEL - HVAC PIPING DEMOLITION
SCALE: 1/8"=1'-0"

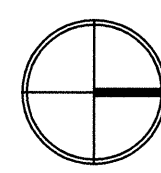

GIFFIN • BOLTE • JURGENS
ARCHITECTS
815 S.W. SECOND AVENUE • PORTLAND, OREGON 97204
(503) 223-0992 • www.gbjarch.com FAX (503) 294-3961

CDI ENGINEERS
4200 - 194th St SW, Suite 200
Lynnwood, WA 98036
T 425.672.1071 F 425.778.8768
www.CDIENGINEERS.com

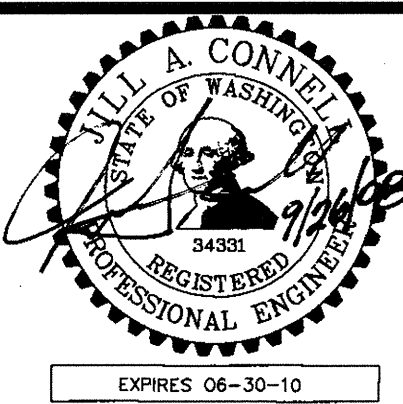

MultiCare

EMERGENCY DEPARTMENT & CANCER CENTER EXPANSION

TACOMA, WASHINGTON

Date 09-26-2008
Scale 1/8"=1'-0"
Drawn By CDI
Job No. 4034

**3RD FLOOR
PLAN - L WING
REMODEL - HVAC
PIPING DEMO**

**M1
23**