


A
B
C
D
E

A
B
C
D
E

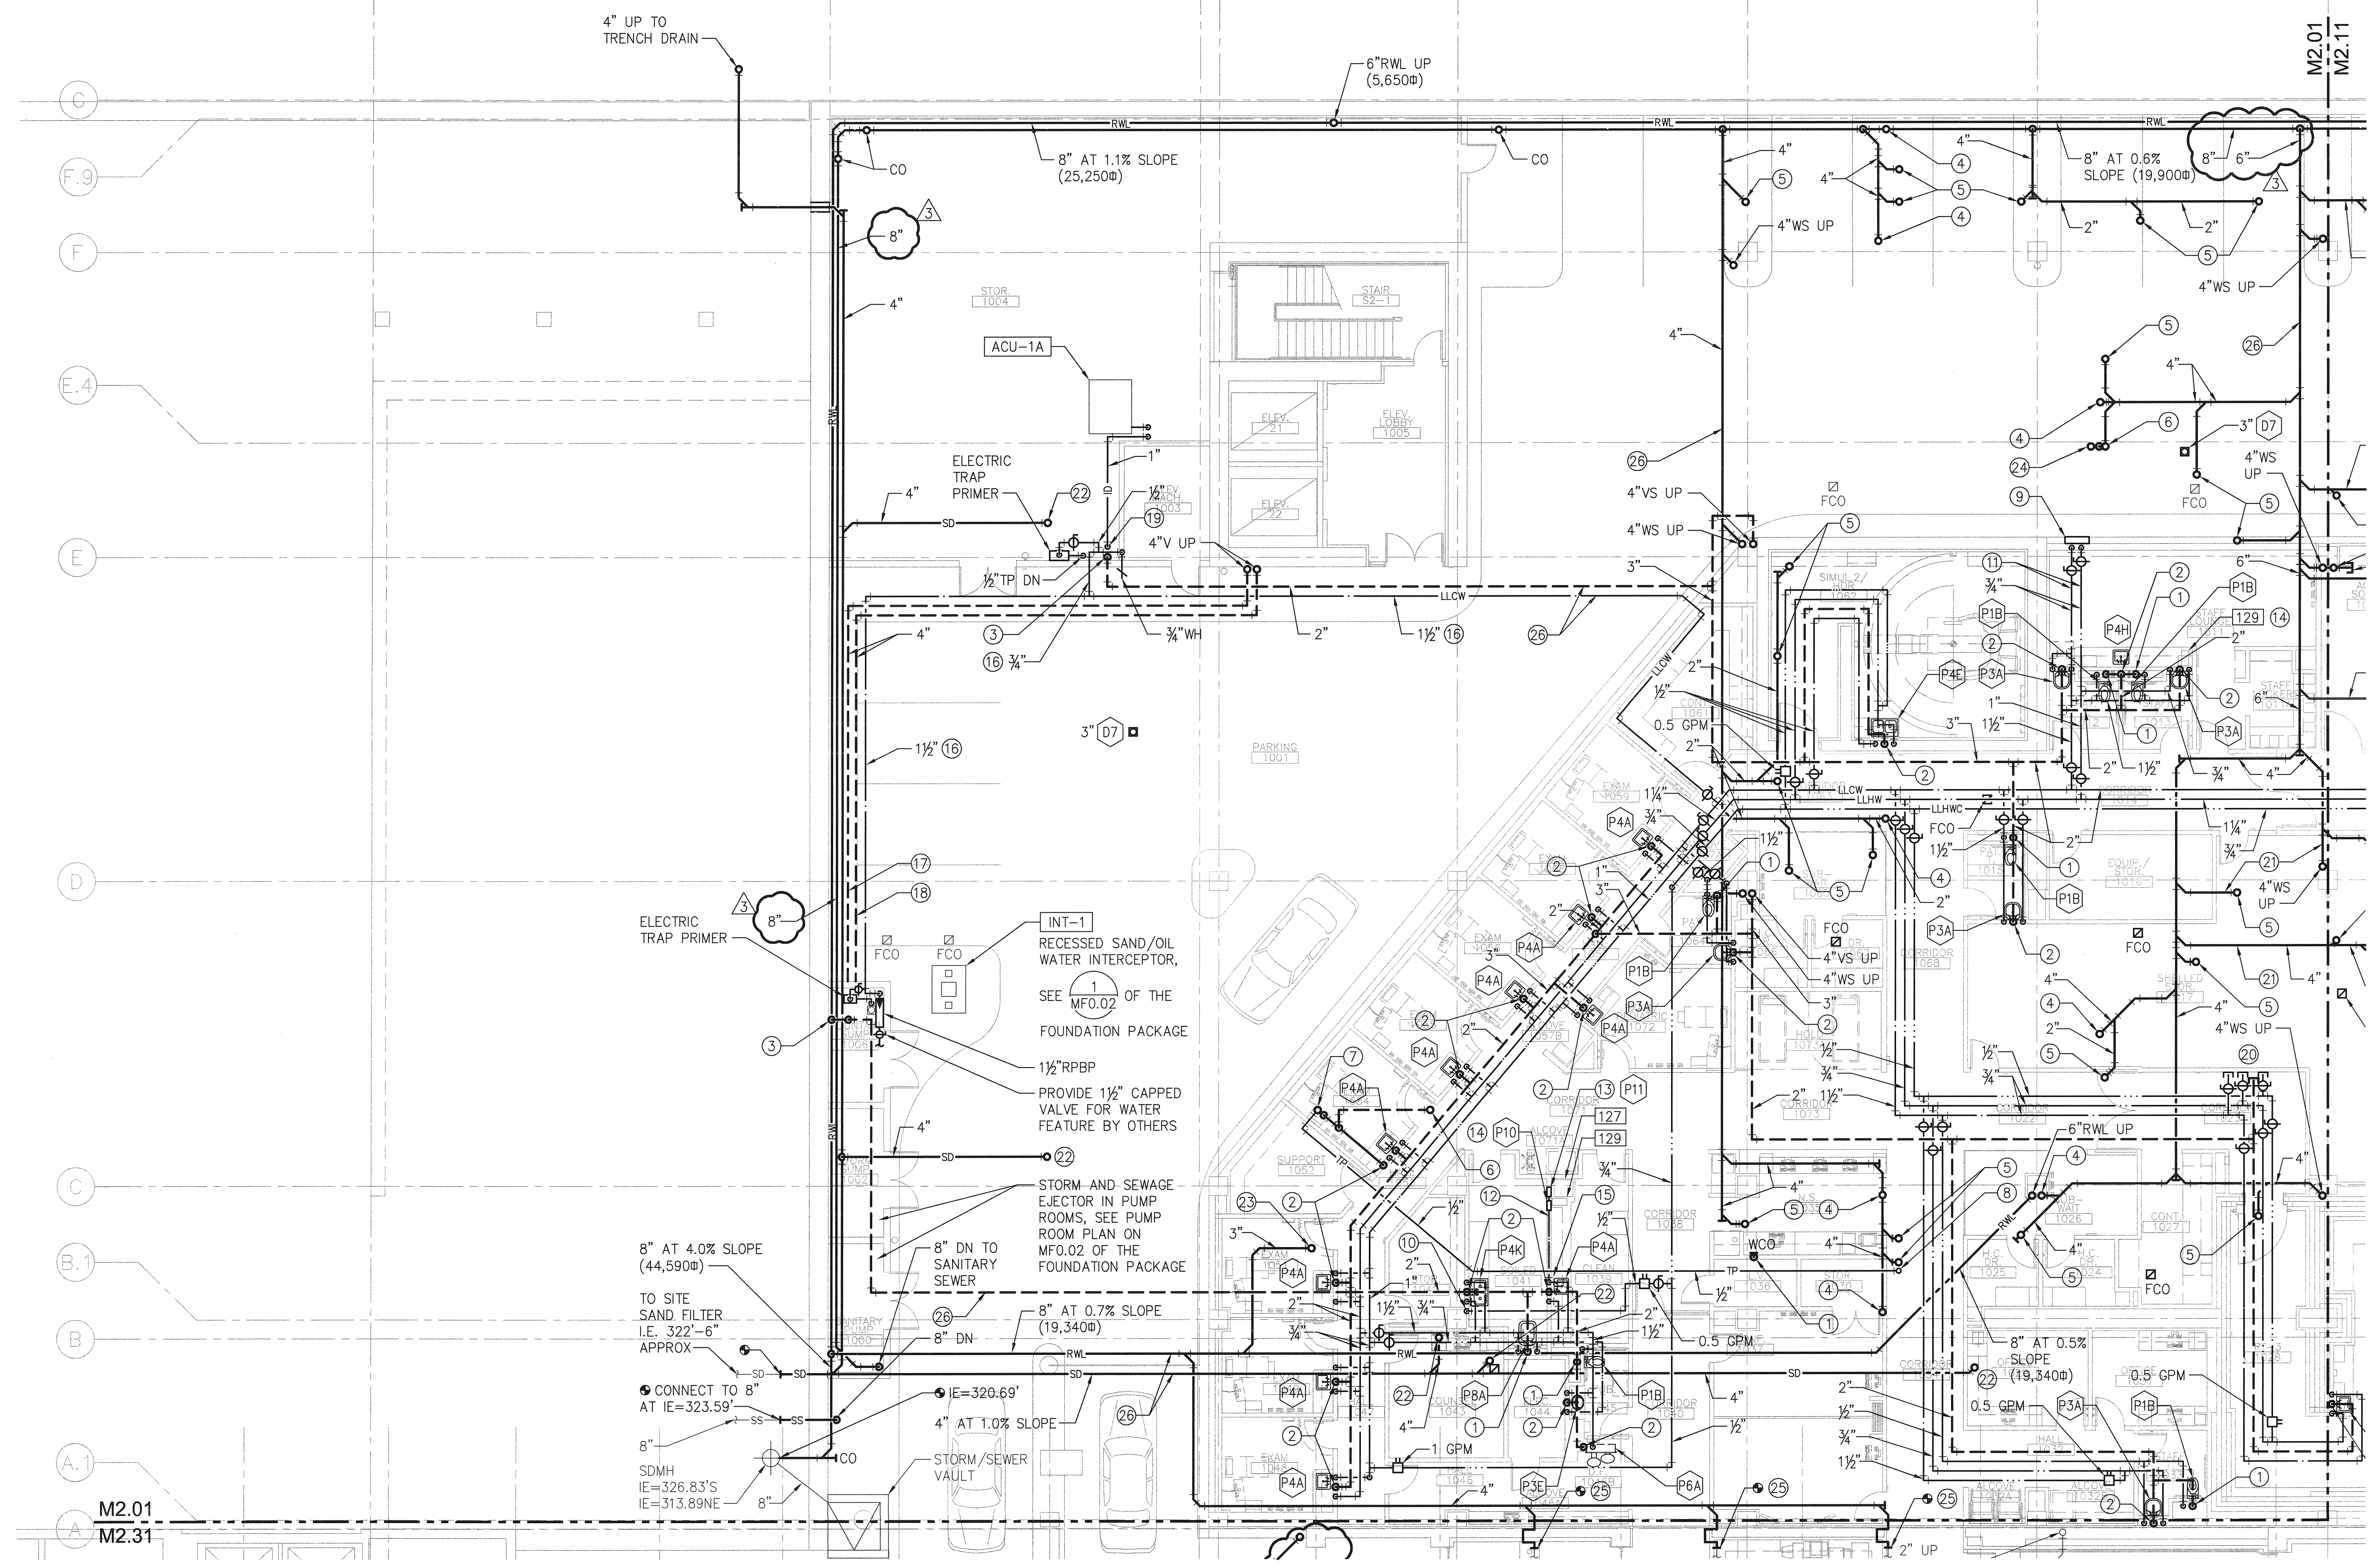


1ST FLOOR PLAN - SOUTH - PLUMBING
SCALE: 1/8"=1'-0"

GENERAL NOTES:
1. REFER TO FOUNDATION PACKAGE FOR FLOOR
CLEANOUT INDICATED AS EXISTING.

- KEY NOTES:
- 4"W DOWN.
 - 2"W DOWN.
 - 2"V DOWN.
 - 4"W UP.
 - 2"W UP.
 - 2"V UP.
 - 2"W UP TO D1 OR D2.
 - 1/2" TP UP TO MECHANICAL TRAP PRIMER.
 - WALL HYDRANT, ZURN Z1325-VB, 3/4" HOSE CONNECTION. MOUNT 42" ABOVE FINISHED FLOOR.
 - 1/2" HWC DOWN TO HOT WATER CONNECTION AT MIXING VALVE.
 - PROVIDE VACUUM BREAKER IN PIPING, WATTS MODEL 288A.
 - 1/2" LLGW AND 1" COPPER INDIRECT DRAIN IN WALL TO P11. MOUNT P11 18" ABOVE FINISHED FLOOR AT BACK OF CASE WORK.
 - PROVIDE 1/2" WATER CONNECTIONS TO COFFEE MAKER [129] AND ICE MACHINE [127]. PROVIDE 3/4" INDIRECT DRAIN CONNECTION TO ICE MACHINE [127] FROM P10 AND P11.
 - MOUNT P10 18" ABOVE FINISHED FLOOR AT BACK OF CASEWORK PROVIDE 1/2" LLGW WATER CONNECTION TO COFFEE MAKER [129].
 - SEE DETAIL 7 ON M10.05.
 - INSULATE AND ELECTRIC HEAT TRACE PIPING IN PARKING AREA SUBJECT TO AMBIENT TEMPERATURES BELOW 40°F.
 - 4"V FROM SANITARY SEWER PUMP VAULT.
 - 4"V FROM STORM WATER PUMP VAULT.
 - 2" STANDPIPE, TERMINATE 24" ABOVE FINISHED FLOOR.
 - PROVIDE 1/2" LLGW, 1/2" LLHW, 1/2" LLHWC AND 1/2" V CAPPED FOR FUTURE.
 - HOLD PIPING TIGHT TO STRUCTURE ABOVE.
 - 4" SD UP TO TRENCH DRAIN.
 - 3" UP TO AREA DRAIN.
 - 2" W UP TO D10.
 - CONNECT 3" RWL TO EXISTING 3" PLANTER DRAIN. PROVIDE FLEXIBLE EXPANSION LOOP AT SEISMIC JOINT.
 - KEEP PIPES CROSSING DRIVE ISLE 10'-0" ABOVE FINISH FLOOR MINIMUM.

GIFFIN • BOLTE • JURGENS p.c.
ARCHITECTS
815 S.W. SECOND AVENUE • PORTLAND, OREGON 97204
(503) 223-0992 www.gbjarch.com FAX (503) 294-3961

CDI ENGINEERS
4200 - 194th St SW, Suite 200
Lynnwood, WA 98036
T 425.672.1071 F 425.778.8769
www.CDIENGINEERS.com

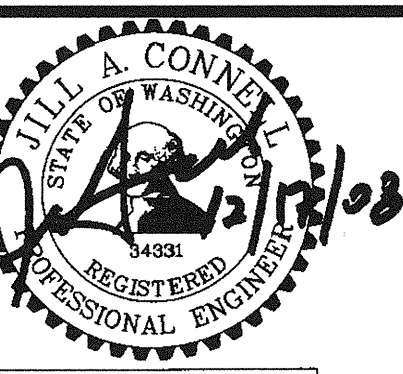

MultiCare
EMERGENCY DEPARTMENT & CANCER CENTER EXPANSION
TACOMA, WASHINGTON

CCD 04 (RFI 0317)	12-17-08
CCD 04 (RFI 0289)	12-17-08
CCD 04	12-17-08

Date 09-26-2008
Scale 1/8"=1'-0"
Drawn By CDI
Job No. 4034

1ST FLOOR
PLAN - SOUTH -
PLUMBING
M2
01