



A
B
C
D
E

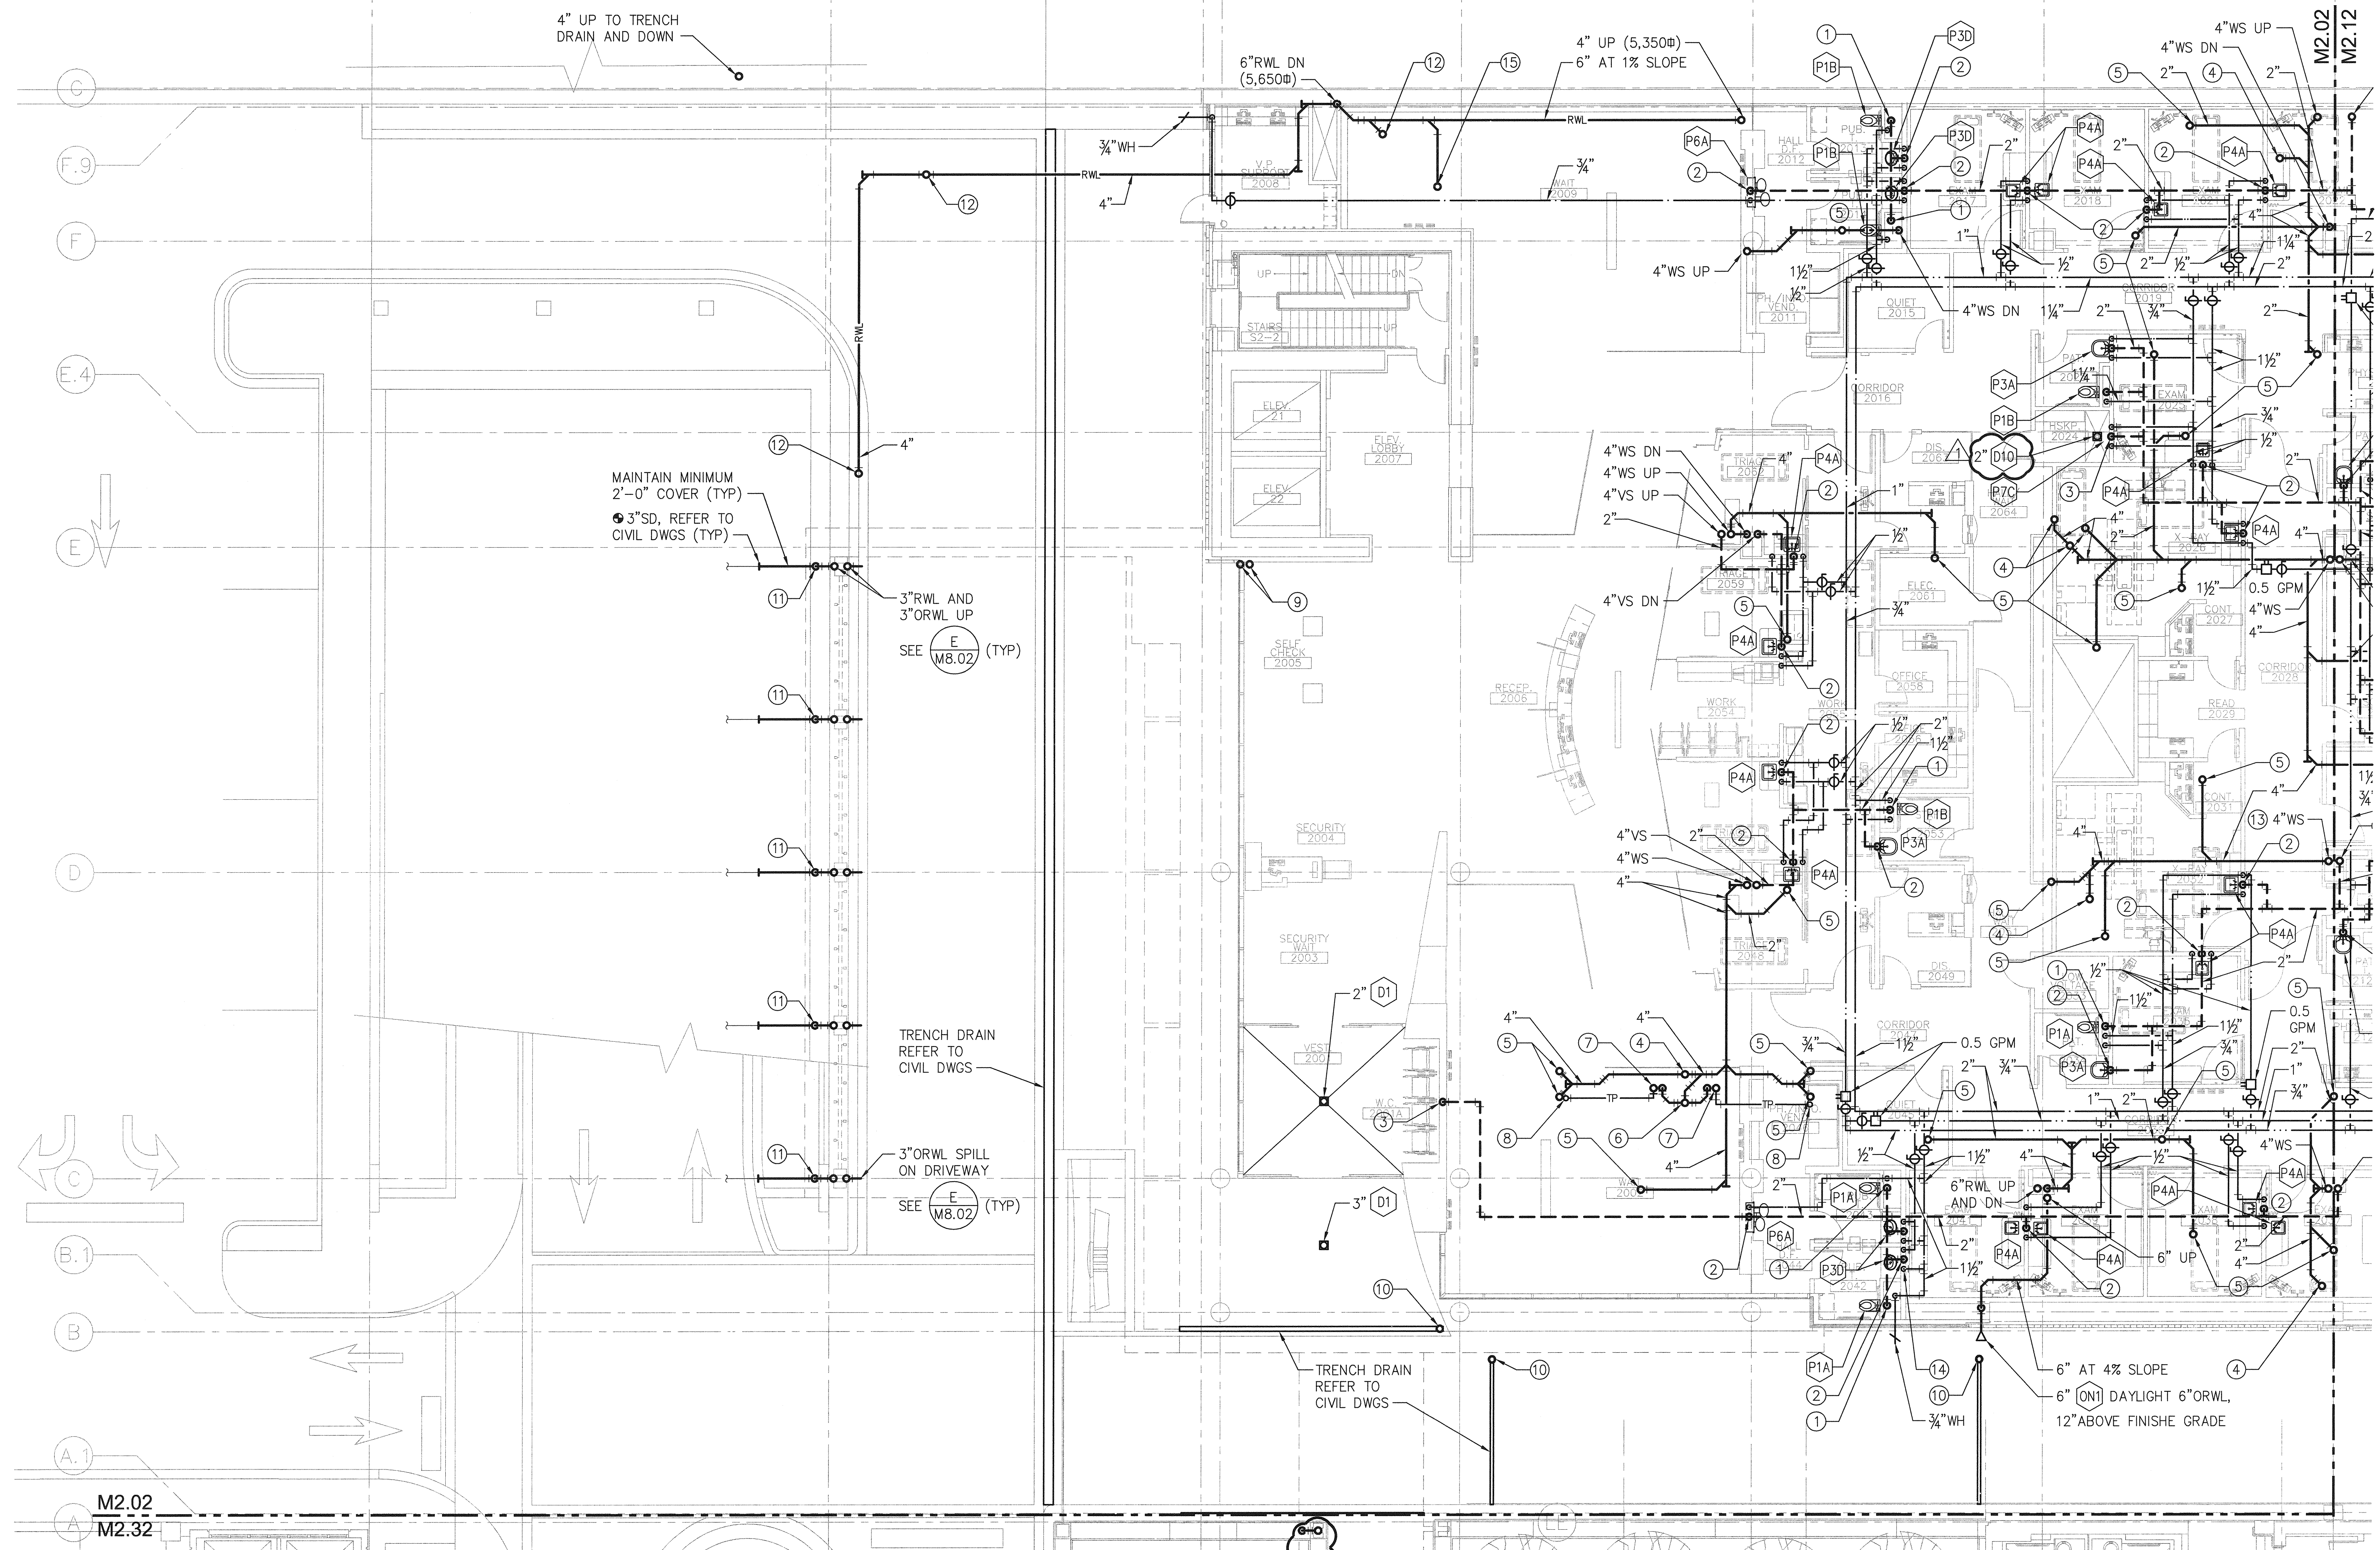


2ND FLOOR PLAN - SOUTH - PLUMBING
SCALE: 1/8"=1'-0"

- KEY NOTES:**
- ① 4"W DOWN.
 - ② 2"W DOWN.
 - ③ 2"V DOWN.
 - ④ 4"W UP.
 - ⑤ 2"W UP.
 - ⑥ 2"V UP.
 - ⑦ 2"W UP TO [D1].
 - ⑧ 1/2"TP UP TO MECHANICAL TRAP PRIMER.
 - ⑨ 4"V UP AND DOWN.
 - ⑩ 4" TRENCH DRAIN DOWN.
 - ⑪ 3"RWL DOWN IN CONCRETE WALL.
 - ⑫ 4"W UP TO [PD1].
 - ⑬ OFFSET 4"WS IN VERTICAL RISER TO PENETRATE FLOOR SLAB NORTH OF BEAM AND GRID LINE.
 - ⑭ PROVIDE MECHANICAL TRAP PRIMER LOCATED ABOVE ACCESSIBLE CEILING WITH 1/2"TP DOWN.
 - ⑮ 2" UP TO TRENCH DRAIN.

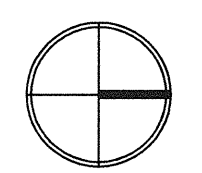

GIFFIN • BOLTE • JURGENS
ARCHITECTS
815 S.W. SECOND AVENUE • PORTLAND, OREGON 97204
(503) 223-0992 • www.gbjaarch.com • FAX (503) 294-3961

CDI ENGINEERS
4200 - 194th St SW, Suite 200
Lynnwood, WA 98036
T 425.672-1071 F 425.778-8769
www.CDIENGINEERS.com

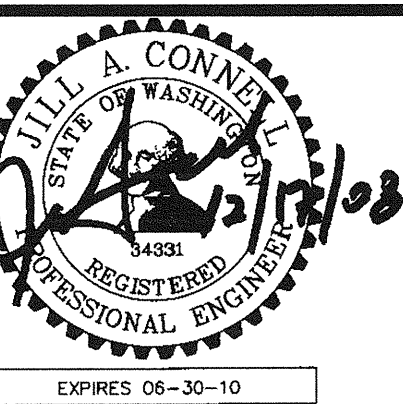

MultiCare
EMERGENCY DEPARTMENT & CANCER CENTER EXPANSION
TACOMA, WASHINGTON

△ CCD 04 (RFI 0289)	12-17-08	Date	09-26-2008
		Scale	1/8"=1'-0"
		Drawn By	CDI
		Job No.	4034

**2ND FLOOR
PLAN - SOUTH -
PLUMBING**

**M2
02**