

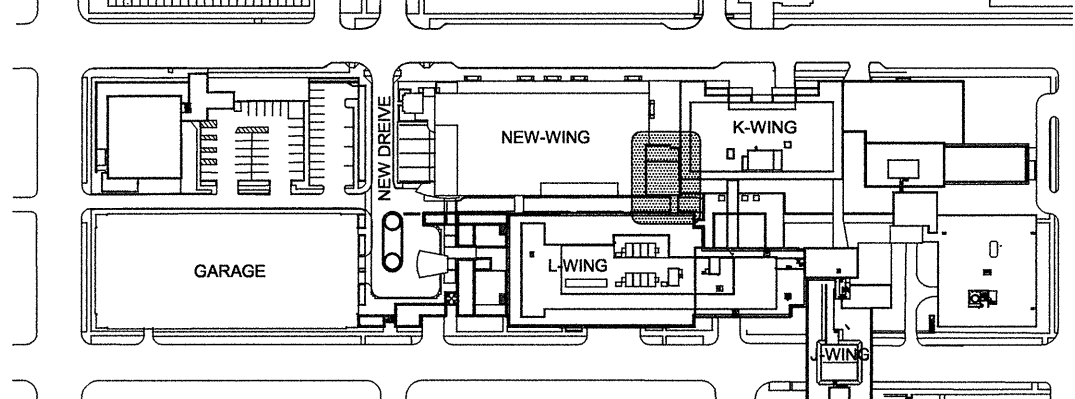


1 2 3 4 5 6 7

A
B
C
D
E

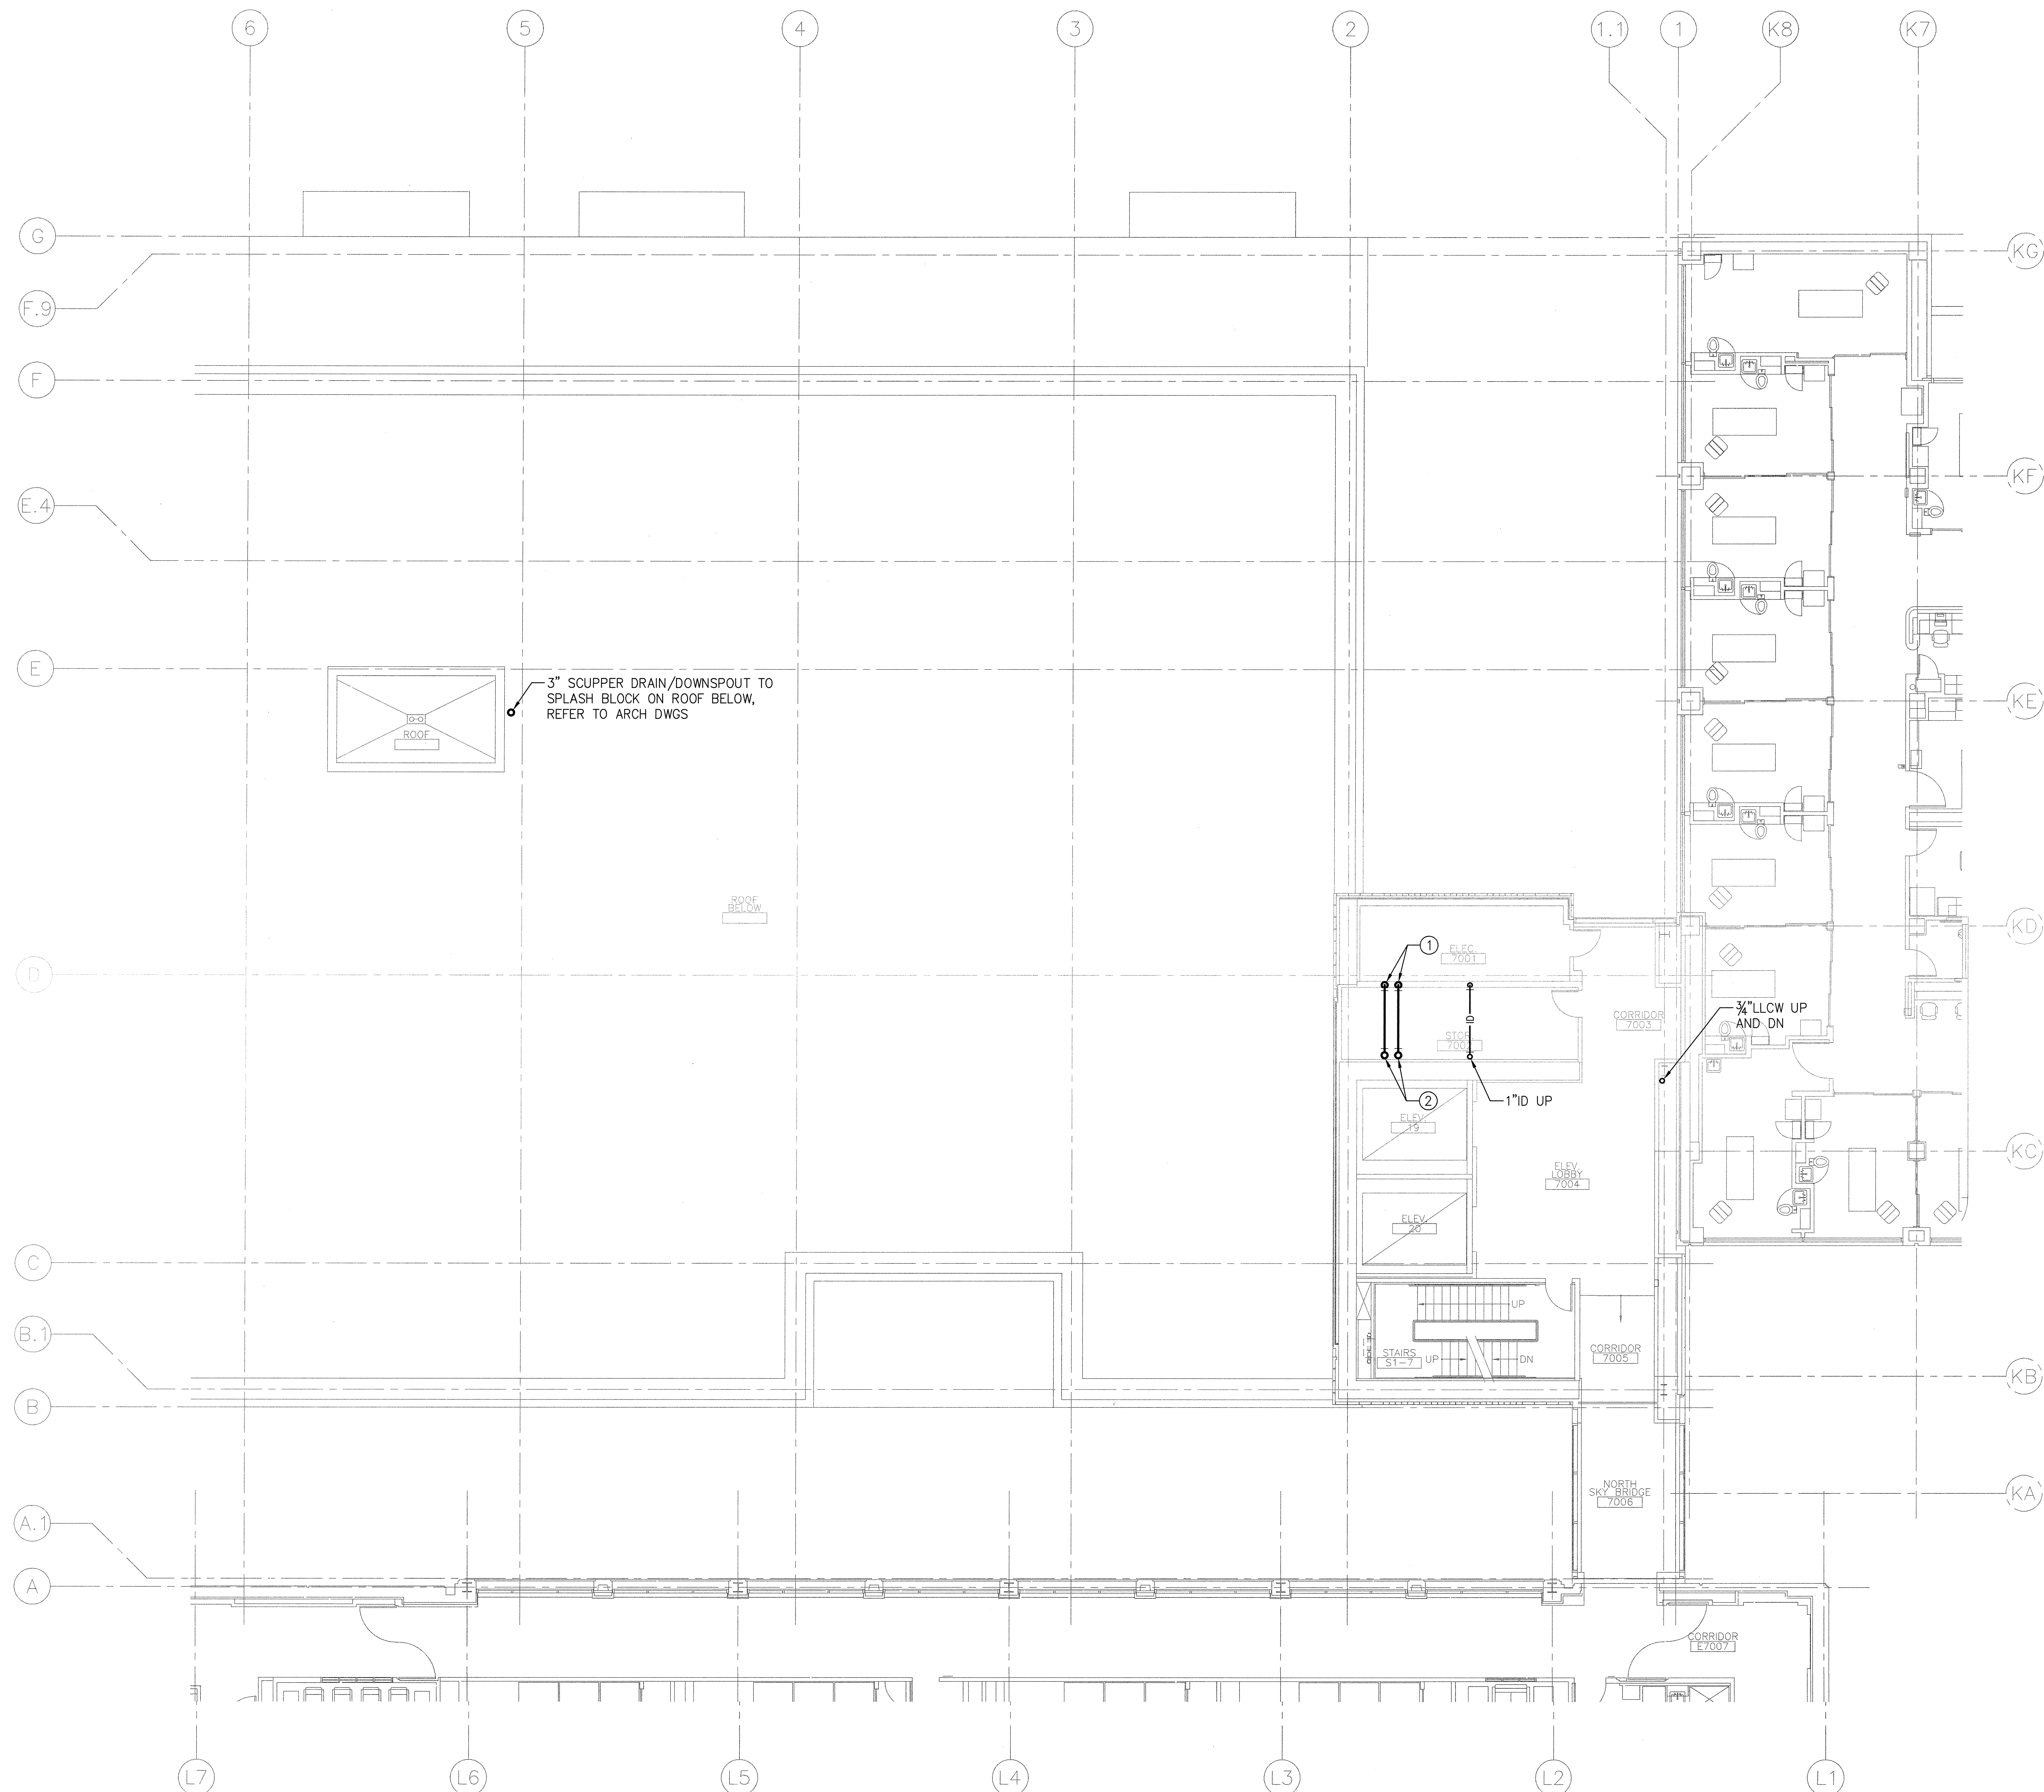

7TH FLOOR PLAN - NORTH - PLUMBING
SCALE: 1/8"=1'-0"

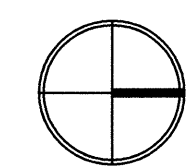


KEY NOTES:
① 4"RWL AND 4"ORWL DOWN.
② 4"RWL AND 4"ORWL UP.

GIFFIN • BOLTE • JURGENS, P.C.
ARCHITECTS

813 S.W. SECOND AVENUE, PORTLAND, OREGON 97204
(503) 223-0992 www.gbjarch.com FAX (503) 234-3961

CDI ENGINEERS

4200 - 194th St SW, Suite 200
Lynnwood, WA 98036
T 425.672.1071 F 425.778.8769
www.CDIENGINEERS.com

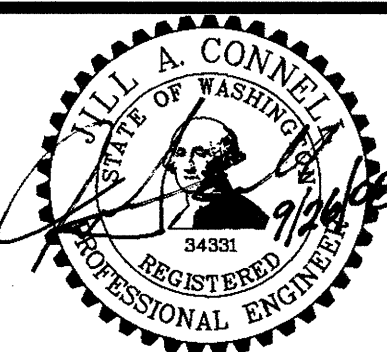

MultiCare

EMERGENCY DEPARTMENT & CANCER CENTER EXPANSION

TACOMA, WASHINGTON

Date 09-26-2008
Scale 1/8"=1'-0"
Drawn By CDI
Job No. 4034

7TH FLOOR PLAN -
NORTH - PLUMBING

M2
17