



**PARTIAL 8TH FLOOR PLAN - PLUMBING**  
SCALE: 1/8"=1'-0"

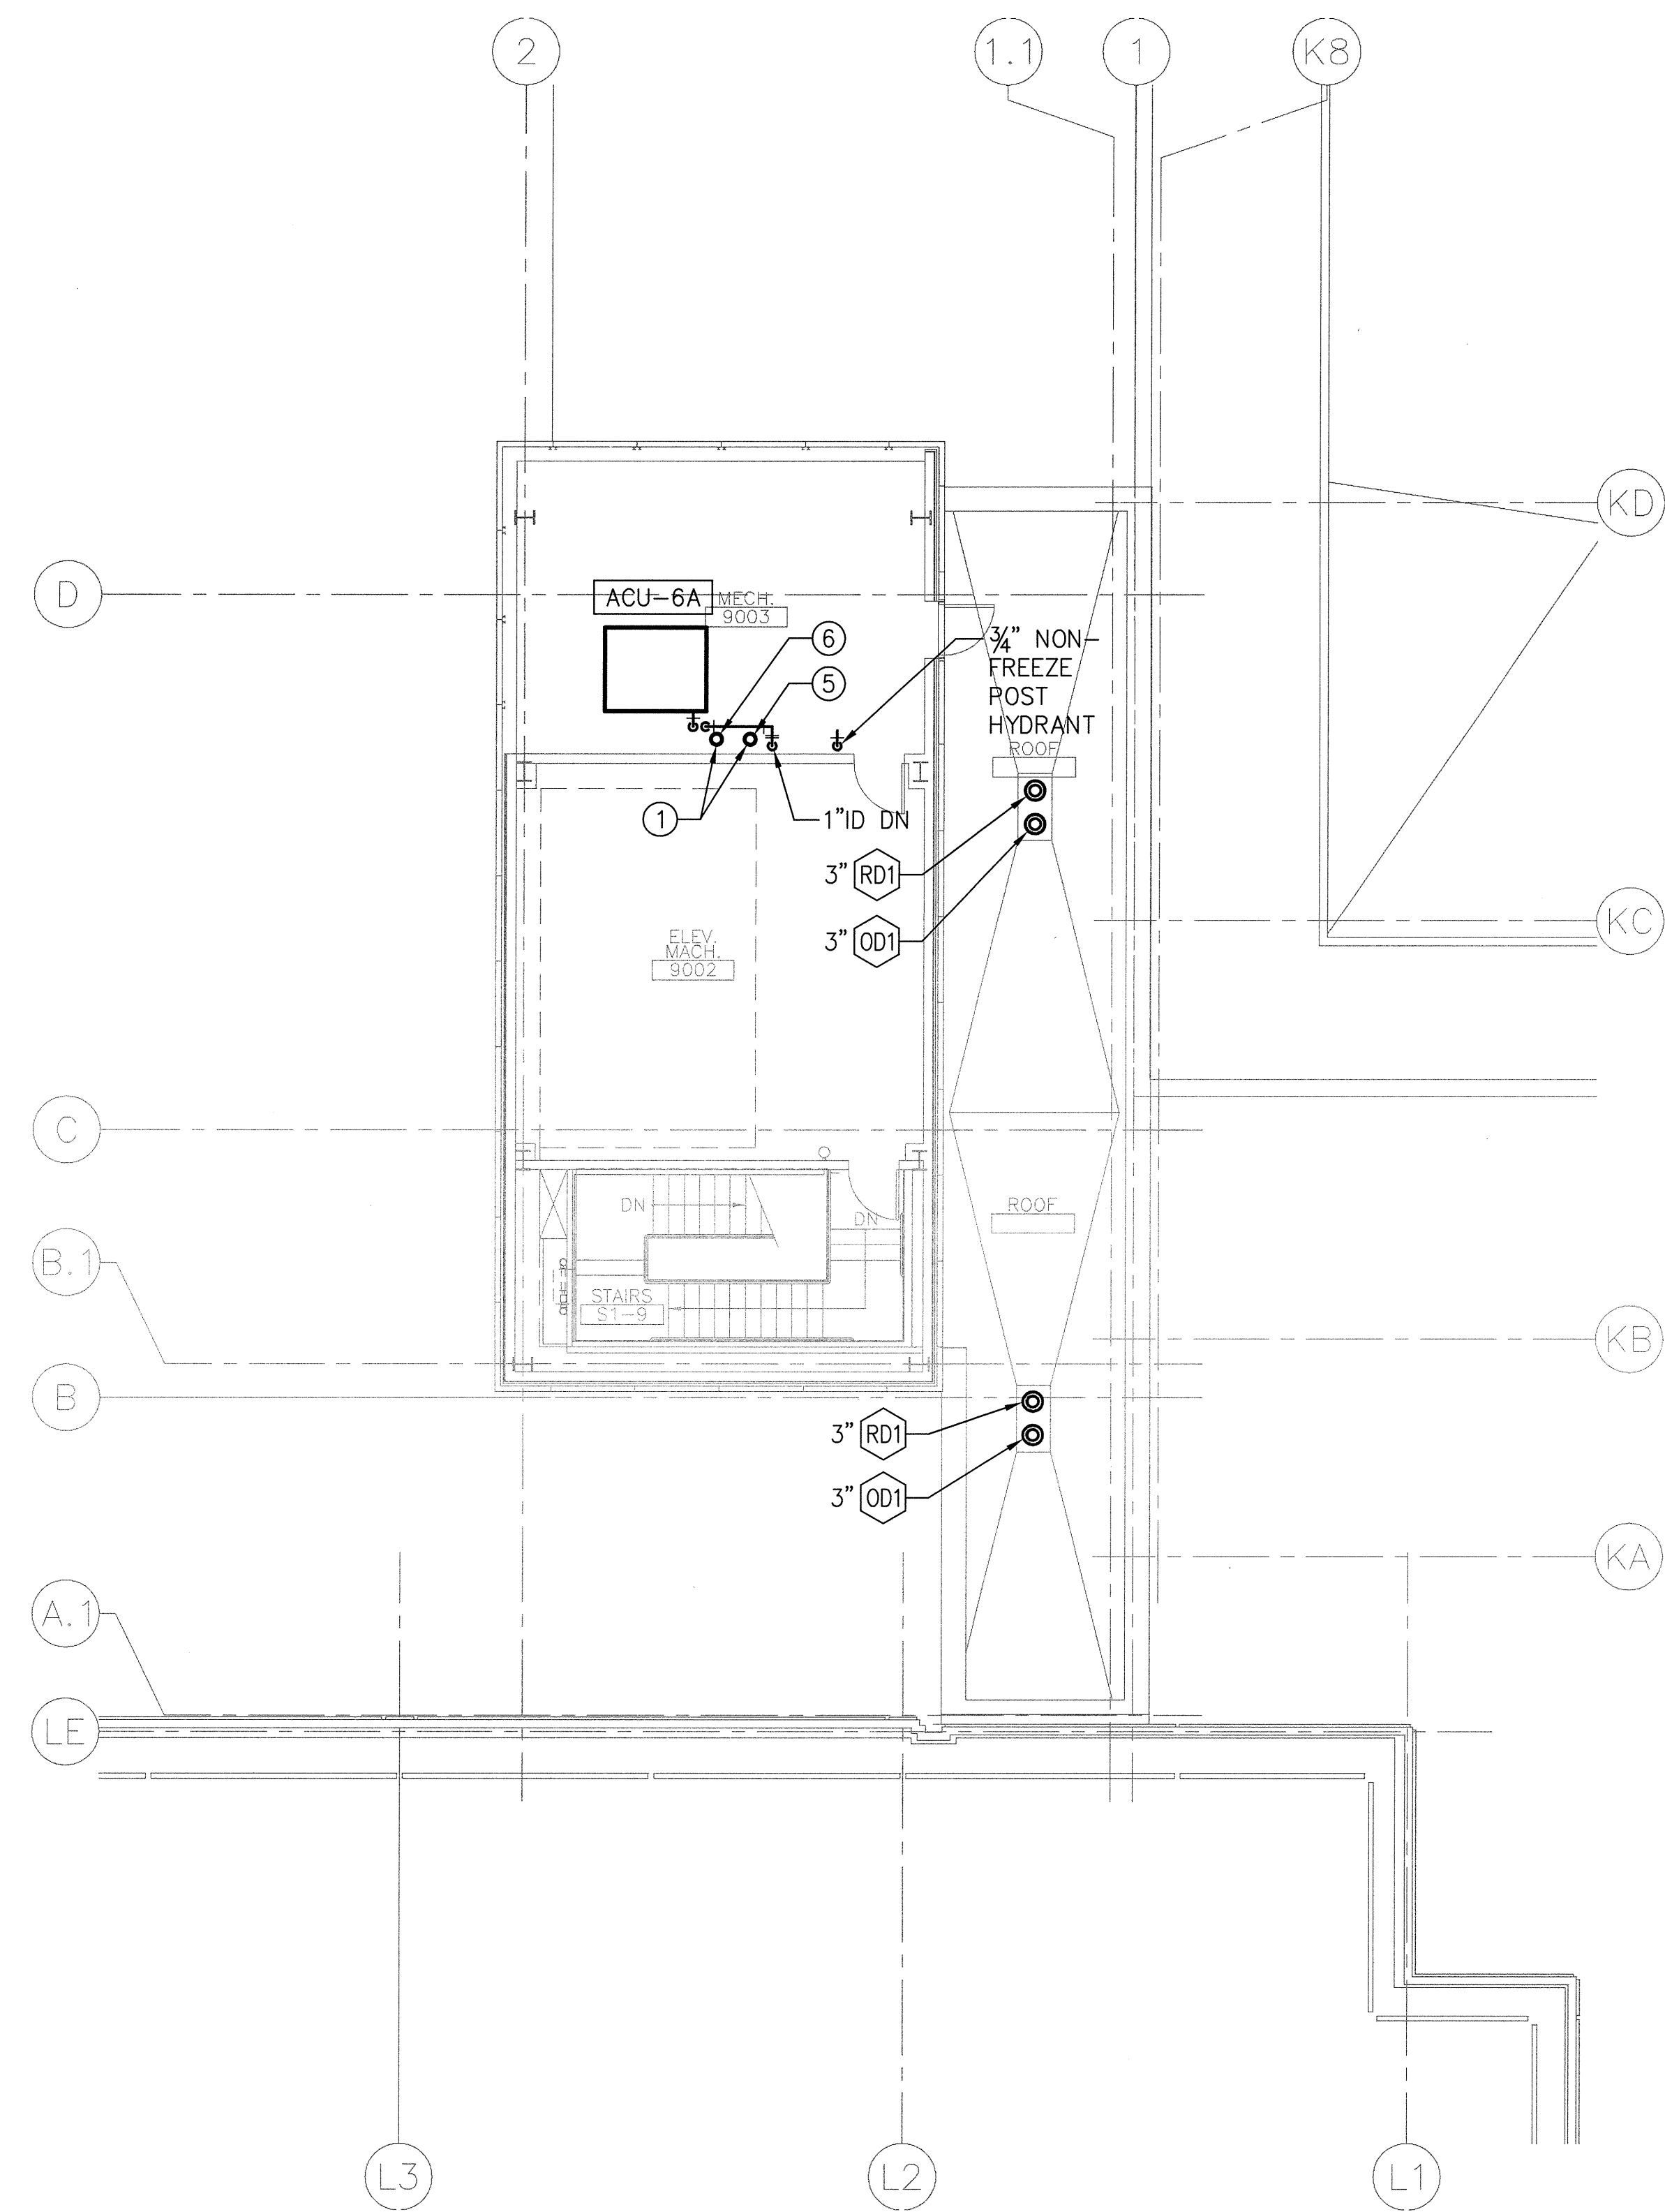

**PARTIAL 9TH FLOOR PLAN - PLUMBING**  
SCALE: 1/8"=1'-0"

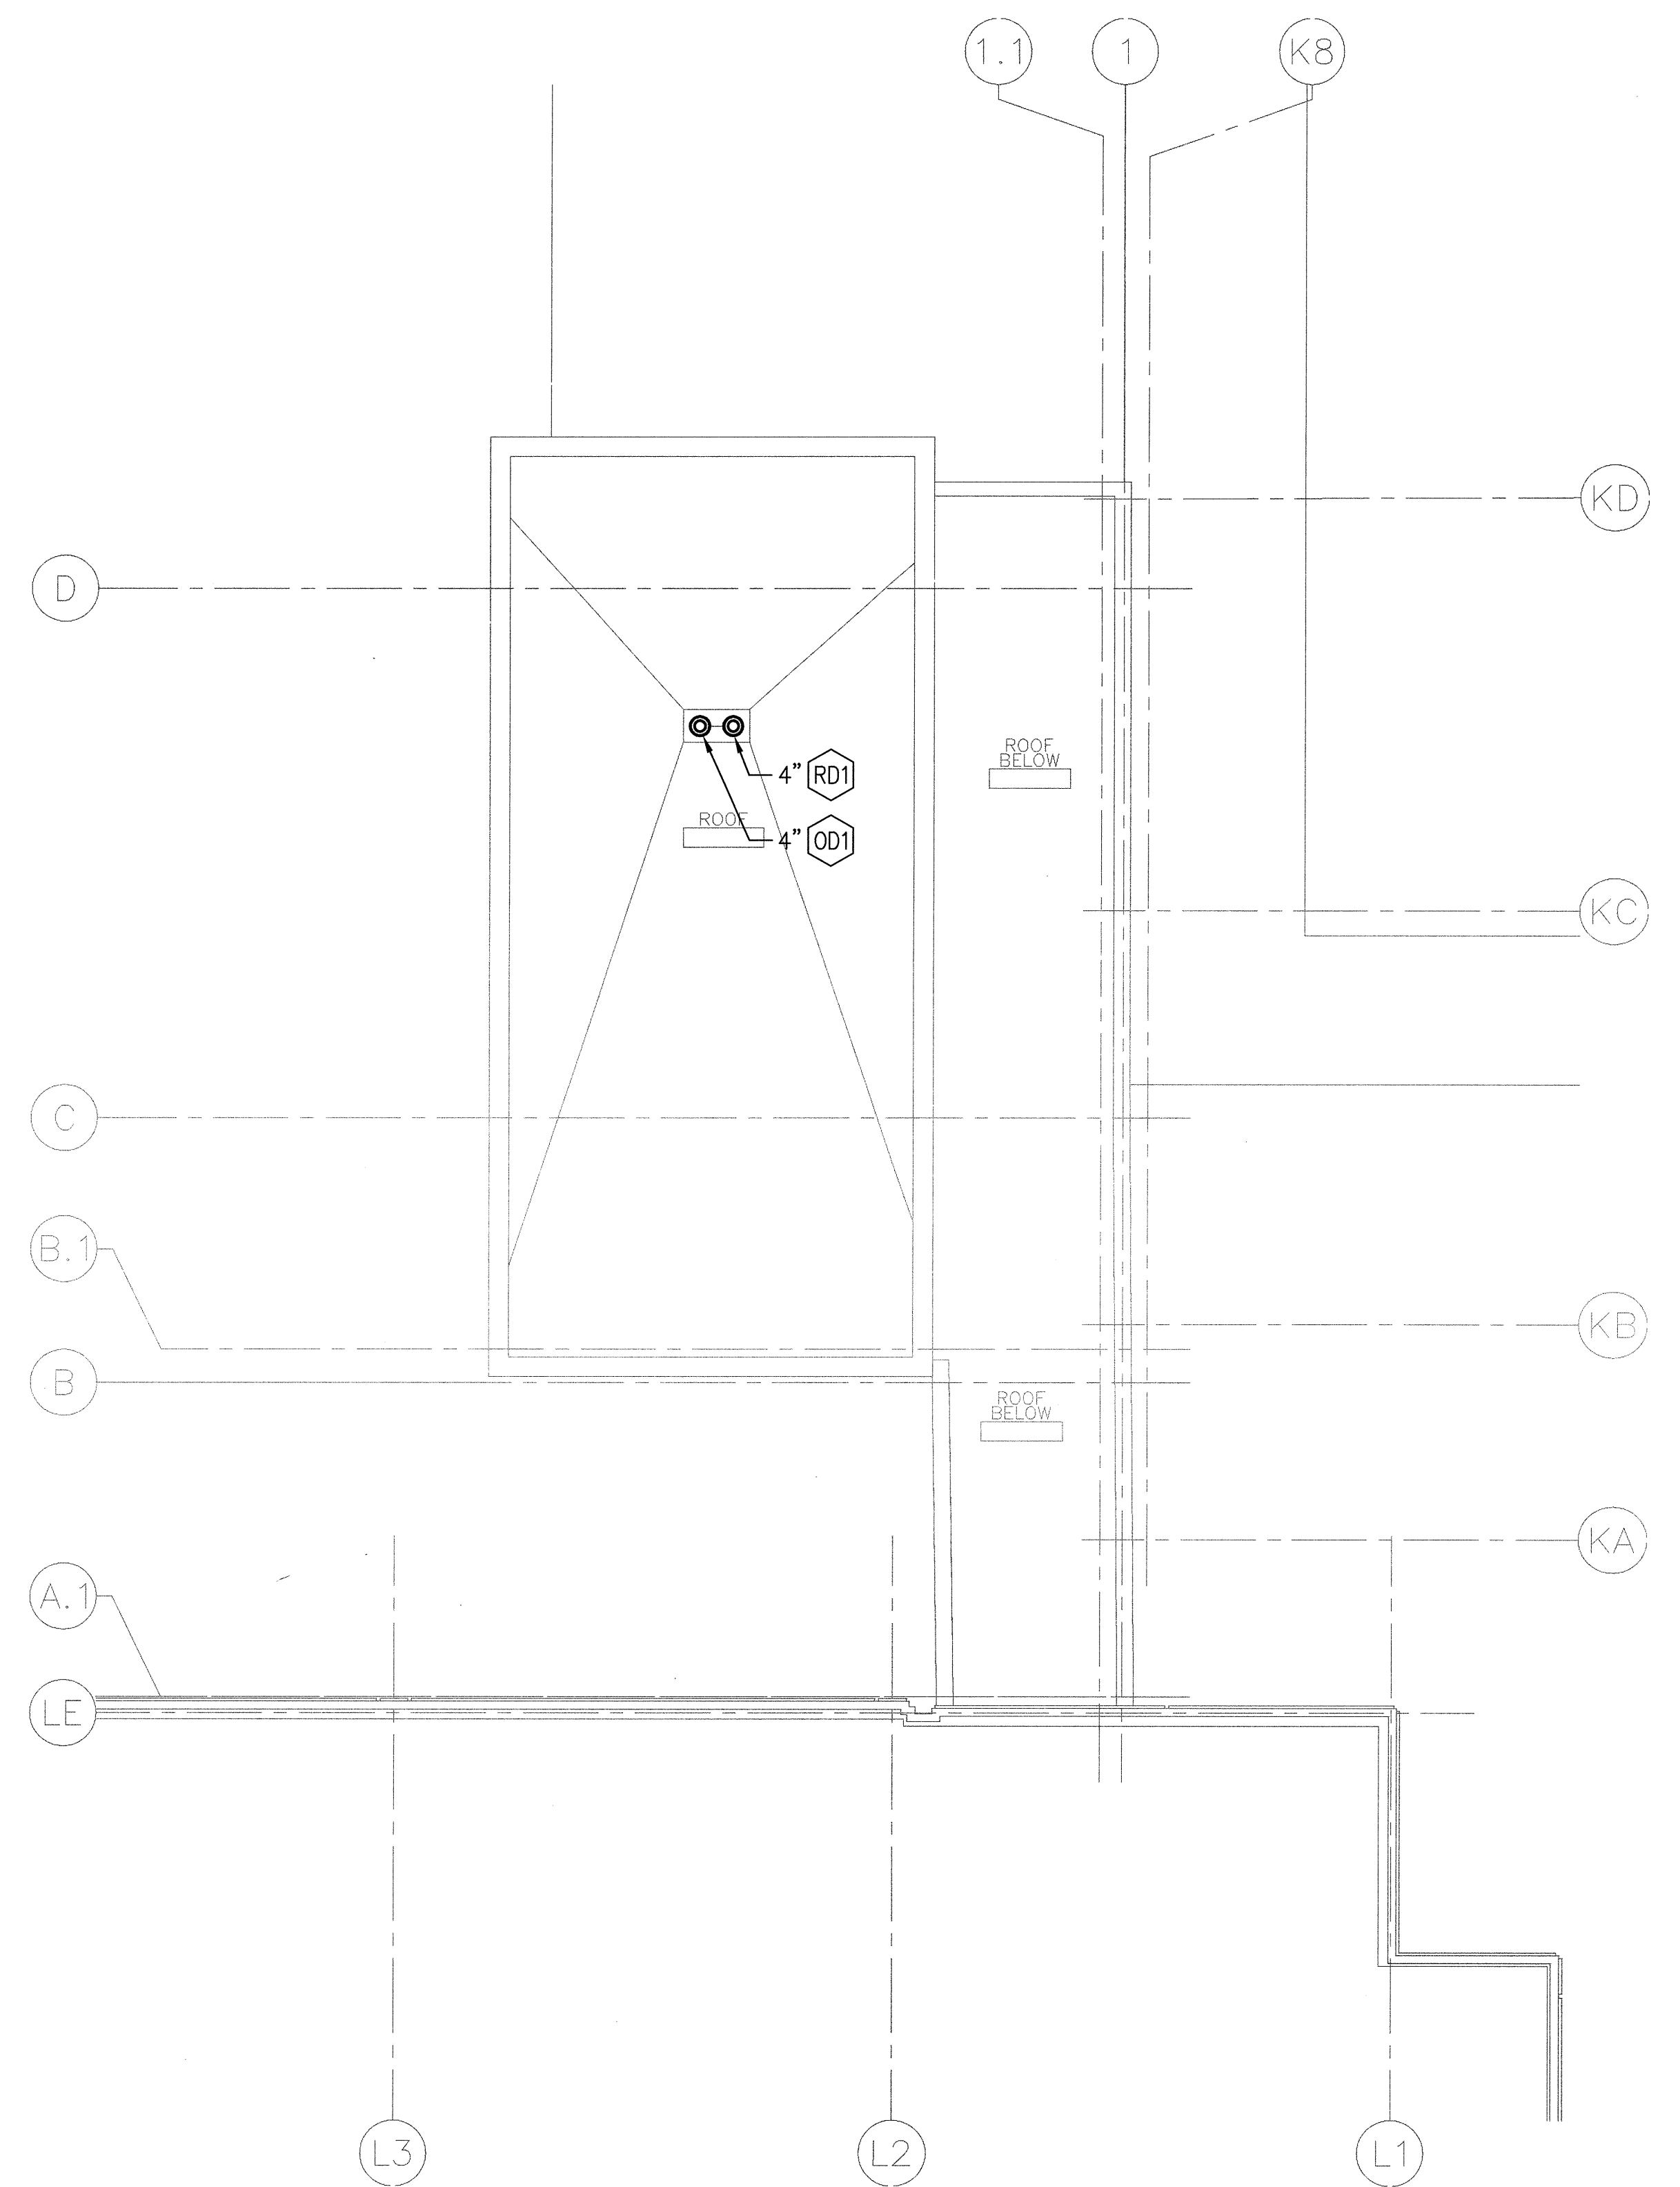

**PARTIAL ROOF PLAN - PLUMBING**  
SCALE: 1/8"=1'-0"

**GENERAL NOTES:**

1. REFER TO M5.19 FOR ADDITIONAL PLUMBING SCOPE OF WORK.

**KEY NOTES:**

- ① 4"RWL AND 4"ORWL DOWN.
- ② 4"RWL AND 4"ORWL UP.
- ③ 3" UP TO RD1.
- ④ 3" UP TO OD1.
- ⑤ 4" UP TO RD1.
- ⑥ 4" UP TO OD1.
- ⑦ PROVIDE AIR GAP FITTING FOR POST HYDRANT DRAIN CONNECTION TO INDIRECT DRAIN FROM AIR CONDITIONING UNIT.

