

1

2

3

4

5

6

7

A

B

C

D

E

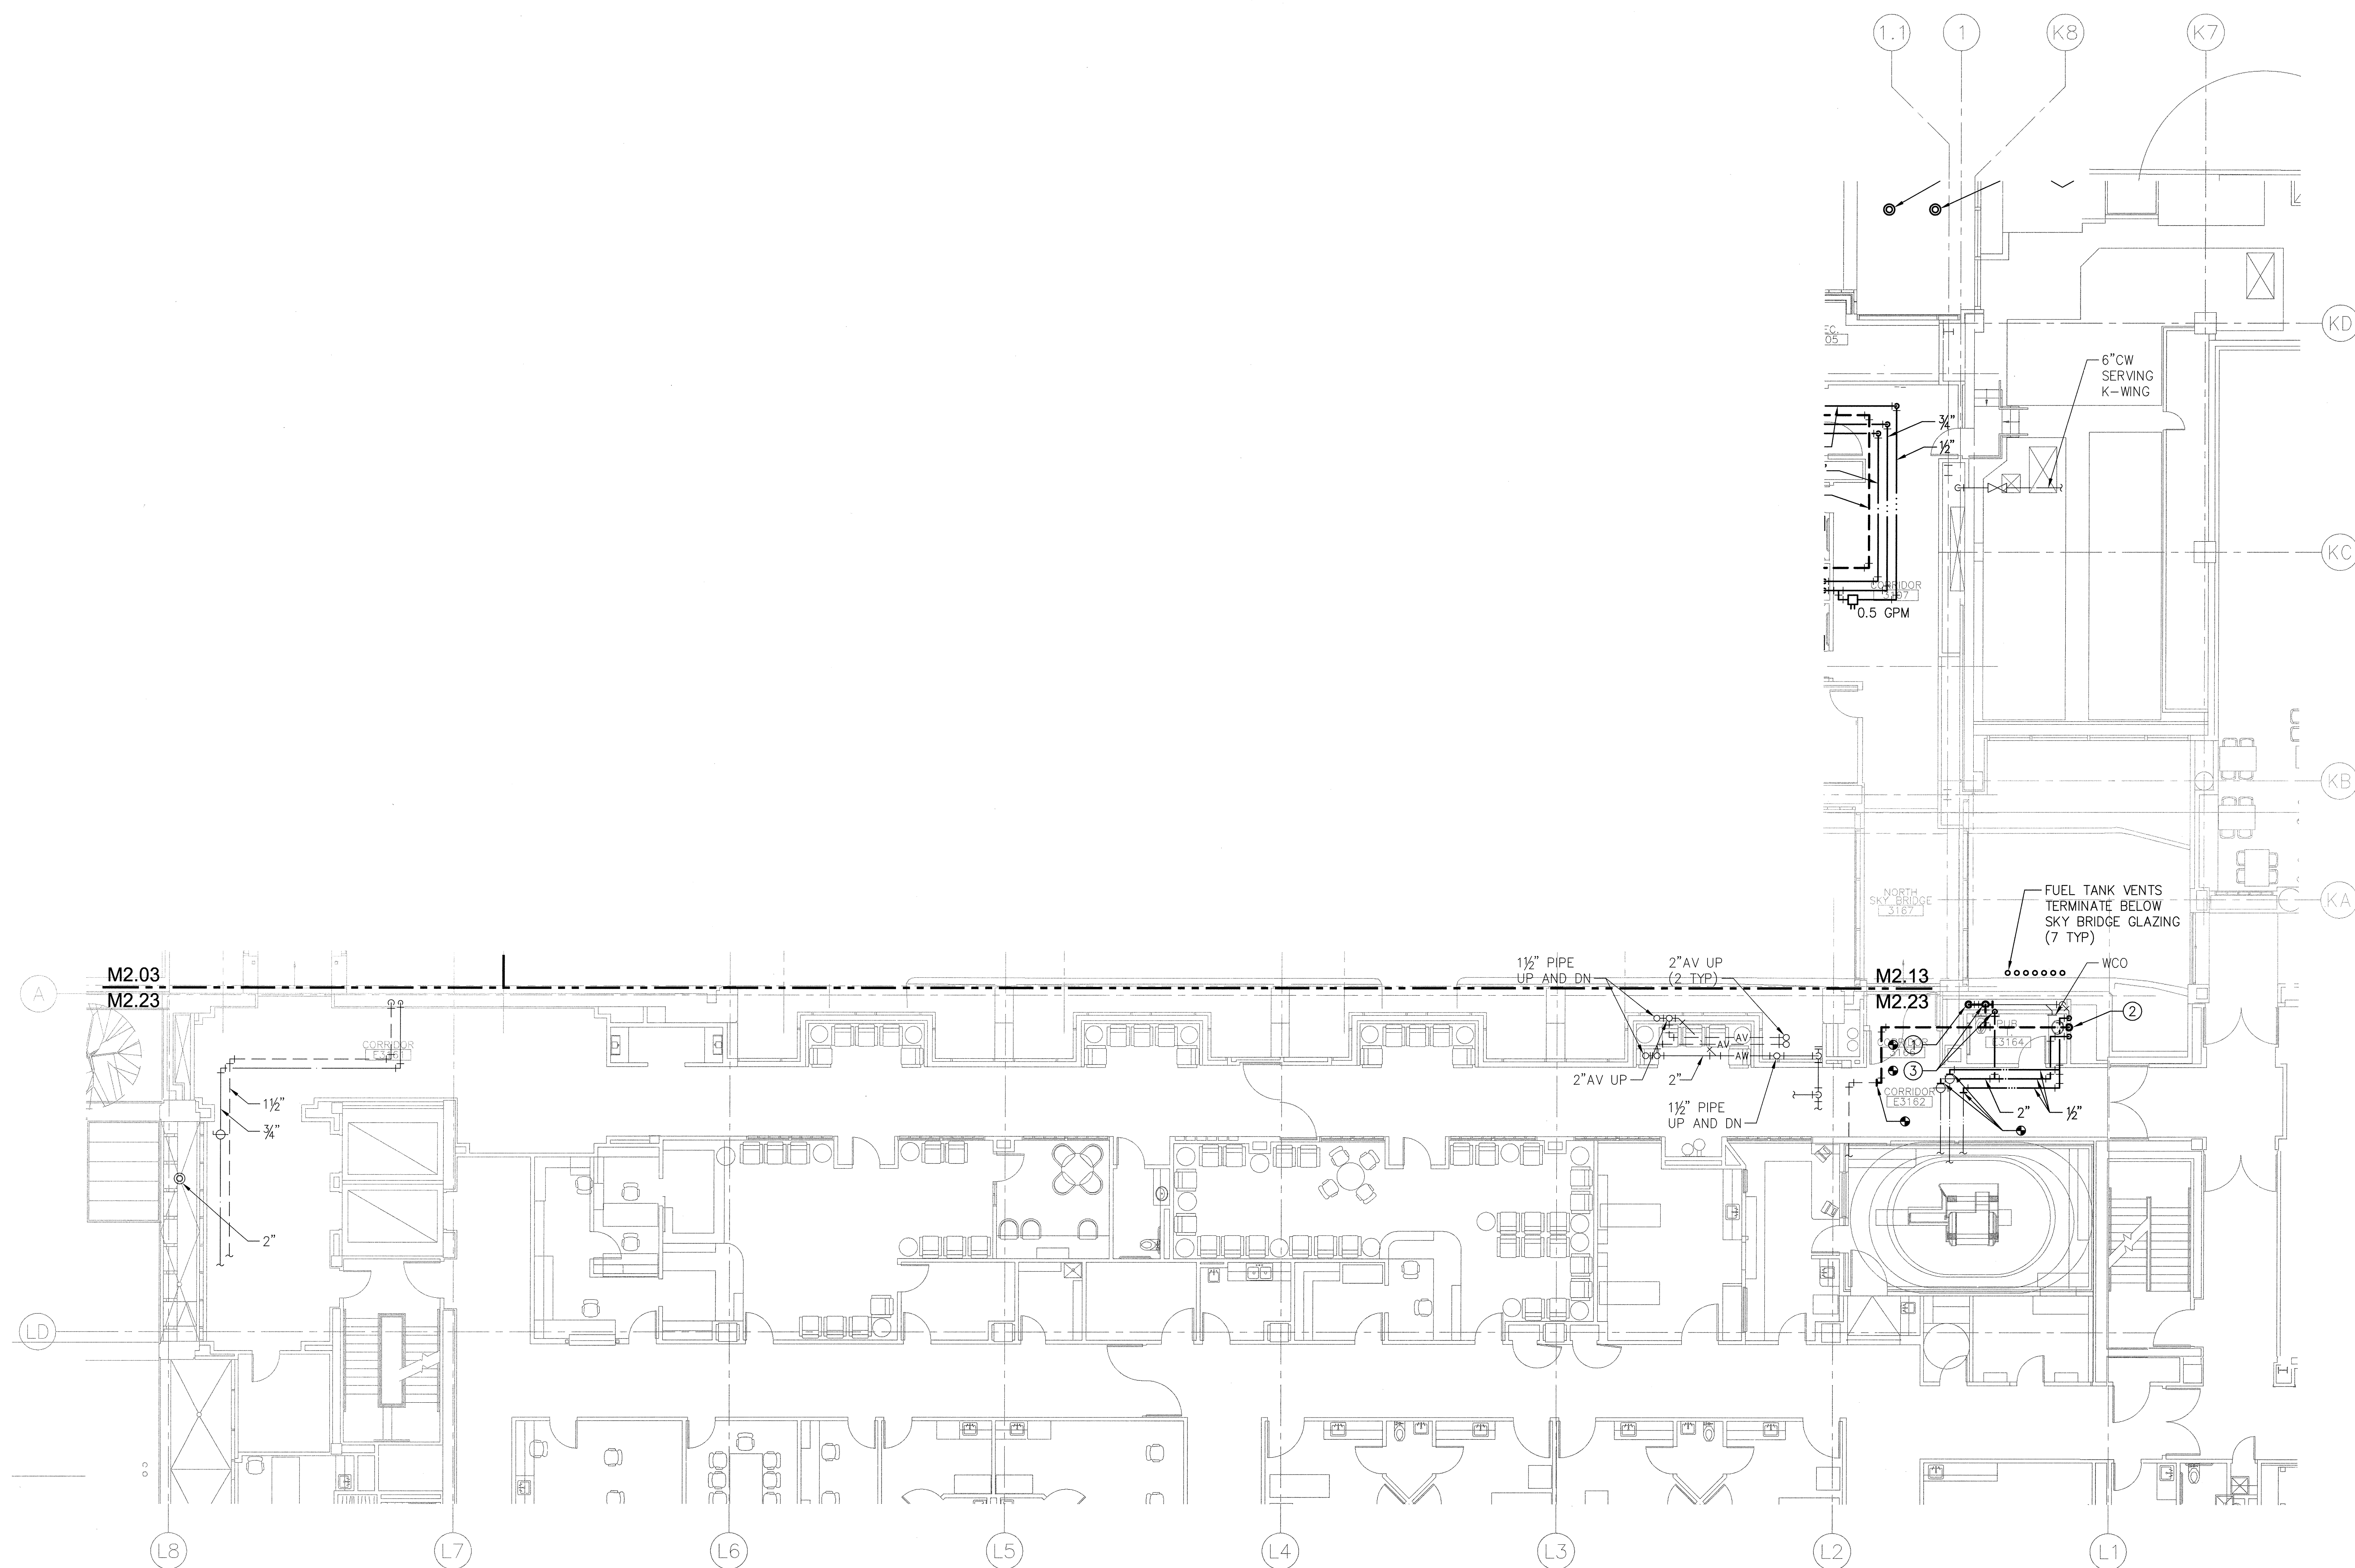
A

B

C

D

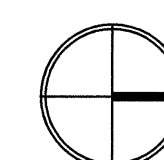
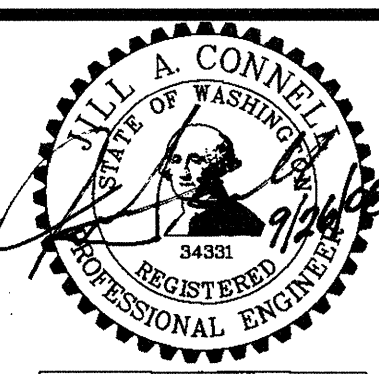
E

**3RD FLOOR PLAN - L & K WING REMODEL - PLUMBING**

SCALE: 1/8"=1'-0"

KEY NOTES:

- ① 4" WASTE DOWN TO SECOND FLOOR.
- ② CONNECT 1/2"HW, 1/2"CW AND 1 1/2"V TO EXISTING RISERS FOR LAVATORY.
- ③ CONNECT 1 1/2"CW AND 2"V TO EXISTING RISERS FOR WATER CLOSET.

**GIFFIN • BOLTE • JURGENS**
ARCHITECTS815 S.W. SECOND AVENUE - PORTLAND, OREGON 97204
(503) 223-0992 www.gbjarch.com FAX (503) 294-3961**CDI ENGINEERS**4200 - 194th St SW, Suite 200
Lynnwood, WA 98036
T 425.872.1071 F 425.778.8769
www.CDIENGINEERS.com**MultiCare****EMERGENCY DEPARTMENT & CANCER CENTER EXPANSION**

TACOMA, WASHINGTON

Date 09-26-2008
Scale 1/8"=1'-0"
Drawn By CDI
Job No. 4034**3RD FLOOR
PLAN - L & K WING
REMODEL -
PLUMBING****M2
23**