
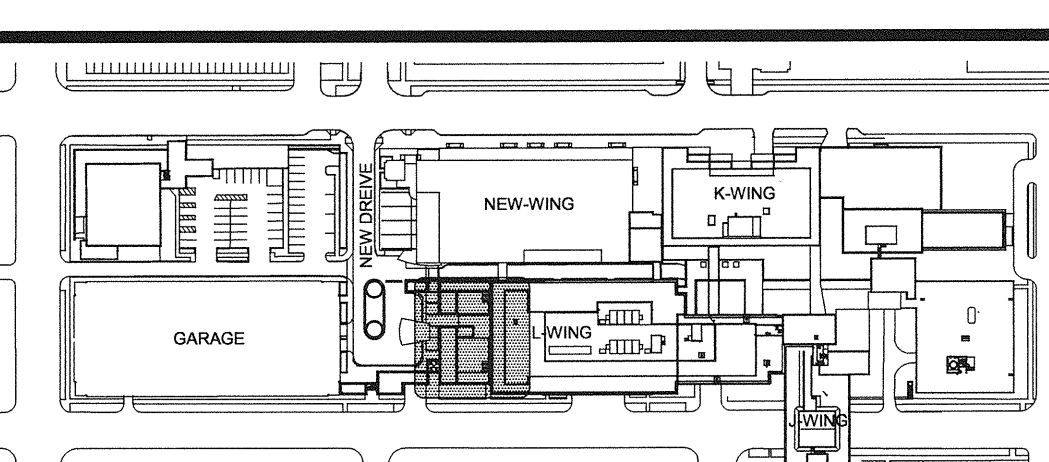



A
B
C
D
E

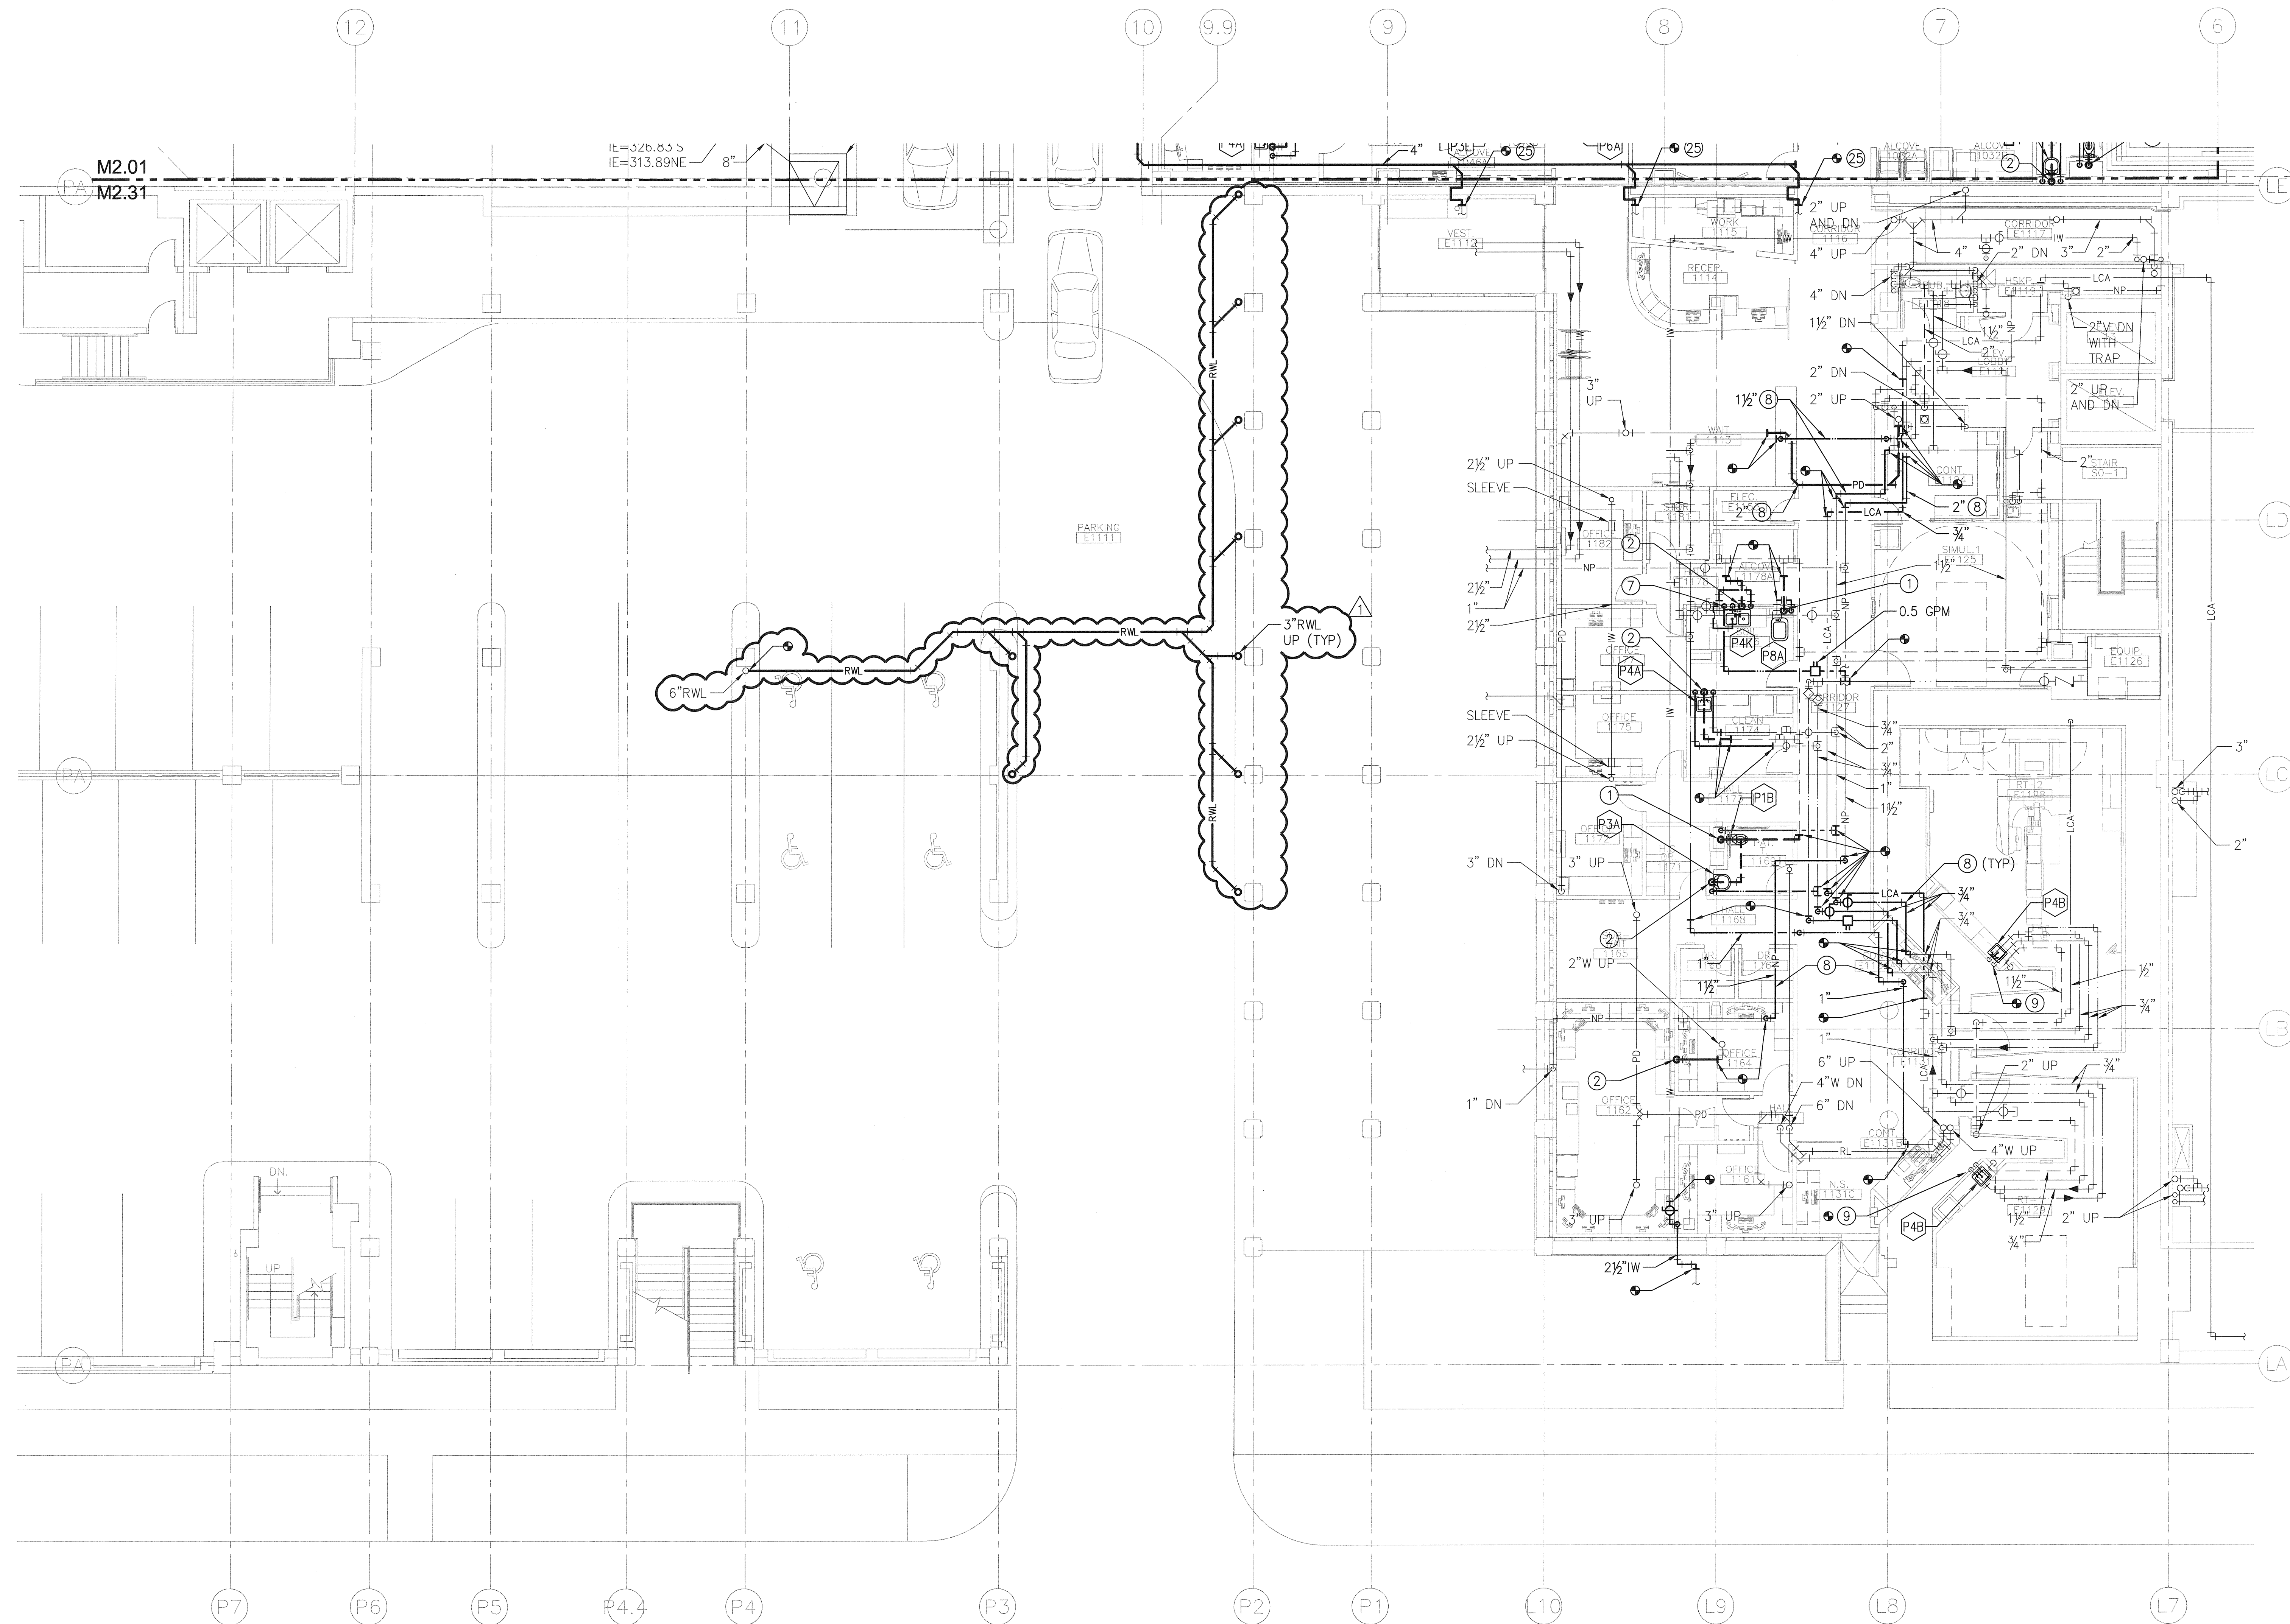

A
B
C
D
E


1ST FLOOR PLAN - L WING & PLAZA REMODEL - PLUMBING
SCALE: 1/8"=1'-0"

- KEY NOTES:**
- ① 4"W DOWN.
 - ② 2"W DOWN.
 - ③ 2"V UP.
 - ④ 4"W UP.
 - ⑤ 2"W UP.
 - ⑥ 2"V UP.
 - ⑦ 1/2"HWC DOWN TO HOT WATER CONNECTION AT MIXING VALVE.
 - ⑧ PIPING REROUTED AROUND OR ABOVE NEW RAISED CEILING IN SKYLIGHT AREA, TYPICAL.
 - ⑨ CONNECT NEW FIXTURE TO EXISTING HOT WATER, COLD WATER, WASTE AND VENT.

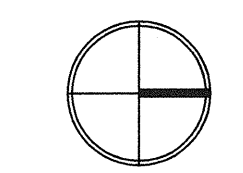

GIFFIN • BOLTE • JURGENS
ARCHITECTS
815 S.W. SECOND AVENUE • PORTLAND, OREGON 97204
(503) 223-0992 www.gbjarch.com FAX (503) 294-3961

CDI ENGINEERS
4200 - 194th St SW, Suite 200
Lynnwood, WA 98036
T 425.672.1071 F 425.778.8769
www.CDIENGINEERS.com

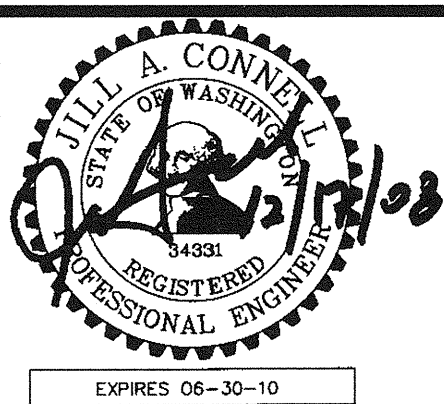

MultiCare
EMERGENCY DEPARTMENT & CANCER CENTER EXPANSION
TACOMA, WASHINGTON

CCD 04	12-17-08

Date 09-26-2008
Scale 1/8"=1'-0"
Drawn By CDI
Job No. 4034

1ST FLOOR
PLAN - L WING &
PLAZA REMODEL -
PLUMBING

M2
31