

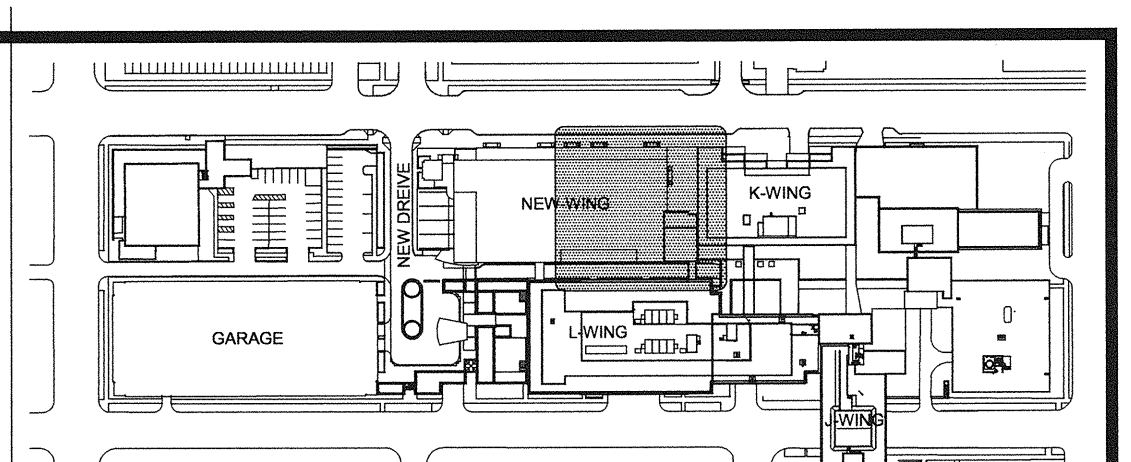


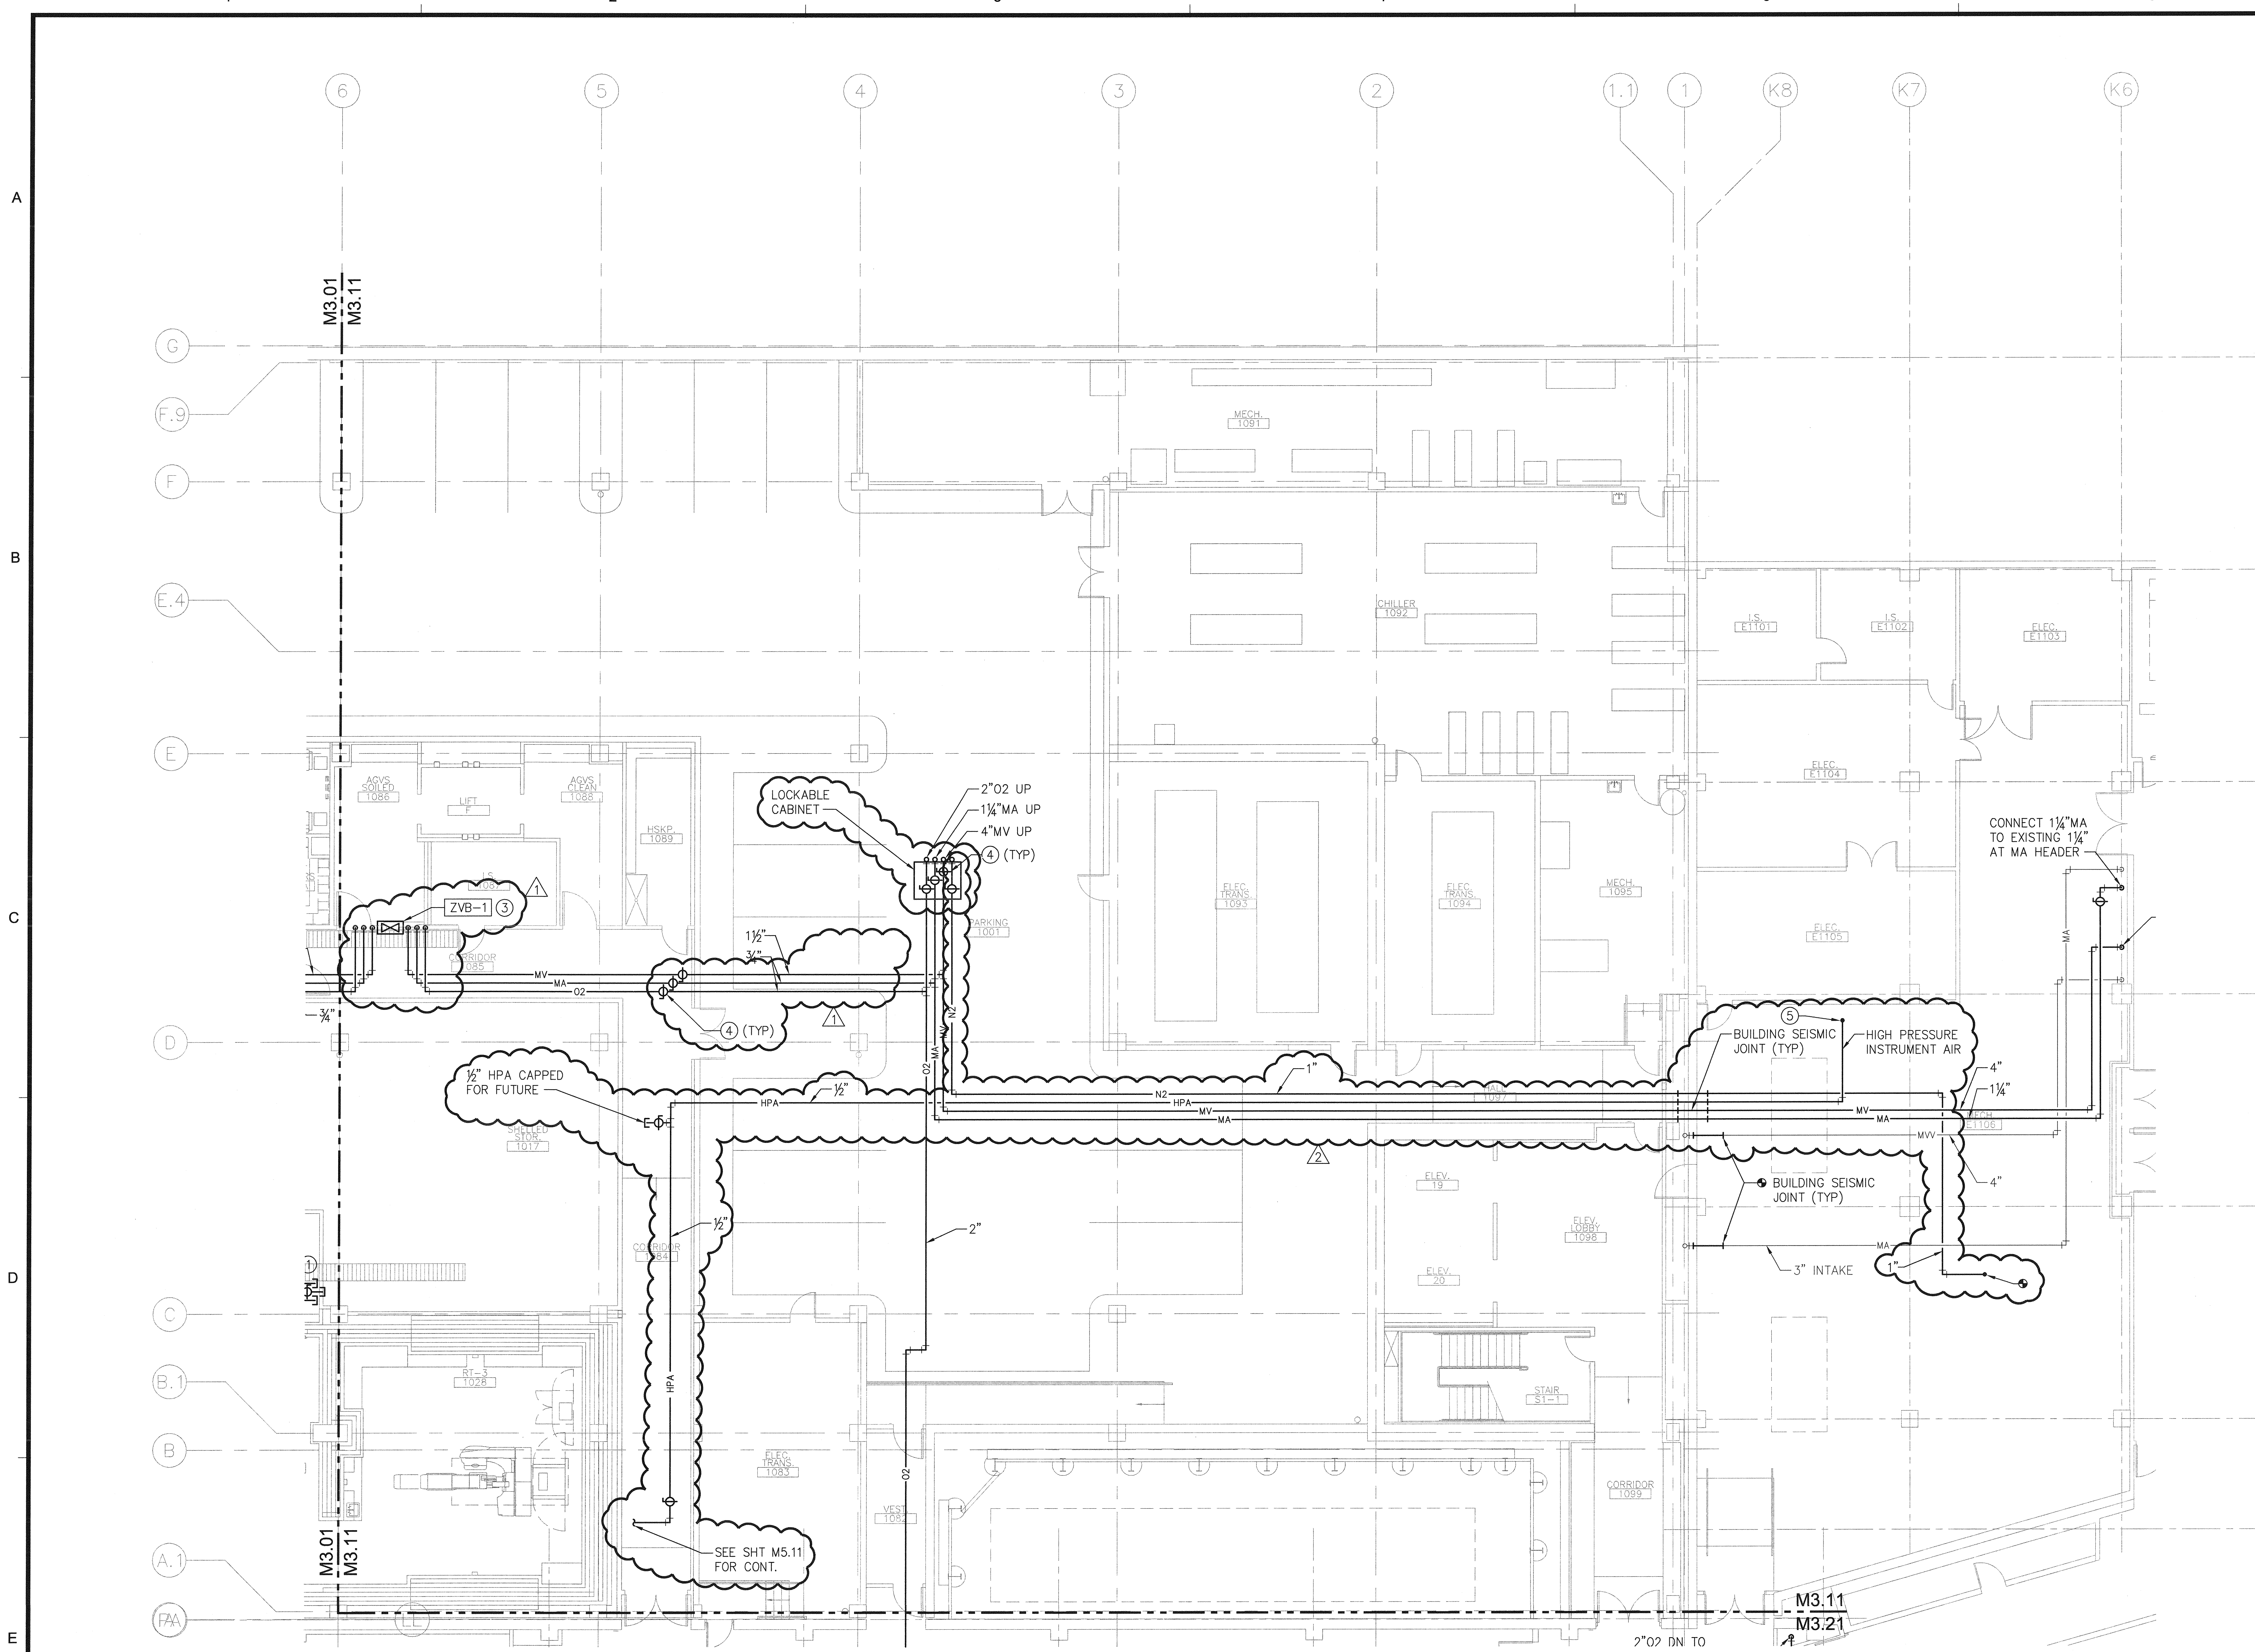

- KEY NOTES:**
- ① 2"O2 TO L-WING MEZZANINE. CONNECT TO EXISTING 4"O2 STUB. PROVIDE 3" VALVE AND CAP FOR FUTURE NEAR TIE-IN.
 - ② EXTEND EXISTING 4"MV HEADER AND PROVIDE 4"MV BRANCH WITH ISOLATION FOR ED.
 - ③ MEDICAL GAS AREA ZONE VALVES.
 - ④ SERVICE VALVES LOCKED OPEN.
 - ⑤ CONNECT 1/2" HIGH PRESSURE INSTRUMENT AIR DOWNSTREAM OF DRYER. PROVIDE AN OIL FILTER AND PRESSURE REGULATOR ABOVE EXISTING HPA MANIFOLD. REGULATE AIR PRESSURE TO 70 PSIG.

1ST FLOOR PLAN - NORTH - MEDICAL GAS PIPING
SCALE: 1/8"=1'-0"

GIFFIN • BOLTE • JURGENS
ARCHITECTS
815 S.W. SECOND AVENUE • PORTLAND, OREGON 97204
(503) 223-0992 www.gbjarch.com FAX (503) 294-3961

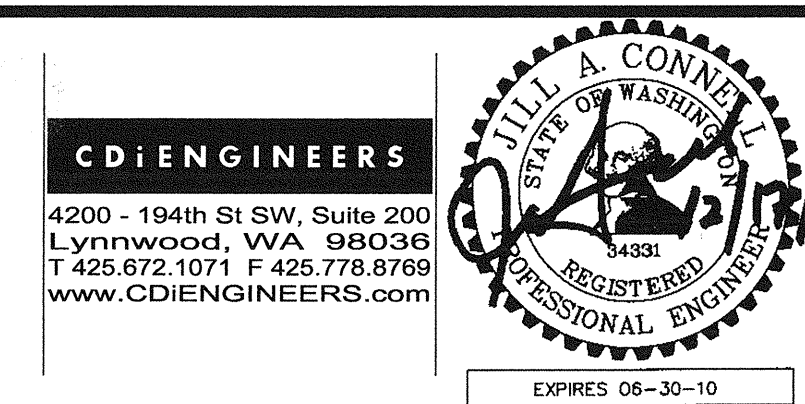

MultiCare
EMERGENCY DEPARTMENT & CANCER CENTER EXPANSION
TACOMA, WASHINGTON

CCD 04 (RFI 0314)	12-17-08
CCD 04	12-17-08

Date 09-26-2008
Scale 1/8"=1'-0"
Drawn By CDI
Job No. 4034

**1ST FLOOR
PLAN - NORTH -
MEDICAL GAS PIPING**

**M3
11**