




2ND FLOOR PLAN - NORTH - MEDICAL GAS PIPING
SCALE: 1/8"=1'-0"

- GENERAL NOTES:**
1. REFER TO ARCHITECTURAL ROOM ELEVATION DRAWINGS FOR EXACT LOCATION, ELEVATION ORDER OF MEDICAL GAS OUTLETS.

- KEY NOTES:**
- ① ISOLATION VALVES IN CEILING SPACE, LOCK OPEN, TYPICAL.
 - ② MEDICAL GAS AREA ZONE VALVES.
 - ③ 1" O₂, 1" MA, AND 3" MV.
 - ④ PROVIDE 1/2" N₂ TO TRAUMA ROOM BOOM. PNEUMATIC BRAKE.

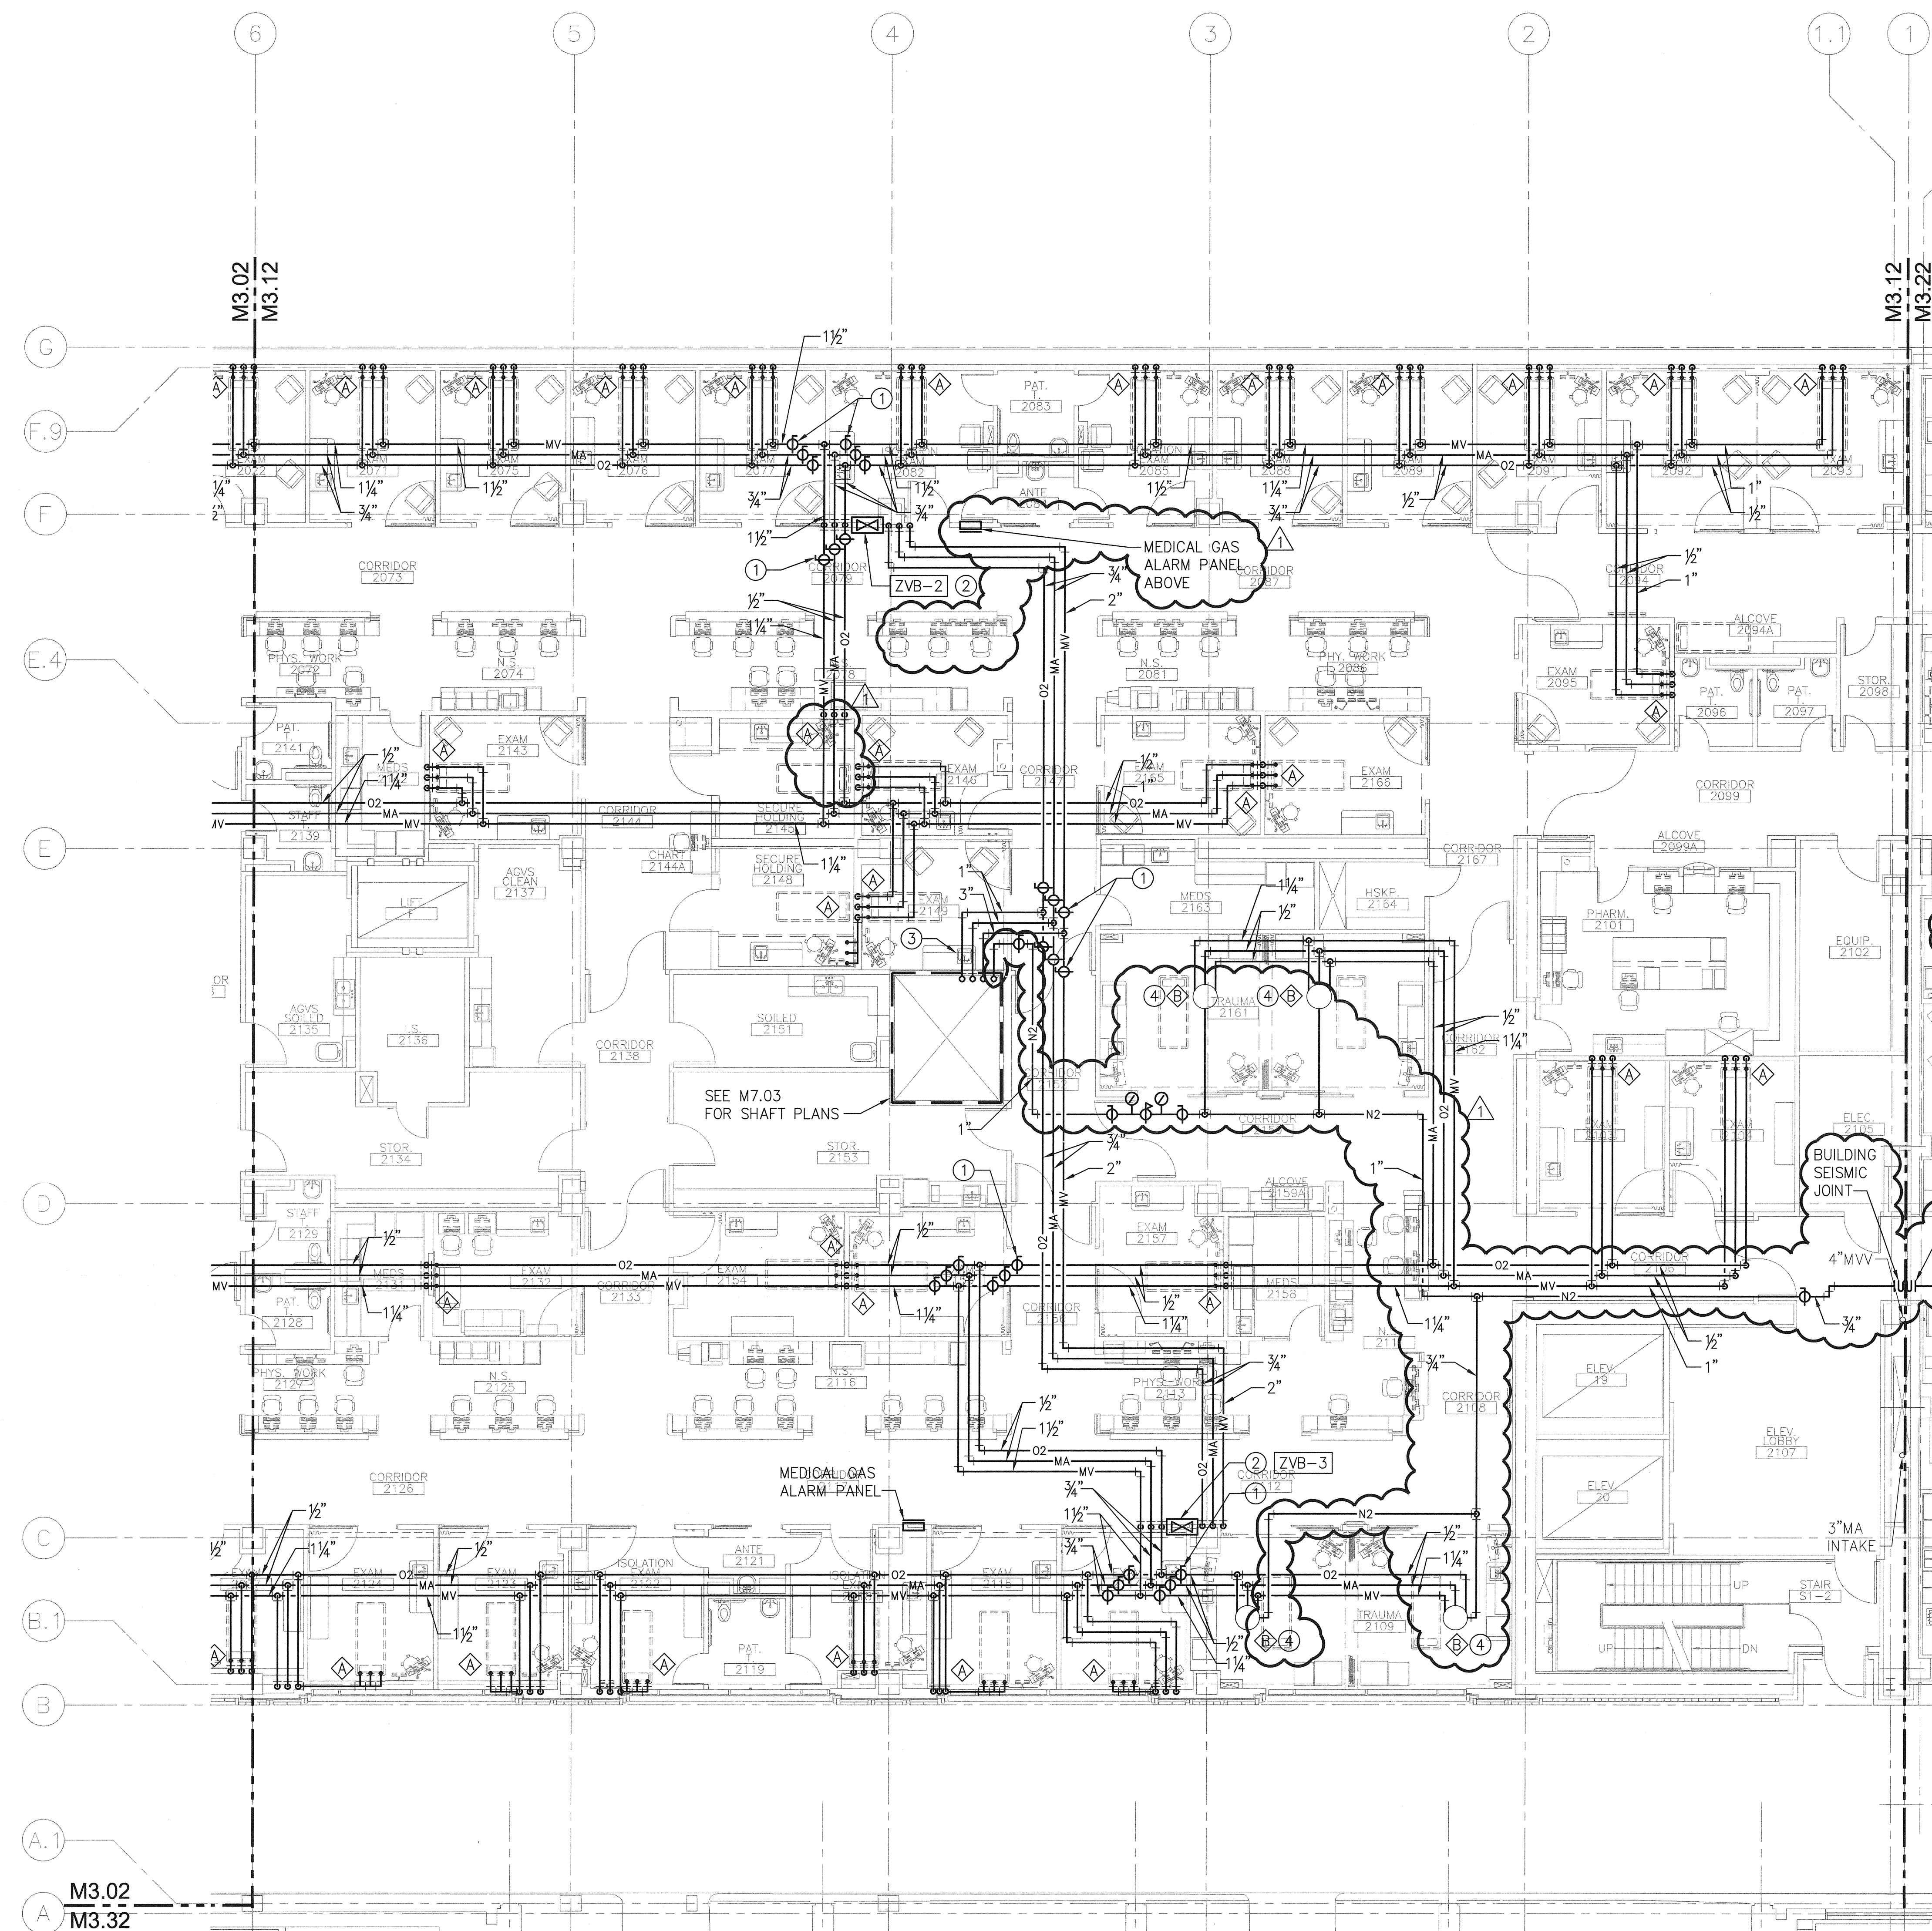