


A
B
C
D
E

A
B
C
D
E

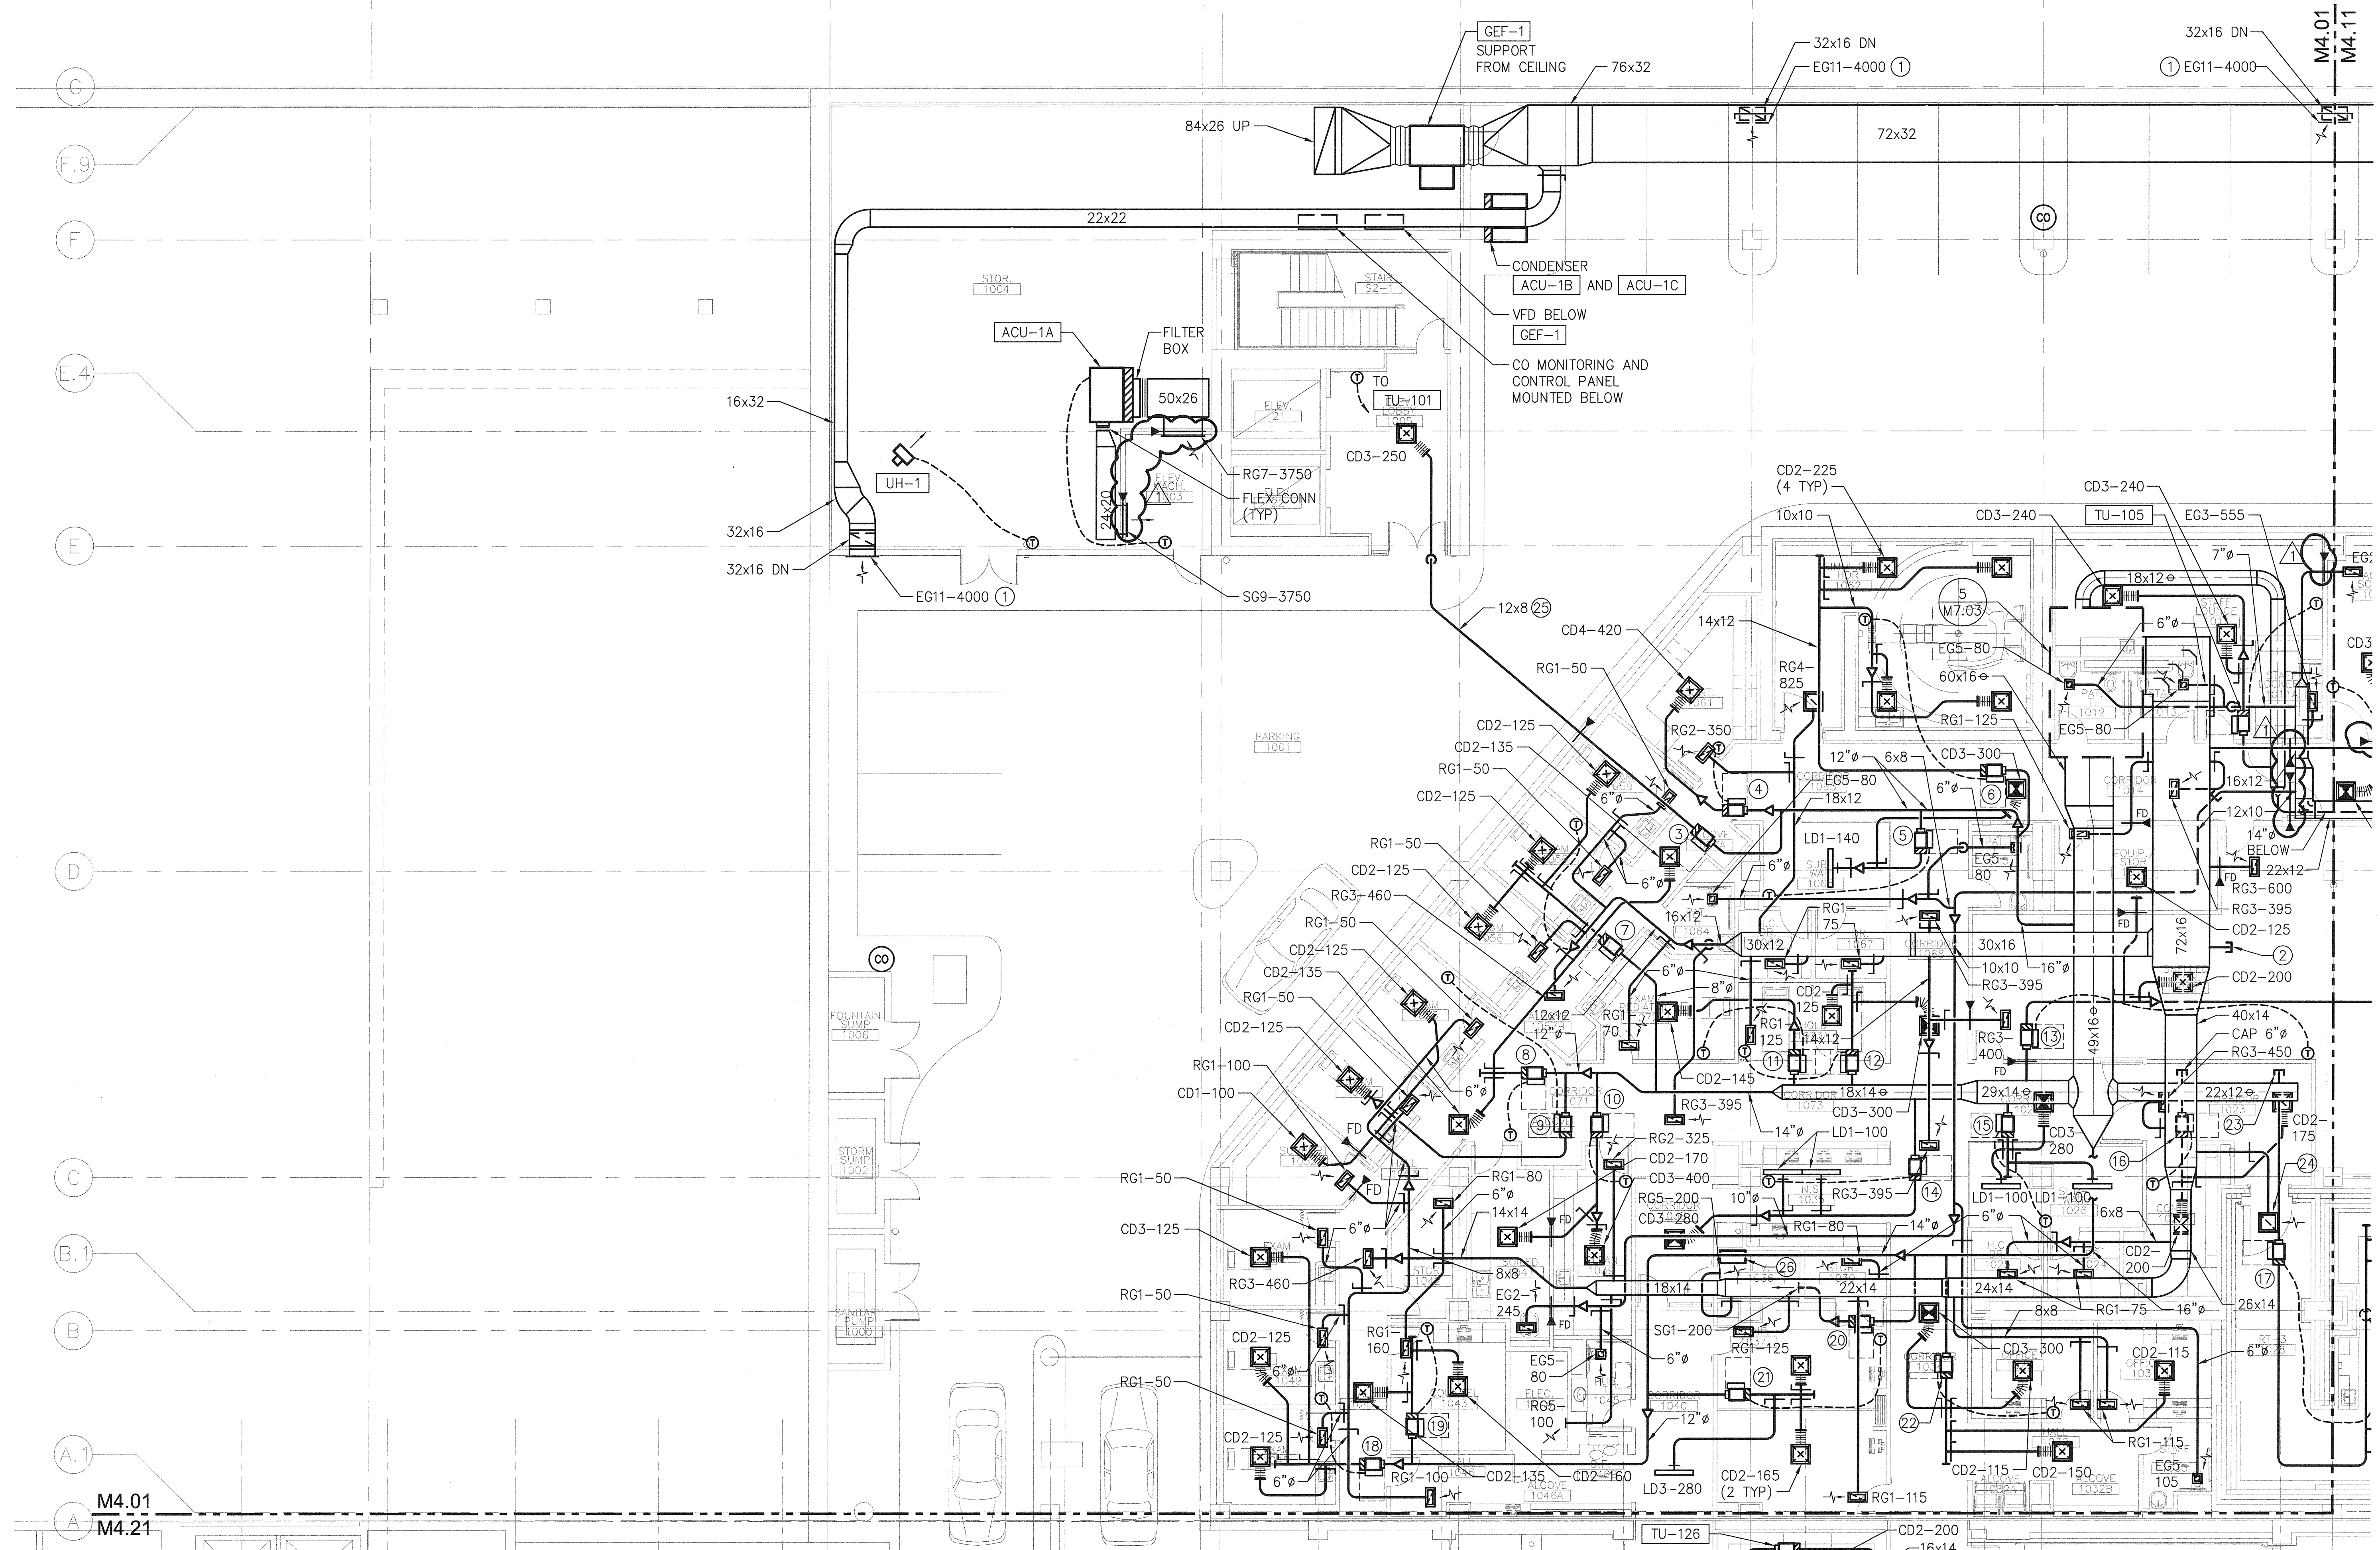

1ST FLOOR PLAN - SOUTH - HVAC
SCALE: 1/8"=1'-0"

- KEY NOTES:**
- ① GRILLE AT 6" ABOVE FINISHED FLOOR.
 - ② CAP 14"Ø FOR FUTURE, 800 CFM.
 - ③ TU-101.
 - ④ TU-102.
 - ⑤ TU-103.
 - ⑥ TU-104.
 - ⑦ TU-109.
 - ⑧ TU-110.
 - ⑨ TU-111.
 - ⑩ TU-112.
 - ⑪ TU-113.
 - ⑫ TU-114.
 - ⑬ TU-115.
 - ⑭ TU-116.
 - ⑮ TU-117.
 - ⑯ TU-118.
 - ⑰ TU-119.
 - ⑱ TU-120.
 - ⑲ TU-121.
 - ⑳ TU-122.
 - ㉑ TU-123.
 - ㉒ TU-124.
 - ㉓ CAP 12"Ø FOR FUTURE.
 - ㉔ RG4-1125.
 - ㉕ MOUNT DUCTWORK TIGHT TO STRUCTURE. INSULATE WITH R-7 INSULATION AND PROVIDE EXTERIOR ALUMINUM JACKET ON EXTERIOR DUCTWORK.
 - ㉖ DDC CONTROL PANEL.