



A
B
C
D
E

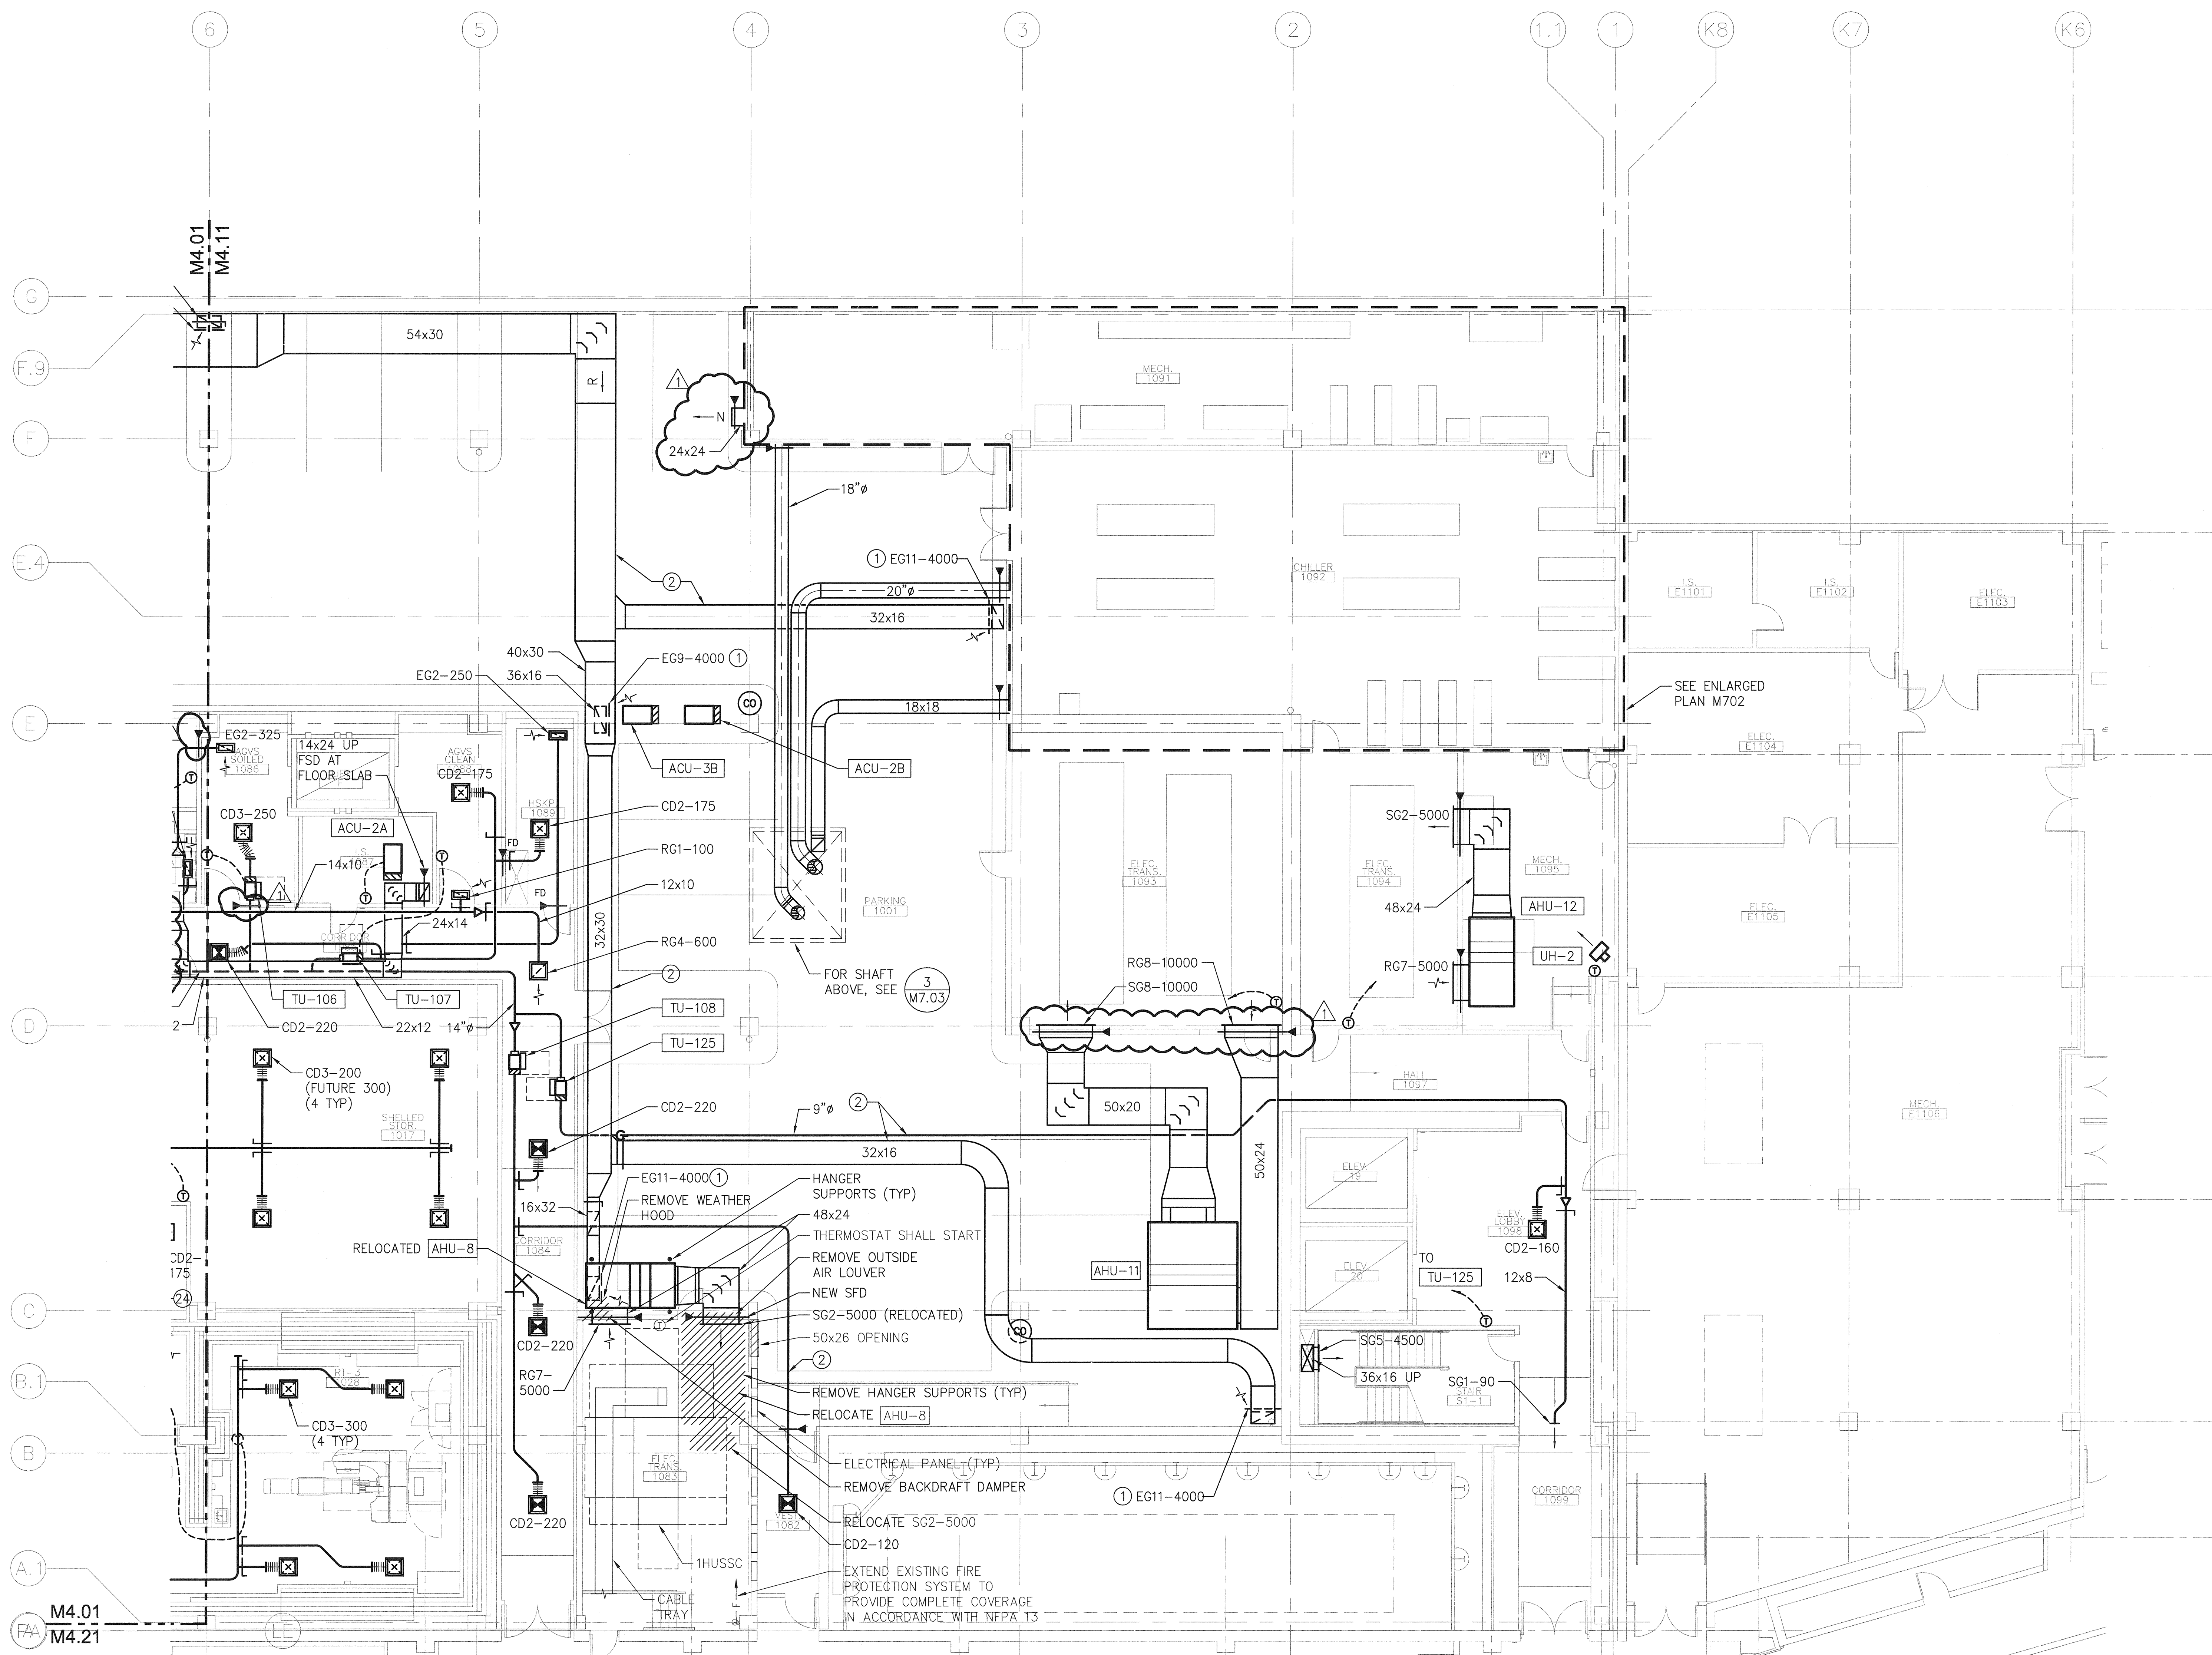


1ST FLOOR PLAN - NORTH - HVAC
SCALE: 1/8"=1'-0"

- KEY NOTES:**
- ① BOTTOM OF GRILLE AT 6" ABOVE FINISHED FLOOR, TYPICAL.
 - ② MOUNT DUCTWORK TIGHT TO STRUCTURE. INSULATE WITH R-7 INSULATION AND PROVIDE AN EXTERIOR ALUMINUM JACKET ON EXTERIOR DUCTWORK.

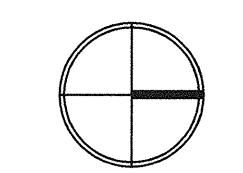

GIFFIN • BOLTE • JURGENS
ARCHITECTS
815 S.W. SECOND AVENUE • PORTLAND, OREGON 97204
(503) 223-0992 www.gbjarch.com FAX (503) 294-3961

CDI ENGINEERS
4200 - 194th St SW, Suite 200
Lynnwood, WA 98036
T 425-672-1071 F 425-778-8769
www.CDIENGINEERS.com

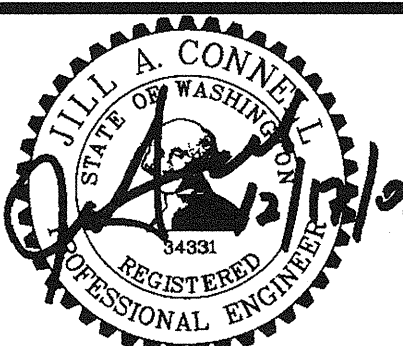

MultiCare
EMERGENCY DEPARTMENT & CANCER CENTER EXPANSION
TACOMA, WASHINGTON

△ CCD 04 (RFI 0250)	12-17-08		

Date 09-26-2008
Scale 1/8"=1'-0"
Drawn By CDI
Job No. 4034

1ST FLOOR
PLAN - NORTH -
HVAC

M4
11