


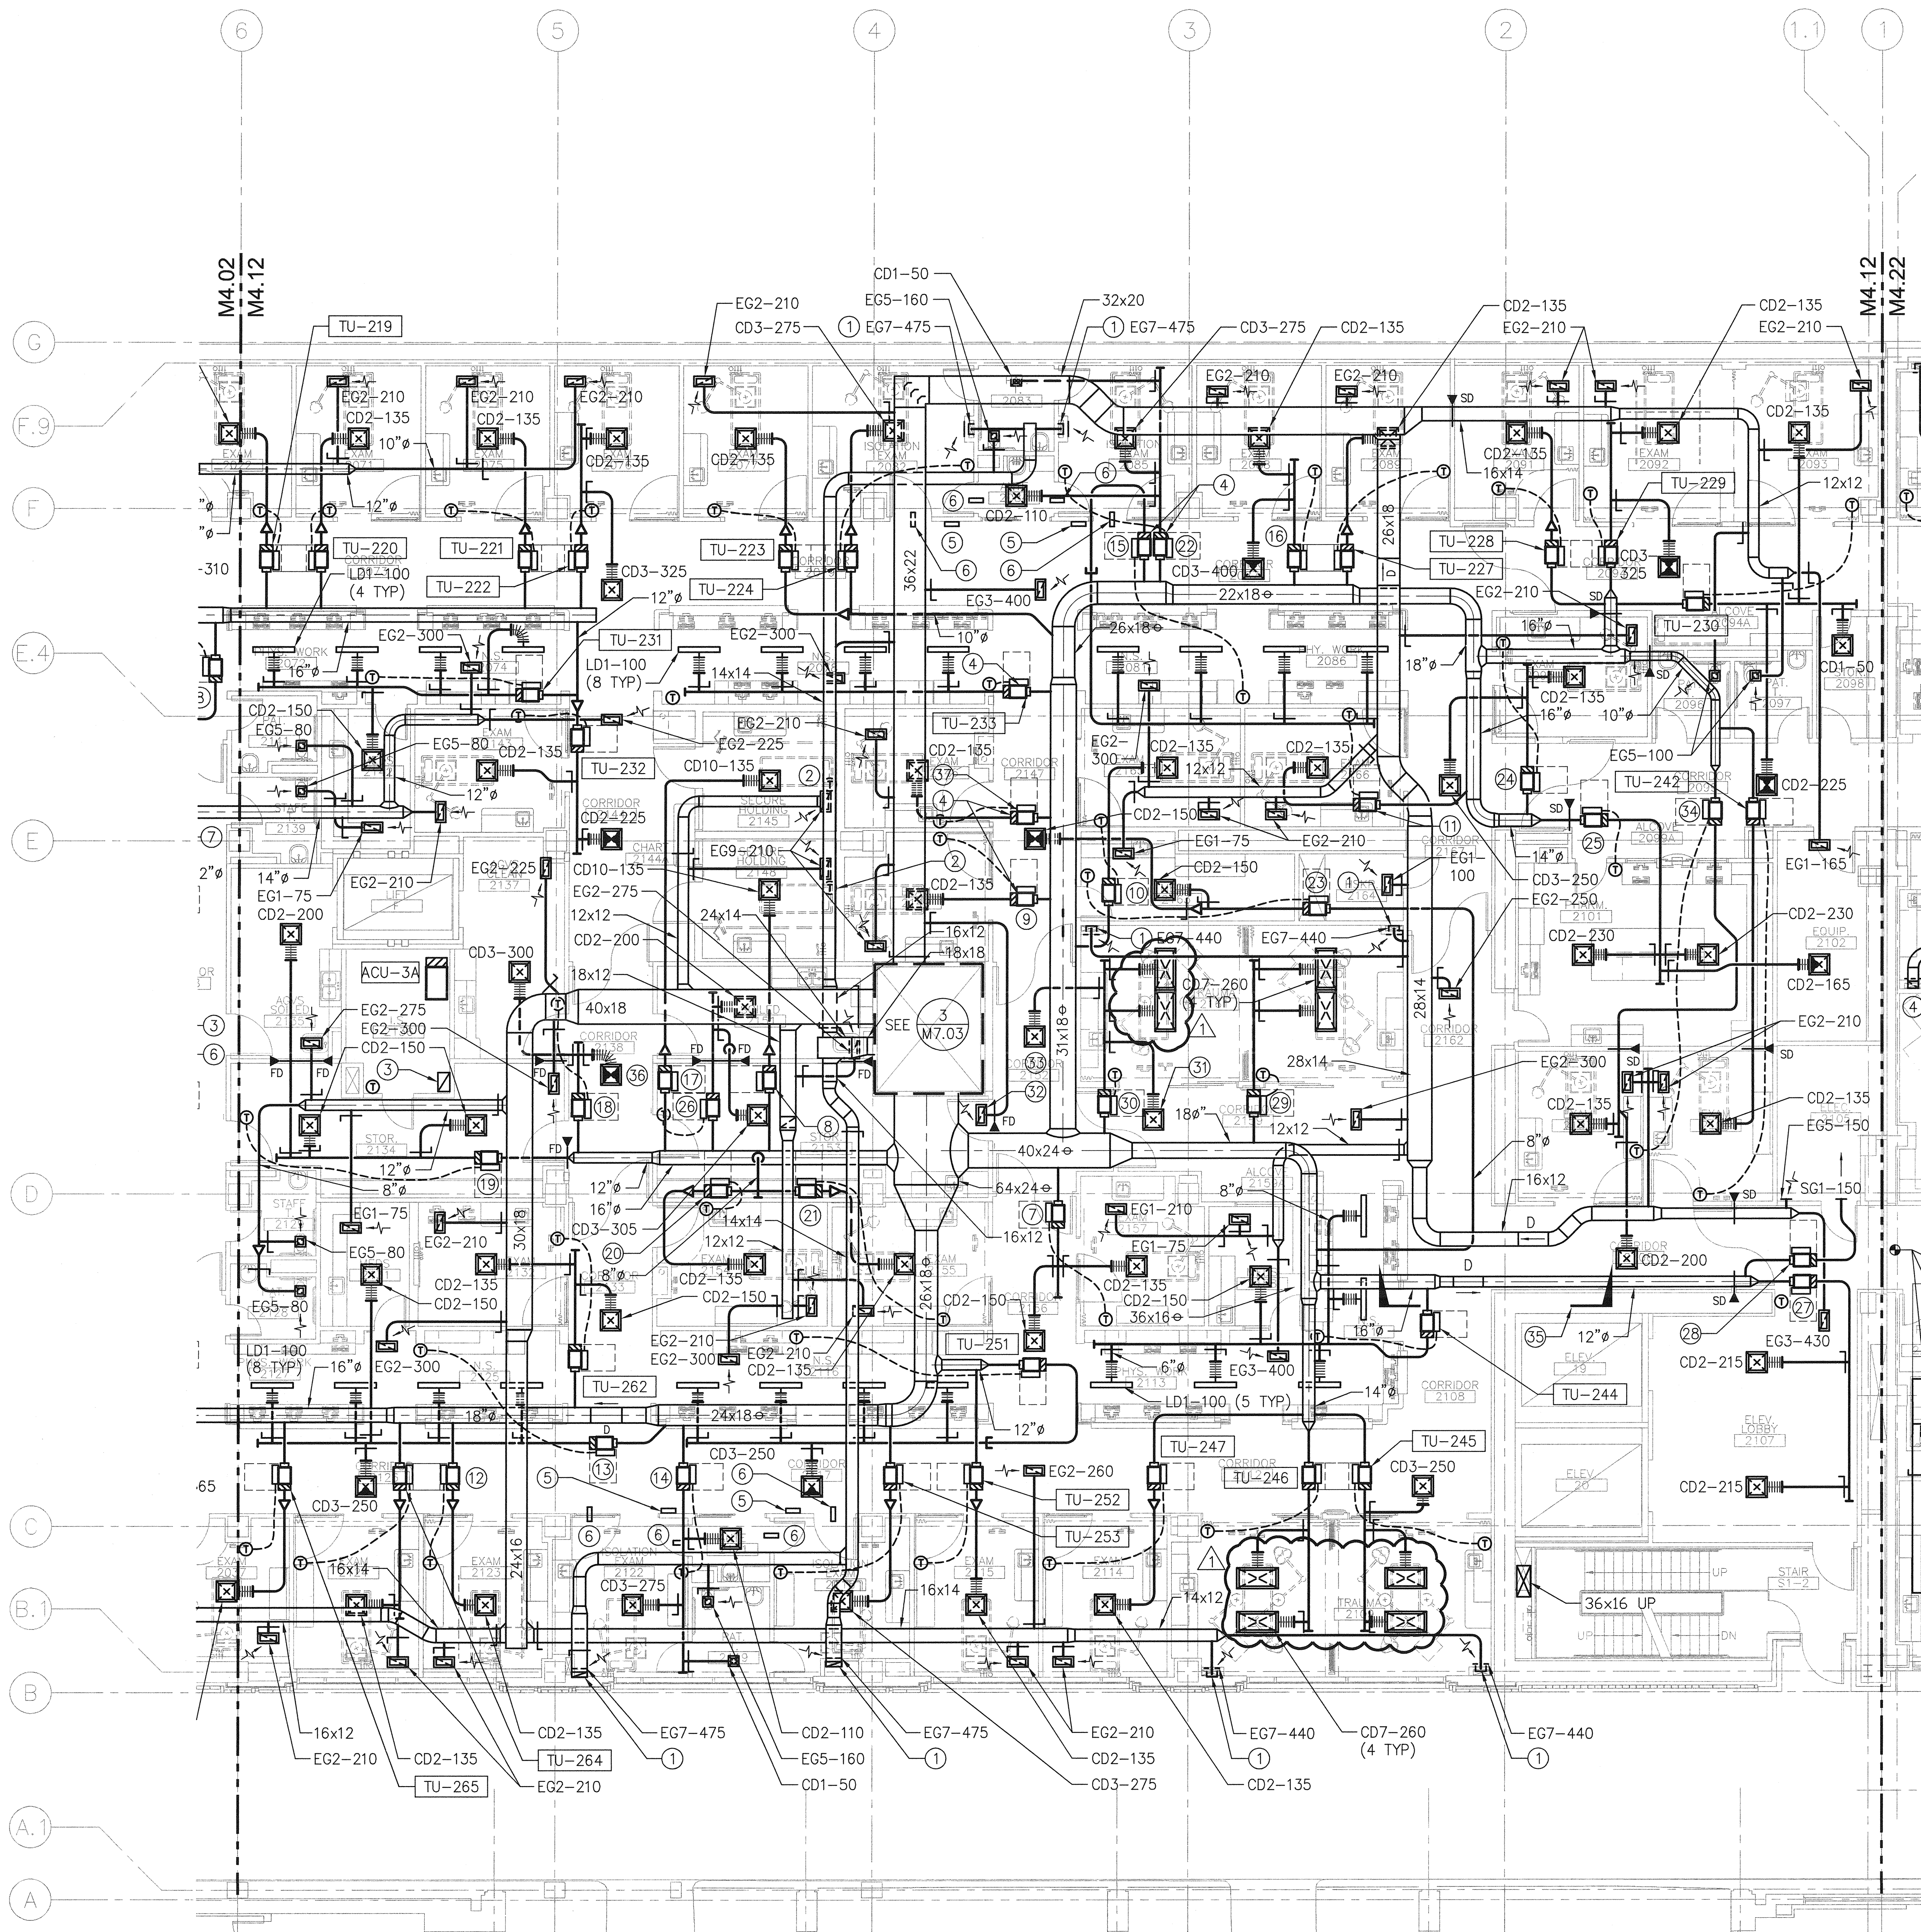

2ND FLOOR PLAN - NORTH - HVAC

SCALE: 1/8"=1'-0"

KEY NOTES:


- 1 18x6 EXHAUST DUCT DOWN IN CHASE. LOCATE GRILLE AT 6" ABOVE FINISHED FLOOR AND PROVIDE VOLUME DAMPER AT GRILLE.
- 2 MOUNT TEMPERATURE SENSOR IN EXHAUST DUCT BEHIND SECURITY GRILLE.
- 3 24x14 EXHAUST DUCT UP AND DOWN.
- 4 10" CONNECTION TO BIOSAFETY CABINET. DIRECT CONNECT DUCT TO THE CABINET. BALANCE TO 360 CFM EXHAUST.
- 5 ISOLATION ROOM PRESSURE MONITOR. SEE CONTROL DIAGRAMS.
- 6 ISOLATION ROOM PRESSURE SENSOR.
- 7 TU-250.
- 8 TU-257.
- 9 TU-238.
- 10 TU-235.
- 11 TU-236.
- 12 TU-263.
- 13 TU-290.
- 14 TU-254.
- 15 TU-289.
- 16 TU-226.
- 17 TU-259.
- 18 TU-260.
- 19 TU-261.
- 20 TU-256.
- 21 TU-255.
- 22 TU-225.
- 23 TU-237.
- 24 TU-239.
- 25 TU-240.
- 26 TU-258.
- 27 TU-291.
- 28 TU-243.
- 29 TU-248.
- 30 TU-249.
- 31 CD2-150.
- 32 EG2-305.
- 33 CD2-175.
- 34 TU-241.
- 35 SEE SECTION F ON M8.02.
- 36 CD2-170.
- 37 TU-234.

GIFFIN • BOLTE • JURGENS
ARCHITECTS

815 S.W. SECOND AVENUE • PORTLAND, OREGON 97204
(503) 223-0992 www.gbjarch.com FAX (503) 294-3961

CDI ENGINEERS

4200 - 194th St SW, Suite 200
Lynnwood, WA 98036
T 425-672-1071 F 425-778-8769
www.CDIENGINEERS.com

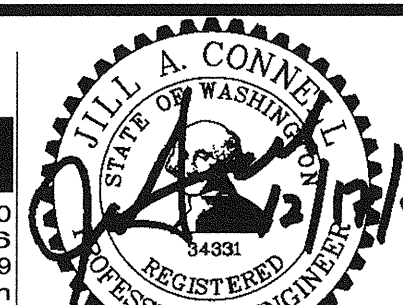

EXPIRES 06-30-10

MultiCare

EMERGENCY DEPARTMENT & CANCER CENTER EXPANSION

TACOMA, WASHINGTON

CCD 04

12-17-08

Date 09-26-2008
Scale 1/8"=1'-0"
Drawn By CDI
Job No. 4034

2ND FLOOR
PLAN - NORTH -
HVAC

M4
12