
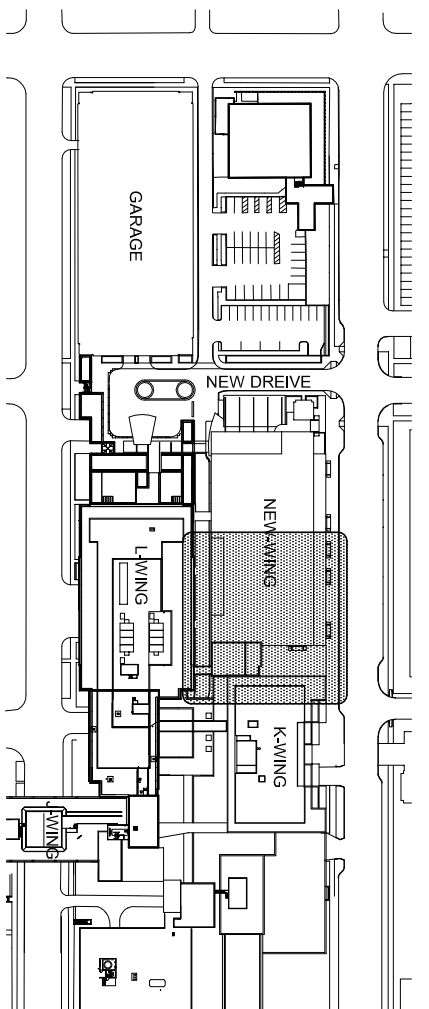


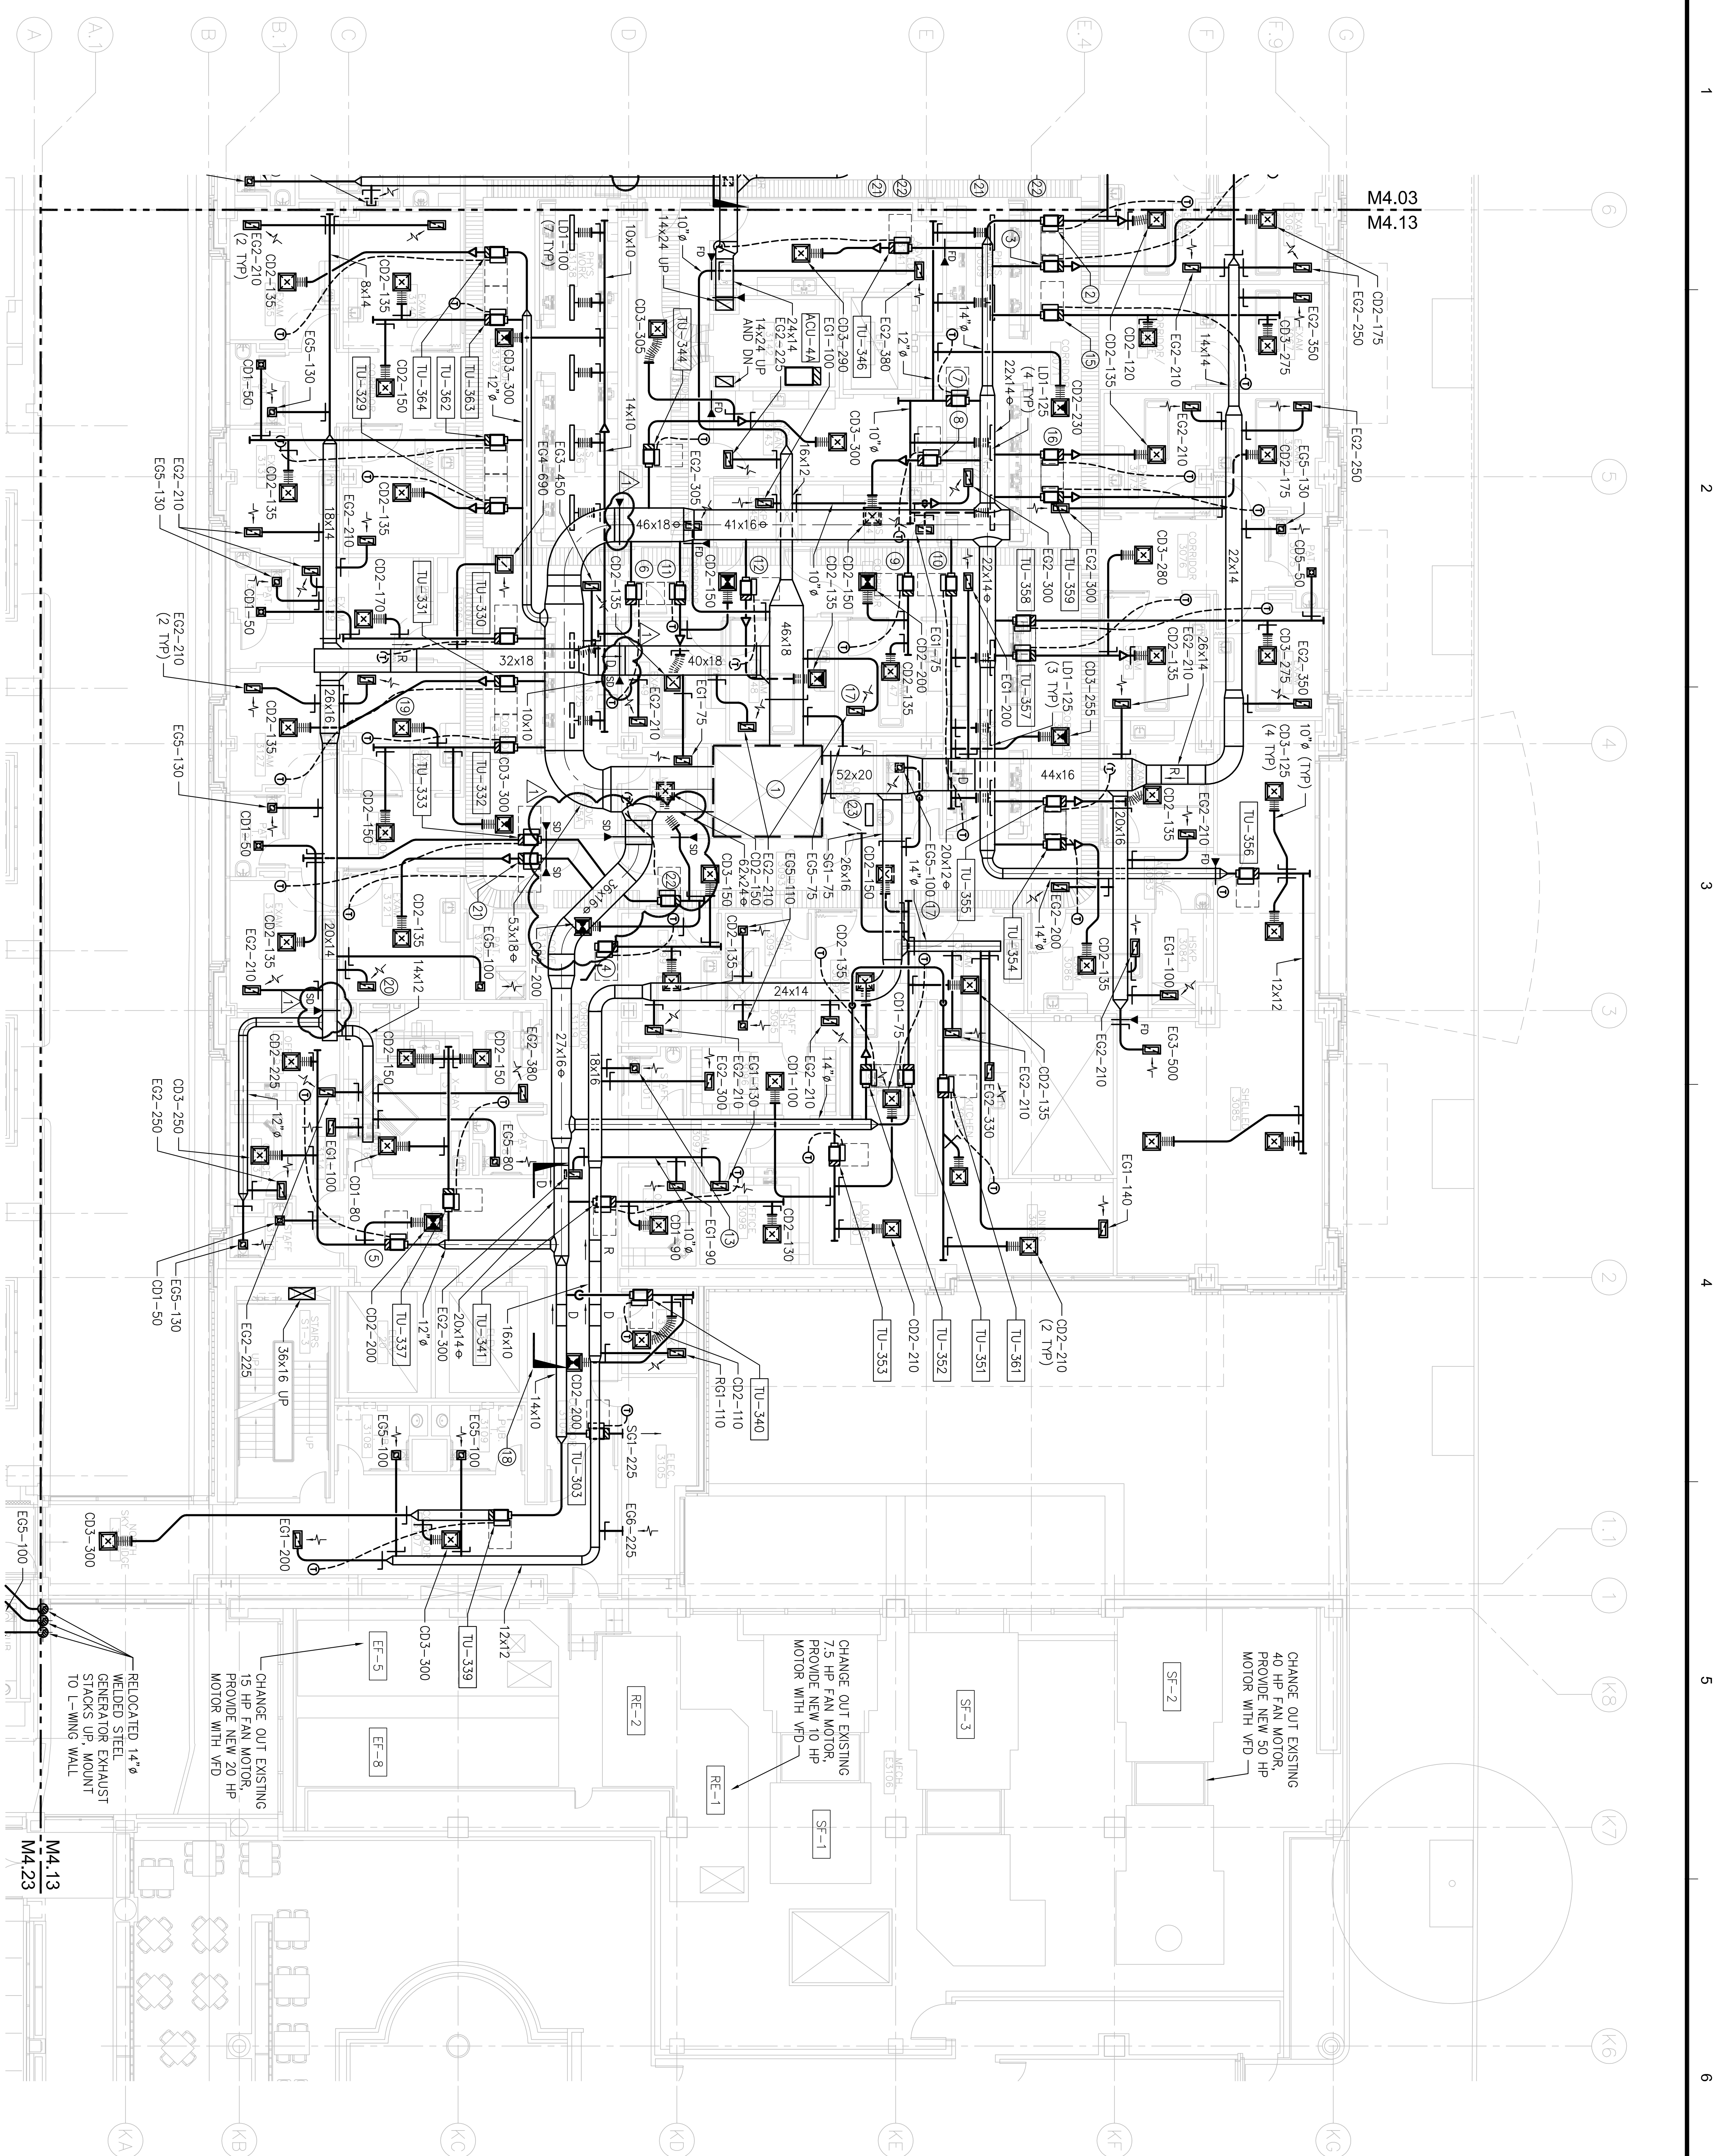

**KEY NOTES:**

- ① SEE ENLARGED PLAN 2 ON M7.03.
- ② TU-311 .
- ③ TU-312 .
- ④ TU-336 .
- ⑤ TU-338 .
- ⑥ TU-342 .
- ⑦ TU-347 .
- ⑧ TU-348 .
- ⑨ TU-349 .
- ⑩ TU-350 .
- ⑪ TU-343 .
- ⑫ TU-345 .
- ⑬ EG5-80 .
- ⑭ CH-80 .
- ⑮ TU-313 .
- ⑯ TU-360 .
- ⑰ DUCT CONNECTED TO GRILLE MUST HAVE A MINIMUM 2 ELBOWS.
- ⑱ SEE SECTION F ON M8.02.
- ⑲ OP2-135.
- ⑳ EG2-210.
- ㉑ TU-334 .
- ㉒ TU-335 .
- ㉓ DDC CONTROL PANEL.

GIFFIN • BOLTE • JURGENS<sub>pa</sub>  
A R C H I T E C T S

815 S.W. SECOND AVENUE · PORTLAND, OREGON 97204  
(503) 223-0992      [www.gbiarch.com](http://www.gbiarch.com)      FAX (503) 294-3961

CDIENGINEERS

4200 - 194th St SW, Suite 20  
Lynnwood, WA 98033  
T 425.672.1071 F 425.778.8766  
www.CDIENGINEERS.com



EXPENSE 06-20-10

## EMERGENCY DEPARTMENT & CANCER CENTER EXPANSION



Multicare

TACOMA, WASHINGTON

CCD 10 

04-03-05

Date 09-26-2008

Scale 1/8"=1'-0"

Drawn By \_\_\_\_\_ (CD)

1034

3RD FLOOR  
PLAN - NORTH -  
HVACM4  
13