
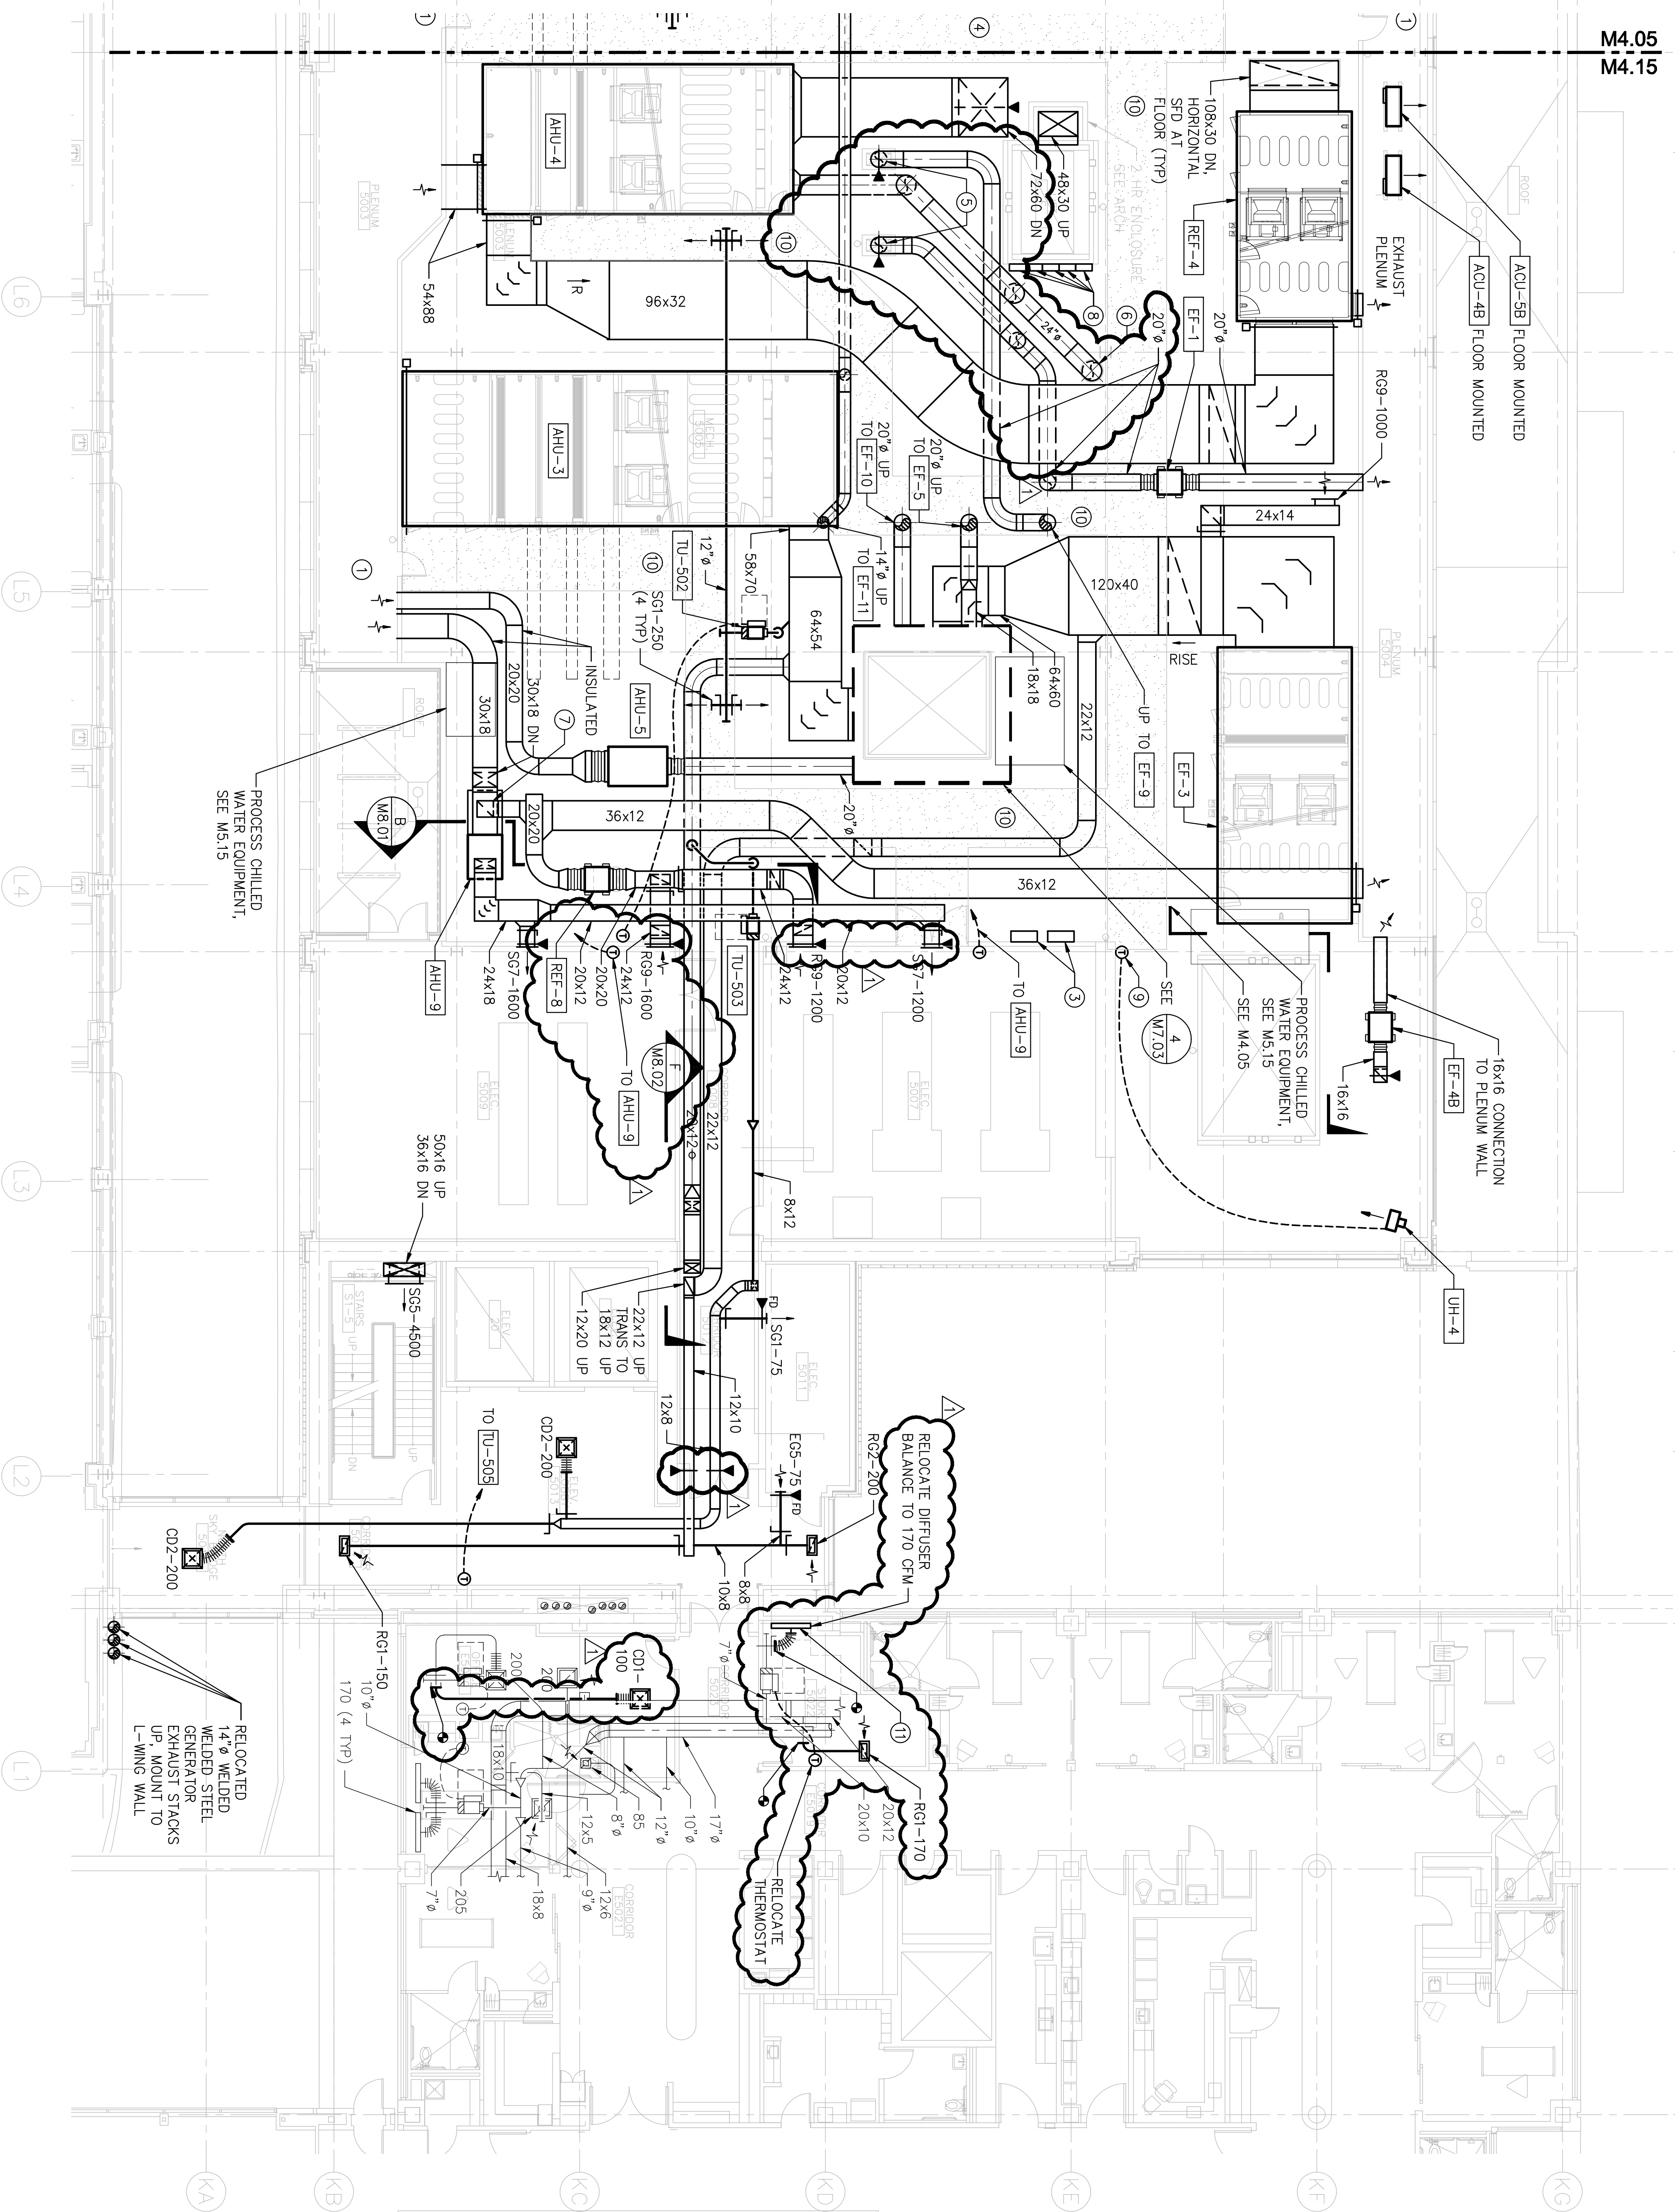


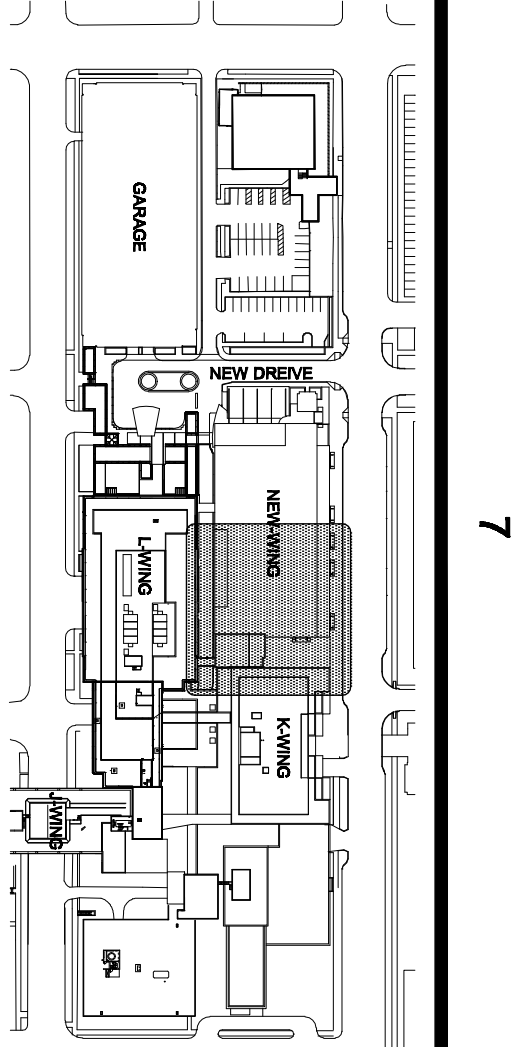

5TH FLOOR PLAN - NORTH & REMODEL - HVAC

SCALE: 1/8"=1'-0"

- KEY NOTES:**
1. ACCESS DOOR, 30x72.
 2. MAINTAIN CLEARANCE FOR FUTURE UNITS AND DUCTWORK, TYPICAL.
 3. DDC CONTROL PANEL.
 4. 14" BIO-SAFETY CABINET EXHAUST, ZERO CLEARANCE DUCT, DOWN.
 5. 20" TRANSITION TO 24x14 DOWN.
 6. 24" DOWN, TRANSITION TO 38x14 DOWN WITH FIRE/SMOKE DAMPER AT FLOOR.
 7. 20x20 DOWN TO 30x18.
 8. VFD'S FOR THE FOLLOWING FANS LOCATED ON ROOF ABOVE: [EF-5], [EF-9], [EF-10], [EF-11] AND [PSF-3].
 9. PROVIDE CONDUIT FOR SENSOR WIRE EXPOSED ON WALL.
 10. EXHAUST FAN.
 11. BALANCE TO 170 CFM.

- GENERAL NOTES:**
1. FOR AIR HANDLER WEIGHTS, DIMENSIONS AND COMPONENT CONFIGURATION, SEE DRAWINGS M10.01 AND M10.02.
 2. PROVIDE BELLMOUTH FITTINGS TO ALL AIR HANDLING UNIT DUCT CONNECTIONS.

GIFFIN • BOLTE • JURGENS
ARCHITECTS
P.C.
815 S.W. 8TH ST., SUITE 200
MIAMI, FL 33135
TEL: 305.375.9992 FAX: 305.375.9991
WWW.GBJA-ARCH.COM

CD ENGINEERS
4200 S.W. 14TH ST., SUITE 200
MIAMI, FL 33135
TEL: 305.872.2071 FAX: 305.872.8786
WWW.CDENGINEERS.COM



MultiCare
EMERGENCY DEPARTMENT & CANCER CENTER EXPANSION
TACOMA, WASHINGTON

CD 011	04-10-09	
Date	09-26-2008	
Scale	1/8"=1'-0"	
Drawn By	CS	
Job No.	4034	

5TH FLOOR
PLAN - NORTH &
REMODEL - HVAC

M4
15