
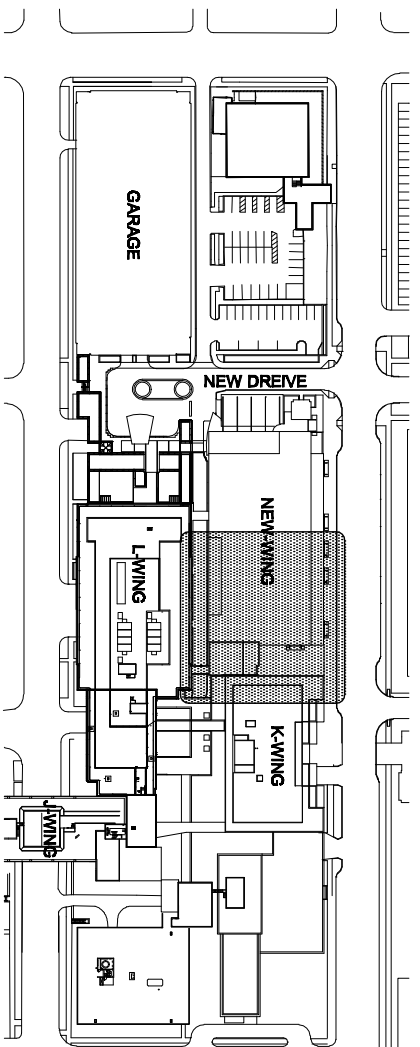


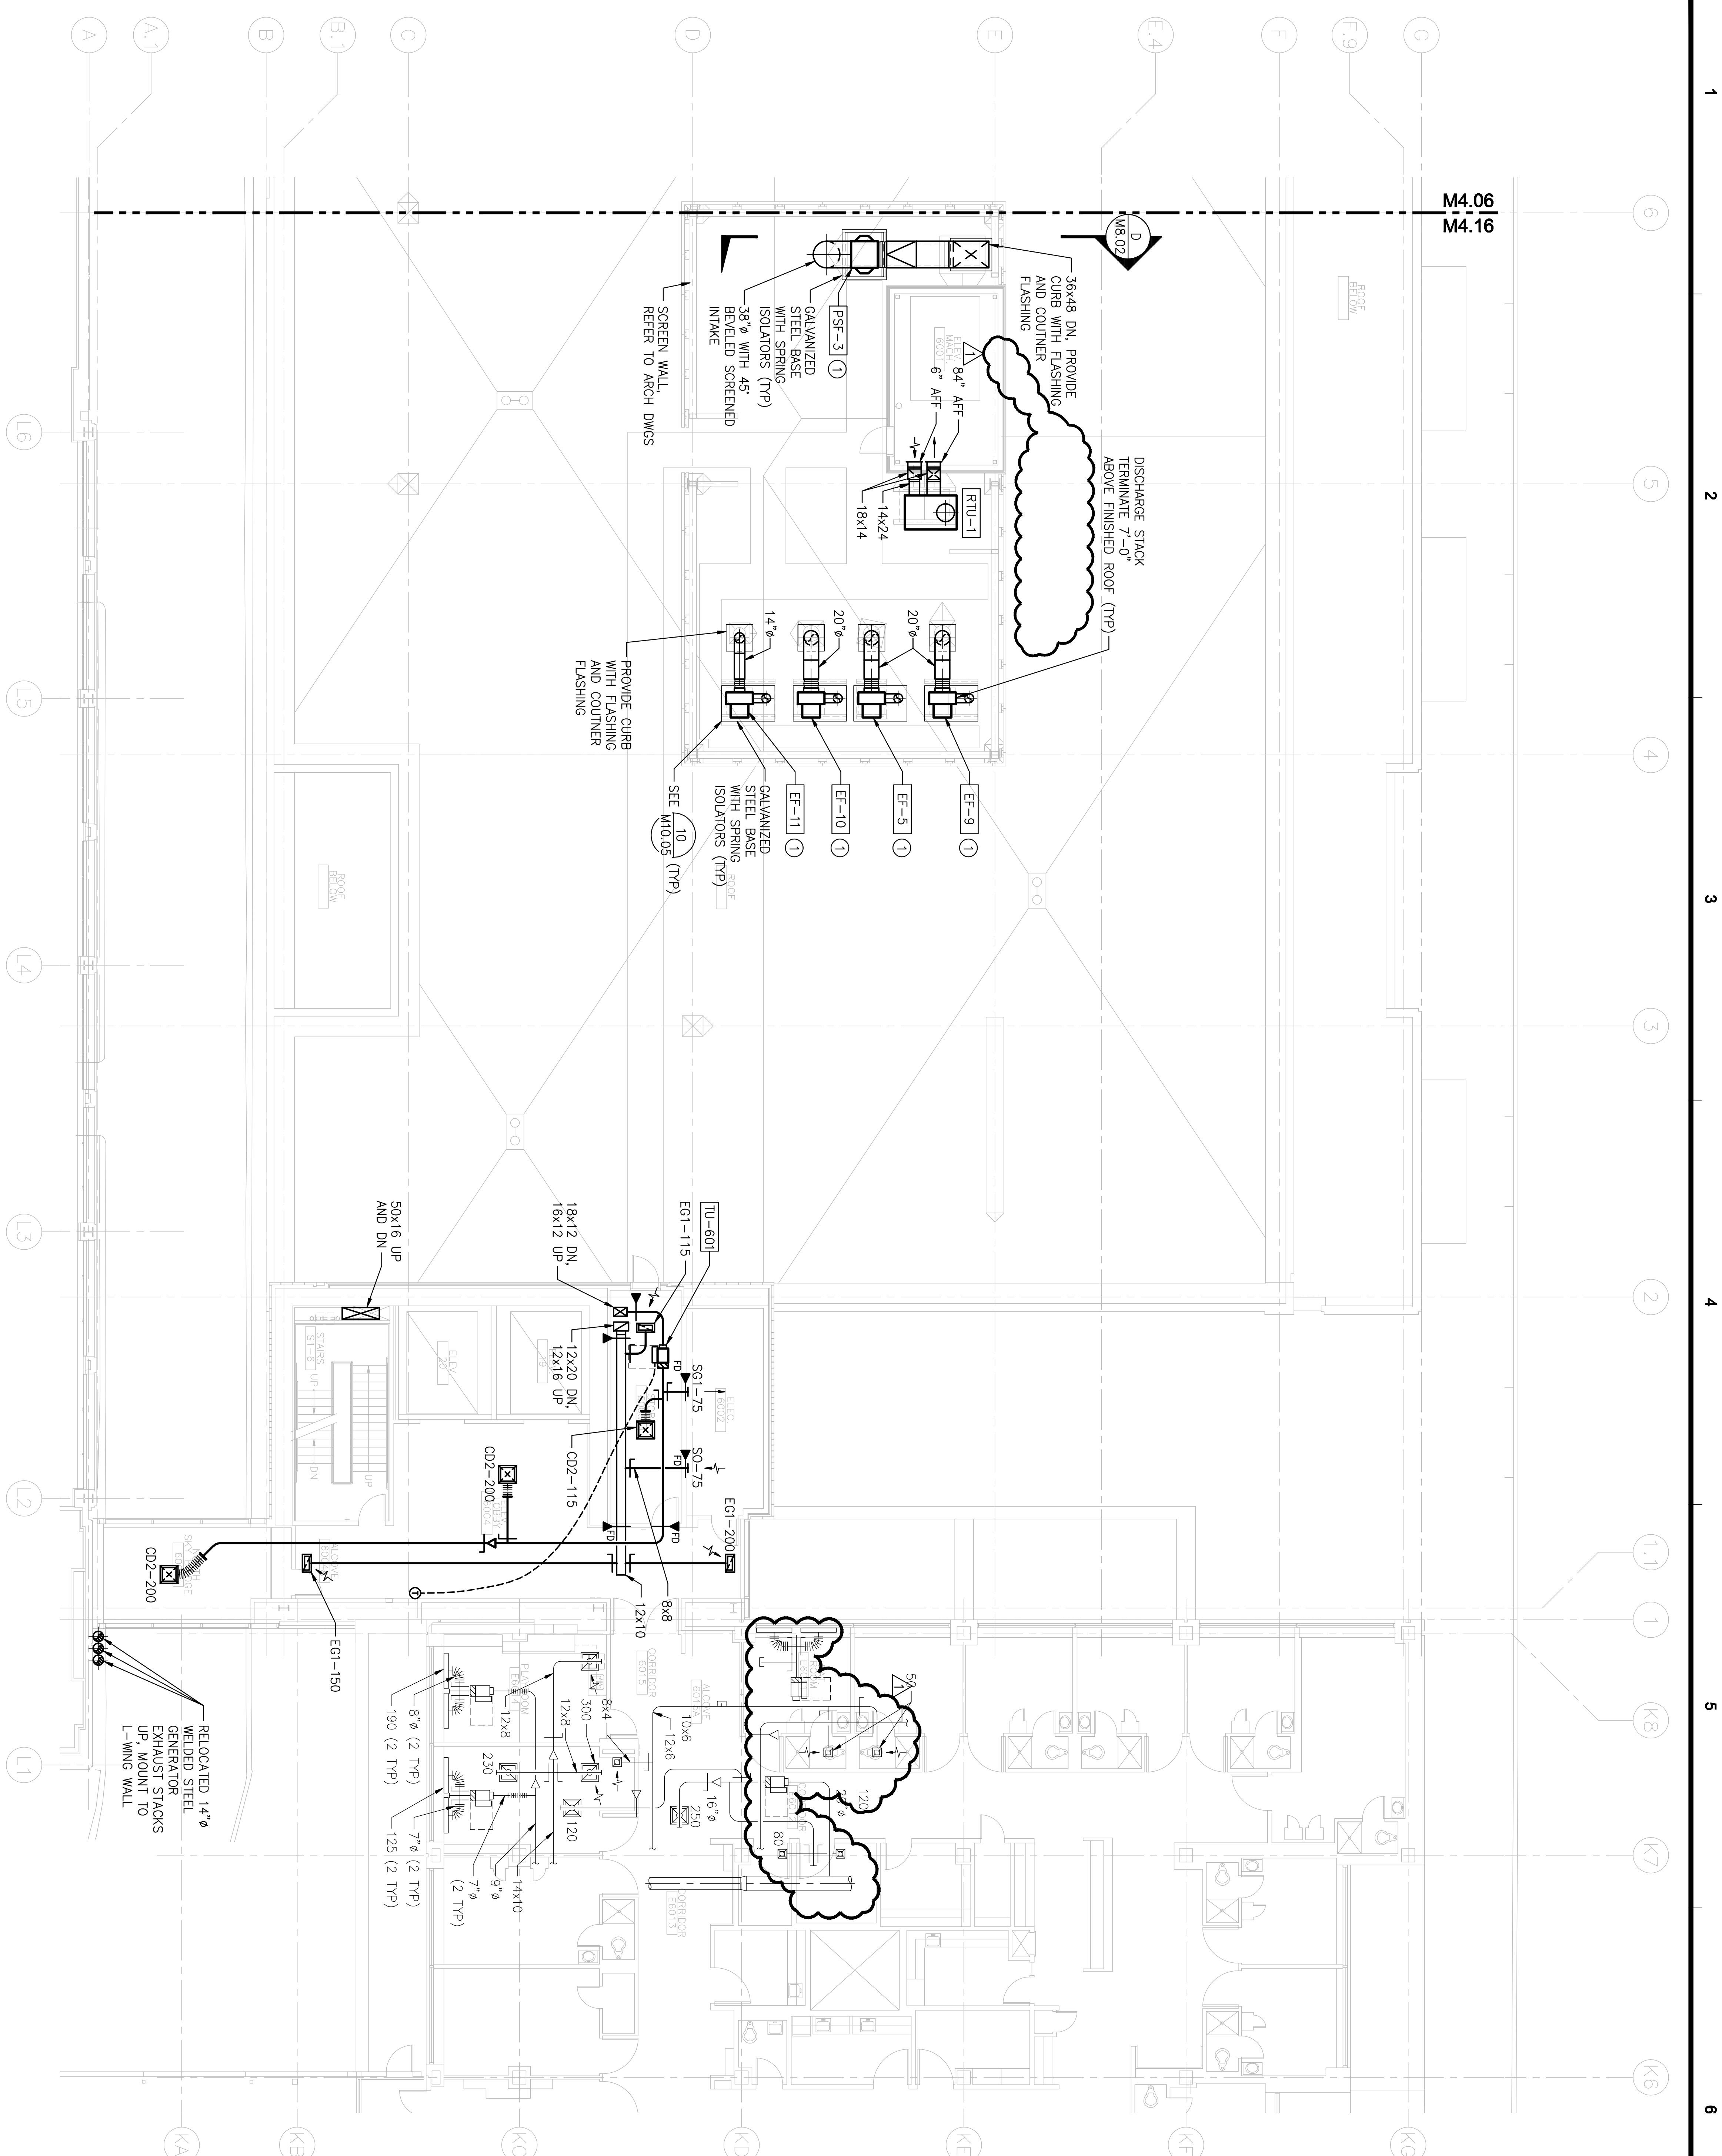


6TH FLOOR PLAN - NORTH & REMODEL - HVAC

KEY NOTES:

① FAN VFD TO BE MOUNTED IN FIFTH FLOOR MECHANICAL ROOM. PROVIDE IDENTIFICATION ON VFD'S.

GIFFIN • BOLTE • JURGENS *pc*
A R C H I T E C T S
815 S.W. SECOND AVENUE • PORTLAND, OREGON 97204
(503) 223-0092 www.gbarch.com FAX (503) 294-3361

C D I ENGINEERS
4200 - 194th St SW, Suite 200
Lynnwood, WA 98036
T 425.672.1071 F 425.778.8788
www.CDIENGINEERS.com

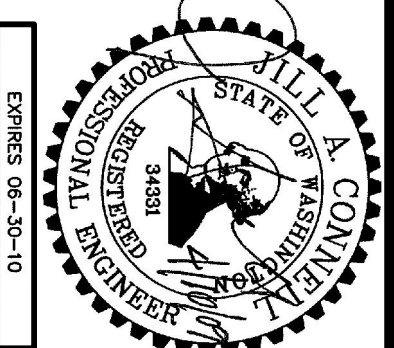

Multicare 

EMERGENCY DEPARTMENT & CANCER CENTER EXPANSION

TACOMA, WASHINGTON

△ CDD 011	04-10-09			Date	09-26-2009
				Scale	1/8"=1'-0"
				Drawn By	CDJ
				Job No.	4034

**6TH FLOOR
PLAN - NORTH &
REMODEL - HVAC**

M4
16