



1ST FLOOR PLAN - NORTH - HVAC PIPING
 SCALE: 1/8"=1'-0"

GENERAL NOTES:

1. TERMINAL UNITS SHALL BE PIPED WITH TWO-WAY CONTROL VALVES UNLESS NOTED OTHERWISE ON PLANS. SEE DETAIL 1 ON M10.05.

KEY NOTES:

- 1" BALL VALVES CAPPED PIPING FOR FUTURE VARIAN CLINIC.
- TERMINATE 10" ABOVE FLOOR SLAB 1/2"CA WITH 1/2" FEMALE NPT BALL VALVE WITH PLUGGED END AND 1"PCWS AND 1"PCWR WITH 1" FEMALE NPT BALL VALVES PLUGGED ON ENDS.
- TERMINATE DRIP PAN INDIRECT DRAIN AT FLOOR SINK.
- HEAT TRACE AND INSULATE PIPES EXPOSED IN GARAGE.
- 80% DIVERSITY APPLIED TO FLOWRATE.

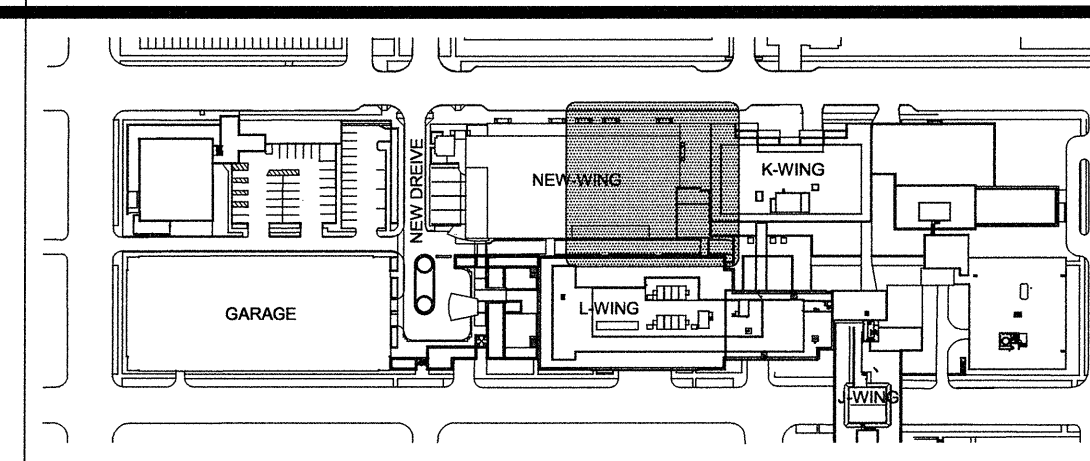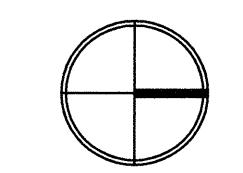

Giffin • Bolte • Jurgens
 ARCHITECTS
 815 S.W. SECOND AVENUE • PORTLAND, OREGON 97204
 (503) 223-0992 www.gbjarch.com FAX (503) 294-3961

CDI ENGINEERS
 4200 - 194th St SW, Suite 200
 Lynnwood, WA 98036
 T 425.672.1071 F 425.778.8769
 www.CDIENGINEERS.com



MultiCare
EMERGENCY DEPARTMENT & CANCER CENTER EXPANSION
 TACOMA, WASHINGTON

Date 09-26-2008
 Scale 1/8"=1'-0"
 Drawn By CDI
 Job No. 4034

**1ST FLOOR
 PLAN - NORTH -
 HVAC PIPING**

**M5
 11**