
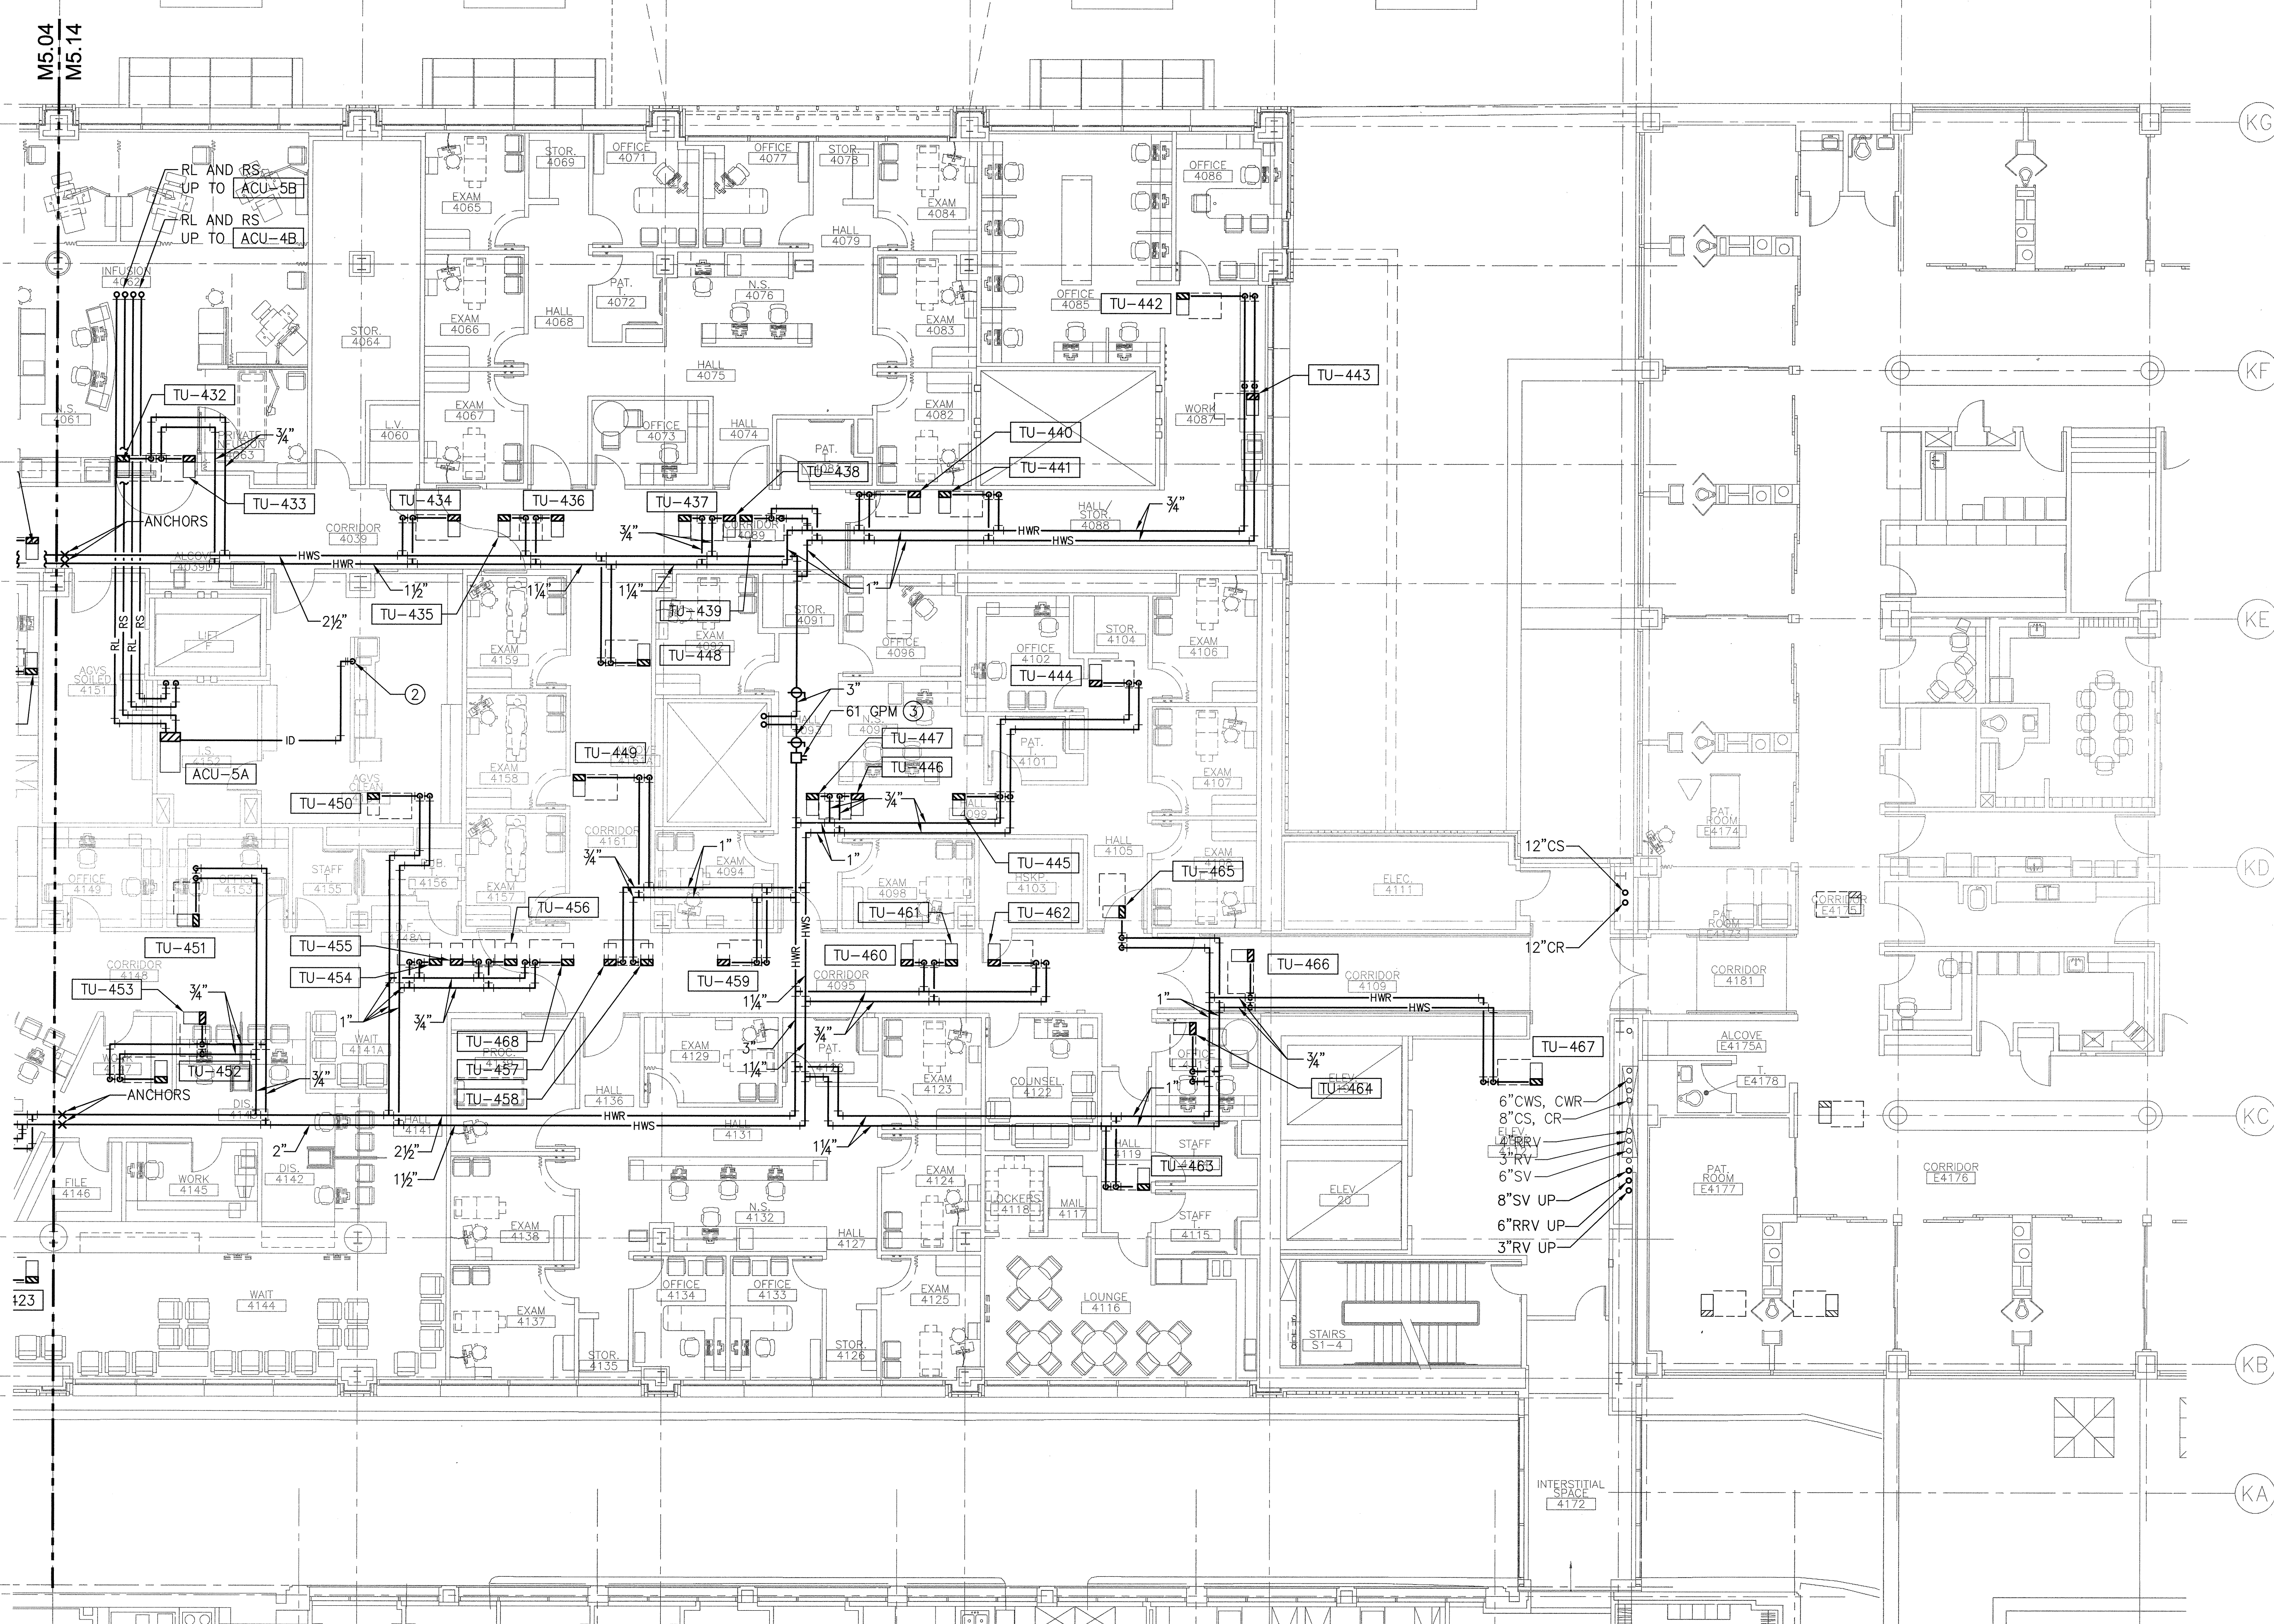


1 2 3 4 5 6 7

A  
B  
C  
D  
E

A  
B  
C  
D  
E

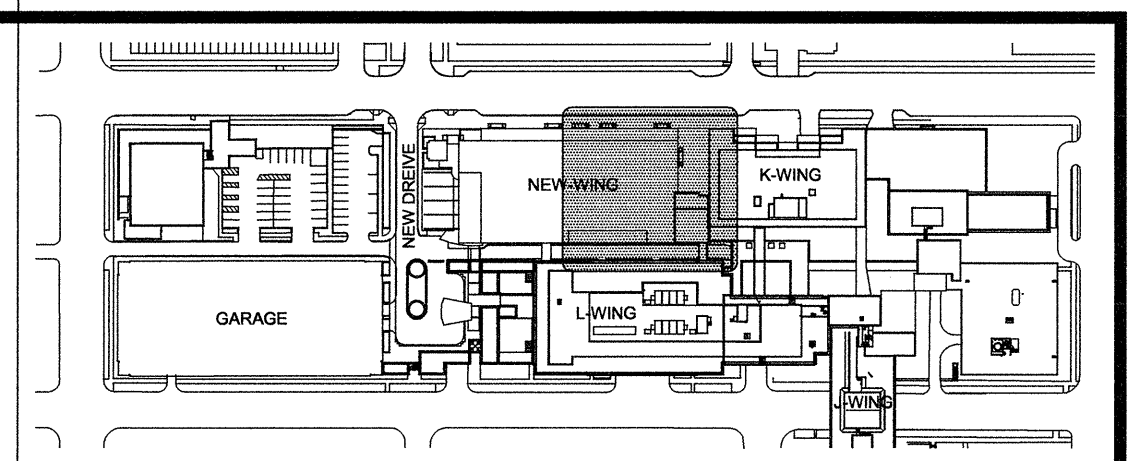

4TH FLOOR PLAN - NORTH - HVAC PIPING  
SCALE: 1/8"=1'-0"

- GENERAL NOTES:**
1. TERMINAL UNITS SHALL BE PIPED WITH TWO-WAY CONTROL VALVES UNLESS NOTED OTHERWISE ON PLANS. SEE DETAIL 1 ON M10.05.
- KEY NOTES:**
- ① PIPE TERMINAL UNIT HEATING COIL WITH 3-WAY CONTROL VALVE, SEE DETAIL 1 ON M10.05.
  - ② 1"ID DOWN IN WALL. SEE M2.14 AND DETAIL 7 ON M10.05.
  - ③ 80% DIVERSITY APPLIED TO FLOWRATE.

