
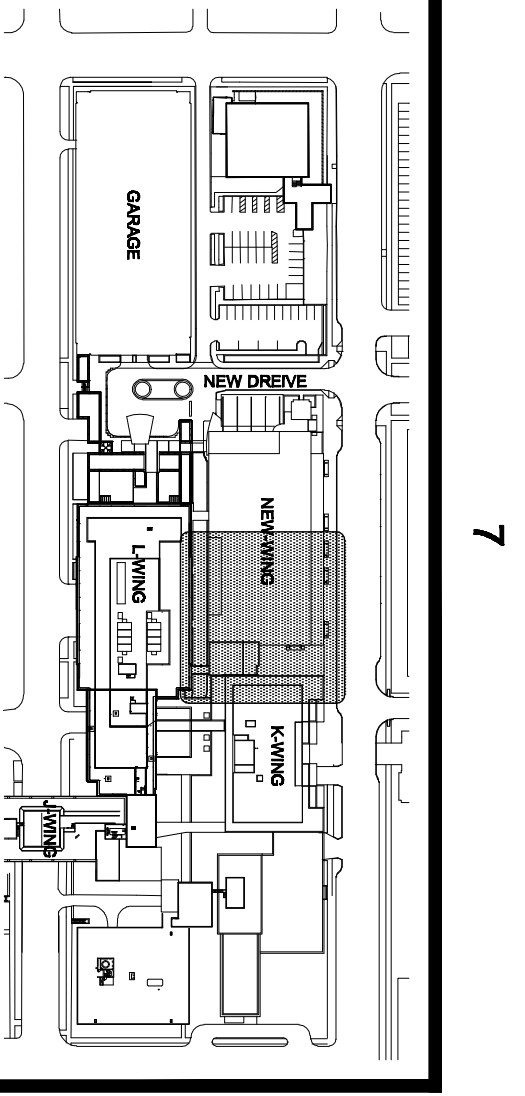


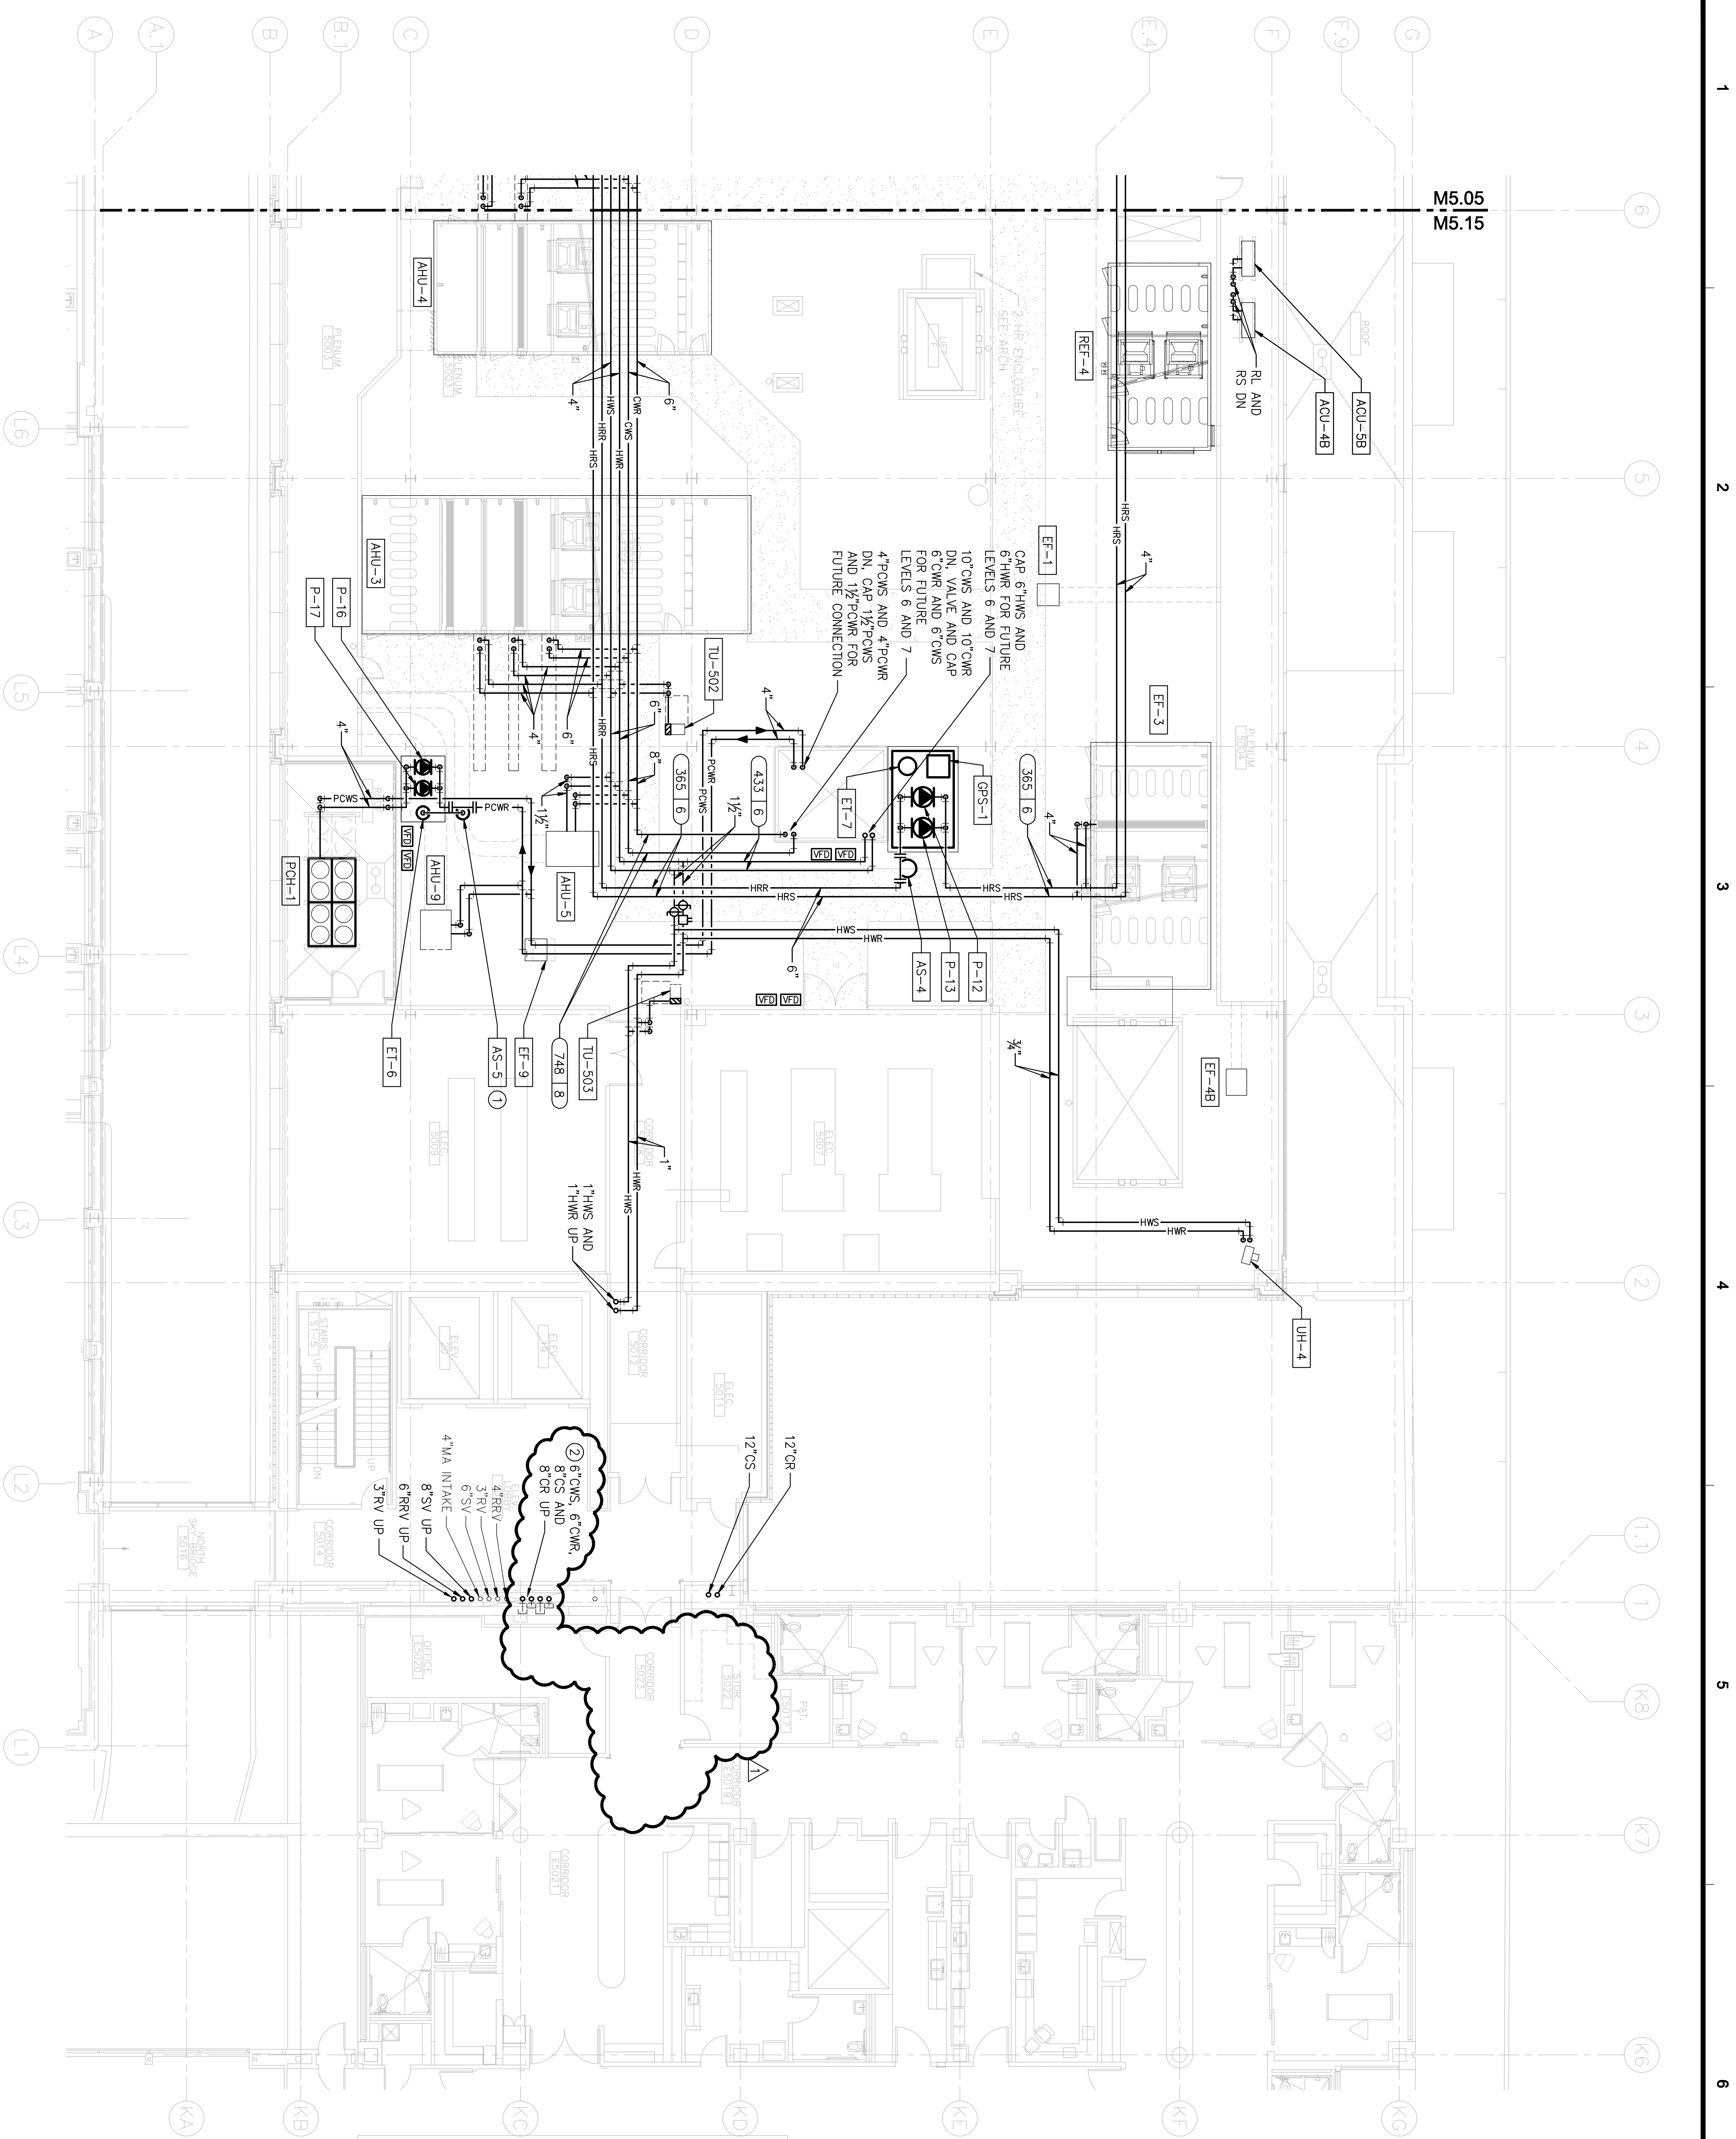

KEY NOTES:

- ① PROVIDE $\frac{3}{4}$ " CONNECTION TO [GPS-1] WITH SYSTEM REGULATOR ASSEMBLY
- ② CONTINUE 6" CHILLED WATER SUPPLY AND RETURN AND 8" CONDENSER WATER SUPPLY AND RETURN UP TO SIXTH FLOOR.

GIFFIN • BOLTE • JURGENS p.c.
A R C H I T E C T S

815 S.W. SECOND AVENUE, PORTLAND, OREGON 97204
(503) 223-0992 www.gbjarch.com FAX (503) 294-3961

CDIENGINEERS

4200 - 194th St SW, Suite 200
Lynnwood, WA 98036
T 425.672.1071 F 425.778.8769
www.CDIENGINEERS.com

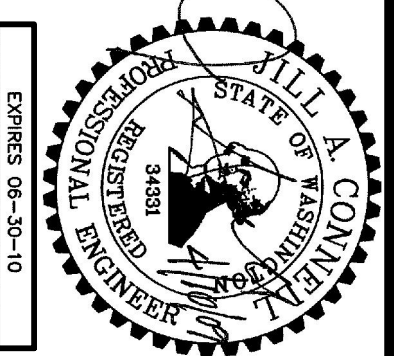


Exhibit 06-10-10

MultiCare  **EMERGENCY DEPARTMENT & CANCER CENTER EXPANSION**

TACOMA, WASHINGTON

△ CDD 011	04-10-09		09-28-2008
			1/8"=1'-0"
			Scale
			Drawn By CDD
			Job No. 4034

Date	09-28-2008
Scale	1/8"=1'-0"
Drawn By	CDI
Job No.	4034

5TH FLOOR PLAN - NORTH - HVAC PIPING

M5
15