



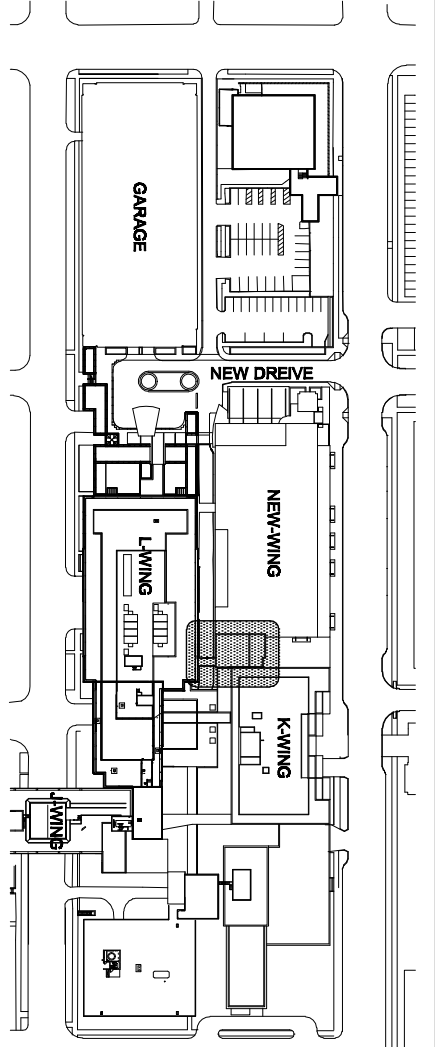


7TH FLOOR PLAN - NORTH - HVAC PIPING

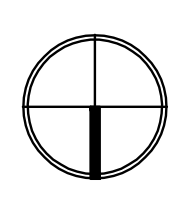

H:\2006\2006-026 Multicore FD\Dwg\M517.dwg, 4/6/2009 10:52:36 AM, jyo

GRIFFIN • BOLTE • JURGENS
P.C.
A R C H I T E C T S
815 S.W. SECOND AVENUE • PORTLAND, OREGON 97204
(503) 223-0992 www.gbjaarch.com FAX (503) 294-3961

CDI ENGINEERS
4200 - 194th St SW, Suite 200
Lynnwood, WA, 98036
T 425.672.1071 F 425.778.8788
www.CDIENGINEERS.com

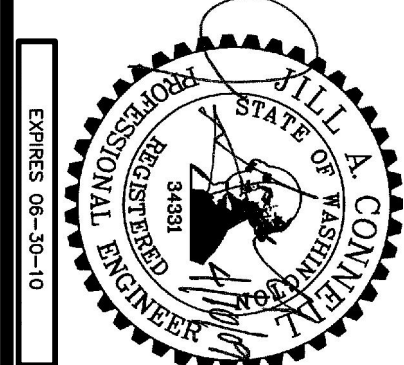

Multicare 

EMERGENCY DEPARTMENT & CANCER CENTER EXPANSION

TACOMA, WASHINGTON

CCD 011	04-10-98		

Date 09-26-2008
Scale 1/8"=1'-0"
Drawn By CMI
Job No. 4034

**7TH FLOOR
PLAN - NORTH -
HVAC PIPING**

M5
17