



1ST FLOOR PLAN - L WING & PLAZA REMODEL - HVAC PIPING
SCALE: 1/8"=1'-0"

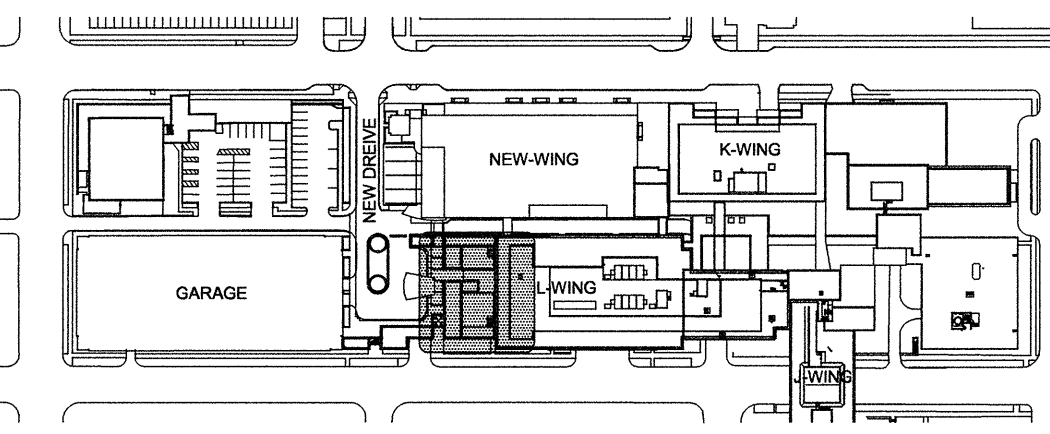

GIFFIN • BOLTE • JURGENS
ARCHITECTS
815 S.W. SECOND AVENUE - PORTLAND, OREGON 97204
(503) 223-0992 www.gbjarch.com FAX (503) 294-3961

CDI ENGINEERS
4200 - 184th St SW, Suite 200
LYNNWOOD, WA 98036
T 425.672.1071 F 425.778.8769
www.CDIENGINEERS.com

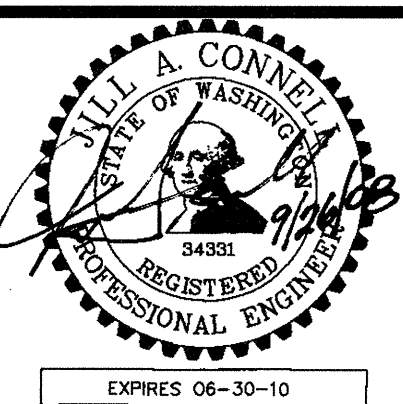

MultiCare
EMERGENCY DEPARTMENT & CANCER CENTER EXPANSION
TACOMA, WASHINGTON

Date 09-26-2008
Scale 1/8"=1'-0"
Drawn By CDI
Job No. 4034

1ST FLOOR
PLAN - L WING &
PLAZA REMODEL -
HVAC PIPING

M5
21