
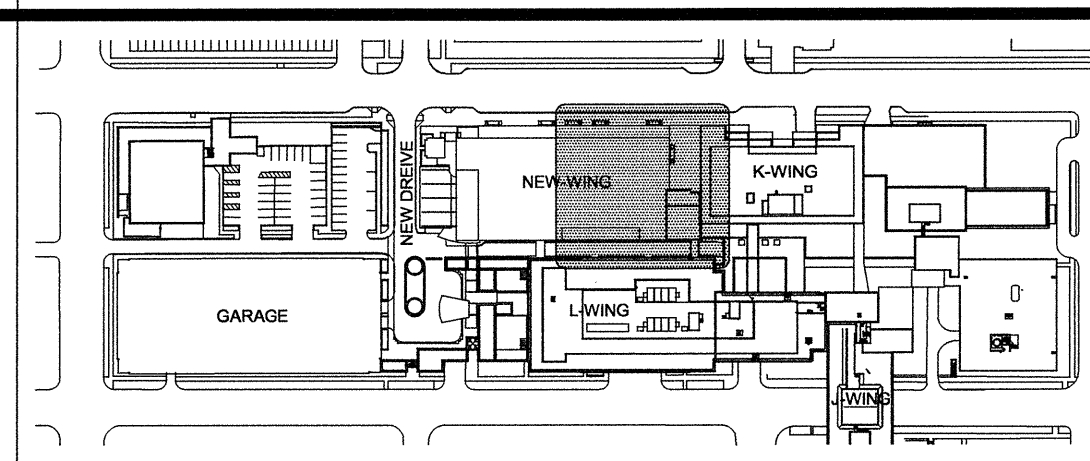



1 2 3 4 5 6 7

A
B
C
D
E

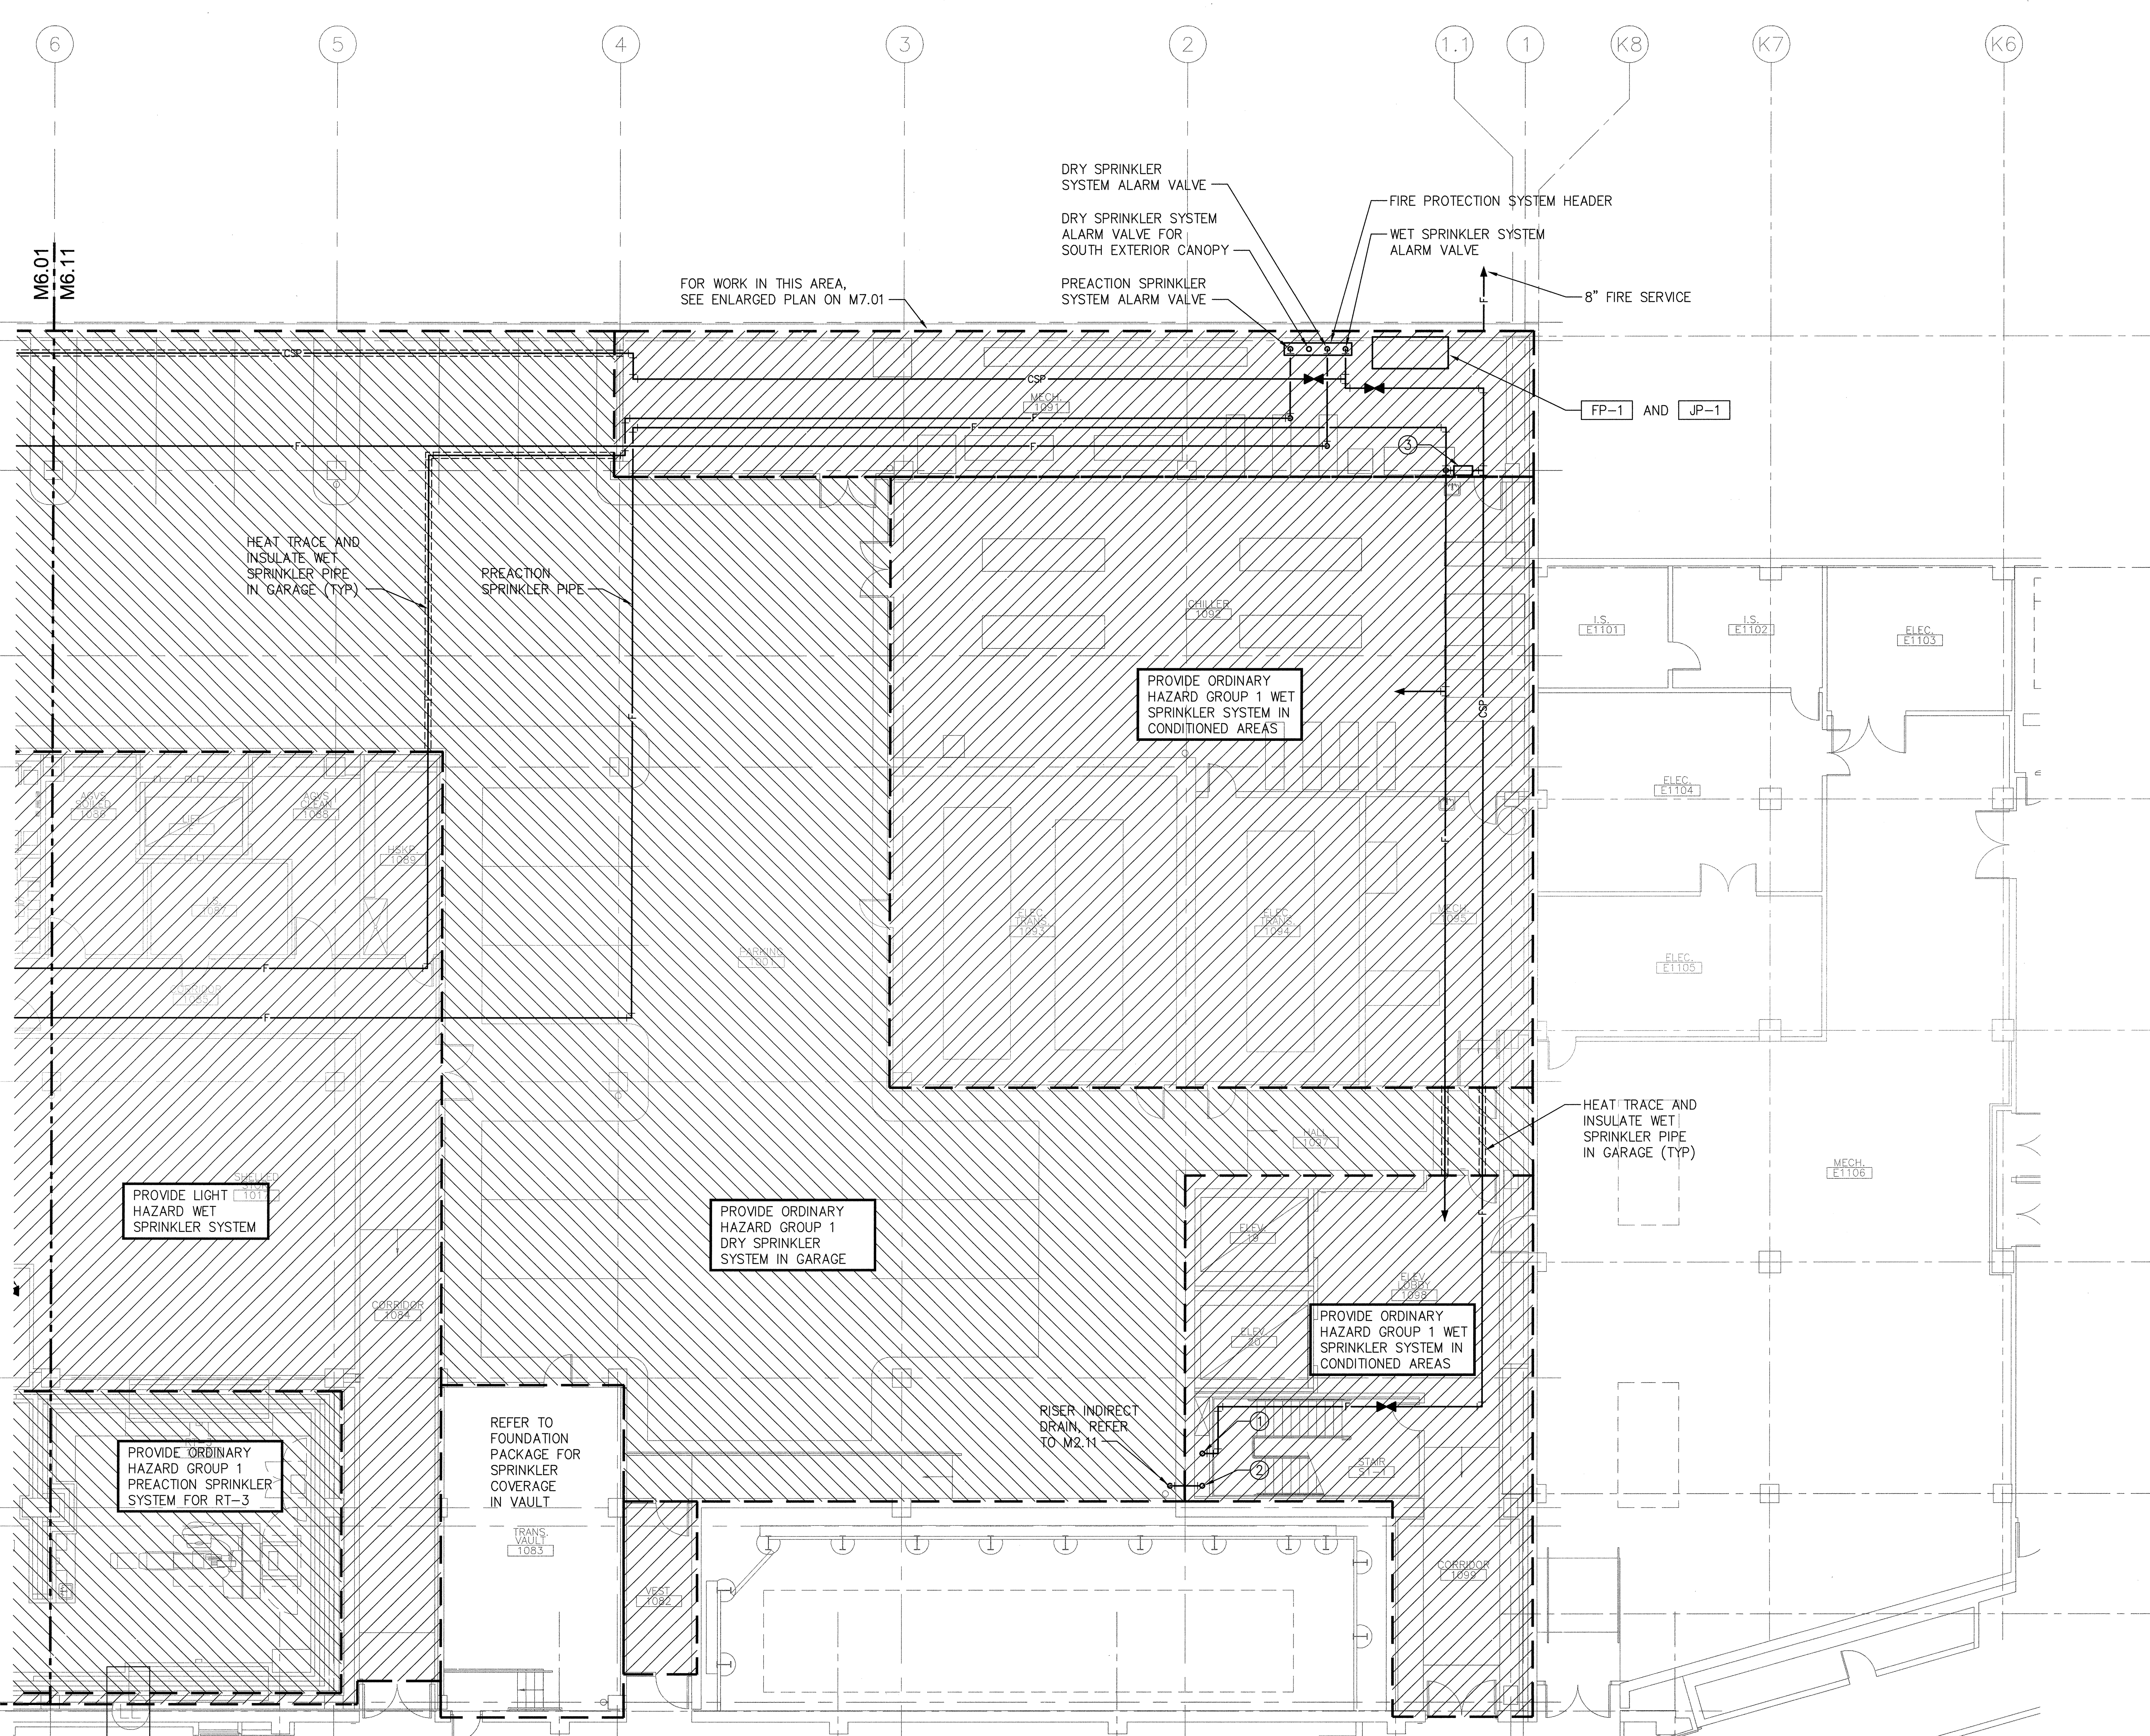


1ST FLOOR PLAN - NORTH - FIRE PROTECTION
SCALE: 1/8"=1'-0"

- KEY NOTES:**
- ① COMBINATION STAND PIPE.
 - ② 2" TEST DRAIN.
 - ③ PROVIDE ZONE VALVE ASSEMBLY.

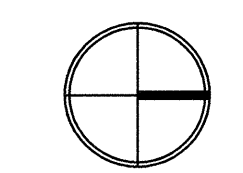

GIFFIN • BOLTE • JURGENS
ARCHITECTS
815 S.W. SECOND AVENUE, PORTLAND, OREGON 97204
(503) 223-0992 • www.gbjarch.com • FAX (503) 294-3961

CDI ENGINEERS
4200 - 194th St SW, Suite 200
Lynnwood, WA 98036
T 425.672.1071 F 425.778.8799
www.CDIENGINEERS.com

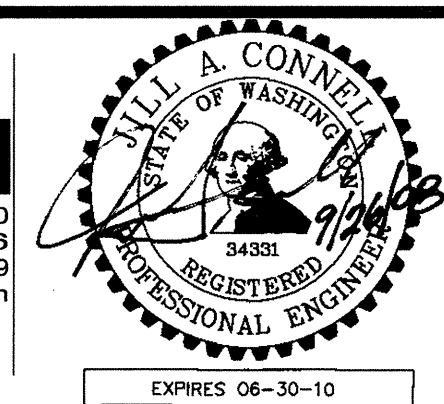

MultiCare
EMERGENCY DEPARTMENT & CANCER CENTER EXPANSION
TACOMA, WASHINGTON

Date 09-26-2008
Scale 1/8"=1'-0"
Drawn By CDI
Job No. 4034

**1ST FLOOR
PLAN - NORTH -
FIRE PROTECTION**

**M6
11**