



1 2 3 4 5 6 7

A
B
C
D
E

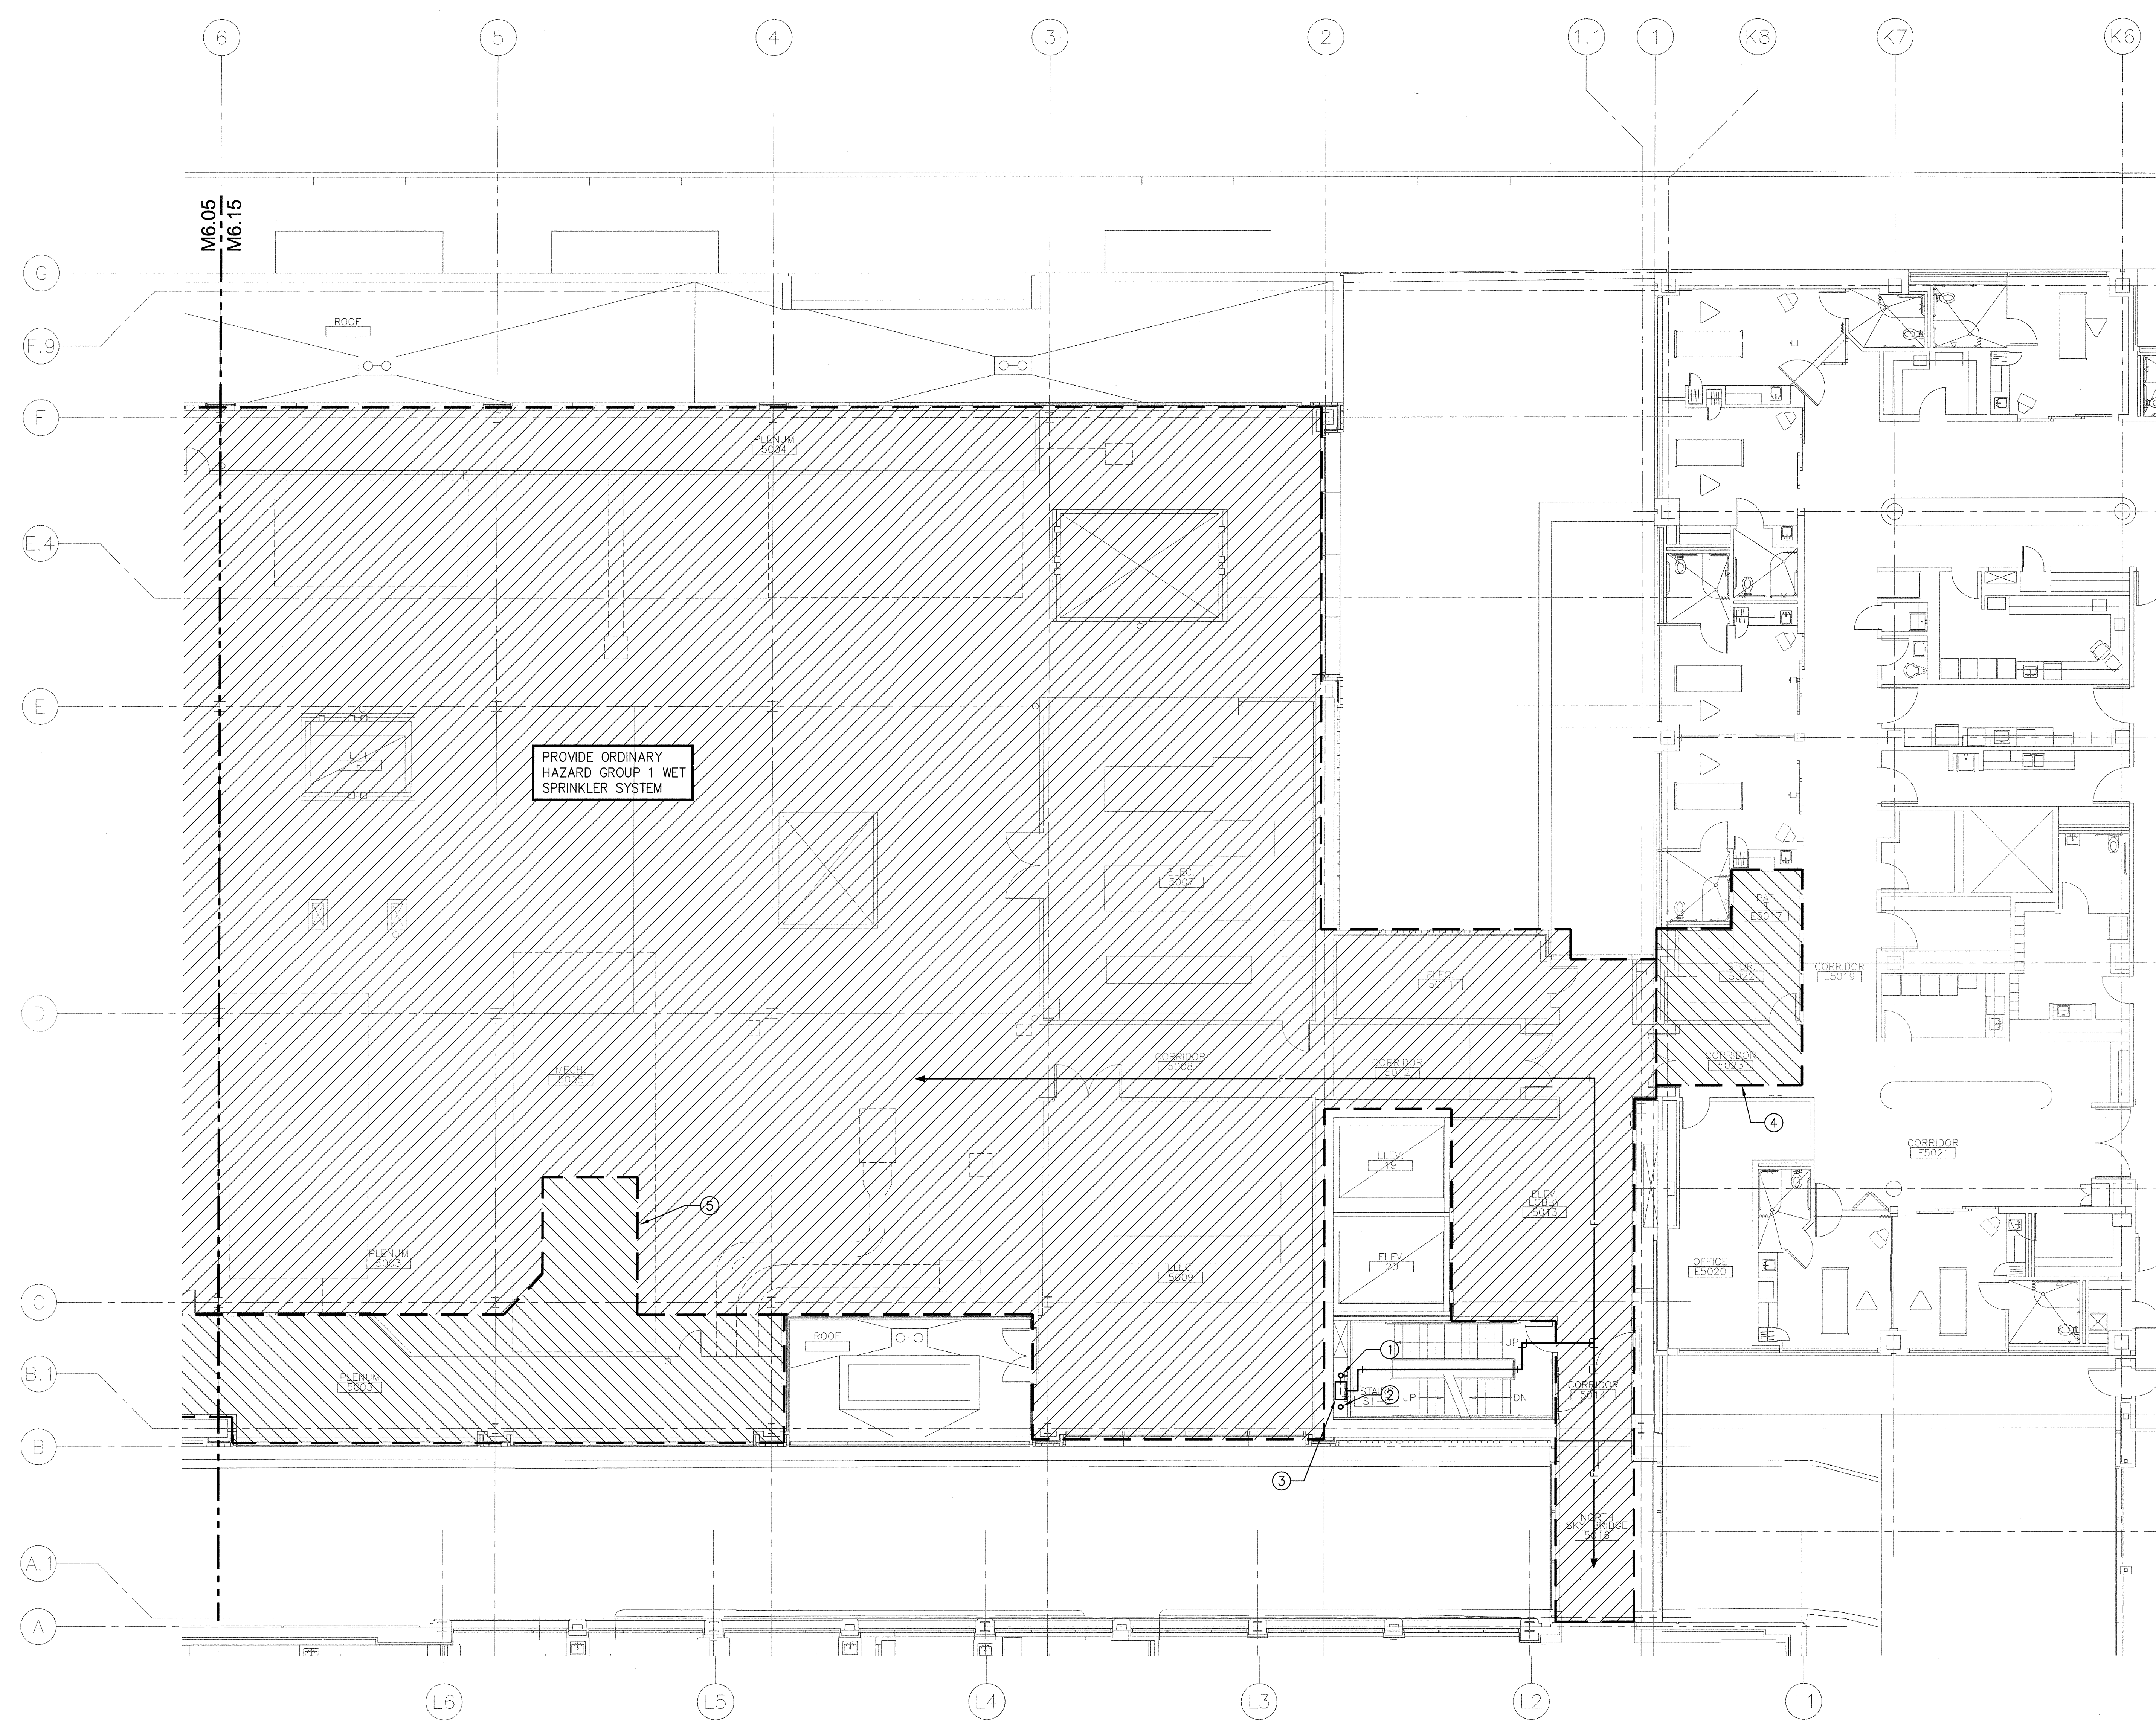

5TH FLOOR PLAN - NORTH - FIRE PROTECTION
SCALE: 1/8"=1'-0"

- KEY NOTES:**
- ① COMBINATION STAND PIPE.
 - ② 2" TEST DRAIN.
 - ③ PROVIDE SPRINKLER ZONE VALVE ASSEMBLY AND HOSE VALVE IN RECESSED CABINET AT MID STAIR LANDING.
 - ④ MODIFY EXISTING FIRE SPRINKLER SYSTEM TO ACCOMMODATE CHANGES TO FLOOR PLANS, WALLS AND CEILINGS. REPLACE ALL EXISTING SPRINKLER HEADS WITH NEW QUICK RESPONSE HEADS, REFER TO PROJECT SPECIFICATIONS FOR FURTHER INFORMATION.
 - ⑤ PROTECT OUTSIDE AIR PLENUM (SUBJECT TO FREEZING) WITH EXTENDED COVERAGE SIDEWALL HEADS FROM WET SYSTEM.

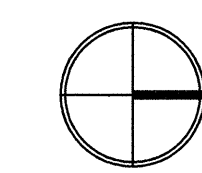


5TH FLOOR
PLAN - NORTH -
FIRE PROTECTION

M6
15

GIFFIN • BOLTE • JURGENS
ARCHITECTS
815 S.W. SECOND AVENUE • PORTLAND, OREGON 97204
(503) 223-0992 www.gbjarch.com FAX (503) 294-3961

CDI ENGINEERS
4200 - 194th St SW, Suite 200
Lynnwood, WA 98036
T 425.672.1071 F 425.778.8799
www.CDIENGINEERS.com

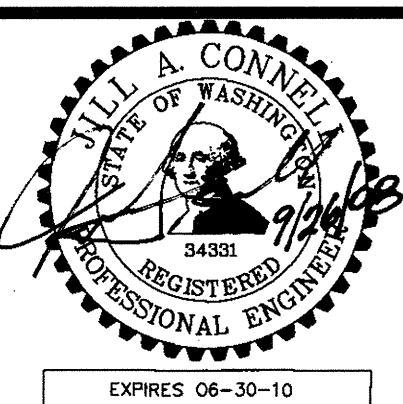

MultiCare
EMERGENCY DEPARTMENT & CANCER CENTER EXPANSION
TACOMA, WASHINGTON

Date 09-26-2008
Scale 1/8"=1'-0"
Drawn By CDI
Job No. 4034