


GENERAL NOTES

- SEE ARCHITECTURAL PLANS, SECTIONS AND ELEVATIONS FOR EXACT EQUIPMENT AND DEVICE LOCATIONS, INCLUDING MOUNTING HEIGHTS.
- PROVIDE RED DEVICES AND COVERPLATES FOR DEVICES SERVED FROM EMERGENCY POWER SYSTEM.
- SEE ARCHITECTURAL PLANS FOR LOCATIONS OF SOUND, SMOKE AND FIRE RATED WALLS.
- ABOVE COUNTER RECEPTACLES LOCATED WITHIN 5' OF SINK SHALL BE GFI RATED.
- SEE MECHANICAL DRAWINGS FOR EXACT LOCATION OF MECHANICAL EQUIPMENT. COORDINATE WITH MECHANICAL CONTRACTOR PRIOR TO ROUGH-IN.

FLAG NOTES

- ▷ KIOSK CONNECTION.
- ▷ CONFIRM EXACT LOCATION FOR AQUARIUM RECEPTACLE WITH ARCHITECT PRIOR TO ROUGH IN.
- ▷ CONFIRM EXACT LOCATION FOR BUBBLE WALL RECEPTACLE WITH ARCHITECT PRIOR TO ROUGH IN.
- ▷ PROVIDE HARD WIRED CONNECTION TO WATER CHILLER FOR DRINKING FOUNTAIN.
- ▷ PROVIDE HARD WIRED CONNECTION TO AUTO-DOOR MOTOR. PROVIDE ALL REQUIRED CONDUIT, WIRING AND ELECTRICAL DOOR HARDWARE. CONFIRM REQUIREMENTS WITH ARCHITECTURAL DOOR HARDWARE SCHEDULE.
- ▷ ICE MACHINE CONNECTION.
- ▷ PROVIDE HARD WIRED CONNECTION TO AUTO-SINK SENSOR.
- ▷ METAL DETECTOR/SECURITY CONNECTION.
- ▷ PROVIDE HARD WIRED CONNECTION TO DDC CONTROL PANEL FOR CONTROL CIRCUIT.
- ▷ PROVIDE (3) DEDICATED DOUBLE DUPLEX (15-200) RECEPTACLES MOUNTED ON RACK CABLE TRAY. REFER TO PANEL SCHEDULE 2L2EE FOR DEDICATED CIRCUITS.
- ▷ PHOTO-COPIER CONNECTION.
- ▷ PROVIDE HARD WIRED CONNECTION TO PNEUMATIC TUBE DIVERTER. CONFIRM EXACT LOCATION AND ELECTRICAL REQUIREMENTS WITH SITE SPECIFIC VENDOR DRAWINGS.
- ▷ VENDING MACHINE CONNECTION.
- ▷ DUPLEX RECEPTACLE FOR WATER FEATURE. COORDINATE EXACT LOCATION AND MOUNTING WITH WATER FEATURE CONTRACTOR PRIOR TO ROUGH-IN.
- ▷ WATER FEATURE CONTROL BOX. PROVIDE RECESSED BOX WITH HINGED, LOCKABLE COVER NEAR 1' CONSTRUCTION. PROVIDE CONTROL SWITCHES, ONE FOR EACH PUMP AND EACH RECEPTACLE. PROVIDE SWITCH FOR LIGHTING CONTROL. COORDINATE EXACT REQUIREMENTS WITH WATER FEATURE CONTRACTOR PRIOR TO ROUGH-IN. COORDINATE EXACT LOCATION WITH ARCHITECT.
- ▷ ROUTE TO WATER FEATURE CONTROL BOX.
- ▷ PROVIDE CONDUIT AND CONDUCTORS FOR LOOP CONNECTIONS PER MANUFACTURER REQUIREMENTS. COORDINATE WITH OWNER AND MANUFACTURER PRIOR TO ROUGH-IN.

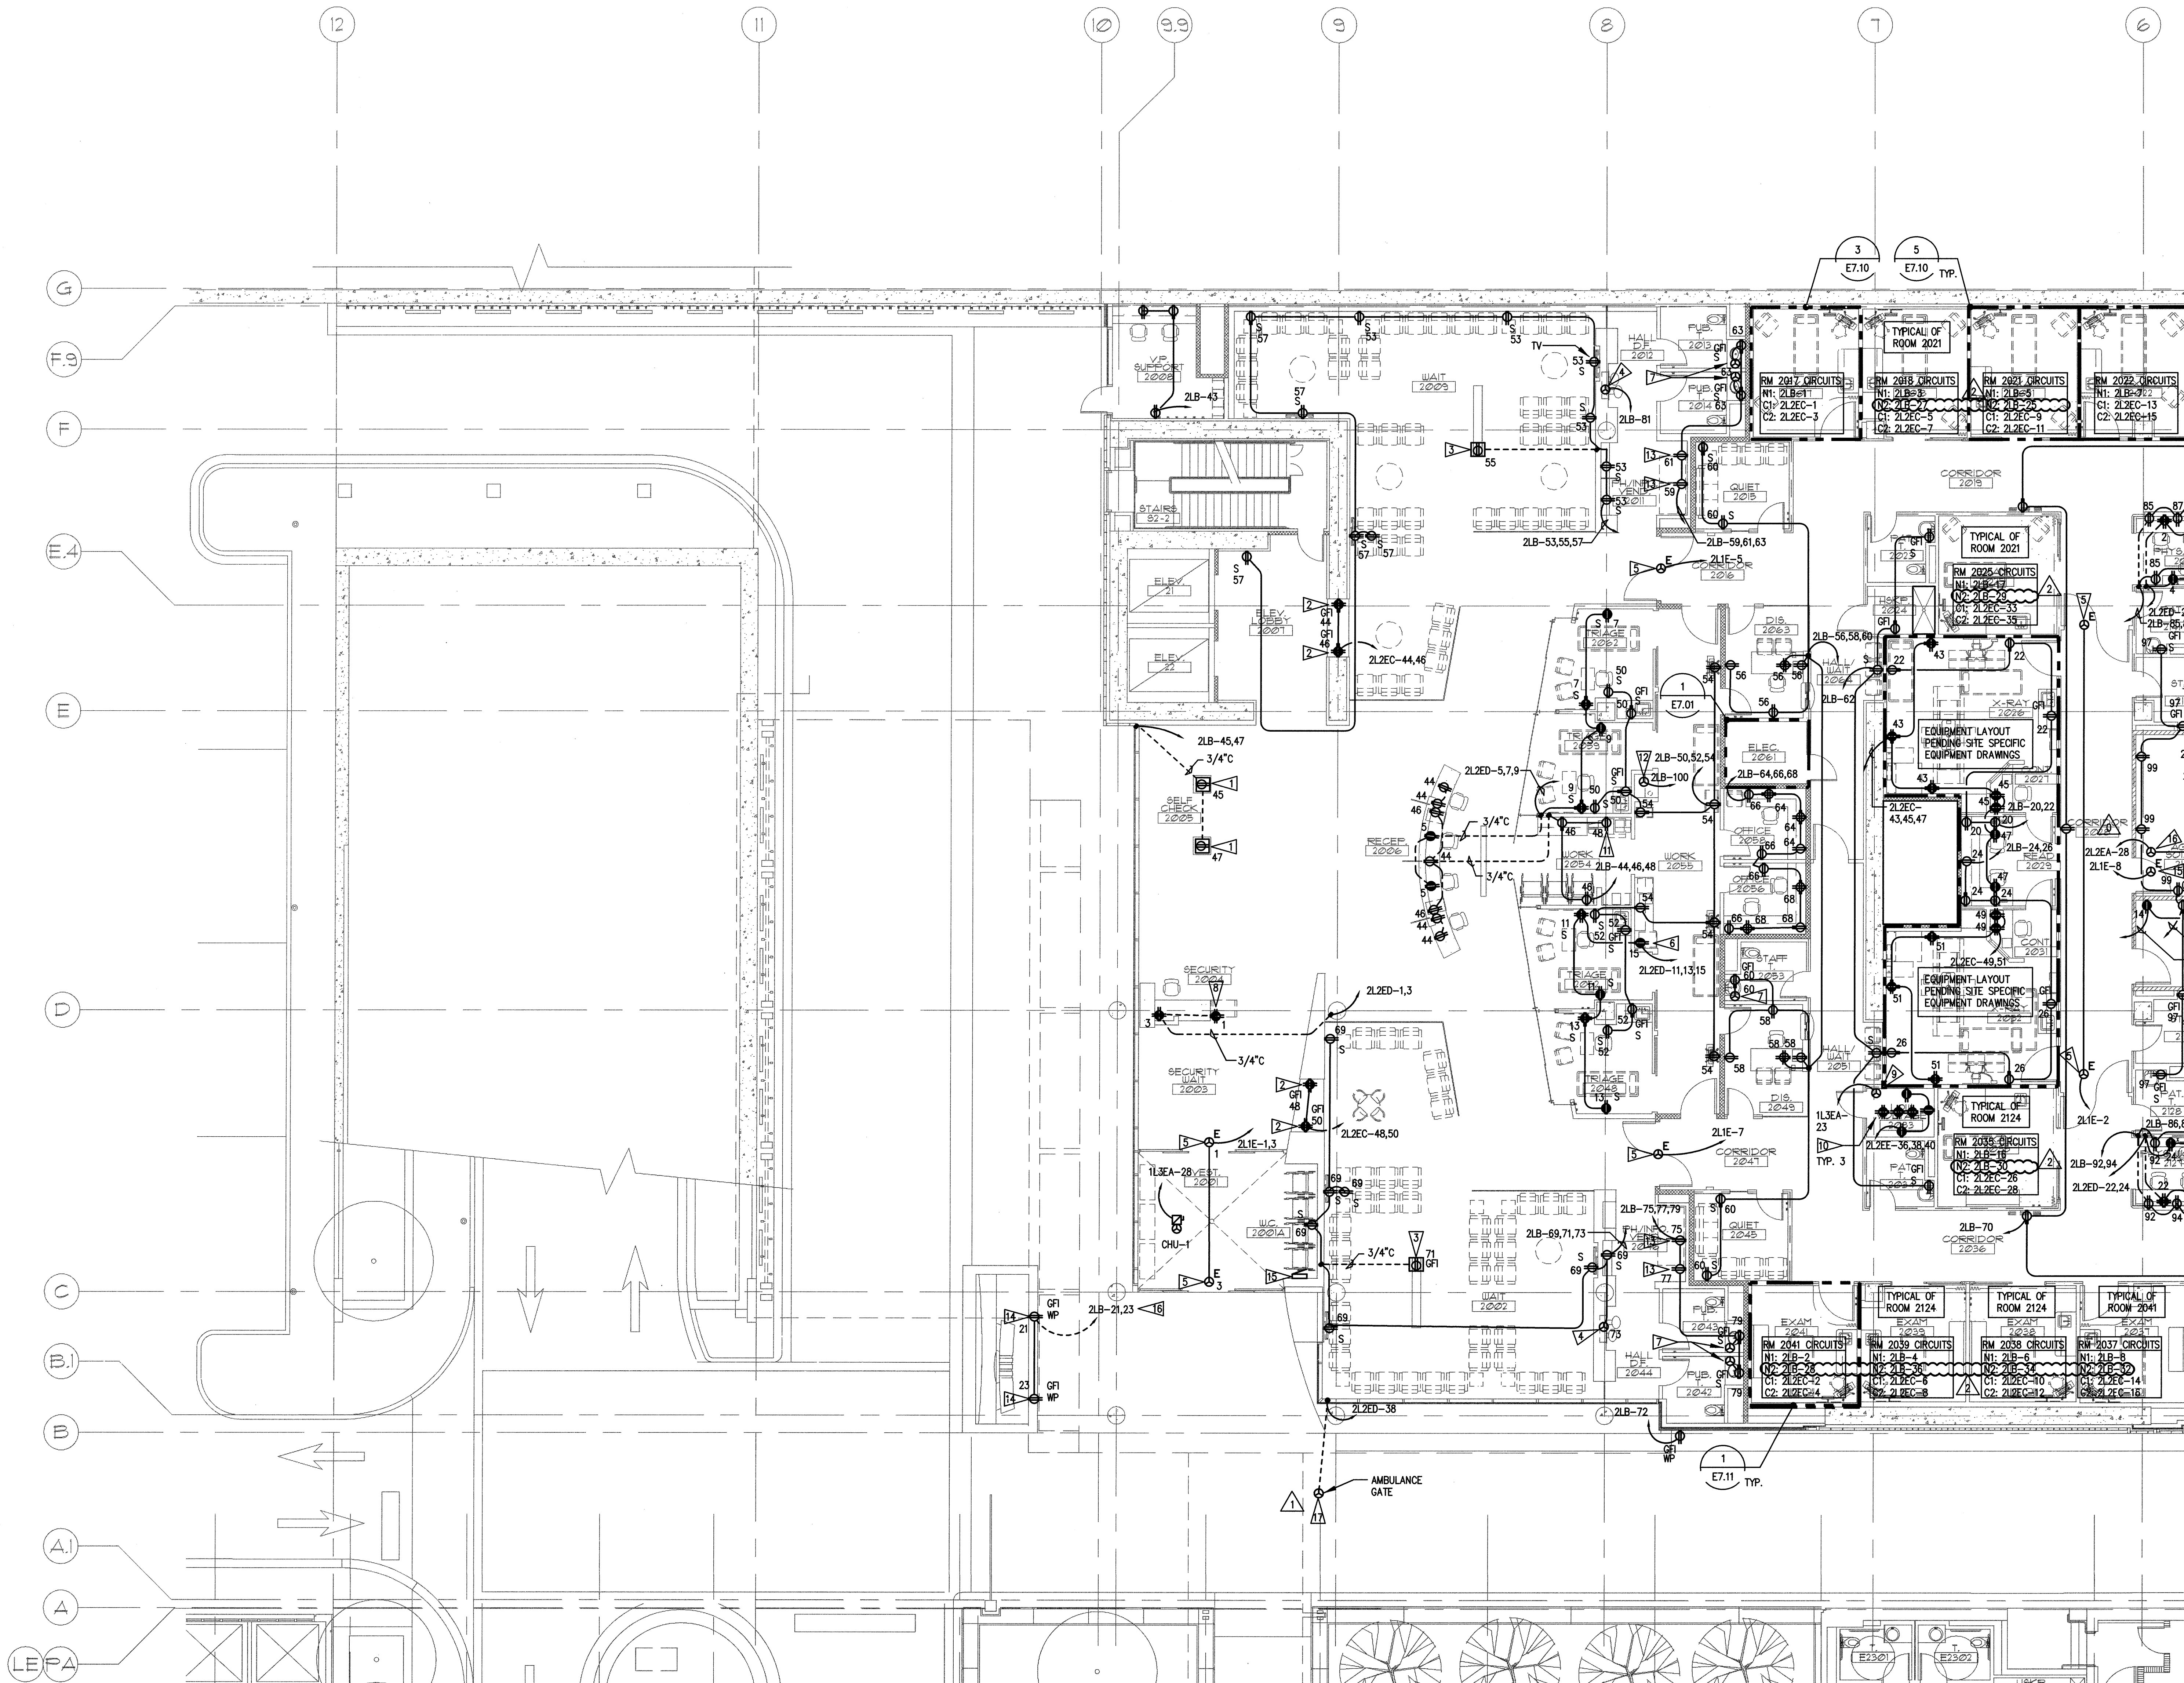


1 SECOND FLOOR PLAN - SOUTH - POWER
 E3.02
 SCALE: AS INDICATED
 0 4 8 16 24
 as indicated feet

N:\B13608\CADD-US\303_E3-02.DWG FEB 13, 2009 - 11:30:53 AM BY: TWHITE

GIFFIN • BOLTE • JURGENS
 ARCHITECTS

815 S.W. SECOND AVENUE • PORTLAND, OREGON 97204
 (503) 223-0992 www.gbjarch.com FAX (503) 294-3961

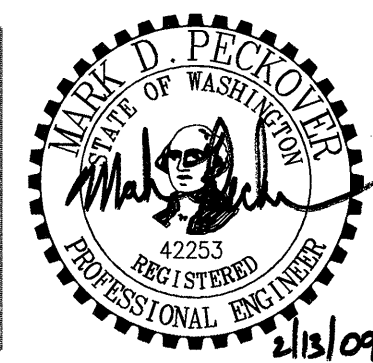

MultiCare

EMERGENCY DEPARTMENT & CANCER CENTER EXPANSION

TACOMA, WASHINGTON

- △ 100% CD SET 9/26/08
- △ CCD #4 12/17/08
- △ CCD #7 2/20/09

Date 09-26-2008
 Scale AS INDICATED
 Drawn By JL
 Job No. 4034

**SECOND FLOOR
 PLAN - SOUTH
 POWER**

**E3
 02**