


A

B


C

D

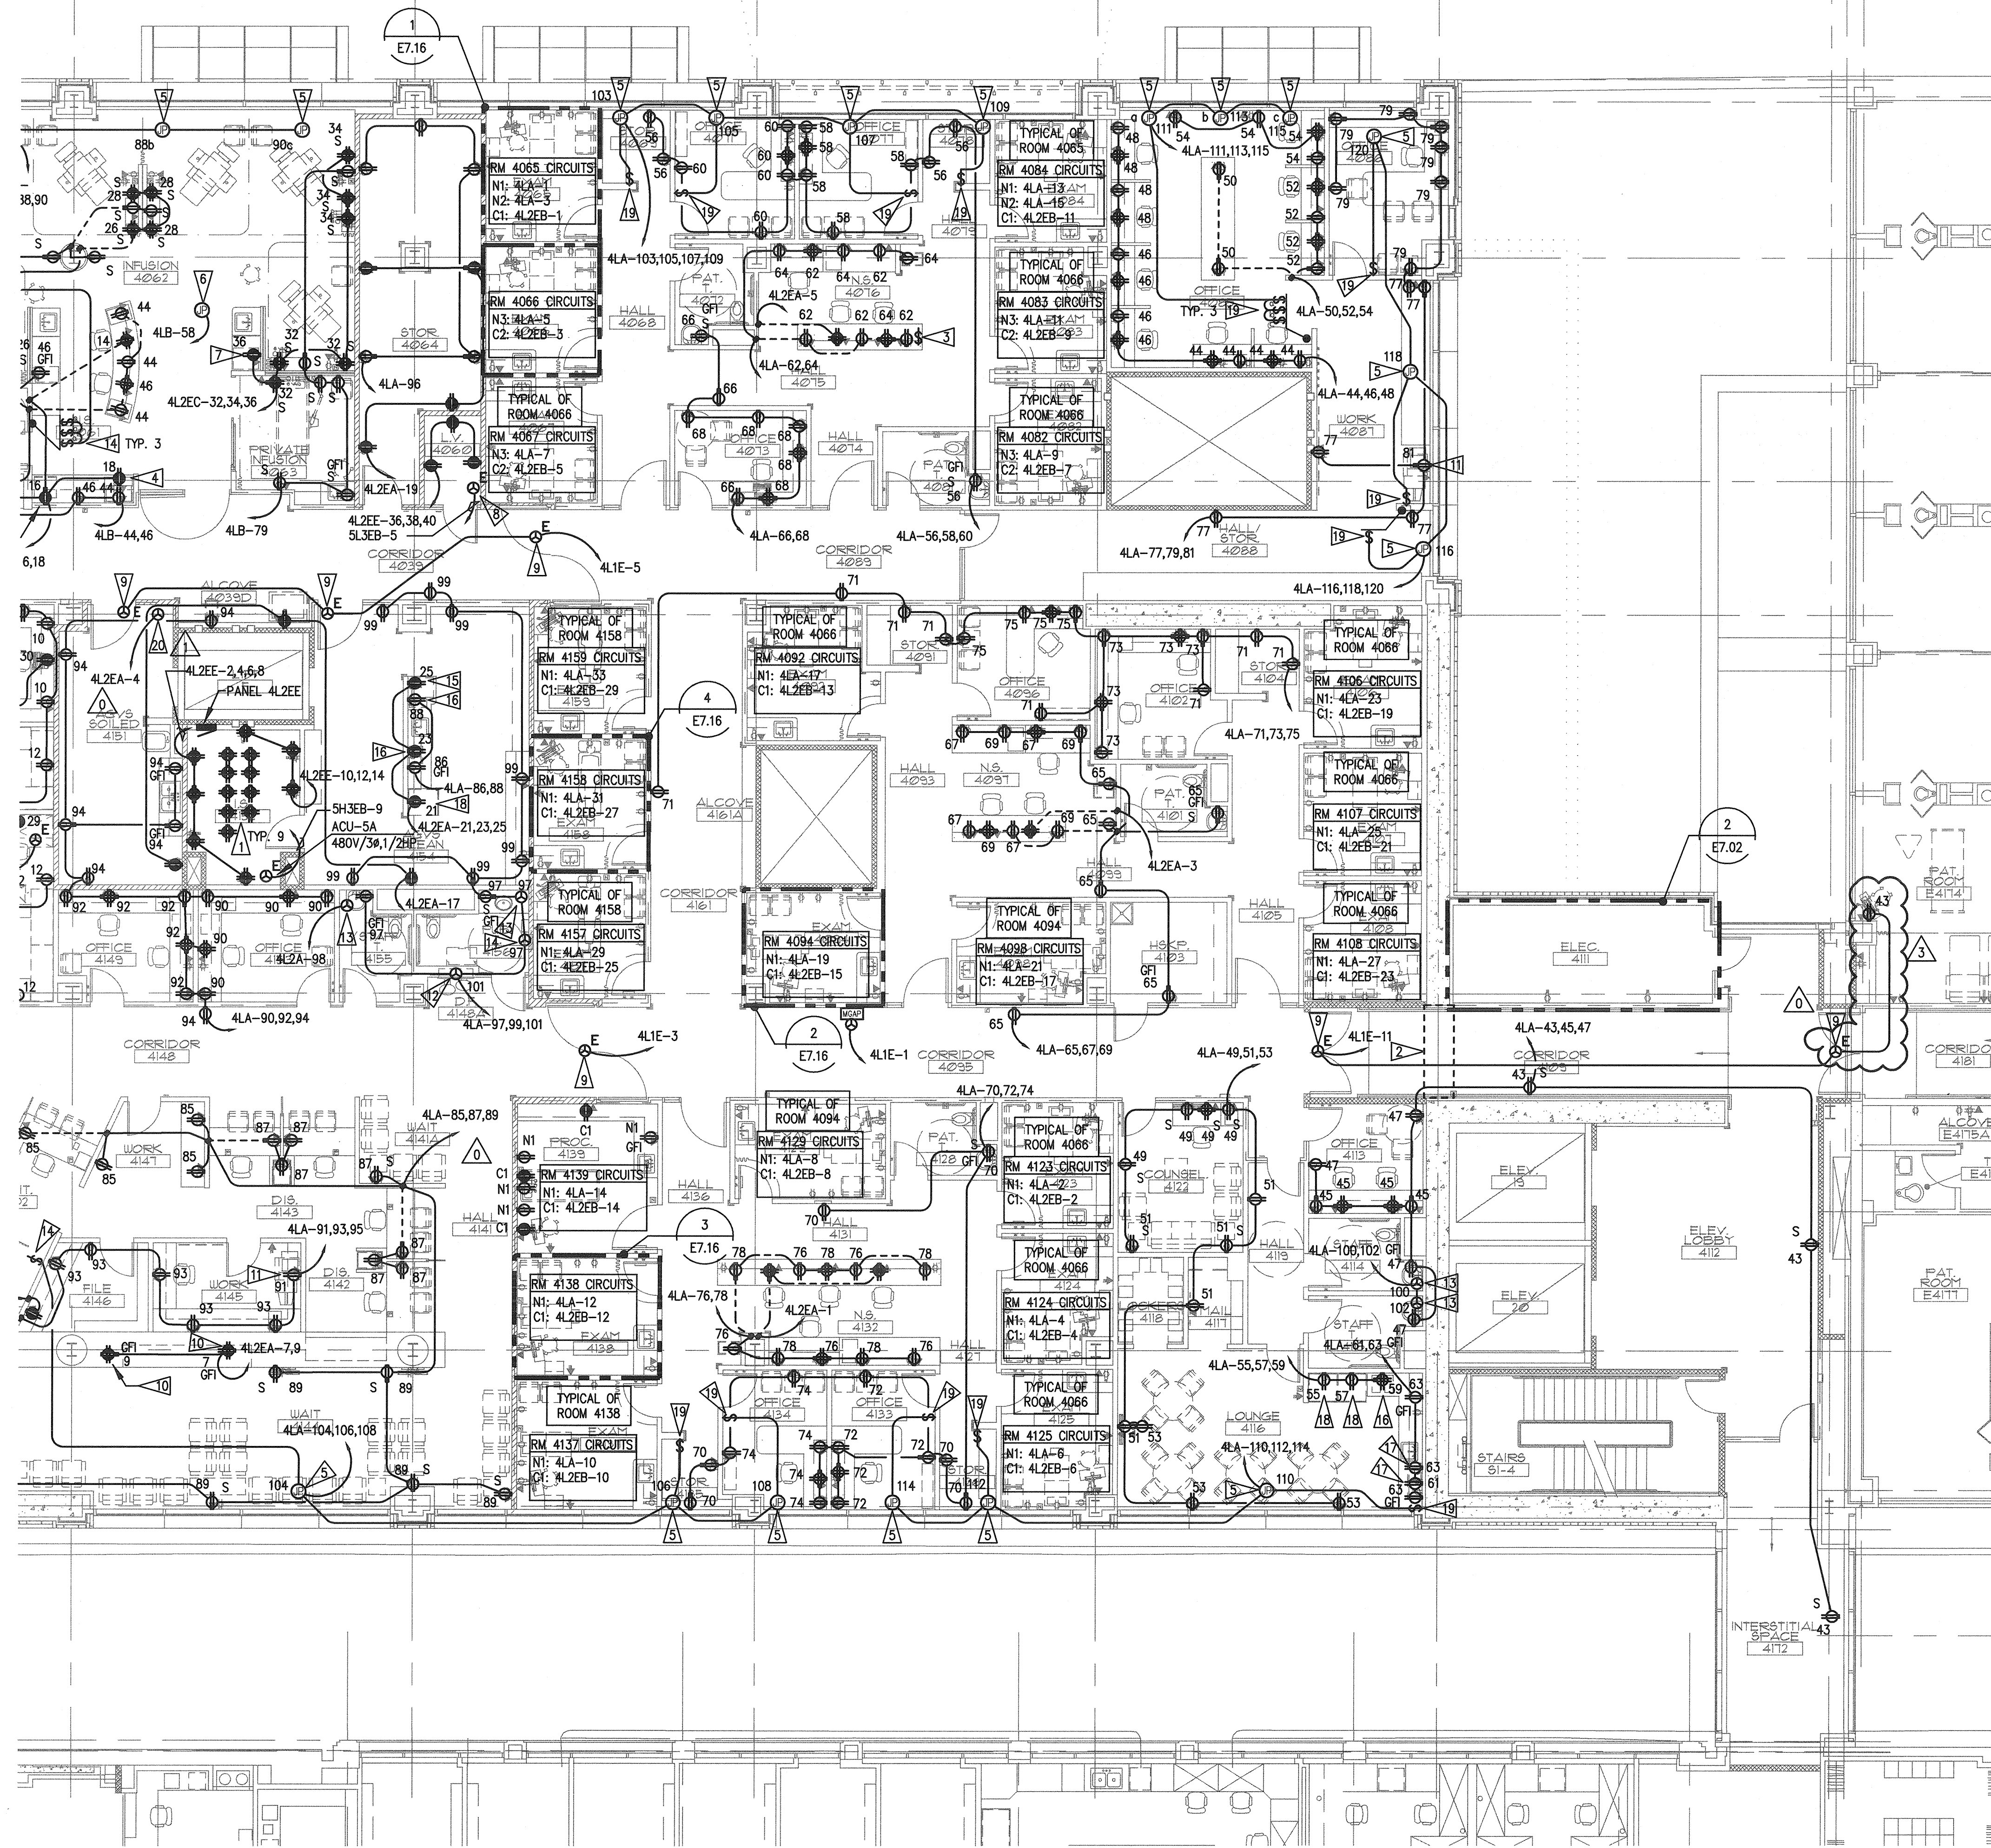

1 FOURTH FLOOR PLAN - NORTH - POWER

E3.14 SCALE: AS INDICATED

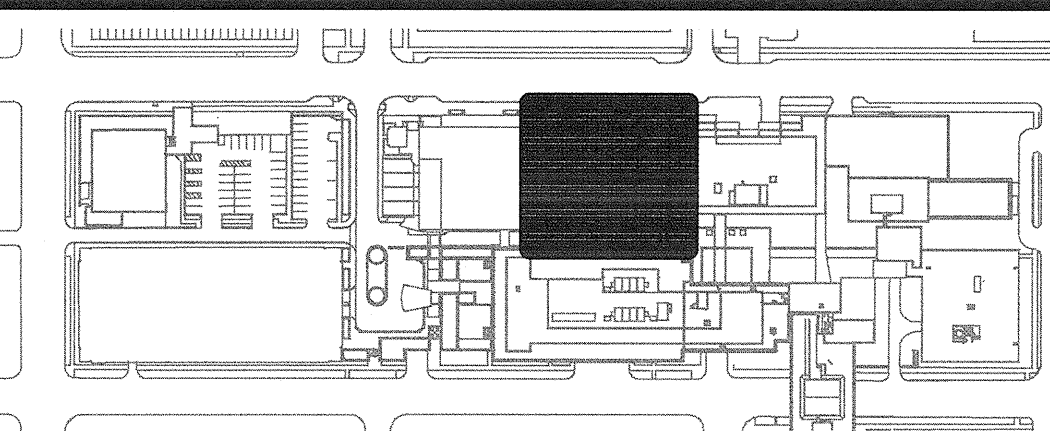

GENERAL NOTES


- SEE ARCHITECTURAL PLANS, SECTIONS AND ELEVATIONS FOR EXACT EQUIPMENT AND DEVICE LOCATIONS, INCLUDING MOUNTING HEIGHTS.
- PROVIDE RED DEVICES AND COVERPLATES FOR DEVICES SERVED FROM EMERGENCY POWER SYSTEM.
- SEE ARCHITECTURAL PLANS FOR LOCATIONS OF SOUND, SMOKE AND FIRE RATED WALLS.
- ABOVE COUNTER RECEPTACLES LOCATED WITHIN 5' OF SINK SHALL BE GFI RATED.
- SEE MECHANICAL DRAWINGS FOR EXACT LOCATION OF MECHANICAL EQUIPMENT. COORDINATE WITH MECHANICAL CONTRACTOR PRIOR TO ROUGH-IN.
- ALL PATIENT CARE AREAS ON FOURTH FLOOR PLAN ARE GENERAL CARE.

FLAG NOTES

- PROVIDE (9) DEDICATED DOUBLE DUPLEX (15-20R) RECEPTACLES MOUNTED ON RACK CABLE TRAY. REFER TO PANEL SCHEDULE 4L2EE FOR DEDICATED CIRCUITS.
- ALL CONDUITS PASSING THROUGH GRID LINE 2 SHALL PASS THROUGH BLOCKOUT IN SHEARWALL.
- PROVIDE AND LOCATE MASTER CONTROL SWITCH FOR MOTORIZED SHADES TO CONTROL WEST EXAM ROOM MOTORIZED SHADES WITHIN NURSE STATION DESK.
- BLANKET WARMER CONNECTION.
- PROVIDE HARD-WIRED CONNECTION FOR ROLLER SHADE MOTOR. COORDINATE EXACT LOCATION WITH ARCHITECT PRIOR TO ROUGH-IN.
- PROVIDE LOW VOLTAGE TRANSFORMER POWER SUPPLY FOR PATIENT TELEHEALTH TV'S. PROVIDE ALL INTERCONNECTING CONDUIT AND WIRING.
- PYXIS CONNECTION.
- PROVIDE HARD WIRED CONNECTION TO DDC CONTROL PANEL FOR CONTROL CIRCUIT.
- PROVIDE HARD WIRED CONNECTION TO AUTO-DOOR MOTOR. PROVIDE ALL REQUIRED CONDUIT, WIRING AND ELECTRICAL DOOR HARDWARE. CONFIRM REQUIREMENTS WITH ARCHITECTURAL DOOR HARDWARE SCHEDULE.
- CONFIRM EXACT LOCATION FOR AQUARIUM RECEPTACLE WITH ARCHITECT PRIOR TO ROUGH IN.
- PHOTO COPIER CONNECTION.
- PROVIDE HARD WIRED CONNECTION TO WATER CHILLER FOR DRINKING FOUNTAIN.
- PROVIDE HARD WIRED CONNECTION TO AUTO-SINK SENSOR.
- PROVIDE HARD WIRED CONNECTION TO HAND DRYER.
- ICE MACHINE CONNECTION.
- COFFEE MACHINE CONNECTION.
- MICROWAVE CONNECTION.
- REFRIGERATOR CONNECTION.
- ROLLER SHADE SWITCH IS PROVIDED BY VENDOR. INSTALLED BY DIVISION 28. COORDINATE BOX SIZE AND CONDUCTOR TERMINATION REQUIREMENTS WITH MANUFACTURER PRIOR TO ROUGH-IN. COORDINATE EXACT SWITCH LOCATION WITH ARCHITECT.
- AGVS CONTROL PANEL CONNECTION COORDINATE WITH AGVS DRAWINGS AND ARCHITECT PRIOR TO ROUGH-IN.

GIFFIN • BOLTE • JURGENS
ARCHITECTS

815 S.W. SECOND AVENUE, PORTLAND, OREGON 97204
(503) 223-0992 www.gbjarch.com FAX (503) 294-3961

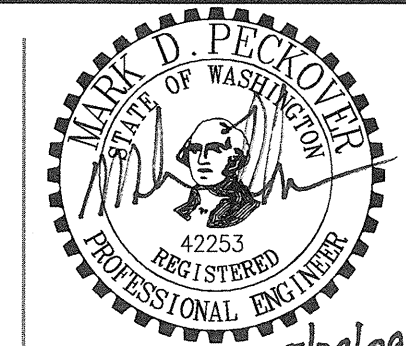

MultiCare
EMERGENCY DEPARTMENT & CANCER CENTER EXPANSION

TACOMA, WASHINGTON

- 100% CD SET 9/26/08
- CCD #4 12/17/08
- CCD #13 5/04/09
- CCD #14 5/26/09

Date 09-26-2008
Scale AS INDICATED
Drawn By JL
Job No. 4034

FOURTH FLOOR
PLAN - NORTH
POWER

E3
14