


N:\13608\CADD-05\413.E4-25.DWG SEP 25, 2008 - 11:35:40 AM BY: TWHITE

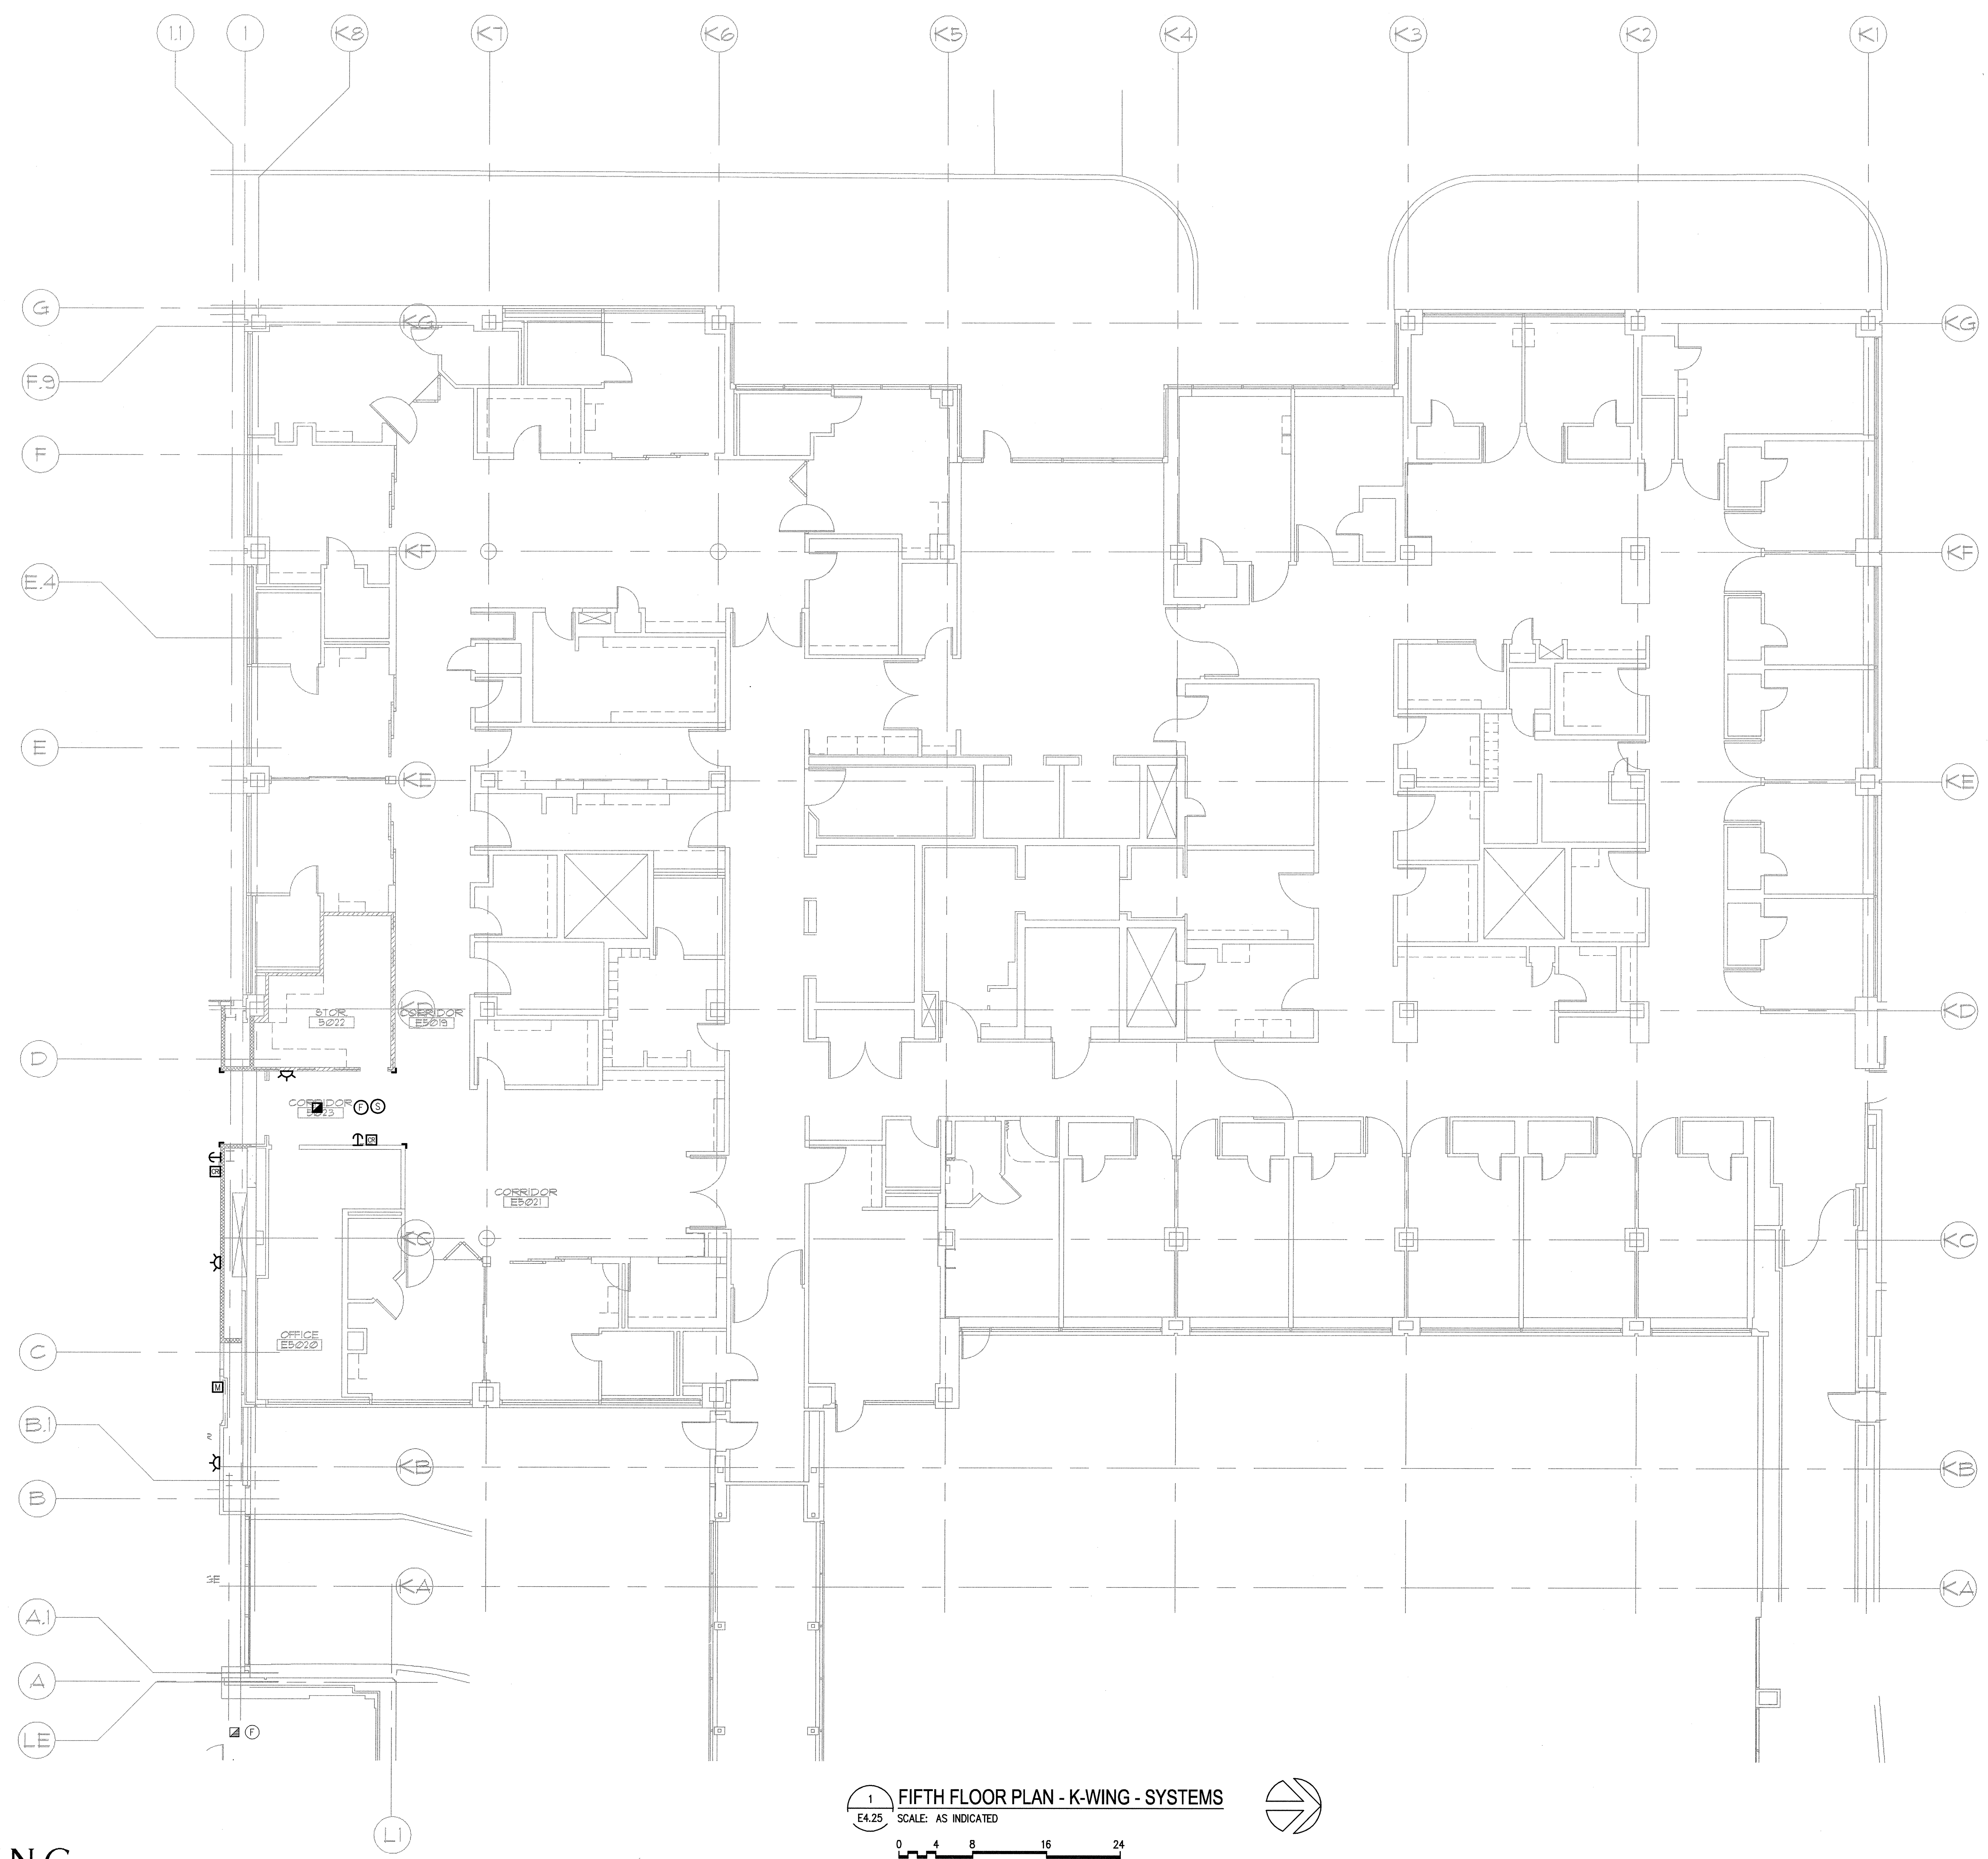


1 FIFTH FLOOR PLAN - K-WING - SYSTEMS  
E4.25  
SCALE: AS INDICATED  
0 4 8 16 24  
as indicated feet

- GENERAL NOTES**
1. SEE ARCHITECTURAL PLANS, SECTIONS AND ELEVATIONS FOR EXACT EQUIPMENT AND DEVICE LOCATIONS.
  2. SEE ARCHITECTURAL PLANS FOR LOCATIONS OF SOUND, SMOKE AND FIRE RATED WALLS.
  3. REFER TO MECHANICAL DRAWINGS FOR FIRE/SMOKE DAMPER LOCATIONS. PROVIDE FIRE ALARM MONITORING POINT FOR EACH FIRE/SMOKE DAMPER.
  4. CONTRACTOR SHALL OBTAIN THE FINAL OWNER APPROVED HILLROM NURSE CALL SHOP DRAWINGS PRIOR TO ROUGH-IN.
- FLAG NOTES**
- NOTE.

**SPARLING**  
ELECTRICAL ENGINEERING | TECHNOLOGY CONSULTING

**GIFFIN • BOLTE • JURGENS**  
ARCHITECTS  
815 S.W. SECOND AVENUE • PORTLAND, OREGON 97204  
(503) 223-0992 www.gbjaarch.com FAX (503) 294-3961

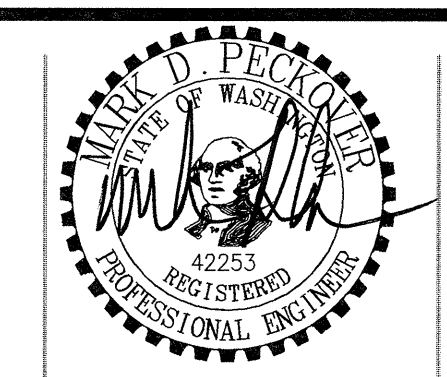

**MultiCare**  
EMERGENCY DEPARTMENT & CANCER CENTER EXPANSION  
TACOMA, WASHINGTON

Date 09-26-2008  
Scale AS INDICATED  
Drawn By JL  
Job No. 4034

**FIFTH FLOOR  
PLAN - K-WING  
SYSTEMS**

**E4  
25**