


N:\B13608\CAD-05\402_E4-L-31.DWG DEC 18, 2008 - 11:42:27 AM BY: JLU

A
B
C
D
E

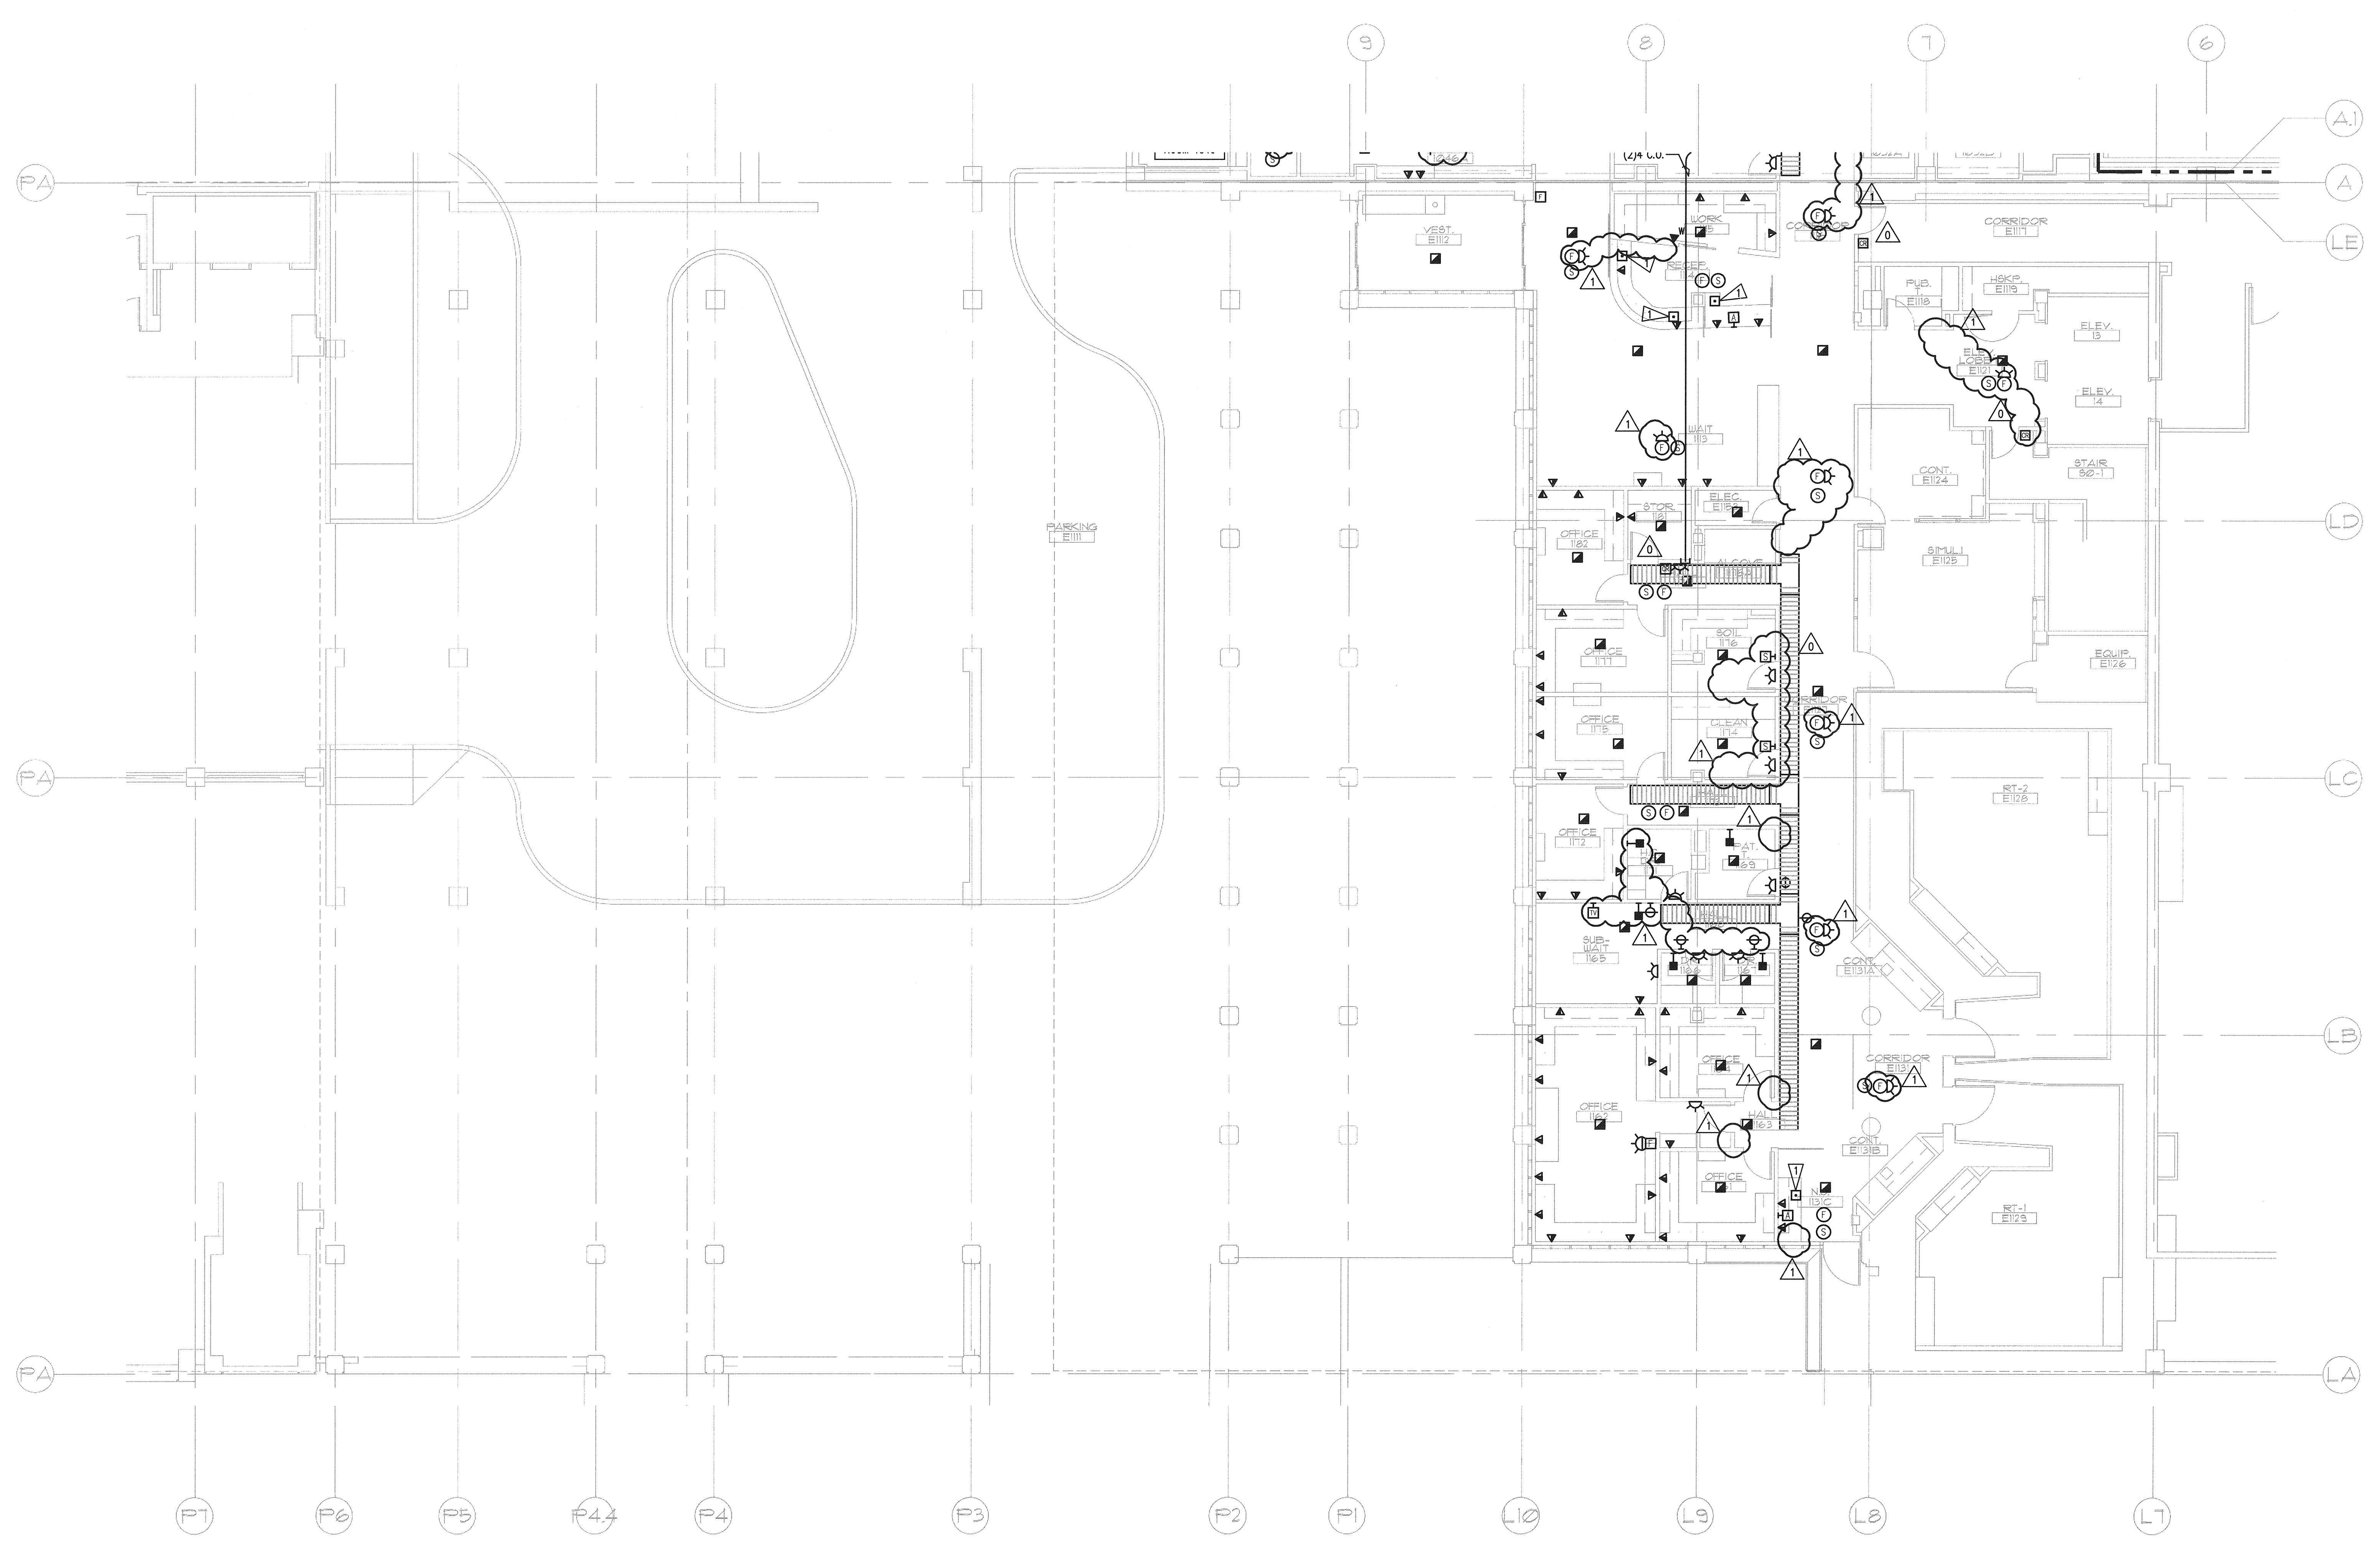

1 FIRST FLOOR PLAN - L-WING - SYSTEMS
E4.31
SCALE: AS INDICATED
0 4 8 16 24
as indicated feet

- GENERAL NOTES**
1. SEE ARCHITECTURAL PLANS, SECTIONS AND ELEVATIONS FOR EXACT EQUIPMENT AND DEVICE LOCATIONS.
 2. SEE ARCHITECTURAL PLANS FOR LOCATIONS OF SOUND, SMOKE AND FIRE RATED WALLS.
 3. REFER TO MECHANICAL DRAWINGS FOR FIRE/SMOKE DAMPER LOCATIONS. PROVIDE FIRE ALARM MONITORING POINT FOR EACH FIRE/SMOKE DAMPER.
 4. CONTRACTOR SHALL OBTAIN THE FINAL OWNER APPROVED HILLROM NURSE CALL SHOP DRAWINGS PRIOR TO ROUGH-IN.
- FLAG NOTES**
- △ PANIC BUTTON CONNECTION.