



SSH JV

Milpitas Station Design Unit 023 Readiness for Construction General Sheets

SVBX C700

Wednesday, July 10, 2013

HALF SIZE
COPY

 



TYLIN INTERNATIONAL
engineers | planners | scientists

SVBX C700
RFC UNRESOLVED ISSUES

Design Unit: DU 023 - MILPITAS STATION, POC, ANCILLARY BLDG. & BUS TRANSIT CENTER									Updated
DU	ID	Issue	Description	Resolution Strategy	Affected Disciplines	Status	BIC	Notes	Updated
023	020	Community Wall	Elimination of the Community wall at the Crossings	Being negotiated on the C700/D720 scope exchange matrix. C720 will not show on RFC drawings.	C, S	OPN	SSHJV		6/25/13
023	025	Storm Drain at Crossings	Storm drain and associated easements (utility and TCE) per current negotiations	SSHJV to provide updated PAR by 6/7/13.	C, L	OPN	SSHJV		6/5/13
023	035	Access Gate at Crossings	Finalized location and grades for vehicle access gate adjacent to Chevron enclosure.	Internal SSHJV coordination issue.	C, L	OPN	SSHJV		6/25/13
023	036	Double Wall at Crossings Trench	Modify wall configuration to eliminate double wall condition	Awaiting direction form VTA	C, L	OPN	VTA		6/25/13
023	037	SLPA Location	SSHJV's proposal to modify SLPA location for better accoustical coverage	RFI #366 issued.	A, S, L, Syst	OPN	VTA		6/25/13
023	038	Lighting Control System	Final Lighting Control Configuration Finalization	Final configuration will be part of a construction submittal.	E	OPN	SSHJV		7/3/13
023	039	Duct Bank Coordination	Coordination Interface of Systems Duct Bank with Structures and Plubming	Internal SSHJV coordination issue.	S, A, P, Syst.	OPN	SSHJV		7/3/13

Jun 26, 2013 5:29pm G:\Current Projects\BART-Berryessa Extension Project\Station - Milpitas\CAD Drawings Out\13-0710 C700 Milpitas Station - RFC Submittal\700-S-DB-X001.dwg

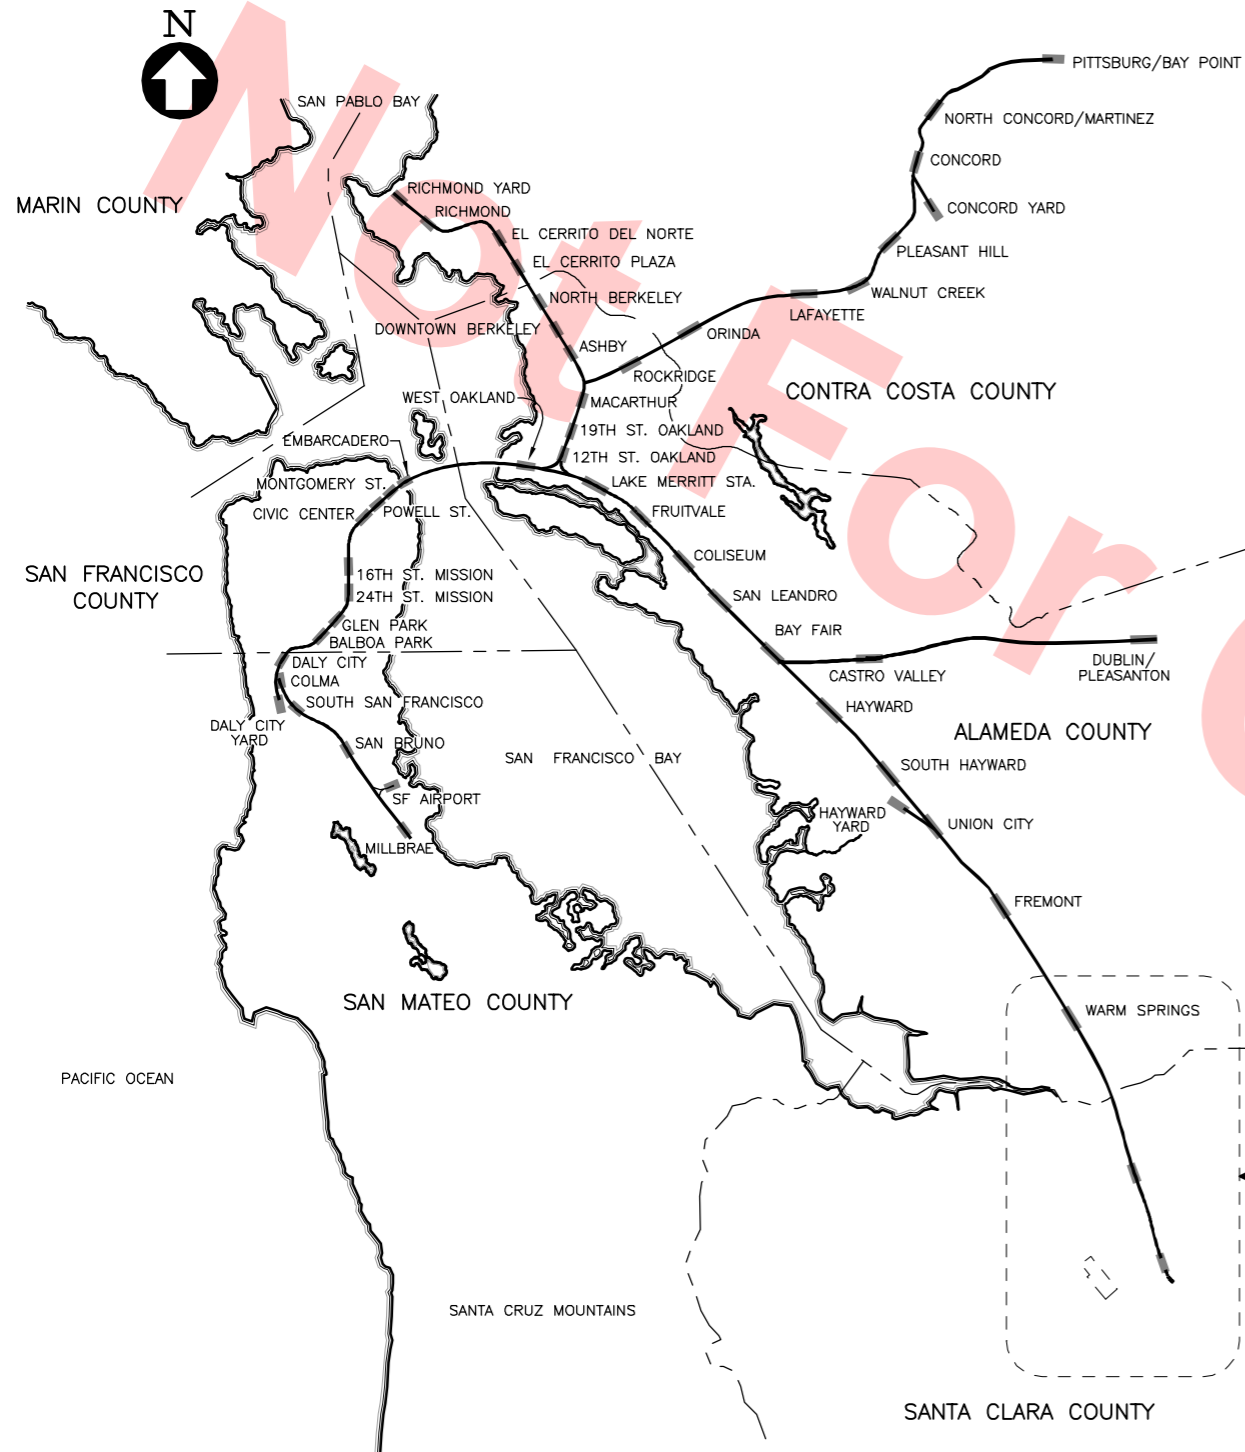



Santa Clara Valley Transportation Authority

NO EXCEPTIONS TAKEN (NET)
MAKE CORRECTIONS NOTED (MCN)
AMEND AND RESUBMIT (A/R)

Any action shown above is subject to the terms of the contract and does not relieve the Contractor of any of its obligations under the contract, including design and detailing.

Contract No.: DB11002F

 By: _____ Date: _____

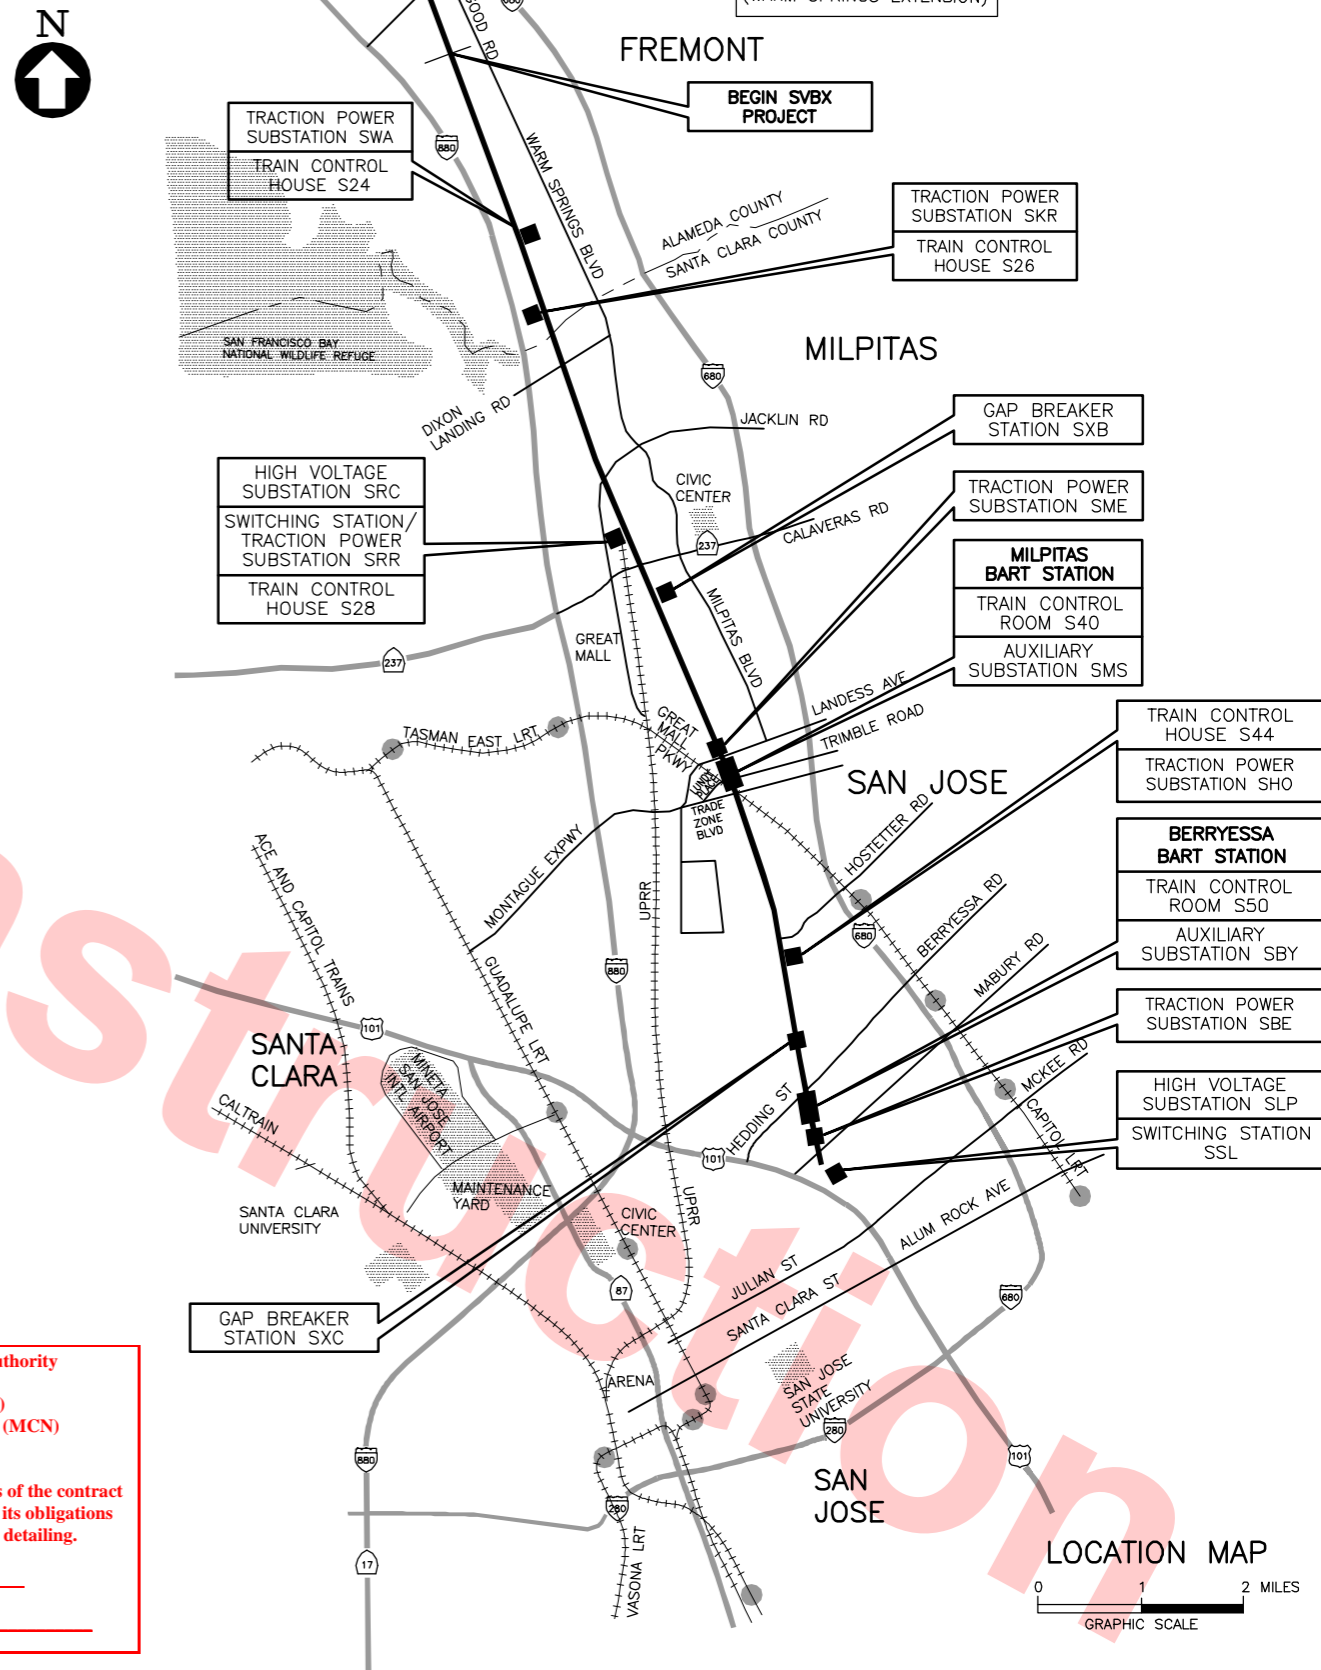

REV	DATE	BY	SUB	APP	DESCRIPTION
0	20130710				READINESS FOR CONSTRUCTION

DESIGNED BY S. DEBNATH	
DRAWN BY J. GALANDEYNES	
CHECKED BY E. BALLADA	
IN CHARGE R. BARLAAN	
DATE 20130710	

Skanska Shimmick Herzog	1436 California Circle Milpitas, California 95035 A Joint Venture
Anil Verma Associates, Inc. 1970 Broadway, Suite 525 Oakland, CA 94612 Phone: (510) 835-2537 Fax: (510) 835-2338	Lookwood, Andrews & Newman, Inc. A L&A BARTY COMPANY
SUBMITTED	APPROVED



LINE, TRACK, STATIONS, AND SYSTEMS
DESIGN UNIT 023
MILPITAS STATION
TITLE SHEET

CADD FILENAME C700-S-DB-X001.dwg	
SIZE D	SCALE AS NOTED
CONTRACT NO. C700	REV. 0
AREA CODE DB	SHEET NO. X001
	PAGE NO. 0001

Jul 09, 2013 - 9:45am G:\Current Projects\VT-Berryessa Extension Project\Station - Milpitas\CAD Drawings 04\13-0710 C700 Milpitas Station - RFC Submitt\700-S-DB-X027.dwg JosephG

PAGE NO.	DWG NO.	REV NO.	TITLE	PAGE NO.	DWG NO.	REV NO.	TITLE	PAGE NO.	DWG NO.	REV NO.	TITLE	PAGE NO.	DWG NO.	REV NO.	TITLE
GENERAL – MILPITAS STATION, ANCILLARY BUILDING, TRANSIT CENTER BUS SHELTER AND MONTAGUE LRT & MILPITAS POC				0029	DB–C130	0	LAYOUT DETAILS SHEET 1 OF 3	0059	DB–C281	0	PAVEMENT PLAN SHEET 2 OF 2	0086	DB–U410	0	UTILITY RELOCATION PLAN (WATER AND FIRE) SHEET 1 OF 3
0001	DB–X001	0	TITLE SHEETS	0030	DB–C131	0	LAYOUT DETAILS SHEET 2 OF 3	0060	DB–C282	0	PAVING DETAILS SHEET 1 OF 2	0087	DB–U412	0	UTILITY RELOCATION PLAN (WATER AND FIRE) SHEET 2 OF 3
0002	DB–X027	0	INDEX OF DRAWINGS SHEET 1 OF 11	0031	DB–C132	0	LAYOUT DETAILS SHEET 3 OF 3	0061	DB–C283	0	PAVING DETAILS SHEET 2 OF 2	0088	DB–U413	0	UTILITY RELOCATION PLAN (WATER & FIRE) SHEET 3 OF 3
0003	DB–X028	0	INDEX OF DRAWINGS SHEET 2 OF 11	0032	DB–C200	0	GRADING PLAN SHEET 1 OF 4	0062	DB–C300	0	SIGNAGE AND PAVEMENT MARKING PLAN	0089	DB–U430	0	PROFILE – "W01" WATER & FIRE
0004	DB–X029	0	INDEX OF DRAWINGS SHEET 3 OF 11	0033	DB–C201	0	GRADING PLAN SHEET 2 OF 4	0063	DB–C620	0	TYPICAL CROSS SECTIONS SHEET 1 OF 4	0090	DB–U431	0	PROFILE – "W04" WATER & FIRE
0005	DB–X030	0	INDEX OF DRAWINGS SHEET 4 OF 11	0034	DB–C202	0	GRADING PLAN SHEET 3 OF 4	0064	DB–C621	0	TYPICAL CROSS SECTIONS SHEET 2 OF 4	0091	DB–U432	0	PROFILE – "W05" WATER & FIRE
0006	DB–X031	0	INDEX OF DRAWINGS SHEET 5 OF 11	0035	DB–C203	0	GRADING PLAN SHEET 4 OF 4	0065	DB–C622	0	TYPICAL CROSS SECTIONS SHEET 3 OF 4	0092	DB–U433	0	PROFILE – "W02" & "W03" WATER & FIRE
0007	DB–X032	0	INDEX OF DRAWINGS SHEET 6 OF 11	0036	DB–C204	0	DRAINAGE PLAN SHEET 1 OF 4	0066	DB–C623	0	TYPICAL CROSS SECTIONS SHEET 4 OF 4	0093	DB–U900	0	DETAILS
0008	DB–X033	0	INDEX OF DRAWINGS SHEET 7 OF 11	0037	DB–C205	0	DRAINAGE PLAN SHEET 2 OF 4	0067	DB–C700	0	CONSTRUCTION DETAILS LIGHTING POLE FOOTING	LANDSCAPE – MILPITAS STATION, ANCILLARY BUILDING, AND TRANSIT CENTER BUS SHELTER			
0009	DB–X034	0	INDEX OF DRAWINGS SHEET 8 OF 11	0038	DB–C206	0	DRAINAGE PLAN SHEET 3 OF 4	0068	DB–C701	0	CONSTRUCTION DETAILS PEDESTRIAN BARRIER FOOTING	0094	DB–L001	0	DRAWING LAYOUT INDEX
0010	DB–X035	0	INDEX OF DRAWINGS SHEET 9 OF 11	0039	DB–C207	0	DRAINAGE PLAN SHEET 4 OF 4	0069	DB–C702	0	CONSTRUCTION DETAILS FENCE, FOOTING AND CURB WALL	0095	DB–L002	0	GENERAL NOTES AND LEGEND
0011	DB–X036	0	INDEX OF DRAWINGS SHEET 10 OF 11	0040	DB–C210	0	DRAINAGE DETAILS – BIO–RETENTION–A SHEET 1 OF 2	0070	DB–C703	0	CONSTRUCTION DETAILS SCREEN WALL DETAILS SHEET 1 OF 2	0096	DB–L003	0	ADA PATH OF TRAVEL
0012	DB–X037	0	INDEX OF DRAWINGS SHEET 11 OF 11	0041	DB–C211	0	DRAINAGE DETAILS – BIO–RETENTION–A SHEET 2 OF 2	0071	DB–C704	0	CONSTRUCTION DETAILS SCREEN WALL DETAILS SHEET 2 OF 2	0097	DB–L201	0	LAYOUT PLAN – HARDSCAPE SHEET 1 OF 4
				0042	DB–C212	0	DRAINAGE DETAILS – WATER TREATMENT BASIN SHEET 1 OF 2	0072	DB–C705	0	CONSTRUCTION DETAILS CURB WALL	0098	DB–L202	0	LAYOUT PLAN – HARDSCAPE SHEET 2 OF 4
DEMOLITION – MONTAGUE LRT AND MILPITAS POC				0043	DB–C213	0	DRAINAGE DETAILS – WATER TREATMENT BASIN SHEET 2 OF 2	0073	DB–C706	0	CONSTRUCTION DETAILS FENCE AND FOOTING DETAILS	0099	DB–L203	0	LAYOUT PLAN – HARDSCAPE SHEET 3 OF 4
0013	DB–D900	0	LRT DEMOLITION NOTES	0044	DB–C214	0	DRAINAGE DETAILS – DETENTION BASIN SHEET 1 OF 3	CIVIL – MONTAGUE LRT AND MILPITAS POC				0100	DB–L204	0	LAYOUT PLAN – HARDSCAPE SHEET 4 OF 4
0014	DB–D901	0	DEMOLITION PLANS	0045	DB–C215	0	DRAINAGE DETAILS – DETENTION BASIN SHEET 2 OF 3	0074	DB–C901	0	SITE, GRADING AND DRAINAGE PLAN SHEET 1 OF 2	0101	DB–L251	0	CONSTRUCTION DETAILS SHEET 1 OF 15
0015	DB–D902	0	LRT STAIR DEMOLITION SECTION	0046	DB–C216	0	DRAINAGE DETAILS – DETENTION BASIN SHEET 3 OF 3	0075	DB–C902	0	SITE, GRADING AND DRAINAGE PLAN SHEET 2 OF 2	0102	DB–L252	0	CONSTRUCTION DETAILS SHEET 2 OF 15
0016	DB–D903	0	LRT EMERGENCY EXIT STAIR DEMOLITION PLANS	0047	DB–C217	0	DRAINAGE DETAILS – BIO–RETENTION–B SHEET 1 OF 3	UTILITIES – MILPITAS STATION, ANCILLARY BUILDING, TRANSIT CENTER BUS SHELTER, AND MONTAGUE LRT AND MILPITAS POC				0103	DB–L253	0	CONSTRUCTION DETAILS SHEET 3 OF 15
0017	DB–D904	0	LRT EMERGENCY EXIT STAIR DEMOLITION SECTION	0048	DB–C218	0	DRAINAGE DETAILS – BIO–RETENTION–B SHEET 2 OF 3	0076	DB–U001	0	SUPPLEMENTAL UTILITY NOTES, ABBREVIATIONS AND SYMBOLS	0104	DB–L254	0	CONSTRUCTION DETAILS SHEET 4 OF 15
CIVIL – MILPITAS STATION, ANCILLARY BUILDING, AND TRANSIT CENTER BUS SHELTER)				0049	DB–C219	0	DRAINAGE DETAILS – BIO–RETENTION–B SHEET 3 OF 3	0077	DB–U010	0	UTILITY DRAWING LAYOUT INDEX	0105	DB–L255	0	CONSTRUCTION DETAILS SHEET 5 OF 15
0018	DB–C001	0	DRAWING LAYOUT INDEX	0050	DB–C220	0	DRAINAGE DETAILS – MISCELLANEOUS SHEET 1 OF 3	0078	DB–U010	0	COMPOSITE UTILITY PLAN SHEET 1 OF 4	0106	DB–L256	0	CONSTRUCTION DETAILS SHEET 6 OF 15
0019	DB–C002	0	ABBREVIATIONS, NOTES AND LEGEND	0051	DB–C221	0	DRAINAGE DETAILS – MISCELLANEOUS SHEET 2 OF 3	0079	DB–U111	0	COMPOSITE UTILITY PLAN SHEET 2 OF 4	0107	DB–L257	0	CONSTRUCTION DETAILS SHEET 7 OF 15
0020	DB–C110	0	SITE PLAN SHEET 1 OF 4	0052	DB–C222	0	DRAINAGE DETAILS – MISCELLANEOUS SHEET 3 OF 3	0080	DB–U112	0	COMPOSITE UTILITY PLAN SHEET 3 OF 4	0108	DB–L258	0	CONSTRUCTION DETAILS SHEET 8 OF 15
0021	DB–C111	0	SITE PLAN SHEET 2 OF 4	0053	DB–C240	0	DRAINAGE DETAILS – BIO–RETENTION–C SHEET 1 OF 2	0081	DB–U113	0	COMPOSITE UTILITY PLAN SHEET 4 OF 4	0109	DB–L259	0	CONSTRUCTION DETAILS SHEET 9 OF 15
0022	DB–C112	0	SITE PLAN SHEET 3 OF 4	0054	DB–C241	0	DRAINAGE DETAILS – BIO–RETENTION–C SHEET 2 OF 2	0082	DB–U310	0	UTILITY RELOCATION PLAN (SANITARY SEWER) SHEET 1 OF 3	0110	DB–L260	0	CONSTRUCTION DETAILS SHEET 10 OF 15
0023	DB–C113	0	SITE PLAN SHEET 4 OF 4	0055	DB–C242	0	DRAINAGE DETAILS – BIO–RETENTION–D SHEET 1 OF 2	0083	DB–U312	0	UTILITY RELOCATION PLAN (SANITARY SEWER) SHEET 2 OF 3	0111	DB–L261	0	CONSTRUCTION DETAILS SHEET 11 OF 15
0024	DB–C120	0	LAYOUT PLAN SHEET 1 OF 4	0056	DB–C243	0	DRAINAGE DETAILS – BIO–RETENTION–D SHEET 2 OF 2	0084	DB–U313	0	UTILITY RELOCATION PLAN (SANITARY SEWER) SHEET 3 OF 3	0112	DB–L262	0	CONSTRUCTION DETAILS SHEET 12 OF 15
0025	DB–C121	0	LAYOUT PLAN SHEET 2 OF 4	0057	DB–C250	0	DRAINAGE PROFILE	0085	DB–U330	0	PROFILE – "SS2" SANITARY SEWER	0113	DB–L263	0	CONSTRUCTION DETAILS SHEET 13 OF 15
0026	DB–C122	0	LAYOUT PLAN SHEET 3 OF 4	0058	DB–C280	0	PAVEMENT PLAN SHEET 1 OF 2					0114	DB–L264	0	CONSTRUCTION DETAILS SHEET 14 OF 15
0027	DB–C123	0	LAYOUT PLAN SHEET 4 OF 4									0115	DB–L265	0	CONSTRUCTION DETAILS SHEET 15 OF 15
0028	DB–C124	0	LINE AND CURVE TABLE												

Jul 11, 2013 - 8:48am G:\Current Projects\Berrysessa Extension Project\Station - Milpitas\CAD Drawings 04\13-0710 C700 Milpitas Station - RFC Submit\700-S-DB-X028.dwg JosephG

PAGE NO.	DWG NO.	REV NO.	TITLE	PAGE NO.	DWG NO.	REV NO.	TITLE	PAGE NO.	DWG NO.	REV NO.	TITLE	PAGE NO.	DWG NO.	REV NO.	TITLE	
0116	DB-L300	0	IRRIGATION NOTES, CALCULATIONS, AND LEGEND	0145	DB-S110	0	KEY PLAN PLATFORM LEVEL	0177	DB-S145	0	ROOF LEVEL FRAMING PLAN SHEET 5 OF 9	0206	DB-S511	0	STEEL BRACED FRAME ELEVATIONS AND DETAILS SHEET 11 OF 11	
0117	DB-L301	0	IRRIGATION PLAN SHEET 1 OF 4	0146	DB-S111	0	PLATFORM LEVEL FRAMING PLAN SHEET 1 OF 7	0178	DB-S146	0	ROOF LEVEL FRAMING PLAN SHEET 6 OF 9	0207	DB-S520	0	MISCELLANEOUS STEEL FRAME AND DETAILS SHEET 1 OF 1	
0118	DB-L302	0	IRRIGATION PLAN SHEET 2 OF 4	0147	DB-S112	0	PLATFORM LEVEL FRAMING PLAN SHEET 2 OF 7	0179	DB-S147	0	ROOF LEVEL FRAMING PLAN SHEET 7 OF 9	0208	DB-S601	0	MAT AND PLATFORM FRAMING SECTIONS AND DETAILS SHEET 1 OF 4	
0119	DB-L303	0	IRRIGATION PLAN SHEET 3 OF 4	0148	DB-S113	0	PLATFORM LEVEL FRAMING PLAN SHEET 3 OF 7	0180	DB-S148	0	ROOF LEVEL FRAMING PLAN SHEET 8 OF 9	0209	DB-S602	0	MAT AND PLATFORM FRAMING SECTIONS AND DETAILS SHEET 2 OF 4	
0120	DB-L304	0	IRRIGATION PLAN SHEET 4 OF 4	0149	DB-S114	0	PLATFORM LEVEL FRAMING PLAN SHEET 4 OF 7	0181	DB-S149	0	ROOF LEVEL FRAMING PLAN SHEET 9 OF 9	0210	DB-S603	0	MAT AND PLATFORM FRAMING SECTIONS AND DETAILS SHEET 3 OF 4	
0121	DB-L351	0	IRRIGATION DETAILS SHEET 1 OF 5	0150	DB-S115	0	PLATFORM LEVEL FRAMING PLAN SHEET 5 OF 7	SECTIONS	0182	DB-S200	0	KEY LONGITUDINAL SECTION	0211	DB-S604	0	MAT AND PLATFORM FRAMING SECTIONS AND DETAILS SHEET 4 OF 4
0122	DB-L352	0	IRRIGATION DETAILS SHEET 2 OF 5	0151	DB-S116	0	PLATFORM LEVEL FRAMING PLAN SHEET 6 OF 7		0183	DB-S201X	0	LONGITUDINAL SECTION SHEET 1 OF 6	0212	DB-S610	0	TYPICAL SECTION
0123	DB-L353	0	IRRIGATION DETAILS SHEET 3 OF 5	0152	DB-S117	0	PLATFORM LEVEL FRAMING PLAN SHEET 7 OF 7		0184	DB-S202X	0	LONGITUDINAL SECTION SHEET 2 OF 6	0213	DB-S611	0	TYPICAL SECTION DETAILS SHEET 1 OF 4
0124	DB-L354	0	IRRIGATION DETAILS SHEET 4 OF 5	0153	DB-S120	0	KEY PLAN FOUNDATION AND CONCOURSE FRAMING		0185	DB-S203X	0	LONGITUDINAL SECTION SHEET 3 OF 6	0214	DB-S612	0	TYPICAL SECTION DETAILS SHEET 2 OF 4
0125	DB-L355	0	IRRIGATION DETAILS SHEET 5 OF 5	0154	DB-S121	0	FOUNDATION AND CONCOURSE FRAMING PLAN SHEET 1 OF 9		0186	DB-S204X	0	LONGITUDINAL SECTION SHEET 4 OF 6	0215	DB-S613	0	TYPICAL SECTION DETAILS SHEET 3 OF 4
0126	DB-L400	0	PLANTING NOTES AND LEGEND	0155	DB-S122	0	FOUNDATION AND CONCOURSE FRAMING PLAN SHEET 2 OF 9	0187	DB-S205X	0	LONGITUDINAL SECTION SHEET 5 OF 6	0216	DB-S614	0	TYPICAL SECTION DETAILS SHEET 4 OF 4	
0127	DB-L401	0	PLANTING PLAN SHEET 1 OF 4	0156	DB-S123	0	FOUNDATION AND CONCOURSE FRAMING PLAN SHEET 3 OF 9	0188	DB-S206X	0	LONGITUDINAL SECTION SHEET 6 OF 6	0217	DB-S641	0	CONCOURSE SECTIONS AND DETAILS SHEET 1 OF 10	
0128	DB-L402	0	PLANTING PLAN SHEET 2 OF 4	0157	DB-S124	0	FOUNDATION AND CONCOURSE FRAMING PLAN SHEET 4 OF 9	0189	DB-S210	0	TRANSVERSE SECTION SHEET 1 OF 7	0218	DB-S642	0	CONCOURSE SECTIONS AND DETAILS SHEET 2 OF 10	
0129	DB-L403	0	PLANTING PLAN SHEET 3 OF 4	0158	DB-S125	0	FOUNDATION AND CONCOURSE FRAMING PLAN SHEET 5 OF 9	0190	DB-S211	0	TRANSVERSE SECTION SHEET 2 OF 7	0219	DB-S643	0	CONCOURSE SECTIONS AND DETAILS SHEET 3 OF 10	
0130	DB-L404	0	PLANTING PLAN SHEET 4 OF 4	0159	DB-S126	0	FOUNDATION AND CONCOURSE FRAMING PLAN SHEET 6 OF 9	0191	DB-S212	0	TRANSVERSE SECTION SHEET 3 OF 7	0220	DB-S644	0	CONCOURSE SECTIONS AND DETAILS SHEET 4 OF 10	
0131	DB-L451	0	PLANTING DETAILS SHEET 1 OF 2	0160	DB-S127	0	FOUNDATION AND CONCOURSE FRAMING PLAN SHEET 7 OF 9	0192	DB-S213	0	TRANSVERSE SECTION SHEET 4 OF 7	0221	DB-S645	0	CONCOURSE SECTIONS AND DETAILS SHEET 5 OF 10	
0132	DB-L452	0	PLANTING DETAILS SHEET 2 OF 2	0161	DB-S128	0	FOUNDATION AND CONCOURSE FRAMING PLAN SHEET 8 OF 9	0193	DB-S214	0	TRANSVERSE SECTION SHEET 5 OF 7	0222	DB-S646	0	CONCOURSE SECTIONS AND DETAILS SHEET 6 OF 10	
LANDSCAPE – MILPITAS LRT STATION AND POC				0162	DB-S129	0	FOUNDATION AND CONCOURSE FRAMING PLAN SHEET 9 OF 9	0194	DB-S215	0	TRANSVERSE SECTION SHEET 6 OF 7	0223	DB-S647	0	CONCOURSE SECTIONS AND DETAILS SHEET 7 OF 10	
STRUCTURAL – MILPITAS STATION				0163	DB-S130	0	KEY PLAN MEZZANINE LEVEL FRAMING	0195	DB-S216	0	TRANSVERSE SECTION SHEET 7 OF 7	0224	DB-S648	0	CONCOURSE SECTIONS AND DETAILS SHEET 8 OF 10	
PLANS				0164	DB-S131	0	EAST ENTRANCE ROOF FRAMING PLAN	MISCELLANEOUS	0196	DB-S501	0	STEEL BRACED FRAME ELEVATIONS AND DETAILS SHEET 1 OF 11	0225	DB-S649	0	CONCOURSE SECTIONS AND DETAILS SHEET 9 OF 10
0134	DB-S001X	0	STRUCTURAL GENERAL NOTES SHEET 1 OF 3	0165	DB-S132	0	WEST ENTRANCE ROOF AND POC ENTRY FRAMING PLAN		0197	DB-S502	0	STEEL BRACED FRAME ELEVATIONS AND DETAILS SHEET 2 OF 11	0226	DB-S650	0	CONCOURSE SECTIONS AND DETAILS SHEET 10 OF 10
0135	DB-S002X	0	STRUCTURAL GENERAL NOTES SHEET 2 OF 3	0166	DB-S133	0	SMOKE CONTROL FAN ROOM FRAMING PLAN		0198	DB-S503	0	STEEL BRACED FRAME ELEVATIONS AND DETAILS SHEET 3 OF 11	0227	DB-S681	0	DETAILS SHEET 1 OF 17
0136	DB-S003X	0	STRUCTURAL GENERAL NOTES SHEET 3 OF 3	0167	DB-S134	0	POC ENTRY PARTIAL FRAMING PLAN		0199	DB-S504	0	STEEL BRACED FRAME ELEVATIONS AND DETAILS SHEET 4 OF 11	0228	DB-S682	0	DETAILS SHEET 2 OF 17
0137	DB-S070	0	KEY PLAN MAT FOUNDATION	0168	DB-S135	0	ELEVATOR FRAMING PLANS AND SECTIONS		0200	DB-S505	0	STEEL BRACED FRAME ELEVATIONS AND DETAILS SHEET 5 OF 11	0229	DB-S683	0	DETAILS SHEET 3 OF 17
0138	DB-S071	0	MAT FOUNDATION PLAN SHEET 1 OF 7	0169	DB-S136	0	POC ENTRY FRAME ELEVATIONS AND DETAILS SHEET 1 OF 2	0201	DB-S506	0	STEEL BRACED FRAME ELEVATIONS AND DETAILS SHEET 6 OF 11	0230	DB-S684	0	DETAILS SHEET 4 OF 17	
0139	DB-S072	0	MAT FOUNDATION PLAN SHEET 2 OF 7	0170	DB-S137	0	POC ENTRY FRAME ELEVATIONS AND DETAILS SHEET 2 OF 2	0202	DB-S507	0	STEEL BRACED FRAME ELEVATIONS AND DETAILS SHEET 7 OF 11	0231	DB-S685	0	DETAILS SHEET 5 OF 17	
0140	DB-S073	0	MAT FOUNDATION PLAN SHEET 3 OF 7	0171	DB-S138	0	PARTIAL WEST ENTRANCE ROOF FRAMING PLAN	0203	DB-S508	0	STEEL BRACED FRAME ELEVATIONS AND DETAILS SHEET 8 OF 11	0232	DB-S686	0	DETAILS SHEET 6 OF 17	
0141	DB-S074	0	MAT FOUNDATION PLAN SHEET 4 OF 7	0172	DB-S140	0	KEY PLAN ROOF LEVEL FRAMING	0204	DB-S509	0	STEEL BRACED FRAME ELEVATIONS AND DETAILS SHEET 9 OF 11	<div>Santa Clara Valley Transportation Authority</div> <div>NO EXCEPTIONS TAKEN (NET) MAKE CORRECTIONS NOTED (MCN) AMEND AND RESUBMIT (A/R)</div> <div>Any action shown above is subject to the terms of the contract and does not relieve the Contractor of any of its obligations under the contract, including design and detailing.</div> <div>Contract No: DB11002F</div> <div>By: _____ Date: _____</div>				
0142	DB-S075	0	MAT FOUNDATION PLAN SHEET 5 OF 7	0173	DB-S141	0	ROOF LEVEL FRAMING PLAN SHEET 1 OF 9	0205	DB-S510	0	STEEL BRACED FRAME ELEVATIONS AND DETAILS SHEET 10 OF 11					
0143	DB-S076	0	MAT FOUNDATION PLAN SHEET 6 OF 7	0174	DB-S142	0	ROOF LEVEL FRAMING PLAN SHEET 2 OF 9									
0144	DB-S077	0	MAT FOUNDATION PLAN SHEET 7 OF 7	0175	DB-S143	0	ROOF LEVEL FRAMING PLAN SHEET 3 OF 9									
				0176	DB-S144	0	ROOF LEVEL FRAMING PLAN SHEET 4 OF 9									
0	20130710															
REV	DATE	BY	SUB	APP												
				READINESS FOR CONSTRUCTION				DESIGNED BY S. DEBNATH				DRAWN BY JG/B/SDG				
								CHECKED BY E. BALLADA								
								IN CHARGE R. BARLAAN								
								DATE 20130710								
				</												

PAGE NO.	DWG NO.	REV NO.	TITLE	PAGE NO.	DWG NO.	REV NO.	TITLE	PAGE NO.	DWG NO.	REV NO.	TITLE	PAGE NO.	DWG NO.	REV NO.	TITLE
(CONTINUATION -- STRUCTURAL)															
0233	DB-S687	0	DETAILS SHEET 7 OF 17	0262	DB-S765	0	CONCRETE BEAM/GIRDER SCHEDULE SHEET 1 OF 2	0292	DB-S823	0	MISCELLANEOUS DETAILS	0322	DB-A050	0	ARCHITECTURAL SITE KEY PLAN
0234	DB-S688	0	DETAILS SHEET 8 OF 17	0263	DB-S766	0	CONCRETE BEAM/GIRDER SCHEDULE SHEET 2 OF 2	0293	DB-S824	0	MISCELLANEOUS DETAILS	0323	DB-A051	0	EXITING PLAN -- PLATFORM LEVEL
0235	DB-S689	0	DETAILS SHEET 9 OF 17	0264	DB-S767	0	CONCRETE BEAM/GIRDER DETAILS SHEET 1 OF 4	0294	DB-S825	0	MISCELLANEOUS DETAILS	0324	DB-A052	0	EXITING PLAN -- CONCOURSE LEVEL
0236	DB-S690	0	DETAILS SHEET 10 OF 17	0265	DB-S768	0	CONCRETE BEAM/GIRDER DETAILS SHEET 2 OF 4	0295	DB-S826	0	MISCELLANEOUS DETAILS	0325			"PLACEHOLDER"
0237	DB-S691	0	DETAILS SHEET 11 OF 17	0266	DB-S769	0	CONCRETE BEAM/GIRDER DETAILS SHEET 3 OF 4	0296	DB-S827	0	MISCELLANEOUS DETAILS	0326	DB-A090	0	KEY PLAN -- TRACK LEVEL
0238	DB-S692	0	DETAILS SHEET 12 OF 17	0267	DB-S770	0	CONCRETE BEAM/GIRDER DETAILS SHEET 4 OF 4	0297	DB-S828	0	MISCELLANEOUS DETAILS	0327	DB-A091	0	TRACK LEVEL PLAN SHEET 1 OF 6
0239	DB-S693	0	DETAILS SHEET 13 OF 17	0268	DB-S771	0	TYPICAL CONCRETE SECTIONS AND DETAILS SHEET 1 OF 3	STRUCTURAL -- TRANSIT CENTER BUS SHELTER				0328	DB-A092	0	TRACK LEVEL PLAN SHEET 2 OF 6
0240	DB-S694	0	DETAILS SHEET 14 OF 17	0269	DB-S772	0	TYPICAL CONCRETE SECTIONS AND DETAILS SHEET 2 OF 3	0298	DB-S851	0	BUS CANOPY FOUNDATION AND ROOF FRAMING PLAN	0329	DB-A093	0	TRACK LEVEL PLAN SHEET 3 OF 6
0241	DB-S695	0	DETAILS SHEET 15 OF 17	0270	DB-S773	0	TYPICAL CONCRETE SECTIONS AND DETAILS SHEET 3 OF 3	0299	DB-S852	0	BUS CANOPY FOUNDATION AND SECTION DETAILS	0330	DB-A094	0	TRACK LEVEL PLAN SHEET 4 OF 6
0242	DB-S696	0	DETAILS SHEET 16 OF 17	0271	DB-S774	0	CONCRETE BEAM/GIRDER DETAILS SHEET 1 OF 1	STRUCTURAL -- MONTAGUE LRT AND MILPITAS POC				0331	DB-A095	0	TRACK LEVEL PLAN SHEET 5 OF 6
0243	DB-S697	0	DETAILS SHEET 17 OF 17	0272	DB-S775	0	TYPICAL MASONRY SECTIONS AND DETAILS SHEET 1 OF 2	0301	DB-S900	0	OVERALL PLAN GROUND LEVEL	0332	DB-A096	0	TRACK LEVEL PLAN SHEET 6 OF 6
0244	DB-S720	0	STAIRS SECTIONS AND DETAILS SHEET 1 OF 4	0273	DB-S776	0	TYPICAL MASONRY SECTIONS AND DETAILS SHEET 2 OF 2	0302	DB-S901	0	OVERALL PLAN POC LEVEL	0333	DB-A110X	0	KEY PLAN -- PLATFORM LEVEL
0245	DB-S721	0	STAIRS SECTIONS AND DETAILS SHEET 2 OF 4	0274	DB-S777	0	CONCRETE BEAM/GIRDER DETAILS SHEET 1 OF 1	0303	DB-S902	0	OVERALL PLAN LRT PLATFORM/POC ROOF LEVEL	0334	DB-A111X	0	PLATFORM LEVEL PLAN SHEET 1 OF 6
0246	DB-S722	0	STAIRS SECTIONS AND DETAILS SHEET 3 OF 4	0275	DB-S781	0	TYPICAL METAL DECK SECTIONS AND DETAILS SHEET 1 OF 4	0304	DB-S911	0	FOUNDATION PLAN	0335	DB-A112X	0	PLATFORM LEVEL PLAN SHEET 2 OF 6
0247	DB-S723	0	STAIRS SECTIONS AND DETAILS SHEET 4 OF 4	0276	DB-S782	0	TYPICAL METAL DECK SECTIONS AND DETAILS SHEET 2 OF 4	0305	DB-S912	0	POC BRIDGE FLOOR FRAMING PLAN	0336	DB-A113X	0	PLATFORM LEVEL PLAN SHEET 3 OF 6
0248	DB-S731	0	ROOF TRUSS FRAMING SECTIONS AND DETAILS SHEET 1 OF 4	0277	DB-S783	0	TYPICAL METAL DECK SECTIONS AND DETAILS SHEET 3 OF 4	0306	DB-S913	0	POC ROOF FRAMING PLAN	0337	DB-A114X	0	PLATFORM LEVEL PLAN SHEET 4 OF 6
0249	DB-S732	0	ROOF TRUSS FRAMING SECTIONS AND DETAILS SHEET 2 OF 4	0278	DB-S784	0	TYPICAL METAL DECK SECTIONS AND DETAILS SHEET 4 OF 4	0307	DB-S915	0	LRT EMERGENCY EXIT STAIRS PLANS	0338	DB-A115X	0	PLATFORM LEVEL PLAN SHEET 5 OF 6
0250	DB-S733	0	ROOF TRUSS FRAMING SECTIONS AND DETAILS SHEET 3 OF 4	0279	DB-S791	0	TYPICAL STEEL SECTIONS AND DETAILS SHEET 1 OF 8	0308	DB-S921	0	ELEVATION TRUSSES LINE P-C	0339	DB-A116X	0	PLATFORM LEVEL PLAN SHEET 6 OF 6
0251	DB-S734	0	ROOF TRUSS FRAMING SECTIONS AND DETAILS SHEET 4 OF 4	0280	DB-S792	0	TYPICAL STEEL SECTIONS AND DETAILS SHEET 2 OF 8	0309	DB-S922	0	ELEVATION TRUSSES LINE P-A	0340	DB-A117	0	RETAINING WALL DRAIN LINE PLAN SHEET 1 OF 3
0252	DB-S750	0	FOUNDATION SCHEDULE AND DETAILS SHEET 1 OF 1	0281	DB-S793	0	TYPICAL STEEL SECTIONS AND DETAILS SHEET 3 OF 8	0310	DB-S931	0	SECTIONS SHEET 1 OF 2	0341	DB-A118	0	RETAINING WALL DRAIN LINE PLAN SHEET 2 OF 3
0253	DB-S751X	0	CONCRETE & STEEL COLUMNS SCHEDULE AND DETAILS SHEET 1 OF 6	0282	DB-S794	0	TYPICAL STEEL SECTIONS AND DETAILS SHEET 4 OF 8	0311	DB-S932	0	SECTIONS SHEET 2 OF 2	0342	DB-A119	0	RETAINING WALL DRAIN LINE PLAN SHEET 3 OF 3
0254	DB-S752X	0	CONCRETE & STEEL COLUMNS SCHEDULE AND DETAILS SHEET 2 OF 6	0283	DB-S795	0	TYPICAL STEEL SECTIONS AND DETAILS SHEET 5 OF 8	0312	DB-S933	0	POC DETAILS	0343	DB-A120X	0	KEY PLAN -- CONCOURSE LEVEL
0255	DB-S753	0	CONCRETE & STEEL COLUMNS SCHEDULE AND DETAILS SHEET 3 OF 6	0284	DB-S796	0	TYPICAL STEEL SECTIONS AND DETAILS SHEET 6 OF 8	0313	DB-S939	0	LRT EMERGENCY EXIT STAIR SECTIONS	0344	DB-A121X	0	CONCOURSE LEVEL PLAN SHEET 1 OF 8
0256	DB-S754	0	CONCRETE & STEEL COLUMNS SCHEDULE AND DETAILS SHEET 4 OF 6	0285	DB-S798	0	TYPICAL STEEL SECTIONS AND DETAILS SHEET 7 OF 8	0314	DB-S943	0	LRT STAIR AND ESCALATORS PLATFORM AND BRIDGE LEVEL DETAIL PLANS	0345	DB-A122X	0	CONCOURSE LEVEL PLAN SHEET 2 OF 8
0257	DB-S755	0	CONCRETE & STEEL COLUMNS SCHEDULE AND DETAILS SHEET 5 OF 6	0286	DB-S799	0	TYPICAL STEEL SECTIONS AND DETAILS SHEET 8 OF 8	0315	DB-S945	0	LRT STAIR LST 2 DETAIL SECTION	0346	DB-A123X	0	CONCOURSE LEVEL PLAN SHEET 3 OF 8
0258	DB-S756	0	CONCRETE & STEEL COLUMNS SCHEDULE AND DETAILS SHEET 6 OF 6	STRUCTURAL -- ANCILLARY BUILDING				0316	DB-S946	0	LRT ESCALATOR LES 1 DETAIL SECTION	0347	DB-A124X	0	CONCOURSE LEVEL PLAN SHEET 4 OF 8
0259	DB-S761	0	CONCRETE SLAB SCHEDULE AND DETAILS SHEET 1 OF 3	0287	DB-S809	0	STRUCTURAL GENERAL NOTES	ARCHITECTURAL -- MILPITAS STATION				0348	DB-A125X	0	CONCOURSE LEVEL PLAN SHEET 5 OF 8
0260	DB-S762	0	CONCRETE SLAB SCHEDULE AND DETAILS SHEET 2 OF 3	0288	DB-S810	0	FOUNDATION PLAN	PLANS				0349	DB-A126X	0	CONCOURSE LEVEL PLAN SHEET 6 OF 8
0261	DB-S763	0	CONCRETE SLAB SCHEDULE AND DETAILS SHEET 3 OF 3	0289	DB-S811	0	ROOF FRAMING PLAN	0320	DB-A010	0	ARCHITECTURAL GENERAL NOTES, ABBREVIATIONS AND SYMBOLS	0350	DB-A127X	0	CONCOURSE LEVEL PLAN SHEET 7 OF 8
				0290	DB-S821	0	MISCELLANEOUS DETAILS	0321	DB-A011	0	MASTER KEY NOTES	0351	DB-A128X	0	CONCOURSE LEVEL PLAN SHEET 8 OF 8
				0291	DB-S822	0	MISCELLANEOUS DETAILS					0352	DB-A130	0	KEY PLAN MEZZANINE LEVEL
												LINE, TRACK, STATIONS, AND SYSTEMS DESIGN UNIT 023 MILPITAS STATION			
												INDEX OF DRAWINGS SHEET 3 OF 11			
												CADD FILENAME C700-S-DB-X029.dwg			
												SIZE D SCALE NONE			
												CONTRACT NO. C700 REV. 0			
												AREA CODE DB SHEET NO. X029 PAGE NO. 0004			

PAGE NO.	DWG NO.	REV NO.	TITLE	PAGE NO.	DWG NO.	REV NO.	TITLE	PAGE NO.	DWG NO.	REV NO.	TITLE	PAGE NO.	DWG NO.	REV NO.	TITLE
ARCHITECTURAL – ANCILLARY BUILDING				0614	DB-A902	0	OVERALL PLAN LRT PLATFORM/POC ROOF LEVEL PLAN	0647	DB-A962	0	LRT CANOPY DETAIL ELEVATION, AND SECTION	0677	DB-M111X	0	PLATFORM LEVEL PLAN – HVAC SHEET 1 OF 6
0582	DB-A800	0	SITE PLAN	0615	DB-A911	0	GROUND LEVEL PLAN	0648	DB-A971	0	FINISH SCHEDULE	0678	DB-M112X	0	PLATFORM LEVEL PLAN – HVAC SHEET 2 OF 6
0583	DB-A811X	0	FIRST FLOOR PLAN	0616	DB-A912	0	POC LEVEL PLAN	0649	DB-A981	0	MISCELLANEOUS DETAILS	0679	DB-M113X	0	PLATFORM LEVEL PLAN – HVAC SHEET 3 OF 6
0584	DB-A812X	0	ROOF PLAN	0617	DB-A913	0	LRT PLATFORM/POC ROOF LEVEL PLAN	0650	DB-A982	0	RAILING DETAILS	0680	DB-M114X	0	PLATFORM LEVEL PLAN – HVAC SHEET 4 OF 6
0585	DB-A813X	0	FIRST FLOOR REFLECTED CEILING PLAN	0618	DB-A914X	0	LRT ROOF LEVEL PLAN	0651	DB-A983	0	LRT CANOPY DETAILS	0681	DB-M115X	0	PLATFORM LEVEL PLAN – HVAC SHEET 5 OF 6
0586	DB-A821	0	ELEVATIONS	0619	DB-A915X	0	LRT EMERGENCY EXIT STAIRS PLANS	0652	DB-A985	0	STAIR RAILING ELEVATIONS	0682	DB-M116X	0	PLATFORM LEVEL PLAN – HVAC SHEET 6 OF 6
0587	DB-A822	0	SECTIONS	0620	DB-A916	0	GROUND LEVEL REFLECTED CEILING PLAN	0653	DB-A986	0	EMERGENCY EXIT STAIR RAILING ELEVATIONS	0683	DB-M120	0	KEY PLAN PLATFORM LEVEL PLUMBING
0588	DB-A825	0	ENLARGED PLAN AND INTERIOR ELEVATIONS SHEET 1 OF 2	0621	DB-A917	0	POC LEVEL REFLECTED CEILING PLAN	0654	DB-A987	0	ENLARGED PLAN, SECTION AND DETAILS	0684	DB-M121	0	PLATFORM LEVEL PLAN – PLUMBING SHEET 1 OF 8
0589	DB-A826	0	ENLARGED PLAN AND INTERIOR ELEVATIONS SHEET 2 OF 2	0622	DB-A920	0	KEY ELEVATIONS	0655	DB-A988	0	ENLARGED PLAN. SECTION AND DETAILS	0685	DB-M122	0	PLATFORM LEVEL PLAN – PLUMBING SHEET 2 OF 8
0590	DB-A831	0	DETAILED WALL SECTIONS SHEET 1 OF 3	0623	DB-A921	0	POC SOUTH ELEVATION	0656	DB-A989	0	ENLARGED PLAN, SECTION AND DETAILS	0686	DB-M123	0	PLATFORM LEVEL PLAN – PLUMBING SHEET 3 OF 8
0591	DB-A832	0	DETAILED WALL SECTIONS SHEET 2 OF 3	0624	DB-A922	0	POC NORTH ELEVATION	0657	DB-A990	0	MISCELLANEOUS DETAILS	0687	DB-M124	0	PLATFORM LEVEL PLAN – PLUMBING SHEET 4 OF 8
0592	DB-A833	0	DETAILED WALL SECTIONS SHEET 3 OF 3	0625	DB-A923	0	LRT WEST ELEVATION	HVAC AND PLUMBING – MILPITAS STATION				0688	DB-M125	0	PLATFORM LEVEL PLAN – PLUMBING SHEET 5 OF 8
0593	DB-A834	0	INTERIOR FINISH SCHEDULE, FINISH CODES AND WALL TYPES	0626	DB-A924	0	LRT EMERGENCY EXIT STAIRS SOUTH AND EAST ELEVATIONS	PLANS				0689	DB-M126	0	PLATFORM LEVEL PLAN – PLUMBING SHEET 6 OF 8
0594	DB-A835	0	DOORS AND HARDWARE SCHEDULES AND DETAILS	0627	DB-A925	0	LRT EMERGENCY EXIT STAIRS WEST AND NORTH ELEVATIONS	0658	DB-M001	0	HVAC AND PLUMBING ABBREVIATIONS & GENERAL NOTES	0690	DB-M127	0	PLATFORM LEVEL PLAN – PLUMBING SHEET 7 OF 8
0595	DB-A840	0	CEILING DETAILS	0628	DB-A930	0	POC KEY LONGITUDINAL SECTION	0659	DB-M002	0	HVAC, PLUMBING AND CONTROLS SYMBOLS	0691	DB-M128	0	PLATFORM LEVEL PLAN – PLUMBING SHEET 8 OF 8
0596	DB-A841	0	SKYLIGHT AND ROOF DETAILS	0629	DB-A931	0	POC LONGITUDINAL SECTION	0660	DB-M005	0	MECHANICAL SITE PLAN	0692	DB-M160	0	PLUMBING DETAILS SHEET 1 OF 4
0597	DB-A842	0	ROOF DETAILS	0630	DB-A935X	0	POC CROSS SECTIONS	0661	DB-M010	0	KEY PLAN TRACK LEVEL HVAC	0693	DB-M161	0	PLUMBING DETAILS SHEET 2 OF 4
0598	DB-A843	0	EXTERIOR WALL DETAILS SHEET 1 OF 2	0631	DB-A936	0	LRT SECTIONS SHEET 1 OF 3	0662	DB-M011	0	TRACK LEVEL PLAN – HVAC SHEET 1 OF 6	0694	DB-M162	0	PLUMBING DETAILS SHEET 3 OF 4
0599	DB-A844	0	EXTERIOR WALL DETAILS SHEET 2 OF 2	0632	DB-A937	0	LRT SECTIONS SHEET 2 OF 3	0663	DB-M012	0	TRACK LEVEL PLAN – HVAC SHEET 2 OF 6	0695	DB-M163	0	PLUMBING DETAILS SHEET 4 OF 4
0600	DB-A845	0	WIRE MESH PANEL SCHEDULE	0633	DB-A938	0	LRT SECTIONS SHEET 3 OF 3	0664	DB-M013	0	TRACK LEVEL PLAN – HVAC SHEET 3 OF 6	0696	DB-M190	0	PLUMBING SCHEDULES SHEET 1 OF 2
0601	DB-A846	0	ELEVATION OF GREEN WALL AND DETAILS	0634	DB-A939	0	LRT EMERGENCY EXIT STAIR SECTIONS	0665	DB-M014	0	TRACK LEVEL PLAN – HVAC SHEET 4 OF 6	0697	DB-M191	0	PLUMBING SCHEDULES SHEET 2 OF 2
0602	DB-A847	0	MISCELLANEOUS DETAILS	0635	DB-A940	0	POC DETAIL CROSS SECTION	0666	DB-M015	0	TRACK LEVEL PLAN – HVAC SHEET 5 OF 6	0698	DB-M210X	0	KEY PLAN CONCOURSE LEVEL HVAC
ARCHITECTURAL – TRANSIT CENTER BUS SHELTER				0636	DB-A941	0	POC DETAIL SECTIONS SHEET 1 OF 2	0667	DB-M016	0	TRACK LEVEL PLAN – HVAC SHEET 6 OF 6	0699	DB-M211X	0	CONCOURSE LEVEL PLAN – HVAC SHEET 1 OF 6
0603	DB-A850	0	SITE PLAN	0637	DB-A942	0	POC DETAIL SECTIONS SHEET 2 OF 2	0668	DB-M020	0	KEY PLAN TRACK LEVEL PLUMBING	0700	DB-M212X	0	CONCOURSE LEVEL PLAN – HVAC SHEET 2 OF 6
0604	DB-A851	0	PLAN AND ELEVATION OF BUS BAY	0638	DB-A943	0	LRT STAIR AND ESCALATORS PLATFORM AND LRT BRIDGE LEVEL DETAIL PLANS	0669	DB-M021	0	TRACK LEVEL PLAN – PLUMBING SHEET 1 OF 6	0701	DB-M213X	0	CONCOURSE LEVEL PLAN – HVAC SHEET 3 OF 6
0605	DB-A852	0	SITE SECTION	0639	DB-A944	0	LRT STAIR LST1 DETAIL SECTION	0670	DB-M022	0	TRACK LEVEL PLAN – PLUMBING SHEET 2 OF 6	0702	DB-M214X	0	CONCOURSE LEVEL PLAN – HVAC SHEET 4 OF 6
0606	DB-A861	0	DETAIL PLANS	0640	DB-A945	0	LRT STAIR LST 2 DETAIL SECTION	0671	DB-M023	0	TRACK LEVEL PLAN – PLUMBING SHEET 3 OF 6	<div>Santa Clara Valley Transportation Authority</div> <div>NO EXCEPTIONS TAKEN (NET)</div> <div>MAKE CORRECTIONS NOTED (MCN)</div> <div>AMEND AND RESUBMIT (A/R)</div> <div>Any action shown above is subject to the terms of the contract and does not relieve the Contractor of any of its obligations under the contract, including design and detailing.</div> <div>Contract No.: DB11002F</div> <div>By: _____ Date: _____</div>			
0607	DB-A862	0	DETAIL ELEVATIONS	0641	DB-A946	0	LRT ESCALATOR LES 1 DETAIL SECTION	0672	DB-M024	0	TRACK LEVEL PLAN – PLUMBING SHEET 4 OF 6				
0608	DB-A863	0	DETAIL SECTIONS	0642	DB-A947	0	ESC. LES1, ESC. LES2, AND STAIR LST 2 DETAIL SECTIONS	0673	DB-M025	0	TRACK LEVEL PLAN – PLUMBING SHEET 5 OF 6				
0609	DB-A864	0	BENCH AND WINDSCREEN DETAIL PLAN, ELEVATION AND SECTION	0643	DB-A951	0	LRT EMERGENCY EXIT STAIRS DETAIL PLANS	0674	DB-M026	0	TRACK LEVEL PLAN – PLUMBING SHEET 6 OF 6				
0610	DB-A865	0	CANOPY SUPPORT DETAILS	0644	DB-A952	0	LRT EMERGENCY EXIT STAIRS DETAIL SECTION, SHEET 1 OF 2	0675	DB-M027	0	LONGITUDINAL SECTION UTILITY CHASE #2 WEST WALL HVAC & PLUMBING LAYOUT				
0611	DB-A871	0	MISCELLANEOUS DETAILS	0645	DB-A953	0	LRT EMERGENCY EXIT STAIRS DETAIL SECTION, SHEET 2 OF 2	0676	DB-M110	0	KEY PLAN PLATFORM LEVEL HVAC				
ARCHITECTURAL – MONTAGUE LRT AND MILPITAS POC				0646	DB-A961X	0	LRT CANOPY DETAIL PLANS								
												<div>LINE, TRACK, STATIONS, AND SYSTEMS</div> <div>DESIGN UNIT 023</div> <div>MILPITAS STATION</div> <div>INDEX OF DRAWINGS</div> <div>SHEET 6 OF 11</div>			
0	20130710						READINESS FOR CONSTRUCTION								
REV	DATE	BY	SUB	APP	DESCRIPTION										
				DESIGNED BY S. DEBNATH								CADD FILENAME C700-S-DB-X032.dwg			
				DRAWN BY JG/BI/SDG								SIZE SCALE D NONE			
				CHECKED BY E. BALLADA								CONTRACT NO. C700			
				IN CHARGE R. BARLAAN								REV. 0			
				DATE 20130710								SHEET NO. DB			
												PAGE NO. X032			
												0007			

PAGE NO.	DWG NO.	REV NO.	TITLE	PAGE NO.	DWG NO.	REV NO.	TITLE	PAGE NO.	DWG NO.	REV NO.	TITLE	PAGE NO.	DWG NO.	REV NO.	TITLE
(CONTINUATION - HVAC)								FIRE SUPPRESSION AND DETECTION - MILPITAS STATION							
0703	DB-M215X	0	CONCOURSE LEVEL PLAN - HVAC SHEET 5 OF 6	0733	DB-M375	0	HVAC CONTROLS SHEET 6 OF 11						DB-M622		PLATFORM LEVEL PLAN FIRE PROTECTION PIPING SHEET 2 OF 6
0704	DB-M218X	0	CONCOURSE LEVEL PLAN - HVAC SHEET 6 OF 6	0734	DB-M376	0	HVAC CONTROLS SHEET 7 OF 11		DB-M460		FM-200 FIRE DETECTION SUPPRESSION AND CONTROL BILL OF MATERIALS/SEQUENCE OF OPERATION		DB-M623		PLATFORM LEVEL PLAN FIRE PROTECTION PIPING SHEET 3 OF 6
0705	DB-M219X	0	SECTIONS - HVAC	0735	DB-M377	0	HVAC CONTROLS SHEET 8 OF 11		DB-M461		FM-200 FIRE DETECTION SUPPRESSION AND CONTROL ELECTRICAL LAYOUT		DB-M624		PLATFORM LEVEL PLAN FIRE PROTECTION PIPING SHEET 4 OF 6
0706	DB-M220	0	KEY PLAN CONCOURSE LEVEL PLUMBING	0736	DB-M378	0	HVAC CONTROLS SHEET 9 OF 11		DB-M462		FM-200 FIRE DETECTION SUPPRESSION AND CONTROL MECHANICAL LAYOUT		DB-M625		PLATFORM LEVEL PLAN FIRE PROTECTION PIPING SHEET 5 OF 6
0707	DB-M221X	0	CONCOURSE LEVEL PLAN - PLUMBING SHEET 1 OF 6	0737	DB-M379	0	HVAC CONTROLS SHEET 10 OF 11		DB-M463		FM-200 FIRE DETECTION SUPPRESSION AND CONTROL RISER DIAGRAM		DB-M626		PLATFORM LEVEL PLAN FIRE PROTECTION PIPING SHEET 6 OF 6
0708	DB-M222X	0	CONCOURSE LEVEL PLAN - PLUMBING SHEET 2 OF 6	0738	DB-M380	0	HVAC CONTROLS SHEET 11 OF 11		DB-M464		FM-200 FIRE DETECTION SUPPRESSION AND CONTROL DETAILS		DB-M630		KEY PLAN CONCOURSE LEVEL FIRE PROTECTION
0709	DB-M223X	0	CONCOURSE LEVEL PLAN - PLUMBING SHEET 3 OF 6	0739	DB-M385	0	SYSTEM DIAGRAMS/RISERS - HVAC SHEET 1 OF 4		DB-M465		FM-200 FIRE DETECTION SUPPRESSION AND CONTROL DETAILS		DB-M631		CONCOURSE LEVEL PLAN FIRE PROTECTION PIPING SHEET 1 OF 8
0710	DB-M224X	0	CONCOURSE LEVEL PLAN - PLUMBING SHEET 4 OF 6	0740	DB-M386	0	SYSTEM DIAGRAMS/RISERS - HVAC SHEET 2 OF 4		DB-M466		FM-200 FIRE DETECTION SUPPRESSION AND CONTROL MECHANICAL ISOMETRICS & FLOW CALCULATIONS		DB-M632		CONCOURSE LEVEL PLAN FIRE PROTECTION PIPING SHEET 2 OF 8
0711	DB-M225X	0	CONCOURSE LEVEL PLAN - PLUMBING SHEET 5 OF 6	0741	DB-M387	0	SYSTEM DIAGRAMS/RISERS - HVAC SHEET 3 OF 4		DB-M467		BATTERY CALCULATIONS & VOLTAGE DROP		DB-M633		CONCOURSE LEVEL PLAN FIRE PROTECTION PIPING SHEET 3 OF 8
0712	DB-M228	0	CONCOURSE LEVEL PLAN - PLUMBING SHEET 6 OF 6	0742	DB-M388	0	SYSTEM DIAGRAMS/RISERS - HVAC SHEET 4 OF 4		FIRE PROTECTION - MILPITAS STATION				DB-M634		CONCOURSE LEVEL PLAN FIRE PROTECTION PIPING SHEET 4 OF 8
0713	DB-M320	0	KEY PLAN MEZZANINE LEVEL HVAC	0743	DB-M390	0	EQUIPMENT SCHEDULES - HVAC SHEET 1 OF 3		COVER SHEET		DB-M590		DB-M635		CONCOURSE LEVEL PLAN FIRE PROTECTION PIPING SHEET 5 OF 8
0714	DB-M321	0	LOWER ROOF LEVEL - HVAC SHEET 1 OF 2	0744	DB-M391	0	EQUIPMENT SCHEDULES - HVAC SHEET 2 OF 3		DB-M600		GENERAL NOTES AND ABBREVIATIONS FIRE PROTECTION		DB-M636		CONCOURSE LEVEL PLAN FIRE PROTECTION PIPING SHEET 6 OF 8
0715	DB-M322	0	LOWER ROOF LEVEL - HVAC SHEET 2 OF 2	0745	DB-M392	0	EQUIPMENT SCHEDULES - HVAC SHEET 3 OF 3		DB-M601		FIRE DETAILS FIRE PROTECTION		DB-M637		CONCOURSE LEVEL PLAN FIRE PROTECTION PIPING SHEET 7 OF 8
0716	DB-M323	0	MEZZANINE PLANS - HVAC	0746	DB-M401	0	KEY PLAN ROOF LEVEL HVAC		DB-M602		HANGER AND BRACING DETAILS FIRE PROTECTION		DB-M638		CONCOURSE LEVEL PLAN FIRE PROTECTION PIPING SHEET 8 OF 8
0717	DB-M324	0	STAIRWAY SECTIONS - HVAC	0747	DB-M412	0	ROOF LEVEL PLAN - HVAC SHEET 1 OF 4		DB-M603		FIRESTOPPING DETAILS FIRE PROTECTION		DB-M650		KEY PLAN PLATFORM LEVEL FIRE PROTECTION
0718	DB-M330	0	KEY PLAN LOWER ROOF LEVEL PLUMBING	0748	DB-M413	0	ROOF LEVEL PLAN - HVAC SHEET 2 OF 4		DB-M610		KEY PLAN TRACK LEVEL FIRE PROTECTION PLAN		DB-M651		PLATFORM LEVEL FIRE PROTECTION RCP SHEET 1 OF 6
0719	DB-M331	0	LOWER ROOF LEVEL - PLUMBING SHEET 1 OF 2	0749	DB-M414	0	ROOF LEVEL PLAN - HVAC SHEET 3 OF 4		DB-M612		TRACK LEVEL PLAN FIRE PROTECTION PIPING SHEET 2 OF 6		DB-M652		PLATFORM LEVEL FIRE PROTECTION RCP SHEET 2 OF 6
0720	DB-M332	0	LOWER ROOF LEVEL - PLUMBING SHEET 2 OF 2	0750	DB-M415	0	ROOF LEVEL PLAN - HVAC SHEET 4 OF 4		DB-M613		TRACK LEVEL PLAN FIRE PROTECTION PIPING SHEET 3 OF 6		DB-M653		PLATFORM LEVEL FIRE PROTECTION RCP SHEET 3 OF 6
0721	DB-M350	0	STATION AGENT'S BOOTH - HVAC	HVAC AND PLUMBING - ANCILLARY BUILDING					DB-M614		TRACK LEVEL PLAN FIRE PROTECTION PIPING SHEET 4 OF 6		<div>Santa Clara Valley Transportation Authority</div> <div>NO EXCEPTIONS TAKEN (NET) MAKE CORRECTIONS NOTED (MCN) AMEND AND RESUBMIT (A/R)</div> <div>Any action shown above is subject to the terms of the contract and does not relieve the Contractor of any of its obligations under the contract, including design and detailing.</div> <div>Contract No.: DB11002F</div> <div>By: _____ Date: _____</div>		
0722	DB-M360	0	HVAC DETAILS SHEET 1 OF 6	0751	DB-M810	0	FIRST FLOOR PLAN UNDERGROUND PLUMBING		DB-M615		TRACK LEVEL PLAN FIRE PROTECTION PIPING SHEET 5 OF 6				
0723	DB-M361	0	HVAC DETAILS SHEET 2 OF 6	0752	DB-M811	0	FIRST FLOOR PLAN PLUMBING		DB-M616		TRACK LEVEL PLAN FIRE PROTECTION PIPING SHEET 6 OF 6				
0724	DB-M362	0	HVAC DETAILS SHEET 3 OF 6	0753	DB-M812	0	FIRST FLOOR PLAN HVAC		DB-M620		KEY PLAN PLATFORM LEVEL FIRE PROTECTION				
0725	DB-M363	0	HVAC DETAILS SHEET 4 OF 6	0754	DB-M813	0	ROOF PLAN HVAC		DB-M621		PLATFORM LEVEL PLAN FIRE PROTECTION PIPING SHEET 1 OF 6				
0726	DB-M364	0	HVAC DETAILS SHEET 5 OF 6	PLUMBING - MONTAGUE LRT AND MILPITAS POC											
0727	DB-M365	0	HVAC DETAILS SHEET 6 OF 6	0755	DB-M911	0	GROUND LEVEL PLAN PLUMBING								
0728	DB-M370	0	HVAC CONTROLS SHEET 1 OF 11	0756	DB-M912	0	POC LEVEL PLAN PLUMBING								
0729	DB-M371	0	HVAC CONTROLS SHEET 2 OF 11	0757	DB-M913	0	POC LEVEL PLAN PLUMBING								
0730	DB-M372	0	HVAC CONTROLS SHEET 3 OF 11	0758	DB-M914	0	LRT ROOF LEVEL PLAN PLUMBING								
0731	DB-M373	0	HVAC CONTROLS SHEET 4 OF 11												
0732	DB-M374	0	HVAC CONTROLS SHEET 5 OF 11												

Jul 08, 2013 - 2:14pm G:\Current Projects\VTB-Berryessa Extension Project\Station - Milpitas\CAD Drawings 04\13-0710 C700 Milpitas Station - RFC Submit\C700-S-DB-X034.dwg JosephG

PAGE NO.	DWG NO.	REV NO.	TITLE
FIRE PROTECTION - (CONTINUATION)			
	DB-M654		PLATFORM LEVEL FIRE PROTECTION RCP SHEET 4 OF 6
	DB-M655		PLATFORM LEVEL FIRE PROTECTION RCP SHEET 5 OF 6
	DB-M656		PLATFORM LEVEL FIRE PROTECTION RCP SHEET 6 OF 6
	DB-M660		KEY PLAN CONCOURSE LEVEL FIRE PROTECTION
	DB-M661		CONCOURSE LEVEL FIRE PROTECTION RCP SHEET 1 OF 6
	DB-M662		CONCOURSE LEVEL FIRE PROTECTION RCP SHEET 2 OF 6
	DB-M663		CONCOURSE LEVEL FIRE PROTECTION RCP SHEET 3 OF 6
	DB-M664		CONCOURSE LEVEL FIRE PROTECTION RCP SHEET 4 OF 6
	DB-M665		CONCOURSE LEVEL FIRE PROTECTION RCP SHEET 5 OF 6
	DB-M668		CONCOURSE LEVEL FIRE PROTECTION RCP SHEET 6 OF 6
	DB-M670		KEY PLAN CONCOURSE LEVEL - HIGH CEILING FIRE PROTECTION
	DB-M671		CONCOURSE LEVEL PLAN FIRE PROTECTION RCP SHEET 1 OF 4
	DB-M672		CONCOURSE LEVEL PLAN FIRE PROTECTION RCP SHEET 2 OF 4
	DB-M673		CONCOURSE LEVEL PLAN FIRE PROTECTION RCP SHEET 3 OF 4
	DB-M674		CONCOURSE LEVEL PLAN FIRE PROTECTION RCP SHEET 4 OF 4
SECTIONS	DB-M681		TRANSVERSE SECTION FIRE PROTECTION SHEET 1 OF 3
	DB-M683		TRANSVERSE SECTION FIRE PROTECTION SHEET 2 OF 3
	DB-M684		TRANSVERSE SECTION FIRE PROTECTION SHEET 3 OF 3
FIRE PROTECTION - ANCILLARY BUILDING			
	DB-M810*		ANCILLARY BUILDING SITE PLAN FIRE PROTECTION
	DB-M811*		ANCILLARY BUILDING FIRST FLOOR PLAN FIRE PROTECTION PIPING
	DB-M813*		ANCILLARY BUILDING FIRST FLOOR PLAN FIRE PROTECTION RCP

PAGE NO.	DWG NO.	REV NO.	TITLE
	DB-M822*		ANCILLARY BUILDING SECTIONS FIRE PROTECTION
FIRE PROTECTION - MONTAGUE LRT AND MILPITAS POC			
	DB-M902*		MONTAGUE LRT AND MILPITAS POC LRT PLATFORM/POC ROOF LEVEL OVERALL PLAN FIRE PROTECTION
	DB-M911*		MONTAGUE LRT AND MILPITAS POC GROUND LEVEL PLAN FIRE PROTECTION PIPING SHEET 1 OF 2
	DB-M912*		MONTAGUE LRT AND MILPITAS POC POC LEVEL PLAN FIRE PROTECTION PIPING SHEET 2 OF 2
	DB-M920*		MONTAGUE LRT AND MILPITAS POC POC SECTION - FIRE PROTECTION PIPING SHEET 1 OF 2
	DB-M922*		MONTAGUE LRT AND MILPITAS POC POC SECTION - FIRE PROTECTION PIPING SHEET 2 OF 2
ELECTRICAL - MILPITAS STATION			
PLANS			
0826	DB-E000	0	ELECTRICAL SITE KEY PLAN
0827	DB-E001	0	ELECTRICAL ABBREVIATIONS
0828	DB-E001X	0	ELECTRICAL ABBREVIATIONS
0829	DB-E002	0	ELECTRICAL LAYOUT SYMBOLS
0830	DB-E002X	0	ELECTRICAL LAYOUT SYMBOLS
0831	DB-E003	0	ELECTRICAL DIAGRAM SYMBOLS
0832	DB-E003X	0	ELECTRICAL DIAGRAM SYMBOLS
0833	DB-E004	0	ELECTRICAL GENERAL NOTES
0834	DB-E010X	0	KEY PLAN TRACK LEVEL - LIGHTING
0835	DB-E011	0	TRACK LEVEL PLAN - LIGHTING SHEET 1 OF 6
0836	DB-E012	0	TRACK LEVEL PLAN - LIGHTING SHEET 2 OF 6
0837	DB-E013	0	TRACK LEVEL PLAN - LIGHTING SHEET 3 OF 6
0838	DB-E014	0	TRACK LEVEL PLAN - LIGHTING SHEET 4 OF 6
0839	DB-E015	0	TRACK LEVEL PLAN - LIGHTING SHEET 5 OF 6
0840	DB-E016	0	TRACK LEVEL PLAN - LIGHTING SHEET 6 OF 6
0841	DB-E020	0	KEY PLAN TRACK LEVEL POWER AND MISCELLANEOUS
0842	DB-E021X	0	TRACK LEVEL PLAN POWER AND MISCELLANEOUS SHEET 1 OF 6
0843	DB-E022X	0	TRACK LEVEL PLAN POWER AND MISCELLANEOUS SHEET 2 OF 6
0844	DB-E023X	0	TRACK LEVEL PLAN POWER AND MISCELLANEOUS SHEET 3 OF 6

PAGE NO.	DWG NO.	REV NO.	TITLE
0845	DB-E024X	0	TRACK LEVEL PLAN POWER AND MISCELLANEOUS SHEET 4 OF 6
0846	DB-E025X	0	TRACK LEVEL PLAN POWER AND MISCELLANEOUS SHEET 5 OF 6
0847	DB-E026X	0	TRACK LEVEL PLAN POWER AND MISCELLANEOUS SHEET 6 OF 6
0848	DB-E100X	0	KEY PLAN PLATFORM LEVEL - LIGHTING
0849	DB-E101X	0	PLATFORM LEVEL PLAN - LIGHTING SHEET 1 OF 6
0850	DB-E102X	0	PLATFORM LEVEL PLAN - LIGHTING SHEET 2 OF 6
0851	DB-E103X	0	PLATFORM LEVEL PLAN - LIGHTING SHEET 3 OF 6
0852	DB-E104	0	PLATFORM LEVEL PLAN - LIGHTING SHEET 4 OF 6
0853	DB-E105	0	PLATFORM LEVEL PLAN - LIGHTING SHEET 5 OF 6
0854	DB-E106	0	PLATFORM LEVEL PLAN - LIGHTING SHEET 6 OF 6
0855	DB-E110X	0	KEY PLAN PLATFORM LEVEL POWER AND MISCELLANEOUS
0856	DB-E111X	0	PLATFORM LEVEL PLAN POWER AND MISCELLANEOUS SHEET 1 OF 6
0857	DB-E112	0	PLATFORM LEVEL PLAN POWER AND MISCELLANEOUS SHEET 2 OF 6
0858	DB-E113	0	PLATFORM LEVEL PLAN POWER AND MISCELLANEOUS SHEET 3 OF 6
0859	DB-E114	0	PLATFORM LEVEL PLAN POWER AND MISCELLANEOUS SHEET 4 OF 6
0860	DB-E115	0	PLATFORM LEVEL PLAN POWER AND MISCELLANEOUS SHEET 5 OF 6
0861	DB-E116	0	PLATFORM LEVEL PLAN POWER AND MISCELLANEOUS SHEET 6 OF 6
0862	DB-E150	0	ELECTRICAL EQUIPMENT LOCATION PLAN PLATFORM AND CONCOURSE LEVELS
0863	DB-E200	0	KEY PLAN CONCOURSE LEVEL - LIGHTING
0864	DB-E201X	0	CONCOURSE LEVEL PLAN - LIGHTING SHEET 1 OF 6
0865	DB-E202X	0	CONCOURSE LEVEL PLAN - LIGHTING SHEET 2 OF 6
0866	DB-E203X	0	CONCOURSE LEVEL PLAN - LIGHTING SHEET 3 OF 6
0867	DB-E204X	0	CONCOURSE LEVEL PLAN - LIGHTING SHEET 4 OF 6
0868	DB-E205X	0	CONCOURSE LEVEL PLAN - LIGHTING SHEET 5 OF 6
0869	DB-E206X	0	CONCOURSE LEVEL PLAN - LIGHTING SHEET 6 OF 6

PAGE NO.	DWG NO.	REV NO.	TITLE
0870	DB-E210	0	KEY PLAN - CONCOURSE LEVEL POWER AND MISCELLANEOUS
0871	DB-E211X	0	CONCOURSE LEVEL PLAN POWER AND MISCELLANEOUS SHEET 1 OF 5
0872	DB-E212X	0	CONCOURSE LEVEL PLAN POWER AND MISCELLANEOUS SHEET 2 OF 5
0873	DB-E213X	0	CONCOURSE LEVEL PLAN POWER AND MISCELLANEOUS SHEET 3 OF 5
0874	DB-E214X	0	CONCOURSE LEVEL PLAN POWER AND MISCELLANEOUS SHEET 4 OF 5
0875	DB-E215X	0	CONCOURSE LEVEL PLAN POWER AND MISCELLANEOUS SHEET 5 OF 5
0876	DB-E300	0	KEY PLAN CONCOURSE LEVEL - HIGH CEILING LIGHTING
0877	DB-E301X	0	CONCOURSE LEVEL - HIGH CEILING PLAN LIGHTING SHEET 1 OF 4
0878	DB-E302X	0	CONCOURSE LEVEL - HIGH CEILING PLAN LIGHTING SHEET 2 OF 4
0879	DB-E303X	0	CONCOURSE LEVEL - HIGH CEILING PLAN LIGHTING SHEET 3 OF 4
0880	DB-E304X	0	CONCOURSE LEVEL - HIGH CEILING PLAN LIGHTING SHEET 4 OF 4
0881	DB-E306	0	KEY PLAN LOWER ROOF LEVEL LIGHTING
0882	DB-E307	0	LOWER ROOF LEVEL PLAN - LIGHTING SHEET 1 OF 3
0883	DB-E308	0	LOWER ROOF LEVEL PLAN - LIGHTING SHEET 2 OF 3
0884	DB-E309	0	LOWER ROOF LEVEL PLAN - LIGHTING SHEET 3 OF 3
0885	DB-E310	0	KEY PLAN LOWER ROOF LEVEL POWER AND MISCELLANEOUS
0886	DB-E311	0	LOWER ROOF LEVEL PLAN POWER AND MISCELLANEOUS SHEET 1 OF 3
0887	DB-E312	0	LOWER ROOF LEVEL PLAN POWER AND MISCELLANEOUS SHEET 2 OF 3
0888	DB-E313	0	LOWER ROOF LEVEL PLAN POWER AND MISCELLANEOUS SHEET 3 OF 3

* DENOTES THAT THIS DRAWING NUMBER IS
GOING TO CHANGE IN THE NEXT SUBMITTAL

Santa Clara Valley Transportation Authority

NO EXCEPTIONS TAKEN (NET)
MAKE CORRECTIONS NOTED (MCN)
AMEND AND RESUBMIT (A/R)

Any action shown above is subject to the terms of the contract
and does not relieve the Contractor of any of its obligations
under the contract, including design and detailing.

Contract No.: DB11002F

By: _____ Date: _____

0	20130710				READINESS FOR CONSTRUCTION
REV	DATE	BY	SUB	APP	DESCRIPTION

DESIGNED BY
S. DEBNATH
DRAWN BY
JG/B/SDG
CHECKED BY
E. BALLADA
IN CHARGE
R. BARLAAN
DATE
20130710



Skanska
Shimmick
Herzog

1436 California Circle
Milpitas, California 95035
A Joint Venture

Anil Verma Associates, Inc.
1970 Broadway, Suite 525
Phone: (510) 855-2537 Fax: (810) 535-2338
Oakland, CA 94612

Lookwood, Andrews
& Newnam, Inc.
A LEO A DALY COMPANY

T-Y LIN INTERNATIONAL

BART SILICON VALLEY BERRYESSA EXTENSION

LINE, TRACK, STATIONS, AND SYSTEMS
DESIGN UNIT 023
MILPITAS STATION

INDEX OF DRAWINGS
SHEET 8 OF 11

CADD FILENAME C700-S-DB-X034.dwg		
SIZE	SCALE	
D	NONE	
CONTRACT NO.	C700	REV. 0
AREA CODE	SHEET NO. DB X034	PAGE NO. 0009

JosephG Jul 09, 2013 - 3:37pm G:\Current Projects\VTa-Bernvessa Extension Project\Station - Milpitas\CAD\Drawings Out\13-0710 C700 Milpitas Station - RFC SubmittC700-S-DB-X035.dwg

Jul 08, 2013 - 2:15pm G:\Current Projects\VTB-Berryessa Extension Project\Station - Milpitas\CAD Drawings 04\13-0710 C700 Milpitas Station - RFC Submit\700-S-DB-X037.dwg JosephG

PAGE NO. DWG NO. REV NO. TITLE

BART FACILITIES STANDARDS – ARCHITECTURAL
(REFERENCE DRAWINGS)

1085	AS00	ABBREVIATIONS AND SYMBOLS
1086	AD15	ESCALATOR LAYOUT AND CLEARANCE DIAGRAMS
1087	AD16	SCHEMATIC ESCALATOR CLADDING ELEVATION
1088	AD17	ESCALATOR INSTALLATION DETAILS
1089	AD20	STAIR/HANDRAIL/GUARDRAIL SHEET 1 OF 3
1090	AD21	STAIR/HANDRAIL/GUARDRAIL SHEET 2 OF 3
1091	AD22	STAIR/HANDRAIL/GUARDRAIL SHEET 3 OF 3
1092	AD87	MISCELLANEOUS ITEMS
1093	AS08	ELEVATOR CAR OPERATING PANEL DETAILS
1094	AS09	ENTRANCE
1095	AS10	ELEVATOR HALL CALL DETAILS
1096	AS11	WHITE COURTESY PHONE DETAILS
1097	AS16	ESCALATOR CLADDING DETAILS
1098	AS20	STAIR/HANDRAIL/GUARDRAIL SHEET 1 OF 2
1099	AS21	STAIR/HANDRAIL/GUARDRAIL SHEET 2 OF 2
1100	AS40	FLOOR PAVING DETAILS
1101	AS42	PLATFORM EDGE DETAILS
1102	AS44	SIGNAGE/LIGHTING/PUBLIC ADDRESS STRUCTURE PROFILE SHEET 1 OF 2
1103	AS45	SIGNAGE/LIGHTING/PUBLIC ADDRESS STRUCTURE PROFILE SHEET 2 OF 2
1104	AS65	FIRE HOSE CABINETS SHEET 1 OF 2
1105	AS66	FIRE HOSE CABINETS SHEET 2 OF 2
1106	AS67	FIRE HOSE CABINET DETAILS
1107	AS70	SERVICE GATES AND BARRIER DETAILS
1108	AS75	TICKET VENDING MACHINE ENCLOSURE DETAILS
1109	AS83	MAPS/SCHEDULE FRAME
1110	AS85	INFORMATION KIOSK

PAGE NO. DWG NO. REV NO. TITLE

PAGE NO. DWG NO. REV NO. TITLE

PAGE NO. DWG NO. REV NO. TITLE

Santa Clara Valley Transportation Authority

NO EXCEPTIONS TAKEN (NET)

MAKE CORRECTIONS NOTED (MCN)

AMEND AND RESUBMIT (A/R)

Any action shown above is subject to the terms of the contract and does not relieve the Contractor of any of its obligations under the contract, including design and detailing.

Contract No.:DB11002F

By:Date:

0	20130710							READINESS FOR CONSTRUCTION	
REV	DATE	BY	SUB	APP				DESCRIPTION	

DESIGNED BY
S. DEBNATH
DRAWN BY
JG/BI/SDG
CHECKED BY
E. BALLADA
IN CHARGE
R. BARLAAN
DATE
20130710



Skanska Shimmick Herzog

1436 California Circle
Milpitas, California 95035
A Joint Venture

Anil Verma Associates, Inc.

1970 Broadway, Suite 525
Milpitas, CA 95035
Phone: (510) 835-2537 Fax: (810) 535-2338

Lookwood, Andrews & Newman, Inc.

A LEAD A BART COMPANY

T-Y LIN INTERNATIONAL

APPROVED

BART

SILICON VALLEY

BART SILICON VALLEY BERRYESSA EXTENSION

LINE, TRACK, STATIONS, AND SYSTEMS
DESIGN UNIT 023
MILPITAS STATION

INDEX OF DRAWINGS
SHEET 11 OF 11

CADD FILENAME
C700-S-DB-X037.dwg

SIZE D SCALE NONE

CONTRACT NO. C700 REV. 0

AREA CODE DB

SHEET NO. X037

PAGE NO. 0012