


FKP Architects

ARCHITECT OF RECORD  
Paul C. Gloriod

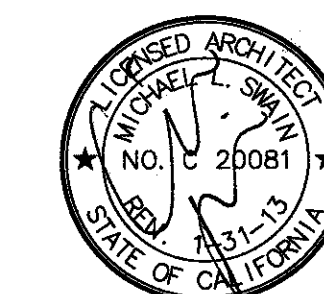


Changes on these drawings do not consist of  
materially altered changes to approved drawings  
and don't require a change order.  
OSHPD review ACO  
OSHPD review FLSO  
OSHPD review DSE

REVISIONS

02/13/11 CO #300

APPROVAL

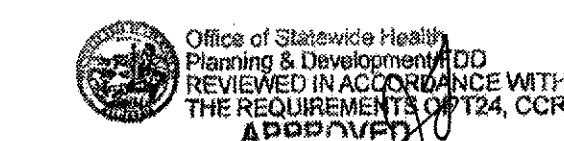

CHANGE ORDER  
INSTRUCTION BULLETIN  
DEFERRED APPROVAL  
ADDENDUM

PROJECT NAME PAD 2011-0239B

CHILDREN'S HOSPITAL  
OF ORANGE COUNTY

455 S. Main St.  
Orange, CA 92668-3874

TOWER II Received  
June 05 2012  
McCarthy



PROJECT NUMBER

12011.00  
Increment #7

OSHPD - PROJECT NUMBER  
IL 072072-30

ISSUE  
OSHPD PERMIT

DATE  
01/27/2010


SCALE


1/16" = 1'-0"

DRAWING TITLE  
LEVEL 4 FLOOR PLAN

DRAWING NUMBER


A3.41

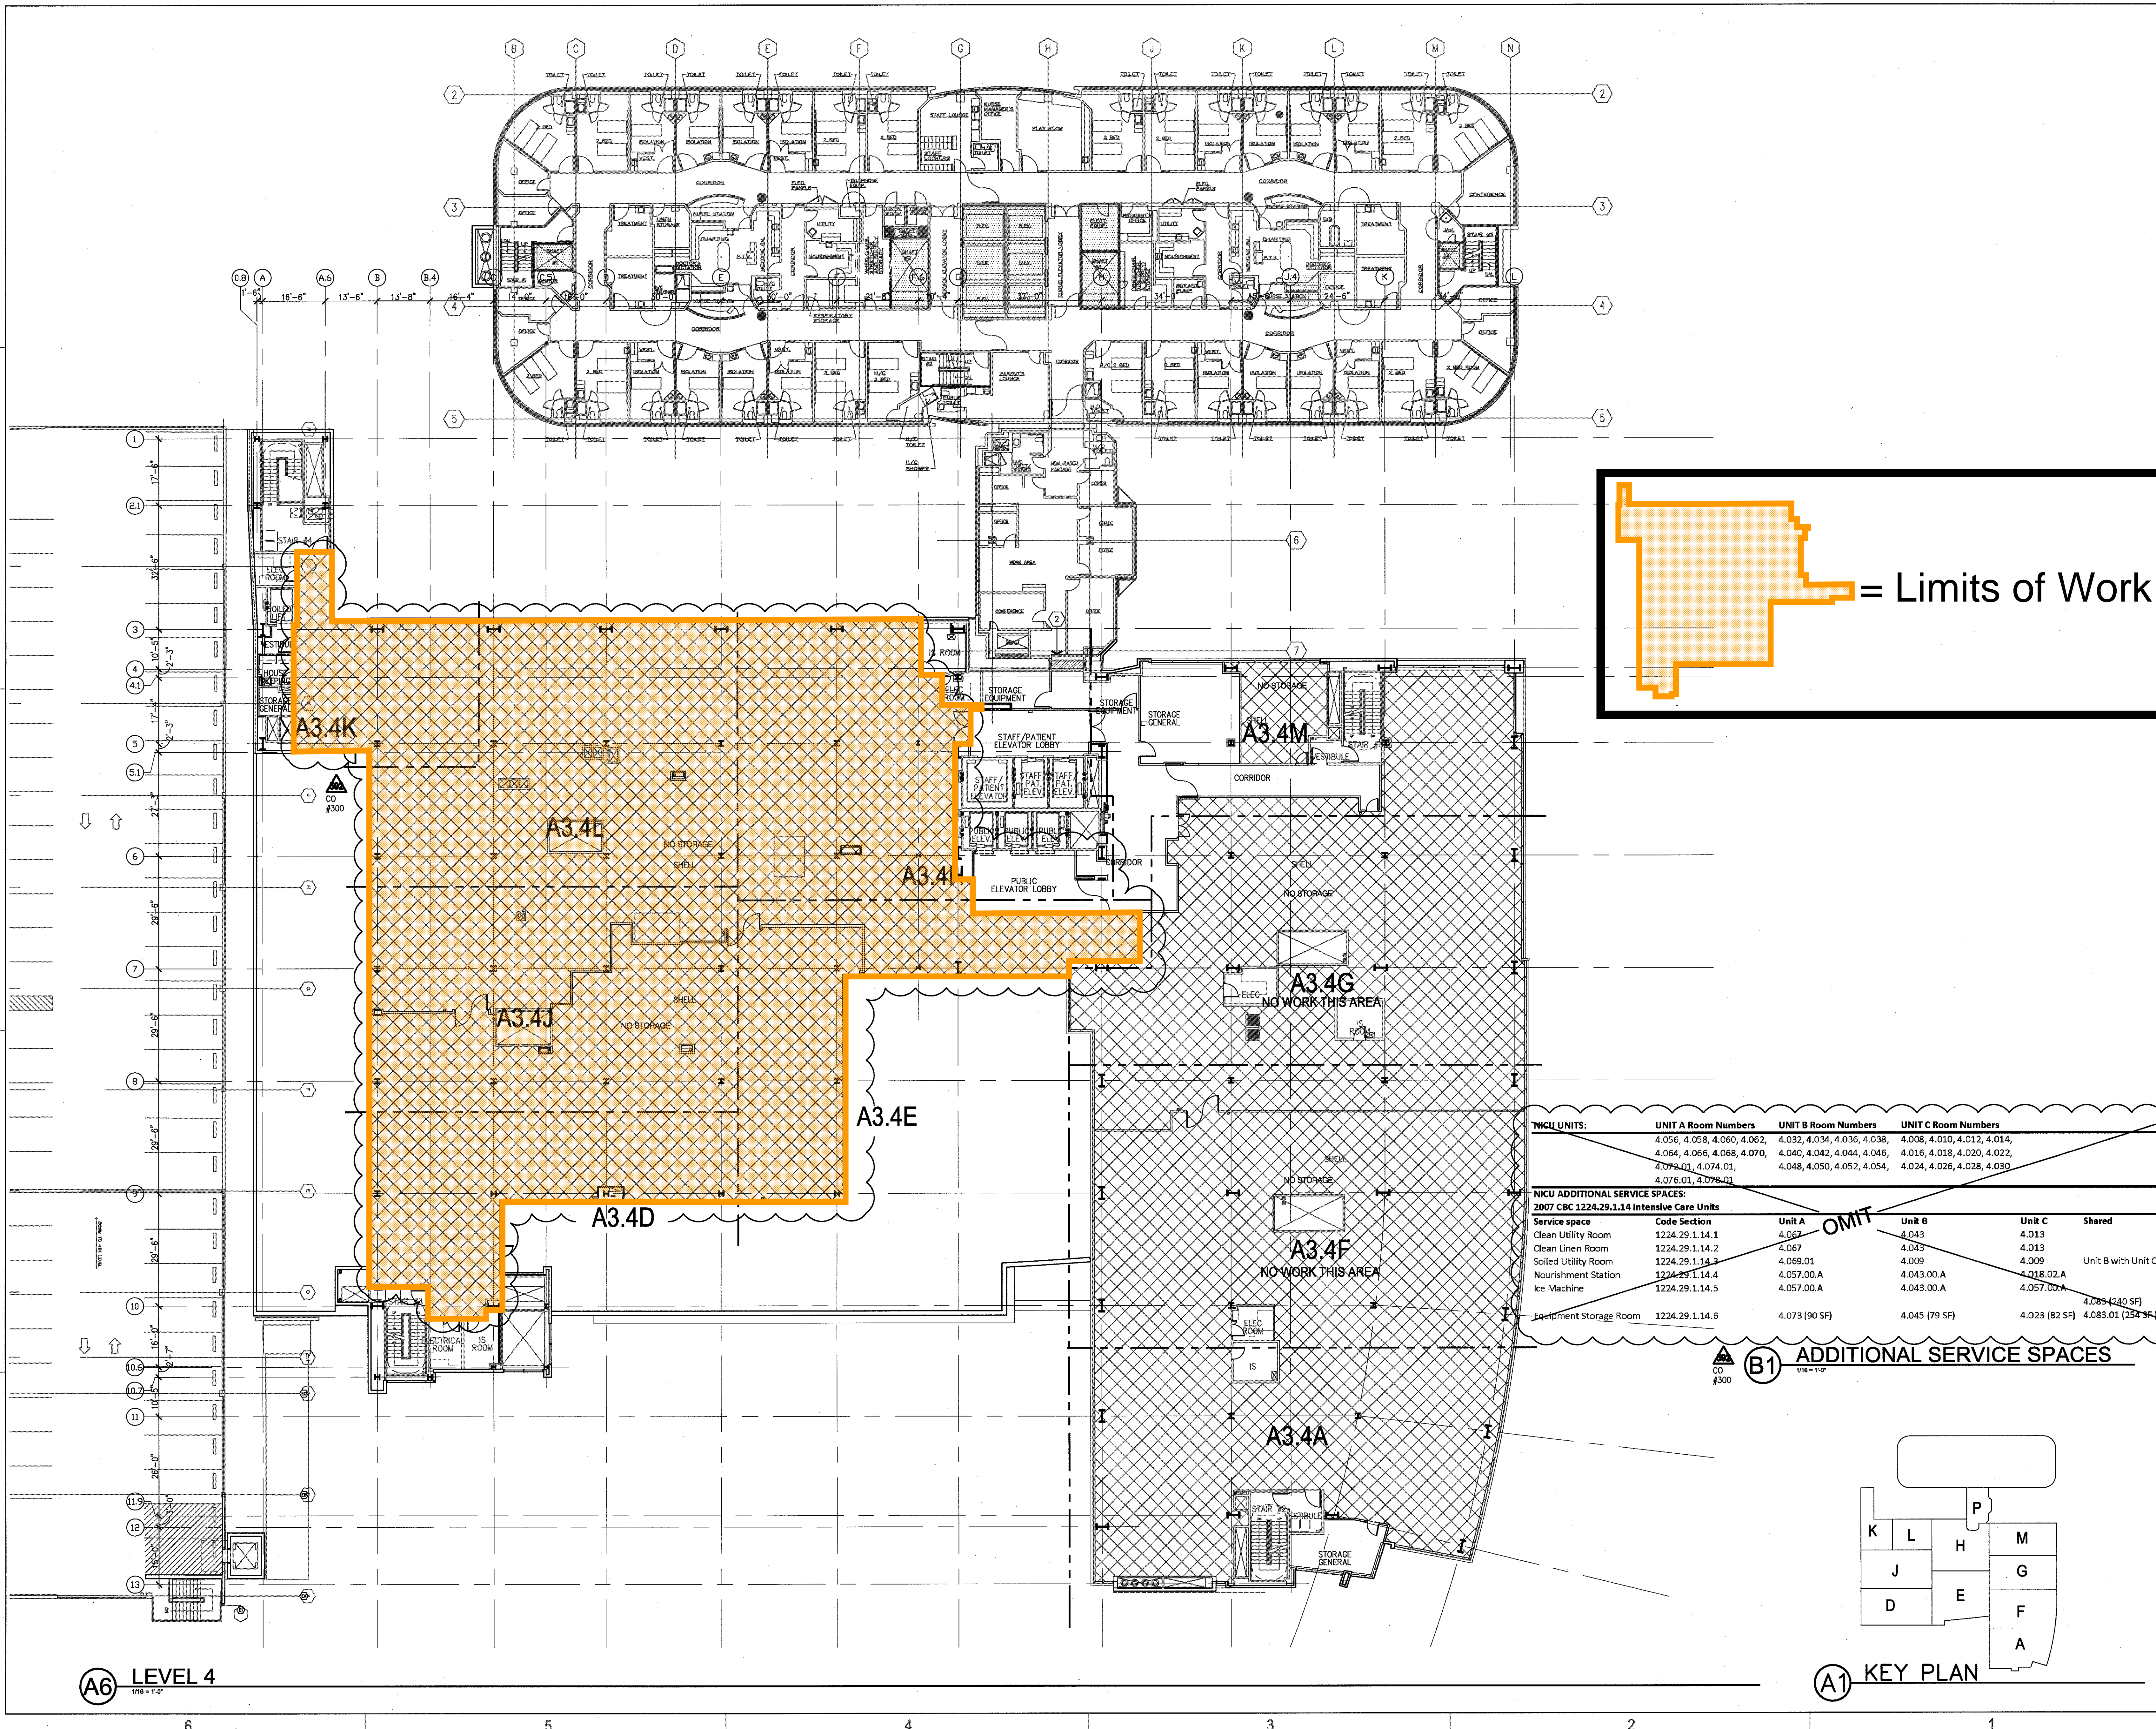

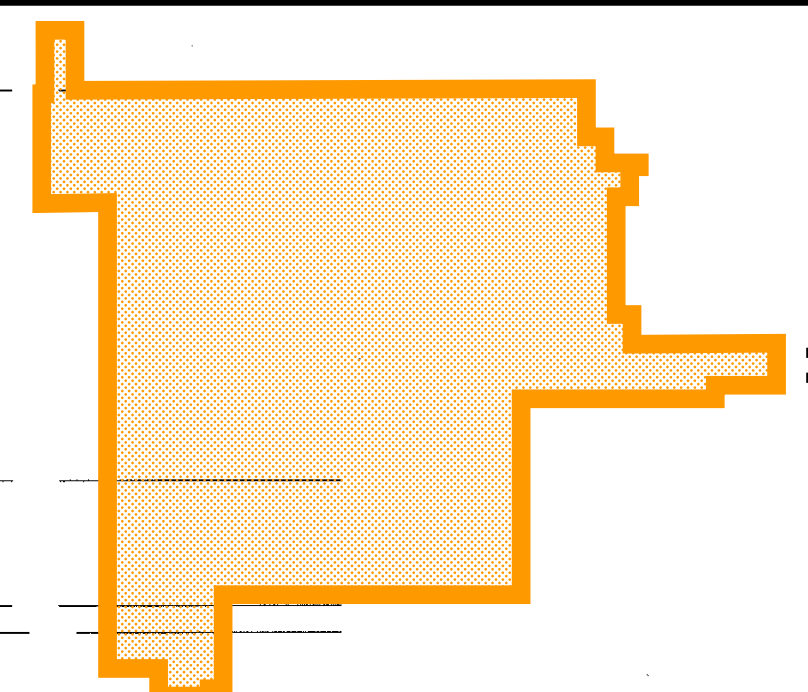 = Limits of Work

NICU UNITS:		UNIT A Room Numbers	UNIT B Room Numbers	UNIT C Room Numbers	
		4.056, 4.058, 4.060, 4.062, 4.064, 4.066, 4.068, 4.070, 4.072-01, 4.074-01, 4.076-01, 4.078-01	4.032, 4.034, 4.036, 4.038, 4.040, 4.042, 4.044, 4.046, 4.048, 4.050, 4.052, 4.054	4.008, 4.010, 4.012, 4.014, 4.016, 4.018, 4.020, 4.022, 4.024, 4.026, 4.028, 4.030	
NICU ADDITIONAL SERVICE SPACES:					
2007 CBC 1224.29.1.14 Intensive Care Units					
Service space	Code Section	Unit A	Unit B	Unit C	Shared
Clean Utility Room	1224.29.1.14.1	4.067	4.043	4.013	
Clean Linen Room	1224.29.1.14.2	4.067	4.043	4.013	
Soiled Utility Room	1224.29.1.14.3	4.069.01	4.009	4.009	Unit B with Unit C
Nourishment Station	1224.29.1.14.4	4.057.00.A	4.043.00.A	4.018.02.A	
Ice Machine	1224.29.1.14.5	4.057.00.A	4.043.00.A	4.057.00.A	
Equipment Storage Room	1224.29.1.14.6	4.073 (90 SF)	4.045 (79 SF)	4.023 (82 SF)	4.085 (240 SF), 4.083.01 (254 SF)

**(B1) ADDITIONAL SERVICE SPACES**  
1/16" = 1'-0"

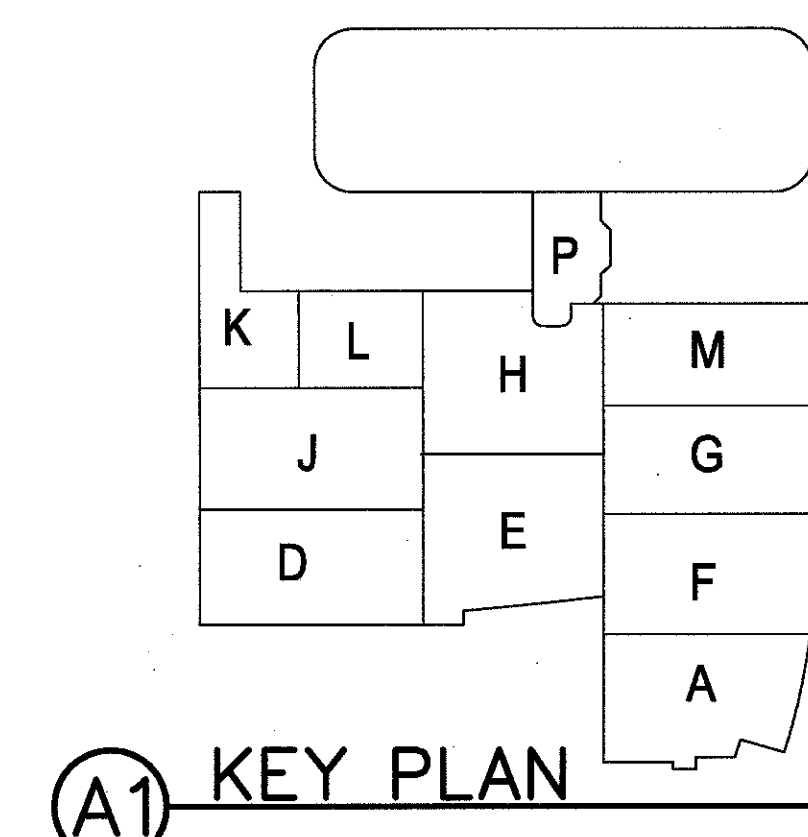

**(A1) KEY PLAN**

**(A6) LEVEL 4**  
1/16" = 1'-0"