


This architectural floor plan shows a building layout with a grid system. The vertical grid lines are labeled G, G.4, H, J, J.4, J.9, K, and L. The horizontal grid lines are labeled 7, 8, 9, 9.5, 10, 10.4, 10.7, 11, 11.9, 12, and 13. Dimensions are provided along the grid lines: 20'-6" (G to G.4), 20'-6" (G.4 to H), 14'-0" (H to J), 14'-0" (J to J.4), 16'-0" (J.4 to J.9), 10'-5" (J.9 to K), 26'-0" (K to L), 3'-0" (7 to 8), 10'-5" (8 to 9), 14'-0" (9 to 9.5), 14'-0" (9.5 to 10), 16'-0" (10 to 10.4), 10'-5" (10.4 to 10.7), 11'-0" (10.7 to 11), 15'-0" (11 to 11.9), 3'-0" (11.9 to 12), and 15'-0" (12 to 13). The plan includes various rooms and areas, such as a CONTROL AREA, GENERATOR, and several rooms with green and blue equipment. A ramp is labeled 1:12 RAMP. The plan also shows a staircase and a large open area with green and blue equipment. The building is situated on a site with a dashed line indicating a boundary or road.

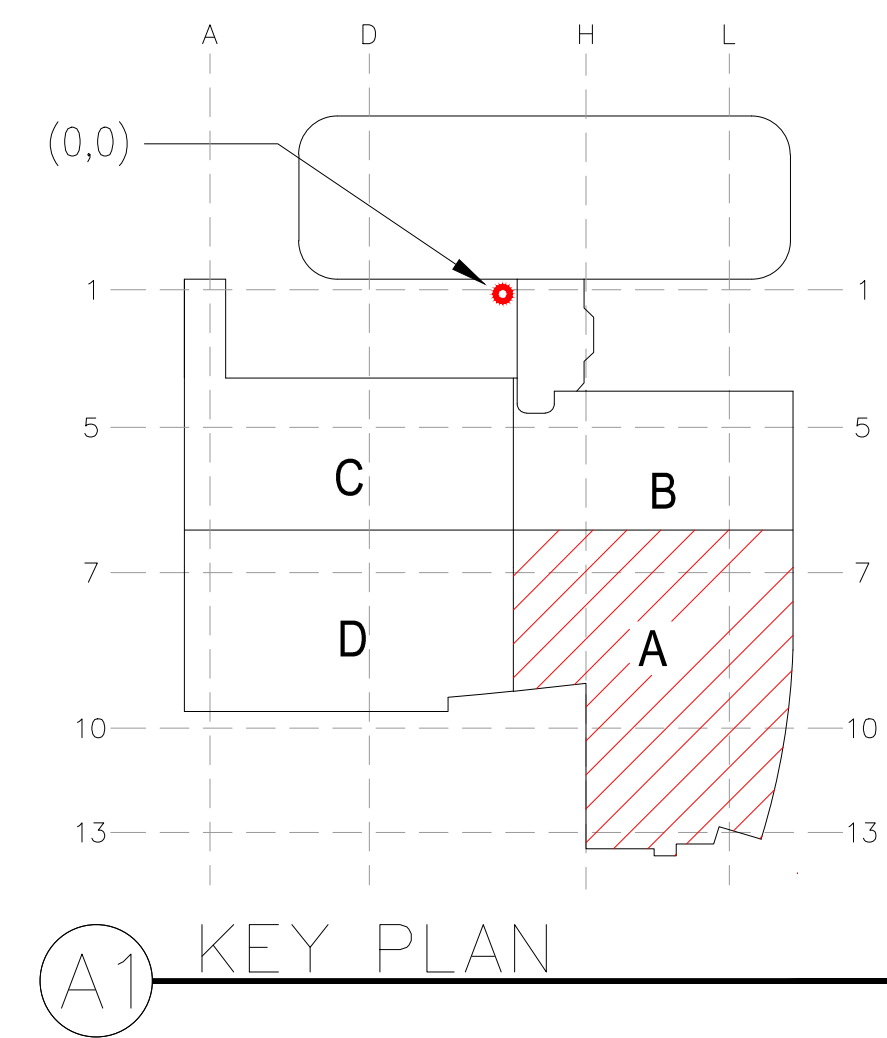

<h2 style="margin: 0;">McCarthy APPROVAL</h2>	
A. Approval is noted for architectural Review	<input type="checkbox"/>
B. Review and Request	<input type="checkbox"/>
C. Rejected	<input type="checkbox"/>
<p>This review is for general conformance with Plans and Specifications only. Any deviations from same not clearly noted by the Preparer have not been reviewed. Review shall not constitute a complete check of detailed dimensions or contract to serve to relieve the Preparer of contractual responsibility for any error or deviation from contract requirements.</p> <p style="text-align: center; font-size: 1.5em; font-weight: bold; margin: 20px 0;">McCarthy</p> <p style="text-align: center;">By _____ Do to _____</p> <p style="text-align: center; font-weight: bold; margin-top: 10px;">SHOP DRAWING REFERENCE NO. _____</p>	

[illegible]

COORD.	SIGNATURE	DATE
MCCARTY		
MECHANICAL DUCT		
MECHANICAL PPE		
PLUMBING		
ELECTRICAL		
FIRE SPRINKLER		
PIUMB		
DRYWALL/FRAMER		
REFRIGERATION		
STRUCTURAL		

[illegible]



**CHILDREN'S HOSPITAL
OF ORANGE COUNTY**
455 S. Main St.
Orange, CA 92668-3874

TOWER III

ACCESS PANEL PLAN - BASEMENT LEVEL AREA-A

©2005 J&J. Printed by J&J. 11-05-2011 15:46pm

DWG: 12-238-308_0001 (2010) (AUTOCAD) (Cadd: Arren) (Format: 1/8"=1'-0")
 DRAWN: J.T.
 CHECKED: M.M.
 DATE: 05/26/2011
 SCALE: 1/8"=1'-0"
 JOB NO.: 09-006
 DRAWING NUMBER: CAD-LL-A
 REFERENCE DRAWING: A4.5A
 1 OF 2 SHEETS

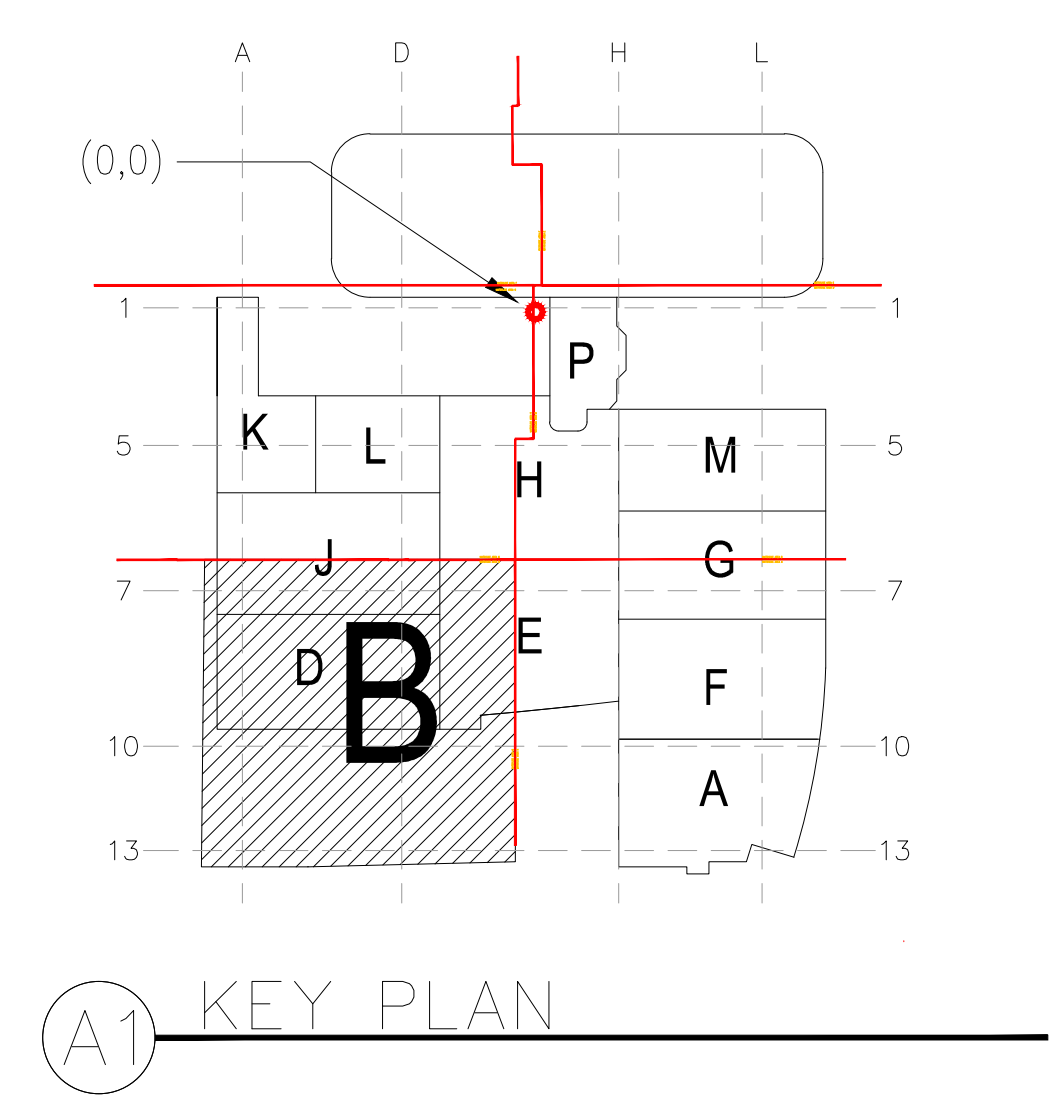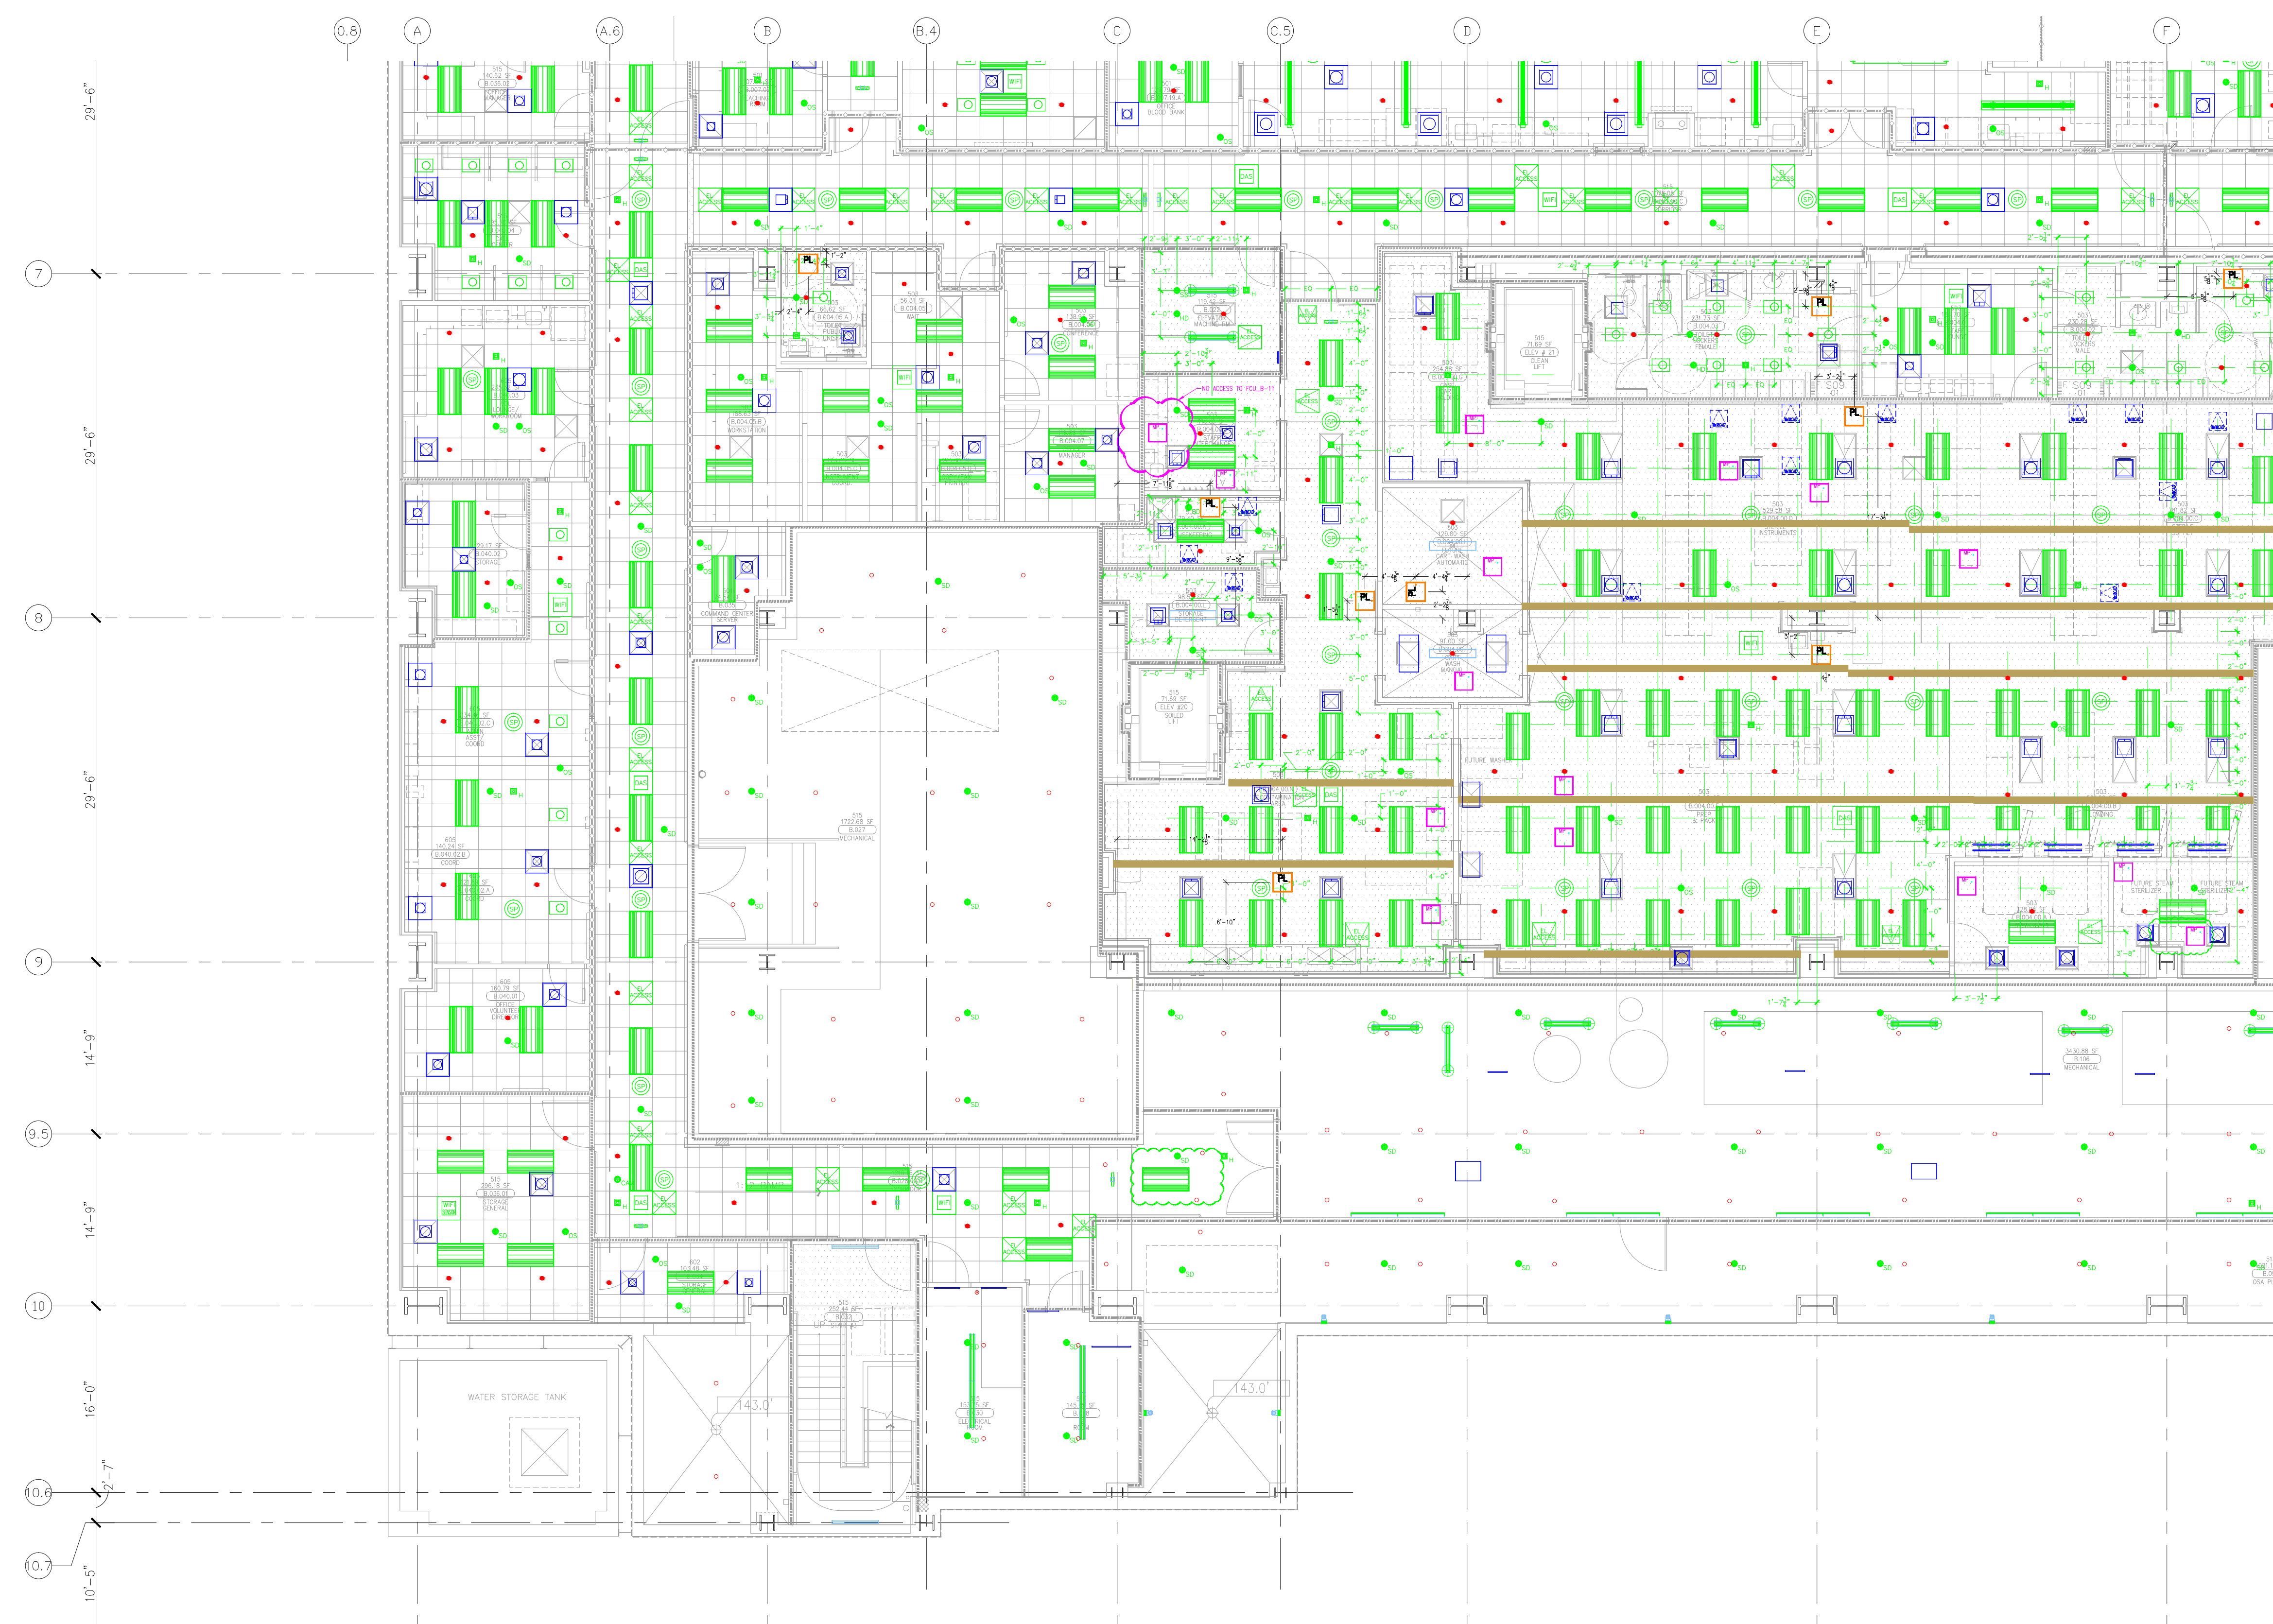

PLUMBING-PL	
SHEET METAL-MD	
FIRE PROTECTION-FP	
MECHANICAL PIPE-MP	
PNEUMATIC TUBE-PT	
ELECTRICAL-EL	

[illegible]

COORD.	SIGNATURE	DATE
MCCARTHY		
MECHANICAL DUCT		
MECHANICAL PIPE		
PLUMBING		
ELECTRICAL		
FIRE SPROWLER		
PAINT		
DRYWALL/FRAMER		
REFRIGERATION		
STRUCTURAL		

[illegible]

**CHILDREN'S HOSPITAL
OF ORANGE COUNTY**
455 S. Main St.
Orange, CA 92665-3874

TOWER II

ACCESS PANEL PLAN - BASEMENT LEVEL AREA-B


PMF

PAN-PACIFIC
PLUMBING & MECHANICAL

Murray
Company

2919 E. VICTORIA STREET, RANCHO DOMINGUEZ, CA 90221
PH. 310 693-1040 FAX. 310 694-4830

This document and the design it covers are the property of Murray Co. They are loaned only with the borrower's expressed written agreement that they will not be reproduced, copied, loaned, exhibited, or used in any other way, except by written consent from Murray Co. to the borrower.

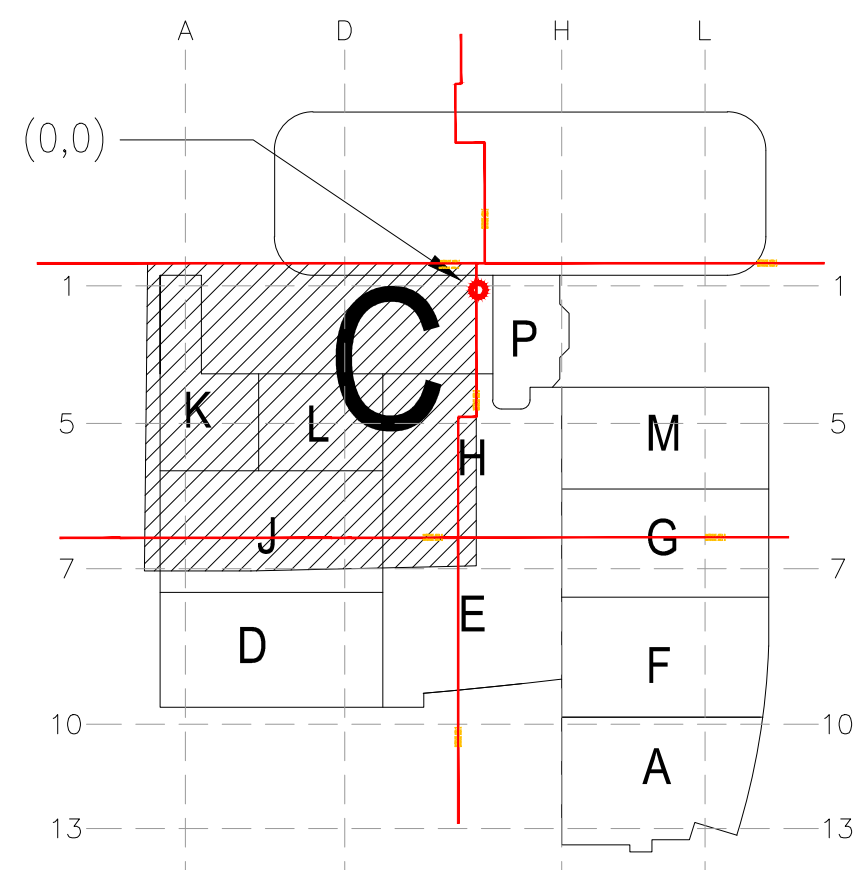

PLUMBING-PL	
SHEET METAL-MD	
FIRE PROTECTION-FP	
MECHANICAL PIPE-MP	
PNEUMATIC TUBE-PT	
ELECTRICAL-EL	

REVISIONS	BY
ISSUED FOR CONSTRUCTION	JT

COORDINATE	SYMBOL	DATE
MECHANICAL		
PLUMBING		
ELECTRICAL		
FIRE PROTECTION		
PNEUMATIC TUBE		
DRYWALL/FRAMER		
REFRIGERATION		
STRUCTURAL		

REV.	DATE	DESCRIPTION	BY	CHK.

CHOC
CHILDREN'S HOSPITAL
OF ORANGE COUNTY
2015 S. MAIN STREET, SUITE 300
ORANGE, CA 92668-3974
TOWER II
ACCESS PANEL PLAN - BASEMENT LEVEL AREA C

PAN-PACIFIC
Murray Company
2019 E. VICTORIA STREET, RANCHO DOMINGUEZ, CA 90221
PH: 310.637-1500 FAX: 310.604-0359

DRAWN: J.M.
CHECKED: M.M.
DATE: 10/6/2011
SCALE: 1/8"=1'-0"
JOB NO.: 09-006
DRAWING NUMBER: CAD-LL-C
REFERENCE DRAWING:

This document and the design it covers are the property of Murray Co. They are loaned only with the borrower's expressed written agreement that they will not be reproduced, copied, loaned, exhibited, or used in any other way, except by written consent from Murray Co. to the borrower.



PLUMBING-PL	
SHEET METAL-MD	
FIRE PROTECTION-FP	
MECHANICAL PIPE-MP	
PNEUMATIC TUBE-PT	
ELECTRICAL-EL	

REVISIONS	BY
ISSUED FOR CONSTRUCTION	JT

COORD.	REVISION	DATE
MECHANICAL		
MECHANICAL DUCT		
MECHANICAL PIPE		
PLUMBING		
ELECTRICAL		
FIRE SPRINKLER		
PIPE		
DRYWALL/FRAMER		
REFRIGERATION		
STRUCTURAL		

REVISION	DATE	BY	CHKD.	DATE	BY	CHKD.	DATE	BY	CHKD.

MCCARTHY APPROVAL

A. Approved as noted for Architectural Review

B. Review and Requisite


C. Rejected

This review is for general conformance with Plans and Specifications only. Any deviations from same not clearly noted by the Program have not been reviewed. Review shall not constitute a complete check of detailed dimensions or details to verify to relieve the Proprietor of contractual responsibility for any error or deviation from contract requirements.

McCarthy

By: _____ Date: _____

SHEP DRAWING REFERENCE NO. _____

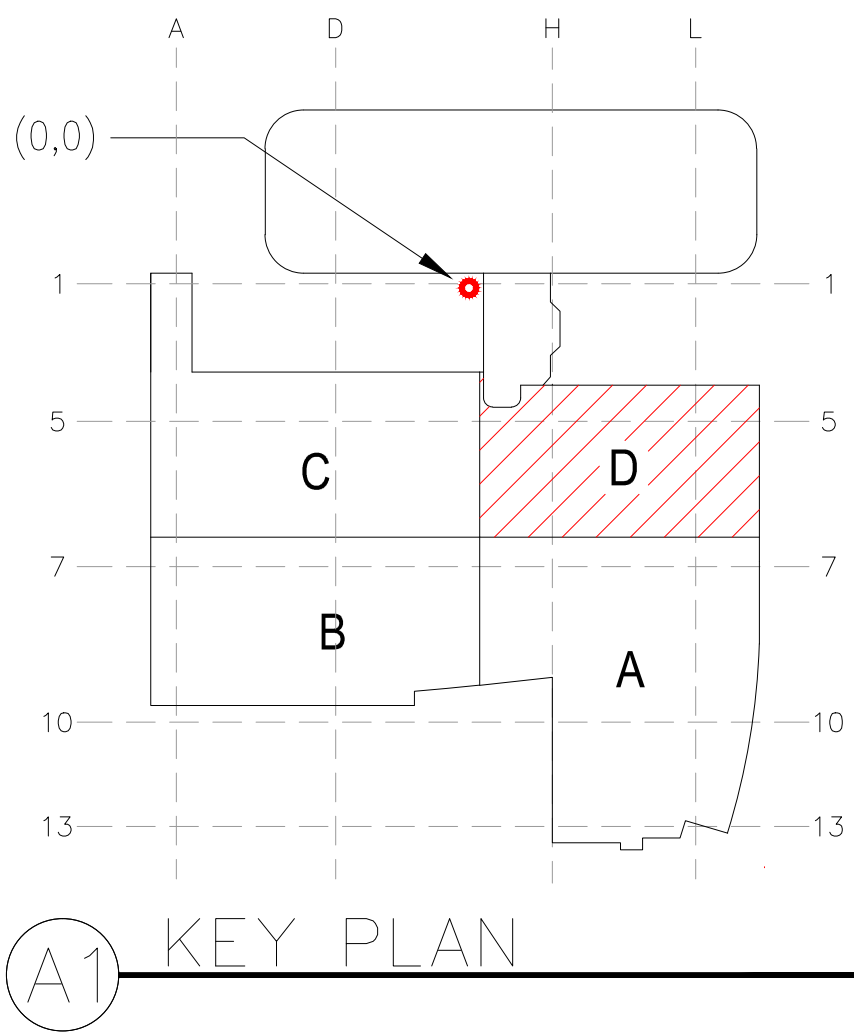

CHOC

CHILDREN'S HOSPITAL
OF ORANGE COUNTY

405 S. MAIN ST.
ORANGE, CA 92667-9974

TOWER II

ACCESS PANEL PLAN - BASEMENT LEVEL AREA-B

PAN-PACIFIC

Murray Company

PAN-PACIFIC

2019 E. VICTORIA STREET, RANCHO DOMINGUEZ, CA 90221

PH: 310 637-1500 FAX: 310 604-0359

DESIGN: JT.

CHECKED: M.M.

DATE: 05/26/2011


SCALE: 1/8"=1'-0"

JOB NO: 09-006


DRAWING NUMBER: CAD-LL-D

REFERENCE DRAWING: A4.5D

This document and the design it covers are the property of Murray Co. They are loaned only with the borrower's expressed written agreement that they will not be reproduced, copied, loaned, exhibited, or used in any other way, except by written consent from Murray Co. to the borrower.

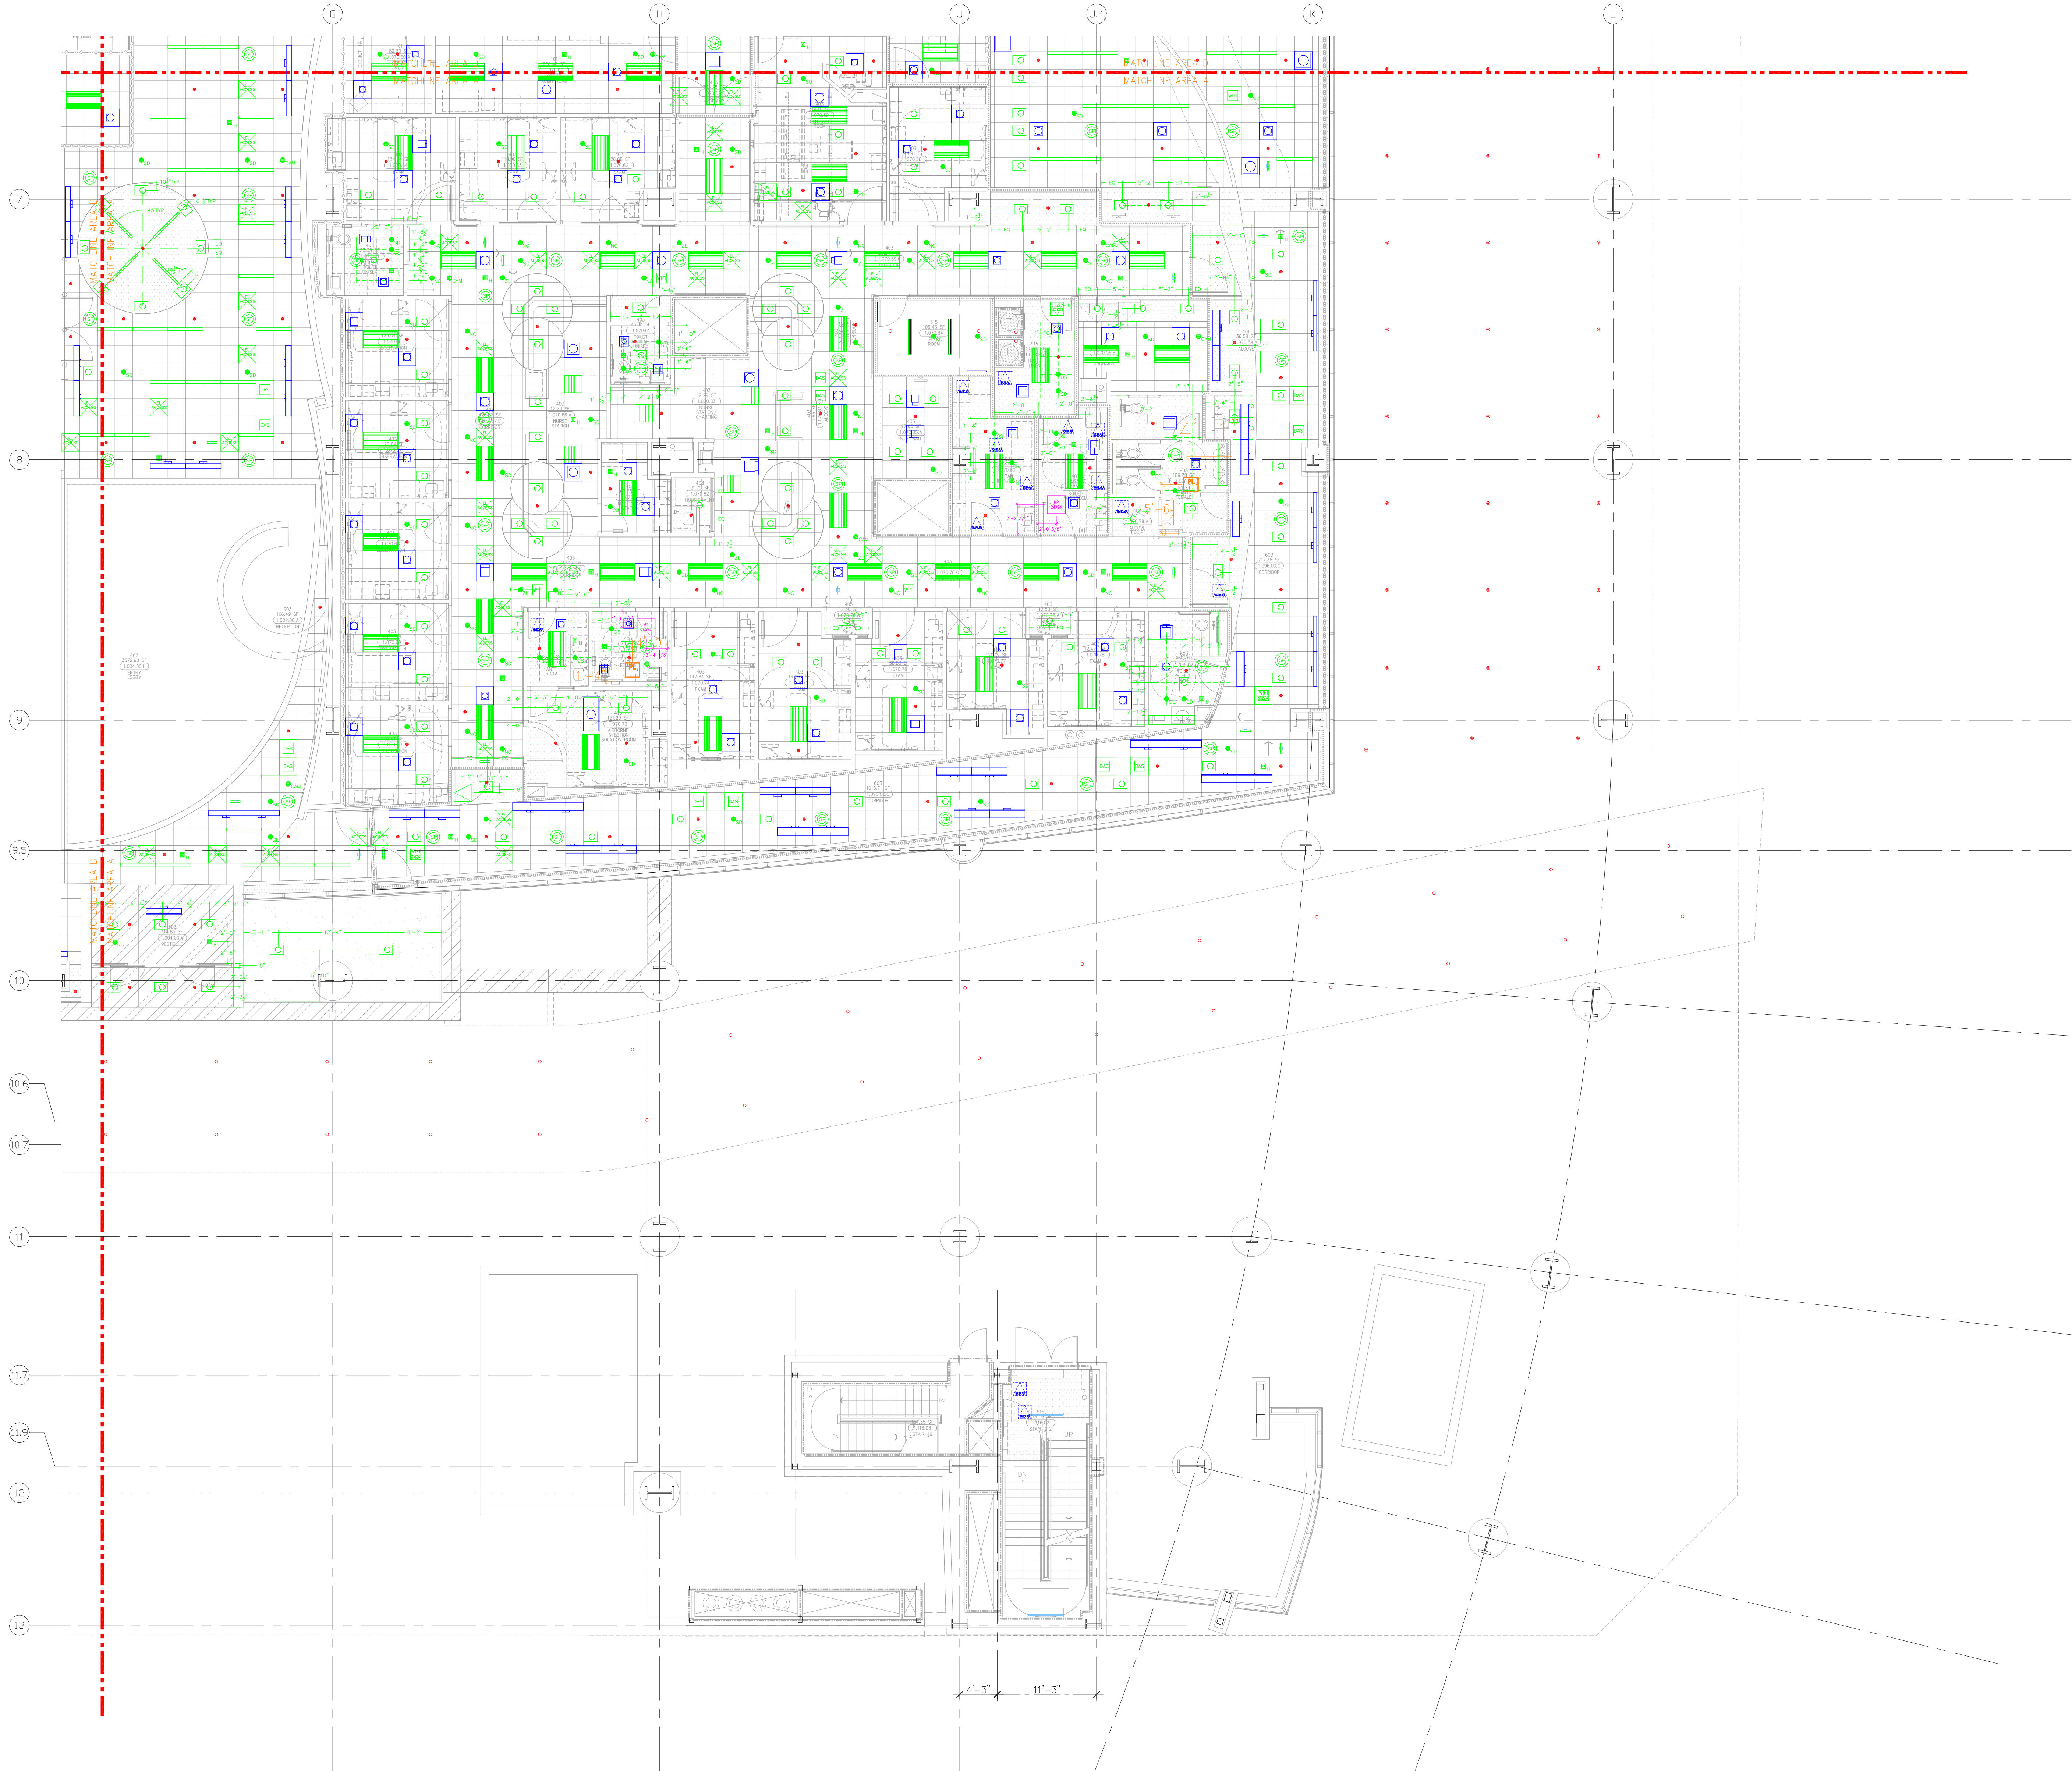

LEVEL 01 161.30' = 0'-0"
REFERENCE THIS SHEET

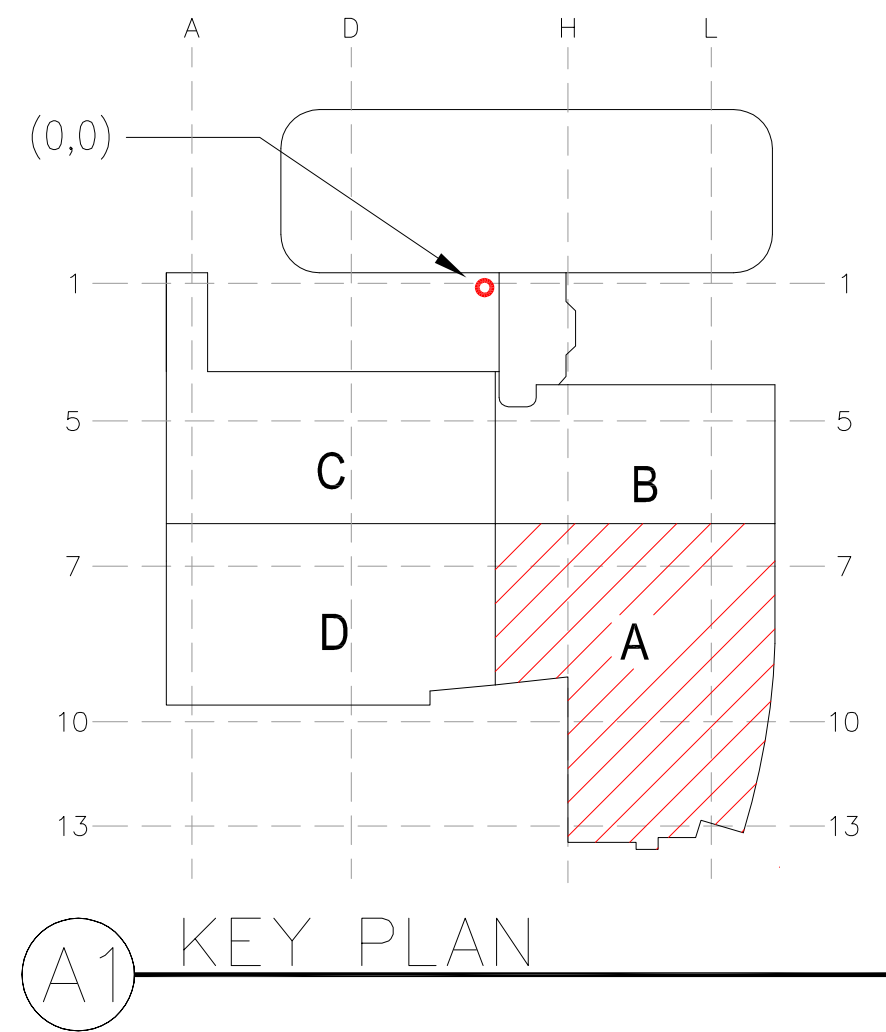

PLUMBING-PL	
SHEET METAL-MD	
FIRE PROTECTION-FP	
MECHANICAL PIPE-MP	
PNEUMATIC TUBE-PT	
ELECTRICAL-EL	

REVISIONS	BY
ISSUED FOR CONSTRUCTION	JT

COUNTY	SIGNATURE	DATE
MECHANICAL		
MECHANICAL		
MECHANICAL		
ELECTRICAL		
FIRE SPRINKLER		
PIPE		
DRYWALL/PAINT		
REFRIGERATION		
STRUCTURAL		

REV.	DATE	DESCRIPTION	BY	CHK.

MCCARTHY APPROVAL

A. Approved as noted for Architectural Review ☐

B. Review and Rejected ☐

C. Rejected ☐

This review is for general conformance with Plans and Specifications only. Any deviations from same not clearly noted by the Project team are not reviewed. Review shall not constitute a complete check of detailed dimensions or construction to ensure the Projector of construction responsibility for any error or deviation from contract requirements.

McCarthy

By: _____ Date: _____

ENR. DRAWING REFERENCE NO. _____

CHOC
CHILDREN'S HOSPITAL
OF ORANGE COUNTY
200 S. MAIN ST.
ORANGE, CA 92668-3874
TOWER II
ACCESS PANEL PLAN-LEVEL 01 AREA A


PAN-PACIFIC
PACIFIC
Murray Co.
2919 E. VICTORIA STREET, RANCHO DOMINGUEZ, CA 90221
PH. 310.637-1500 FAX 310.604-0359

DRAWN
JT
CHECKED
M.M.
DATE
05/26/2011
SCALE
1/8"=1'-0"
JOB NO.
09-006
DRAWING NUMBER
CAD-L1-A
REFERENCE DRAWING
A4.5A

This document and the design it covers are the property of Murray Co. They are loaned only with the borrower's expressed written agreement that they will not be reproduced, copied, loaned, exhibited, or used in any other way, except by written consent from Murray Co. to the borrower.



LEVEL 01 161.30' = 0'-0"
REFERENCE THIS SHEET

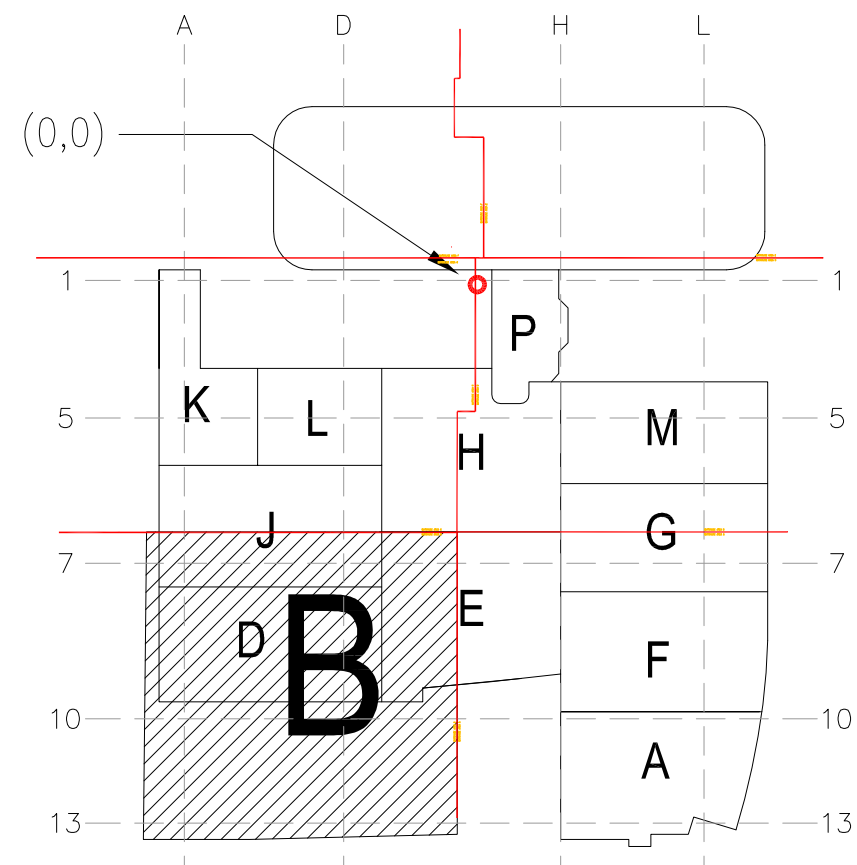

PLUMBING-PL	
SHEET METAL-MD	
FIRE PROTECTION-FP	
MECHANICAL PIPE-MP	
PNEUMATIC TUBE-PT	
ELECTRICAL-EL	

REVISIONS	BY
ISSUED FOR CONSTRUCTION	JT



COUNT	REVISION	DATE

REF.	SENT	ANS.	REF.	SENT	ANS.	REF.	SENT	ANS.	REF.	SENT	ANS.

CHOC
CHILDREN'S HOSPITAL
OF ORANGE COUNTY
405 S. MAIN ST.
ORANGE, CA 92668-3874
TOWER II
ACCESS PANEL PLAN-LEVEL 01 AREA-B

PAN-PACIFIC
PLUMBING & MECHANICAL
Murray Company
2919 E. VICTORIA STREET, RANCHO DOMINGUEZ, CA 90221
PH. 310.637-1500 FAX 310.604-0359

DRAWN: J.M.
CHECKED: M.M.
DATE: 7/5/2011
SCALE: 1/8"=1'-0"
JOB NO.: 09-006
DRAWING NUMBER: CAD-L1-B
REFERENCE DRAWING: 1 OF 1 SHEETS

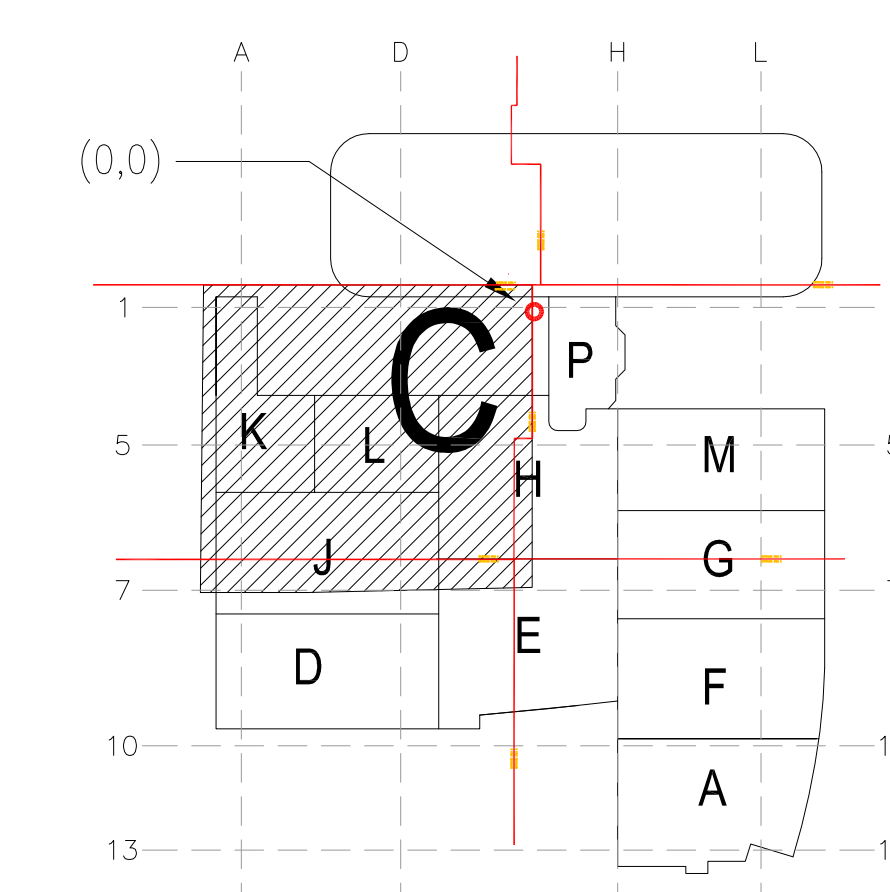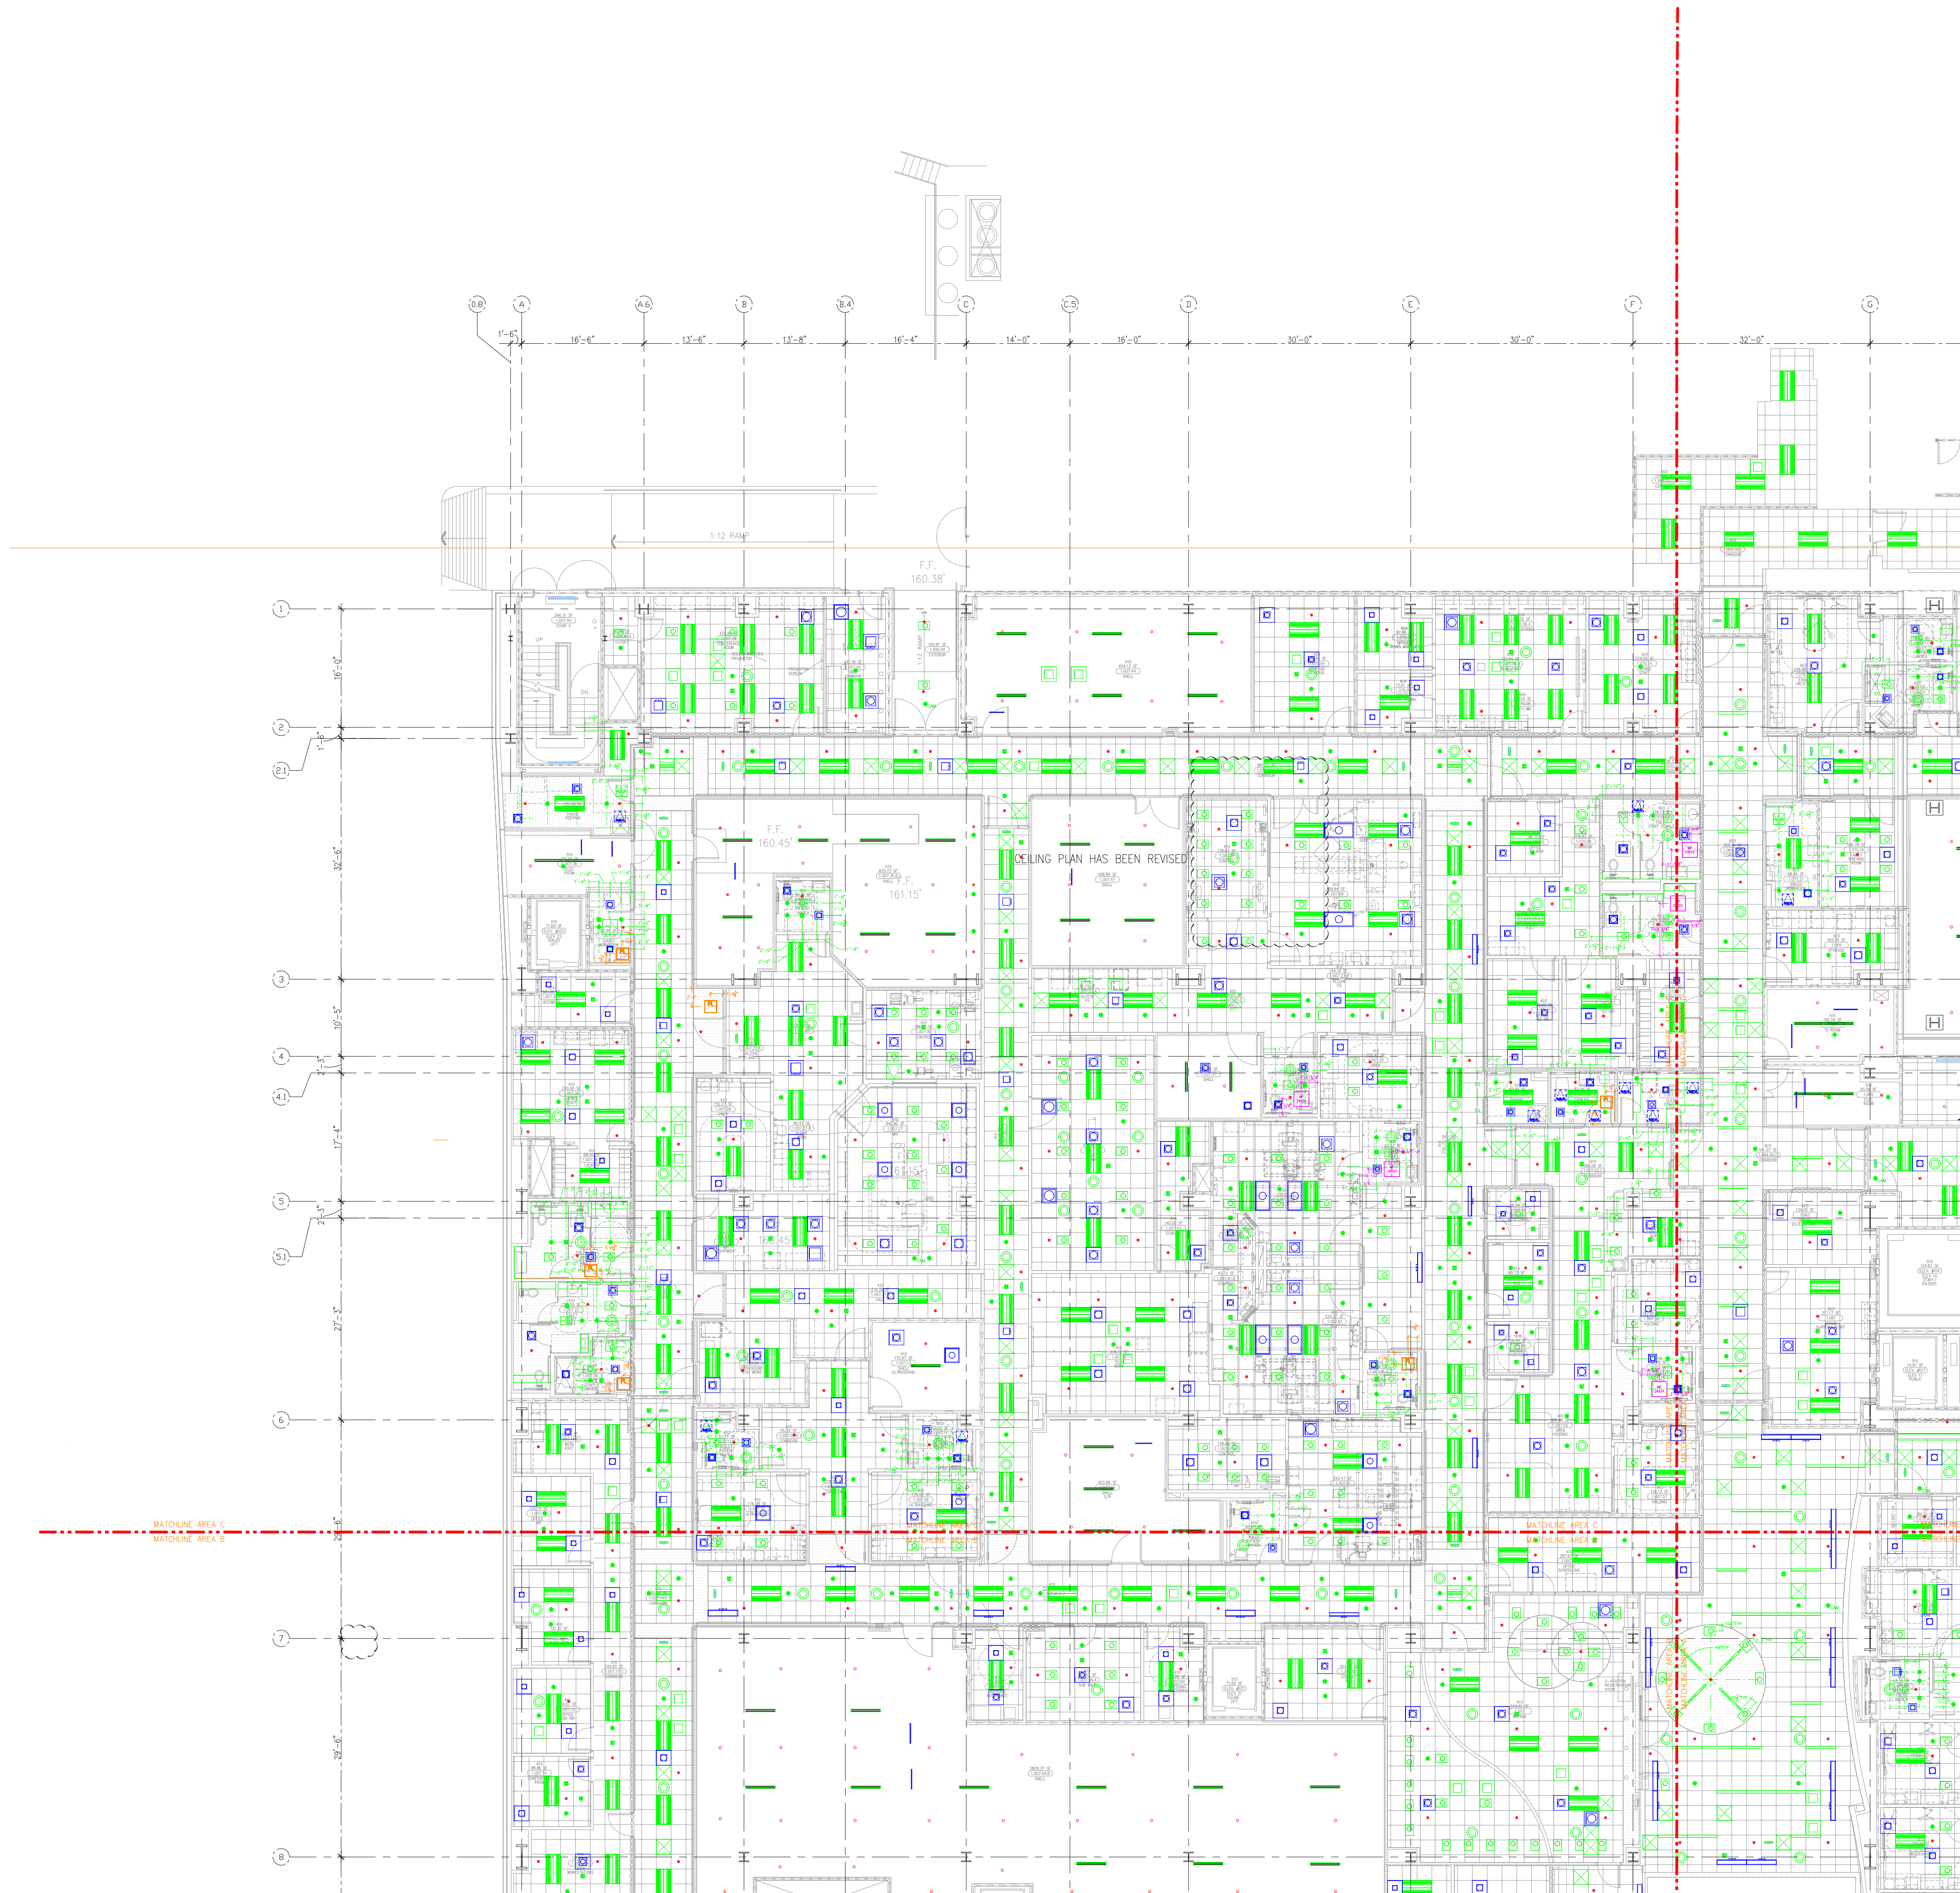

A1 KEY PLAN

LEVEL 01 161.30' = 0'-0"

REFERENCE THIS SHEET

PLUMBING-PL	
SHEET METAL-MD	
FIRE PROTECTION-FP	
MECHANICAL PIPE-MP	
PNEUMATIC TUBE-PT	
ELECTRICAL-EL	

[illegible]

COURD.	SIGNATURE	DATE
McARTHUR		
MECHANICAL DUCT		
MECHANICAL PIPE		
PLUMBING		
ELECTRICAL		
FIRE SPRINKLER		
PIPE		
DRYWALL/FRAMER		
REFRIGERATION		
STRUCTURAL		

[illegible]

CHILDREN'S HOSPITAL
OF ORANGE COUNTY
465 S. Main St.
Orange, CA 92665-3974
TOWER II
ACCESS PANEL PLUMB - LEVEL 01 AREA-C

PAN-PACIFIC
PLANNING & ANALYSIS, INC.


PAC

Murray Company

2919 E. VICTORIA STREET, RANCHO DOMINGUEZ, CA 90221
PH: 310.639-1500 FAX: 310.604-0559

DRAWN
 J.M.
 CHECKED
 M.M.
 DATE
 7/5/2011
 SCALE
 $1/8" = 1'-0"$
 JOB NO.
 09-006
 DRAWING NUMBER
 CAD-L1-C
 REFERENCE DRAWING

This document and the design it covers are the property of Murray Co. They are loaned only with the borrower's expressed written agreement that they will not be reproduced, copied, loaned, exhibited, or used in any other way, except by written consent from Murray Co. to the borrower.

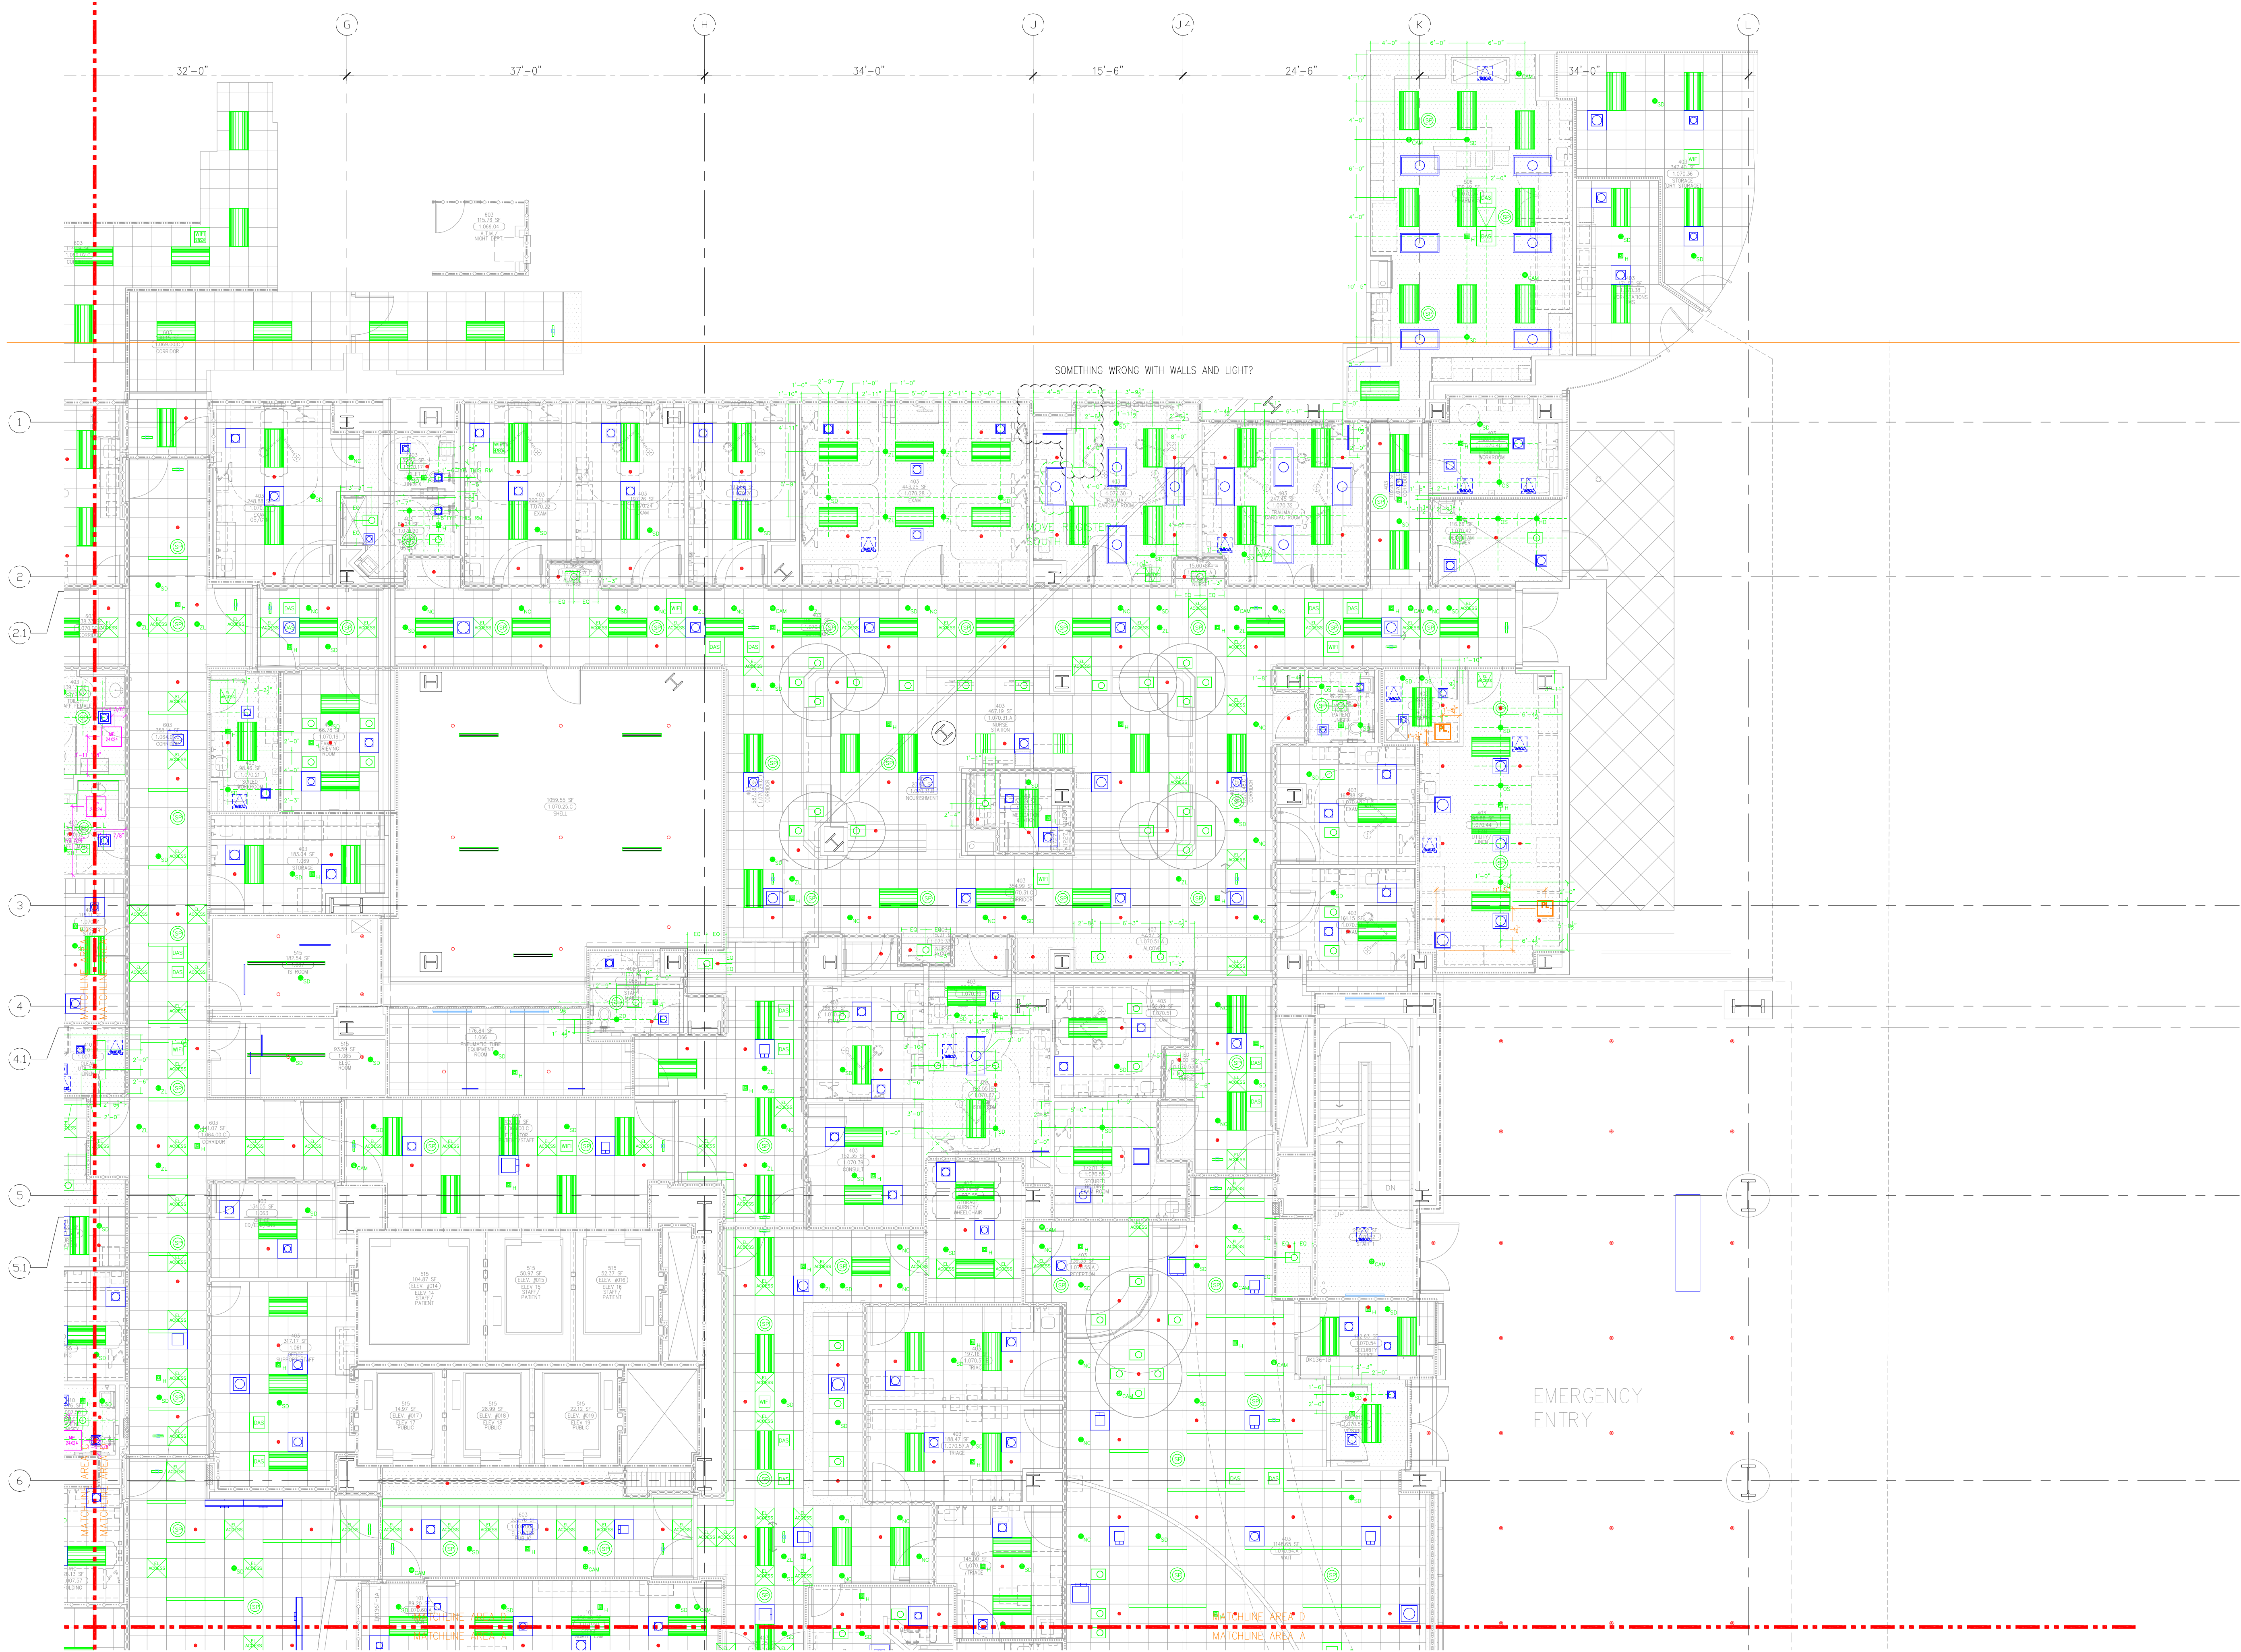

PLUMBING-PL	
SHEET METAL-MD	
FIRE PROTECTION-FP	
MECHANICAL PIPE-MP	
PNEUMATIC TUBE-PT	
ELECTRICAL-EL	

REVISIONS	BY
ISSUED FOR CONSTRUCTION	JT

COUNT	SIGNATURE	DATE
MECHANICAL		
PLUMBING		
ELECTRICAL		
FIRE PROTECTION		
PIPE		
DRYWALL/FRAME		
REFRIGERATION		
STRUCTURAL		

REVISION	DATE	BY	CHKD	APPD

MCCARTHY APPROVAL

A. Approved as noted for Architectural Review ☐

B. Review and Rejection ☐

C. Rejection ☐

This review is for general conformance with Plans and Specifications only. Any deviations from same not clearly noted by the Engineer have not been reviewed. Review shall not constitute a complete check of detailed dimensions or data or serve to relieve the Engineer of contractual responsibility for any error or deviation from contract requirements.

McCarthy

By: _____ Date: _____

SHOP DRAWING REFERENCE NO. _____

CHOC CHILDREN'S HOSPITAL OF ORANGE COUNTY

405 S. MAIN ST. CA 92668-3874

TOWER II

ACCESS PANEL PLAN-LEVEL 01 AREA-B

PAN-PACIFIC **Murray Company**

2919 E. VICTORIA STREET, RANCHO DOMINGUEZ, CA 90221

PH. 310.637-1500 FAX 310.604-0359

0,0,0

1 5 7 10 13

C D

B A

KEY PLAN

LEVEL 01 161.30' = 0'-0"

REFERENCE THIS SHEET

JOHN JT. CHECKED M.M. DATE 05/28/2011 SCALE 1/8"=1'-0" JOB NO. 09-006 DRAWING NUMBER CAD-L1-D REFERENCE DRAWING A4.5D

This document and the design it covers are the property of Murray Co. They are loaned only with the borrower's expressed written agreement that they will not be reproduced, copied, loaned, exhibited, or used in any other way, except by written consent from Murray Co. to the borrower.



PLUMBING-PL	
SHEET METAL-MD	
FIRE PROTECTION-FP	
MECHANICAL PIPE-MP	
PNEUMATIC TUBE-PT	
ELECTRICAL-EL	


REVISIONS	BY
ISSUED FOR CONSTRUCTION	JT

COUNT	REVISION	DATE

REV.	DATE	REV.	DATE	REV.	DATE	REV.	DATE	REV.	DATE

CHOC
CHILDREN'S HOSPITAL
OF ORANGE COUNTY
405 S. MAIN ST.
ORANGE, CA 92668-9974
TOWER II
ACCESS PANEL PLAN - LEVEL 03 AREA A-B



PAN-PACIFIC
PLANNING & ARCHITECTURAL
Murray Company
2919 E. VICTORIA STREET, RANCHO DOMINGUEZ, CA 90221
PH. 310.637-1500 FAX 310.604-0359

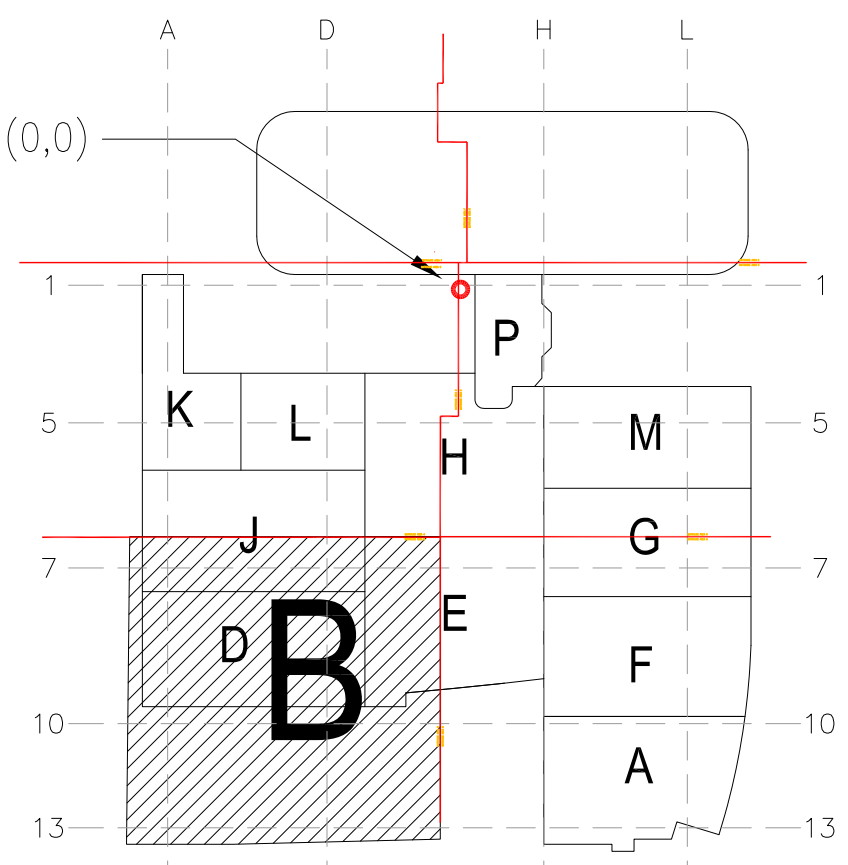

A1 KEY PLAN

DRAWN	J.M.
CHECKED	M.M.
DATE	10/6/2011
SCALE	1/8"=1'-0"
JOB NO.	09-006
DRAWING NUMBER	CAD-L3-B
REFERENCE DRAWING	

This document and the design it covers are the property of Murray Co. They are loaned only with the borrower's expressed written agreement that they will not be reproduced, copied, loaned, exhibited, or used in any way, except by written consent from Murray Co. to the borrower.

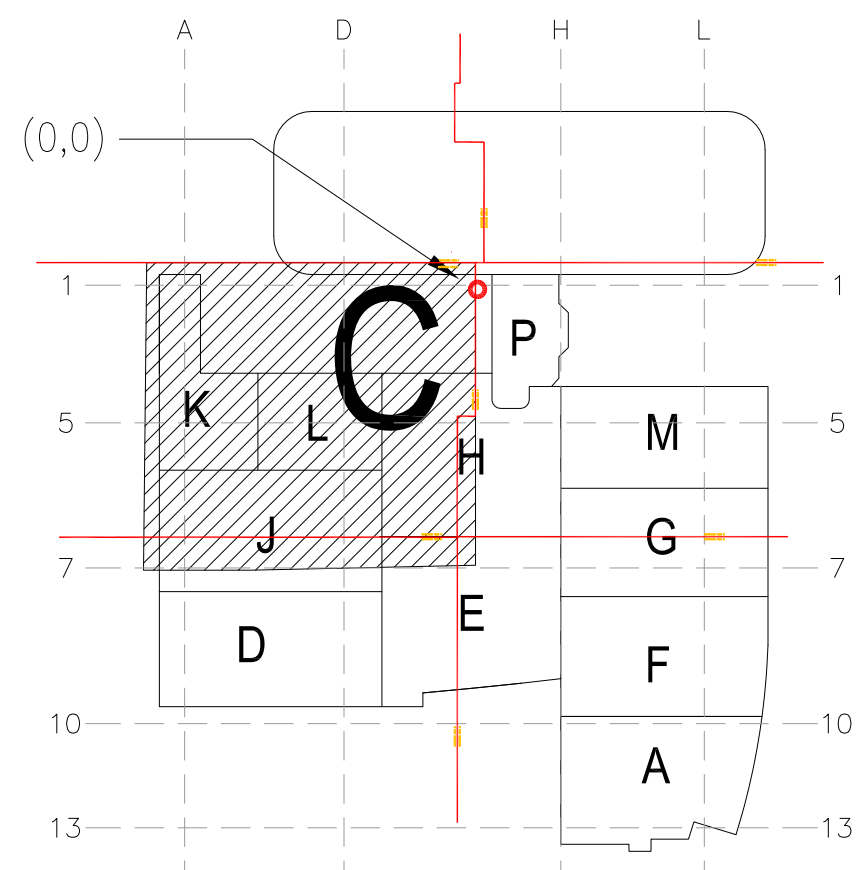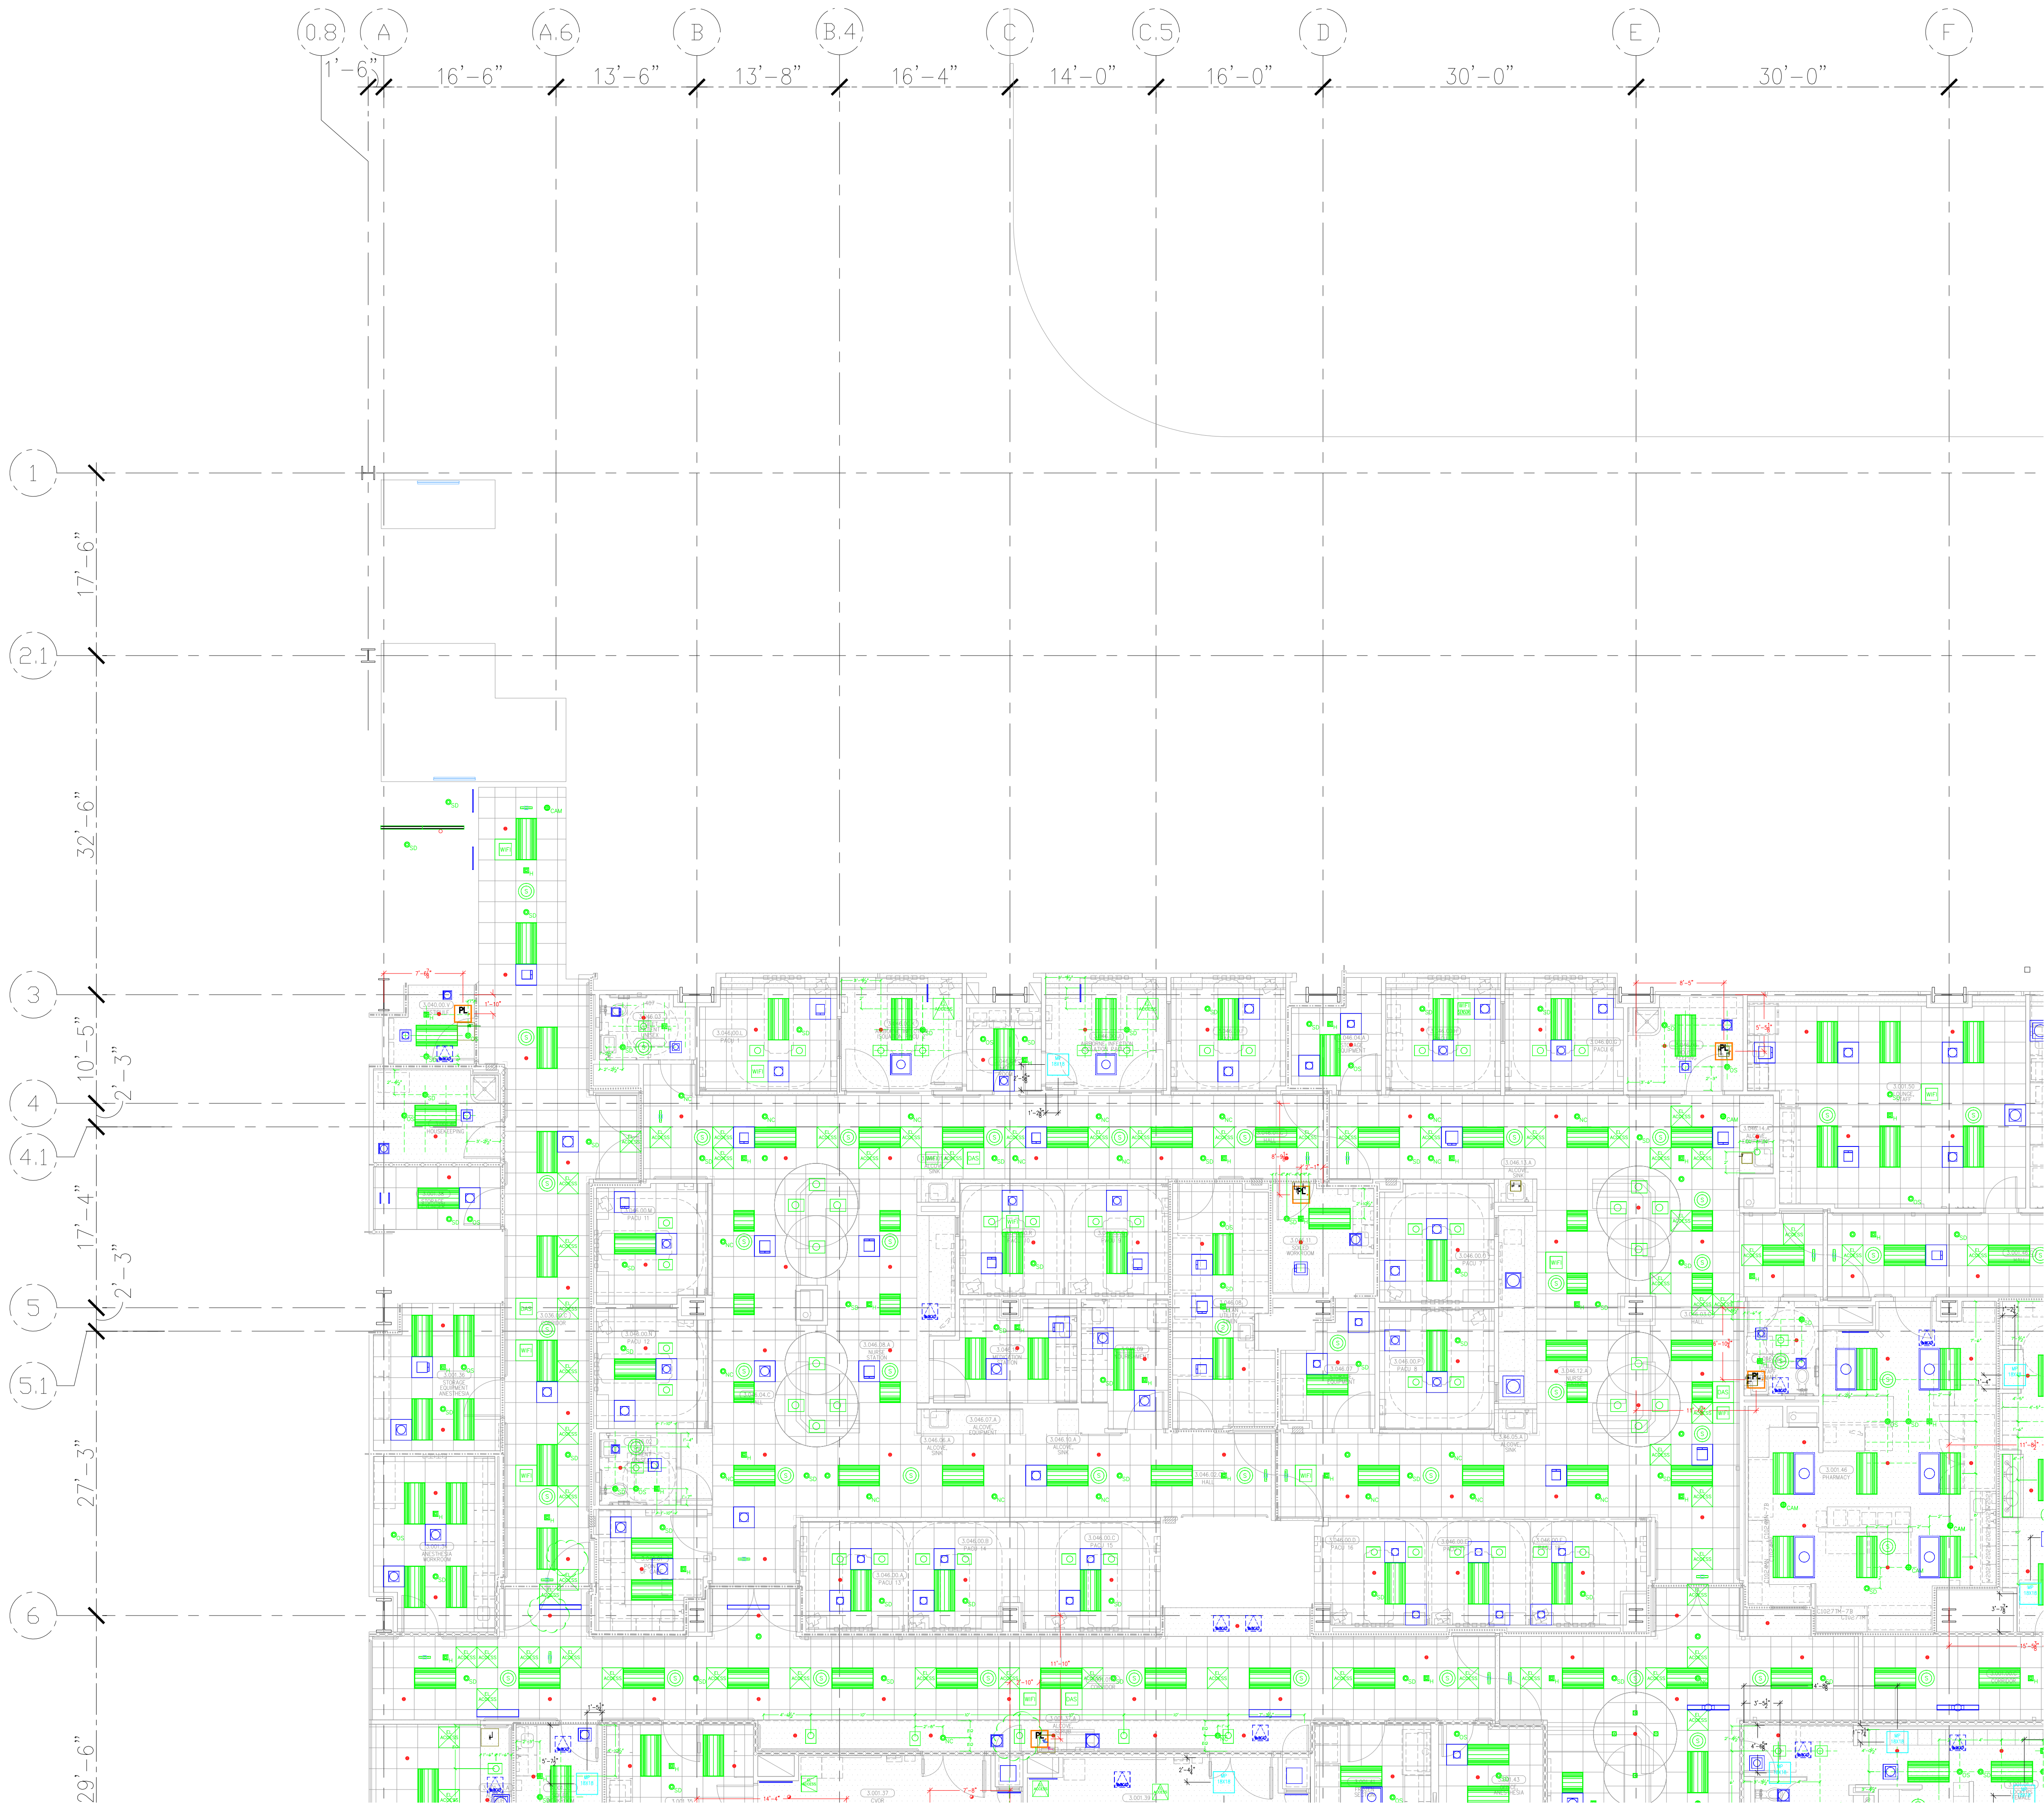

A1 KEY PLAN

PLUMBING-PL	
SHEET METAL-MD	
FIRE PROTECTION-FP	
MECHANICAL PIPE-MP	
PNEUMATIC TUBE-PT	
ELECTRICAL-EL	

REVISIONS	BY
ISSUED FOR CONSTRUCTION	JT



COUNTY	SUBMIT DATE	DATE
MECHANICAL		
MECHANICAL PIPE		
PLUMBING		
ELECTRICAL		
FIRE SPRINKLER		
PIPE		
DRAIN/WASTE/VENT		
REFRIGERATION		
STRUCTURAL		

REV.	DATE	DESCRIPTION	BY	CHK.

CHOC
CHILDREN'S HOSPITAL
OF ORANGE COUNTY
405 S. TOLSON
COSTA MESA, CA 92626-5974
TOWER II
ACCESS PANEL PLAN-LEVEL 03 AREA-C

PAN-PACIFIC
PAN-PACIFIC
2919 E. VICTORIA STREET, RANCHO DOMINGUEZ, CA 90221
PH. 310.637-1500 FAX 310.604-0359

DRAWN
J.M.
CHECKED
M.M.
DATE
10/6/2011
SCALE
1/8"=1'-0"
JOB NO.
09-006
DRAWING NUMBER
CAD-L3-C
REFERENCE DRAWING

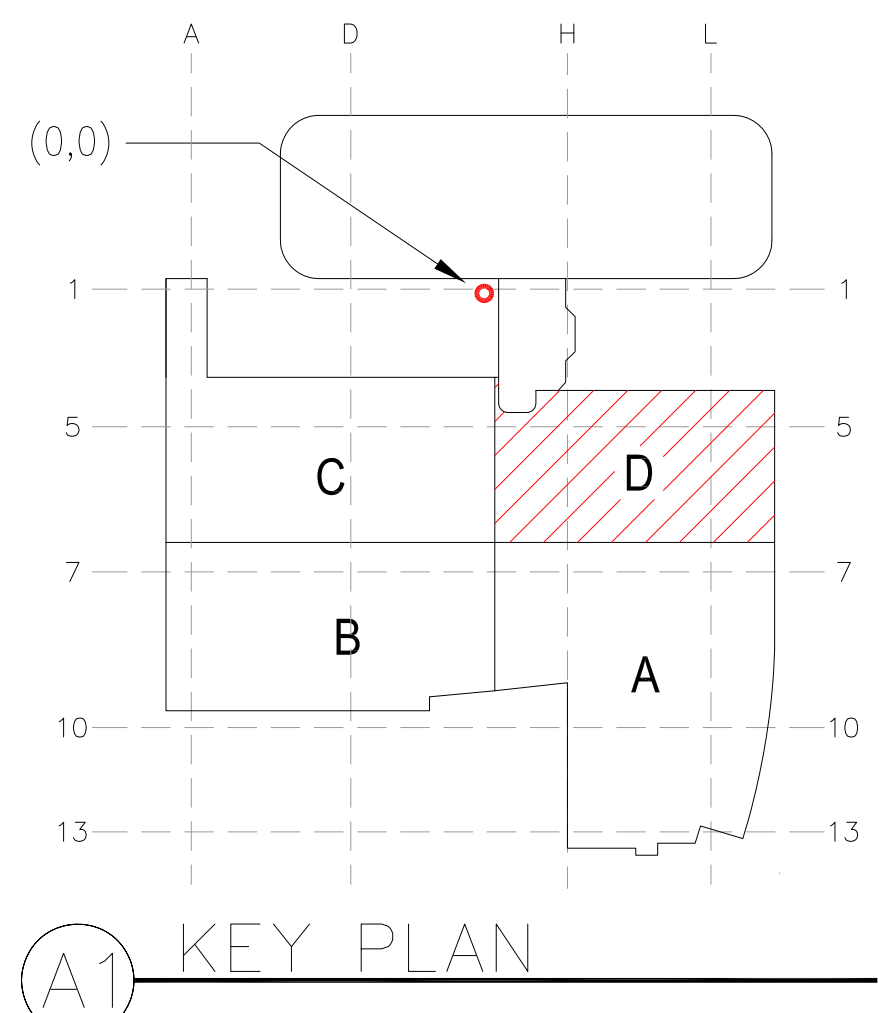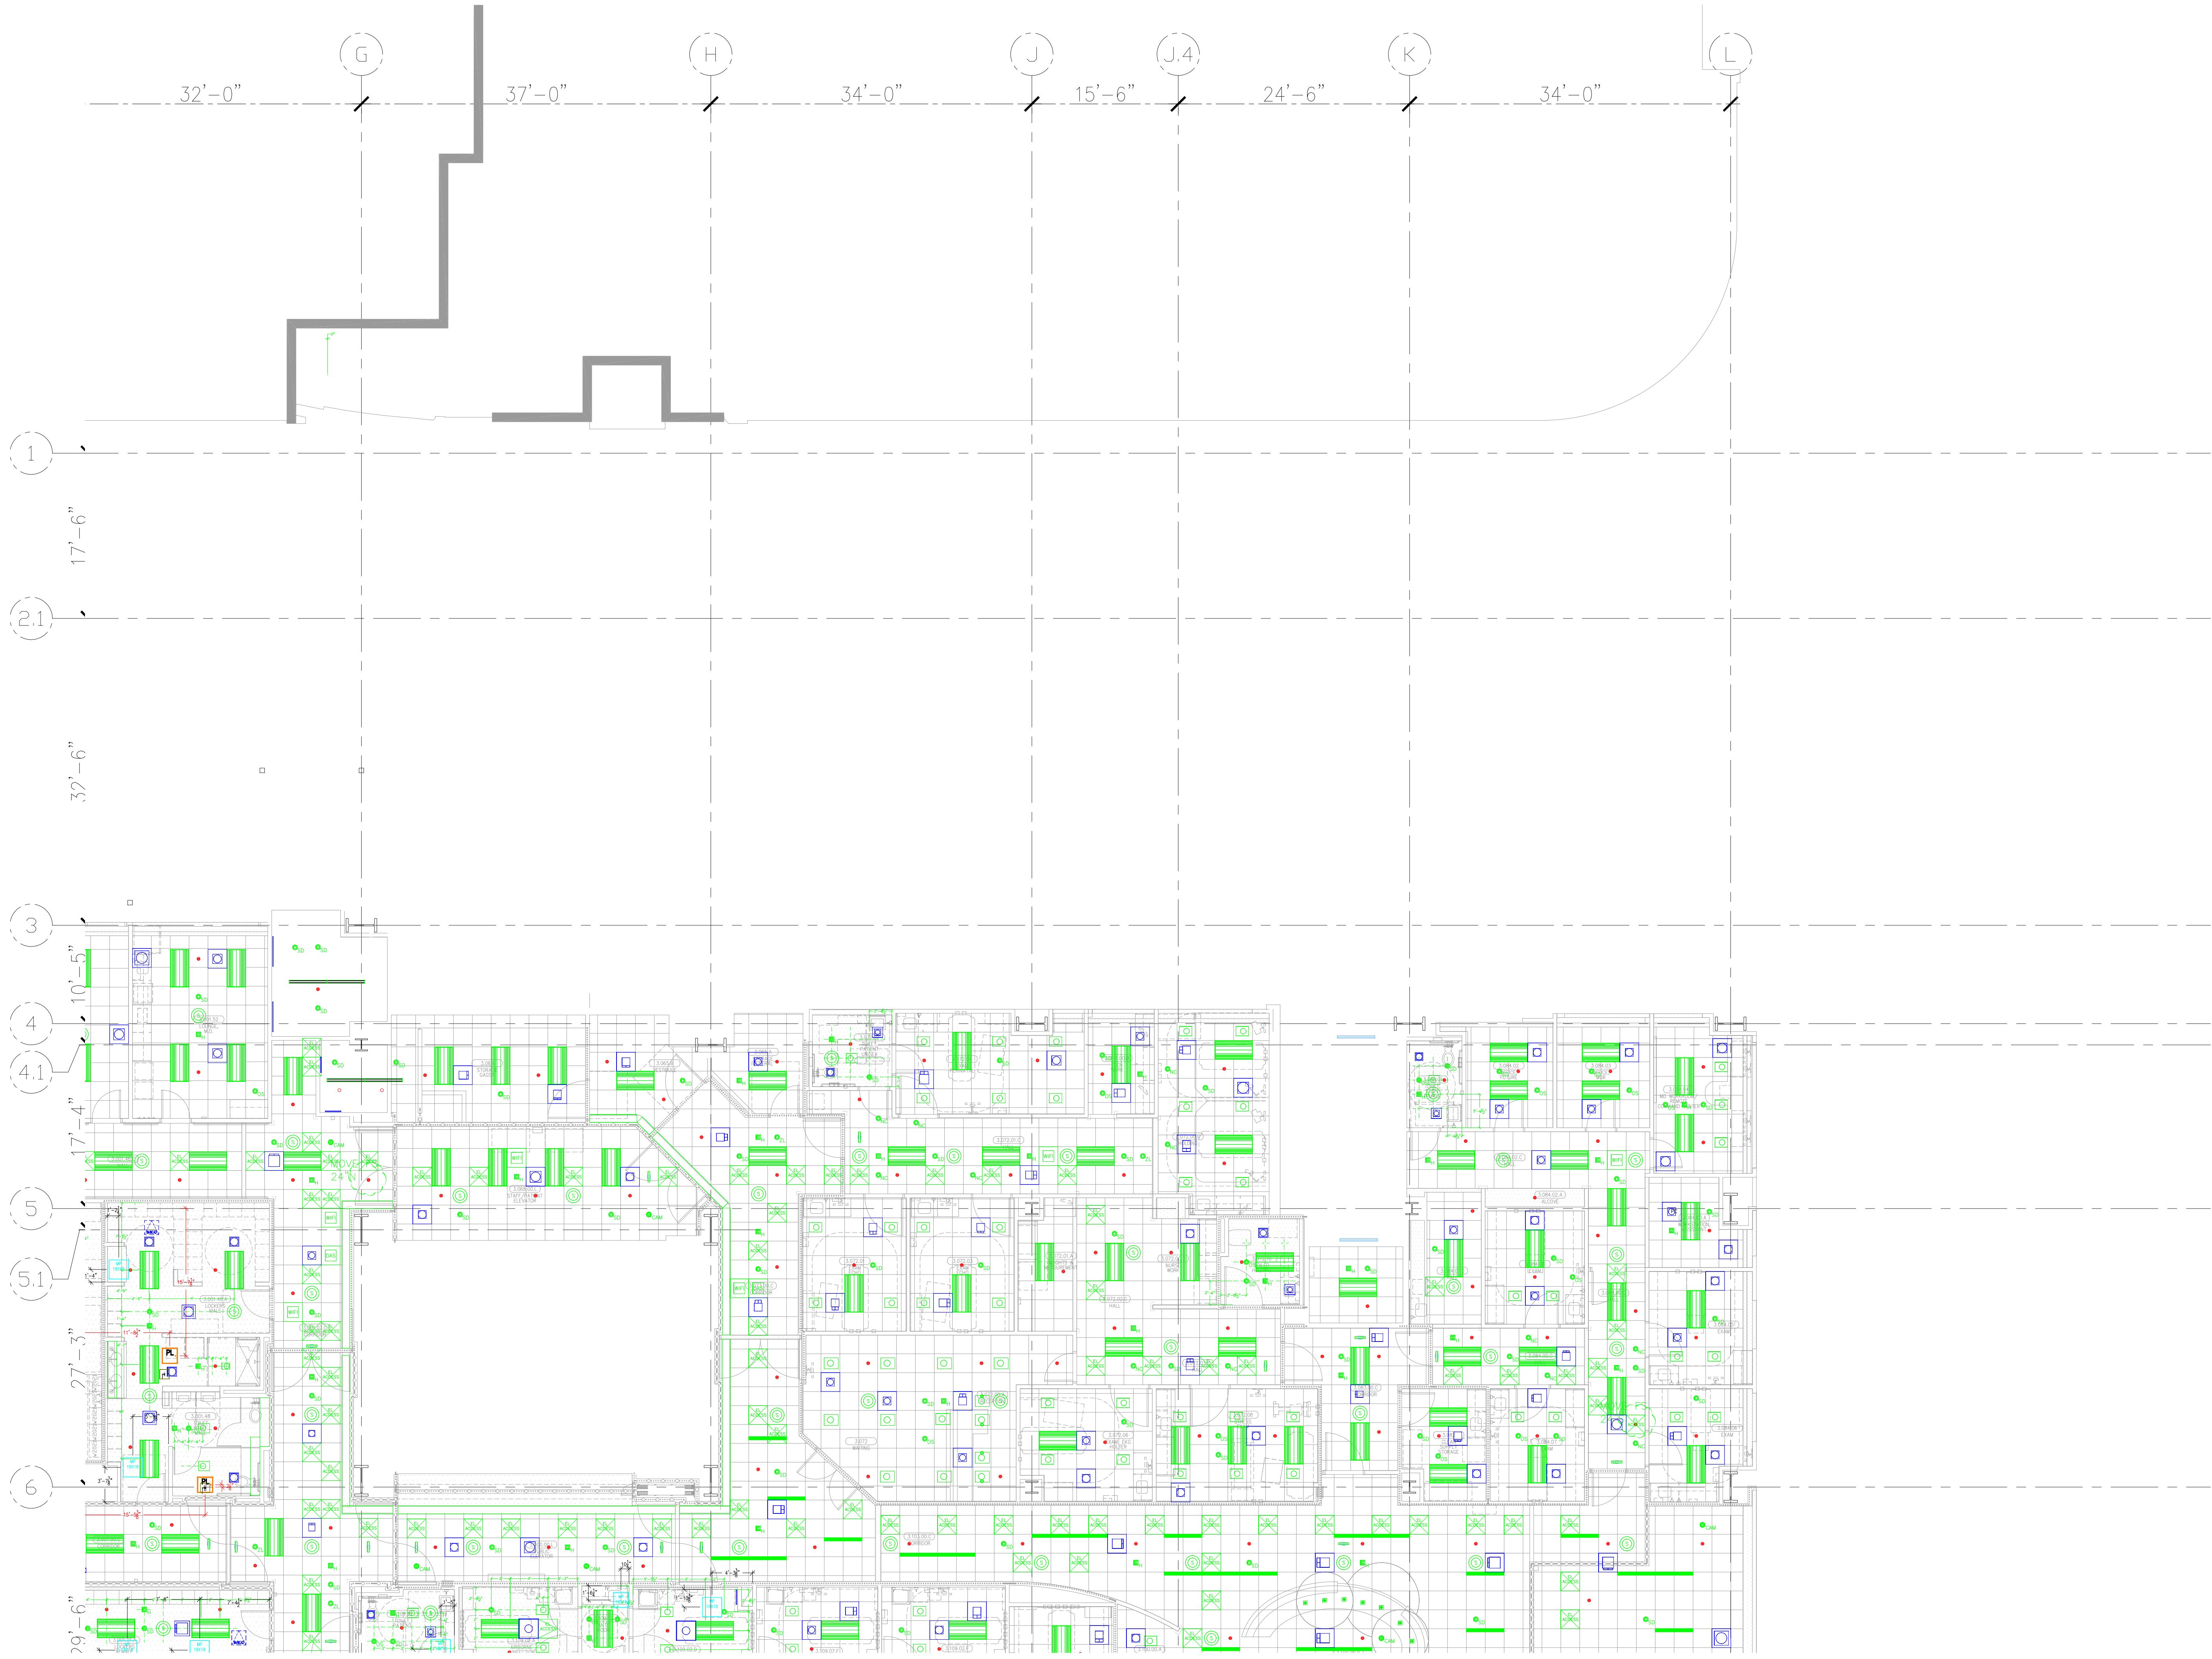

PLUMBING-PL	
SHEET METAL-MD	
FIRE PROTECTION-FP	
MECHANICAL PIPE-MP	
PNEUMATIC TUBE-PT	
ELECTRICAL-EL	

[illegible]

COORD.	SIGNATURE	DATE
McCarthy		
MECHANICAL DUCT		
MECHANICAL PIPE		
PLUMBING		
ELECTRICAL		
FIRE SPROINKLER		
PLUMB		
DRYWALL/FRAME		
REFRIGERATION		
STRUCTURAL		

[illegible]

MCCARTHY APPROVAL	
A. Approved as noted for Architectural Review	<input type="checkbox"/>
C. Review and Reprint	<input type="checkbox"/>
D. Rejected	<input type="checkbox"/>

This review is for general conformance with Plans and Specifications only. Any deviations from same not clearly noted by the Preparer have not been reviewed. Reviewer shall not constitute a complete check of detailed dimensions or count to verify to release the Preparer of contractual responsibility for any error or deviation from contract requirements.

McCarthy

By: _____ Date: _____

SHIP DRAWING REFERENCE NO.

**CHILDREN'S HOSPITAL
OF ORANGE COUNTY**
435 S. Main St.
Orange, CA 92668-3874

TOWER II

ACCESS PANEL PLAN - LEVEL 03 AREA-B

PAN-PACIFIC
LUMBER & NEG. CLASSICAL

Murray
Company

2919 E. VICTORIA STREET, RANCHO DOMINGUEZ, CA 90221
PH. 310 637-1500 FAX. 310 604-0359

DRAWN
J.T.
CHECKED
M.M.
DATE
05/26/2011
SCALE
1/8"=1'-0"
JOB NO.
09-006
DRAWING NUMBER
CAD-L3-D
REFERENCE DRAWING
A4.5D
2 OF 2 SHEETS

This document and the design it covers are the property of Murray Co. They are loaned only with the borrower's expressed written agreement that they will not be reproduced, copied, loaned, exhibited, or used in any other way, except by written consent from Murray Co. to the borrower.



MCCARTHY APPROVAL

A. Approved as noted for Architectural Review ☐

B. Review and Revisions ☐

C. Rejected ☐

This review is for general conformance with Plans and Specifications only. Any deviations from same are those noted by the Project team and are not subject to review. Review shall not constitute a complete check of detailed dimensions or exact location to reflect the Project or construction responsibility for any error or deviation from contract requirements.


McCarthy

By: _____ Date: _____

ENR. DRAWING REFERENCE NO. _____

LEVEL 05 224.30' = 0'-0"

REFERENCE THIS SHEET

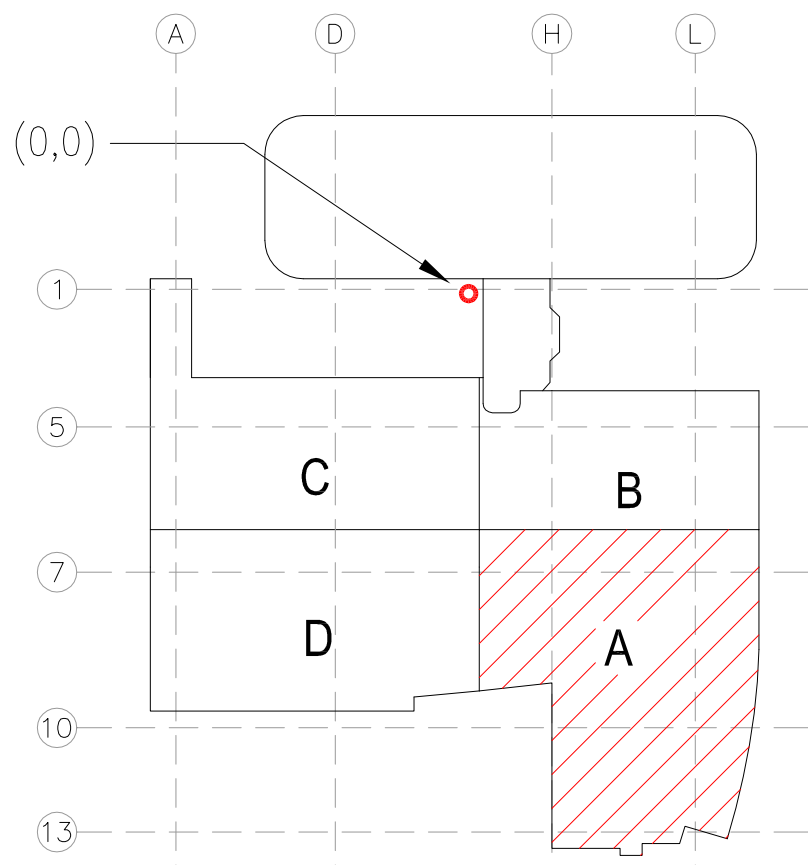

KEY PLAN

REVISIONS	BY
ISSUED FOR CONSTRUCTION	JT

COUNT	REVISION	DATE

REVISION	DATE	BY	REVISION	DATE	BY

**CHILDREN'S HOSPITAL
OF ORANGE COUNTY
TOWER II**


ACCESS PANEL PLAN - LEVEL 05 AREA D

2019 E. VICTORIA STREET, RANCHO DOMINGUEZ, CA 90221
PH. 310.637.1500 FAX 310.604.0399

PAN-PACIFIC
PACIFIC PACIFIC
Murray Co.
2019 E. VICTORIA STREET, RANCHO DOMINGUEZ, CA 90221
PH. 310.637.1500 FAX 310.604.0399

DESIGN
J.T.
CHECKED
M.M.
DATE
05/26/2011
SCALE
3/16"=1'-0"
JOB NO.
09-006
DRAWING NUMBER
CAD-L5-A
REFERENCE DRAWING
A4.5A
1 OF 2 SHEETS

This document and the design it covers are the property of Murray Co. They are loaned only with the borrower's expressed written agreement that they will not be reproduced, copied, loaned, exhibited, or used in any way, except by written consent from Murray Co. to the borrower.

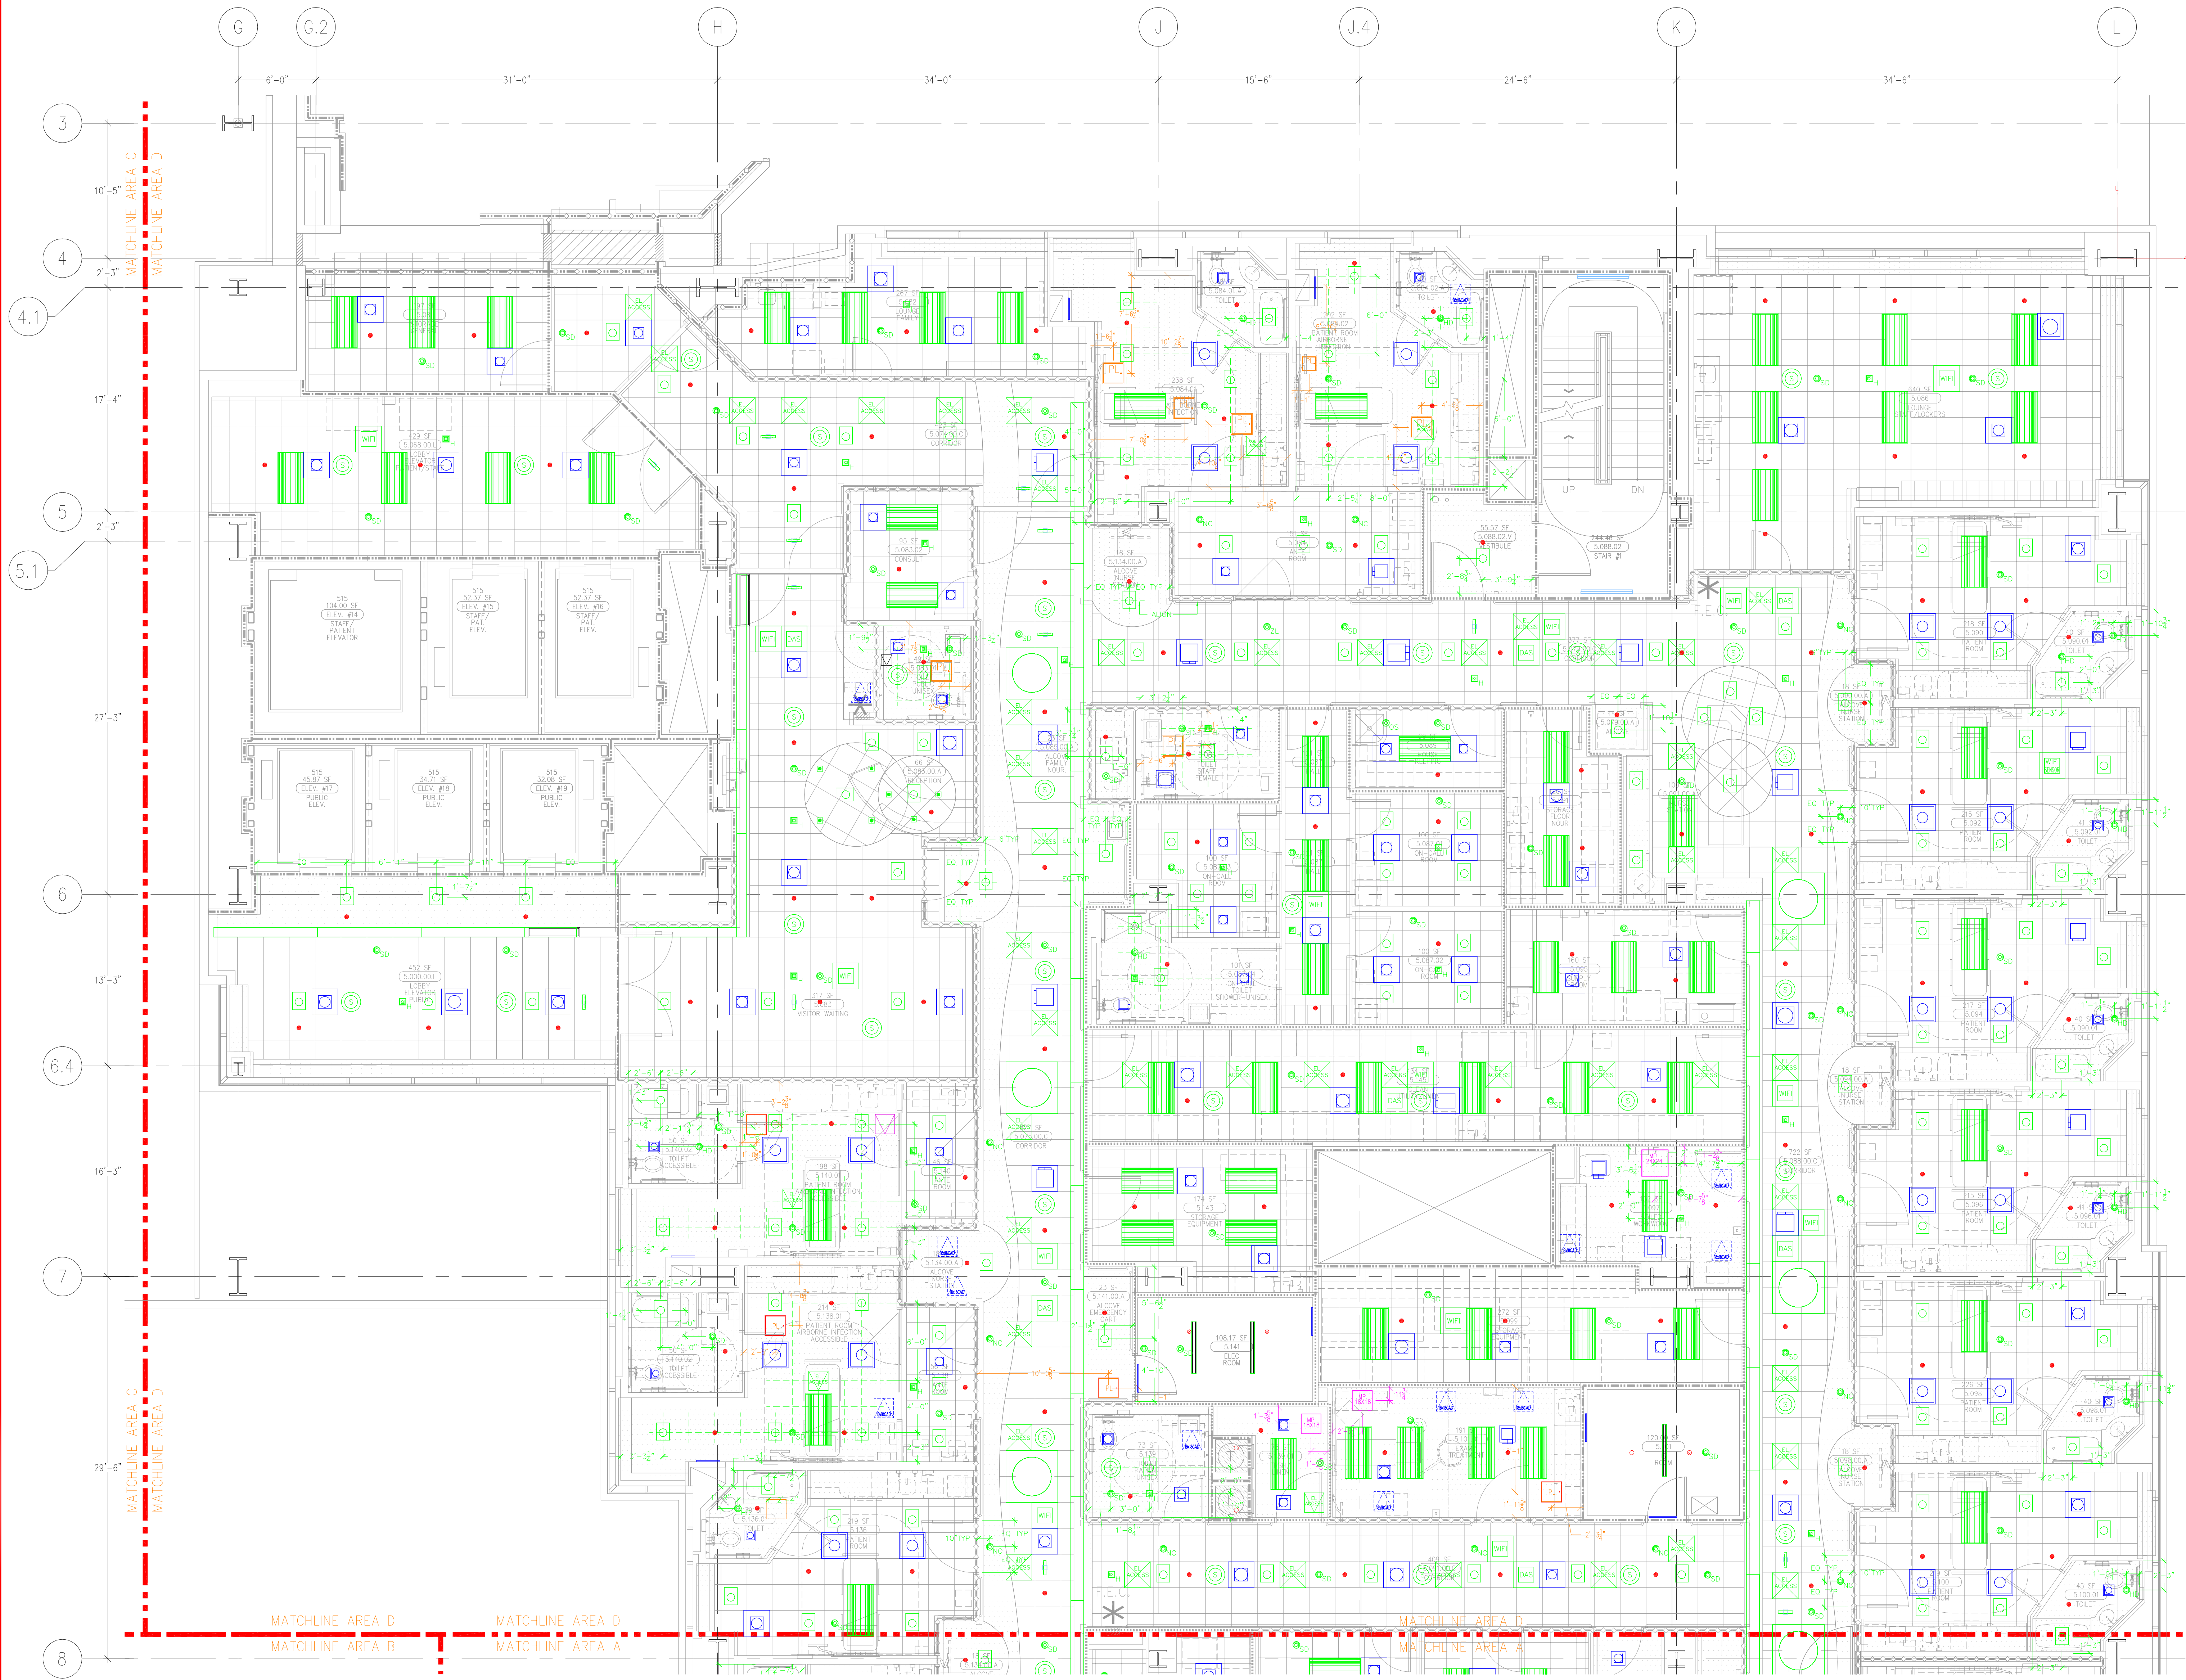

MCCARTHY APPROVAL

A. Approved as noted for Architectural Review

B. Review and Rejection

C. Rejection

This review is for general conformance with Plans and Specifications only. Any deviations from same not clearly noted by the Program have not been reviewed. Review shall not constitute a complete check or detailed dimension or check to error to reduce the Program of construction responsibility for any error or deviation from contract requirements.

McCarthy

By: _____ Date: _____

SHEET DRAWING REFERENCE NO.

LEVEL 05 224.30' = 0'-0"
REFERENCE THIS SHEET

KEY PLAN

REVISIONS		BY
0	ISSUED FOR CONSTRUCTION	JT

COUNT	DATE	REVISION
0		

REVISION	DATE	BY	DESCRIPTION
0			

CHILDREN'S HOSPITAL
OF ORANGE COUNTY

400 S. MAIN ST.
ORANGE, CA 92668-3874

TOWER II

ACCESS PANEL PLAN - LEVEL 05 AREA-D

PAN-PACIFIC
PACIFIC & ANAHEIM

Murray Co.

2919 E. VICTORIA STREET, RANCHO DOMINGUEZ, CA 90221

PH. 310.637.1500 FAX 310.604-0359

JOHN
J.T.

CHECKED
M.M.

DATE
05/26/2011

SCALE
3/16"=1'-0"

JOB NO.
09-006

DRAWING NUMBER
CAD-L5-D

REFERENCE DRAWING
A4.50

2 OF 2 SHEETS