

ARCHITECT OF RECORD

CONSULTANT

REVISIONS

APPROVAL _____

PROJECT NAME

TOWER II

PROJECT NUMBER _____

ISSUE

OSHPD PERMIT

DATE _____

01/27/2010


SCALE _____


$$1/4'' = 1' - 0''$$

DRAWING TITLE _____

DRAWING NUMBER

 EL3.2A



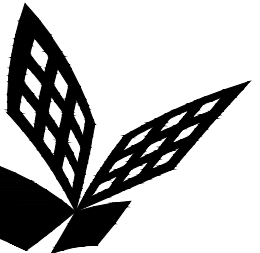

FKP Architects

ARCHITECT OF RECORD

CONSULTANT

T M A D
TAYLOR
& G AINES

100 South Anaheim Boulevard, Suite 150
Anaheim, California 92805
Phone: 714.490.5555 Fax: 714.490.5560
Project No. 2305-163-07

REVISIONS

163	03/01/11	CHANGE ORDER #134
160	04/02/11	ASI #193

APPROVAL

PROJECT NAME

CHILDREN'S HOSPITAL
OF ORANGE COUNTY

455 S. Main St.
Orange, CA 92668-3874

TOWER II



PROJECT NUMBER

12011.00
Increment #7

OSHPD - PROJECT NUMBER

IL 072072-30

ISSUE

OSHPD PERMIT

DATE

01/27/2010

SCALE


1/4" = 1' - 0"

DRAWING TITLE

LEVEL 2 LIGHTING PLAN
AREA - D

DRAWING NUMBER

EL3.2D

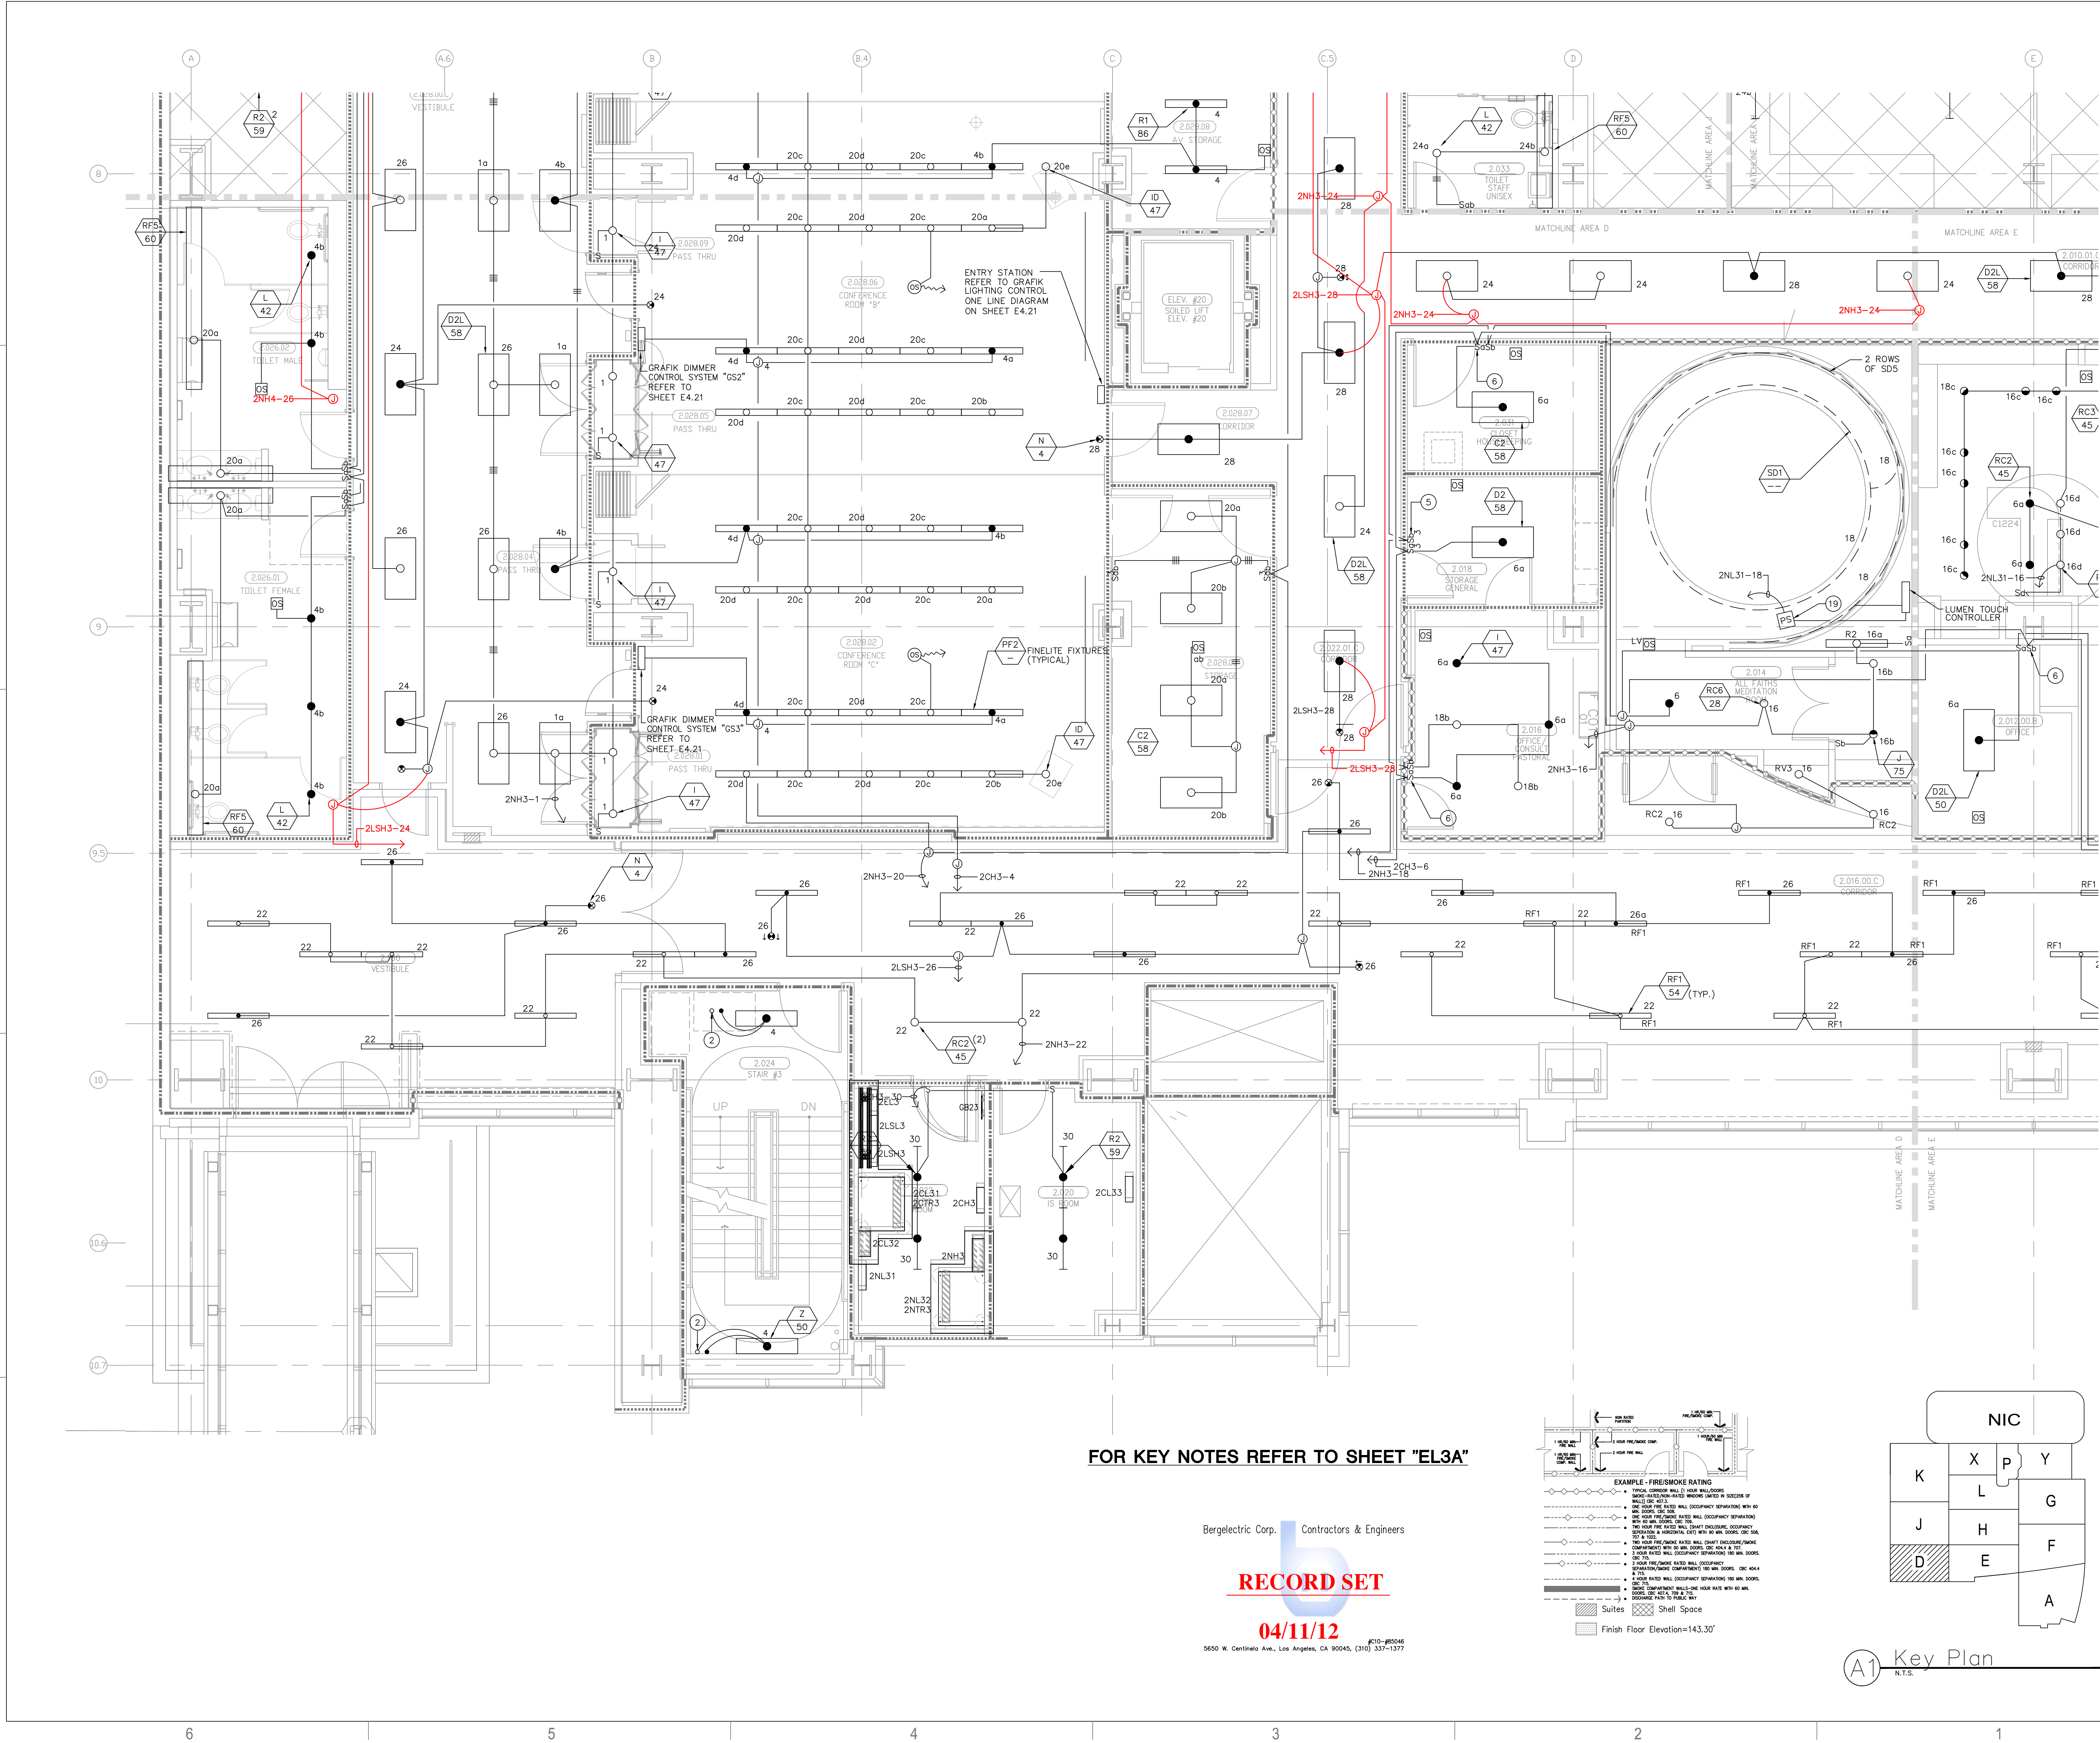



FOR KEY NOTES REFER TO SHEET "EL3A"

Bergelectric Corp. Contractors & Engineers


RECORD SET

04/11/12

5650 W. Centinela Ave., Los Angeles, CA 90045, (310) 337-1377

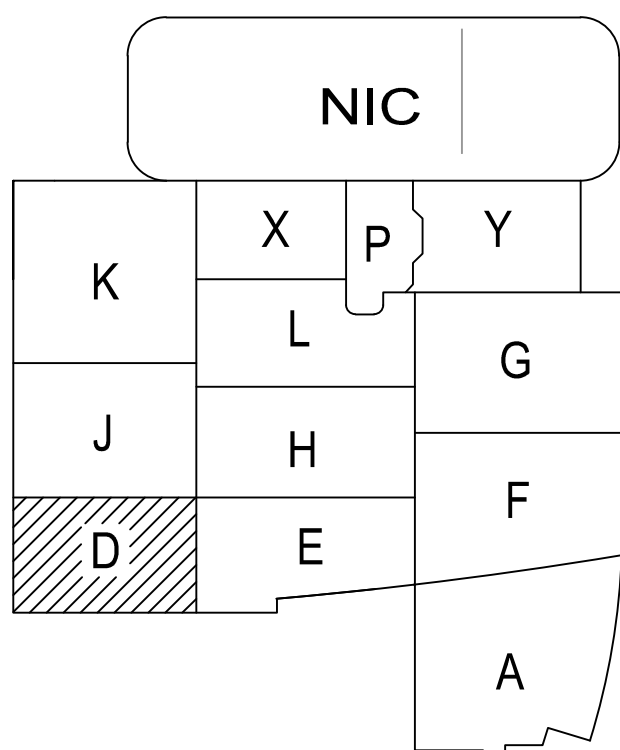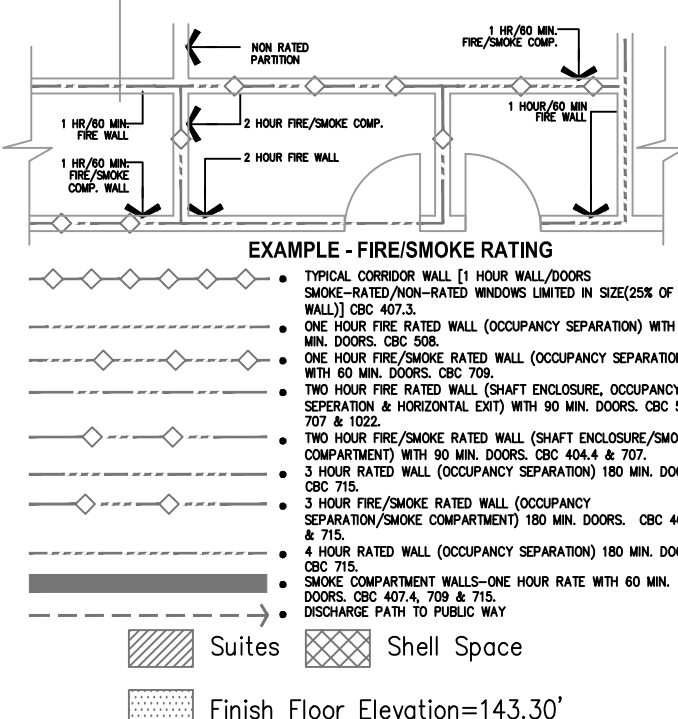

A1 Key Plan
N.T.S.

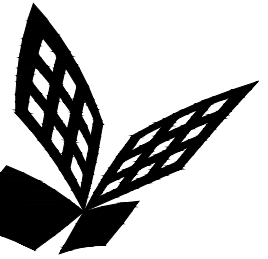

FKP Architects

ARCHITECT OF RECORD

CONSULTANT

T M A D
TAYLOR
& GAINES

- STRUCTURAL
- MECHANICAL
- ELECTRICAL
- CIVIL

100 South Anaheim Boulevard, Suite 150
Anaheim, California 92805
Phone: 714.490.5555 Fax: 714.490.5560
Project No. 2305-163-07

REVISIONS

34	12/06/10	CHANGE ORDER #109
41	03/01/11	CHANGE ORDER #134
44	09/12/11	CHANGE ORDER #266

APPROVAL

PROJECT NAME

CHILDREN'S HOSPITAL
OF ORANGE COUNTY
455 S. Main St.
Orange, CA 92868-3874

TOWER II



PROJECT NUMBER

12011.00
Increment #7
12002-00
OSHPD - PROJECT NUMBER
IL 072072-30

ISSUE

OSHPD PERMIT

DATE

01/27/2010

SCALE


1/4" = 1' - 0"

DRAWING TITLE

LEVEL 2 LIGHTING PLAN
AREA - E

DRAWING NUMBER

EL3.2E

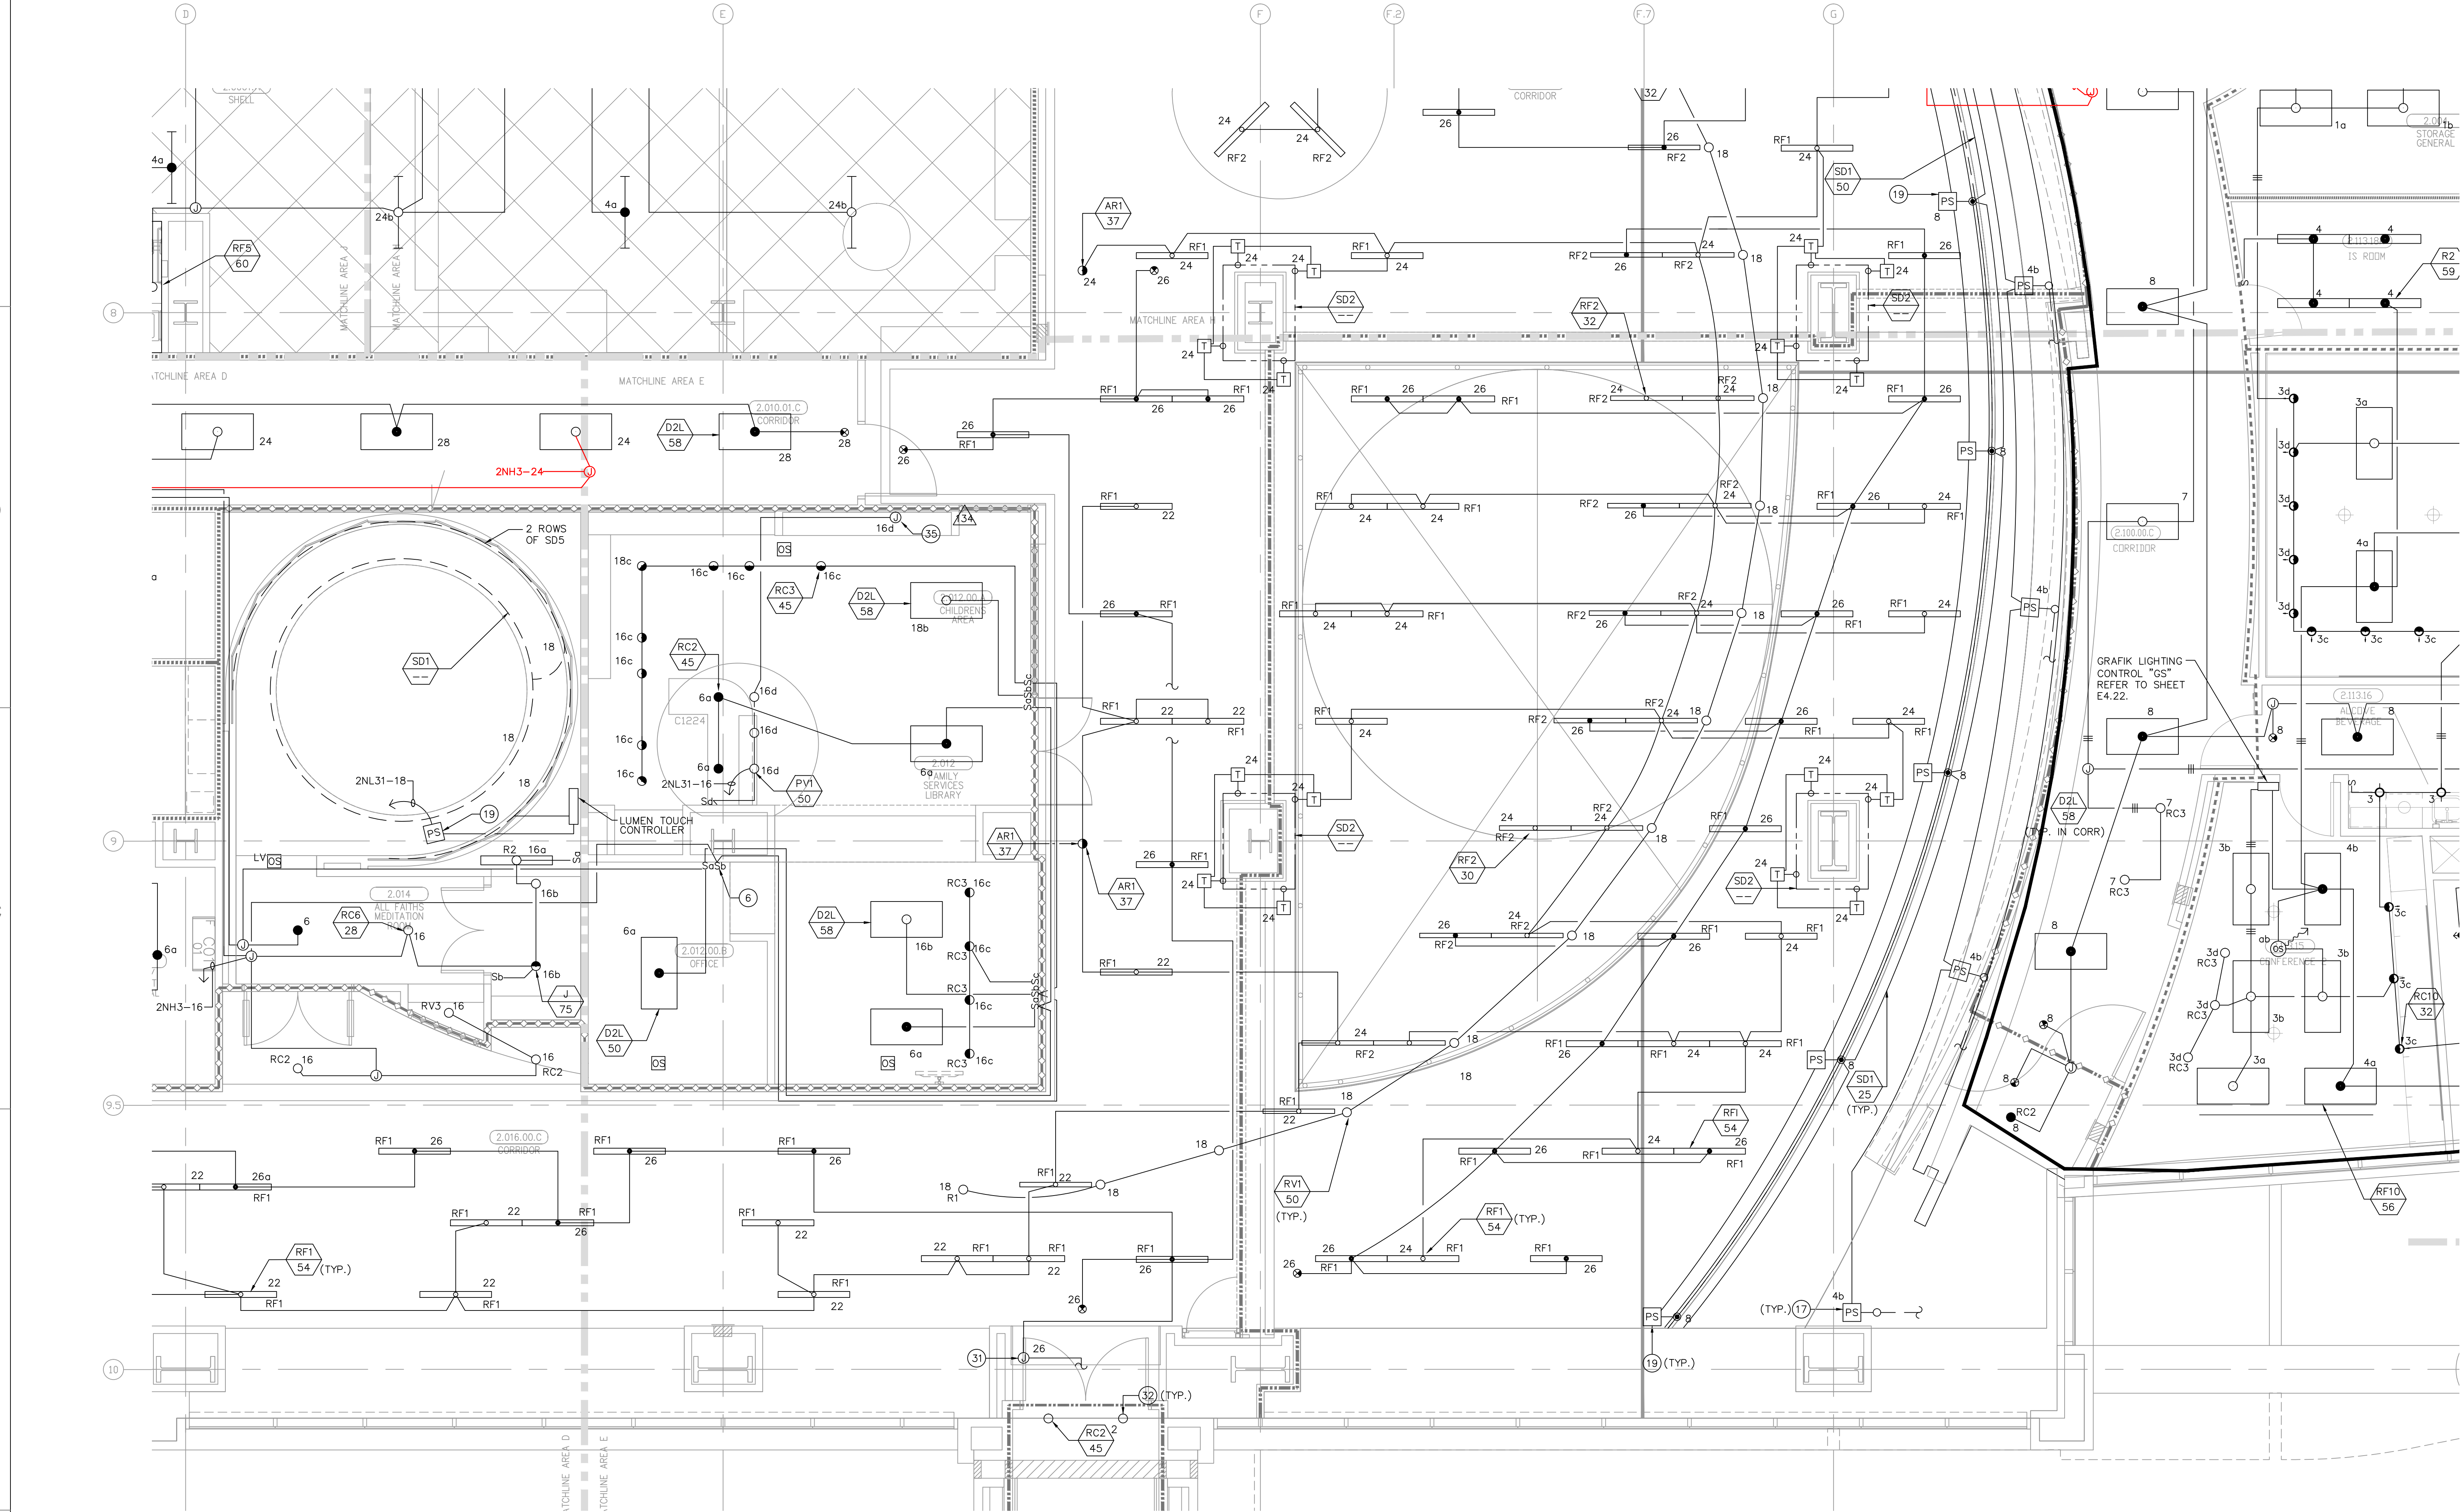



FOR KEY NOTES REFER TO SHEET "EL3A"

Bergelectric Corp. Contractors & Engineers

RECORD SET

04/11/12

5650 W. Centinela Ave., Los Angeles, CA 90045, (310) 337-1377

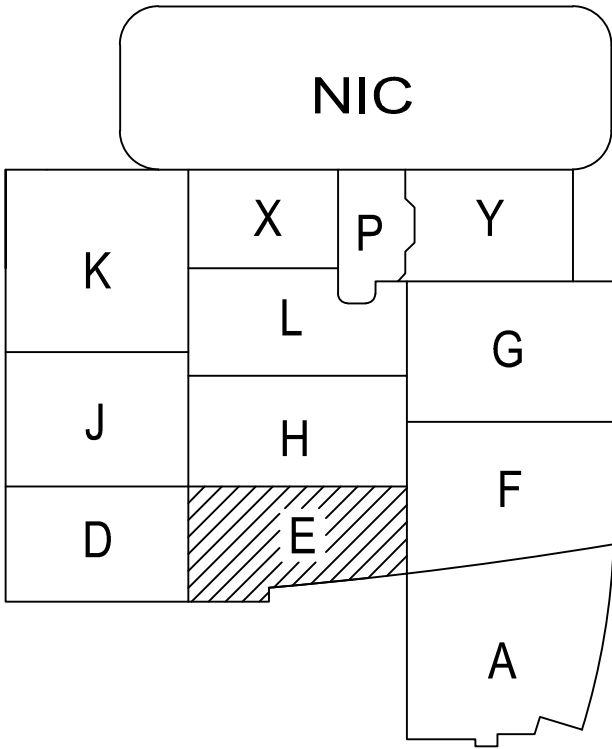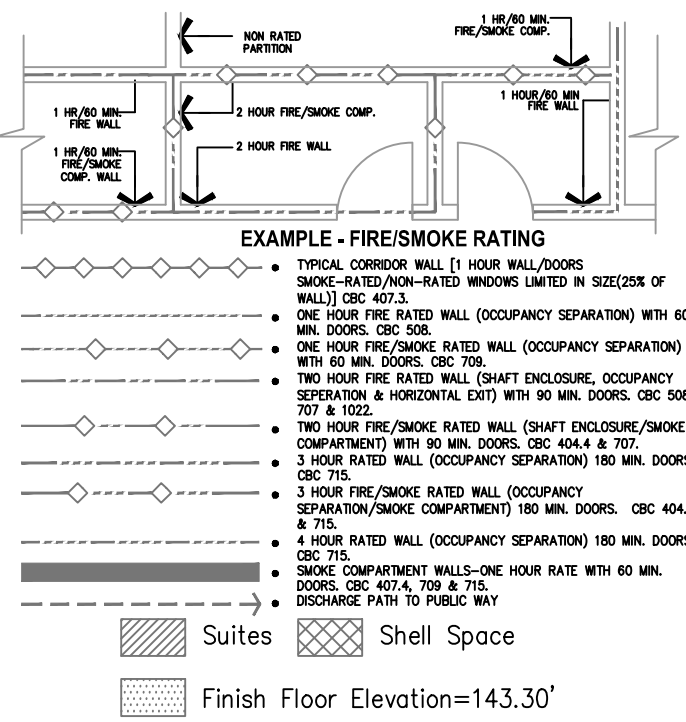

A1 Key Plan
N.T.S.

EL3.2F



ARCHITECT OF RECORD

CONSULTANT

100 South Anaheim Boulevard, Suite 150
Anaheim, California 92805
Phone: 714.490.5555 Fax: 714.490.5560
Project No. 2305-163-07

REVISIONS

16	03/01/11	CHANGE ORDER #134
340	09/12/11	CHANGE ORDER #266
297	11/11/11	CHANGE ORDER #232
398	12/05/11	CHANGE ORDER #304

APPROVAL

PROJECT NAME

CHILDREN'S HOSPITAL
OF ORANGE COUNTY
455 S. Main St.
Orange, CA 92868-3874

TOWER II



PROJECT NUMBER _____

12011.00
Increment #7

OSHPD - PROJECT NUMBER
IL 072072-30

ISSUE

OSHPD PERMIT

DATE _____

01/27/2010


SCALE


$$1/4'' = 1' - 0''$$

LEVEL 2 LIGHTING PLAN
AREA - G

DRAWING NUMBER

EL3.2G

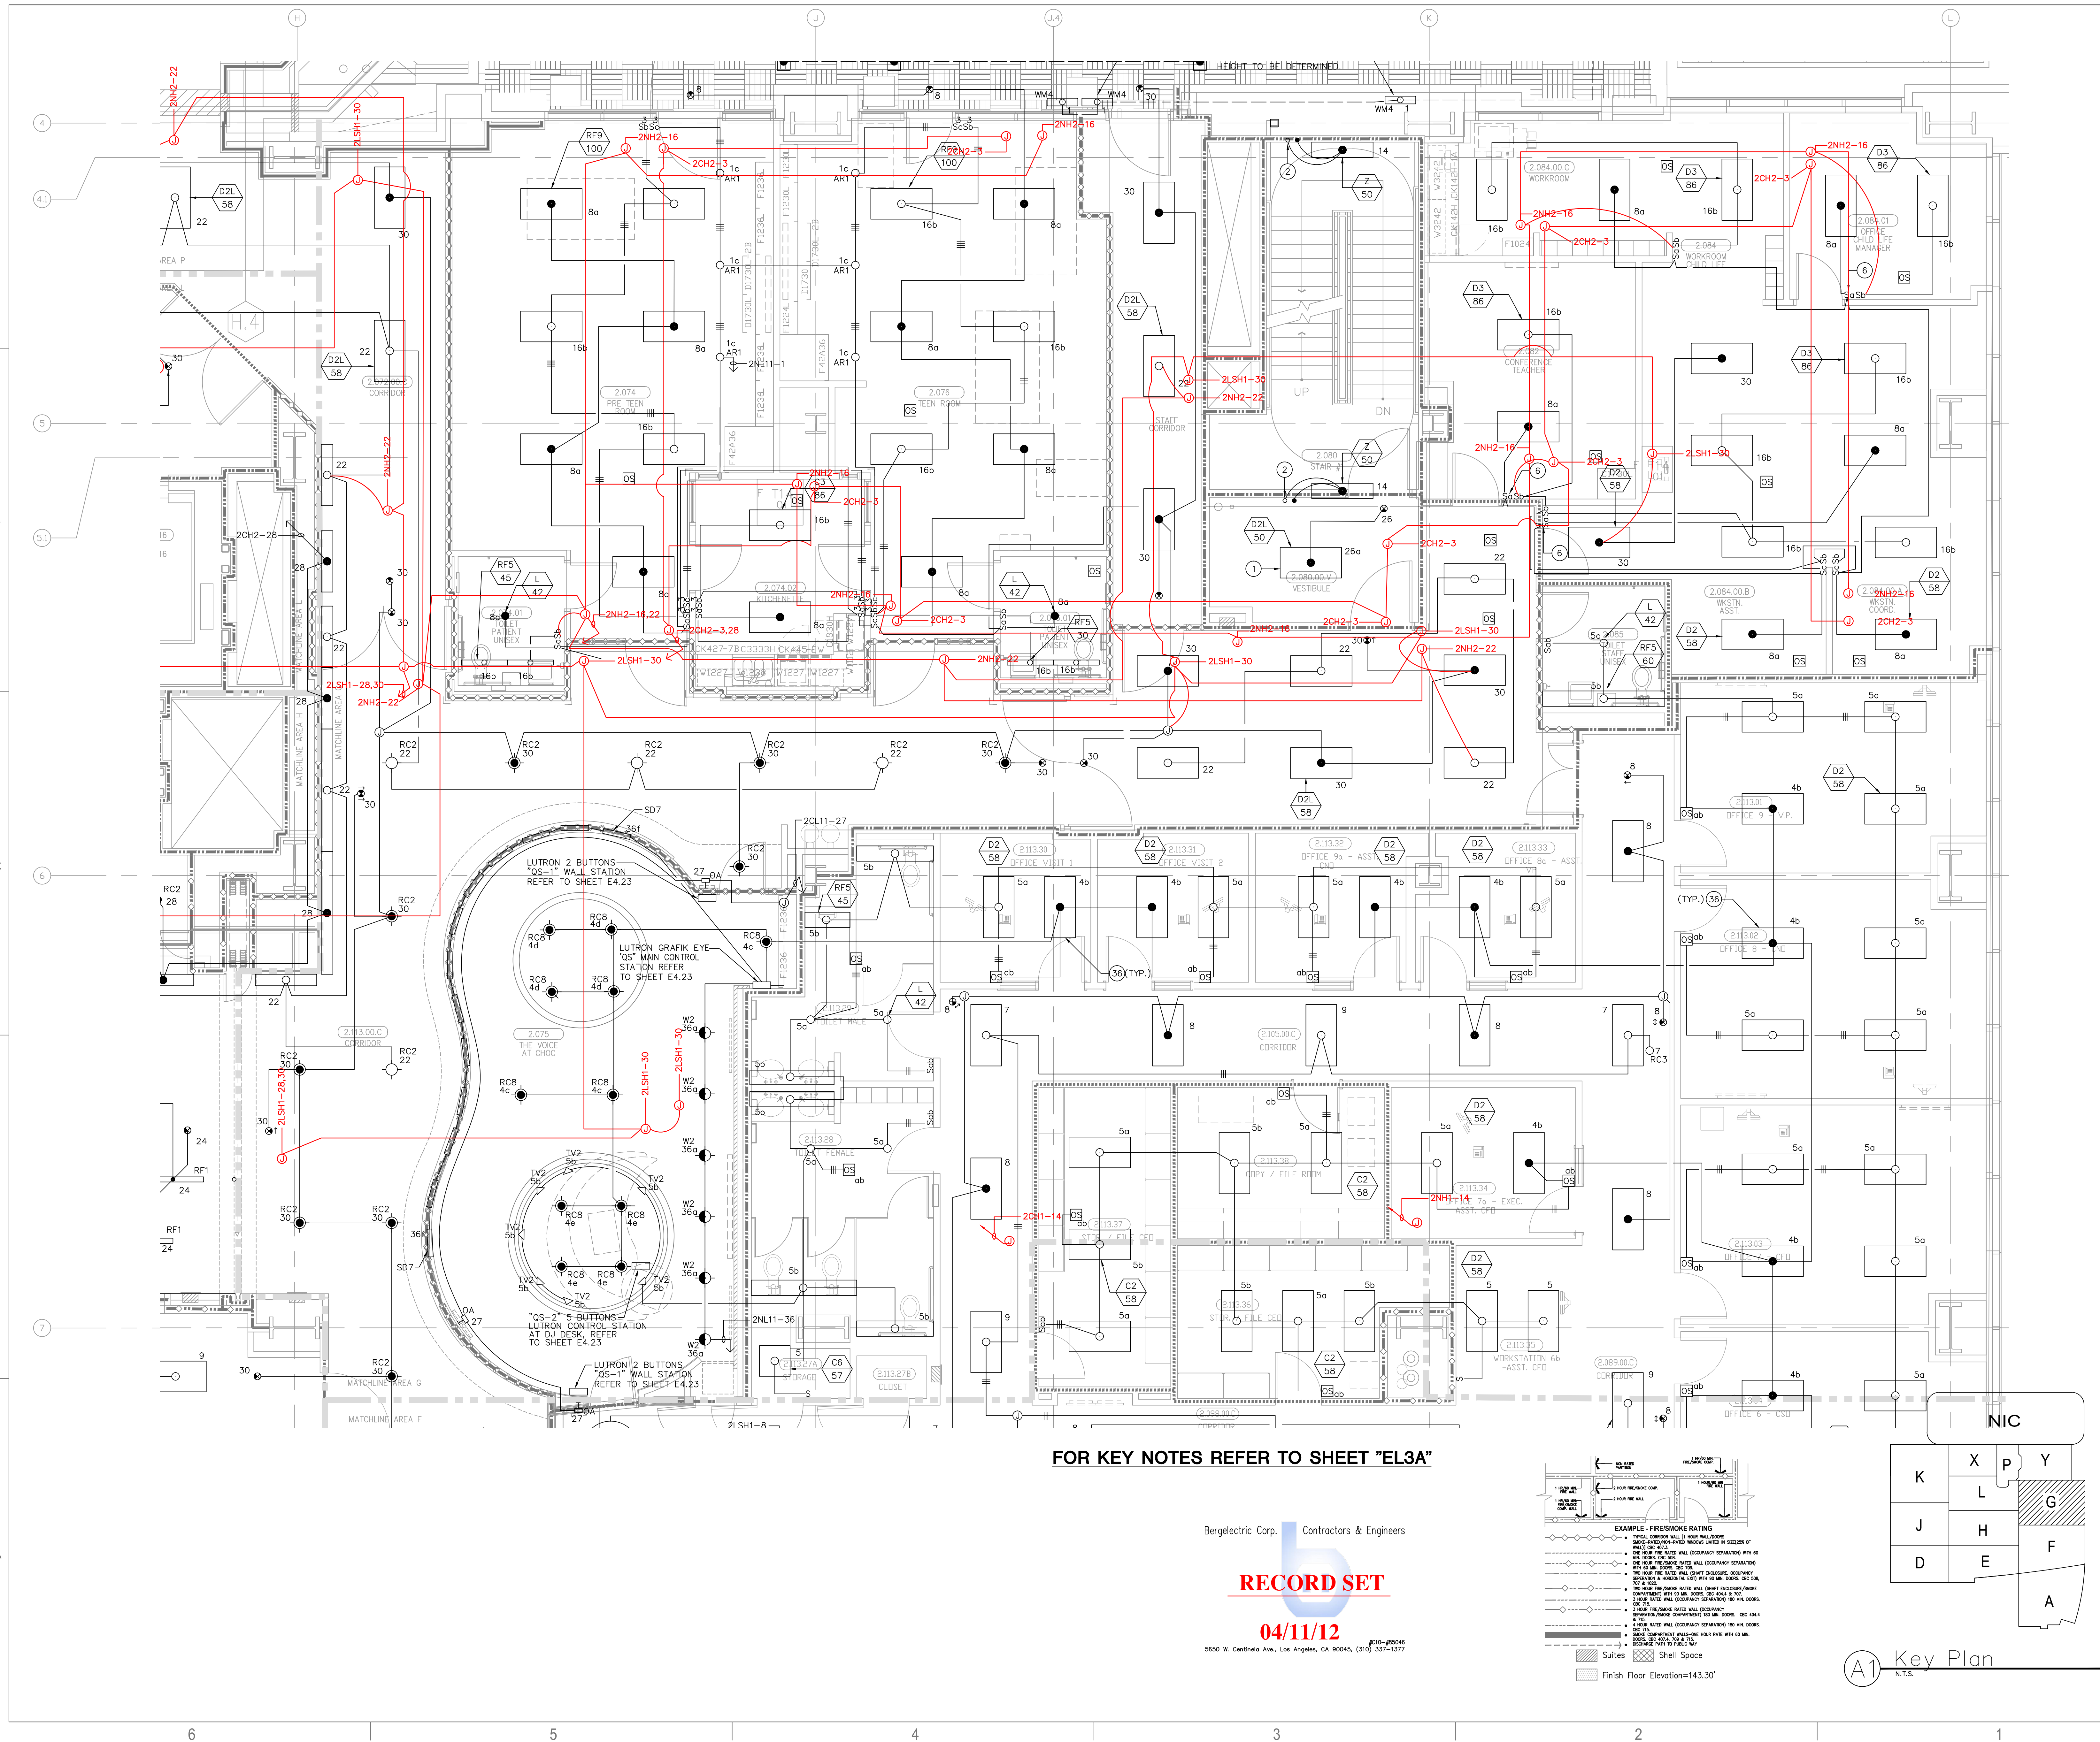

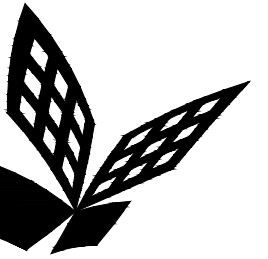

FKP Architects

ARCHITECT OF RECORD

CONSULTANT

T M A D
TAYLOR
& GAINES

STRUCTURAL
MECHANICAL
ELECTRICAL
CIVIL

100 South Anaheim Boulevard, Suite 150
Anaheim, California 92805
Phone: 714.490.5555 Fax: 714.490.5560
Project No. 2305-163-07

REVISIONS

161 03/01/11 CHANGE ORDER #134

APPROVAL

PROJECT NAME

CHILDREN'S HOSPITAL
OF ORANGE COUNTY

455 S. Main St.
Orange, CA 92668-3874

TOWER II



PROJECT NUMBER

12011.00
Increment #7

OSHPD - PROJECT NUMBER
IL 072072-30

ISSUE

OSHPD PERMIT

DATE

01/27/2010

SCALE


1/4" = 1' - 0"

DRAWING TITLE

LEVEL 2 LIGHTING PLAN
AREA - H

DRAWING NUMBER

EL3.2H

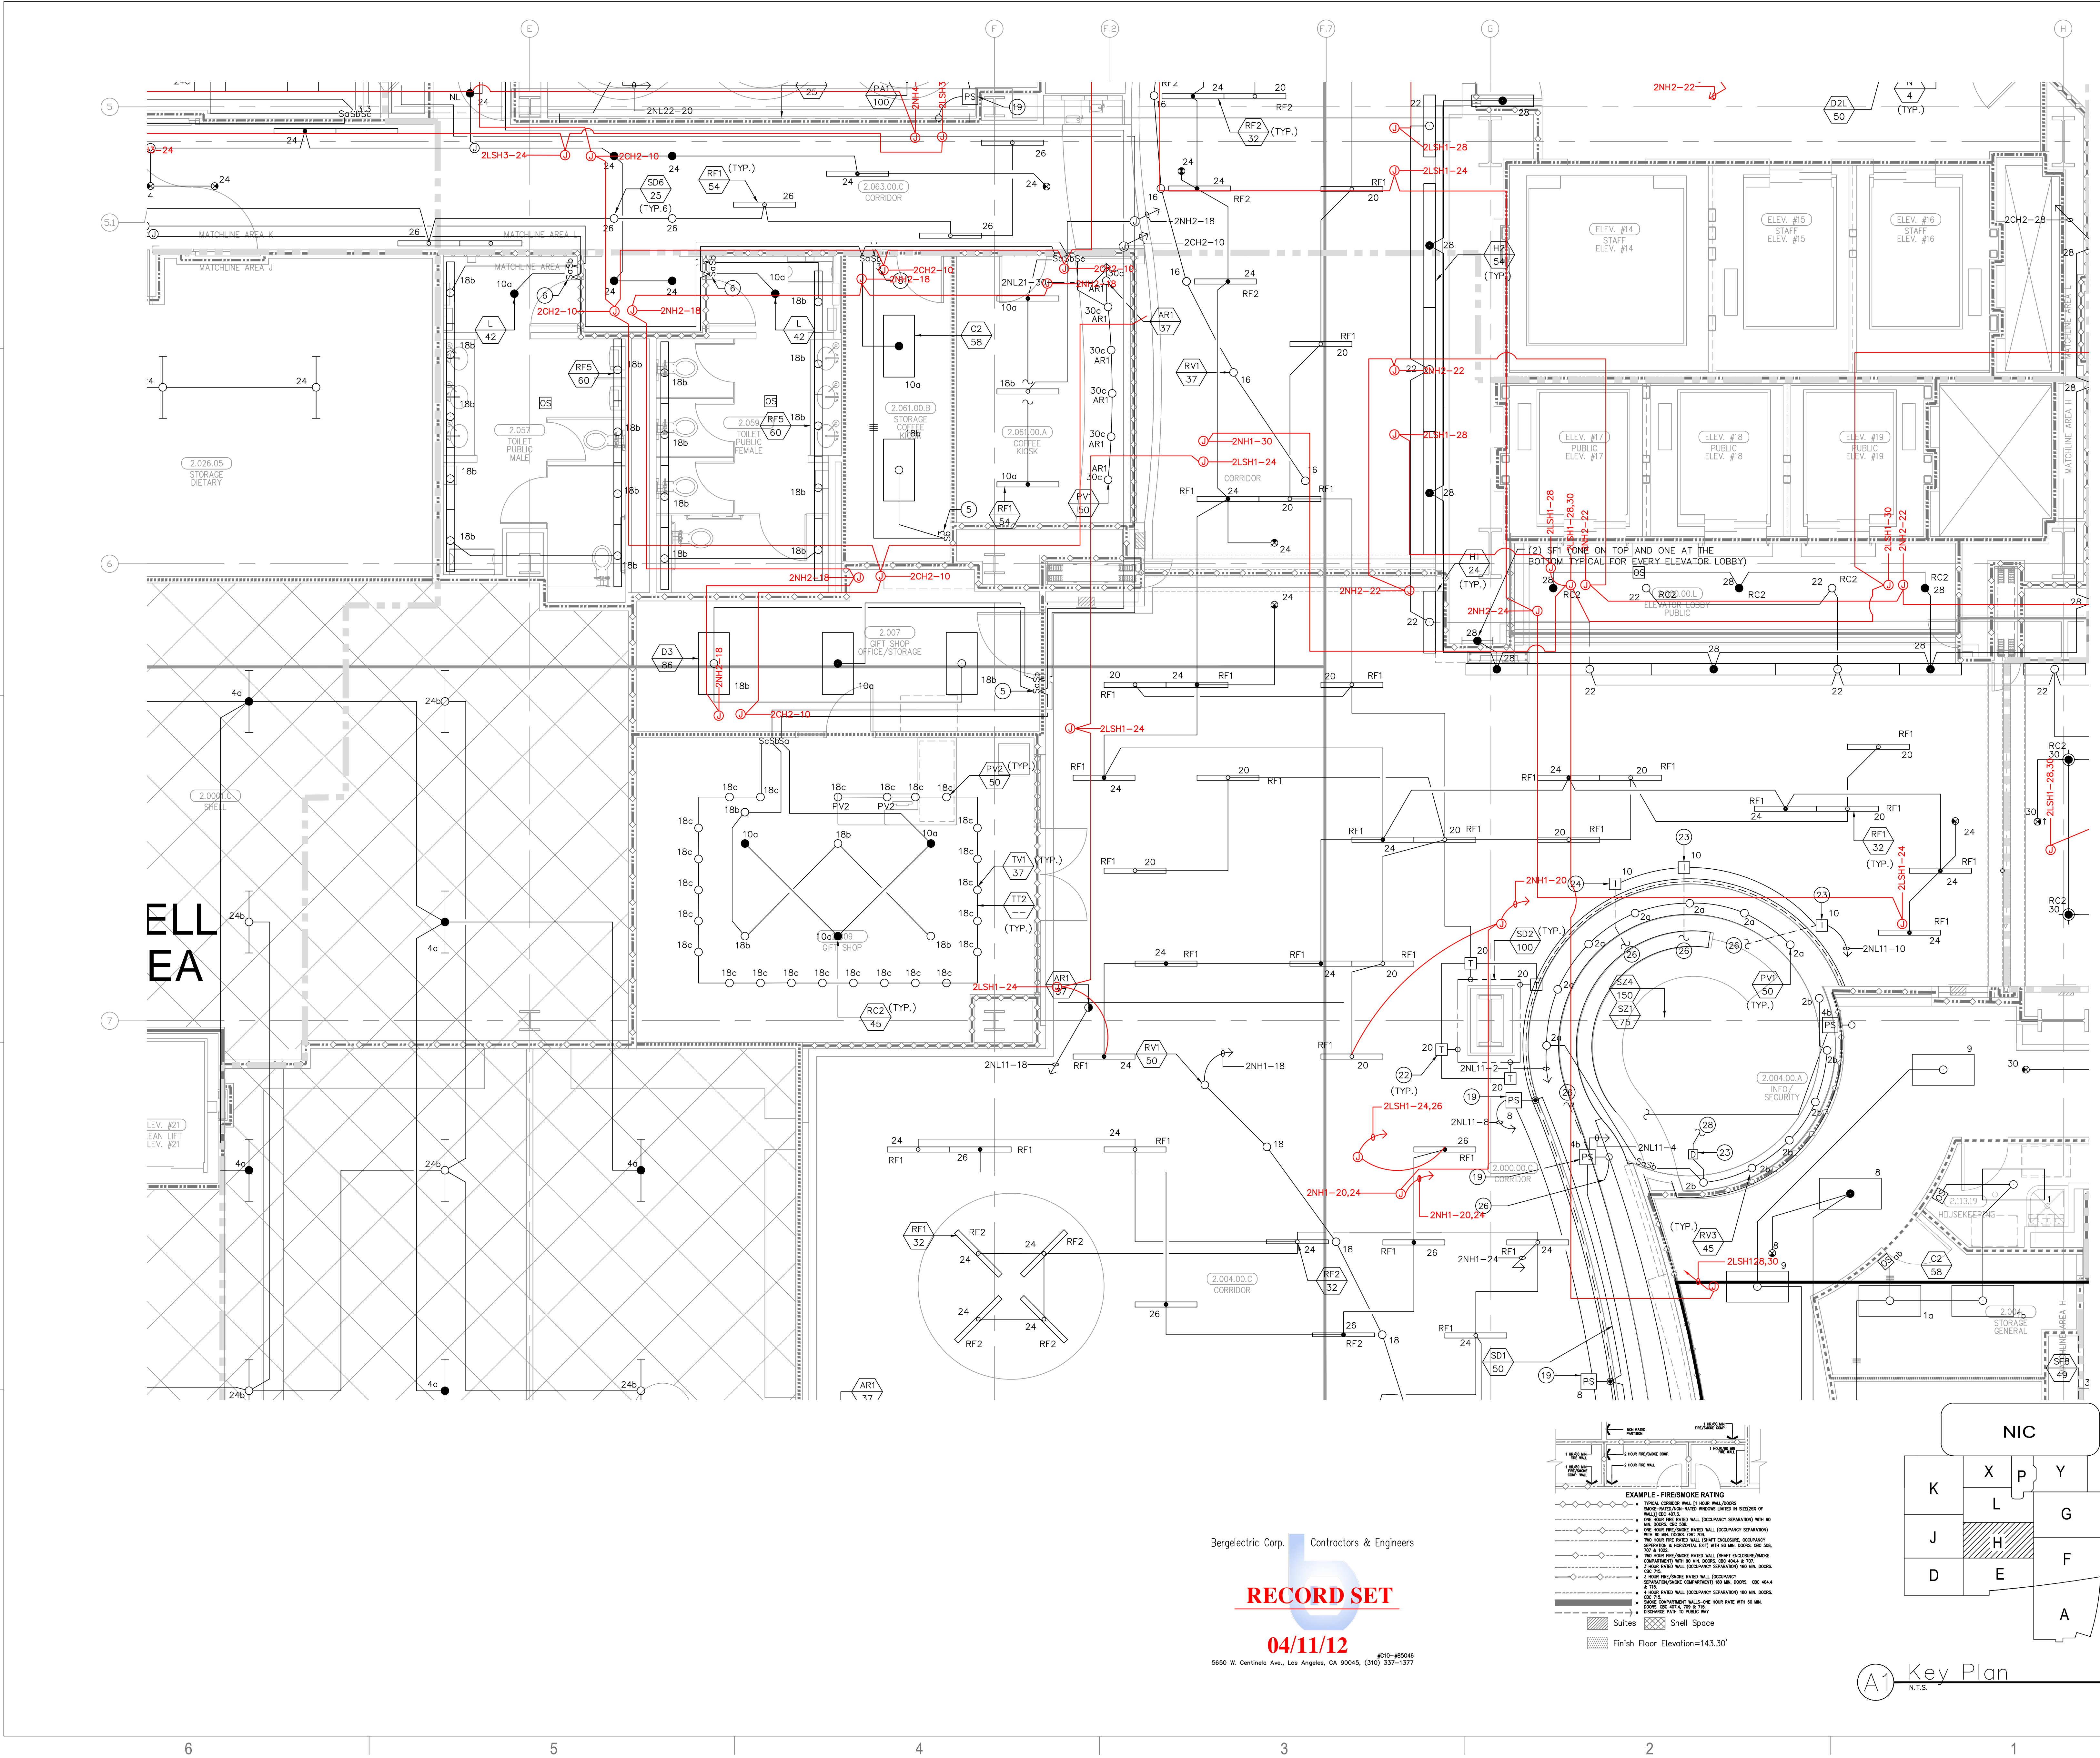

Bergelectric Corp. Contractors & Engineers



RECORD SET

04/11/12


5650 W. Centinela Ave., Los Angeles, CA 90045, (310) 337-1377

A1 Key Plan
N.T.S.

EL3.2J

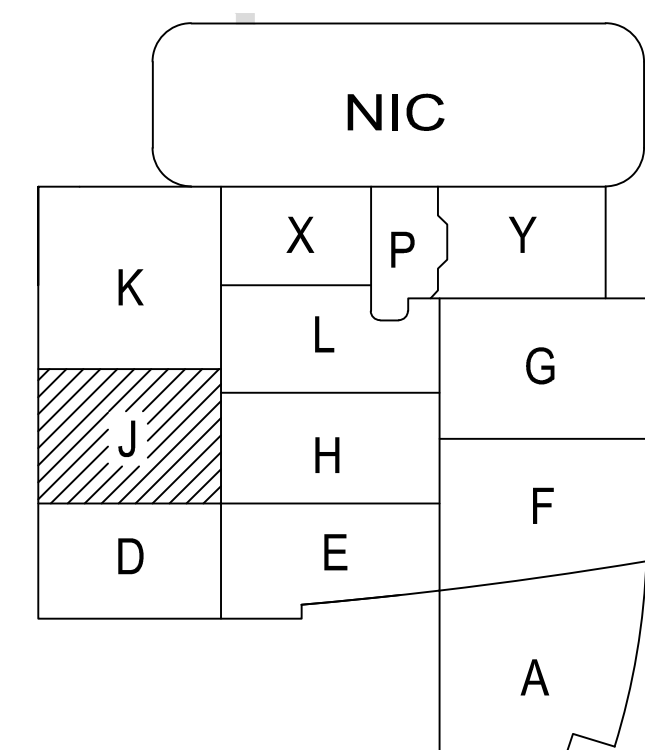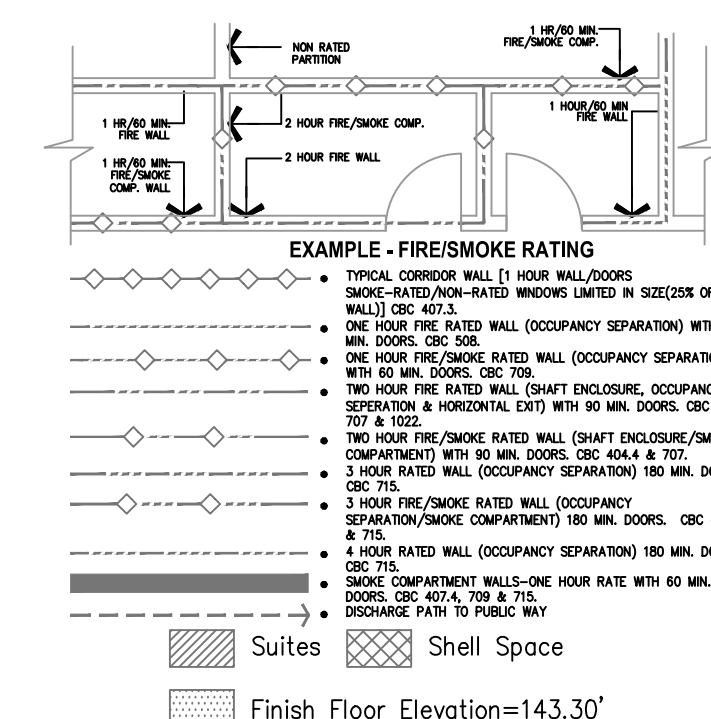


A1 Key Plan
N.T.S.

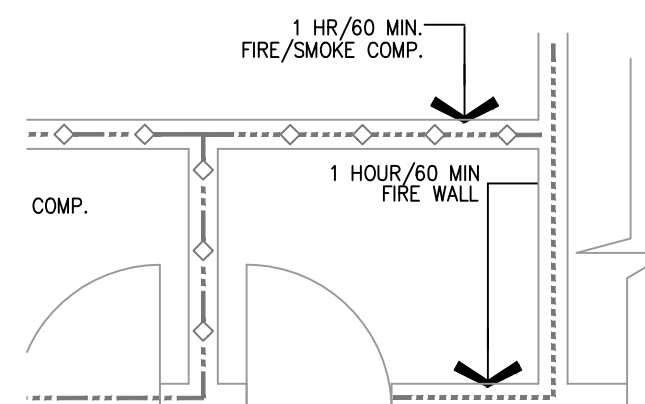


FIRE/SMOKE RATING

CORRIDOR WALL [1 HOUR WALL/DOORS
 RATED/NON-RATED WINDOWS LIMITED IN SIZE(25% OF
 CBC 407.3.
 UR FIRE RATED WALL (OCCUPANCY SEPARATION) WITH 60
 ORS. CBC 508.
 UR FIRE/SMOKE RATED WALL (OCCUPANCY SEPARATION)
 MIN. DOORS. CBC 709.
 UR FIRE RATED WALL (SHAFT ENCLOSURE, OCCUPANCY
 NON & HORIZONTAL EXIT) WITH 90 MIN. DOORS. CBC 508,
 1022.
 UR FIRE/SMOKE RATED WALL (SHAFT ENCLOSURE, SHAFT

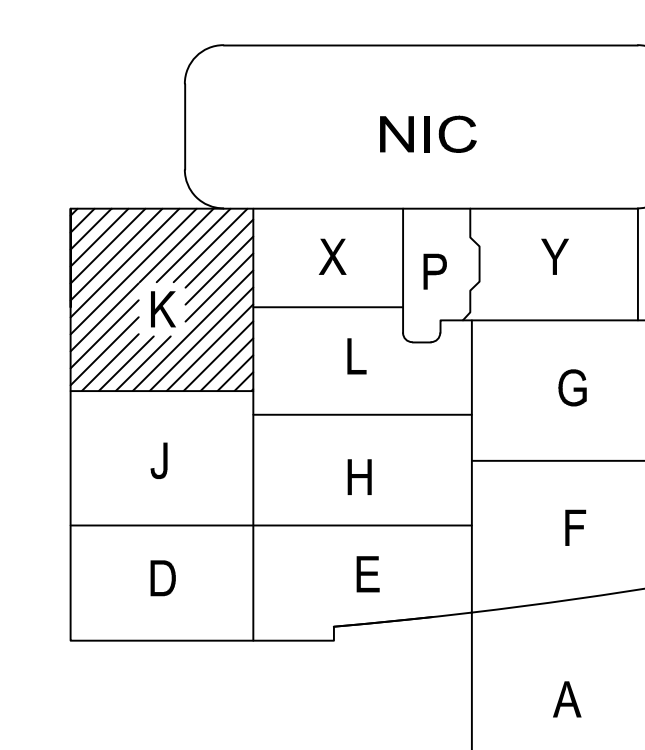

A1 Key Plan
N.T.S.

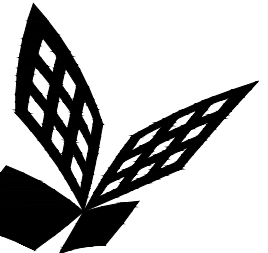

FKP Architects

ARCHITECT OF RECORD

CONSULTANT

T M A D
TAYLOR
& G AINES

STRUCTURAL
MECHANICAL
ELECTRICAL
CIVIL

100 South Anaheim Boulevard, Suite 150
Anaheim, California 92805
Phone: 714.490.5555 Fax: 714.490.5560
Project No. 2305-163-07

REVISIONS

09/12/11 CHANGE ORDER #266

APPROVAL

PROJECT NAME

CHILDREN'S HOSPITAL
OF ORANGE COUNTY

455 S. Main St.
Orange, CA 92668-3874

TOWER II



PROJECT NUMBER

12011.00
Increment #7

OSHPD - PROJECT NUMBER

IL 072072-30

ISSUE

OSHPD PERMIT

DATE

01/27/2010

SCALE


1/4" = 1' - 0"

DRAWING TITLE

LEVEL 2 LIGHTING PLAN
AREA - L

DRAWING NUMBER

EL3.2L

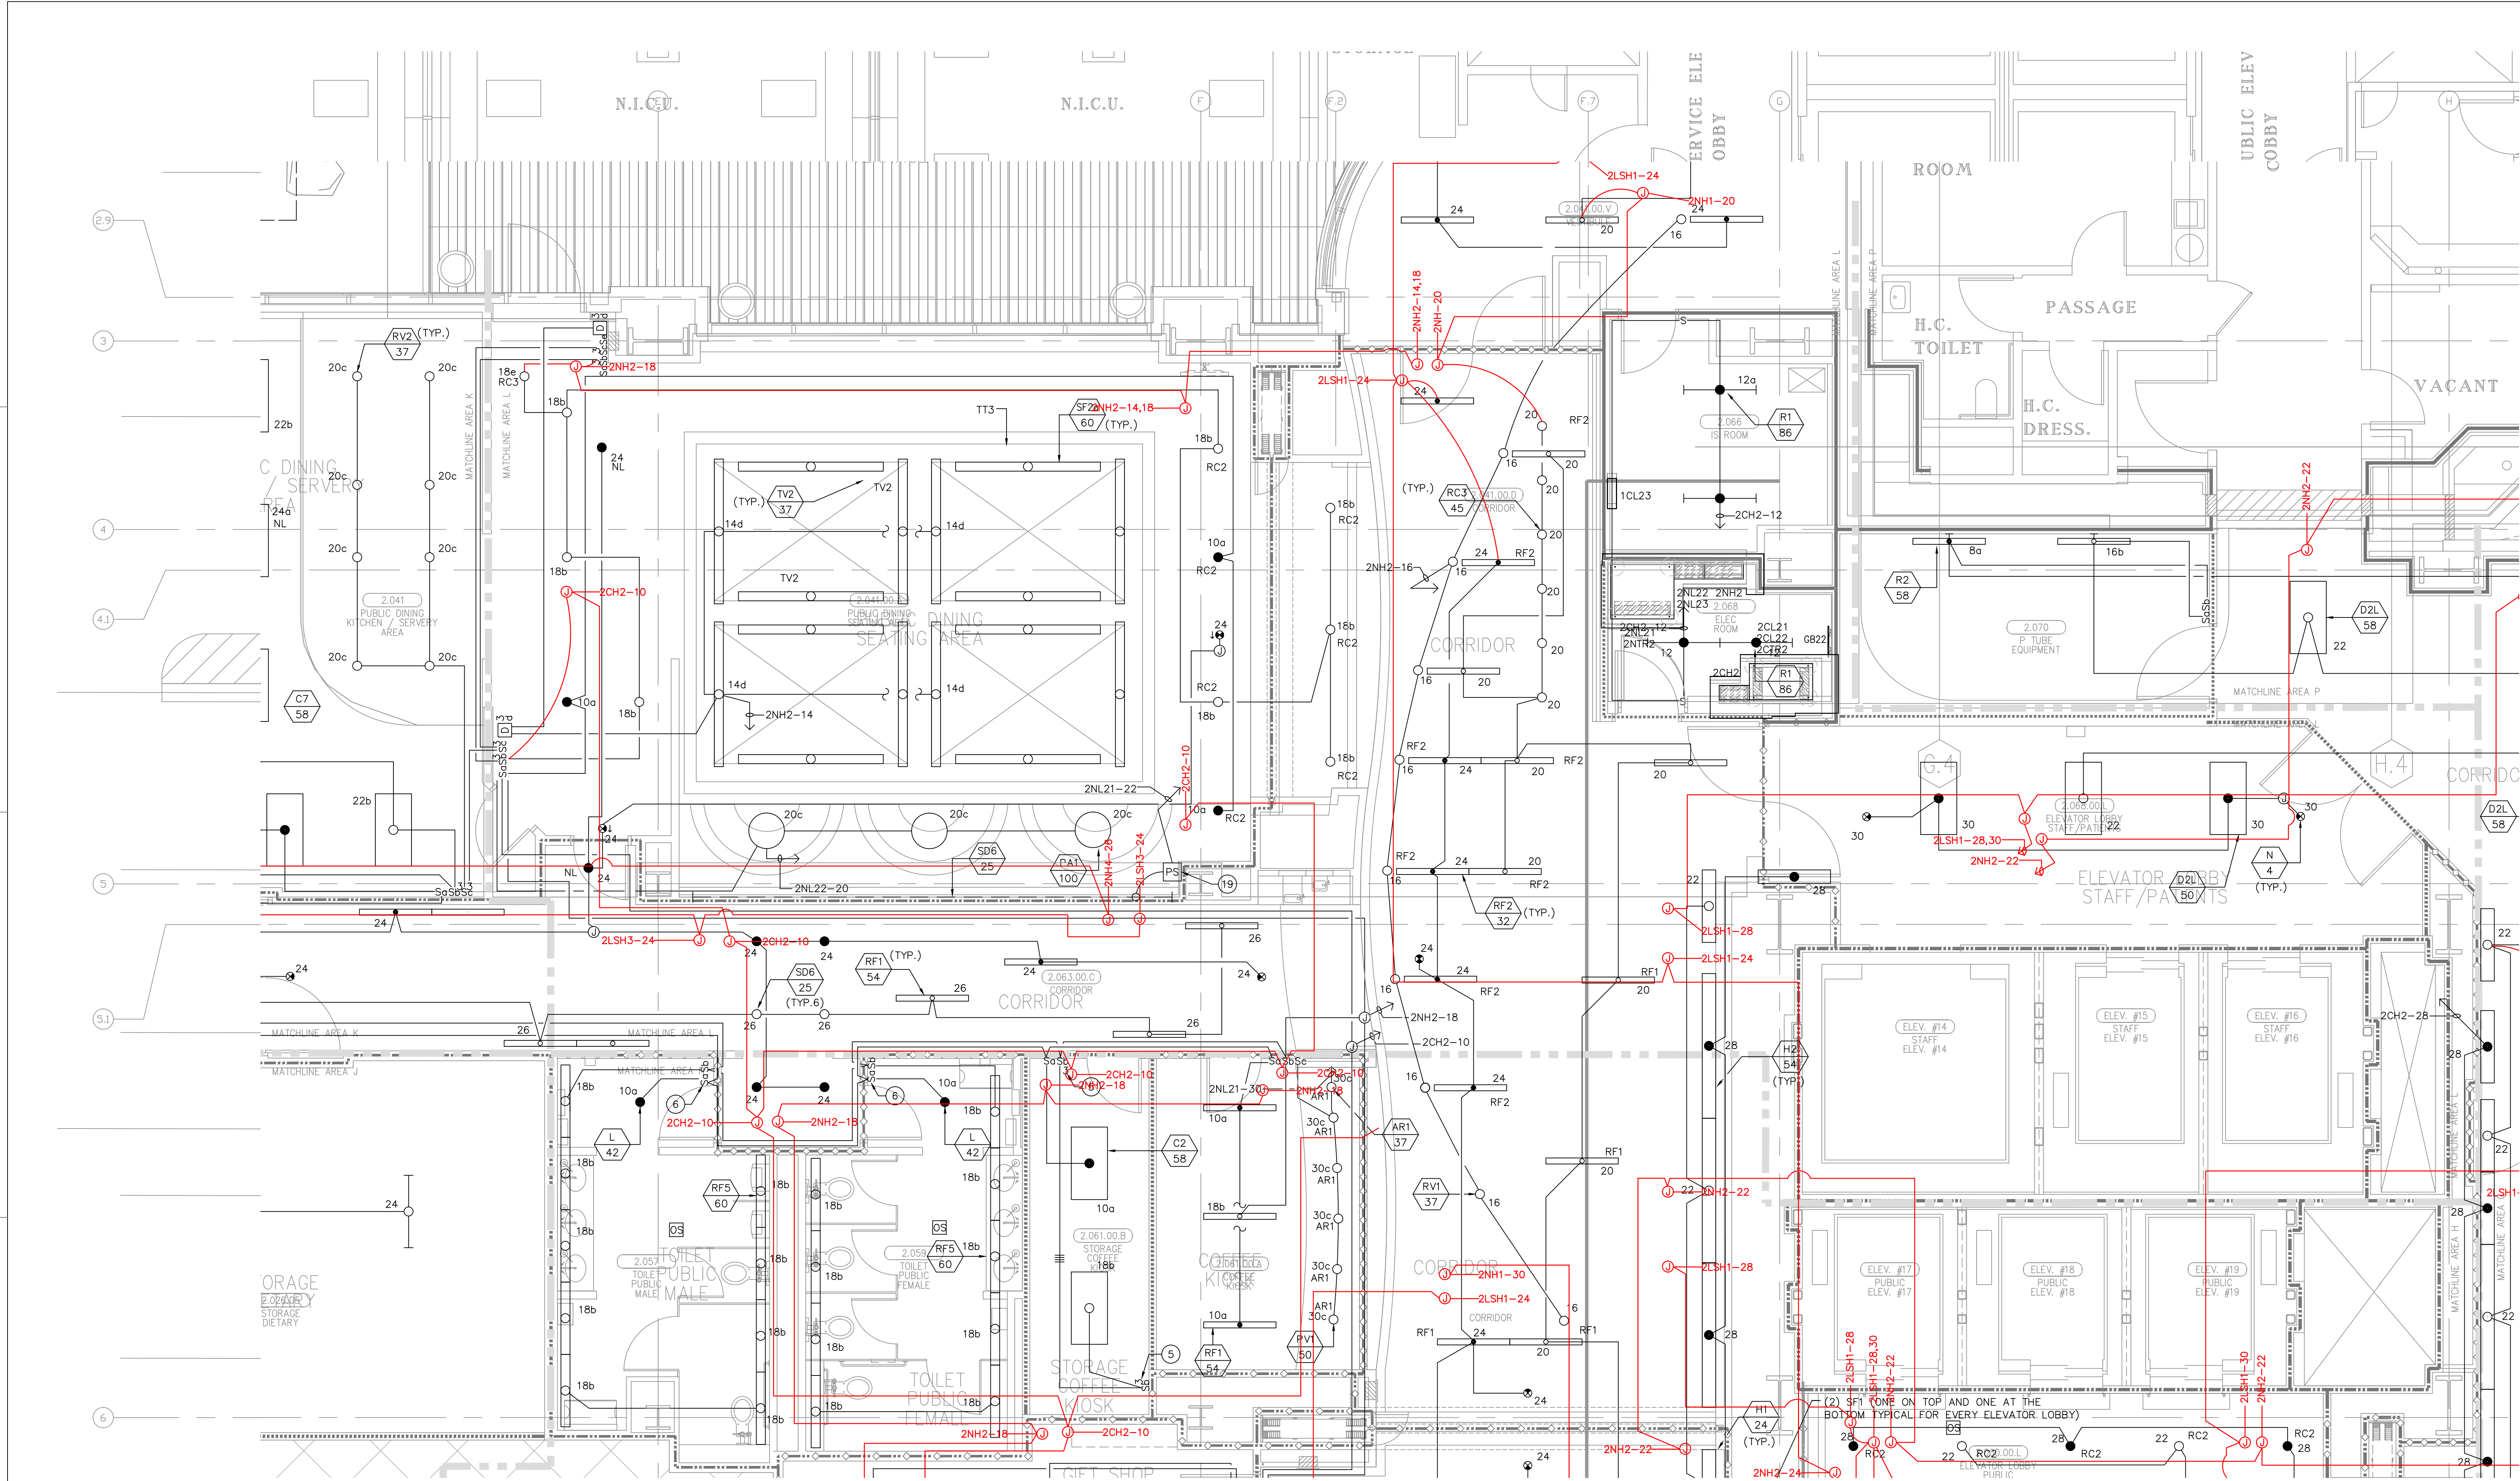


FOR KEY NOTES REFER TO SHEET "EL3A"

Bergelectric Corp. Contractors & Engineers


RECORD SET

04/11/12

5650 W. Centinela Ave., Los Angeles, CA 90045, (310) 337-1377

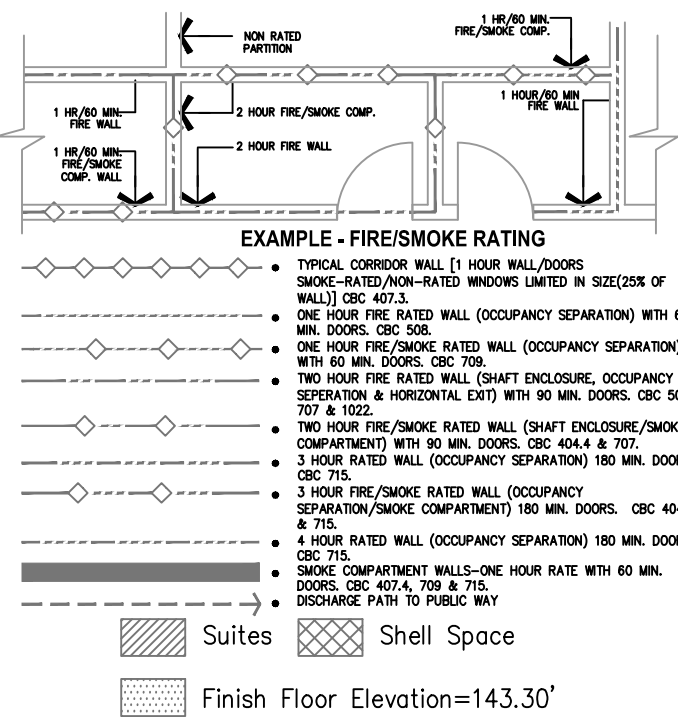

A1 Key Plan
N.T.S.

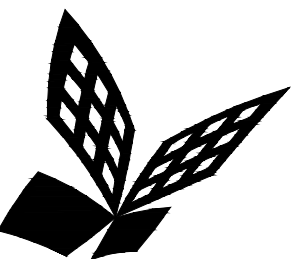

FKP Architects

ARCHITECT OF RECORD

CONSULTANT

T M A D
TAYLOR
& G AINES

- STRUCTURAL
- MECHANICAL
- ELECTRICAL
- CIVIL

100 South Anaheim Boulevard, Suite 150
Anaheim, California 92805
Phone: 714.490.5555 Fax: 714.490.5560
Project No. 2305-163-07

REVISIONS

APPROVAL

Bergelectric Corp. Contractors & Engineers

RECORD SET

04/11/12

5650 W. Centinela Ave., Los Angeles, CA 90045, (310) 337-1377

PROJECT NAME

**CHILDREN'S HOSPITAL
OF ORANGE COUNTY**
455 S. Main St.
Orange, CA 92668-3874

TOWER II



PROJECT NUMBER

**12011.00
Increment #7**

OSHPD - PROJECT NUMBER

IL 072072-30

ISSUE

OSHPD PERMIT

DATE

01/27/2010

SCALE

1/4" = 1' - 0"


DRAWING TITLE

**LEVEL 2 LIGHTING PLAN
AREA - P**


DRAWING NUMBER

EL3.2P

FOR KEY NOTES REFER TO SHEET "EL3A"

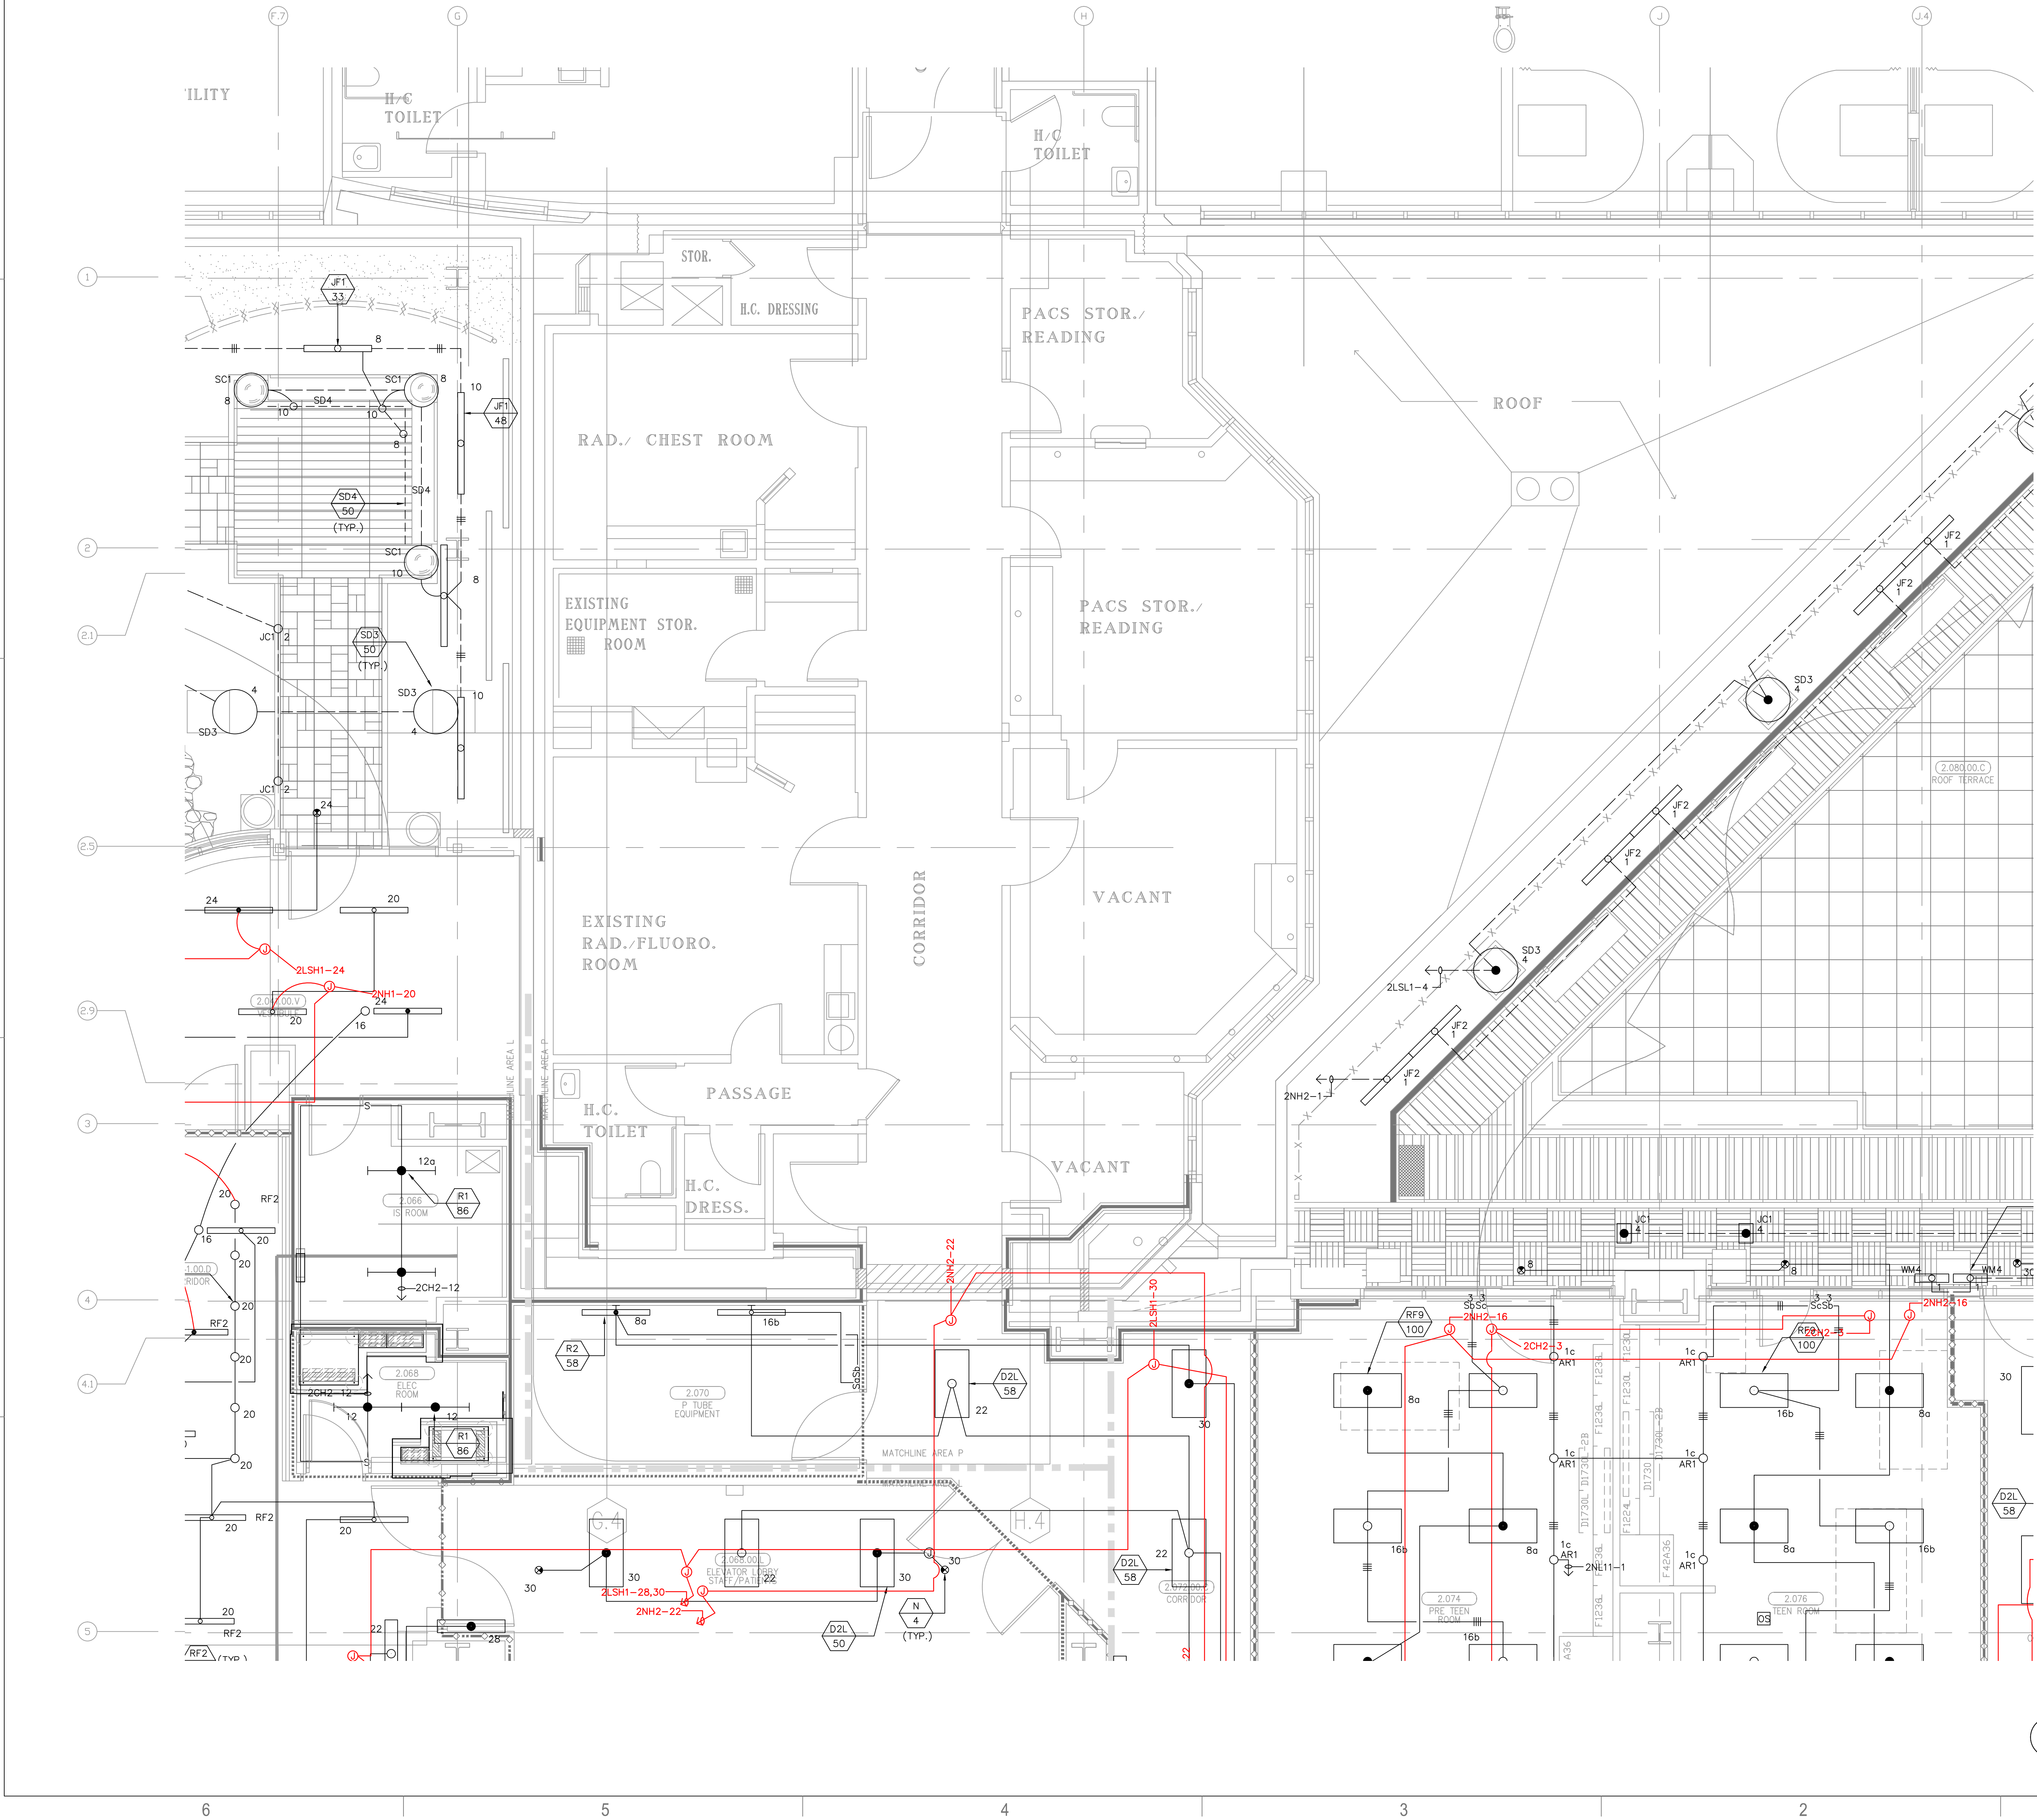

A1 Key Plan
N.T.S.

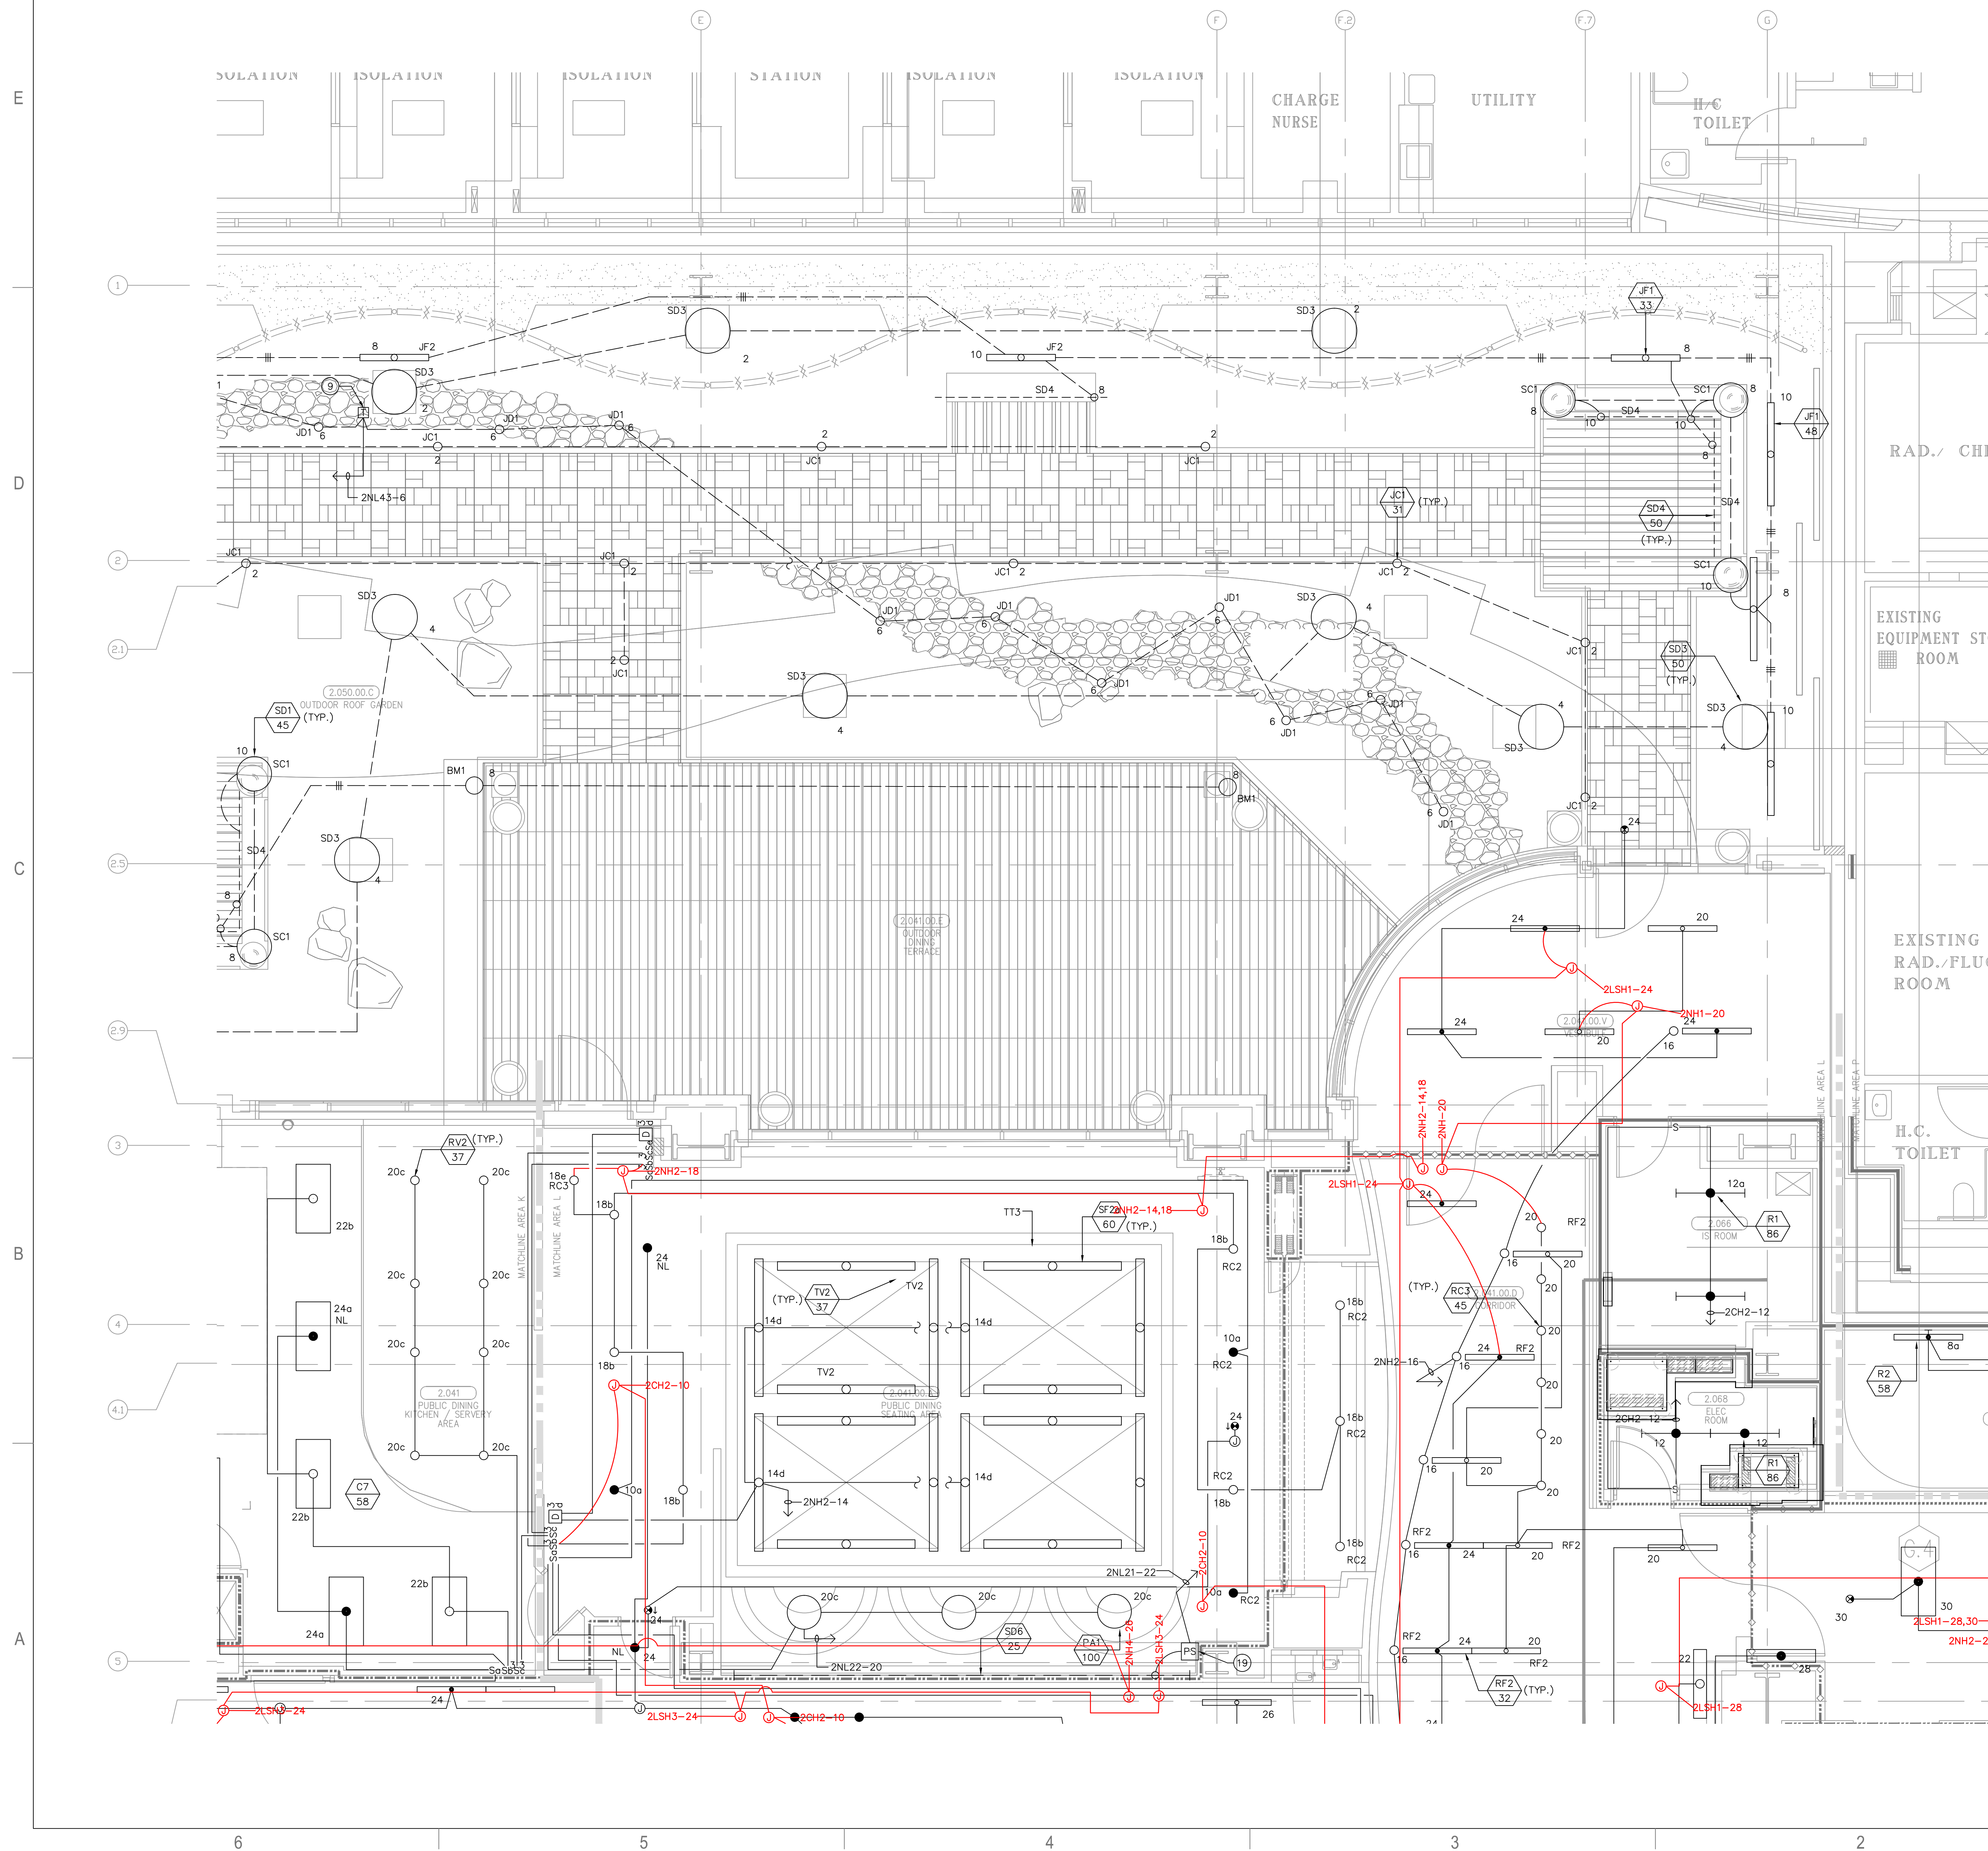

FOR KEY NOTES REFER TO SHEET "EL3A"



ARCHITECT OF RECORD

CONSULTANT
T M A D
TAYLOR
& G AINES
100 South Anaheim Boulevard, Suite 150
Anaheim, California 92805
Phone: 714.490.5555 Fax: 714.490.5560
Project No. 2305-163-07

REVISIONS
A20 01/09/12 CHANGE ORDER #316

APPROVAL

Bergelectric Corp. Contractors & Engineers

RECORD SET

04/11/12

5650 W. Centinela Ave., Los Angeles, CA 90045, (310) 337-1377

PROJECT NAME
**CHILDREN'S HOSPITAL
OF ORANGE COUNTY**
455 S. Main St.
Orange, CA 92668-3874





PROJECT NUMBER
**12011.00
Increment #7**
OSHPD - PROJECT NUMBER
IL 072072-30

ISSUE
OSHPD PERMIT
DATE
01/27/2010
SCALE

1/4" = 1' - 0"
DRAWING TITLE
**LEVEL 2 LIGHTING PLAN
AREA - Y**

DRAWING NUMBER

EL3.2Y

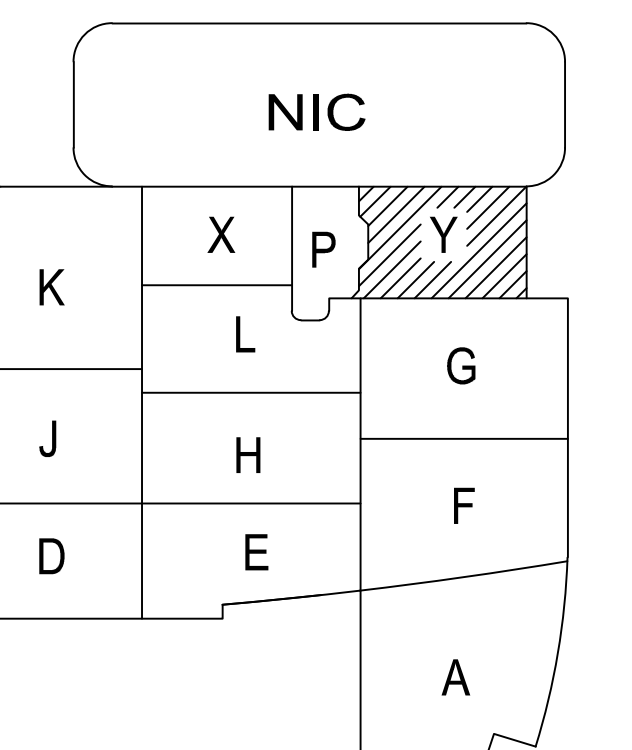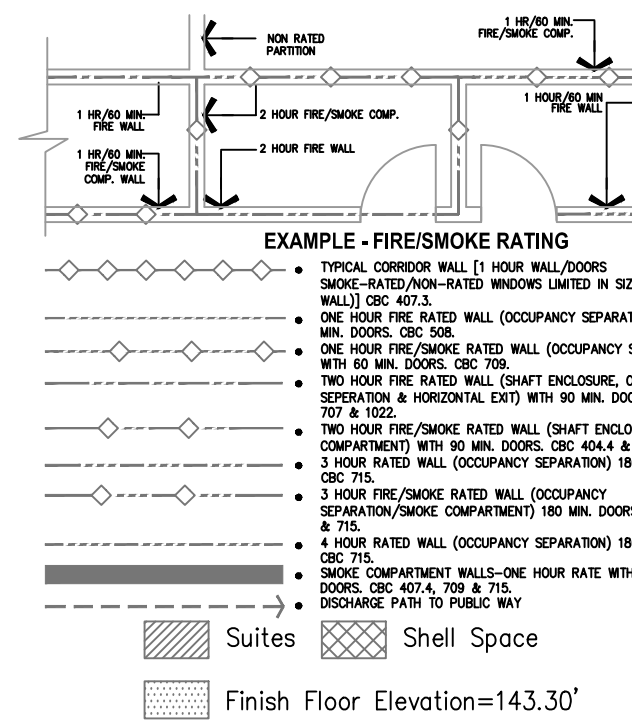

A1 Key Plan
N.T.S.

