

FKP Architects

ARCHITECT OF RECORD

CONSULTANT

T M A D  
TAYLOR  
& GAINES

• STRUCTURAL  
• MECHANICAL  
• ELECTRICAL  
• CIVIL

100 South Anaheim Boulevard, Suite 150  
Anaheim, California 92805  
Phone: 714.490.5555 Fax: 714.490.5560  
Project No. 2305-163-07

REVISIONS

APPROVAL

PROJECT NAME

CHILDREN'S HOSPITAL  
OF ORANGE COUNTY

455 S. Main St.  
Orange, CA 92868-3874

TOWER II



PROJECT NUMBER

12011.00  
Increment #7

OSHPD - PROJECT NUMBER  
IL 072072-30

ISSUE

OSHPD PERMIT

DATE

01/27/2010

SCALE

1/4" = 1' - 0"

DRAWING TITLE

LEVEL 6 LIGHTING PLAN  
AREA - A

DRAWING NUMBER

EL3.6A

SHELL AREA



FOR KEY NOTES REFER TO SHEET "EL3A"

Bergelectric Corp. Contractors & Engineers

RECORD SET


04/11/12

670-85046  
5650 W. Centinela Ave., Los Angeles, CA 90045, (310) 337-1377

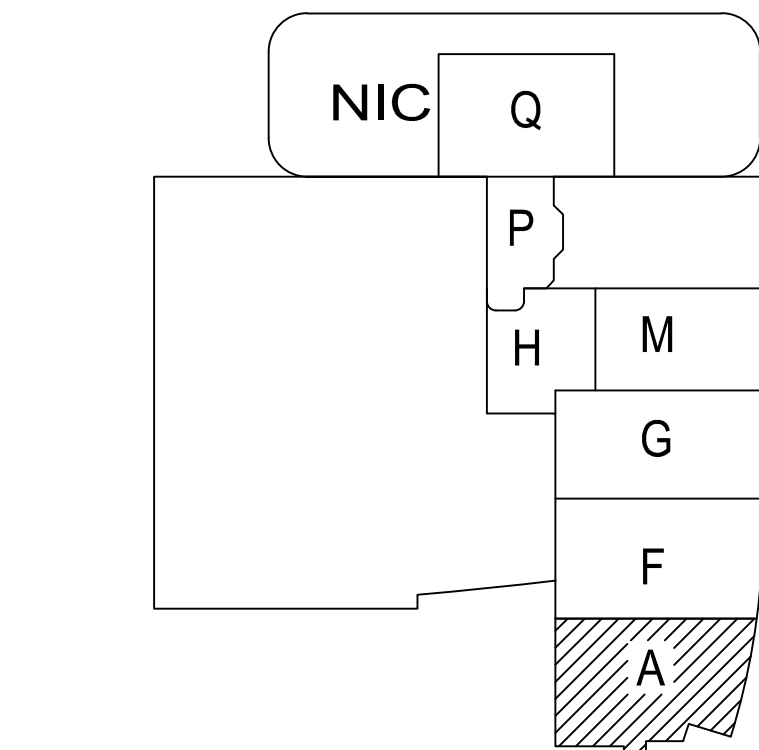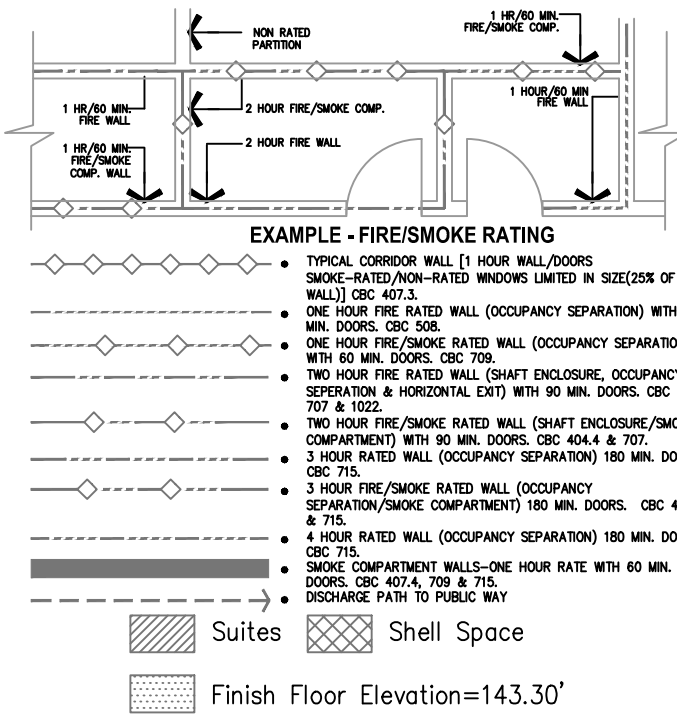

A1 Key Plan  
N.T.S.



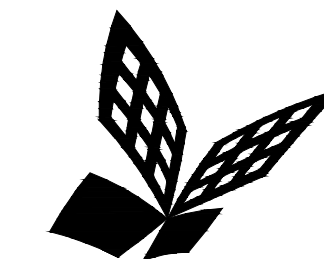

FKP Architects

ARCHITECT OF RECORD

CONSULTANT

T M A D  
TAYLOR  
& GAINES

- STRUCTURAL
- MECHANICAL
- ELECTRICAL
- CIVIL

100 South Anaheim Boulevard, Suite 150  
Anaheim, California 92805  
Phone: 714.490.5555 Fax: 714.490.5560  
Project No. 2305-163-07

REVISIONS

APPROVAL

PROJECT NAME

CHILDREN'S HOSPITAL  
OF ORANGE COUNTY  
455 S. Main St.  
Orange, CA 92868-3874

TOWER II



PROJECT NUMBER

12011.00  
Increment #7  
OSHPD - PROJECT NUMBER  
IL 072072-30

ISSUE

OSHPD PERMIT

DATE

01/27/2010

SCALE


1/4" = 1' - 0"

DRAWING TITLE

LEVEL 6 LIGHTING PLAN  
AREA - F

DRAWING NUMBER

EL3.6F

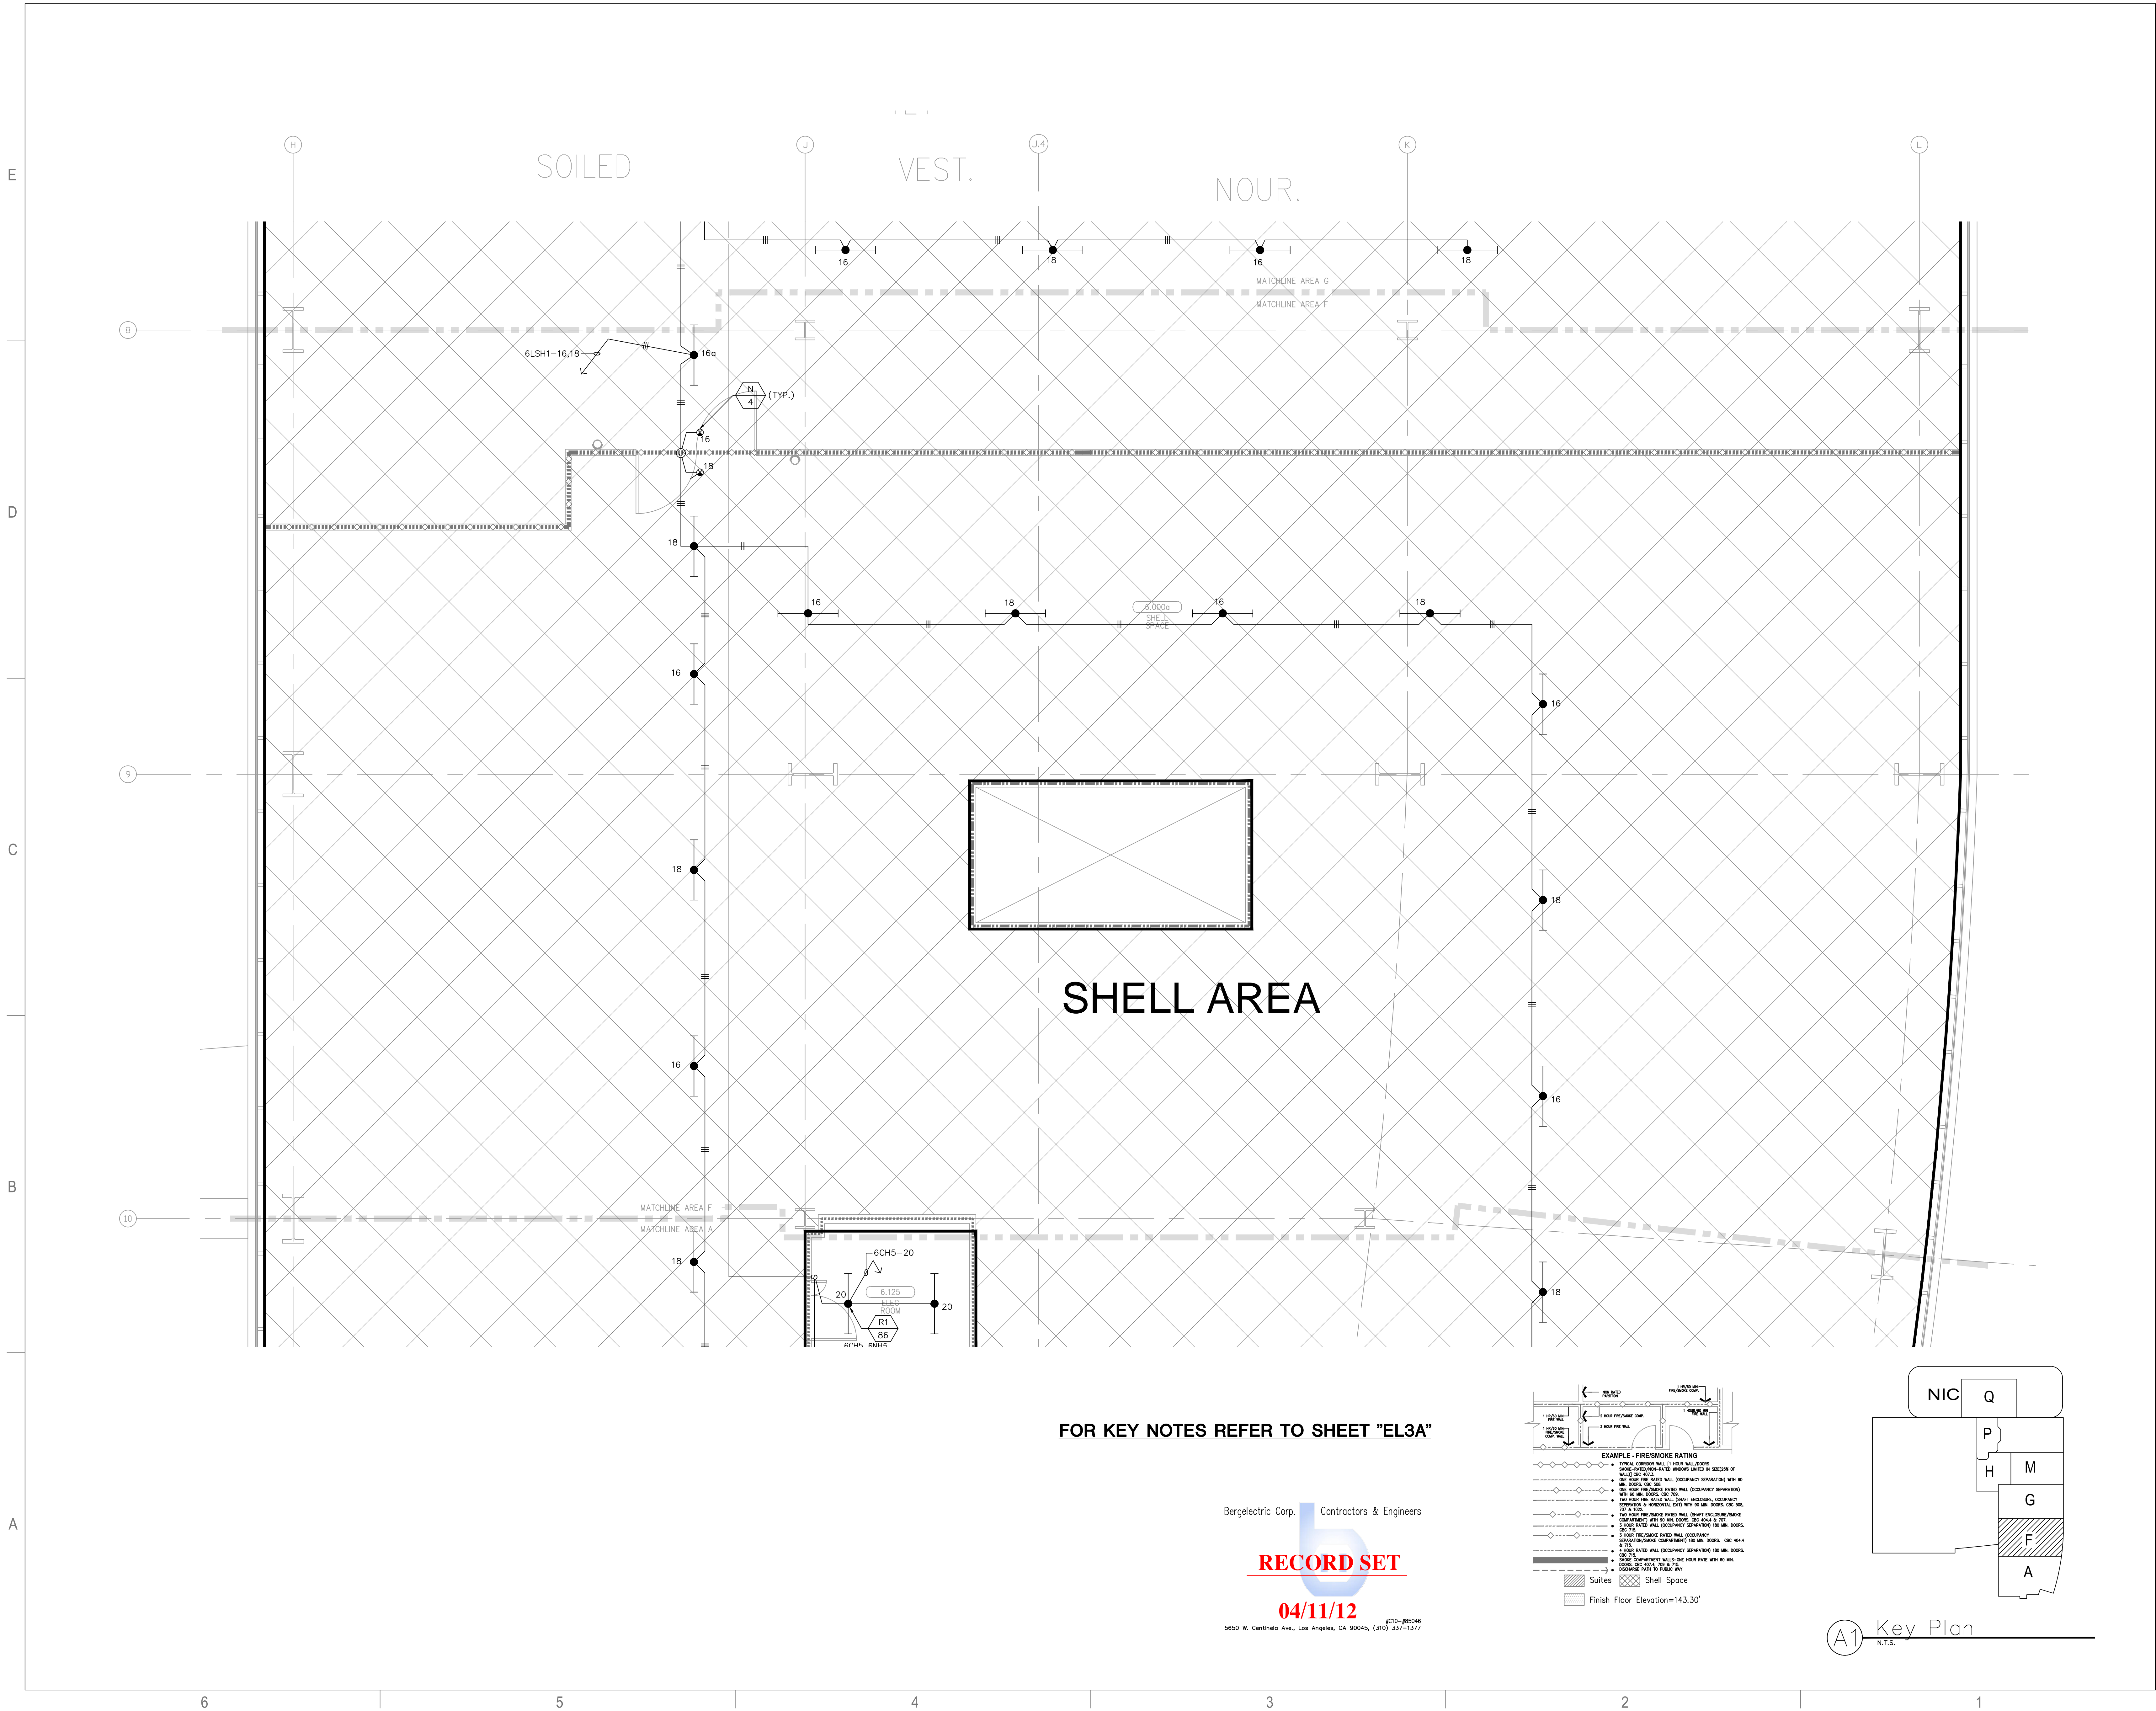



FOR KEY NOTES REFER TO SHEET "EL3A"

Bergelectric Corp. Contractors & Engineers

RECORD SET

04/11/12


#C10-#R5046  
5650 W. Centinela Ave., Los Angeles, CA 90045, (310) 337-1377

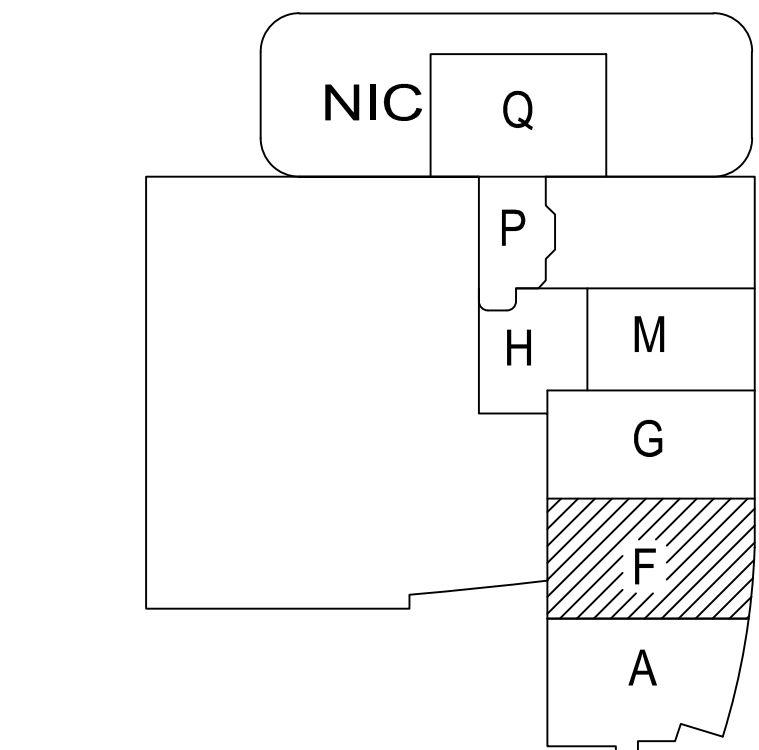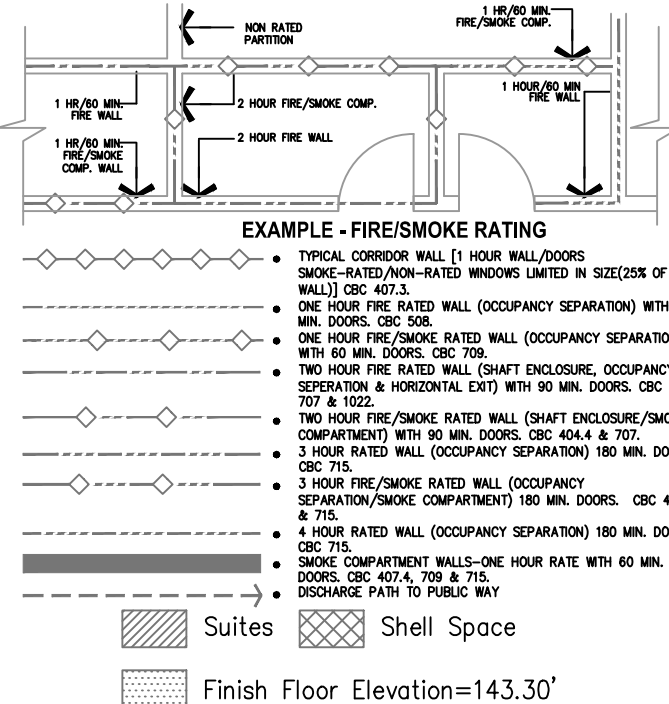

A1 Key Plan  
N.T.S.

F:\PROJECTS\12011\12011.00\12011.00.dwg  
4/18/2012  
JGONZALEZ



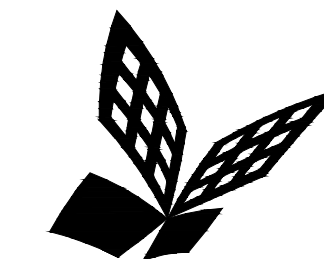

FKP Architects

ARCHITECT OF RECORD

CONSULTANT

T M A D  
TAYLOR  
& GAINES

• STRUCTURAL  
• MECHANICAL  
• ELECTRICAL  
• CIVIL

100 South Anaheim Boulevard, Suite 150  
Anaheim, California 92805  
Phone: 714.490.5555 Fax: 714.490.5560  
Project No. 2305-163-07

REVISIONS

APPROVAL

PROJECT NAME

CHILDREN'S HOSPITAL  
OF ORANGE COUNTY

455 S. Main St.  
Orange, CA 92868-3874

TOWER II



PROJECT NUMBER

12011.00  
Increment #7

OSHPD - PROJECT NUMBER  
IL 072072-30

ISSUE

OSHPD PERMIT

DATE

01/27/2010

SCALE


1/4" = 1' - 0"

DRAWING TITLE

LEVEL 6 LIGHTING PLAN  
AREA - G

DRAWING NUMBER

EL3.6G

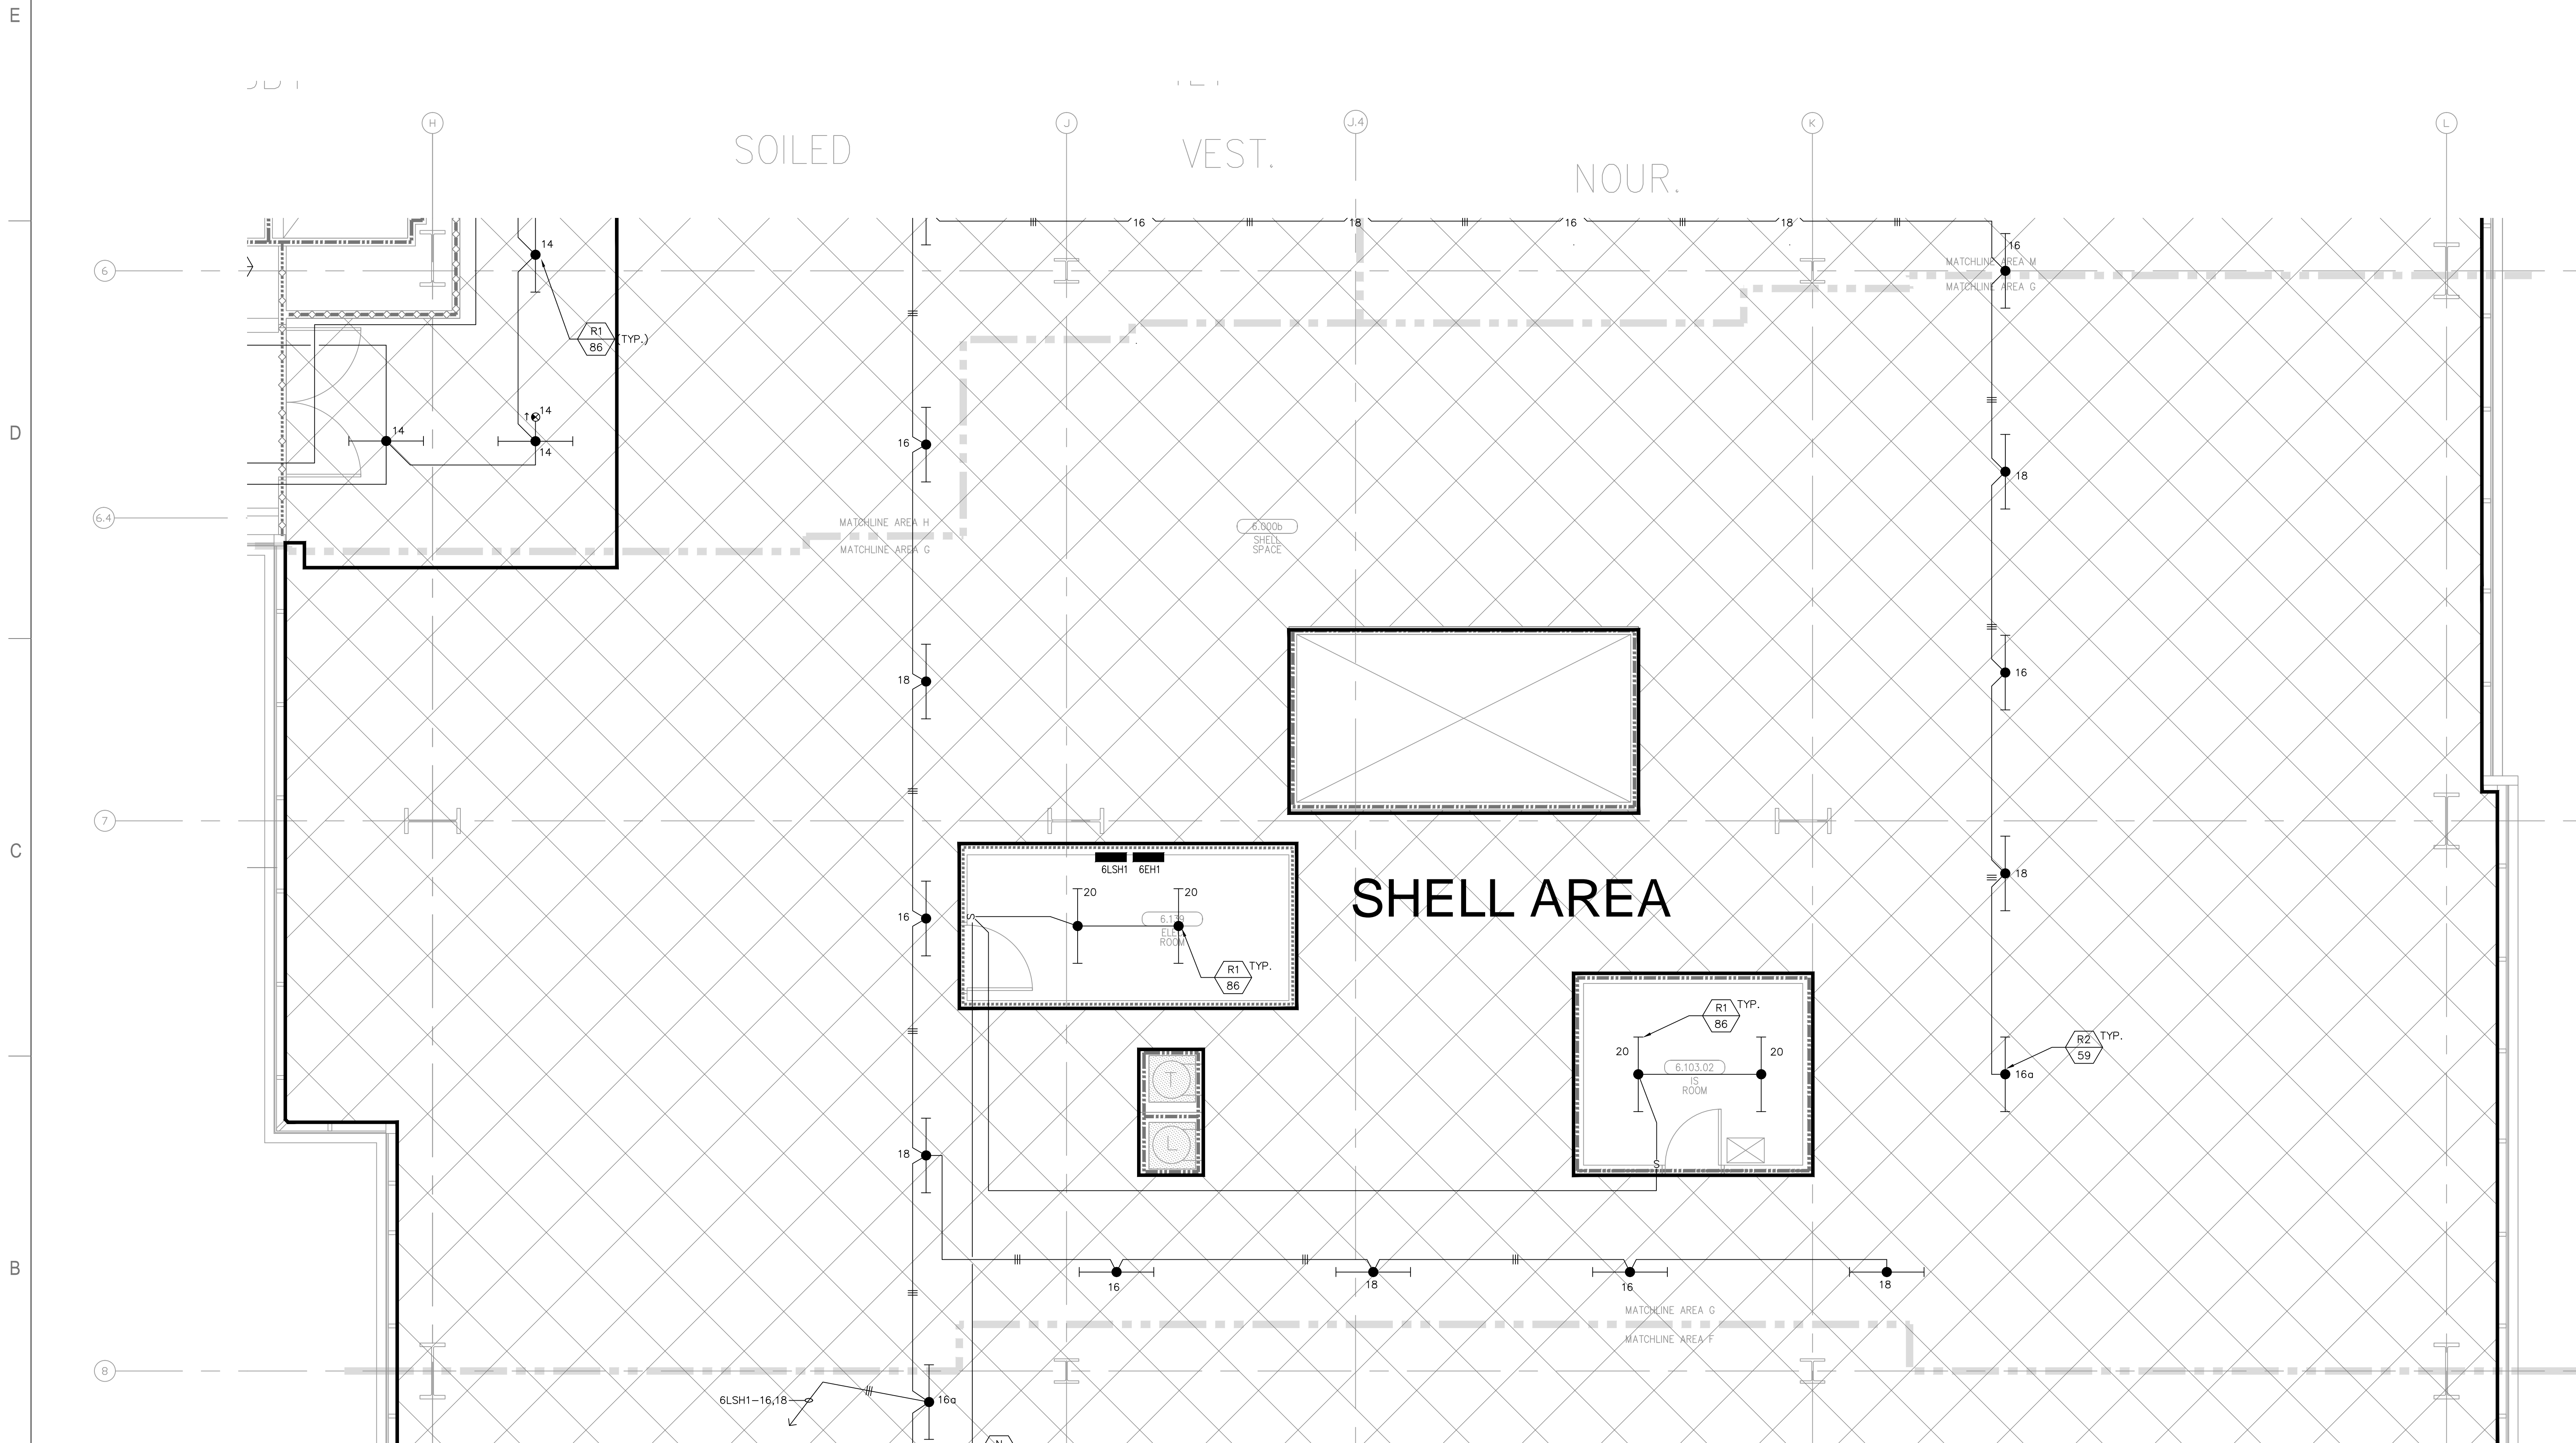


FOR KEY NOTES REFER TO SHEET "EL3A"

Bergelectric Corp. Contractors & Engineers

RECORD SET

04/11/12

#C10-#B5046  
5650 W. Centinela Ave., Los Angeles, CA 90045, (310) 337-1377

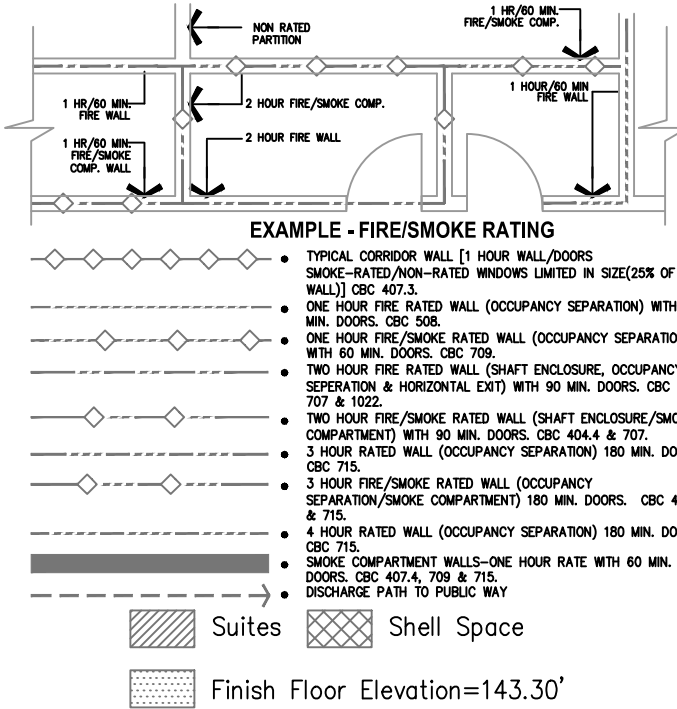


A1 Key Plan  
N.T.S.







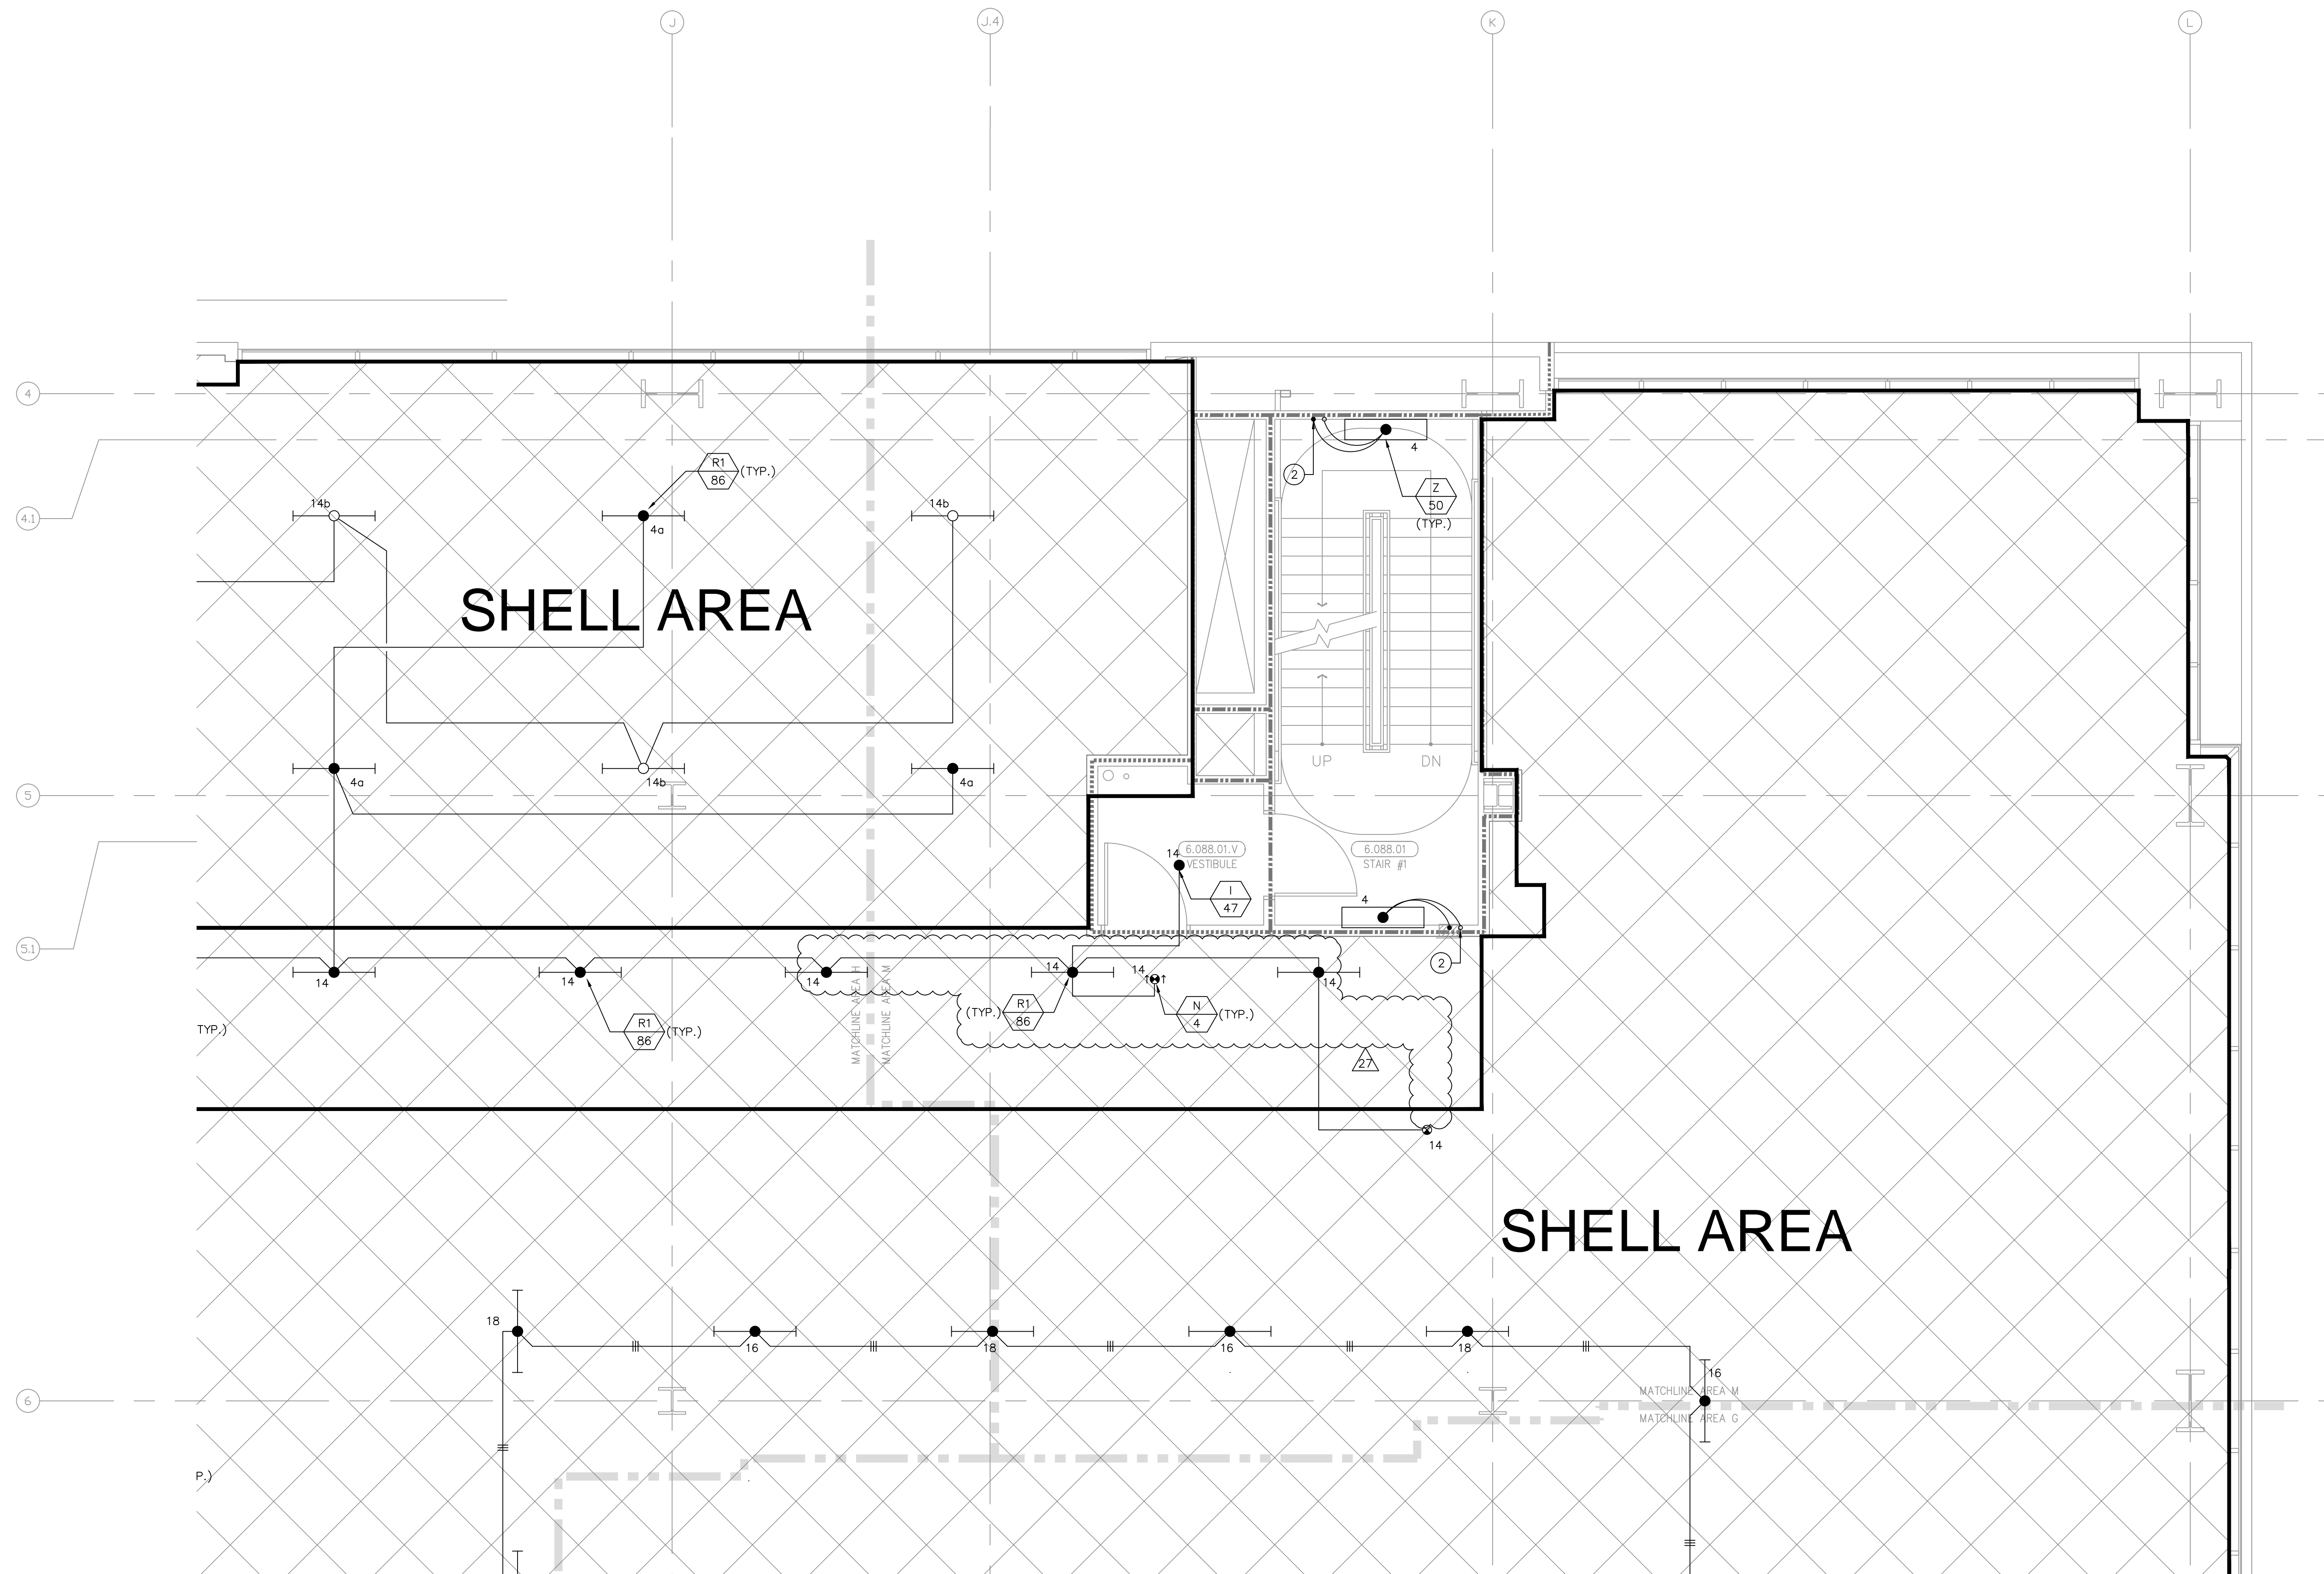



**FOR KEY NOTES REFER TO SHEET "EL3A"**

Bergelectric Corp.  Contractors & Engineers

## RECORD SET

04/11/12

04/11/12 #C10-#85046  
5650 W. Centinela Ave., Los Angeles, CA 90045, (310) 337-1377

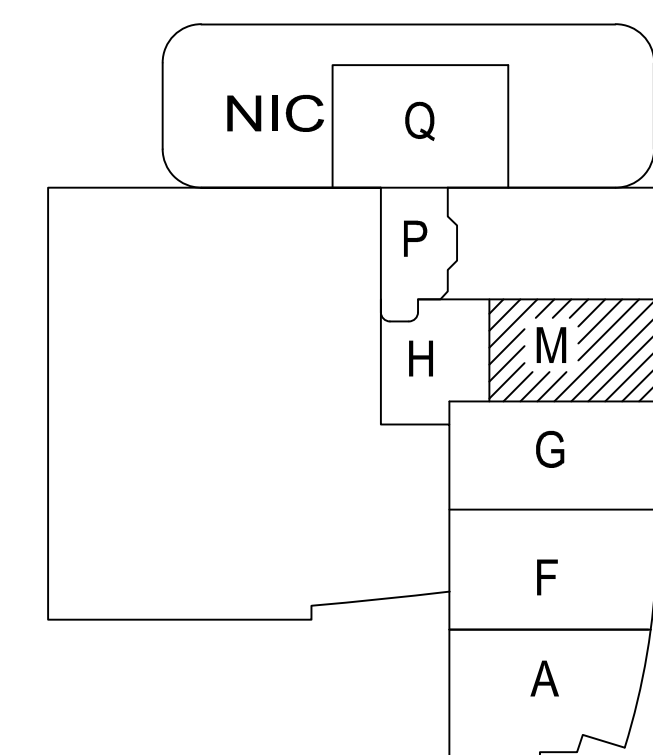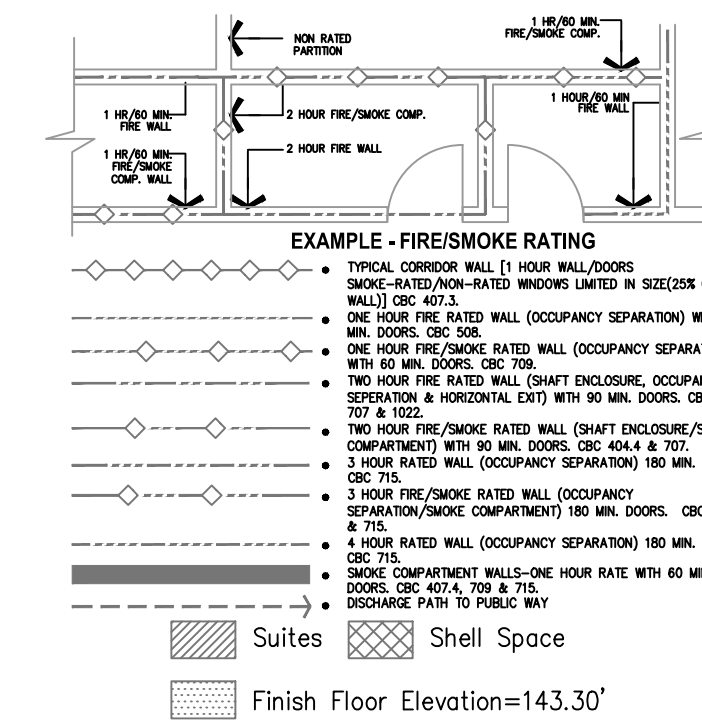

A1 Key Plan  
N.T.S.