
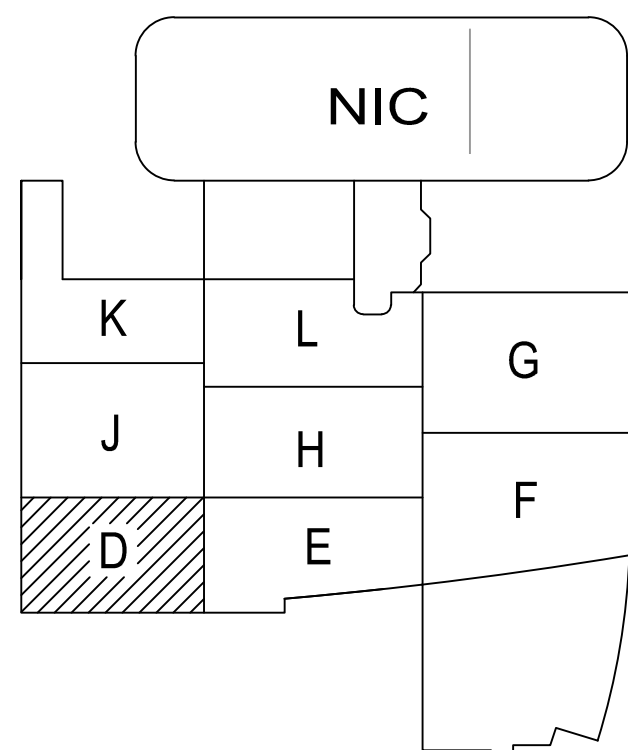


EP3.2D

[illegible]

A1 Key Plan
N.T.S.

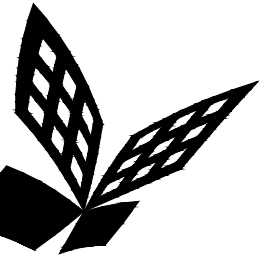

FKP Architects

ARCHITECT OF RECORD

CONSULTANT

T M A D
TAYLOR
& GAINES

- STRUCTURAL
- MECHANICAL
- ELECTRICAL
- CIVIL

100 South Anaheim Boulevard, Suite 150
Anaheim, California 92805
Phone: 714.490.5555 Fax: 714.490.5560
Project No. 2305-163-07

REVISIONS

134	12/06/10	CHANGE ORDER #109
161	03/01/11	CHANGE ORDER #134

APPROVAL

PROJECT NAME

**CHILDREN'S HOSPITAL
OF ORANGE COUNTY**
455 S. Main St.
Orange, CA 92868-3874

TOWER II



PROJECT NUMBER

12011.00
Increment #7
12002-00
OSHPD - PROJECT NUMBER
IL 072072-30

ISSUE

OSHPD PERMIT

DATE

01/27/2010

SCALE

1/4" = 1' - 0"

DRAWING TITLE

**LEVEL 2 POWER PLAN
AREA - E**

DRAWING NUMBER

EP3.2E



FOR KEY NOTES REFER TO SHEET "EP3A"

Bergelectric Corp. Contractors & Engineers

RECORD SET

04/11/12

1650 W. Centinela Ave., Los Angeles, CA 90045, (310) 337-1377

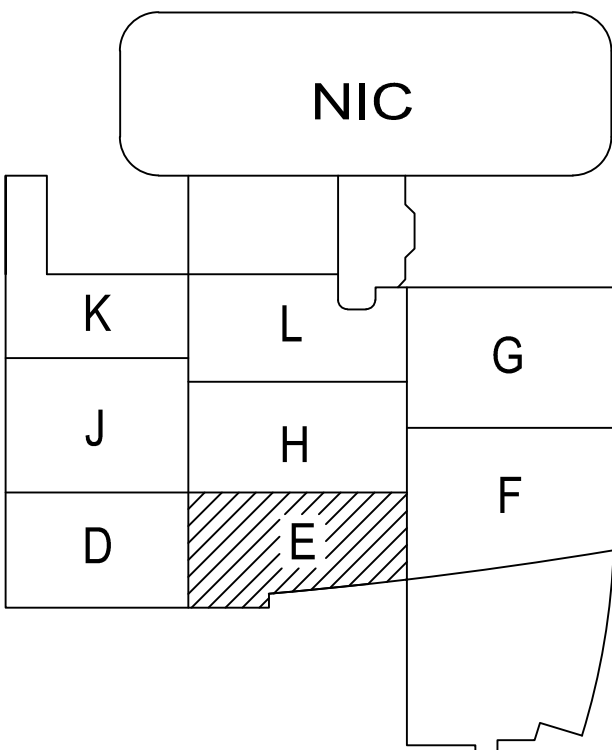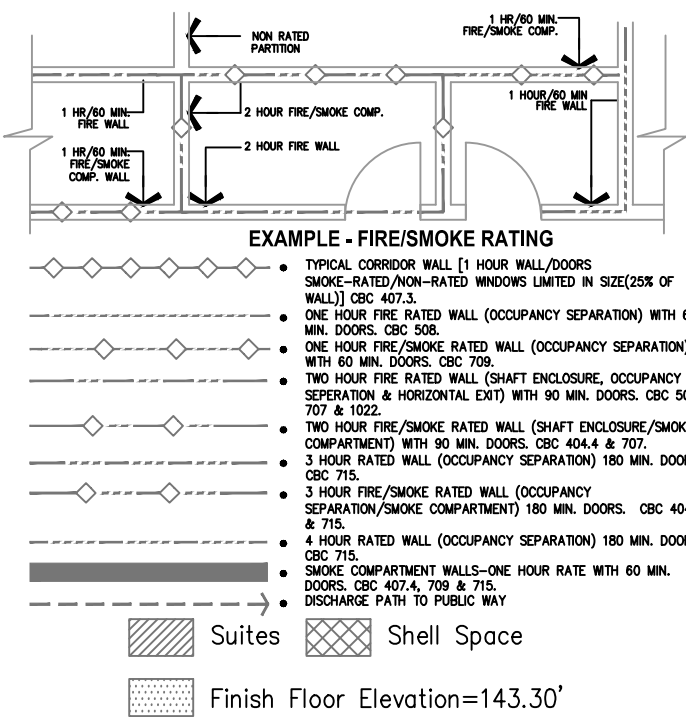

A1 Key Plan
N.T.S.

ARCHITECT OF RECORD

CONSULTANT

REVISIONS

161 03/01/11 CHANGE ORDER #134

APPROVAL _____

PROJECT NAME

TOWER II



PROJECT NUMBER _____

2011.00
Increment #7

OSHPD - PROJECT NUMBER
L 072072-30

ISSUE

OSHPD PERMIT

DATE _____

01/27/2010

SCALE



$$1/4'' = 1' - 0''$$

LEVEL 2 POWER PLAN

AREA - F

DRAWING NUMBER

EP3.2F

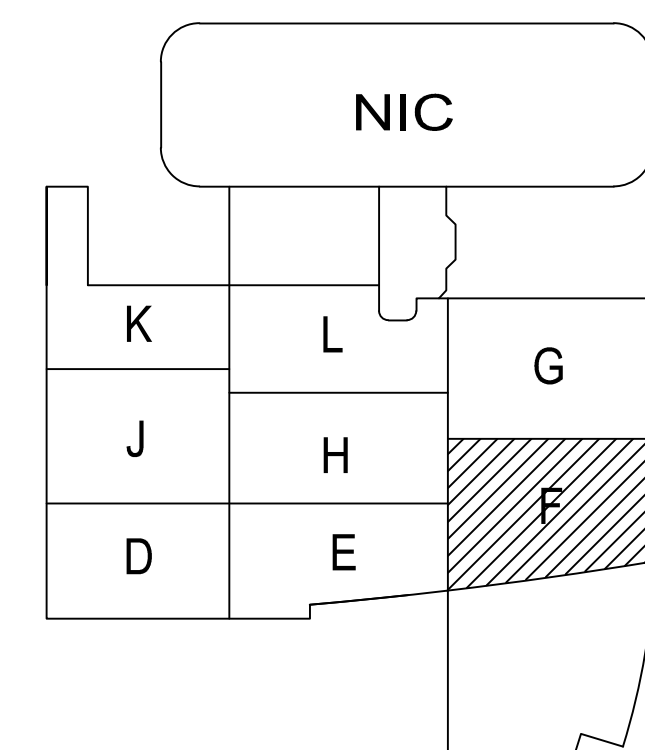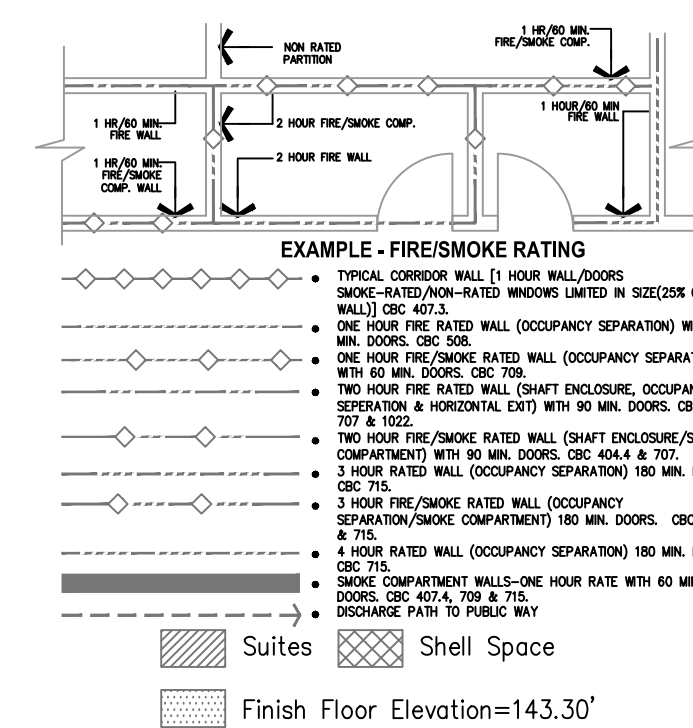


A1 Key Plan
N.T.S.

Bergelectric Corp. Contractors & Engineers

RECORD SET

04/11/12

5650 W. Centinela Ave., Los Angeles, CA 90045, (310) 337-1377

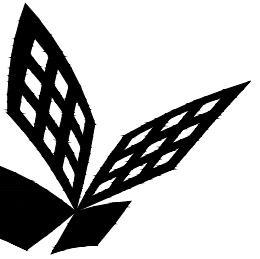

FKP Architects

ARCHITECT OF RECORD

CONSULTANT

T M A D
TAYLOR
& G AINES

STRUCTURAL
MECHANICAL
ELECTRICAL
CIVIL

100 South Anaheim Boulevard, Suite 150
Anaheim, California 92805
Phone: 714.490.5555 Fax: 714.490.5560
Project No. 2305-163-07

REVISIONS

03/01/11 CHANGE ORDER #134
11/11/11 CHANGE ORDER #232

APPROVAL

PROJECT NAME

CHILDREN'S HOSPITAL
OF ORANGE COUNTY
455 S. Main St.
Orange, CA 92868-3874

TOWER II



PROJECT NUMBER

12011.00
Increment #7

OSHPD - PROJECT NUMBER
IL 072072-30

ISSUE

OSHPD PERMIT

DATE

01/27/2010

SCALE

1/4" = 1' - 0"

DRAWING TITLE

LEVEL 2 POWER PLAN
AREA - G

DRAWING NUMBER

EP3.2G


FOR KEY NOTES REFER TO SHEET "EP3A"

Bergelectric Corp. Contractors & Engineers


RECORD SET

04/11/12

1650 W. Centinela Ave., Los Angeles, CA 90045, (310) 337-1377

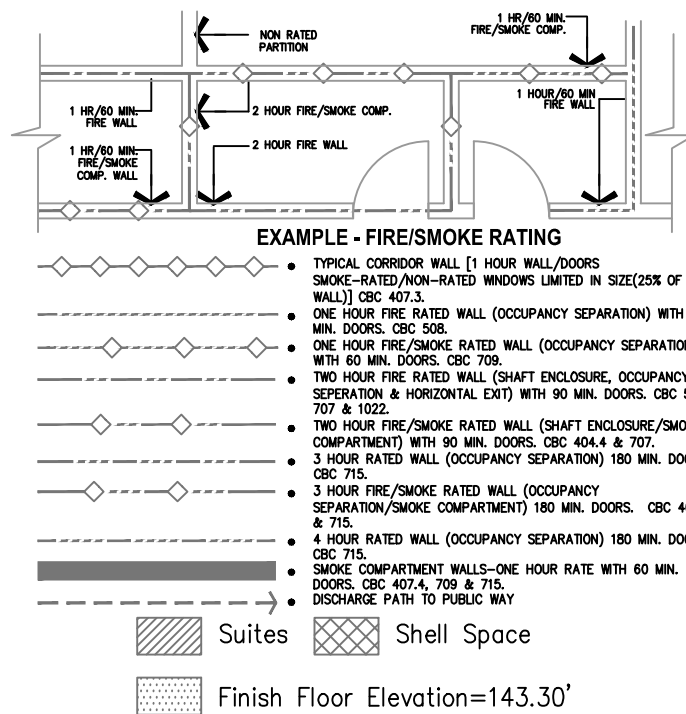

A1 Key Plan
N.T.S.

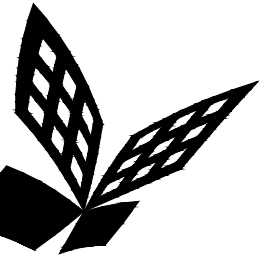

FKP Architects

ARCHITECT OF RECORD

CONSULTANT

T M A D
TAYLOR
& G AINES

- STRUCTURAL
- MECHANICAL
- ELECTRICAL
- CIVIL

100 South Anaheim Boulevard, Suite 150
Anaheim, California 92805
Phone: 714.490.5555 Fax: 714.490.5560
Project No. 2305-163-07

REVISIONS

63	03/01/11	CHANGE ORDER #134
87	12/19/11	CHANGE ORDER #294
85	12/22/11	CHANGE ORDER #295

APPROVAL

PROJECT NAME

**CHILDREN'S HOSPITAL
OF ORANGE COUNTY**
455 S. Main St.
Orange, CA 92868-3874

TOWER II



PROJECT NUMBER

**12011.00
Increment #7**

OSHPD - PROJECT NUMBER
IL 072072-30

ISSUE

OSHPD PERMIT

DATE

01/27/2010

SCALE

1/4" = 1' - 0"

DRAWING TITLE

**LEVEL 2 POWER PLAN
AREA - H**

DRAWING NUMBER

EP3.2H


FOR KEY NOTES REFER TO SHEET "EP3A"

Bergelectric Corp. Contractors & Engineers

RECORD SET

04/11/12

1650 W. Centinela Ave., Los Angeles, CA 90045, (310) 337-1377

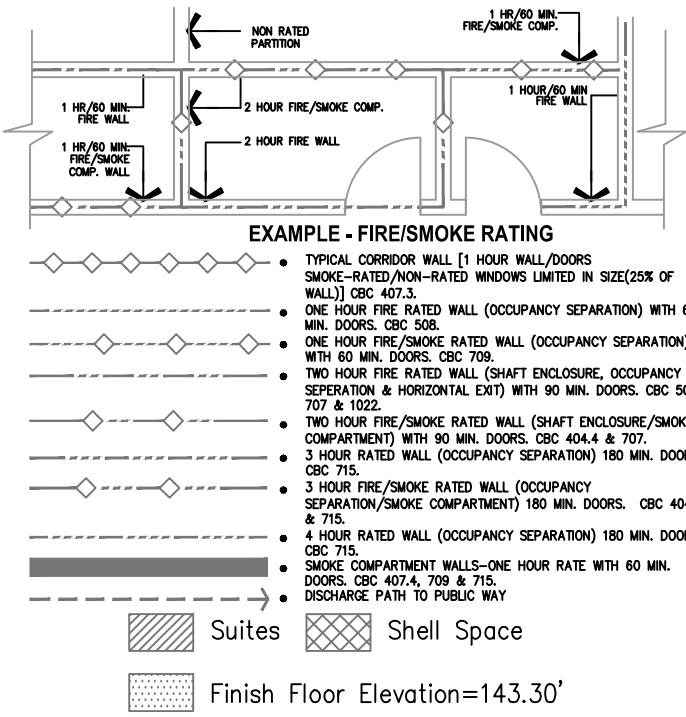

A1 Key Plan
N.T.S.

ARCHITECT OF RECORD






CONSULTANT

T M A D
TAYLOR
& GAINES

- STRUCTURAL
- MECHANICAL
- ELECTRICAL
- CIVIL

100 South Anaheim Boulevard, Suite 150
Anaheim, California 92805
Phone: 714.490.5555 Fax: 714.490.5560
Project No. 2305-163-07

REVISIONS

	02/05/10	INFORMATION BULLETIN #5
	08/28/10	A.S.I. 38
	11/22/10	CHANGE ORDER #29
	03/01/11	CHANGE ORDER #134
	12/19/11	CHANGE ORDER #294

APPROVAL

PROJECT NAME

**CHILDREN'S HOSPITAL
OF ORANGE COUNTY**
455 S. Main St.
Orange, CA 92668-3874

TOWER II



PROJECT NUMBER _____

12011.00
Increment #7

OSHPD - PROJECT NUMBER
IL 072072-30

ISSUE

OSHPD PERMIT

DATE _____

01/27/2010

SCALE


$$1/4'' = 1' - 0''$$

DRAWING TITLE

LEVEL 2 POWER PLAN
AREA - J

DRAWING NUMBER

EP3.2J

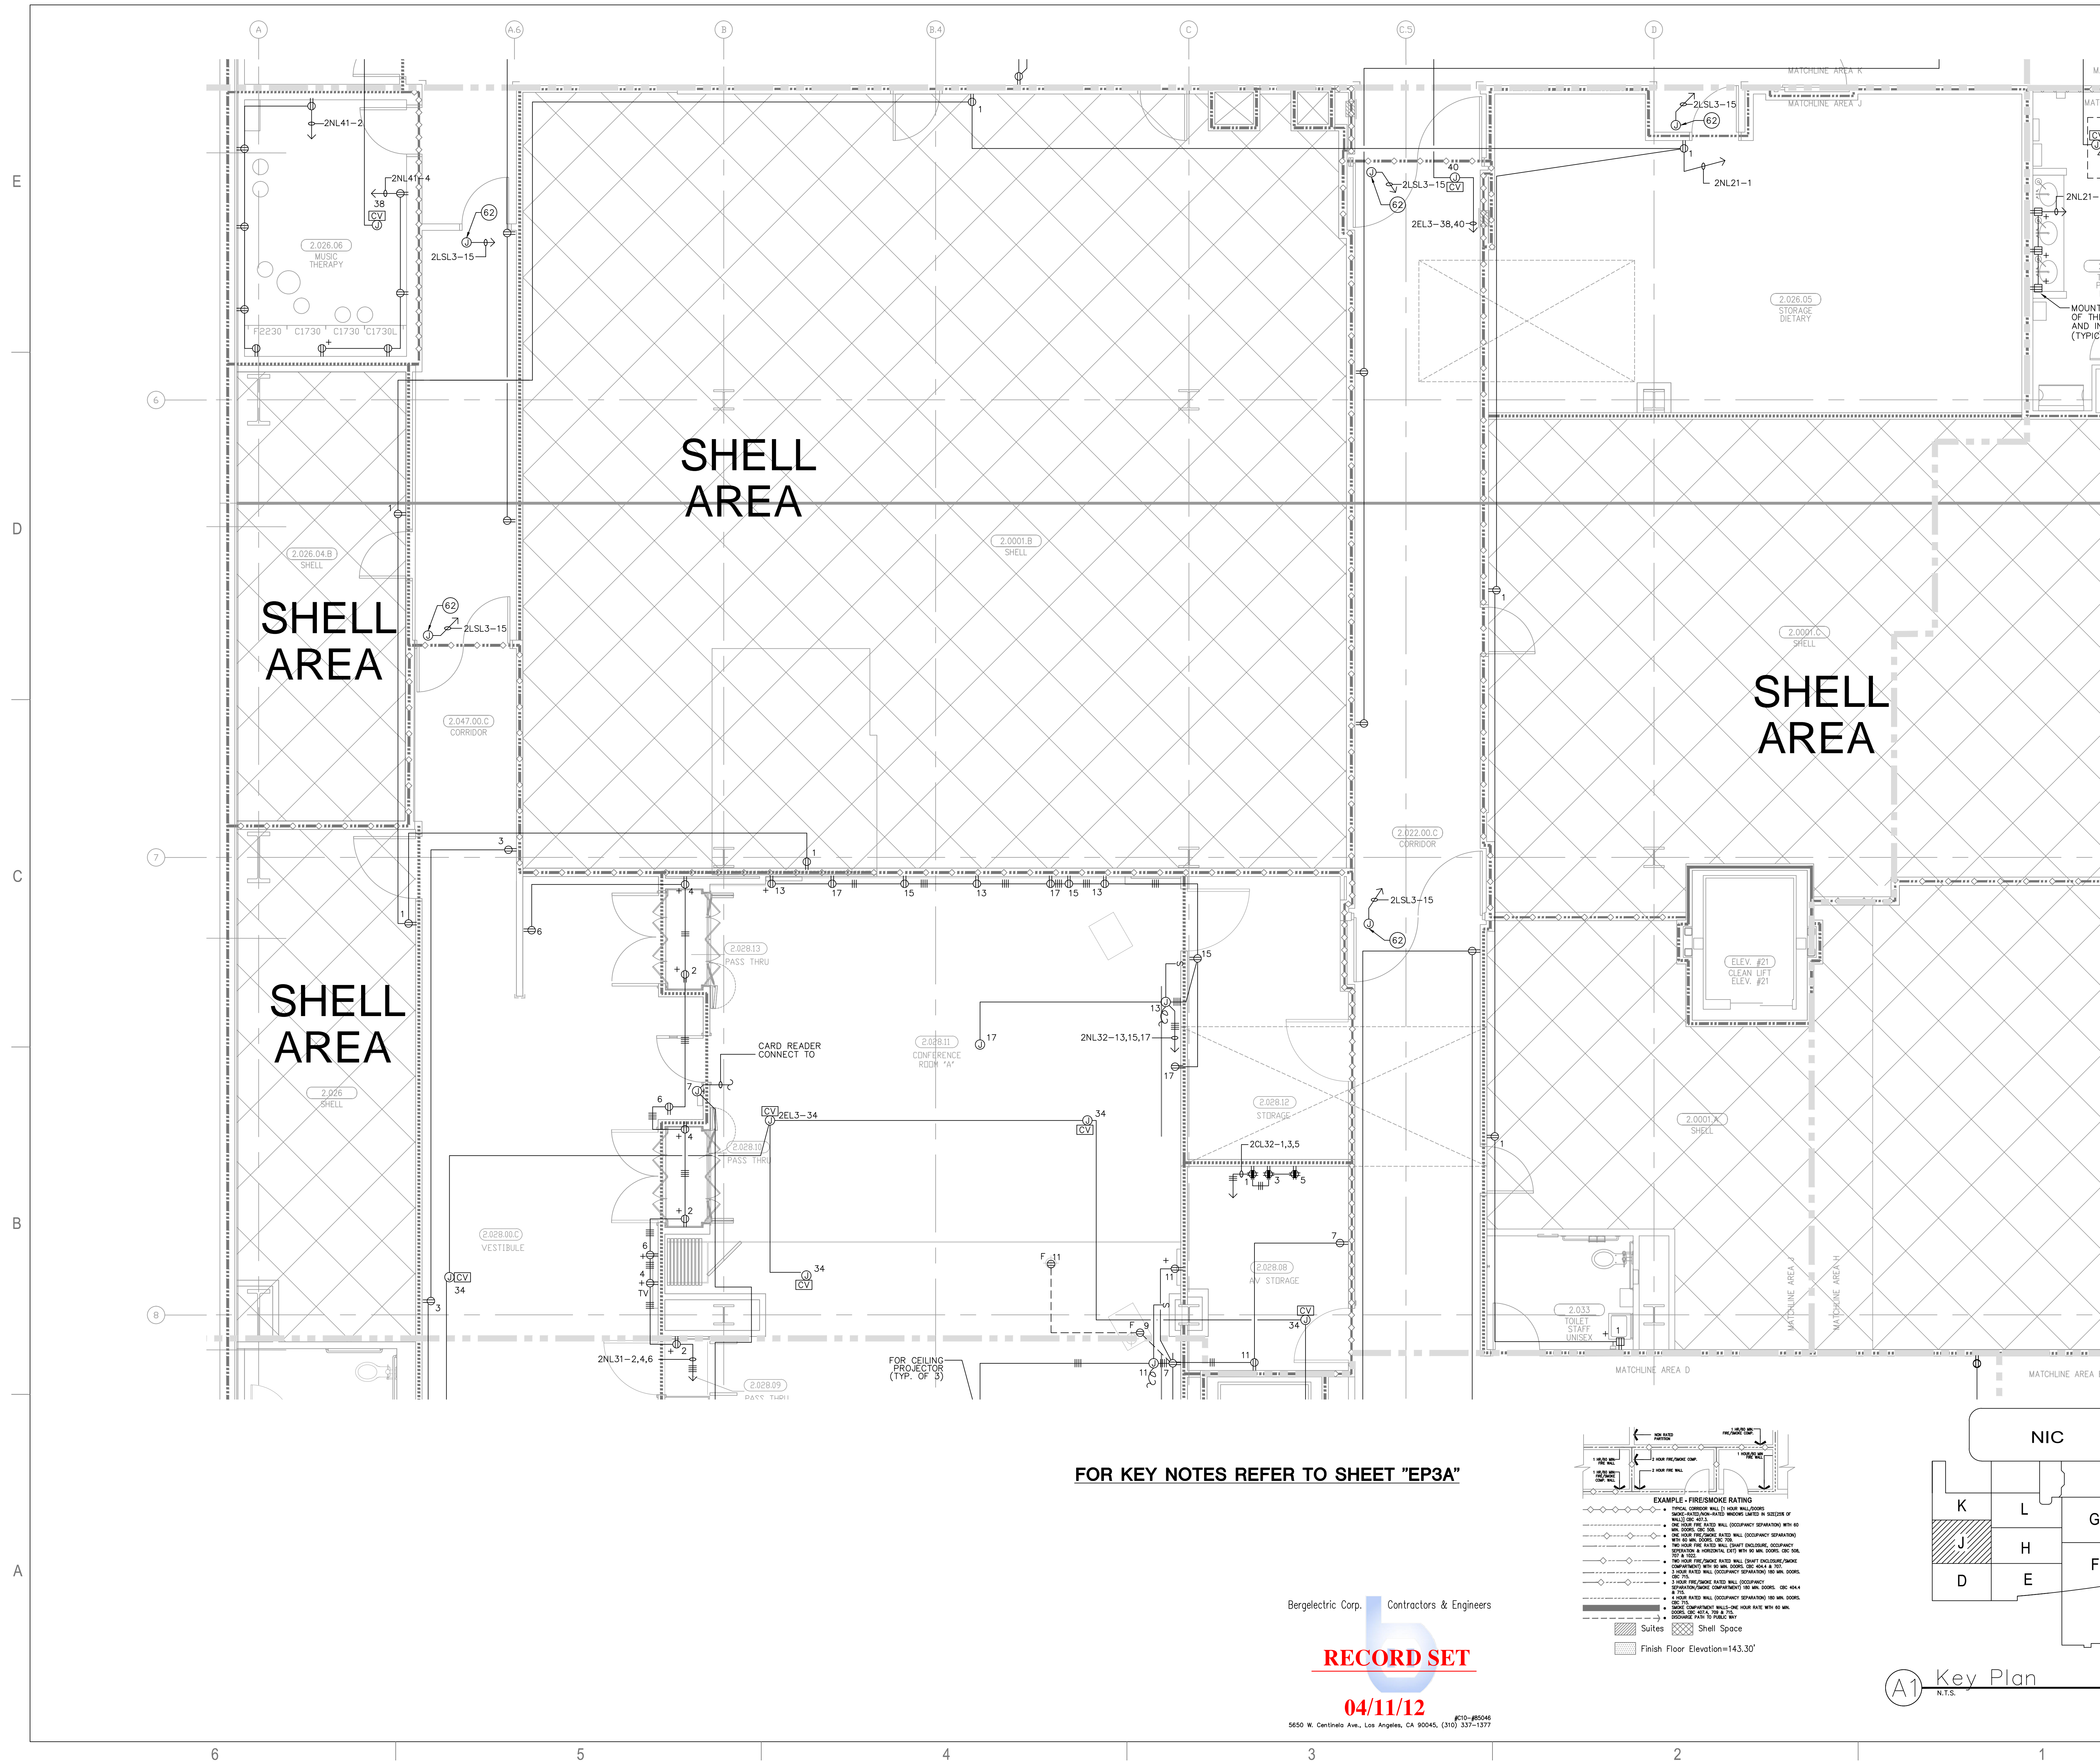


Bergelectric Corp. Contractors & Engineers

RECORD SET

04/11/12

5650 W. Centinela Ave., Los Angeles, CA 90045, (310) 337-1377

A1 Key Plan
N.T.S.

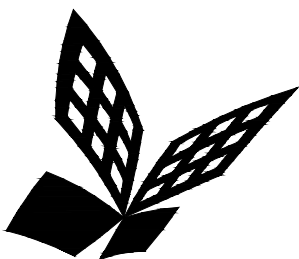

FKP Architects

ARCHITECT OF RECORD

CONSULTANT

T M A D
TAYLOR
& G AINES

- STRUCTURAL
- MECHANICAL
- ELECTRICAL
- CIVIL

100 South Anaheim Boulevard, Suite 150
Anaheim, California 92805
Phone: 714.490.5555 Fax: 714.490.5560
Project No. 2305-163-07

REVISIONS

157 03/08/11 CHANGE ORDER #130

APPROVAL

Bergelectric Corp. Contractors & Engineers

RECORD SET

04/11/12

5650 W. Centinela Ave., Los Angeles, CA 90045, (310) 337-1377

PROJECT NAME

**CHILDREN'S HOSPITAL
OF ORANGE COUNTY**
455 S. Main St.
Orange, CA 92668-3874

TOWER II



PROJECT NUMBER

**12011.00
Increment #7**

OSHPD - PROJECT NUMBER
IL 072072-30

ISSUE

OSHPD PERMIT

DATE

01/27/2010

SCALE

1/4" = 1' - 0"


DRAWING TITLE

**LEVEL 2 POWER PLAN
AREA - K**


DRAWING NUMBER

EP3.2K

FOR KEY NOTES REFER TO SHEET "EP3A"

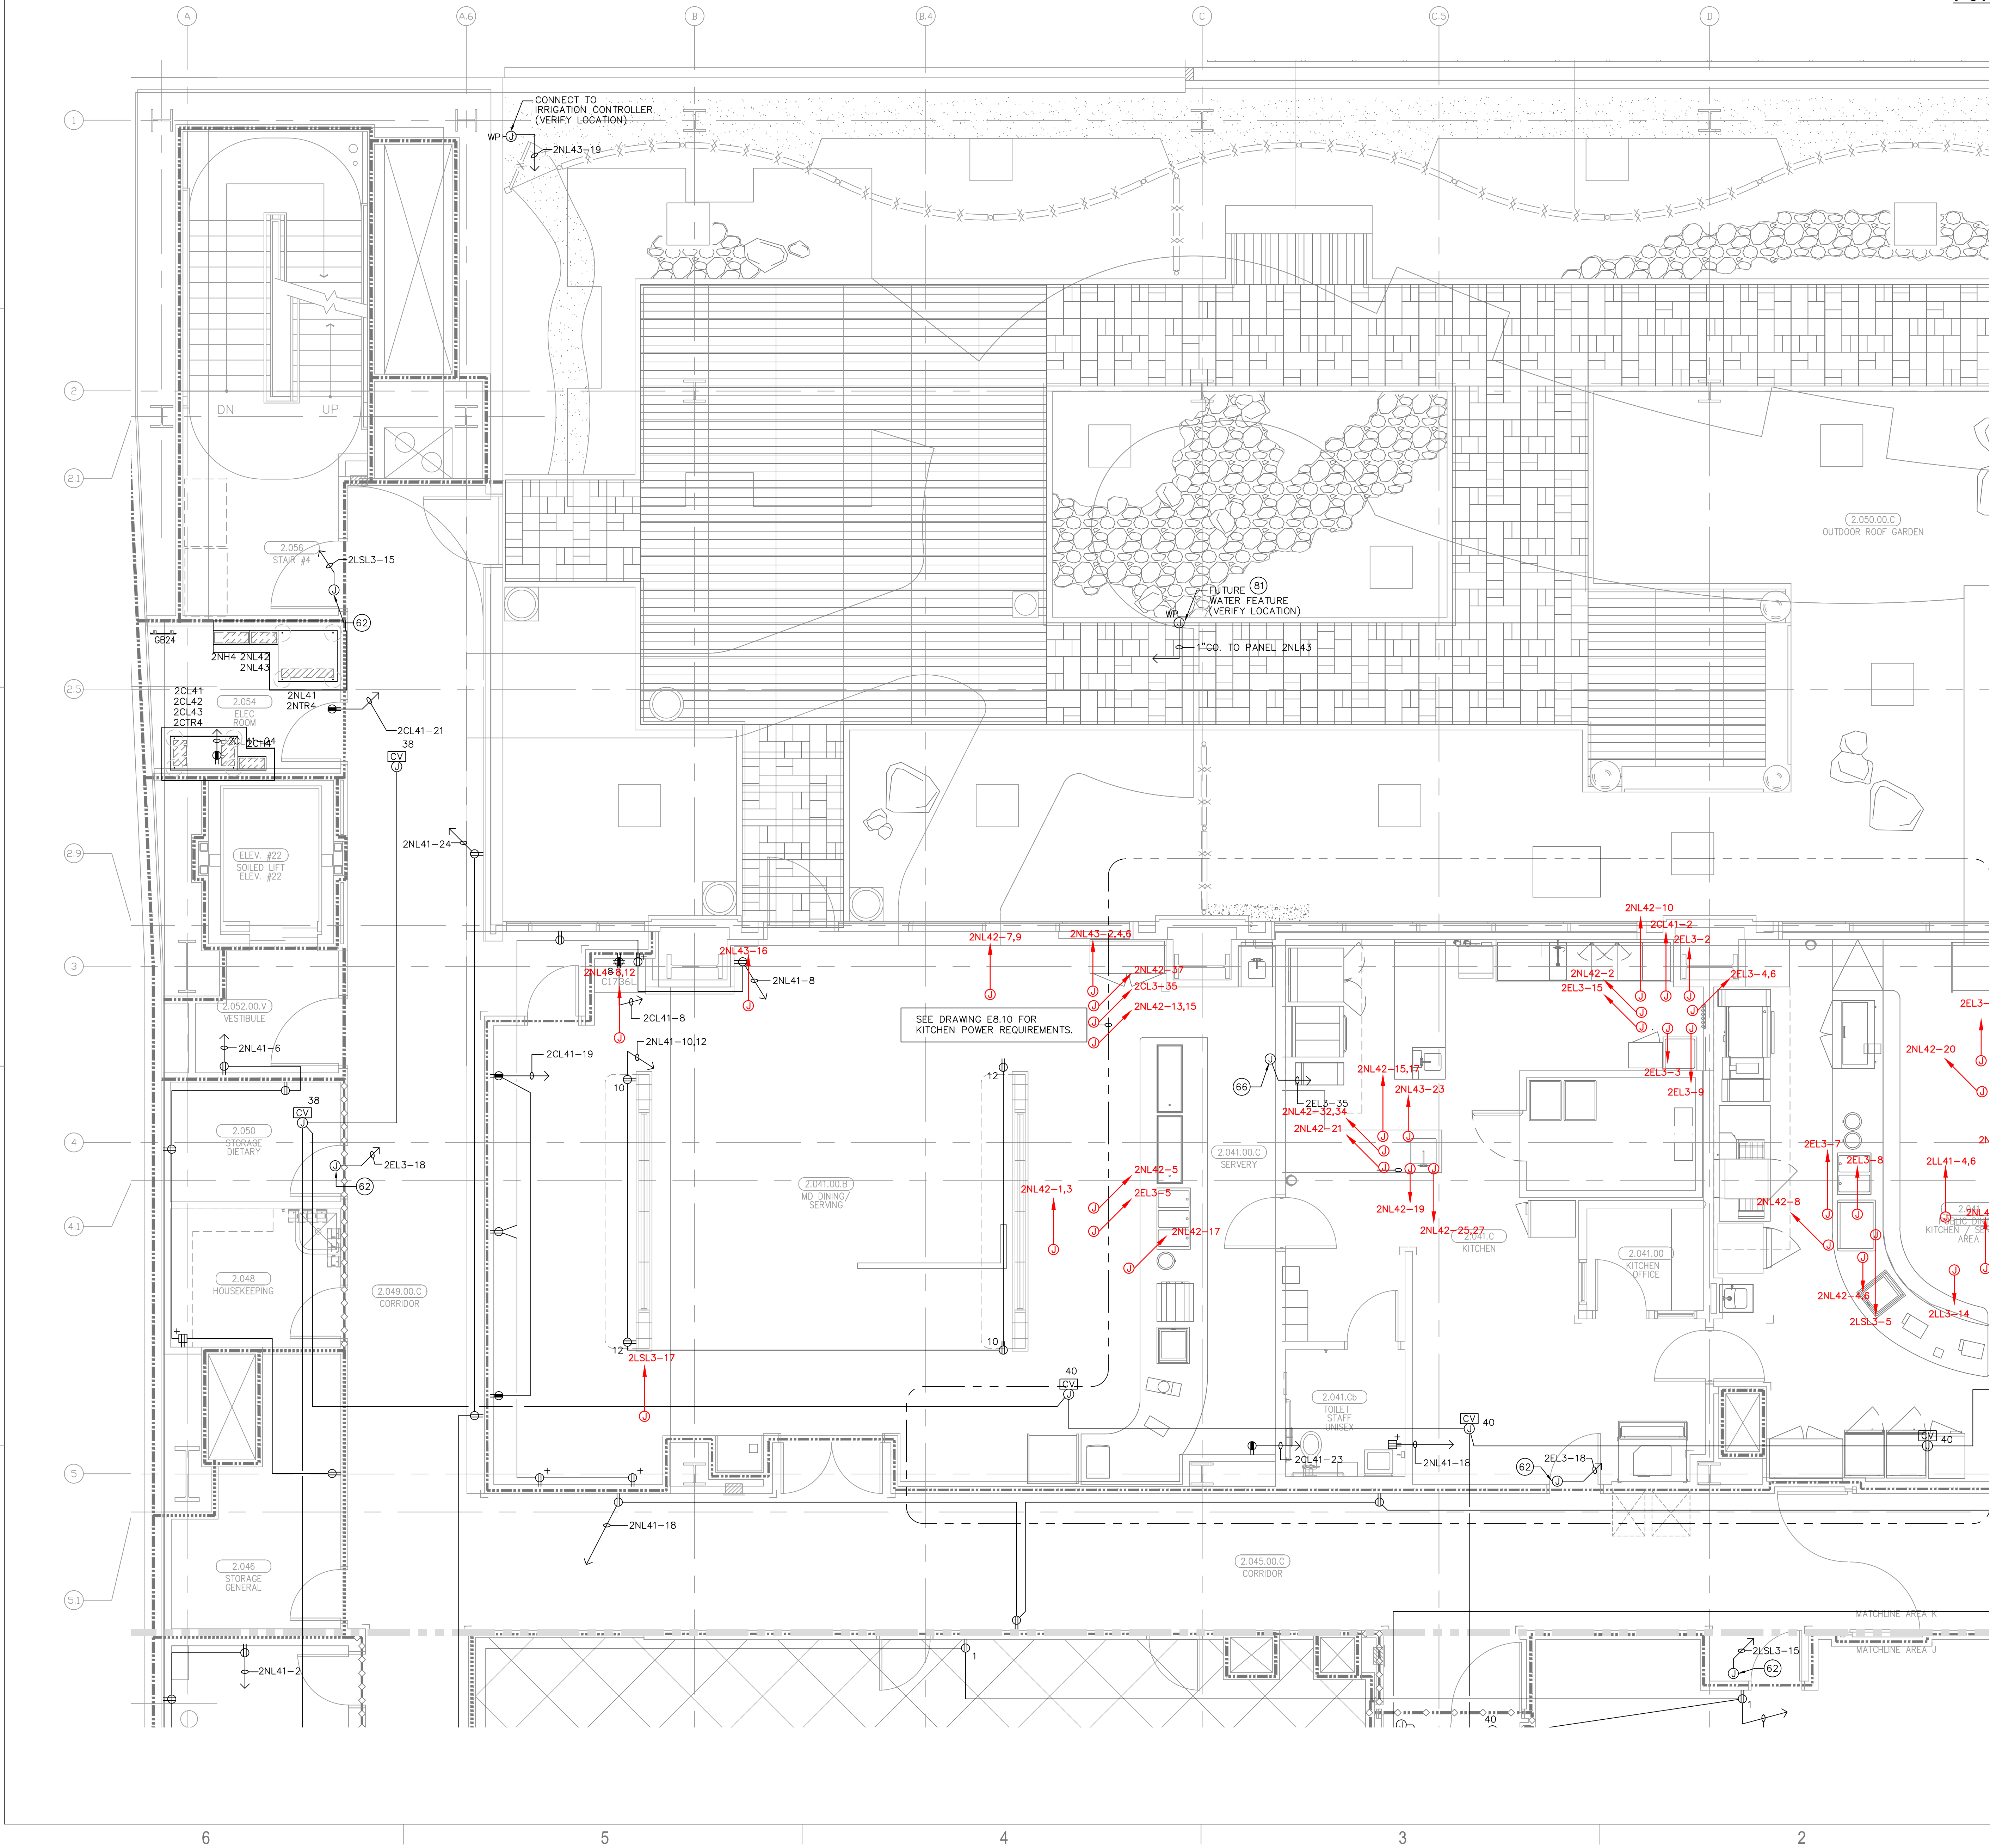

A1 Key Plan
N.T.S.

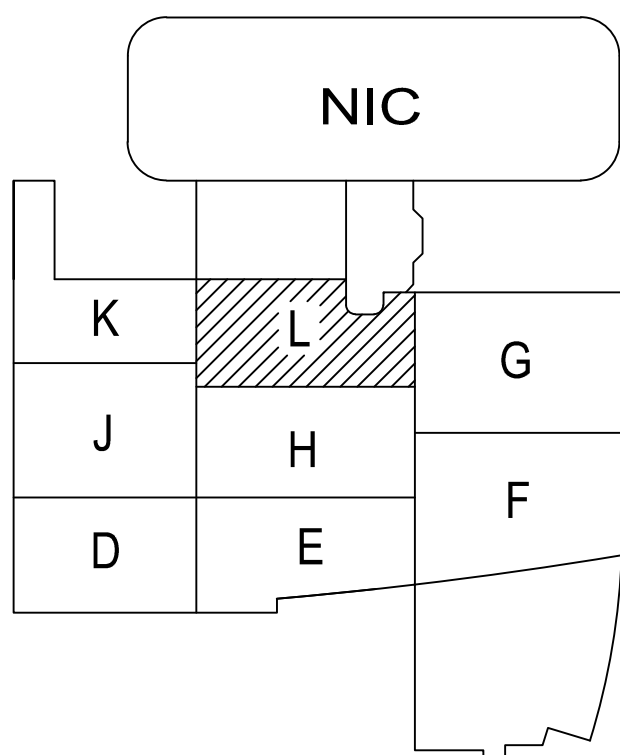


A1 Key Plan
N.T.S.

Bergelectric Corp.  Contractors & Engineer

RECORD SET

04/11/12

5650 W. Centinela Ave., Los Angeles, CA 90045, (310) 337-137

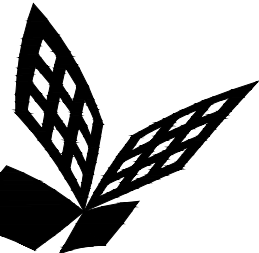

FKP Architects

ARCHITECT OF RECORD

CONSULTANT

T M A D
TAYLOR
& GAINES

STRUCTURAL
MECHANICAL
ELECTRICAL
CIVIL

100 South Anaheim Boulevard, Suite 150
Anaheim, California 92805
Phone: 714.490.5555 Fax: 714.490.5560
Project No. 2305-163-07

REVISIONS

APPROVAL

PROJECT NAME

CHILDREN'S HOSPITAL
OF ORANGE COUNTY
455 S. Main St.
Orange, CA 92868-3874

TOWER II



PROJECT NUMBER

12011.00
Increment #7

OSHPD - PROJECT NUMBER
IL 072072-30

ISSUE

OSHPD PERMIT

DATE

01/27/2010

SCALE




1/4" = 1' - 0"

DRAWING TITLE

LEVEL 2 POWER PLAN
AREA - P

DRAWING NUMBER

EP3.2P

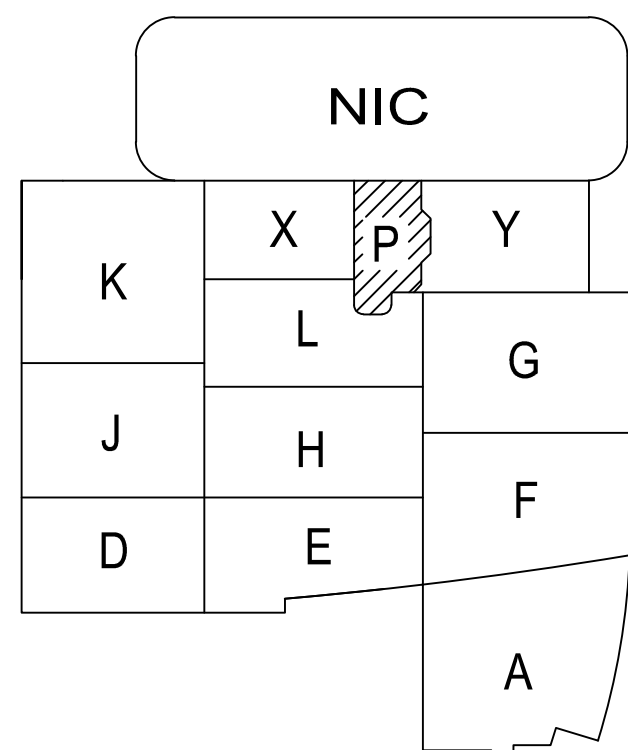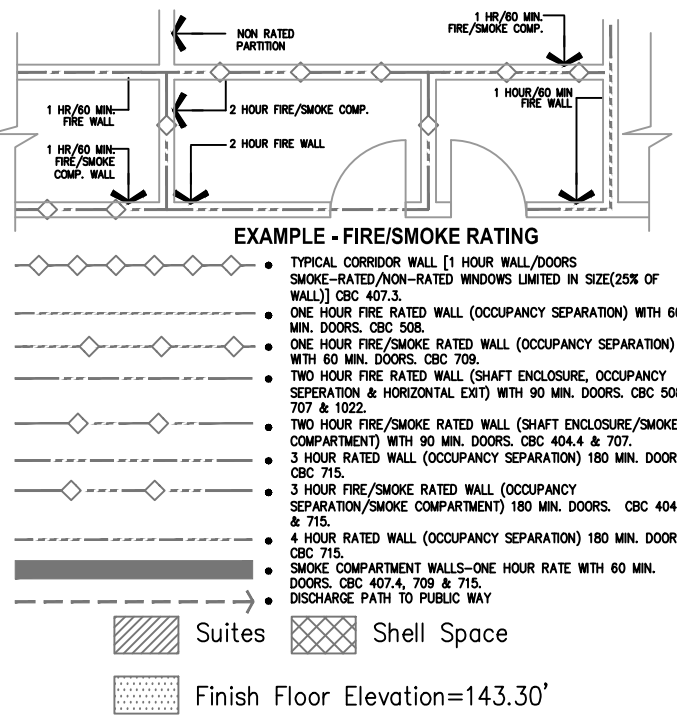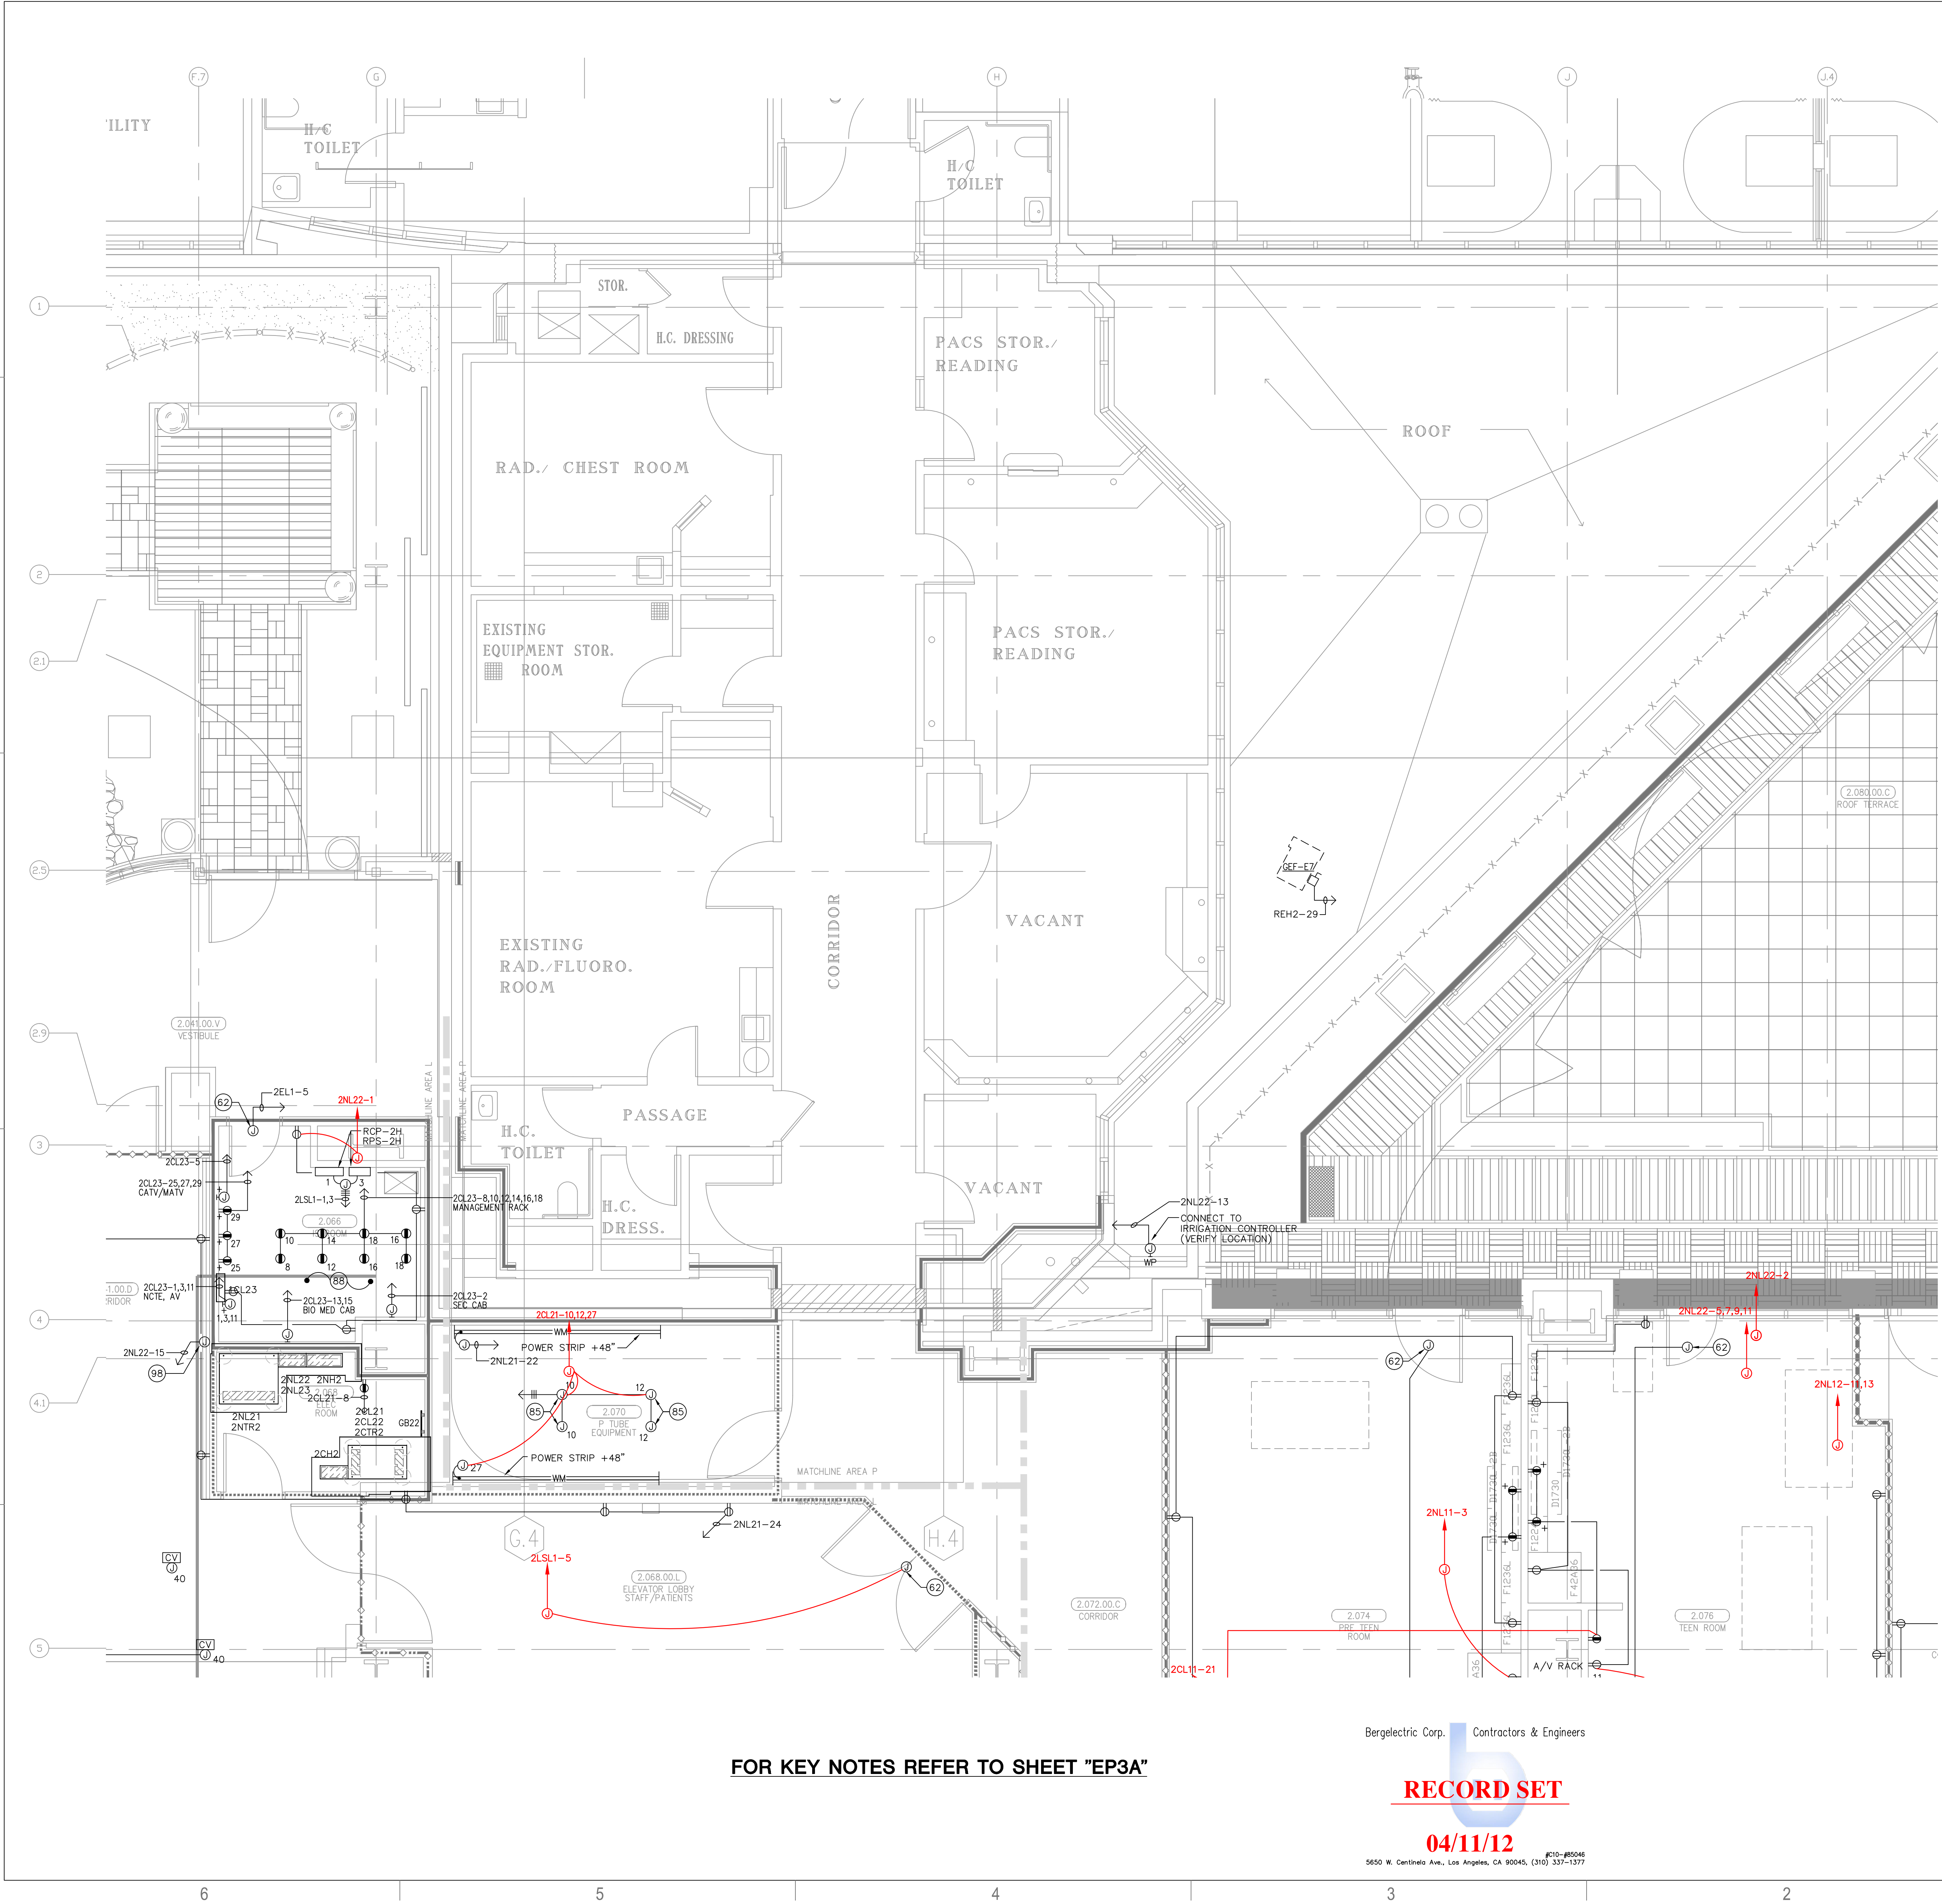

A1 Key Plan
N.T.S.

FOR KEY NOTES REFER TO SHEET "EP3A"

Bergelectric Corp. Contractors & Engineers

RECORD SET

04/11/12

#C10-#05046
5650 W. Centinela Ave., Los Angeles, CA 90045, (310) 337-1377