



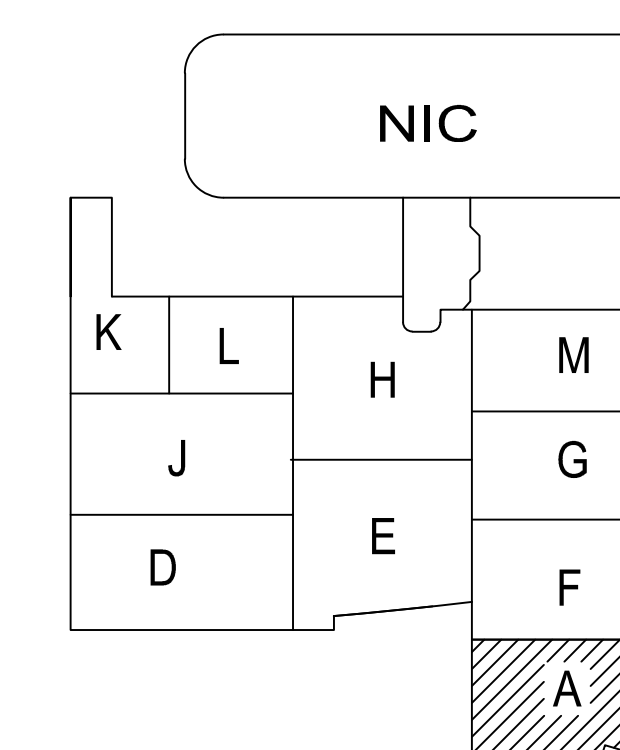

RECORD SET


04/11/12

04/11/12 #C10-85048
5650 W. Centinela Ave., Los Angeles, CA 90045. (310) 337-1377

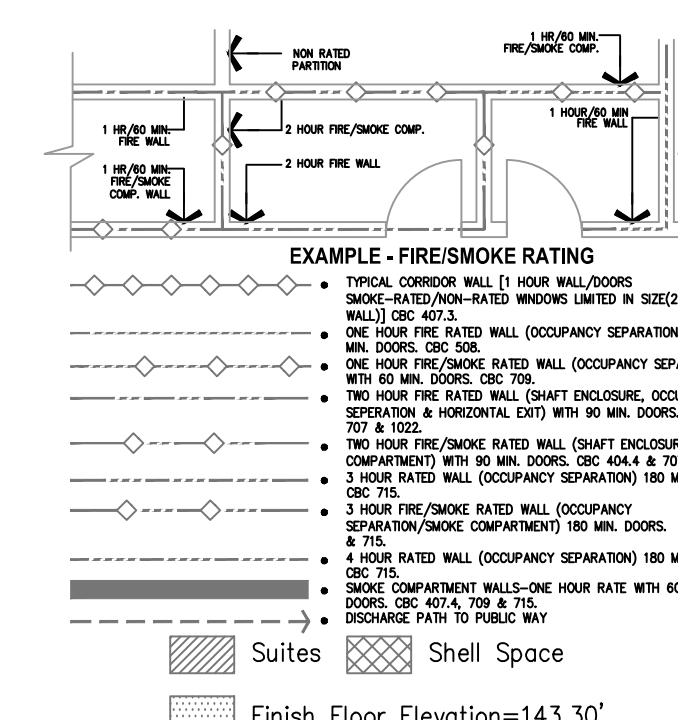

A1 Key Plan

FOR KEY NOTES REFER TO SHEET "EP3A"

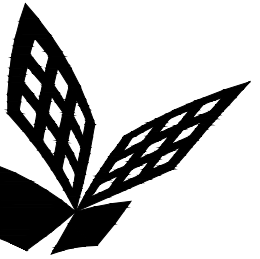

FKP Architects

ARCHITECT OF RECORD

CONSULTANT

T M A D
TAYLOR
& GAINES
100 South Anaheim Boulevard, Suite 150
Anaheim, California 92805
Phone: 714.490.5555 Fax: 714.490.5560
Project No. 2305-163-07

REVISIONS		
27	11/22/10	CHANGE ORDER #29
71	12/20/10	CHANGE ORDER #62
192	03/08/11	CHANGE ORDER #120
297	12/19/11	CHANGE ORDER #294
283	12/22/11	CHANGE ORDER #295

APPROVAL

PROJECT NAME
CHILDREN'S HOSPITAL
OF ORANGE COUNTY
455 S. Main St.
Orange, CA 92868-3874

TOWER II




PROJECT NUMBER
12011.00
Increment #7
OSHPD - PROJECT NUMBER
IL 072072-30

ISSUE
OSHPD PERMIT
DATE
01/27/2010
SCALE

1/4" = 1' - 0"
DRAWING TITLE
LEVEL 3 POWER PLAN
AREA - D

DRAWING NUMBER

EP3.3D

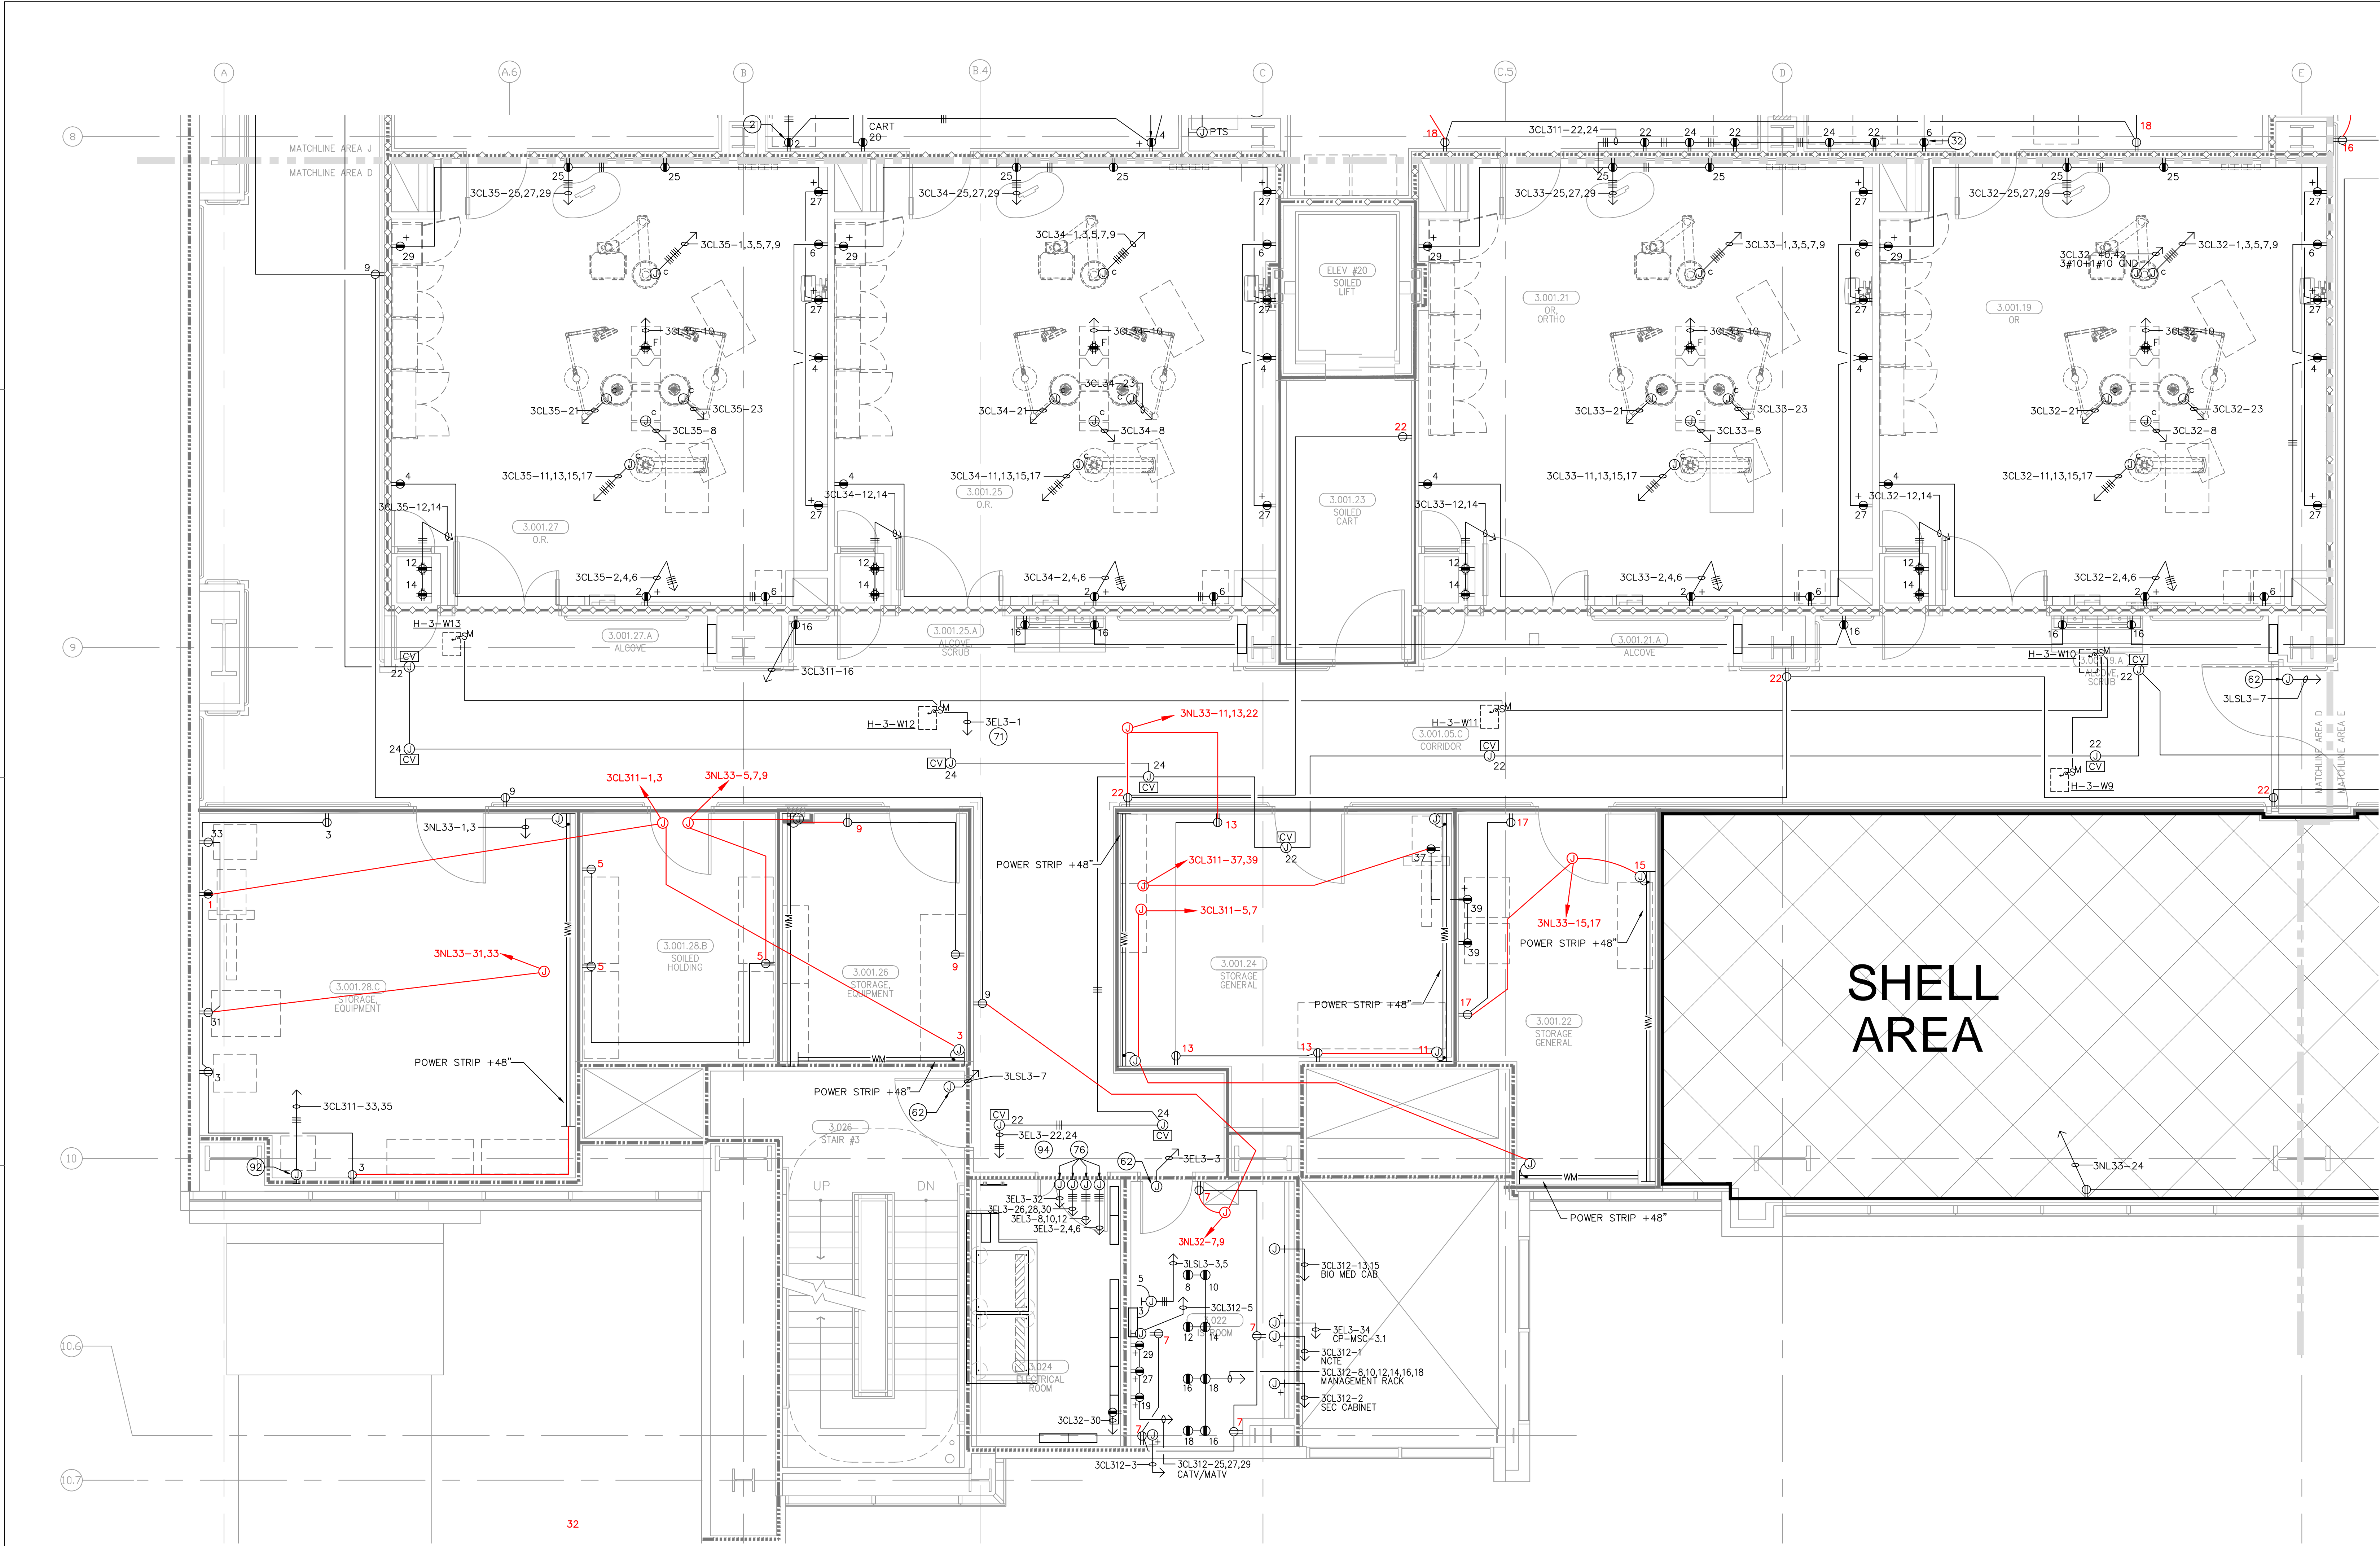



FOR KEY NOTES REFER TO SHEET "EP3A"

Bergelectric Corp. Contractors & Engineers


RECORD SET

04/11/12

6560 W. Centinela Ave., Los Angeles, CA 90045, (310) 337-1377

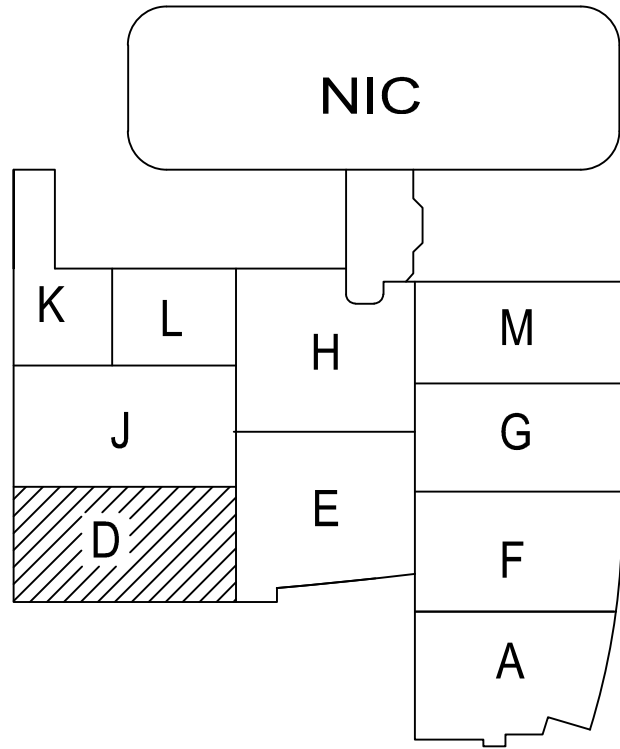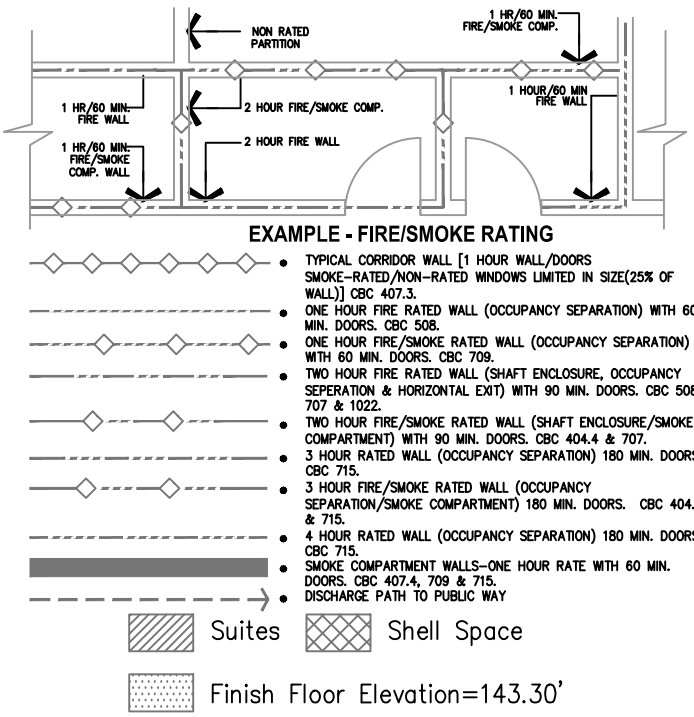

A1 Key Plan
N.T.S.

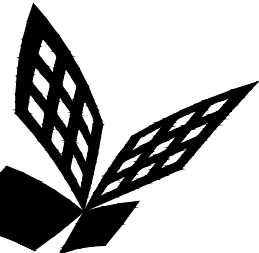

FKP Architects

ARCHITECT OF RECORD

CONSULTANT

T M A D
TAYLOR
& GAINES

100 South Anaheim Boulevard, Suite 150
Anaheim, California 92805
Phone: 714.490.5555 Fax: 714.490.5560
Project No. 2305-163-07

• STRUCTURAL
• MECHANICAL
• ELECTRICAL
• CIVIL

REVISIONS		
27	11/08/10	CHANGE ORDER #29
21	12/20/10	CHANGE ORDER #62
85	12/19/11	CHANGE ORDER #271
80	03/19/12	CHANGE ORDER #281

APPROVAL

Bergelectric Corp. Contractors & Engineers

RECORD SET

04/11/12

5850 W. Centinela Ave., Los Angeles, CA 90045, (310) 337-1377

PROJECT NAME

**CHILDREN'S HOSPITAL
OF ORANGE COUNTY**
455 S. Main St.
Orange, CA 92868-3874

TOWER II



PROJECT NUMBER

**12011.00
Increment #7**

OSHPD - PROJECT NUMBER
IL 072072-30

ISSUE

OSHPD PERMIT

DATE

01/27/2010

SCALE

1/4" = 1' - 0"


DRAWING TITLE


**LEVEL 3 POWER PLAN
AREA - E**

DRAWING NUMBER

EP3.3E

FOR KEY NOTES REFER TO SHEET "EP3A"

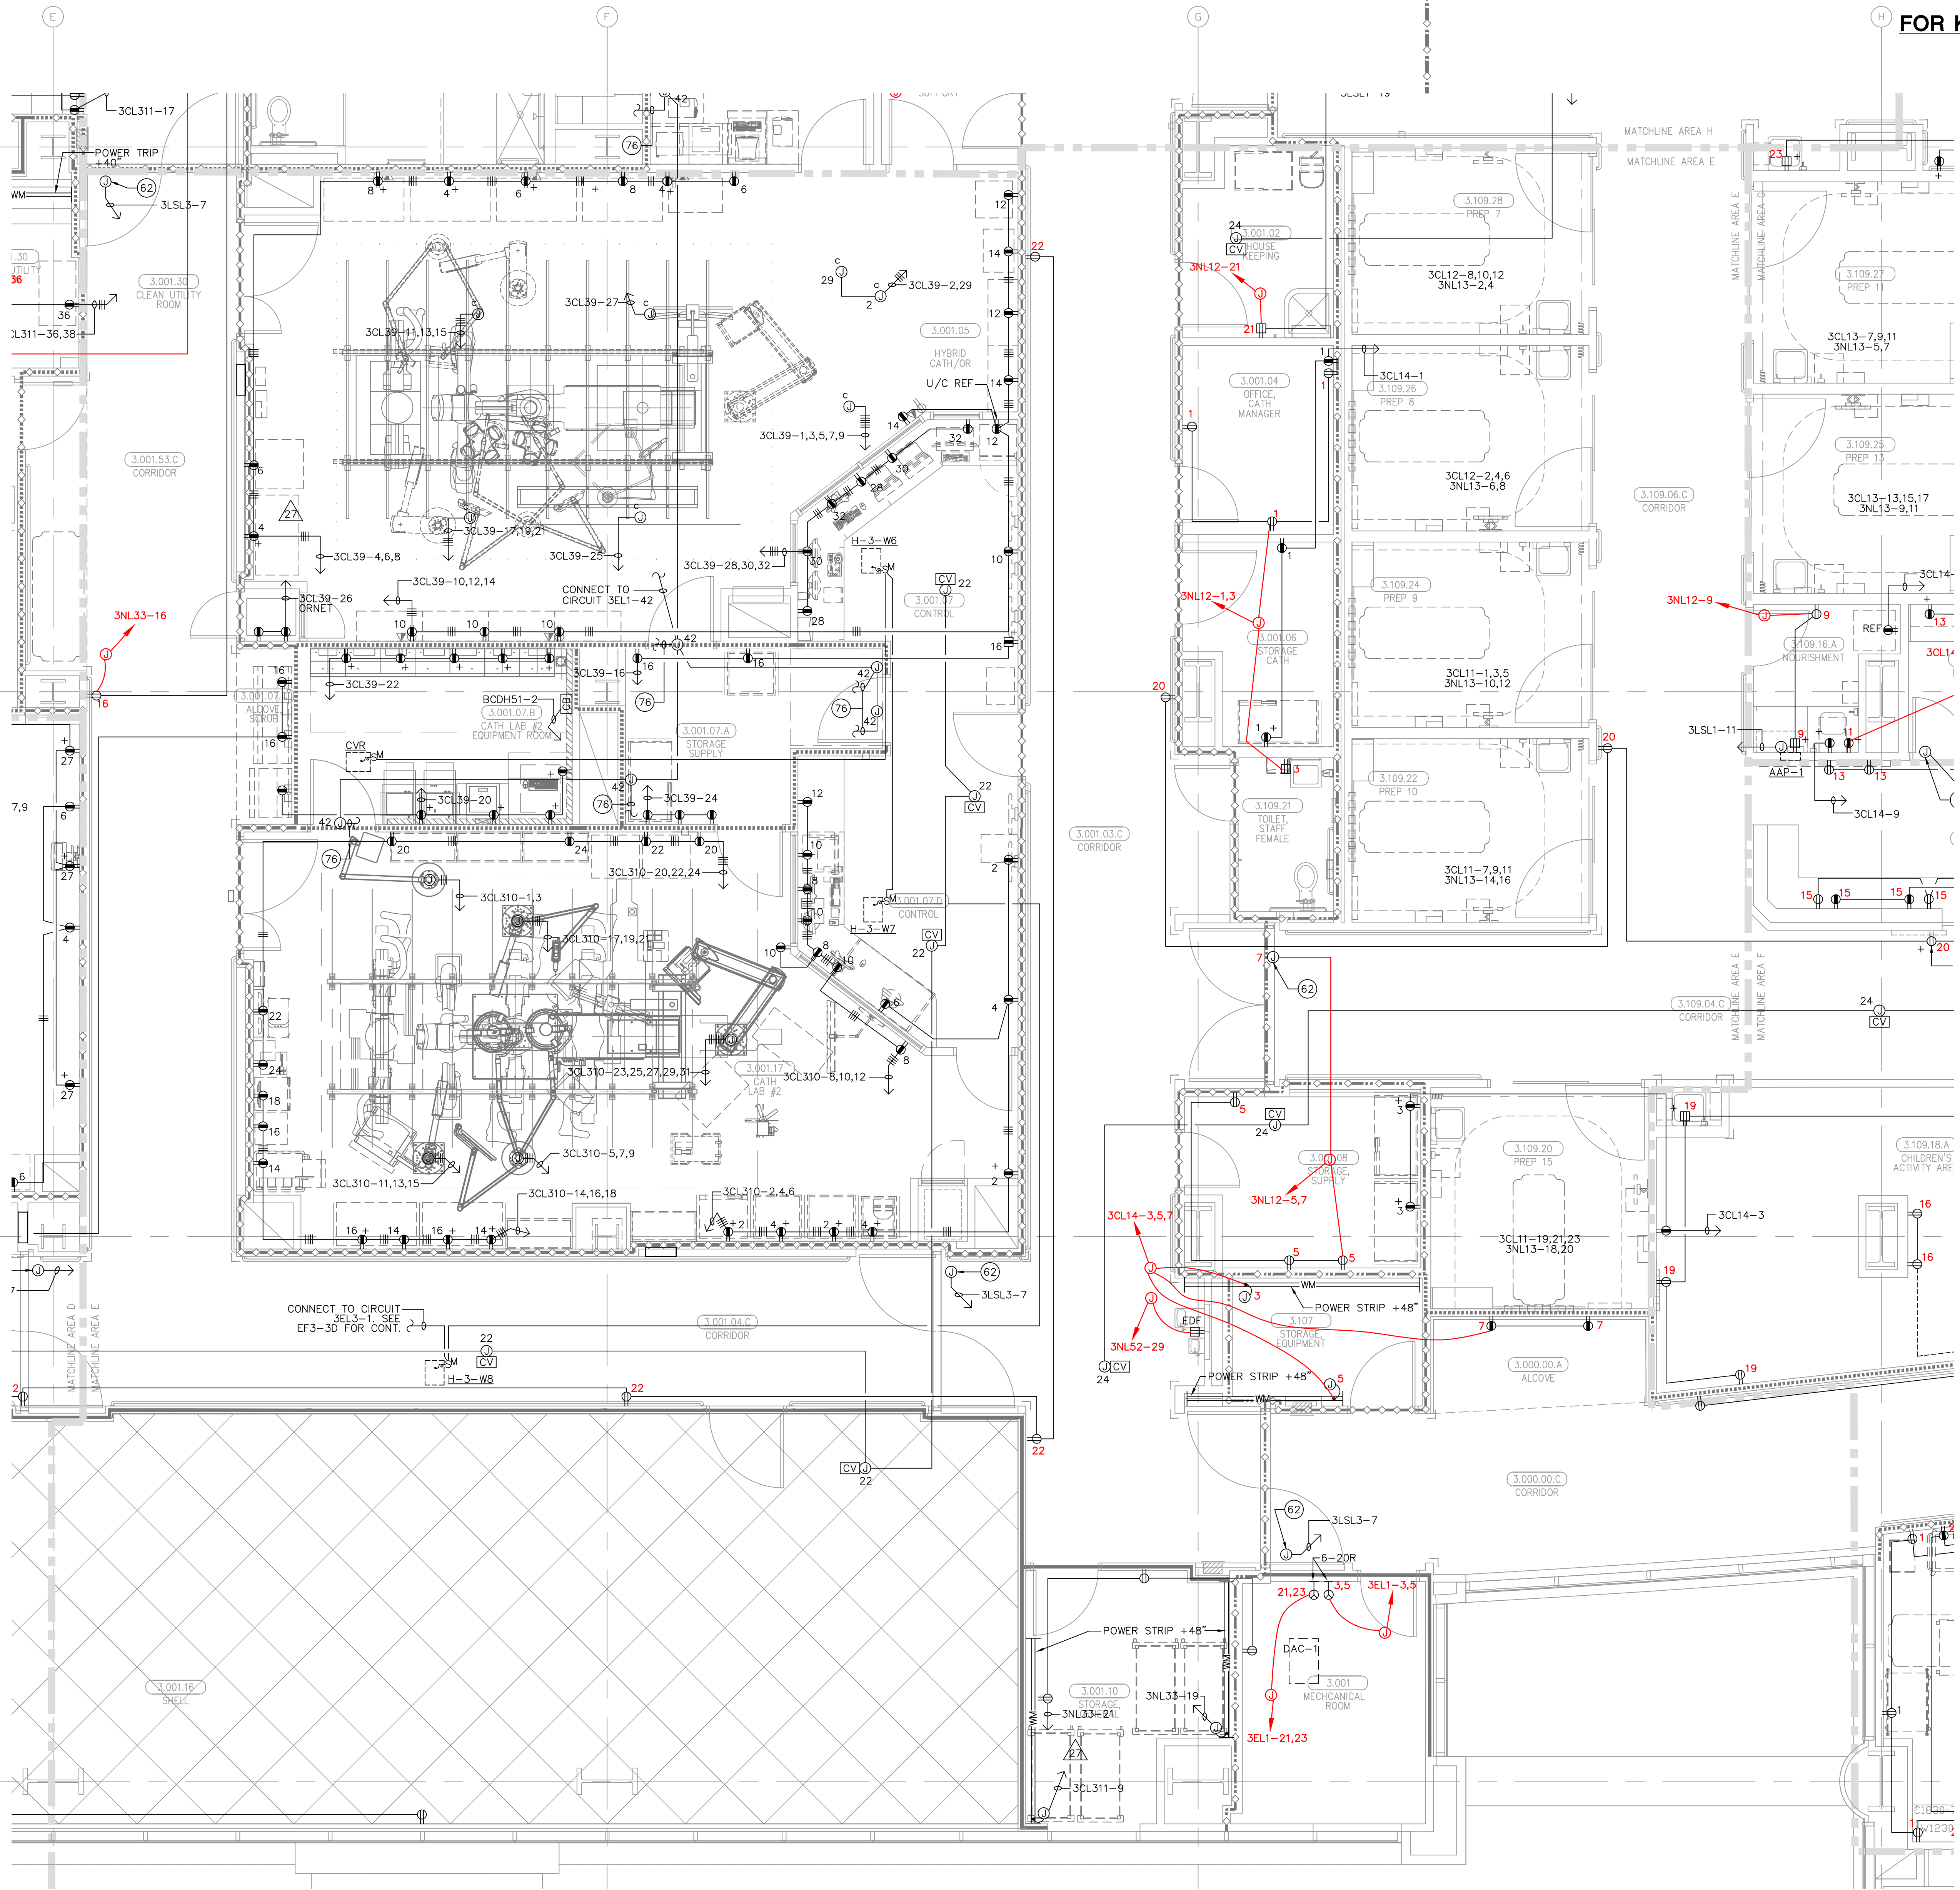

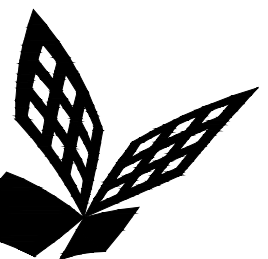

FKP Architects

ARCHITECT OF RECORD

CONSULTANT

T M A D
TAYLOR
& G AINES
100 South Anaheim Boulevard, Suite 150
Anaheim, California 92805
Phone: 714.490.5555 Fax: 714.490.5560
Project No. 2305-163-07

REVISIONS

03/28/10 CHANGE ORDER #161
12/19/11 CHANGE ORDER #299

APPROVAL

PROJECT NAME

CHILDREN'S HOSPITAL
OF ORANGE COUNTY
455 S. Main St.
Orange, CA 92868-3874

TOWER II



PROJECT NUMBER

12011.00
Increment #7

OSHPD - PROJECT NUMBER
IL 072072-30

ISSUE

OSHPD PERMIT

DATE

01/27/2010

SCALE

1/4" = 1' - 0"

DRAWING TITLE

LEVEL 3 POWER PLAN
AREA - F

DRAWING NUMBER

EP3.3F



FOR KEY NOTES REFER TO SHEET "EP3A"

Bergelectric Corp. Contractors & Engineers


RECORD SET

04/11/12

5650 W. Centinela Ave., Los Angeles, CA 90045, (310) 337-1377

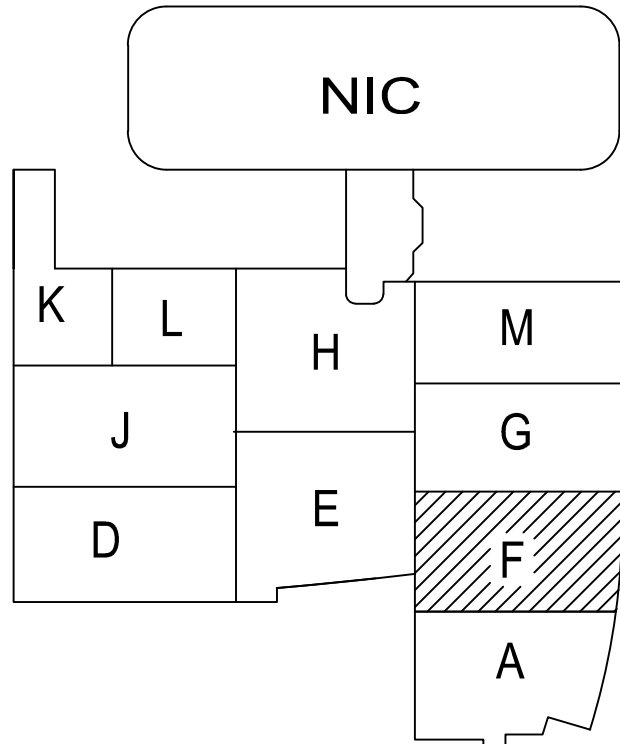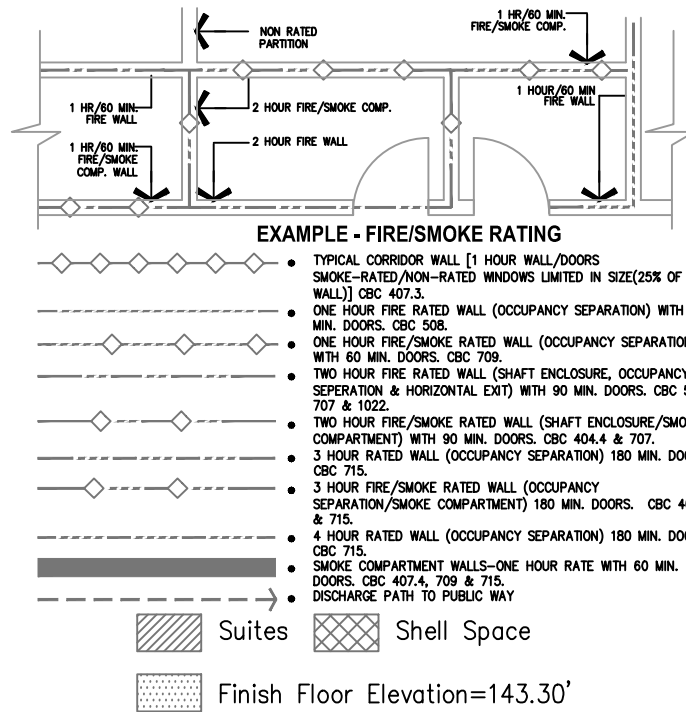

A1 Key Plan
N.T.S.

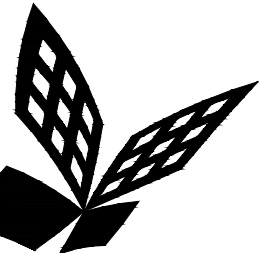

FKP Architects

ARCHITECT OF RECORD

CONSULTANT

T M A D
TAYLOR
& G AINES

- STRUCTURAL
- MECHANICAL
- ELECTRICAL
- CIVIL

100 South Anaheim Boulevard, Suite 150
Anaheim, California 92805
Phone: 714.490.5555 Fax: 714.490.5560
Project No. 2305-163-07

REVISIONS

27	11/22/10	CHANGE ORDER #29
15A	03/08/11	CHANGE ORDER #130
22A	09/26/11	ASI #109

APPROVAL

PROJECT NAME

**CHILDREN'S HOSPITAL
OF ORANGE COUNTY**
455 S. Main St.
Orange, CA 92668-3874

TOWER II



PROJECT NUMBER

**12011.00
Increment #7**

OSHPD - PROJECT NUMBER
IL 072072-30

ISSUE

OSHPD PERMIT

DATE

01/27/2010

SCALE

1/4" = 1' - 0"

DRAWING TITLE

**LEVEL 3 POWER PLAN
AREA - G**

DRAWING NUMBER

EP3.3G



FOR KEY NOTES REFER TO SHEET "EP3A"

Belectric Corp. Contractors & Engineers

RECORD SET

04/11/12

5650 W. Centinela Ave., Los Angeles, CA 90045, (310) 337-1377

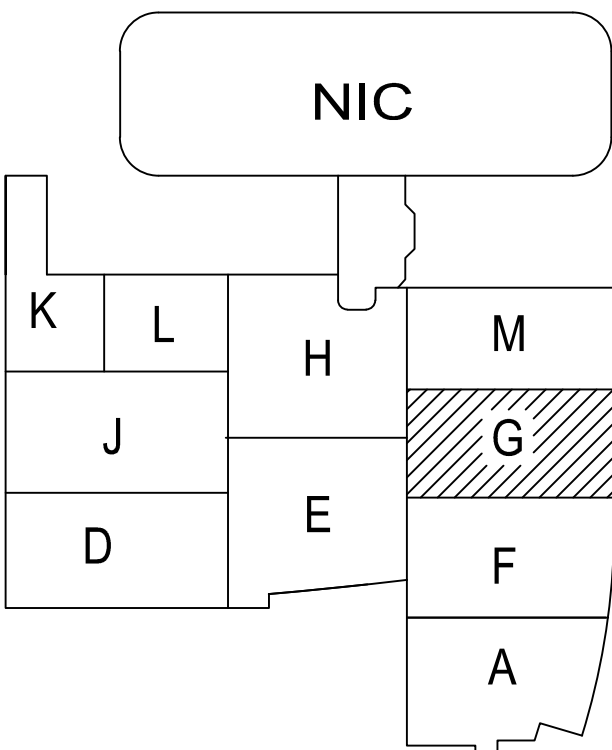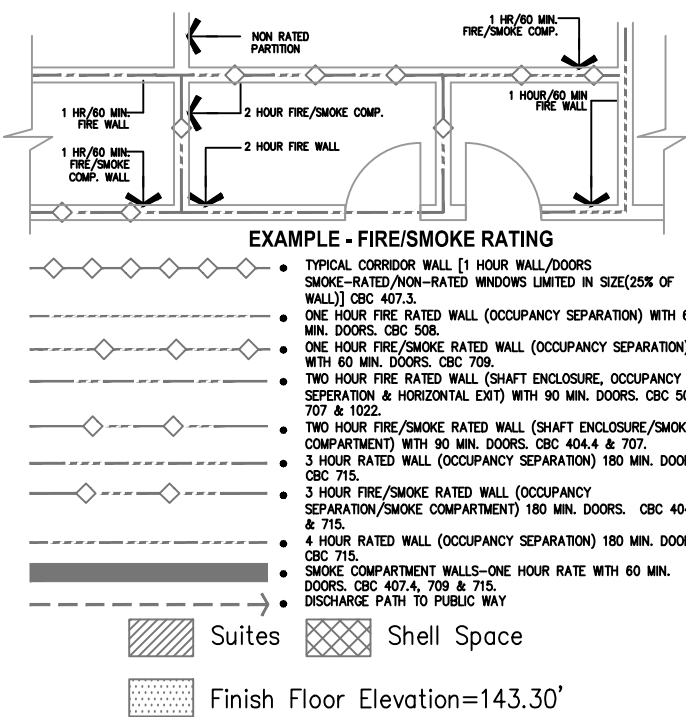

A1 Key Plan
N.T.S.



ARCHITECT OF RECORD






CONSULTANT

T M A D
TAYLOR
& GAINES

- STRUCTURAL
- MECHANICAL
- ELECTRICAL
- CIVIL

100 South Anaheim Boulevard, Suite 150
Anaheim, California 92805
Phone: 714.490.5555 Fax: 714.490.5560
Project No. 2305-163-07

REVISIONS

	10/15/10	CHANGE ORDER #93
	11/22/10	CHANGE ORDER #29
	12/20/10	CHANGE ORDER #62
	03/08/11	CHANGE ORDER #12
	09/12/11	CHANGE ORDER #26
	12/22/11	CHANGE ORDER #29

APPROVAL

PROJECT NAME
CHILDREN'S HOSPITAL
OF ORANGE COUNTY
455 S. Main St.
Orange, CA 92868-3874

TOWER II



PROJECT NUMBER

12011.00
Increment #7

OSHPD - PROJECT NUMBER
IL 072072-30

ISSUE

OSHPD PERMIT

DATE _____

01/27/2010

SCAL


$$1/4'' = 1' - 0''$$


DRAWING TITLE


LEVEL 3 POWER PLAN
AREA - J

DRAWING NUMBER

EP3.3J

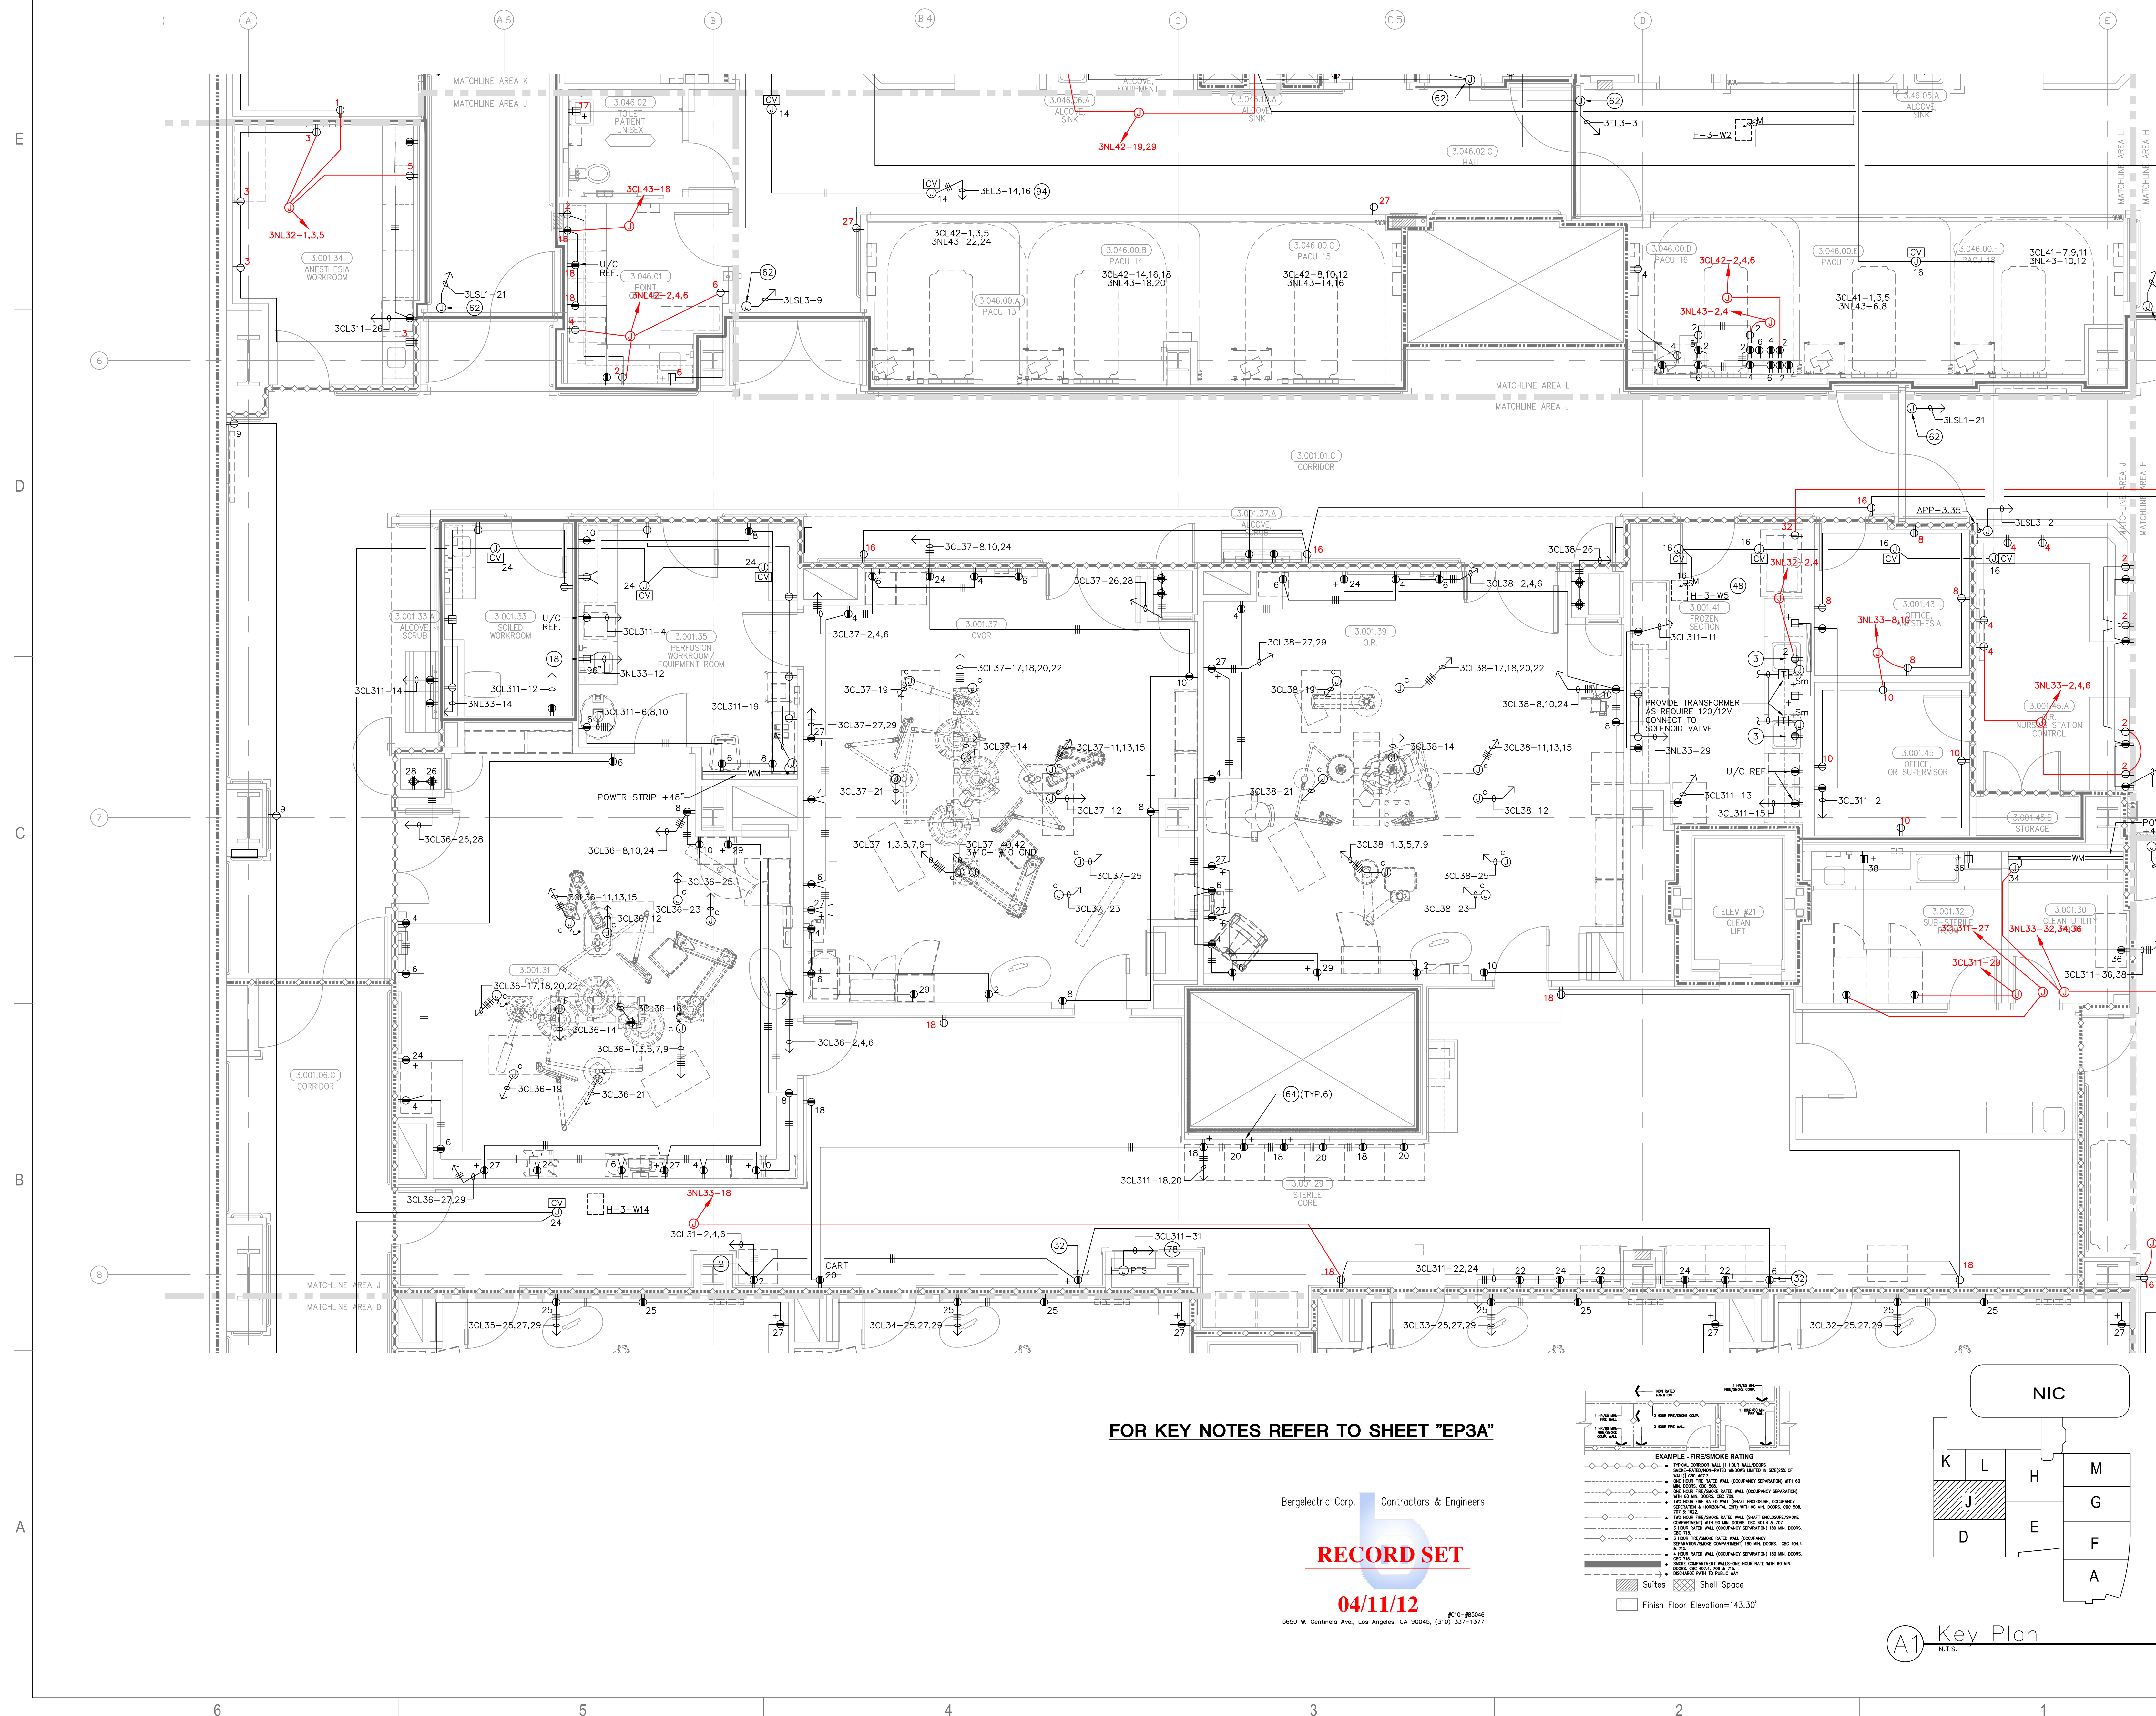

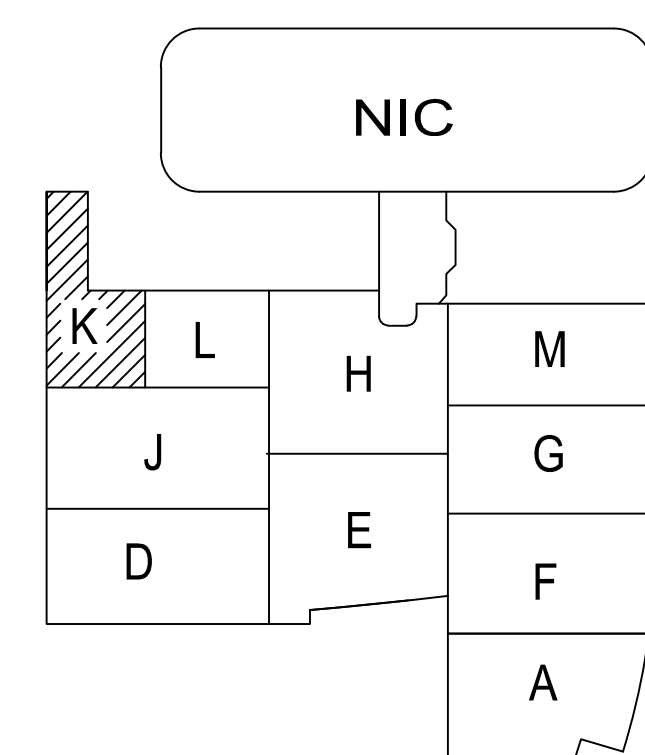

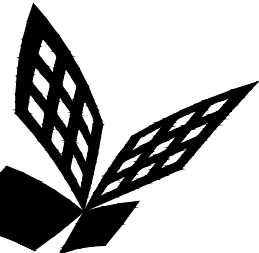

FKP Architects

ARCHITECT OF RECORD

CONSULTANT

T M A D
TAYLOR
& GAINES

- STRUCTURAL
- MECHANICAL
- ELECTRICAL
- CIVIL

100 South Anaheim Boulevard, Suite 150
Anaheim, California 92805
Phone: 714.490.5555 Fax: 714.490.5560
Project No. 2305-163-07

REVISIONS

12/19/11 CHANGE ORDER #294

APPROVAL

PROJECT NAME

**CHILDREN'S HOSPITAL
OF ORANGE COUNTY**
455 S. Main St.
Orange, CA 92868-3874

TOWER II



PROJECT NUMBER

**12011.00
Increment #7**

OSHPD - PROJECT NUMBER

IL 072072-30

ISSUE

OSHPD PERMIT

DATE

01/27/2010

SCALE


1/4" = 1' - 0"

DRAWING TITLE



**LEVEL 3 POWER PLAN
AREA - L**

DRAWING NUMBER

EP3.3L

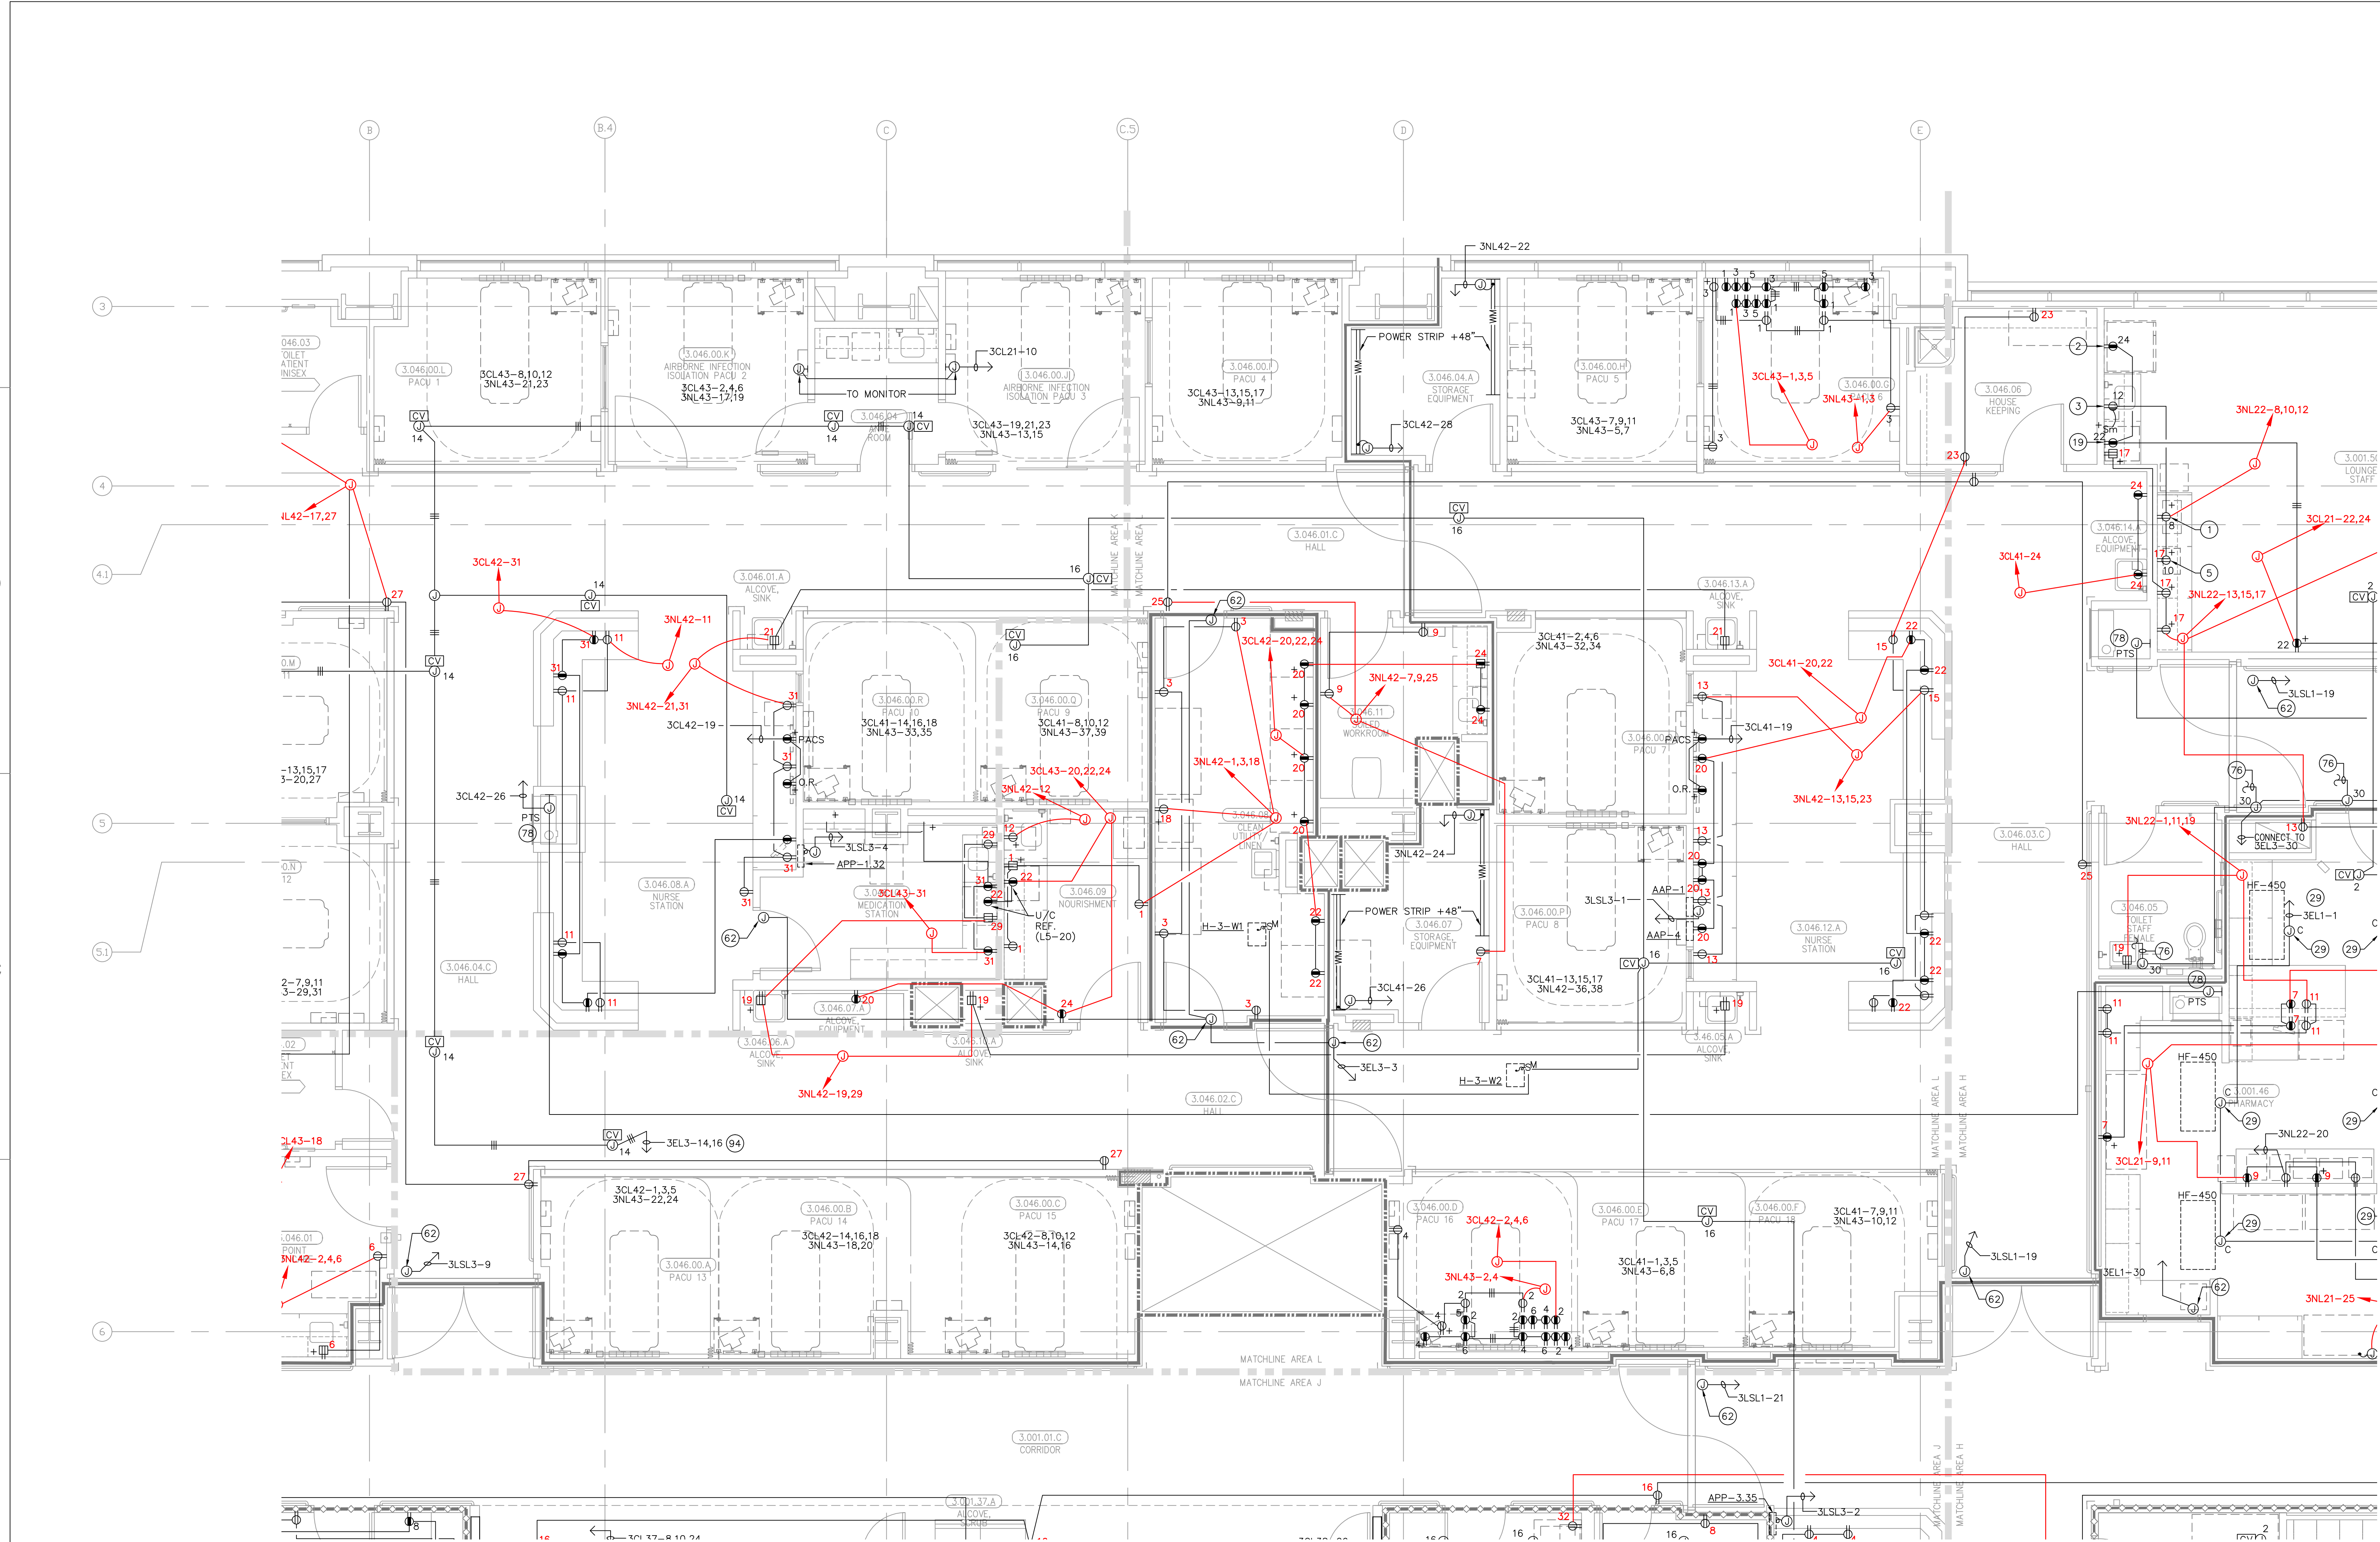

FOR KEY NOTES REFER TO SHEET "EP3A"

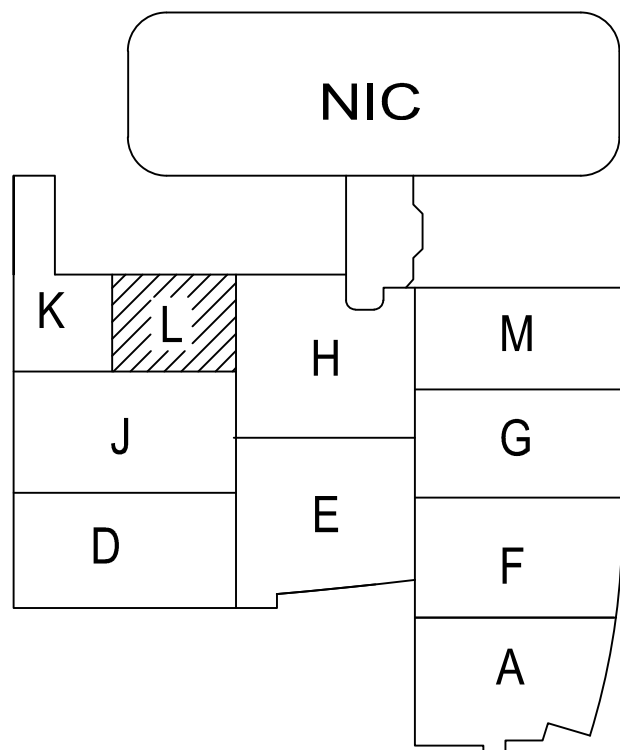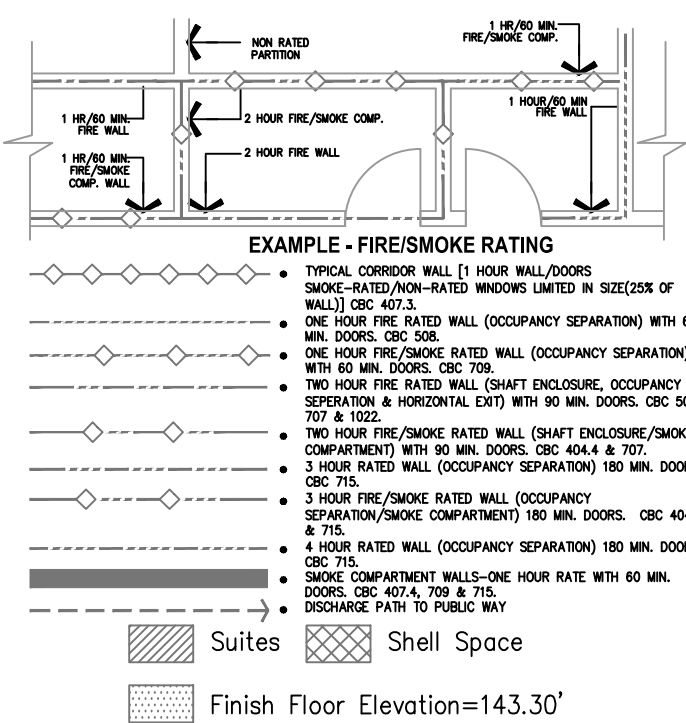

Bergelectric Corp. Contractors & Engineers



RECORD SET

04/11/12

5650 W. Centinella Ave., Los Angeles, CA 90045, (310) 337-1377

Key Plan
N.T.S.

5650 W. Centinela Ave., Los Angeles, CA 90045, (310) 337-1377

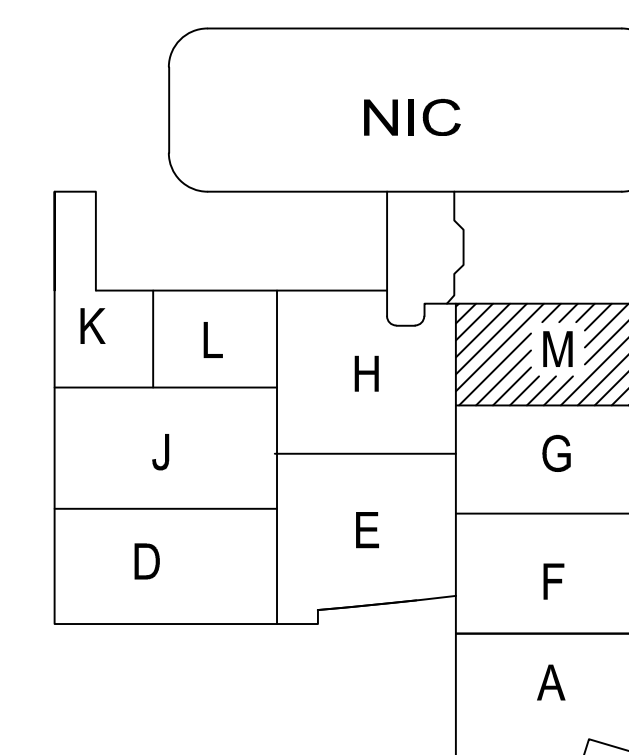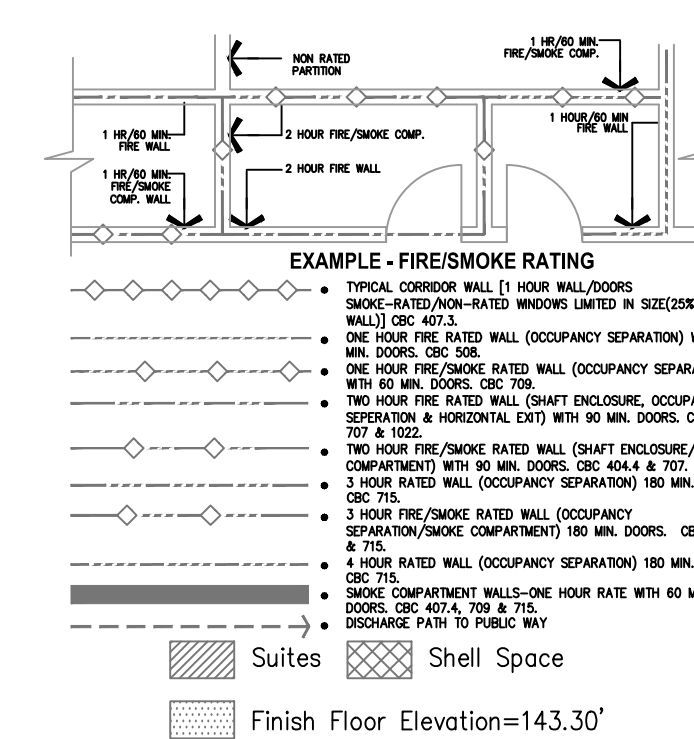

A1 Key Plan
N.T.S.