


ARCHITECT OF RECORD

CONSULTANT

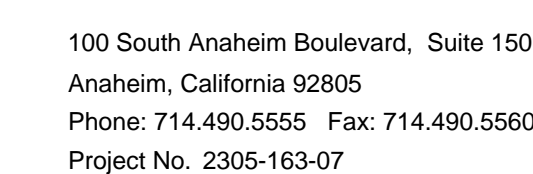

REVISIONS

APPROVAL

PROJECT NAME

TOWER II



04/11/12

04/11/12 #C10-#85046
5850 W. Centinela Ave., Los Angeles, CA 90045. (310) 337-1377

PROJECT NUMBER

OSHPD - PROJECT NUMBER
IL 072072-30

ISSUE

OSHPD PERMIT

DATE _____

01/27/2010


SCALE

$$1/4'' = 1' - 0''$$


LEVEL 6 POWER PLAN
AREA - A

DRAWING NUMBER

EP3.6A

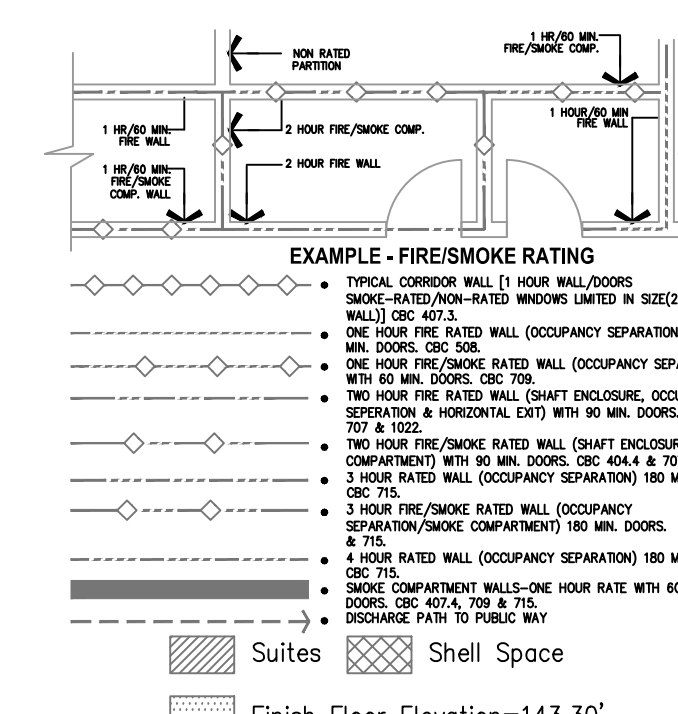

A1 Key Plan

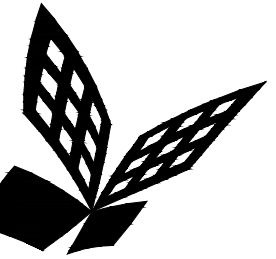

FKP Architects

ARCHITECT OF RECORD

CONSULTANT
T M A D
TAYLOR
& G AINES
100 South Anaheim Boulevard, Suite 150
Anaheim, California 92805
Phone: 714.490.5555 Fax: 714.490.5560
Project No. 2305-163-07

REVISIONS

APPROVAL

PROJECT NAME
CHILDREN'S HOSPITAL
OF ORANGE COUNTY
455 S. Main St.
Orange, CA 92868-3874

TOWER II




PROJECT NUMBER
12011.00
Increment #7
OSHPD - PROJECT NUMBER
IL 072072-30

ISSUE
OSHPD PERMIT
DATE
01/27/2010
SCALE

1/4" = 1' - 0"
DRAWING TITLE
LEVEL 6 POWER PLAN
AREA - F

DRAWING NUMBER

EP3.6F

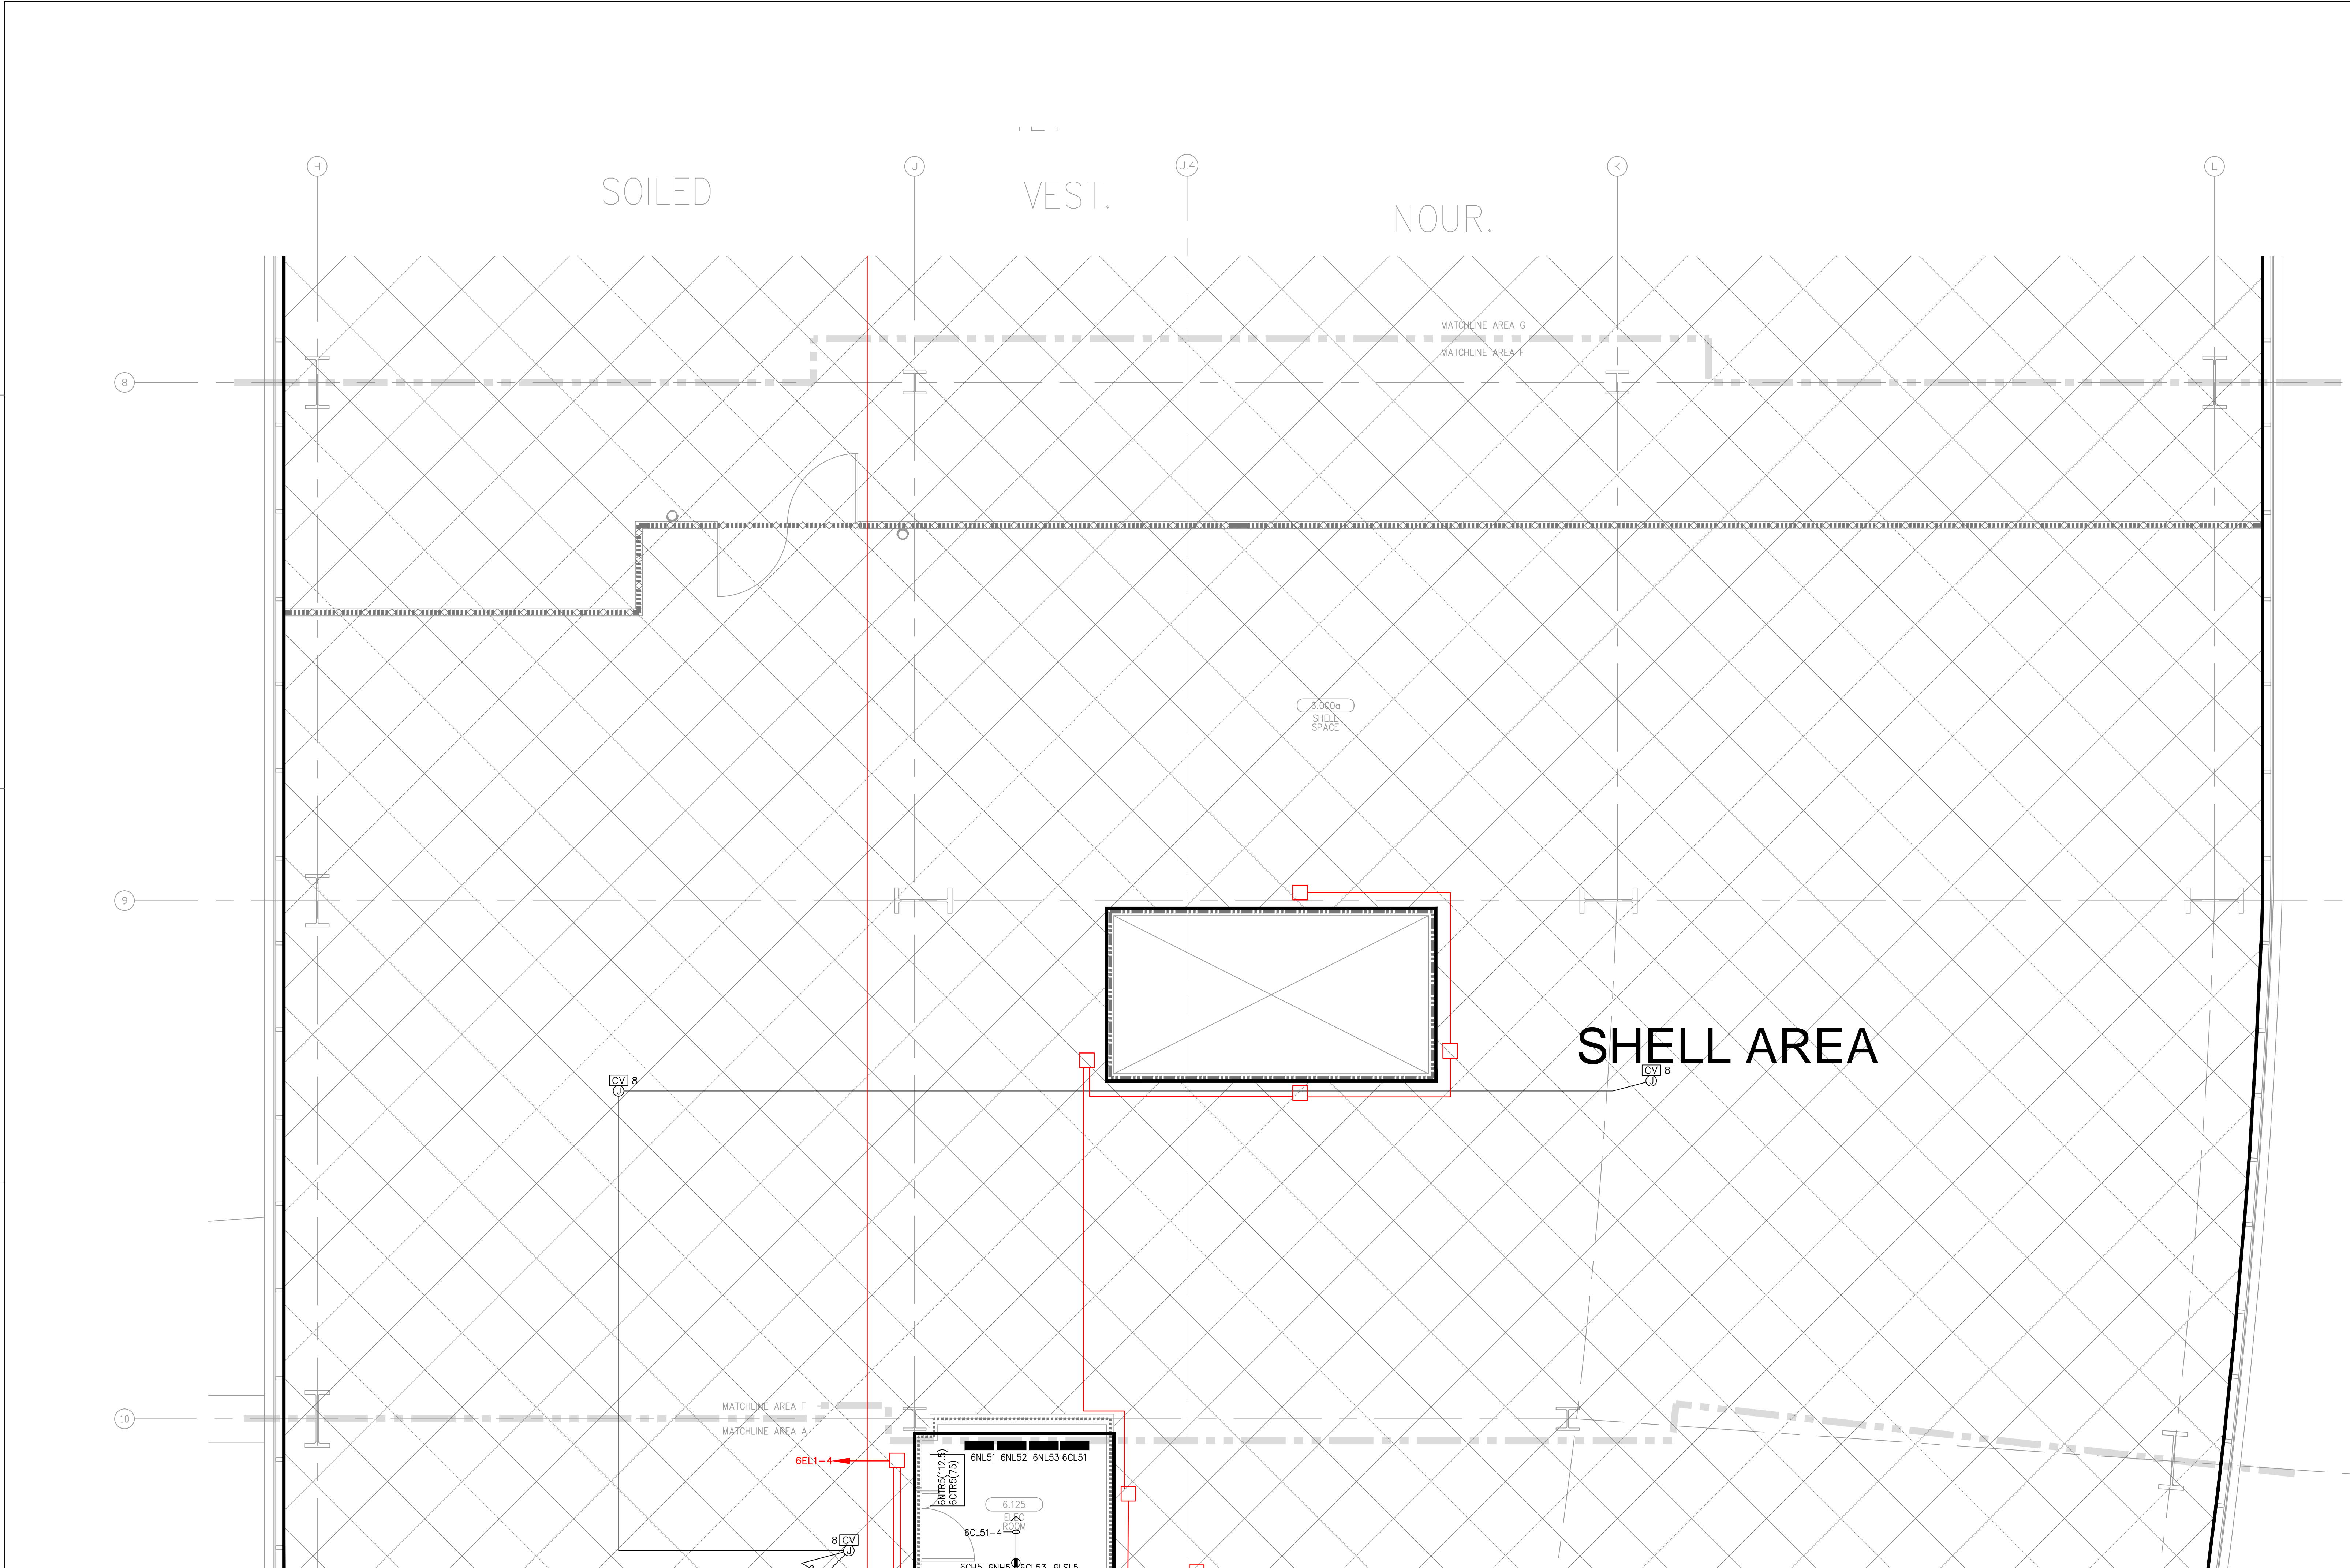



FOR KEY NOTES REFER TO SHEET "EP3A"

Bergelectric Corp. Contractors & Engineers



RECORD SET

04/11/12

6500 W. Centinela Ave., Los Angeles, CA 90045, (310) 357-1377

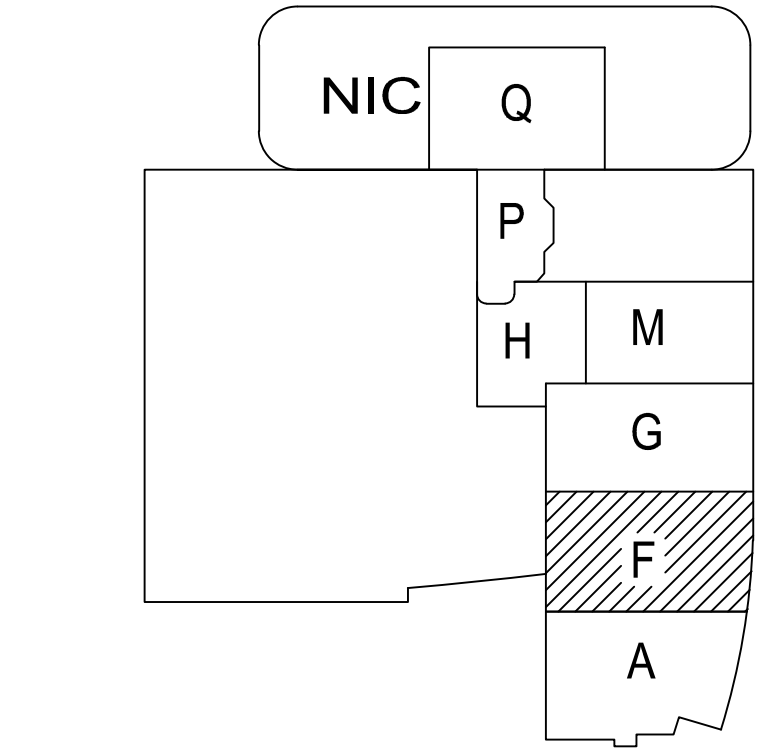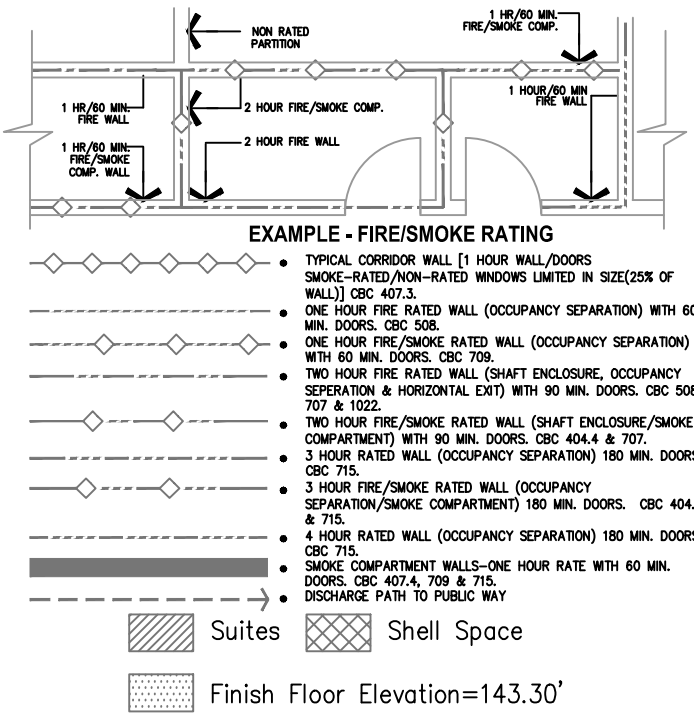

A1 Key Plan
N.T.S.

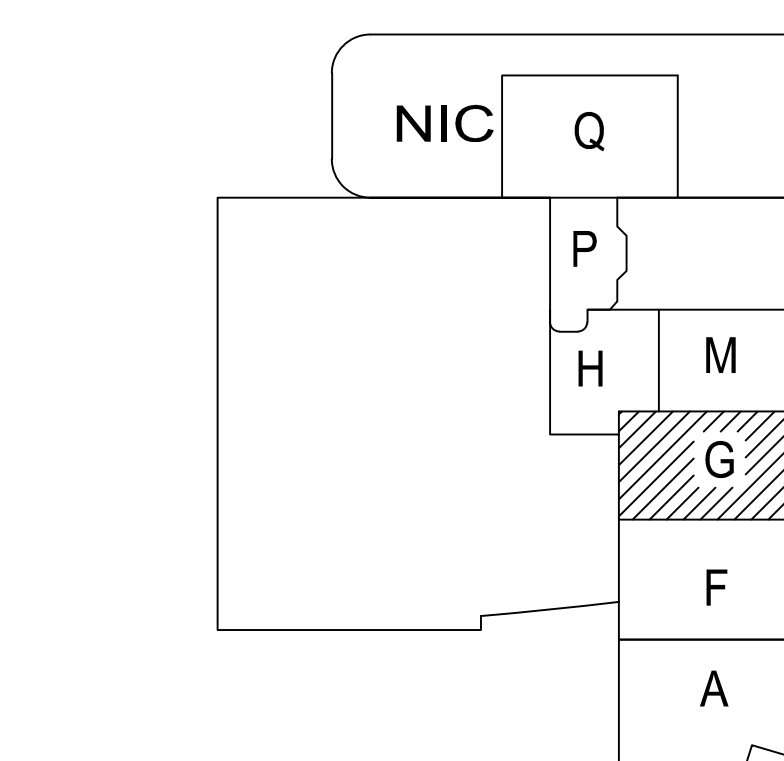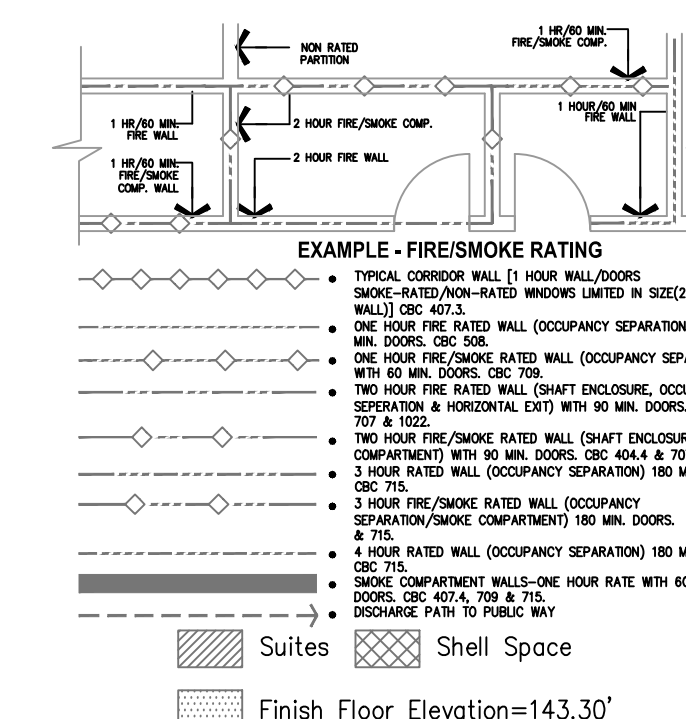

A1 Key Plan
N.T.S.

