

FKP Architects

ARCHITECT OF RECORD

CONSULTANT

T M A D
TAYLOR
& G AINES

- STRUCTURAL
- MECHANICAL
- ELECTRICAL
- CIVIL

100 South Anaheim Boulevard, Suite 150
Anaheim, California 92805
Phone: 714.490.5555 Fax: 714.490.5560
Project No. 2305-163-07

REVISIONS

897 12/19/11 CHANGE ORDER #294

APPROVAL

PROJECT NAME

**CHILDREN'S HOSPITAL
OF ORANGE COUNTY**
455 S. Main St.
Orange, CA 92668-3874

TOWER II



PROJECT NUMBER

**12011.00
Increment #7**

OSHPD - PROJECT NUMBER

IL 072072-30

ISSUE

OSHPD PERMIT

DATE

01/27/2010

SCALE


1/4" = 1' - 0"

DRAWING TITLE

**LEVEL 7 POWER PLAN
AREA - A**

DRAWING NUMBER

EP3.7A

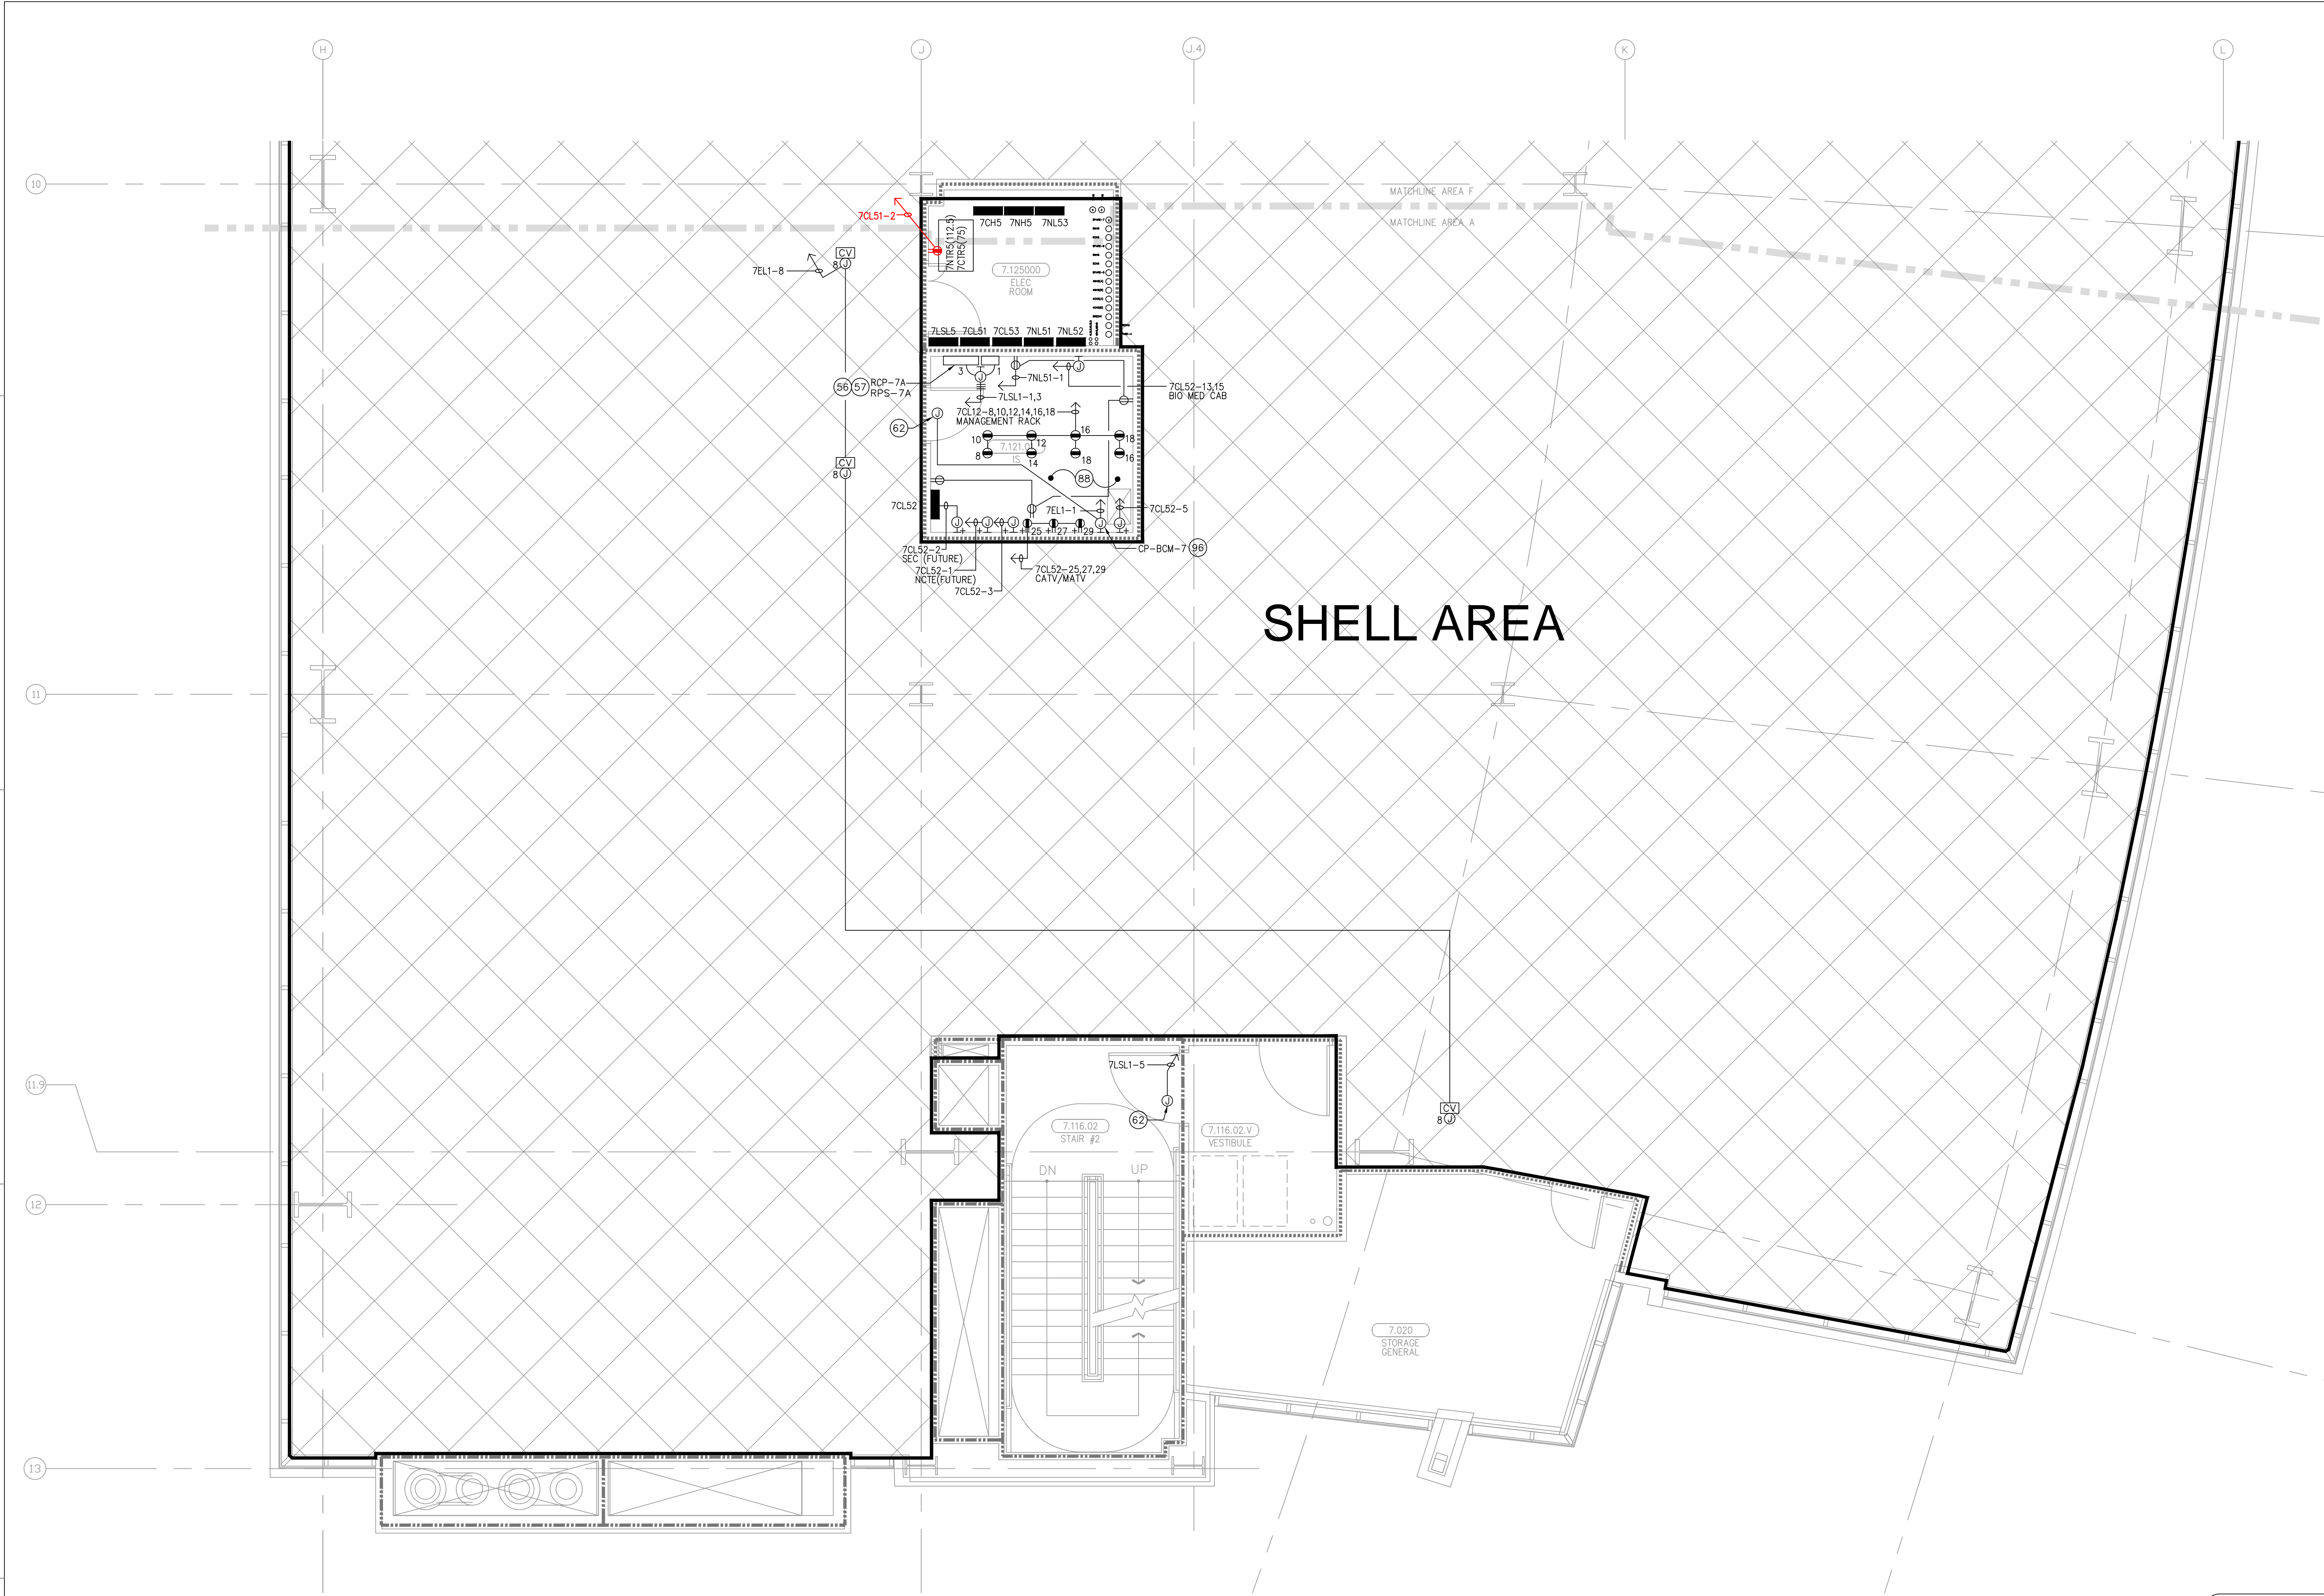


FOR KEY NOTES REFER TO SHEET "EP3A"

Bergelectric Corp. Contractors & Engineers

RECORD SET

08/17/12

5650 W. Centinela Ave., Los Angeles, CA 90045, (310) 537-1377

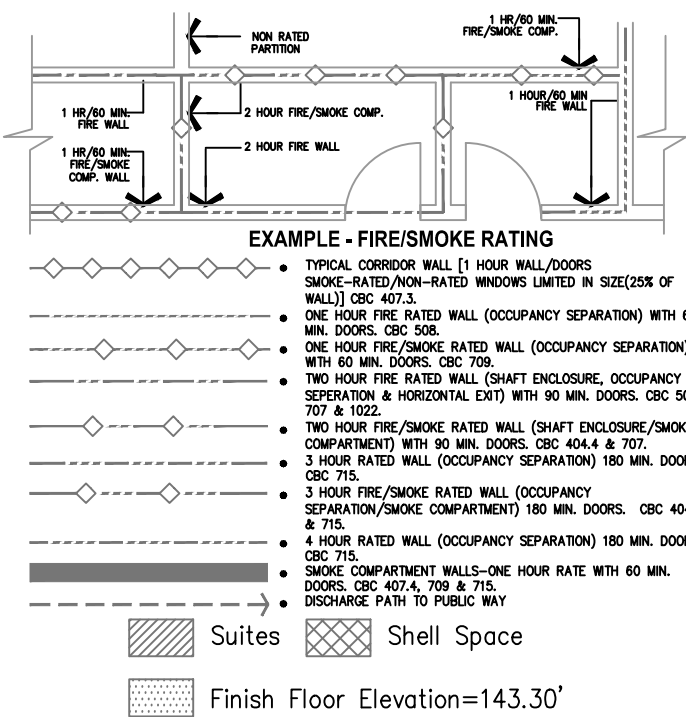

A1 Key Plan
N.T.S.

ARCHITECT OF RECORD

CONSULTANT

T M A D
TAYLOR
& GAINES

- STRUCTURAL
- MECHANICAL
- ELECTRICAL
- CIVIL

100 South Anaheim Boulevard, Suite 150
Anaheim, California 92805
Phone: 714.490.5555 Fax: 714.490.5560
Project No. 2305-163-07

REVISIONS

APPROVAL

PROJECT NAME

**CHILDREN'S HOSPITAL
OF ORANGE COUNTY**
455 S. Main St.
Orange, CA 92868-3874

TOWER II



PROJECT NUMBER

12011.00
Increment #7

OSHPD - PROJECT NUMBER
IL 072072-30

ISSUE

QSHPD PERMIT

DATE _____

01/27/2010

SCALE

$$1/4'' = 1' - 0''$$

DRAWING TITLE



LEVEL 7 POWER PLAN
AREA - F

DRAWING NUMBER


EP3.7F



EP3.7G

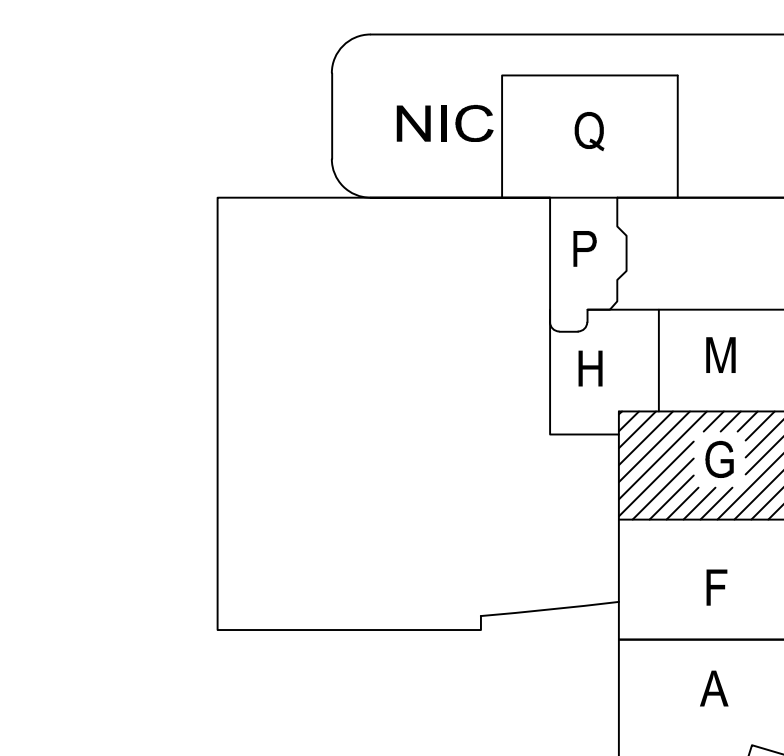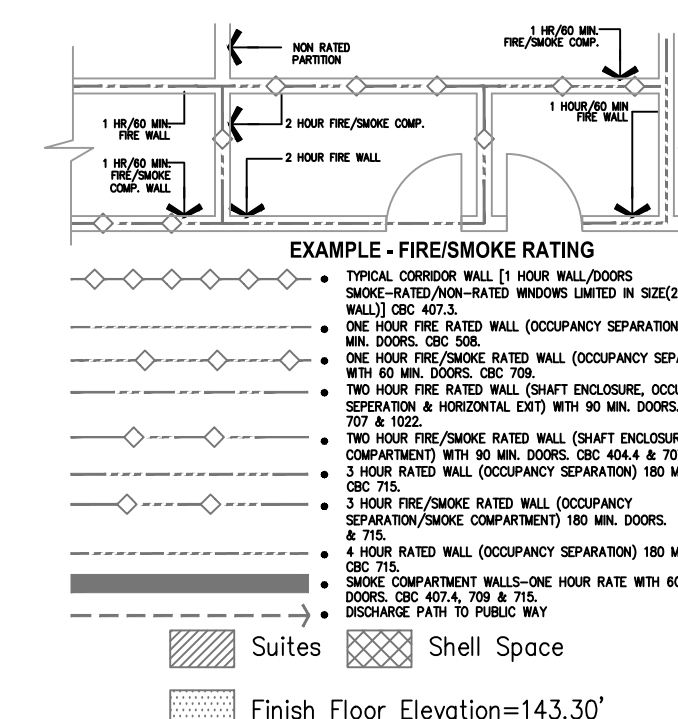

A1 Key Plan
N.T.S.

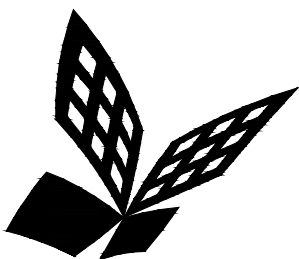

FKP Architects

ARCHITECT OF RECORD

CONSULTANT

T M A D
TAYLOR
& G AINES


- STRUCTURAL
- MECHANICAL
- ELECTRICAL
- CIVIL

100 South Anaheim Boulevard, Suite 150
Anaheim, California 92805
Phone: 714.490.5555 Fax: 714.490.5560
Project No. 2305-163-07

REVISIONS

APPROVAL

FOR KEY NOTES REFER TO SHEET "EP3A"


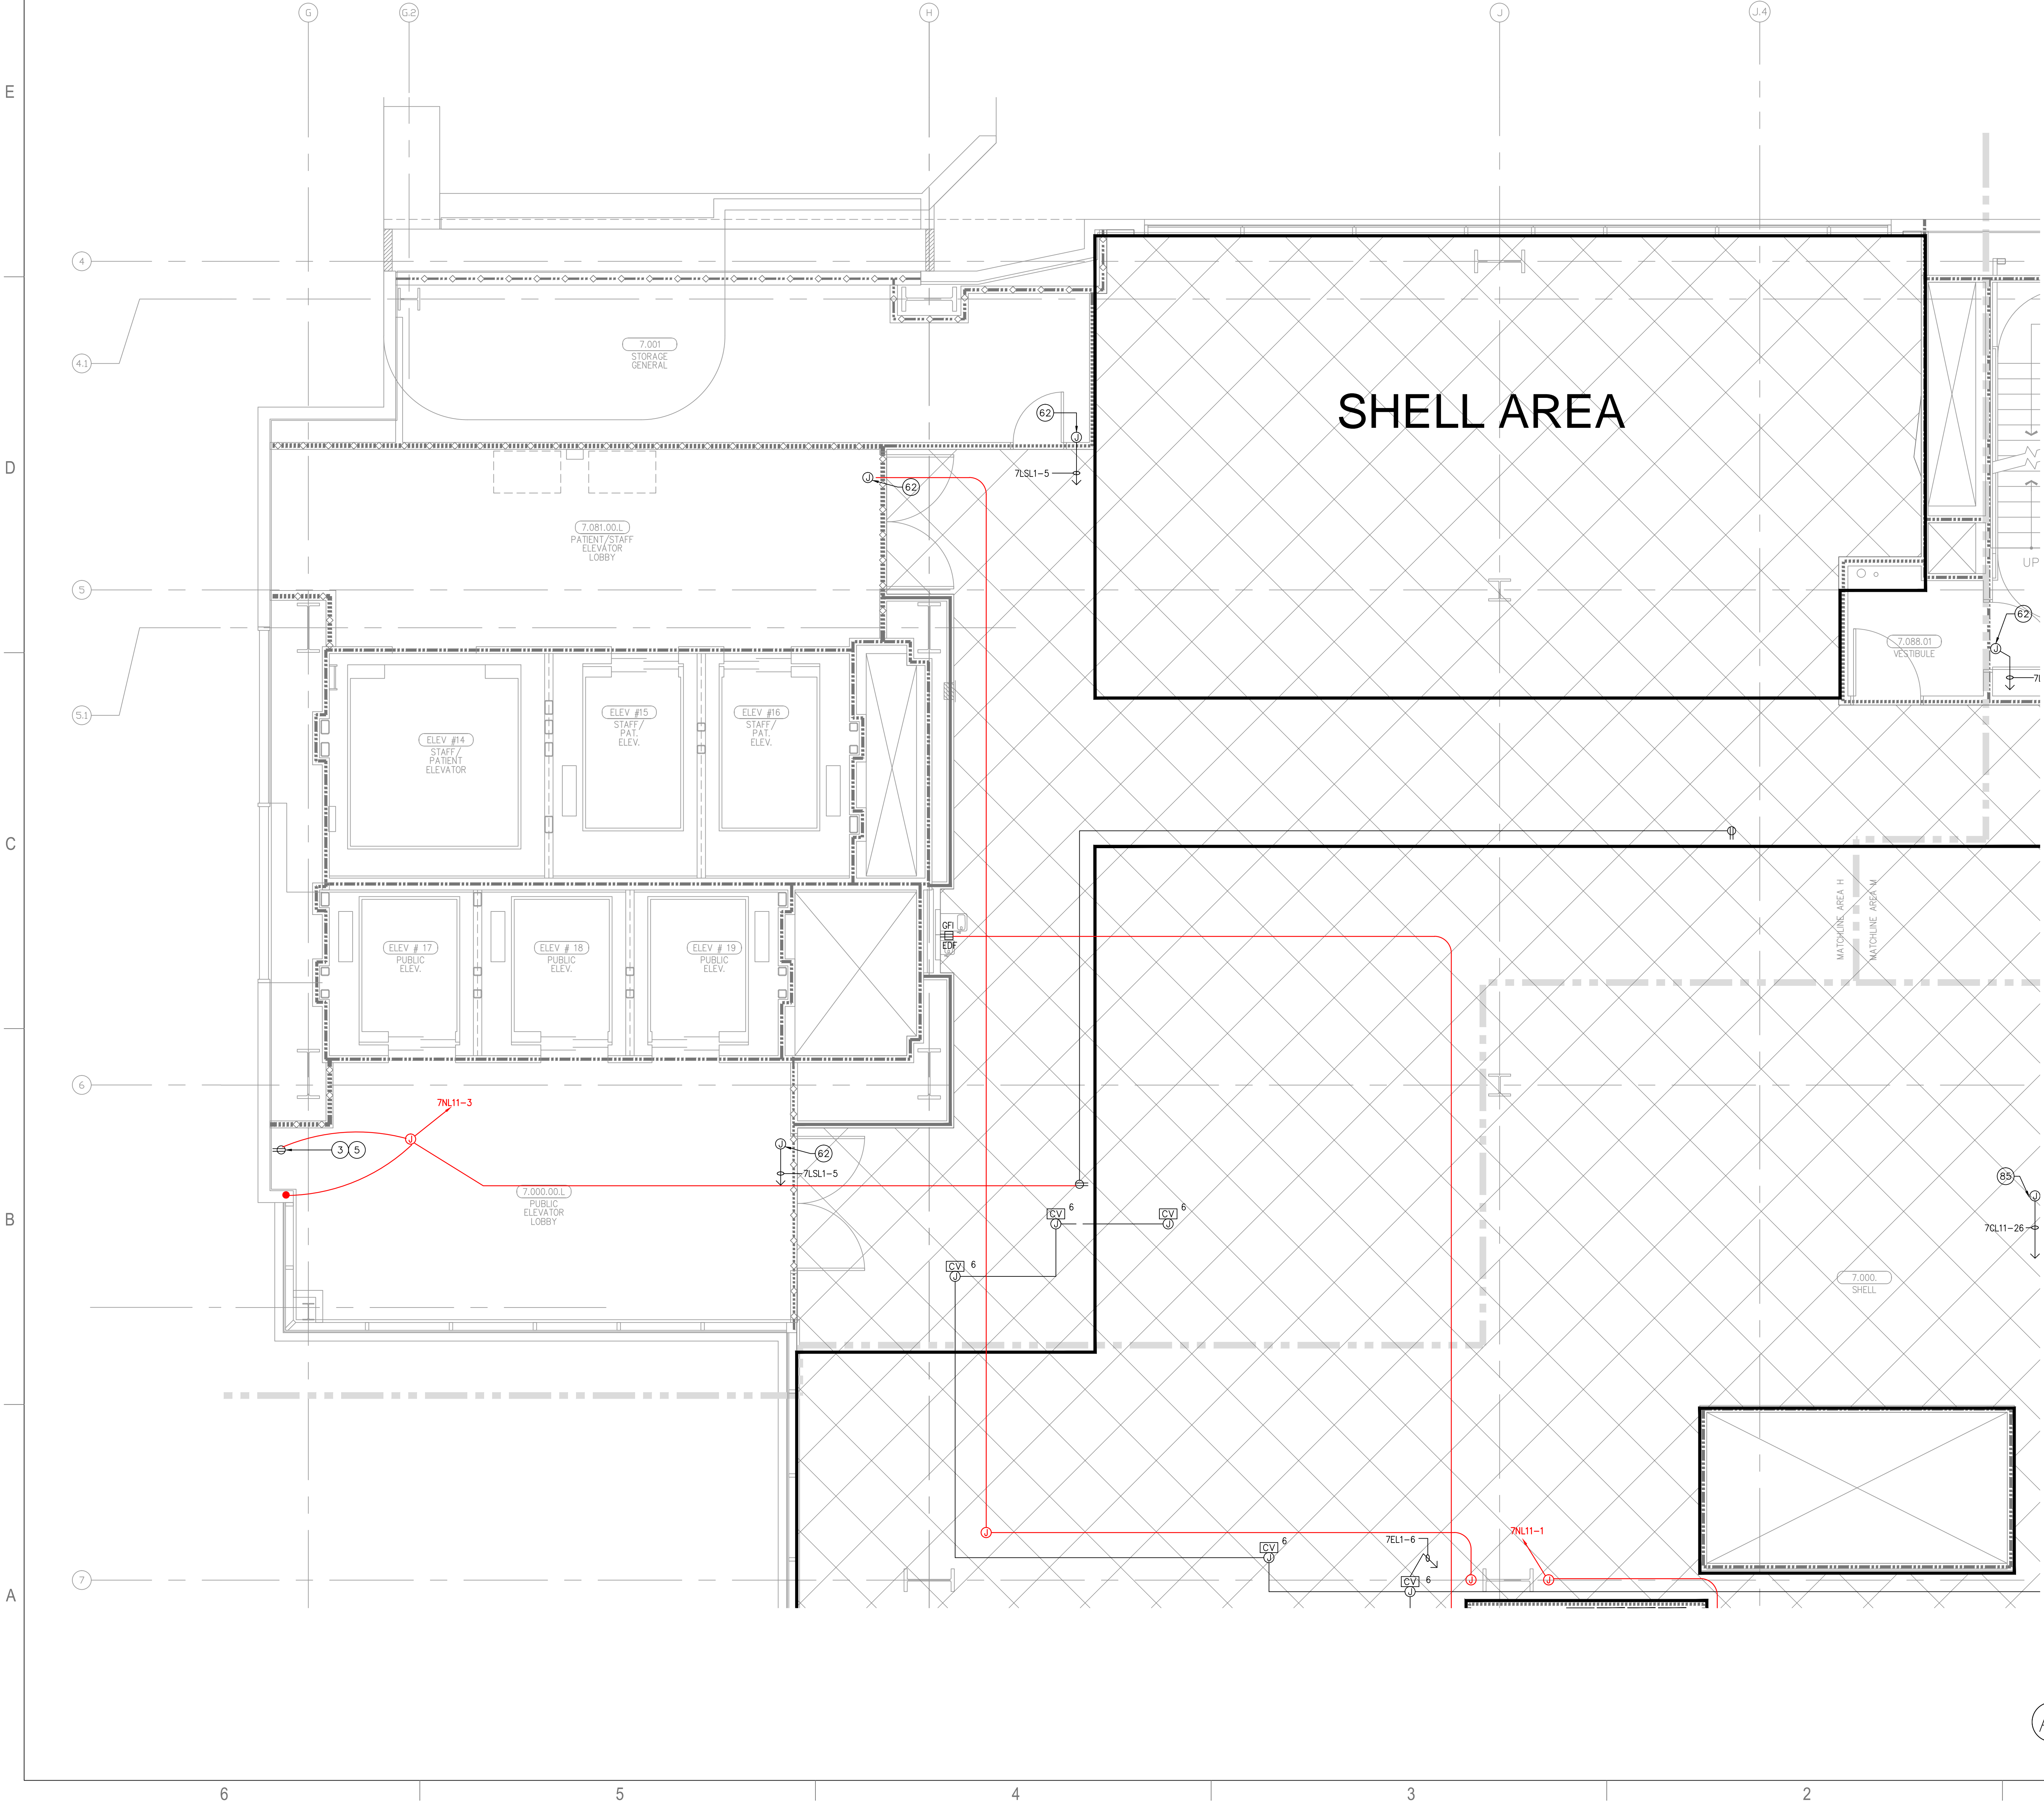


Bergelectric Corp. Contractors & Engineers

RECORD SET

08/17/12

5650 W. Centinela Ave., Los Angeles, CA 90045, (310) 337-1377

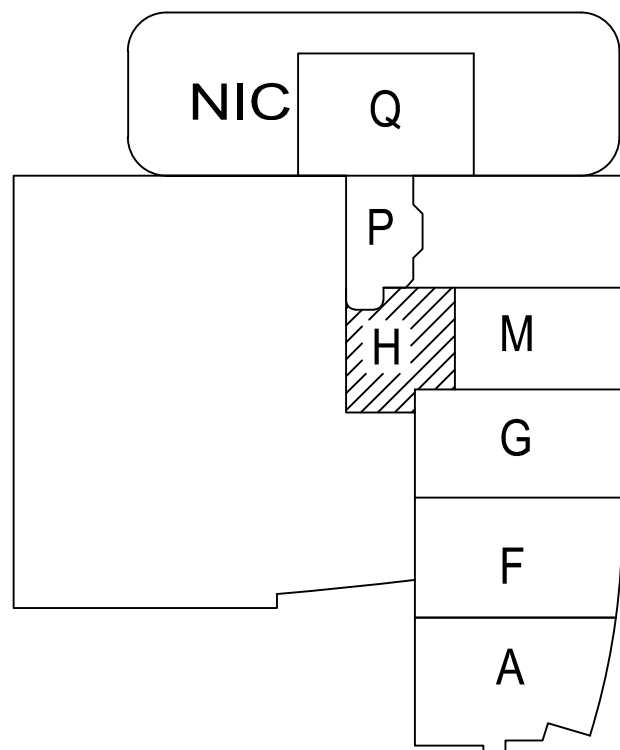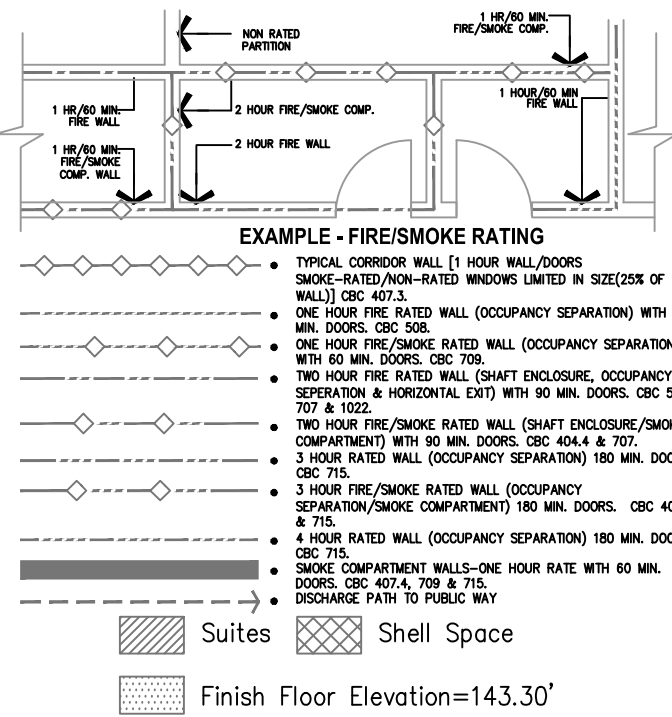

A1 Key Plan
N.T.S.

PROJECT NAME
**CHILDREN'S HOSPITAL
OF ORANGE COUNTY**
455 S. Main St.
Orange, CA 92868-3874

TOWER II
CHOC
HOSPITAL

PROJECT NUMBER
**12011.00
Increment #7**
OSHDP - PROJECT NUMBER
IL 072072-30

ISSUE
OSHDP PERMIT
DATE
01/27/2010
SCALE
1/4" = 1' - 0"
DRAWING TITLE
**LEVEL 7 POWER PLAN
AREA - H**

DRAWING NUMBER

EP3.7H

