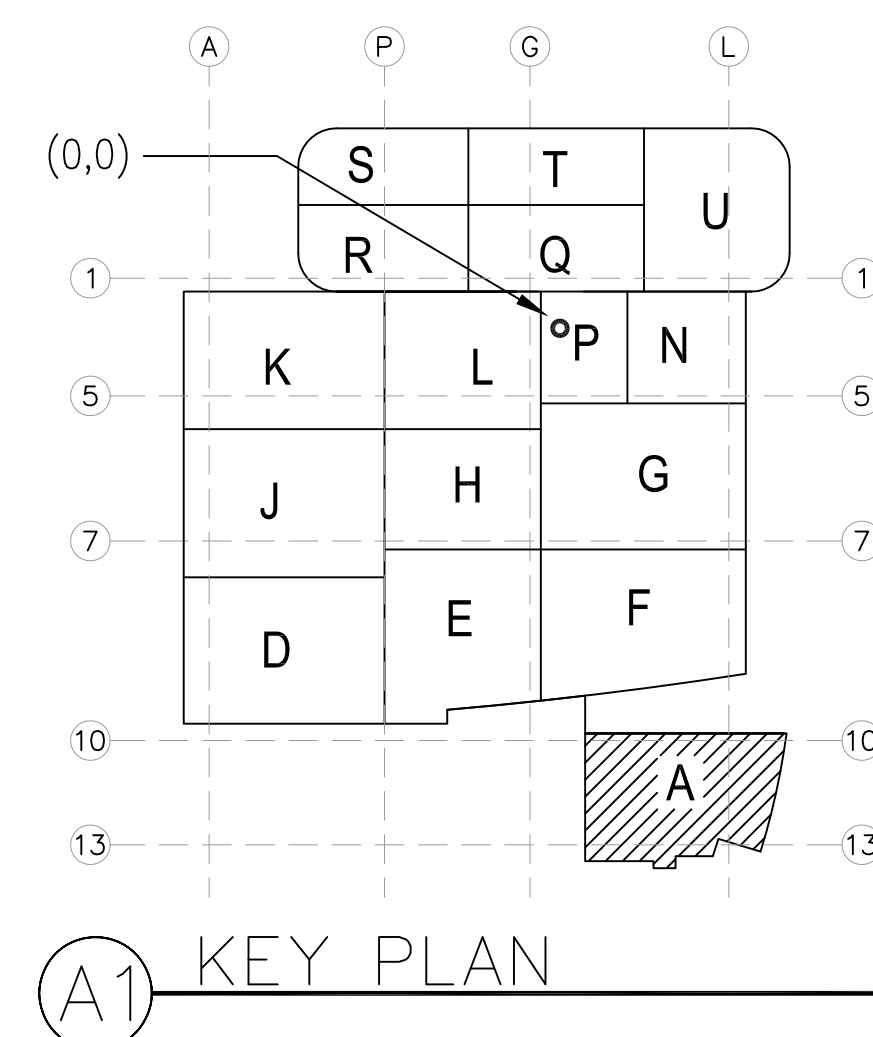
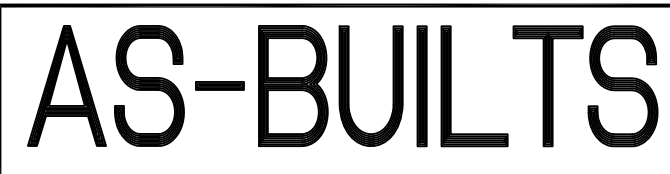


[illegible]

COORD.	SIGNATURE	DATE
McARTHUR		
MECHANICAL DUCT		
MECHANICAL PIPE		
PLUMBING		
ELECTRICAL		
FIRE SPRINKLER		
PIPE		
DRYWALL/FRAMER		
REFRIGERATION		
STRUCTURAL		

[illegible]

CHILDREN'S HOSPITAL
OF ORANGE COUNTY
455 S. Main St.
Orange, CA 92668-3874
TOWER II

PLUMBING FLOOR PLAN - LEVEL 01 AREA-A

PAN-PACIFIC
PLUMBING & MECHANICAL




Murray
Company

2919 E. VICTORIA STREET, RANCHO DOMINGUEZ, CA 90221
PH. 310 637-1500 FAX 310 604-0359


Setup Printed by jpress@netnet 9-04-2012 10:06am

DRAWN
 R.O.
 CHECKED
 M.M.
 DATE
 9/4/2012
 SCALE
 $1/4" = 1' - 0"$
 JOB NO.
 09-006
 DRAWING NUMBER
 MP3.1A
 REFERENCE DRAWING
 A3.1A
 P3.1A
 1 OF 1 SHEETS

This document and the design it covers are the property of Murray Co. They are loaned only with the borrower's expressed written agreement that they will not be reproduced, copied, loaned, exhibited, or used in any other way, except by written consent from Murray Co. to the borrower.

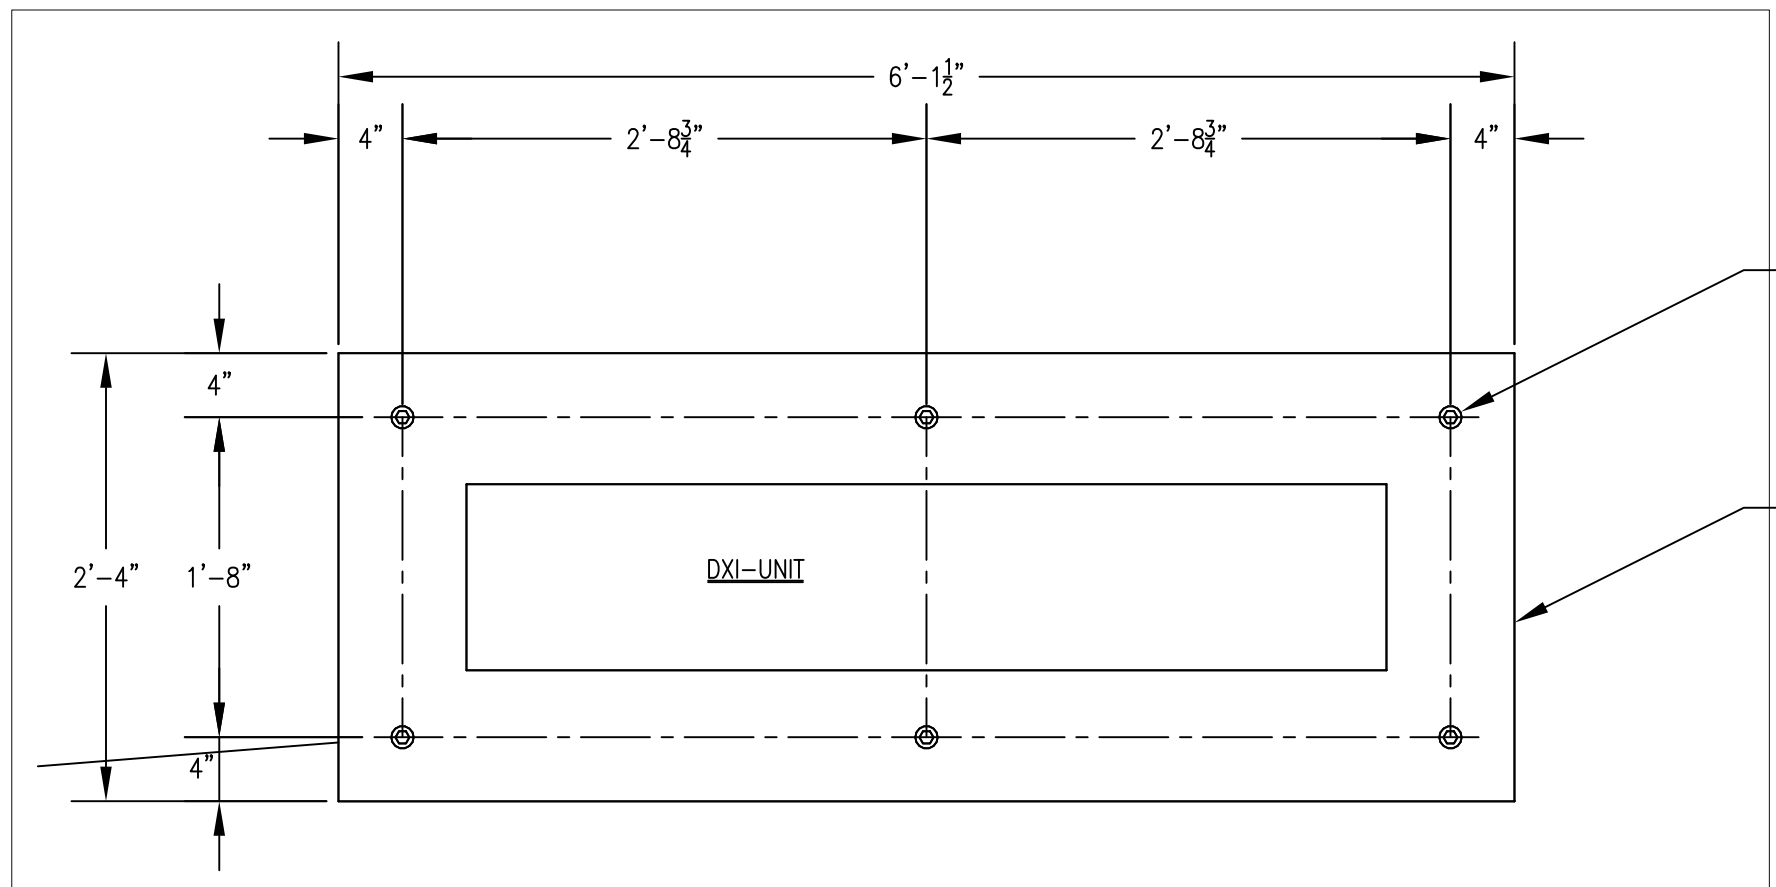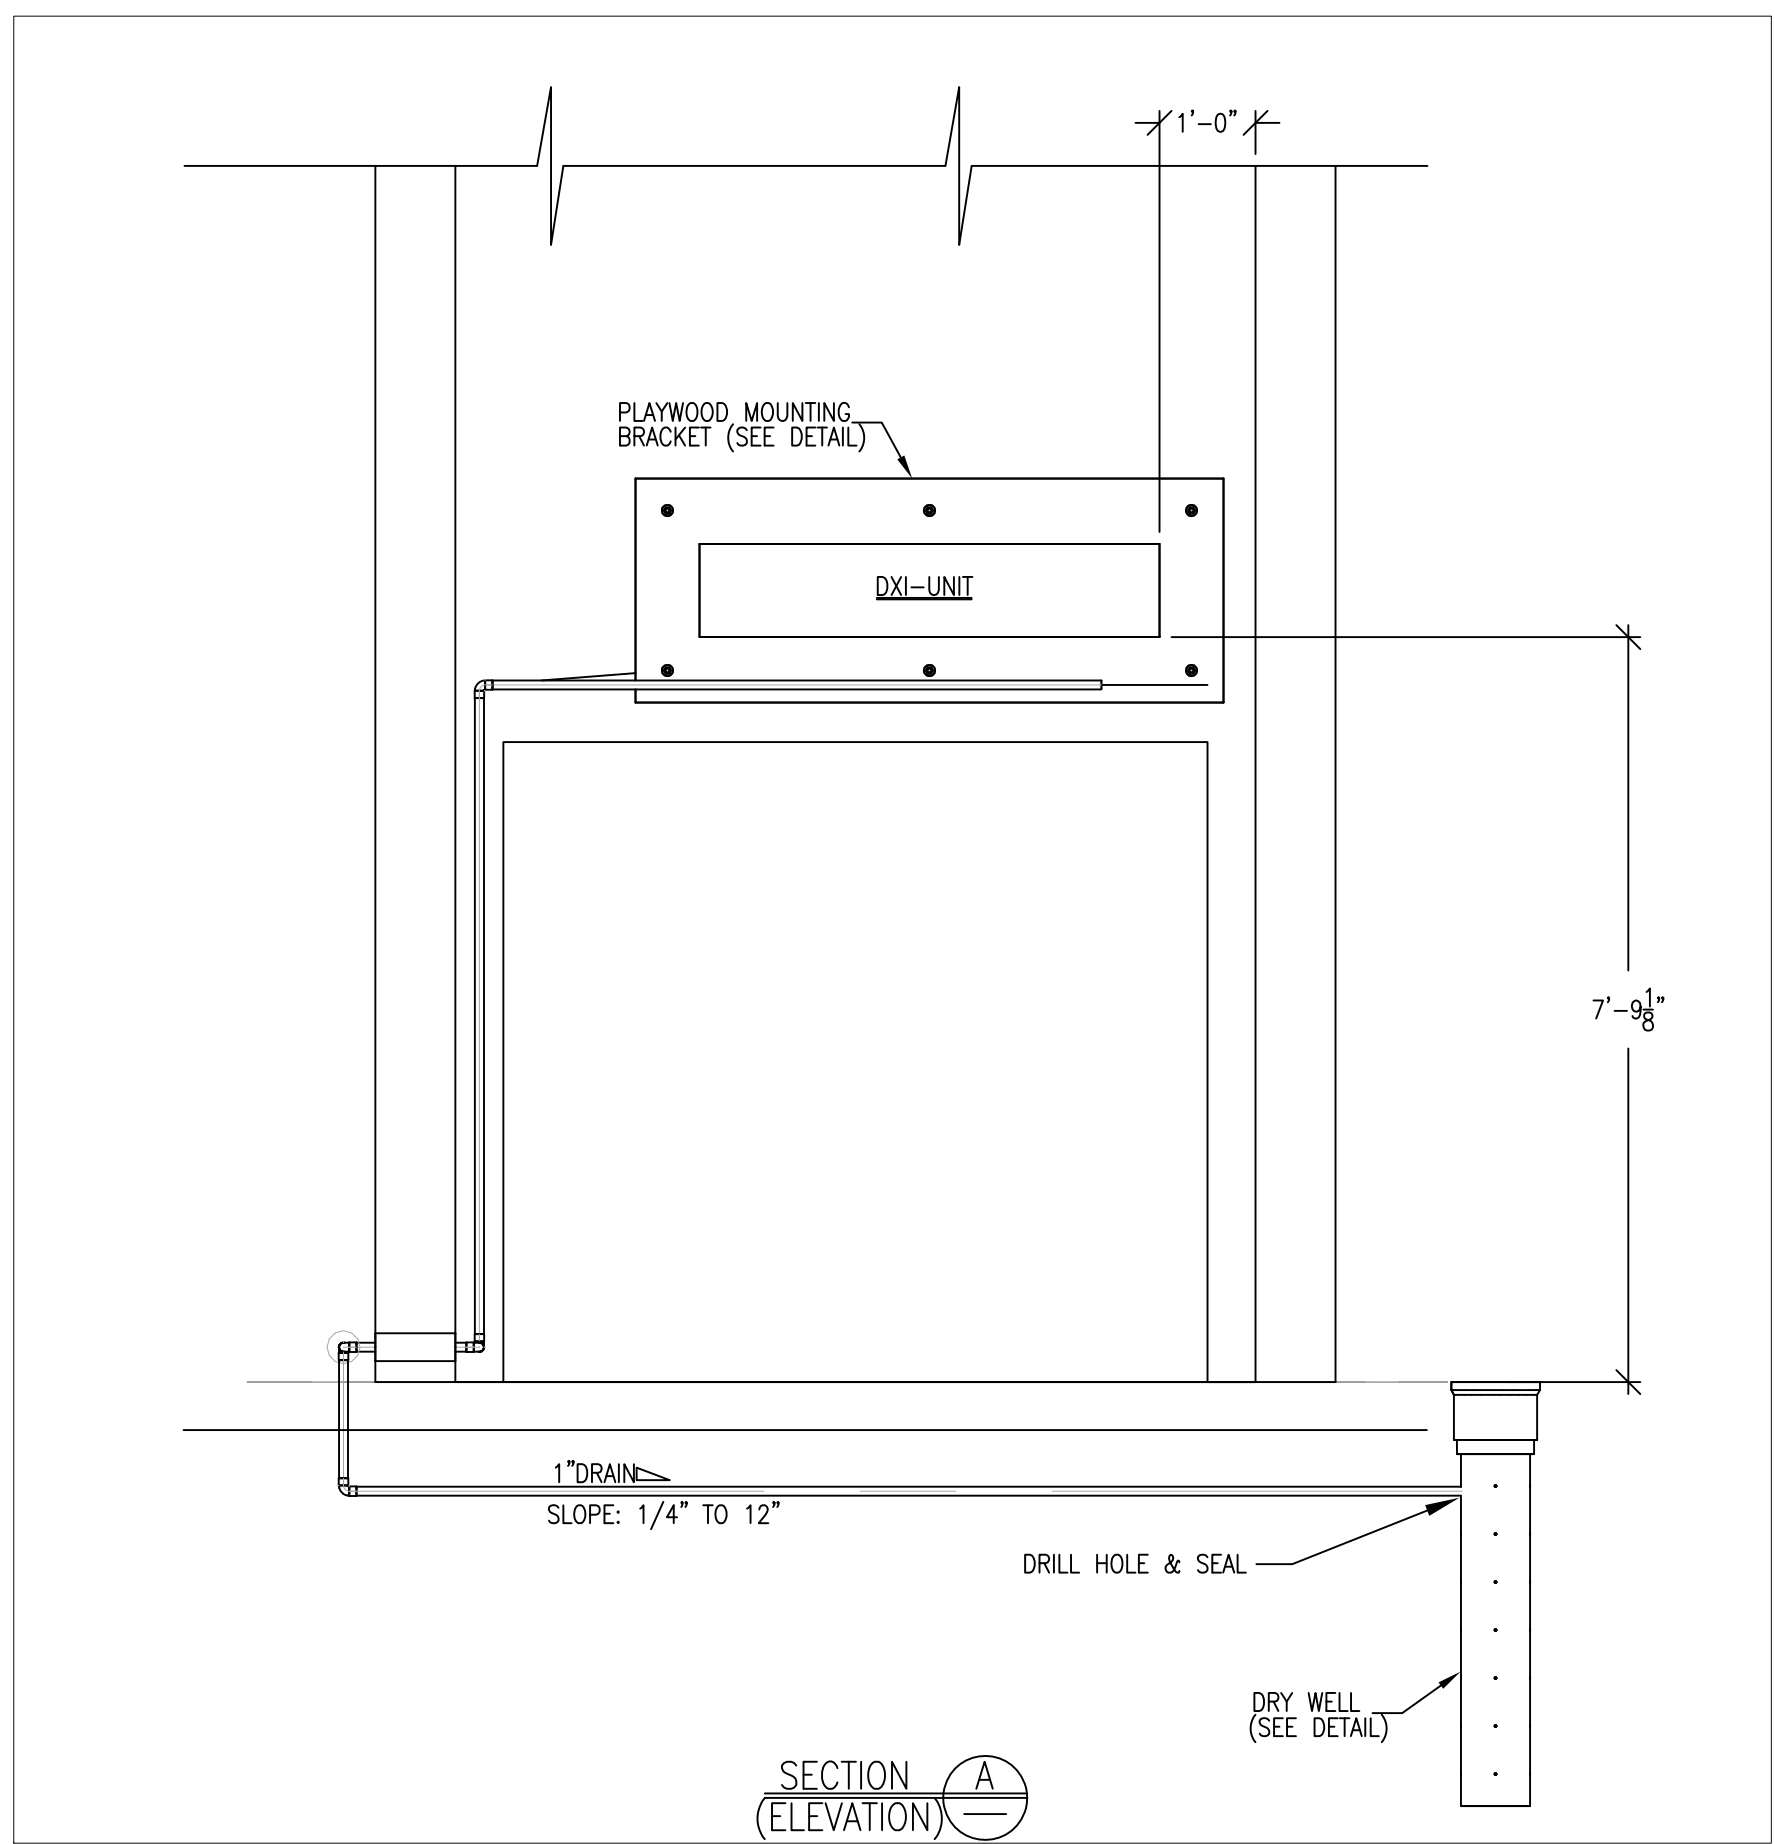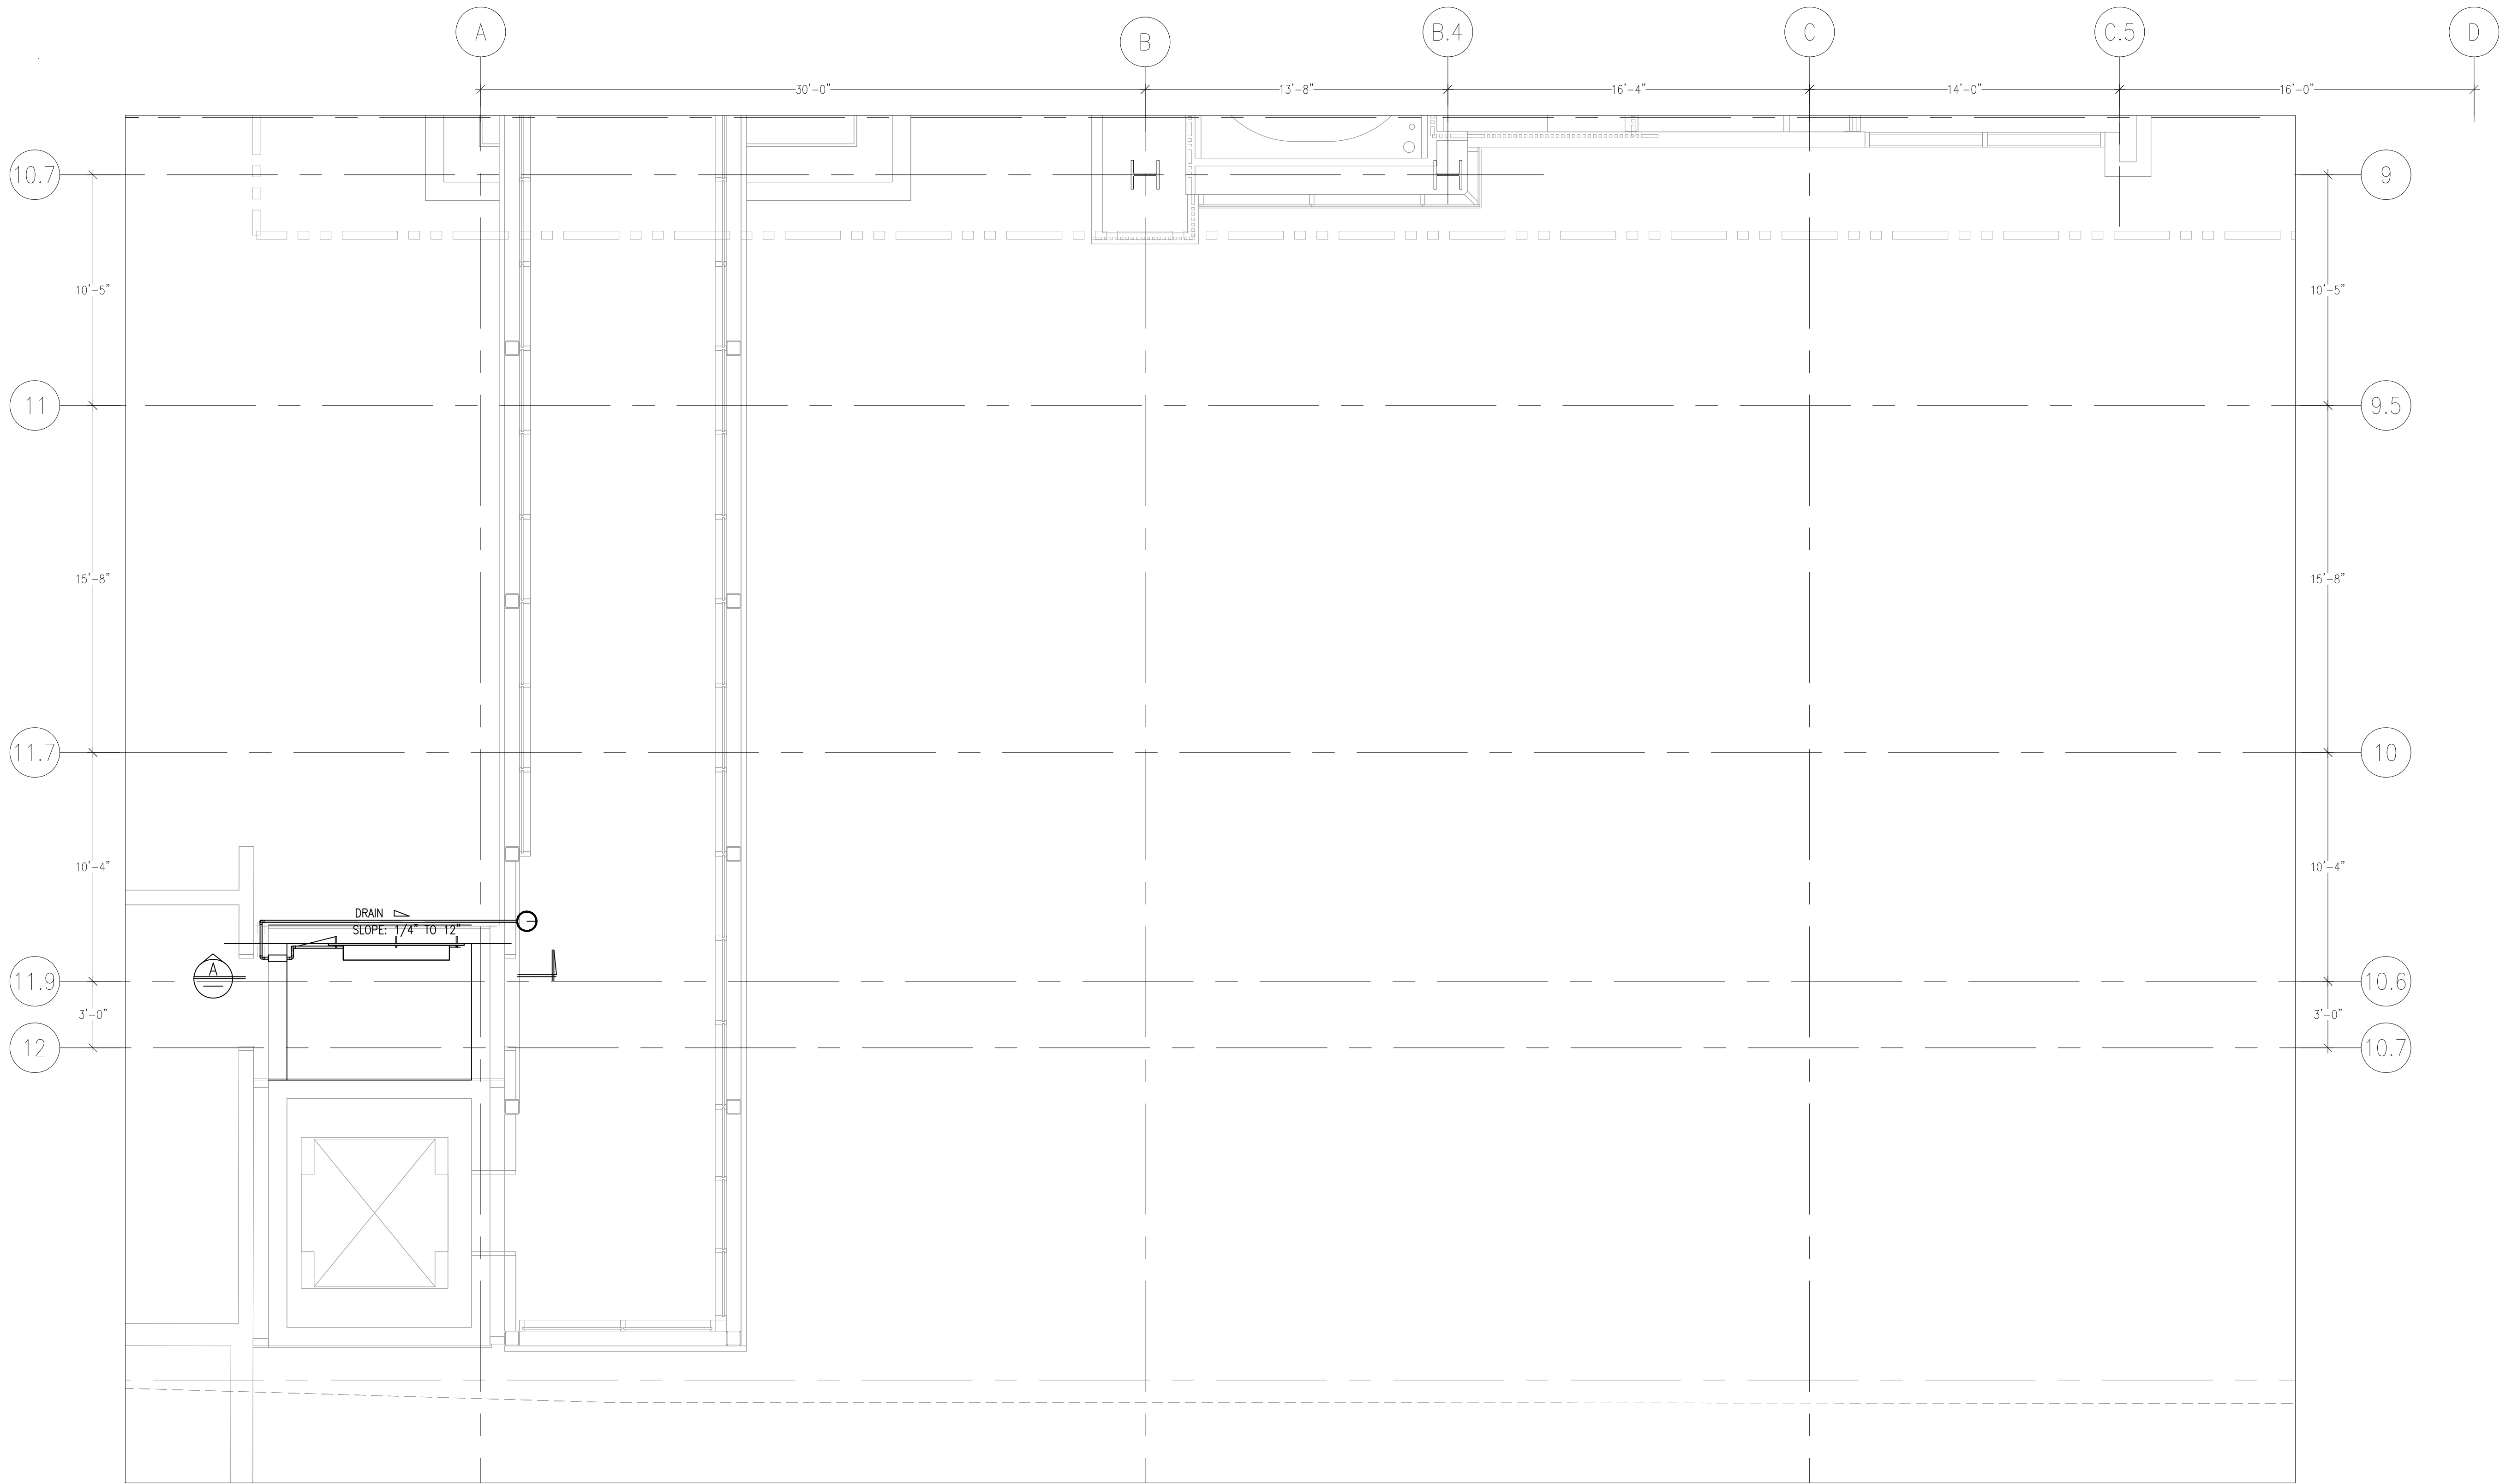



PLAYWOOD MOUNTING BRACKET

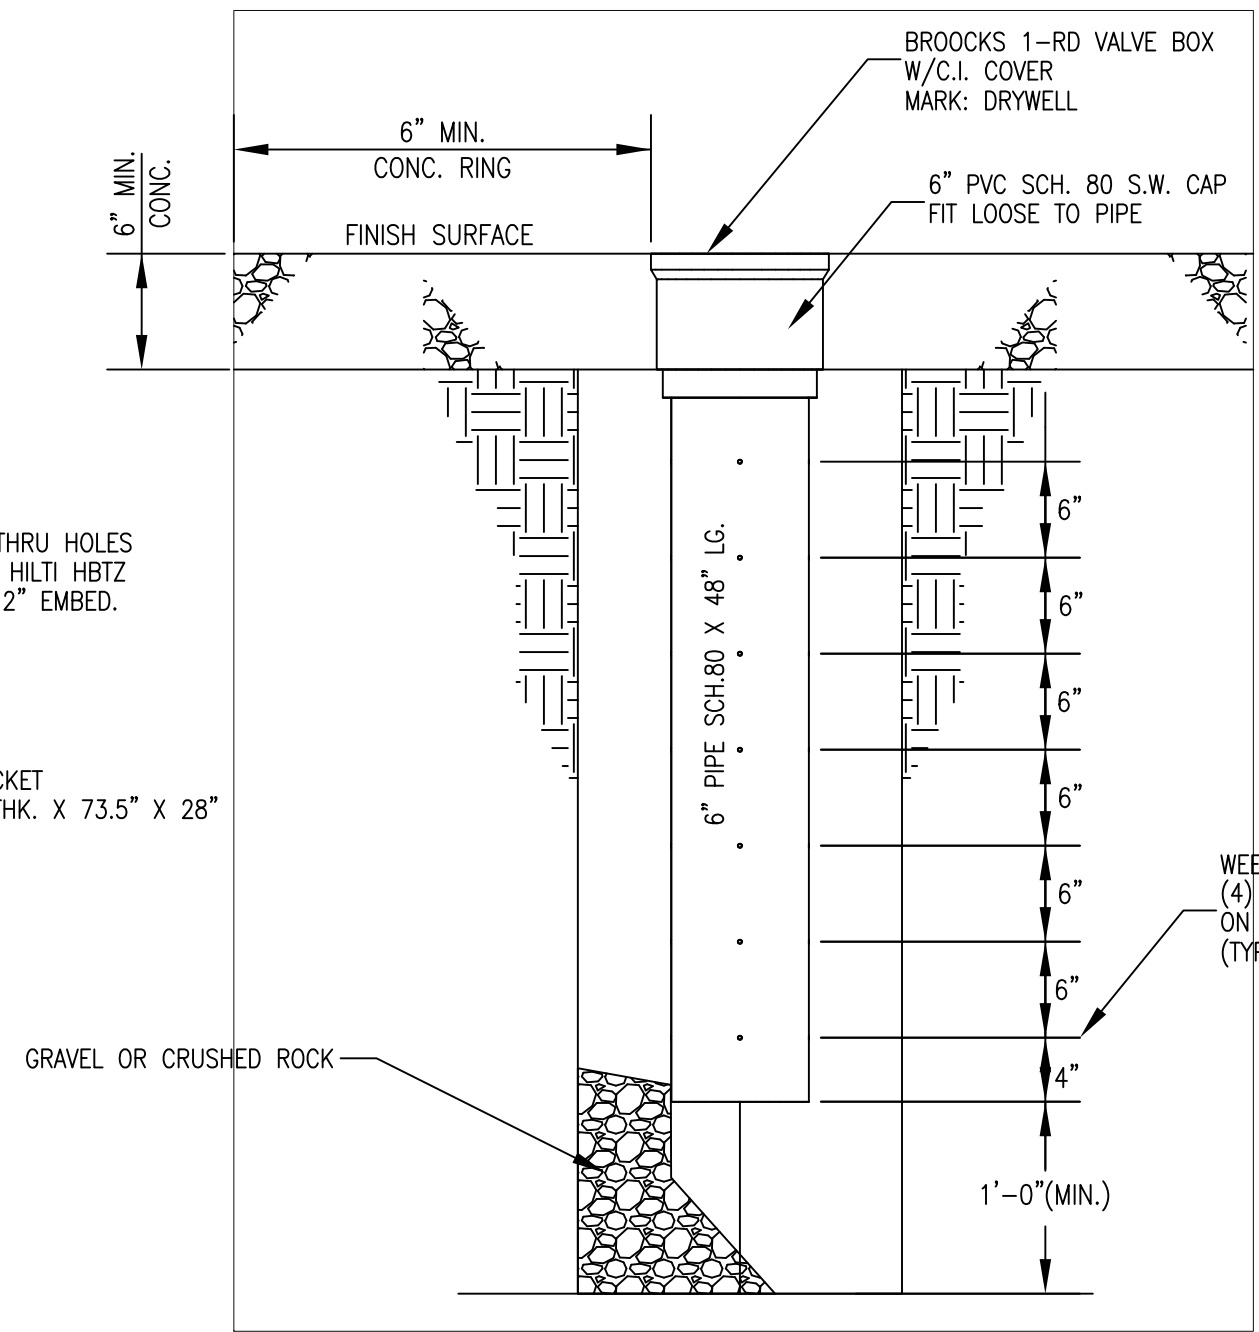

DRY WELL

AS-BUILTS

DATE: 6-18-12 BY: J. CLINTON

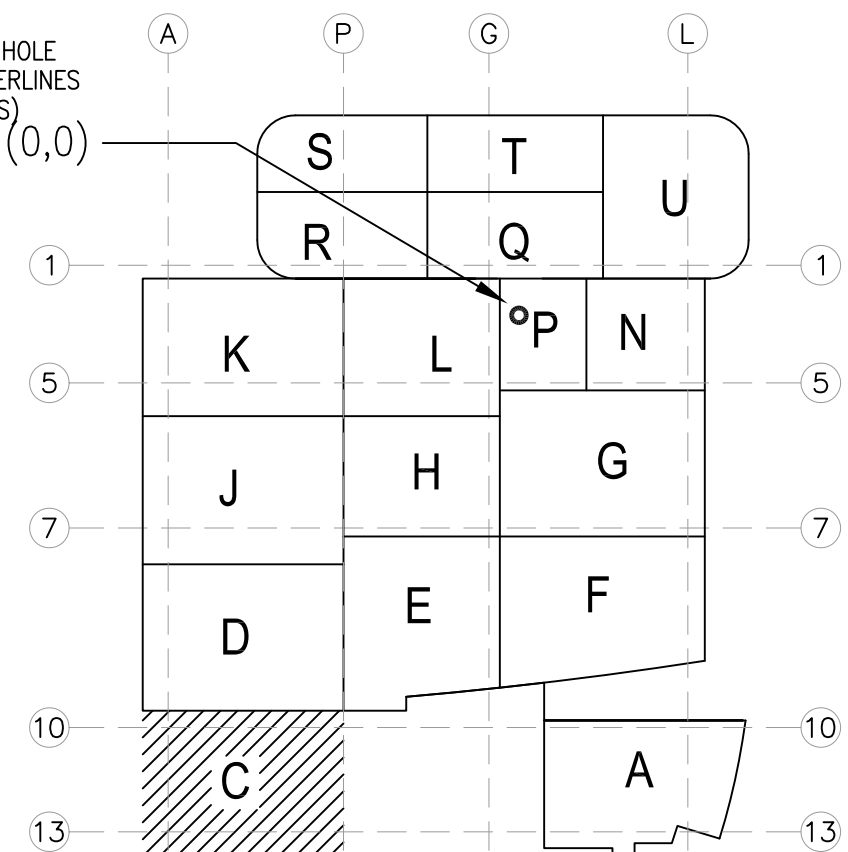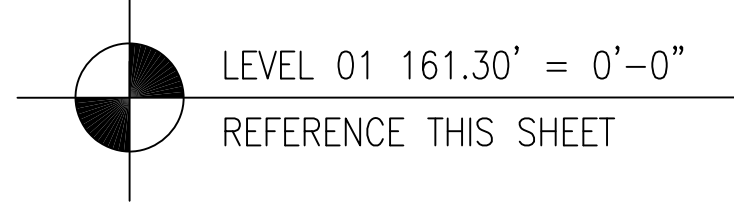

KEY PLAN

REVISIONS	BY

COORD.	SIGNATURE	DATE
MECHANICAL		
ELECTRICAL		
PLUMBING		
STRUCTURAL		
PIPE		
DRYWELL/FRAMER		
REFRIGERATION		
STRUCTURAL		

R.F.I.	SENT	ANS.	R.F.I.	SENT	ANS.	R.F.I.	SENT	ANS.

CHILDREN'S HOSPITAL
OF ORANGE COUNTY
455 S. MAIN ST.
ORANGE, CA 92668-5974

TOWER II

MECH PIPE FLOOR PLAN - LEVEL 01 AREAD

PAN-PACIFIC
PLUMBING & MECHANICAL

Murray Company

2919 E. VICTORIA STREET, RANCHO DOMINGUEZ, CA 90221
PH. 310 637-1500 FAX 310 604-0359

DRAWN
SB

CHECKED
M.M.

DATE
9/4/2012

SCALE
1/4" = 1'-0"





JOB NO.
09-006

DRAWING NUMBER
MP3.1C

REFERENCE DRAWING
A3.1D
P3.1D


1 OF 1 SHEETS

This document and the design it covers are the property of Murray Co. They are loaned only with the borrower's expressed written agreement that they will not be reproduced, copied, loaned, exhibited, or used in any other way, except by written consent from Murray Co. to the borrower.

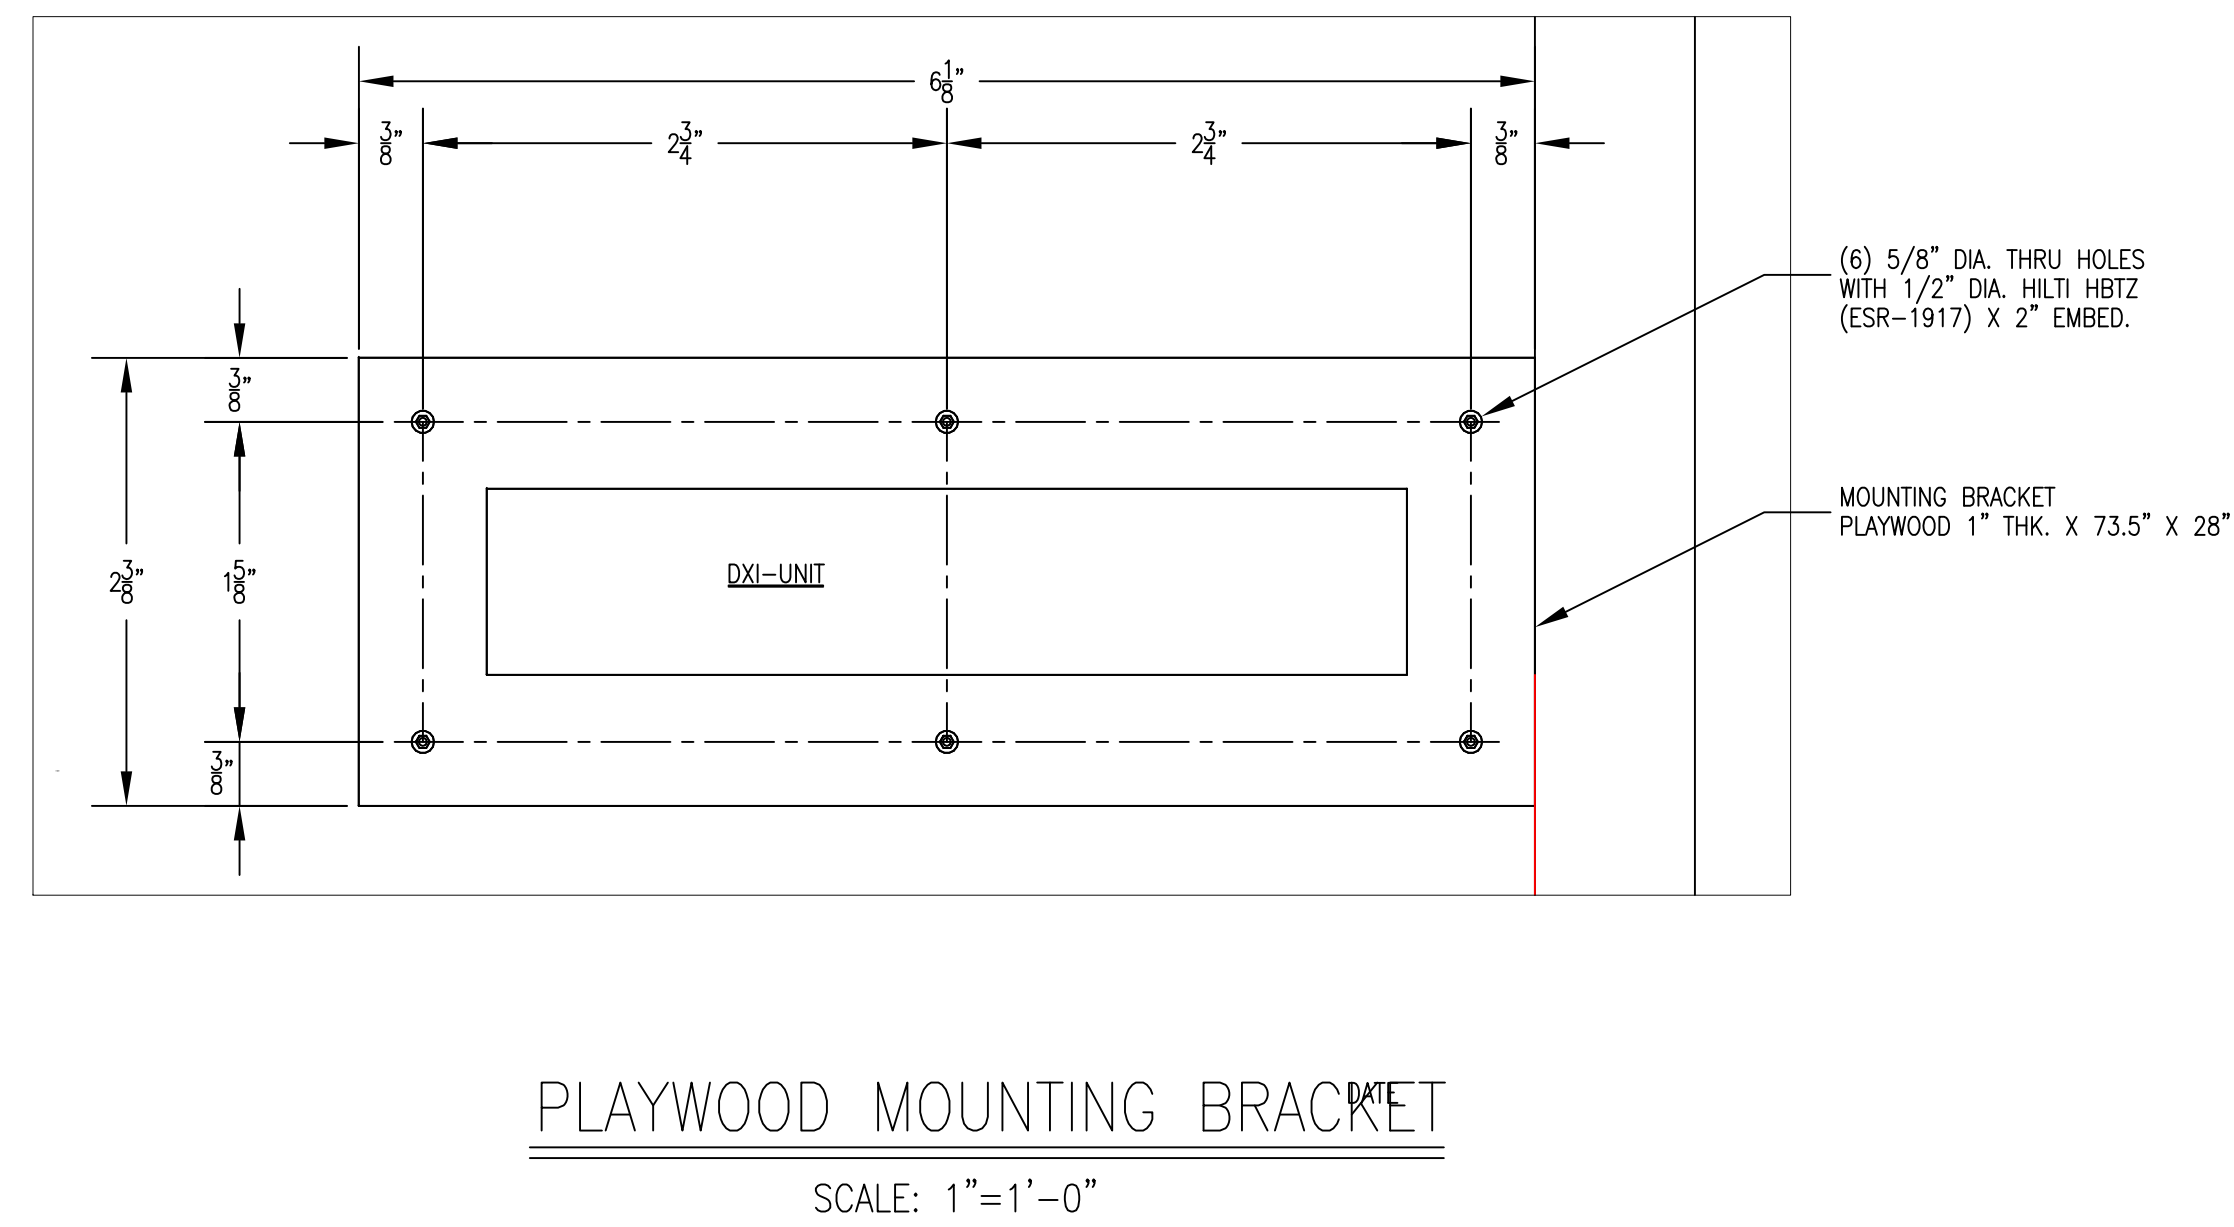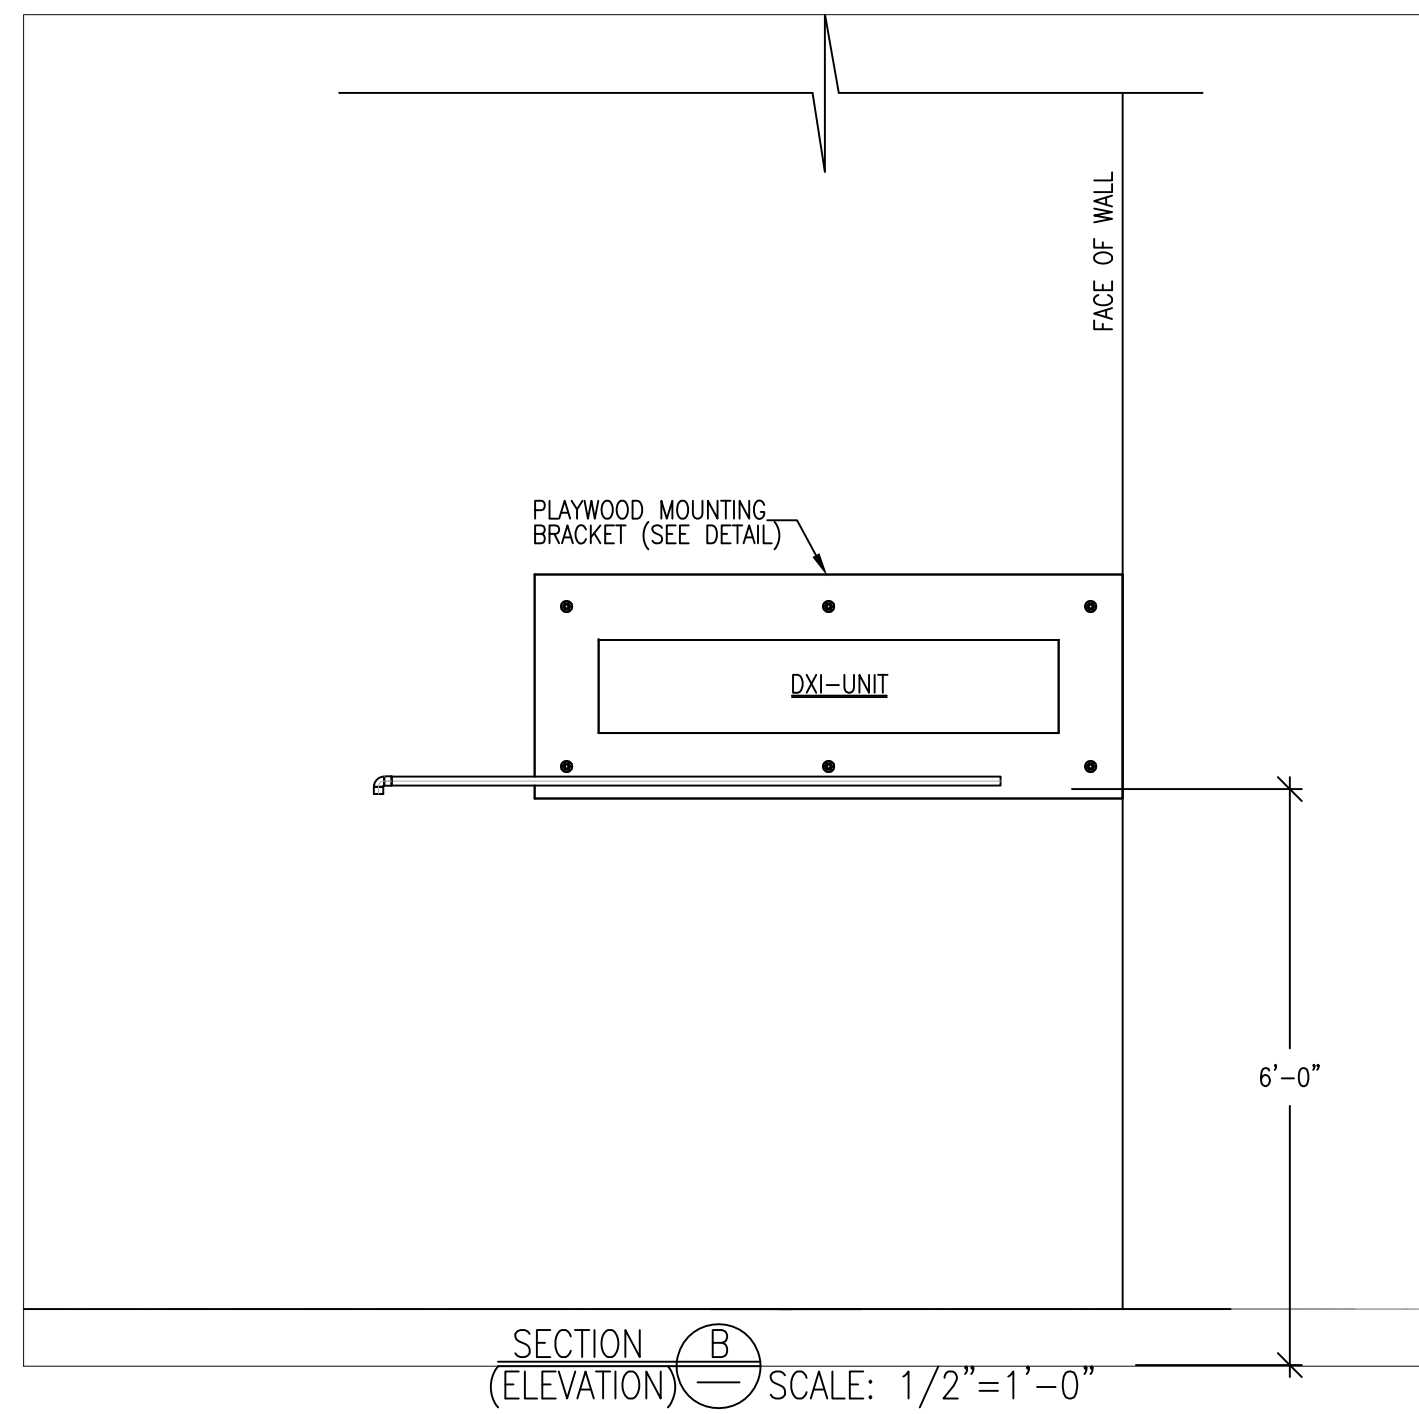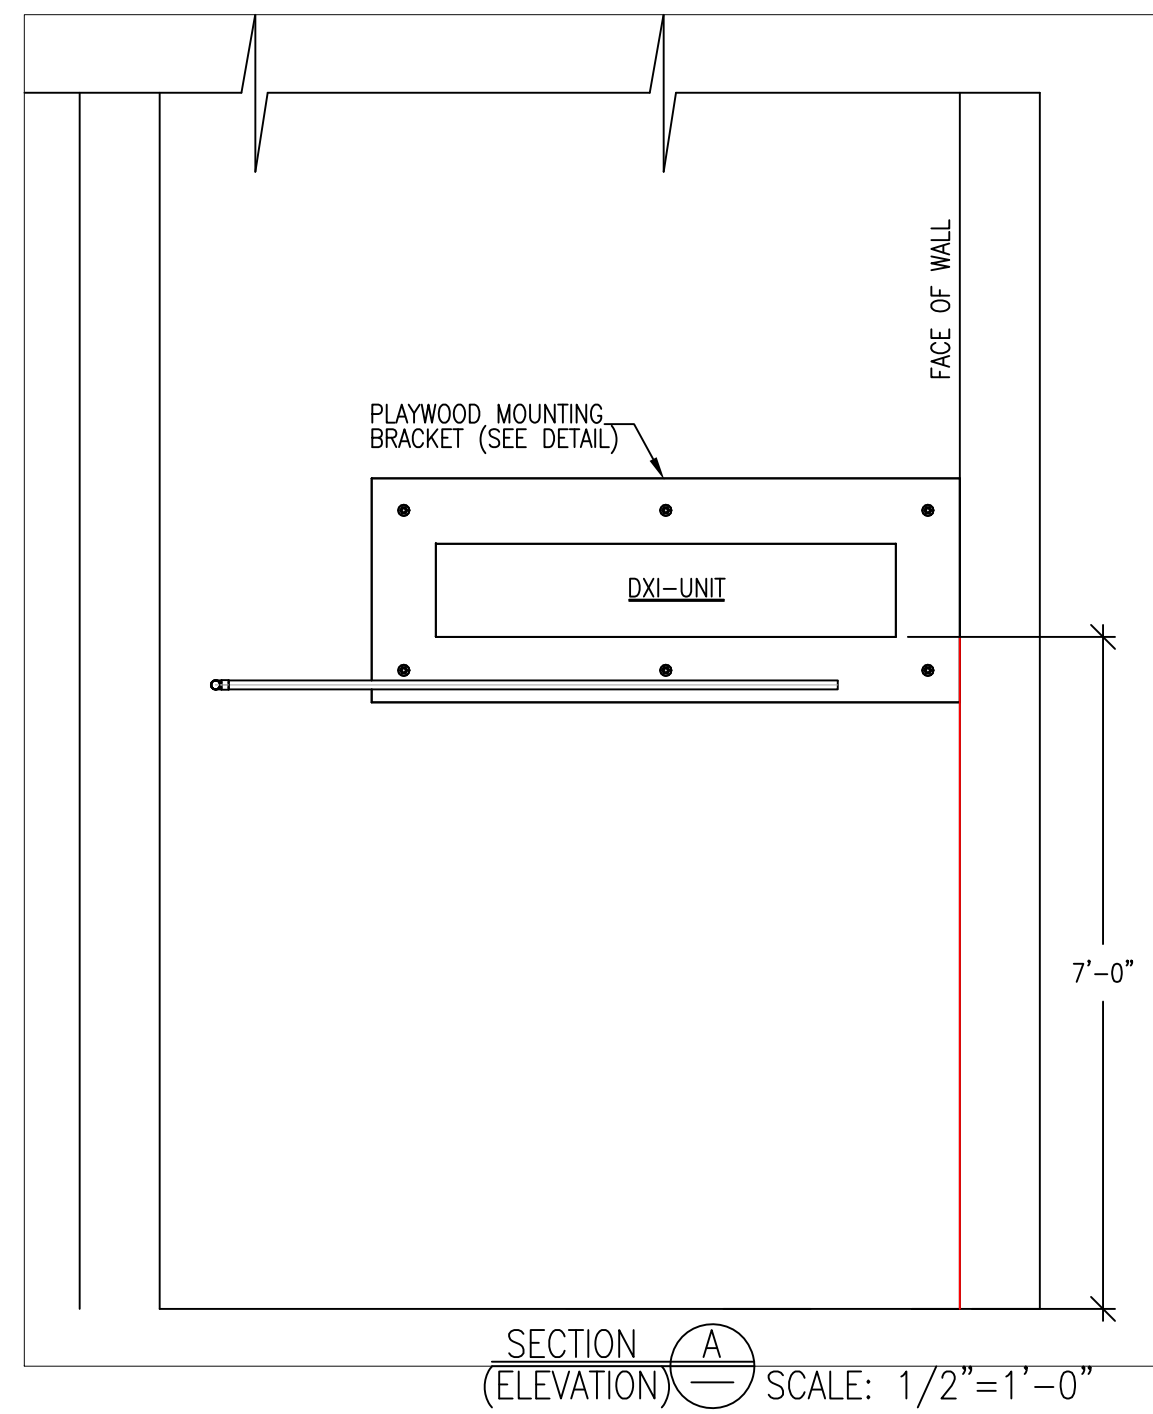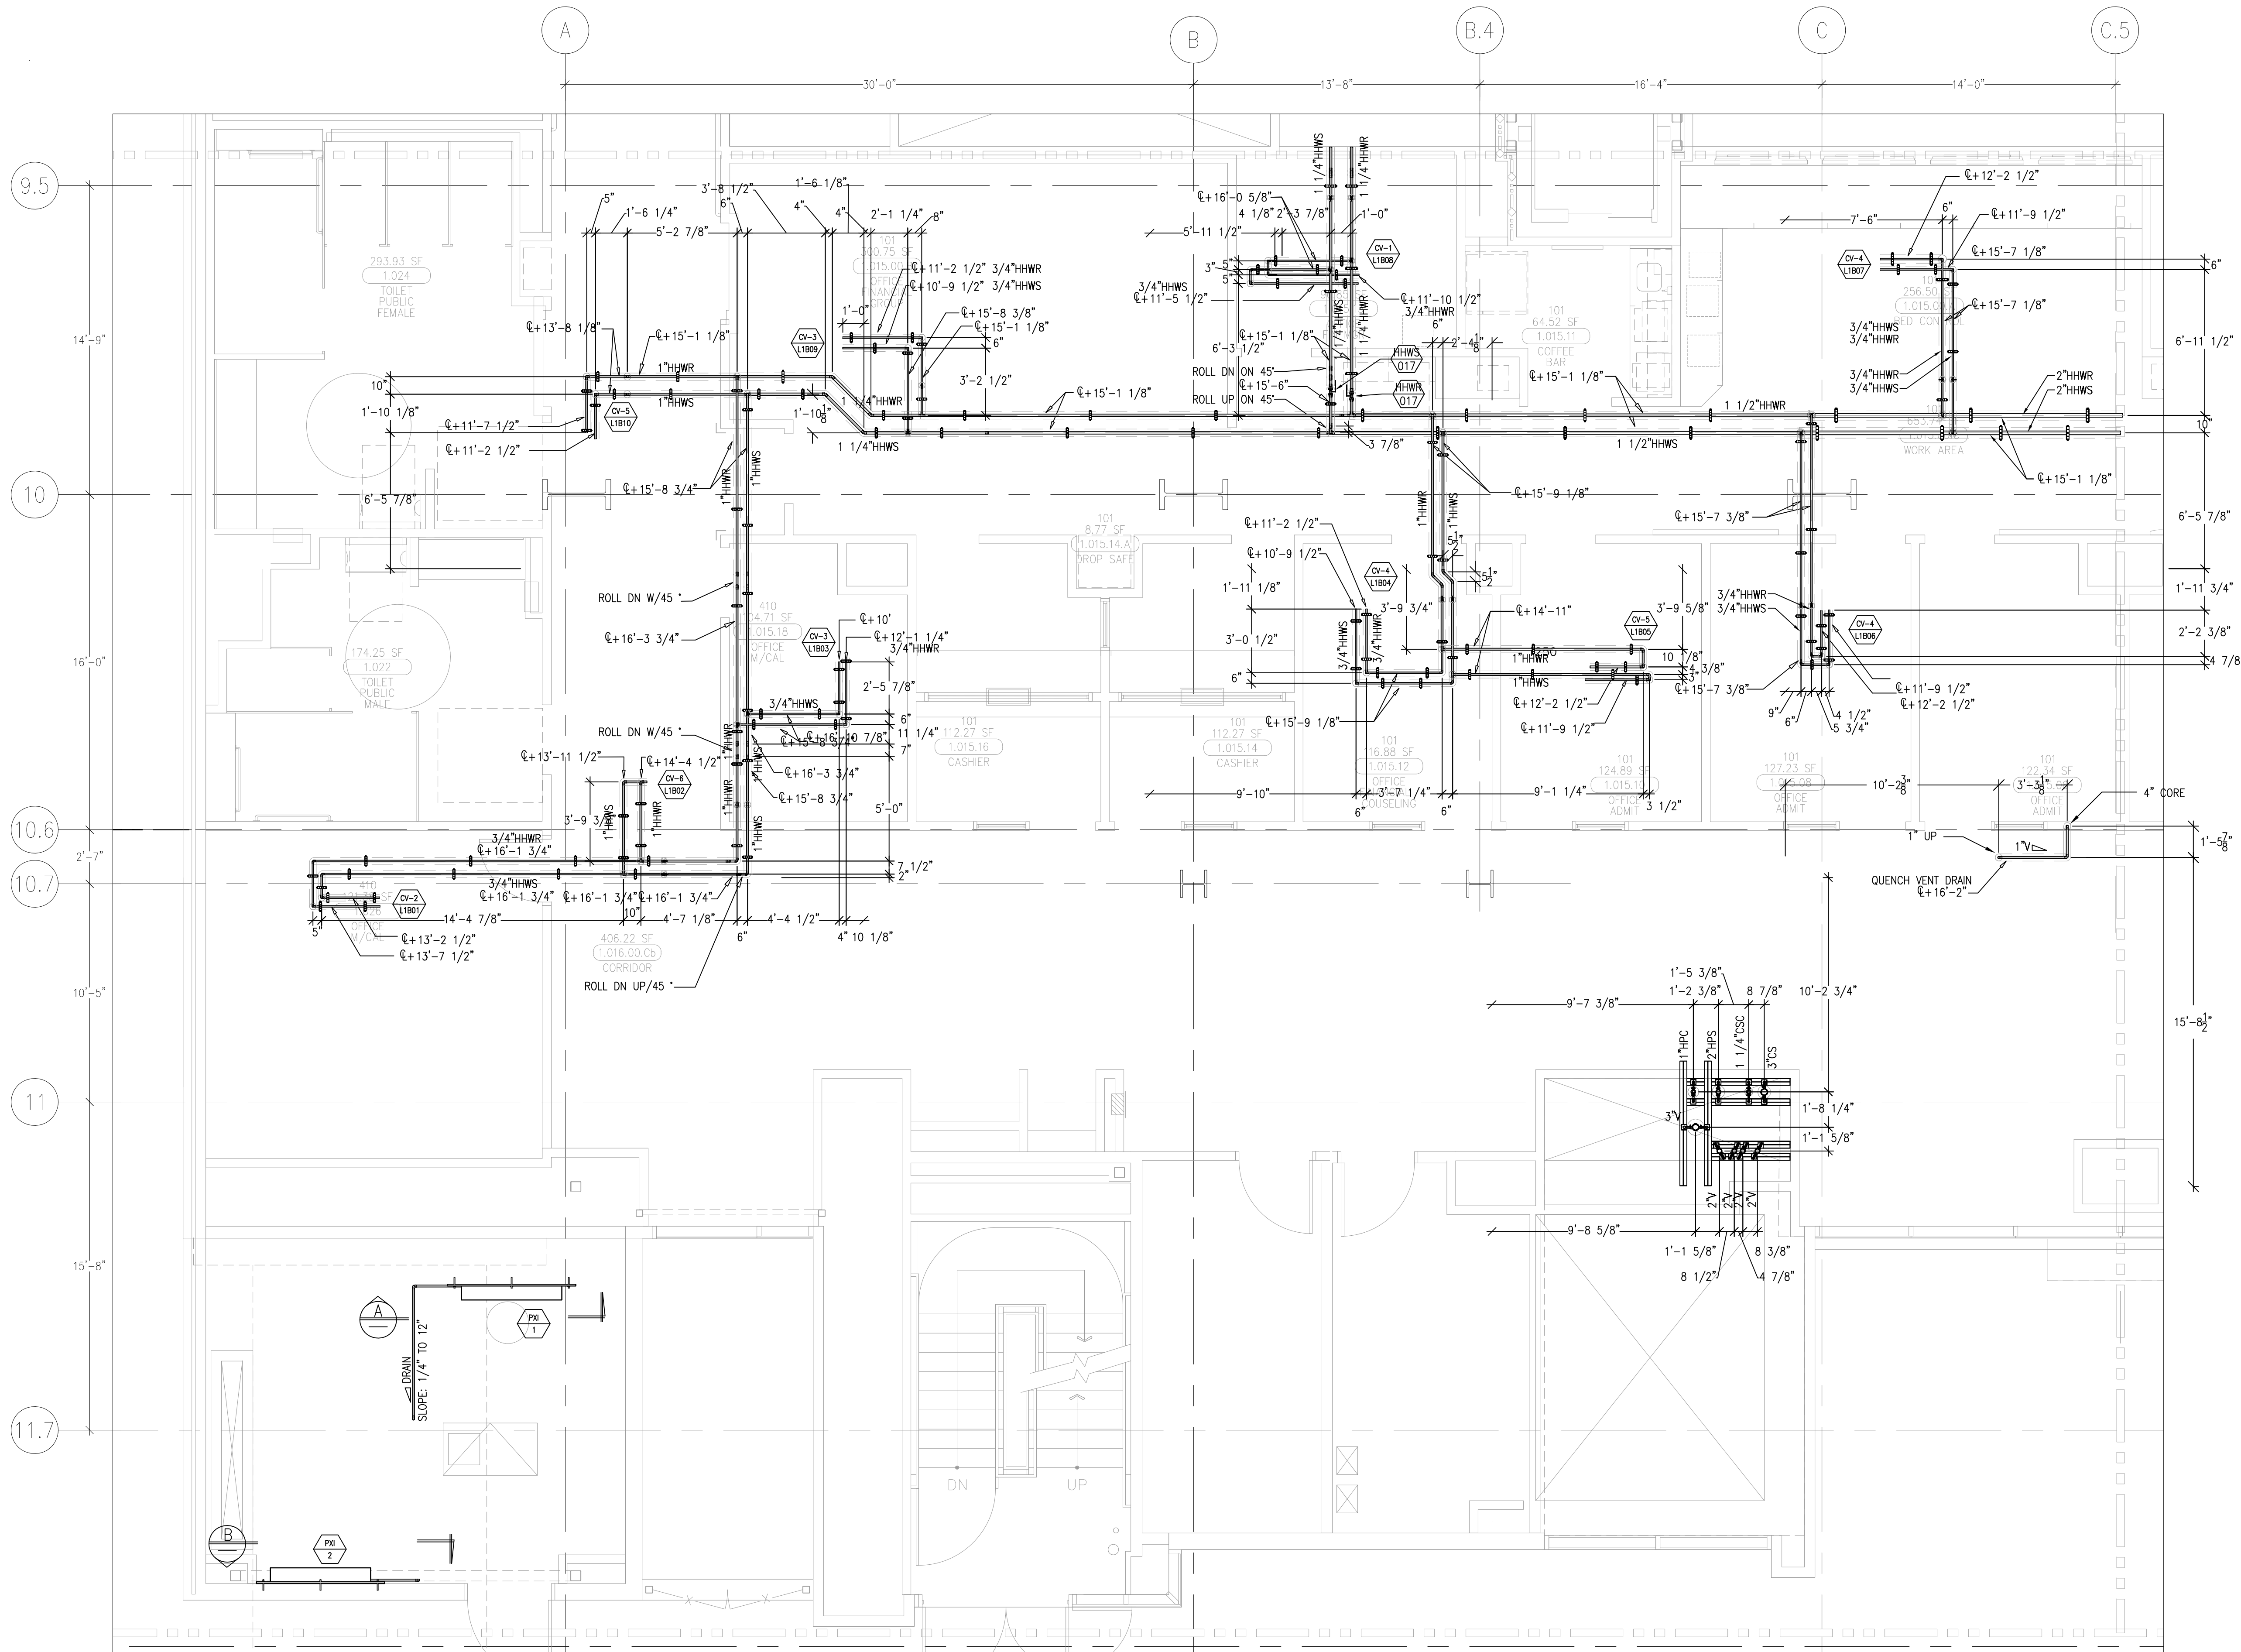

AS-BUILTS
DATE: 6-18-12 BY: J. CLINTON

LEVEL 01 161.30' = 0'-0"
REFERENCE THIS SHEET

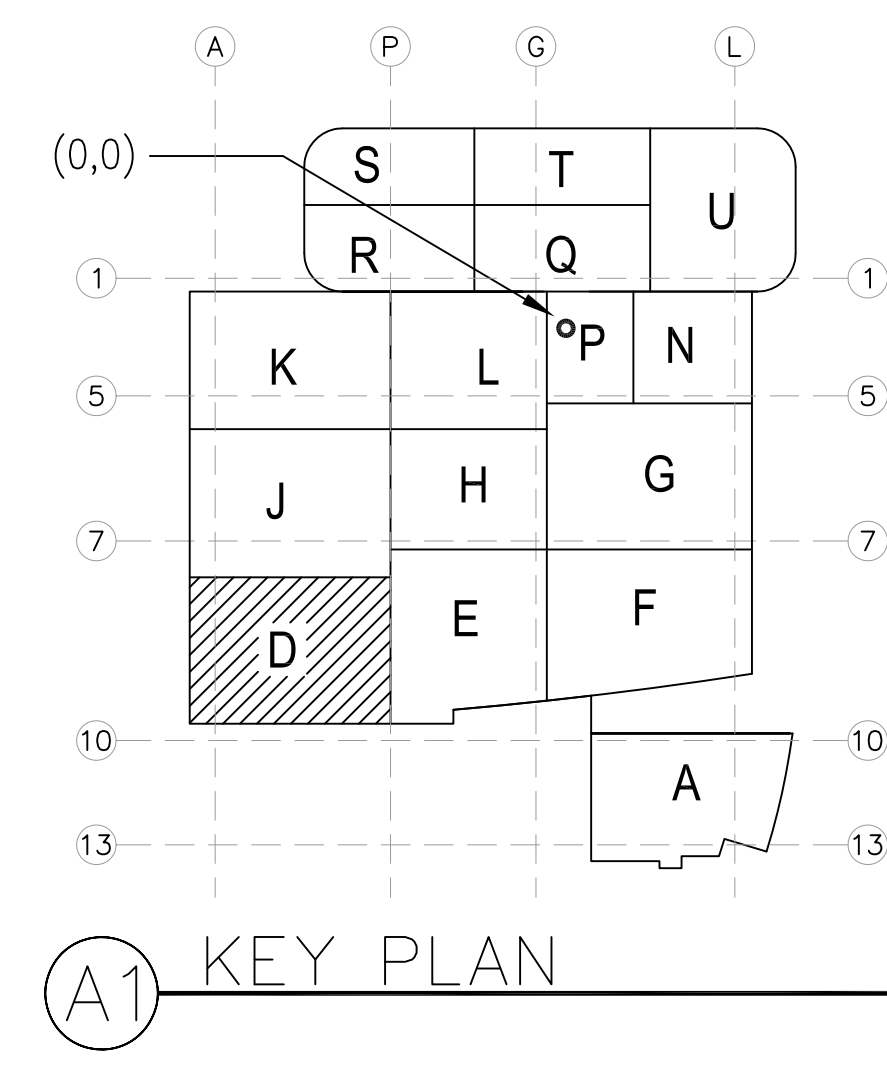

REVISIONS	BY

COORD.	SIGNATURE	DATE
MECHANICAL		
ELECTRICAL		
PLUMBING		
STRUCTURAL		


ANS.	SENT	R.F.I.	ANS.	SENT	R.F.I.	ANS.	SENT	R.F.I.	ANS.	SENT	R.F.I.

CHILDREN'S HOSPITAL
OF ORANGE COUNTY
455 S. MAIN ST., SUITE 200
ORANGE, CA 92668-3974
TOWER II
MECH PIPE FLOOR PLAN - LEVEL 01 AREAD


PAN-PACIFIC
PLUMBING & MECHANICAL
2919 E. VICTORIA STREET, RANCHO DOMINGUEZ, CA 90221
PH. 310 637-1500 FAX 310 604-0359

DRAWN
SB
CHECKED
M.M.
DATE
9/4/2012
SCALE
1/4"=1'-0"
JOB NO.
09-006
DRAWING NUMBER
MP3.1D
REFERENCE DRAWING
A3.1D
P3.1D
1 OF 1 SHEETS


This document and the design it covers are the property of Murray Co. They are loaned only with the borrower's expressed written agreement that they will not be reproduced, copied, loaned, exhibited, or used in any way, except by written consent from Murray Co. to the borrower.

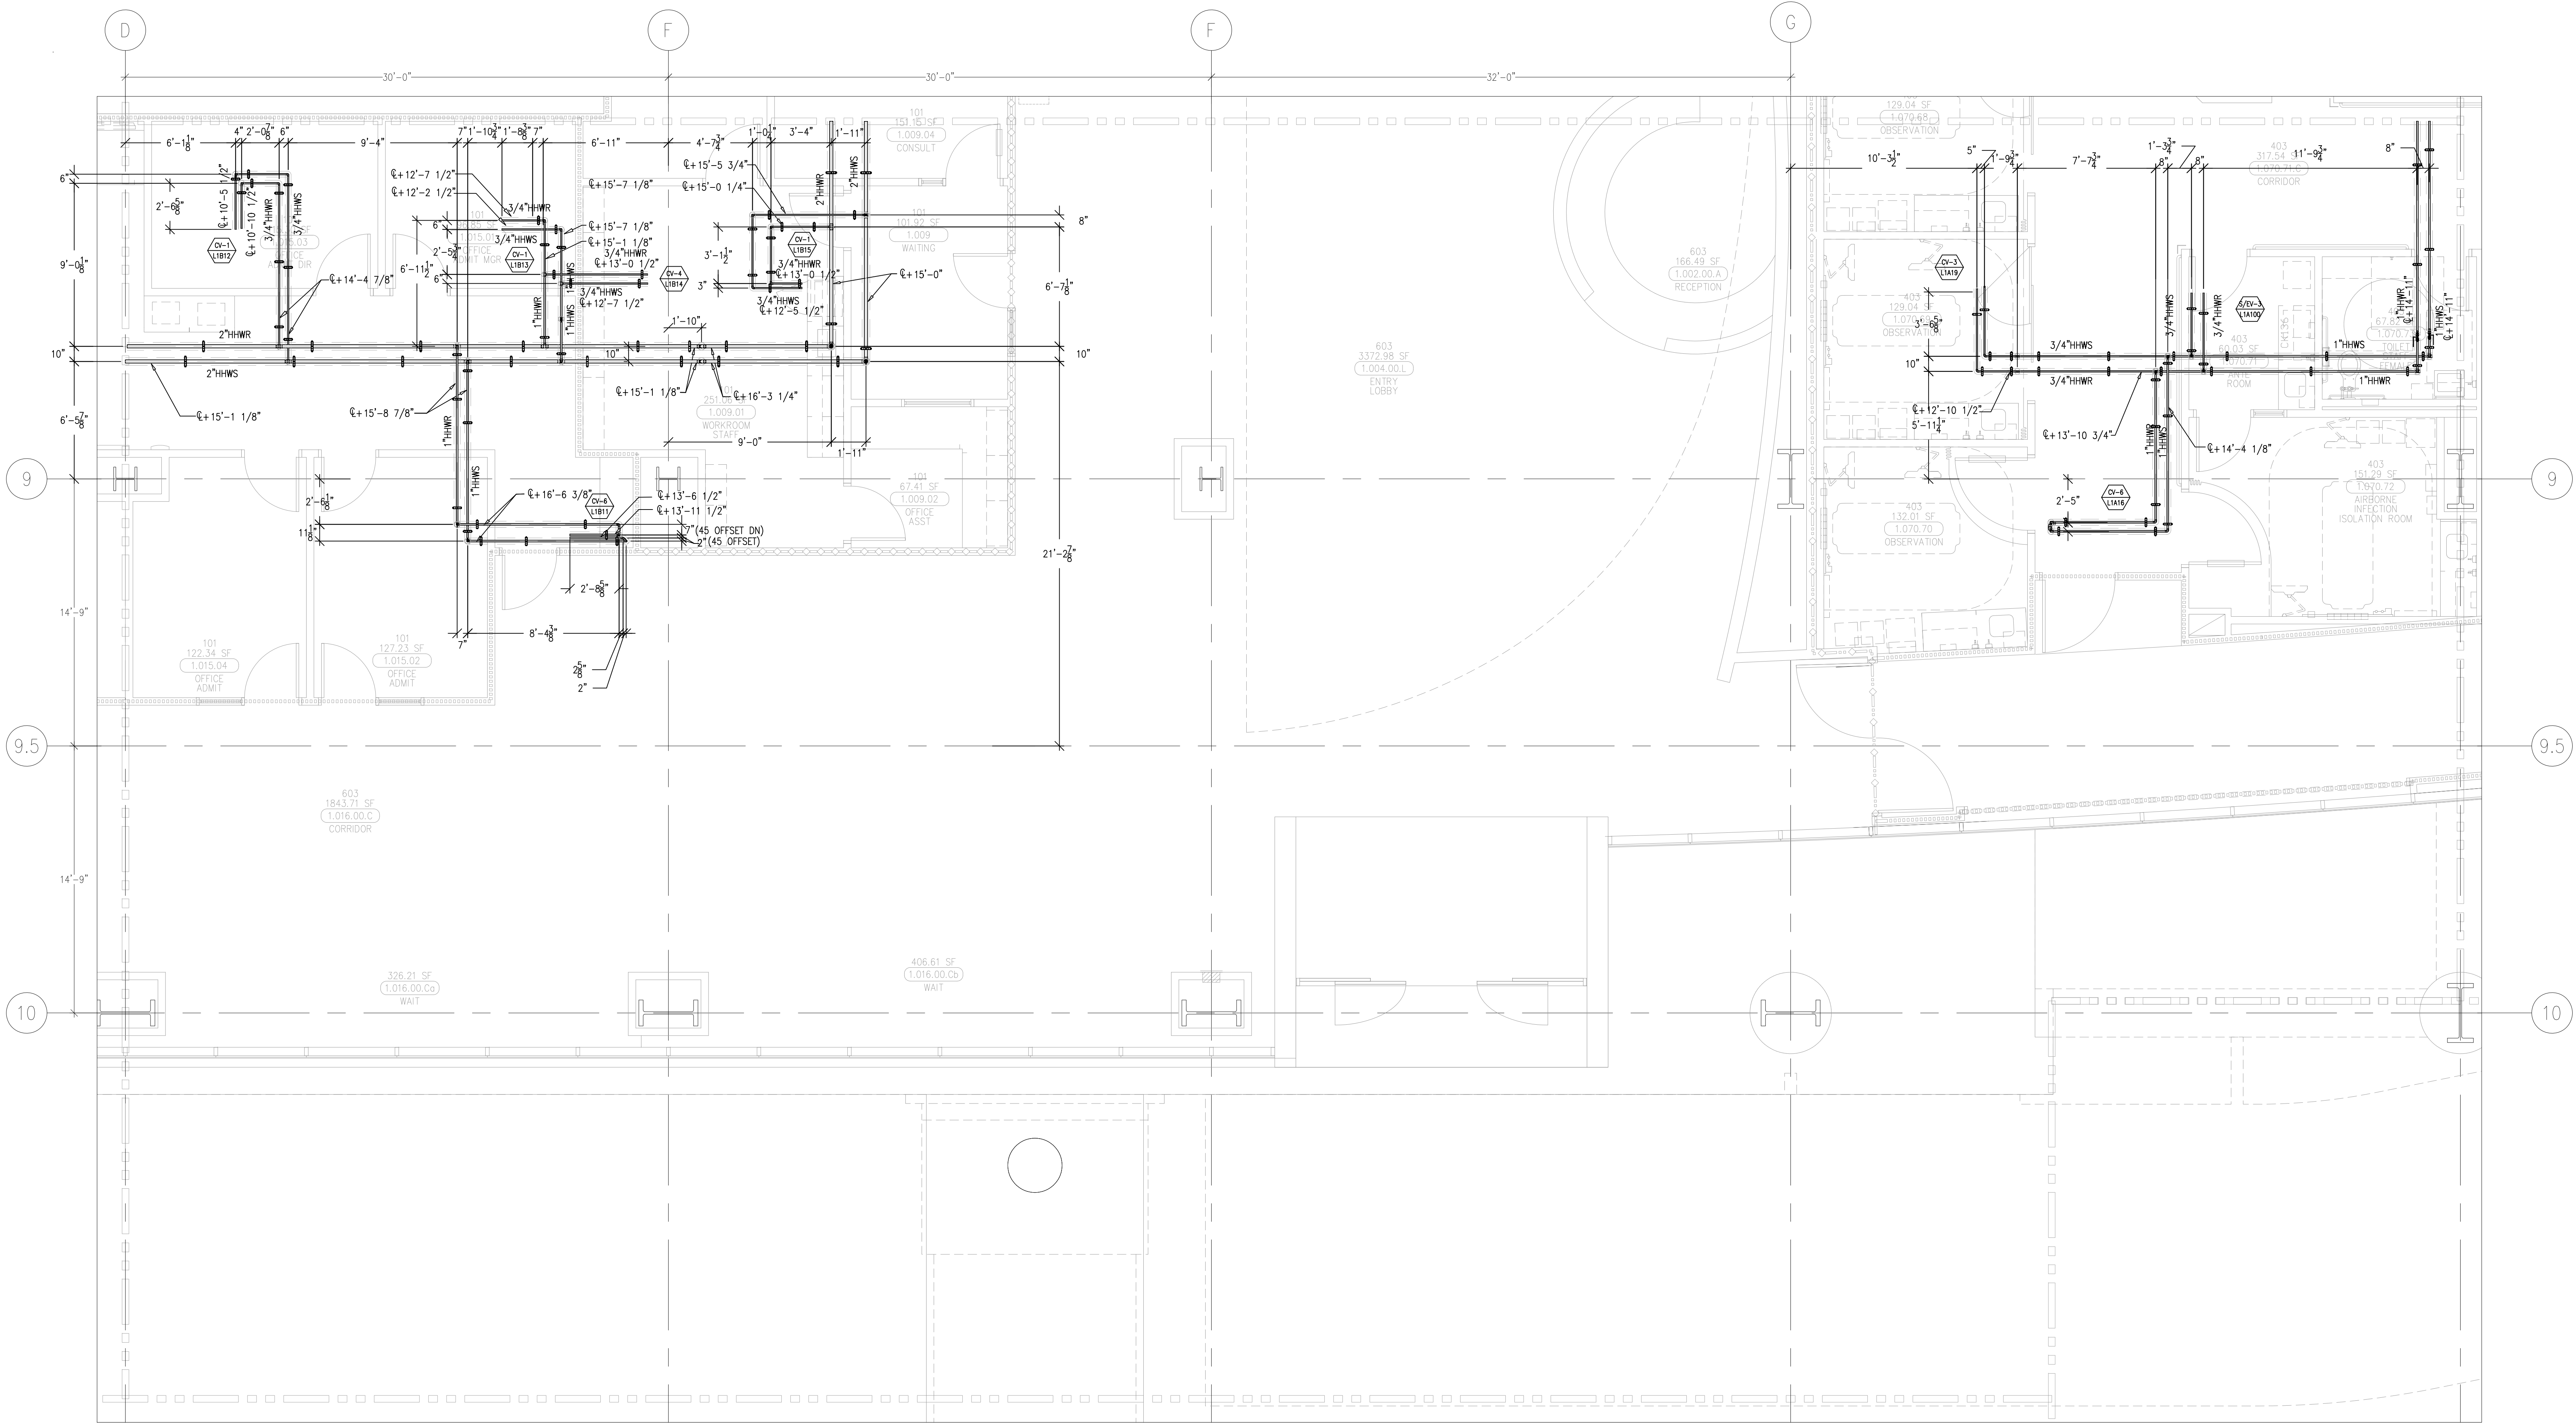

LEVEL 01 161.30' = 0'-0"
REFERENCE THIS SHEET

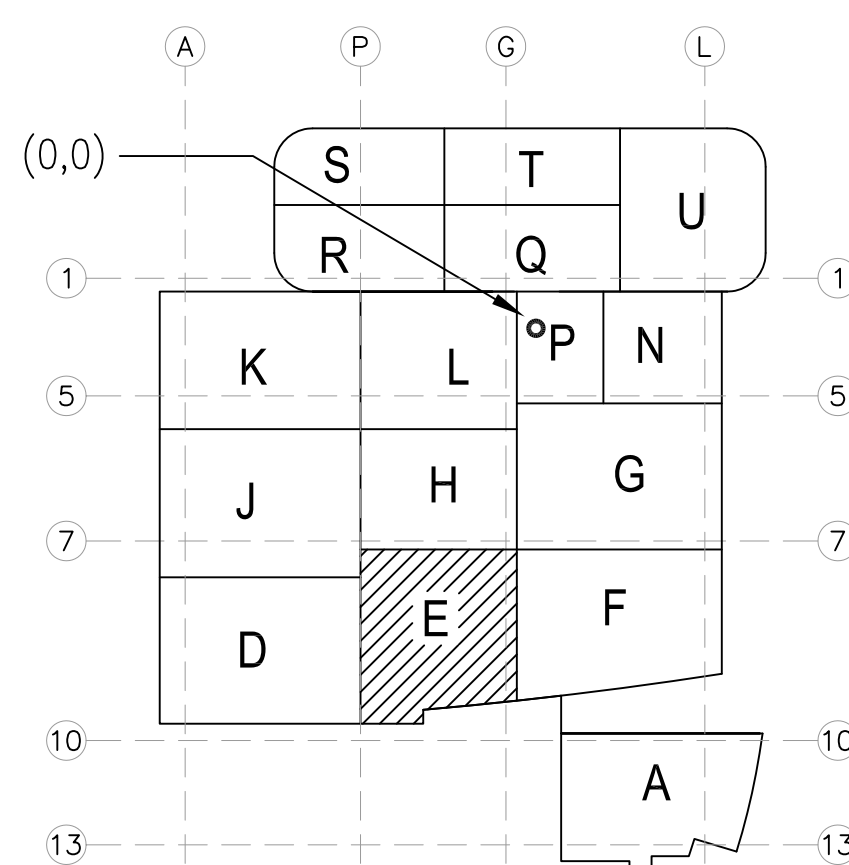


This document and the design it covers are the property of Murray Co. They are loaned only with the borrower's expressed written agreement that they will not be reproduced, copied, loaned, exhibited, or used in any other way, except by written consent from Murray Co. to the borrower.

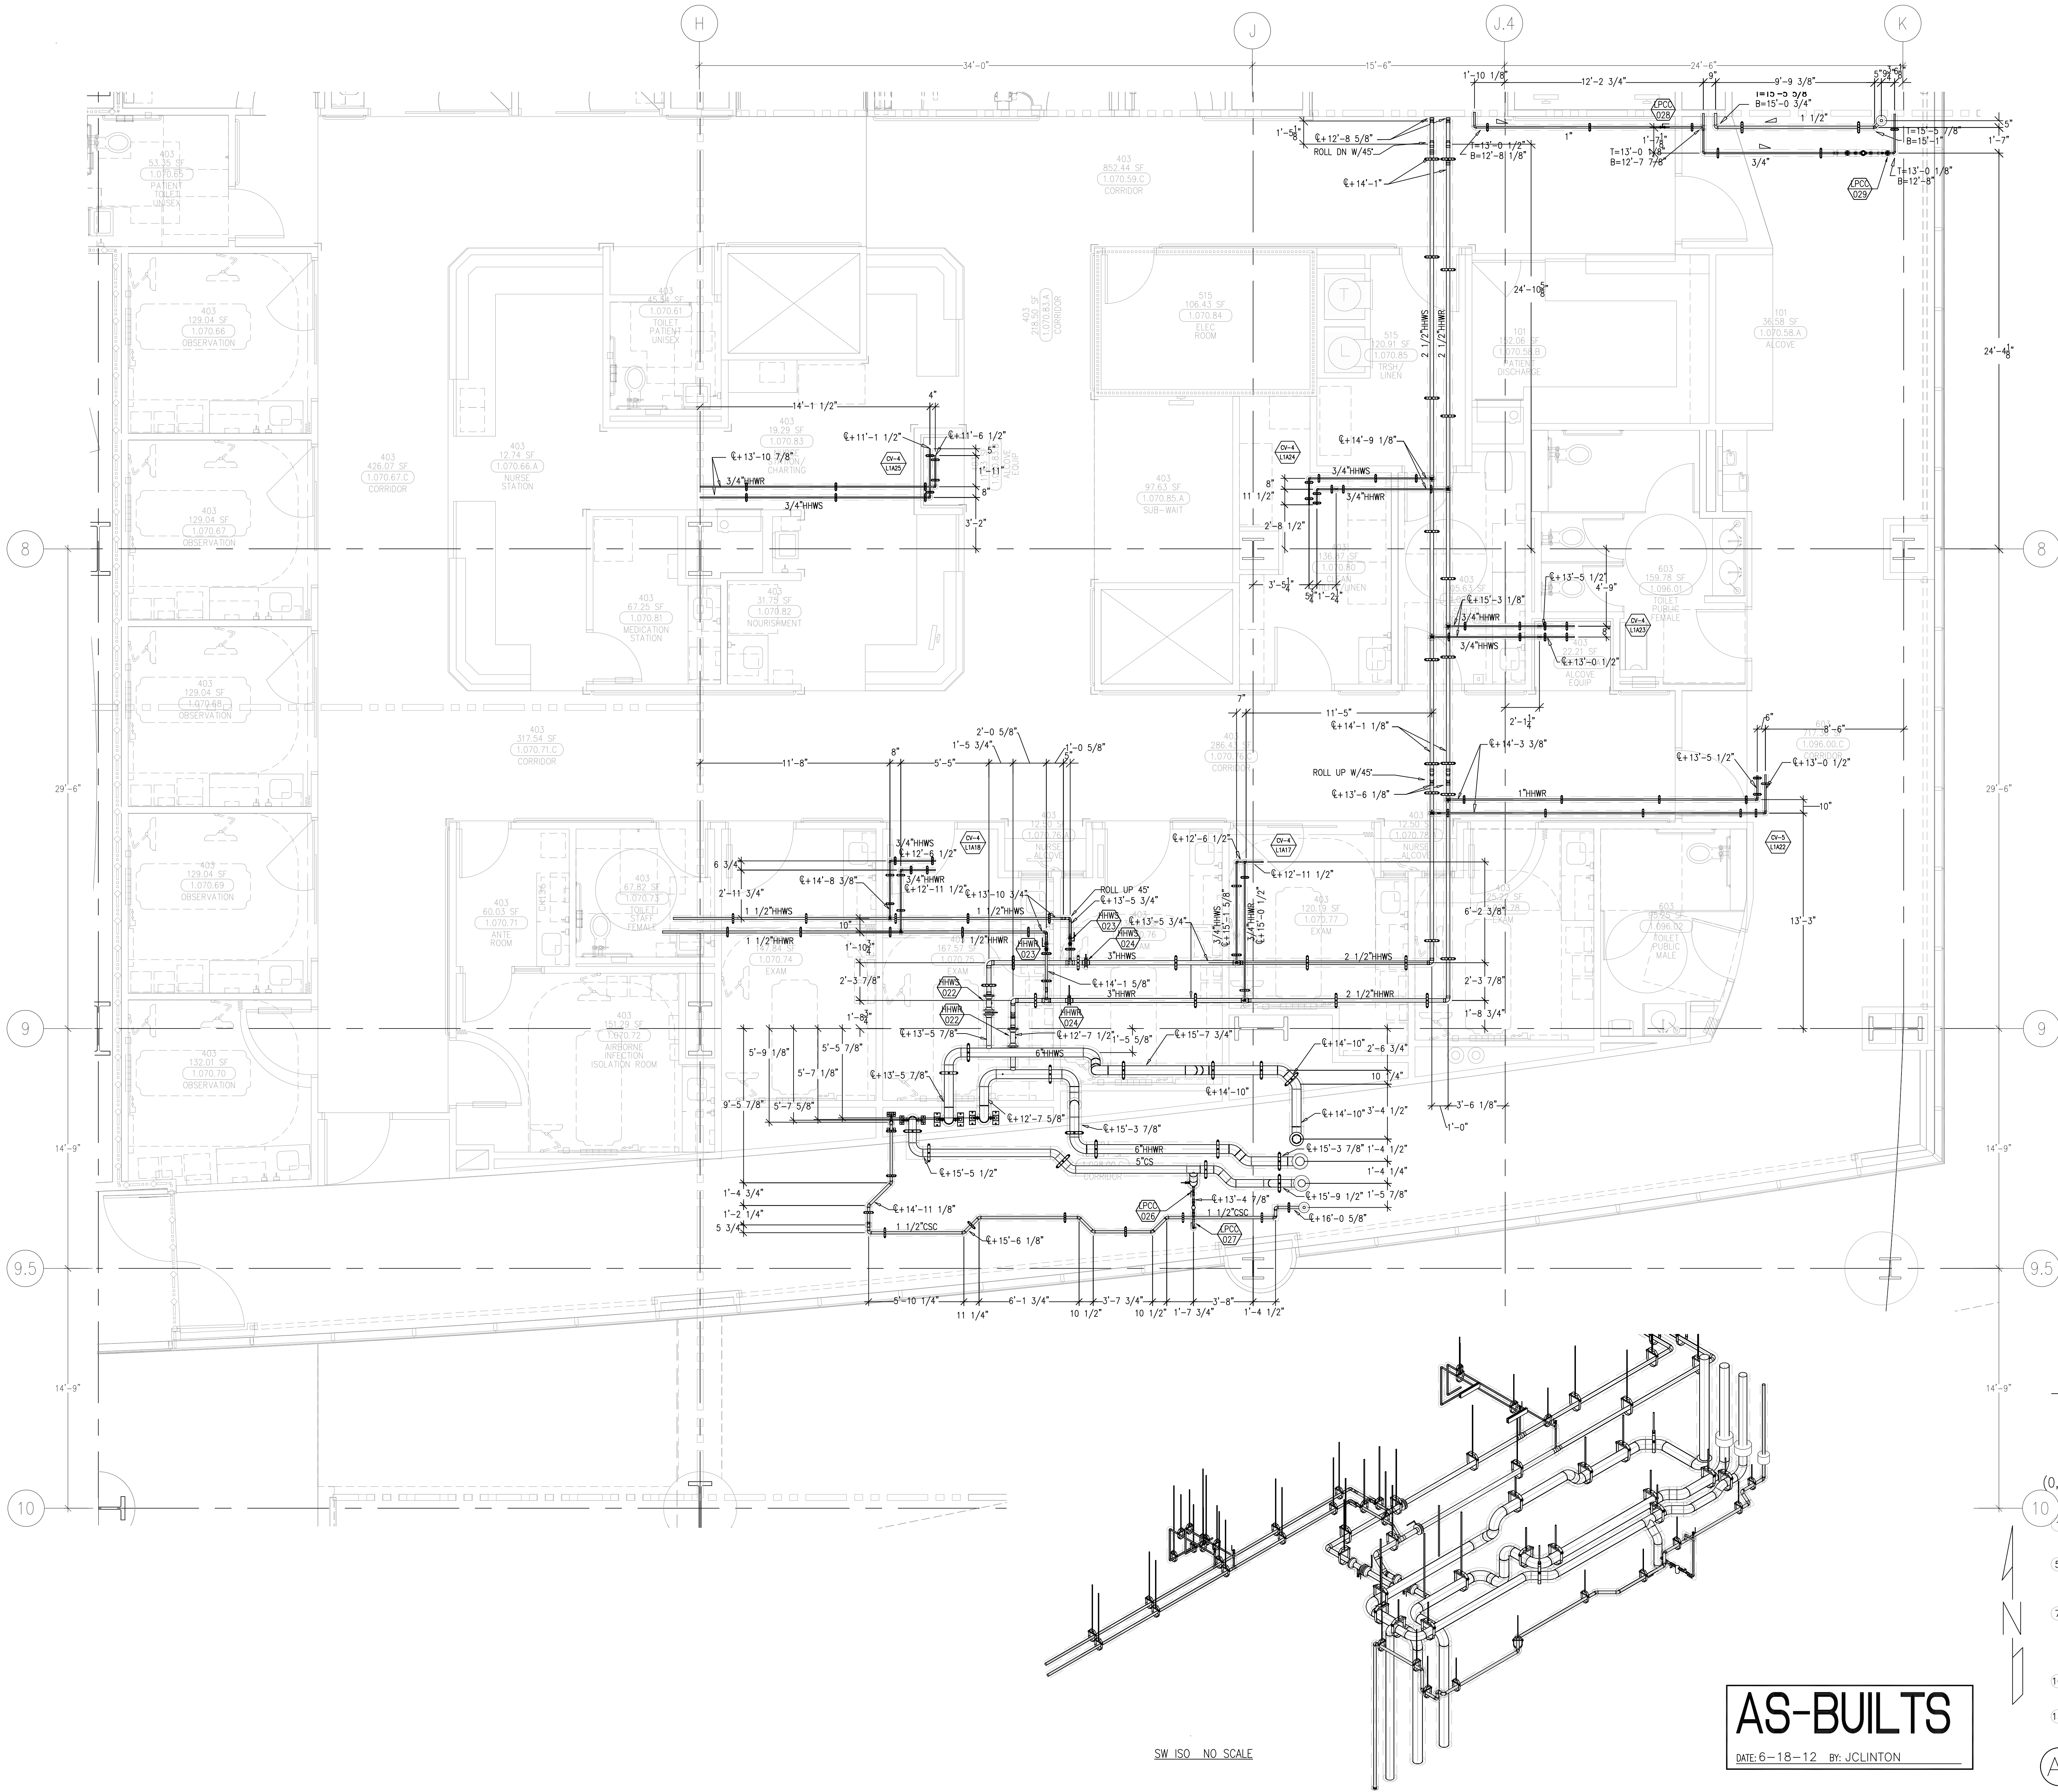

AS-BUILTS

DATE: 6-18-12 BY: JCLINTON

LEVEL 01 161.30' = 0'-0"
REFERENCE THIS SHEET

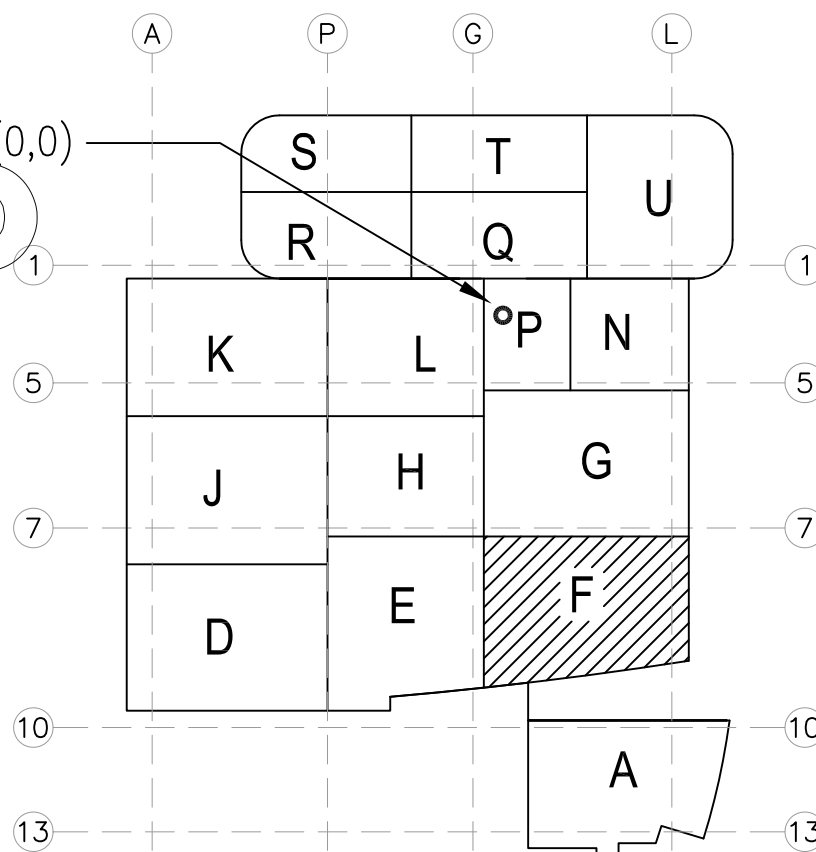

KEY PLAN

REVISIONS	BY

COORD.	SIGNATURE	DATE
MECHANICAL		
MECHANICAL		
MECHANICAL		
ELECTRICAL		
FIRE SPRINKLER		
PLUMB		
DRYWALL/FRAME		
REPAIR/REPLACE		
STRUCTURAL		

ANS.	SENT	R.F.I.	ANS.	SENT	R.F.I.	ANS.	SENT	R.F.I.	ANS.	SENT	R.F.I.


CHILDREN'S HOSPITAL
OF ORANGE COUNTY
455 S. MAIN ST., ORANGE, CA 92668-9874
TOWER II
MECHANICAL PIPE FLOOR PLAN - LEVEL 01 AREA F

Pan-Pacific
PLUMBING & MECHANICAL
2919 E. VICTORIA STREET, RANCHO DOMINGUEZ, CA 90221
PH. 310 637-1500 FAX 310 604-0359

DRAWN: SB
CHECKED: M.M.
DATE: 9/4/2012
SCALE: 1/4"=1'-0"
JOB NO.: 09-006
DRAWING NUMBER: MP3.1F
REFERENCE DRAWING: A3.1F, P3.1F
1 OF 1 SHEETS

AS-BUILTS

DATE: 6-18-12 BY: J.CLINTON

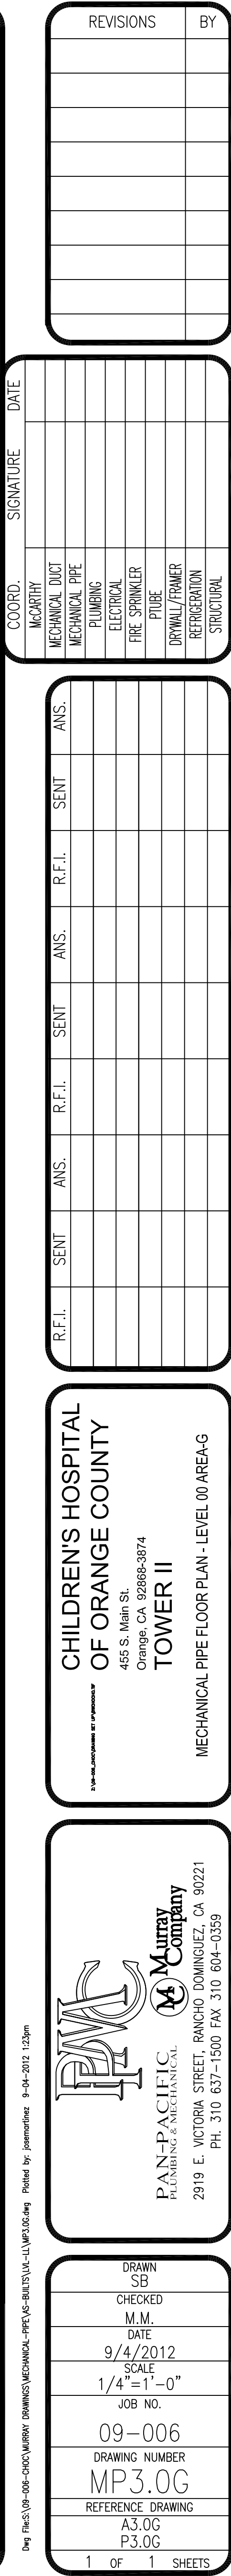

AS-BUILTS

DATE: 6-18-12 BY: J. CLINTON


LEVEL 01 161.30' = 0'-0"

REFERENCE THIS SHEET

KEY PLAN


DRAWN
SB
CHECKED
M.M.
DATE
9/4/2012
SCALE
1/4"=1'-0"
JOB NO.
09-006
DRAWING NUMBER
MPL3.1H
REFERENCE DRAWING
A3.1H
P3.1H
1 OF 1 SHEETS

This document and the design it covers are the property of Murray Co. They are loaned only with the borrowers' expressed agreement that they will not be reproduced, copied, loaned, exhibited, or used in any other way, except by written consent from Murray Co. to the borrower.

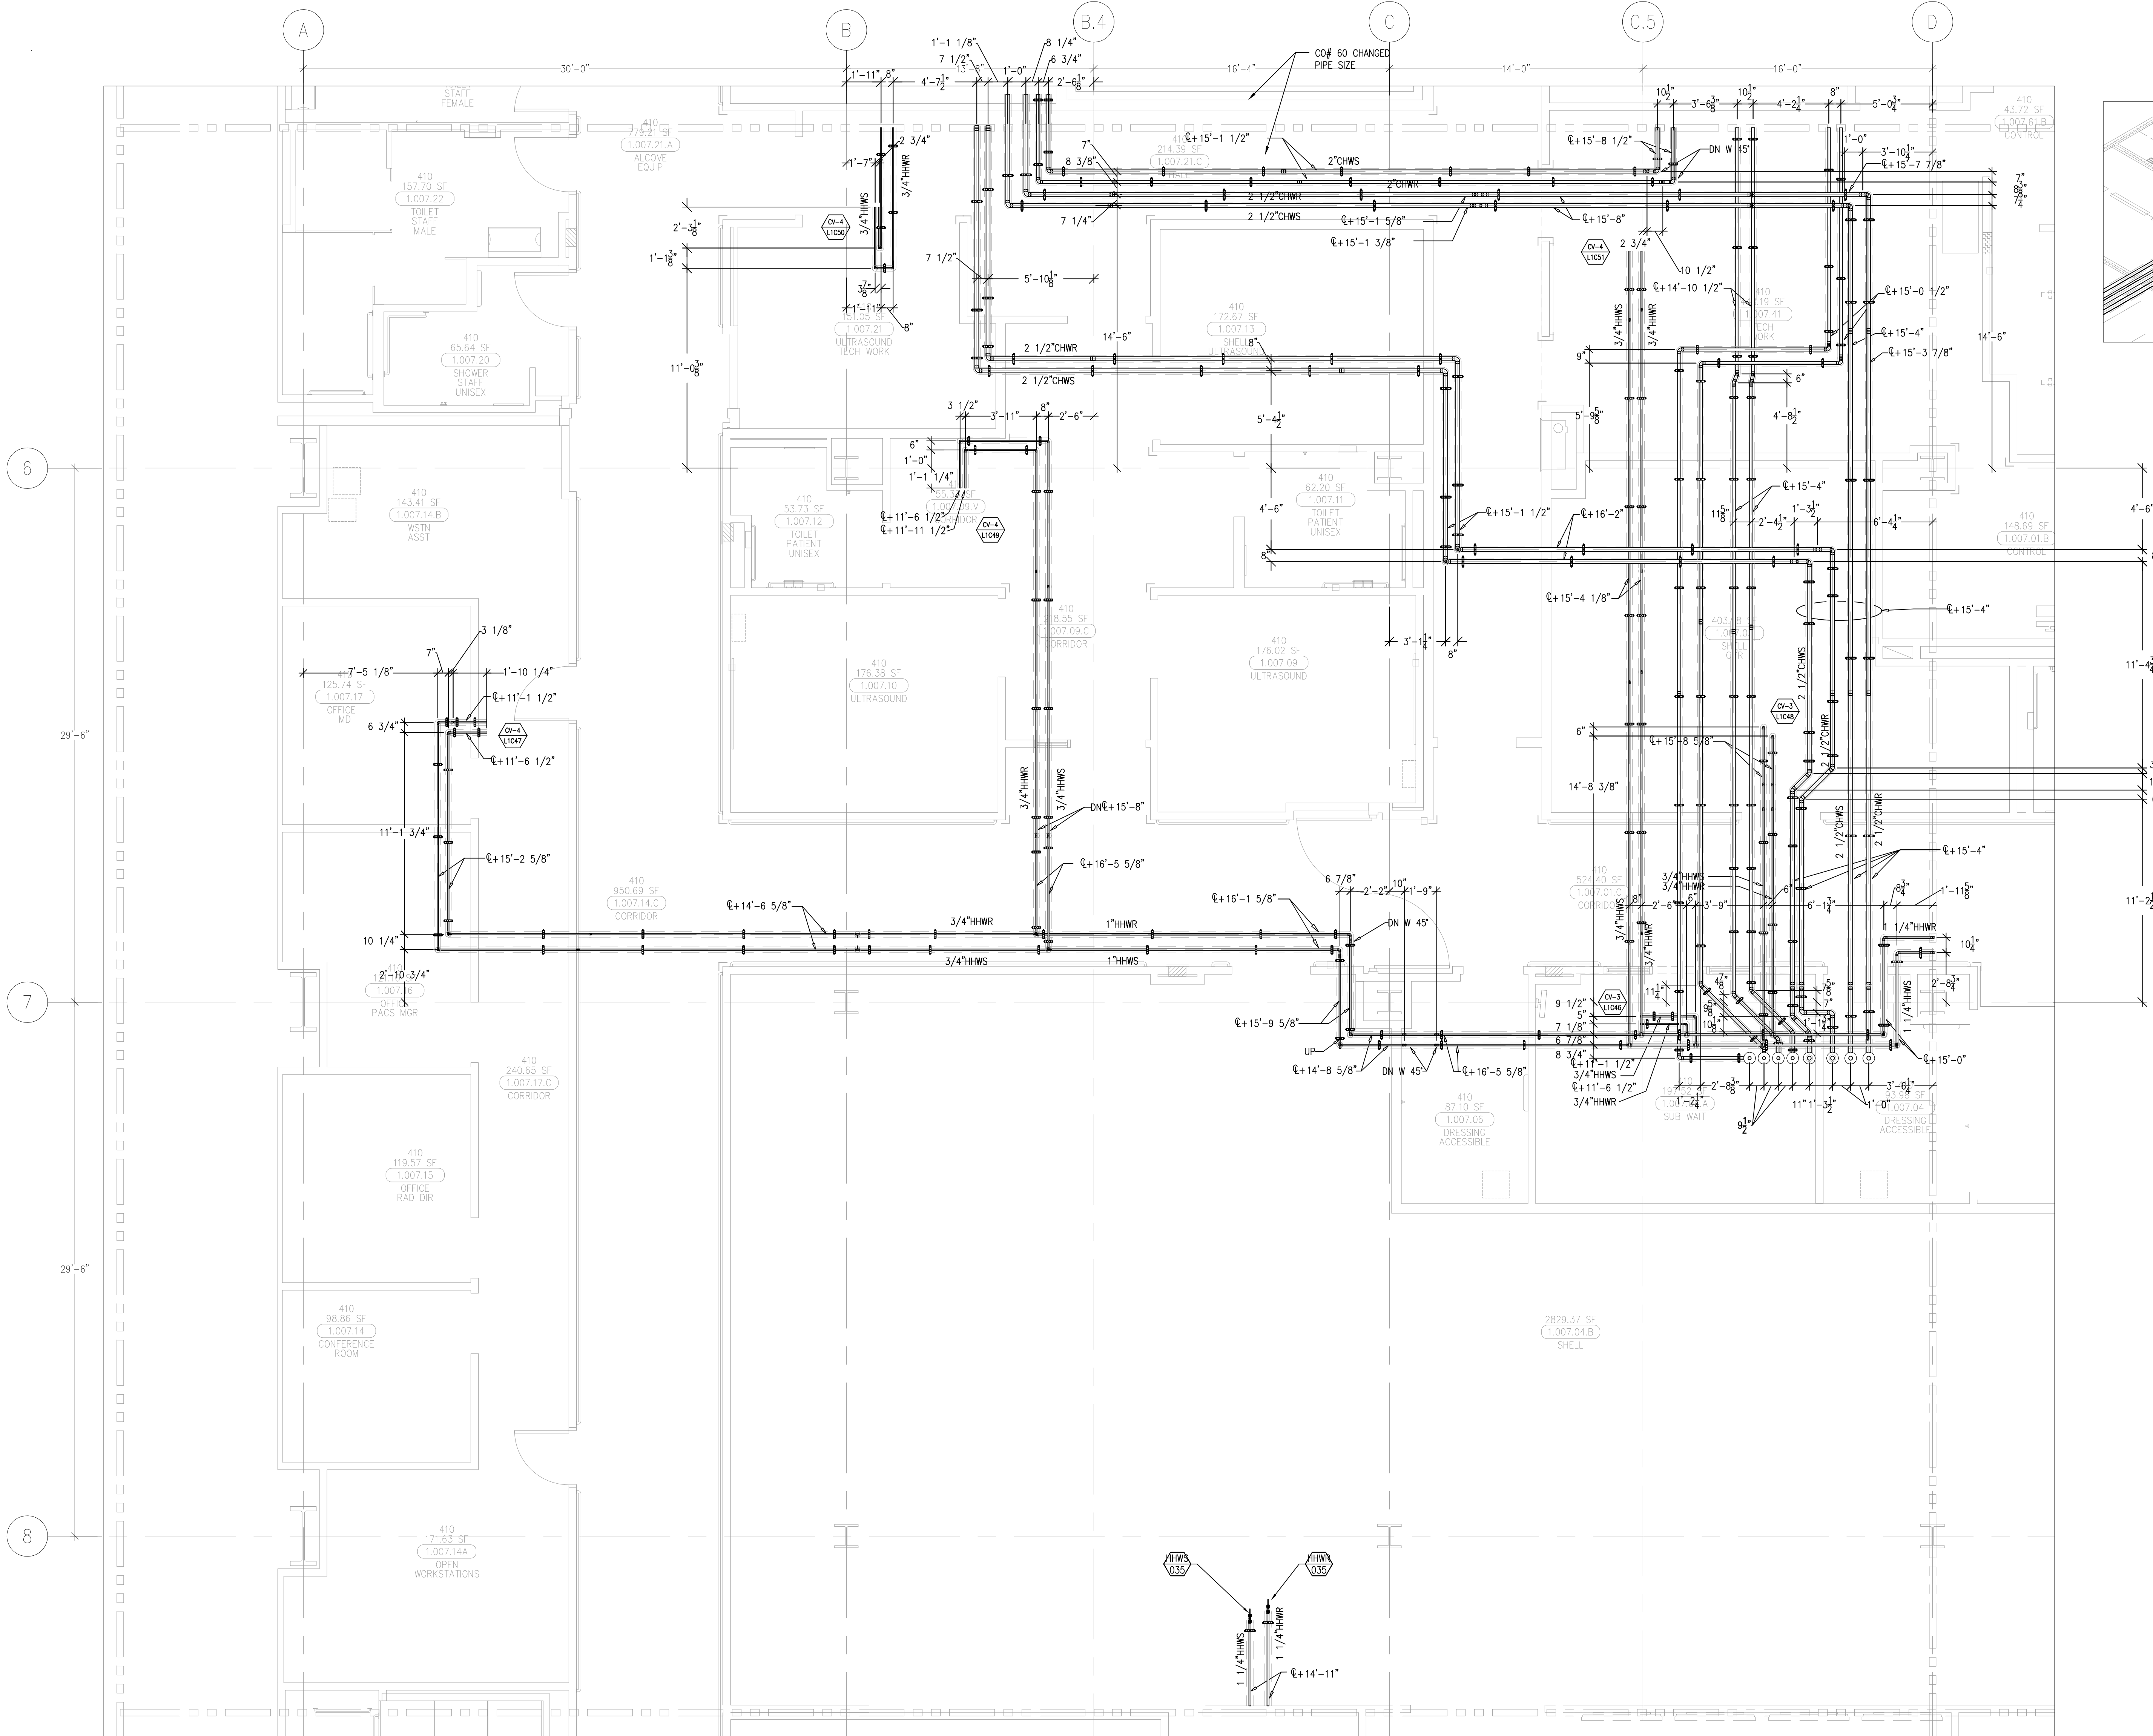


AS-BUILTS

DATE: 6-18-12 BY: J. CLINTON

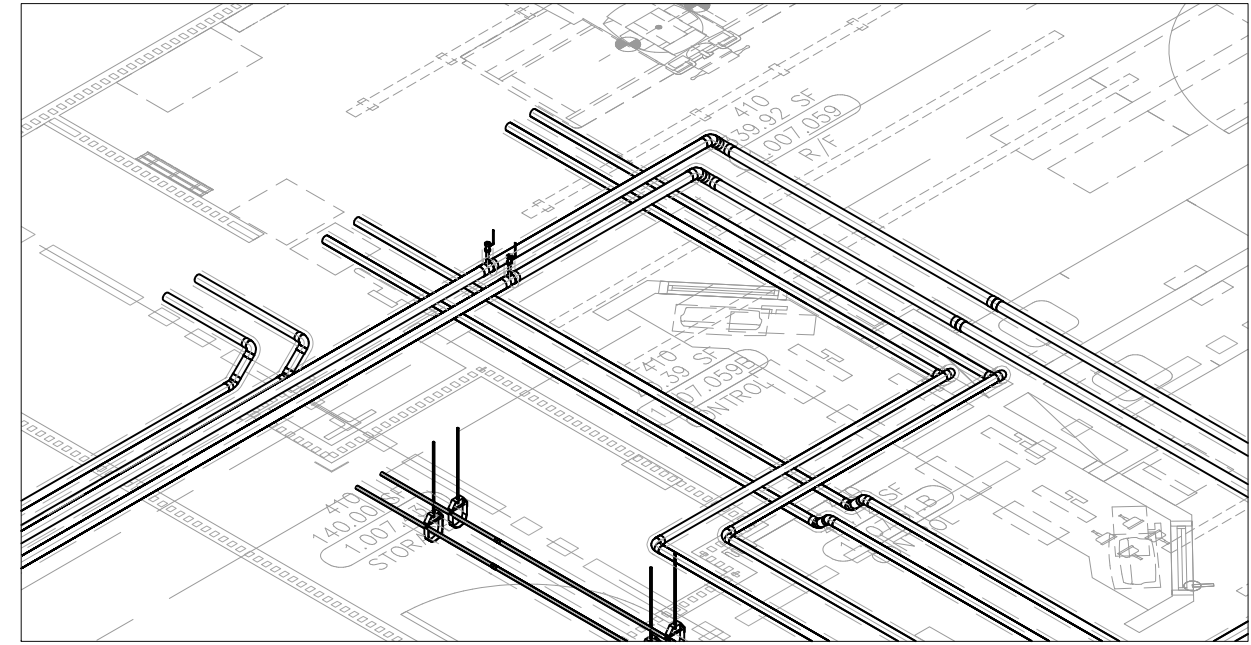

LEVEL 01 161.30' = 0'-0"
REFERENCE THIS SHEET

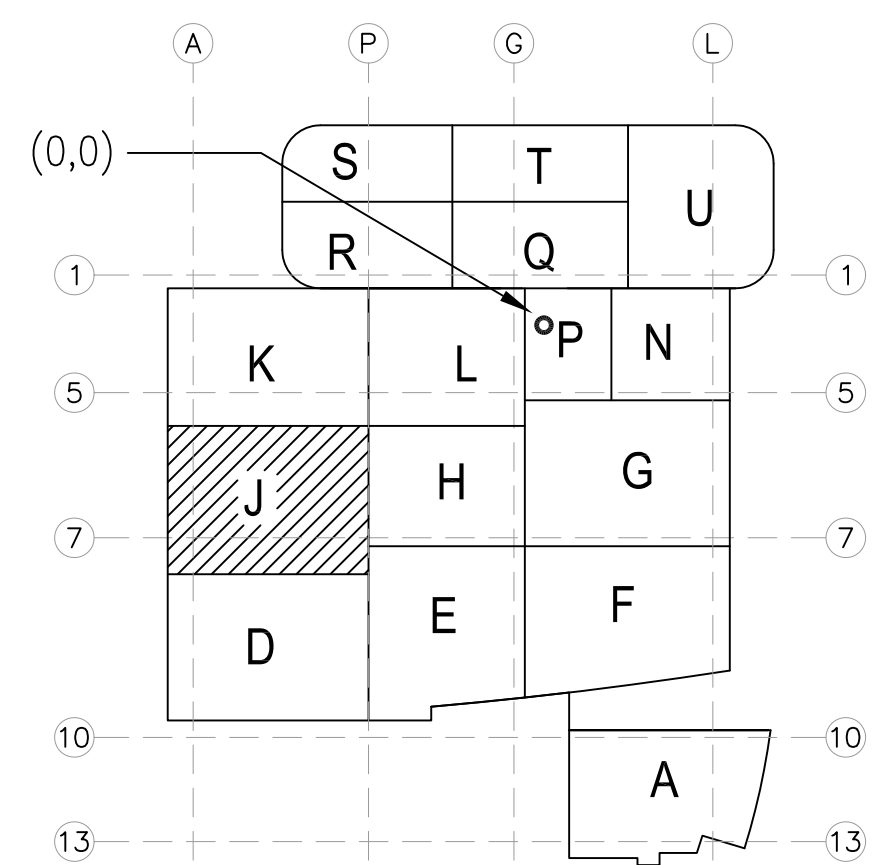

A1 KEY PLAN

[illegible]

MCCARTHY	
MECHANICAL DUCT	
MECHANICAL PIPE	
PLUMBING	
ELECTRICAL	
FIRE SPRINKLER	
PITING	
DRYWALL/FRAMER	
REFRIGERATION	
STRUCTURAL	

[illegible]

CHILDREN'S HOSPITAL
OF ORANGE COUNTY
455 S. Main St.
Orange, CA 92668-3874

TOWER II

MECHANICAL PIPE FLOOR PLAN - LEVEL 01 AREA J



PAN-PACIFIC
PLUMBING & MECHANICAL

 **Murray Company**

2919 E. VICTORIA STREET, RANCHO DOMINGUEZ, CA 90221
PH. 310 637-1500 FAX 310 604-0359


DRAWN J.M.
CHECKED M.M.
DATE 9/4/2012
SCALE 1/4"=1'-0"
JOB NO. 09-006
DRAWING NUMBER MP3.1J
REFERENCE DRAWING A3.1J P3.1J
1 OF 1 SHEETS

document and the design it covers are the property of Murray Co. They are loaned only with the borrowers' expressed agreement that they will not be reproduced, copied, loaned, exhibited, or used in any other way, except by written consent from Murray Co. to the borrower.

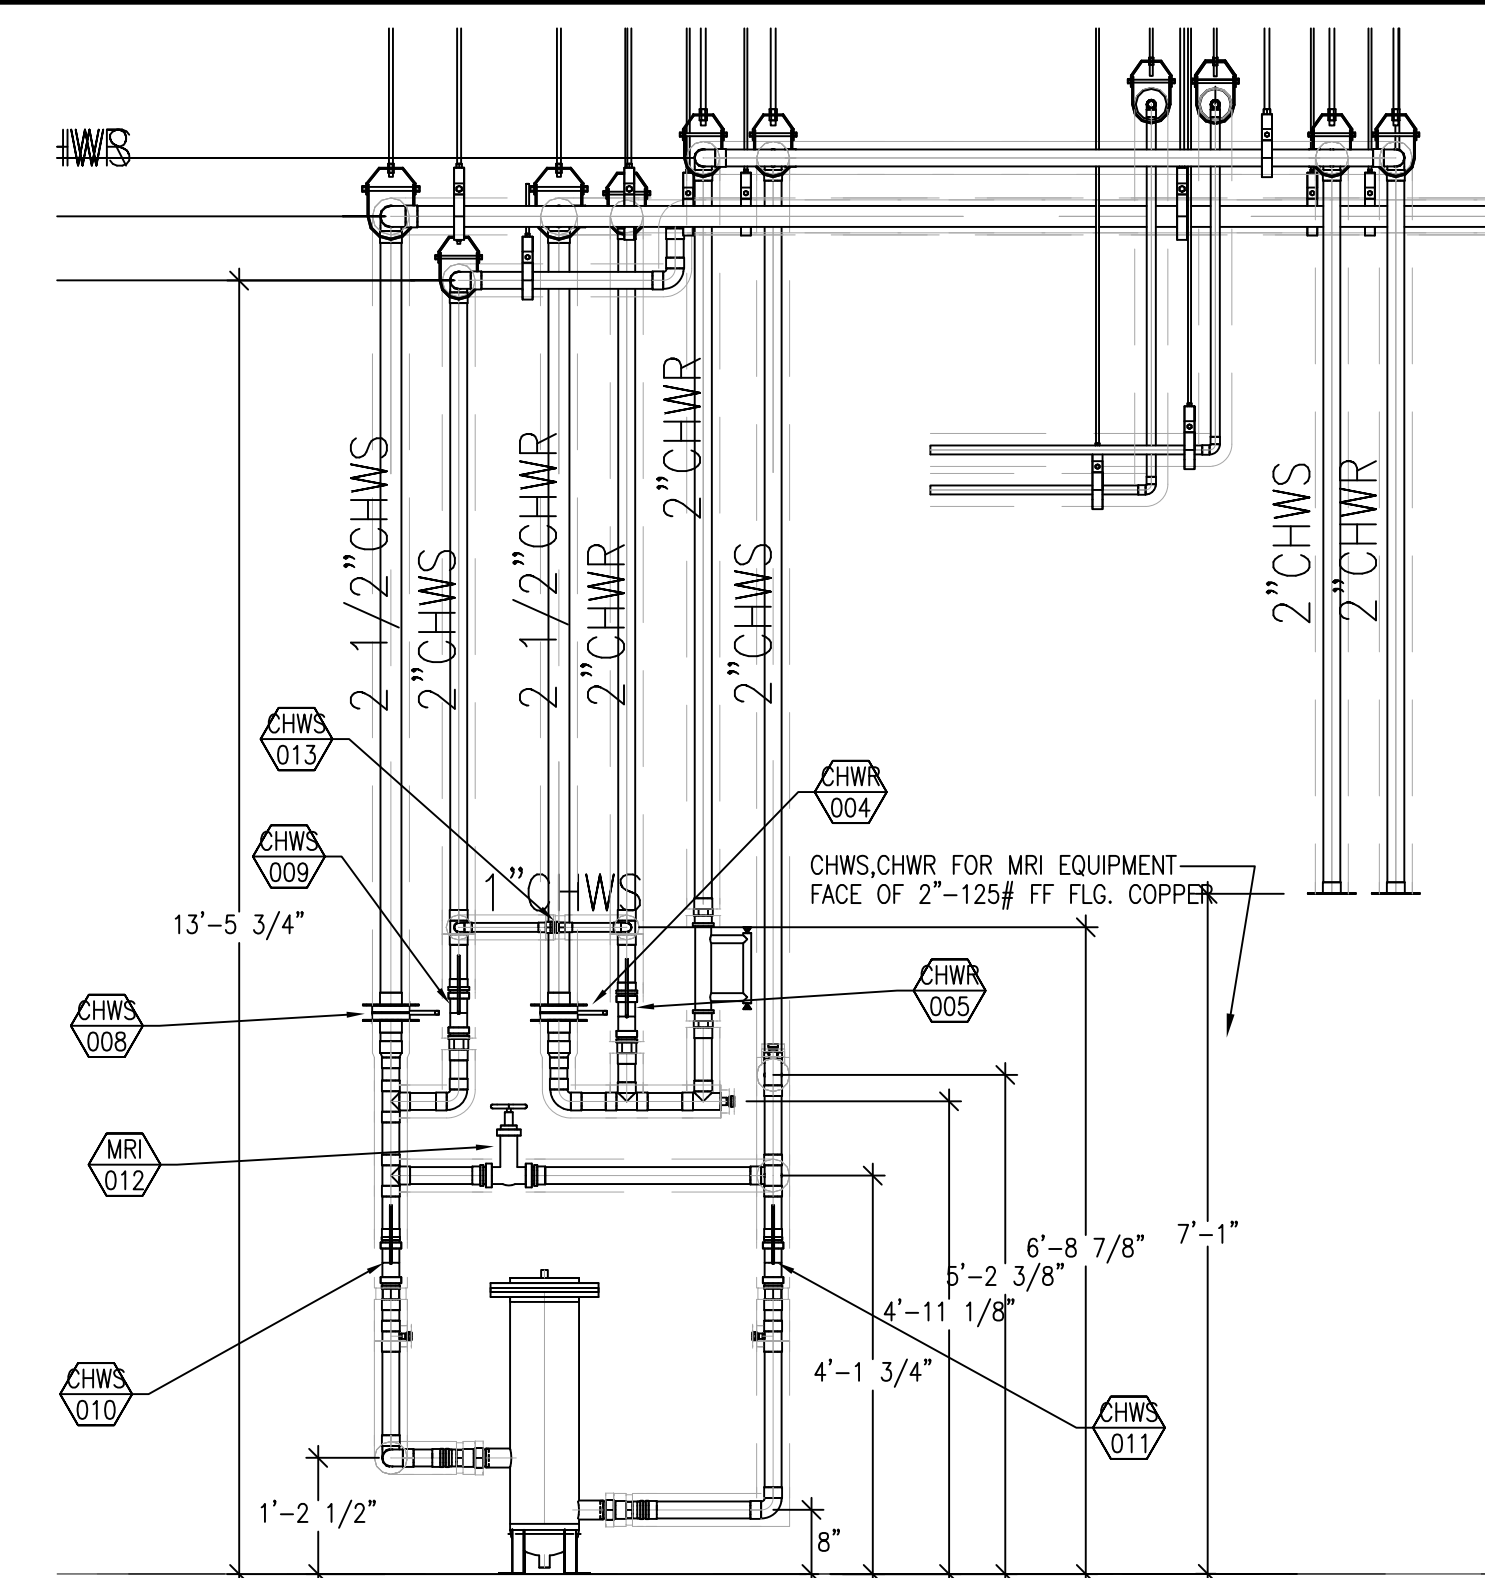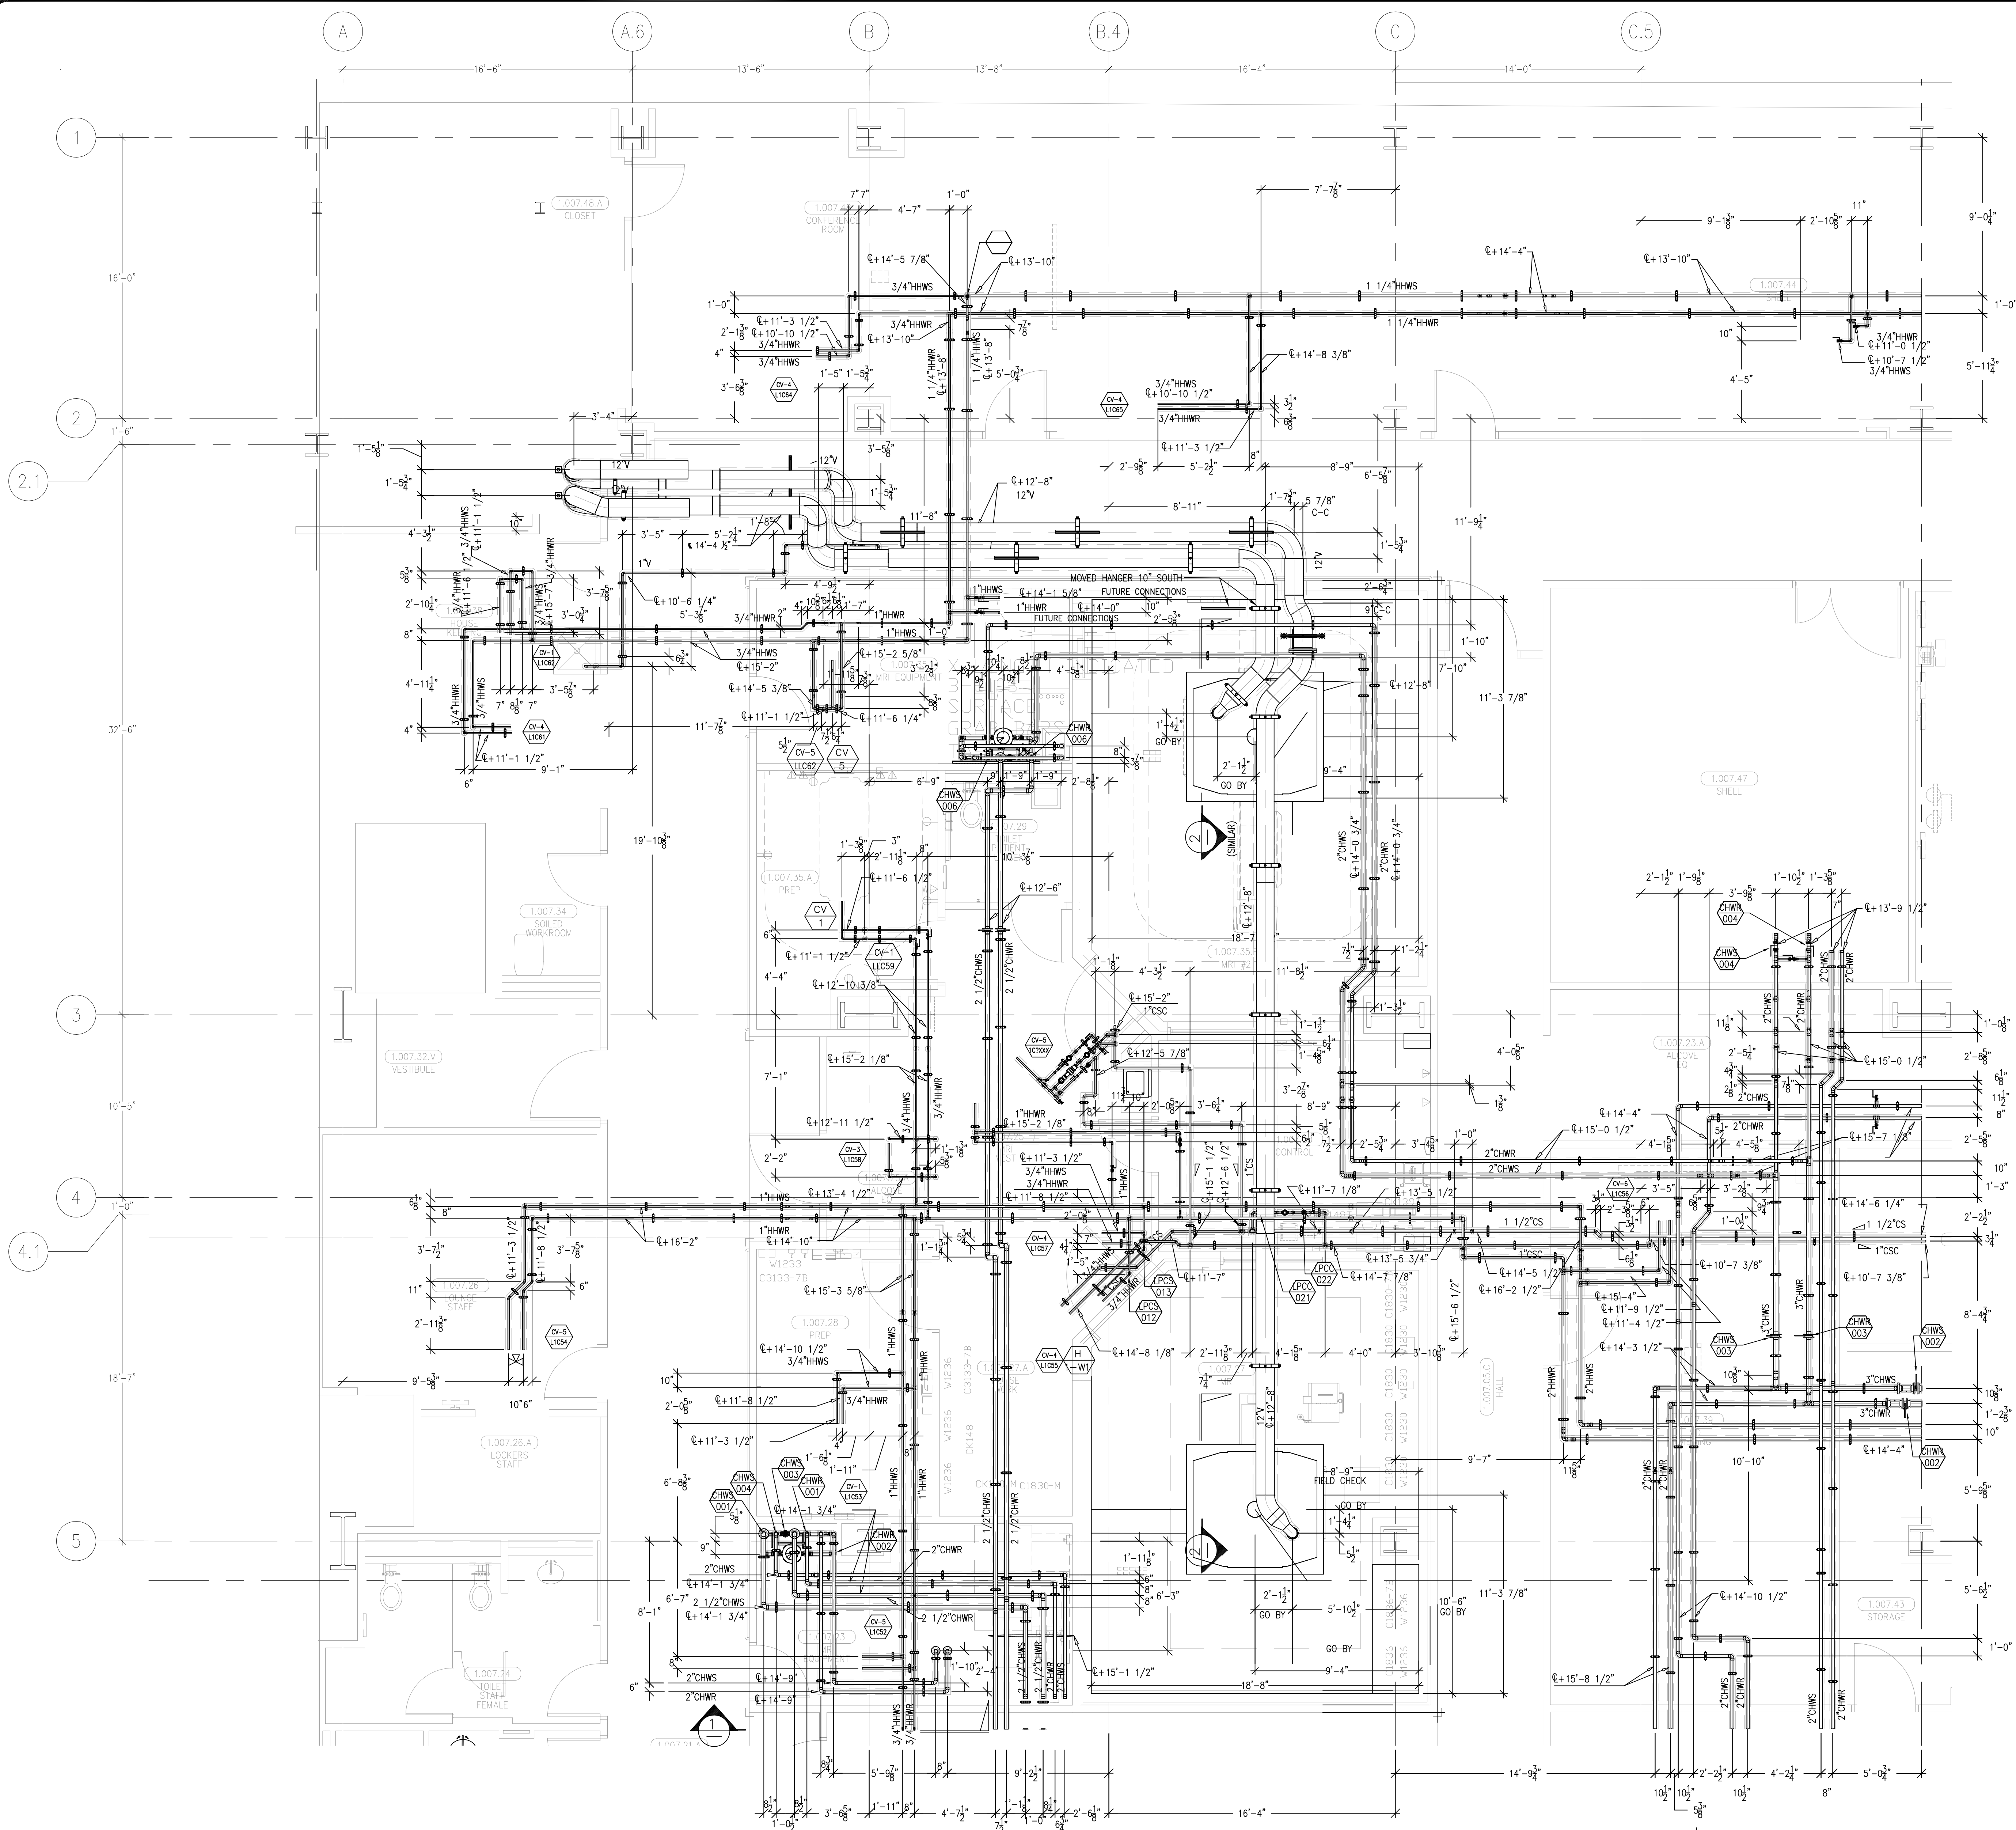


SECTION 1 (MRI-1)


SCALE: 1/2" = 1'-0"

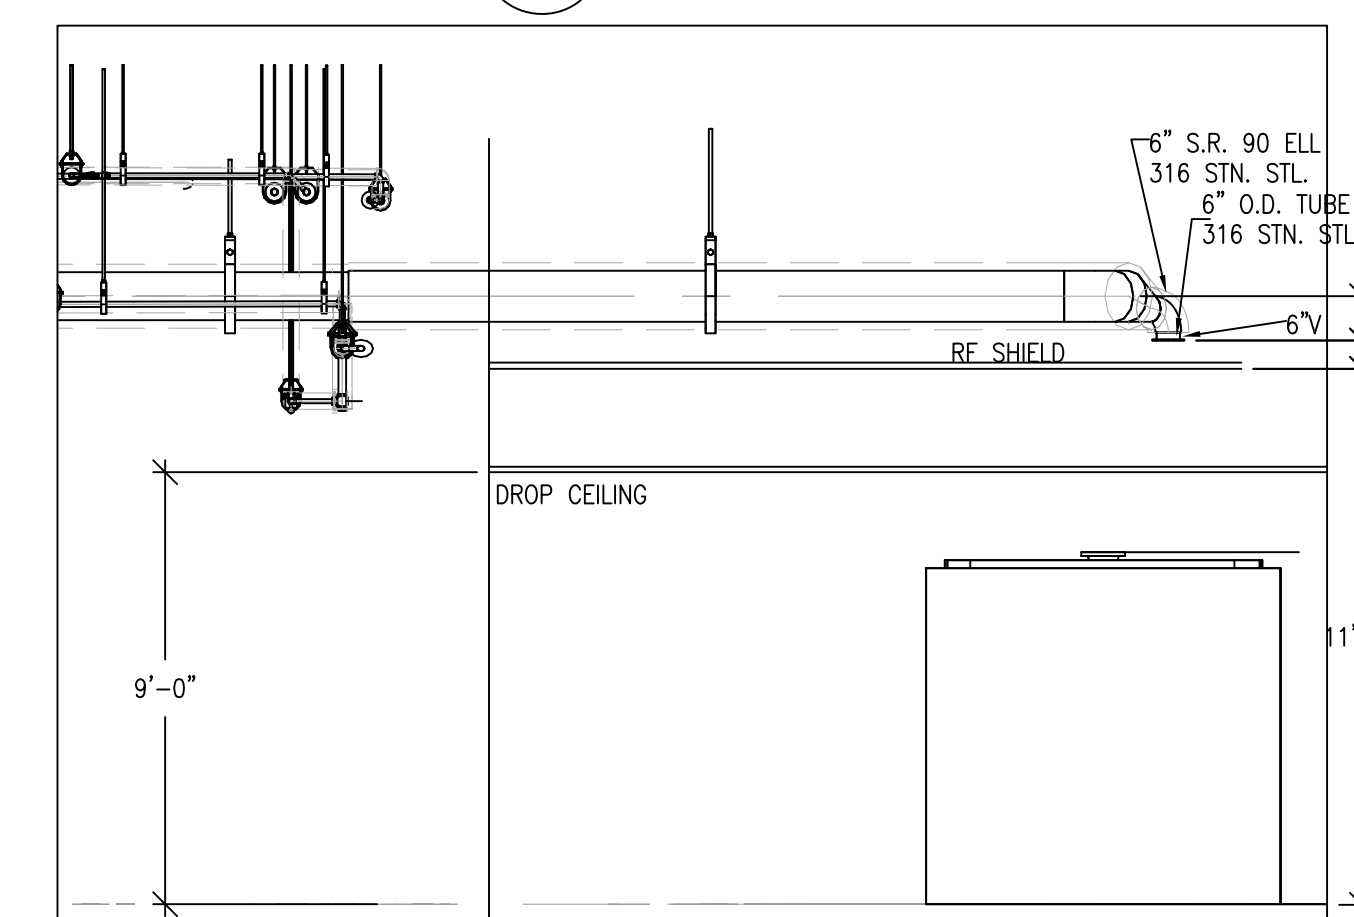

SECTION 2

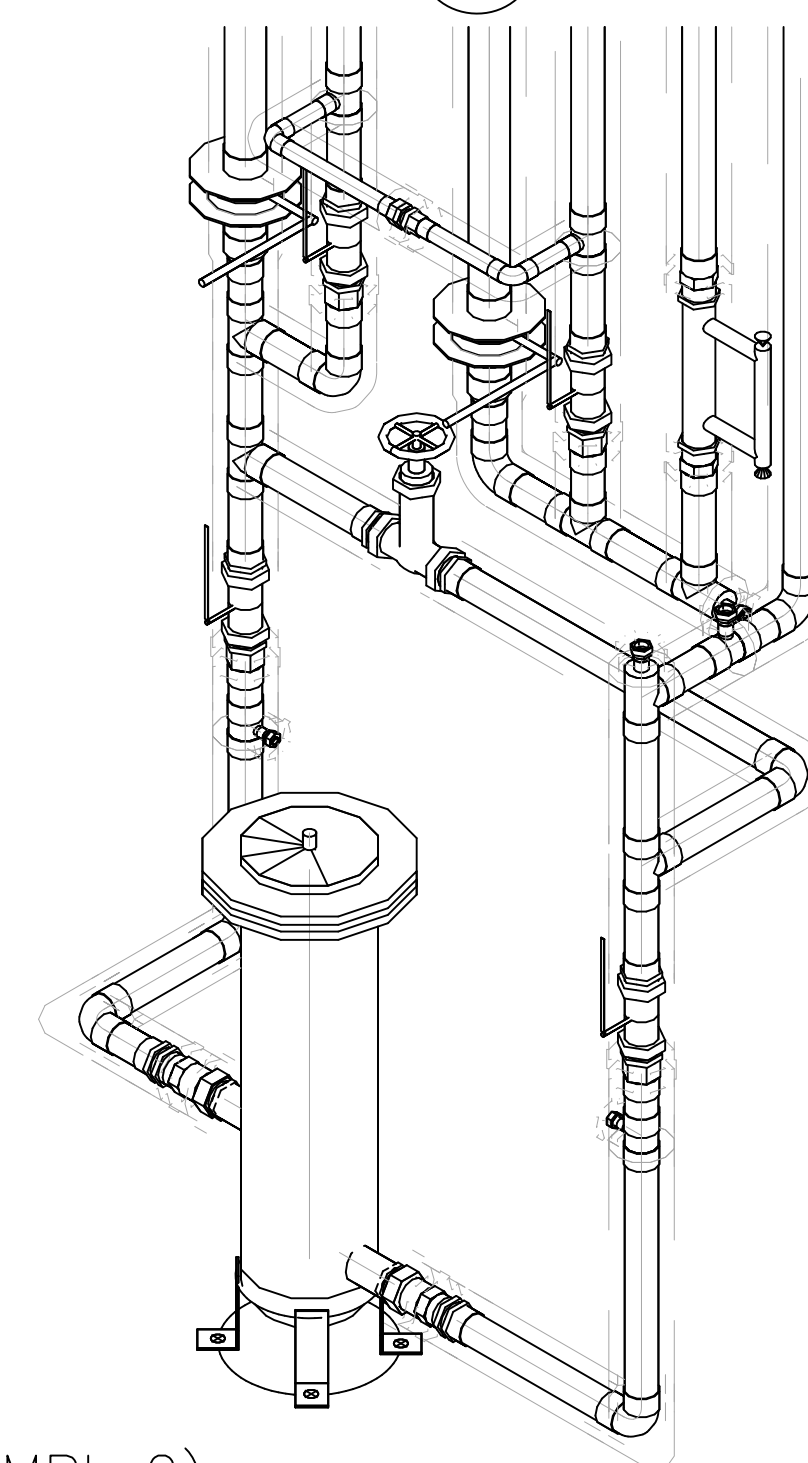

ISOMETRIC (MRI-2)

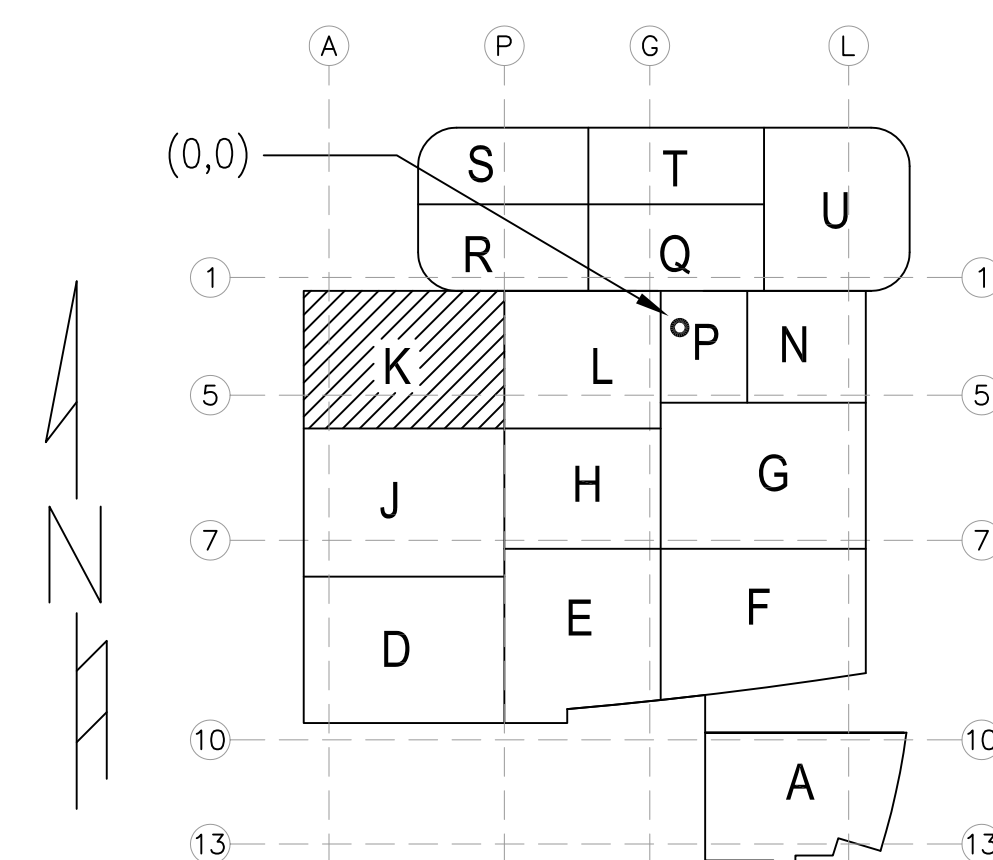

A1 KEY PLAN

[illegible]

COORD.	SIGNATURE	DATE
MCARTHY		
MECHANICAL DUCT		
MECHANICAL PIPE		
PLUMBING		
ELECTRICAL		
FIRE SPRINKLER		
PIPE		
DRYWALL/FRAMER		
REFRIGERATION		
STRUCTURAL		

[illegible]





**CHILDREN'S HOSPITAL
OF ORANGE COUNTY**
455 S. Main St.
Orange, CA 92668-3874
TOWER II

PMI
PAN-PACIFIC
PLUMBING & MECHANICAL
Murray
Company
2919 E. VICTORIA STREET, RANCHO DOMINGUEZ, CA 90221


DRAWN
S.B.
CHECKED
M.M.
DATE
9/4/2012
SCALE
1/4" = 1'-0"
JOB NO.
09-006
DRAWING NUMBER
MP3.1K
REFERENCE DRAWING
A3.1K
P3.1K
1 OF 1 SHEETS

bioRxiv preprint doi: <https://doi.org/10.1101/110111>; this version posted May 1, 2017. The copyright holder for this preprint (which was not certified by peer review) is the author/funder, who has granted bioRxiv a license to display the preprint in perpetuity. It is made available under aCC-BY-NC-ND 4.0 International license.

This document and the design it covers are the property of Murray Co. They are loaned only with the borrower's expressed written agreement that they will not be reproduced, copied, loaned, exhibited, or used in any way, except by written consent from Murray Co. to the borrower.

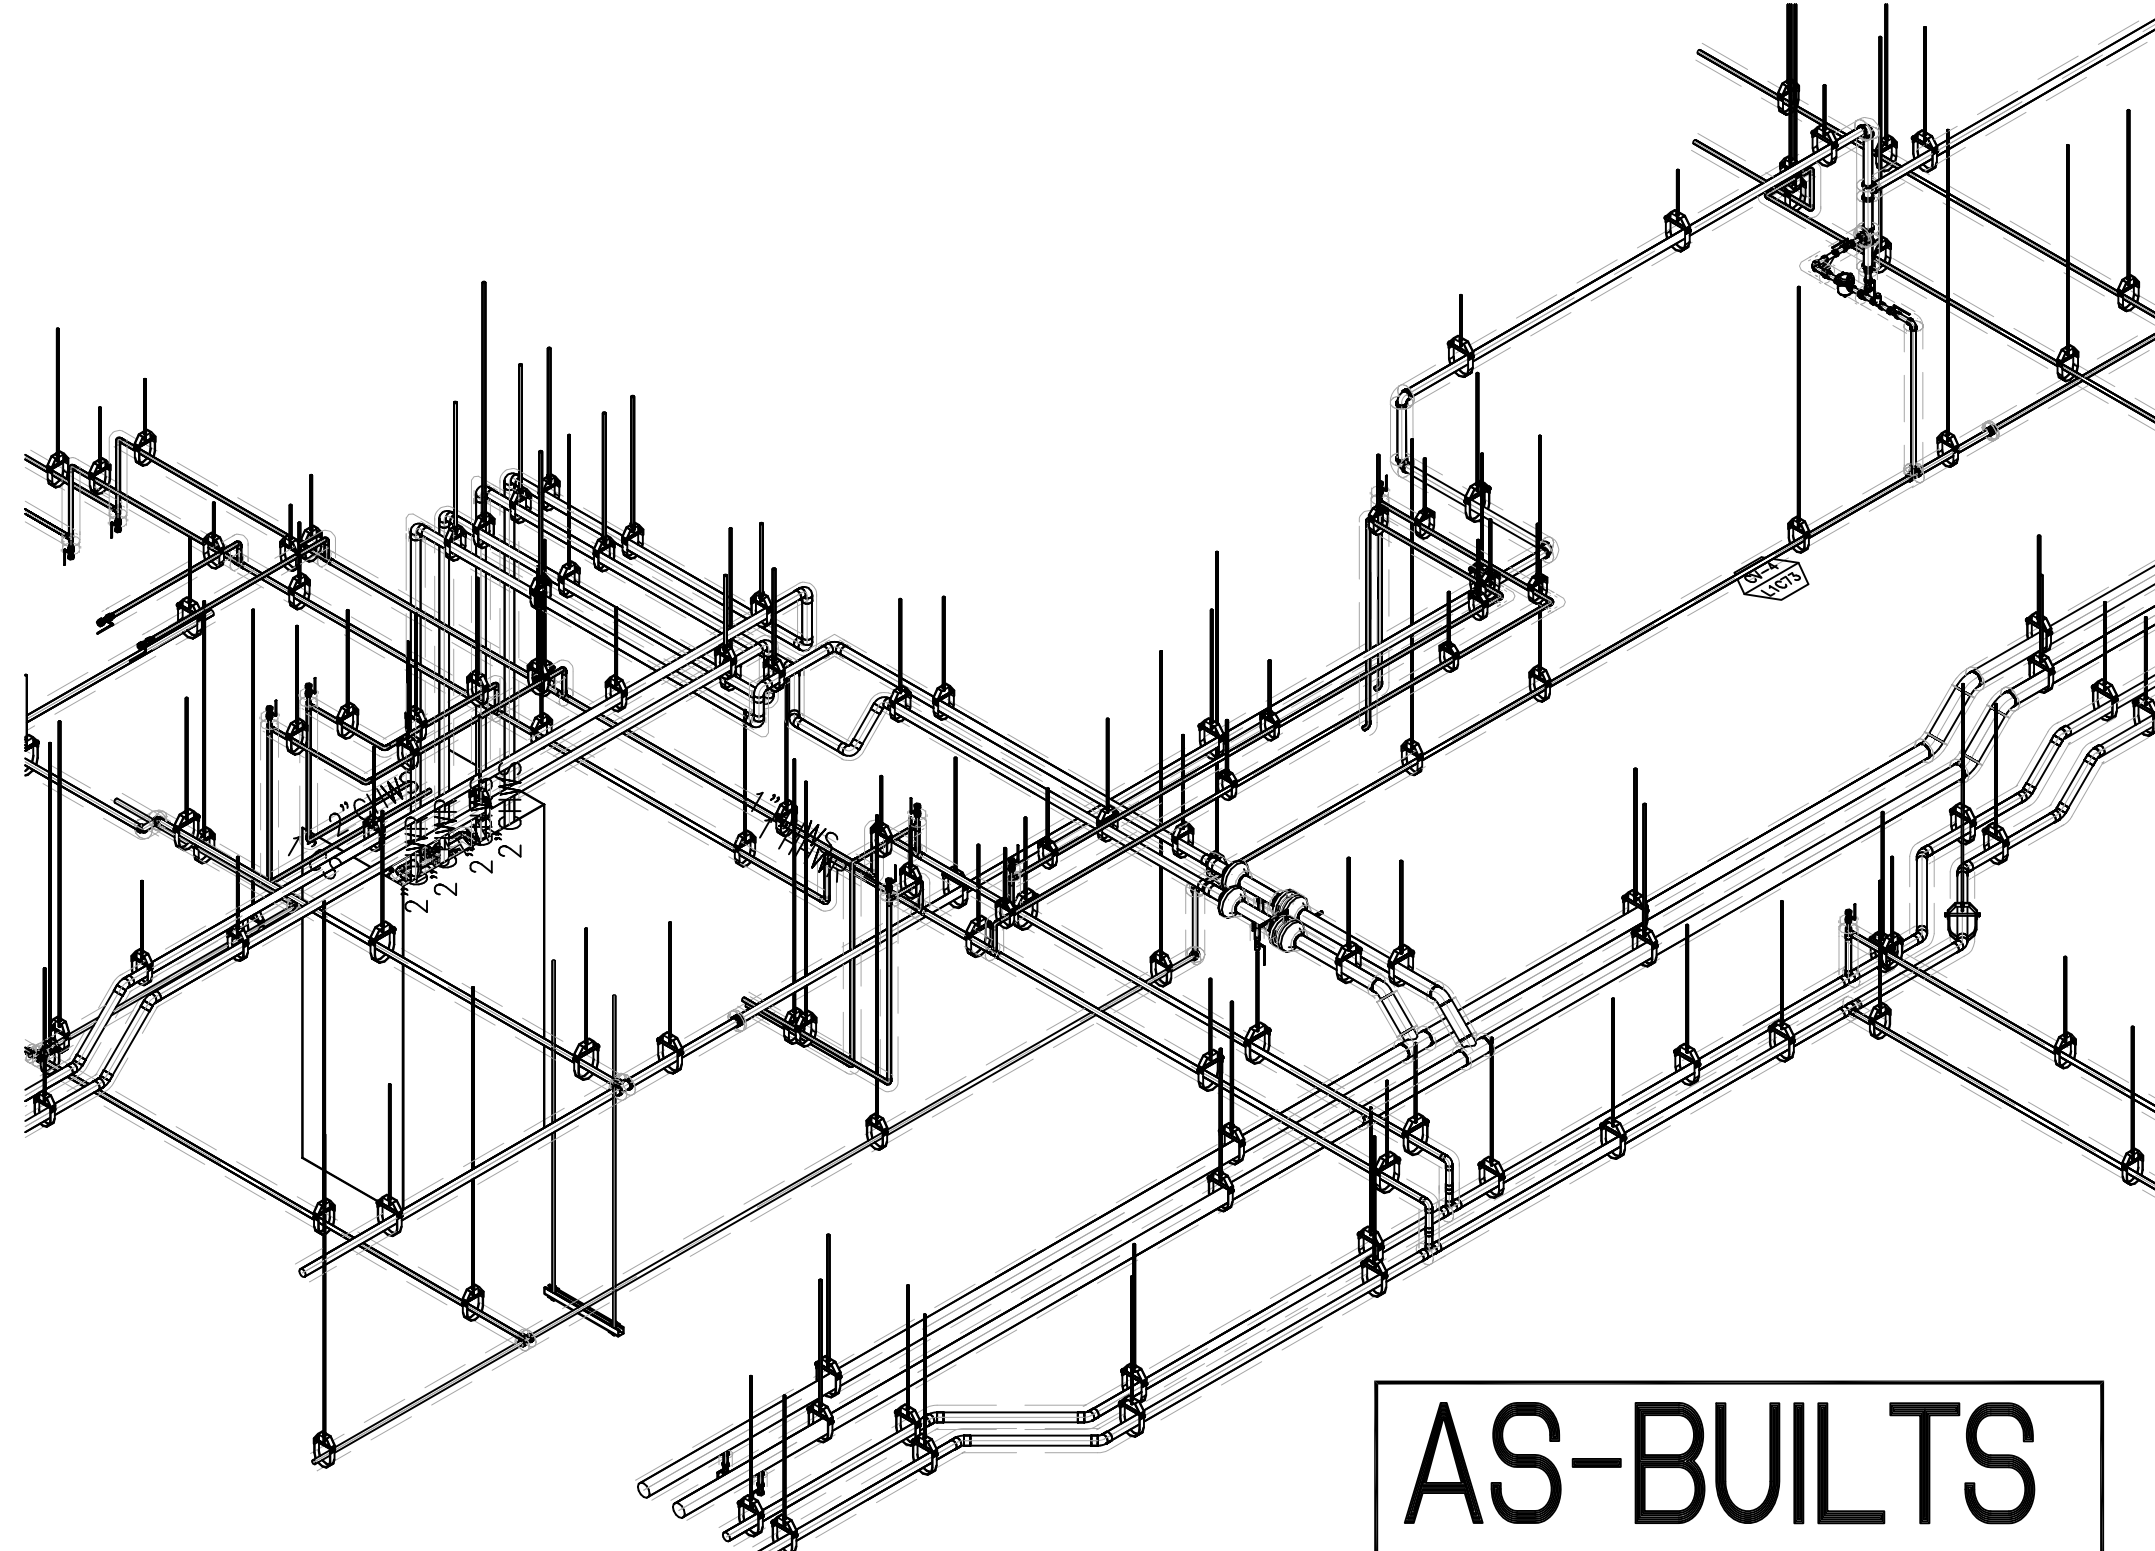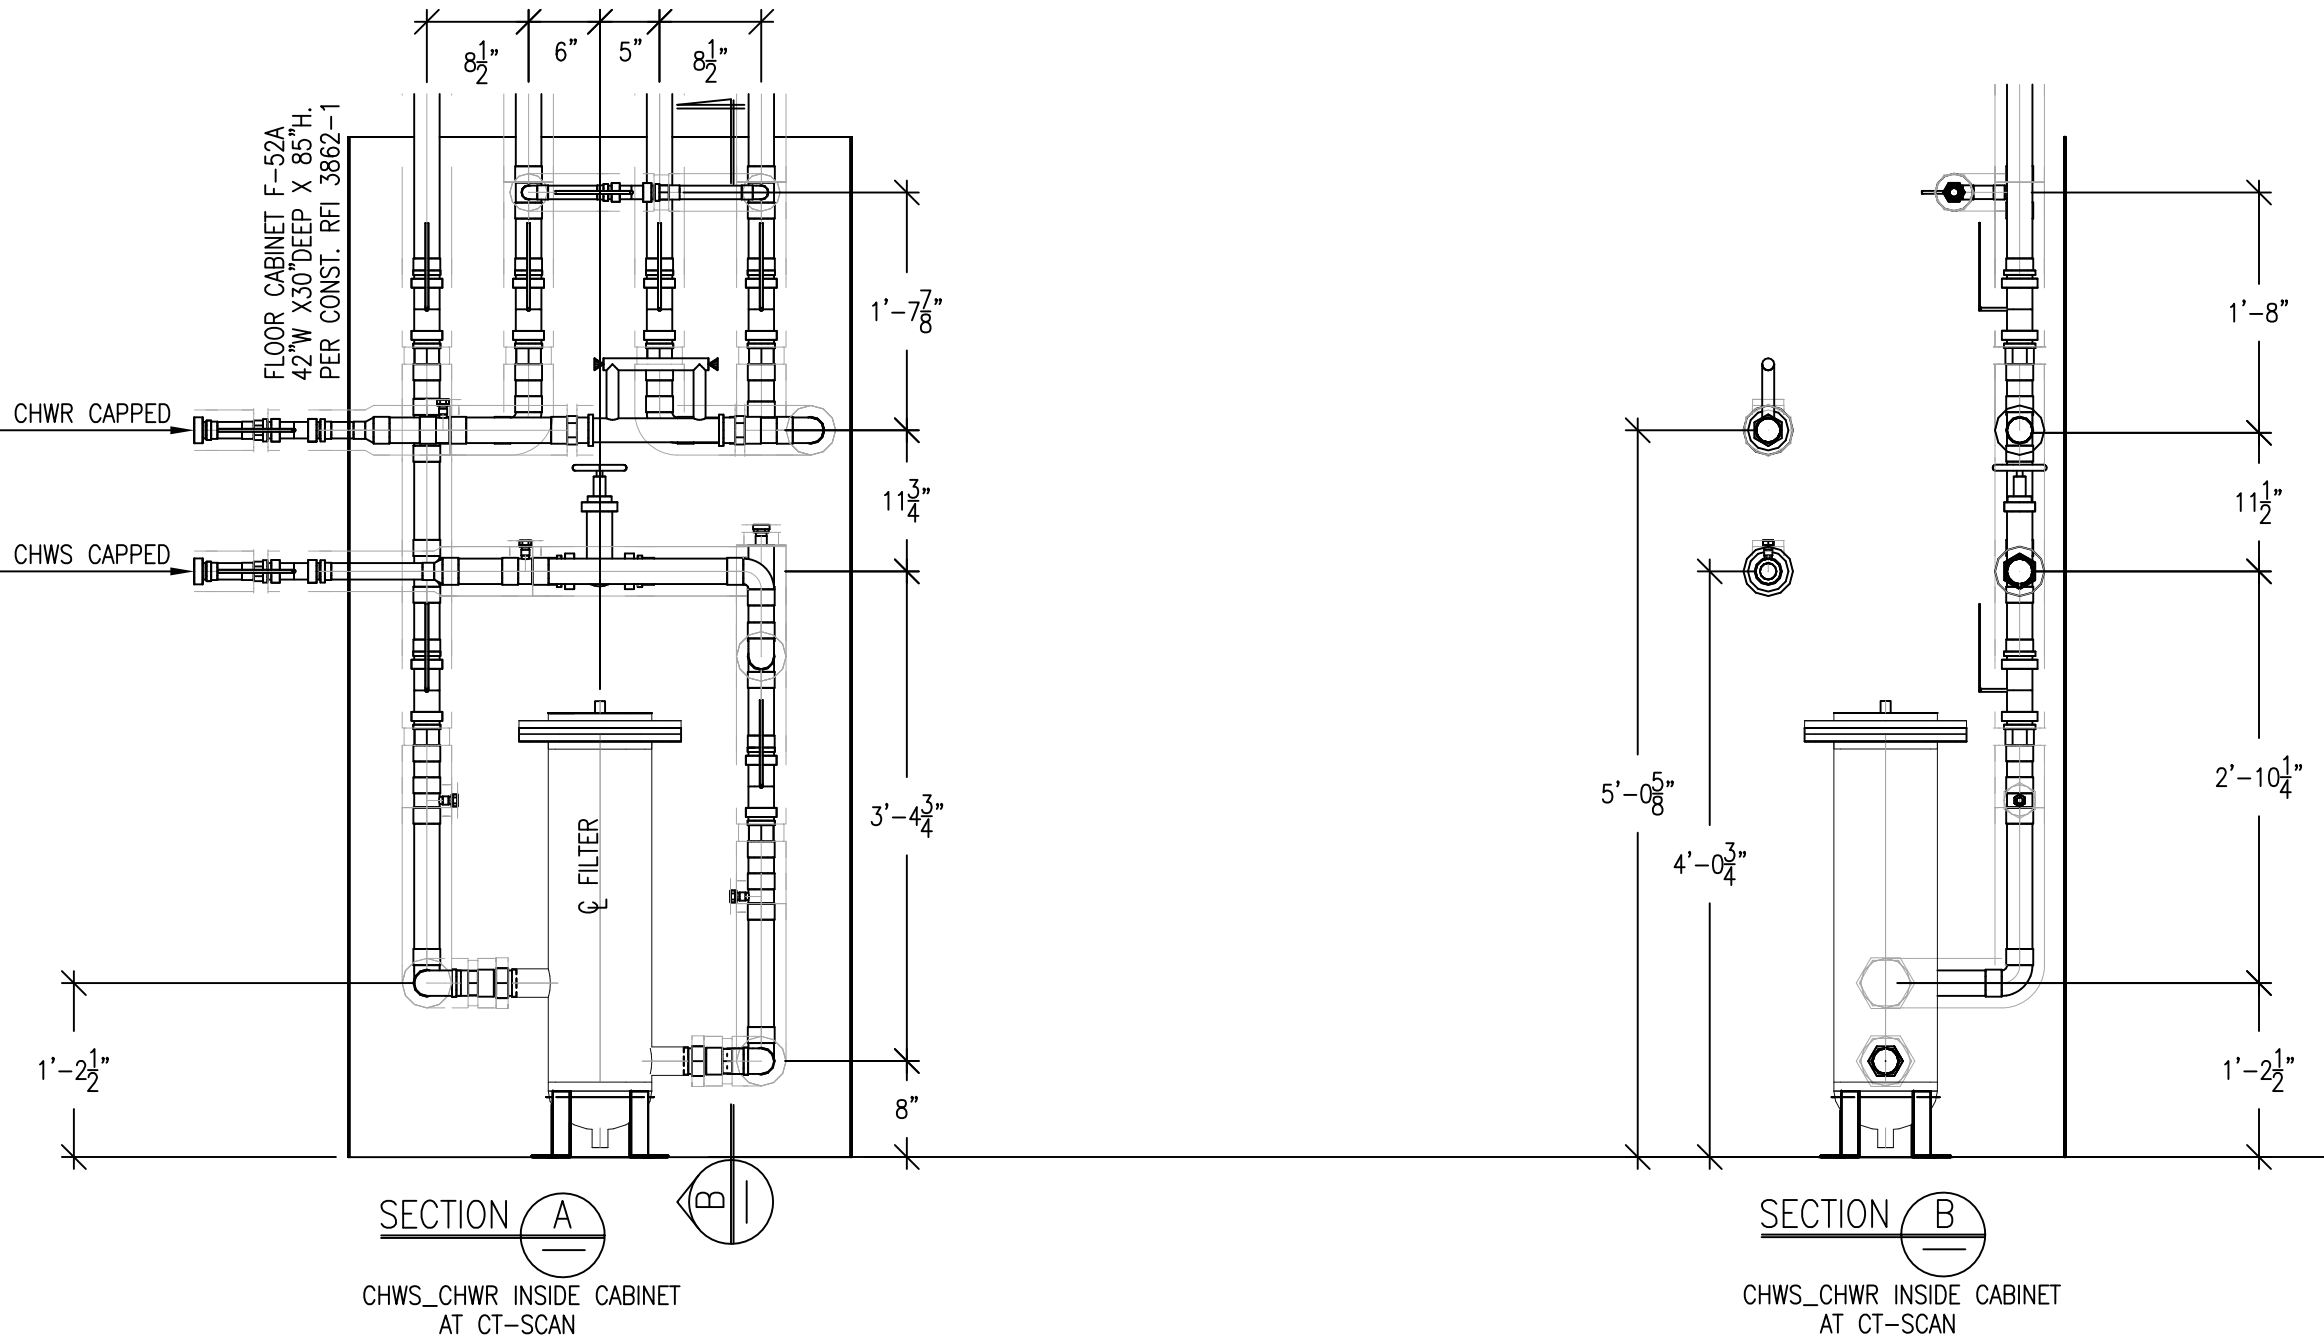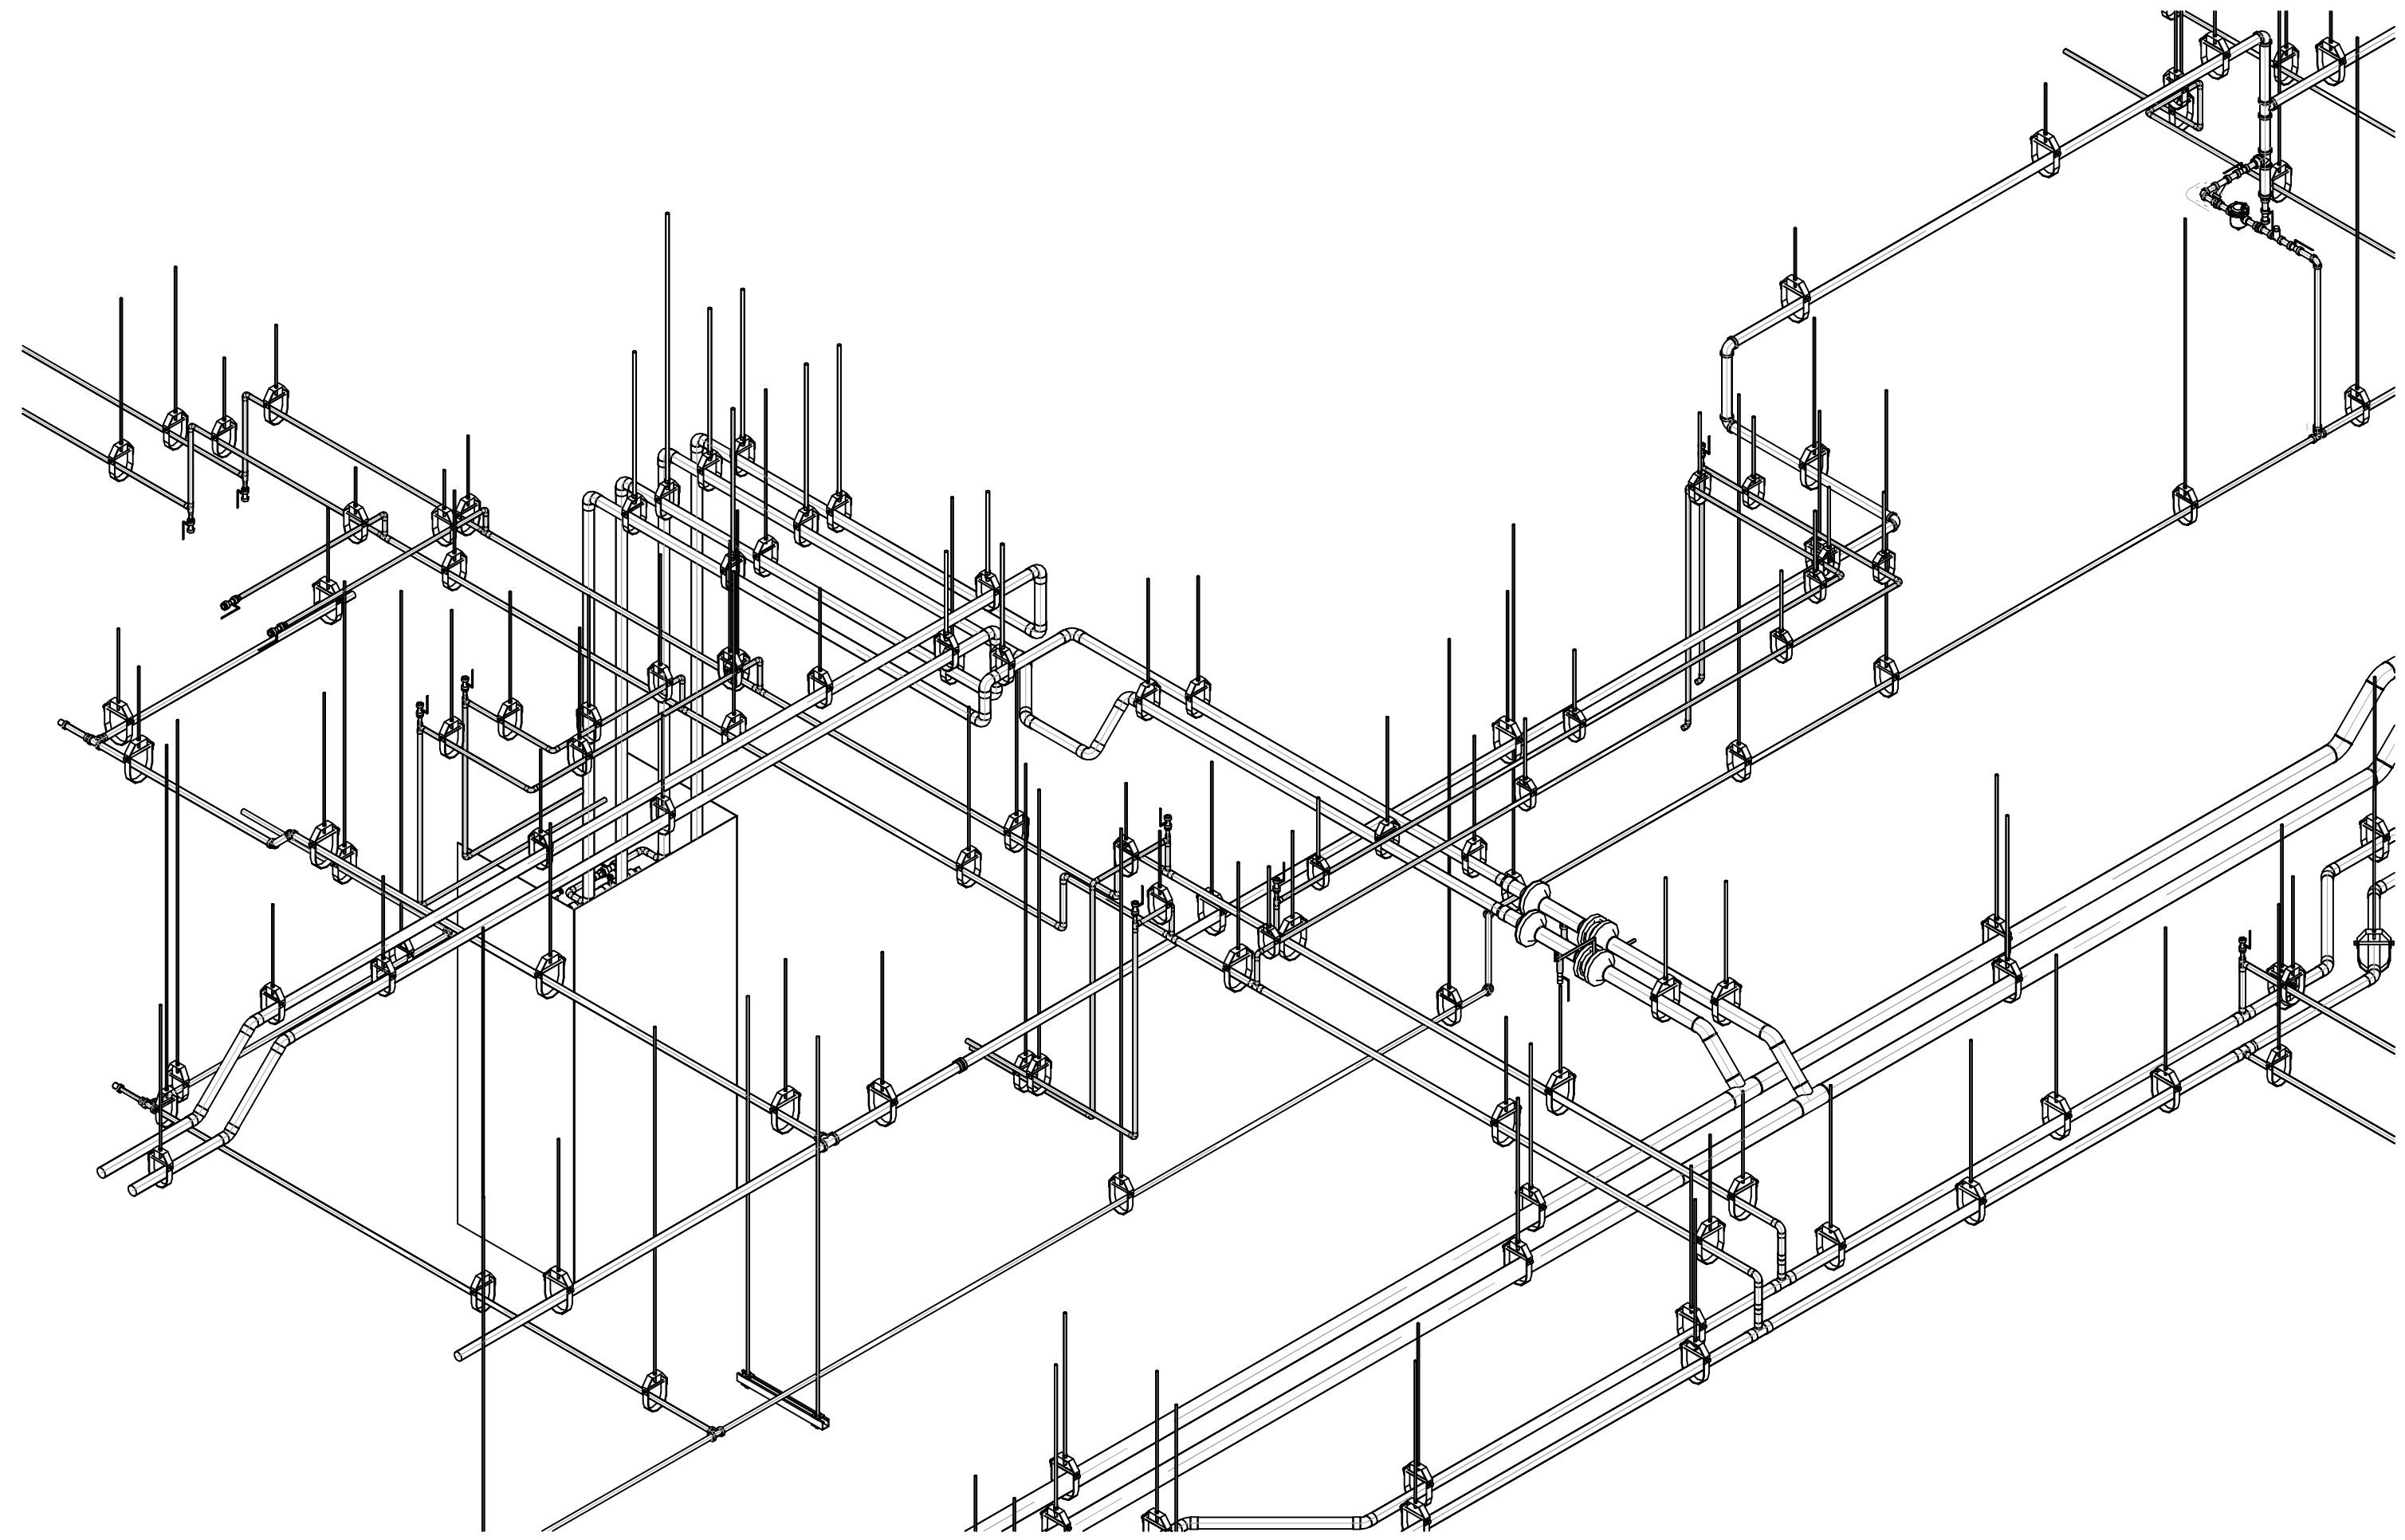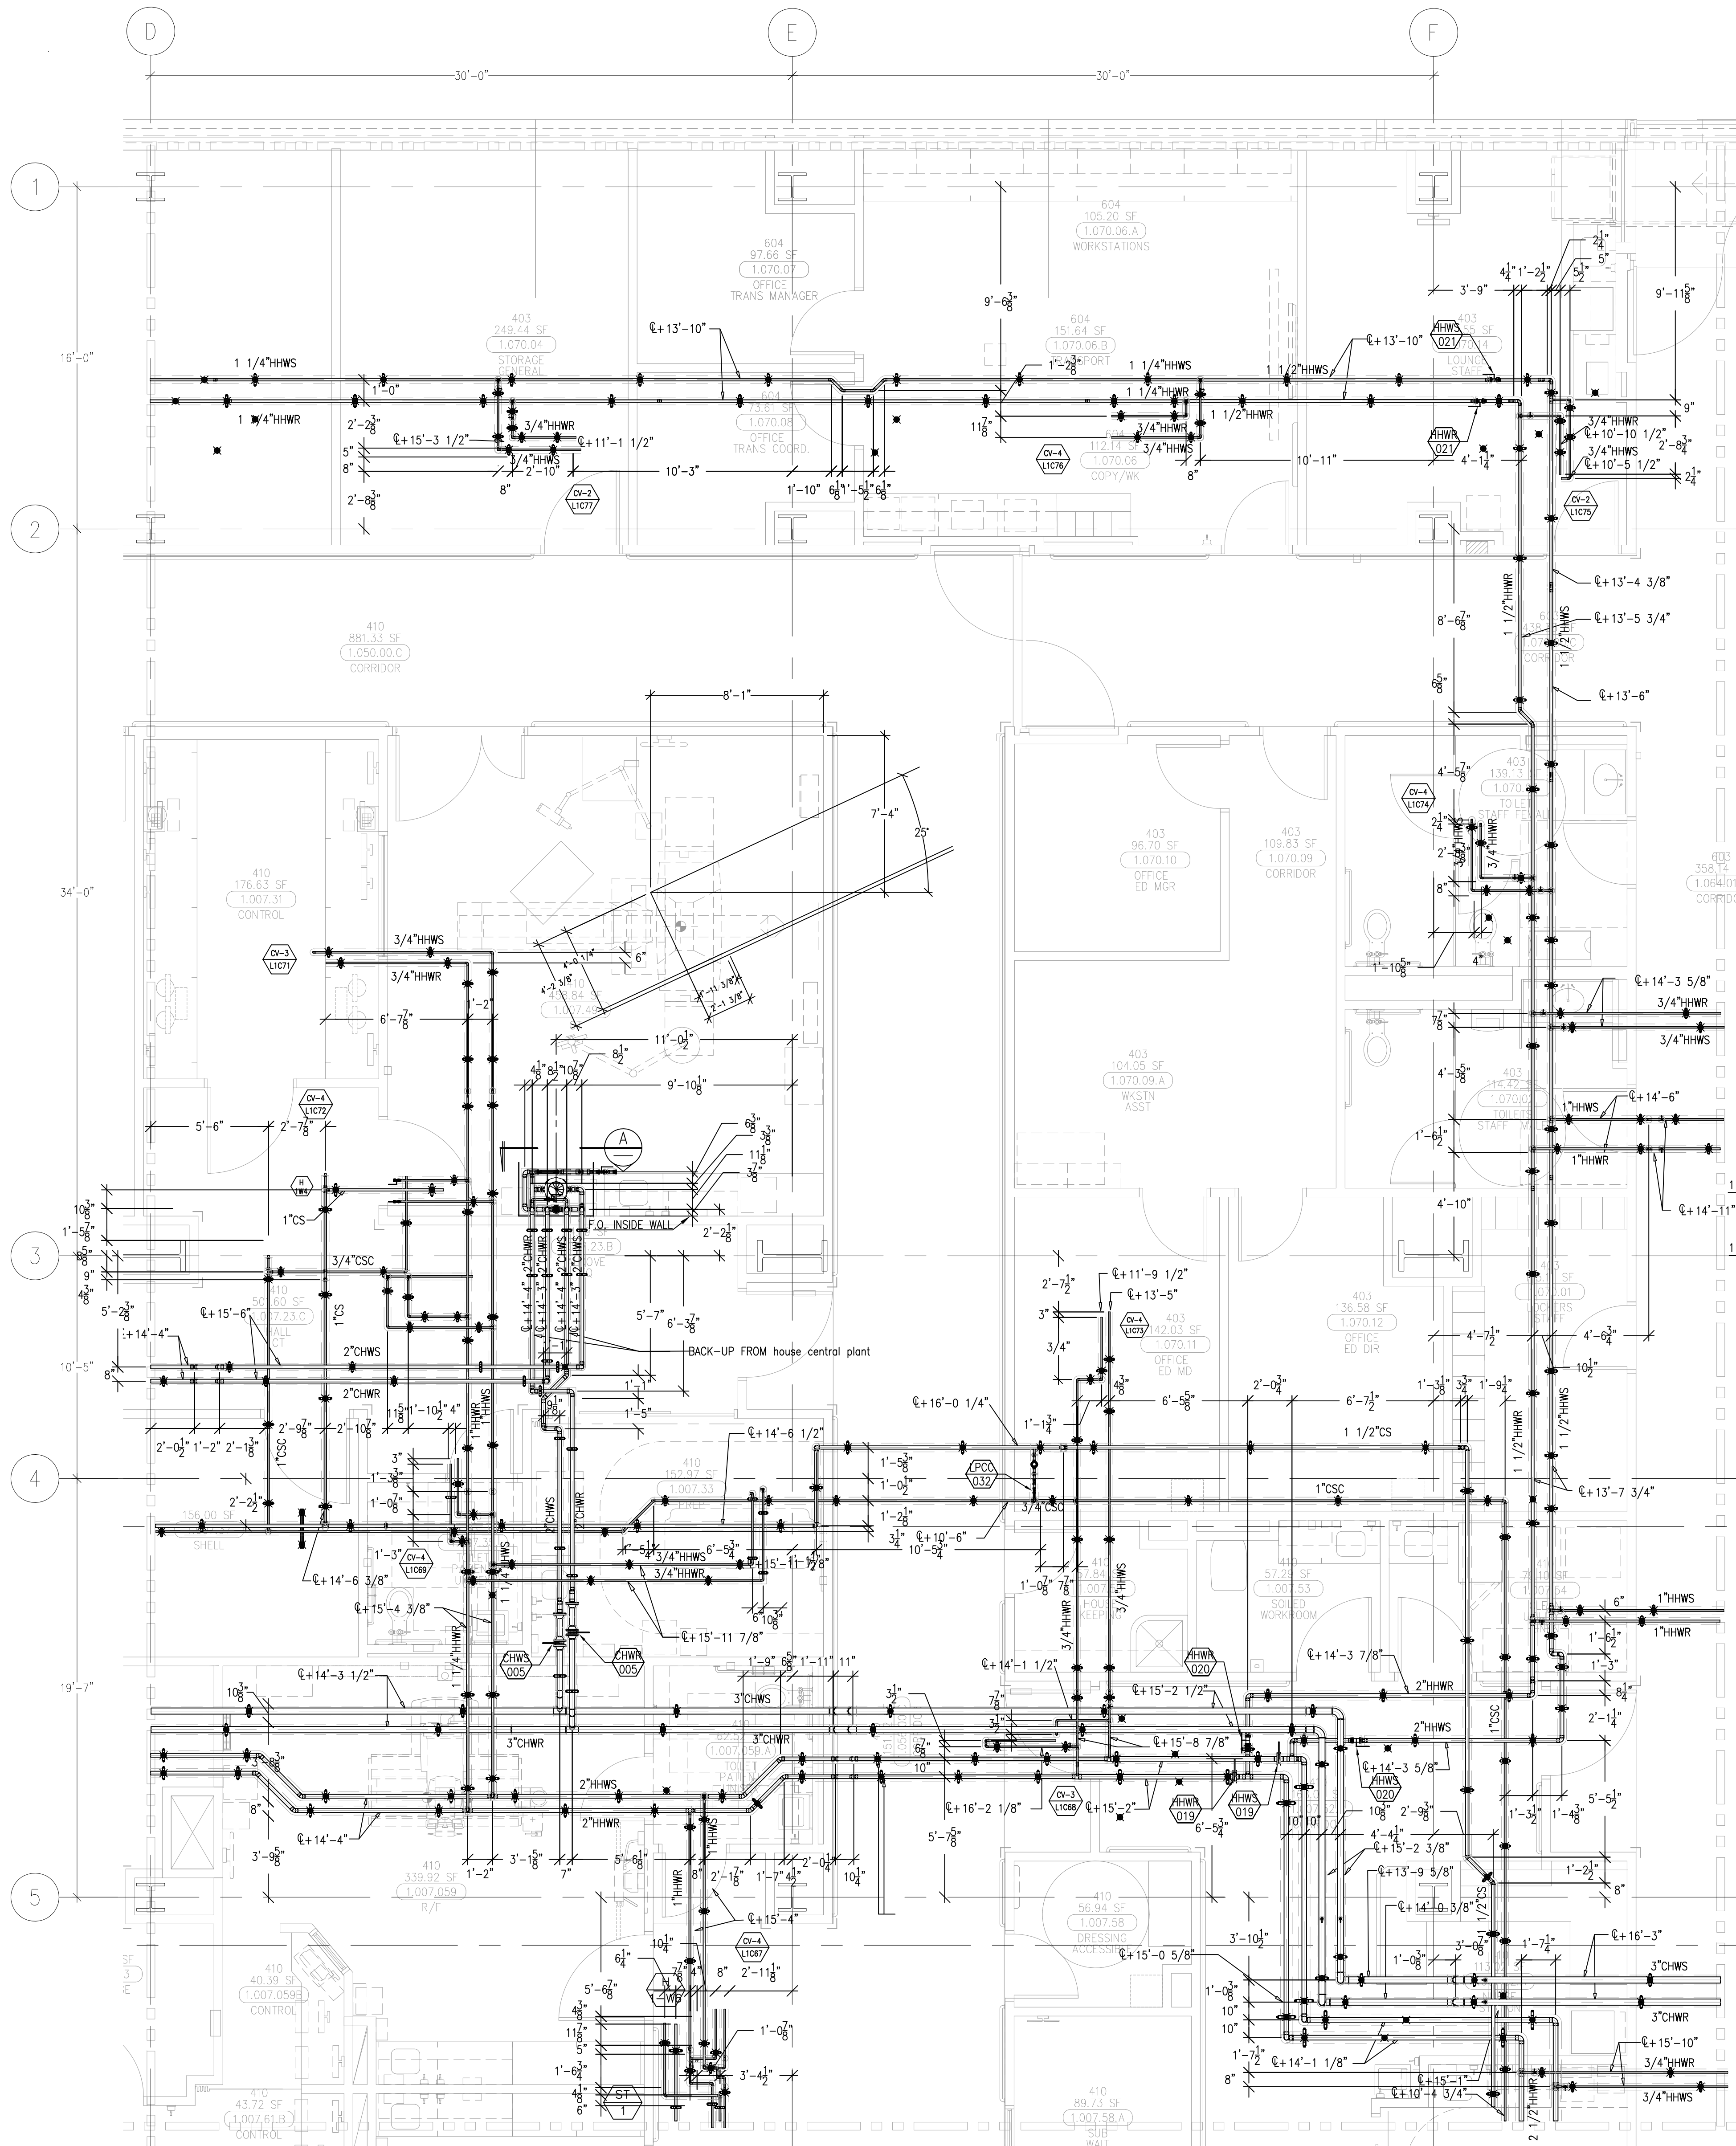

LEVEL 02 179.30' = 0'-0"
REFERENCE THIS SHEET

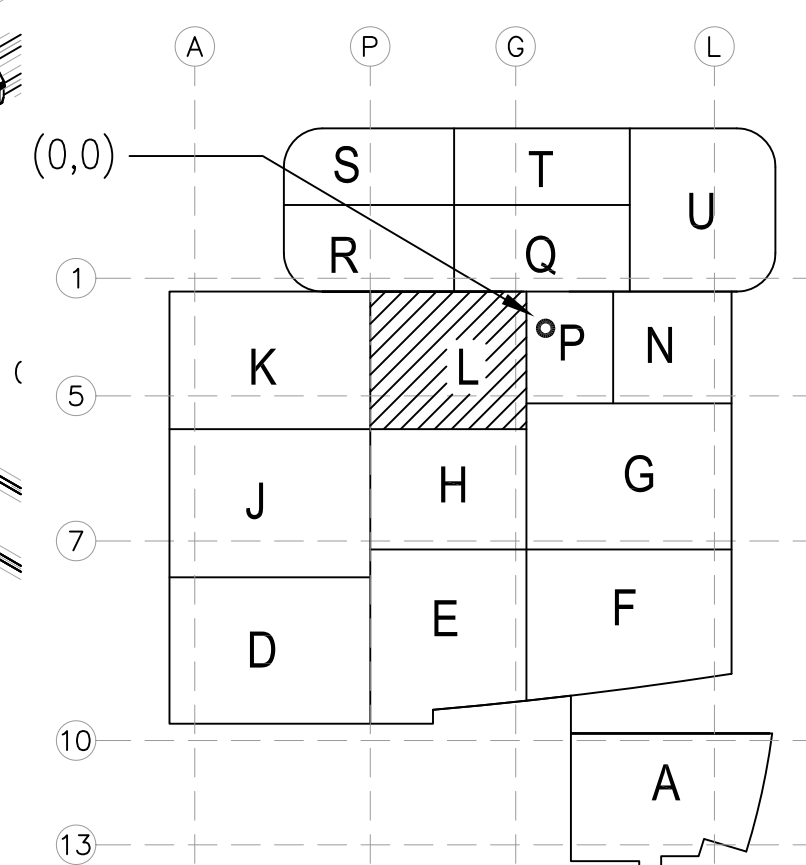

AS-BUILTS
DATE: 6-18-12 BY: J. CLINTON

REVISIONS	BY

COORD.	SIGNATURE	DATE
MECHANICAL		
MECHANICAL		
MECHANICAL		
ELECTRICAL		
FIRE SPRINKLER		
PLUMBING		
PIPE		
DRYWALL/FRAMER		
REFRIGERATION		
STRUCTURAL		

ANS.	SENT	R.F.I.	ANS.	SENT	R.F.I.	ANS.	SENT	R.F.I.	ANS.	SENT	R.F.I.

CHILDREN'S HOSPITAL
OF ORANGE COUNTY
455 S. HICKS AVE.
ORANGE, CA 92668-9974
TOWER II
MECHANICAL PIPE FLOOR PLAN - LEVEL 02 AREAL

PAN-PACIFIC
PLUMBING & MECHANICAL
2919 E. VICTORIA STREET, RANCHO DOMINGUEZ, CA 90221
PH. 310 637-1500 FAX 310 604-0359

DRAWN
SB
CHECKED
M.M.
DATE
9/4/2012
SCALE
1/4" = 1'-0"
JOB NO.
09-006
DRAWING NUMBER
MP3.1L
REFERENCE DRAWING
A3.1L
P3.1L
1 OF 1 SHEETS

[illegible][illegible]

Mechanical Duct				
Mechanical Pipe				
Plumbing				
Electrical				
Fire Sprinkler				
Pipe				
Drywall/Framer				
Refrigeration				
Structural				

[illegible]


CHILDREN'S HOSPITAL
OF ORANGE COUNTY
455 S. Main St.
Orange, CA 92668-3874
TOWER II
MECHANICAL PIPE FLOOR PLAN - LEVEL 01 AREA-N

PMI
PAN-PACIFIC
PLUMBING & MECHANICAL


Murray Company
2919 E. VICTORIA STREET, RANCHO DOMINGUEZ, CA 90221
PH. 310 637-1500 FAX. 310 604-0359

R.O.
CHECKED
M.M.
DATE
9/4/2012
SCALE
1/4"=1'-0"
JOB NO.
09-006
DRAWING NUMBER
MP3.1N
REFERENCE DRAWING
A3.1N
P3.1N
1 OF 1 SHEETS

document and the design it covers are the property of Murray Co. They are loaned only with the borrowers' expressed written agreement that they will not be reproduced, copied, loaned, exhibited, or used in any other way, except by written consent from Murray Co. to the borrower.

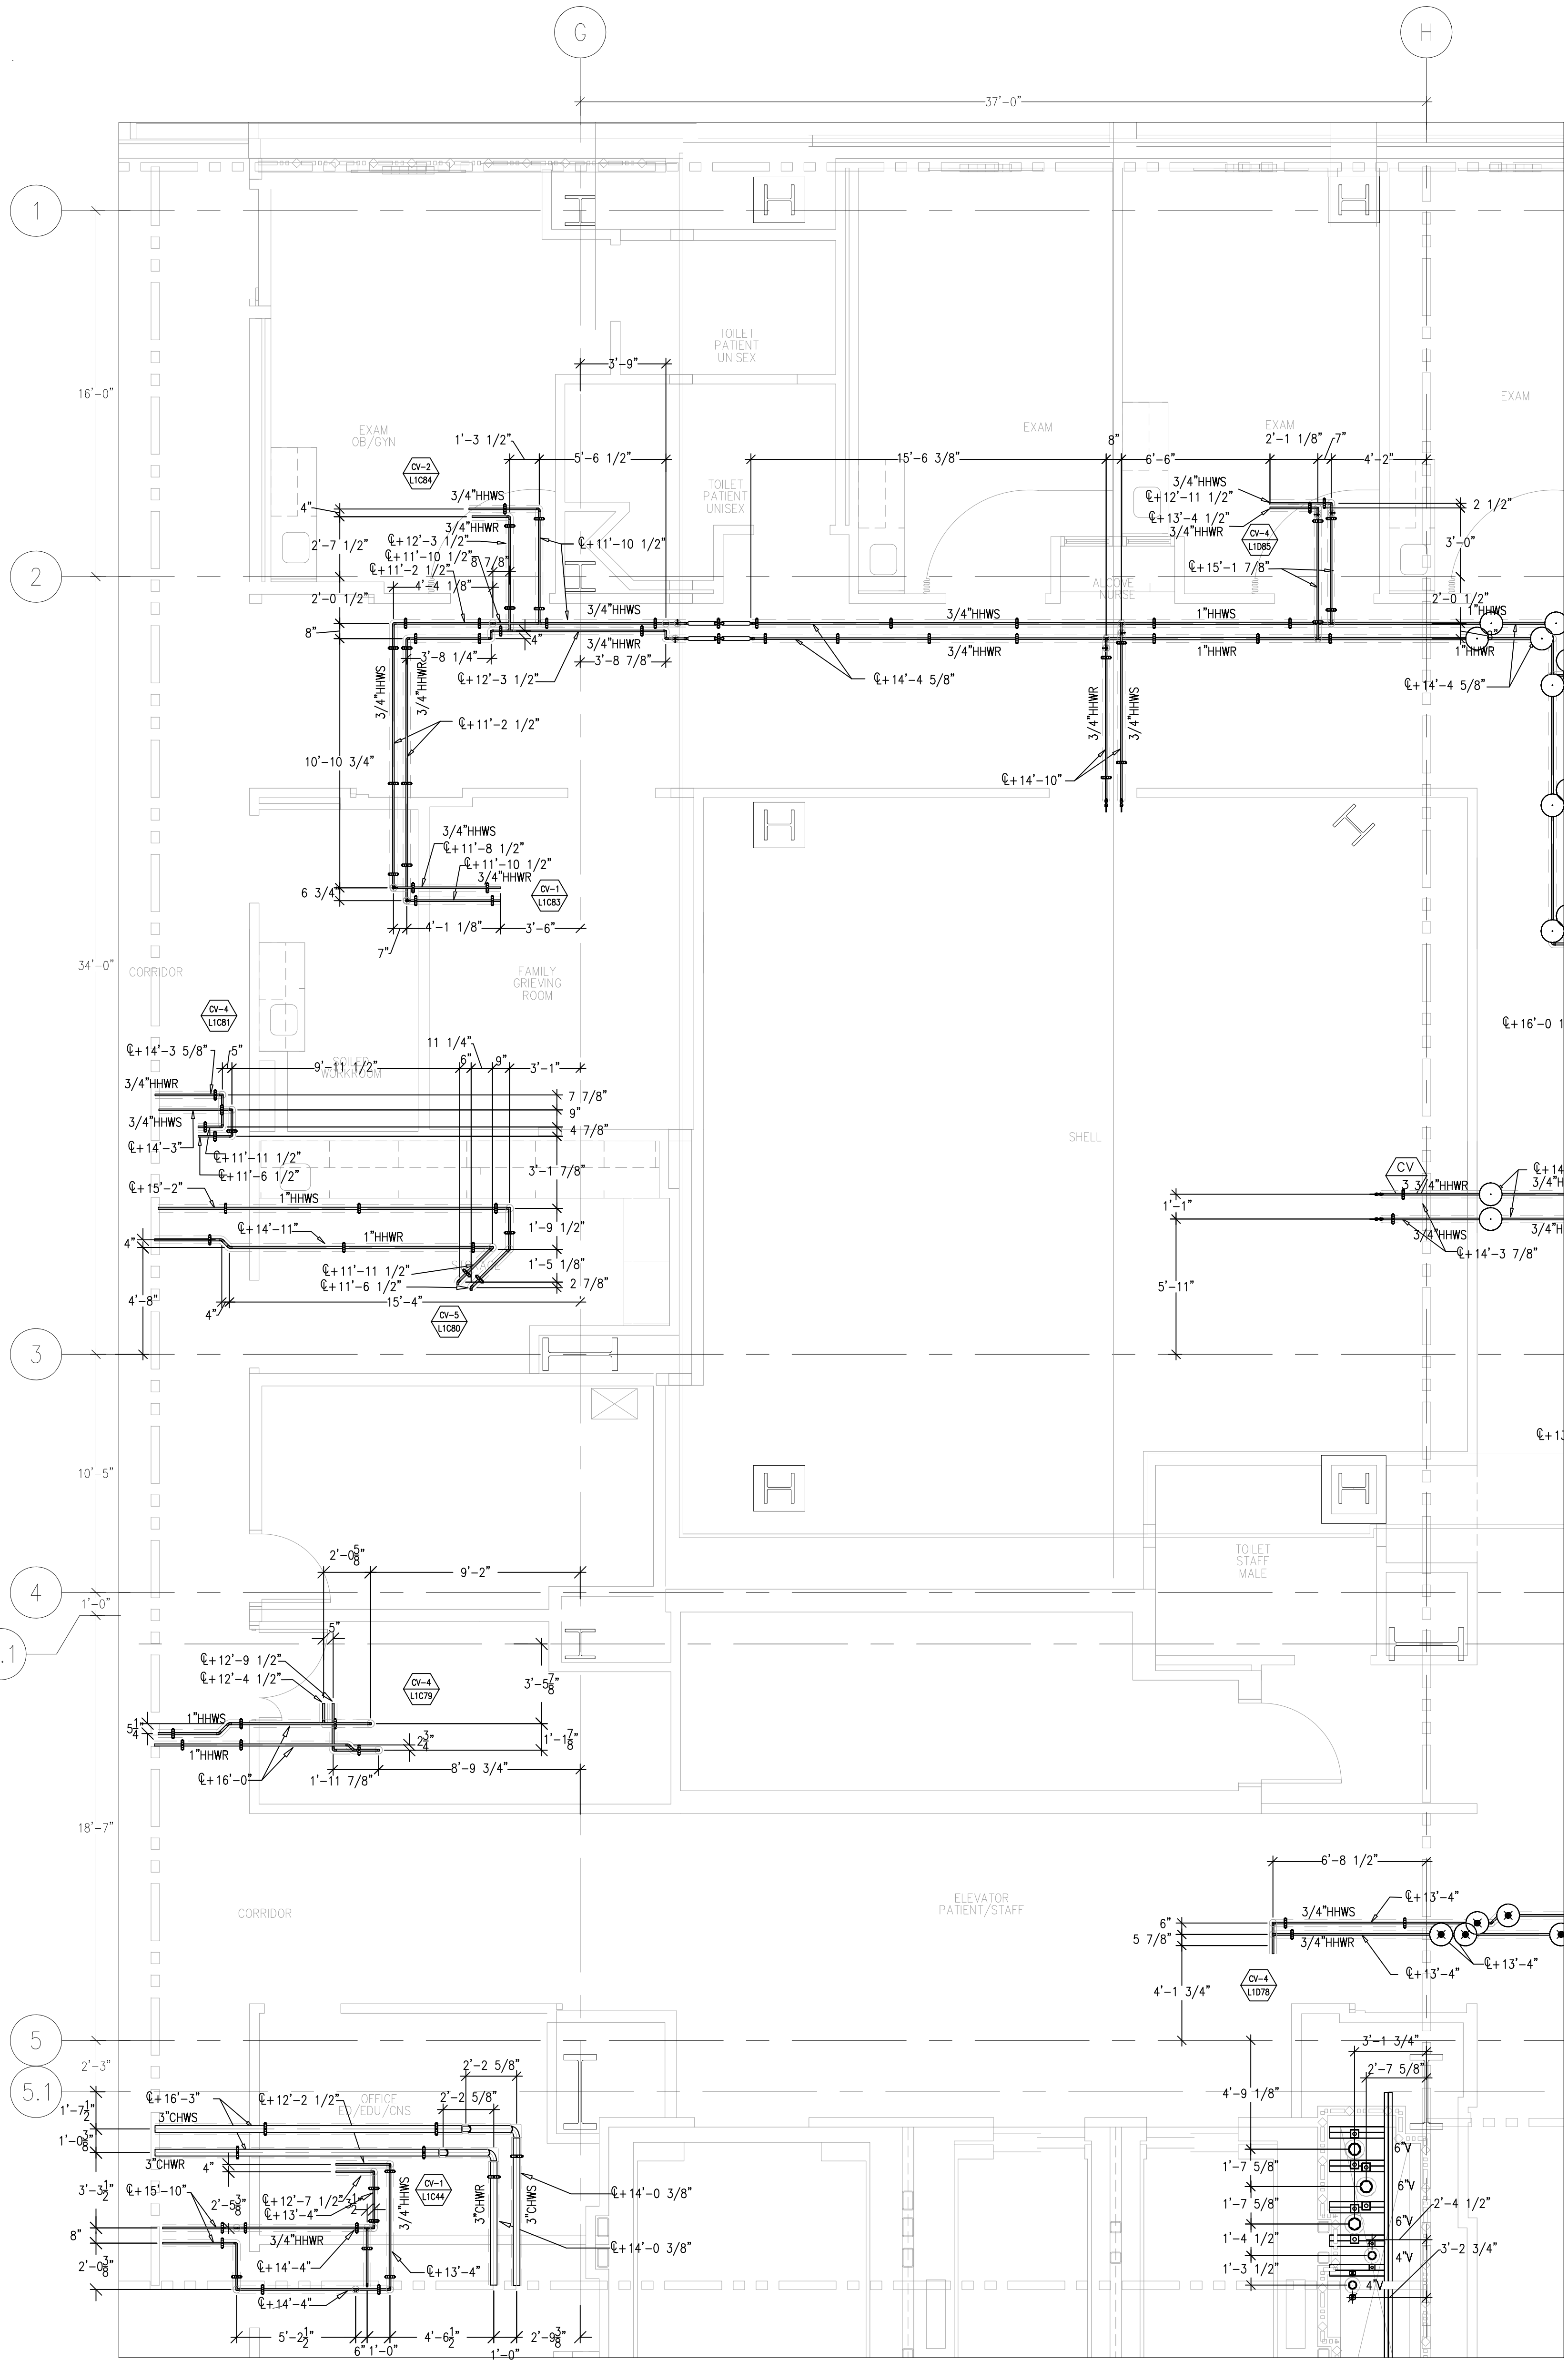

DATE: 6-18-12 BY: J.CLINTON

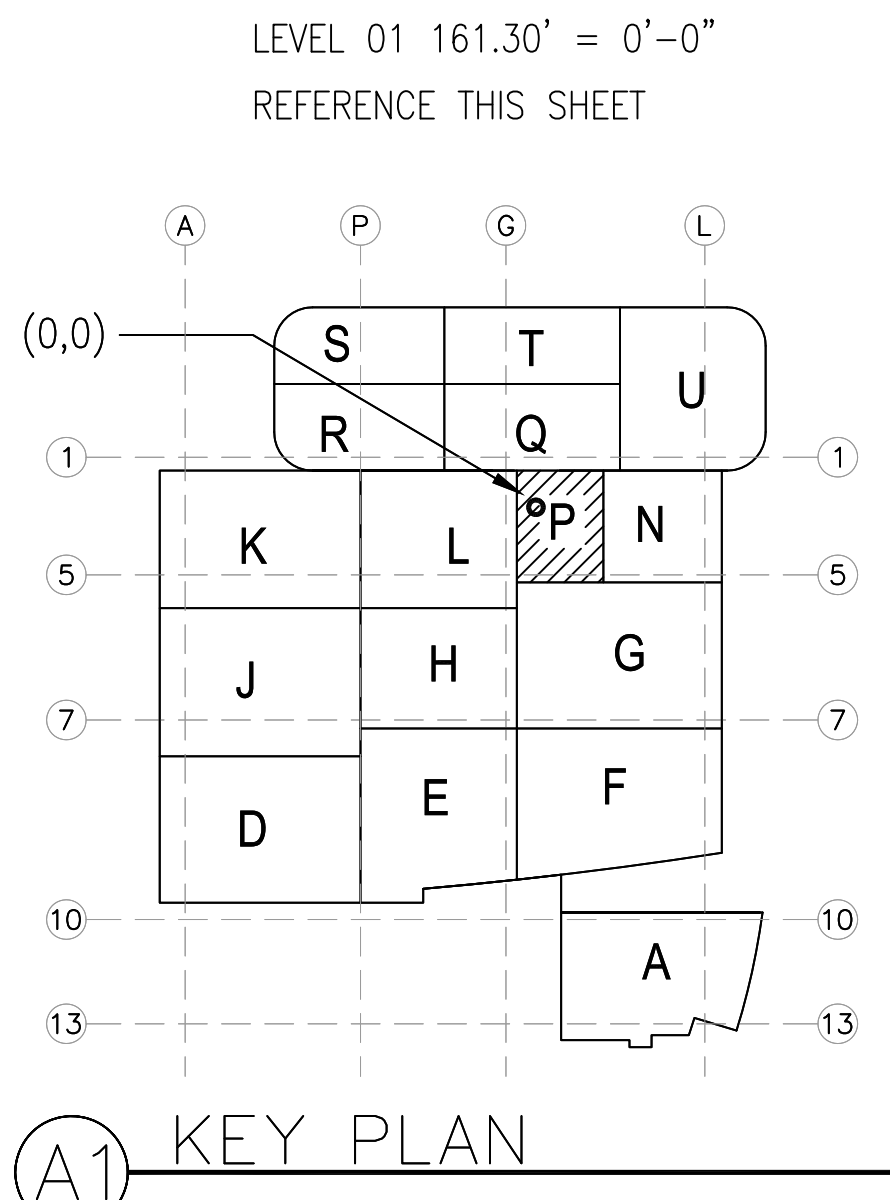

COORD.	SIGNATURE	DATE
McGARRY		
MECHANICAL DUCT		
MECHANICAL PIPE		
PLUMBING		
ELECTRICAL		
FIRE SPRINKLER		
PIPE		
DRYWALL/FRAMER		
REFRIGERATION		
STRUCTURAL		

[illegible]

CHILDREN'S HOSPITAL
OF ORANGE COUNTY
455 S. Main St.
Orange, CA 92668-3874
TOWER II
MECHANICAL PIPE FLOOR PLAN - LEVEL 01 AREA-P

PLANET
PAN-PACIFIC
PLANNING & ARCHITECTS
Murray Company
2919 E. VICTORIA STREET, RANCHO DOMINGUEZ, CA 90221
PH. 310 637-1500 FAX. 310 604-0359

DRAWN	SB
CHECKED	
M.M.	
DATE	9/4/2012
SCALE	1/4" = 1'-0"
JOB NO.	09-006
DRAWING NUMBER	MP3.1P
REFERENCE DRAWING	
A3.1P	
P3.1P	
1 OF 1 SHEETS	


[illegible]

DATE: 6-18-12 BY: J.CLINTON





DRAWN
 SB
 CHECKED
 M.M.
 DATE
 9/4/2012
 SCALE
 1/4" = 1' - 0"
 JOB NO.
 09-006
 DRAWING NUMBER
 MP3.1Q
 REFERENCE DRAWING
 A3.1P
 P3.1P
 1 OF 1 SHEETS

This document and the design it covers are the property of Murray Co. They are loaned only with the borrower's expressed written agreement that they will not be reproduced, copied, loaned, exhibited, or used in any other way, except by written consent from Murray Co. to the borrower.

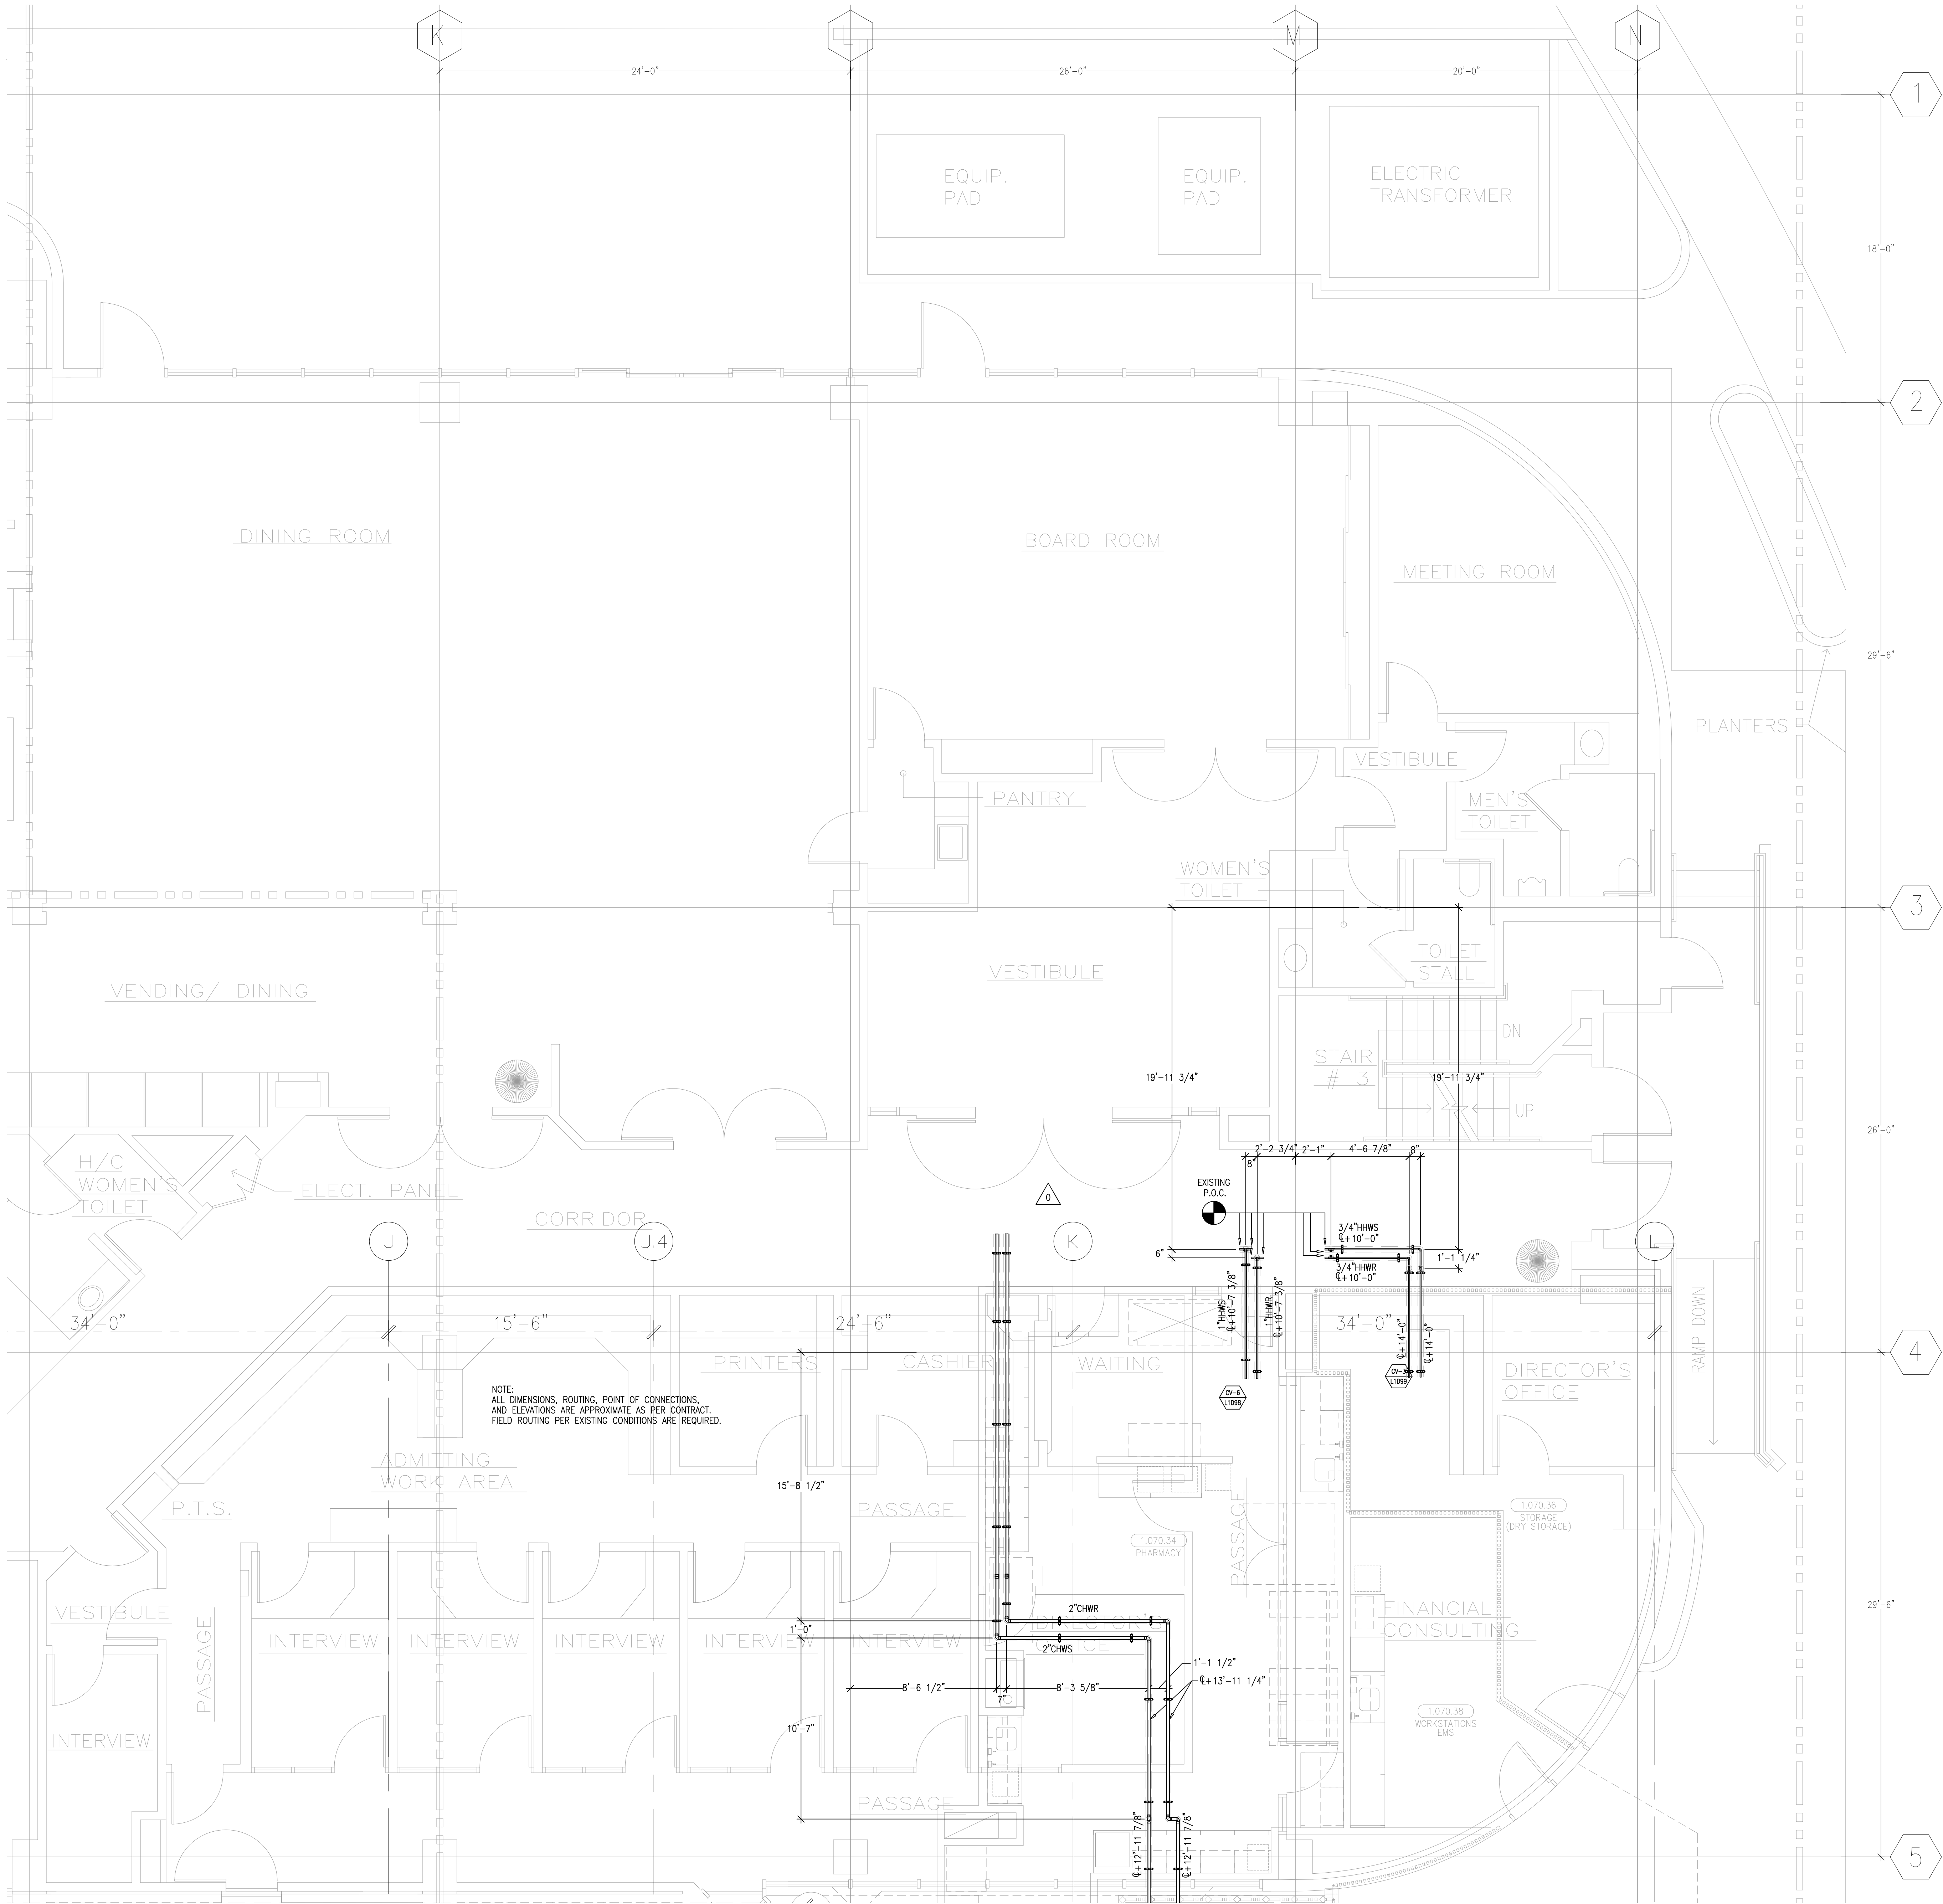

AS-BUILTS

DATE: 6-18-12 BY: J. CLINTON

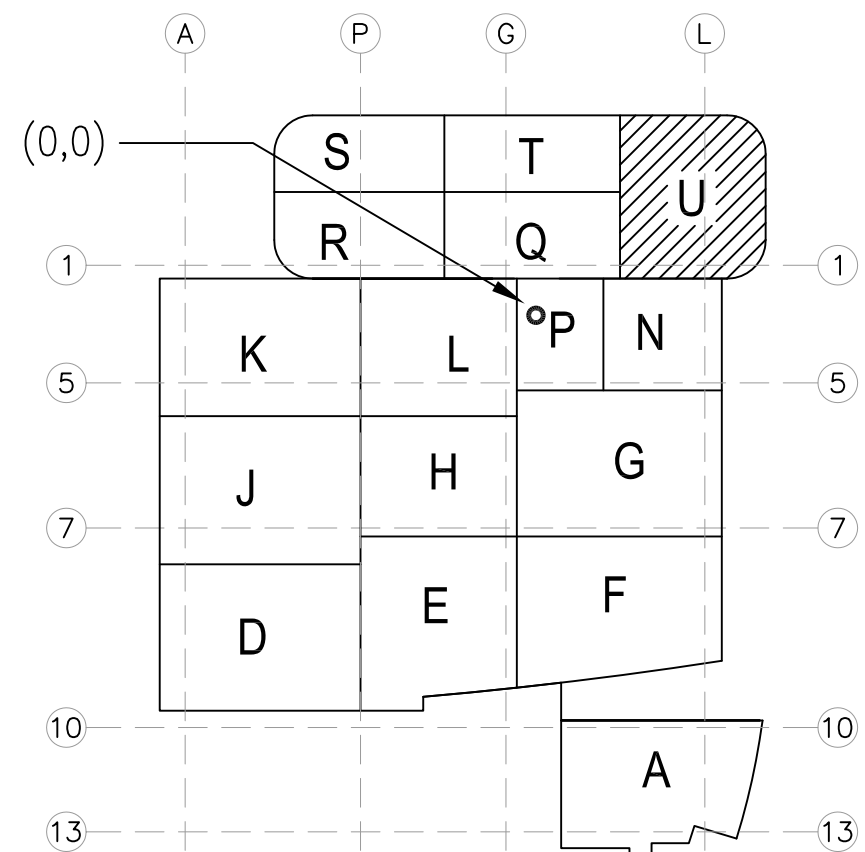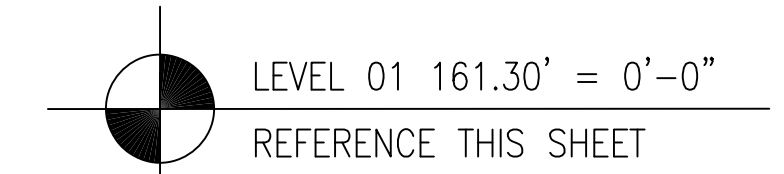

KEY PLAN

REVISIONS	BY

COORD.	SIGNATURE	DATE
MECHANICAL		
ELECTRICAL		
PLUMBING		
STRUCTURAL		

ANS.	SENT	R.F.I.	ANS.	SENT	R.F.I.	ANS.	SENT	R.F.I.	ANS.	SENT	R.F.I.

CHILDREN'S HOSPITAL
OF ORANGE COUNTY
455 S. MAIN ST.
ORANGE, CA 92668-3974

TOWER II

MECHANICAL PIPE FLOOR PLAN - LEVEL 01 AREA J

PAN-PACIFIC
PLANNING & ARCHITECTURAL

2919 E. VICTORIA STREET, RANCHO DOMINGUEZ, CA 90221
PH. 310 637-1500 FAX 310 604-0359

DRAWN
R.O.

CHECKED
M.M.

DATE
9/4/2012

SCALE
1/4" = 1'-0"

JOB NO.
09-006

DRAWING NUMBER
MP3.1U

REFERENCE DRAWING
A3.1U
P3.1U

1 OF 1 SHEETS