



This document and the design it covers are the property of Murray Co. They are loaned only with the borrower's expressed written agreement that they will not be reproduced, copied, loaned, exhibited, or used in any other way, except by written consent from Murray Co. to the borrower.

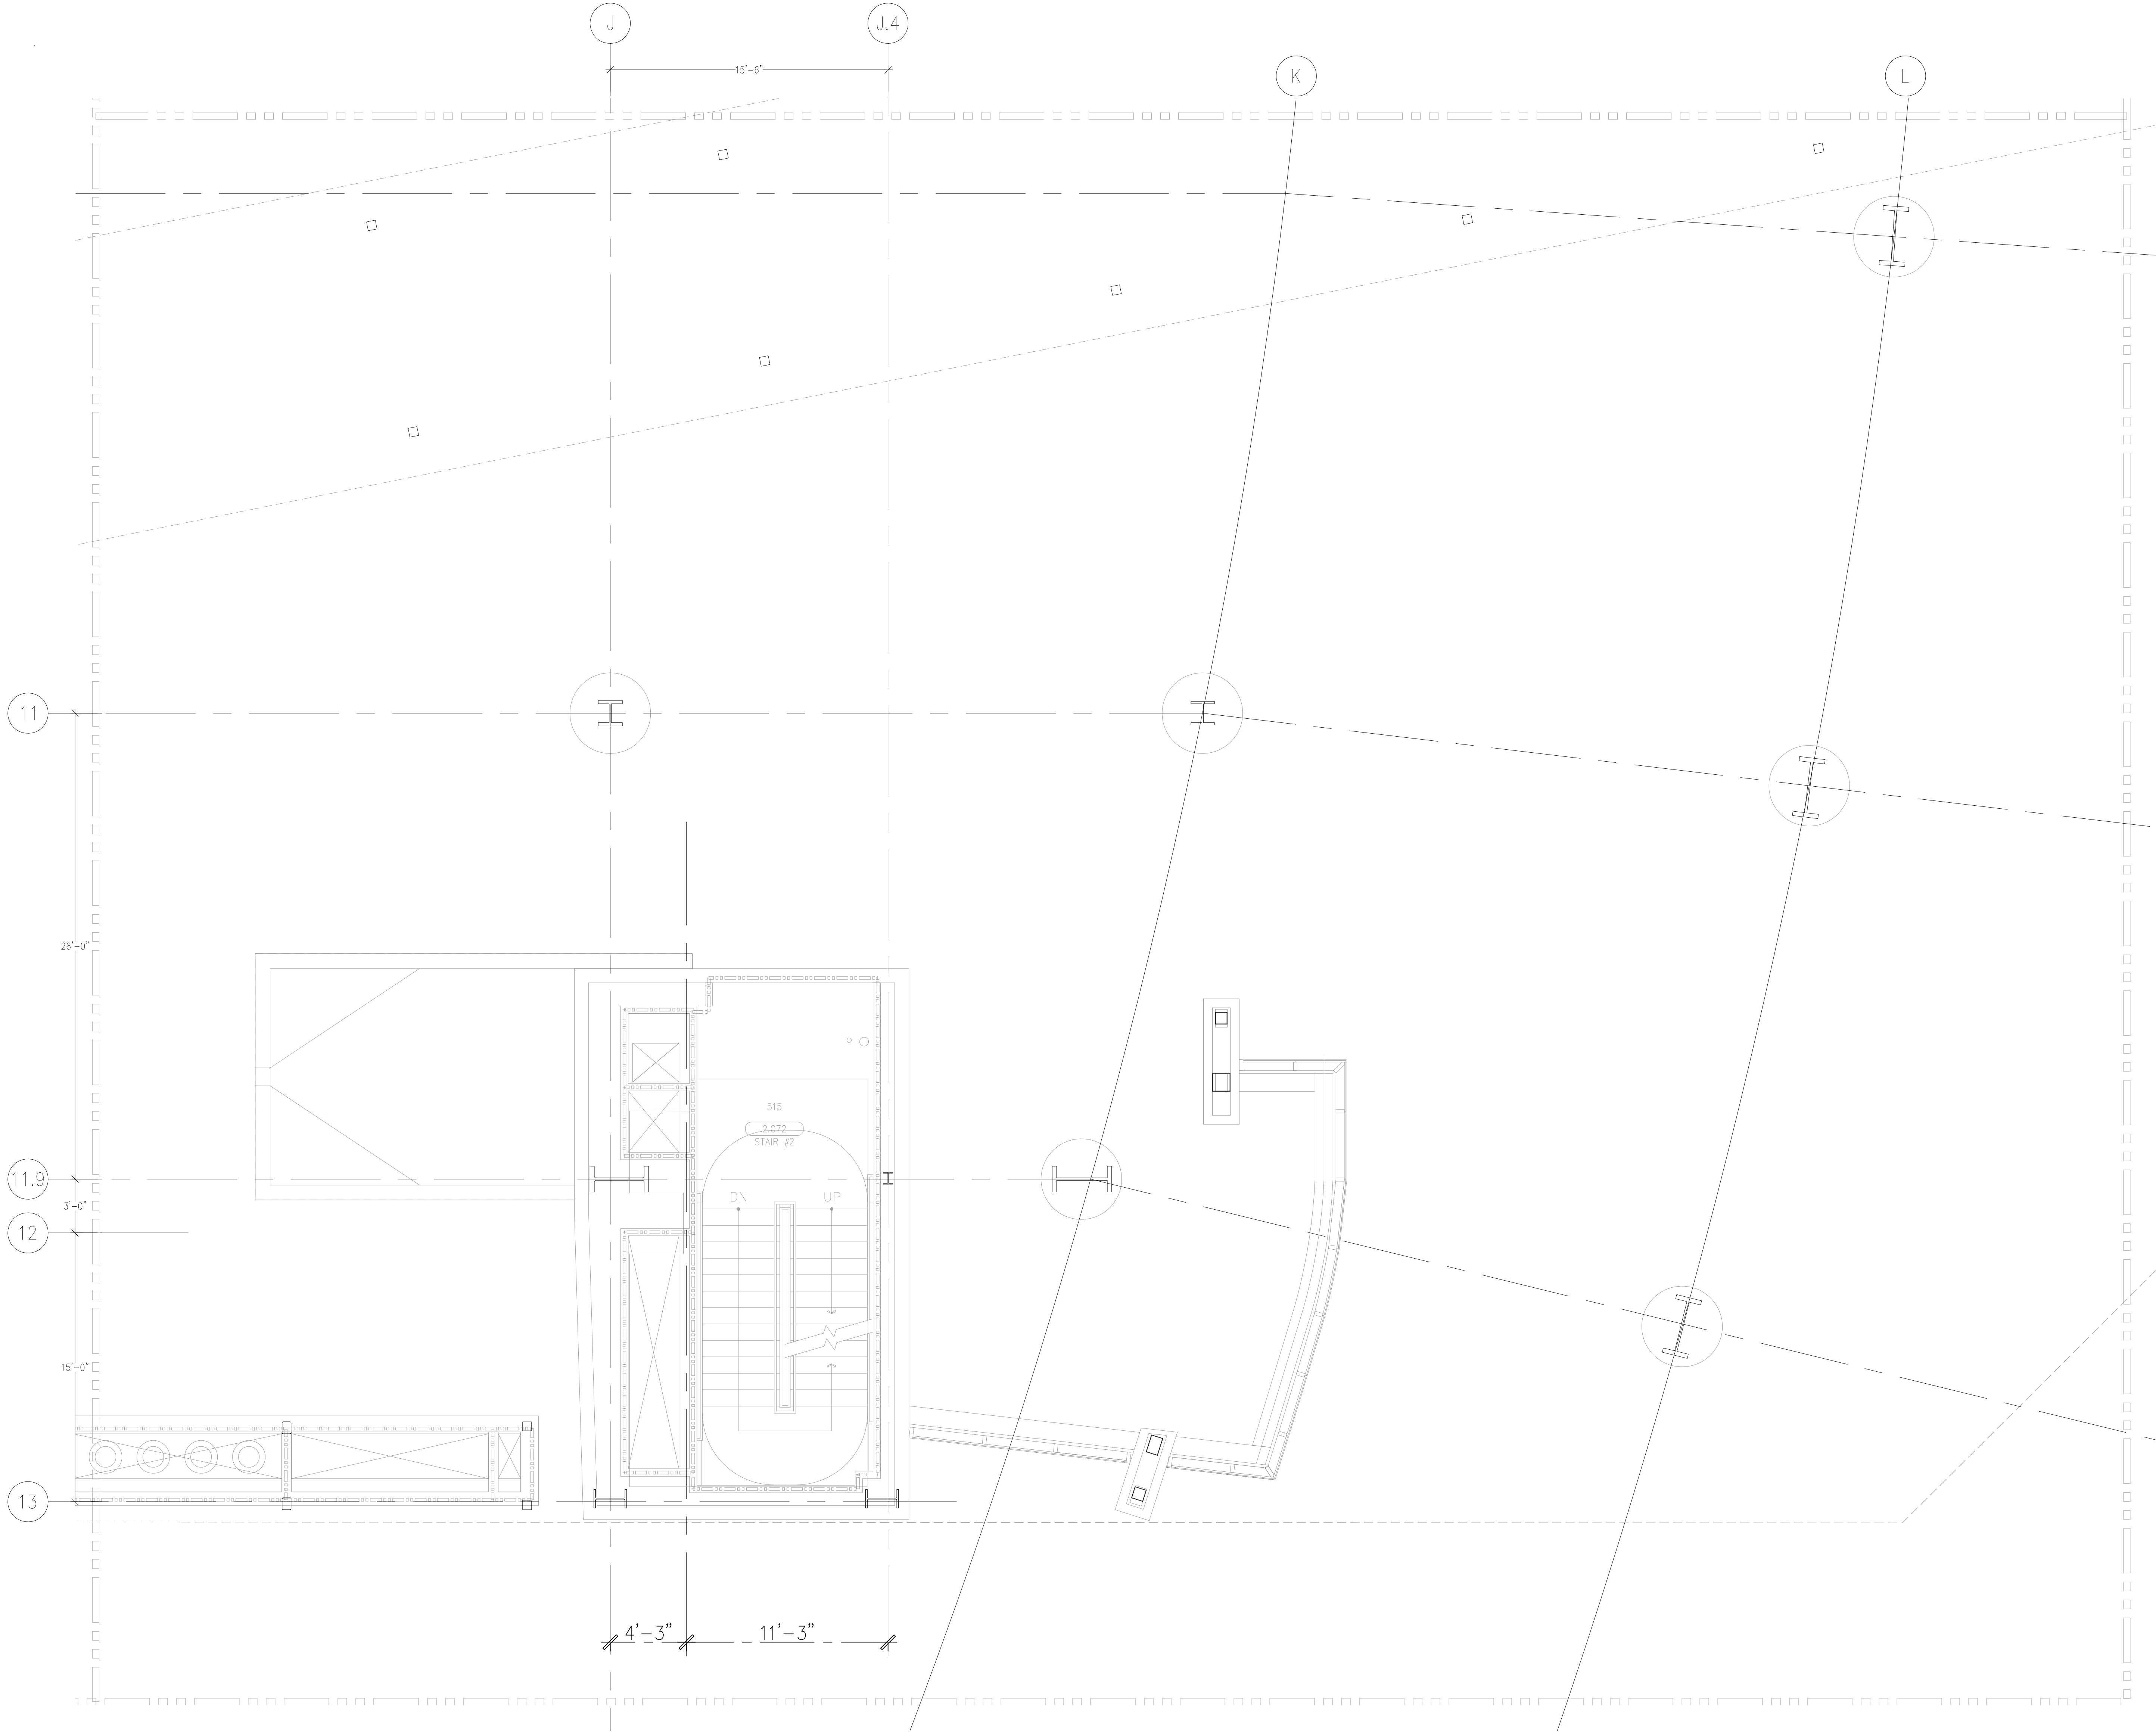

AS-BUILTS

DATE: 6-18-12 BY: J.CLINTON

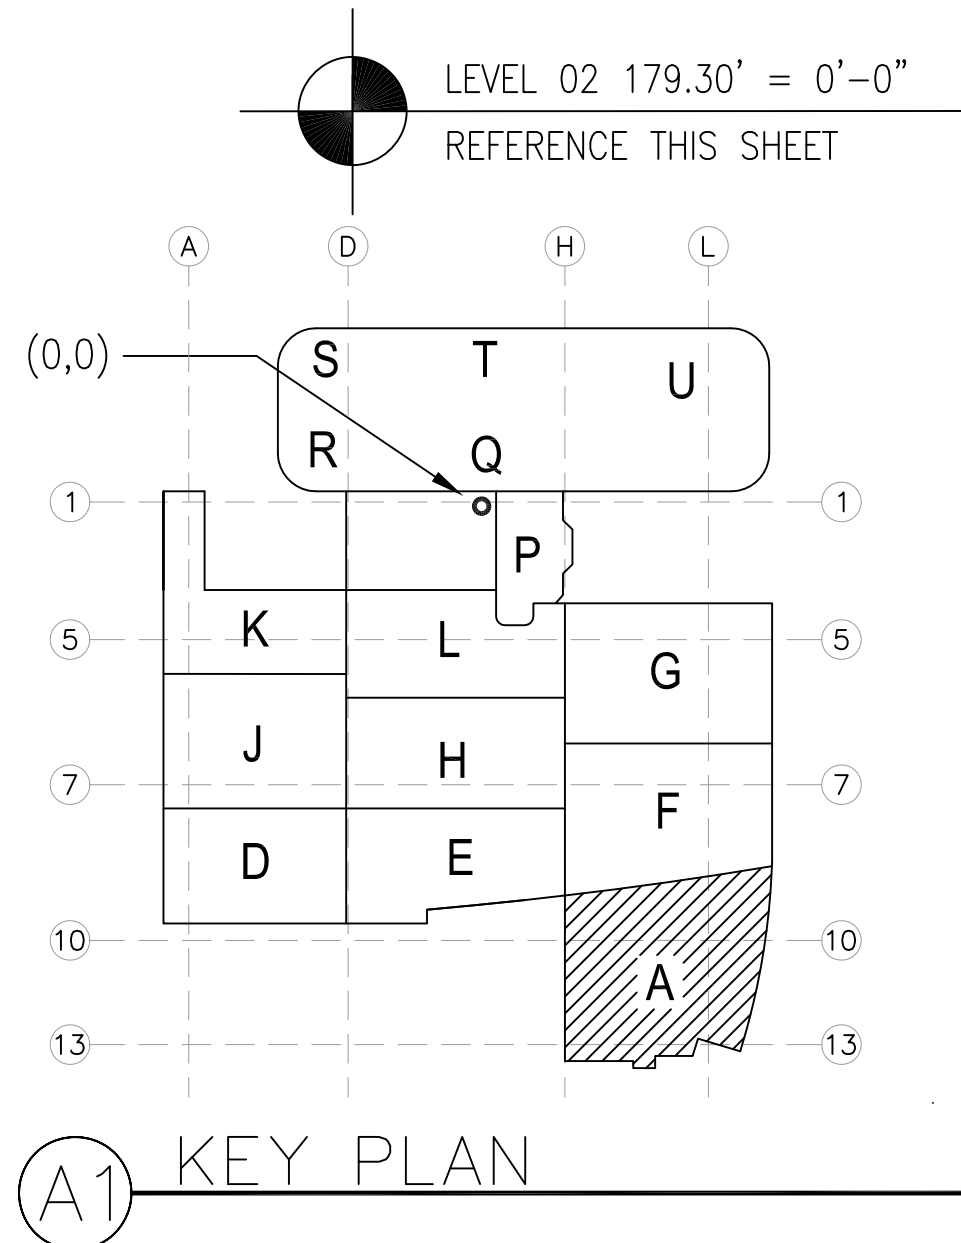

REVISIONS	BY

COORD.	SIGNATURE	DATE
MECHANICAL		
MECHANICAL		
PLUMBING		
ELECTRICAL		
FIRE SPRINKLER		
PIPE		
DRYWALL/FRAMING		
REFRIGERATION		
STRUCTURAL		

R.F.I.	SENT	ANS.	R.F.I.	SENT	ANS.	R.F.I.	SENT	ANS.

**CHILDREN'S HOSPITAL
OF ORANGE COUNTY**
455 S. MAIN ST.
ORANGE, CA 92668-5974
PH. 714.936.5974

TOWER II



PLUMBING FLOOR PLAN - LEVEL 02 AREA A

PAN-PACIFIC
PLUMBING & MECHANICAL
2919 E. VICTORIA STREET, RANCHO DOMINGUEZ, CA 90221
PH. 310.637-1500 FAX 310.604-0359

Murray Company
2919 E. VICTORIA STREET, RANCHO DOMINGUEZ, CA 90221
PH. 310.637-1500 FAX 310.604-0359


DRAWN R.O.
CHECKED M.M.
DATE 9/4/2012
SCALE 1/4"=1'-0"
JOB NO. 09-006
DRAWING NUMBER MP3.2A
REFERENCE DRAWING A3.2A P3.2A
1 OF 1 SHEETS

This document and the design it covers are the property of Murray Co. They are loaned only with the borrower's expressed agreement that they will not be reproduced, copied, loaned, exhibited, or used in any other way, except by written consent from Murray Co. to the borrower.

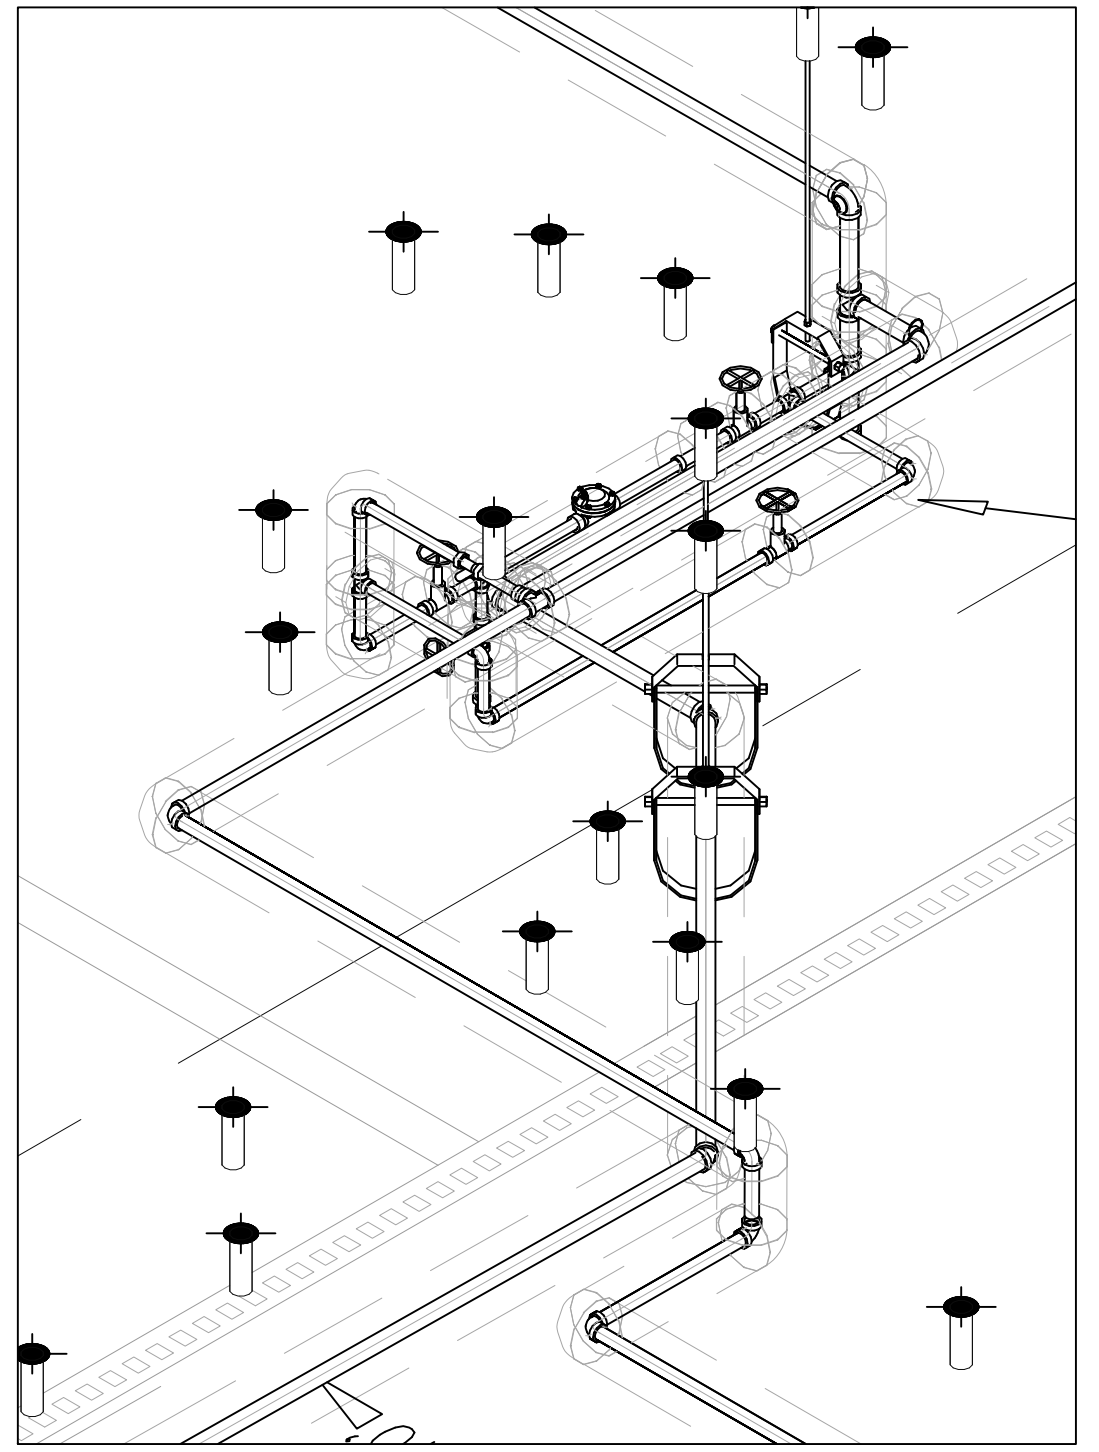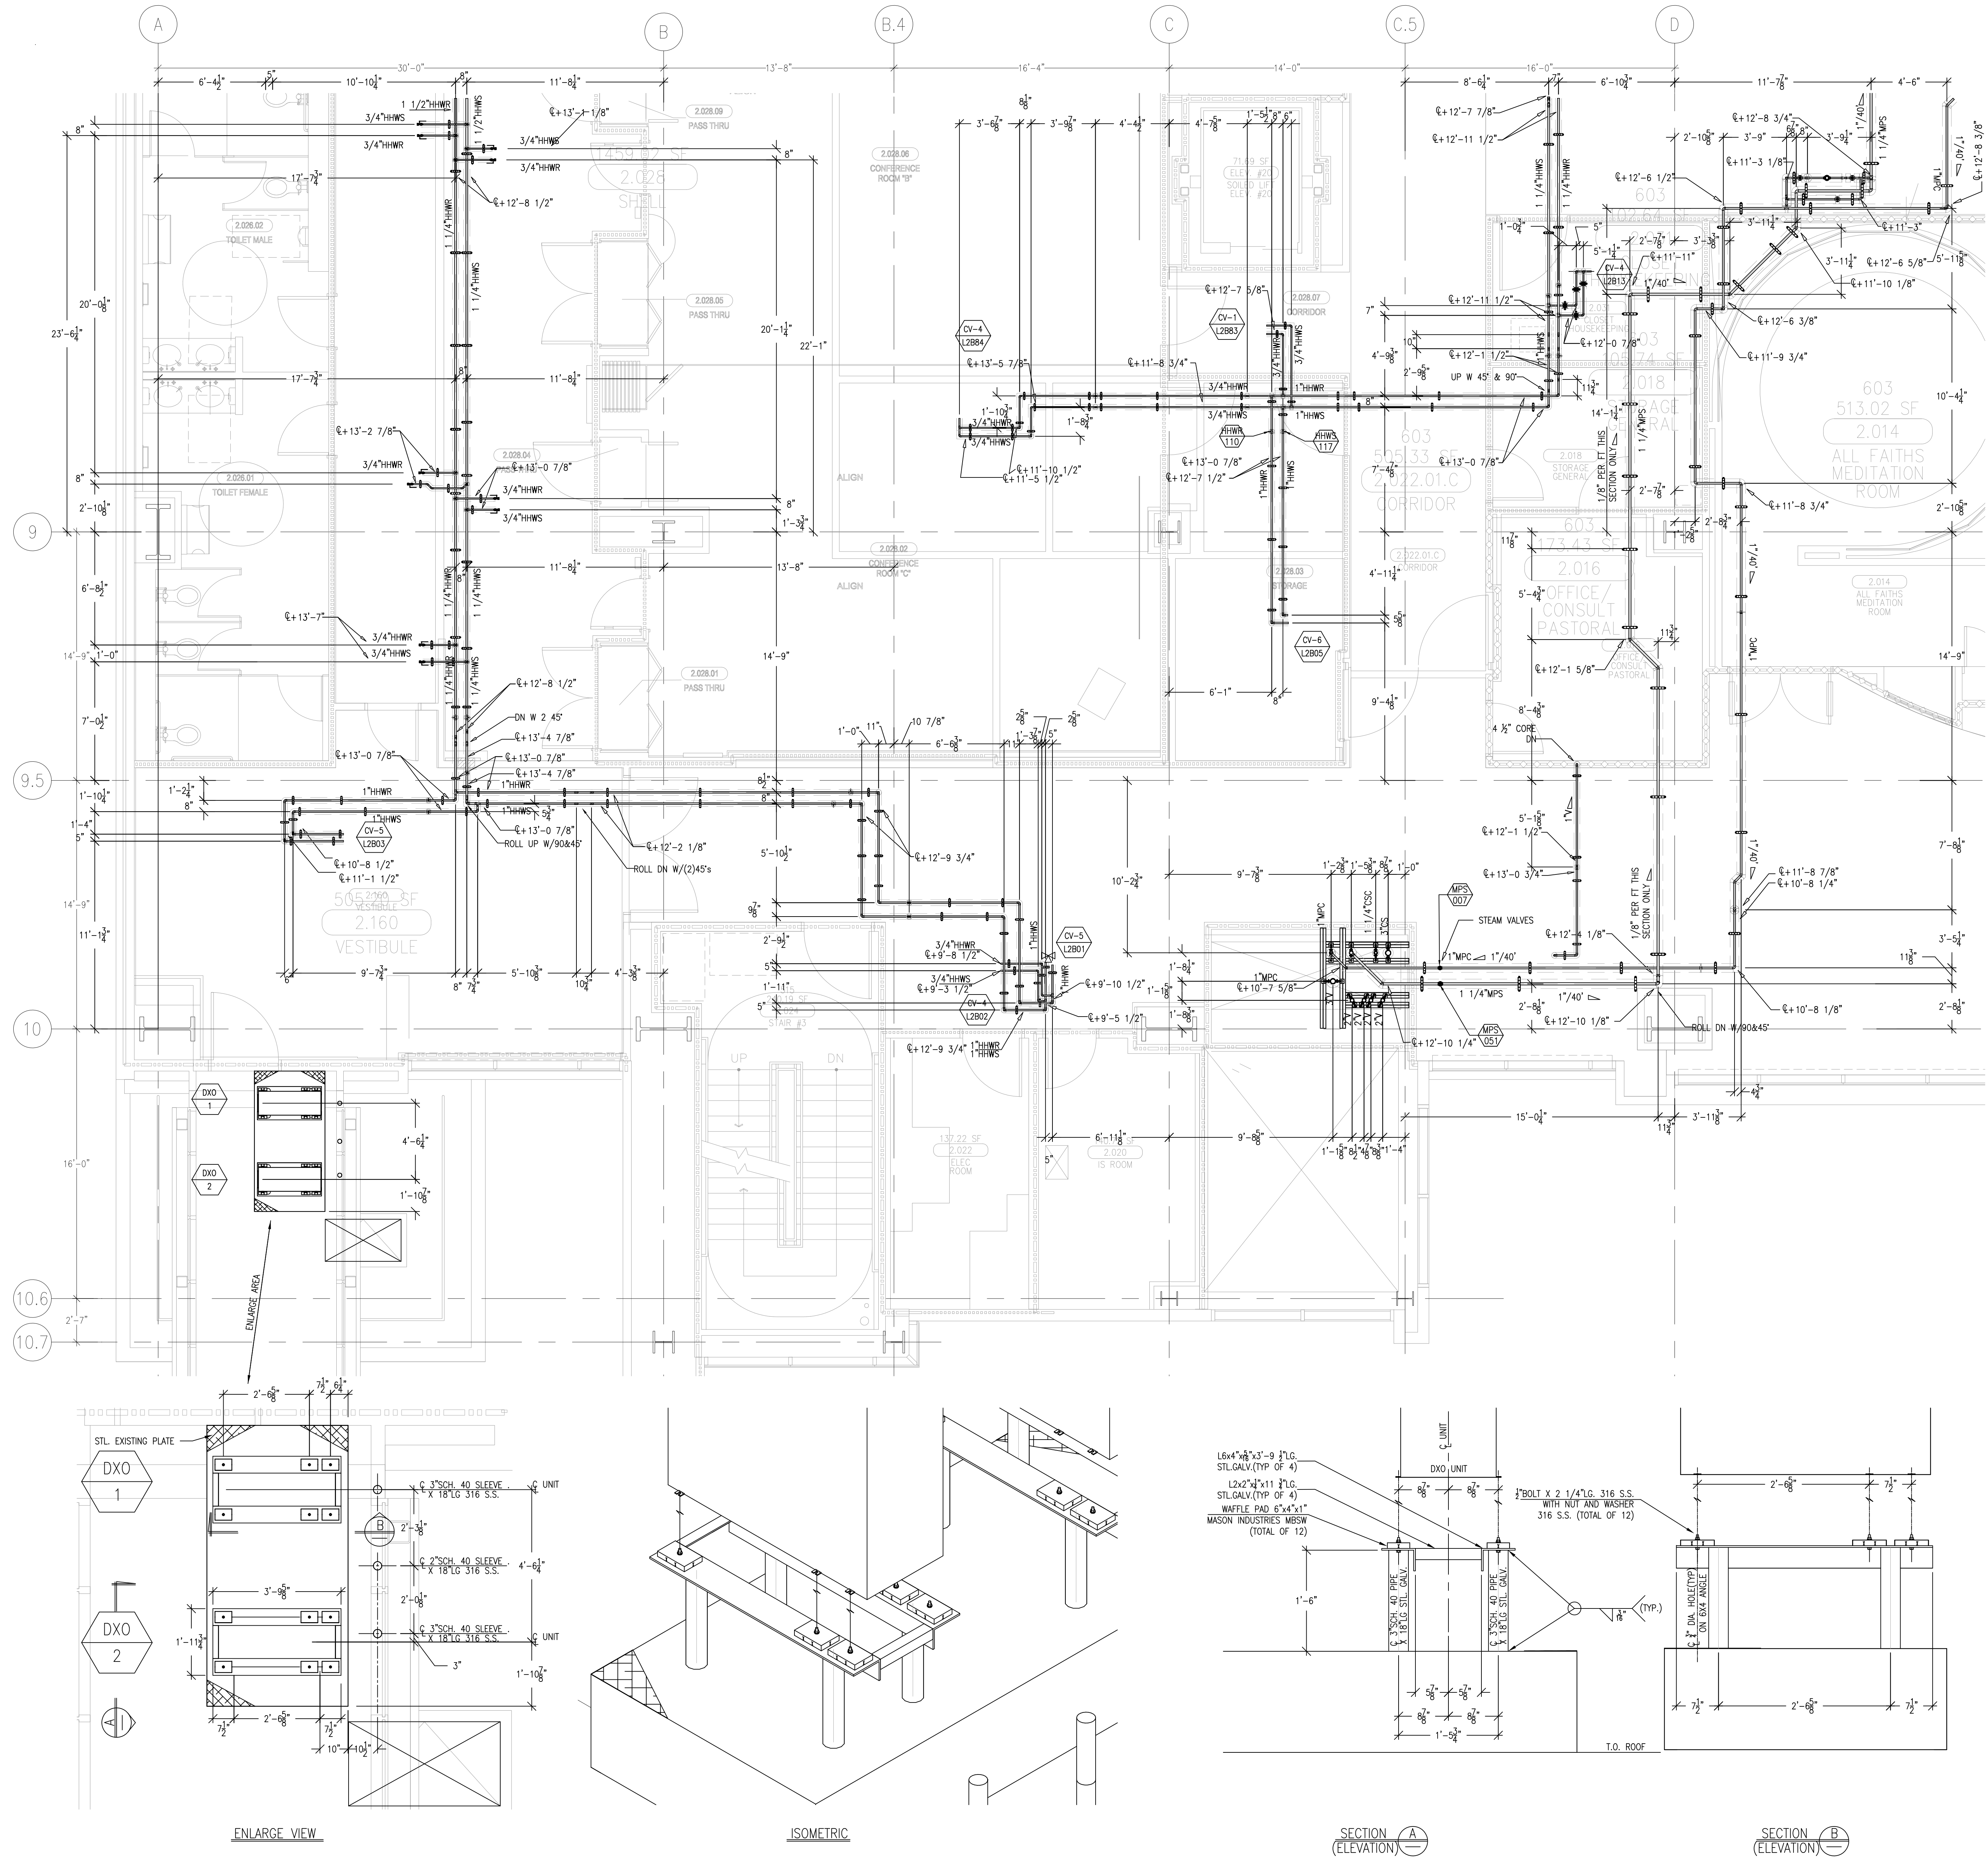

AS-BUILTS

DATE: 6-18-12 BY: J.CLINTON

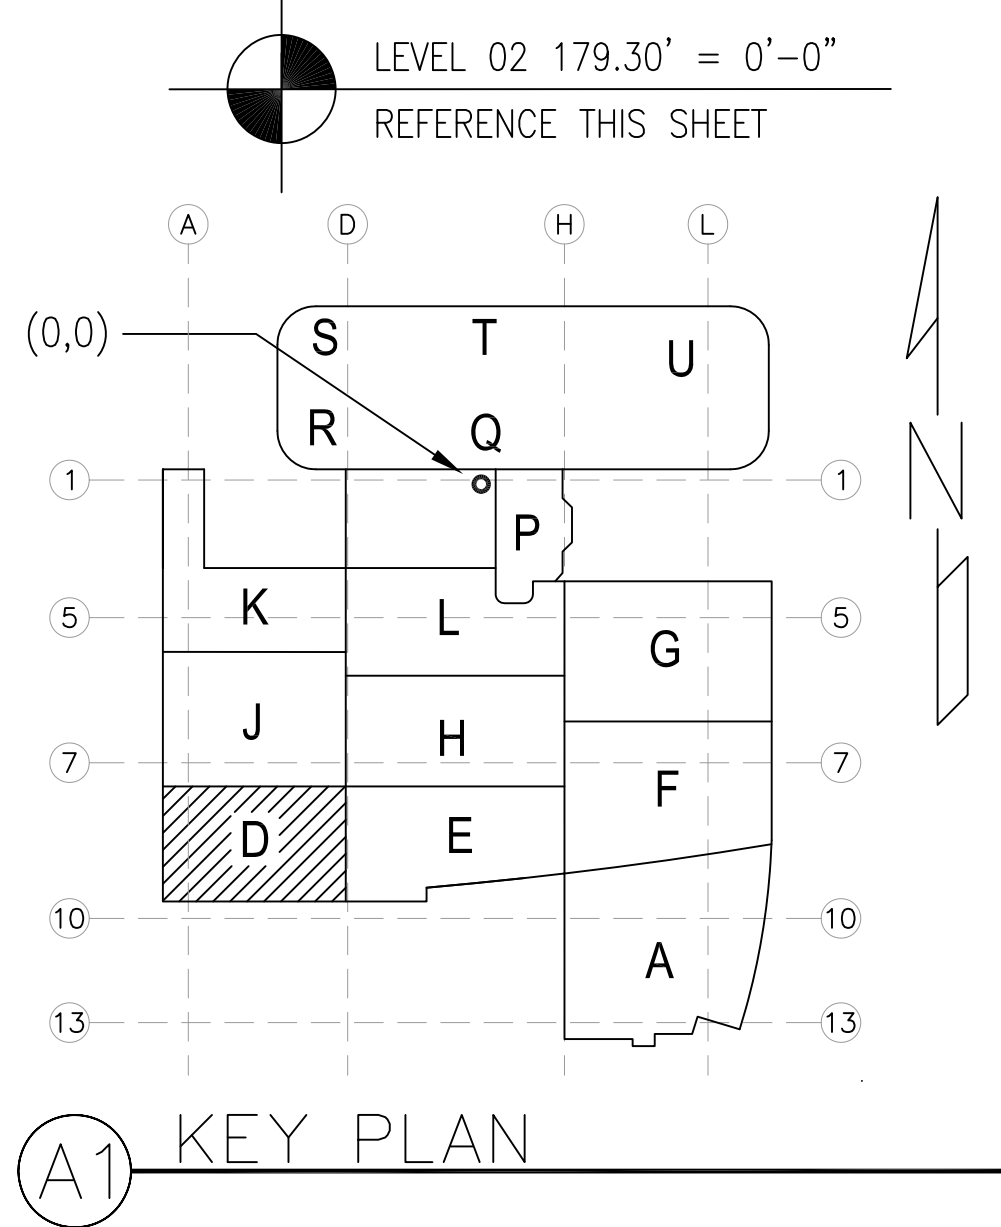[illegible]

MECHANICAL DUCT	
MECHANICAL PIPE	
PLUMBING	
ELECTRICAL	
FIRE SPRINKLER	
PIPE	
DRAIN/W/FRAMER	
REFRIGERATION	
STRUCTURAL	

[illegible]

CHILDREN'S HOSPITAL
OF ORANGE COUNTY
455 S. Main St.
Orange, CA 92668-3874
TOWER II
MECHANICAL PIPE FLOOR PLAN - LEVEL 02 AREA-D


PMI
PAN-PACIFIC
PLUMBING & MECHANICAL

 **Murray Company**

2919 E. VICTORIA STREET, RANCHO DOMINGUEZ, CA 90221
PH. 310.637-1500 FAX 310.604-0359


DRAWN
S.B.
CHECKED
M.M.
DATE
12/16/10
SCALE
1/4"=1'-0"
JOB NO.
09-006
DRAWING NUMBER
MP3.2D
REFERENCE DRAWING
A3.2D
P3.2D
1 OF 1 SHEETS

This document and the design it covers are the property of Murray Co. They are loaned only with the borrower's expressed written agreement that they will not be reproduced, copied, loaned, exhibited, or used in any other way, except by written consent from Murray Co. to the borrower.

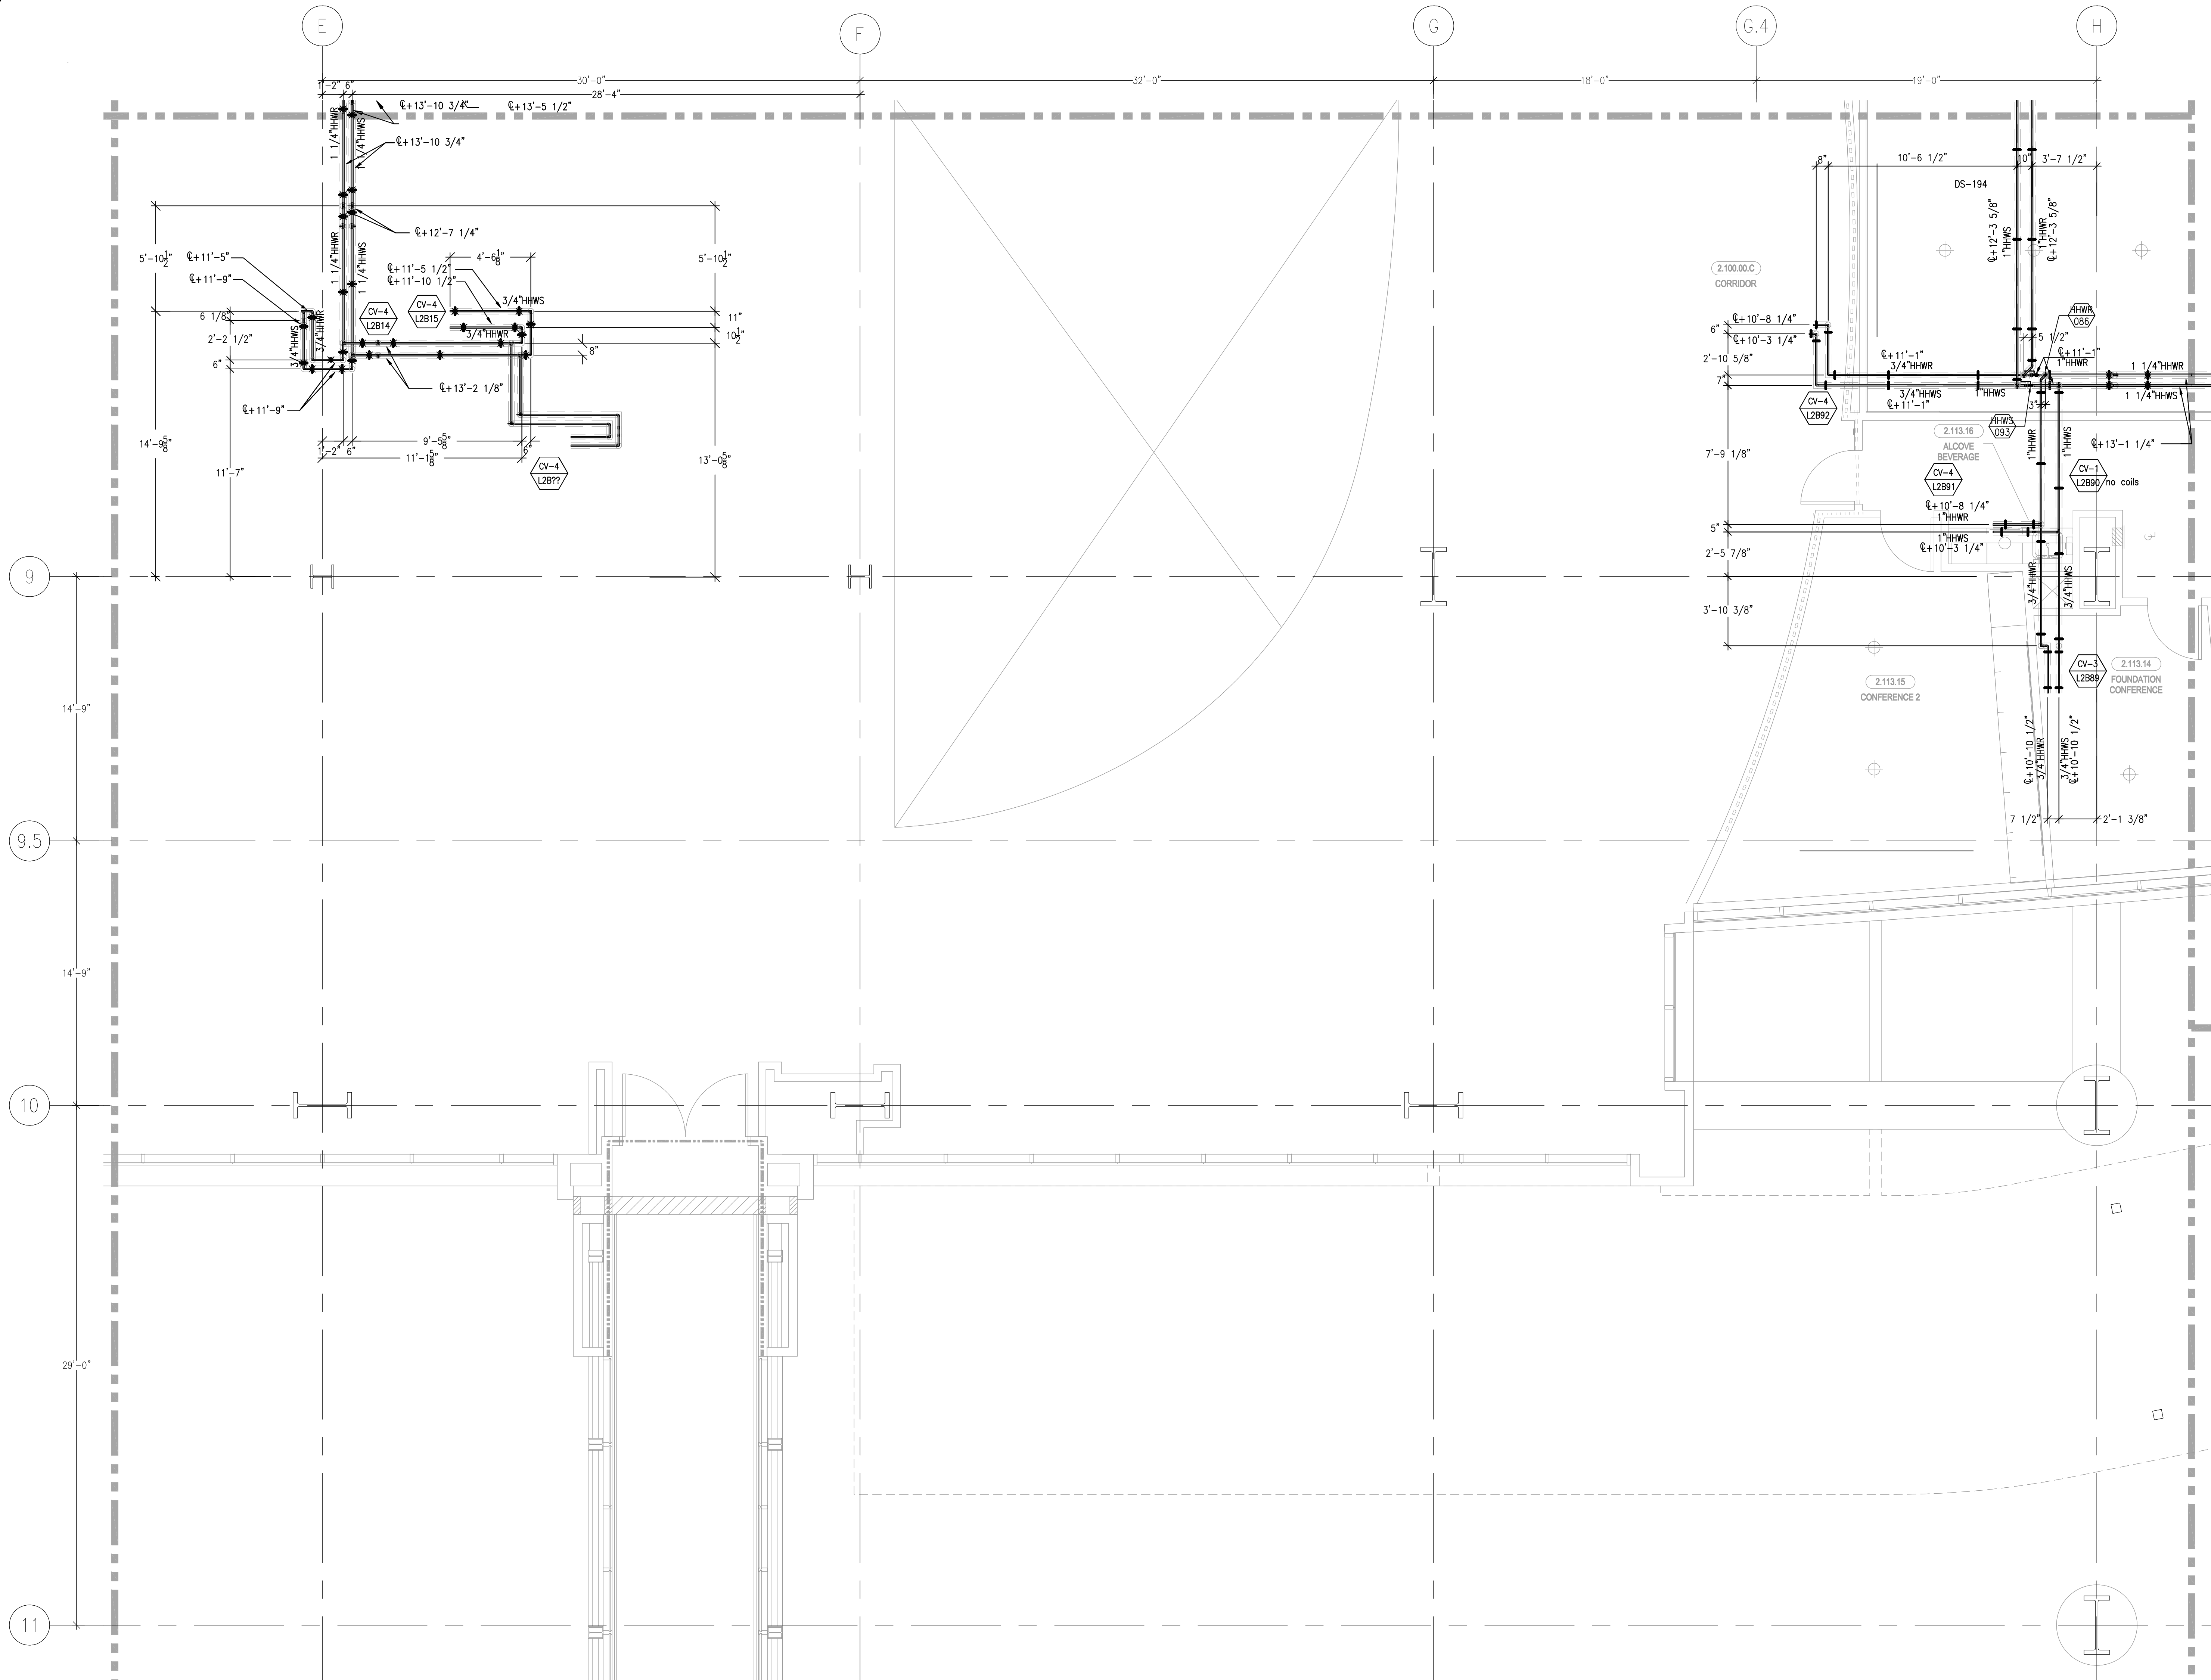

AS-BUILTS

DATE: 6-18-12 BY: J.CLINTON

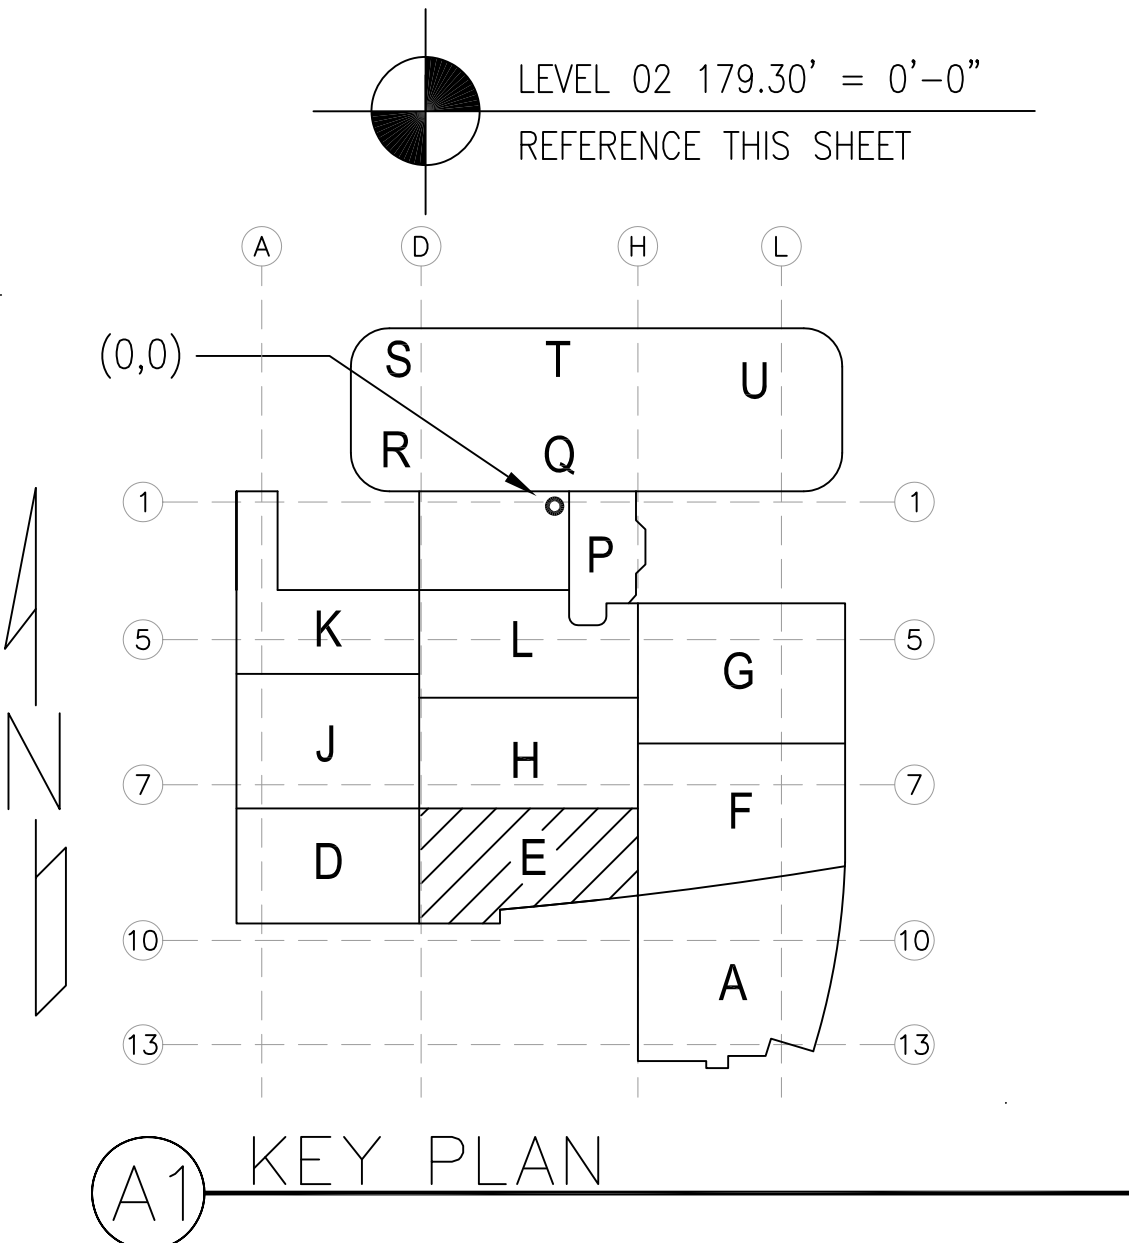

REVISIONS	BY

COORD.	SIGNATURE	DATE
MECHANICAL		
ELECTRICAL		
PLUMBING		
STRUCTURAL		

R.F.I.	SENT	ANS.	R.F.I.	SENT	ANS.	R.F.I.	SENT	ANS.	R.F.I.	SENT	ANS.

CHILDREN'S HOSPITAL
OF ORANGE COUNTY
455 S. MAIN ST.
ORANGE, CA 92668-9874
TOWER II
MECHANICAL PIPE FLOOR PLAN - LEVEL 02 AREA F

PAN-PACIFIC
PLUMBING & MECHANICAL
Murray Co.
2919 E. VICTORIA STREET, RANCHO DOMINGUEZ, CA 90221
PH. 310 637-1500 FAX 310 604-0359

DRAWN
S.B.
CHECKED
M.M.
DATE
12/16/10
SCALE
1/4"=1'-0"
JOB NO.
09-006
DRAWING NUMBER
MP3.2E
REFERENCE DRAWING
A3.2F
P3.2F
1 OF 1 SHEETS

Dwg. Files: \\09-006-000-MURRAY-ORANGE-MECHANICAL-PIPE-FLOOR-PLAN-LEVEL-02-AREA-F.dwg Plotted By: jclinton Date: 6-18-12 10:58am

[illegible]


DATE: 6-18-12 BY: J.CLINTON



DRAWN SB
CHECKED
M.M.
DATE
12/16/10
SCALE
1/4" = 1' - 0"
JOB NO.
09-006
DRAWING NUMBER
MP3.2F
REFERENCE DRAWING
A3.2F
P3.2F
1 OF 1 SHEETS

11

DRAWN SB
CHECKED
M.M.
DATE
9/4/2012
SCALE
1/4"=1'-0"
JOB NO.
09-006
DRAWING NUMBER
MP3.2G
REFERENCE DRAWING
A3.2A
P3.2A
1 OF 1 SHEETS

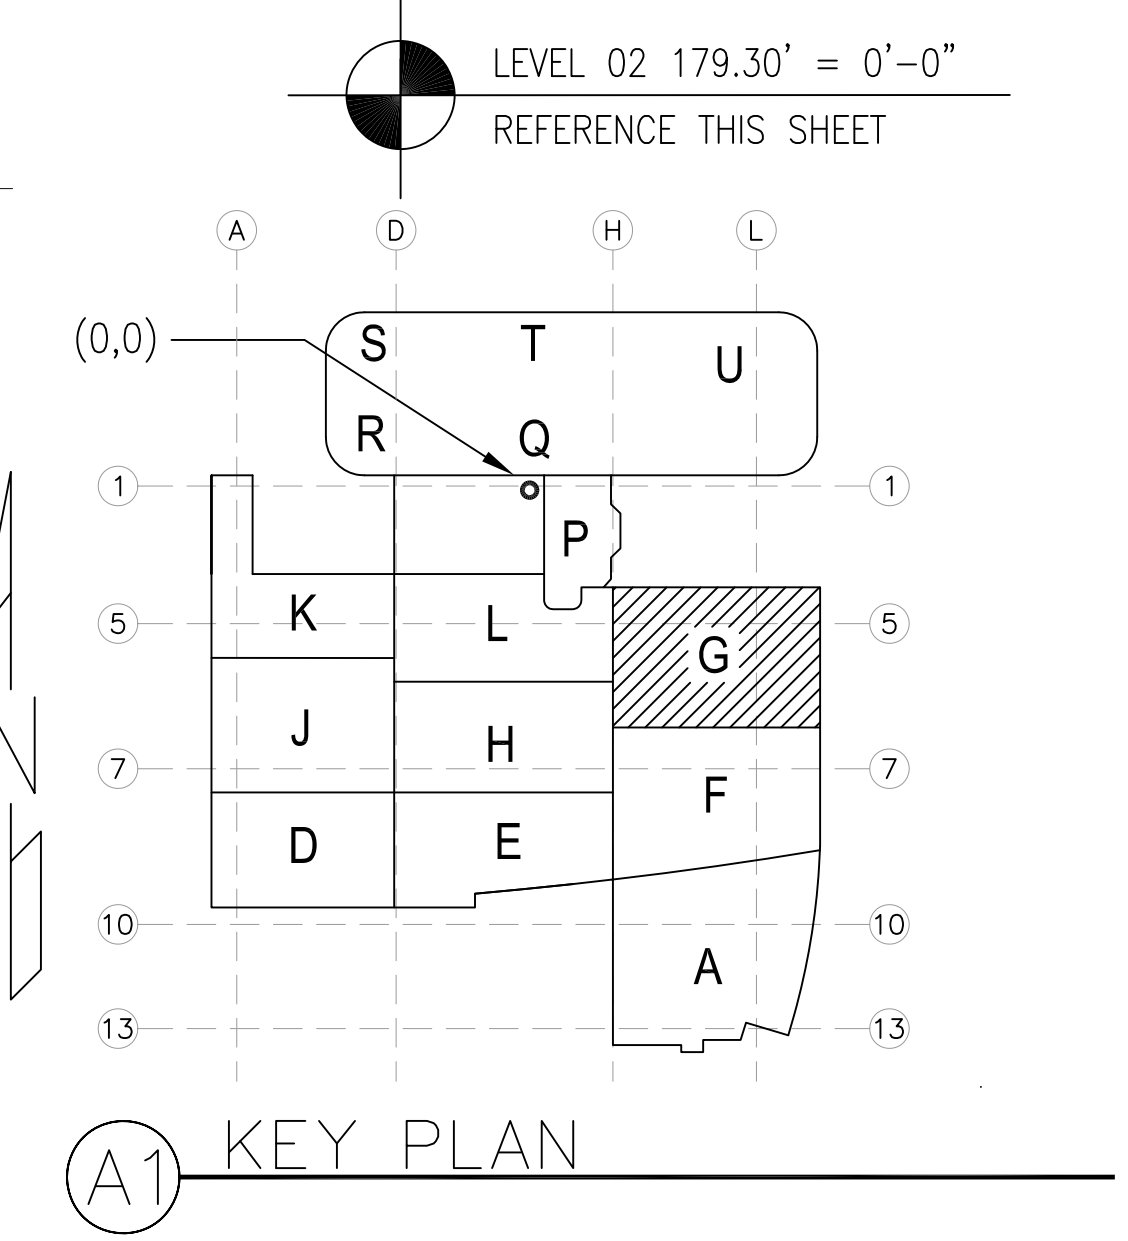

AS-BUILTS
DATE: 6-18-12 BY: J. CLINTON

KEY PLAN

CHILDREN'S HOSPITAL OF ORANGE COUNTY TOWER II
MECHANICAL PIPE FLOOR PLAN - LEVEL 02 AREA-H

REVISIONS

NO.	DATE	DESCRIPTION
1	6-18-12	AS-BUILTS

PROJECT INFORMATION

CHILDREN'S HOSPITAL OF ORANGE COUNTY
455 S. Main St.
Orange, CA 92668-3874
TOWER II
MECHANICAL PIPE FLOOR PLAN - LEVEL 02 AREA-H

DESIGNER
J. CLINTON

DATE
6-18-12

SCALE
1/4" = 1'-0"

JOB NO.
09-006


DRAWING NUMBER
MP3.2H

REFERENCE DRAWING
A3.2H
P3.2H


1 OF 1 SHEETS

DRAWN	S.B.
CHECKED	
M.M.	
DATE	11/30/09
SCALE	1/4"=1'-0"
JOB NO.	09-006
DRAWING NUMBER	MP3.2H
REFERENCE DRAWING	A3.2H
	P3.2H
1	OF 1 SHEETS

document and the design it covers are the property of Murray Co. They are loaned only with the borrowers' expressed written agreement that they will not be reproduced, copied, loaned, exhibited, or used in any other way, except by written consent from Murray Co. to the borrower.

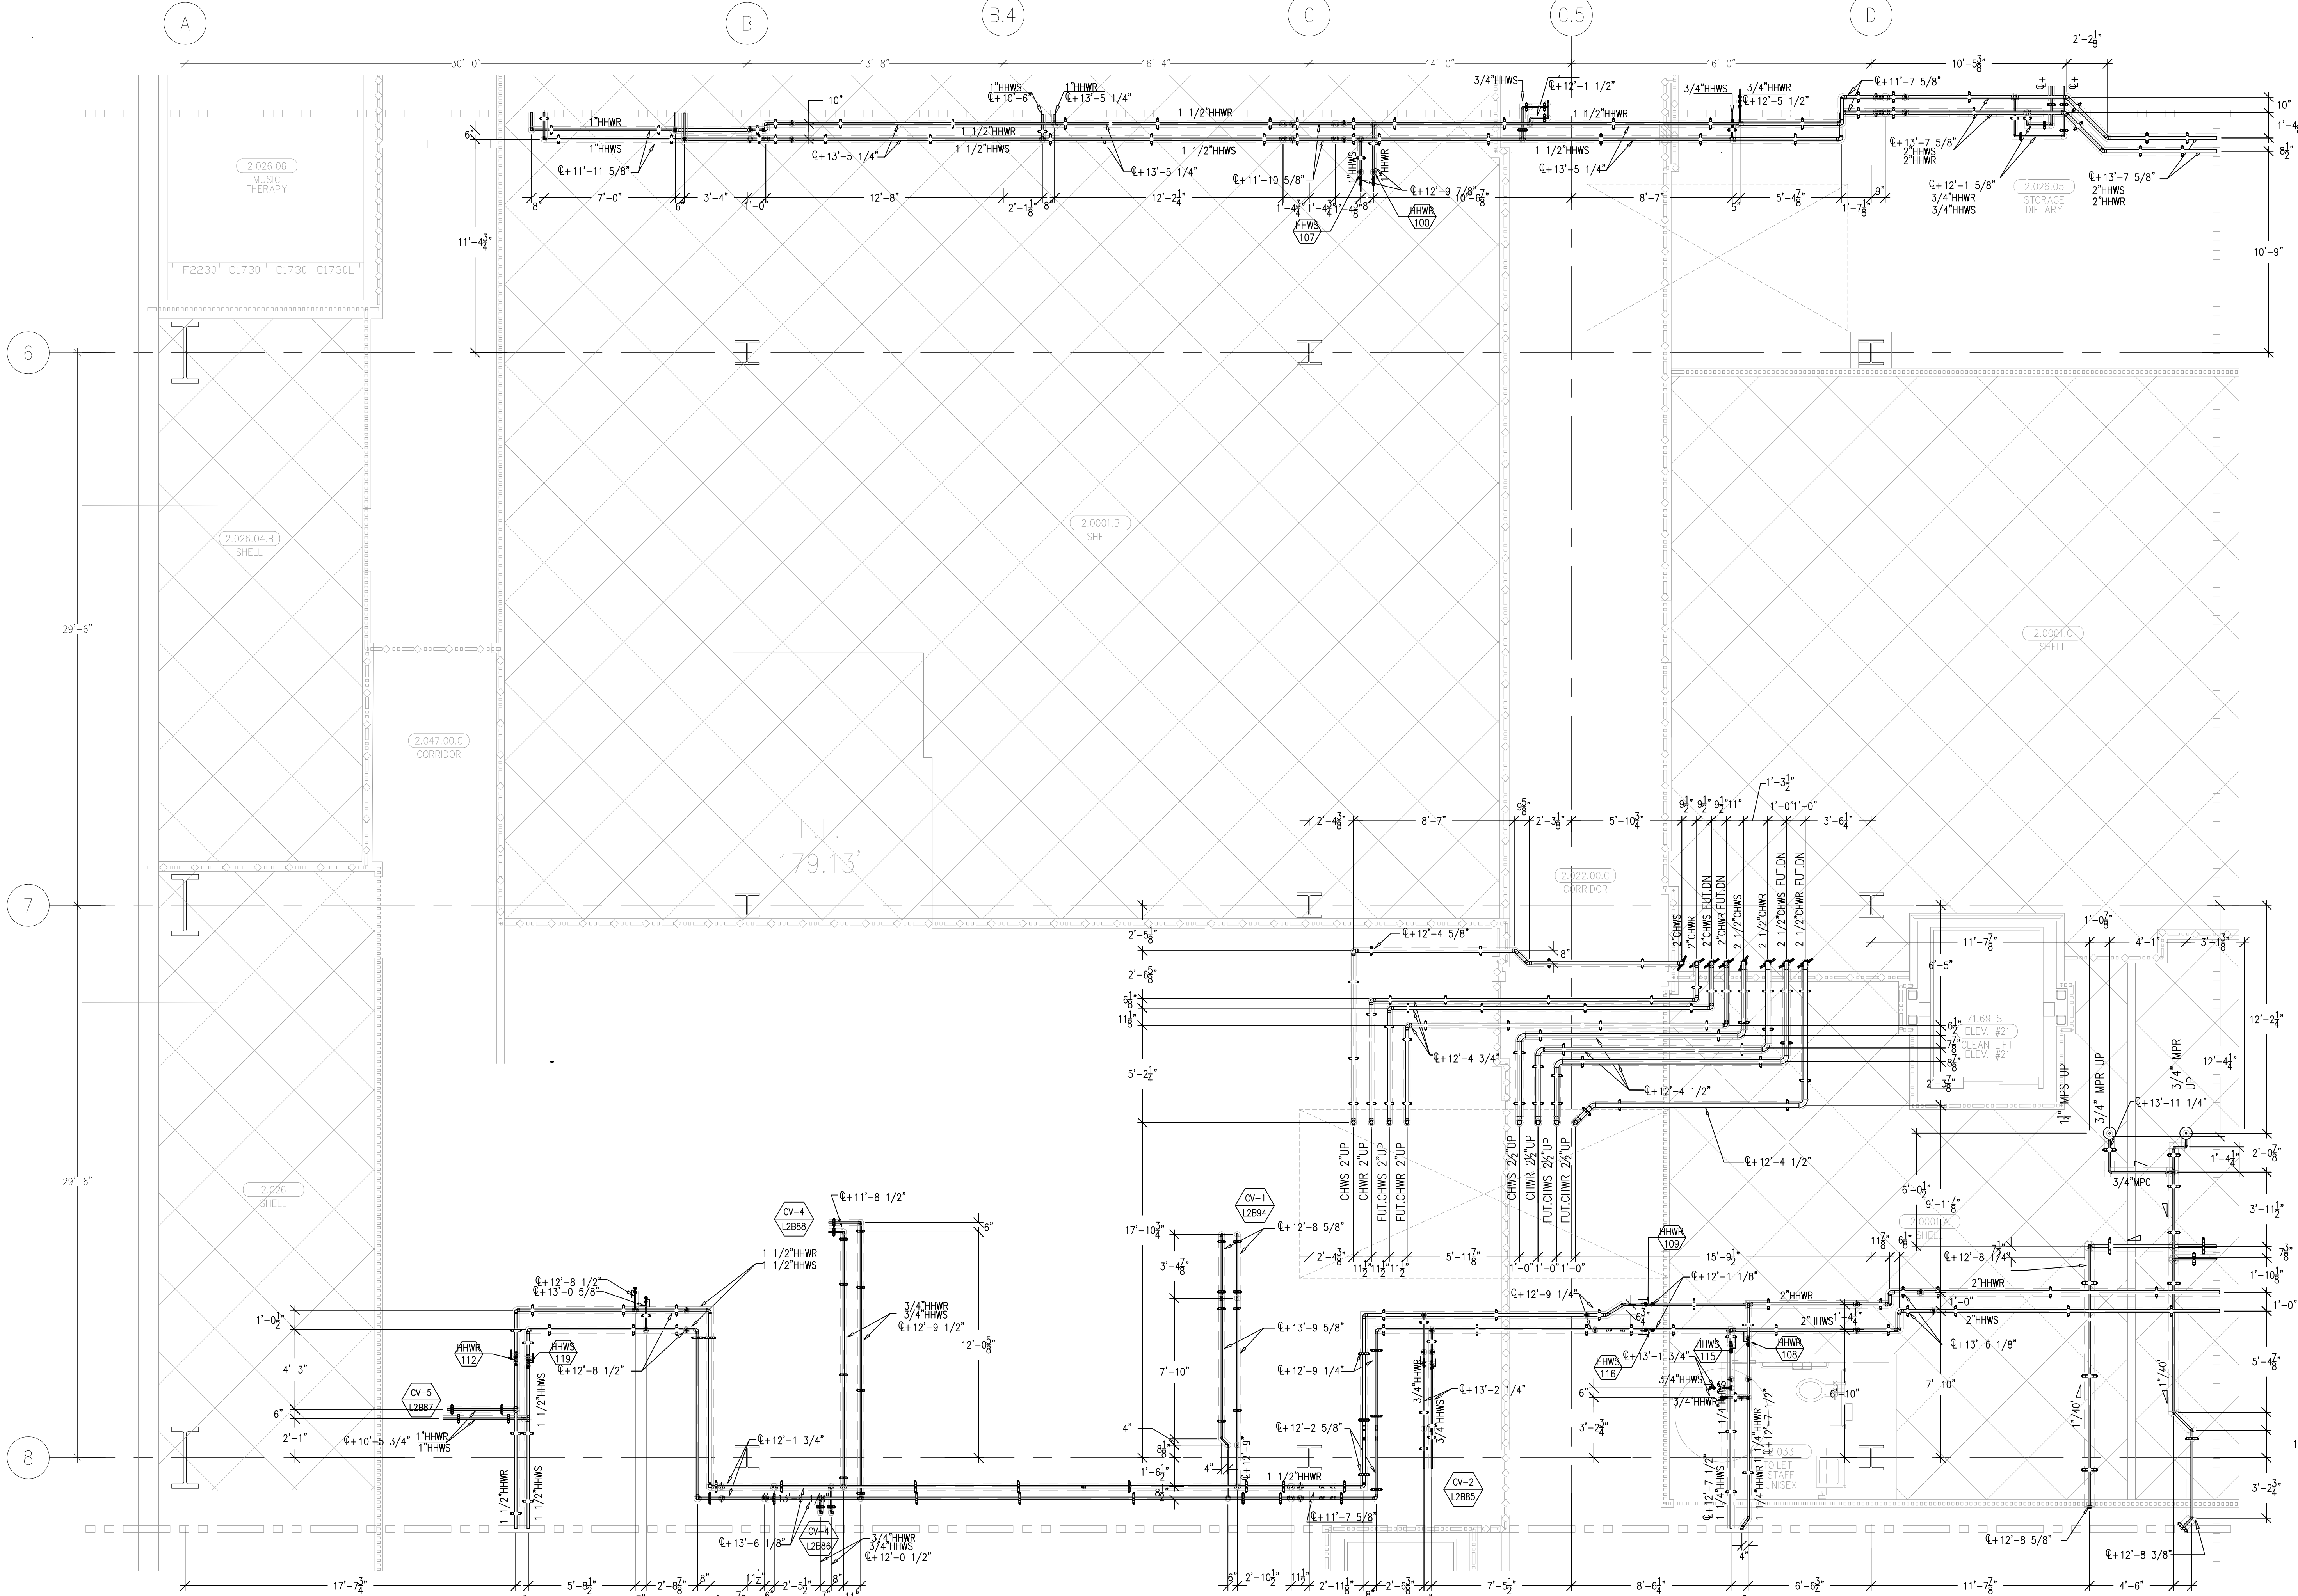

DATE: 6-18-12 BY: J.CLINTON

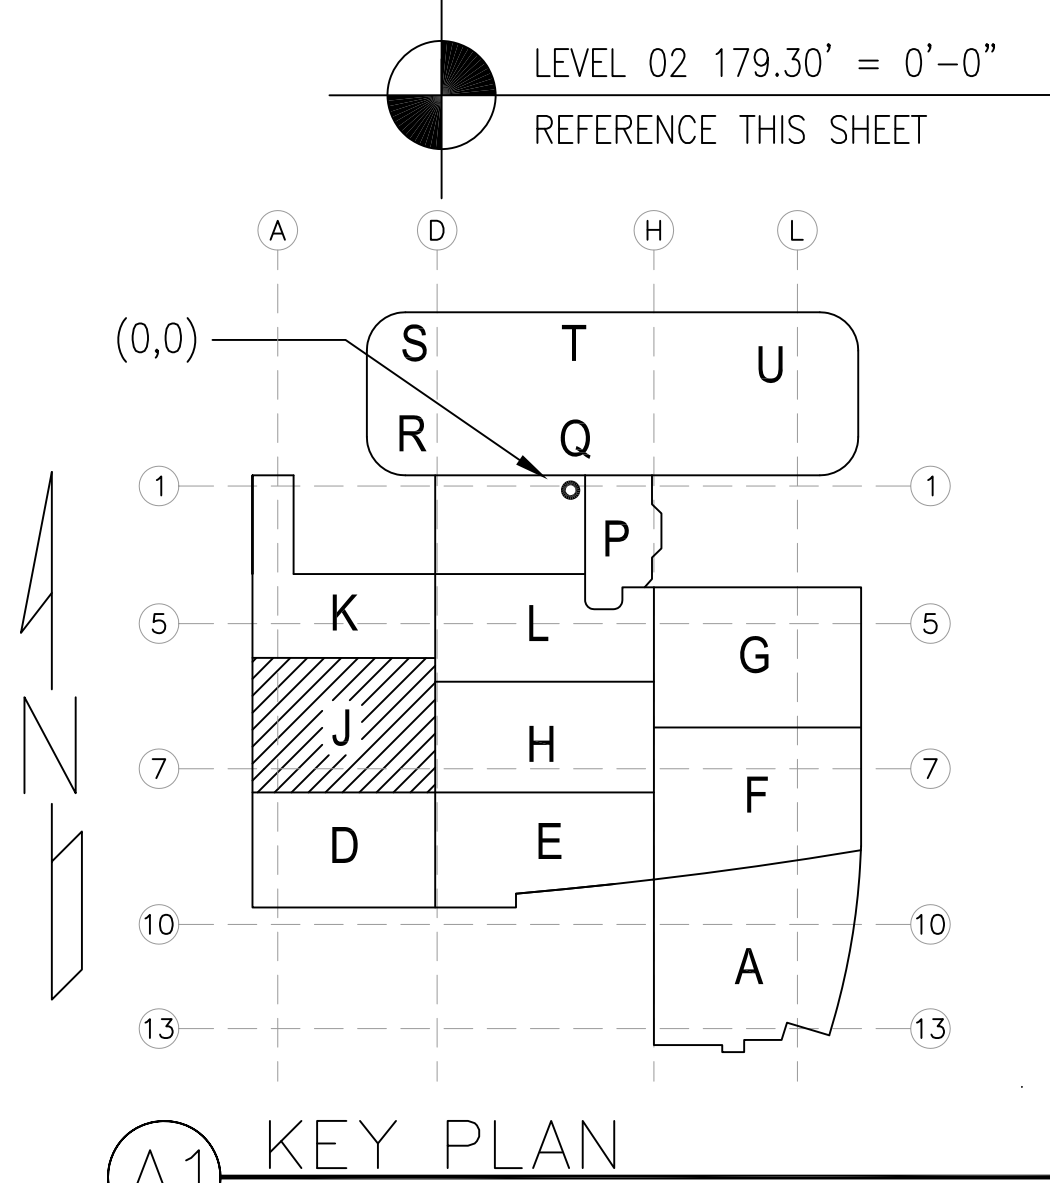[illegible]

MECHANICAL DUCT	
MECHANICAL PIPE	
PLUMBING	
ELECTRICAL	
FIRE SPRINKLER	
PIPE	
RYMALL/FRAMER	
REFRIGERATION	
STRUCTURAL	

[illegible]

CHILDREN'S HOSPITAL
OF ORANGE COUNTY

Orange, CA 92868-3874

MECHANICAL PIPE FLOOR PLAN - LEVEL 02 AREA-F


PAN-PACIFIC
LUMBER & MECHANICAL

 **Murray Company**



919 E. VICTORIA STREET, RANCHO DOMINGUEZ, CA 90221

Fig. 14: \\09-006-CHCC\MURRAY_CRAWINS\MECHANICAL-PIPE\AS-BUILT\11-2\MP3.21.dwg Plotted by: joemartinez 9-04-2012 10:57am

DRAWN
SB
CHECKED
M.M.
DATE
12/16/10
SCALE
1/4" = 1'-0"
JOB NO.
09-006
DRAWING NUMBER
MP3.2J
REFERENCE DRAWING
A3.2J
P3.2J
1 OF 1 SHEETS

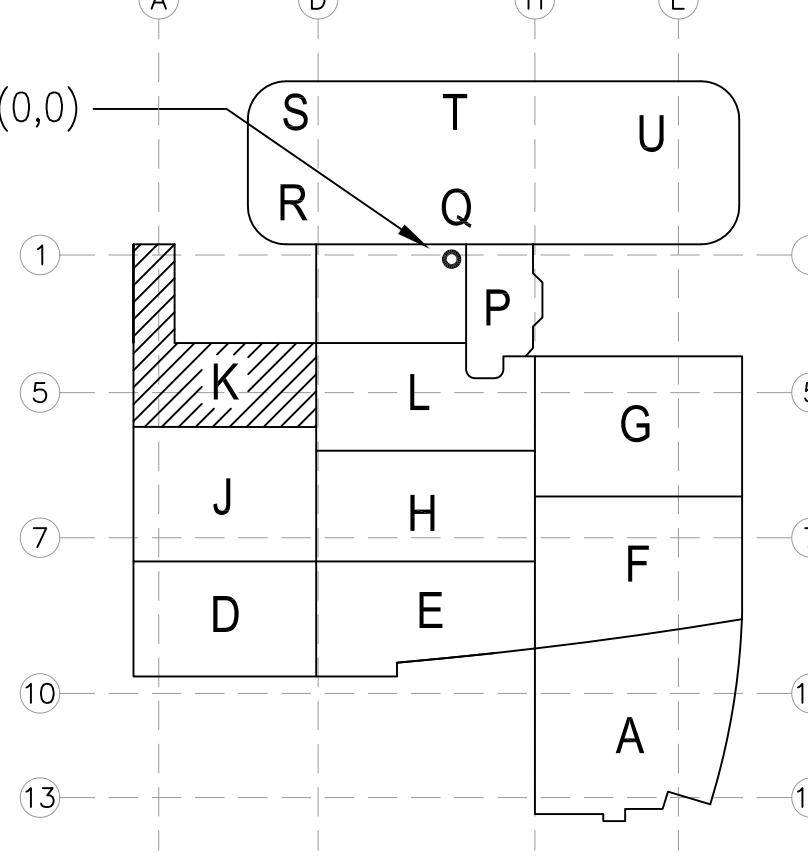

DRAWN
 S.L.B.
 CHECKED
 M.M.
 DATE
 11/21/09
 SCALE
 $1/4" = 1' - 0"$
 JOB NO.
 09-006
 DRAWING NUMBER
 MP3.2K
 REFERENCE DRAWING
 A3.2K
 P3.2K
 1 OF 1 SHEETS

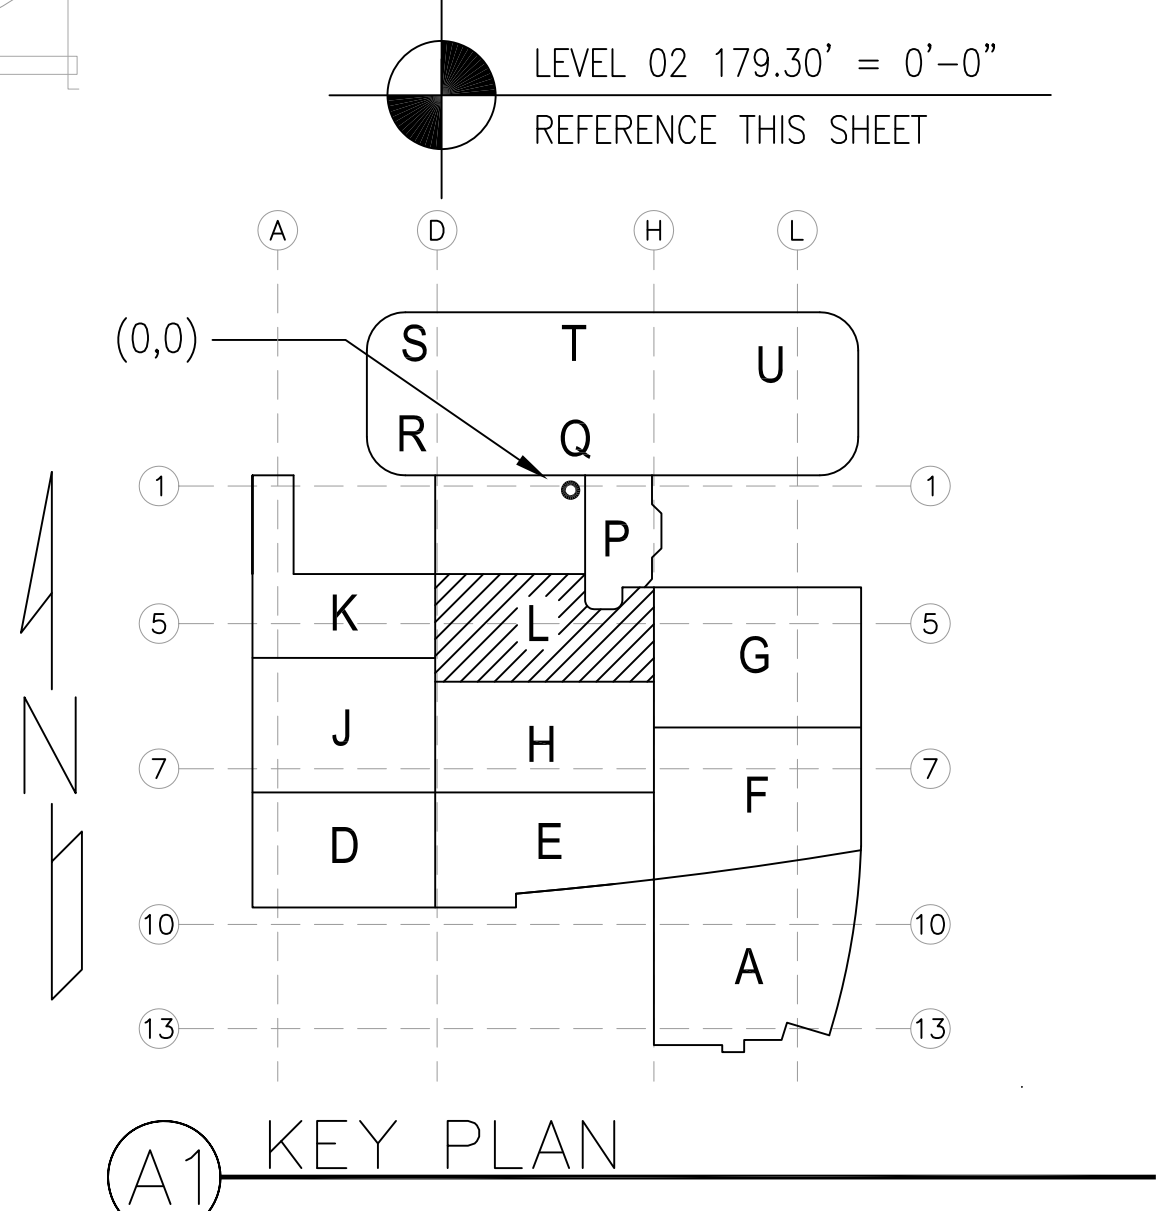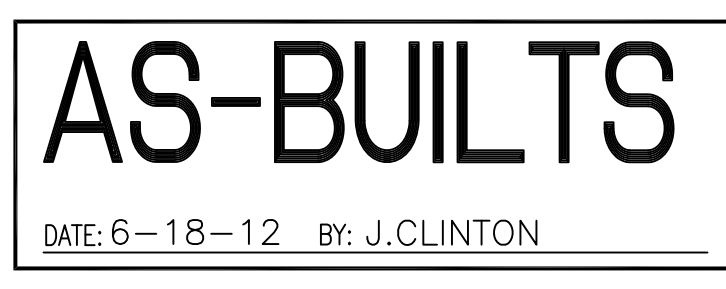[illegible]

**CHILDREN'S HOSPITAL
OF ORANGE COUNTY**

CHILDREN'S HOSPITAL OF ORANGE COUNTY

465 S. Main St.
Orange, CA 92668-3674

TOWER II

MECHANICAL PIPE FLOOR PLAN - LEVEL 02 AREA-I

PAN-PACIFIC

PAN-PACIFIC ARCHITECTURAL

McCurry

McCurry Company

2919 E. VICTORIA STREET, RANCHO DOMINGUEZ, CA 90221
PH. 310 637-1500 FAX 310 604-0359

DATE 12/16/10

CHECKED M.M.

DRAWN R.O.

SCALE 1/4" = 1' - 0"

JOB NO. 09-006

DRAWING NUMBER MP3.2L

REFERENCE DRAWING A3.2L
P3.2L

BY

REVISIONS

COORD.

SIGNATURE

DATE

MCARRY

MECHANICAL DUCT

MECHANICAL PIPE

MECHANICAL ROOM

MECHANICAL TOWER

FIRE SINKLER

PIPE

DRAWAL/FRAMER

REFRIGERATION

STRUCTURAL

R.F.I.

SENT

ANS.

R.F.I.

SENT

ANS.

R.F.I.

SENT

ANS.

R.F.I.

SENT

ANS.

R.F.I.

SENT


ANS.

R.F.I.

SENT


ANS.

This document and the design it covers are the property of Murray Co. They are loaned only with the borrower's expressed written agreement that they will not be reproduced, copied, loaned, exhibited, or used in any other way, except by written consent from Murray Co. to the borrower.

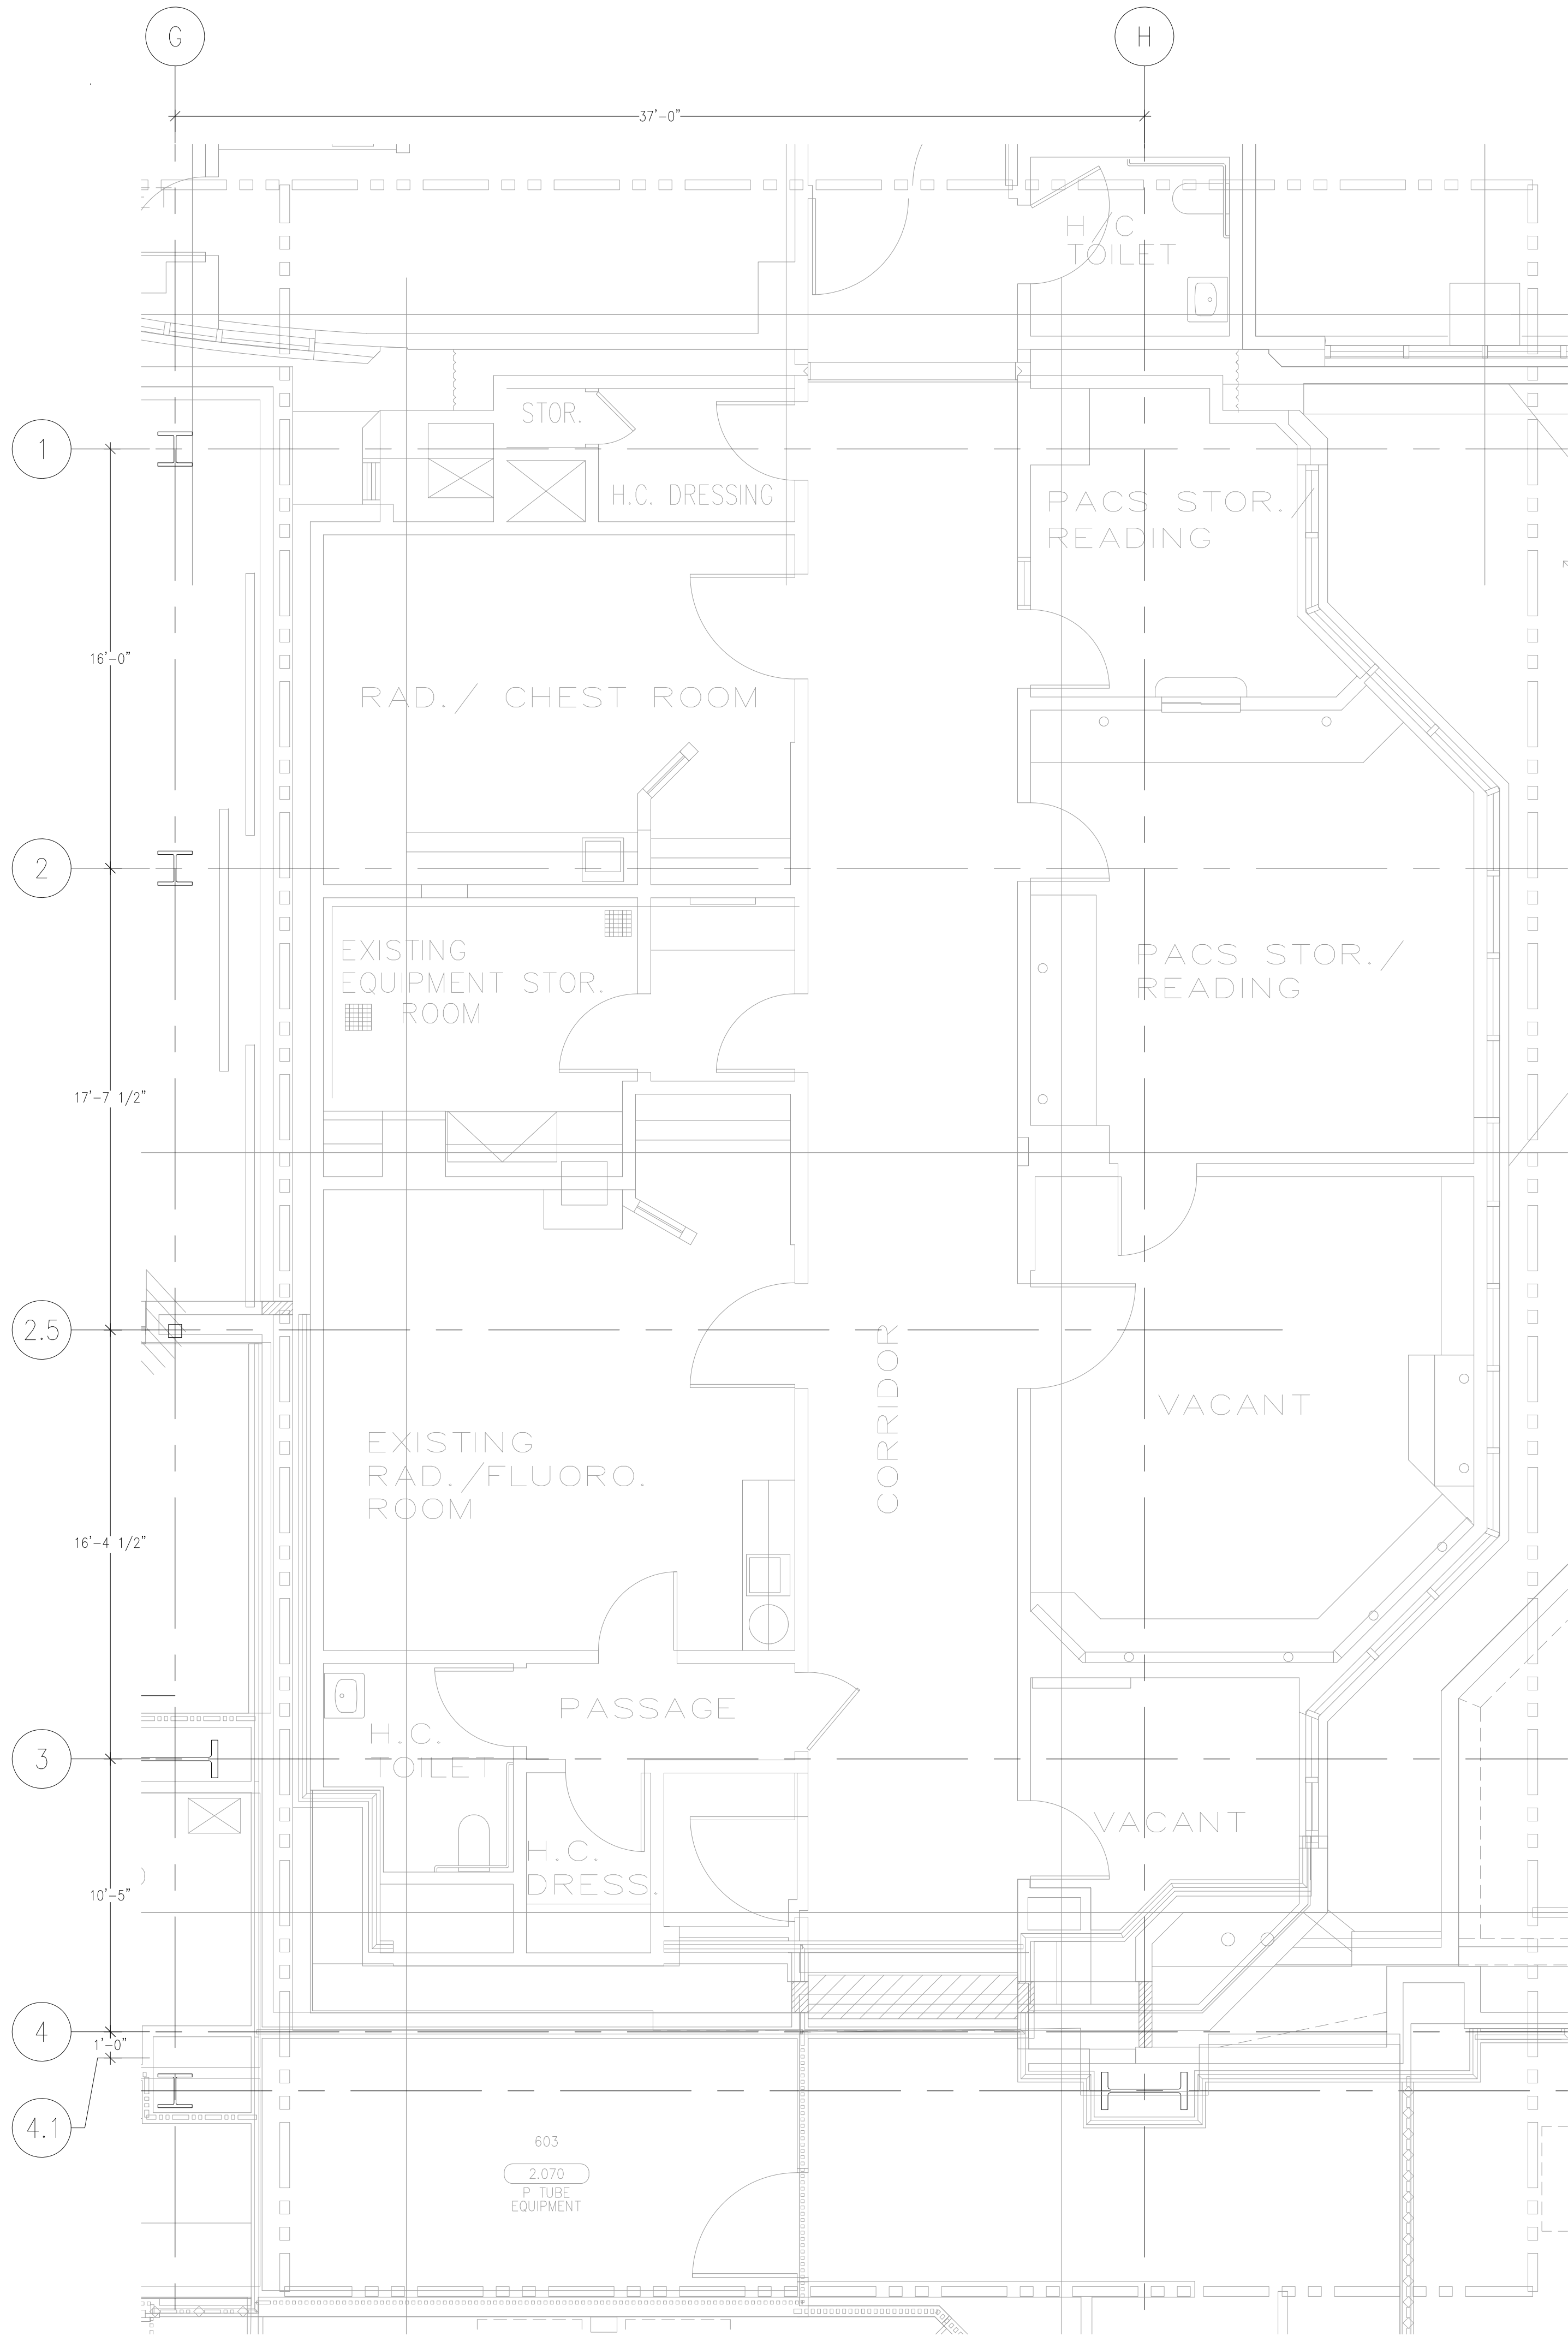

AS-BUILTS

DATE: 6-18-12 BY: J.CLINTON

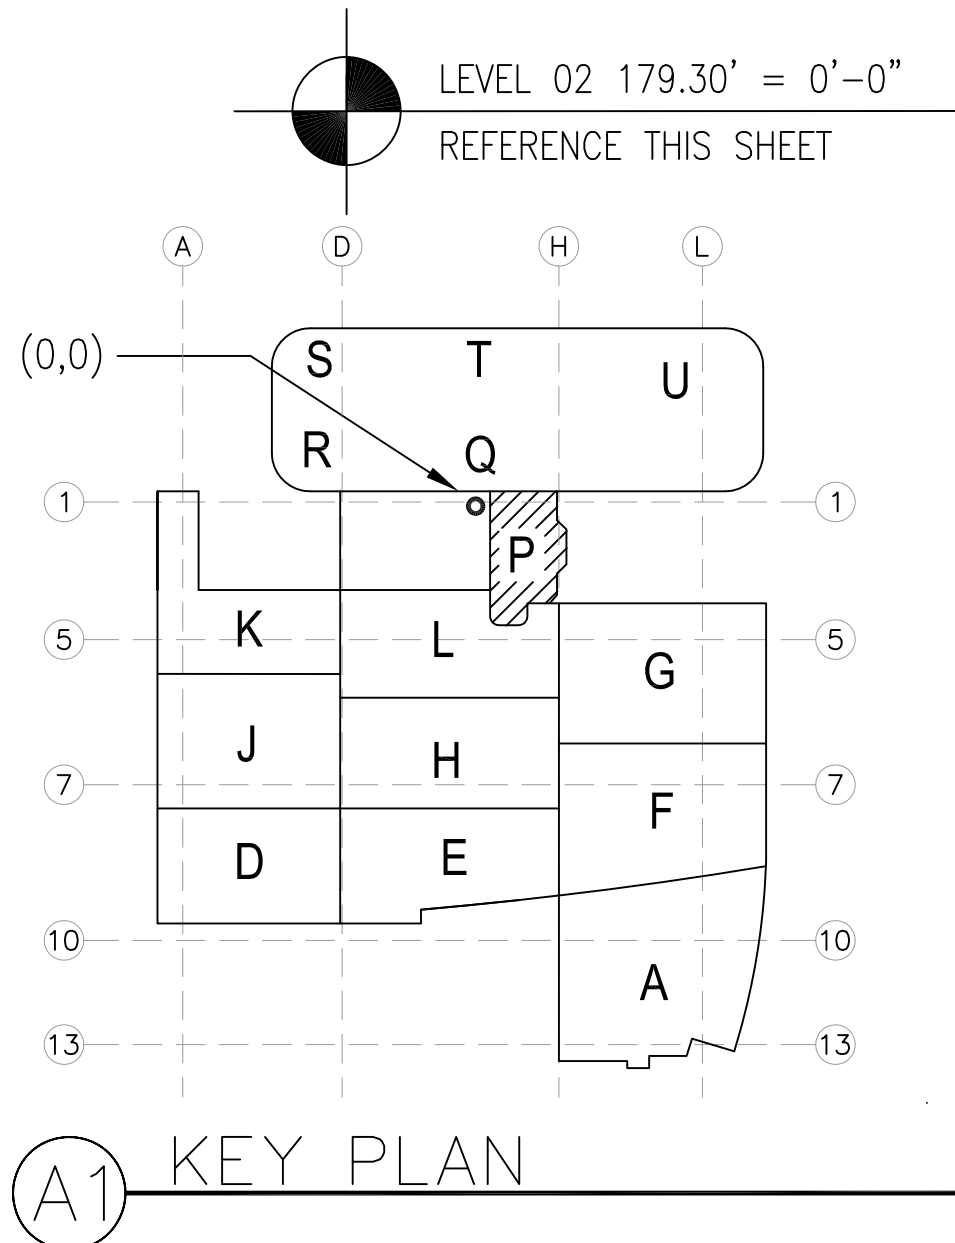

REVISIONS	BY

COORD.	SIGNATURE	DATE
MECHANICAL		
MECHANICAL		
PLUMBING		
ELECTRICAL		
FIRE SPRINKLER		
PLUMB		
DRYWALL/FRAME		
REFRIGERATION		
STRUCTURAL		

R.F.I.	SENT	ANS.	R.F.I.	SENT	ANS.	R.F.I.	SENT	ANS.


CHILDREN'S HOSPITAL
OF ORANGE COUNTY
455 S. MAIN ST.
ORANGE, CA 92668-5874
TOWER II
PLUMBING FLOOR PLAN - LEVEL 02 AREA P

Murray Company
PLUMBING & MECHANICAL
2919 E. VICTORIA STREET, RANCHO DOMINGUEZ, CA 90221
PH. 310 637-1500 FAX 310 604-0359

DRAWN
R.O.
CHECKED
M.M.
DATE
9/4/2012
SCALE
1/4"=1'-0"
JOB NO.
09-006
DRAWING NUMBER
MP3.2P
REFERENCE DRAWING
A3.2P
P3.2P
1 OF 1 SHEETS


DRAWN
T.C.
CHECKED
M.M.
DATE
9/4/2012
SCALE
1/4" = 1'-0"
JOB NO.
09-006
DRAWING NUMBER
VALVE TAG 1
REFERENCE DRAWING
A3.0S
P3.0S
1 OF 1 SHEETS

This document and the design it covers are the property of Murray Co. They are loaned only with the borrowers' expressed agreement that they will not be reproduced, copied, loaned, exhibited, or used in any other way, except by written consent from Murray Co. to the borrower.

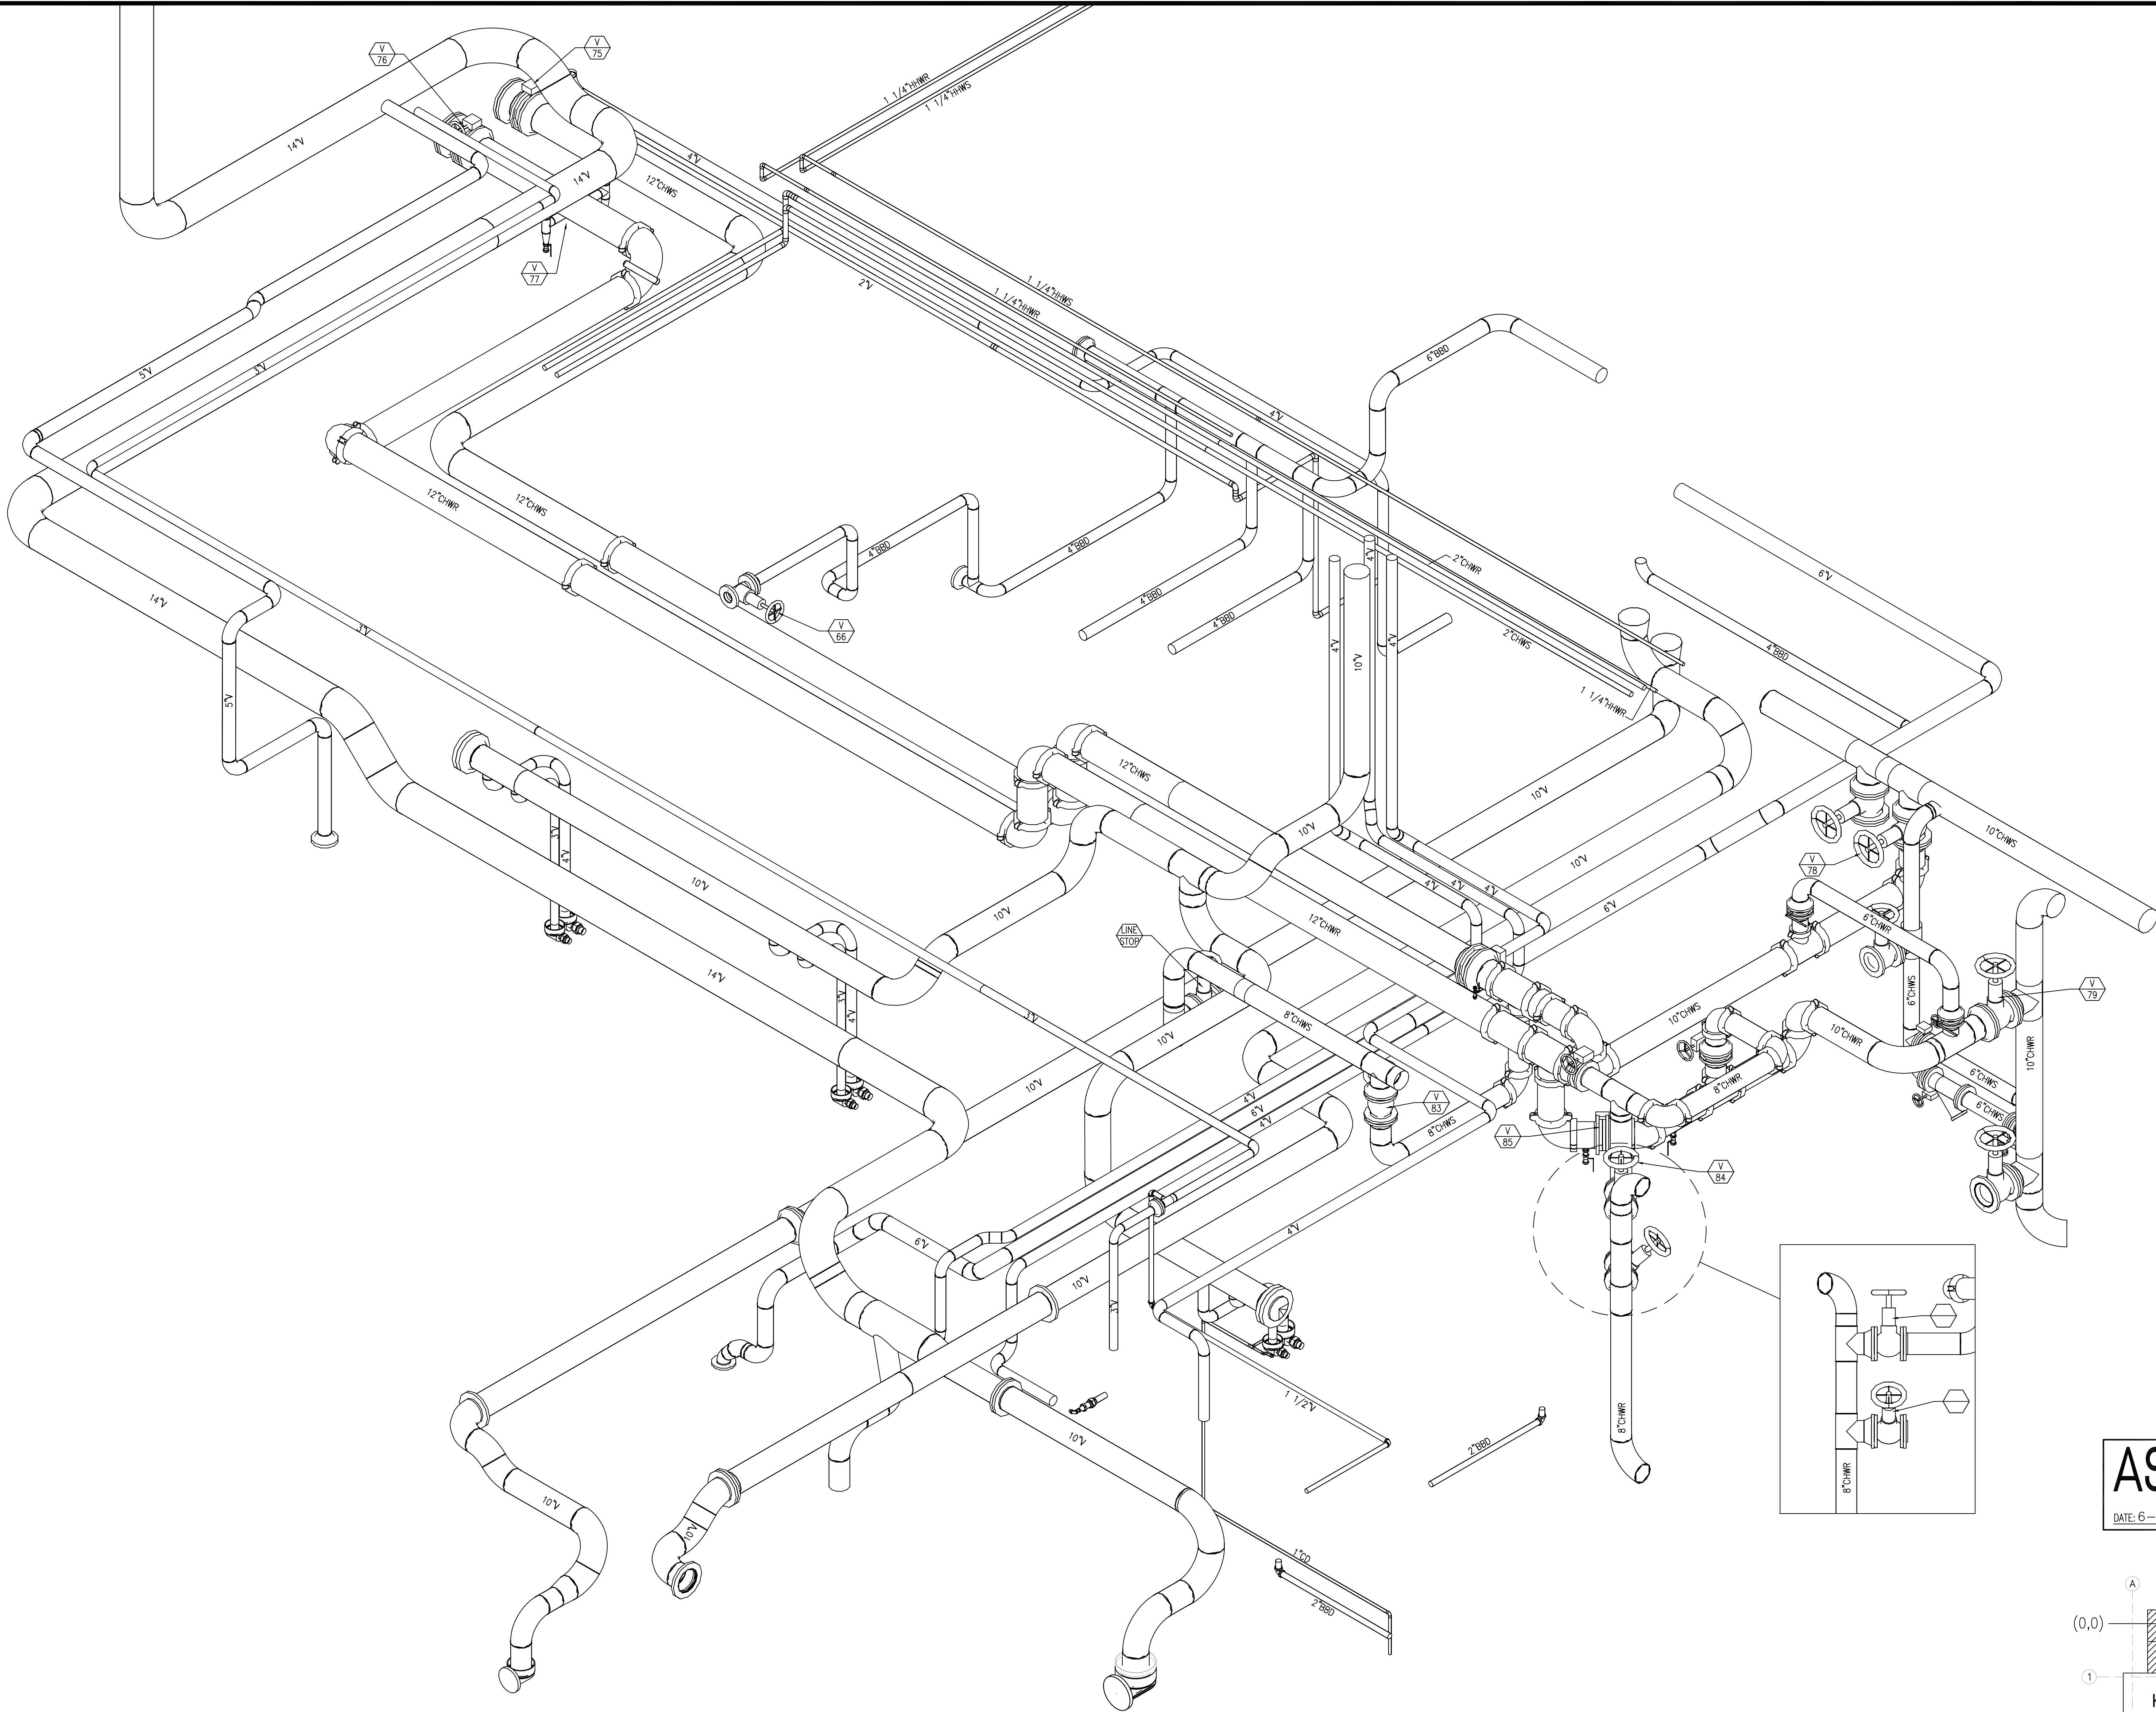

LEVEL BOILER ROOM
131.80' = 0'-0" (-12'-6" FROM LL)
REFERENCE THIS SHEET

DATE: 6-18-12 BY: J.CLINTON

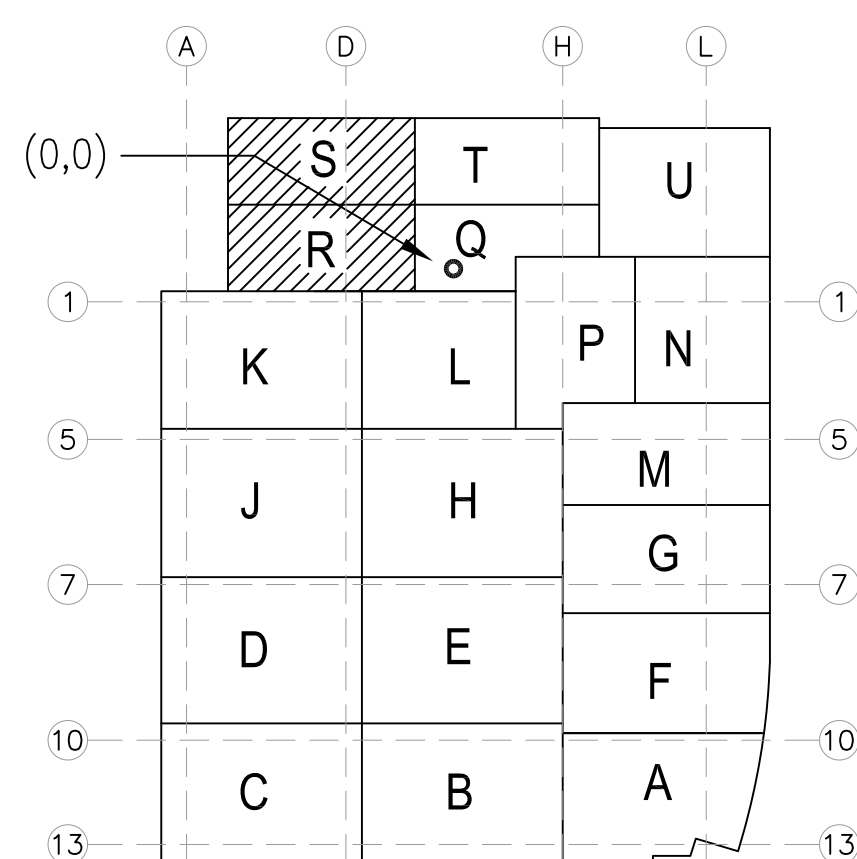

(A1) KEY PLAN

[illegible]

DATE	SIGNATURE	CONTRACTOR
		MCCARTHY
		MECHANICAL DUCT
		MECHANICAL PIPE
		PLUMBING
		ELECTRICAL
		FIRE SPRINKLER
		PIPE
		DRYWALL/FRAMER
		REFRIGERATION
		STRUCTURAL

[illegible]

**CHILDREN'S HOSPITAL
OF ORANGE COUNTY**
455 S. Main St.
Orange, CA 92668-3874

TOWER II

MECHANICAL PIPE FLOOR PLAN • LEVEL 00 AREA-S

PAN-PACIFIC
PLUMBING & MECHANICAL

Murray Company

2919 E. VICTORIA STREET, RANCHO DOMINGUEZ, CA 90221
PH. 310 637-1500 FAX 310 604-0359

DRAWN T.C.
CHECKED M.M.
DATE 9/4/2012
SCALE 1/4" = 1'-0"
JOB NO. 09-006
DRAWING NUMBER WALVE TAG 2
REFERENCE DRAWING A3.0S P3.0S
1 OF 1 SHEETS