



document and the design it covers are the property of Murray Co. They are loaned only with the borrower's expressed written agreement that they will not be reproduced, copied, loaned, exhibited, or used in any other way, except by written consent from Murray Co. to the borrower.

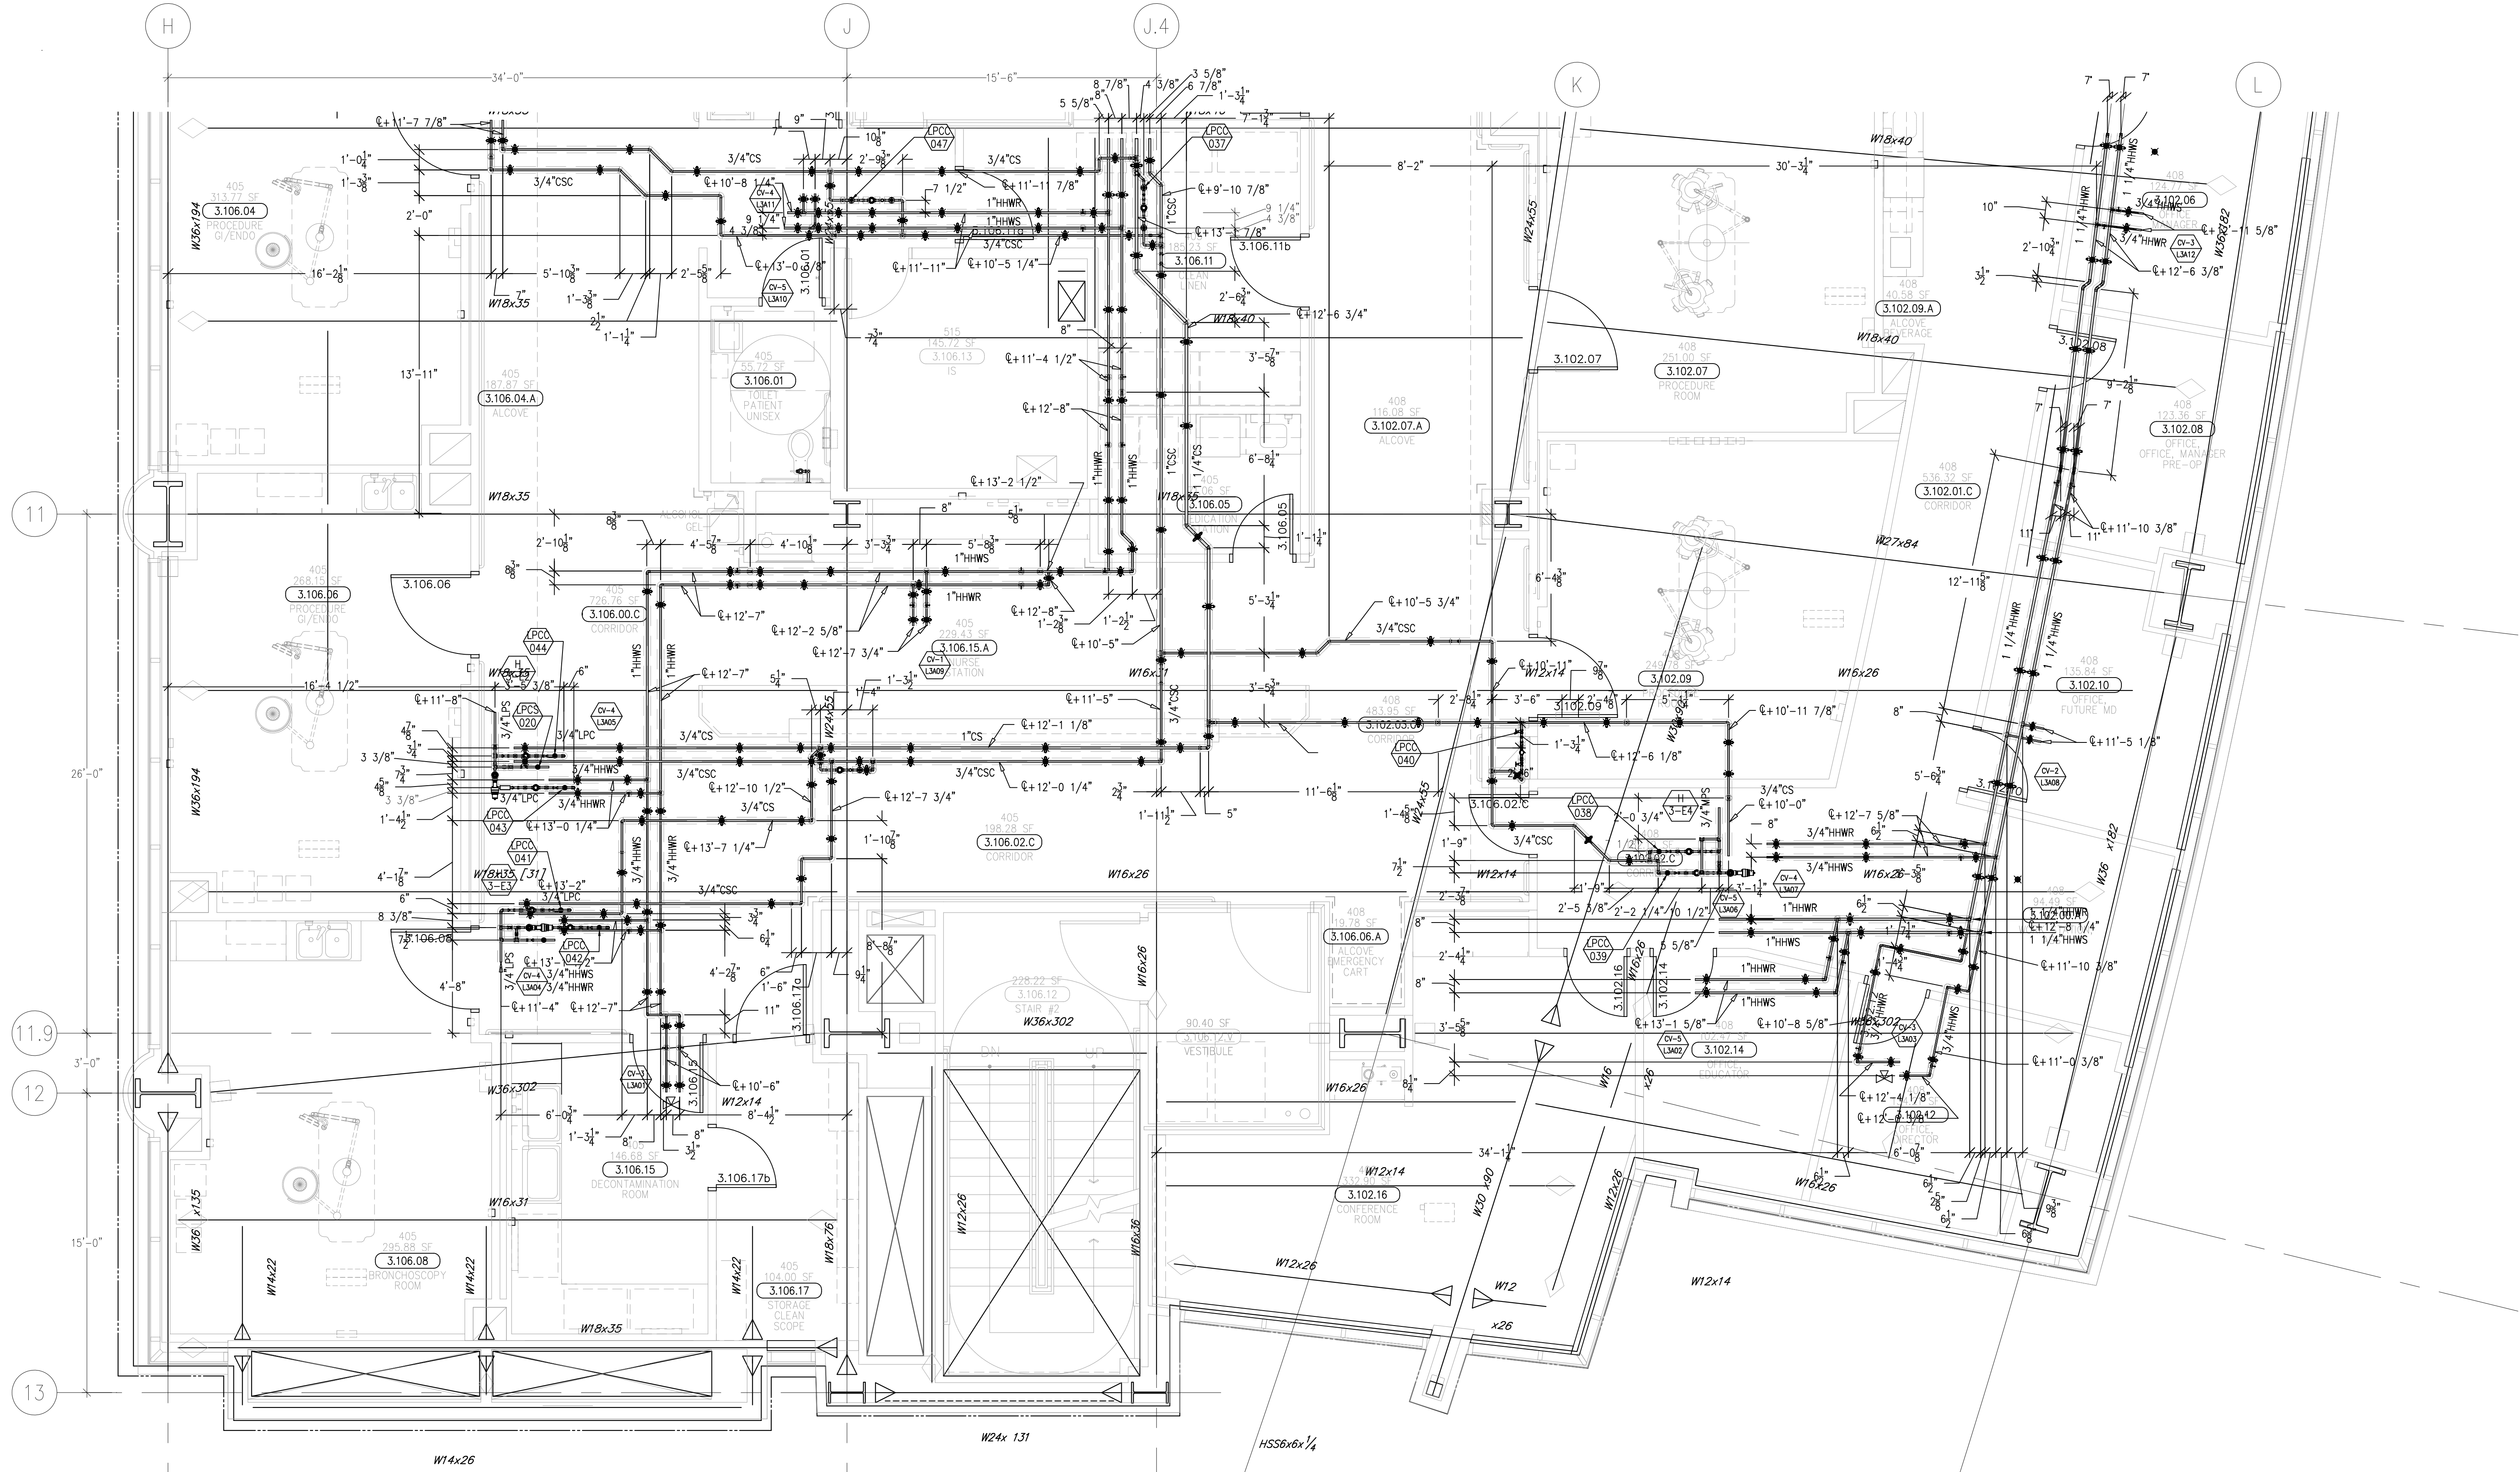

DATE: 6-18-12 BY: J.CLINTON

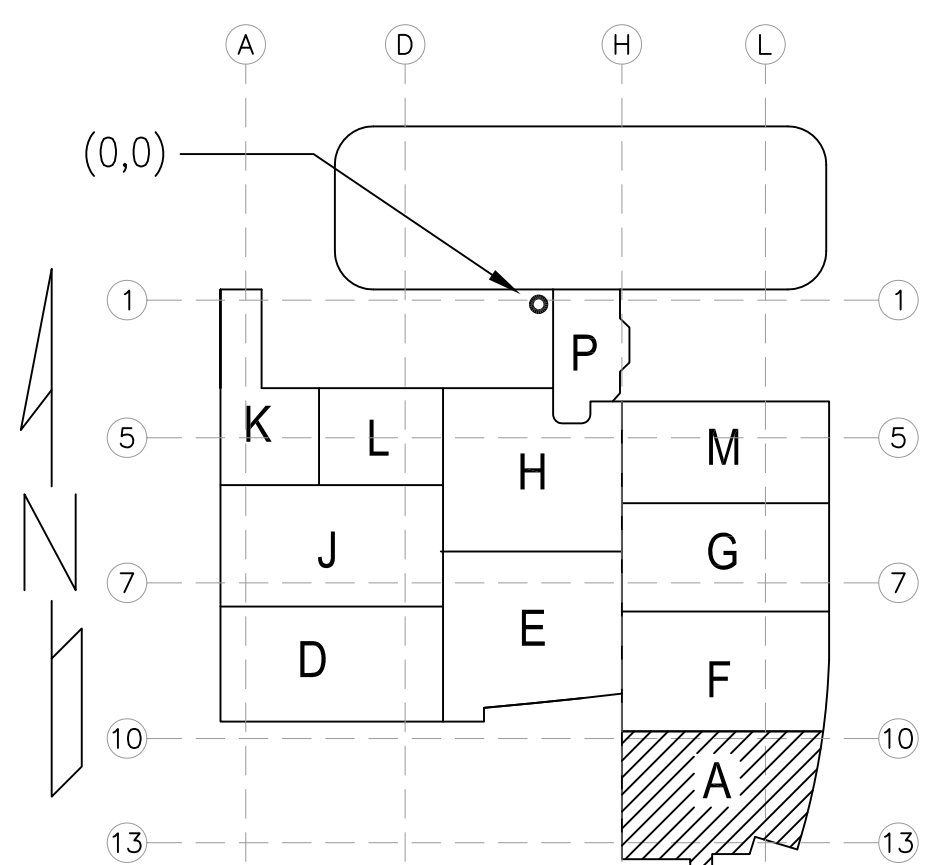

A1 KEY PLAN

[illegible]

COORD.	SIGNATURE	DATE
McARTHY		
MECHANICAL DUCT		
MECHANICAL PIPE		
PLUMBING		
ELECTRICAL		
FIRE SPRINKLER		
PIPE		
DRYWALL/FRAME		
REFRIGERATION		
STRUCTURAL		

[illegible]

CHILDREN'S HOSPITAL
OF ORANGE COUNTY
465 S. Main St.
Orange, CA 92668-3874
TOWER II
MECHANICAL PIPE FLOOR PLAN - LEVEL 03 AREA-A



PAN-PACIFIC
PLUMBING & MECHANICAL

 **Murray Company**


2919 E. VICTORIA STREET, RANCHO DOMINGUEZ, CA 90221
PH. 310 637-1500 FAX 310 604-0359

DRAWN
R.O.
CHECKED
M.M.
DATE
9/4/2012
SCALE
1/4"=1'-0"
JOB NO.
09-006
DRAWING NUMBER
MP3.3A
REFERENCE DRAWING
A3.3A
P3.3A
1 OF 1 SHEETS


This document and the design it covers are the property of Murray Co. They are loaned only with the borrower's expressed written agreement that they will not be reproduced, copied, loaned, exhibited, or used in any way, except by written consent from Murray Co. to the borrower.

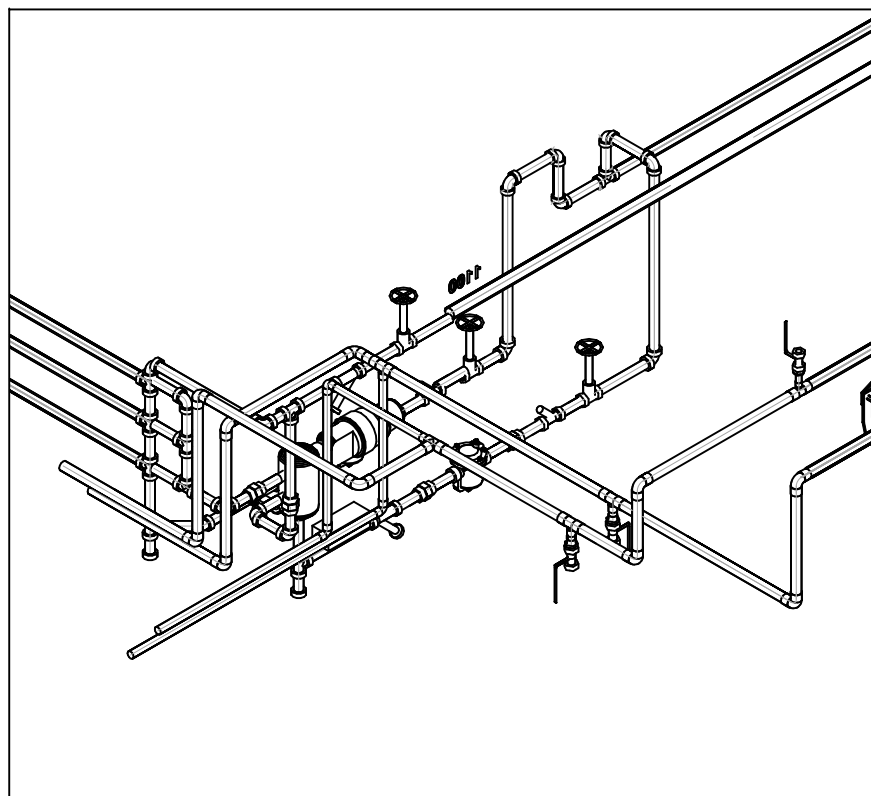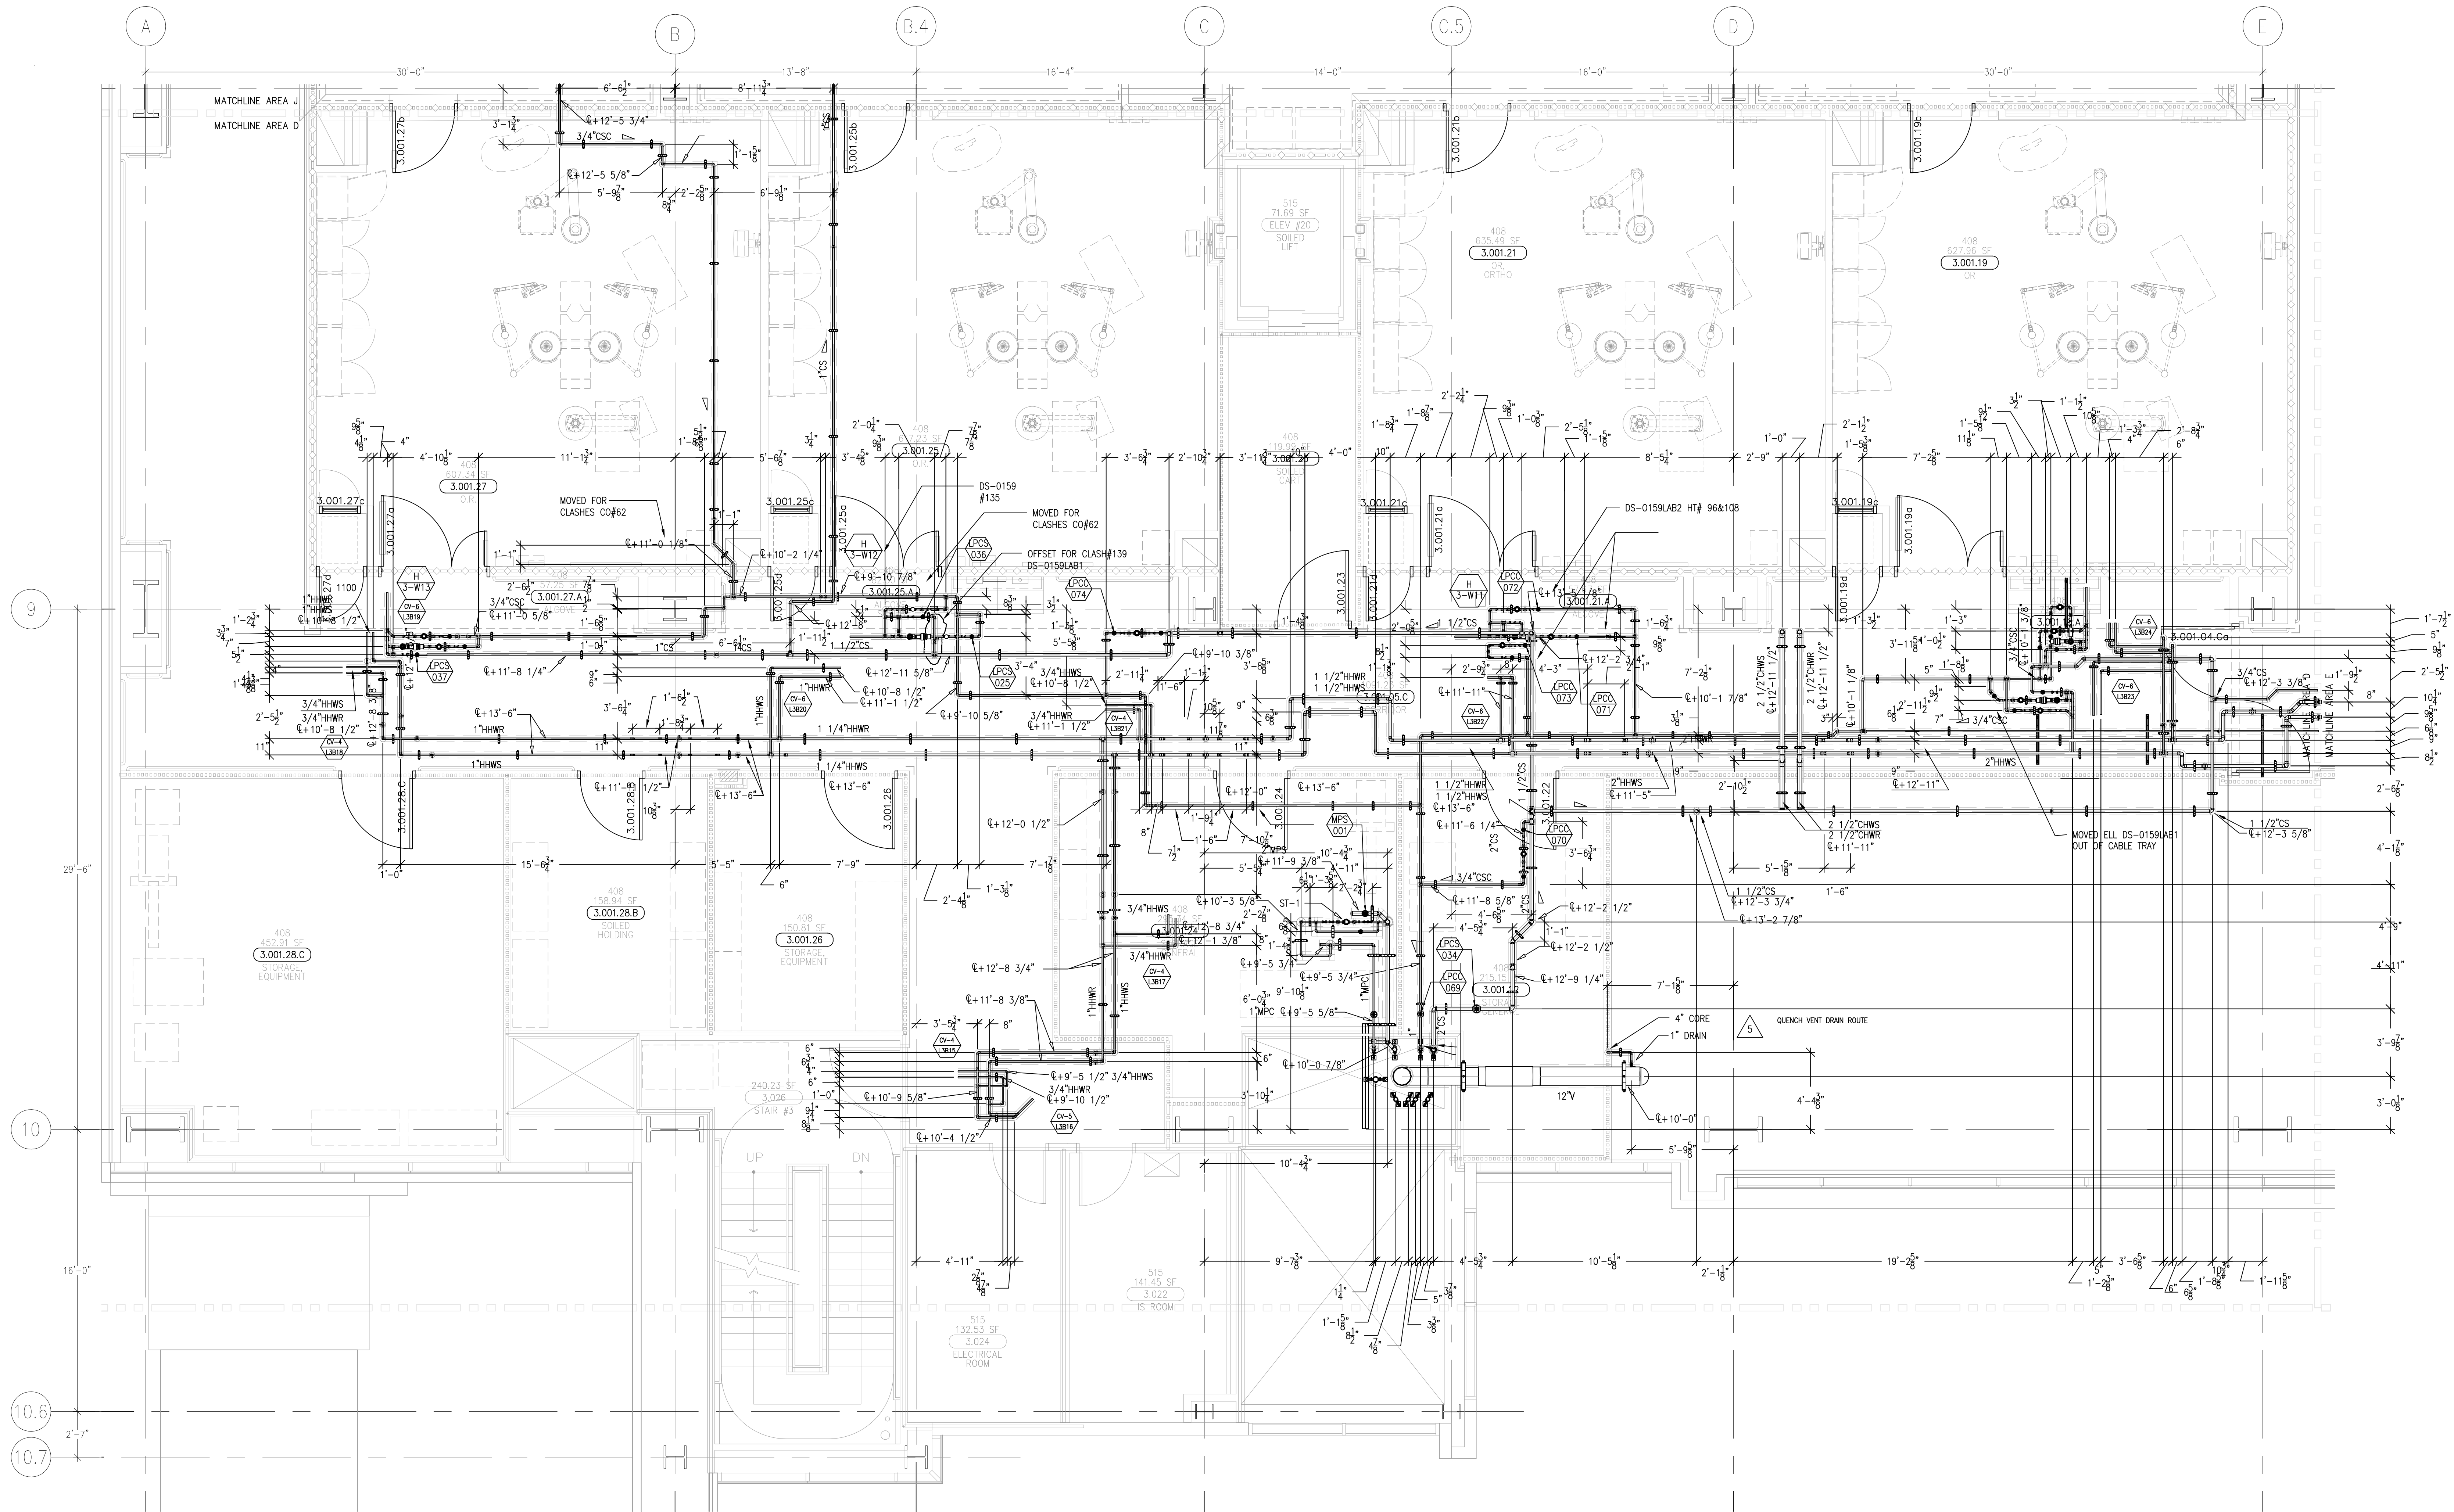


H 3-W13

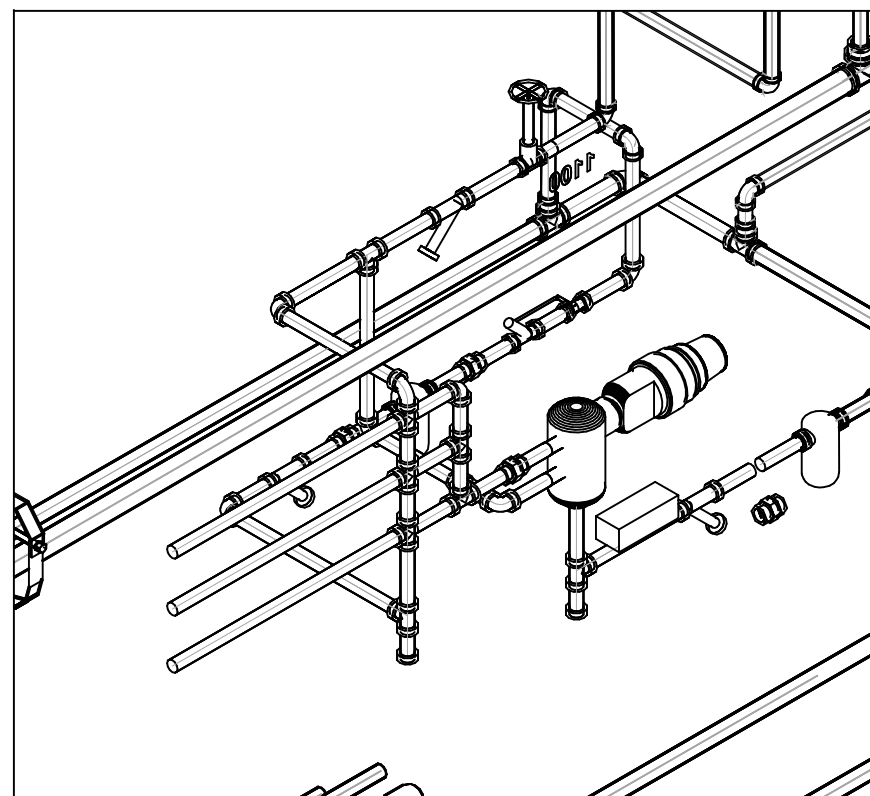


H 3-W12

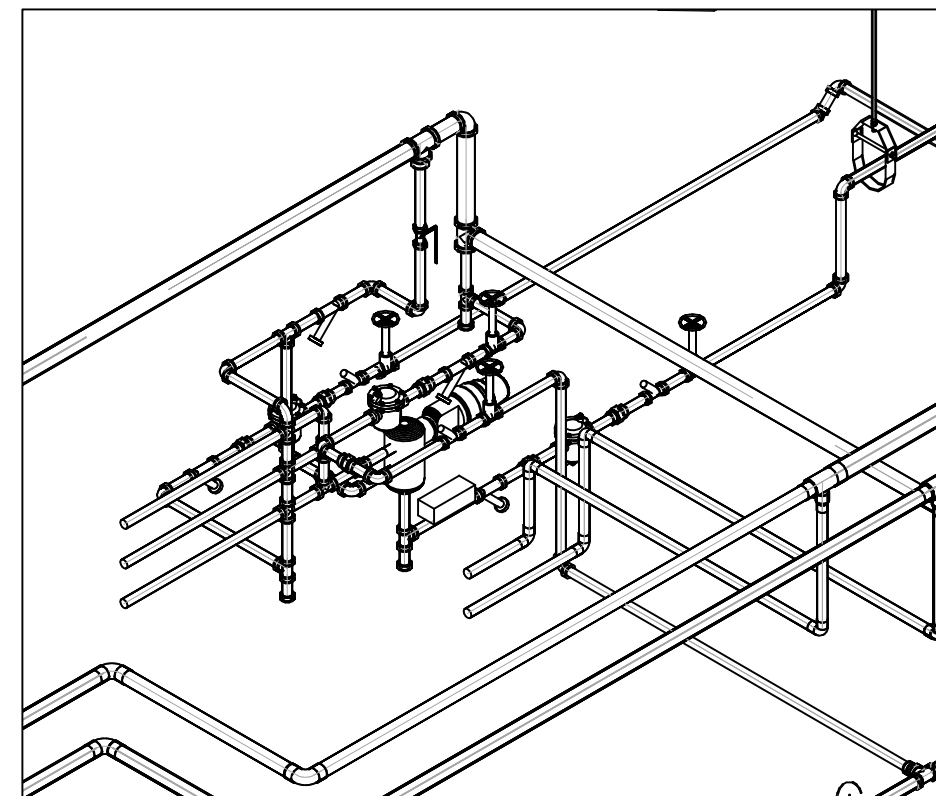

H 3-W11

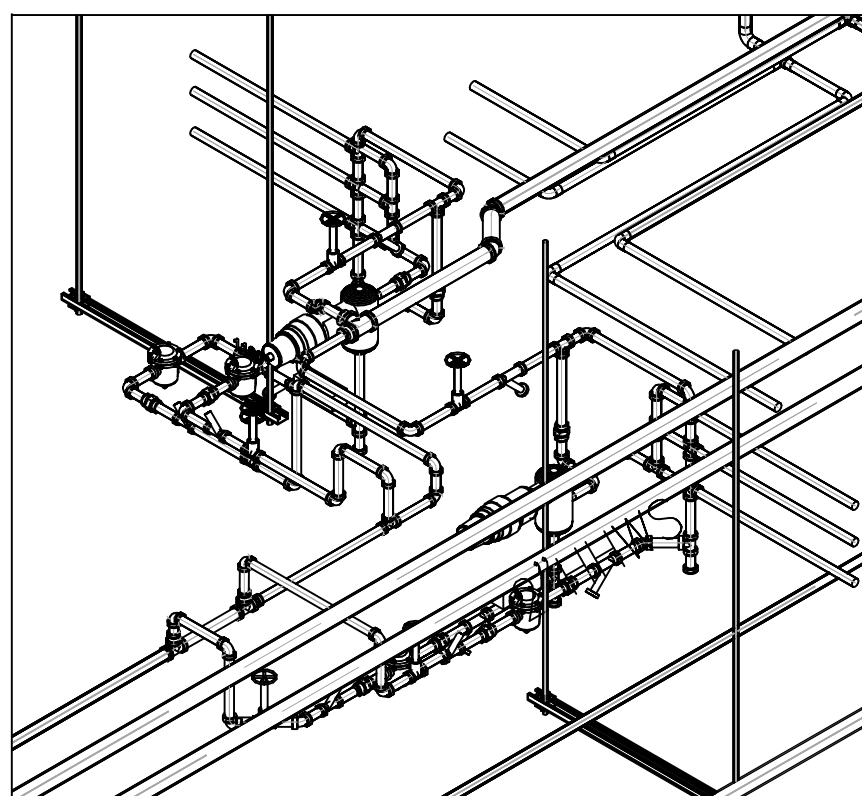

H 3-W10

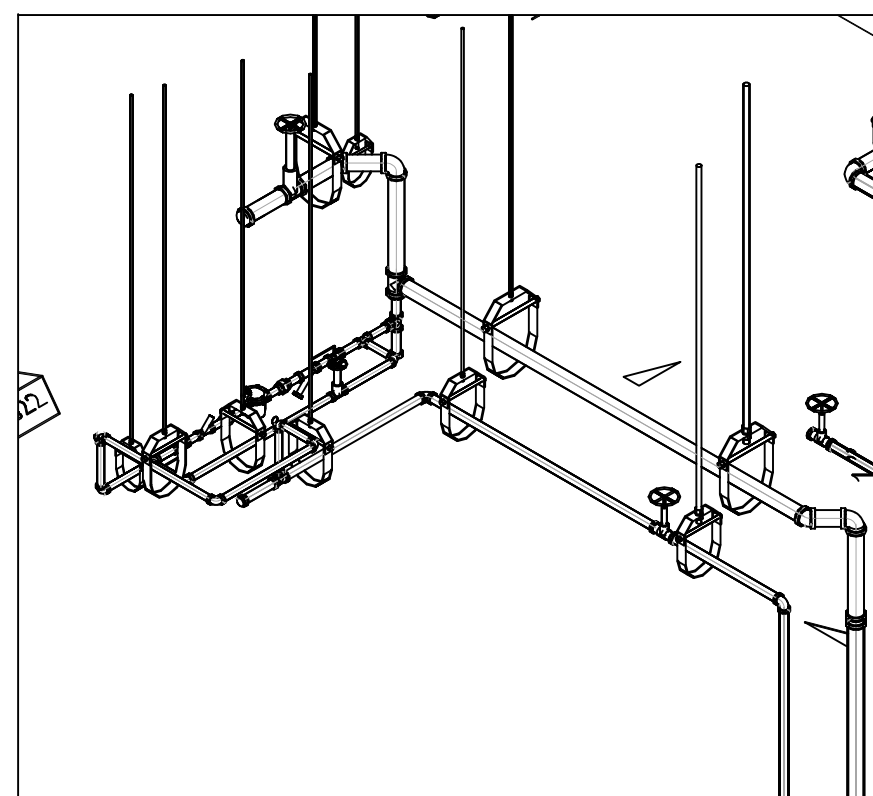


H 3-W9

LEVEL 03 194.30' = 0'-0"
REFERENCE THIS SHEET

AS-BUILTS

DATE: 6-18-12 BY: J. CLINTON

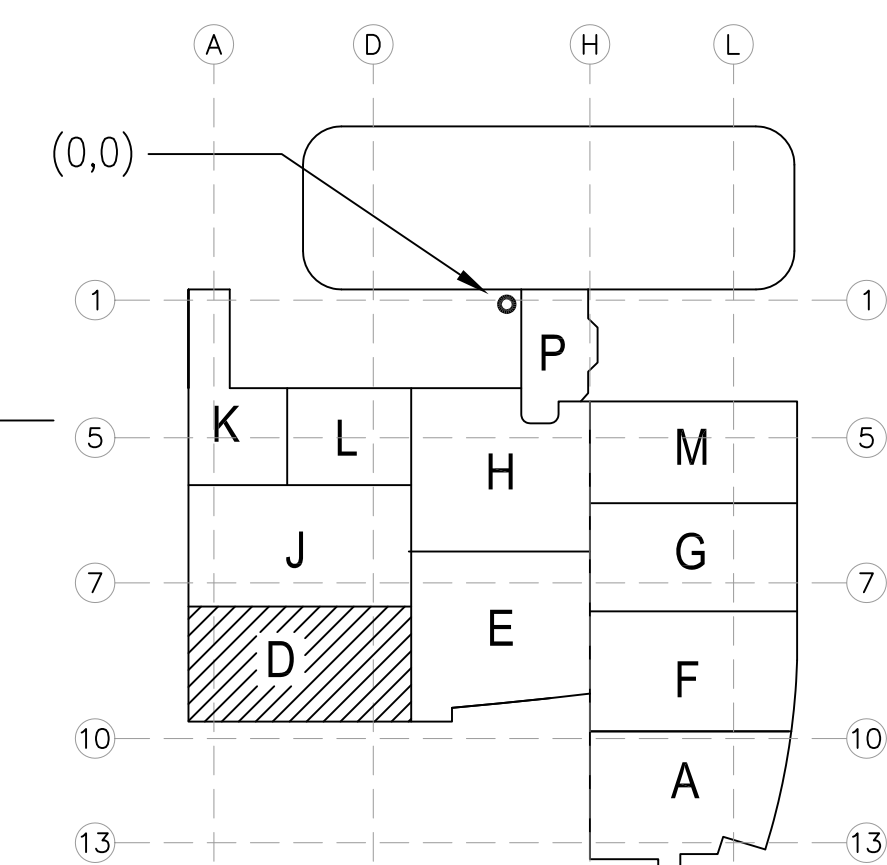

KEY PLAN

REVISIONS	BY

COORD.	SIGNATURE	DATE
MECHANICAL		
ELECTRICAL		
PLUMBING		
STRUCTURAL		

ANS.	SENT	R.F.I.	ANS.	SENT	R.F.I.	ANS.	SENT	R.F.I.	ANS.	SENT	R.F.I.


CHILDREN'S HOSPITAL
OF ORANGE COUNTY
455 S. MAIN ST., SUITE 200
ORANGE, CA 92668-9874
TOWER II
MECHANICAL PIPE FLOOR PLAN - LEVEL 03 AREAD

PAN-PACIFIC
PLUMBING & MECHANICAL
2919 E. VICTORIA STREET, RANCHO DOMINGUEZ, CA 90221
PH. 310 637-1500 FAX 310 604-0359



DRAWN
R.O.
CHECKED
M.M.
DATE
9/4/2012
SCALE
1/4" = 1'-0"
JOB NO.
09-006
DRAWING NUMBER
MP3.3D
REFERENCE DRAWING
A3.3D
P3.3D
1 OF 1 SHEETS

Doc Files\09-006-CHC-Mechanical-Pipe-Floor-Plans\09-006-MP3.3D.rvt Plotted by J. Clinton 8-14-2012 11:00am

DRAWN R.O.
CHECKED
M.M.
DATE
9/4/2012
SCALE
1/4"=1'-0"
JOB NO.
09-006
DRAWING NUMBER
MP3.3E
REFERENCE DRAWING
A3.3E
P3.3E
1 OF 1 SHEETS

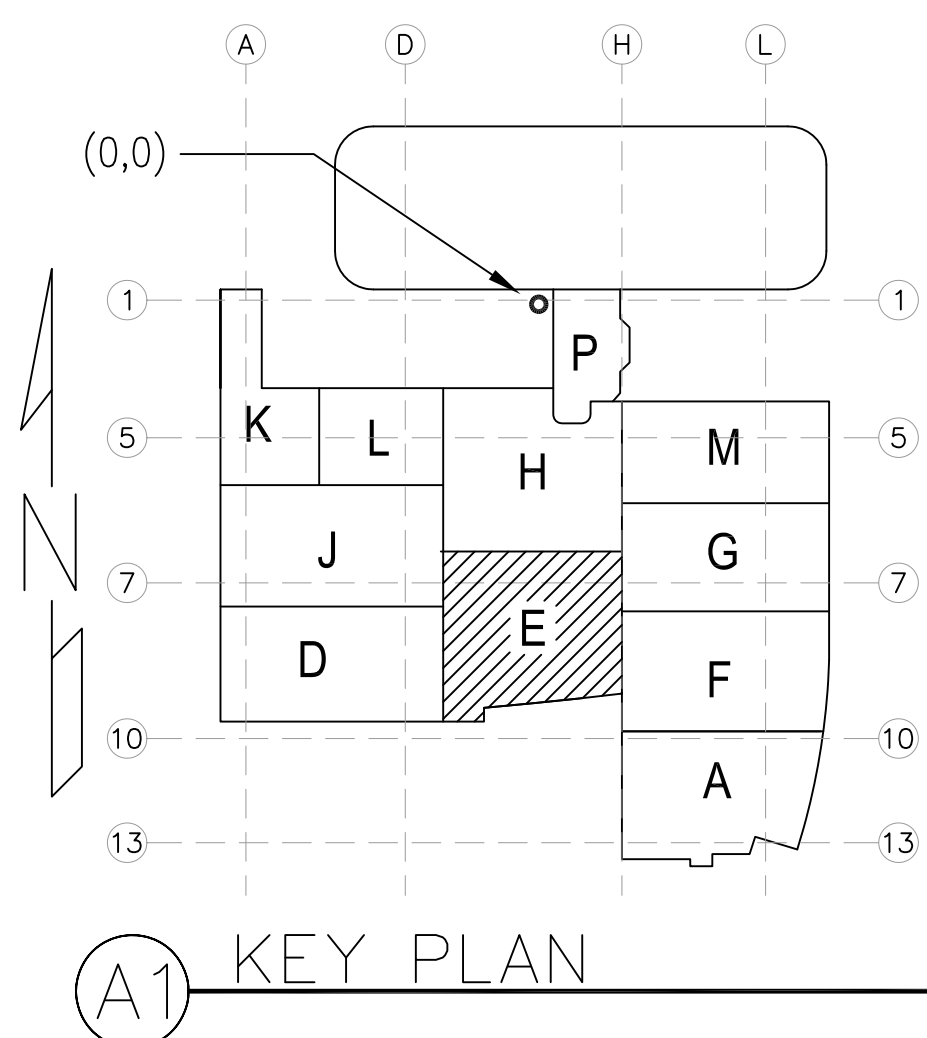


This document and the design it covers are the property of Murray Co. They are loaned only with the borrower's expressed written agreement that they will not be reproduced, copied, loaned, exhibited, or used in any other way, except by written consent from Murray Co. to the borrower.

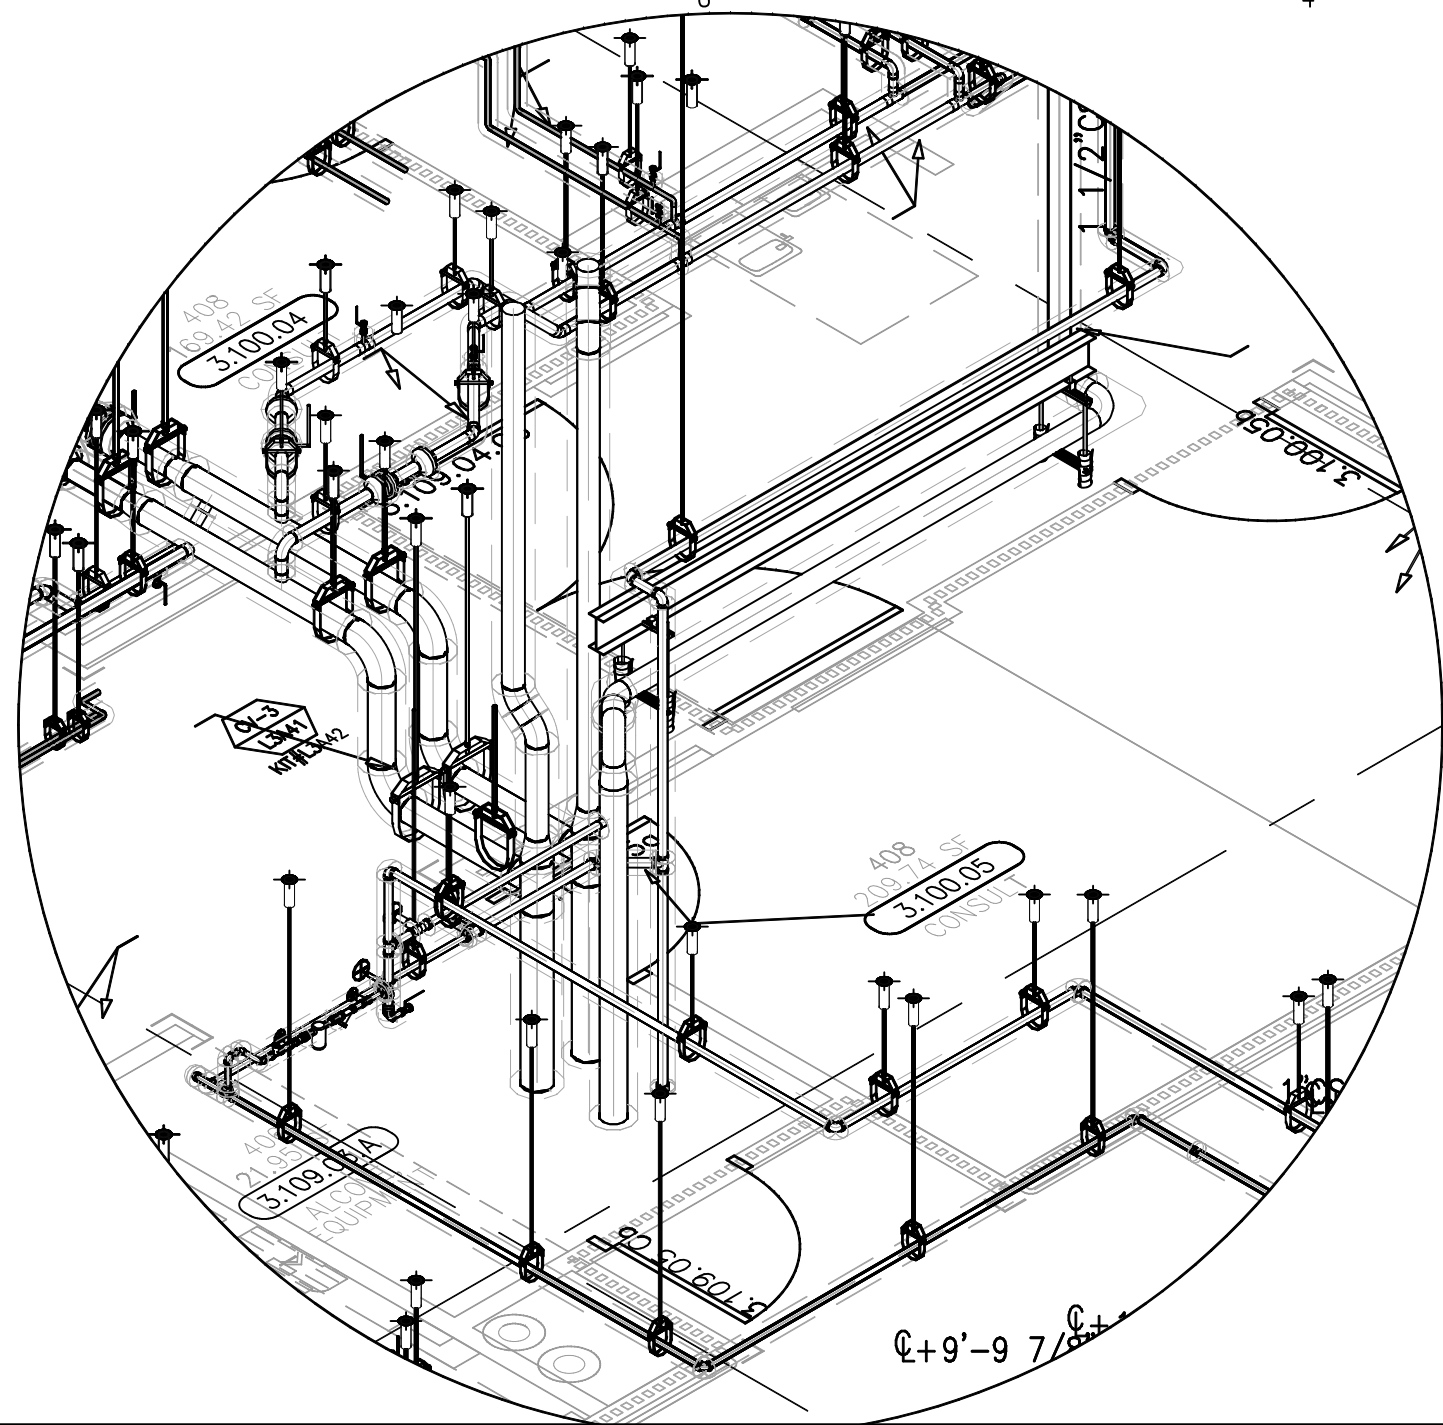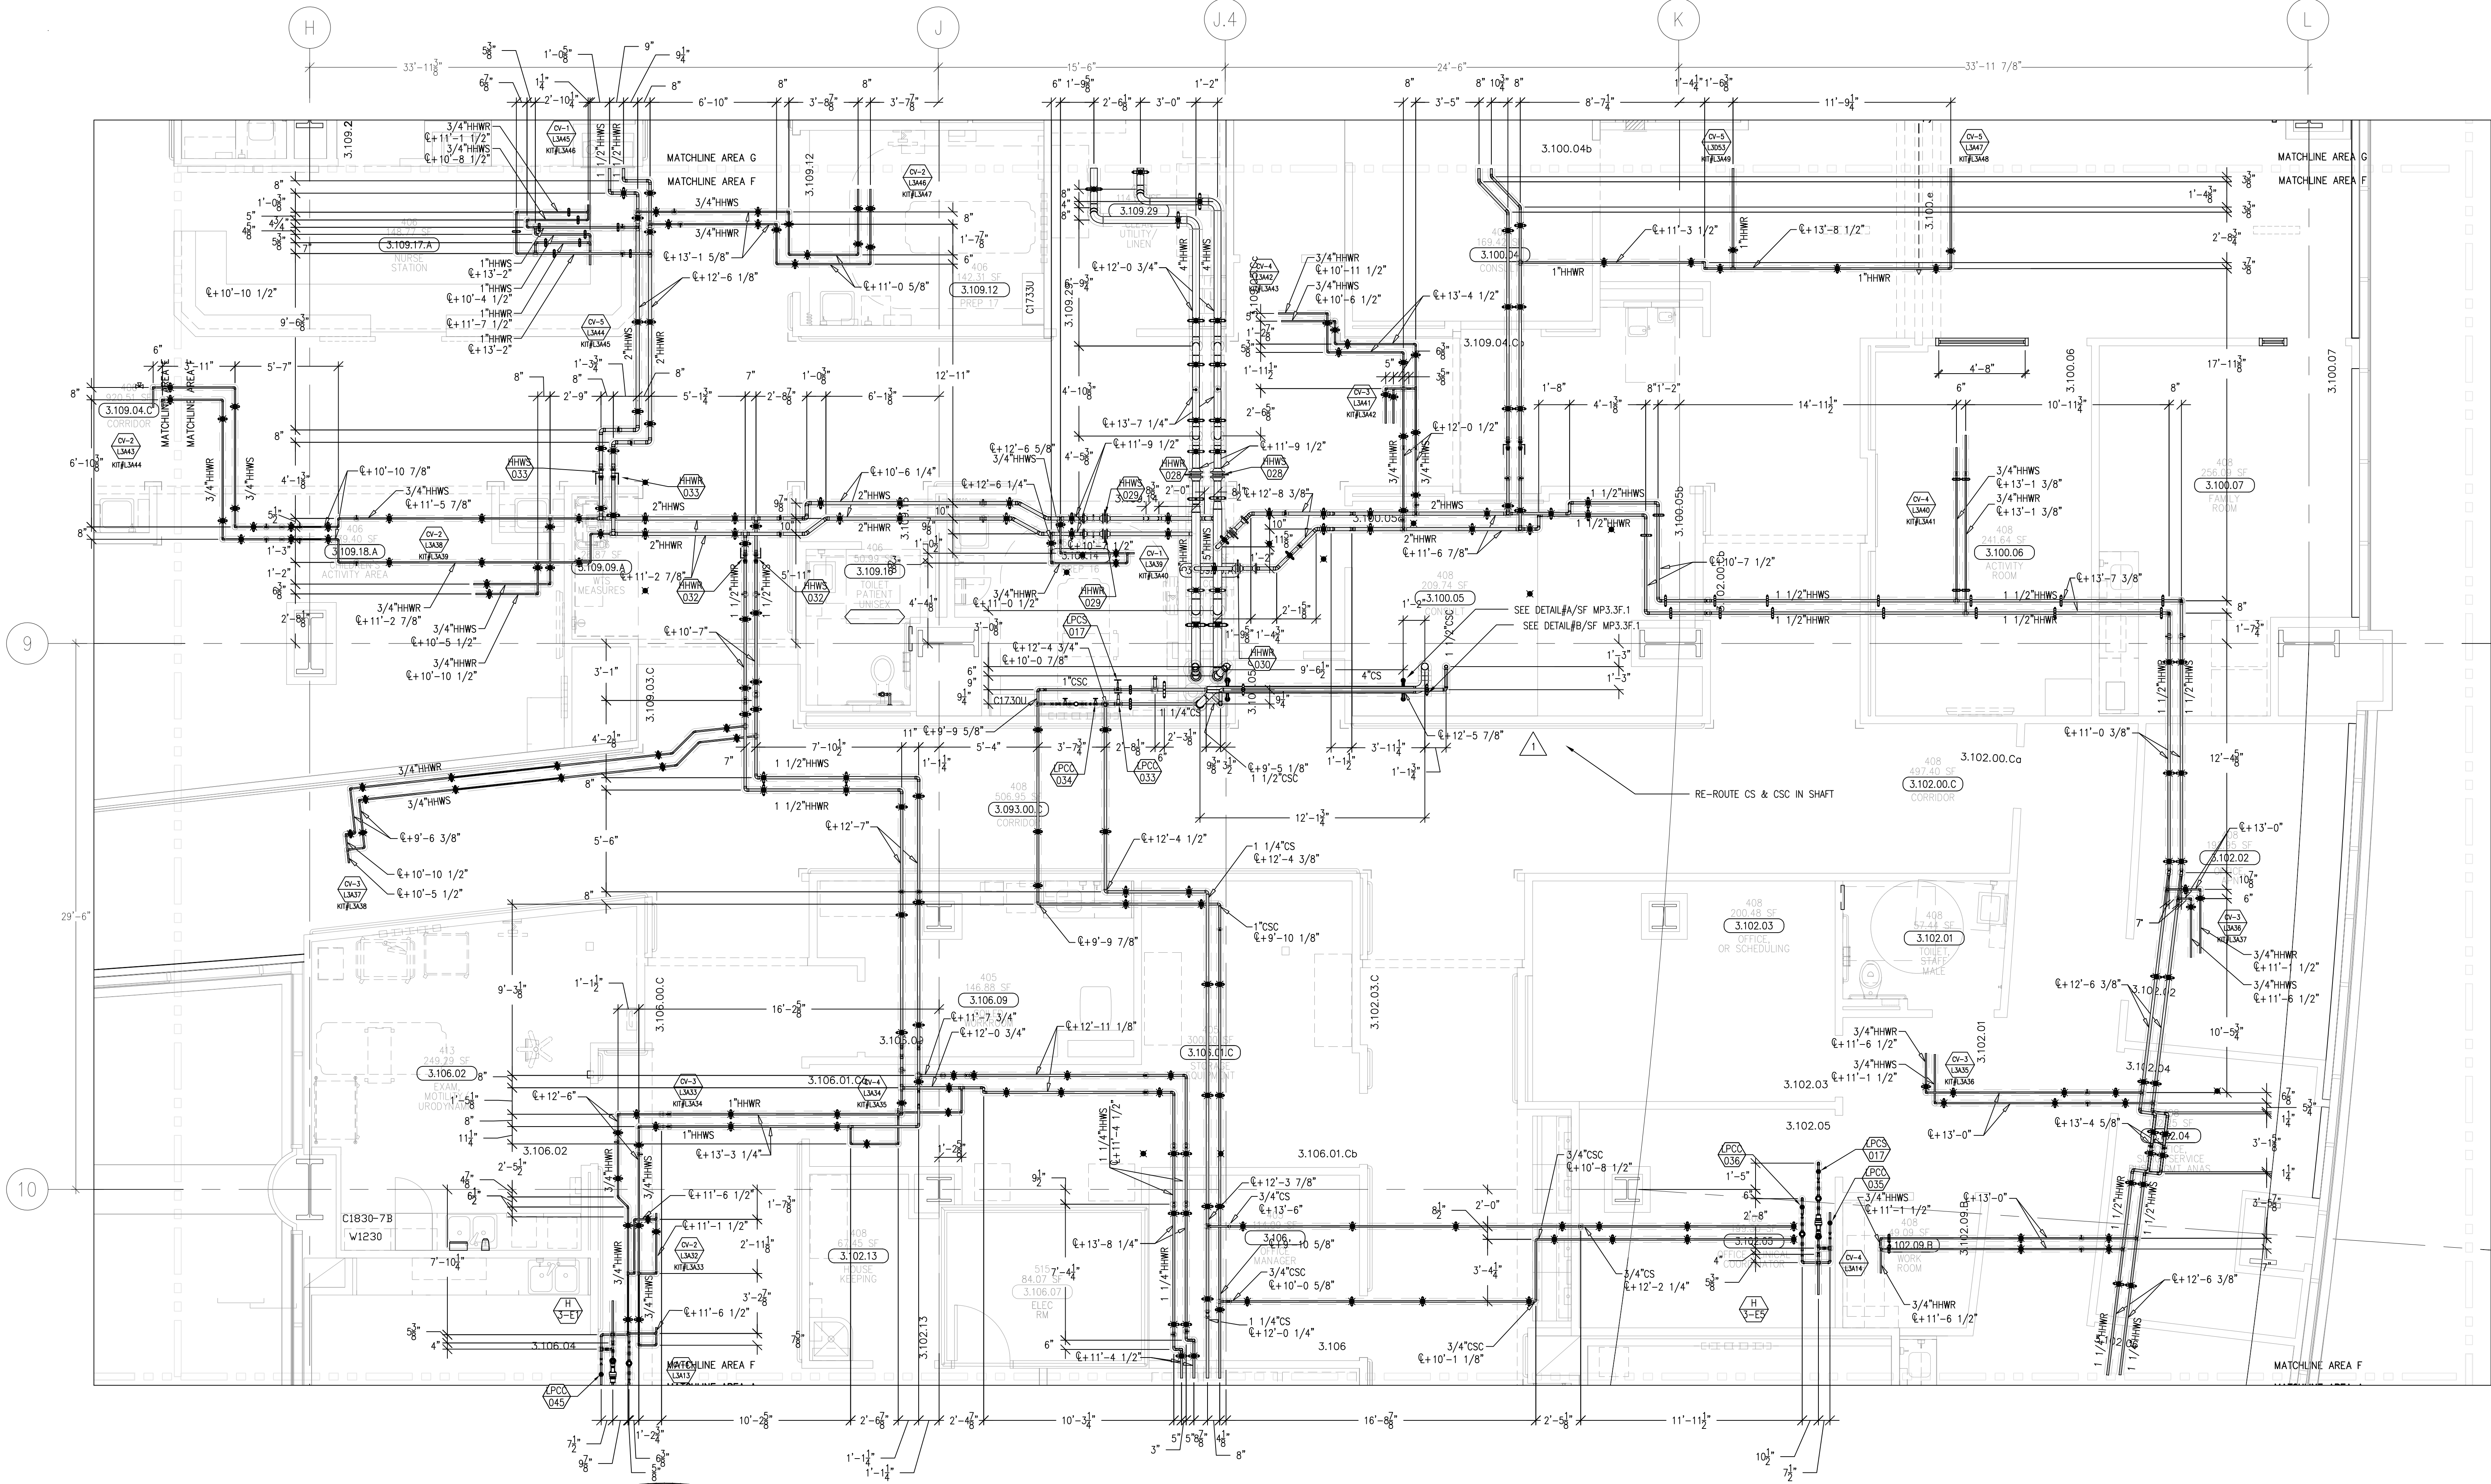

LEVEL 03 194.30' = 0'-0"
REFERENCE THIS SHEET

AS-BUILTS

DATE: 6-18-12 BY: J. CLINTON

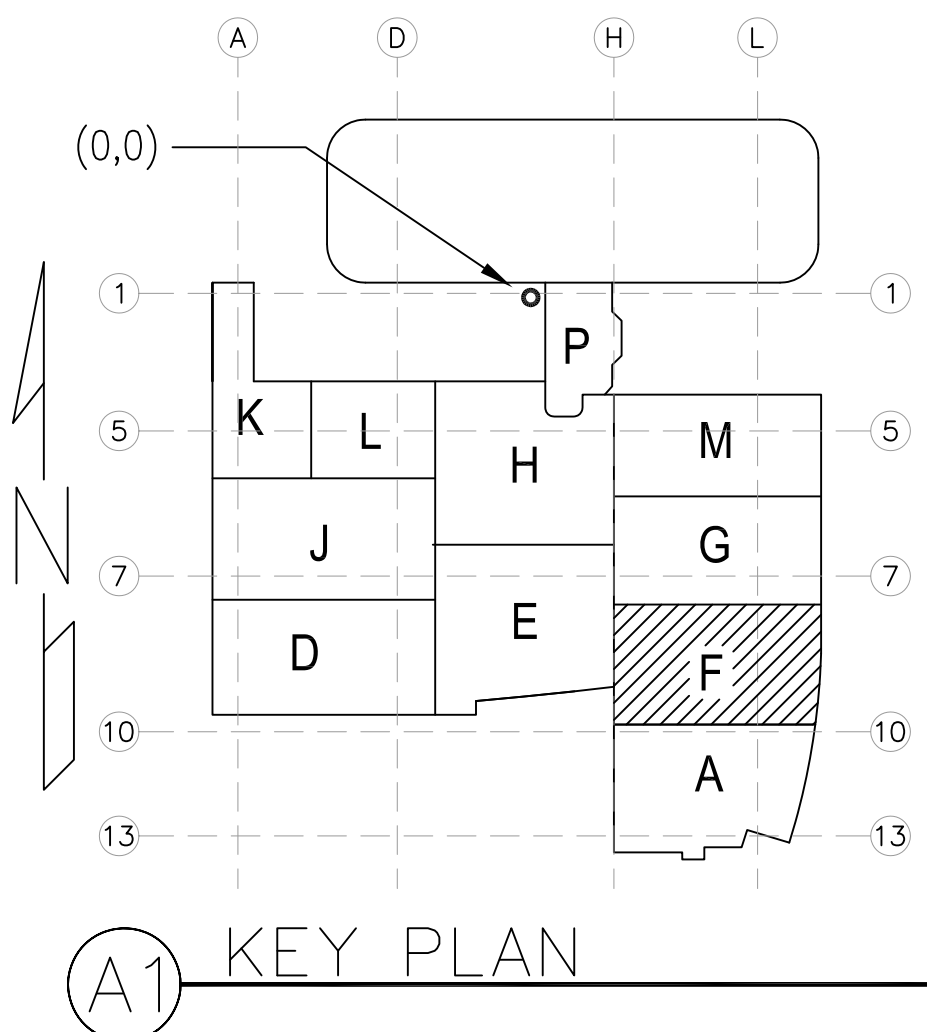

REVISIONS	BY

COORD.	SIGNATURE	DATE
MECHANICAL		
PLUMBING		
ELECTRICAL		
FIRE SPRINKLER		
PIPE		
DRAIN/WASTE/VENT		
STRUCTURAL		

ANS.	SENT	R.F.I.	ANS.	SENT	R.F.I.	ANS.	SENT	R.F.I.	ANS.	SENT	R.F.I.

CHILDREN'S HOSPITAL
OF ORANGE COUNTY
455 S. MAIN ST.
ORANGE, CA 92666-3974

TOWER II

MP FLOOR PLAN - LEVEL 03 AREA F

PAN-PACIFIC
PLUMBING & MECHANICAL
2919 E. VICTORIA STREET, RANCHO DOMINGUEZ, CA 90221
PH. 310.637.1500 FAX 310.604.0359

DRAWN
R.O.

CHECKED
M.M.

DATE
9/4/2012

SCALE
1/4" = 1'-0"

JOB NO.
09-006


DRAWING NUMBER
MP3.3F

REFERENCE DRAWING
A3.3F
P3.3F


1 OF 1 SHEETS

Day Files\09-006-CHC\MP3.3F-MP3.3F-BUILDING-03-AREA-F.dwg Printed by: jclinton Date: 9-4-2012 11:02am


This document and the design it covers are the property of Murray Co. They are loaned only with the borrower's expressed written agreement that they will not be reproduced, copied, loaned, exhibited, or used in any way, except by written consent from Murray Co. to the borrower.

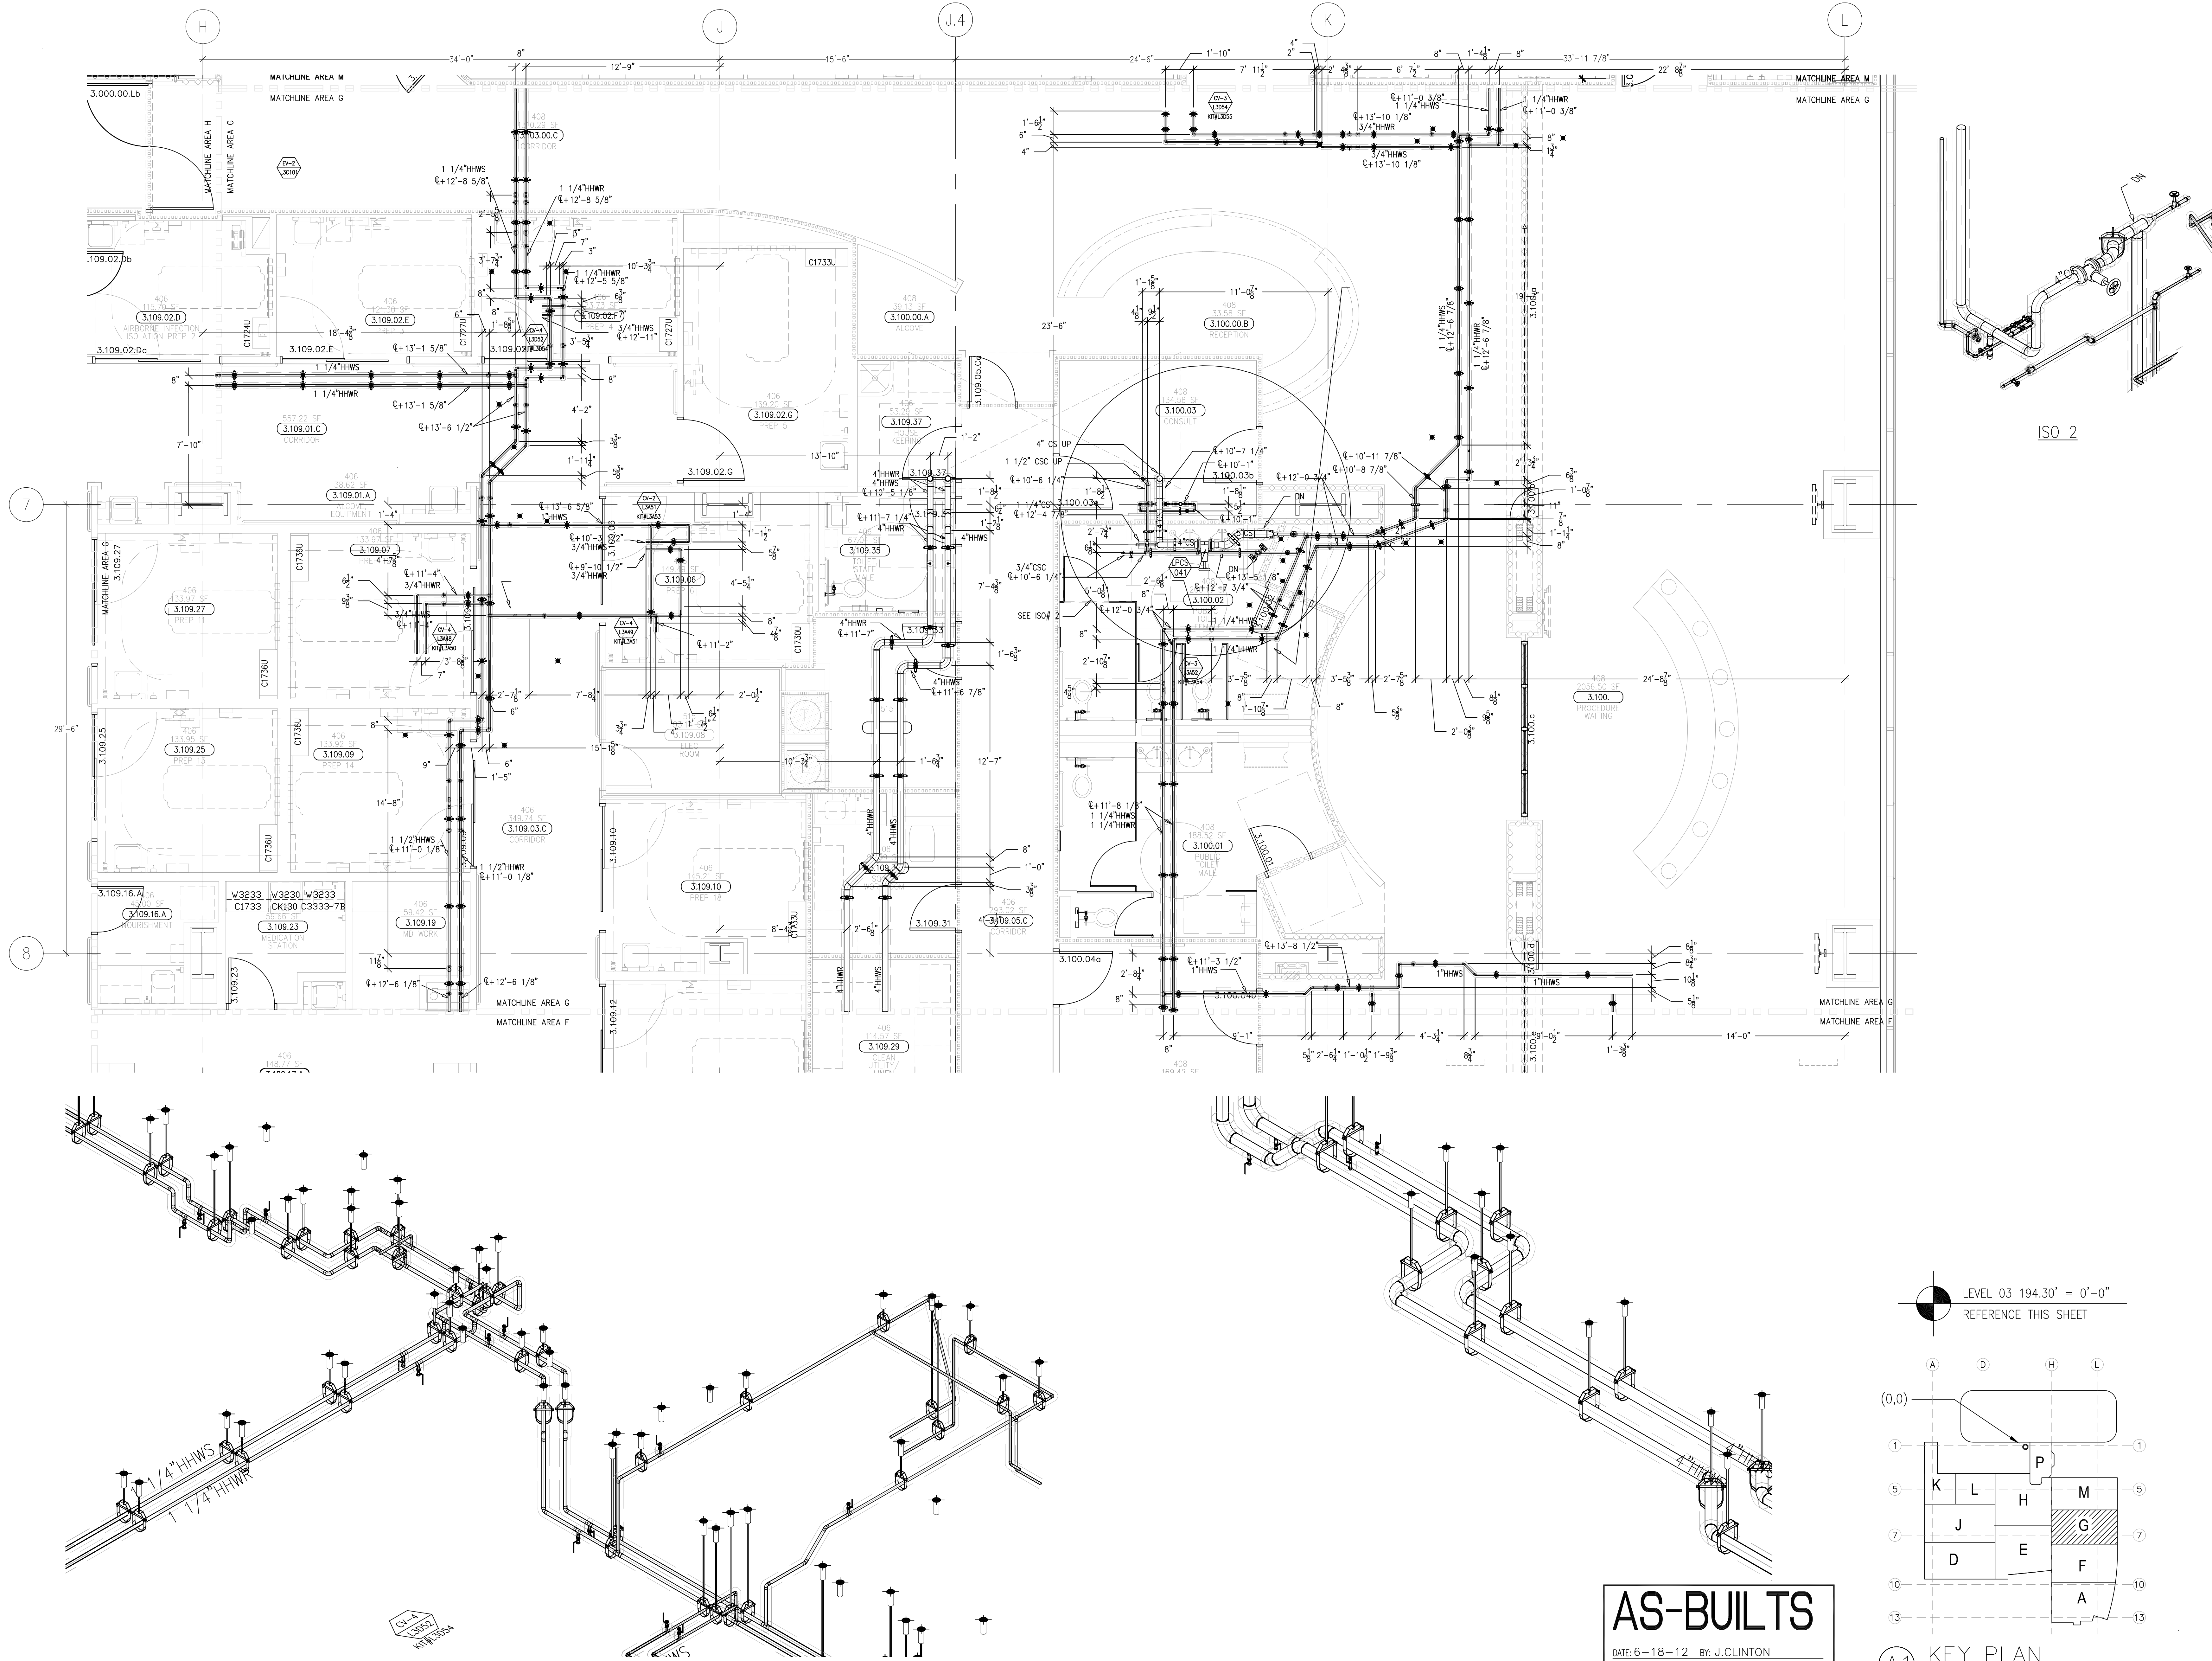

LEVEL 03 194.30' = 0'-0"
REFERENCE THIS SHEET

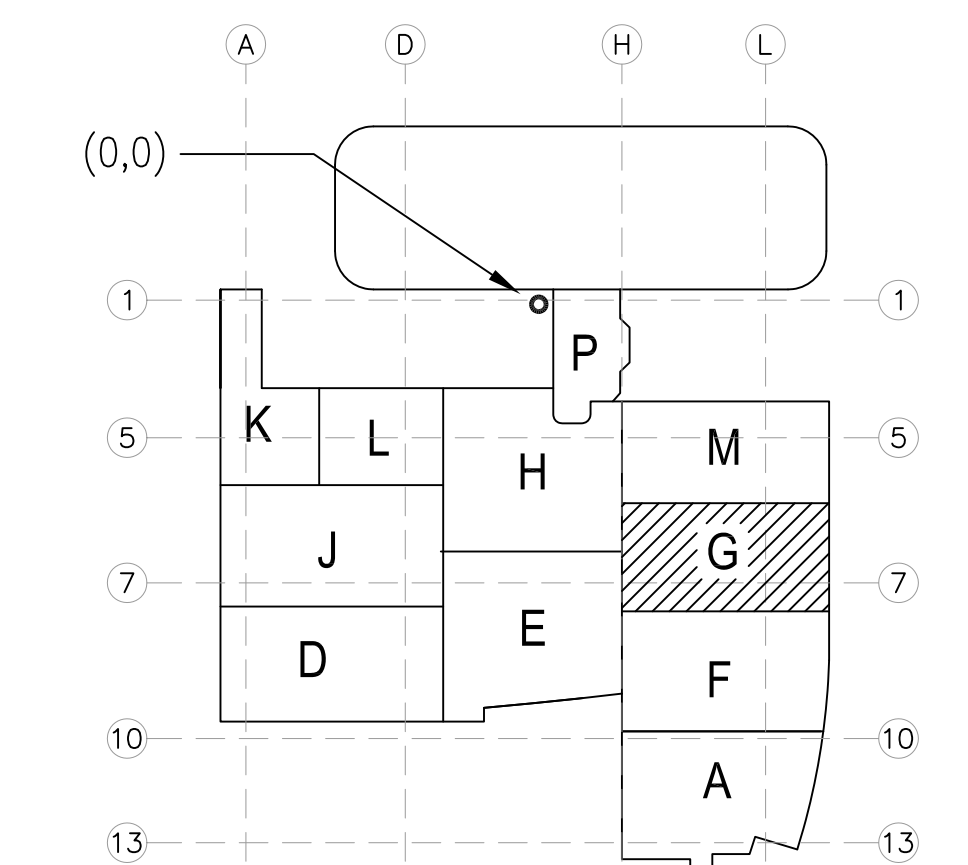

AS-BUILTS
DATE: 6-18-12 BY: J. CLINTON

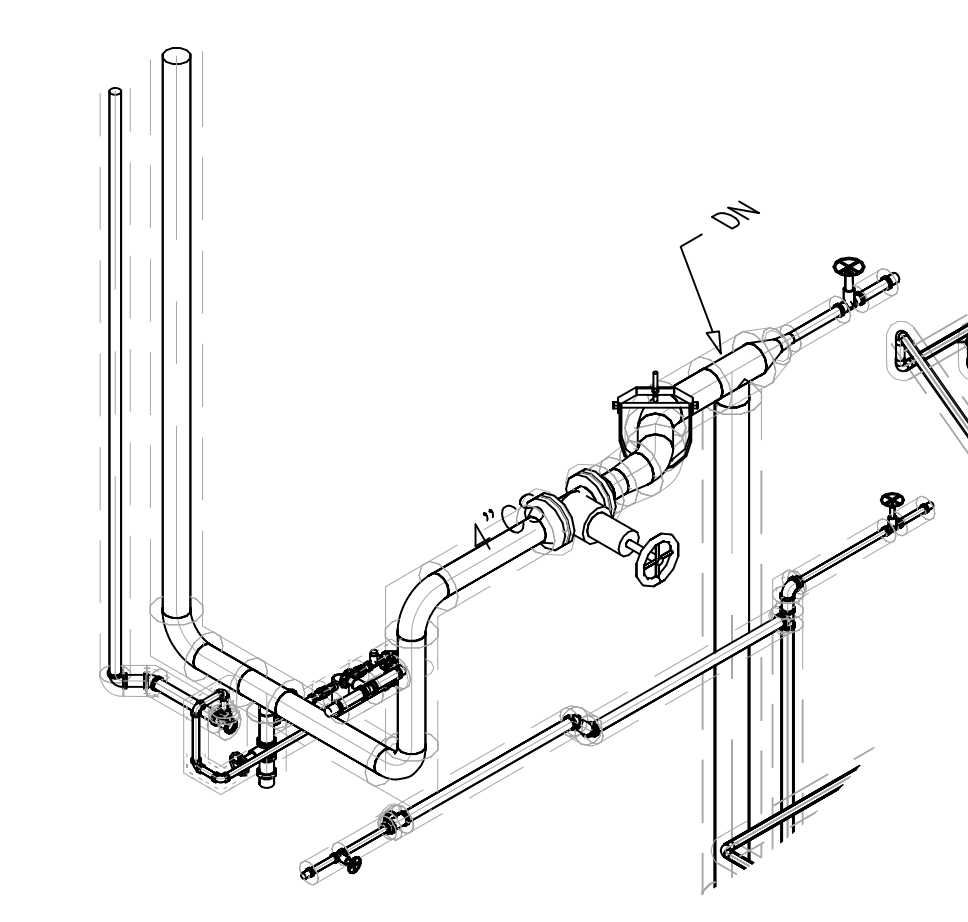

ISO 2

REVISIONS		BY

COORD.	SIGNATURE	DATE
MECHANICAL		
ELECTRICAL		
PLUMBING		
STRUCTURAL		

**CHILDREN'S HOSPITAL
OF ORANGE COUNTY
TOWER II**
MECHANICAL PIPE FLOOR PLAN - LEVEL 03 AREAS

**PAN-PACIFIC
PLUMBING & MECHANICAL**
2919 E. VICTORIA STREET, RANCHO DOMINGUEZ, CA 90221
PH. 310 637-1500 FAX 310 604-0359

Murray Co.
1405 S. MAIN ST. CA 92605-9874








DRAWN	R.O.
CHECKED <th>M.M.</th>	M.M.
DATE <td>9/4/2012</td>	9/4/2012
SCALE <td>1/4" = 1'-0"</td>	1/4" = 1'-0"
JOB NO. <td>09-006</td>	09-006
DRAWING NUMBER <td>MP3.3G</td>	MP3.3G
REFERENCE DRAWING <td>A3.3G</td>	A3.3G
P3.3G	
1 OF 1 SHEETS	

DATE: 6-18-12 BY: J.CLINTON



DRAWN
R.O.
CHECKED
M.M.
DATE
9/4/2012
SCALE
1/4"=1'-0"
JOB NO.
09-006
DRAWING NUMBER
MP3.3H
REFERENCE DRAWING
A3.3H
P3.3H
1 OF 1 SHEETS

This document and the design it covers are the property of Murray Co. They are loaned only with the borrower's expressed written agreement that they will not be reproduced, copied, loaned, exhibited, or used in any way, except by written consent from Murray Co. to the borrower.

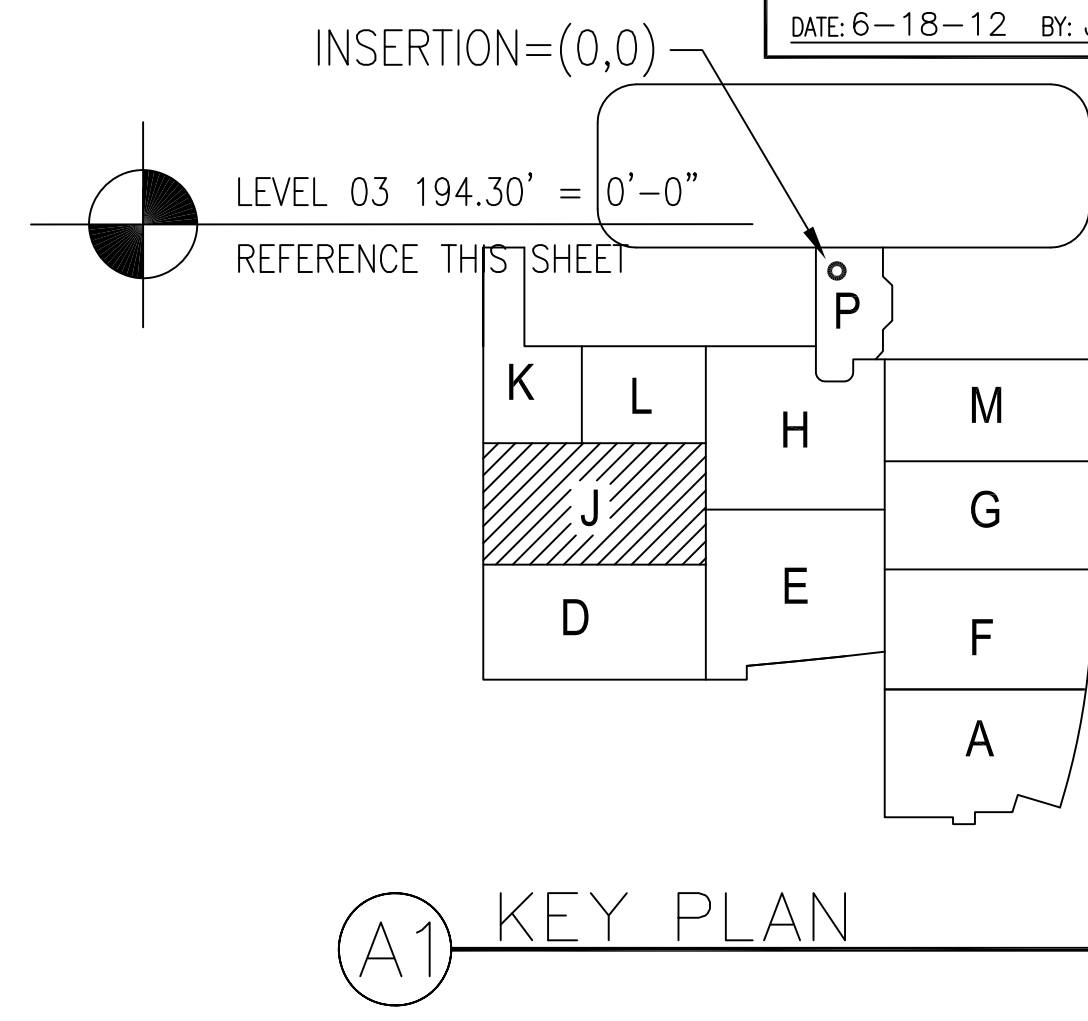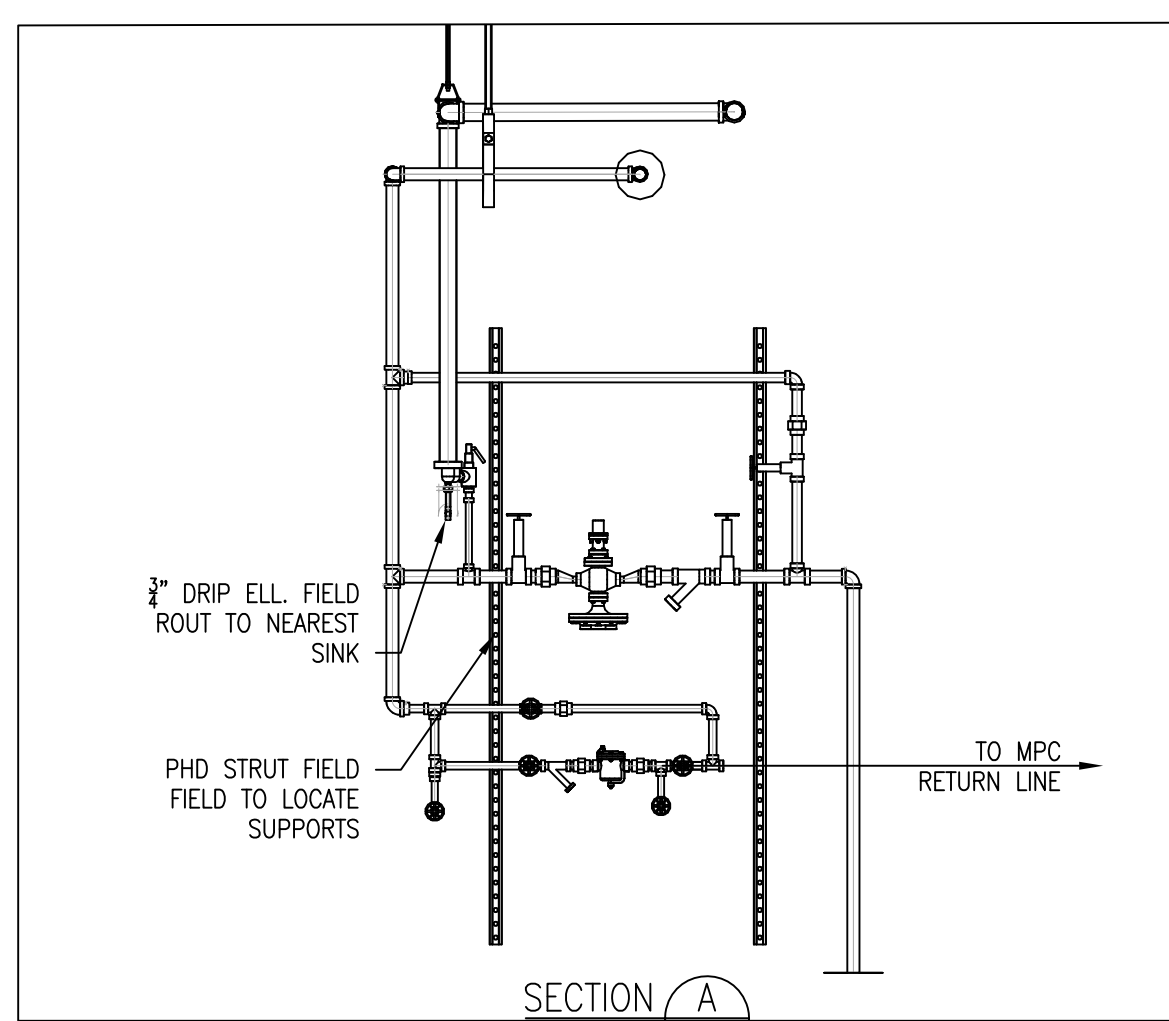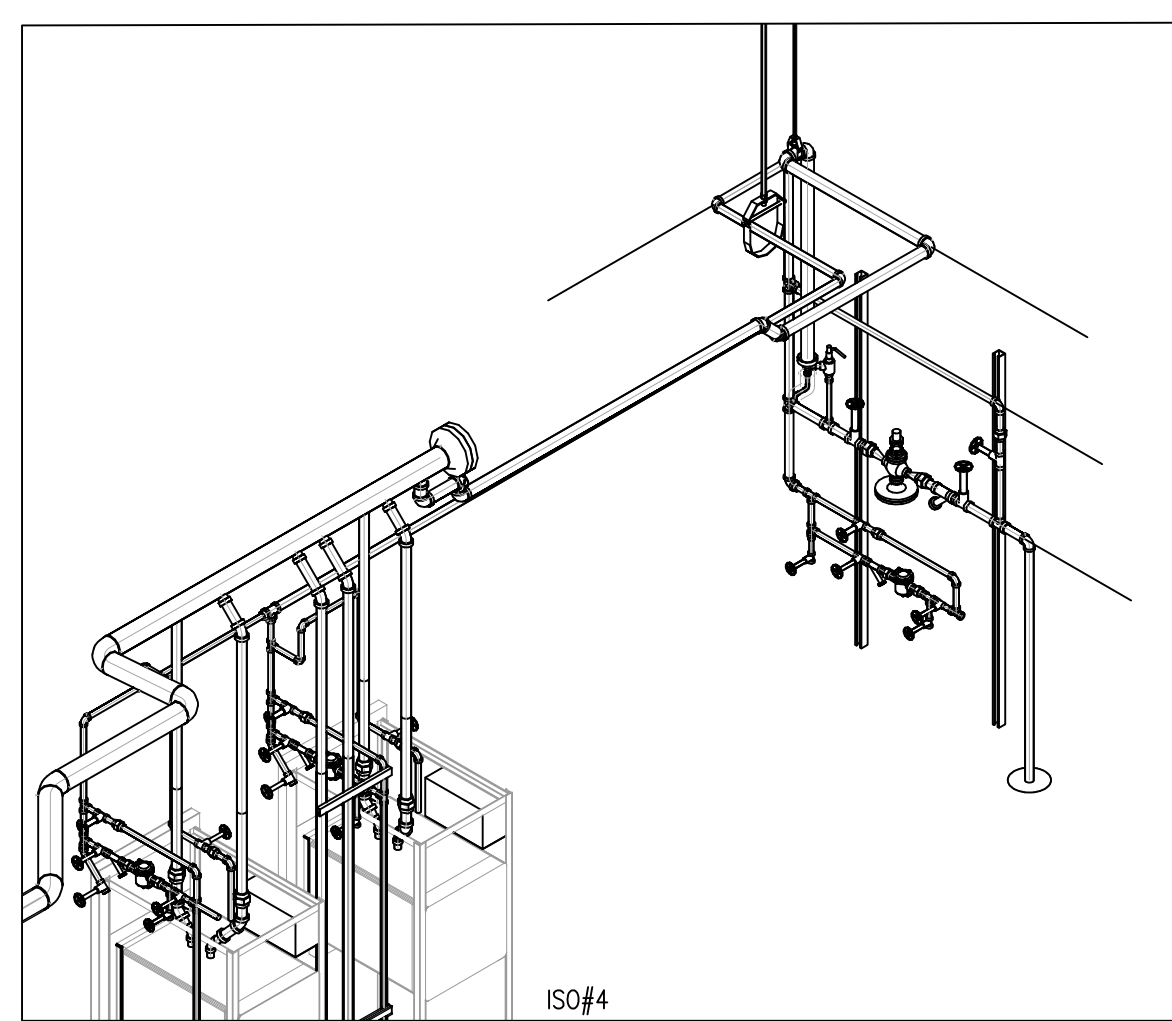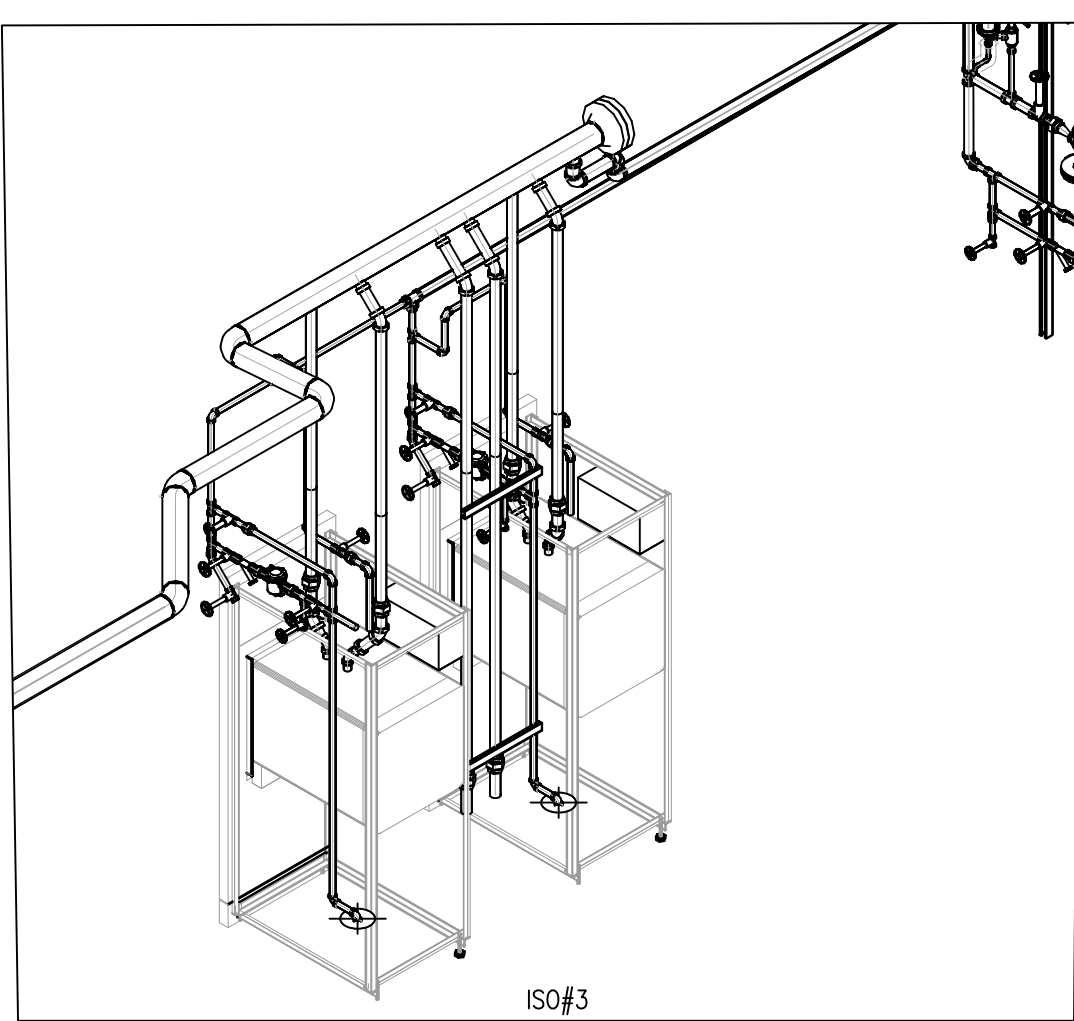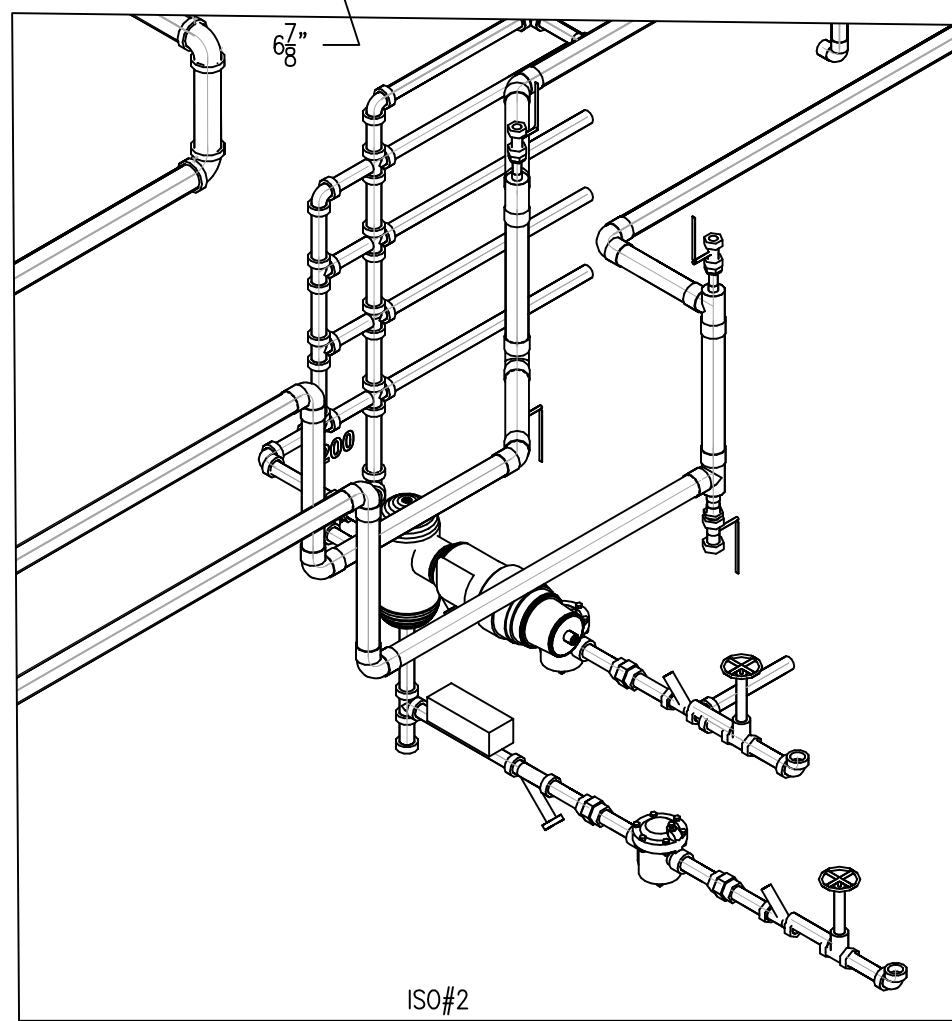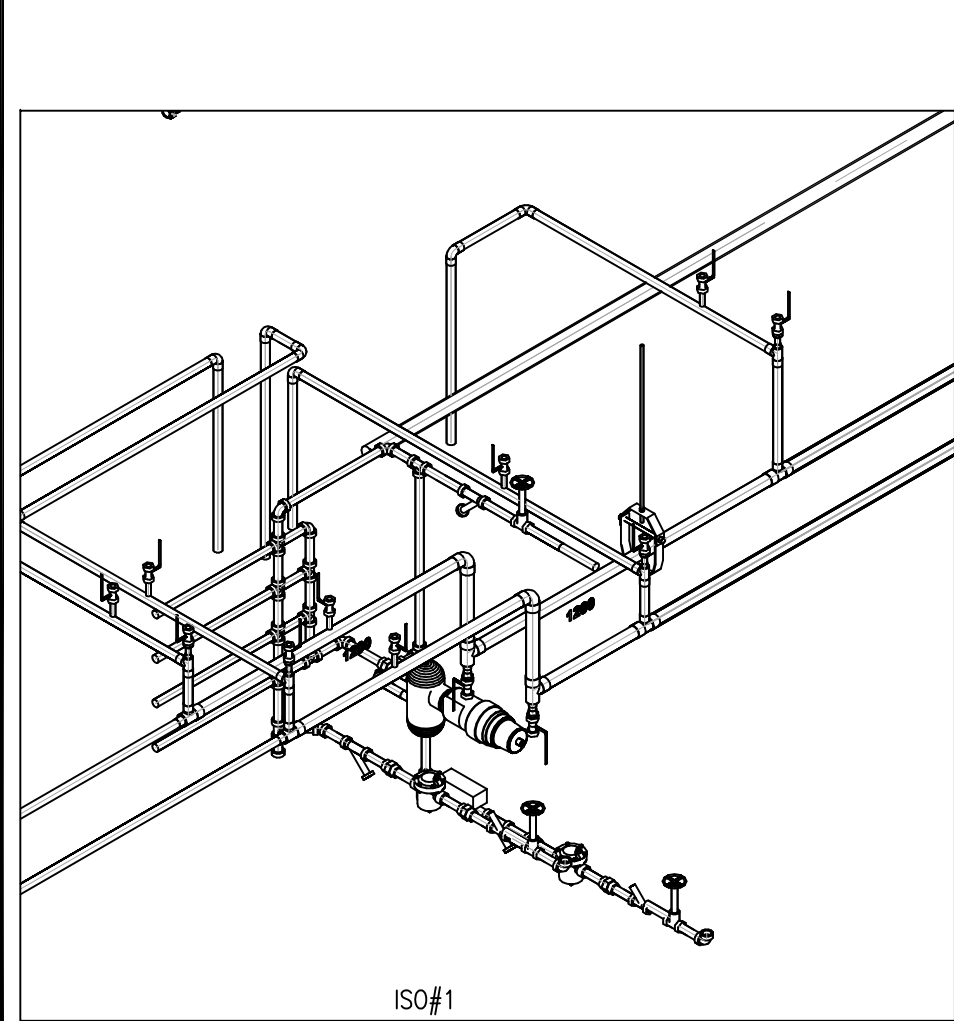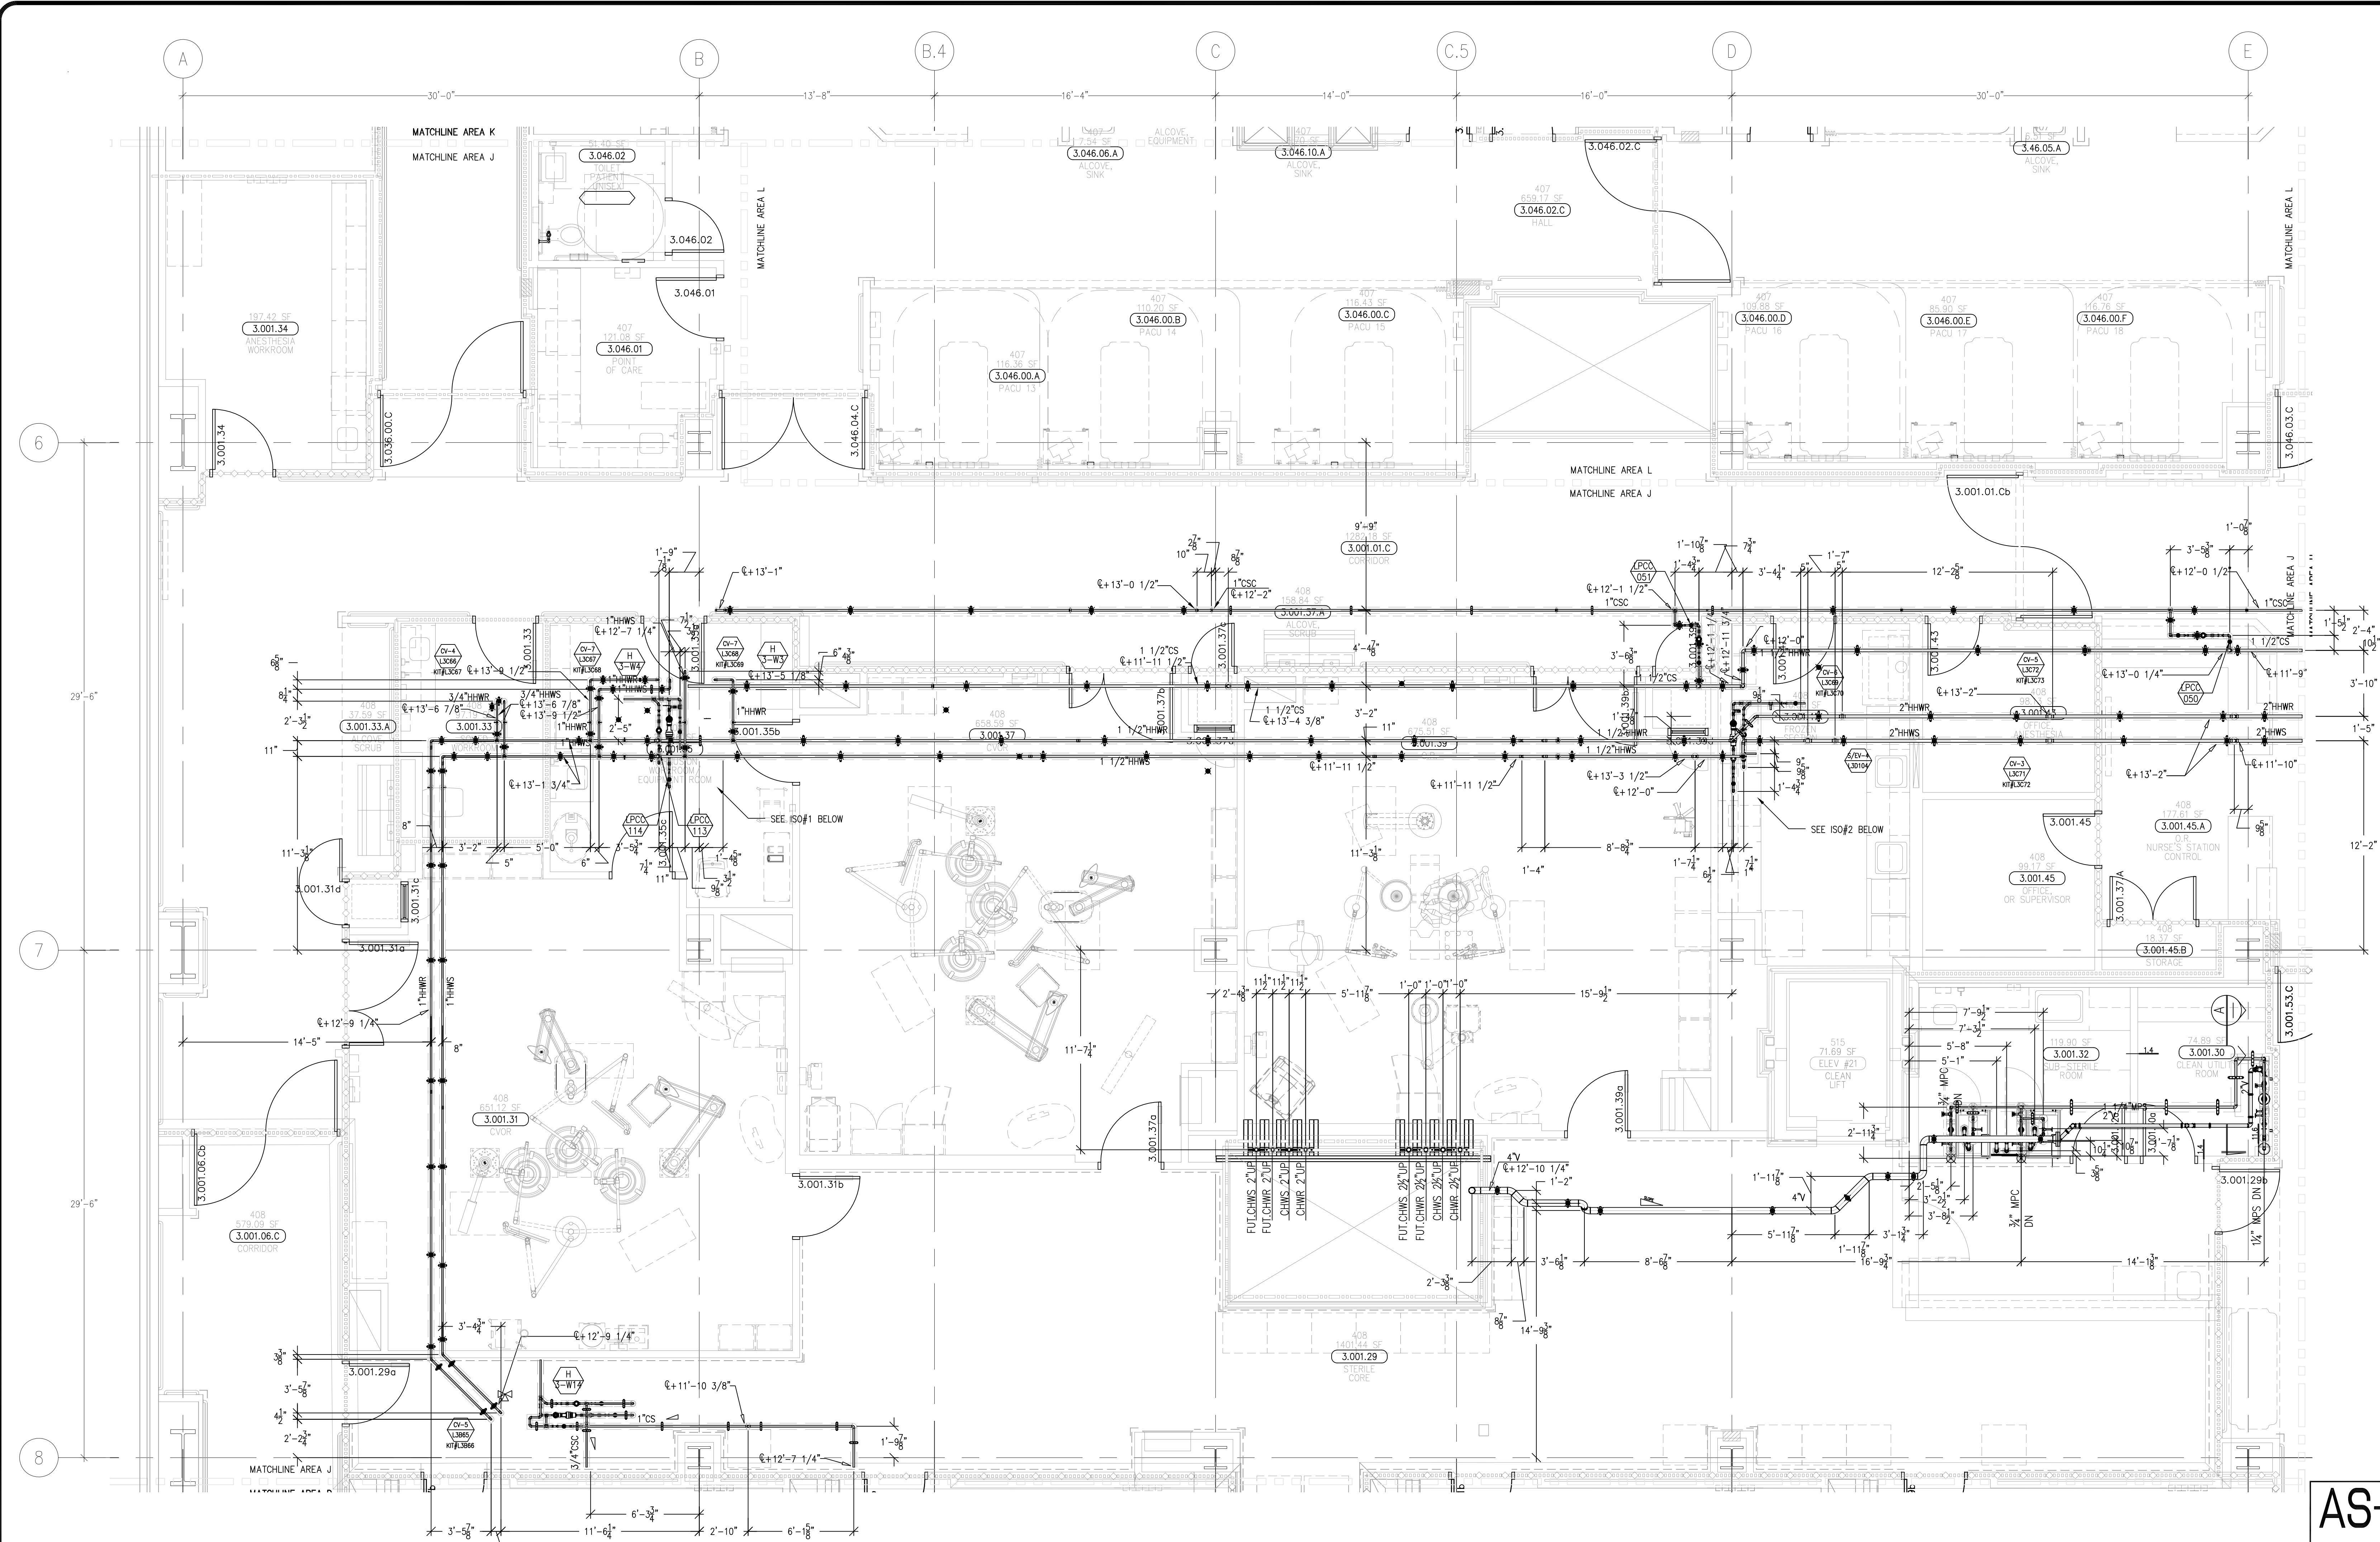

AS-BUILTS
DATE: 6-18-12 BY: J. CLINTON

REVISIONS	BY

COORD.	SIGNATURE	DATE
MECHANICAL		
ELECTRICAL		
PLUMBING		
STRUCTURAL		


ANS.	SENT	R.F.I.	ANS.	SENT	R.F.I.	ANS.	SENT	R.F.I.	ANS.	SENT	R.F.I.

**CHILDREN'S HOSPITAL
OF ORANGE COUNTY**
455 S. MAIN ST.
ORANGE, CA 92666-3974
TOWER II
MECHANICAL PIPE PLAN - LEVEL 03 AREA J

PAN-PACIFIC
PLUMBING & MECHANICAL
2919 E. VICTORIA STREET, RANCHO DOMINGUEZ, CA 90221
PH. 310 637-1500 FAX 310 604-0359


DRAWN
R.O.
CHECKED
M.M.
DATE
9/4/2012
SCALE
1/4" = 1'-0"
JOB NO.
09-006
DRAWING NUMBER
MP3.3J
REFERENCE DRAWING
A3.3J
P3.3J
1 OF 1 SHEETS

document and the design it covers are the property of Murray Co. They are loaned only with the borrower's expressed agreement that they will not be reproduced, copied, loaned, exhibited, or used in any other way, except by written consent from Murray Co. to the borrower.

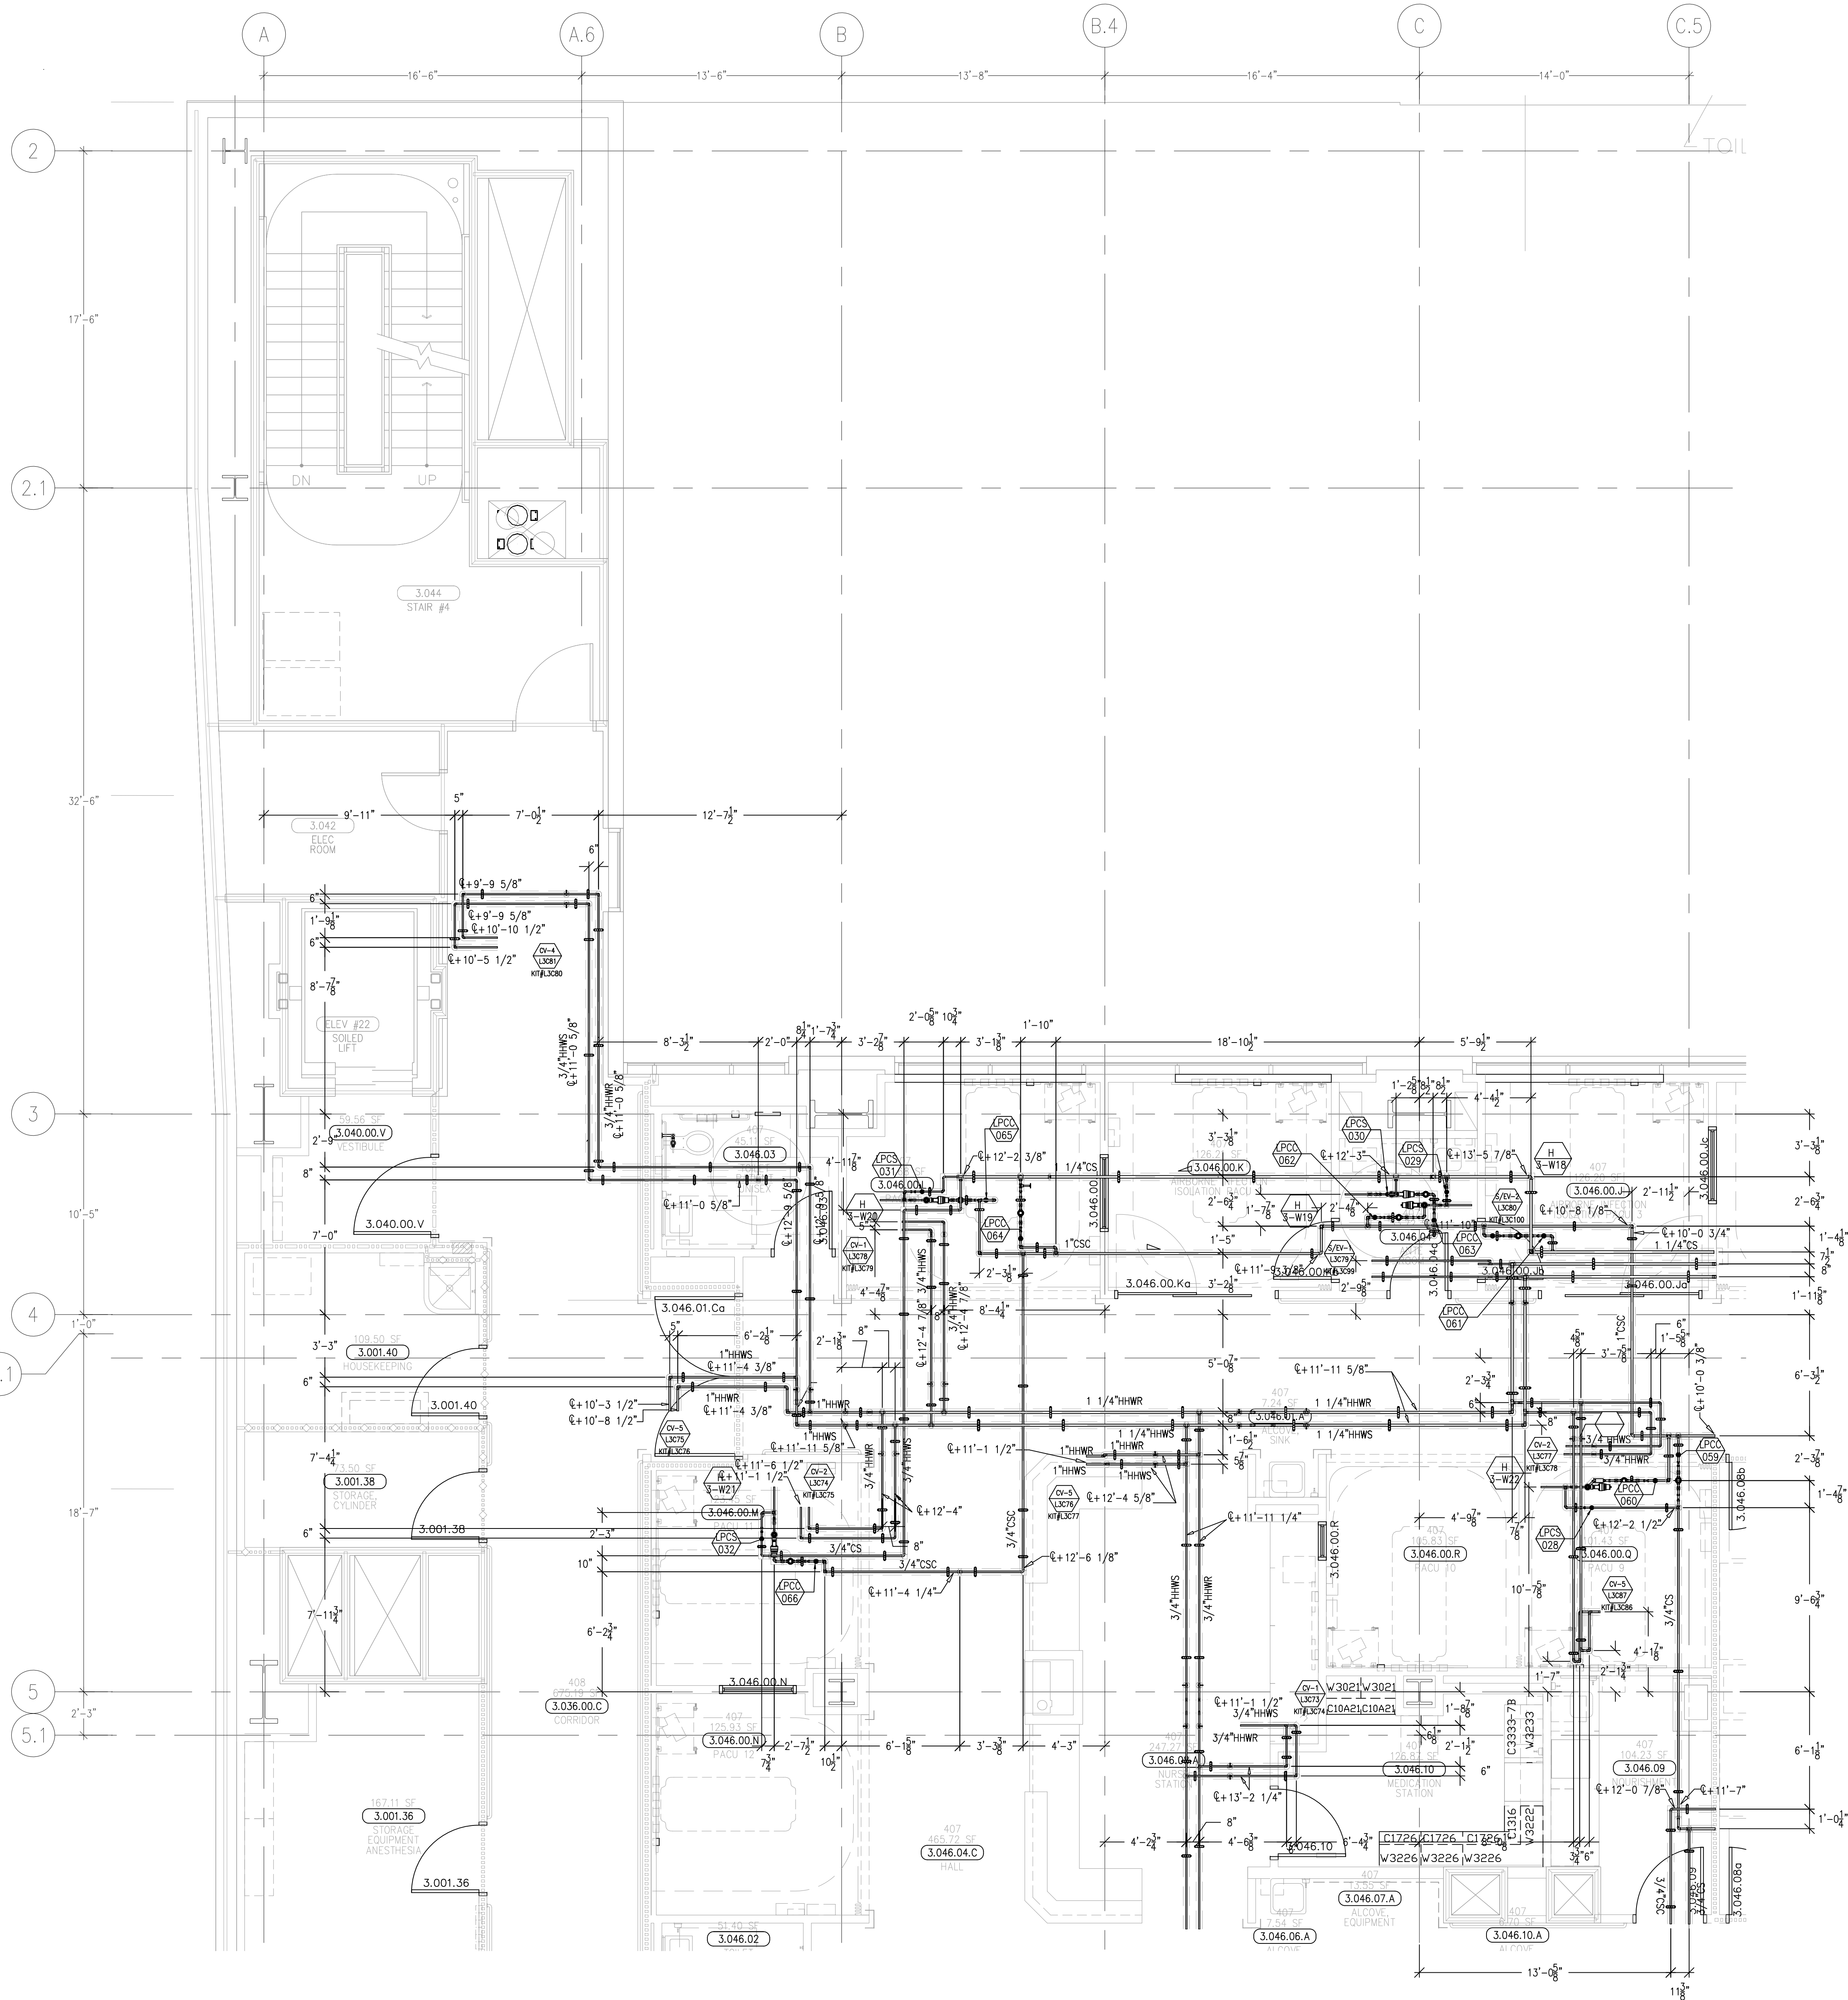

AS-BUILTS

DATE: 6-18-12 BY: J.CLINTON

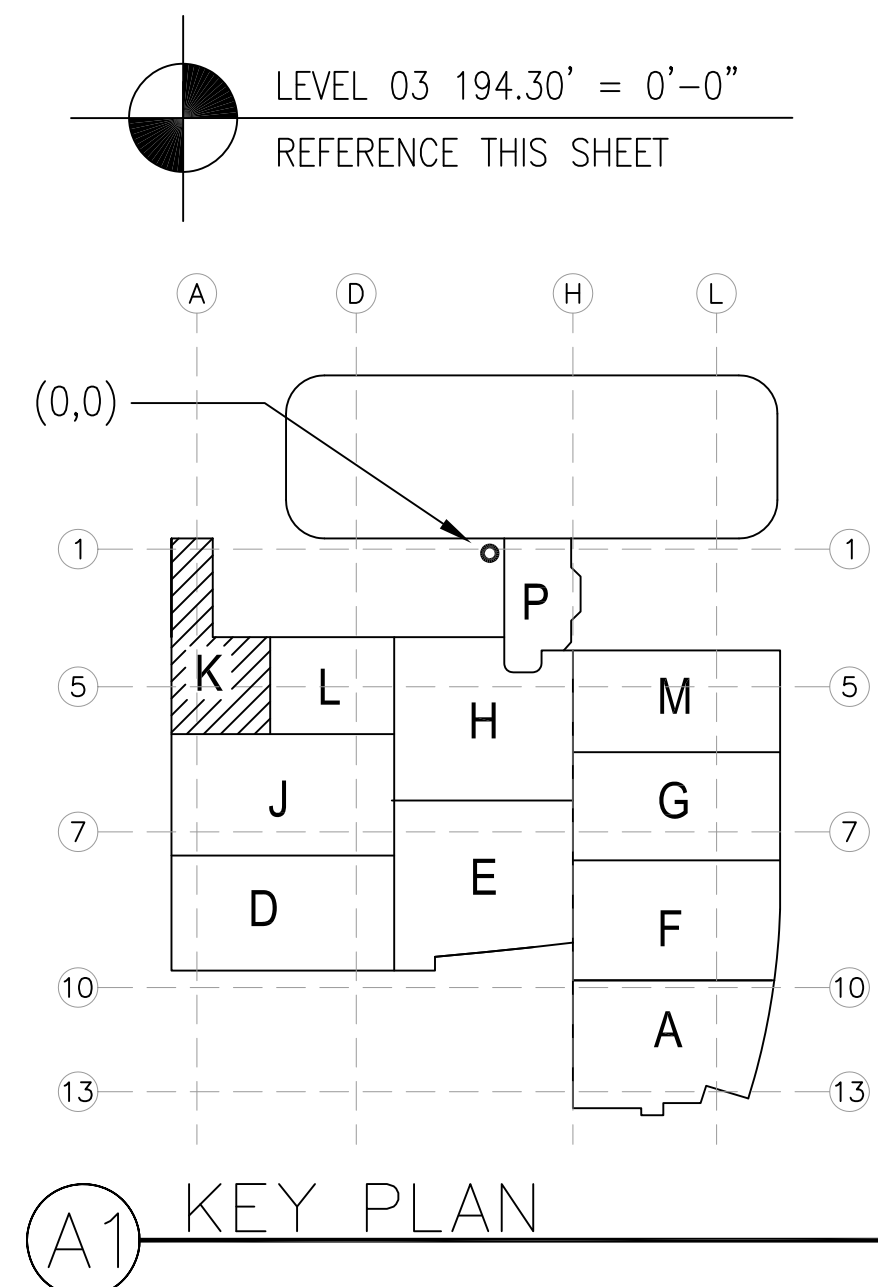[illegible]

COORD.	SIGNATURE	DATE
MCCARTY		
MECHANICAL DUCT		
MECHANICAL PIPE		
PLUMBING		
ELECTRICAL		
FIRE SPRINKLER		
PLUMB		
DRYWALL/FRAMER		
REFRIGERATION		
STRUCTURAL		

[illegible]

CHILDREN'S HOSPITAL
OF ORANGE COUNTY
455 S. Main St.
Orange, CA 92669-3874
TOWER II
MECHANICAL PIPE FLOOR PLAN - LEVEL 03 AREA-K

PAN-PACIFIC
PLUMBING & MECHANICAL

Murray Company


2919 E. VICTORIA STREET, RANCHO DOMINGUEZ, CA 90221
PH. 310 637-1500 FAX. 310 604-0359

DRAWN R.O.
CHECKED
M.M.
DATE
9/4/2012
SCALE
1/4" = 1' - 0"
JOB NO.
09-006
DRAWING NUMBER
MP3.3K
REFERENCE DRAWING
A3.3K
P3.3K
1 OF 1 SHEETS


[illegible]

LEVEL 03 194.30' = 0'-0"


REFERENCE THIS SHEET

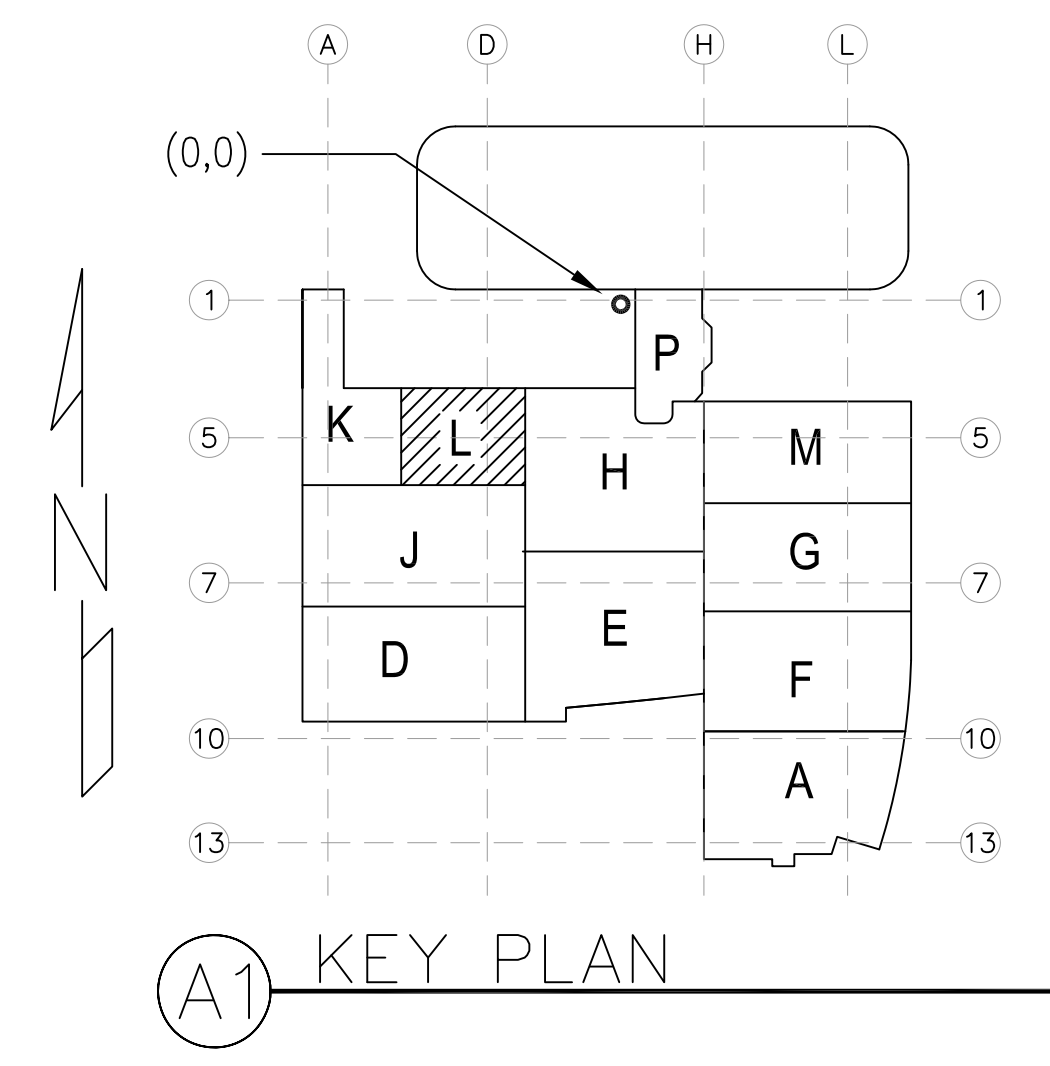[illegible]

This document and the design it covers are the property of Murray Co. They are loaned only with the borrower's expressed agreement that they will not be reproduced, copied, loaned, exhibited, or used in any other way, except by written consent from Murray Co. to the borrower.

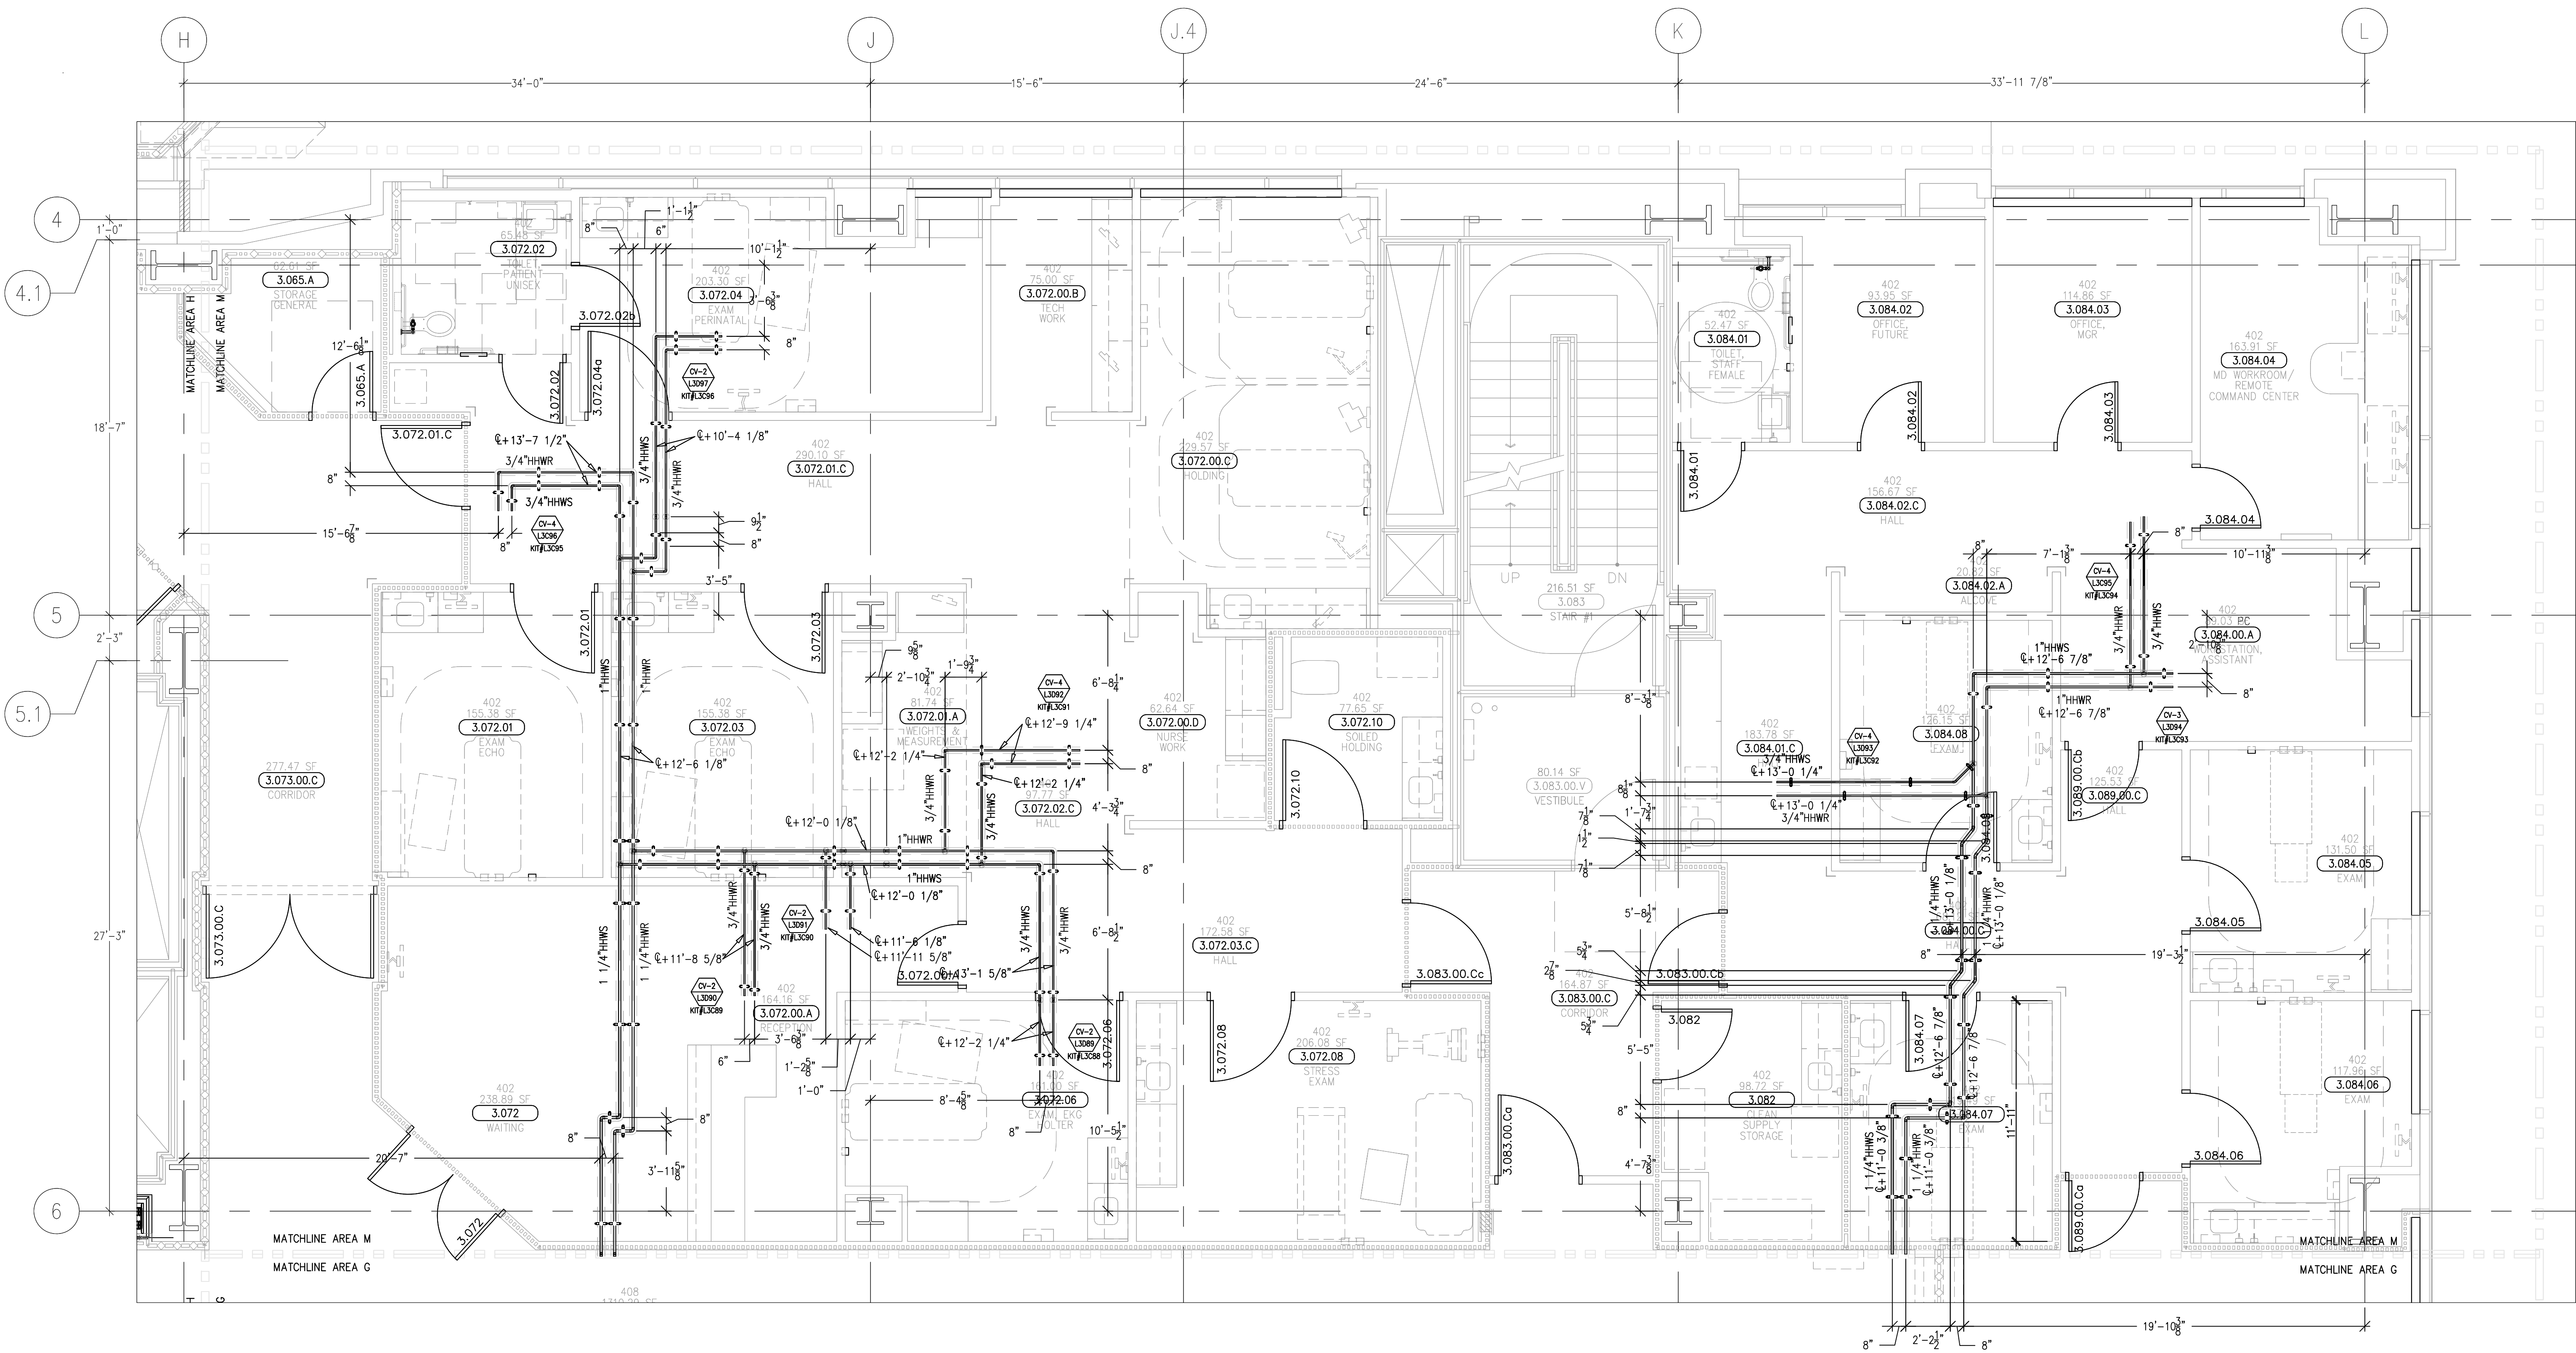

DATE: 6-18-12 BY: J.CLINTON

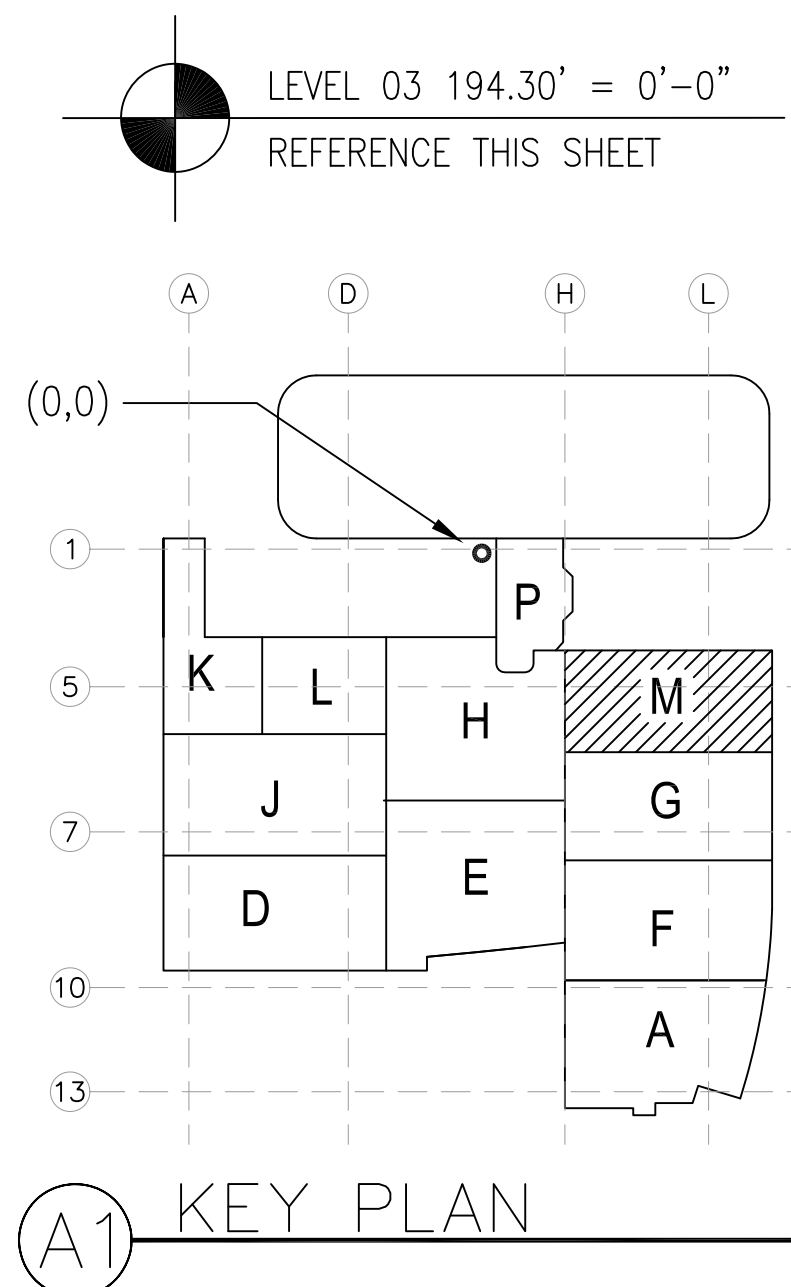
[illegible]

COORD.	SIGNATURE	DATE
MCARTHY		
MECHANICAL DUCT		
MECHANICAL PIPE		
PLUMBING		
ELECTRICAL		
FIRE SPRINKLER		
PIPE		
DRYWALL/FRAMER		
REFRIGERATION		
STRUCTURAL		

[illegible]

CHILDREN'S HOSPITAL
OF ORANGE COUNTY

MECHANICAL PIPE FLOOR PLAN - LEVEL 03 AREA-M

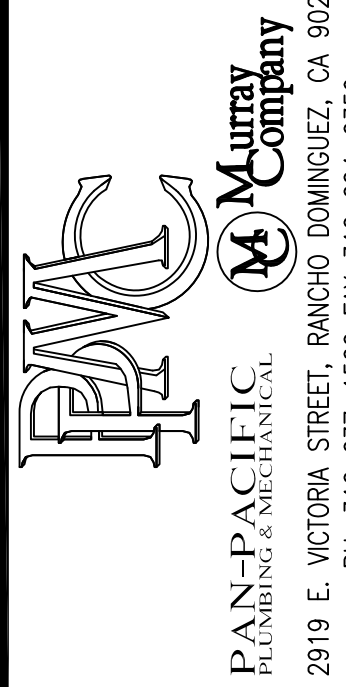

DRAWN	J.M.
CHECKED	M.M.
DATE	9/4/2012
SCALE	1/4"=1'-0"
JOB NO.	09-006
DRAWING NUMBER	MP3.3M
REFERENCE DRAWING	A3.3M