



This document and the design it covers are the property of Murray Co. They are loaned only with the borrower's expressed written agreement that they will not be reproduced, copied, loaned, exhibited, or used in any way, except by written consent from Murray Co. to the borrower.

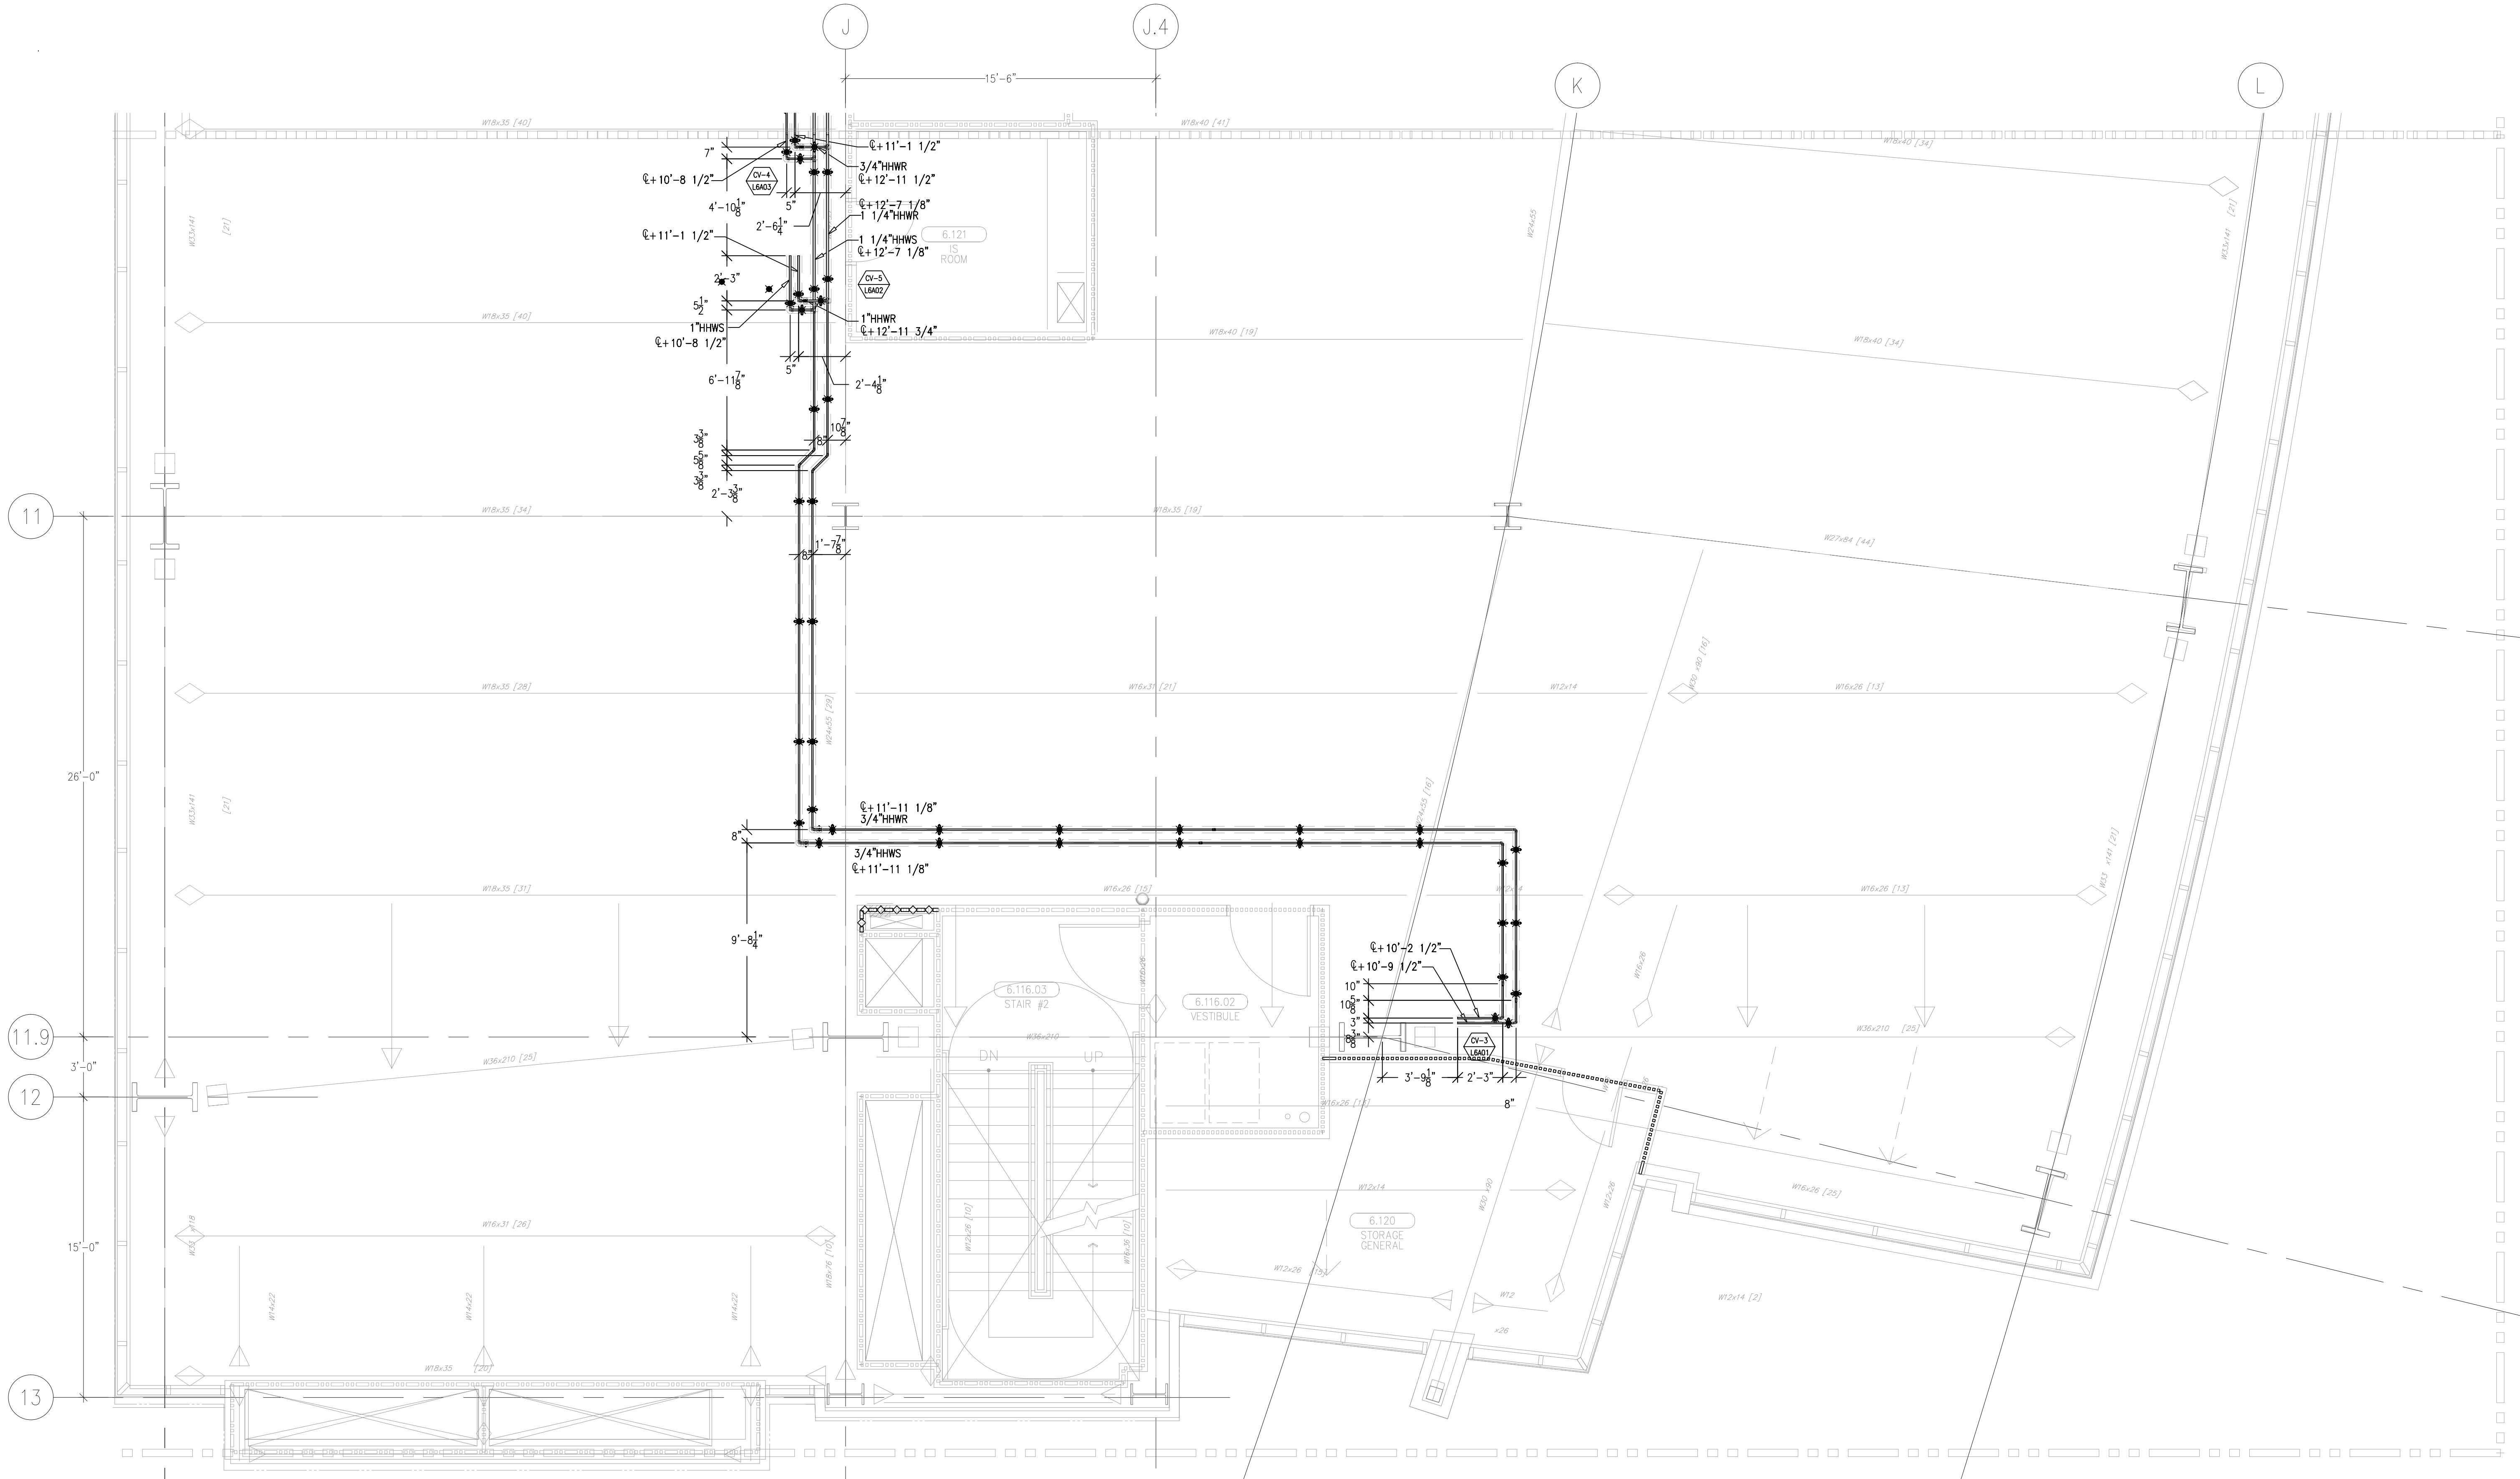

LEVEL 06 239.30' = 0'-0"
REFERENCE THIS SHEET

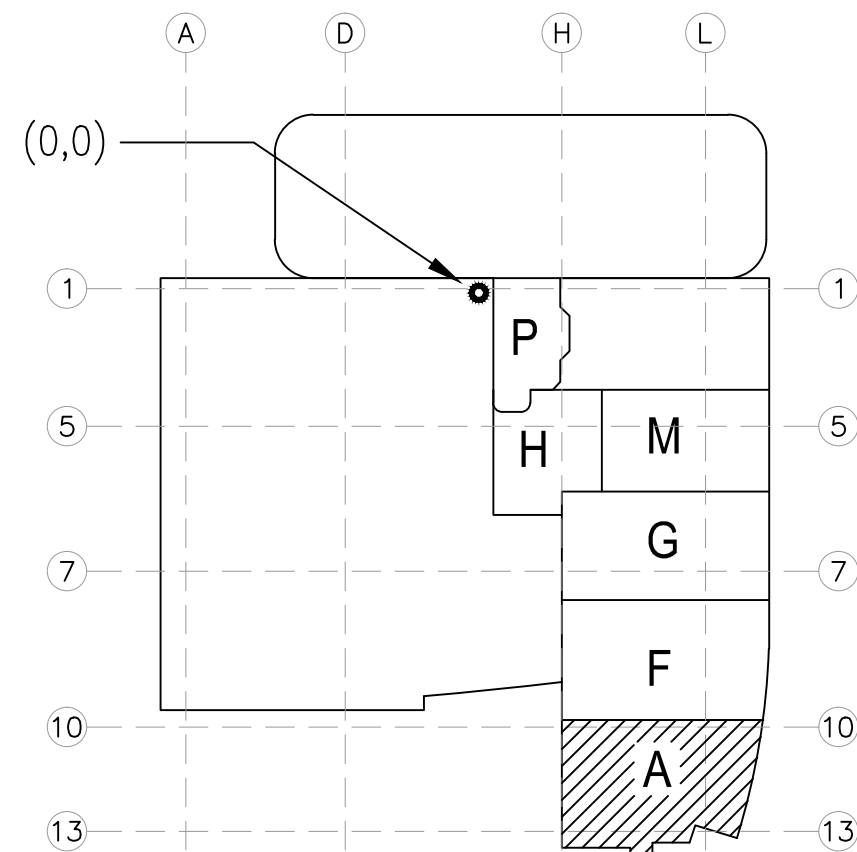

KEY PLAN

MCCARTHY APPROVAL	
A. Approved as noted for Architectural Review	<input type="checkbox"/>
B. Review and Assent	<input type="checkbox"/>
C. Rejected	<input type="checkbox"/>

This review is for general conformance with Plans and Specifications only. Any deviations from same not clearly noted by the Proprietor have not been reviewed. Reviewer shall not constitute a complete check of detailed dimensions or detail to serve to release the Proprietor of construction responsibility for any error or deviation from contract requirements.


McCarthy

By: _____ To: _____
SHP: DRAWING REFERENCE NO. _____


REVISIONS	BY
ISSUED FOR COORDINATION SDV-07T 04-07-10	JM

COORD.	SIGNATURE	DATE
MCCARTHY		
MECHANICAL DUCT		
MECHANICAL PIPE		
PLUMBING		
ELECTRICAL		
FIRE SPRINKLER		
PIPE		
DRYWALL/FRAMER		
REFRIGERATION		
STRUCTURAL		

R.F.I.	SENT	ANS.	R.F.I.	SENT	ANS.	R.F.I.	SENT	ANS.

**CHILDREN'S HOSPITAL
OF ORANGE COUNTY**
HOSPITAL
335 S. TULY
ORANGE, CA 92668-3874


TOWER II
MECHANICAL PIPE FLOOR PLAN - LEVEL 06 AREA A

**Murray Co.**
PAN-PACIFIC
PLUMBING & MECHANICAL
2919 E. VICTORIA STREET, RANCHO DOMINGUEZ, CA 90221
PH. 310 637-1500 FAX 310 604-0359


DRAWN	JM
CHECKED	M.M.
DATE	10/11/2011
SCALE	1/4" = 1'-0"
JOB NO.	09-006
DRAWING NUMBER	MP3.6A
REFERENCE DRAWING	A3.6A M3.6A
1 OF 1 SHEETS	

Day: FILED: 09-20-2010 09:00AM DRAWING: MCMC0004-PIPE/06-A3.6A.dwg Plotter: HP: User: 10-11-2011 10:02am

This document and the design it covers are the property of Murray Co. They are loaned only with the borrower's expressed written agreement that they will not be reproduced, copied, loaned, exhibited, or used in any other way, except by written consent from Murray Co. to the borrower.

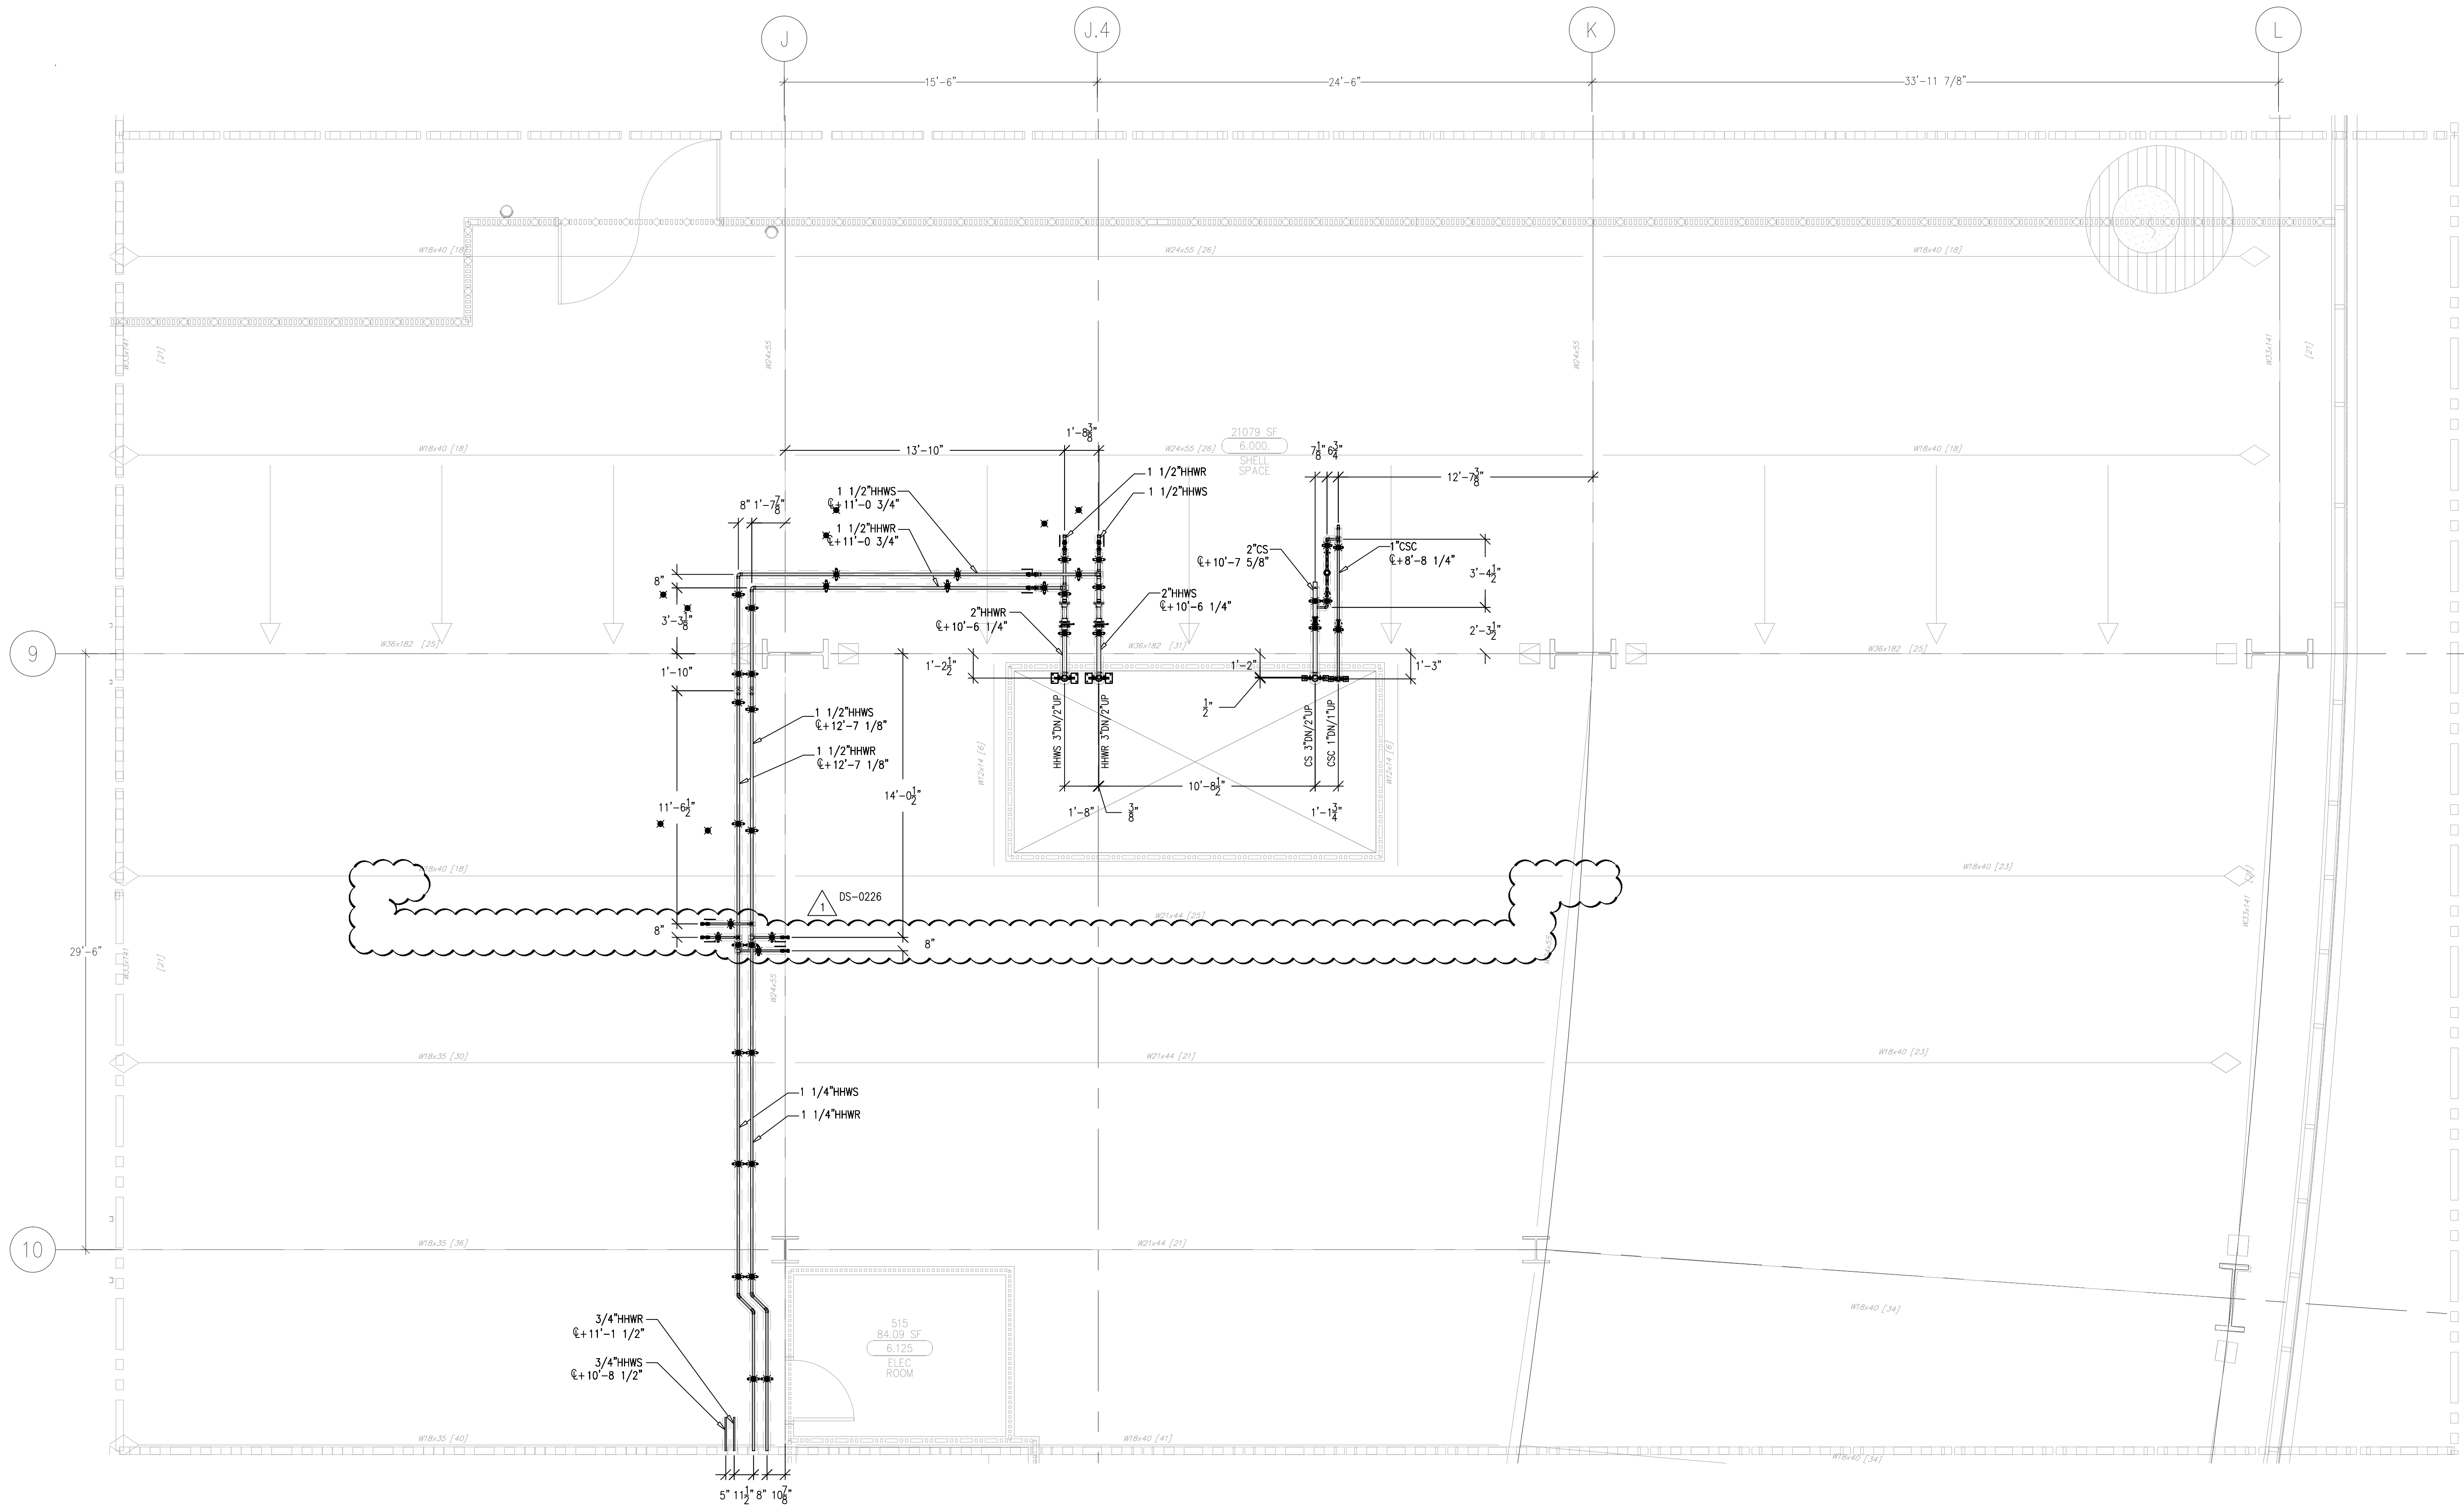

LEVEL 06 239.30' = 0'-0"
REFERENCE THIS SHEET

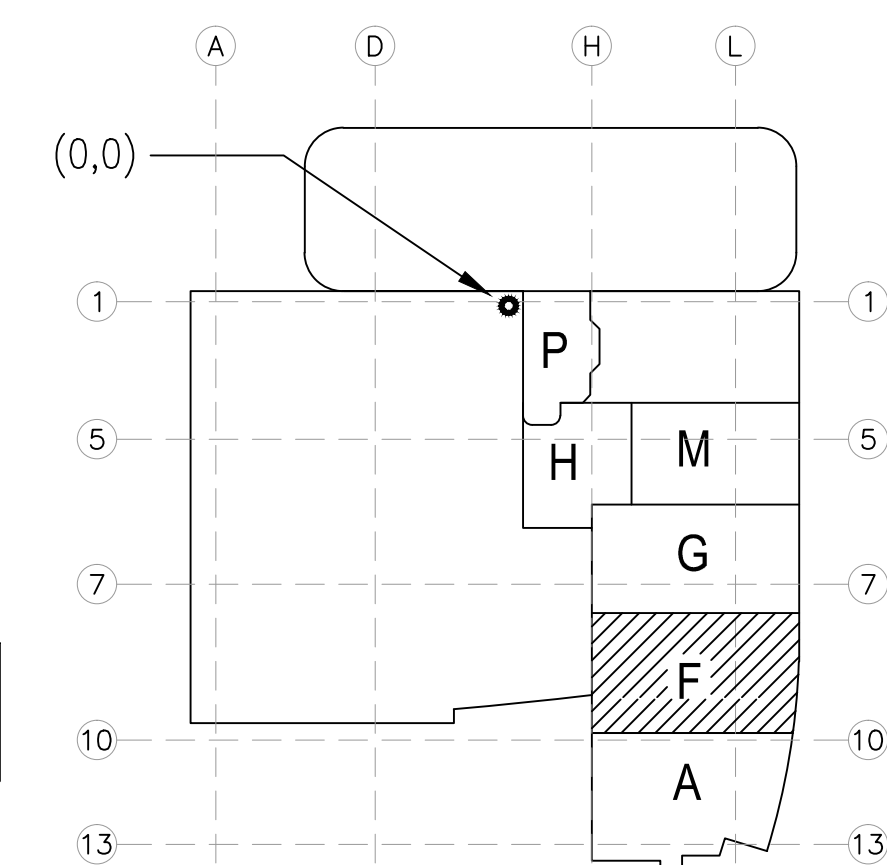

KEY PLAN

MCCARTHY APPROVAL	
A. Approved as noted for Architectural Review	<input type="checkbox"/>
B. Review and Rejected	<input type="checkbox"/>
C. Rejected	<input type="checkbox"/>

This review is for general conformance with Plans and Specifications only. Any deviations from same not clearly noted by the Proprietor have not been reviewed. Reviewer shall not constitute a complete check of detailed dimensions or detail to serve to release the Proprietor of construction responsibility for any error or deviation from contract requirements.


McCarthy

By: _____ Date: _____
SHEP DRAWING REFERENCE NO. _____


REVISIONS		BY
A	ISSUED FOR COORDINATION SIGN-OFF 04-07-10	JM
B	ISSUED FOR PRESSURE TUBE RE-COORDINATION SIGN OFF 04-28-10	JM
1	REVISED PER CORP 05-0026 05-25-11	MO

COORD.	SIGNATURE	DATE
MECHANICAL DUCT		
MECHANICAL PIPE		
PLUMBING		
ELECTRICAL		
FIRE SPRINKLER		
PIPE		
DRYAL/FRAMER		
REFRIGERATION		
STRUCTURAL		

R.F.I.	SENT	ANS.	R.F.I.	SENT	ANS.	R.F.I.	SENT	ANS.

**CHILDREN'S HOSPITAL
OF ORANGE COUNTY**
HOSPITAL
455 S. MAIN ST.
ORANGE, CA 92668-3874



TOWER II
MECHANICAL PIPE FLOOR PLAN - LEVEL 06 AREA F

**Murray Company**
PLUMBING & MECHANICAL
2919 E. VICTORIA STREET, RANCHO DOMINGUEZ, CA 90221
PH. 310 637-1500 FAX 310 604-0359

DRAWN J.M.
CHECKED M.M.
DATE 10/11/2011
SCALE 1/4" = 1'-0"
JOB NO. 09-006
DRAWING NUMBER MP3.6F
REFERENCE DRAWING A3.6F M3.6F
1 OF 1 SHEETS

Day: P:\2\09-006\09-006\MCCARTHY\MECHANICAL\PIPE\06-06\06-06.dwg Plotter: HP DesignJet 1100 10/11/2011 10:00am

8

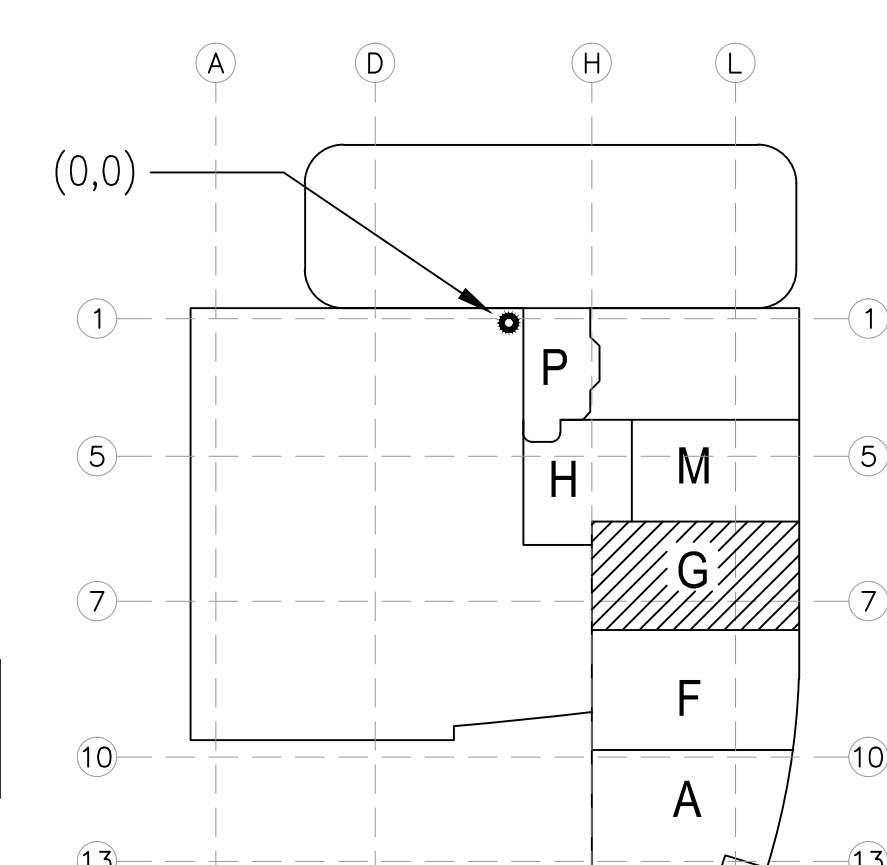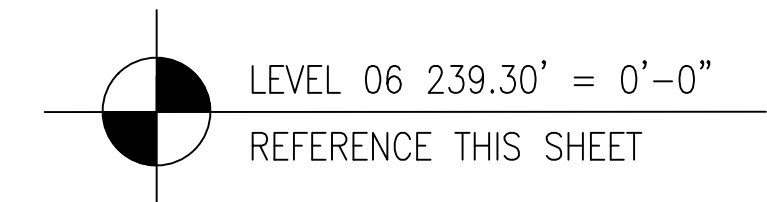

A1 KEY PLAN

Dwg File: \\09-006_CHOC\MURRAY_DRAWINGS\MECHANICAL-PIPE\L11-6\MP3.60.dwg Plotted by: User 10-11-2011 10:44am

DRAWN	J.M.
CHECKED	
M.M.	
DATE	10/11/2011
SCALE	1/4" = 1'-0"
JOB NO.	09-006
DRAWING NUMBER	MP3.6G
REFERENCE DRAWING	A3.6G M3.6G
1 OF 1 SHEETS	

Architectural floor plan of a building section, showing various rooms, elevators, and structural elements. The plan includes a grid system with letters G, G.2, and H across the top, and numbers 4, 4.1, 5, 5.1, 6, 6.4, and 7 along the left side. Key areas include a 'SHAF' (shaft), 'STORAGE GENERAL' (184 SF), 'PATIENT/STAFF ELEVATOR LOBBY' (438 SF), and several 'ELEV.' (elevator) rooms. Structural elements like columns (e.g., W18x42, W16x55) and beams (e.g., W24x55, W24x55) are indicated. The plan also shows a 'PUBLIC ELEVATOR' and a 'STAFF PAT. ELEV.'


MCCARTHY APPROVAL

A. Approved as noted for Architectural Review ☐
 B. Review and Resubmit ☐
 C. Rejected ☐

This review is for general conformance with Plans and Specifications only. Any deviations from same not clearly noted by the Reviewer have not been reviewed. Reviewer shall not constitute a complete check of detailed dimensions or count to serve to release the Designer of contractual responsibility for any error or deviation from contract requirements.

McCarthy

By _____ Date _____
 SHEP DRAWING REFERENCE NO. _____

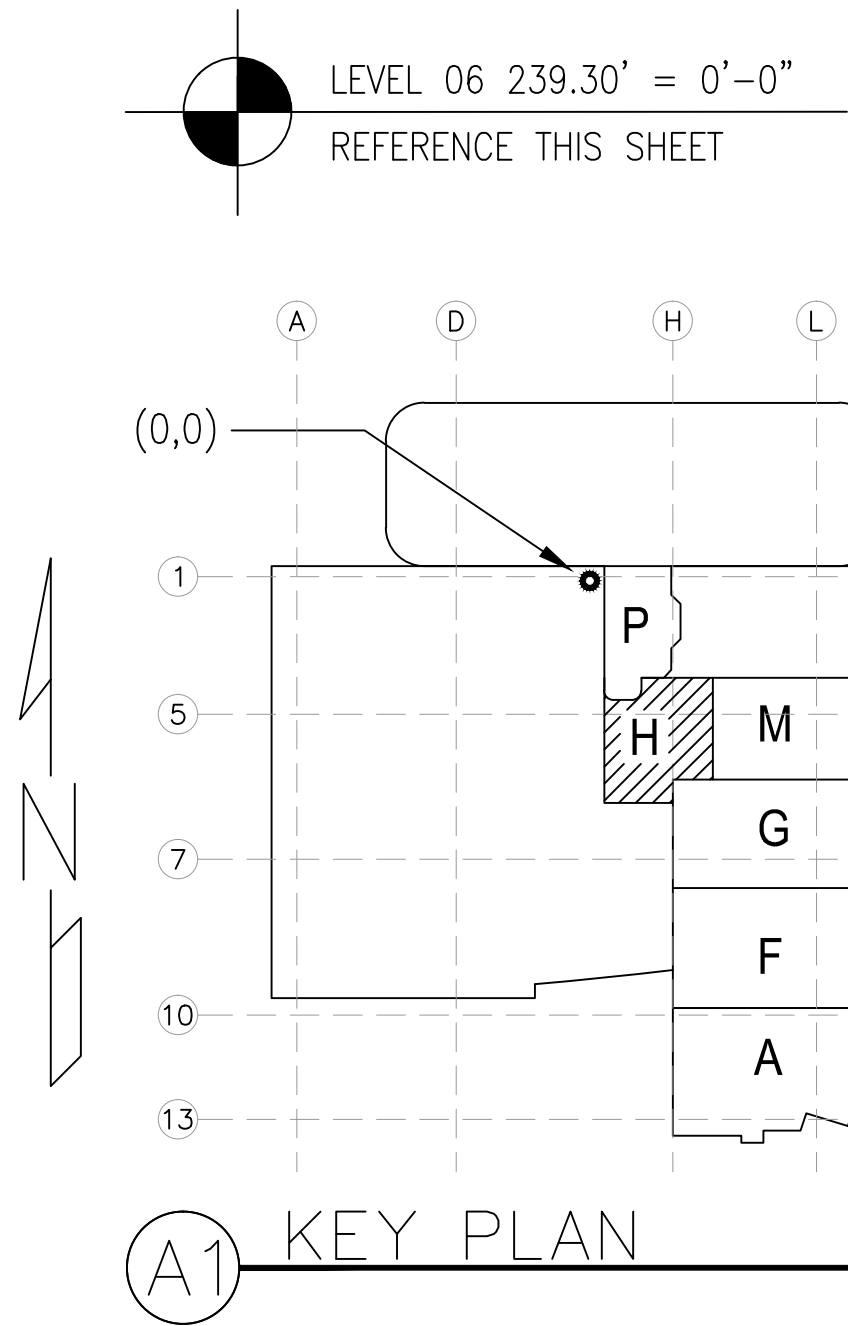

<h2 style="margin: 0;">MCCARTHY APPROVAL</h2>	
A. Approved as noted for Architectural Review	<input type="checkbox"/>
B. Review and Re-submit	<input type="checkbox"/>
C. Rejected	<input type="checkbox"/>

This review is for general conformance with Plans and Specifications only. Any deviations from same not clearly noted by the Preparer have not been reviewed. Reviewer shall not constitute a complete check of detailed dimensions or count to serve to relieve the Preparer of contractual responsibility for any error or deviation from contract requirements.

McCarthy


By _____ Date _____

SHOP DRAWING REFERENCE NO. _____


Day: Fact: 09-006-000C-MURRAY DOWNINGS MECHANICAL-PPE(LUT-e)M3.6H.dwg

DRAWN	J.M.
CHECKED	
M.M.	
DATE	10/11/2011
SCALE	1/4"=1'-0"
JOB NO.	09-006
DRAWING NUMBER	MP3.6H
REFERENCE DRAWING	A3.6H M3.6H
1	OF 1 SHEETS

This document and the design it covers are the property of Murray Co. They are loaned only with the borrower's expressed written agreement that they will not be reproduced, copied, loaned, exhibited, or used in any other way, except by written consent from Murray Co. to the borrower.

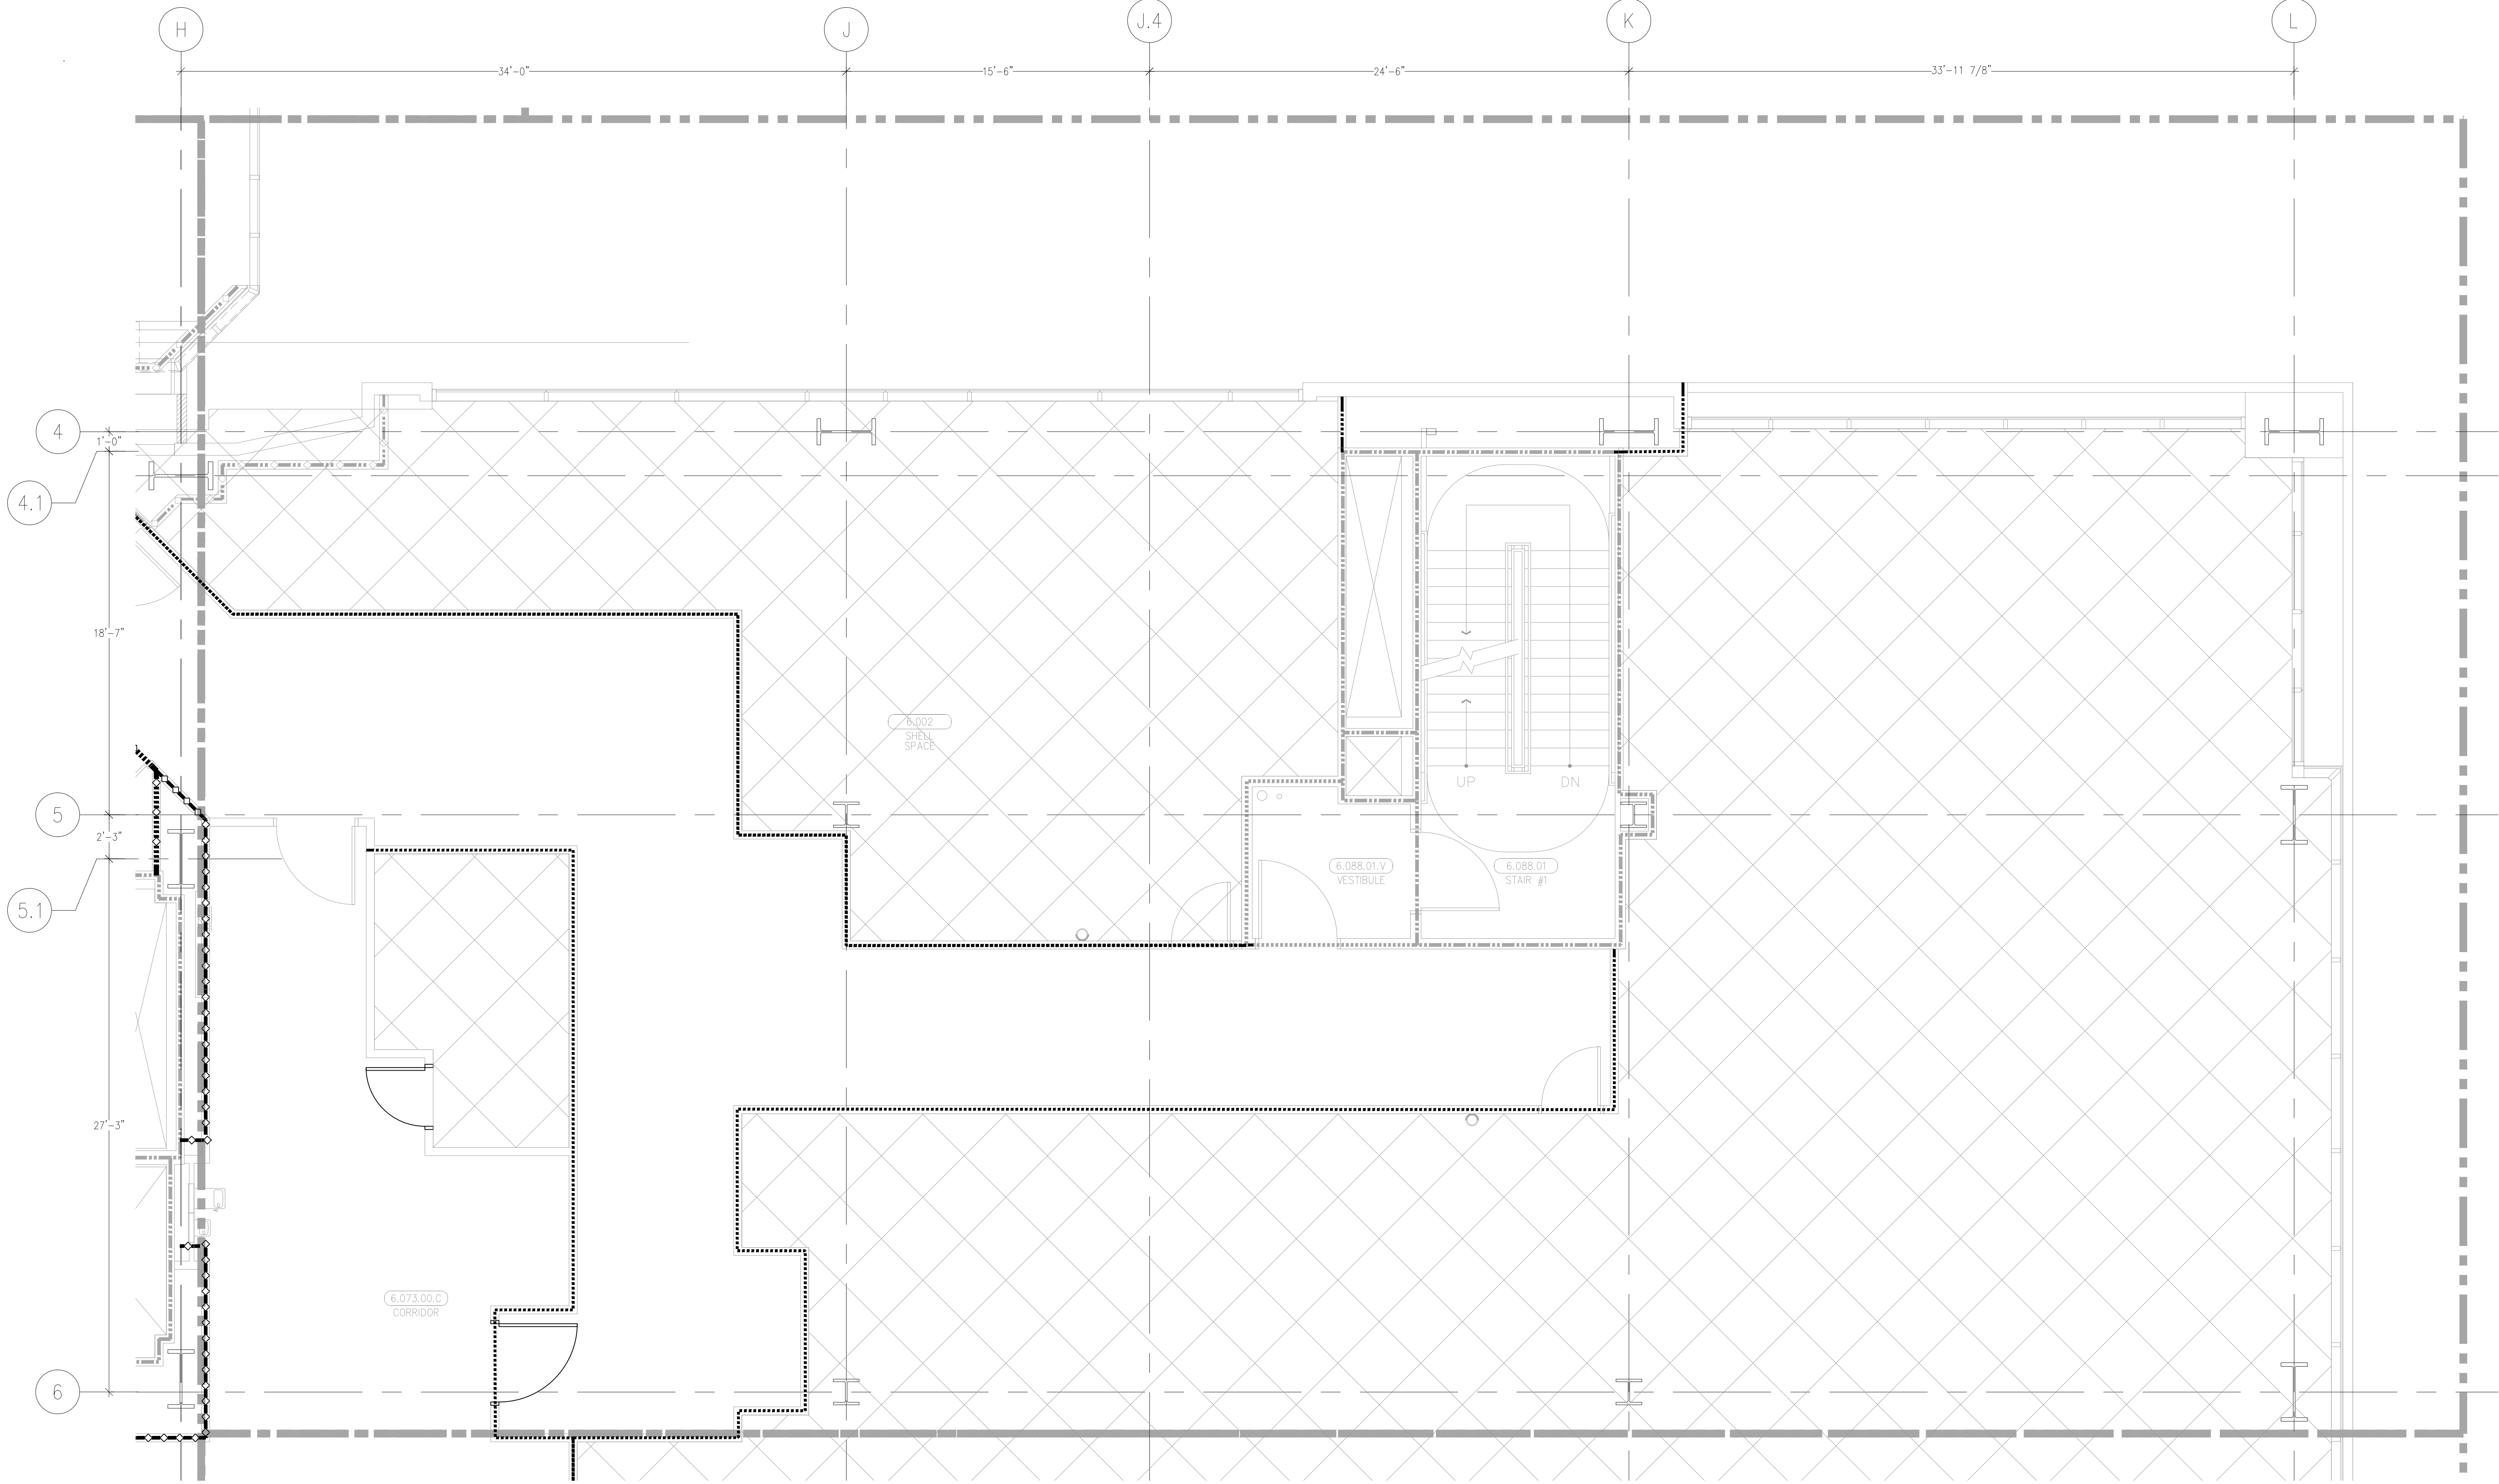

LEVEL 06 239.30' = 0'-0"
REFERENCE THIS SHEET

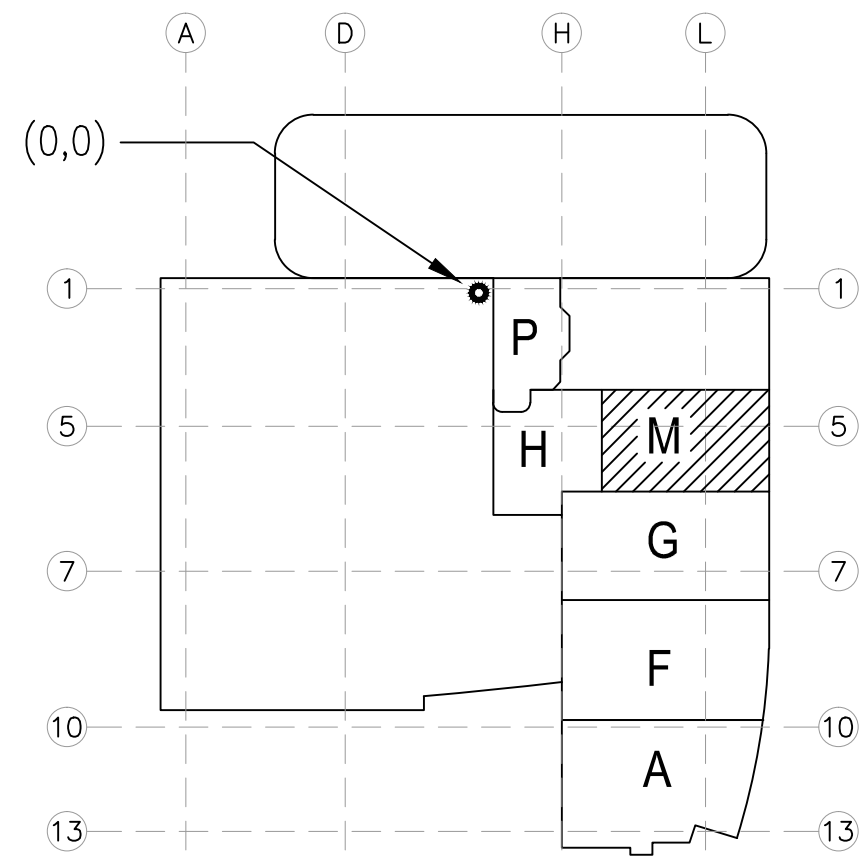

A1 KEY PLAN

REVISIONS	BY

COORD.	SIGNATURE	DATE
KASPER PERMANENTE		
FEDERAL CONTRACTOR		
MECHANICAL DUCT		
MECHANICAL PIPE		
PLUMBING		
ELECTRICAL		
SPRINKLER		
P-TUBE		
DRY WALL/FRAMER		
REFRIGERATION		

R.F.I.	SENT	ANS.	R.F.I.	SENT	ANS.	R.F.I.	SENT	ANS.	R.F.I.	SENT	ANS.

CHILDREN'S HOSPITAL
CHOC OF ORANGE COUNTY
HOSPITAL
405 S. GATE AVE., CA 92668-3874
TOWER II
PLUMBING FLOOR PLAN - LEVEL 06 AREA-M

PAN-PACIFIC
PLUMBING & MECHANICAL
Murray Company
2919 E. VICTORIA STREET, RANCHO DOMINGUEZ, CA 90221
PH. 310 637-1500 FAX 310 604-0359

DRAWN
R.O.
CHECKED
M.M.
DATE
10/11/2011
SCALE
1/4" = 1'-0"
JOB NO.
09-006
DRAWING NUMBER
MP3.6M
REFERENCE DRAWING
A3.6M
P3.6M
1 OF 1 SHEETS