



This document and the design it covers are the property of Murray Co. They are loaned only with the borrower's expressed written agreement that they will not be reproduced, copied, loaned, exhibited, or used in any other way, except by written consent from Murray Co. to the borrower.

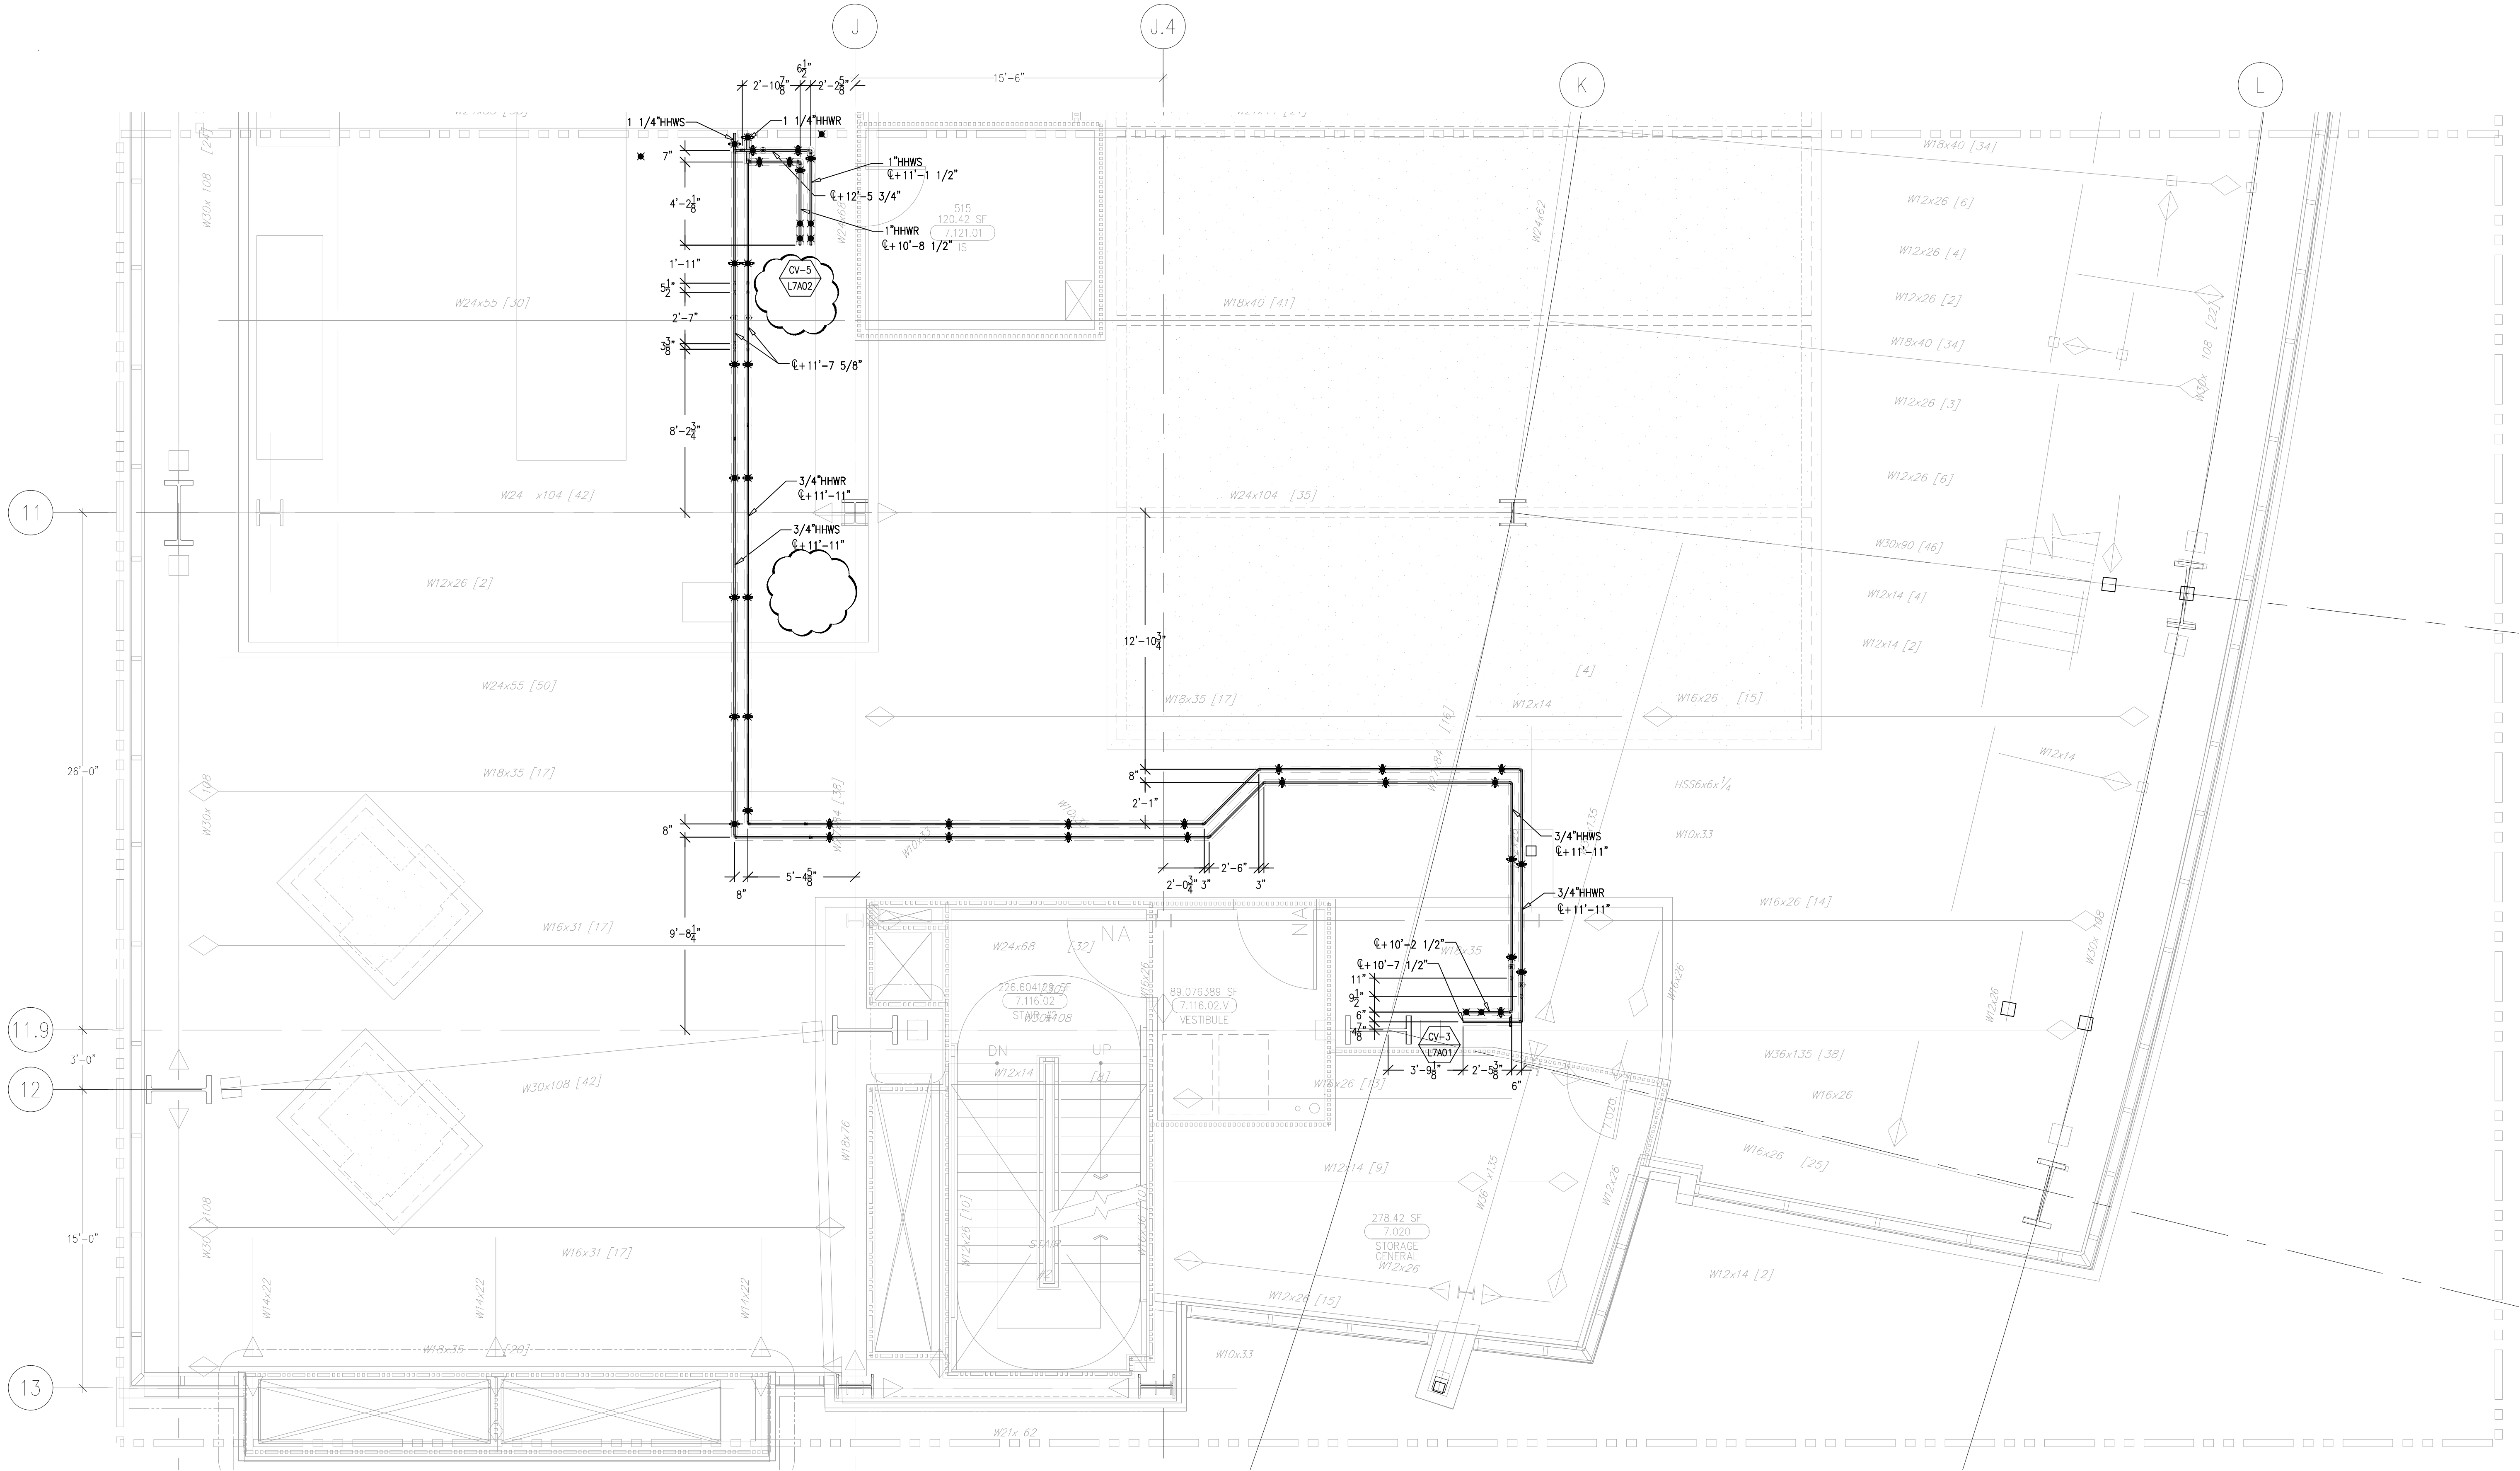

LEVEL 07 254.30' = 0'-0"
REFERENCE THIS SHEET

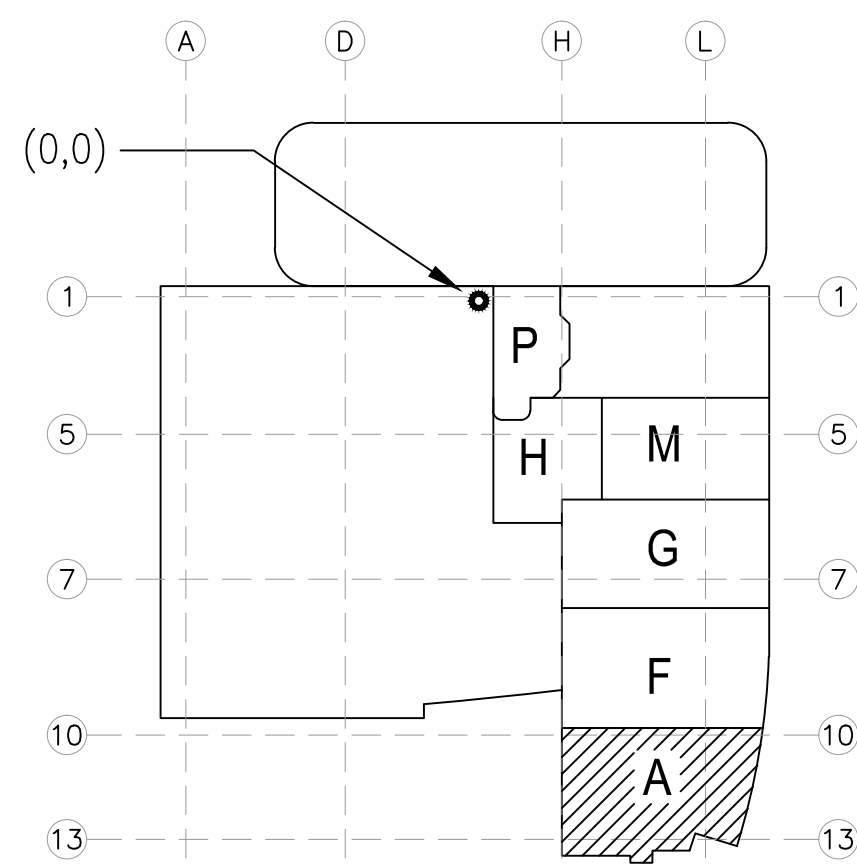

MCCARTHY APPROVAL	
A. Approved as noted for Architectural Review	<input type="checkbox"/>
B. Review and Rejected	<input type="checkbox"/>
C. Rejected	<input type="checkbox"/>
This review is for general conformance with Plans and Specifications only. Any deviations from same not clearly noted by the Proprietor have not been reviewed. Reviewer shall not constitute a complete check of detailed dimensions or detail to serve to release the Proprietor of construction responsibility for any error or deviation from contract requirements.	
McCarthy	
By _____	To _____
SHEP. DRAWING REFERENCE NO.	

REVISIONS		BY
A	ISSUED FOR COORDINATION SIGN-OFF 04-09-10	JM
B	ISSUED FOR PRESSURE TUBE RE-COORDINATION SIGN OFF 4-23-10	JM

COORD.	SIGNATURE	DATE
MCCARTHY		
MECHANICAL		
PLUMBING		
ELECTRICAL		
FIRE SPRINKLER		
PIPE		
DRYAL FRAMER		
REFRIGERATION		
STRUCTURAL		

ANS.	SENT	REF.	ANS.	SENT	REF.	ANS.	SENT	REF.

**CHILDREN'S HOSPITAL
OF ORANGE COUNTY**
HOSPITAL
455 S. Tustin Ave.
Orange, CA 92668-3874

TOWER II
MECHANICAL PIPE FLOOR PLAN - LEVEL 07 AREA-A


**PAN-PACIFIC
PLUMBING & MECHANICAL**

Murray Co.
2919 E. VICTORIA STREET, RANCHO DOMINGUEZ, CA 90221
PH. 310 637-1500 FAX 310 604-0359

DRAWN
J.M.
CHECKED
M.M.
DATE
10/11/2011
SCALE
1/4" = 1'-0"
JOB NO.
09-006
DRAWING NUMBER
MP3.7A
REFERENCE DRAWING
A3.7A
M3.7A
1 OF 1 SHEETS

Day: FILED: 09-08-2010 09:00 AM DRAWING: MCH004-PIPE/07-A3.7A.dwg Plotter: HP: 10-11-2011 10:00 am

DRAWING
 J.M.
 CHECKED
 M.M.
 DATE
 10/11/2011
 SCALE
 $1/4" = 1'-0"$
 JOB NO.
 09-006
 DRAWING NUMBER
 MP3.7F
 REFERENCE DRAWING
 A3.7F
 MP3.7F
 1 OF 1 SHEETS

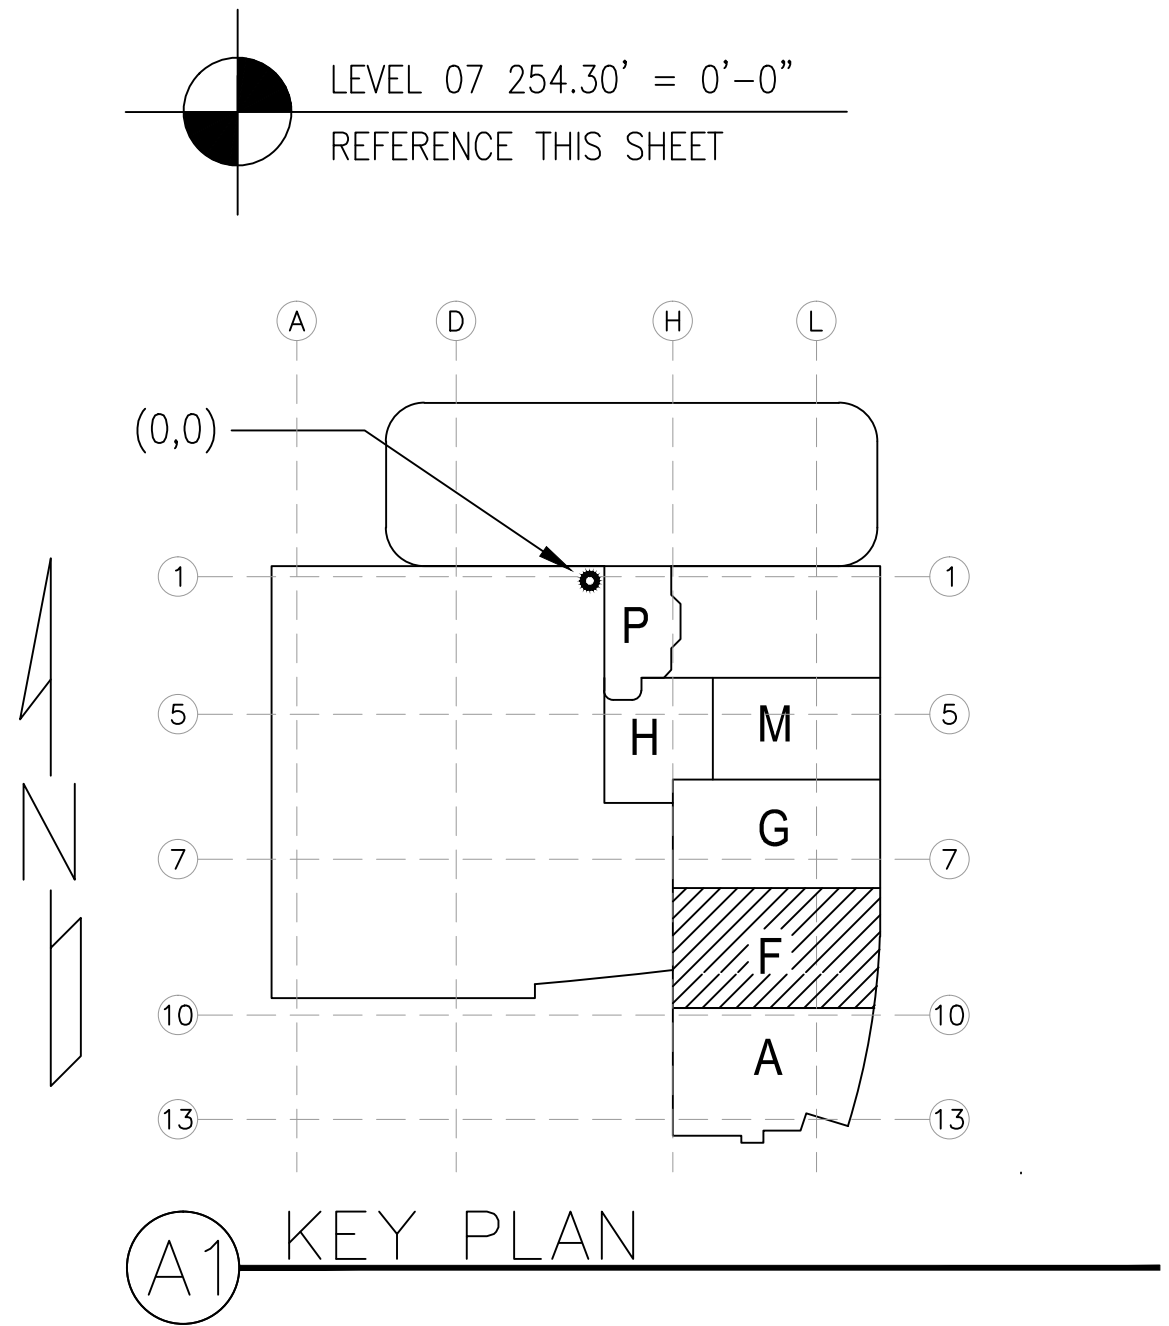

<h1 style="margin: 0;">MCCARTHY APPROVAL</h1>	
A. Approved as noted for Architectural Review	<input type="checkbox"/>
B. Review and Resubmit	<input type="checkbox"/>
C. Rejected	<input type="checkbox"/>




This review is for general conformance with Plans and Specifications only. Any deviations from same not clearly noted by the Preparer have not been reviewed. Review shall not constitute a complete check of detailed dimensions or count to serve to relieve the Preparer of contractual responsibility for any error or deviation from contract requirements.

McCarthy

By _____
Date _____

SHOP DRAWING REFERENCE NO.

This document and the design it covers are the property of Murray Co. They are loaned only with the borrowers' expressed written agreement that they will not be reproduced, copied, loaned, exhibited, or used in any other way, except by written consent from Murray Co. to the borrower.

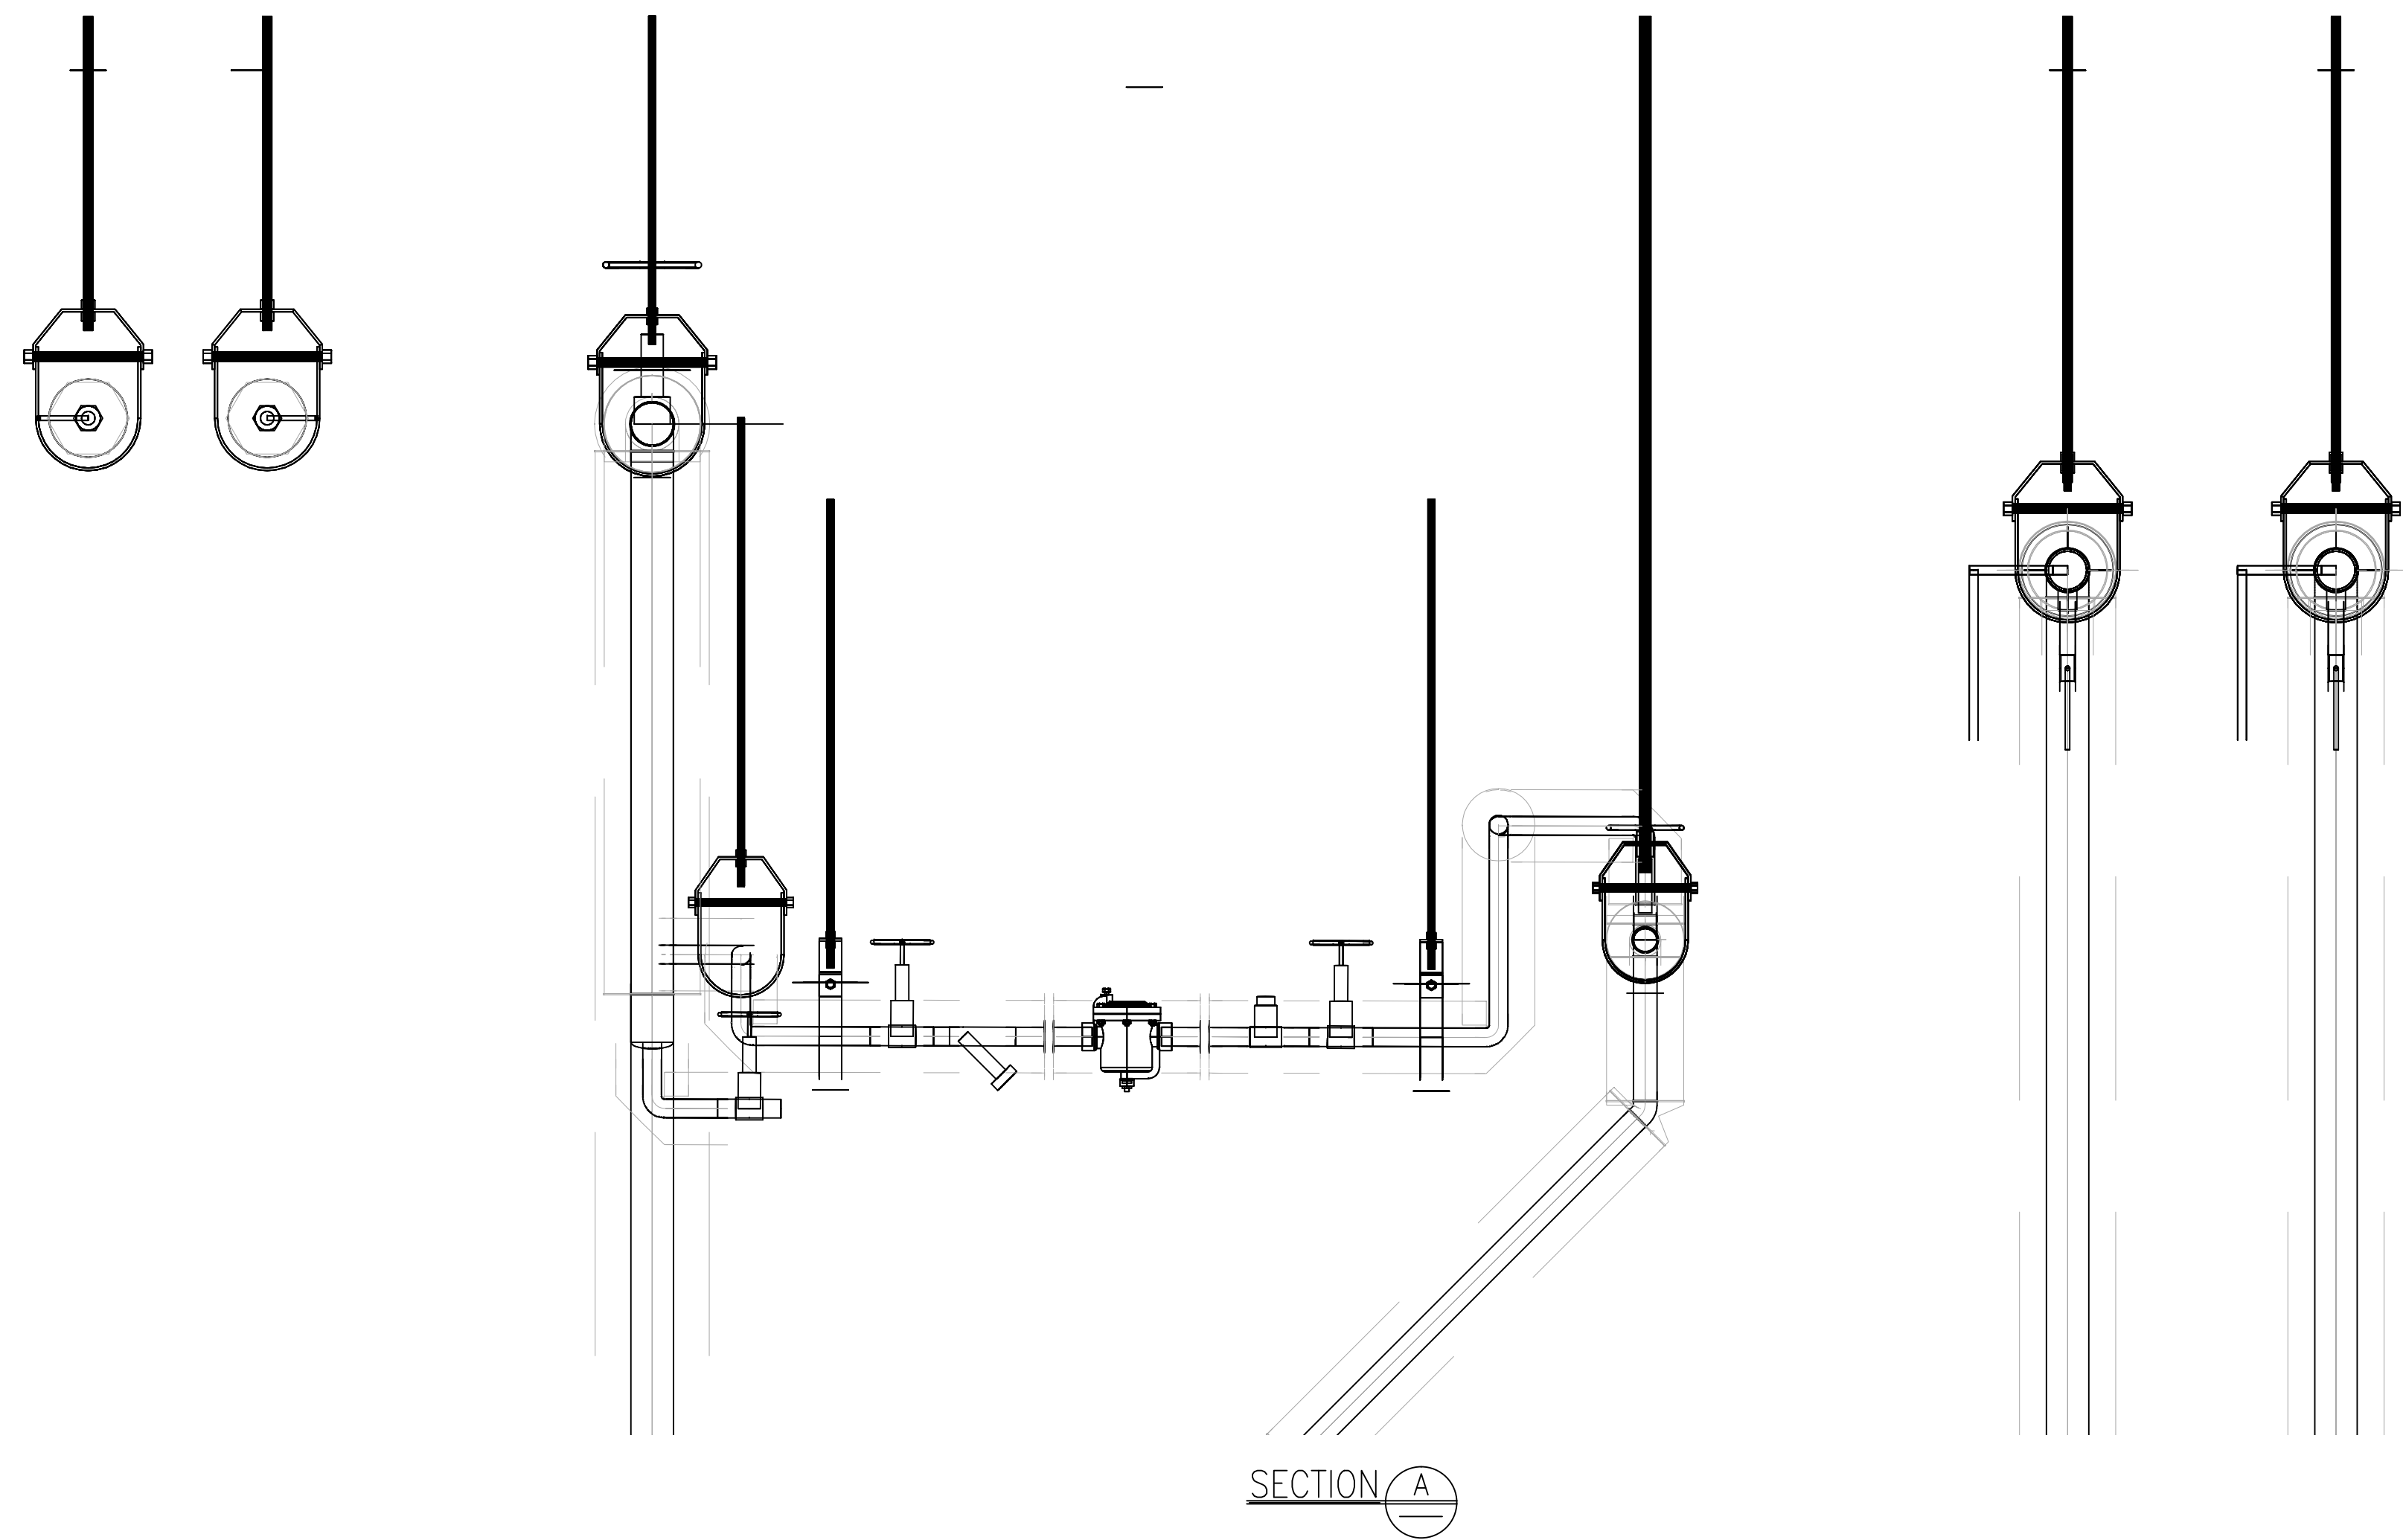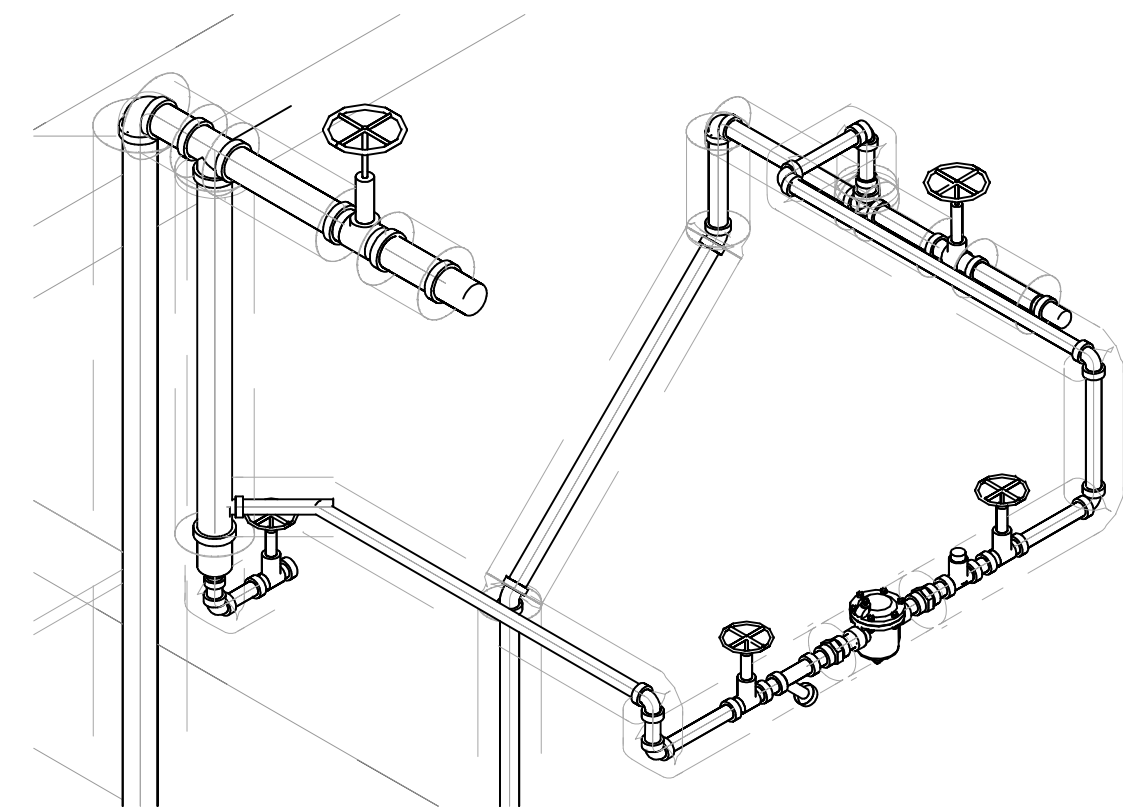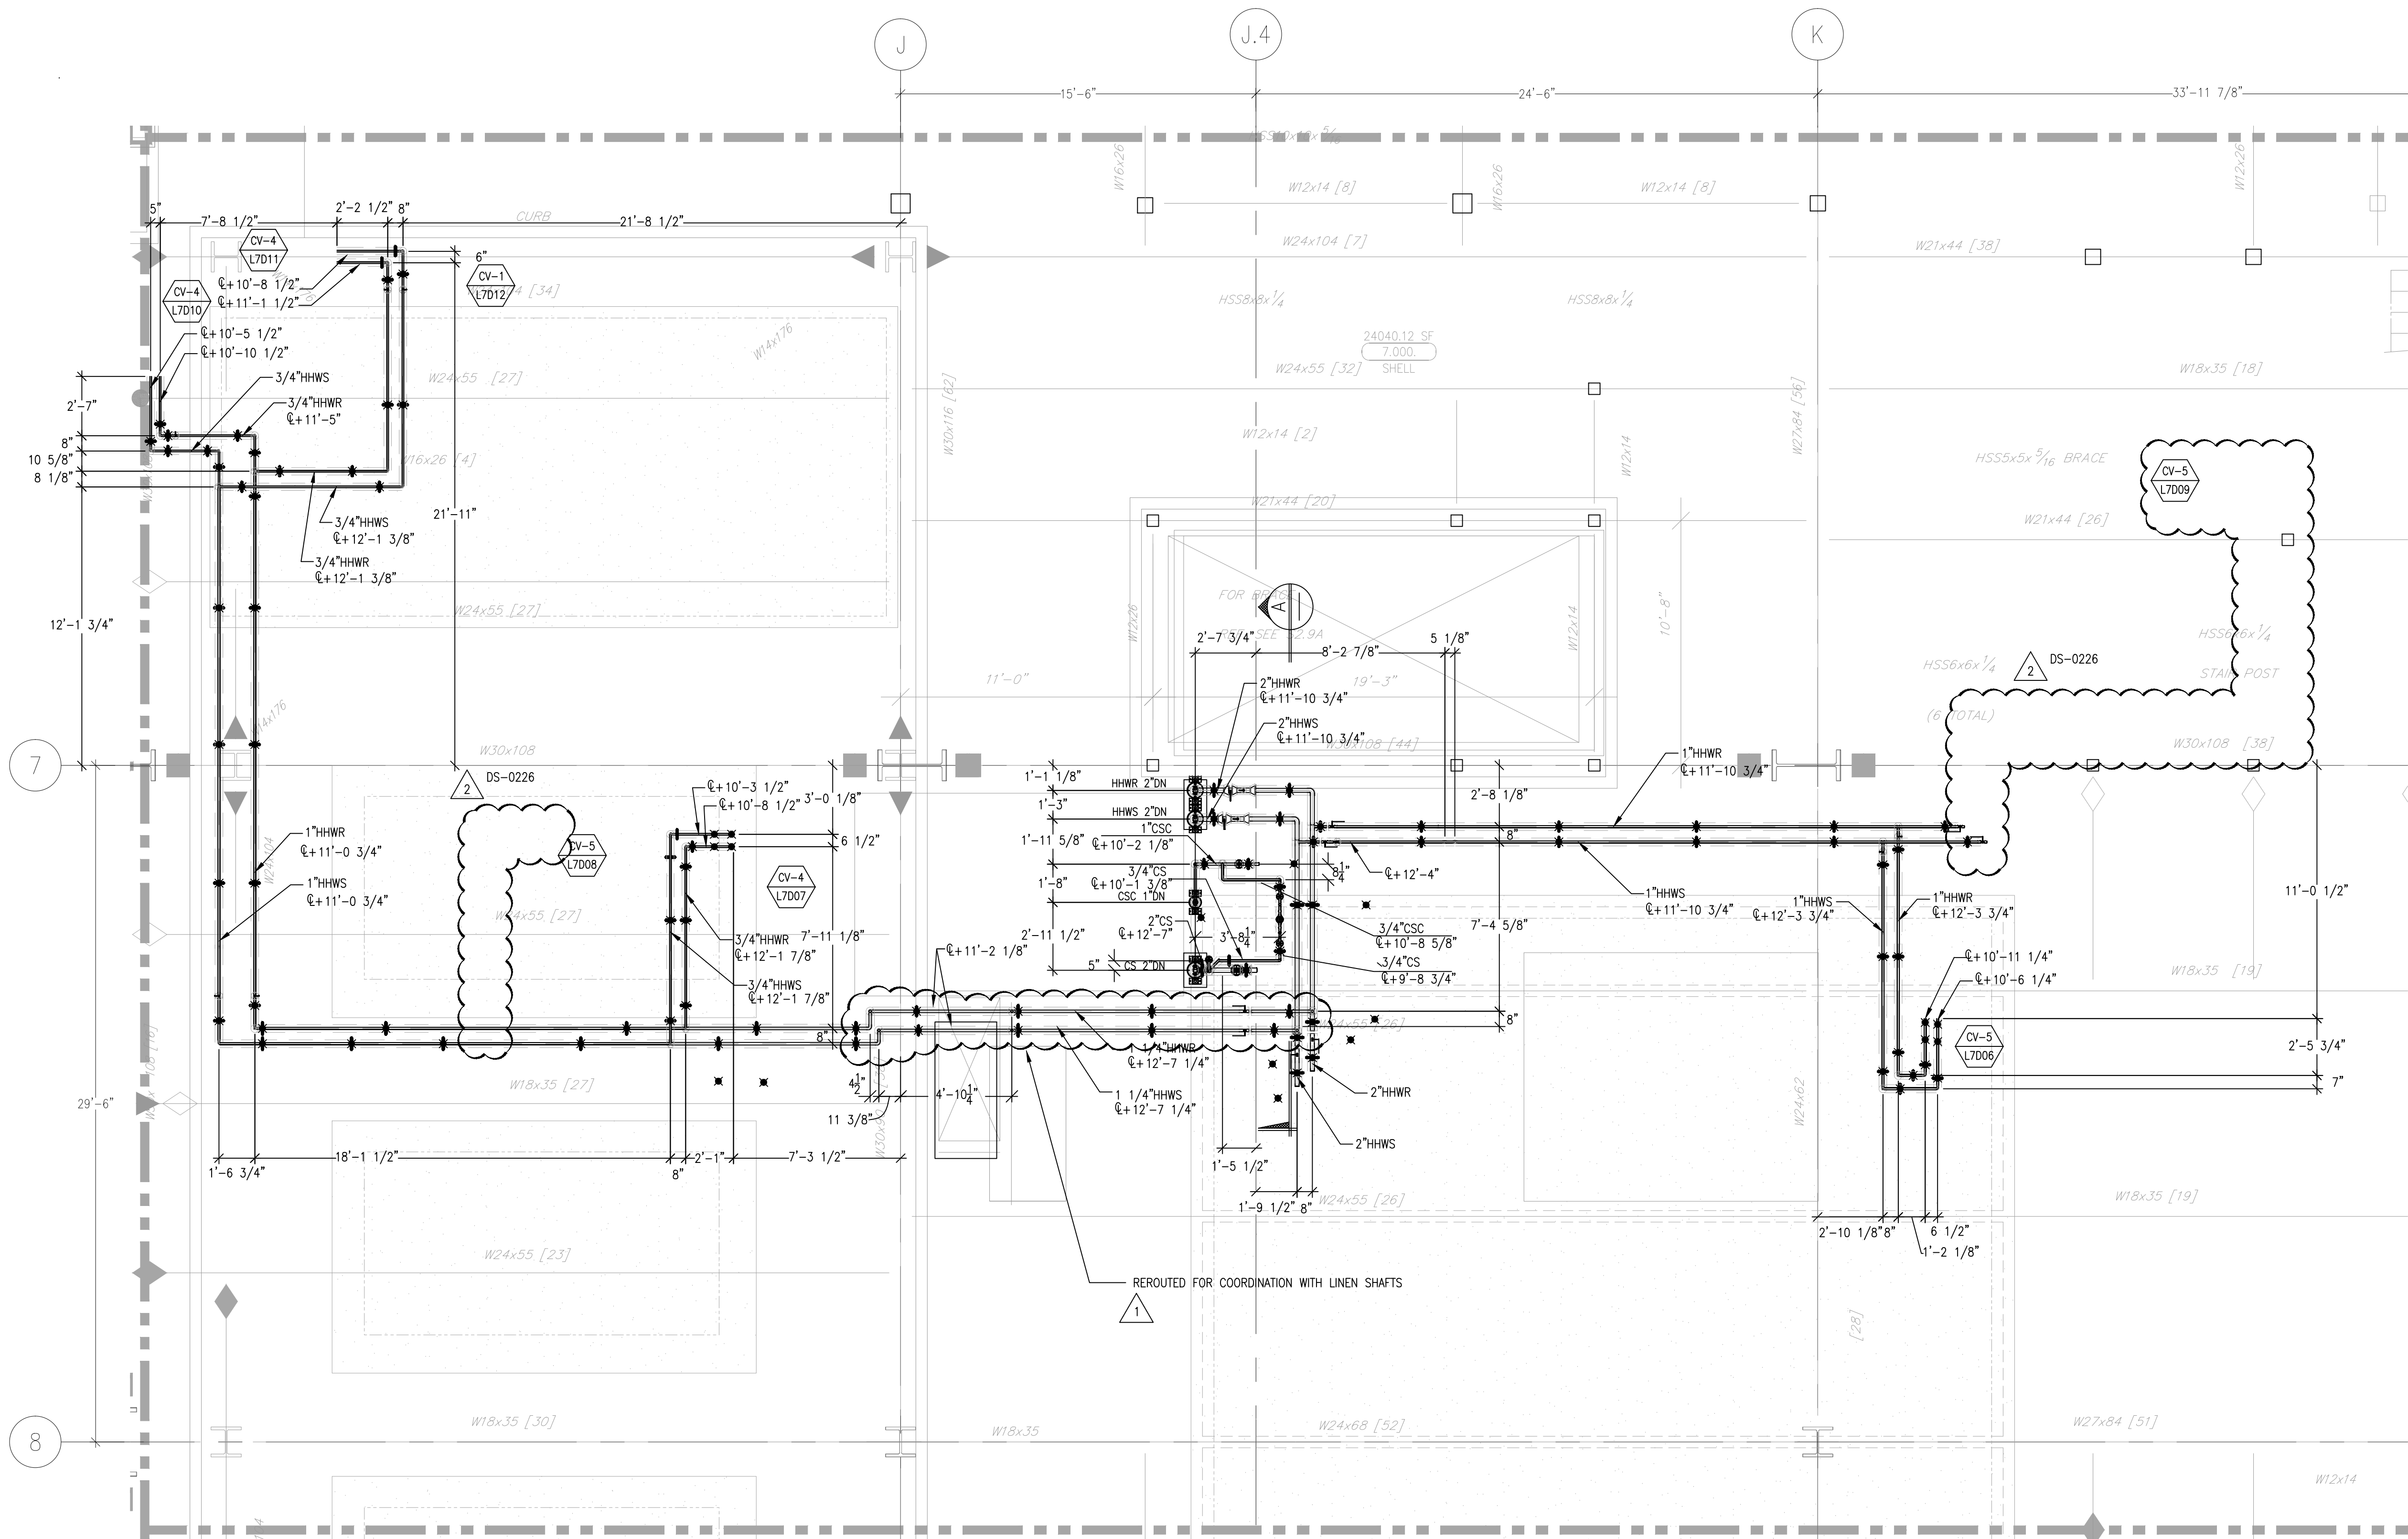

2

<h1 style="margin: 0;">MCCARTHY APPROVAL</h1>	
A. Approved as noted for Architectural Review	<input type="checkbox"/>
B. Revised and Resubmit	<input type="checkbox"/>
C. Rejected	<input type="checkbox"/>


This review is for general conformance with Plans and Specifications only. Any deviations from same not clearly noted by the Preparer have not been reviewed. Reviewer shall not constitute a complete check of detailed dimensions or count to serve to relieve the Preparer of contractual responsibility for any error or deviation from contract requirements.

McCarthy

By _____

Date _____

SHOP DRAWING REFERENCE NO. _____

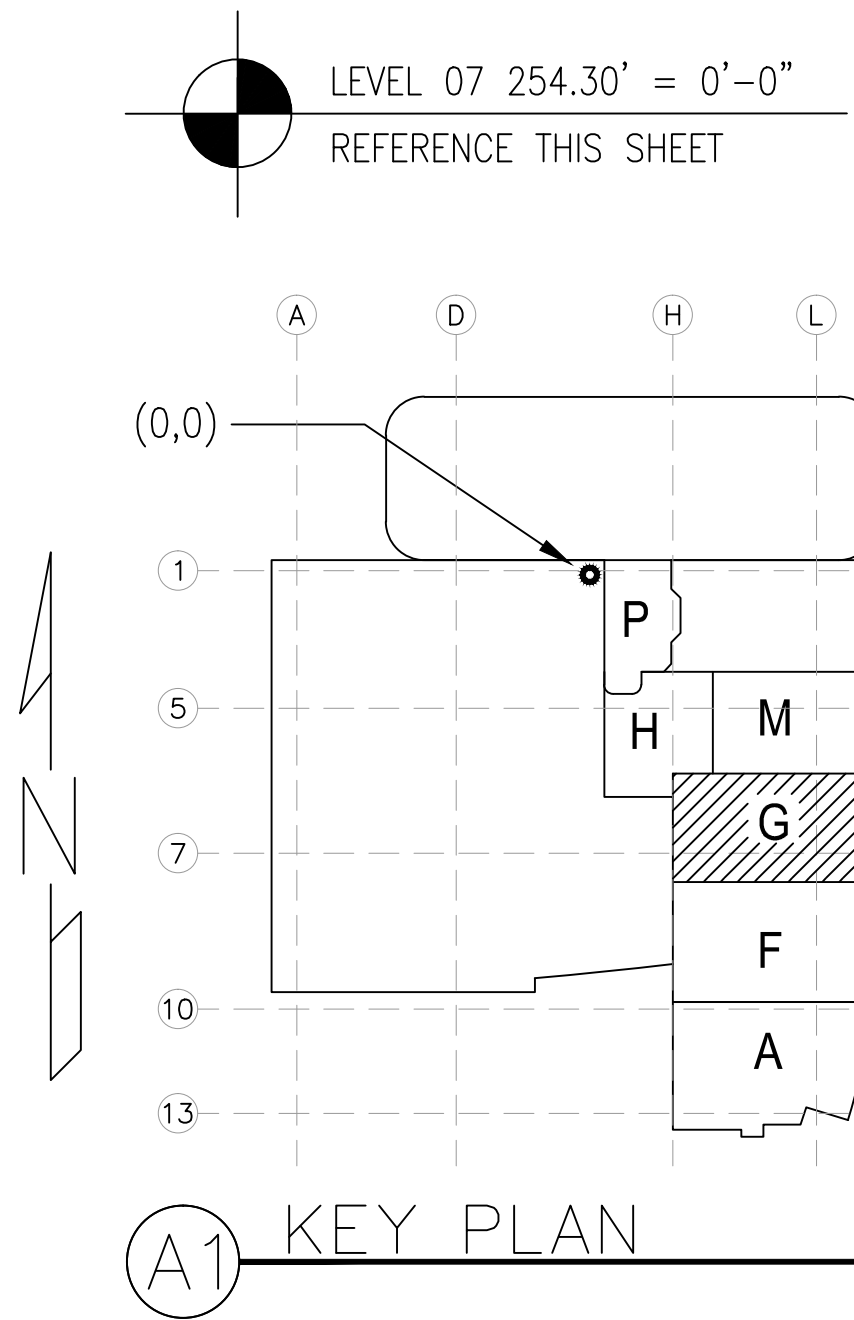

	REVISIONS	BY
A	ISSUED FOR COORDINATION SIGN-OFF 04-09-10	JM
B	ISSUED FOR PRESSURE TUBE RE-COORDINATION SIGN OFF 4-23-10	JM
1	ISSUED PER RFI 2314 SMART LINEN INTRFS.	TC
2	REVISED PER C0499 DS-0026 2-2-11	MO

COORD.	SIGNATURE	DATE
McCarthy		
MECHANICAL DUCT		
MECHANICAL PIPE		
PLUMBING		
ELECTRICAL		
FIRE SPRINKLER		
PIPE		
DRYWALL/FRAMER		
REFRIGERATION		
STRUCTURAL		

[illegible]

**CHILDREN'S HOSPITAL
OF ORANGE COUNTY**
455 S. Main St.
Orange, CA 92668-3874
TOWER II

MECHANICAL PIPE FLOOR PLAN - LEVEL 07 AREA-G

PAN-PACIFIC
PLUMBING & MECHANICAL


PMI

Murray Company

2919 E. VICTORIA STREET, RANCHO DOMINGUEZ, CA 90221
PH. 310 637-1500 FAX. 310 604-0359


DRAWN J.M.
CHECKED M.M.
DATE 10/11/2011
SCALE 1/4"=1'-0"
JOB NO. 09-006
DRAWING NUMBER MP3.7G
REFERENCE DRAWING A3.7G M3.7G
1 OF 1 SHEETS

This document and the design it covers are the property of Murray Co. They are loaned only with the borrower's expressed written agreement that they will not be reproduced, copied, loaned, exhibited, or used in any other way, except by written consent from Murray Co. to the borrower.

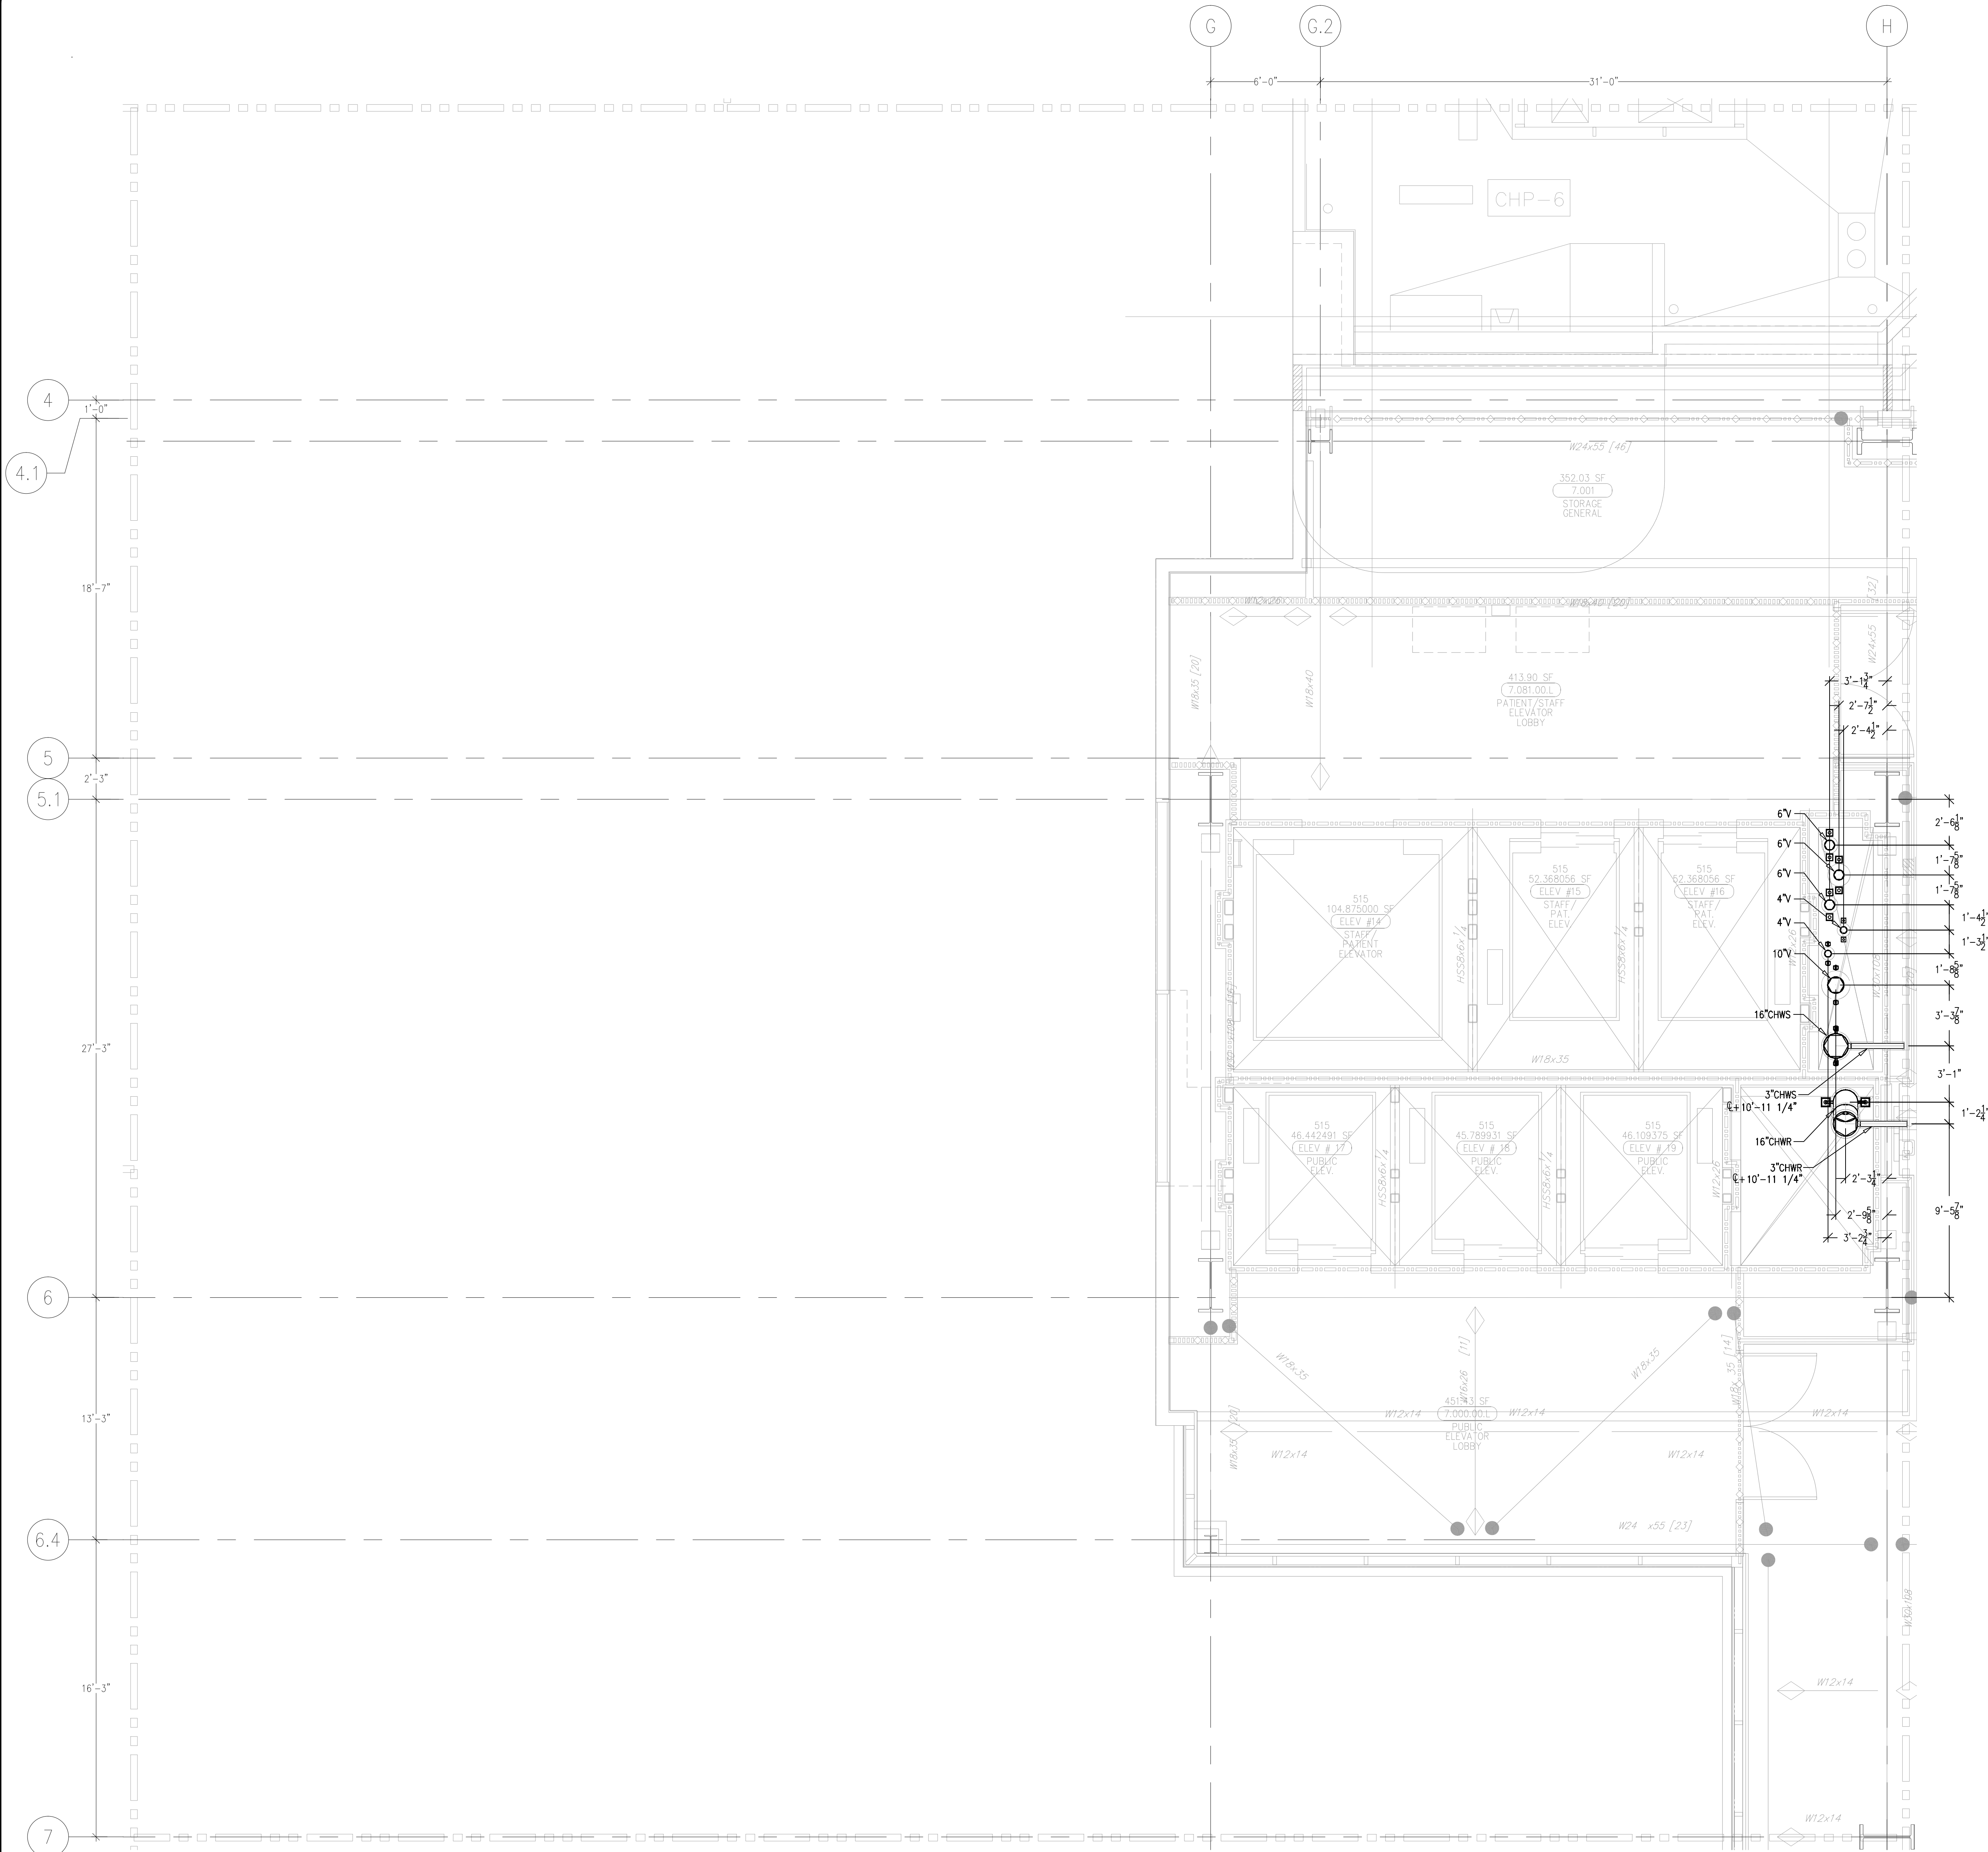

MCCARTHY APPROVAL	
A. Approved as noted for Architectural Review	<input type="checkbox"/>
B. Review and Assent	<input type="checkbox"/>
C. Rejected	<input type="checkbox"/>
This review is for general conformance with Plans and Specifications only. Any deviations from same not clearly noted by the Proprietor have not been reviewed. Reviewer shall not constitute a complete check of detailed dimensions or details to serve to release the Proprietor of construction responsibility for any error or deviation from contract requirements.	
McCarthy	
By _____	To _____
SHEET DRAWING REFERENCE NO.	


LEVEL 07 254.30' = 0'-0"
REFERENCE THIS SHEET

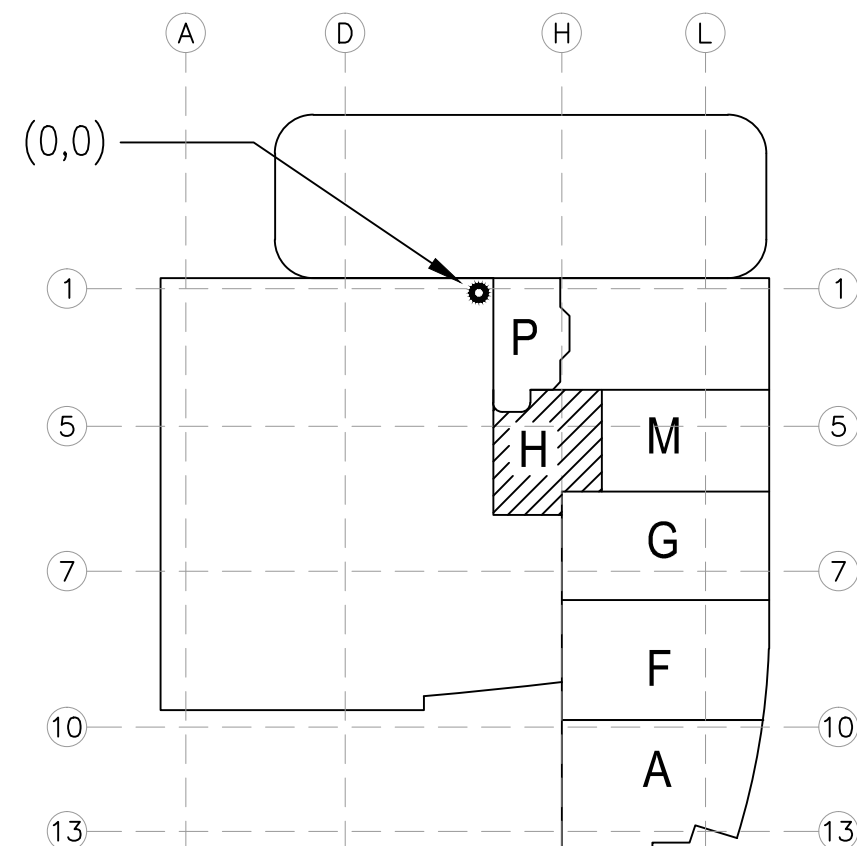

REVISIONS		BY
A	ISSUED FOR COORDINATION SIGN-OFF 04-09-10	JM
B	ISSUED FOR PRESSURE TUBE RE-COORDINATION SIGN OFF 4-23-10	JM


COORD.	SIGNATURE	DATE
MCCARTHY		
MECHANICAL DUCT		
MECHANICAL PIPE		
PLUMBING		
ELECTRICAL		
FIRE SPRINKLER		
PIPE		
DRYWALL/FRAMER		
REFRIGERATION		
STRUCTURAL		

ANS.	SENT	R.F.I.	ANS.	SENT	R.F.I.	ANS.	SENT	R.F.I.	ANS.	SENT	R.F.I.

**CHILDREN'S HOSPITAL
CHOC**
OF ORANGE COUNTY
HOSPITAL

255 S. TOLSON AVE.
ORANGE, CA 92668-3874
800-988-3874

TOWER II
MECHANICAL PIPE FLOOR PLAN - LEVEL 07 AREA H


**PAN-PACIFIC**
PLUMBING & MECHANICAL

2919 E. VICTORIA STREET, RANCHO DOMINGUEZ, CA 90221
PH. 310 637-1500 FAX 310 604-0359

**Murray Co.**

DRAWN J.M.
CHECKED M.M.
DATE 10/11/2011
SCALE 1/4" = 1'-0"
JOB NO. 09-006
DRAWING NUMBER MP3.7H
REFERENCE DRAWING A3.7H M3.7H
1 OF 1 SHEETS

Day: FILED: 09-08-2011 09:00 AM DRAWING: MCH000004-015 (A3.7H) 3.7H.dwg Printed By: User 10-11-2011 10:46am

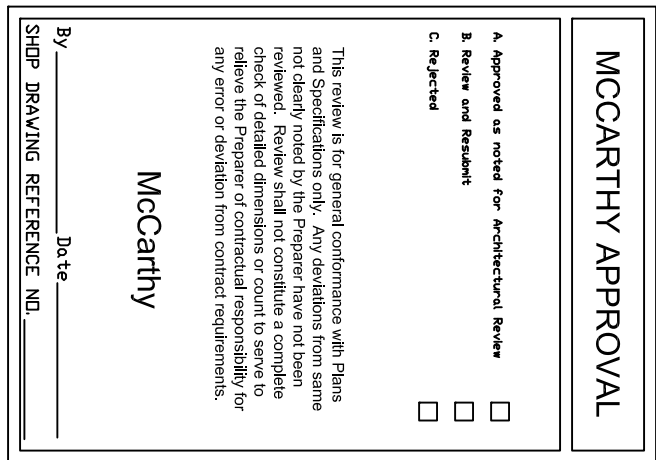

Dwg File: 27-09_005_CDS\MURRAY DRAWINGS\MECHANICAL\PPS\1A-7-TUP3-DWG.Plot by: User 10-11-2011 15:00am

DRWING J.M.	CHECKED
M.M.	DATE
	10/06/2011
	1/4" = 1'-0"
JOB NO.	
09-006	
DRAWING NUMBER	
MP3.7M	
REFERENCE DRAWING	
A3.7M	
M3.7M	
1 OF 1 SHEETS	

PAN-PACIFIC
PLUMBING & MECHANICAL

2919 E. VICTORIA ST.
PH. 310 688-8888

 **CHOC™**
HOSPITAL

**CHILDREN'S HOSPITAL
OF ORANGE COUNTY**

455 S. Main St.
Orange, CA 92868-3874

TOWER II

MECHANICAL PIPE FLOOR PLAN - LEVEL 07 AREA-M

COORD.	SIGNATURE	DATE
KAISER PERMANENTE		
GENERAL CONTRACTOR		
MECHANICAL DUCT		
MECHANICAL PIPE		
PLUMBING		
ELECTRICAL		
SPRINKLER		
P TUBE		
DRYWALL/FRAMER		
REFRIGERATION		

REVISIONS		BT
A	ISSUED FOR CONSTRUCTION SIGN-OFF 04-09-10	JLM
B	ISSUED FOR PRESSURE TUBE RE-CONSTRUCTION SIGN OFF 4-21-10	JLM
0	ISSUED FOR CONSTRUCTION REVISED PER COR 141 DS-0265 JAB 3-21-11	MO