


DRAWN S.B.
CHECKED
M.M.
DATE
2/26/2010
SCALE
1/4" = 1'-0"
JOB NO.
09-006
DRAWING NUMBER
MP3.0A
REFERENCE DRAWING
A3.0A
P3.0A
1 OF 1 SHEETS

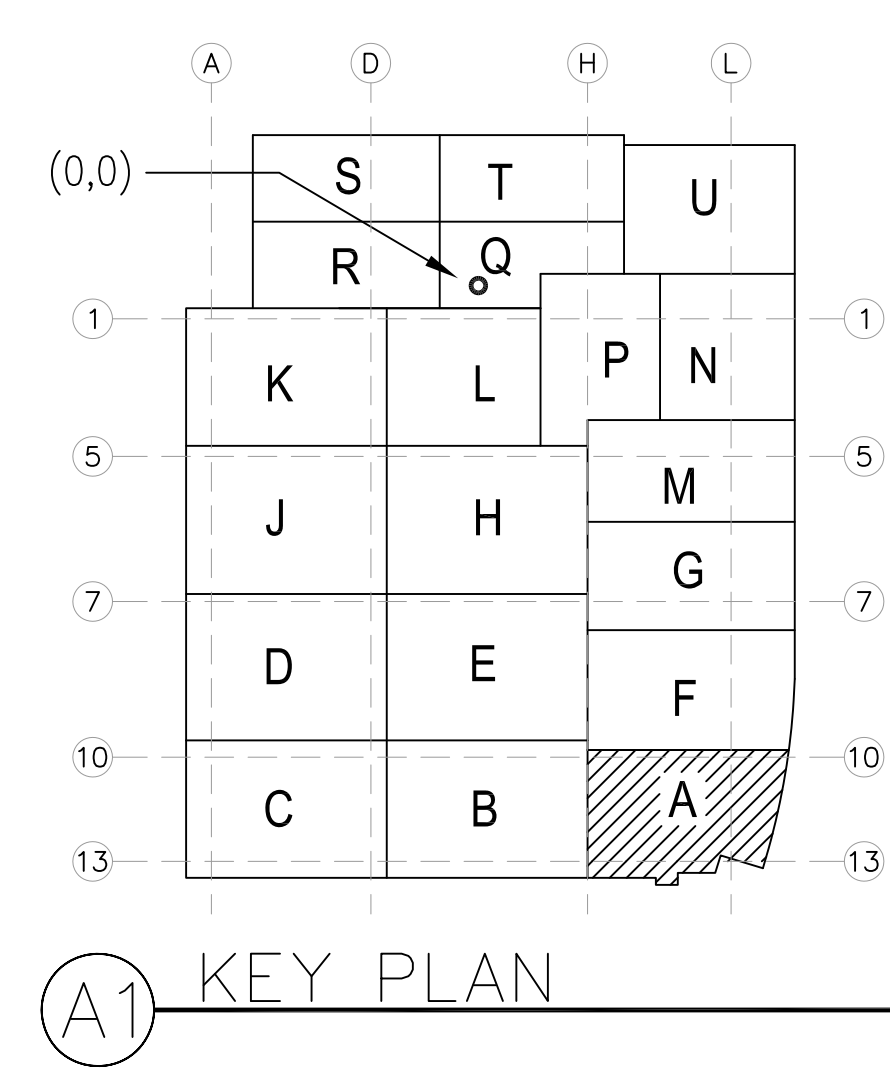


ISO AT SHAFT NO SCALE




LEVEL 00 144.30' = 0'-0"

REFERENCE THIS SHEET

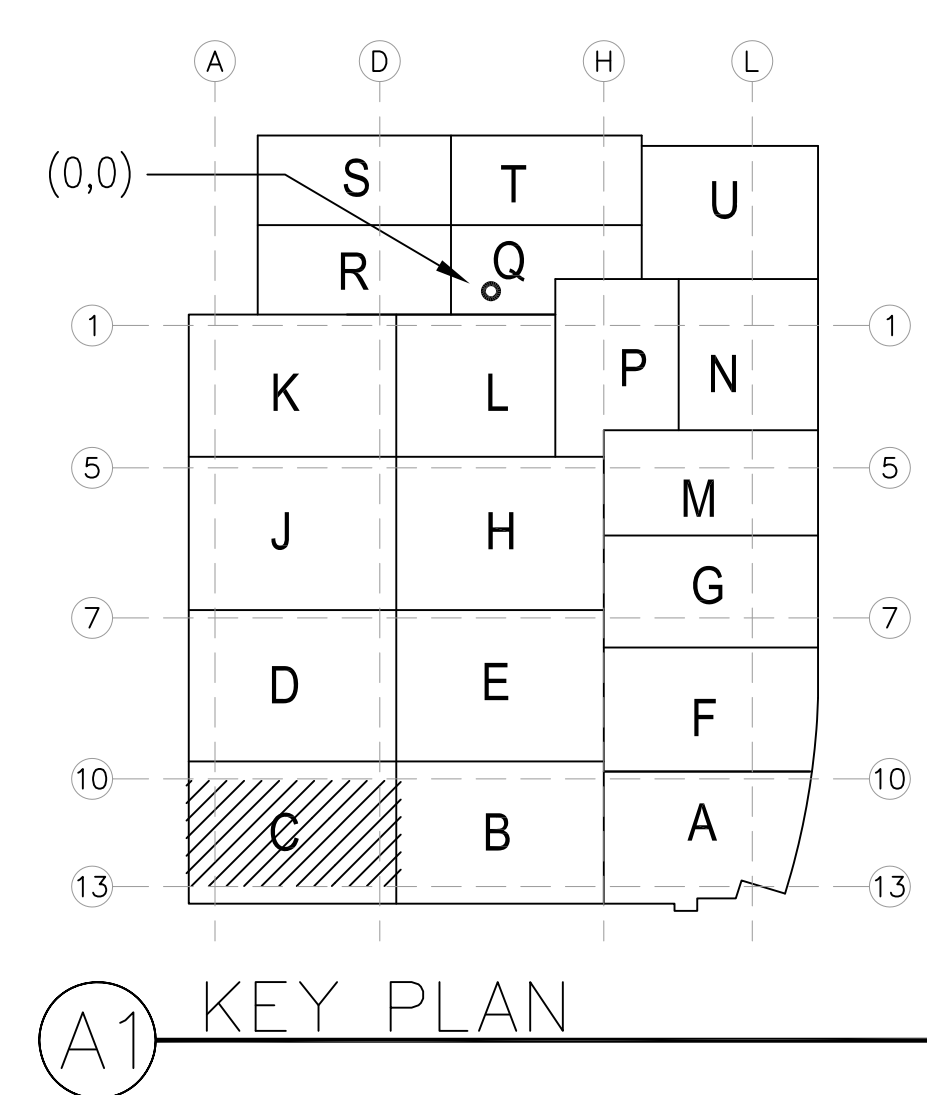[illegible]

This document and the design it covers are the property of Murray Co. They are loaned only with the borrower's expressed written agreement that they will not be reproduced, copied, loaned, exhibited, or used in any other way, except by written consent from Murray Co. to the borrower.

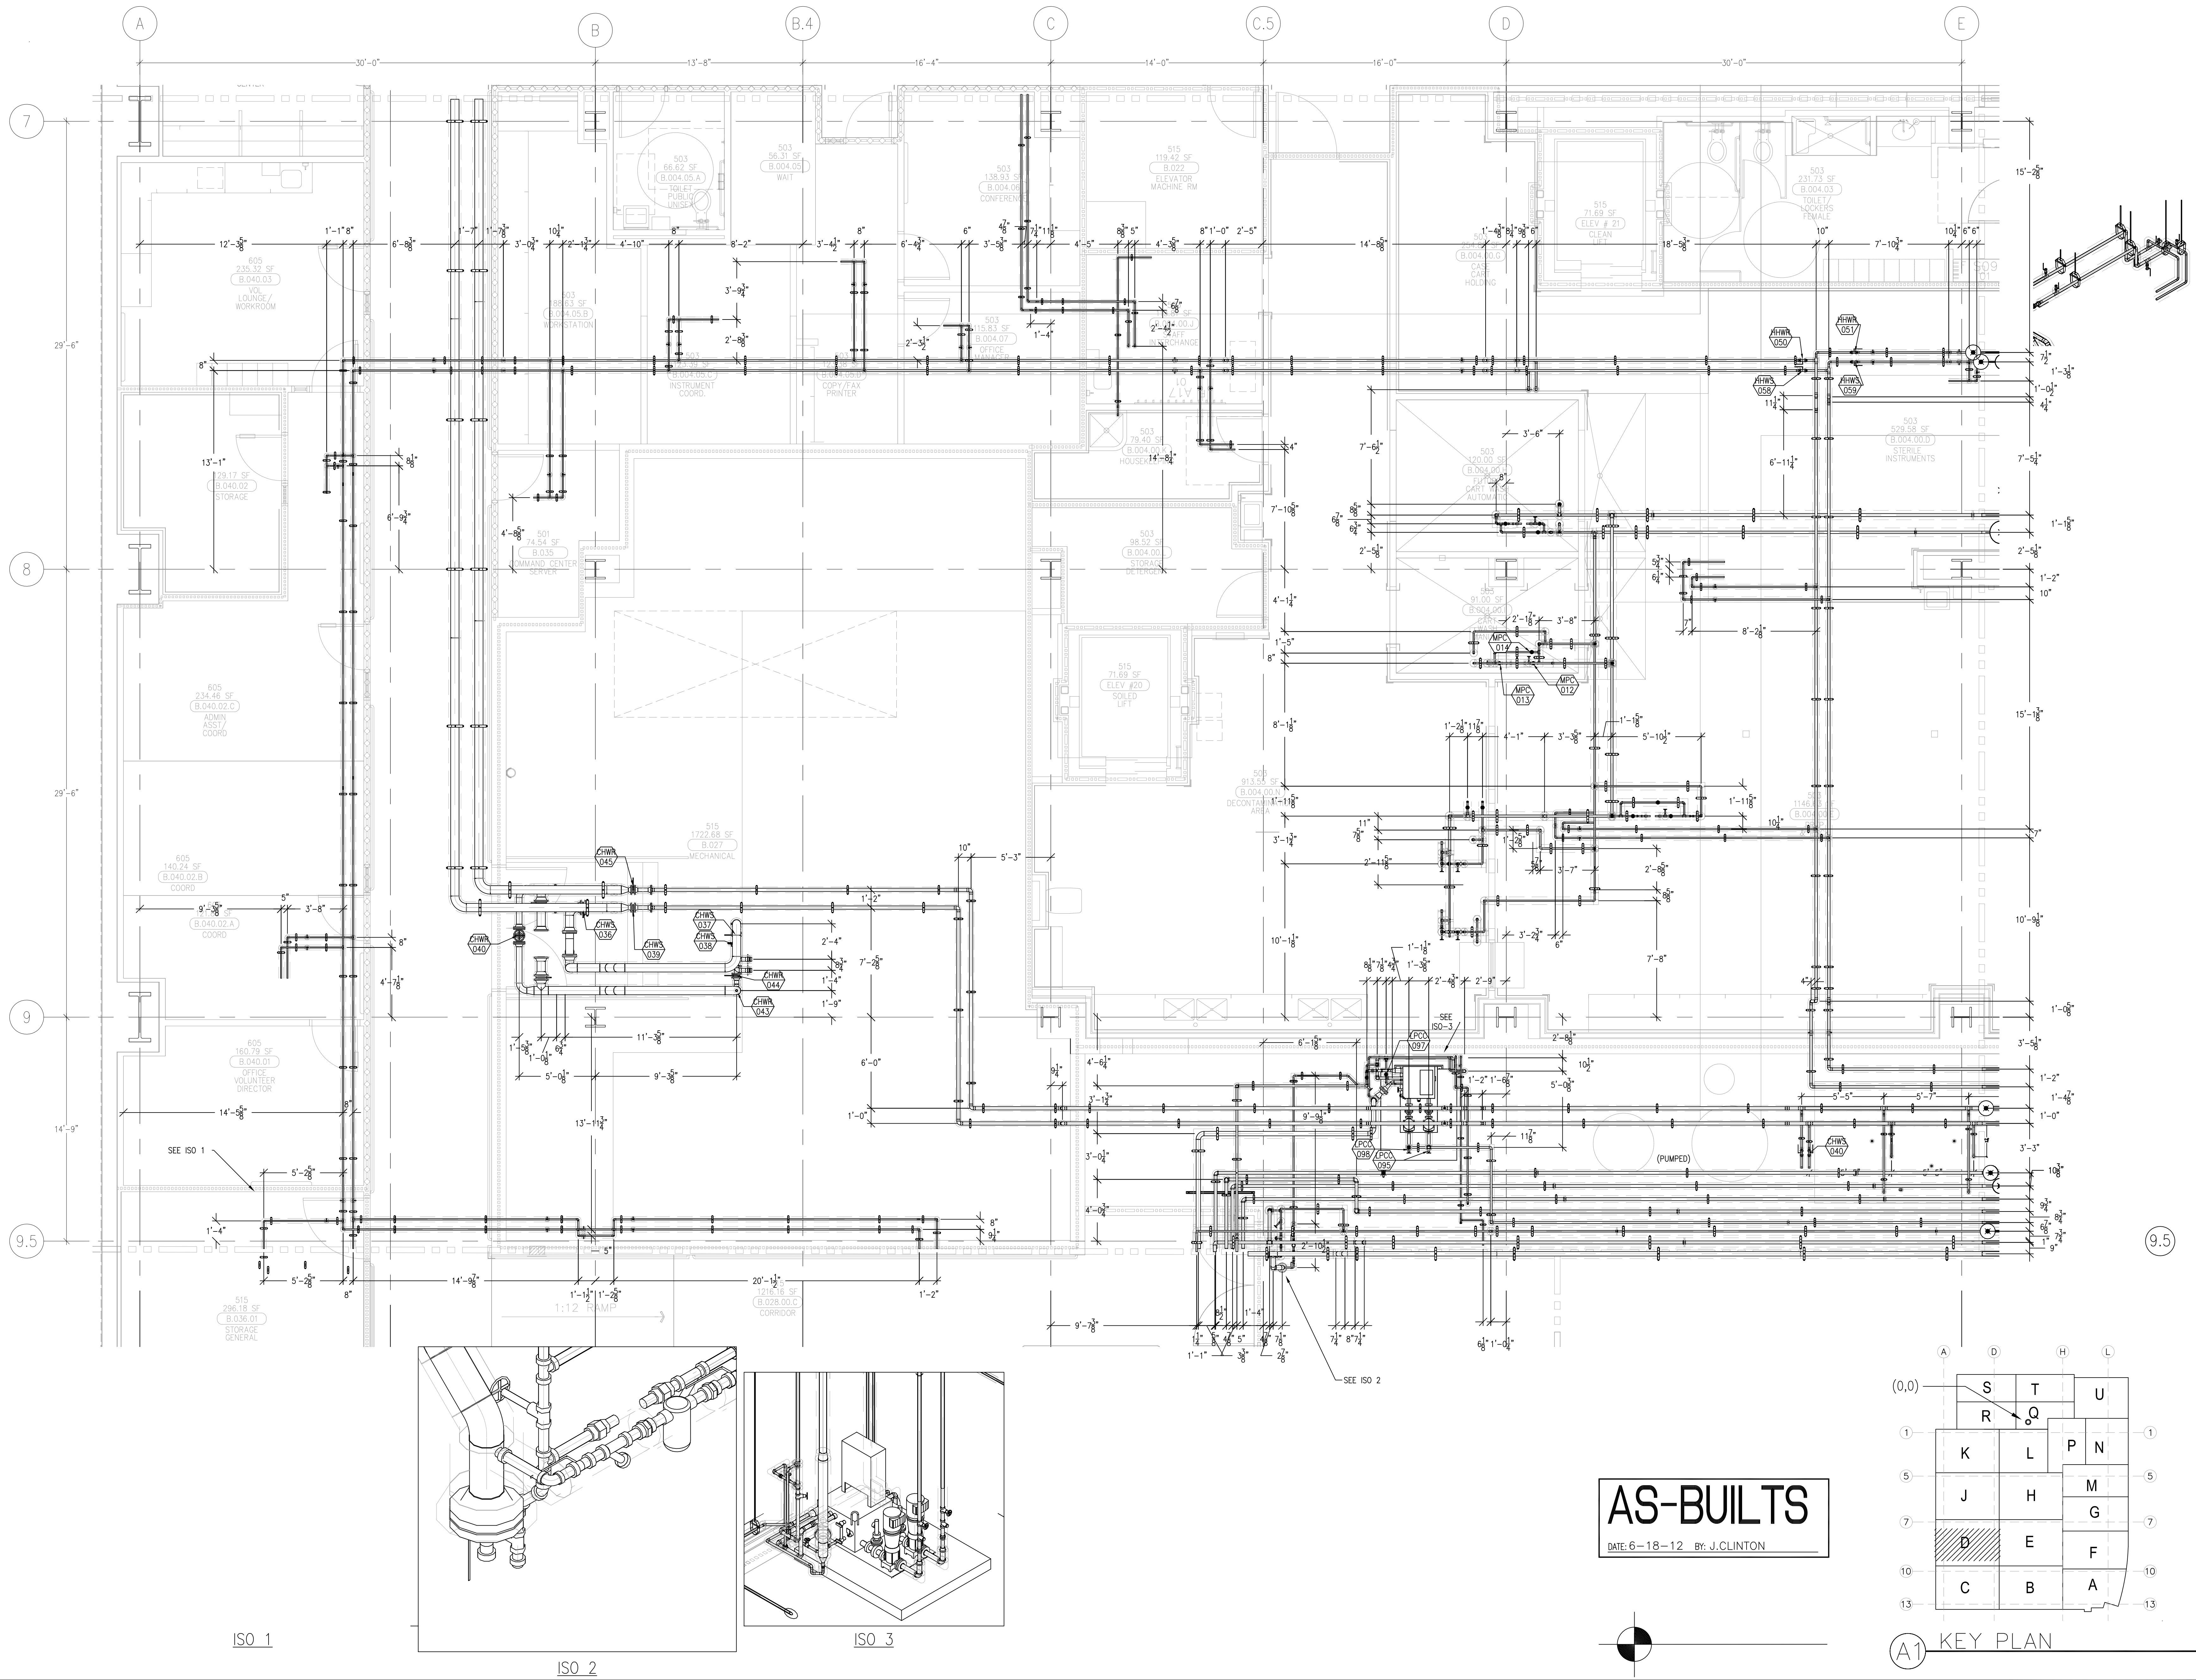[illegible]

COORD.	SIGNATURE	DATE
MCARTHY		
MECHANICAL DUCT		
MECHANICAL PIPE		
PLUMBING		
ELECTRICAL		
FIRE SPRINKLER		
PTJGE		
DRYWALL/FRAMER		
RETRICERATION		
STRUCTURAL		

[illegible]

CHILDREN'S HOSPITAL
OF ORANGE COUNTY
455 S. Main St.
Orange, CA 92668-3874
TOWER II
MECHANICAL PIPE FLOOR PLAN - LEVEL 00 AREA-D




PAN-PACIFIC
PUMPING & MECHANICAL

Murray
Company

2919 E. VICTORIA STREET, RANCHO DOMINGUEZ, CA 90221
PH. 310 637-1500 FAX 310 604-0359

DRAWN S.B.
CHECKED
M.M.
DATE
9/4/2012
SCALE
1/4" = 1'-0"
JOB NO.
09-006
DRAWING NUMBER
MP3.0D
REFERENCE DRAWING
A3.0D
P3.0D
1 OF 1 SHEETS

This document and the design it covers are the property of Murray Co. They are loaned only with the borrower's expressed written agreement that they will not be reproduced, copied, loaned, exhibited, or used in any other way, except by written consent from Murray Co. to the borrower.

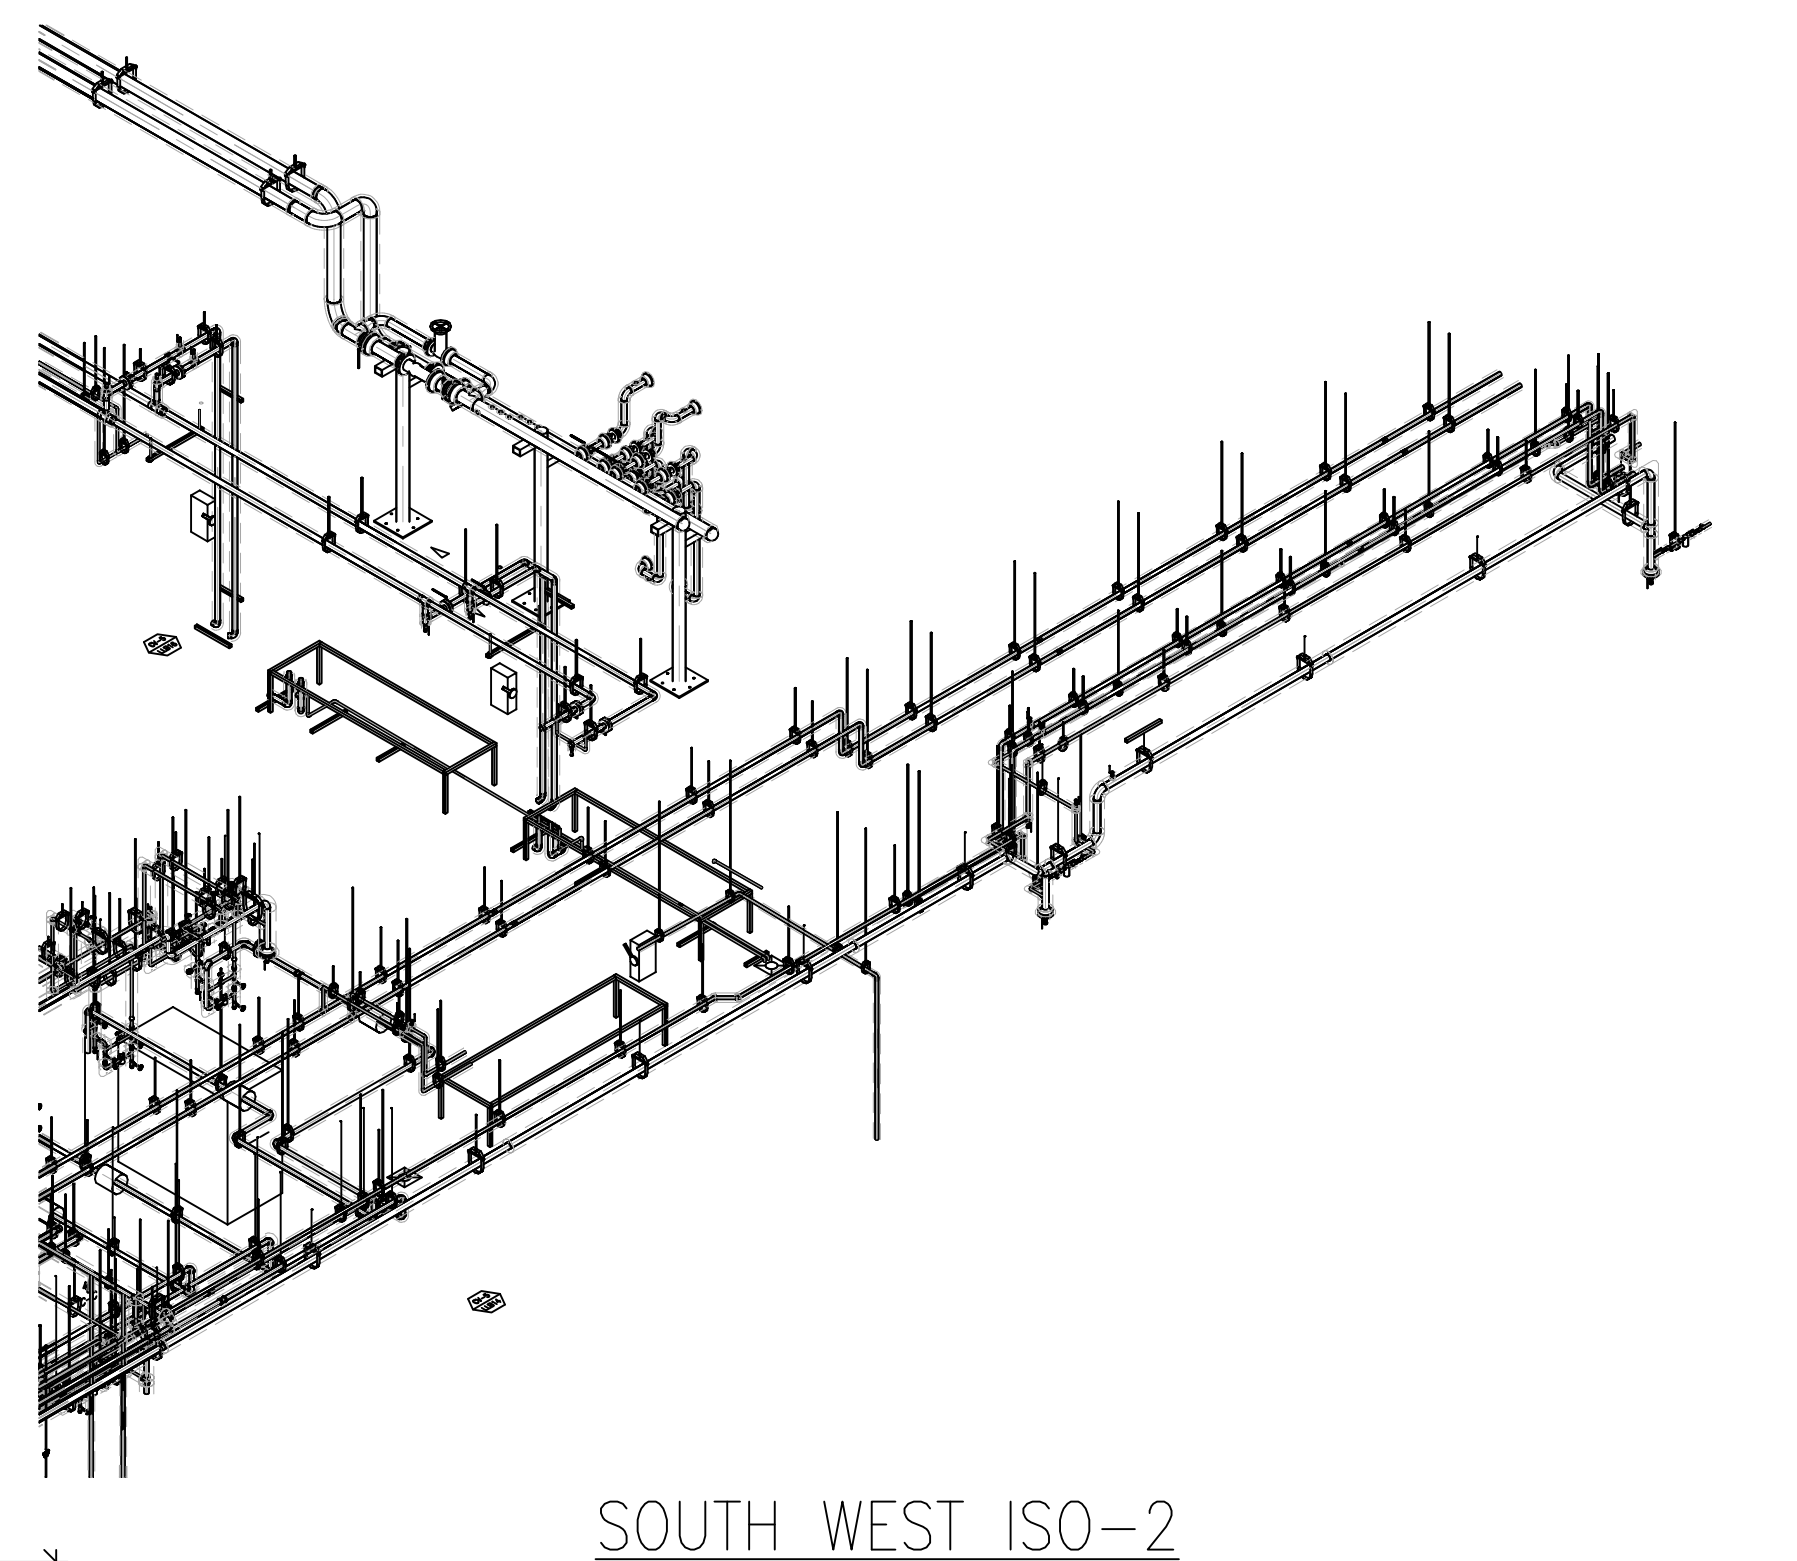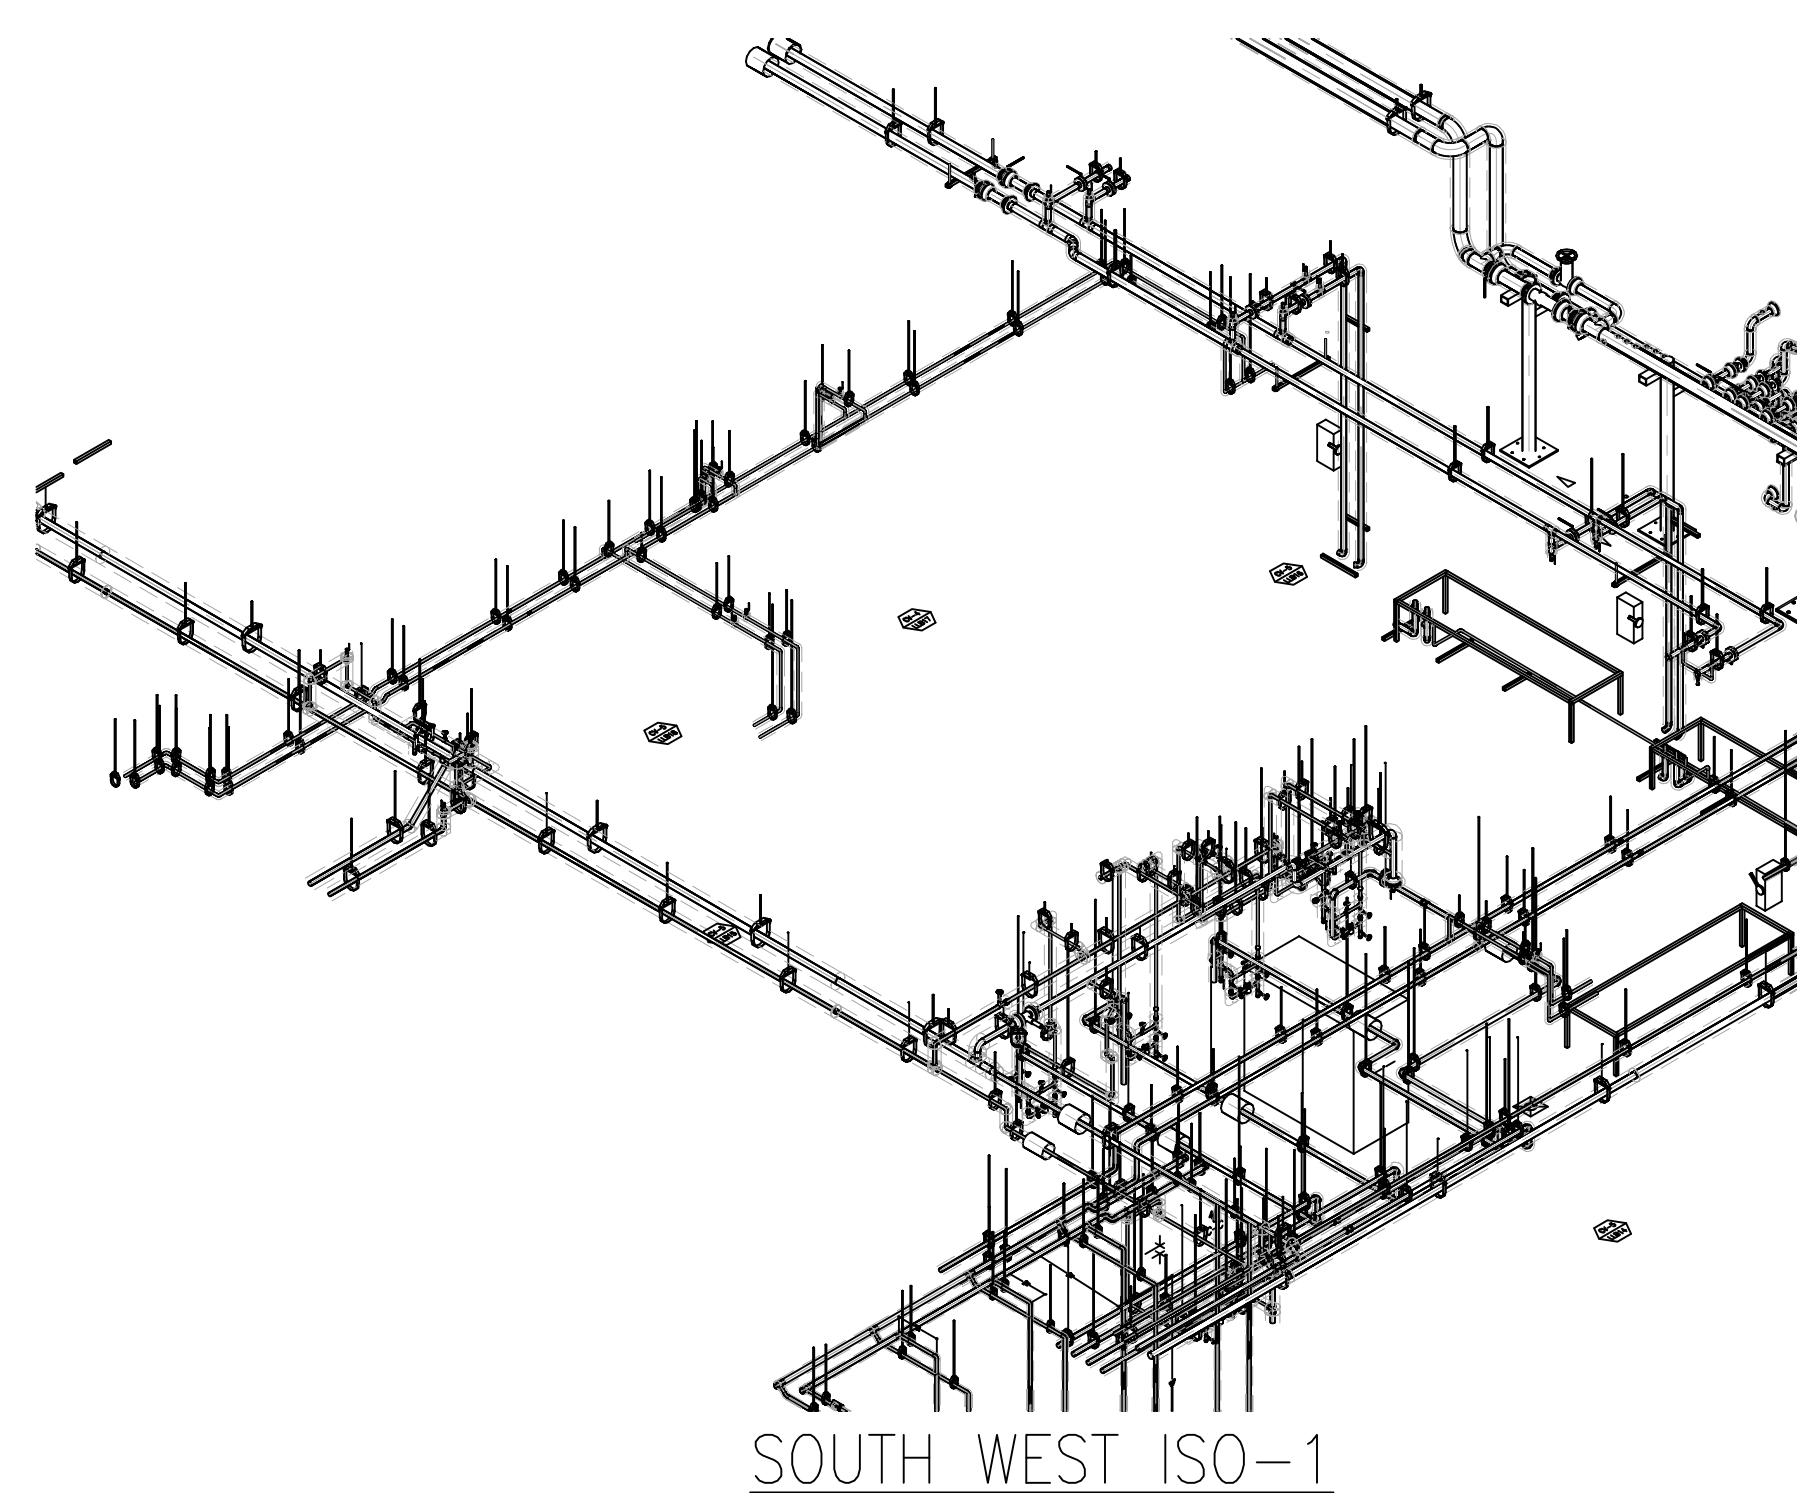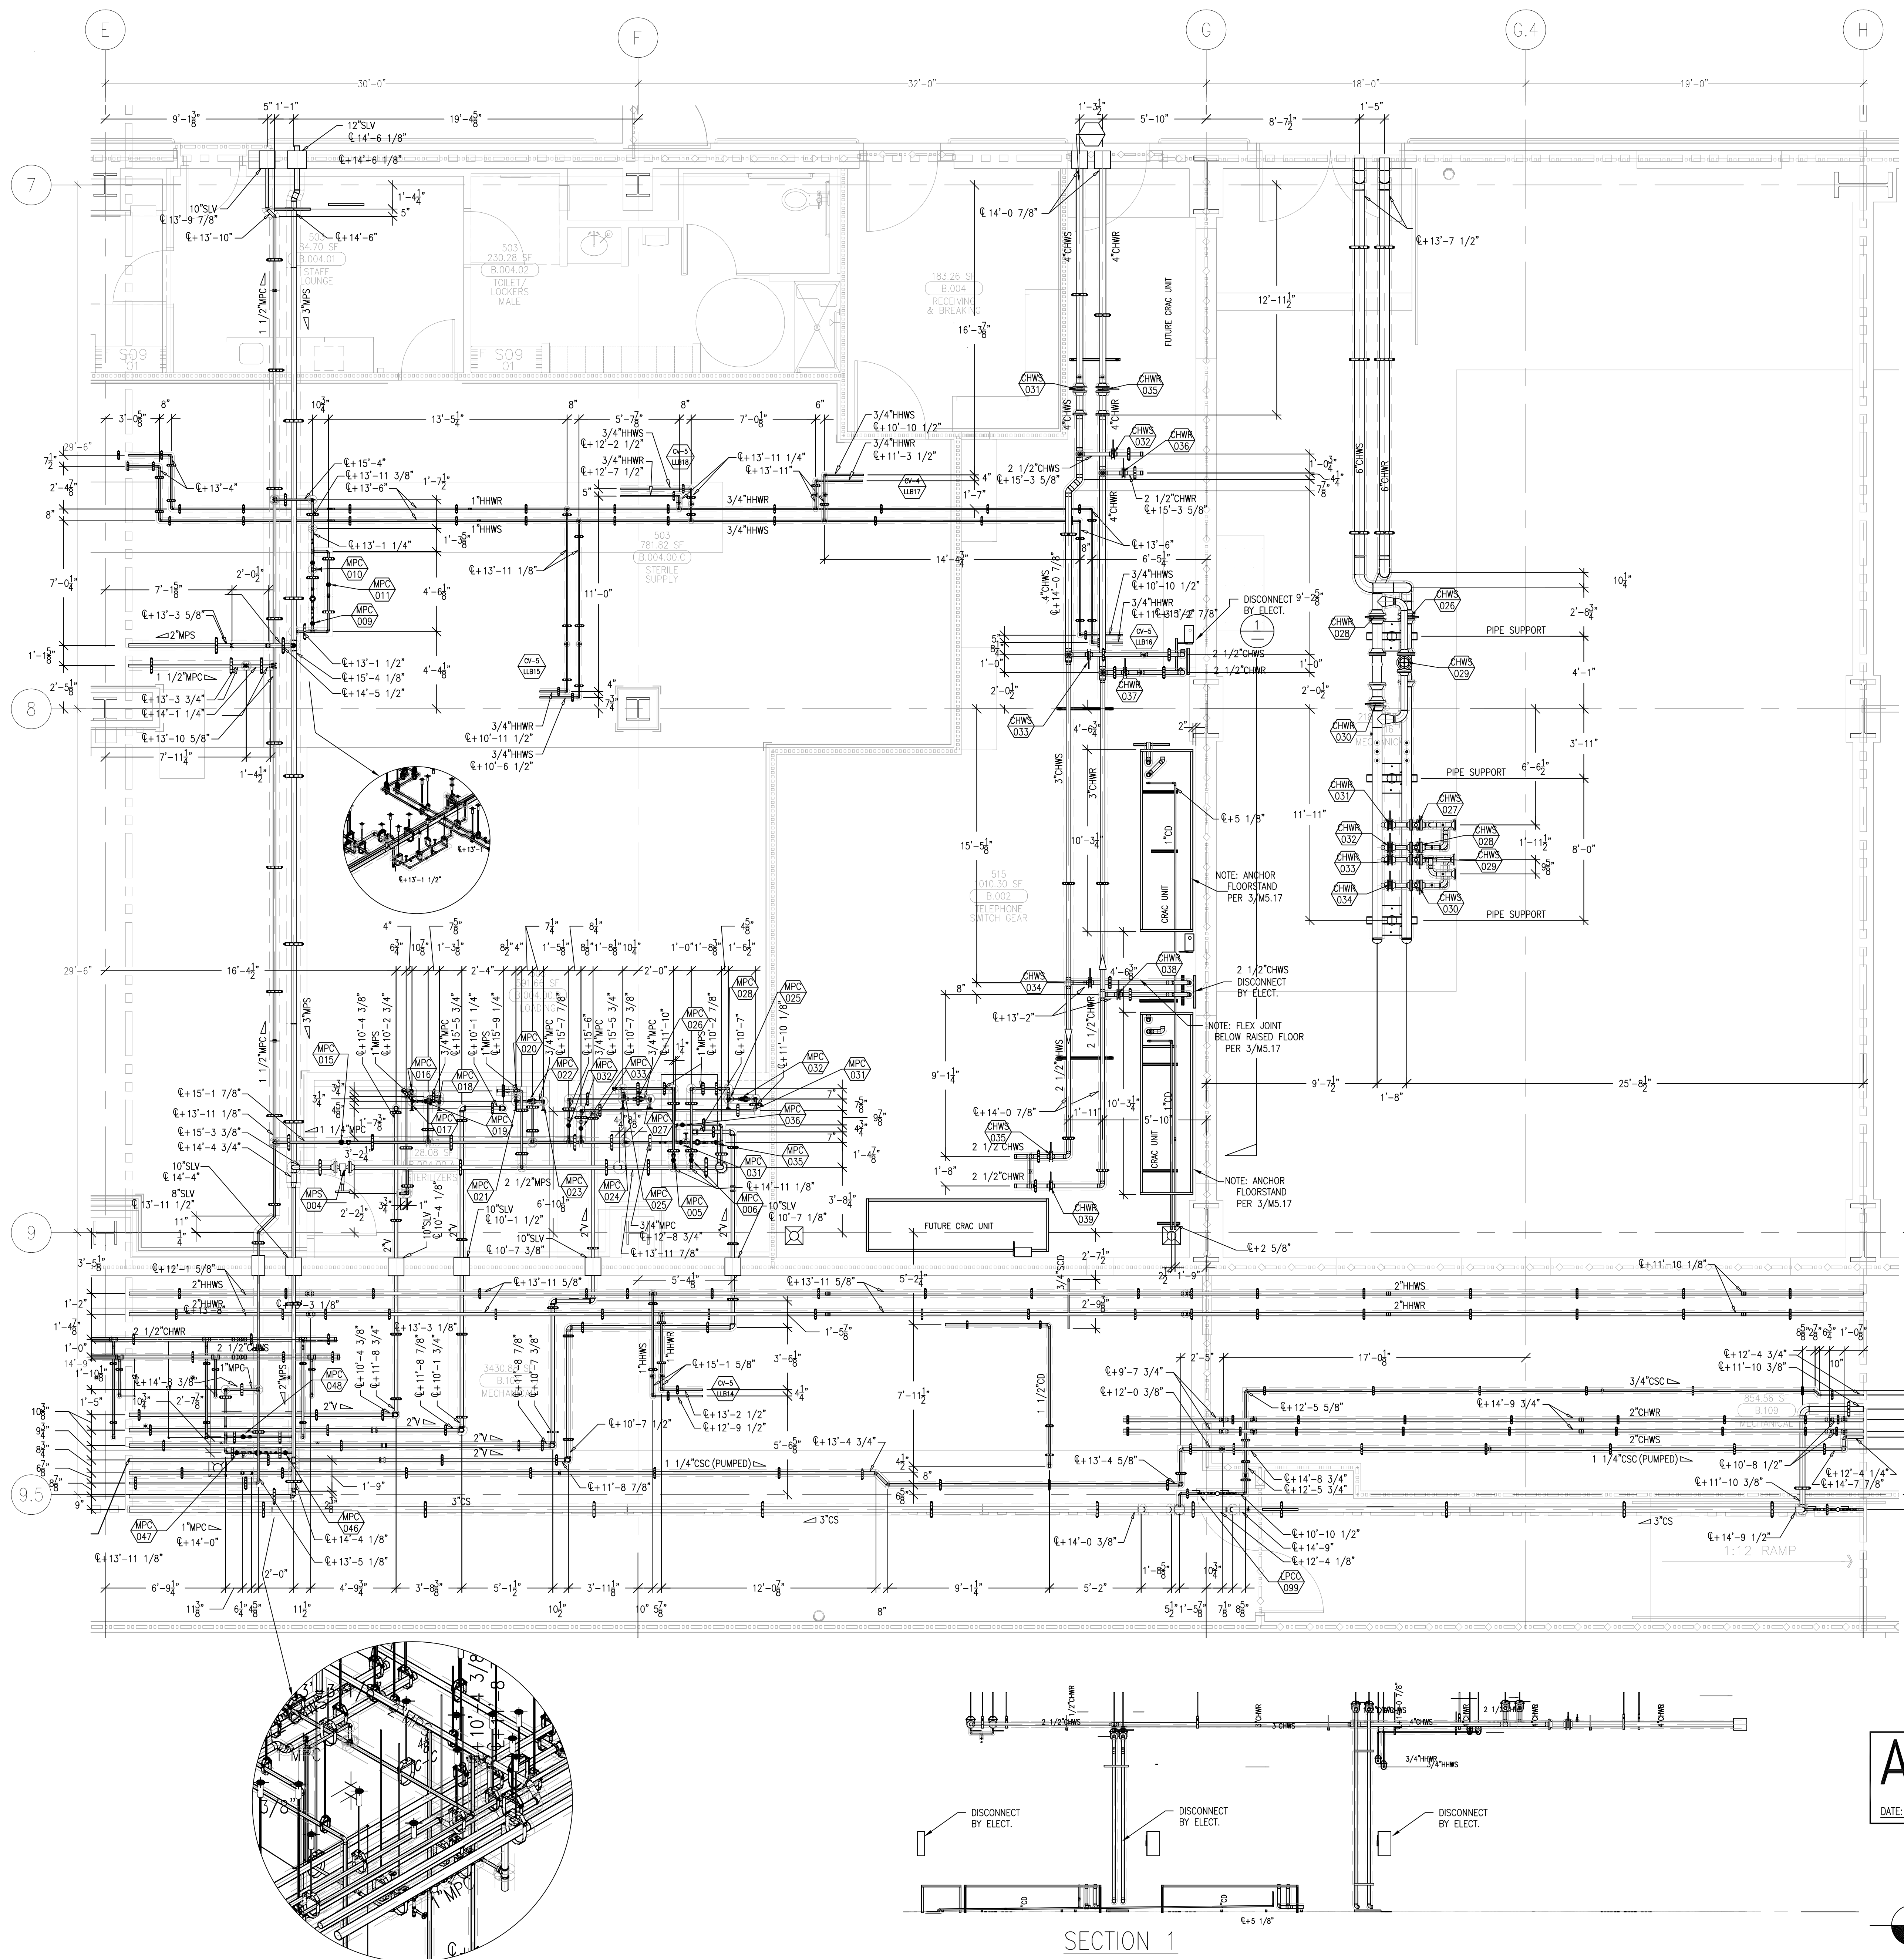[illegible]

MCCANTH	
MECHANICAL DUCT	
MECHANICAL PIPE	
PUMPING	
ELECTRICAL	
FIRE SPRINKLER	
PTUBE	
DRYWALL/FRAMER	
REFRIGERATION	
STRUCTURAL	

[illegible]

CHILDREN'S HOSPITAL
OF ORANGE COUNTY
455 S. Main St.
Orange, CA 92665-3974
TOWER II
MECHANICAL PIPE FLOOR PLAN - LEVEL 00 AREA


CPM
PACIFIC
PLUMBING & MECHANICAL

Murray Company

2919 E. VICTORIA STREET, RANCHO DOMINGUEZ, CA 90221
PH. 310 637-1500 FAX 310 604-0359

DRAWN
SB
CHECKED
M.M.
DATE
9/4/2012
SCALE
1/4"=1'-0"
JOB NO.
09-006
DRAWING NUMBER
MP3.0E
REFERENCE DRAWING
A3.0E
P3.0E
1 OF 1 SHEETS

This document and the design it covers are the property of Murray Co. They are loaned only with the borrower's expressed written agreement that they will not be reproduced, copied, loaned, exhibited, or used in any other way, except by written consent from Murray Co. to the borrower.

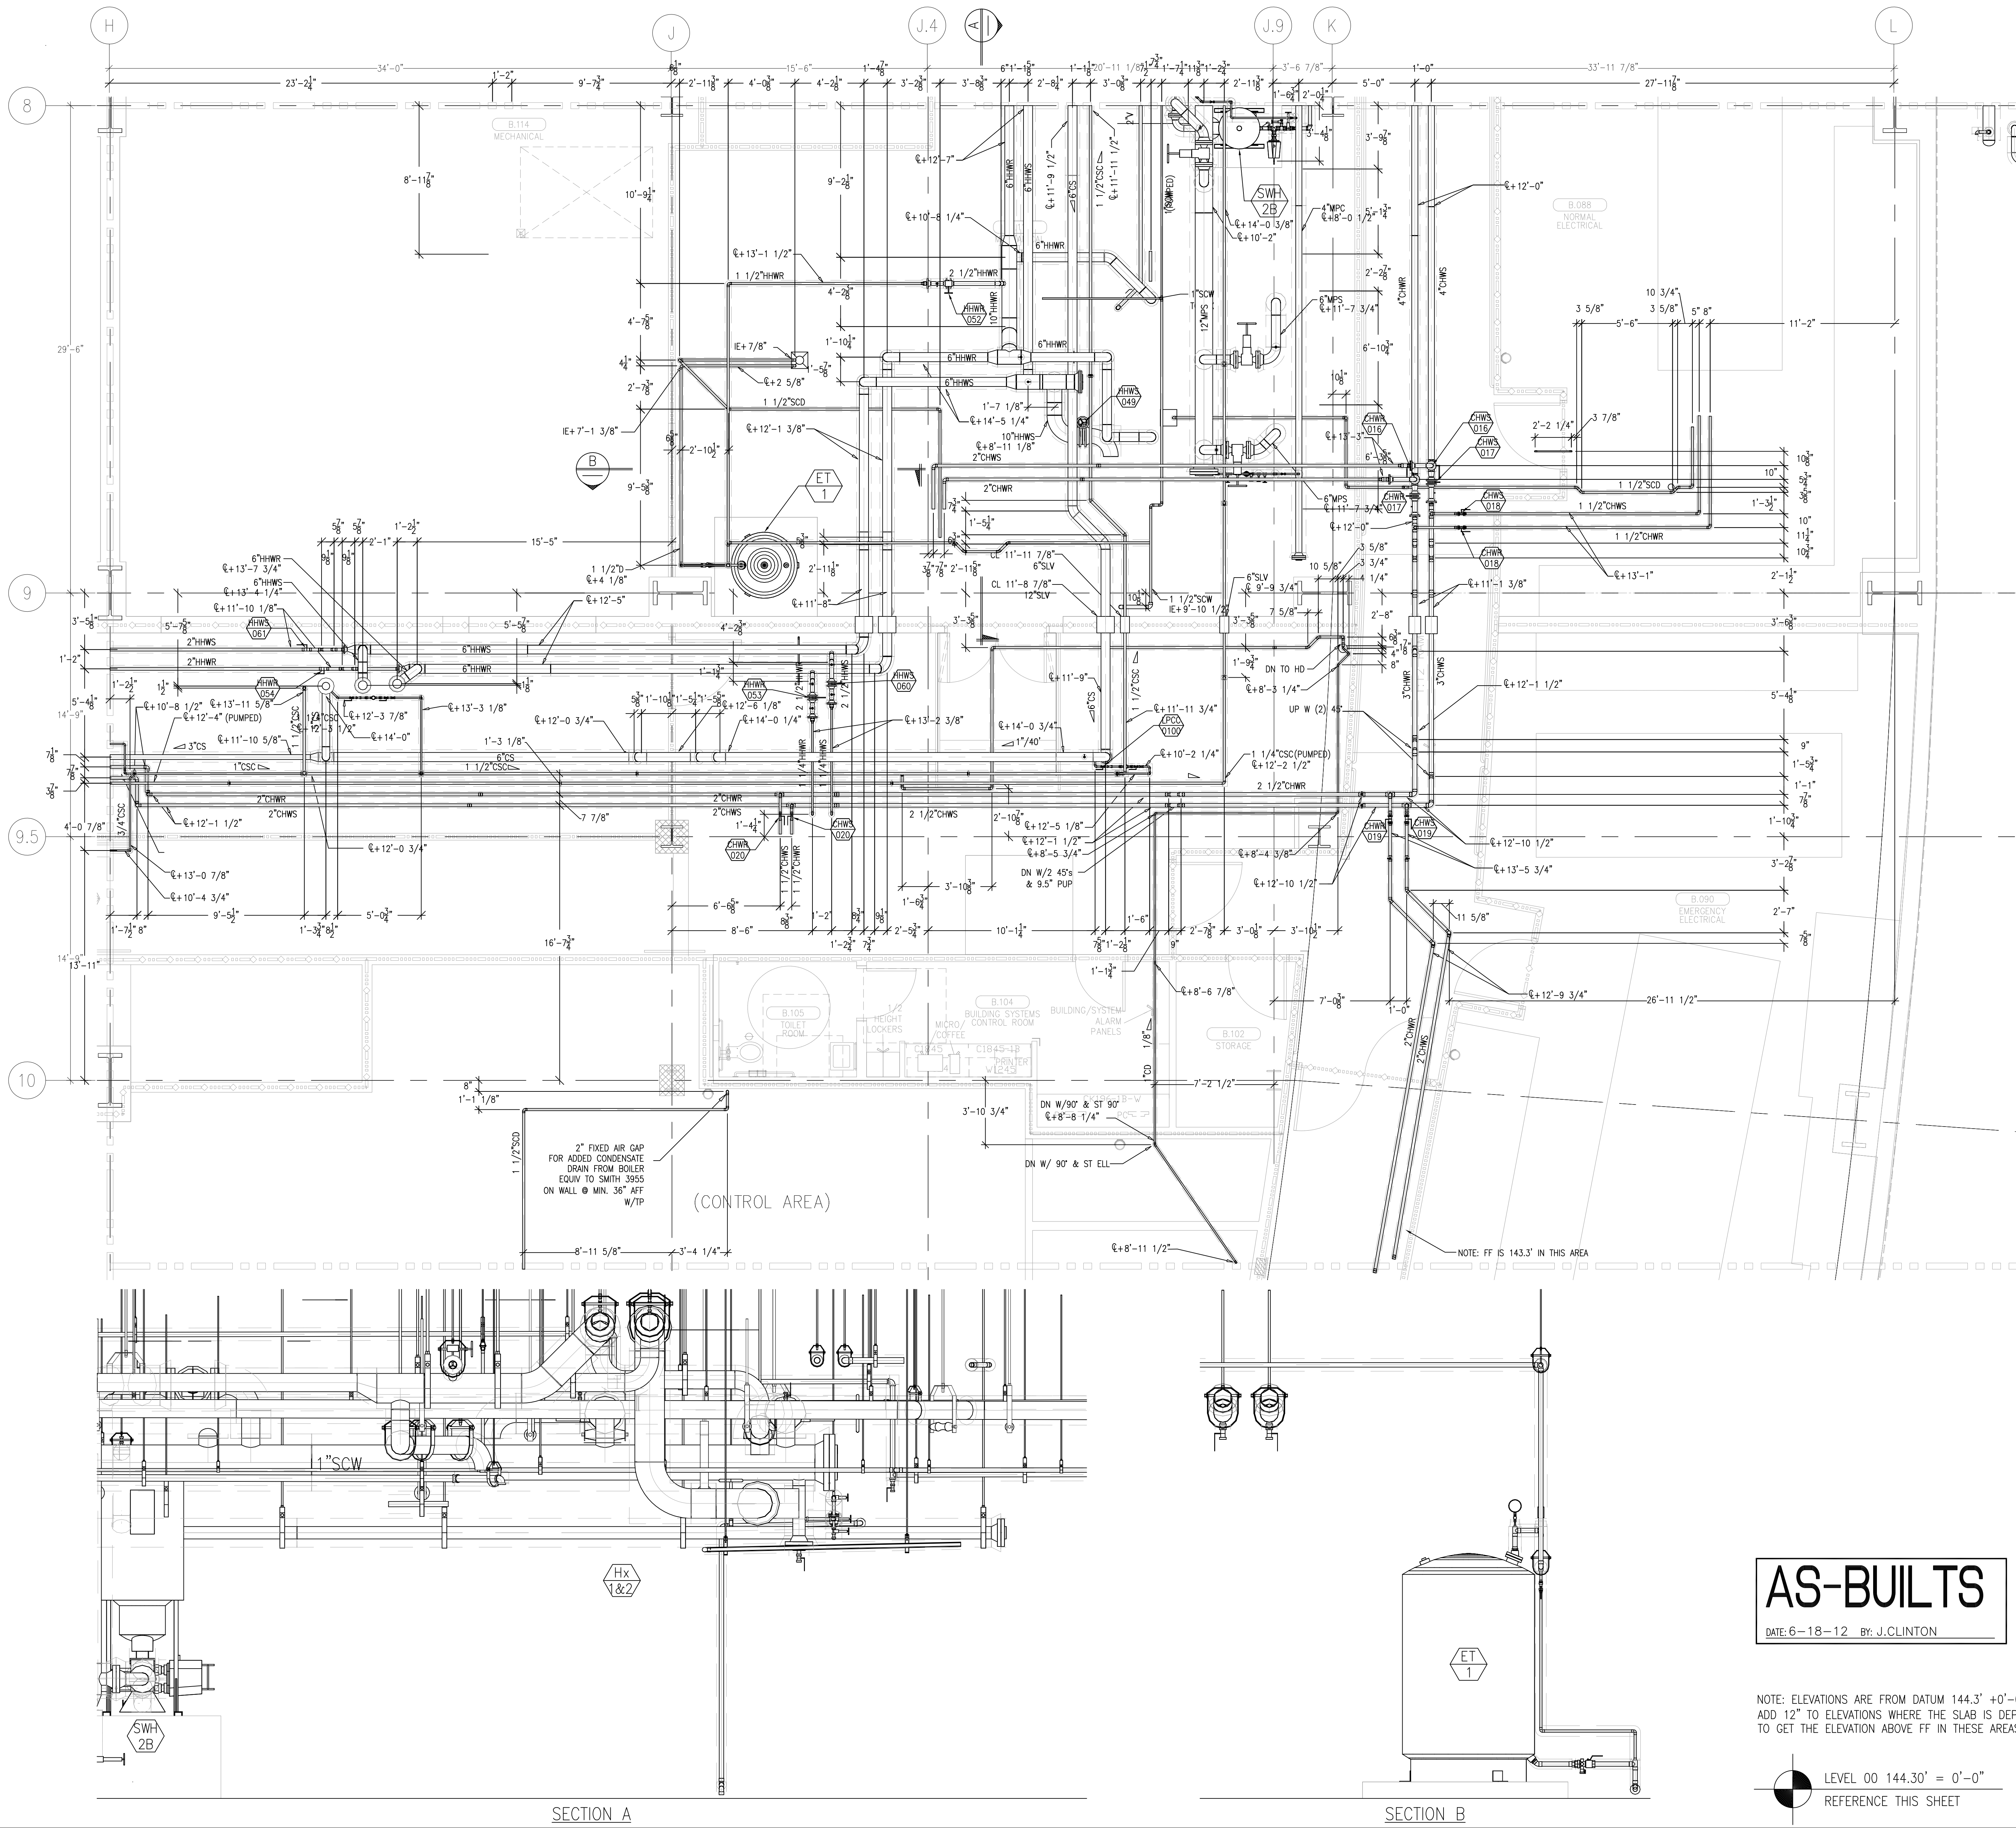


AS-BUILTS

DATE: 6-18-12 BY: J. CLINTON

NOTE: ELEVATIONS ARE FROM DATUM 144.3' +0'-0"
ADD 12" TO ELEVATIONS WHERE THE SLAB IS DEPRESSED
TO GET THE ELEVATION ABOVE FF IN THESE AREAS.

LEVEL 00 144.30' = 0'-0"
REFERENCE THIS SHEET

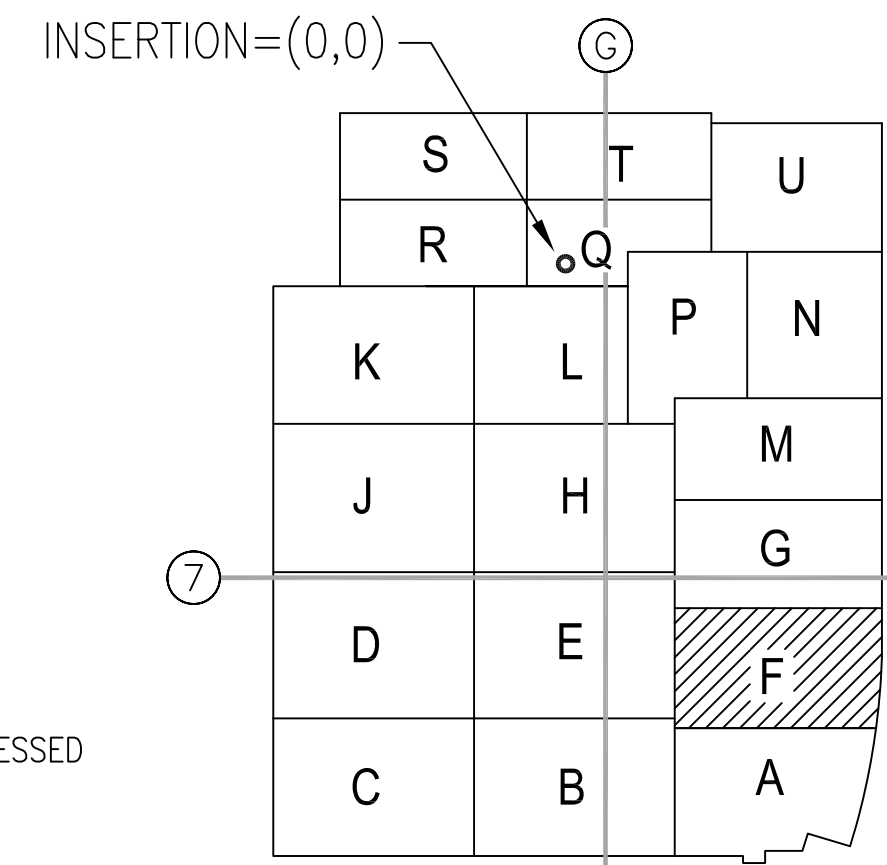

KEY PLAN

REVISIONS	BY

COORD.	SIGNATURE	DATE
MECHANICAL		
MECHANICAL		
ELECTRICAL		
PLUMBING		
STRUCTURAL		


ANS.	SENT	R.F.I.	ANS.	SENT	R.F.I.	ANS.	SENT	R.F.I.	ANS.	SENT	R.F.I.

CHILDREN'S HOSPITAL
OF ORANGE COUNTY
455 S. MAIN ST., SUITE 200
ORANGE, CA 92668-3974
TOWER II
MECHANICAL PIPE FLOOR PLAN - LEVEL 00 AREA F

PAN-PACIFIC
PLUMBING & MECHANICAL
Murray Company
2919 E. VICTORIA STREET, RANCHO DOMINGUEZ, CA 90221
PH. 310 637-1500 FAX 310 604-0359

DRAWN
SB
CHECKED
M.M.
DATE
9/4/2012
SCALE
1/4" = 1'-0"
JOB NO.
09-006
DRAWING NUMBER
MP3.0F
REFERENCE DRAWING
A3.0F
P3.0F
1 OF 1 SHEETS

AS-BUILTS
DATE: 6-18-12 BY: J.CLINTON

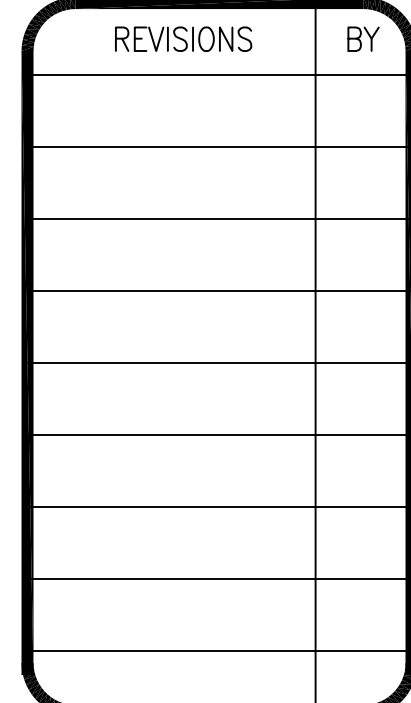

MECHANICAL	
MECHANICAL DUCT	
MECHANICAL PIPE	
PUMPING	
ELECTRICAL	
FIRE SPRINKLER	
PIT/UBE	
DRYWALL/FRAMER	
REFRIGERATION	
STRUCTURAL	

[illegible]

CHILDREN'S HOSPITAL
OF ORANGE COUNTY
455 S. Main St.
Orange, CA 92668-3874
TOWER II
MECHANICAL PIPE FLOOR PLAN - LEVEL 00 AREA-G

PAN-PACIFIC
PLUMBING & MECHANICAL

PMI

Murray Company


2919 E. VICTORIA STREET, RANCHO DOMINGUEZ, CA 90221
PH. 310 637-1500 FAX. 310 604-0359

DRAWN SB
CHECKED
M.M.
DATE 9/4/2012
SCALE 1/4"=1'-0"
JOB NO. 09-006
DRAWING NUMBER MP3.0G
REFERENCE DRAWING A3.0G P3.0G
1 OF 1 SHEETS



LEVEL 00 144.30' = 0'-0"


REFERENCE THIS SHEET

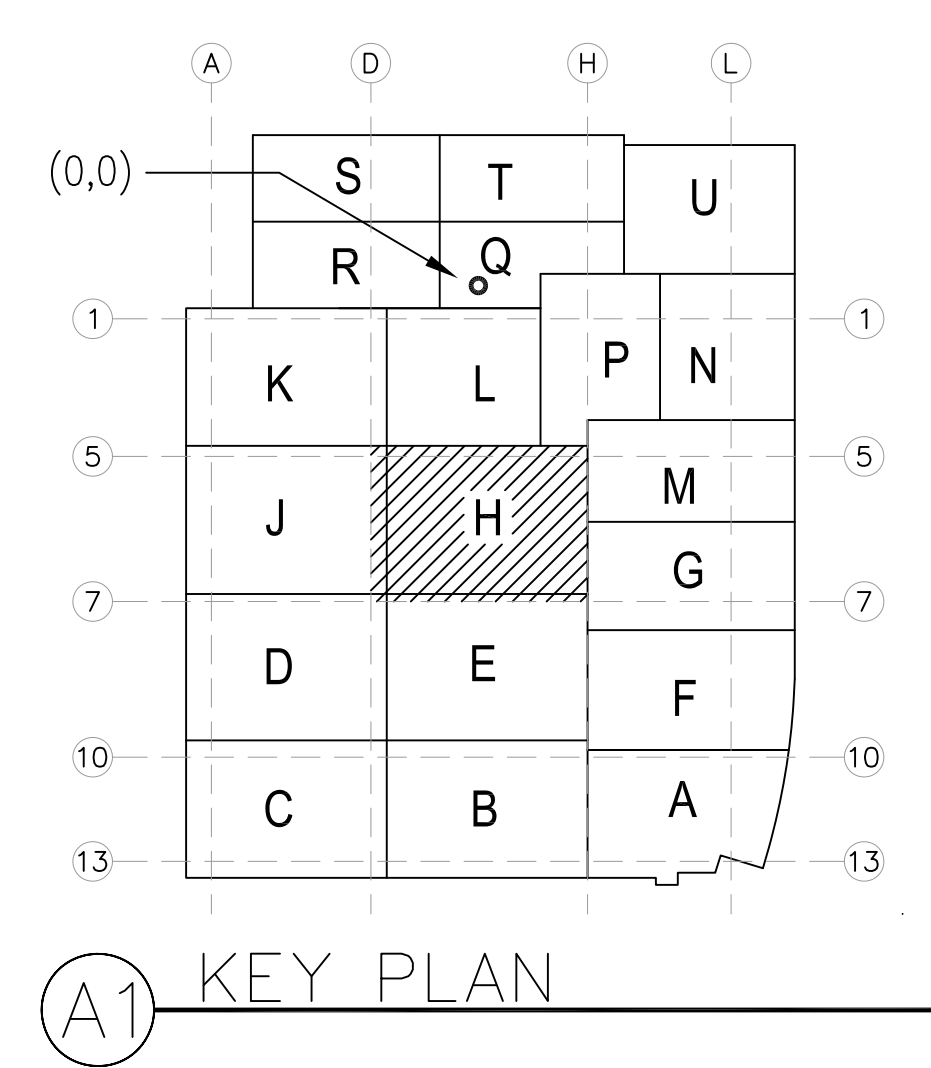



DRAWN	SB
CHECKED	
M.M.	
DATE	9/4/2012
SCALE	1/4" = 1'-0"
JOB NO.	
	09-006
DRAWING NUMBER	MP3.0H
REFERENCE DRAWING	A3.0H
	P3.0H
1	OF 1 SHEETS


DRAWN
S.B.
CHECKED
M.M.
DATE
9/4/2012
SCALE
1/4" = 1' - 0"
JOB NO.
09-006
DRAWING NUMBER
MP3.0K
REFERENCE DRAWING
A3.0K
P3.0K
1 OF 1 SHEETS

DRAWN	S.B.
CHECKED	
M.M.	
DATE	9/4/2012
SCALE	1/4" = 1' - 0"
JOB NO.	09-006
DRAWING NUMBER	MP3.0L
REFERENCE DRAWING	A3.0L P3.0L
1	OF 1 SHEETS

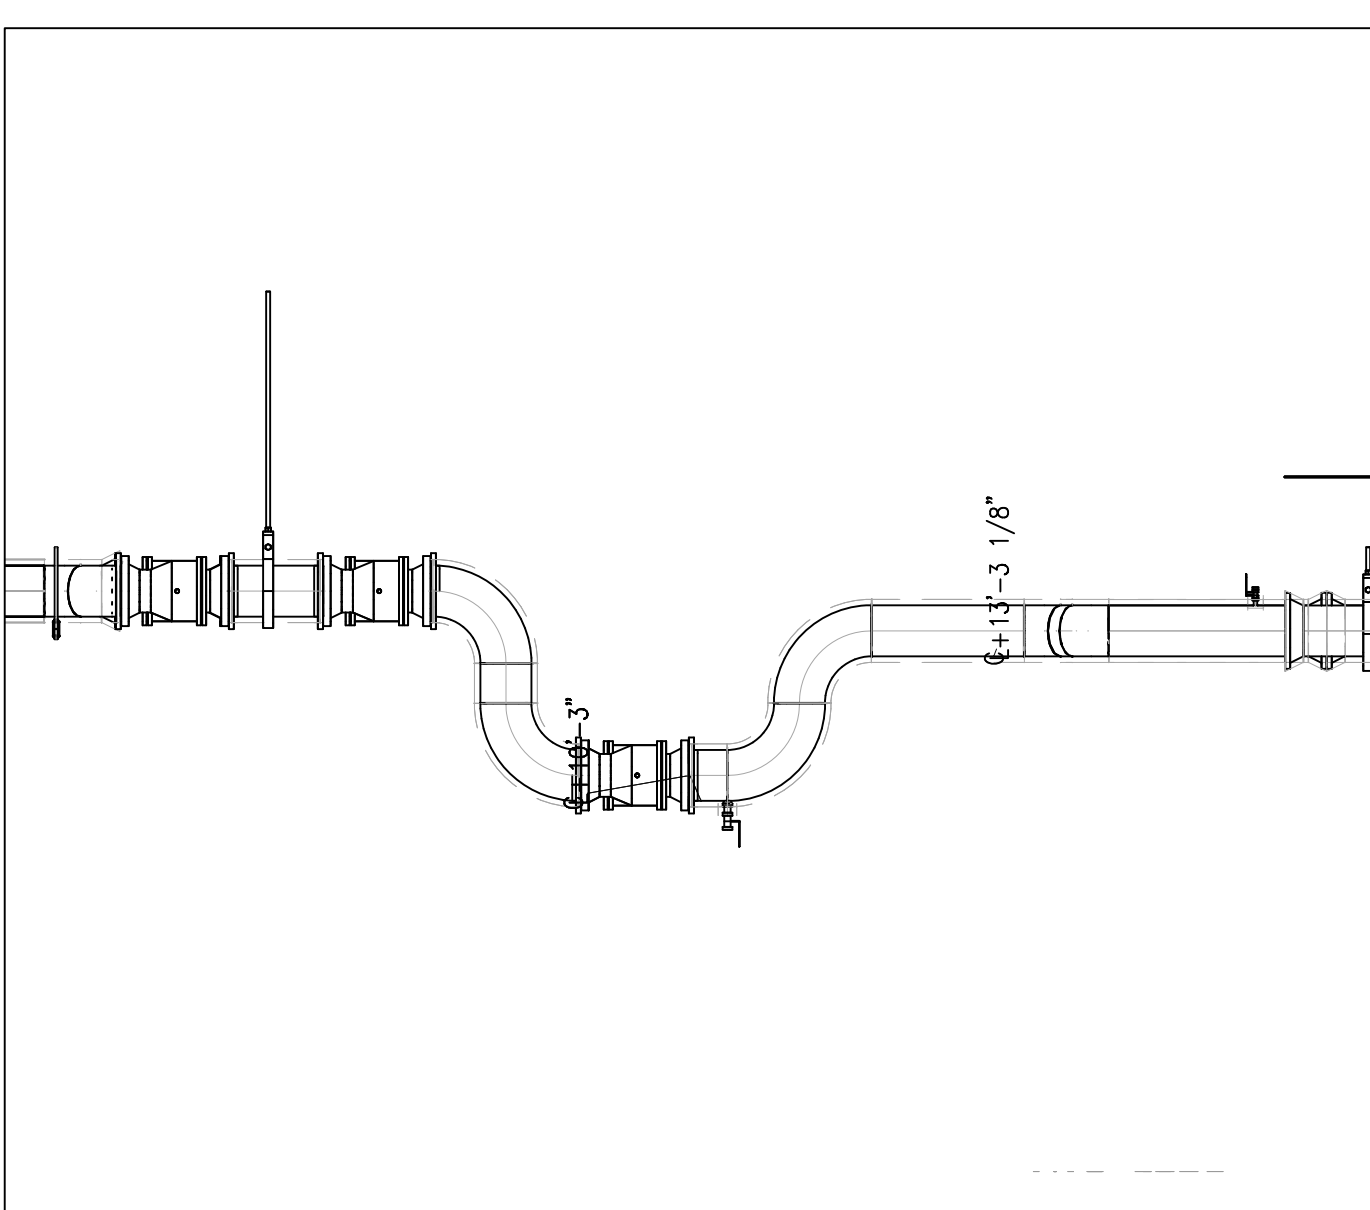


DETAIL A (ELEV.)

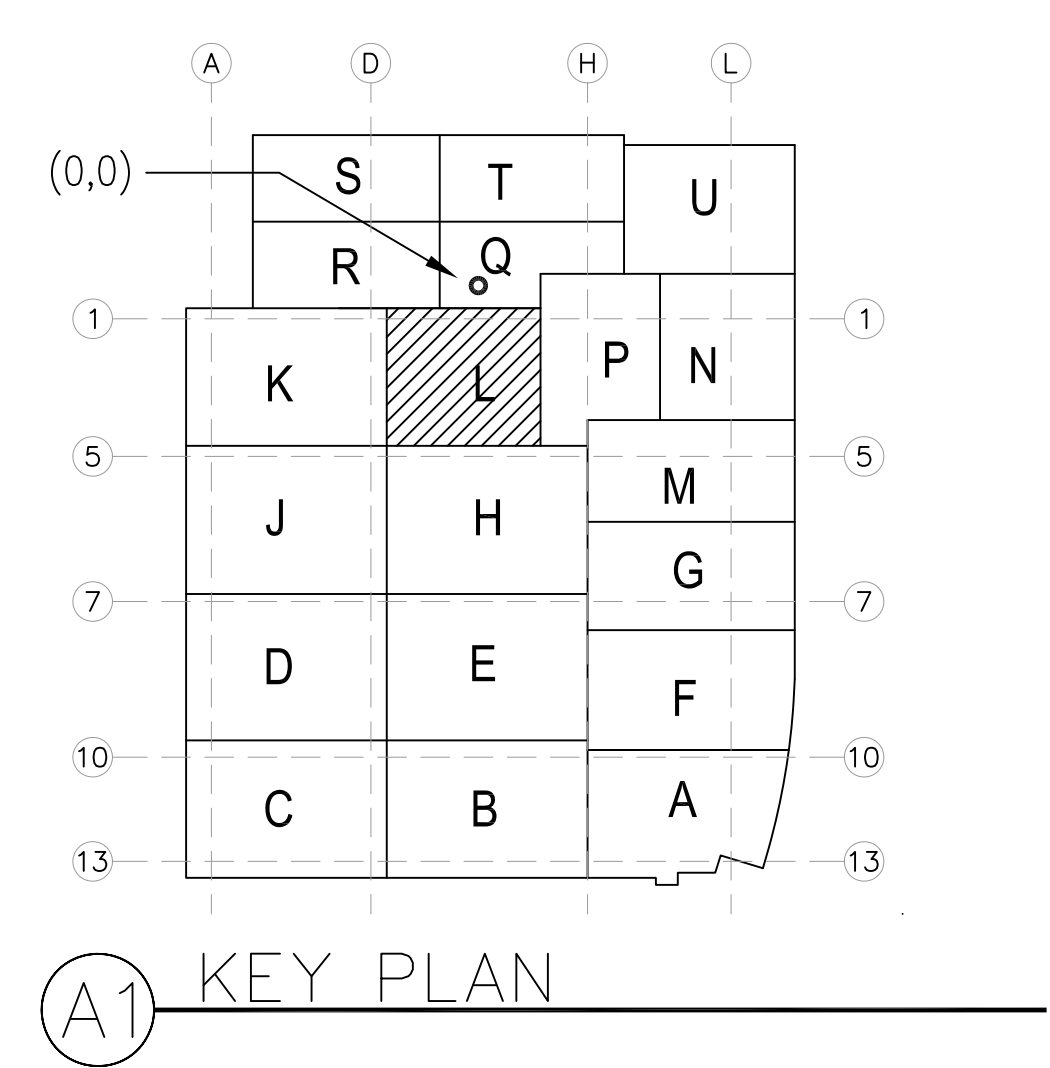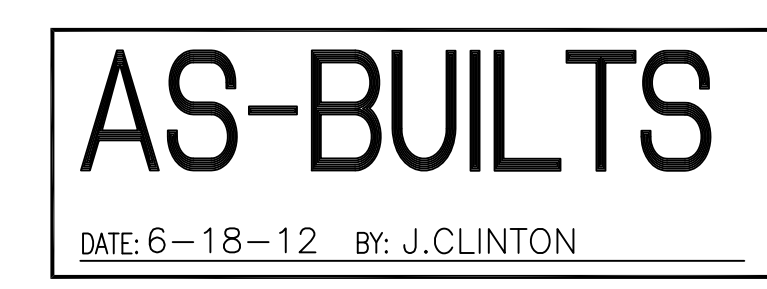

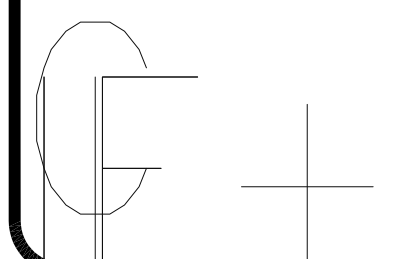

DATE: 6-18-12 BY: J.CLINTON

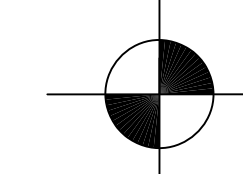

A1

[illegible]

COORD.	SIGNATURE	DATE
McCarthy		
MECHANICAL DUCT		
MECHANICAL PIPE		
PLUMBING		
ELECTRICAL		
FIRE SPRINKLER		
PIPE		
DRYWALL/FRAMER		
REFRIGERATION		
STRUCTURAL		

[illegible]

CHILDREN'S HOSPITAL
OF ORANGE COUNTY
465 S. Main St.
Orange, CA 92668-3974
TOWER II
MECHANICAL PIPE FLOOR PLAN - LEVEL 00 AREA-M

PAN-PACIFIC
PLUMBING & MECHANICAL



Pan Pacific

Murray Company


2919 E. VICTORIA STREET, RANCHO DOMINGUEZ, CA 90221
PH. 310 637-1500 FAX. 310 604-0569

DRAWN SB
CHECKED
M.M.
DATE
9/4/2012
SCALE
1/4" = 1'-0"
JOB NO.
09-006
DRAWING NUMBER
MP3.0M
REFERENCE DRAWING
A3.0M
P3.0M
1 OF 1 SHEETS

This document and the design it covers are the property of Murray Co. They are loaned only with the borrower's expressed written agreement that they will not be reproduced, copied, loaned, exhibited, or used in any other way, except by written consent from Murray Co. to the borrower.

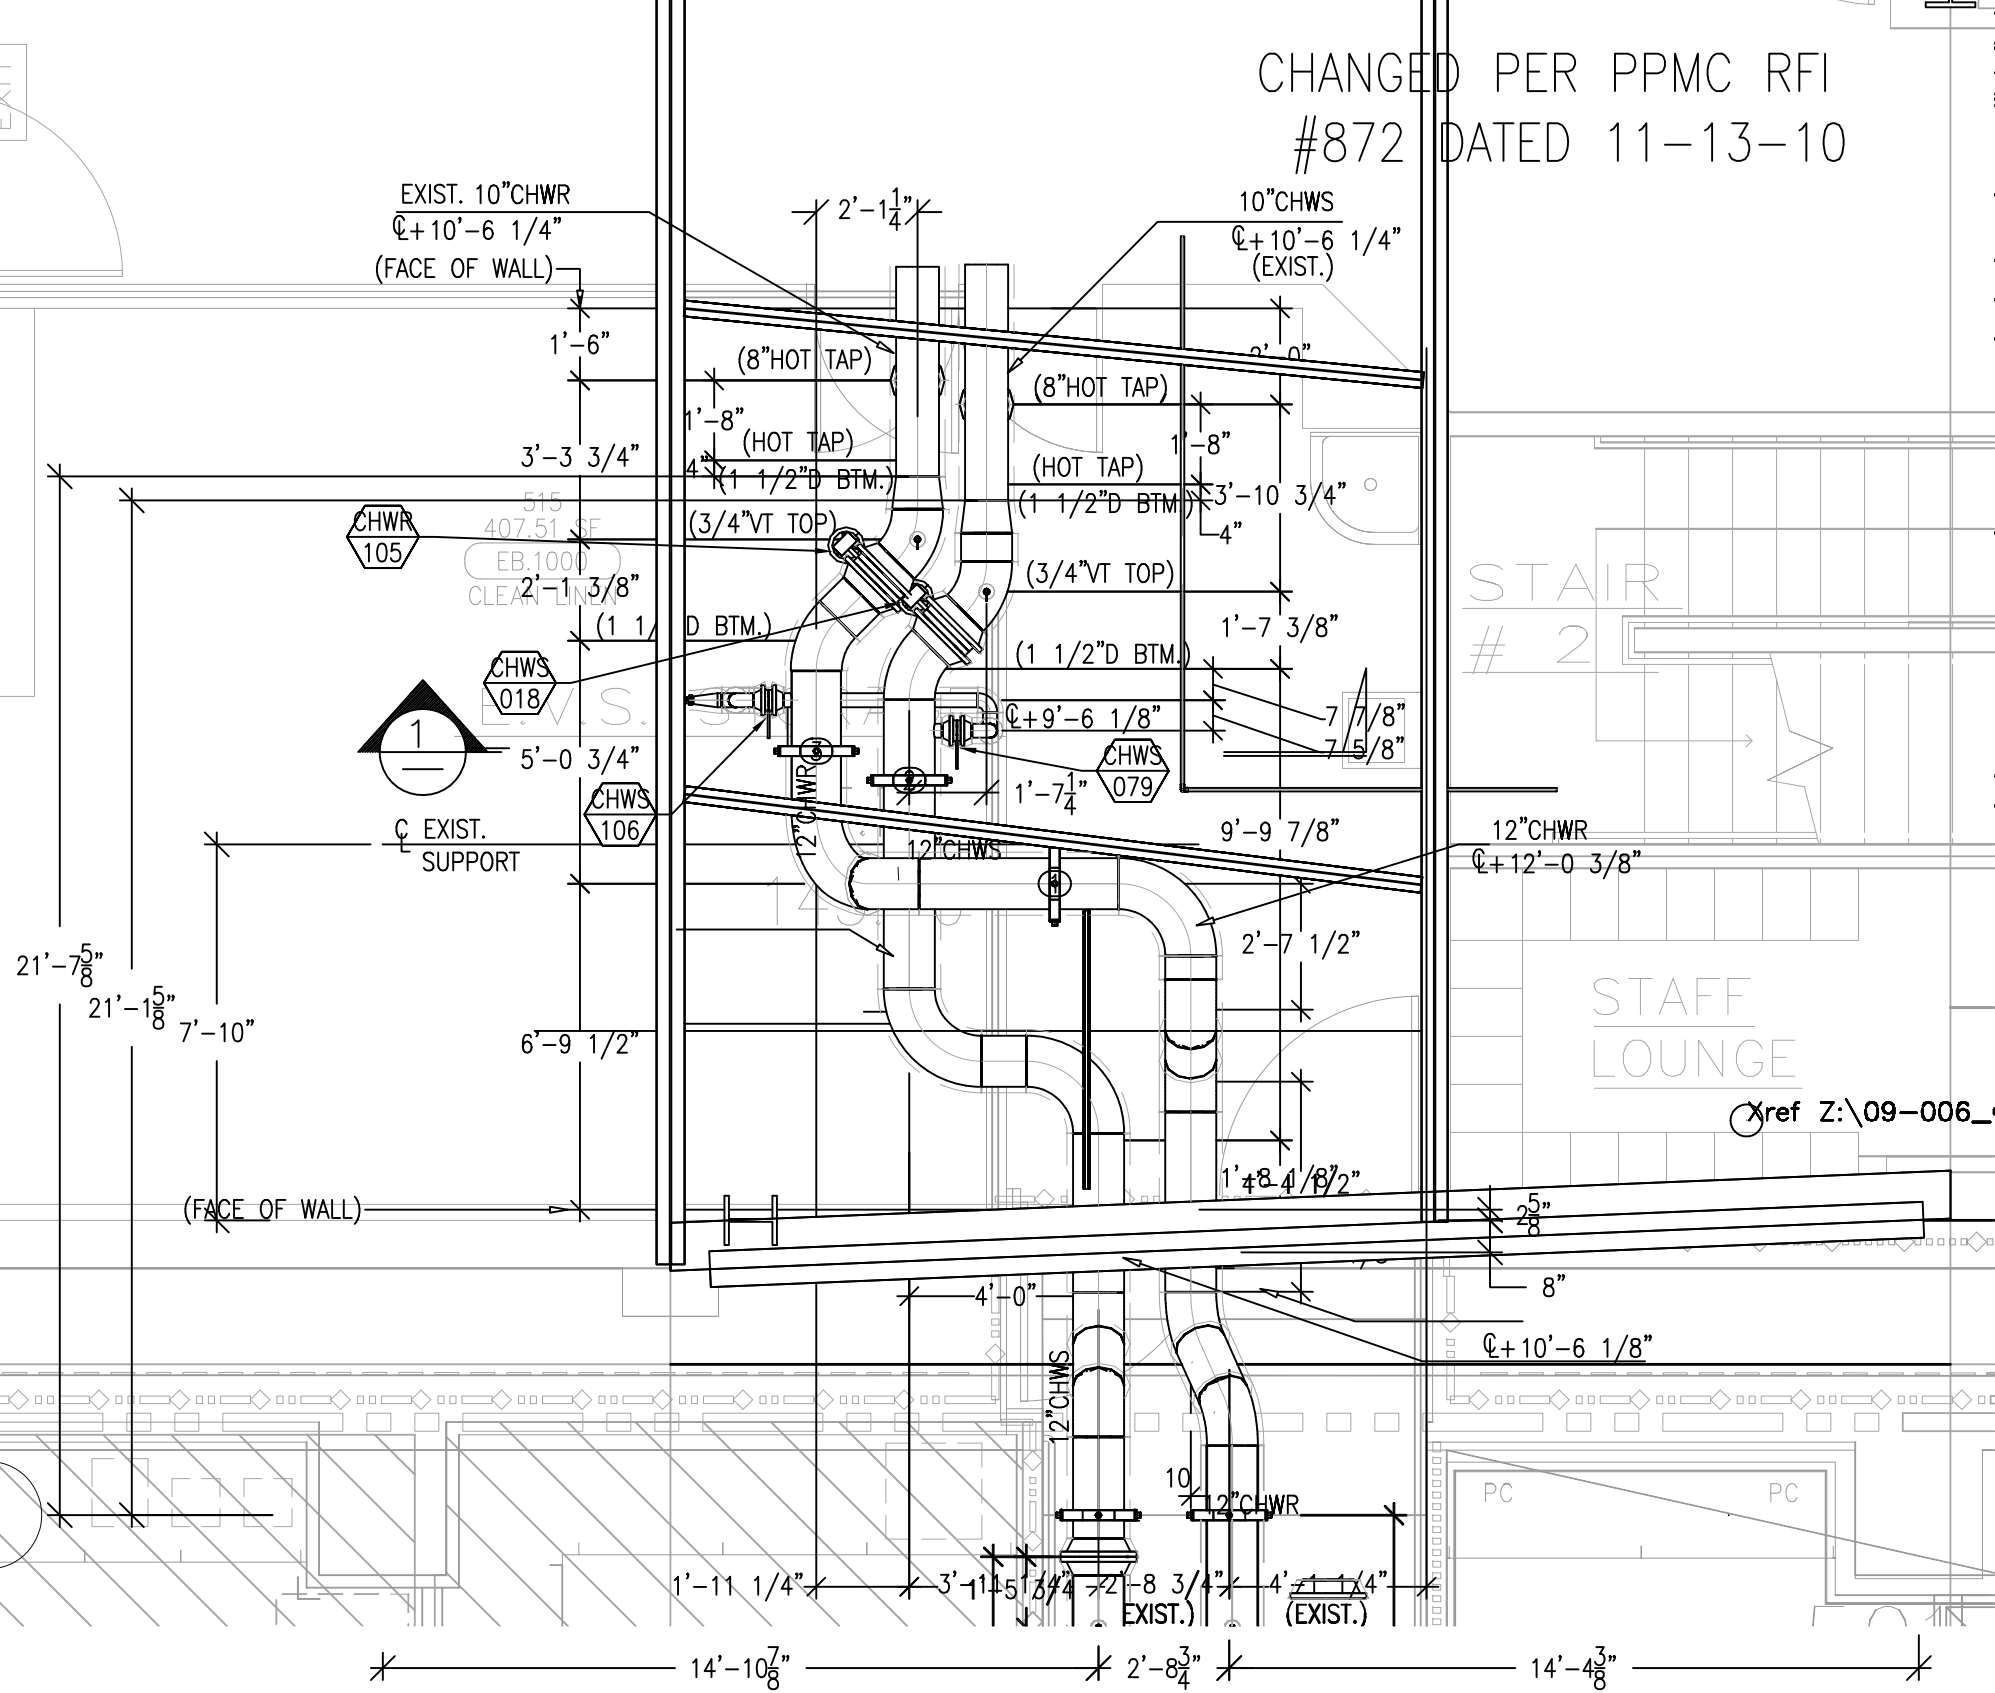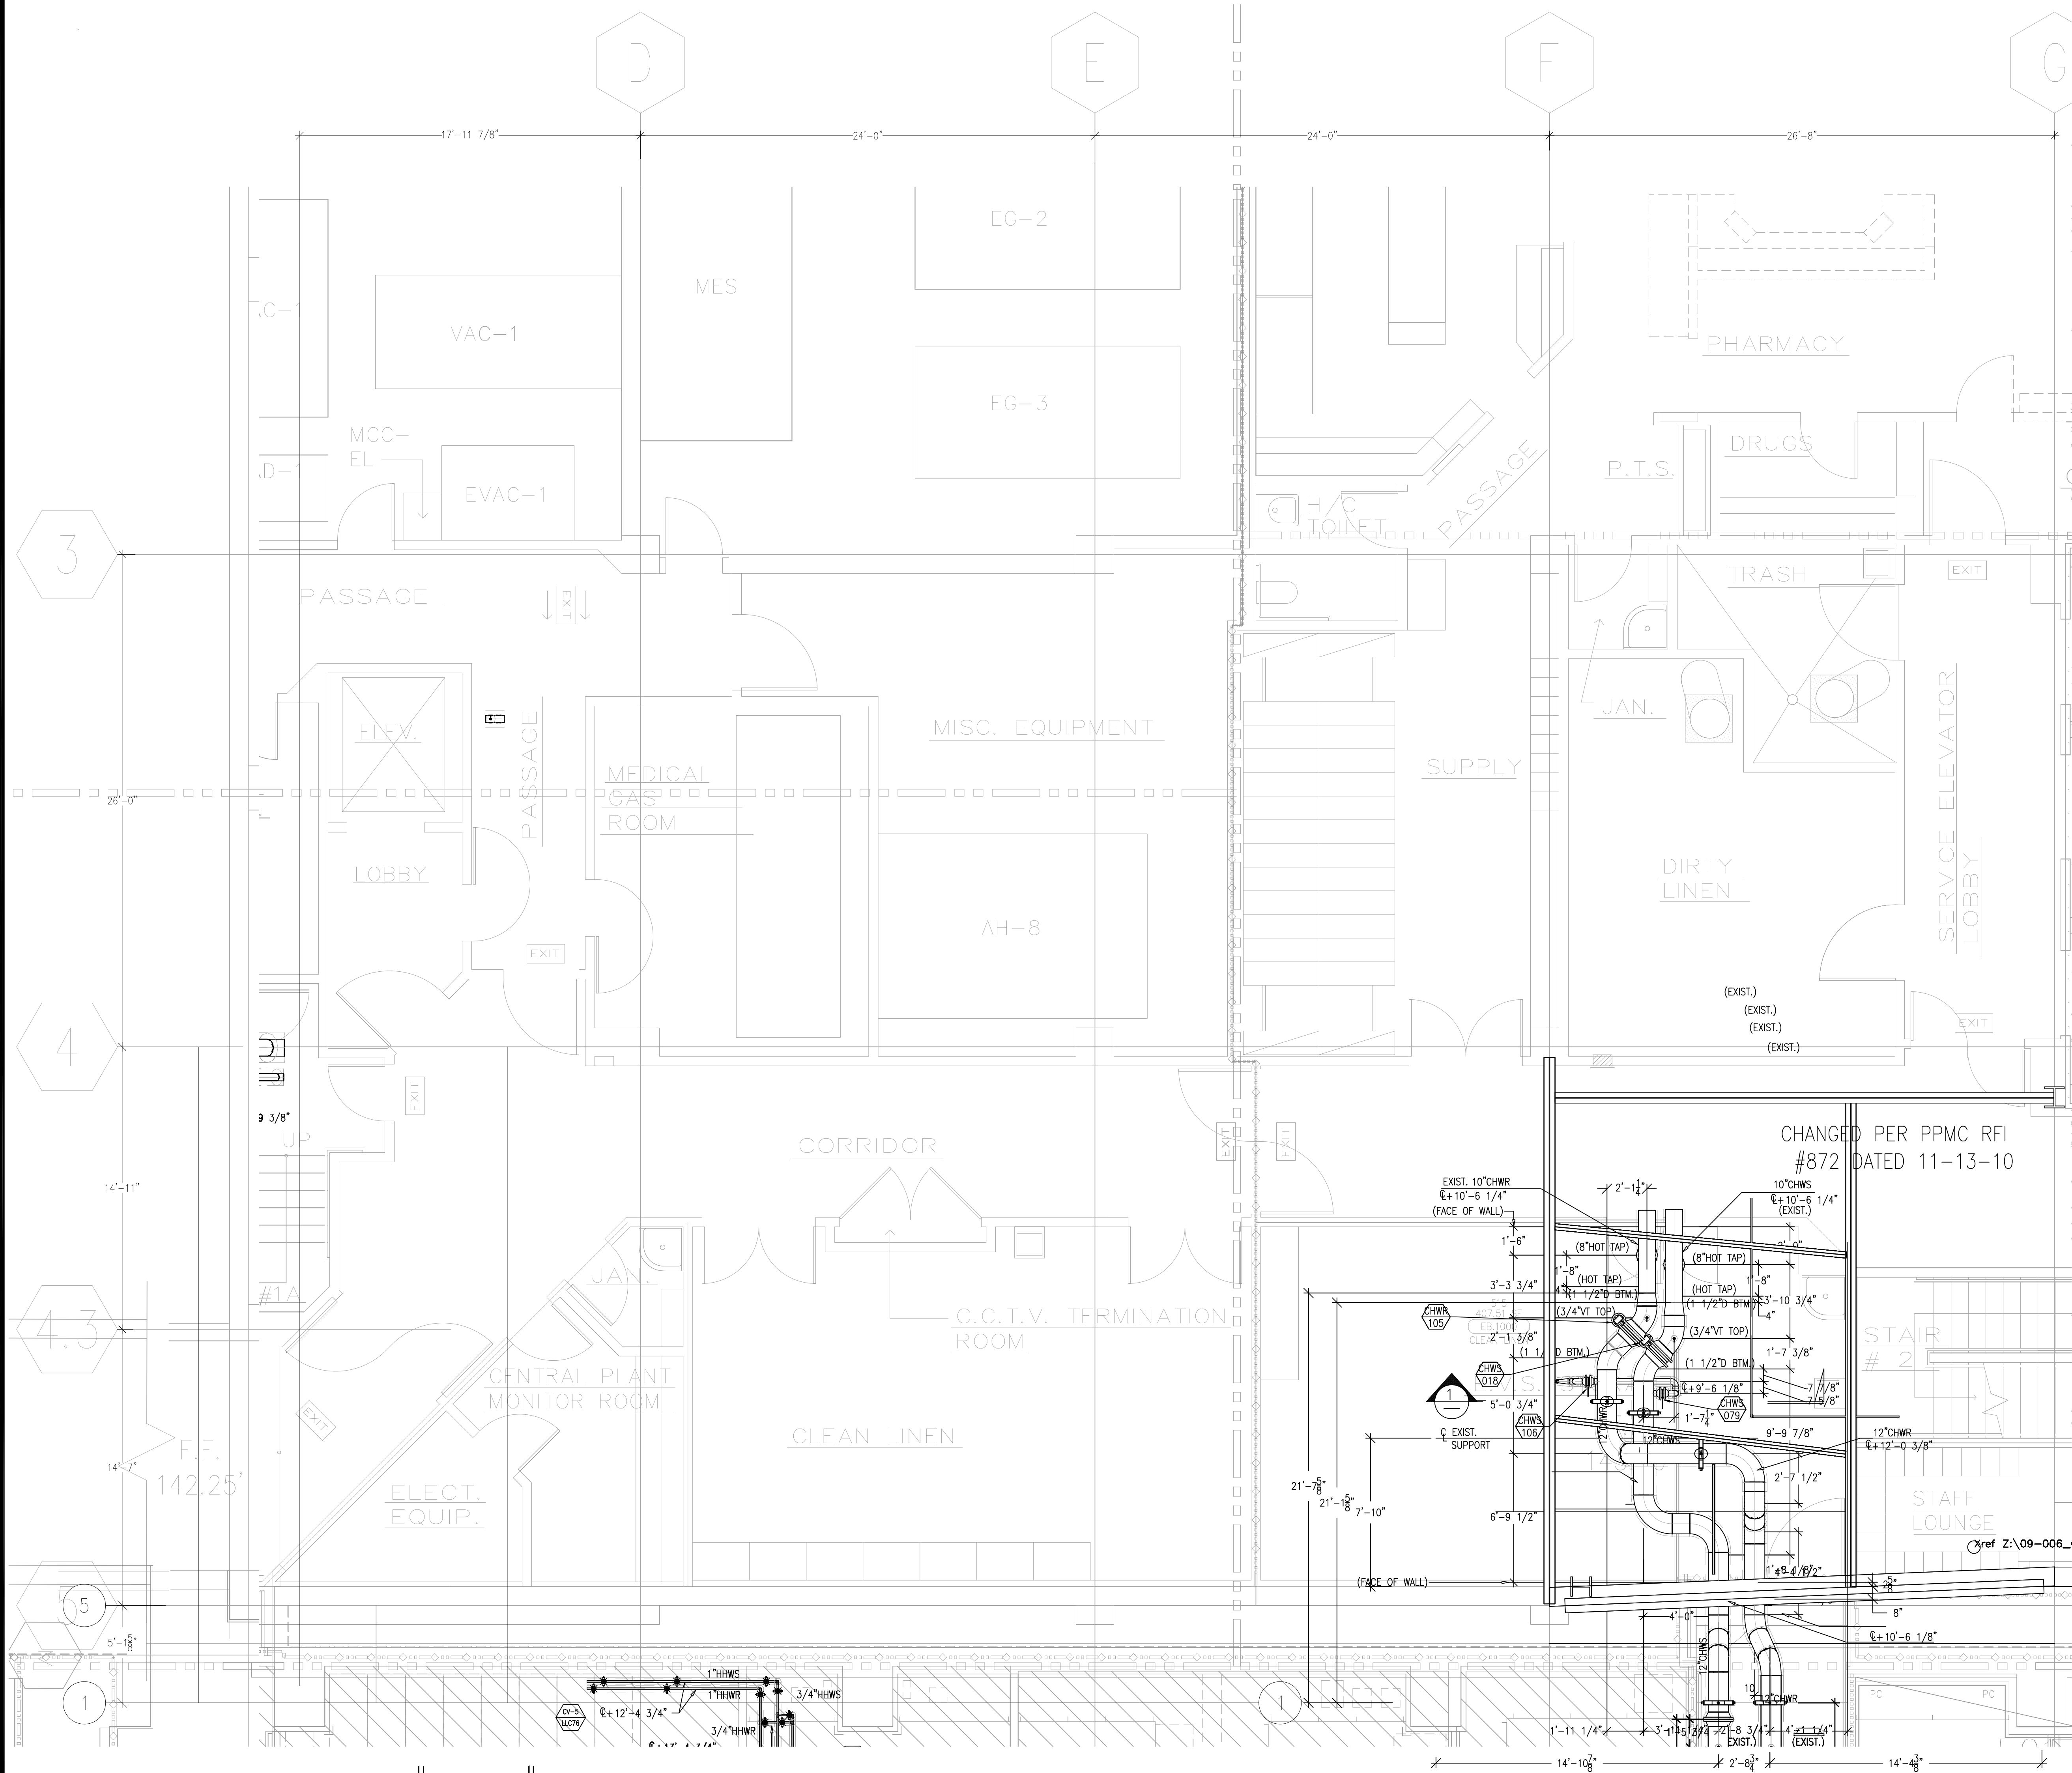

PLAN

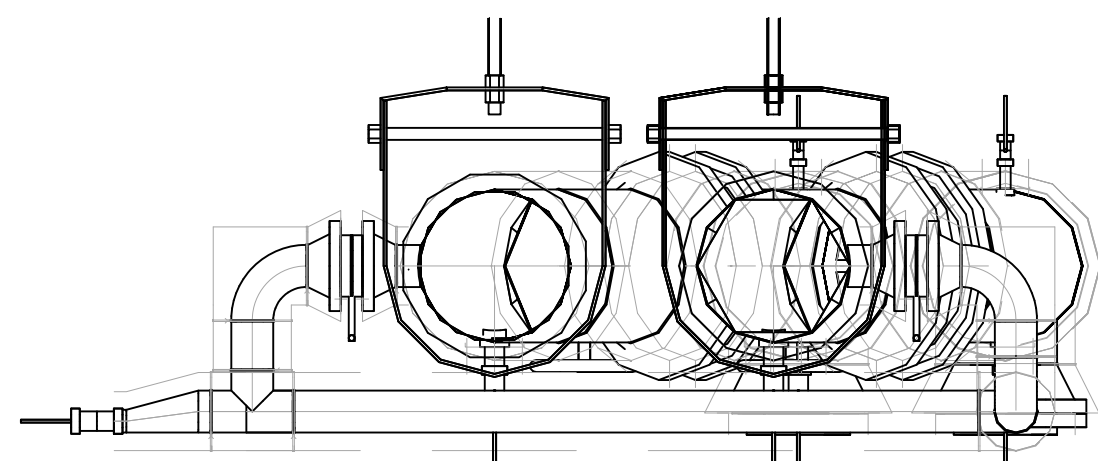


SECTION 1



AS-BUILTS

DATE: 6-18-12 BY: J. CLINTON

LEVEL 00 144.30' = 0'-0"
REFERENCE THIS SHEET

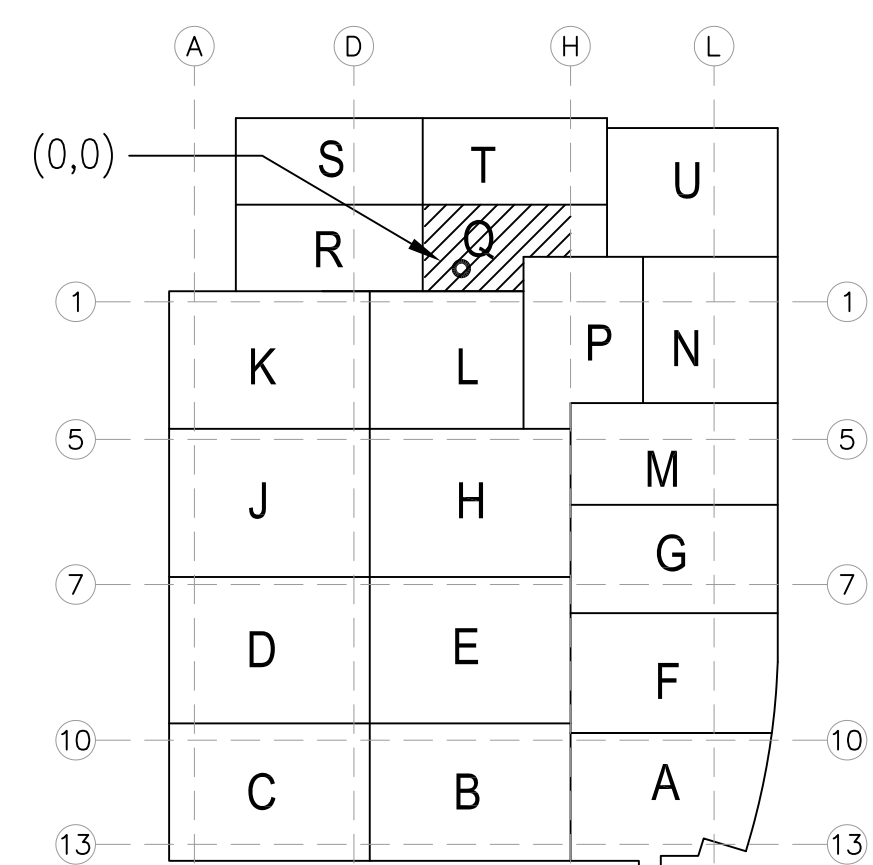

KEY PLAN

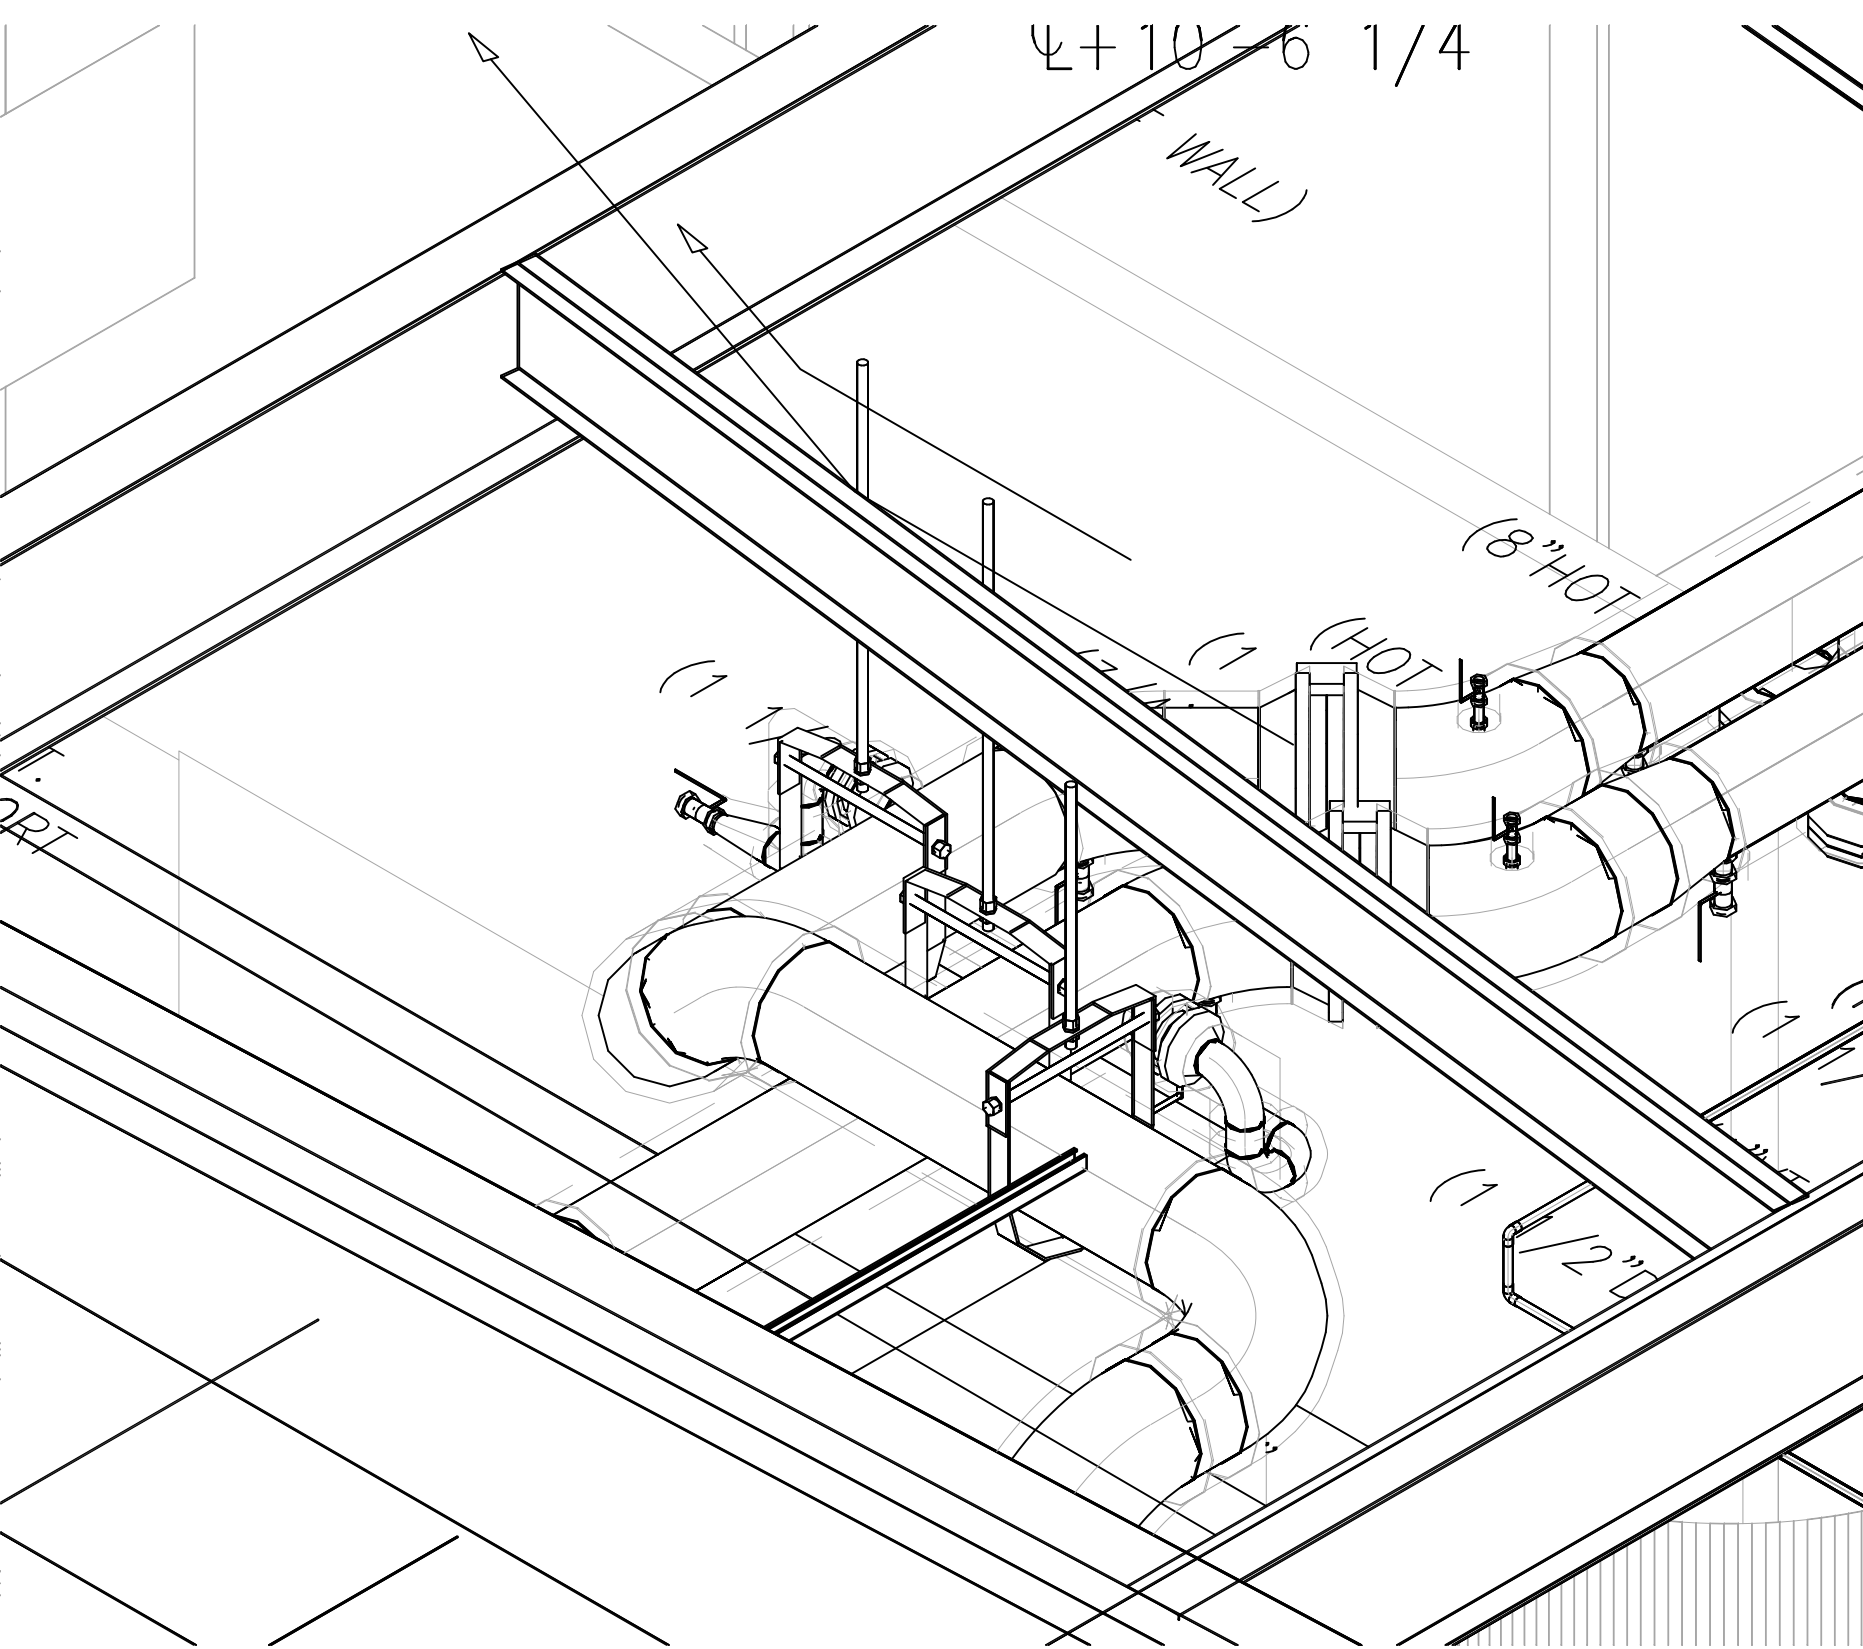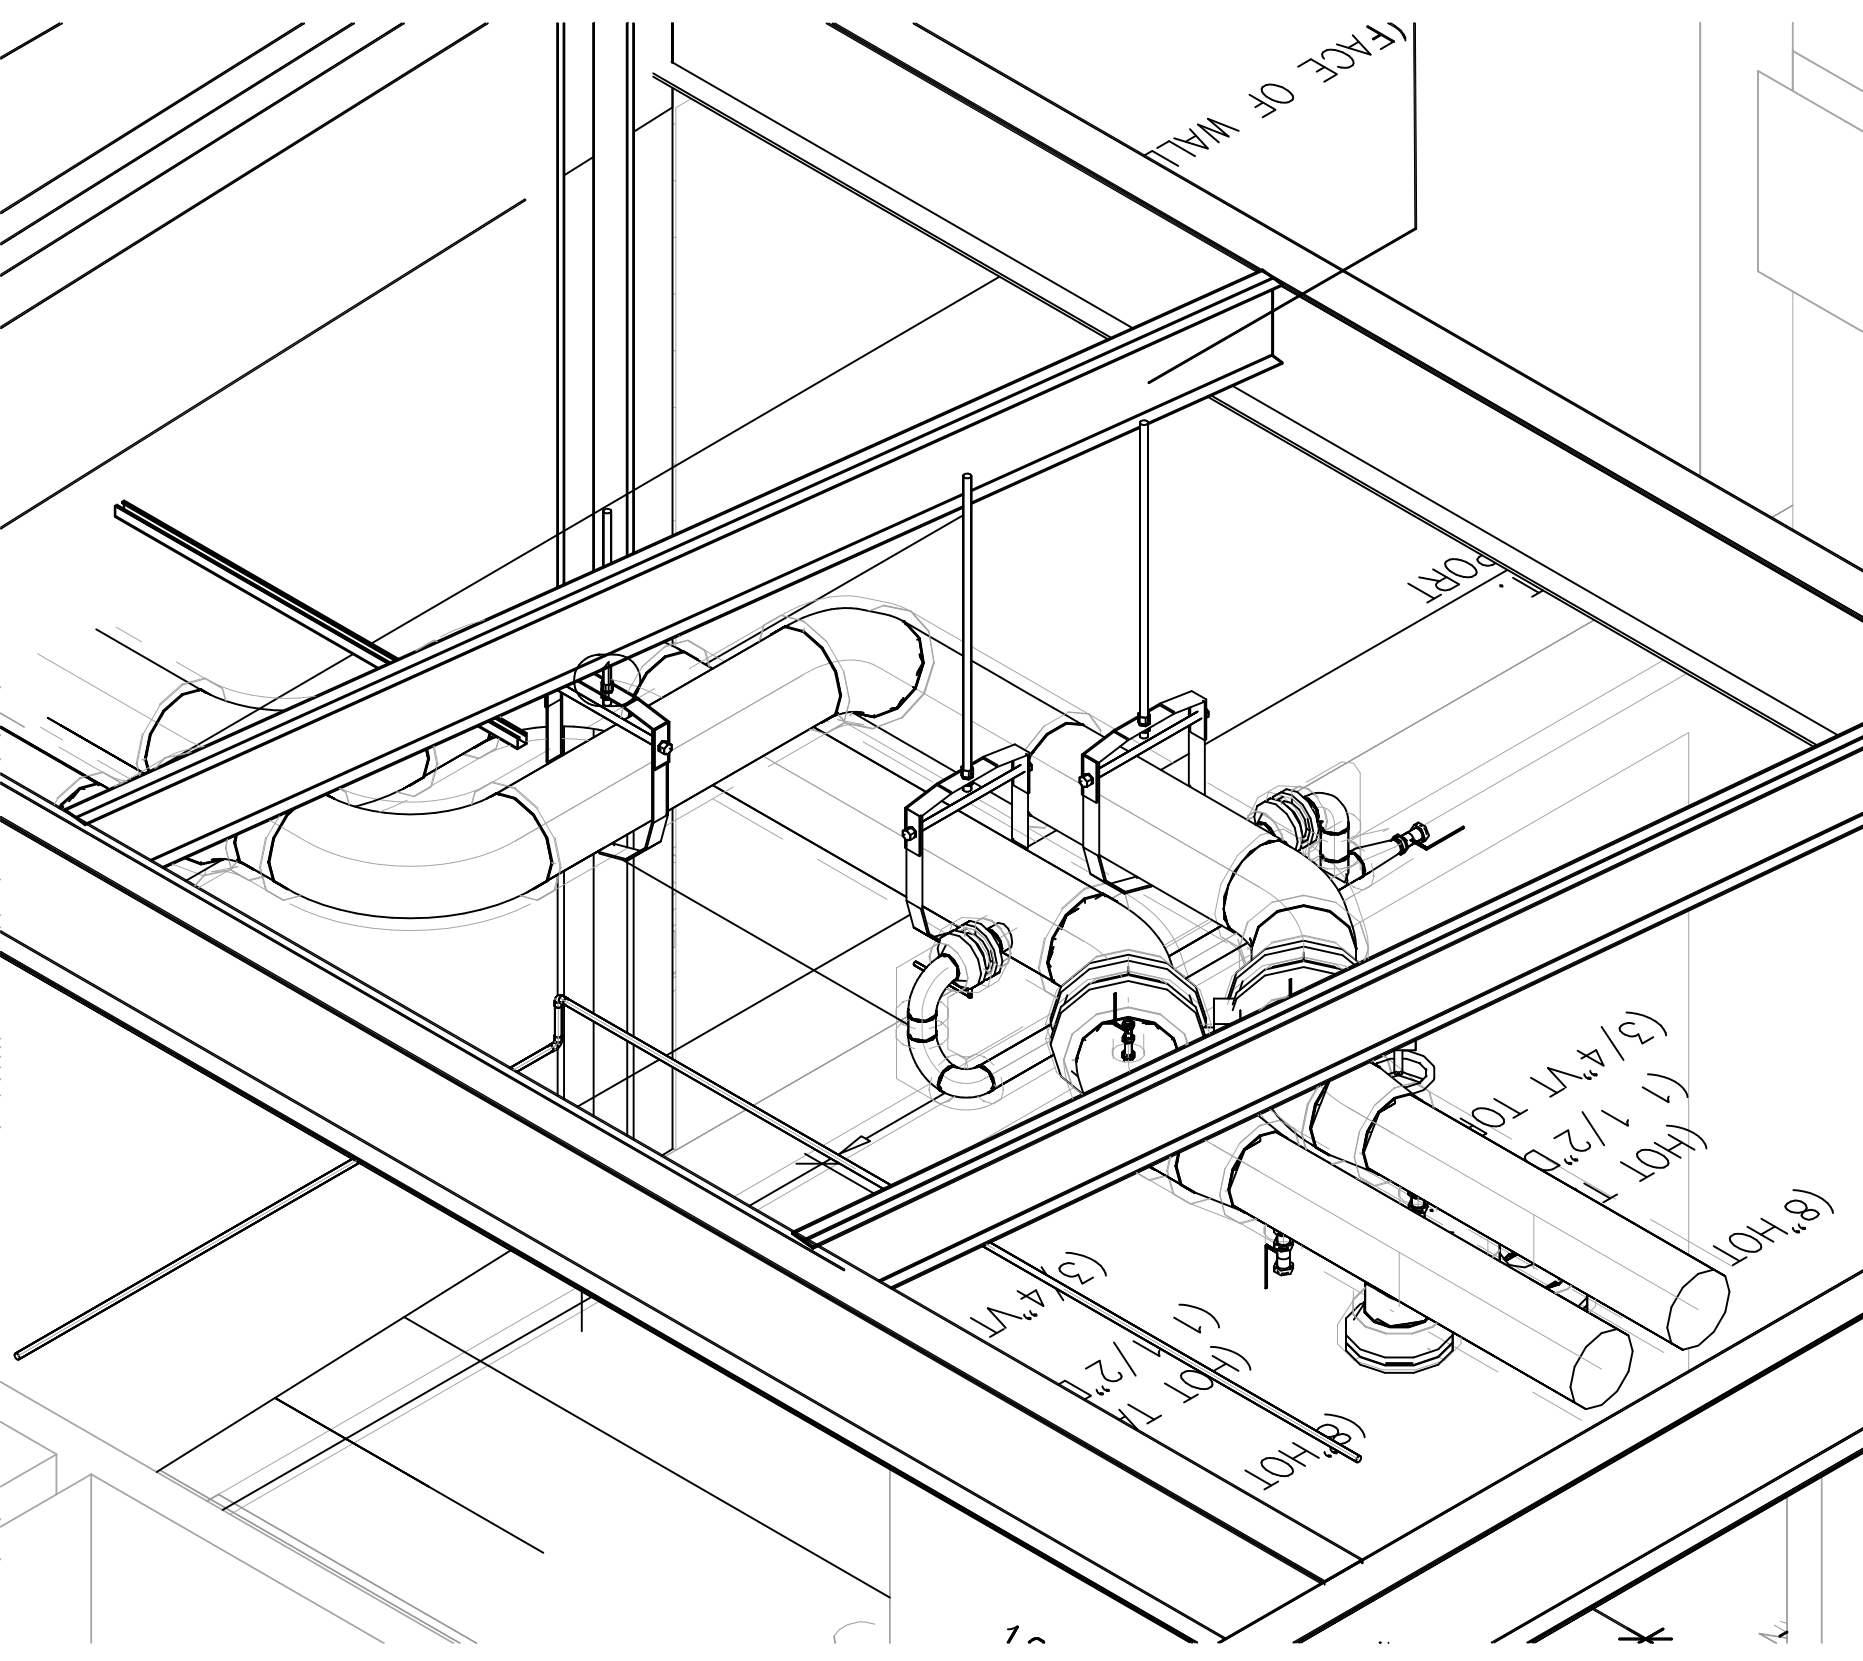

REVISIONS	BY

COORD.	SIGNATURE	DATE
MECHANICAL		
ELECTRICAL		
PLUMBING		
STRUCTURAL		


ANS.	SENT	R.F.I.	ANS.	SENT	R.F.I.	ANS.	SENT	R.F.I.	ANS.	SENT	R.F.I.

CHILDREN'S HOSPITAL
OF ORANGE COUNTY
2919 E. VICTORIA STREET, RANCHO DOMINGUEZ, CA 90221
PH. 310 637-1500 FAX 310 604-0359


PAN-PACIFIC
PLUMBING & MECHANICAL
Murray Company
2919 E. VICTORIA STREET, RANCHO DOMINGUEZ, CA 90221
PH. 310 637-1500 FAX 310 604-0359

DRAWN
R.O.
CHECKED
M.M.
DATE
9/4/2012
SCALE
1/4" = 1'-0"
JOB NO.
09-006
DRAWING NUMBER
MP3.0Q
REFERENCE DRAWING
A3.0Q
P3.0Q
1 OF 1 SHEETS



This document and the design it covers are the property of Murray Co. They are loaned only with the borrower's expressed written agreement that they will not be reproduced, copied, loaned, exhibited, or used in any other way, except by written consent from Murray Co. to the borrower.

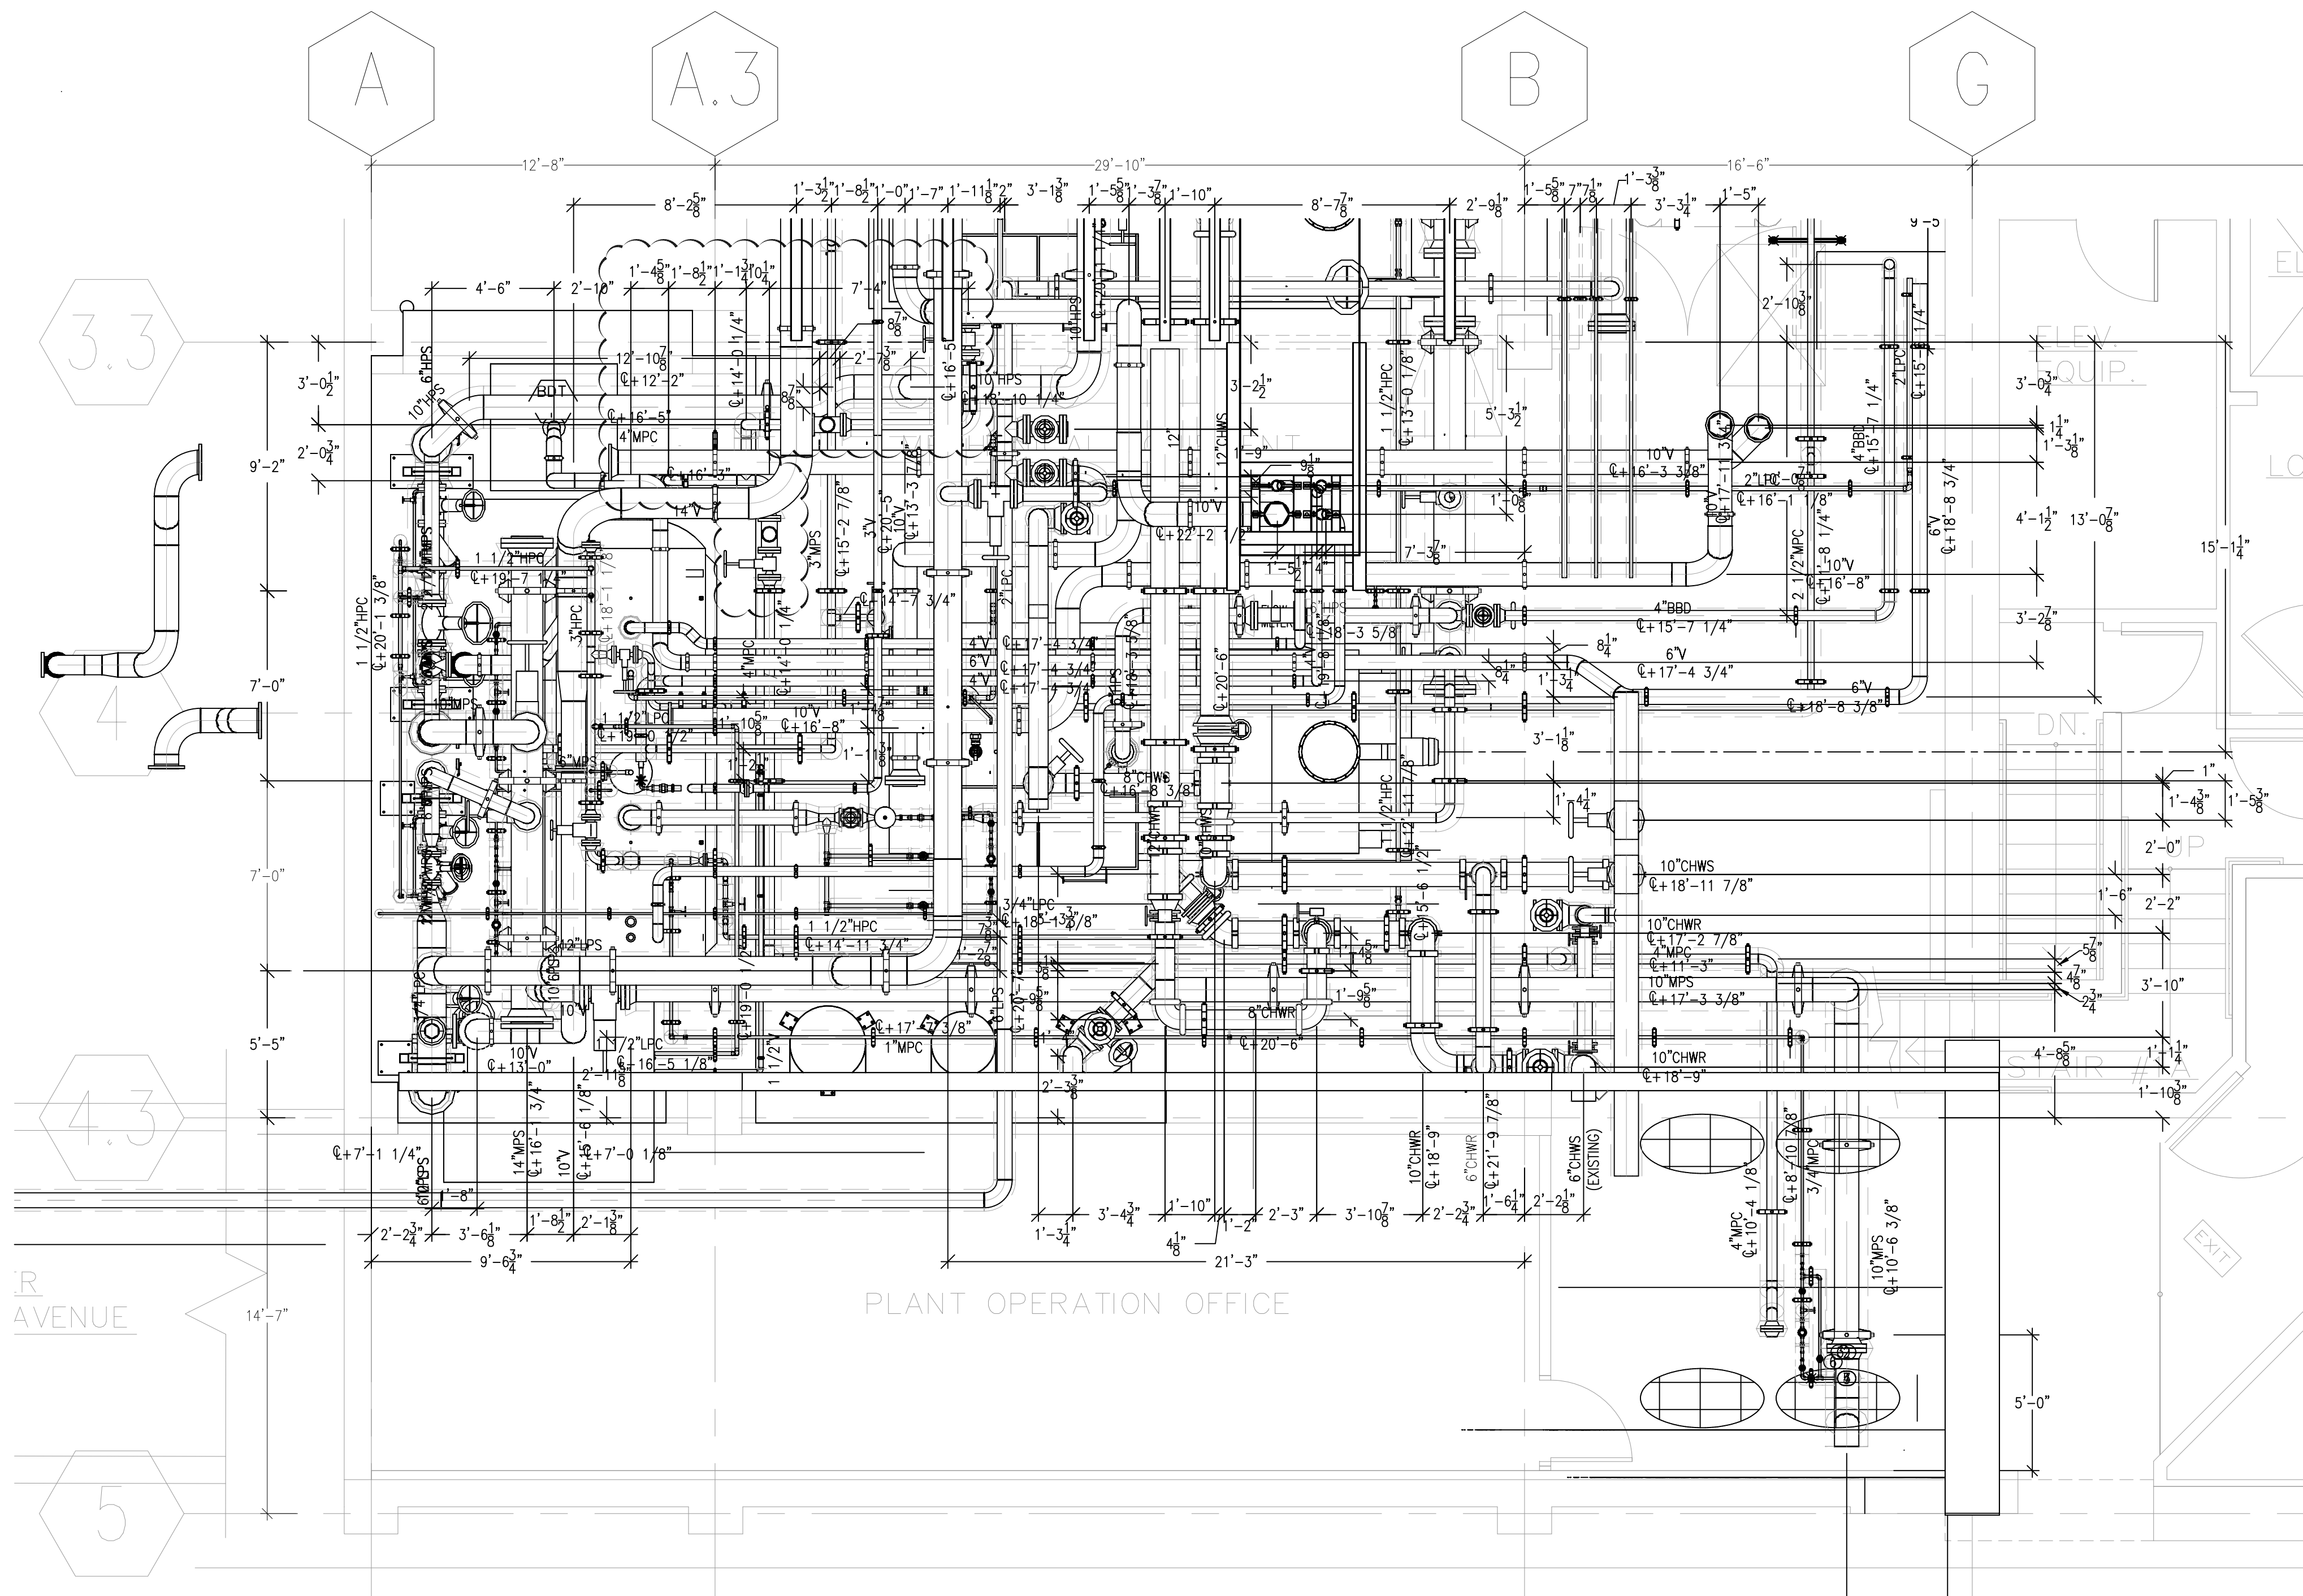

PLAN VIEW

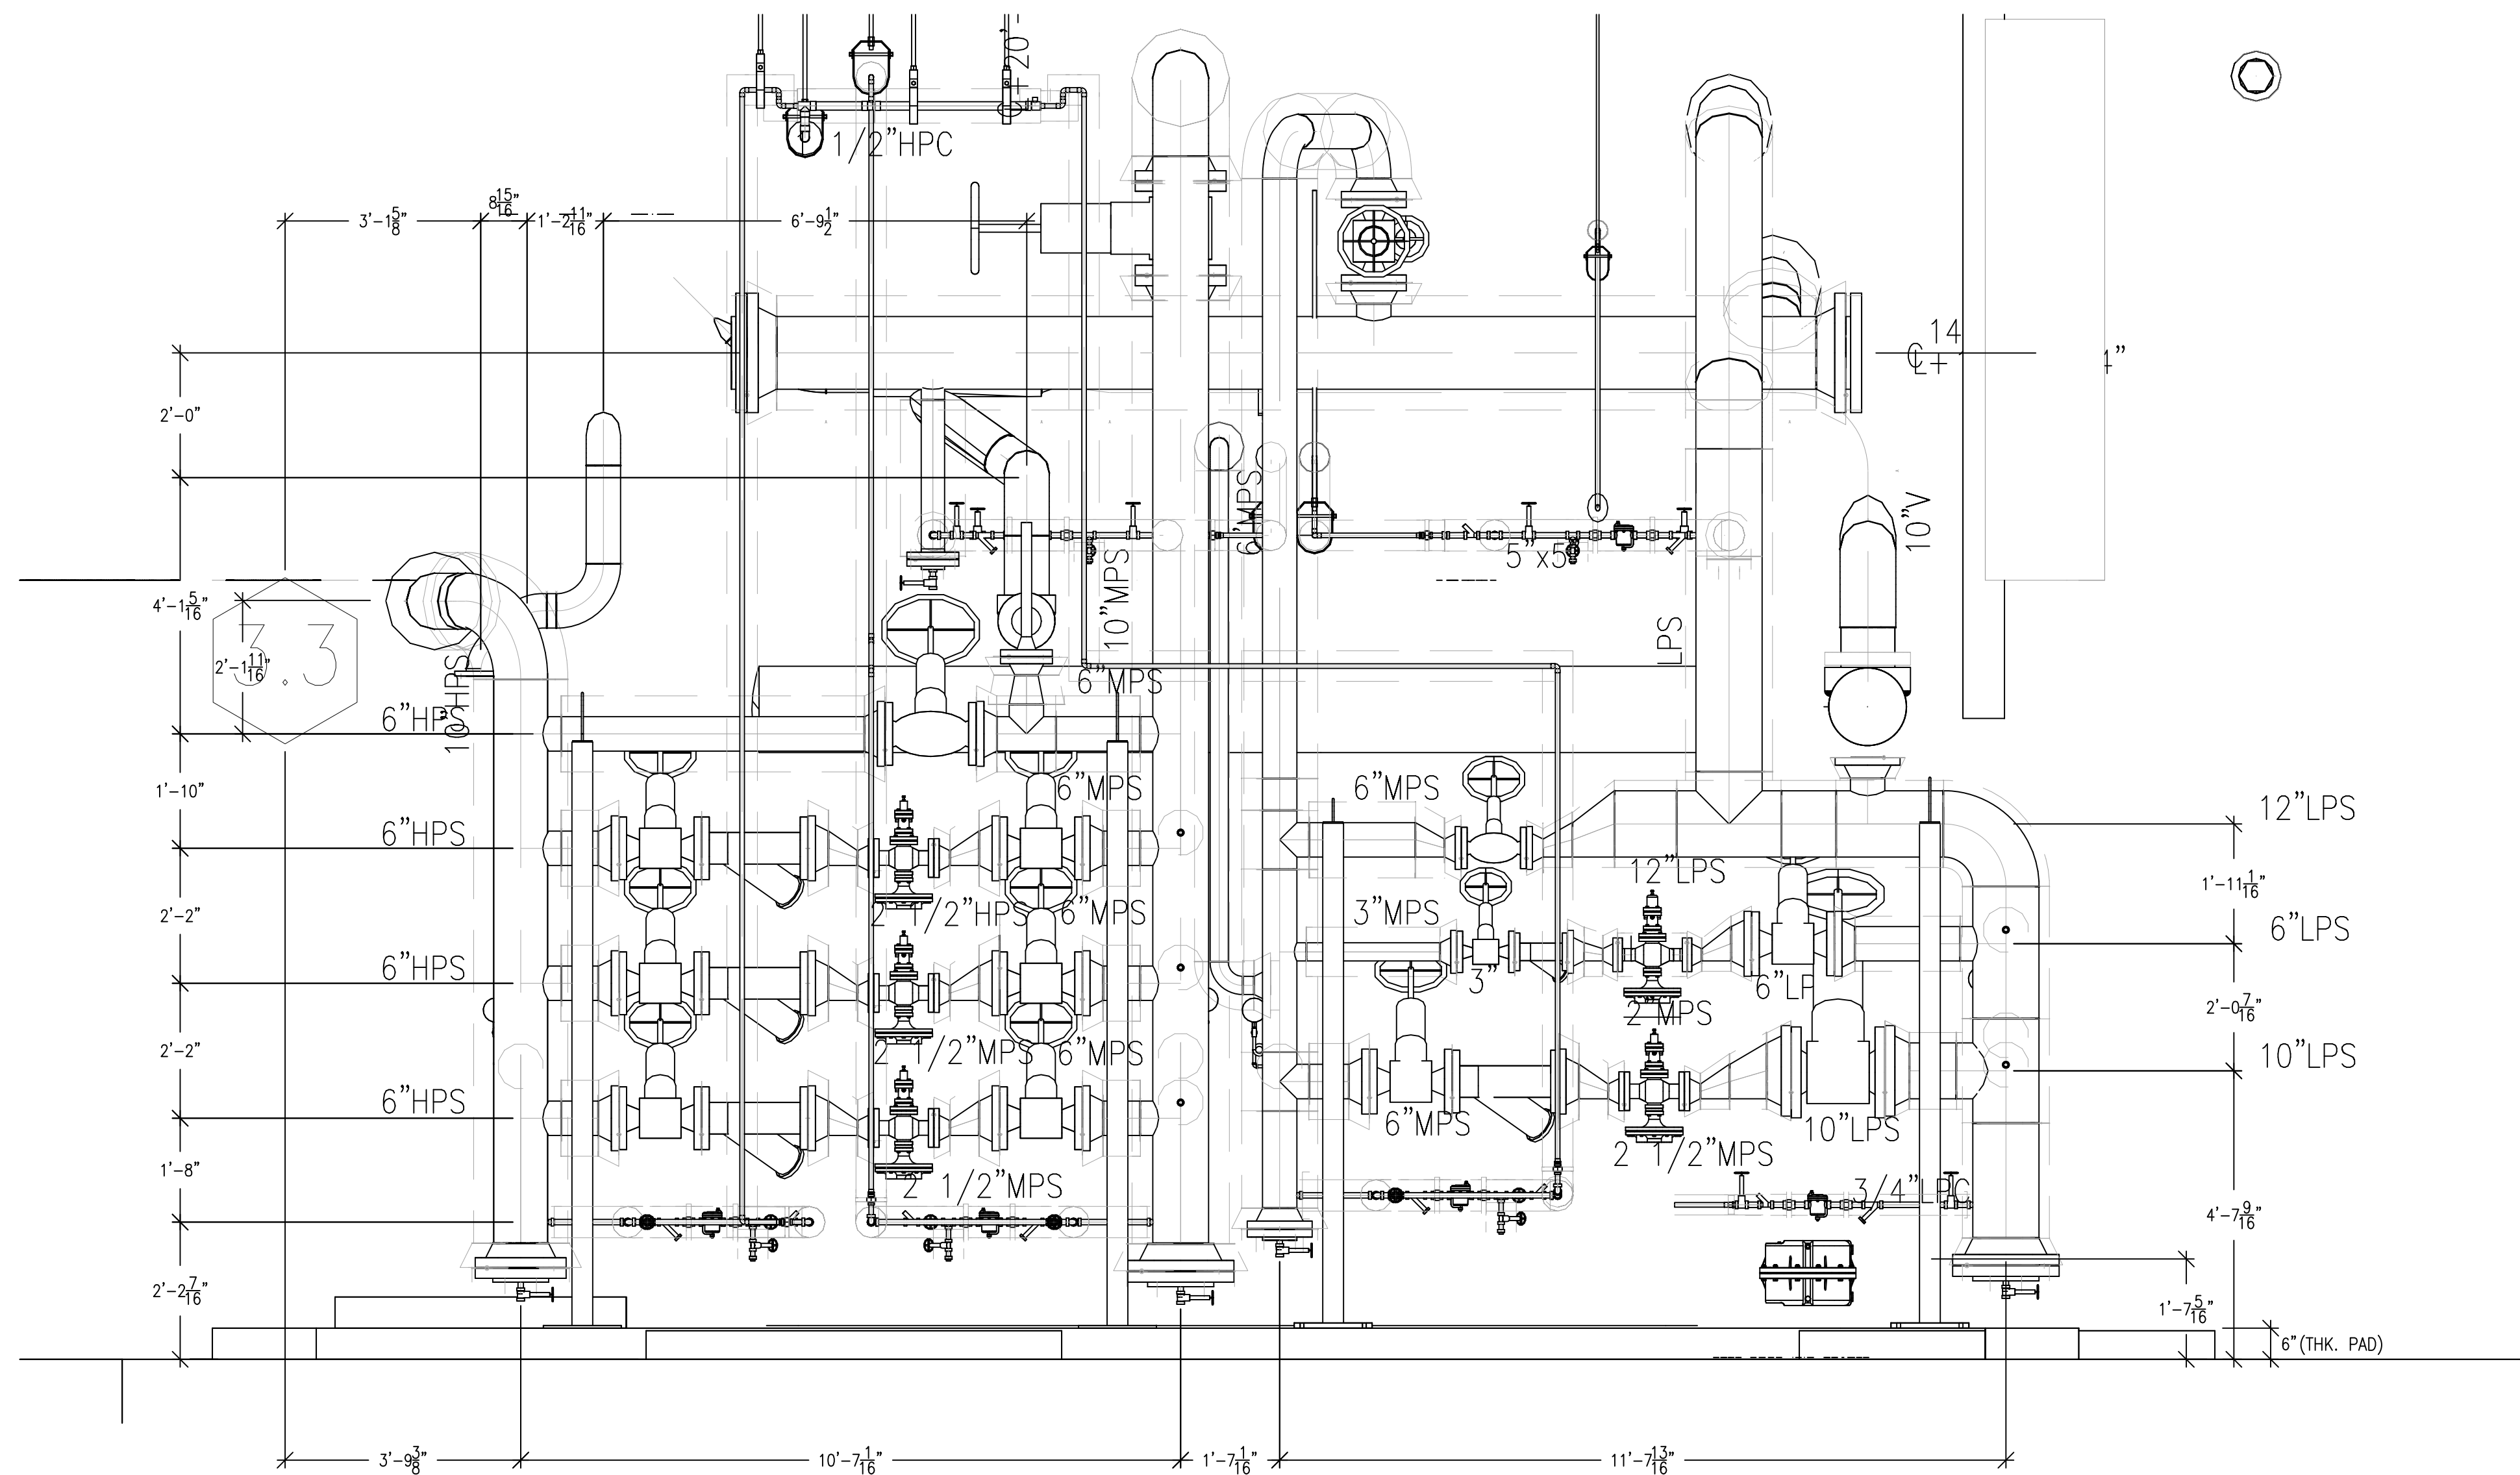

SECTION

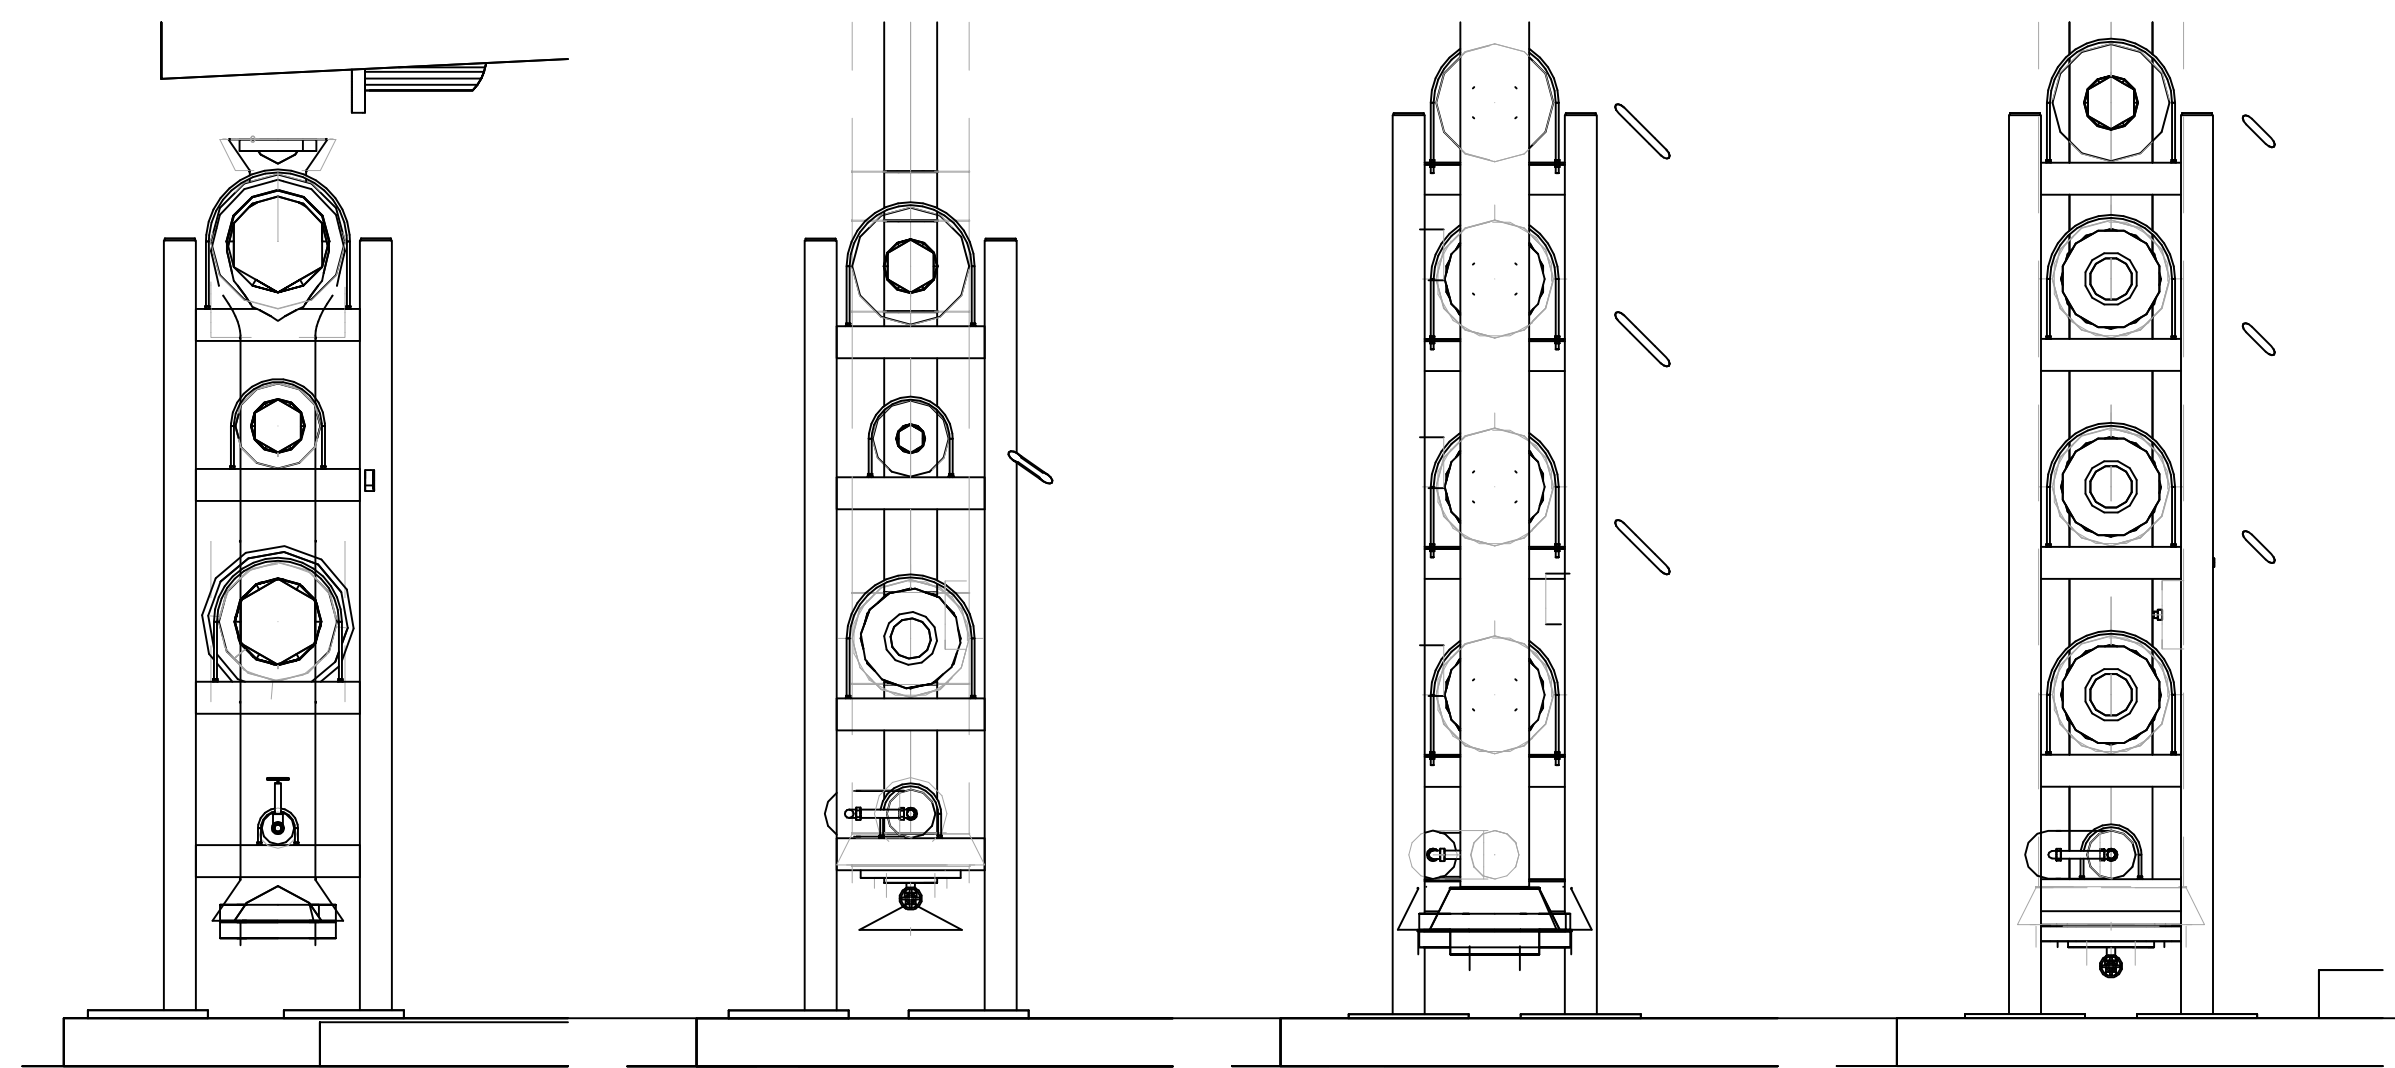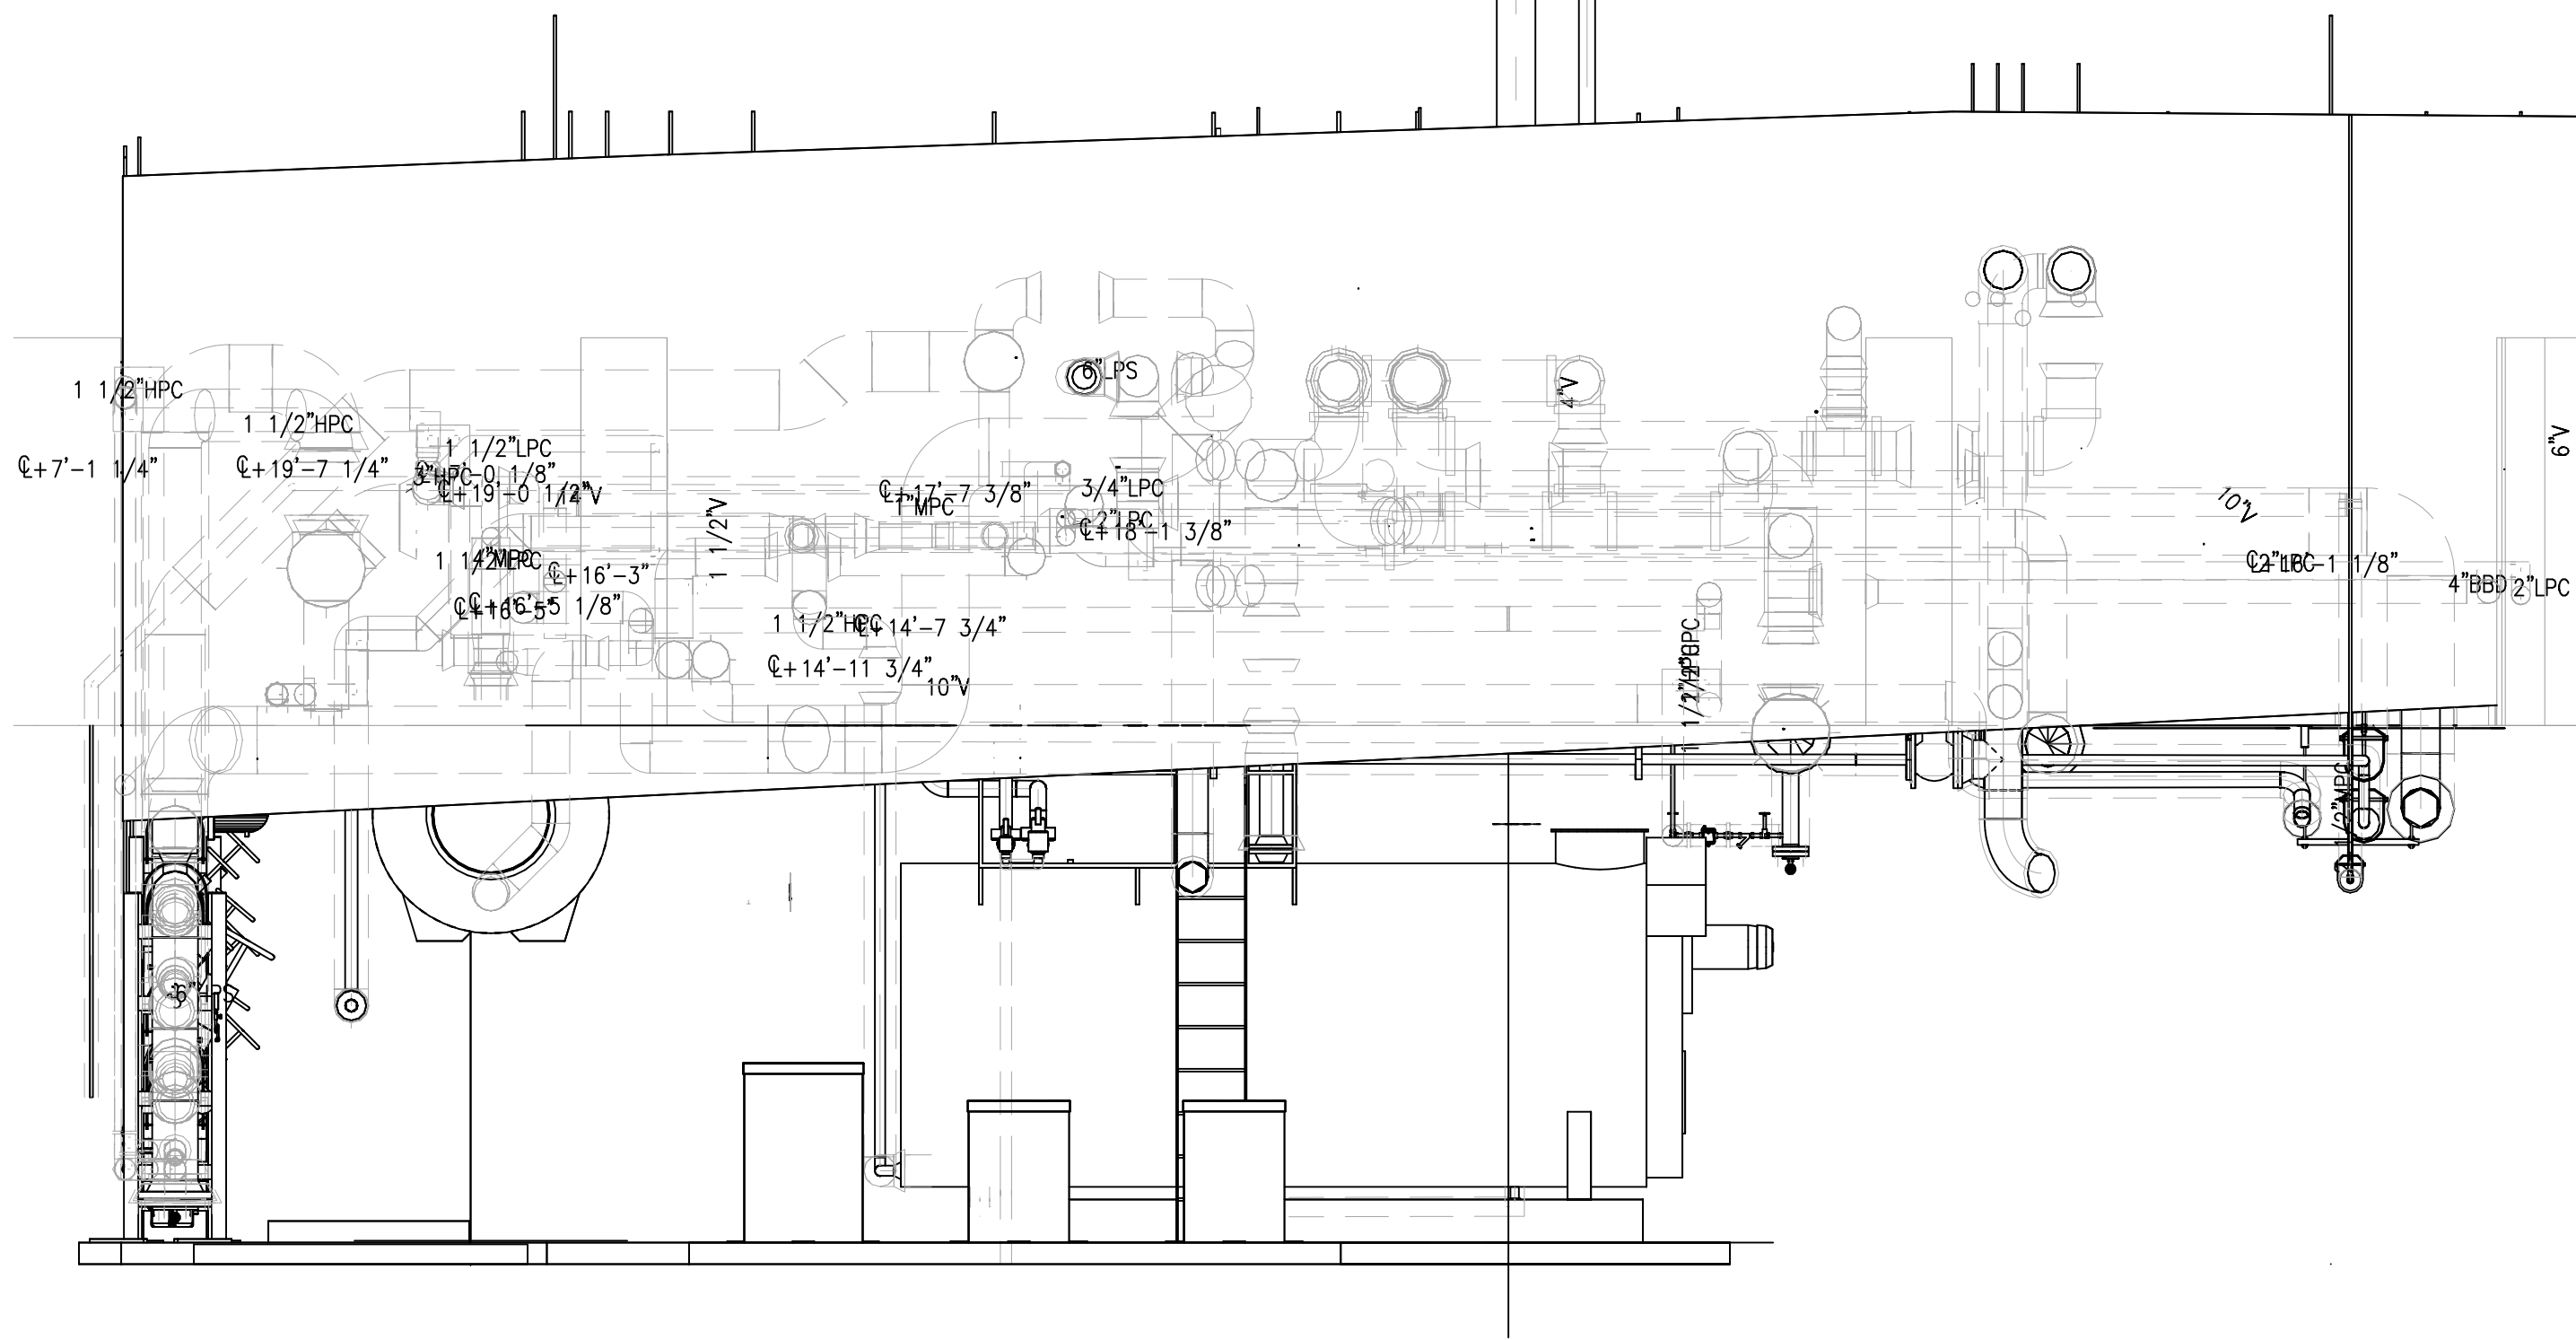

SECTION


SECTION

SECTION

SECTION

AS-BUILTS

DATE: 6-18-12 BY: J. CLINTON

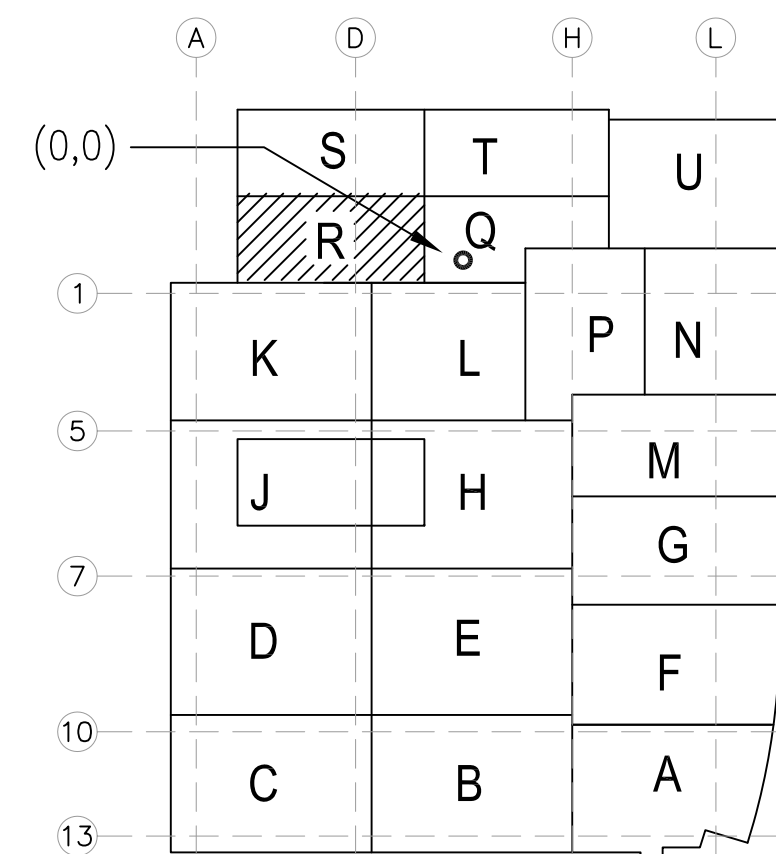

KEY PLAN

LEVEL 00 144.30' = 0'-0"
REFERENCE THIS SHEET

REVISIONS	BY

COORD.	DATE	SIGNATURE
MECHANICAL		
ELECTRICAL		
PLUMBING		
STRUCTURAL		


COORD.	DATE	SIGNATURE
MECHANICAL		
ELECTRICAL		
PLUMBING		
STRUCTURAL		

CHILDREN'S HOSPITAL
OF ORANGE COUNTY
455 S. MAIN ST.
ORANGE, CA 92668-9874
TOWER II
PLUMBING FLOOR PLAN - LEVEL 00 REAR

PAN-PACIFIC
PLUMBING & MECHANICAL
2919 E. VICTORIA STREET, RANCHO DOMINGUEZ, CA 90221
PH. 310 637-1500 FAX 310 604-0359

DRAWN
T.C.
CHECKED
M.M.
DATE
9/4/2012
SCALE
1/4"=1'-0"
JOB NO.
09-006
DRAWING NUMBER
MP3.0R
REFERENCE DRAWING
A3.0R
P3.0R
1 OF 1 SHEETS

LEVEL BOILER ROOM
131.80' = 0'-0" (-12'-6" FROM LL)
REFERENCE THIS SHEET

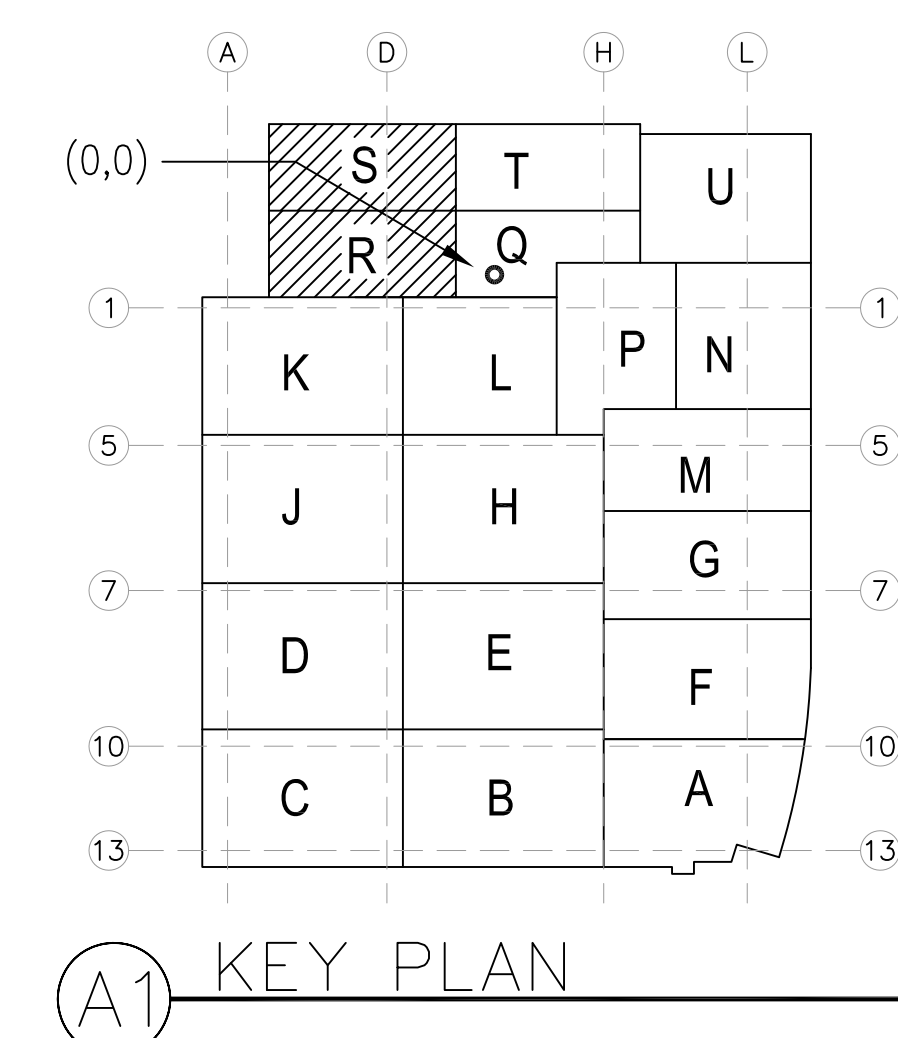

DRAWN
 T.C.
 CHECKED
 M.M.
 DATE
 9/4/2012
 SCALE
 $1/4" = 1' - 0"$
 JOB NO.
 09-006
 DRAWING NUMBER
 AREA_R_S
 REFERENCE DRAWING
 A3.0S
 P3.0S
 1 OF 1 SHEETS