



This document and the design it covers are the property of Murray Co. They are loaned only with the borrower's expressed written agreement that they will not be reproduced, copied, loaned, exhibited, or used in any way, except by written consent from Murray Co. to the borrower.

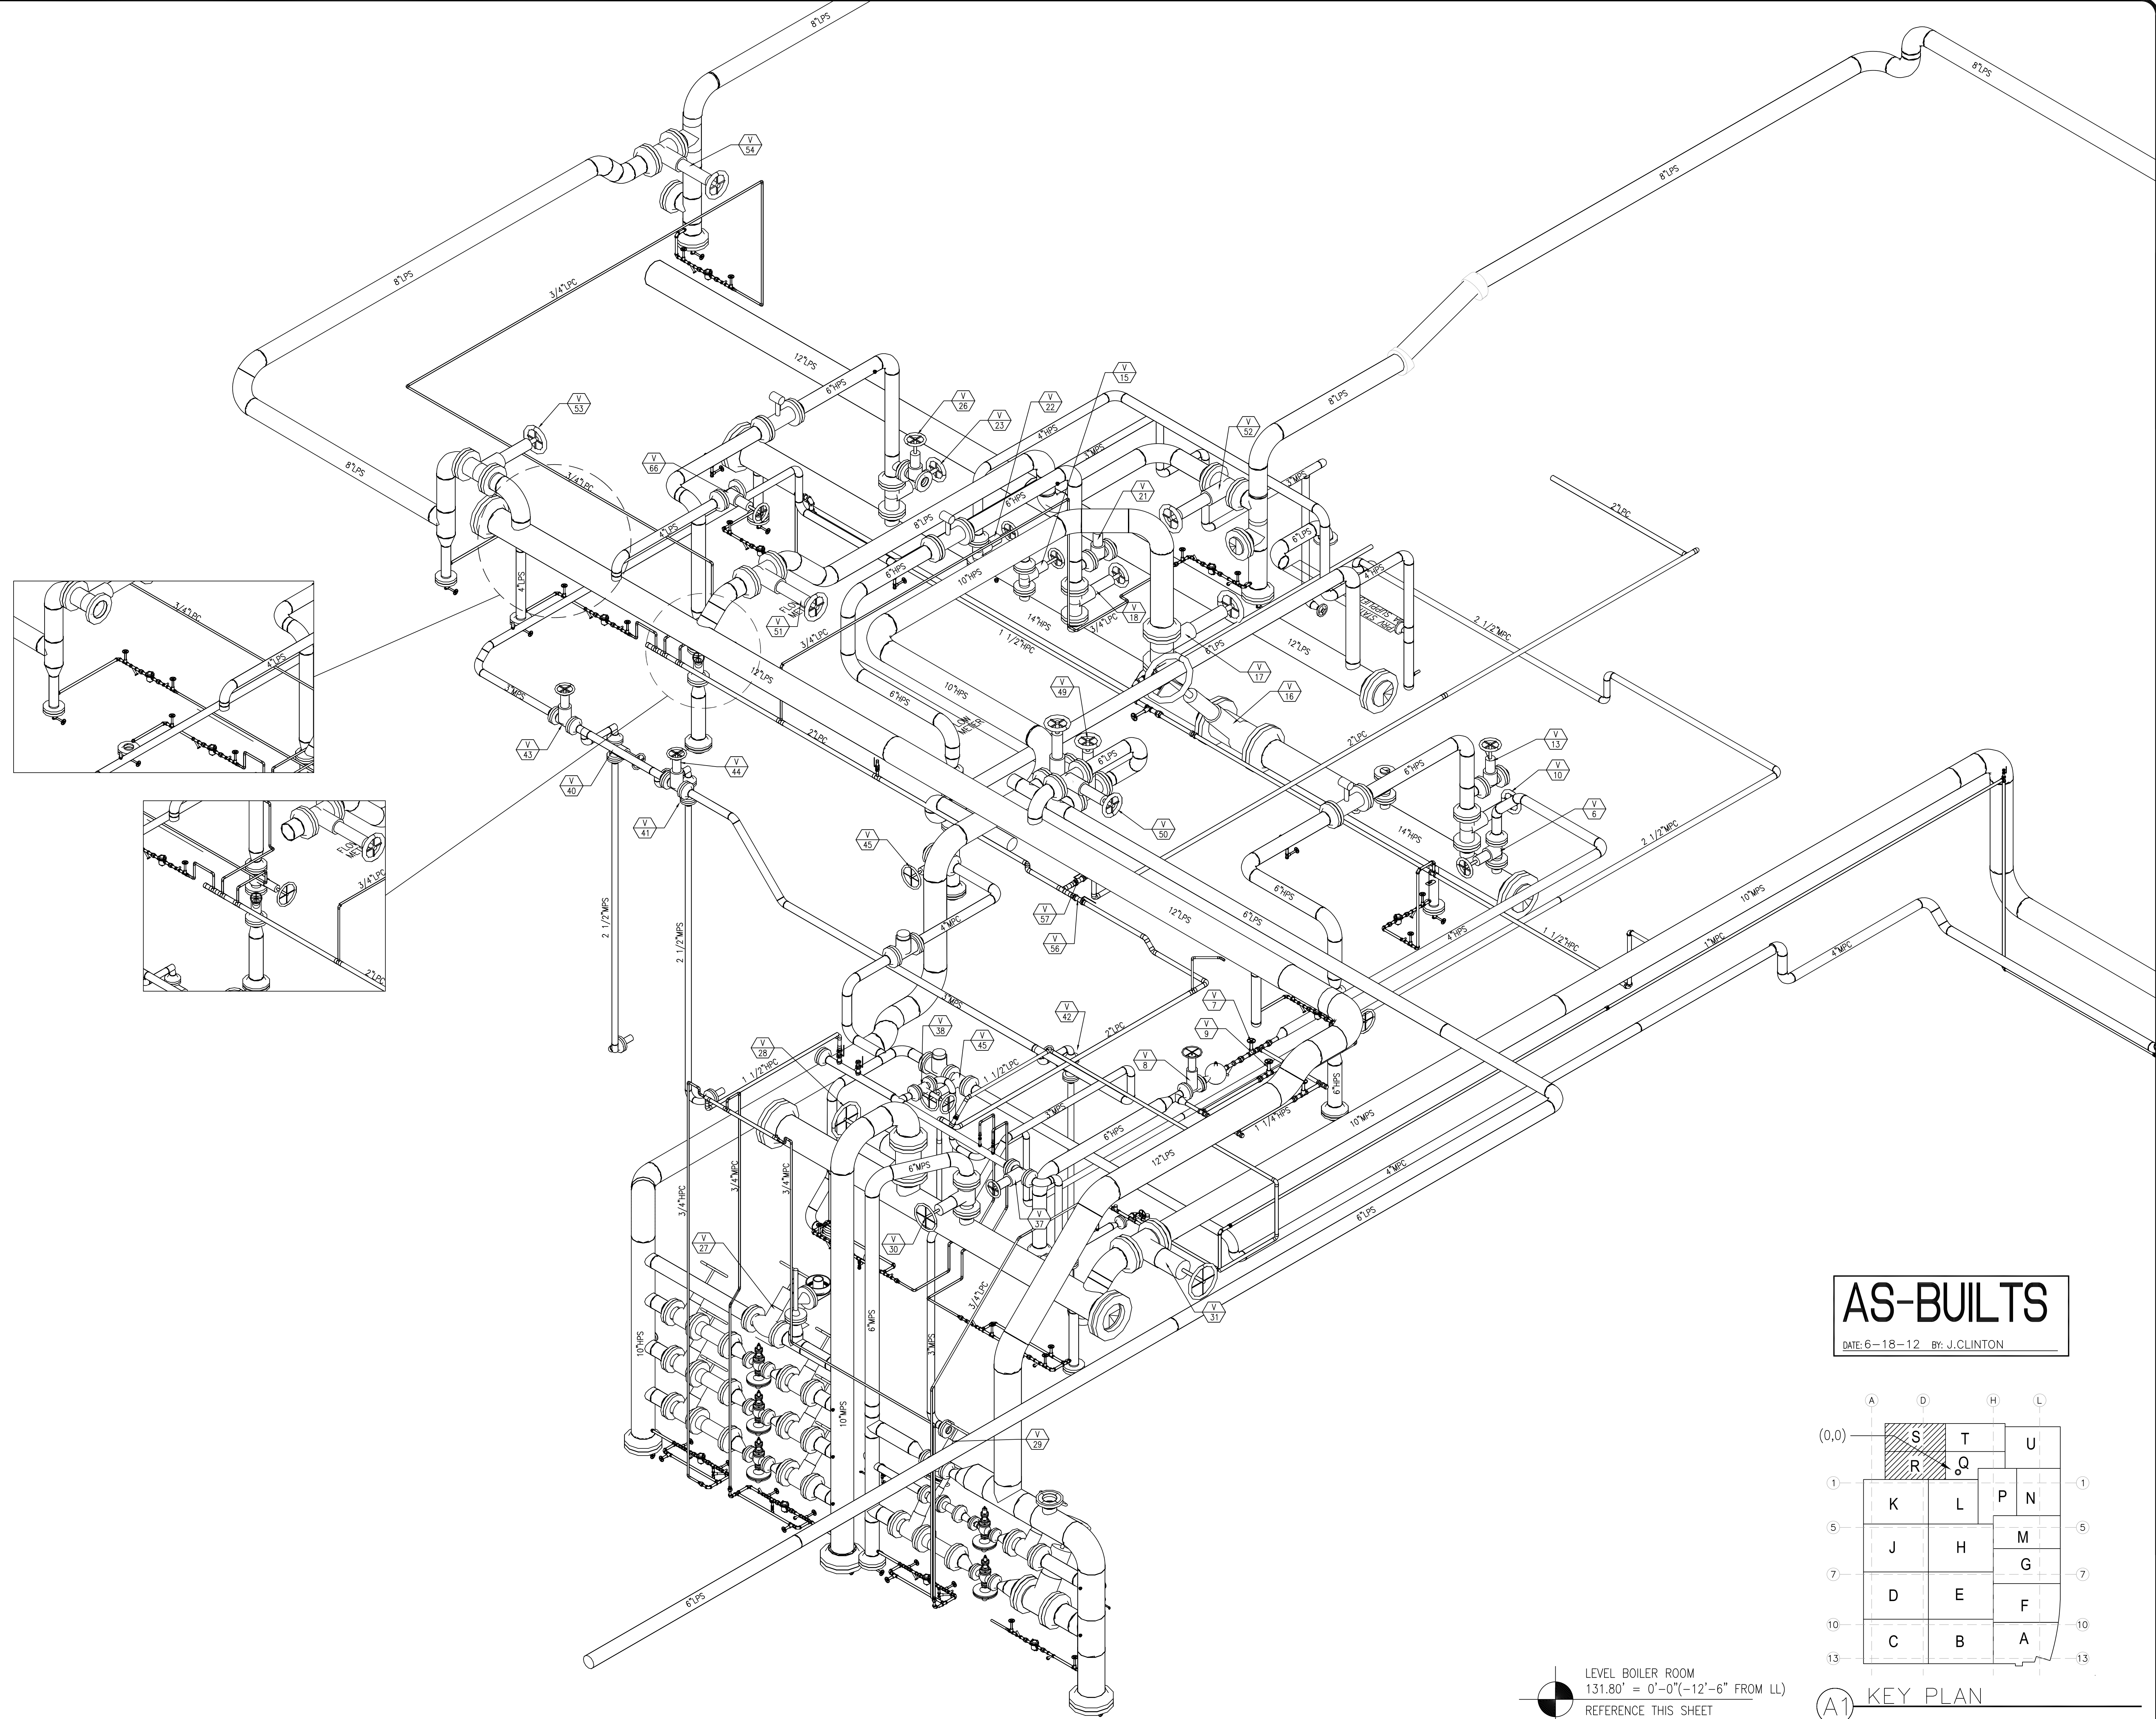

**AS-BUILTS**  
 DATE: 6-18-12 BY: J. CLINTON

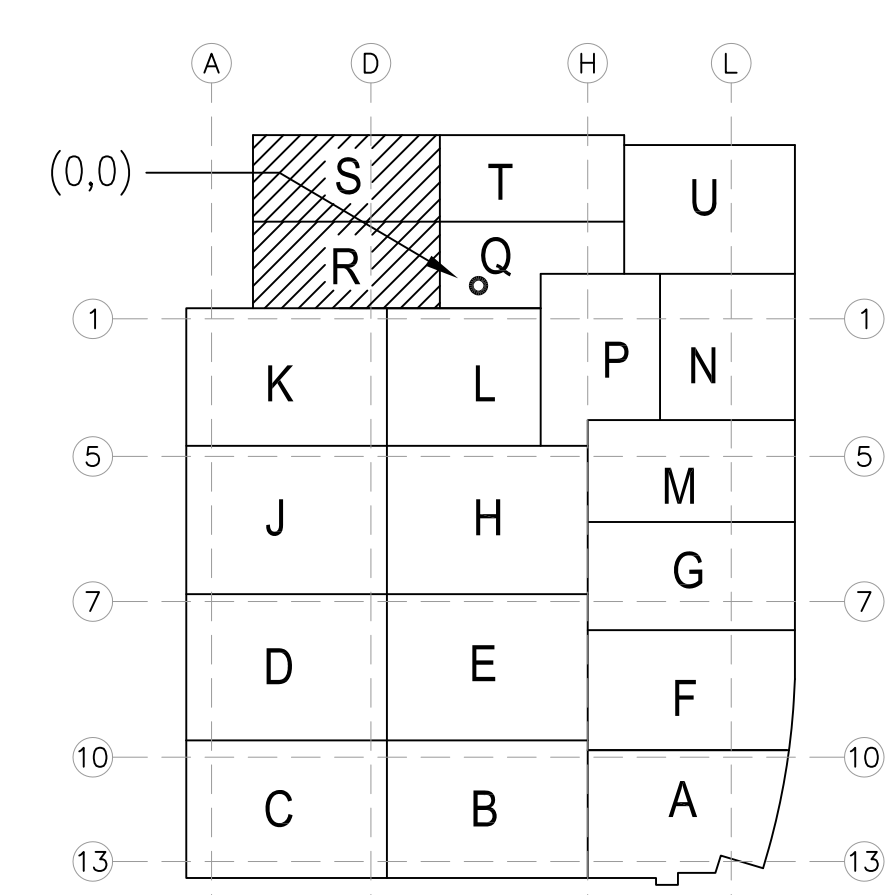

LEVEL BOILER ROOM  
 131.80' = 0'-0" (-12'-6" FROM LL)  
 REFERENCE THIS SHEET

REVISIONS	BY

COORD.	SIGNATURE	DATE
MECHANICAL		
MECHANICAL DUCT		
MECHANICAL PIPE		
PLUMBING		
ELECTRICAL		
FIRE SPRINKLER		
PLUMB		
DRYWALL/FRAMING		
REFRIGERATION		
STRUCTURAL		

REF. I.	SENT	ANS.	REF. I.	SENT	ANS.	REF. I.	SENT	ANS.


**CHILDREN'S HOSPITAL OF ORANGE COUNTY**  
 455 S. MAIN ST. SUITE 3000-3074  
 COSTA MESA, CA 92626  
**TOWER II**  
 MECHANICAL PIPE FLOOR PLAN - LEVEL 00 AREAS

**PAN-PACIFIC**  
 PLUMBING & MECHANICAL  
 2919 E. VICTORIA STREET, RANCHO DOMINGUEZ, CA 90221  
 PH. 310.637.1500 FAX 310.604.0359

DRAWN: T.C.  
 CHECKED: M.M.  
 DATE: 9/4/2012  
 SCALE: 1/4" = 1'-0"  
 JOB NO.: 09-006  
 DRAWING NUMBER: VALVE TAG 1  
 REFERENCE DRAWING: A3.05, P3.05  
 1 OF 1 SHEETS


DWG FILES: \\PAC-008-CORP\DRAWING\COMMON\MECHANICAL\PIPEFLOOR\LEVEL 00\MECHANICAL\_PIPEFLOOR\_00.dwg Plotter: hp-j4000 Plot Date: 9-4-2012 10:56am

This document and the design it covers are the property of Murray Co. They are loaned only with the borrower's expressed written agreement that they will not be reproduced, copied, loaned, exhibited, or used in any other way, except by written consent from Murray Co. to the borrower.

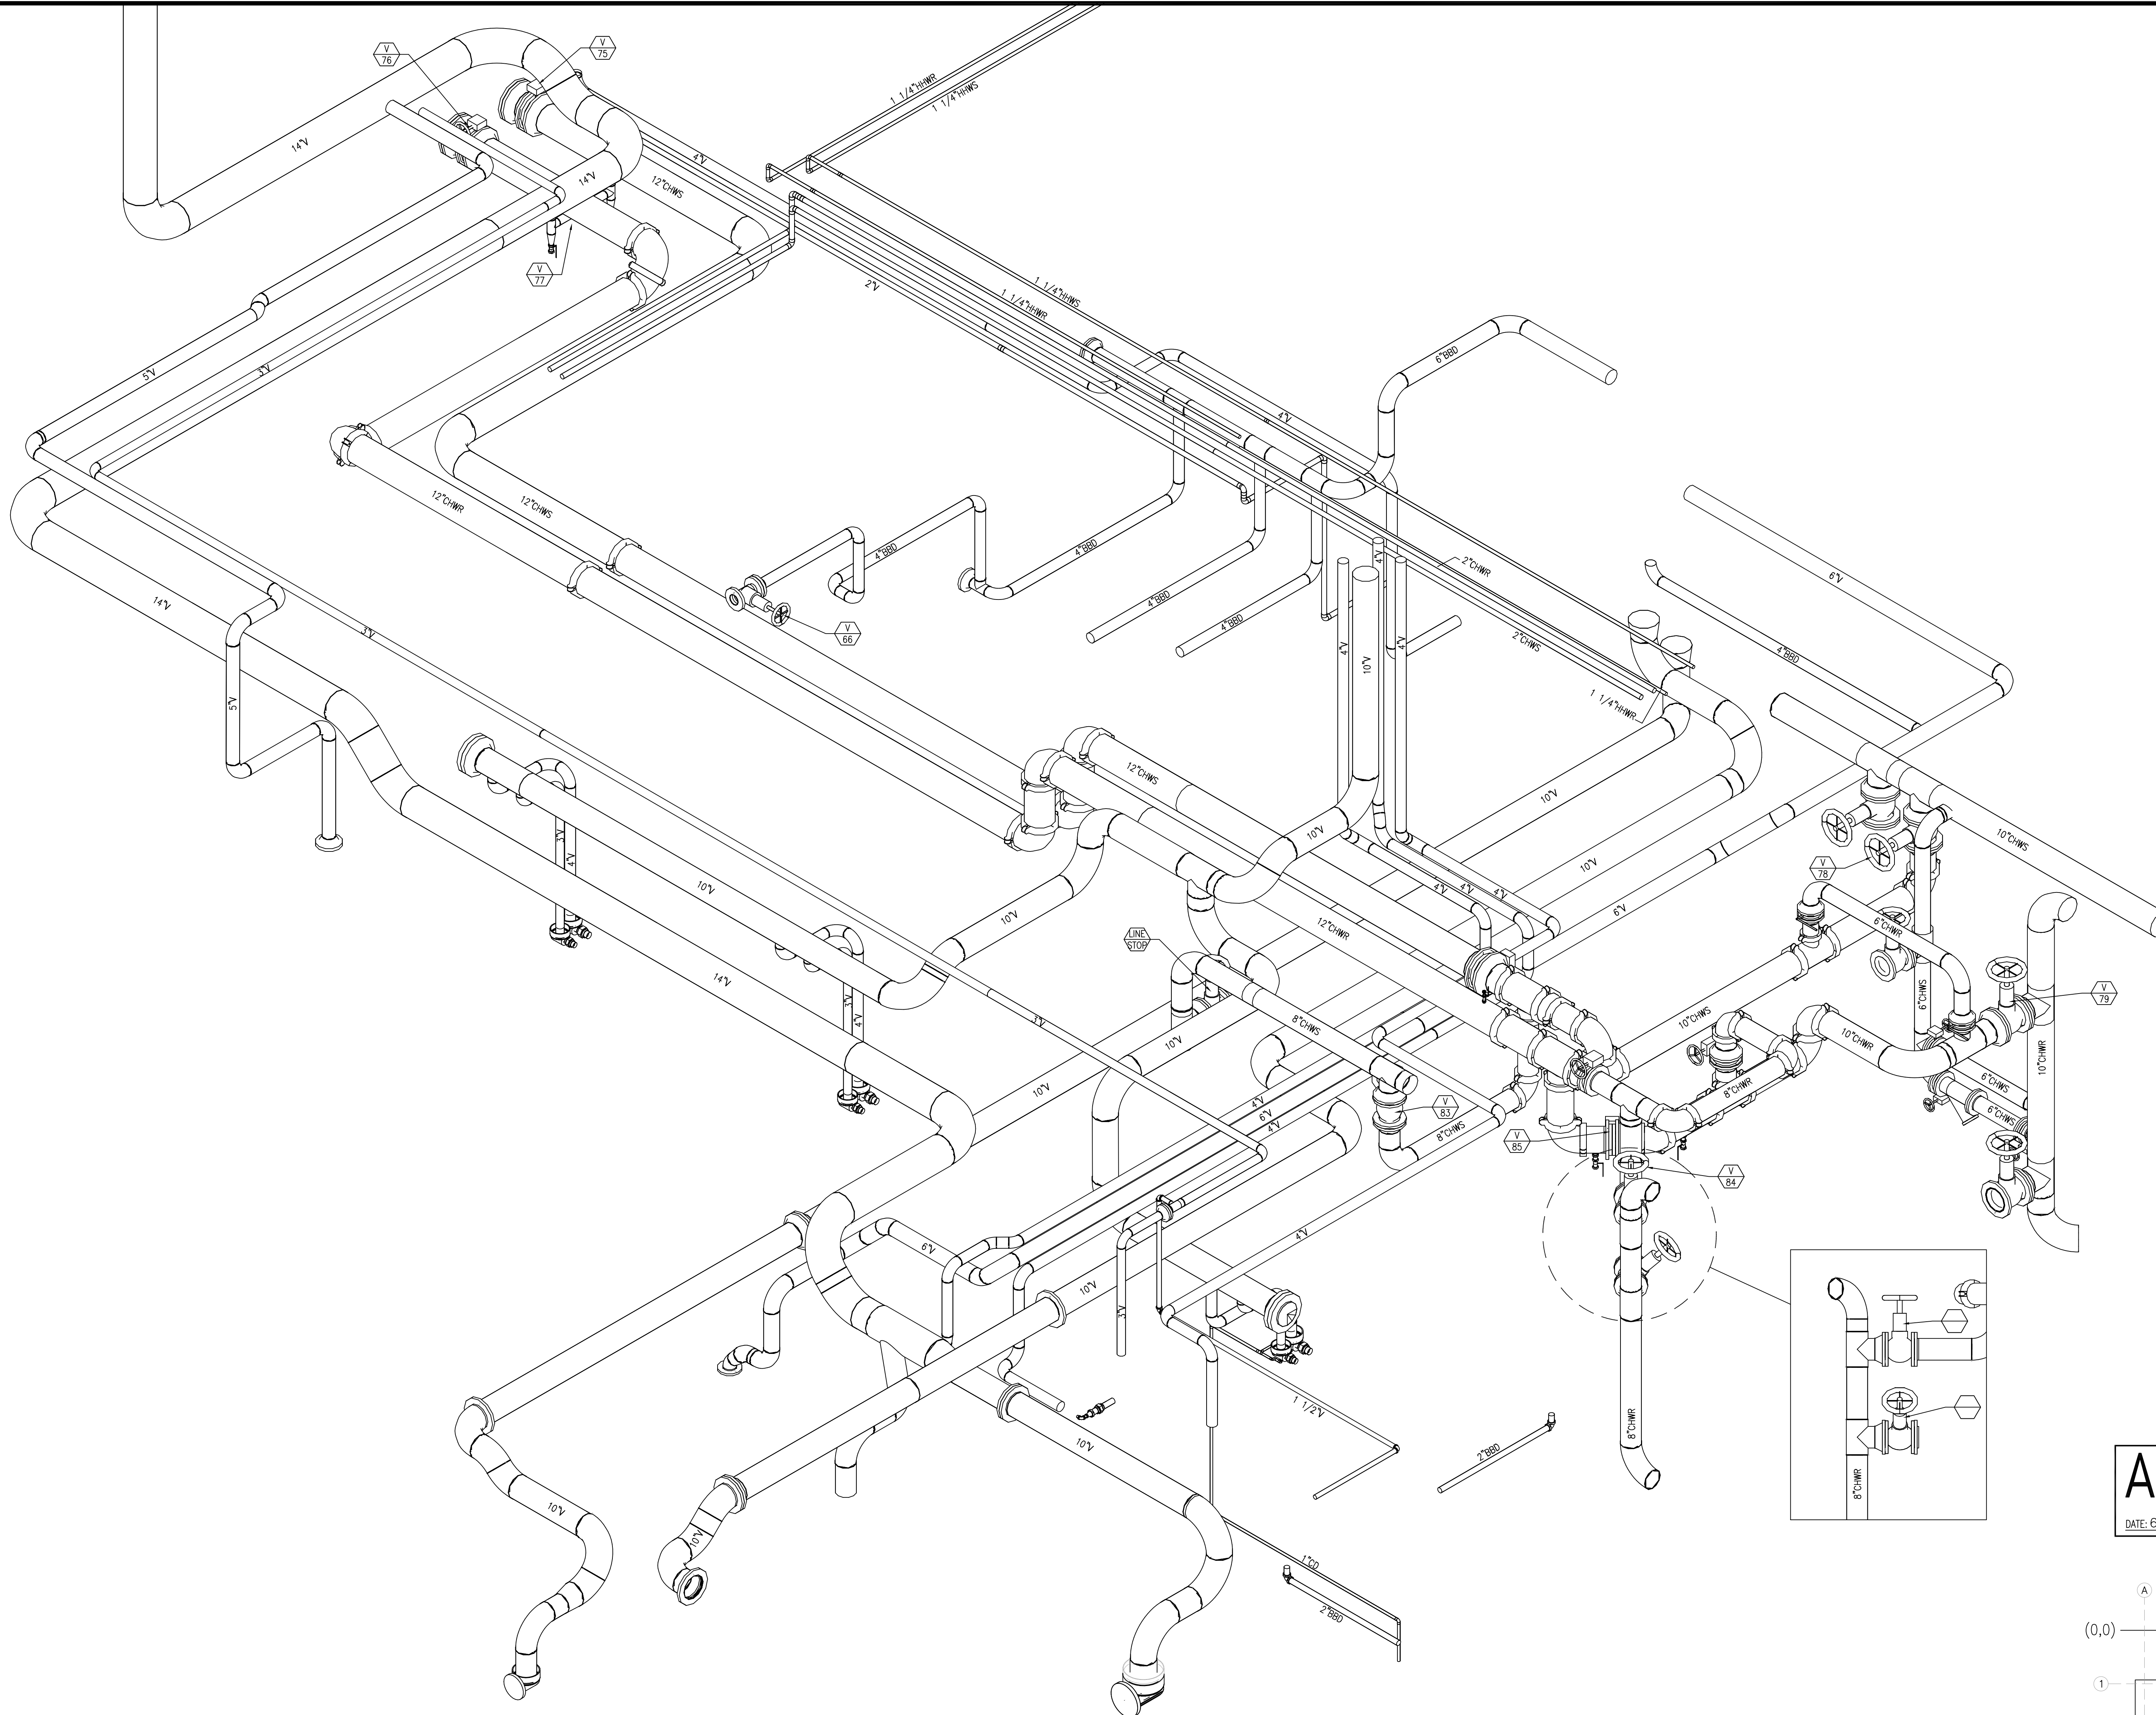

LEVEL BOILER ROOM  
131.80' = 0'-0" (-12'-6" FROM LL)  
REFERENCE THIS SHEET

**AS-BUILTS**  
DATE: 6-18-12 BY: J. CLINTON

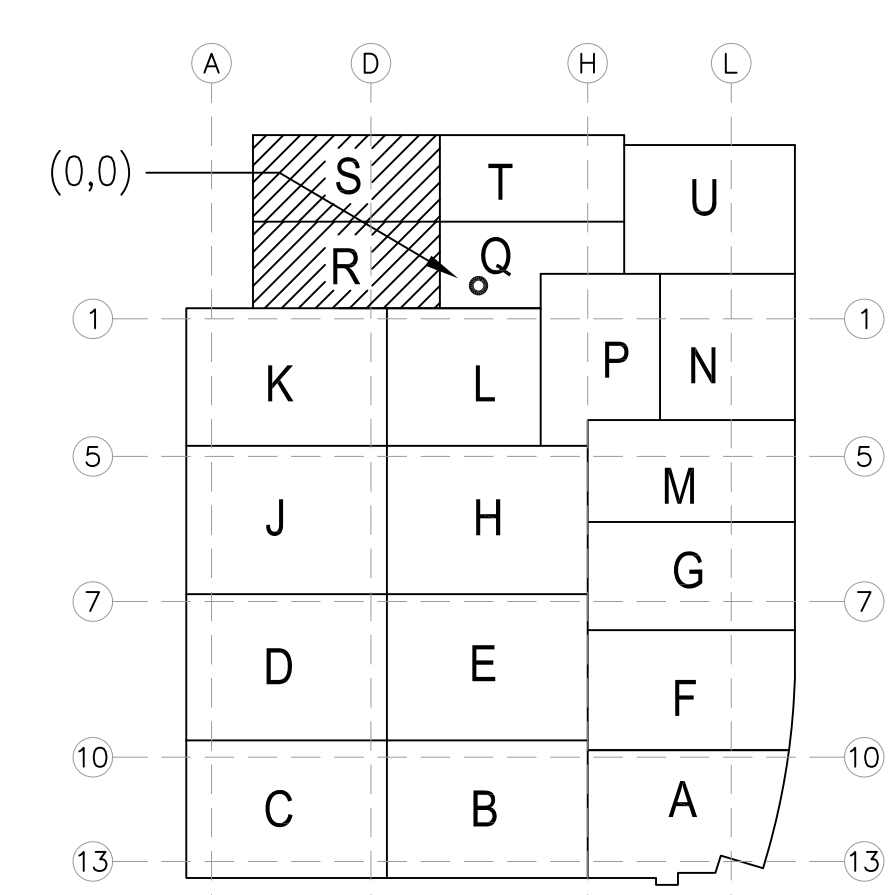

**KEY PLAN**

REVISIONS		BY
ISSUED FOR COORDINATION	9-18-09	TC
ISSUED FOR COORDINATION	10-27-09	TC

COORD.	DATE	SIGNATURE
MECHANICAL		
MECHANICAL PIPE		
PLUMBING		
ELECTRICAL		
FIRE SPRINKLER		
PLUMB		
DRYWALL/FRAMING		
REFRIGERATION		
STRUCTURAL		

REF. I.	SENT	ANS.	REF. I.	SENT	ANS.	REF. I.	SENT	ANS.

**CHILDREN'S HOSPITAL  
OF ORANGE COUNTY**  
255 S. MAIN ST., SUITE 200  
ORANGE, CA 92668-3974  
**TOWER II**  
MECHANICAL PIPE FLOOR PLAN - LEVEL 00 AREAS

**PAN-PACIFIC**  
PLANNING & ARCHITECTURAL  
Murray Company  
2919 E. VICTORIA STREET, RANCHO DOMINGUEZ, CA 90221  
PH. 310.637.1500 FAX 310.604.0359

DESIGN: T.C.  
CHECKED: M.M.  
DATE: 9/4/2012  
SCALE: 1/4" = 1'-0"  
JOB NO.: 09-006  
DRAWING NUMBER: VALVE TAG 2  
REFERENCE DRAWING: A3.05, P3.05  
1 OF 1 SHEETS

DWG FILE: \\P:\09-006\09-006-MECHANICAL-PIPE-FLOOR-PLAN-LEVEL-00-AREAS.dwg Plotter: hp-j41000 Date: 11-04-2012 10:58am