



This document and the design it covers are the property of Murray Co. They are loaned only with the borrower's expressed written agreement that they will not be reproduced, copied, loaned, exhibited, or used in any other way, except by written consent from Murray Co. to the borrower.

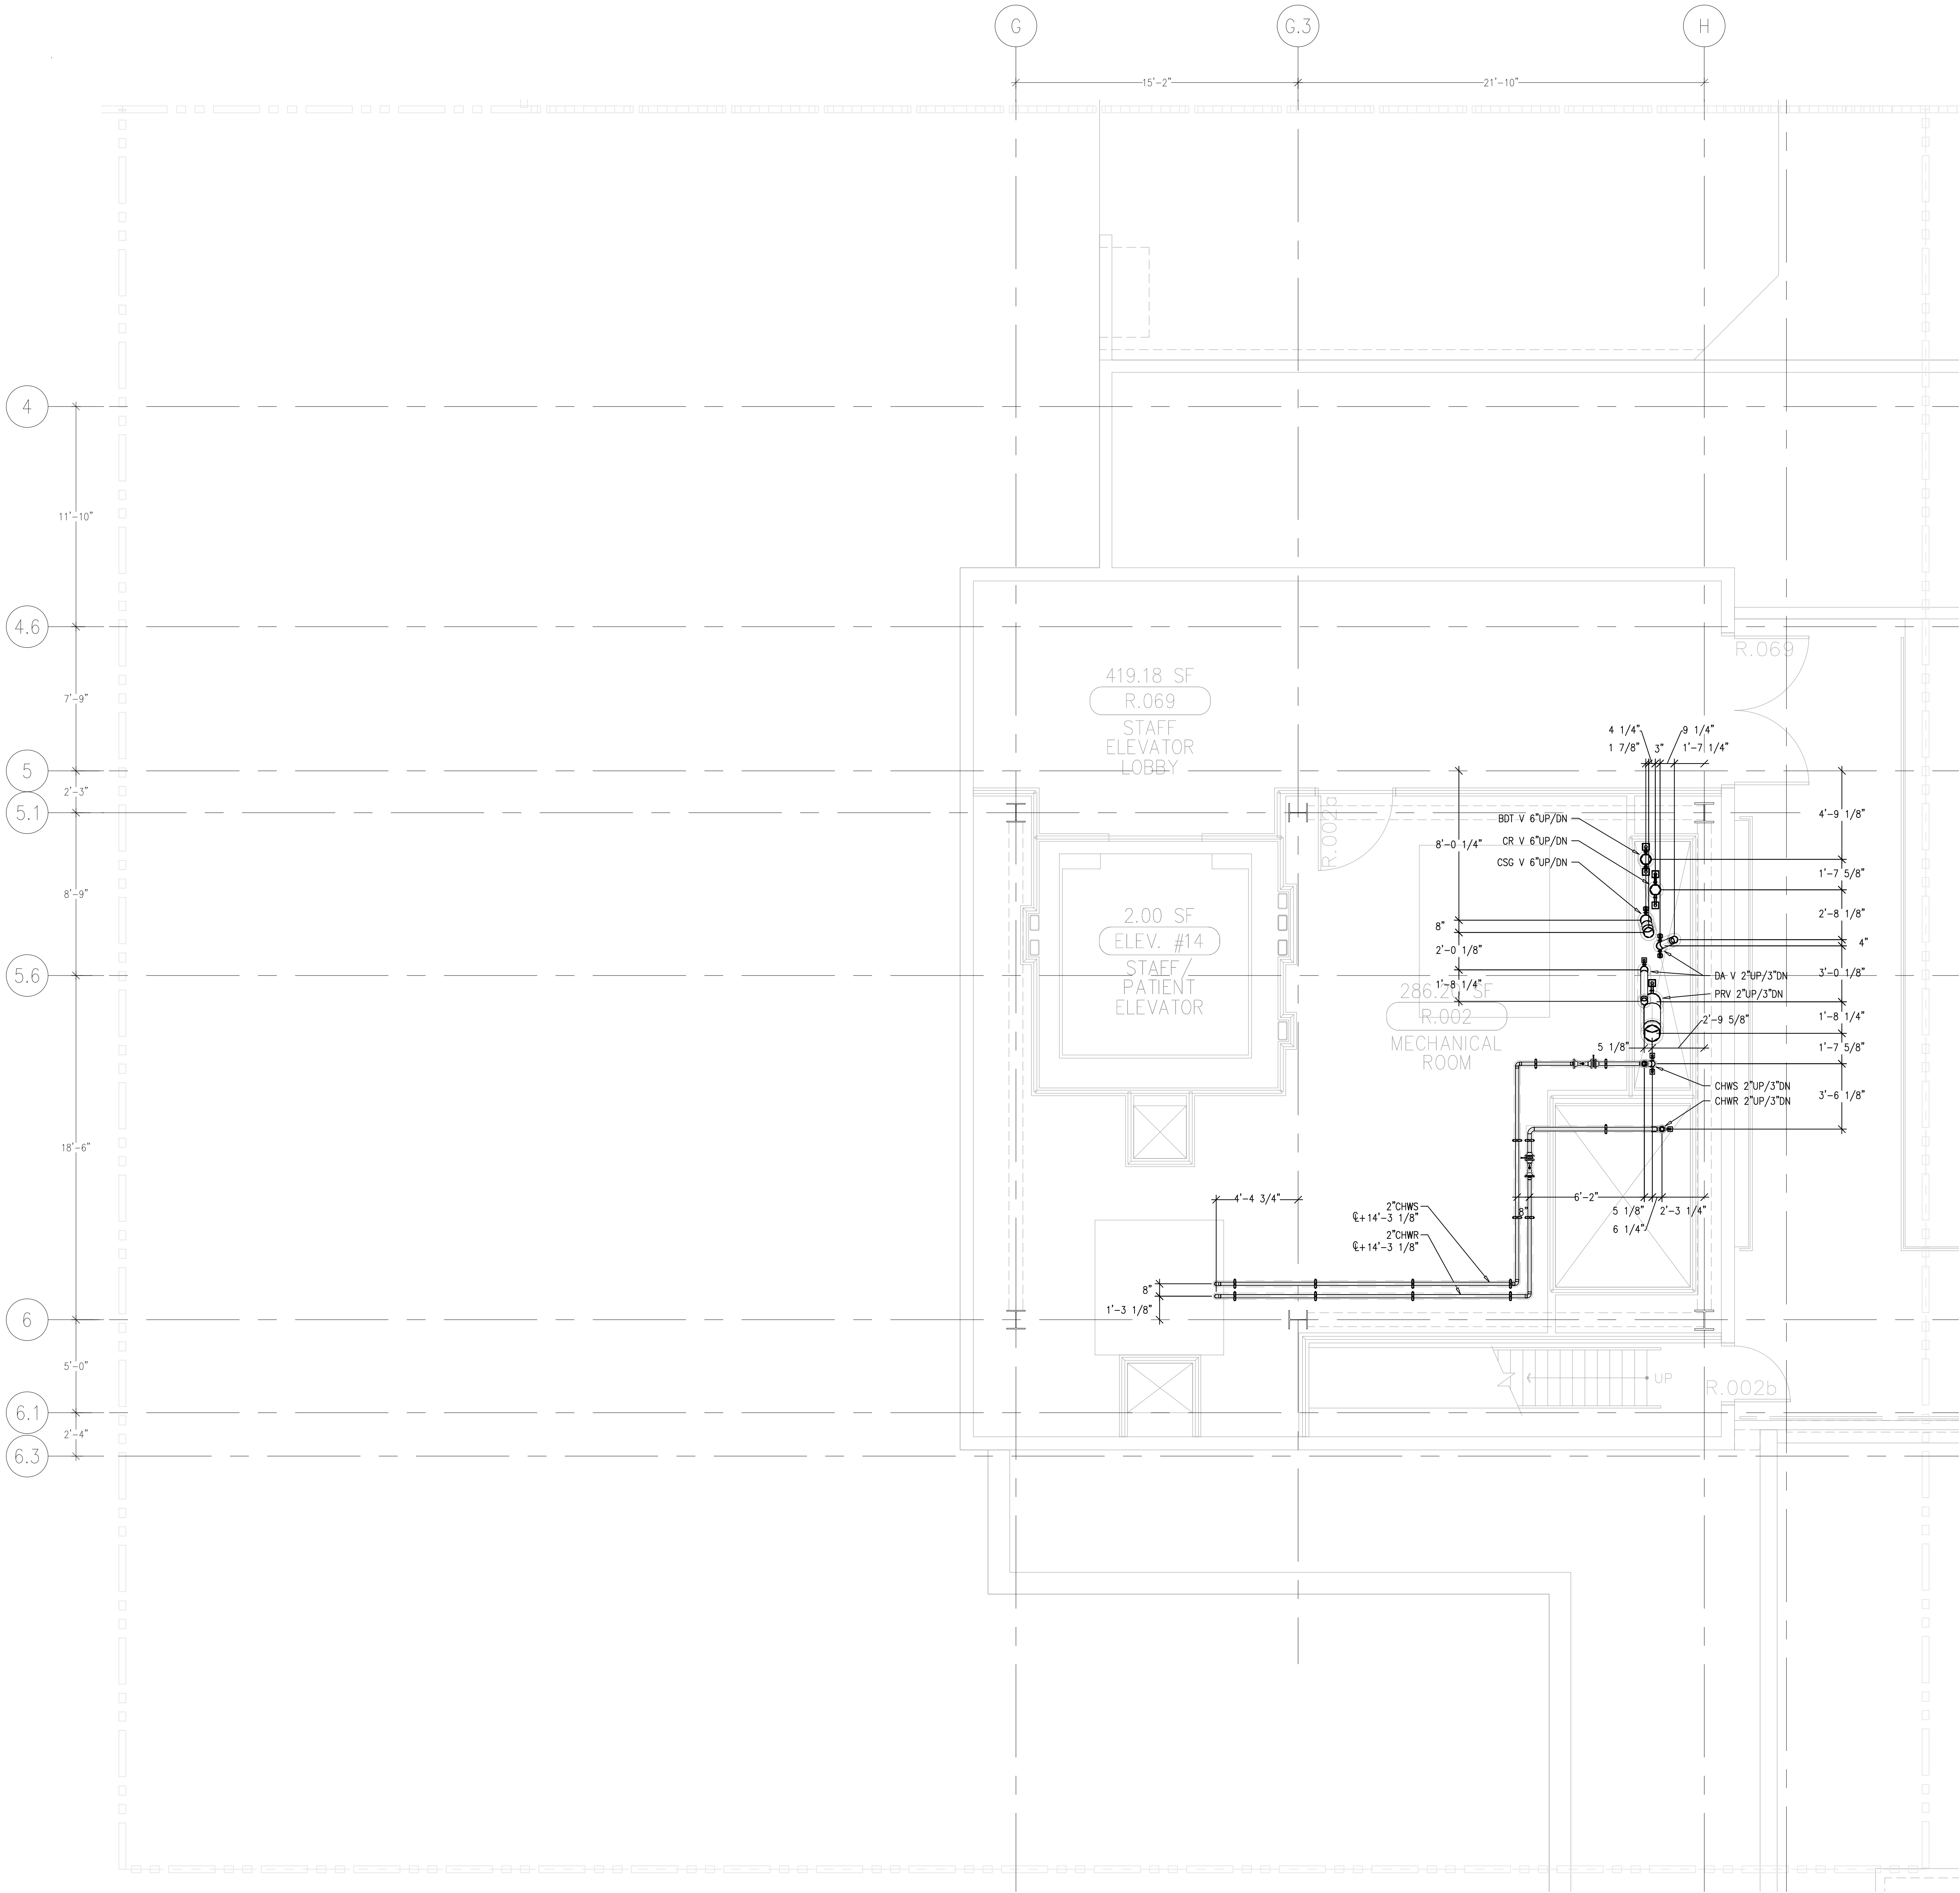

AS-BUILTS

DATE: 6-18-12 BY: J. CLINTON

LEVEL 09 284.30' = 0'-0"
REFERENCE THIS SHEET

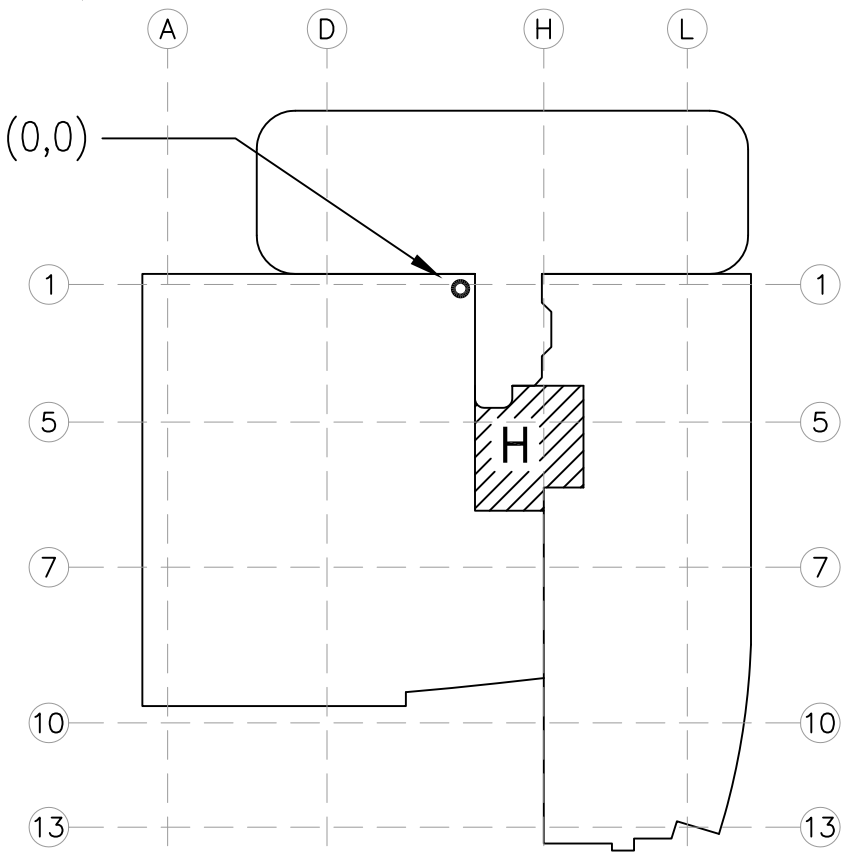

A1 Key Plan
N.T.S.

REVISIONS	BY

COORD.	SIGNATURE	DATE
MECHANICAL		
MECHANICAL		
MECHANICAL		
ELECTRICAL		
FIRE SPRINKLER		
PLUMB		
DRYWALL/FRAMER		
REFRIGERATION		
STRUCTURAL		

R.F.I.	SENT	ANS.	R.F.I.	SENT	ANS.	R.F.I.	SENT	ANS.

CHILDREN'S HOSPITAL
OF ORANGE COUNTY
455 S. MAIN ST.
ORANGE, CA 92668-3974
TOWER II
MECHANICAL FLOOR PLAN - LEVEL 09 AREA-H

PAN-PACIFIC
PLUMBING & MECHANICAL
Murray Company
2919 E. VICTORIA STREET, RANCHO DOMINGUEZ, CA 90221
PH. 310.637-1500 FAX 310.604-0359

DRAWN
J.M.
CHECKED
M.M.
DATE
9/4/2012
SCALE
1/4" = 1'-0"
JOB NO.
09-006
DRAWING NUMBER
MP3.9H
REFERENCE DRAWING
A3.9H
1 OF 1 SHEETS