

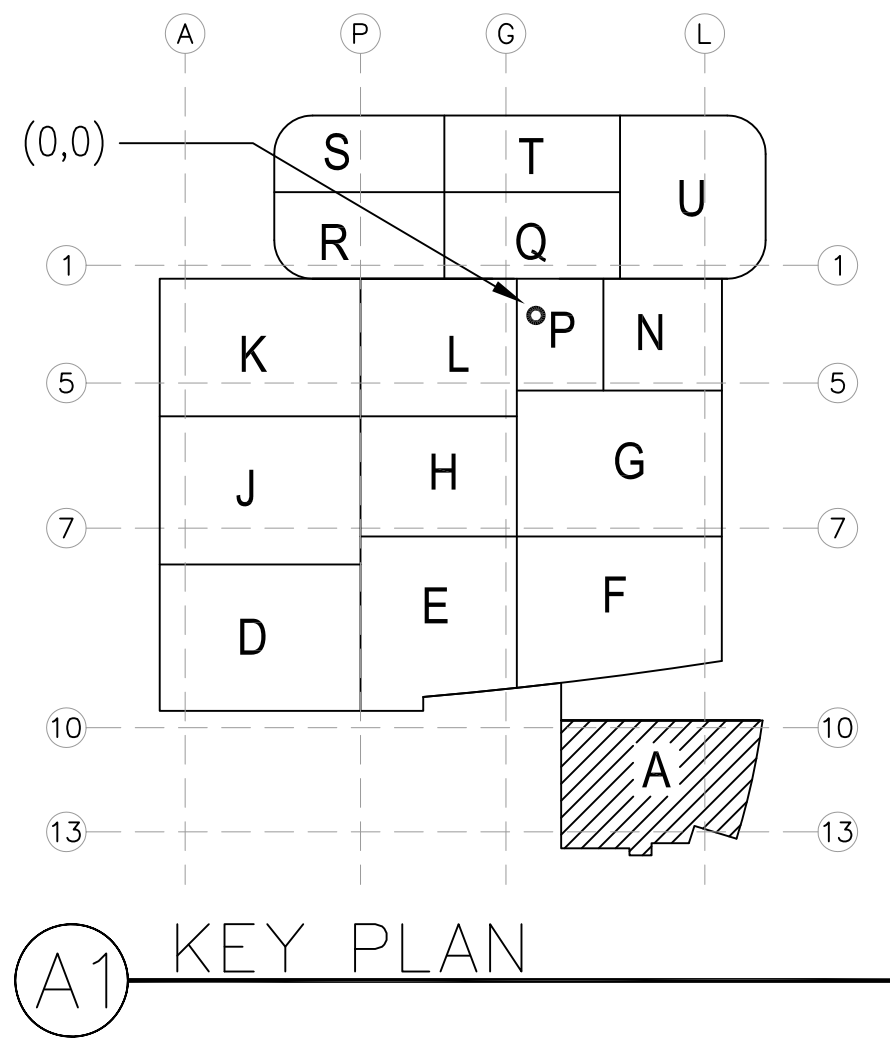



Drawn
R.O.
Checked
M.M.
Date
4/30/2012
Scale
1/4" = 1'-0"
Job No.
09-006
Drawing Number
PL3.1A
Reference Drawing
A3.1A
A3.1A
1 OF 1 SHEETS

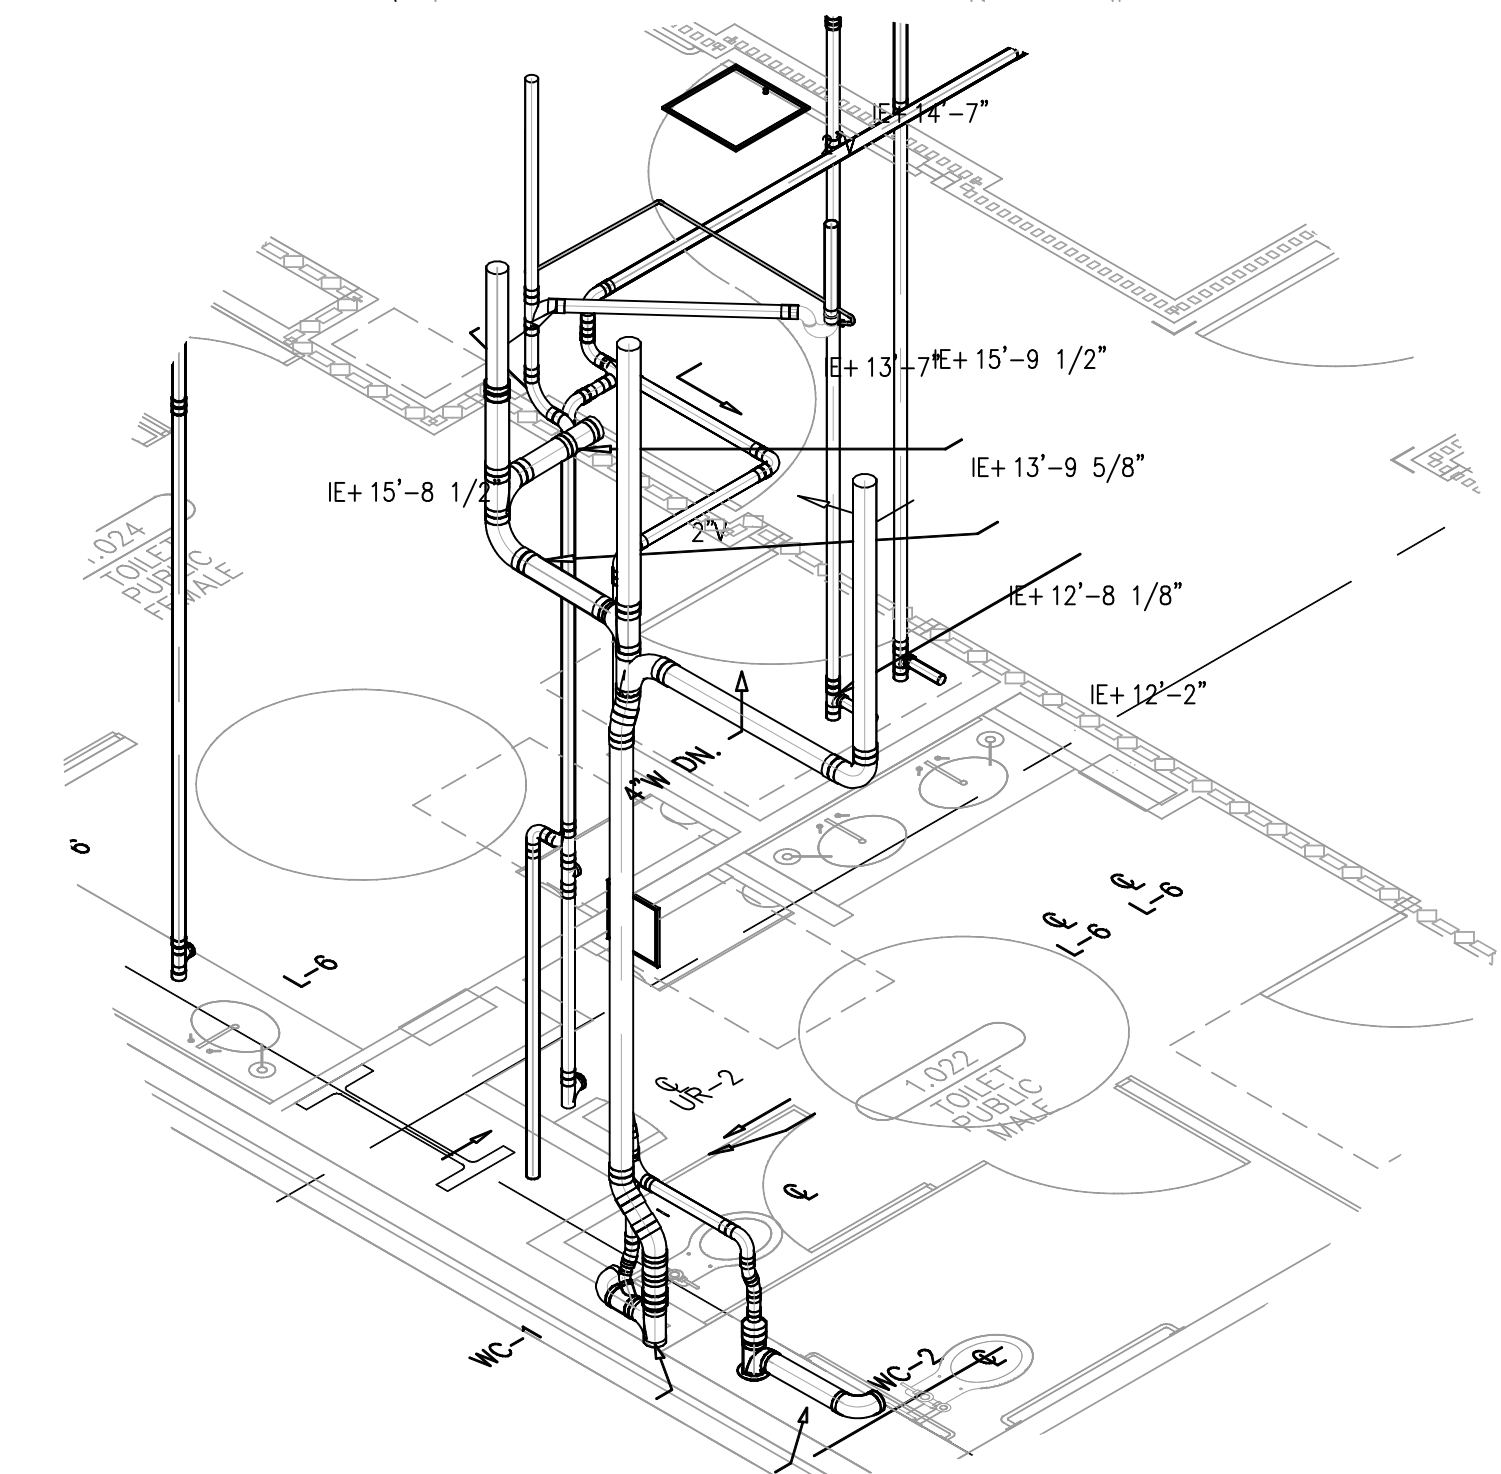

This document and the design it covers are the property of Murray Co. They are loaned only with the borrower's expressed written agreement that they will not be reproduced, copied, loaned, exhibited, or used in any other way, except by written consent from Murray Co. to the borrower.

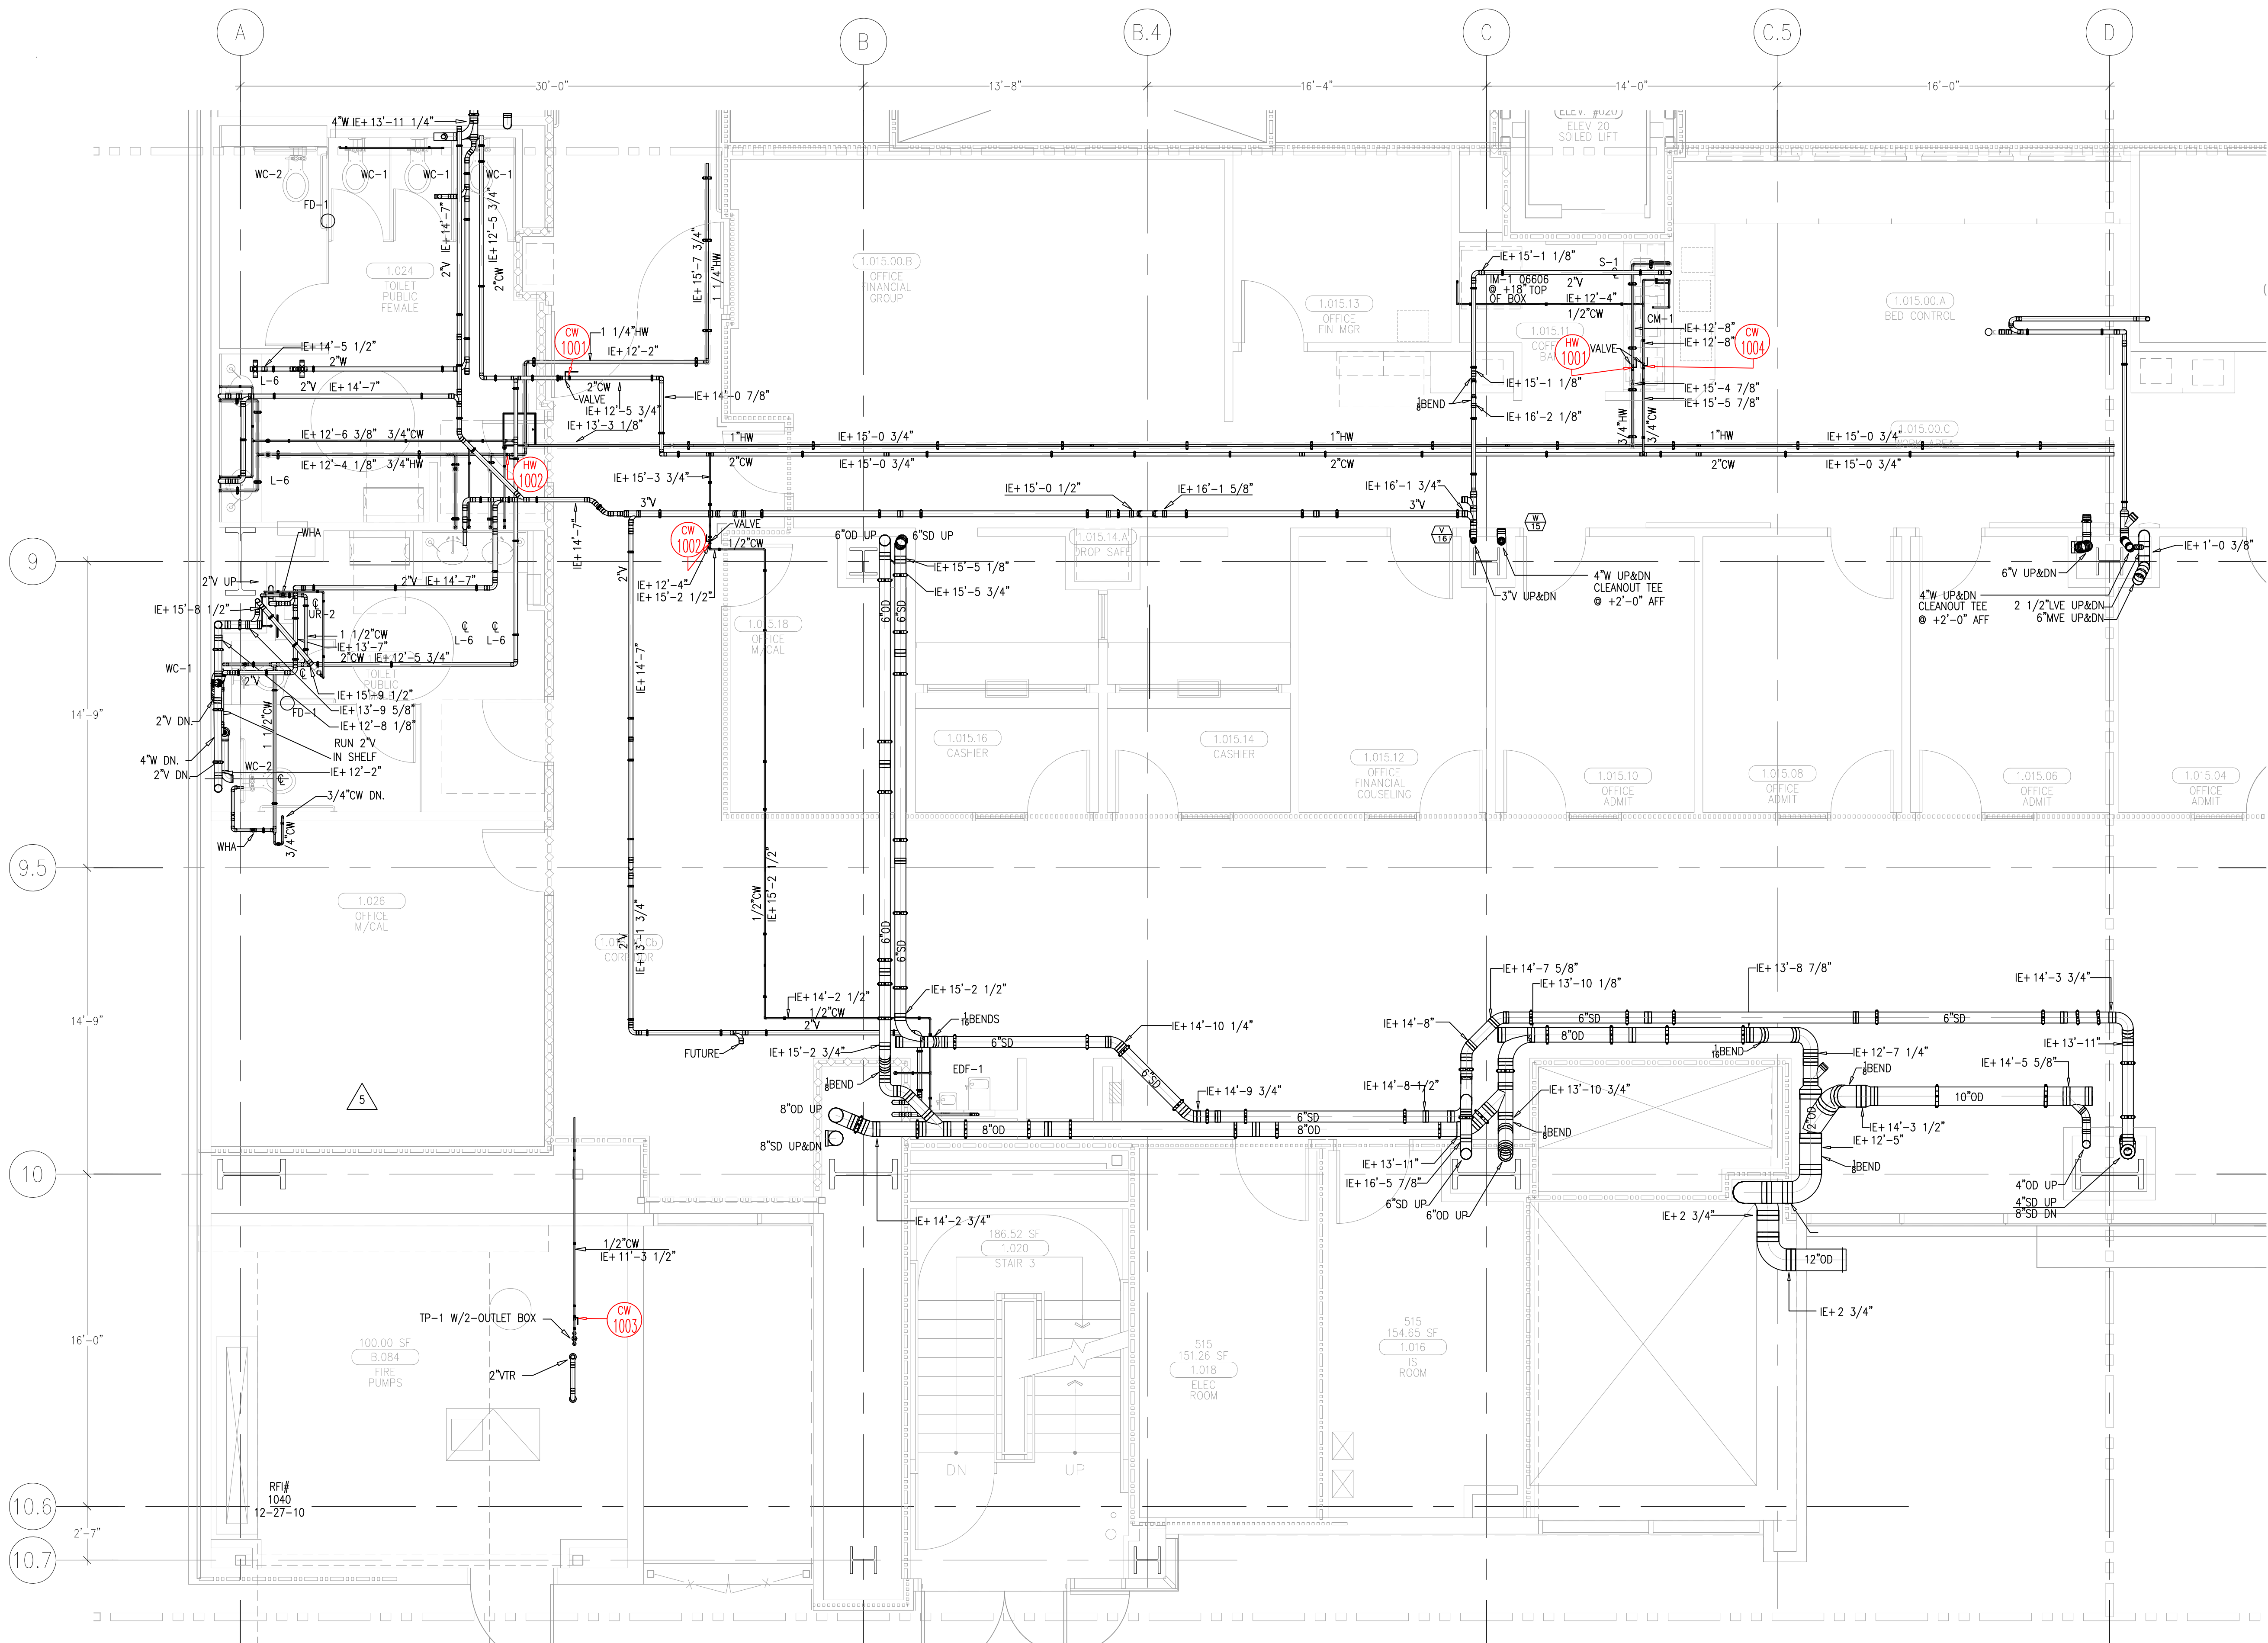

LEVEL 01 161.30' = 0'-0"
REFERENCE THIS SHEET

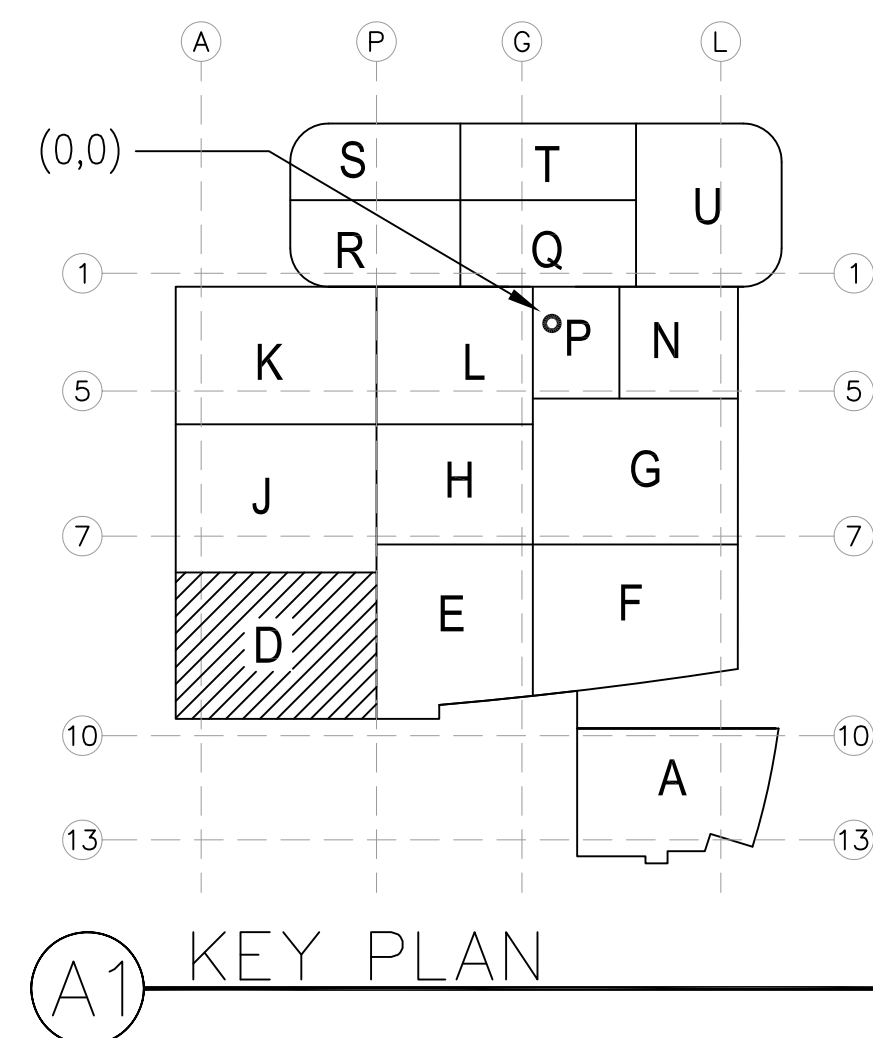

1	ISSUED FOR COORDINATION SIGN-OFF 11-4-09	DK
2	ISSUED FOR OSHPD PERMIT 3-1-10	DK
3	ISSUED FOR COORDINATION SIGN-OFF 3-1-10	DK
4	ADDED NOTE FOR FD-1 PER CON RPT 1270 PPMV 05/05/09 5-4-10	REO
5	REVISED DUE TO SLEEVE RELOCATION 6-19-10	DK

REVISIONS	BY
1	JT
2	JT
3	GTP
4	JT
5	DK
6	DK
7	DK
8	DK

COORD.	SIGNATURE	DATE
MECHANICAL		
ELECTRICAL		
PLUMBING		
STRUCTURAL		



R.F.I.	SENT	ANS.	R.F.I.	SENT	ANS.	R.F.I.	SENT	ANS.
0061	04/24/09	05/01/09	0321	08/17/09	08/28/09	0721	02/09/10	02/25/10
0068	04/27/09	05/01/09	0337	08/26/09	09/14/09	0723	02/12/10	03/28/10
0131	05/29/09	07/08/09	0362	09/02/09	10/13/09	0871	06/30/10	07/12/10
0153	05/29/09	07/08/09	0369	09/02/09	10/13/09	0954	08/25/10	09/02/10
0204	06/19/09	08/24/09	0416	09/24/09	11/02/09			
0208	06/19/09	08/21/09	0490	10/03/09	11/02/09			
0306	08/07/09	08/10/09	0720	02/09/10	02/11/10			

**CHILDREN'S HOSPITAL
OF ORANGE COUNTY**
455 S. MAIN ST., 3RD FLOOR
ORANGE, CA 92668-3974
TOWER II
PLUMBING FLOOR PLAN - LEVEL 01 AREAD

PAN-PACIFIC
PLUMBING & MECHANICAL
2919 E. VICTORIA STREET, RANCHO DOMINGUEZ, CA 90221
PH. 310.637-1500 FAX 310.604-0359

DRAWN
R.O.
CHECKED
M.M.
DATE
4/30/2012
SCALE
1/4" = 1'-0"
JOB NO.
09-006
DRAWING NUMBER
PL3.1D
REFERENCE DRAWING
A3.1D
P3.1D
1 OF 1 SHEETS

document and the design it covers are the property of Murray Co. They are loaned only with the borrower's expressed written agreement that they will not be reproduced, copied, loaned, exhibited, or used in any other way, except by written consent from Murray Co. to the borrower.

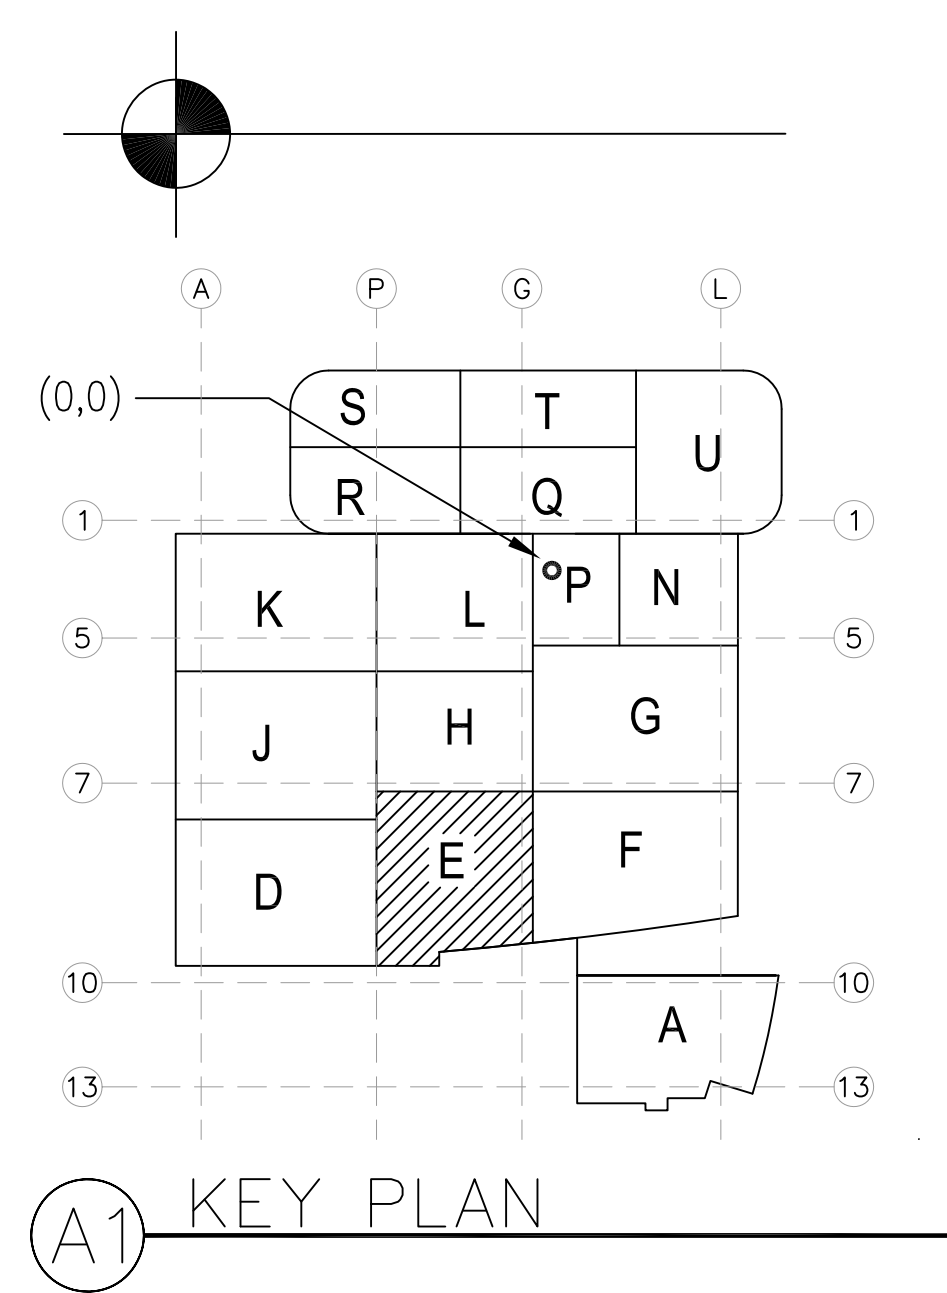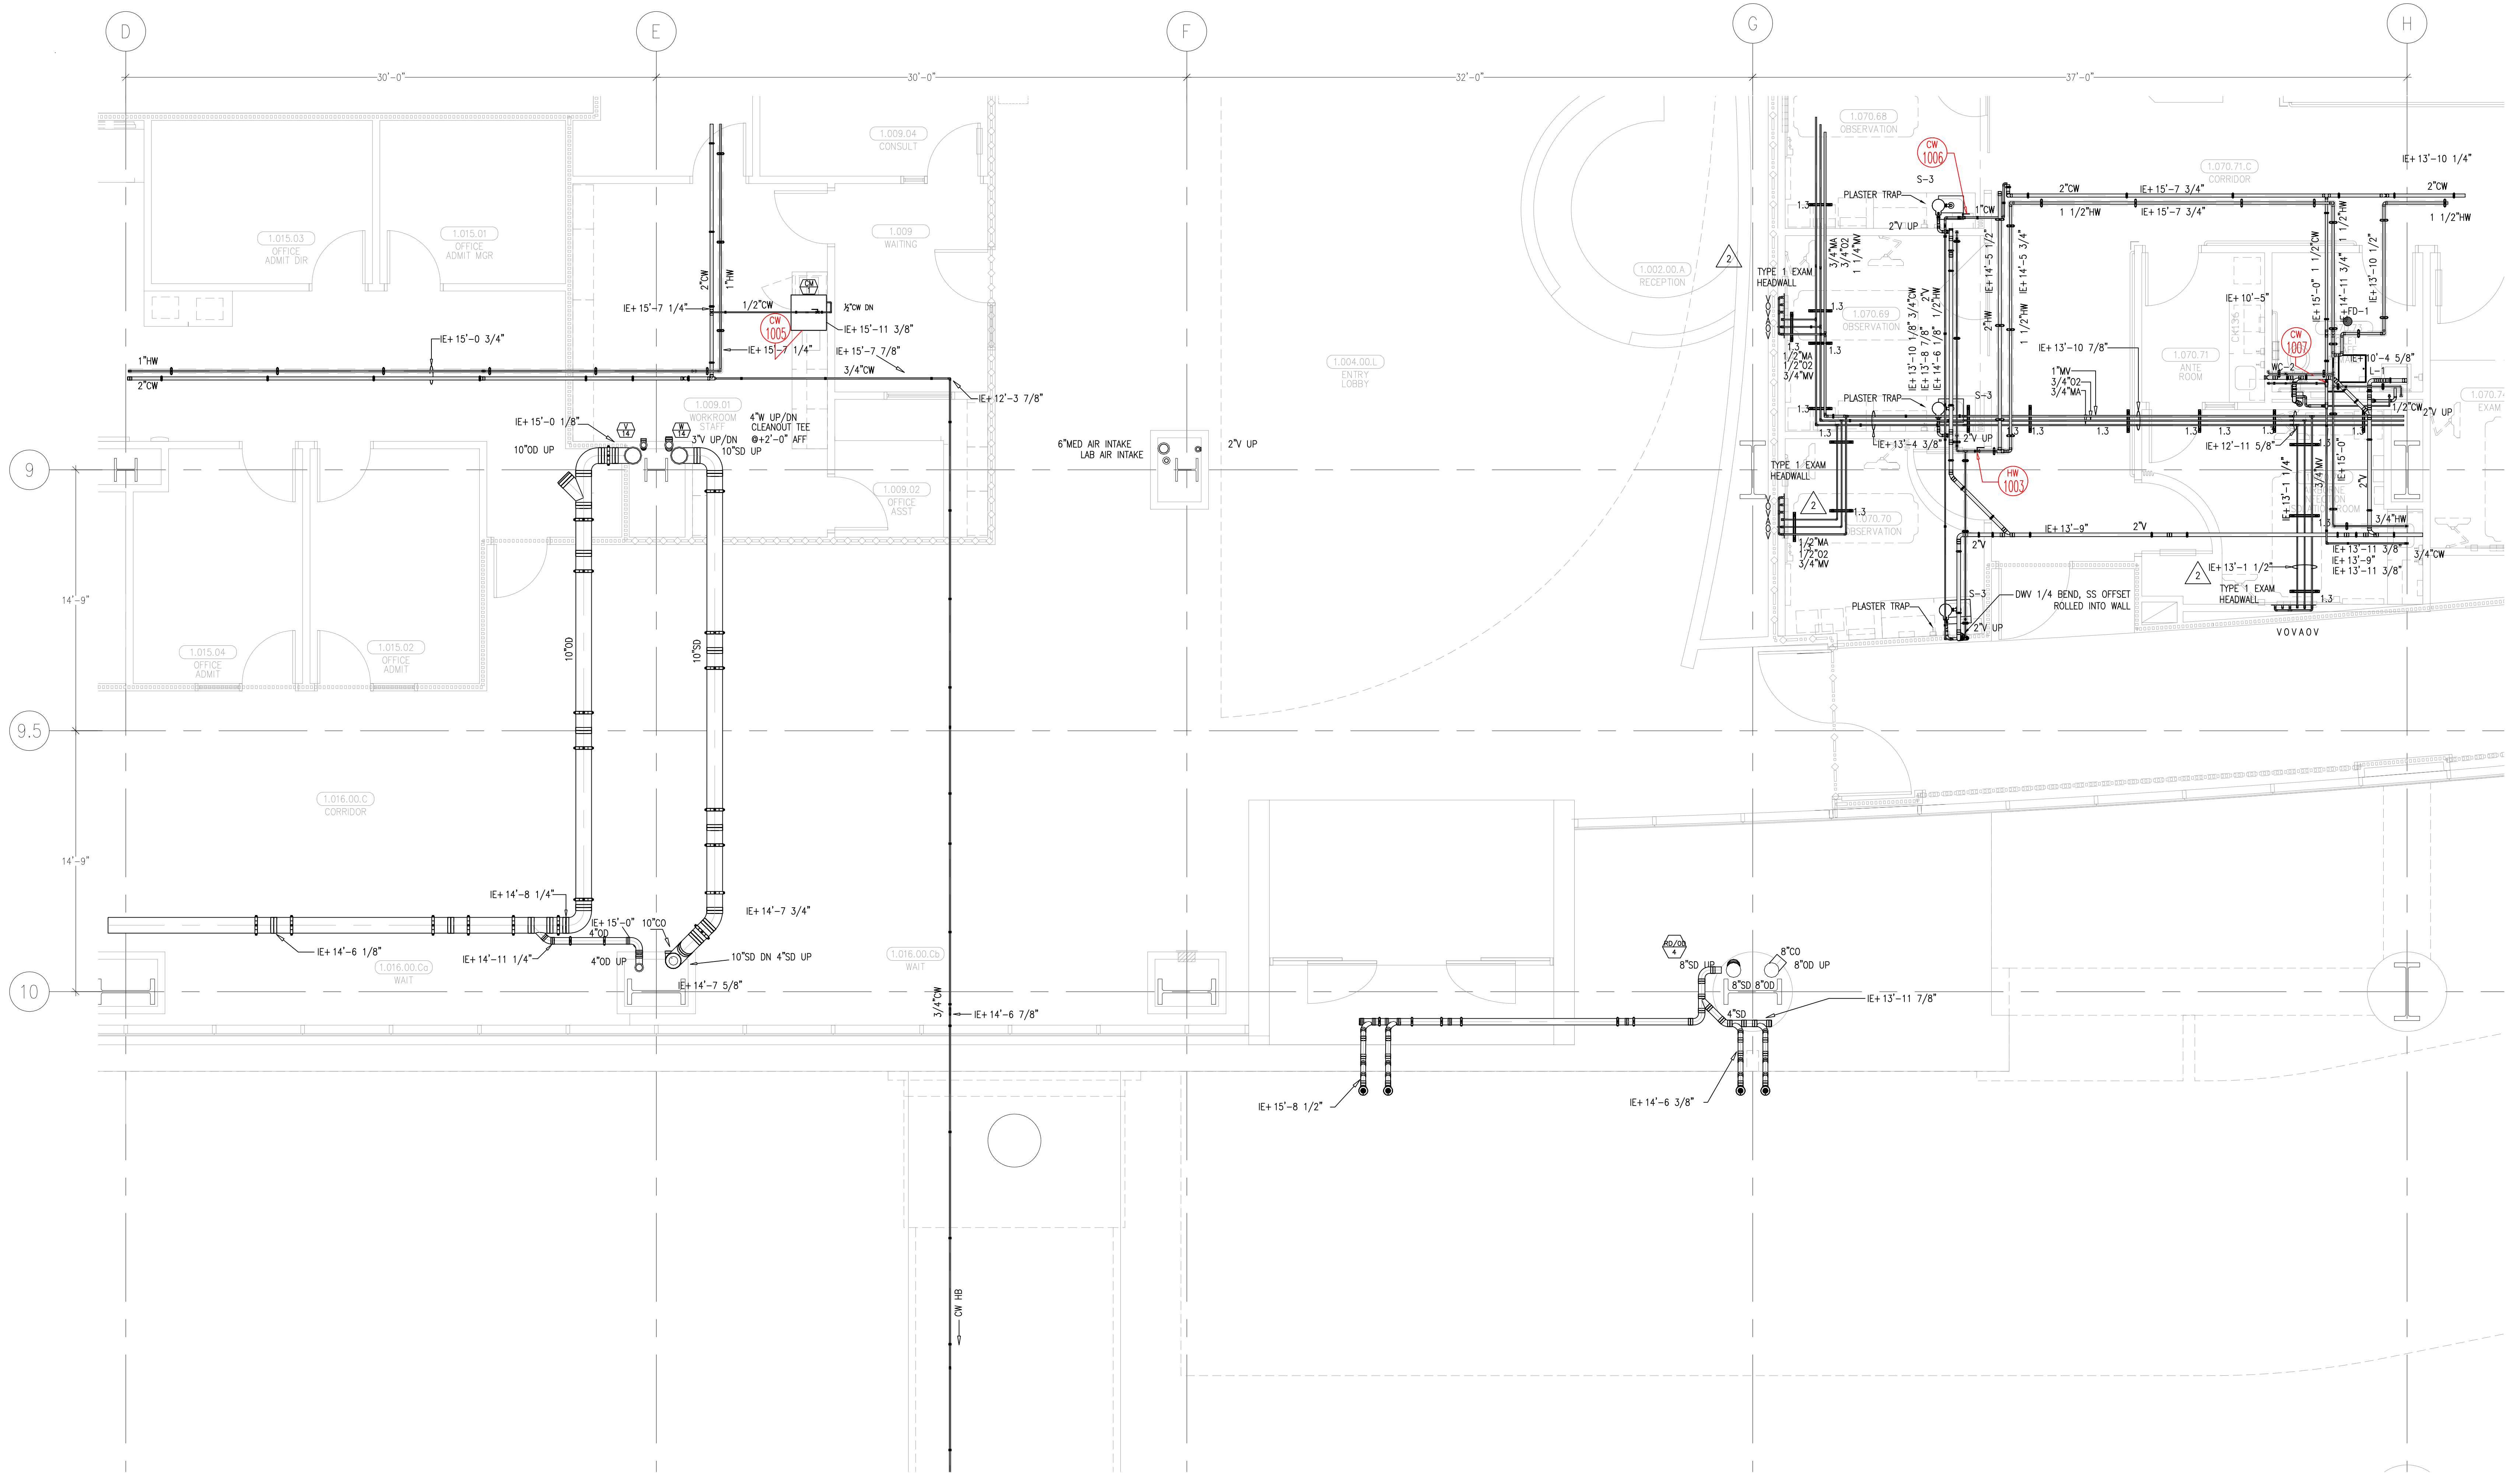

1 ALL FD-1 TOP OF DRAINS
TO BE SET $-1/2"$ BELOW
FINISHED FLOOR PER PPMC 0800

MCCARTHY APPROVAL

A. Approved as noted for Architectural Review ☐

B. Review and Resubmit ☐

C. Rejected ☐

This review is for general conformance with Plans and Specifications only. Any deviations from same not clearly noted by the Preparer have not been reviewed. Review shall not constitute a complete check of detailed dimensions or count to serve to relieve the Preparer of contractual responsibility for any error or deviation from contract requirements.

McCarthy

By _____ Date _____
SHOP DRAWING REFERENCE NO. _____

REVISONS	BY
ISSUED FOR COORDINATION SIGN-OFF 11-4-09	DK
ISSUED FOR OSHPD PERMIT RE-COORDINATION SIGN-OFF 3-8-10	DK
ISSUED FOR CONSTRUCTION 04-09-10	DK
ADDED NOTE FOR FD-1 PER CON RFI 1270 PROJECT CLOSURE 5-4-10	REGO
REVISED PER HEADWALL COORDINATION 10-18-10	JT
ADDED RELEASER TRAPS PER CO# 54 12-13-10	DK
CLEANOUT ANNOTATIONS ADDED 12-28-10	JT
ADDED STORM DRAIN PER CO# 284 08-30-11	CP

MECHANICAL DUCT	
MECHANICAL PIPE	
PLUMBING	
ELECTRICAL	
FIRE SPRINKLER	
PIPE	
DRYWALL/FRAME	
REFRIGERATION	
STRUCTURAL	

	R.F.I.	SENT	ANS.	R.F.I.	SENT	ANS.
0295	06/19/09		08/21/09			
0207	06/19/09		09/09/09			
0208R1	09/01/09		09/11/09			
0294	08/06/09		09/24/09			
0306	08/07/09		09/10/09			
0399	09/11/09		09/29/09			

 CHILDREN'S HOSPITAL
OF ORANGE COUNTY

455 S. Main St.
Orange, CA 92868-3874

PLUMBING FLOOR PLAN - LEVEL 01 AREA-F

PAN-PACIFIC
PLUMBING & MECHANICAL


PAN-PACIFIC
PLUMBING & MECHANICAL

Murray Company

2919 E. VICTORIA STREET, RANCHO DOMINGUEZ, CA 90221
OIL, GAS, PETROLEUM, FUEL, FURNACE, OIL, GAS, PETROLEUM

DRAWN R.O.
CHECKED
M.M.
DATE
4/30/2012
SCALE
1/4" = 1' - 0"
JOB NO.
09-006
DRAWING NUMBER
PL3.1E
REFERENCE DRAWING
A3.1F
P3.1F
1 OF 1 SHEETS

This document and the design it covers are the property of Murray Co. They are loaned only with the borrower's expressed written agreement that they will not be reproduced, copied, loaned, exhibited, or used in any other way, except by written consent from Murray Co. to the borrower.

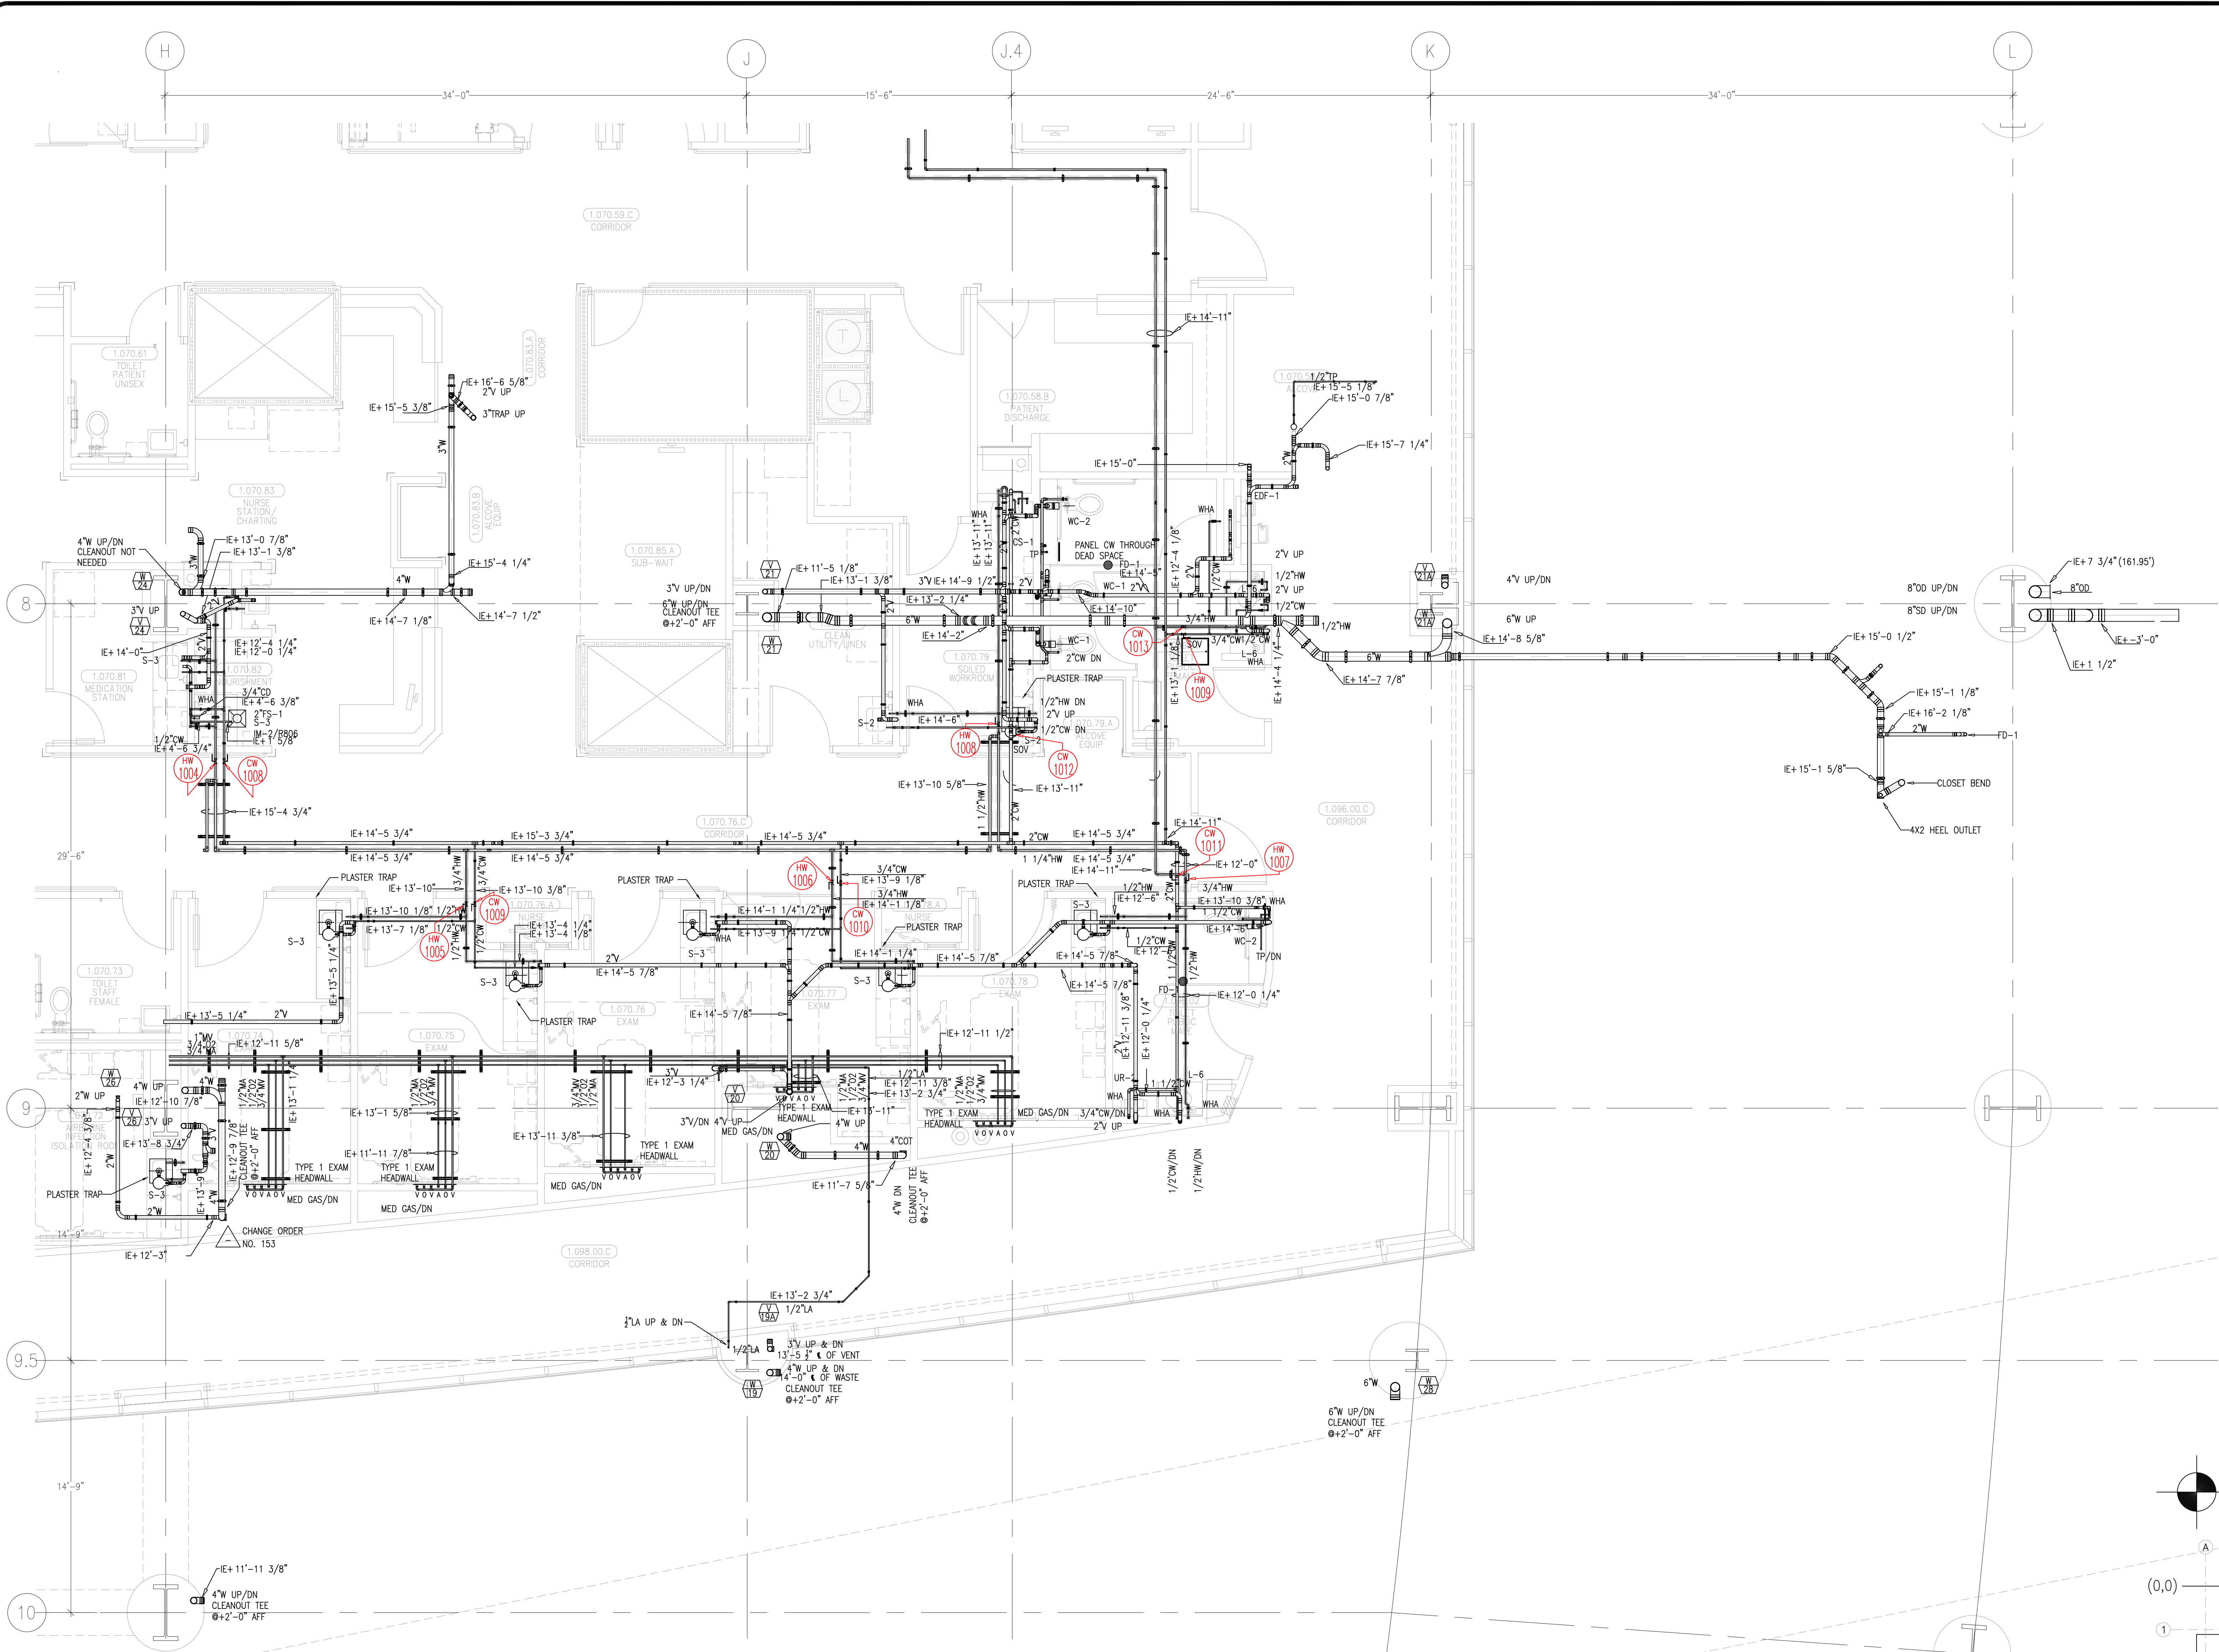

1	ISSUED FOR COORDINATION SIGN-OFF 11-4-09	DK
2	ALL FD-1 TOP OF DRAWS TO BE SET -1/2" BELOW FINISHED FLOOR PER PWC 0800	DK
3	ISSUED FOR OSHPD PERMIT RE-COORDINATION SIGN OFF 3-8-10	DK
4	ISSUED FOR CONSTRUCTION 04-09-10	DK
5	REVISED FOR CON RFI 1115 04-14-10	DK

REVISIONS	BY
1	RED
2	JT
3	JT
4	JT
5	DK
6	JT
7	DK
8	JT
9	DK

MCCARTHY APPROVAL

A. Approved as noted for Architectural Review ☐

B. Review and Recheck ☐

C. Recheck ☐


This review is for general conformance with Plans and Specifications only. Any deviations from same not clearly noted by the Engineer here and there. Reviewer shall be responsible for a complete check of detailed dimensions or count to verify to where the Engineer or contractor responsible for any error or deviation from contract requirements.

McCarthy

By: _____ Date: _____

SHOP DRAWING REFERENCE NO. _____

LEVEL 01 161.30' = 0'-0"
REFERENCE THIS SHEET

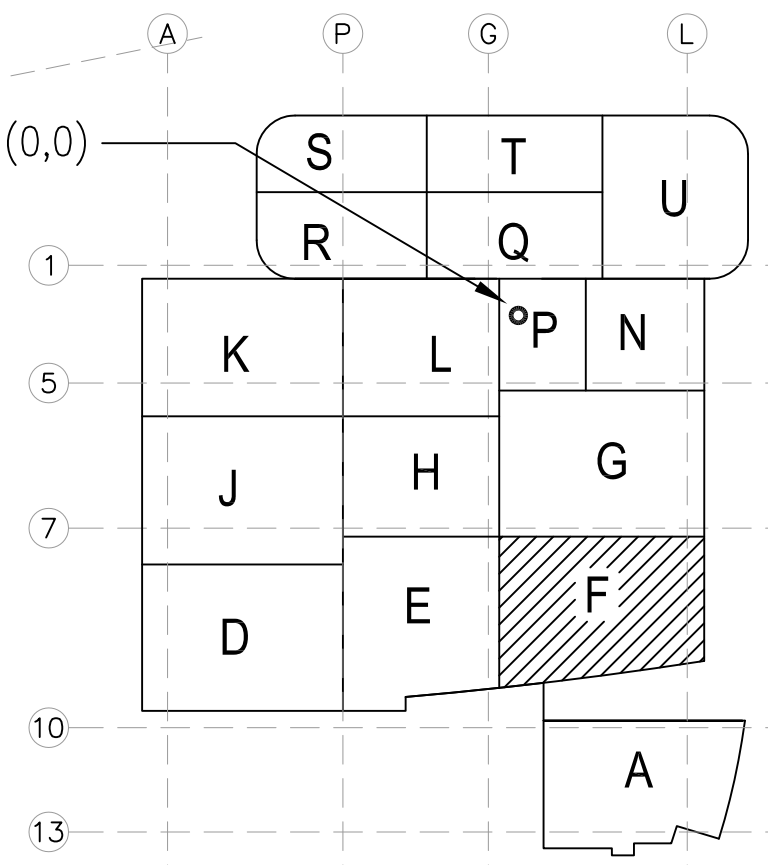

KEY PLAN

0954 08/25/10 XX/XX/XX
0955 07/20/10 07/23/10
0956 05/19/10 07/14/10


COORD.	SIGNATURE	DATE
MECHANICAL		
PLUMBING		
ELECTRICAL		
FIRE SPRINKLER		
PIPE		
BRICK/FRAMER		
REVISIONS		

**CHILDREN'S HOSPITAL
OF ORANGE COUNTY**
HOSPITAL
455 S. Main St.
Orange, CA 92668-8874
TOWER II
PLUMBING FLOOR PLAN - LEVEL 01 AREA-F

PAN-PACIFIC
PLUMBING & MECHANICAL
Murray Co.
2919 E. VICTORIA STREET, RANCHO DOMINGUEZ, CA 90221
PH. 310.637-1500 FAX. 310.604-0358

DRAWN R.O.
CHECKED M.M.
DATE 4/30/2012
SCALE 1/4"=1'-0"
JOB NO. 09-006
DRAWING NUMBER PL3.1F
REFERENCE DRAWING A3.1F
P3.1F
1 OF 1 SHEETS

This document and the design it covers are the property of Murray Co. They are loaned only with the borrower's expressed written agreement that they will not be reproduced, copied, loaned, exhibited, or used in any way, except by written consent from Murray Co. to the borrower.

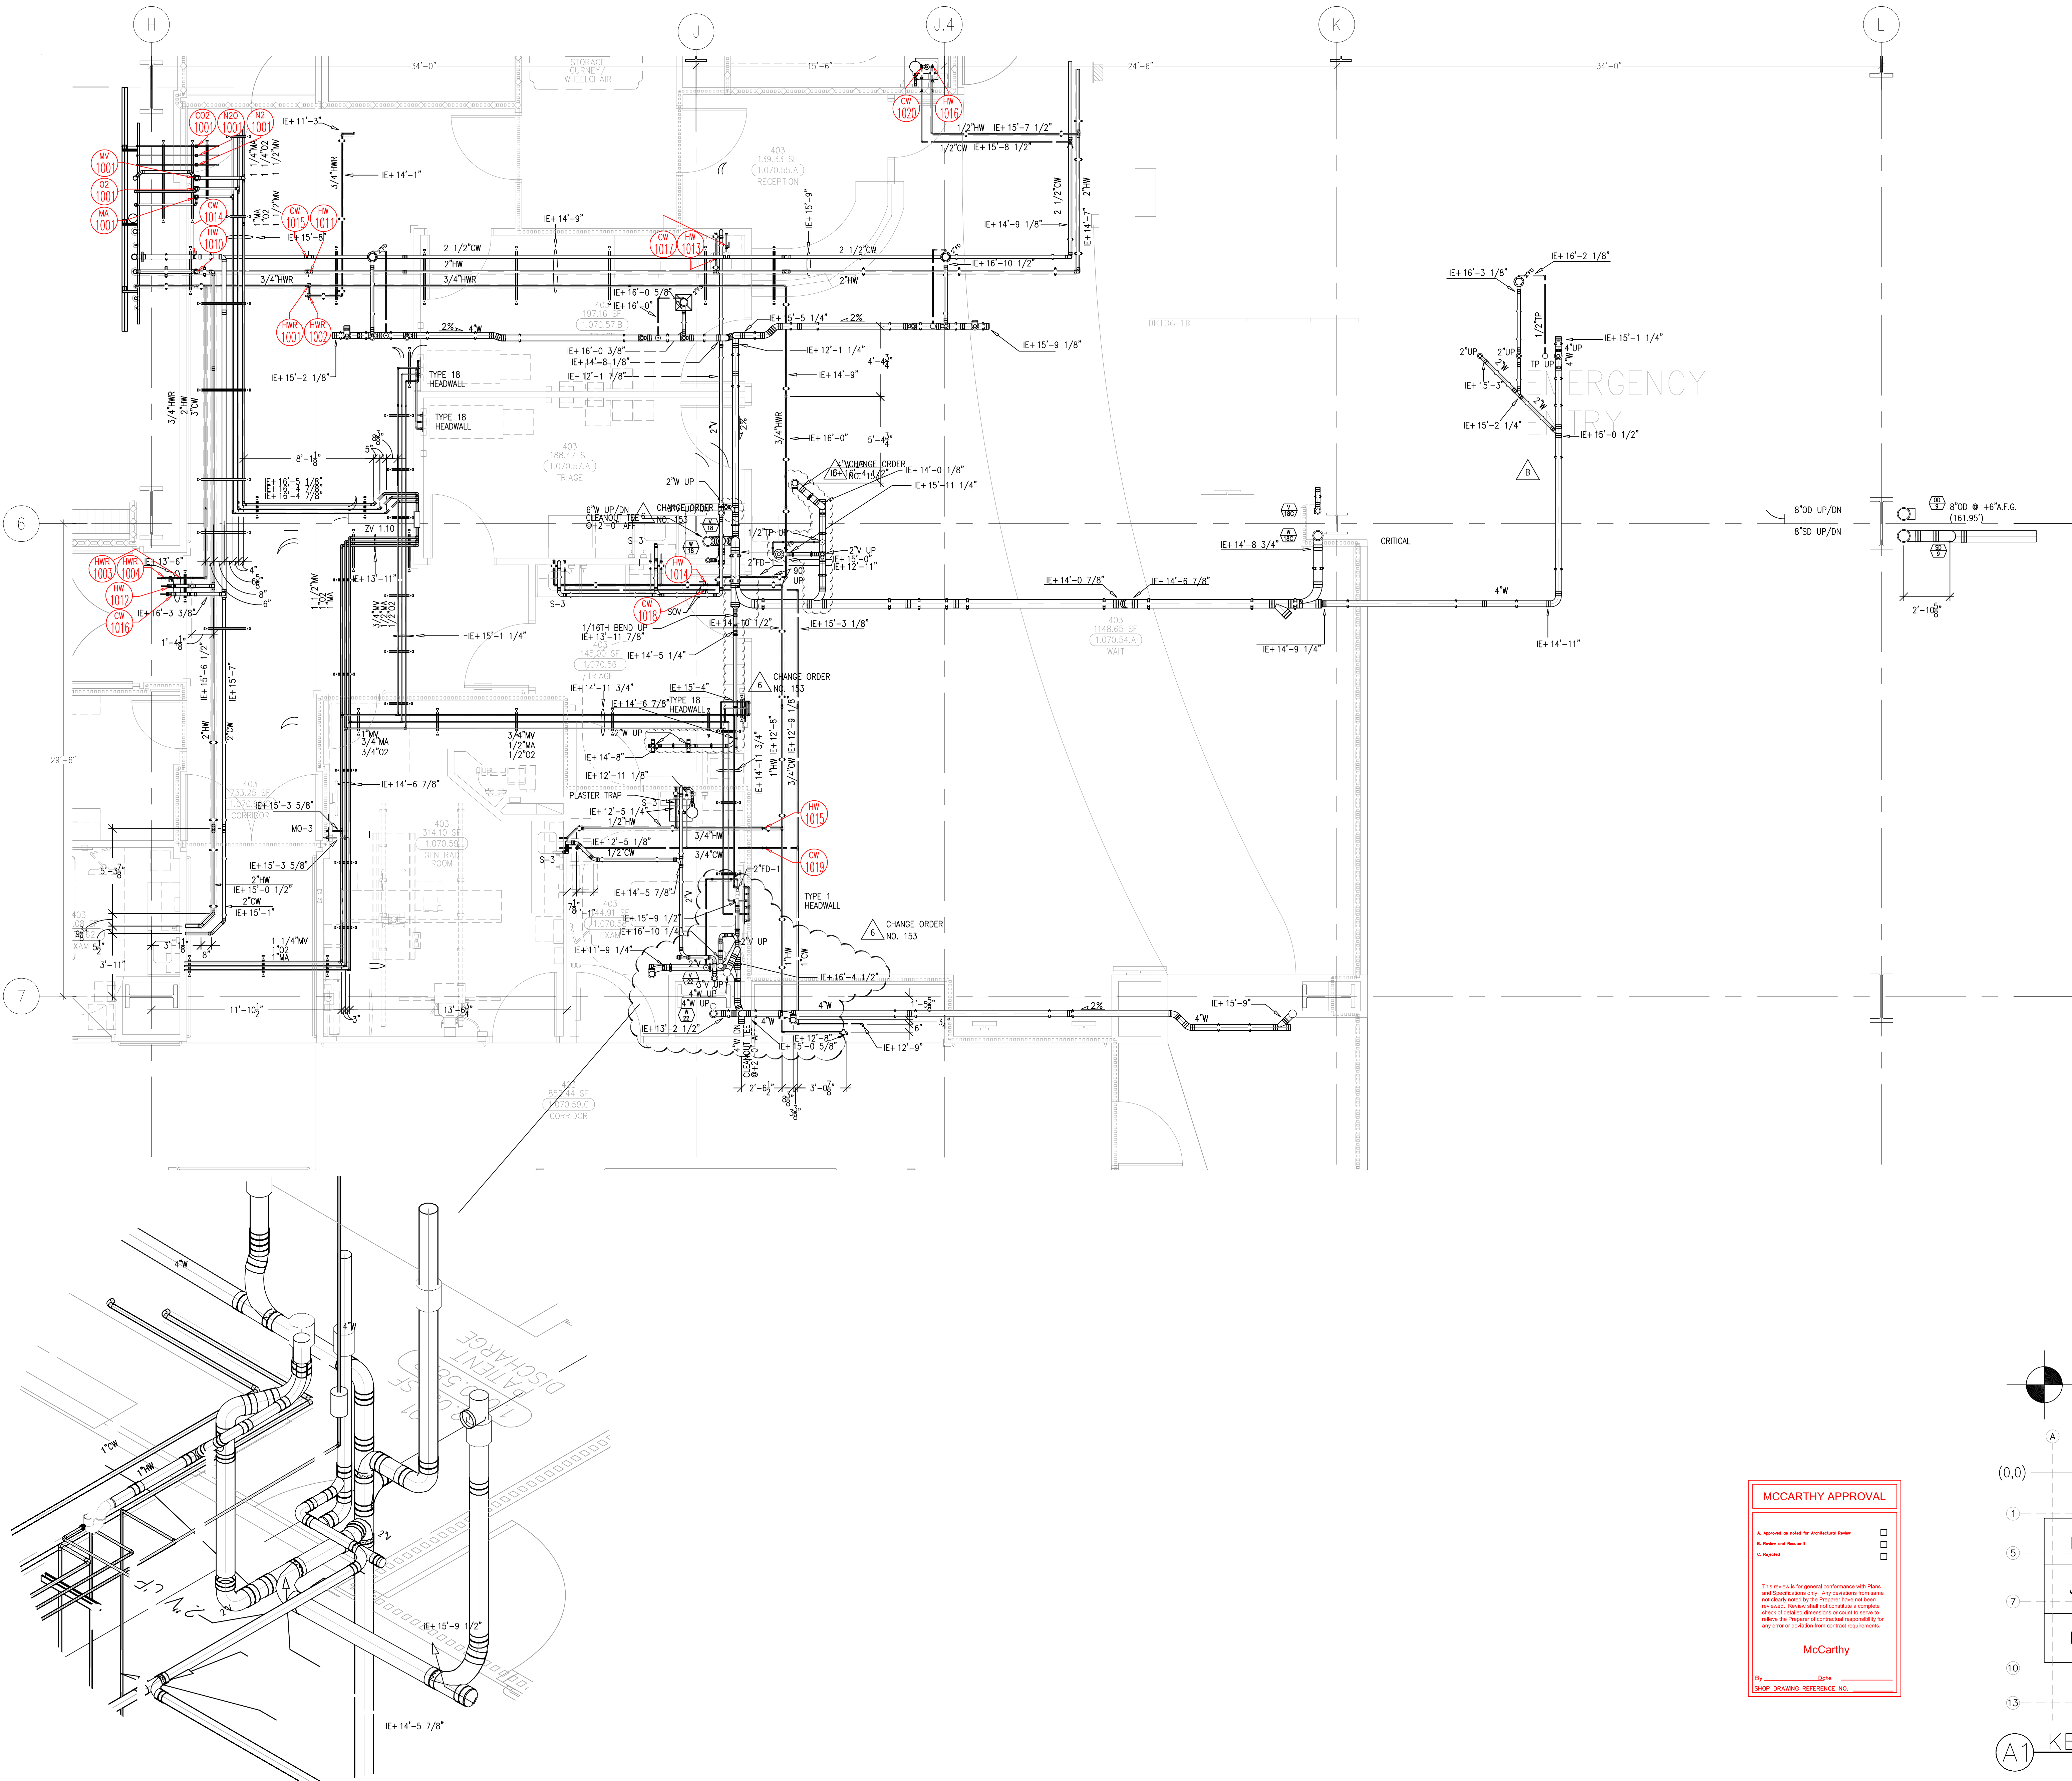

MCCARTHY APPROVAL


A. Approved as noted for Architectural Review
B. Review and Record
C. Rejected

This review is for general conformance with Plans and Specifications only. Any deviations from same not clearly noted by the Proprietor must be noted. Reviewer shall not constitute a complete check of detailed dimensions or count for same to release the Proprietor of contractual responsibility for any error or deviation from contract requirements.

McCarthy

By: _____ Date: _____
SHOP DRAWING REFERENCE NO. _____

LEVEL 01 161.30' = 0'-0"
REFERENCE THIS SHEET

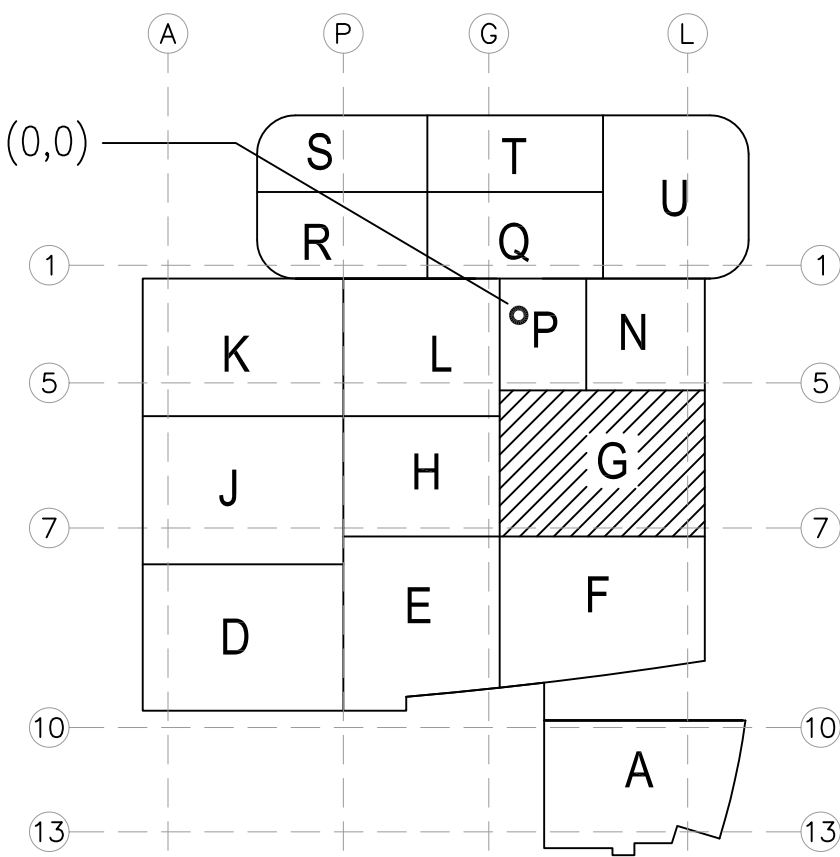

KEY PLAN

ISSUED FOR COORDINATION
SIGN-OFF 11-4-09 DK

CONSTRUCTION RFI 201
REVISED WASTE SLOPE
PER ENGINEERS REQUEST
REVISED DUE TO
SOFTT CONFLICT
REVISED PER HEADWALL
COORDINATION
REVISED PER PLASTER TRAPS
COORDINATION
CLEANOUT ANNOTATIONS
ADDED
12-28-10
COM 153 REVISIONS
3-22-11

REVISIONS	BY
0	DK
1	DK
2	DK
3	DK
4	DK
5	DK
6	DK

COORD.	SIGNATURE	DATE
MECHANICAL		
ELECTRICAL		
PLUMBING		
STRUCTURAL		


R.F.I.	SENT	ANS.	R.F.I.	SENT	ANS.
0163	05/03/09	06/11/09	0486	10/02/09	10/14/09
0165	06/02/09	06/12/09	0503	10/07/09	11/12/09
0306	08/07/09	08/10/09	0513	11/24/09	12/07/09
0313	09/14/09	09/04/09	0644	01/05/10	04/01/10
0322	08/20/09	09/25/09			
0354	08/23/09	09/18/09			
0418	09/28/09	10/13/09			

**CHILDREN'S HOSPITAL
OF ORANGE COUNTY**
455 S. MAIN ST., SUITE 200
ORANGE, CA 92668-3974
TOWER II
PLUMBING FLOOR PLAN - LEVEL 01 AREA H

PAN-PACIFIC
PLUMBING & MECHANICAL
2919 E. VICTORIA STREET, RANCHO DOMINGUEZ, CA 90221
PH. 310 637-1500 FAX 310 604-0359

DRAWN
R.O.
CHECKED
M.M.
DATE
4/30/2012
SCALE
1/4" = 1'-0"
JOB NO.
09-006
DRAWING NUMBER
PL3.1G
REFERENCE DRAWING
A3.1G
P3.1G
1 OF 1 SHEETS

This document and the design it covers are the property of Murray Co. They are loaned only with the borrower's expressed written agreement that they will not be reproduced, copied, loaned, exhibited, or used in any other way, except by written consent from Murray Co. to the borrower.

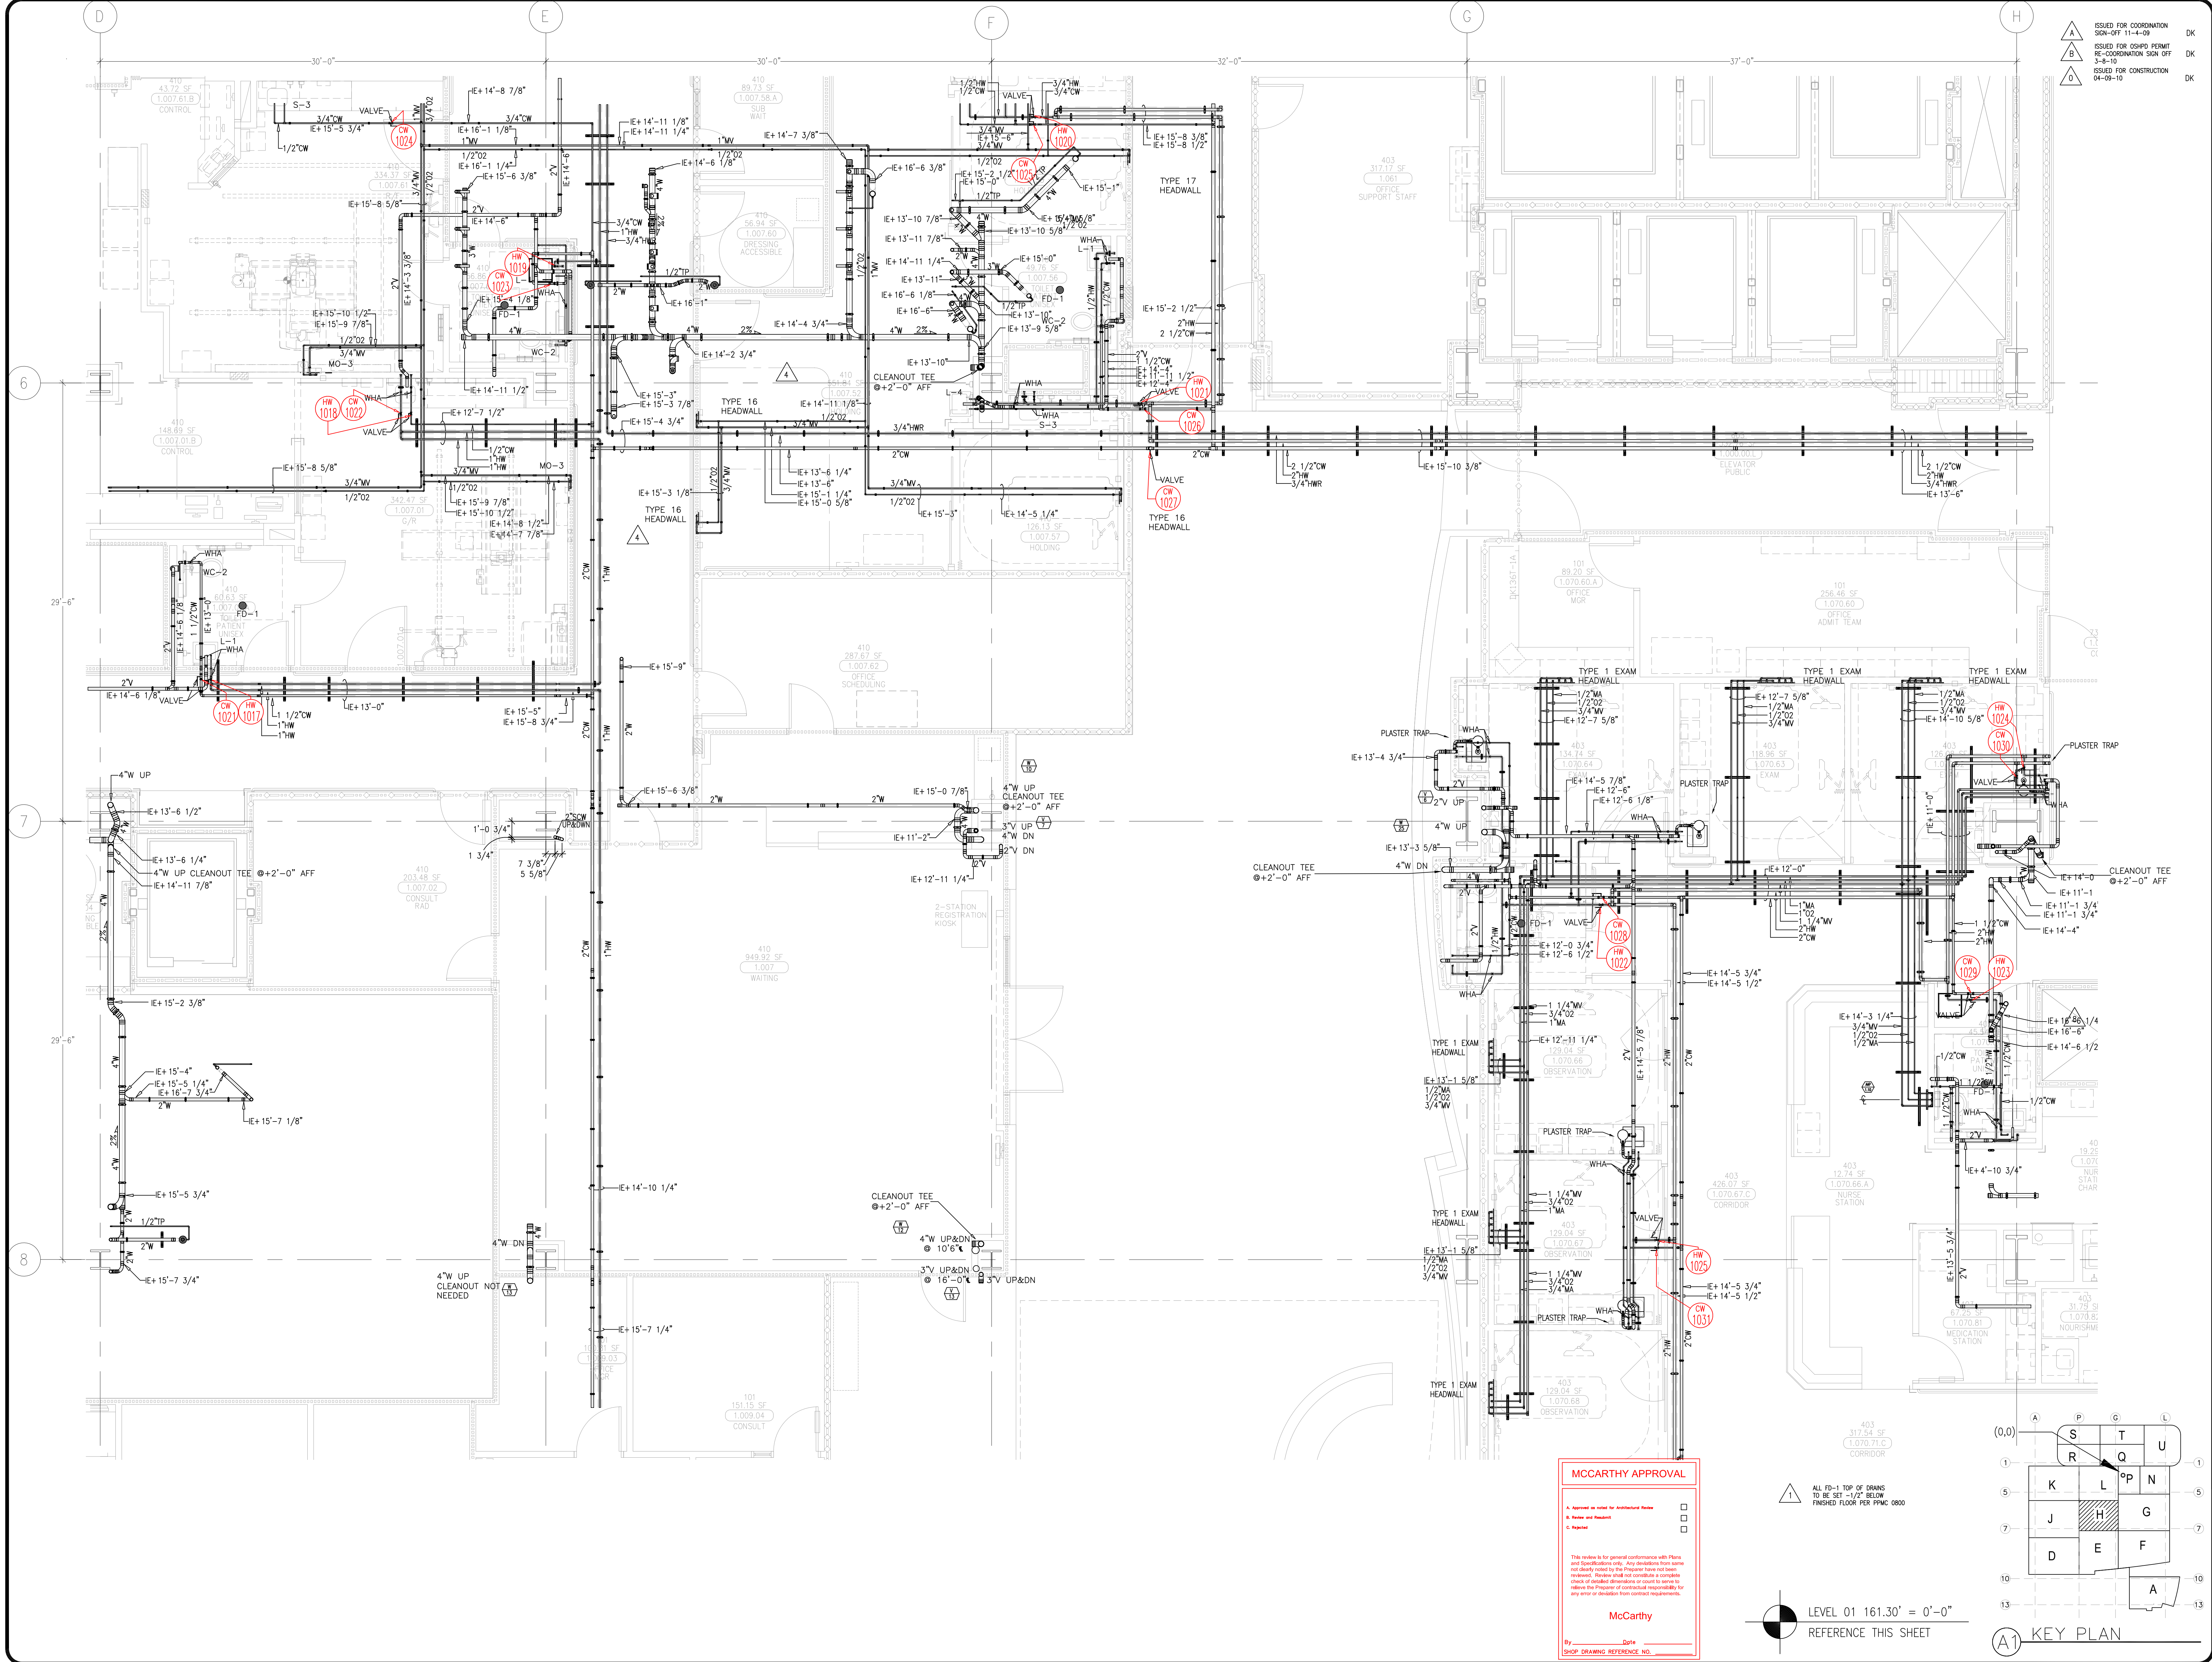

REVISIONS	BY
1. ISSUED FOR COORDINATION	DK
2. PER CHOC RFI 1270	DK
3. CHANGE PER CHOC RFI 304	DK
4. REVISIONS REQUEST	DK
5. REVISIONS REQUEST	DK
6. REVISIONS REQUEST	DK
7. REVISIONS REQUEST	DK
8. REVISIONS REQUEST	DK

COORD.	SIGNATURE	DATE
MECHANICAL		
ELECTRICAL		
PLUMBING		
STRUCTURAL		

CHILDREN'S HOSPITAL
CHOC OF ORANGE COUNTY
455 S. MAIN ST., SUITE 300
ORANGE, CA 92668-3974

TOWER II
PLUMBING FLOOR PLAN - LEVEL 01 AREA H

McCarthy

APPROVED FOR CONSTRUCTION


DATE: 04-09-10

ALL FD-1 TOI DRAINS
TO BE SET -1/2" BELOW
FINISHED FLOOR PER FINWC 0800



KEY PLAN

1 OF 1 SHEETS

This document and the design it covers are the property of Murray Co. They are loaned only with the borrower's expressed written agreement that they will not be reproduced, copied, loaned, exhibited, or used in any other way, except by written consent from Murray Co. to the borrower.

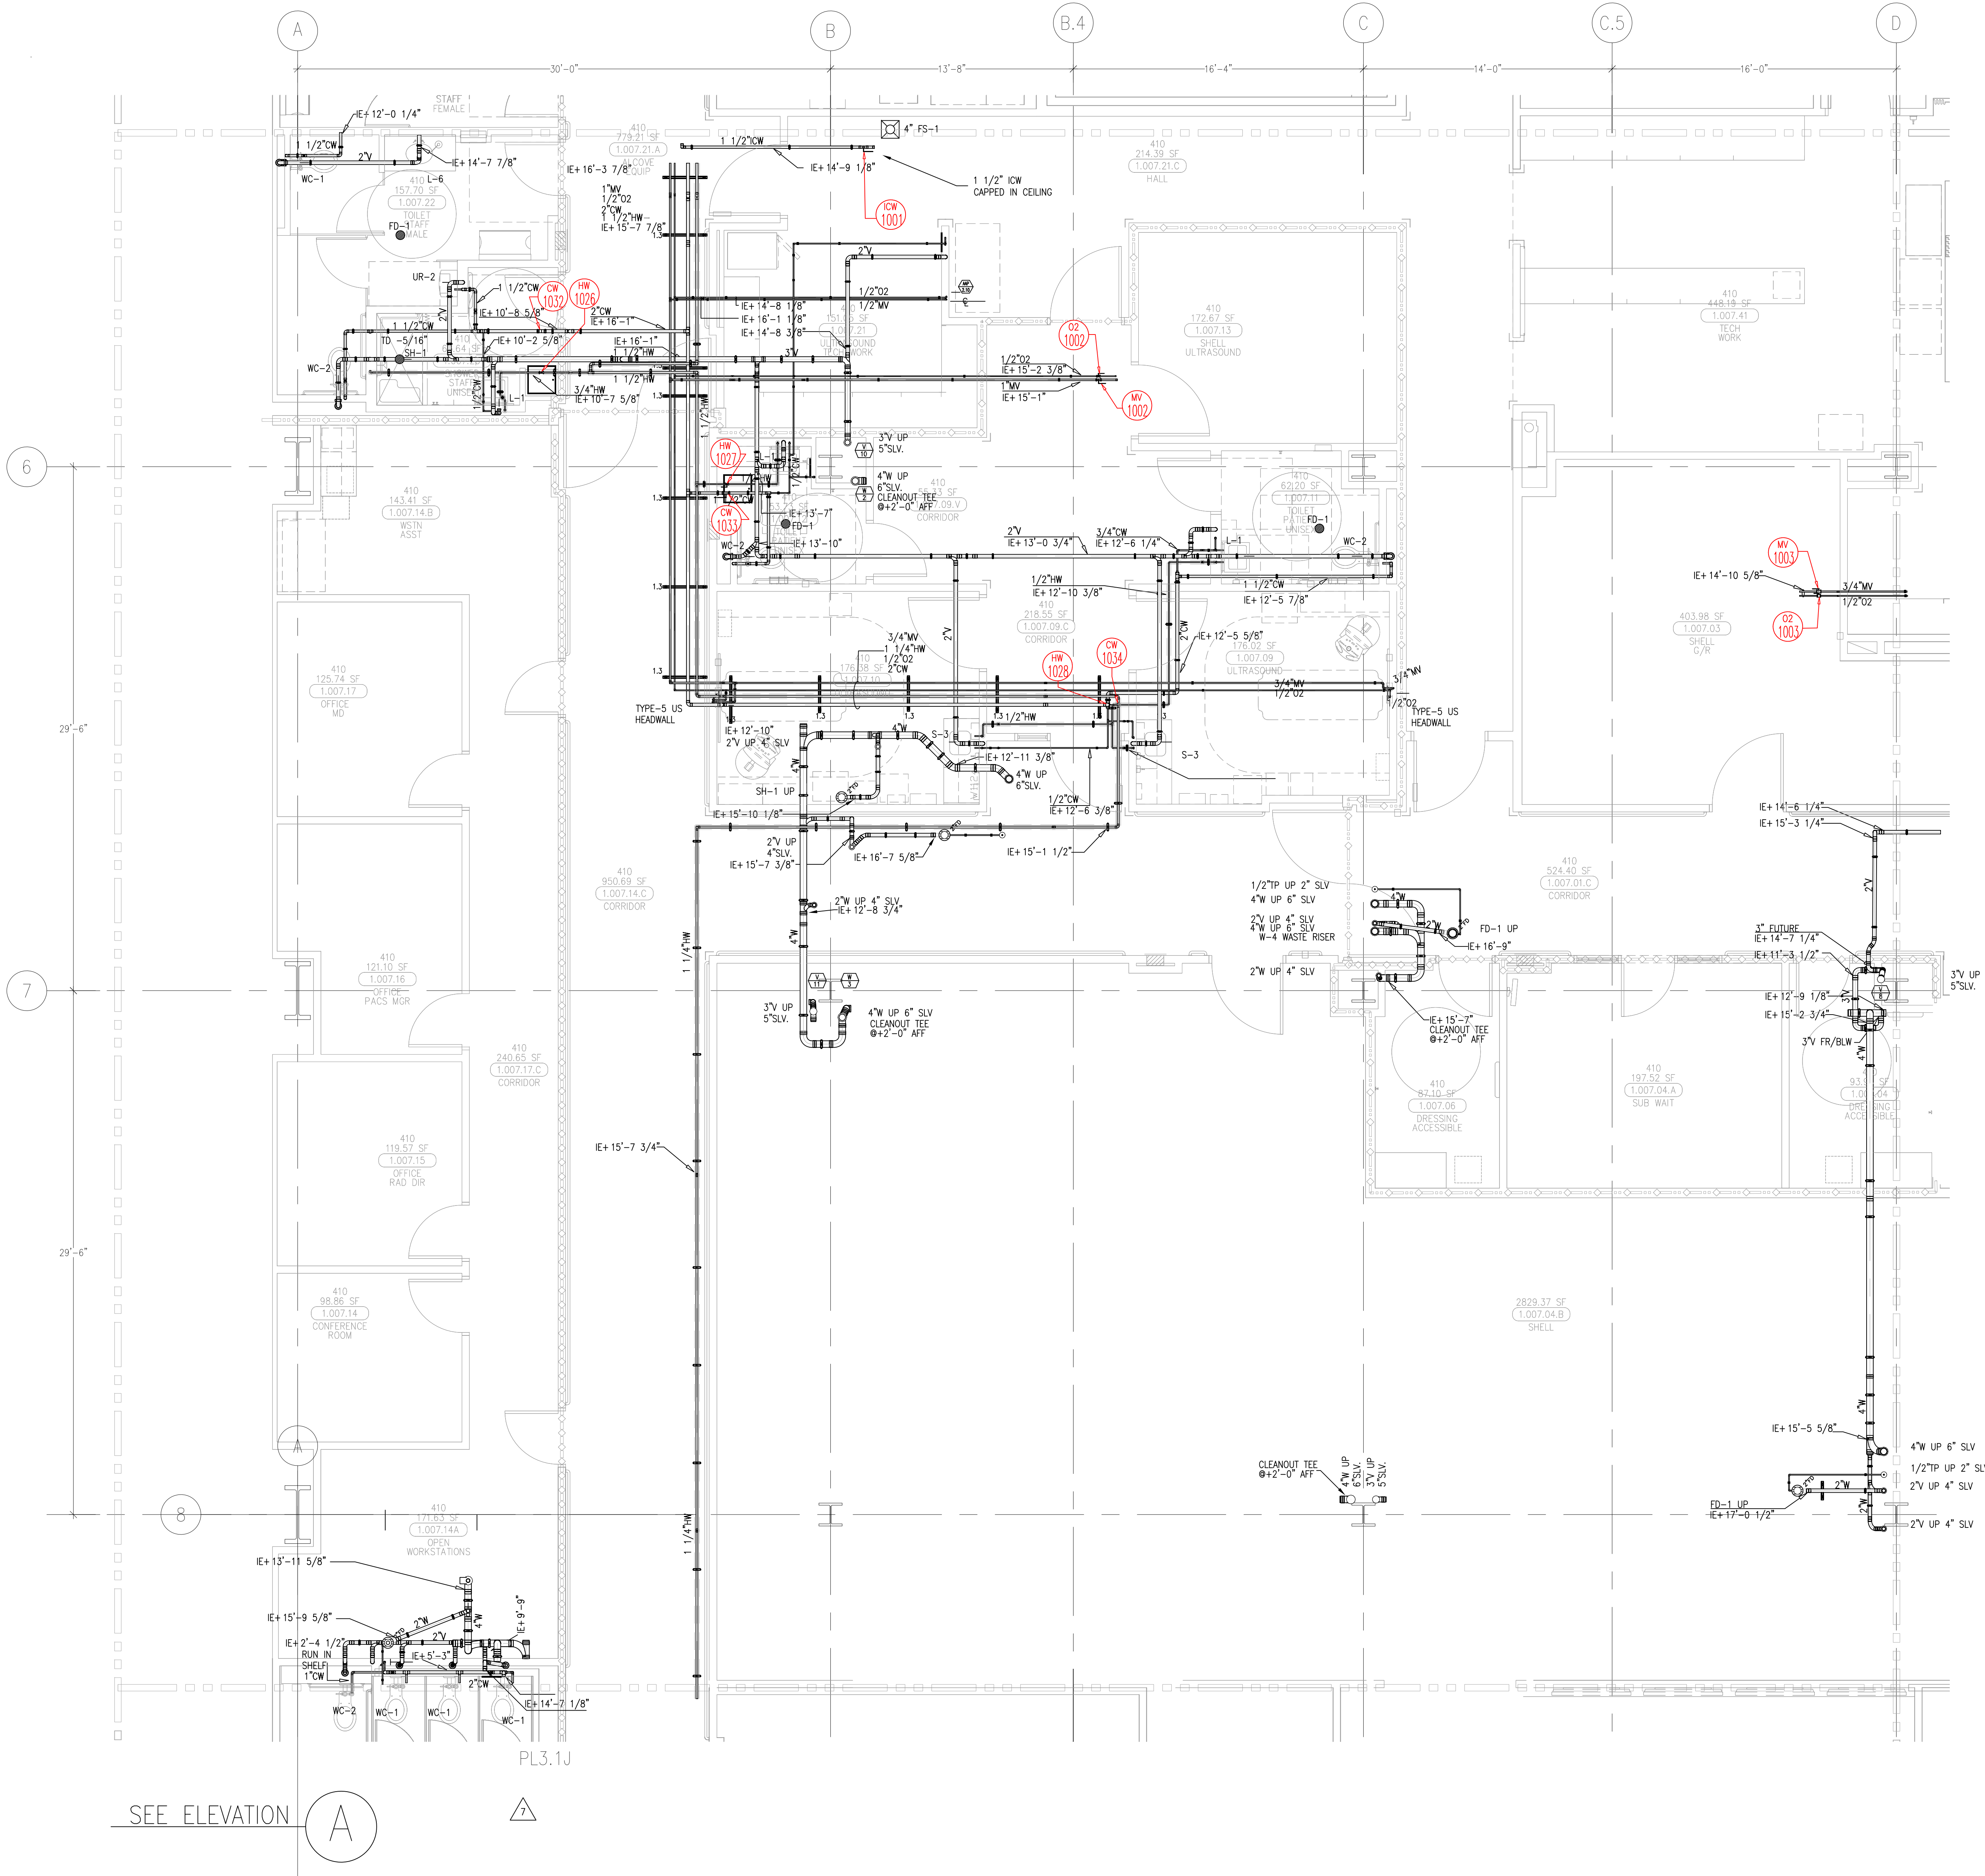

- 1 ALL FD-1 TOP OF DRAINS TO BE SET -1/2\"/>
- 2 ADD NOTE FOR FD-1 PER CON RFI 120. PPMC RFI 0800 5-4-10 TOILET ROOM LAYOUT CHANGE PER PPMC RFI 304 5-24-10
- 3 REVISED PER HEADWALL COORDINATION 10-13-10
- 4 CLEANOUT ANNOTATIONS ADDED 12-28-10
- 5 REVISED L/W WASTE AND WATER 1-7-11
- 6 REVISED PER RFI 3205 (C-1033481) 03-26-11
- 7 REVISED FOR OSHPD CODES PMP/05 0264 05-11
- 8 REVISED PER RFI 3908 PPMC RFI 1321 06-22-11

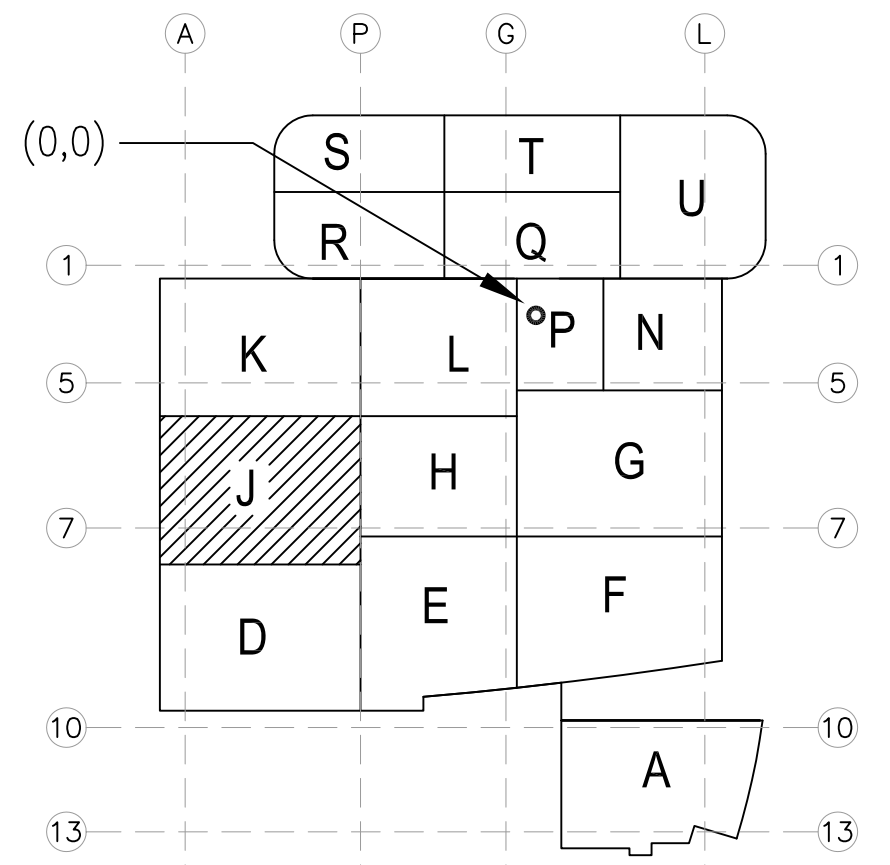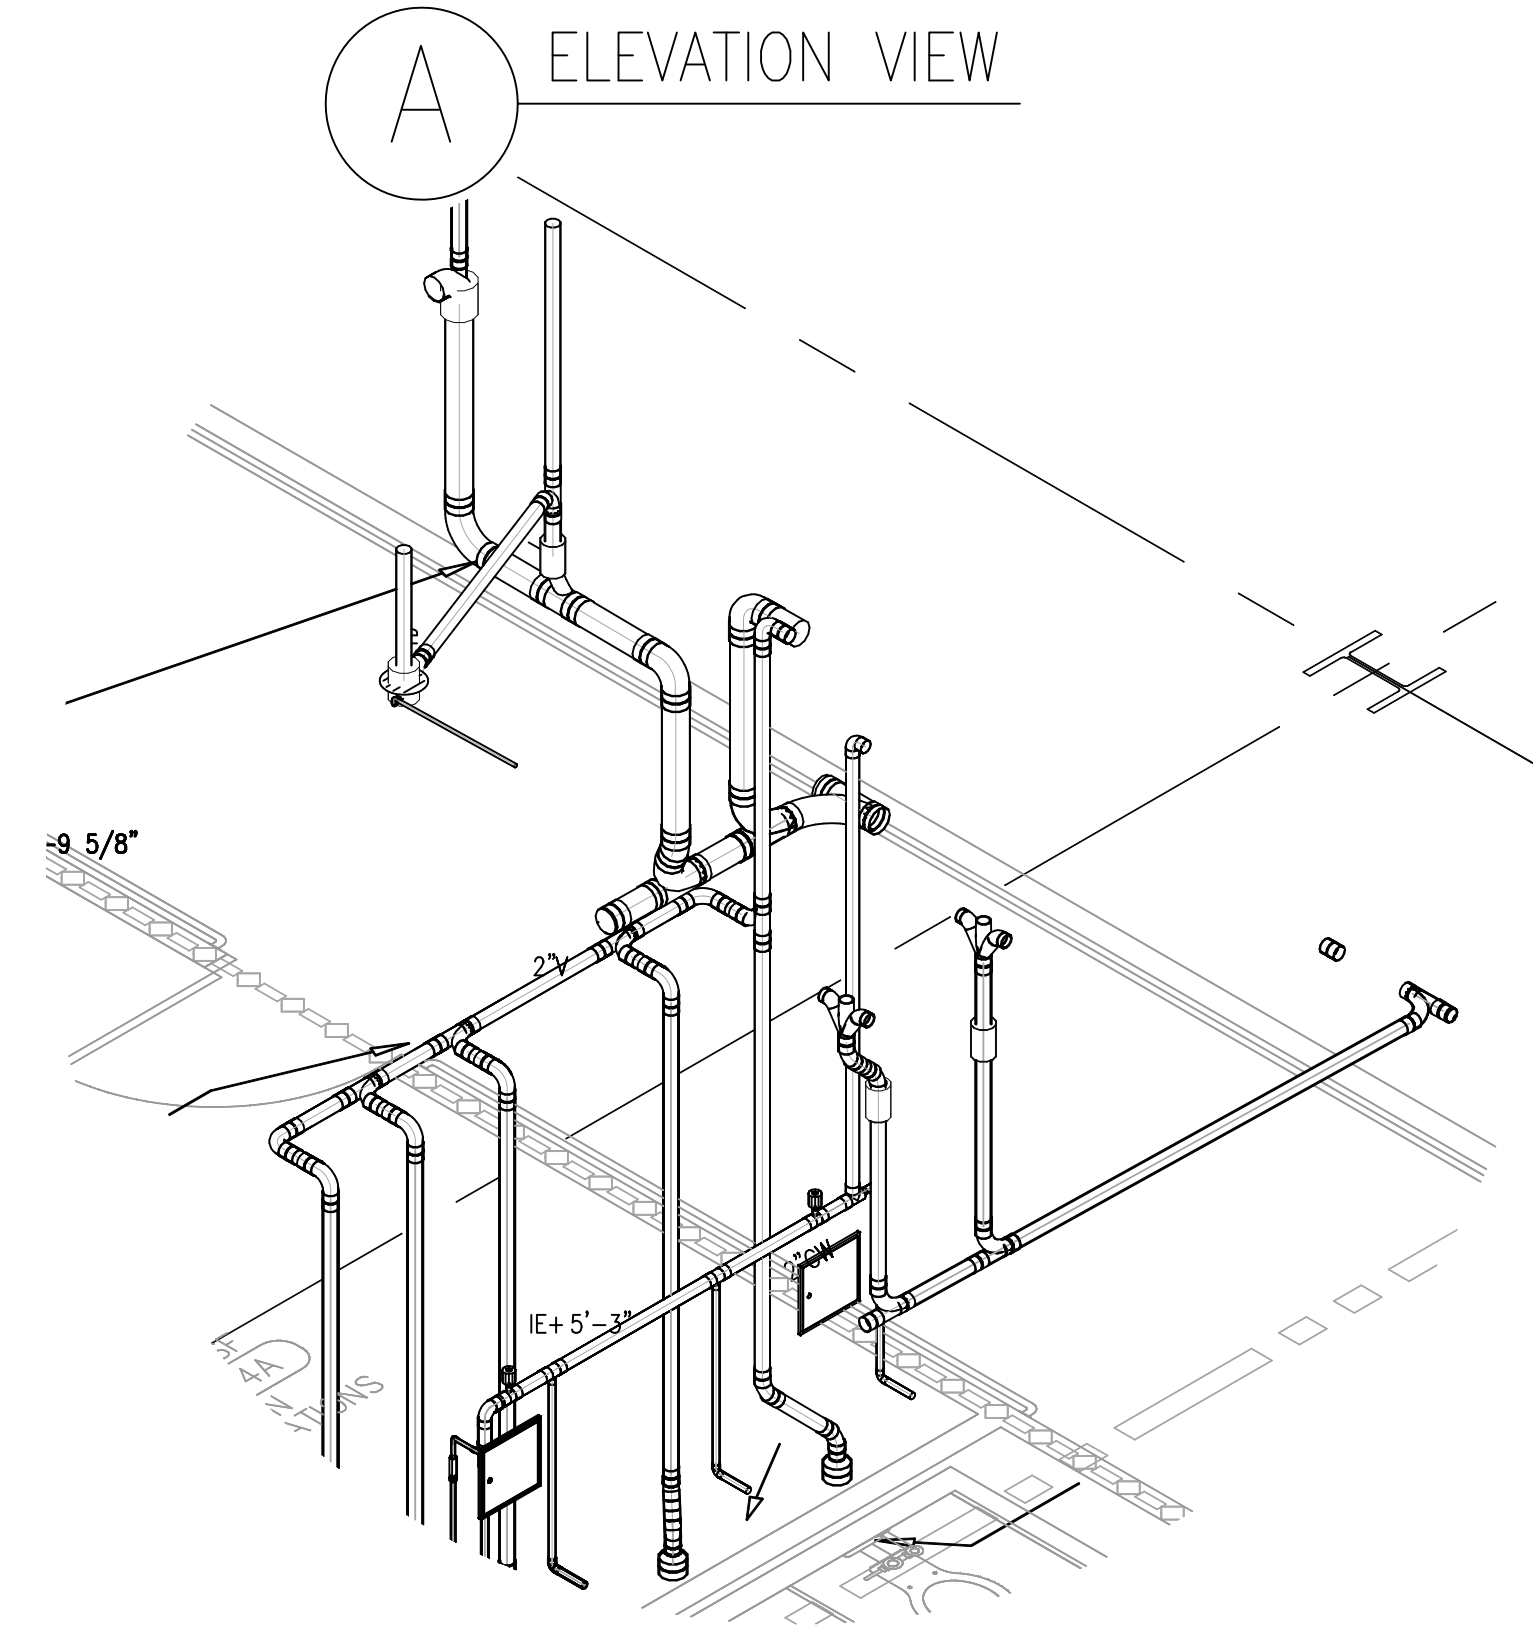

MCCARTHY APPROVAL

A. Approved as noted for Installation Review ☐

B. Review and Recheck ☐

C. Rejected ☐

This release is for general convenience with Plans and Specifications only. Any deviations from same not clearly noted by the Preparer have not been reviewed. Review and not constitute a complete check of detailed dimensions or omissions to serve to release the Preparer of contractual responsibility for any error or deviation from contract requirements.

McCarthy

By _____ Date _____

SHIP DRAWING REFERENCE NO. _____

REVISIONS	BY
3	JT
4	JT
5	DK
6	DK
7	JT
8	DK

COORD.	SIGNATURE	DATE
MECHANICAL		
ELECTRICAL		
PLUMBING		
STRUCTURAL		

ANS.	SENT	R.F.I.	SENT	ANS.	SENT	R.F.I.	SENT	ANS.	SENT	R.F.I.	SENT
0117	05/14/09	05/14/09	05/14/09	05/14/09	05/14/09	05/14/09	05/14/09	05/14/09	05/14/09	05/14/09	05/14/09
0168	05/12/09	05/12/09	05/12/09	05/12/09	05/12/09	05/12/09	05/12/09	05/12/09	05/12/09	05/12/09	05/12/09
0187	06/12/09	06/12/09	06/12/09	06/12/09	06/12/09	06/12/09	06/12/09	06/12/09	06/12/09	06/12/09	06/12/09
0189	06/12/09	06/12/09	06/12/09	06/12/09	06/12/09	06/12/09	06/12/09	06/12/09	06/12/09	06/12/09	06/12/09
0190	06/12/09	06/12/09	06/12/09	06/12/09	06/12/09	06/12/09	06/12/09	06/12/09	06/12/09	06/12/09	06/12/09
0193	06/12/09	06/12/09	06/12/09	06/12/09	06/12/09	06/12/09	06/12/09	06/12/09	06/12/09	06/12/09	06/12/09

CHILDREN'S HOSPITAL CHOC OF ORANGE COUNTY

455 S. MAIN ST. STE. 200
ORANGE, CA 92668-3974

TOWER II


PLUMBING FLOOR PLAN - LEVEL 01 AREA-J

PAN-PACIFIC PLUMBING & MECHANICAL


2919 E. VICTORIA STREET, RANCHO DOMINGUEZ, CA 90221
PH. 310 310-1500 FAX 310 604-0359

DRAWN R.O.
CHECKED M.M.
DATE 4/30/2012
SCALE 1/4" = 1'-0"
JOB NO. 09-006
DRAWING NUMBER PL3.1J
REFERENCE DRAWING A3.1J P3.1J
1 OF 1 SHEETS


This document and the design it covers are the property of Murray Co. They are loaned only with the borrower's expressed written agreement that they will not be reproduced, copied, loaned, exhibited, or used in any way, except by written consent from Murray Co. to the borrower.

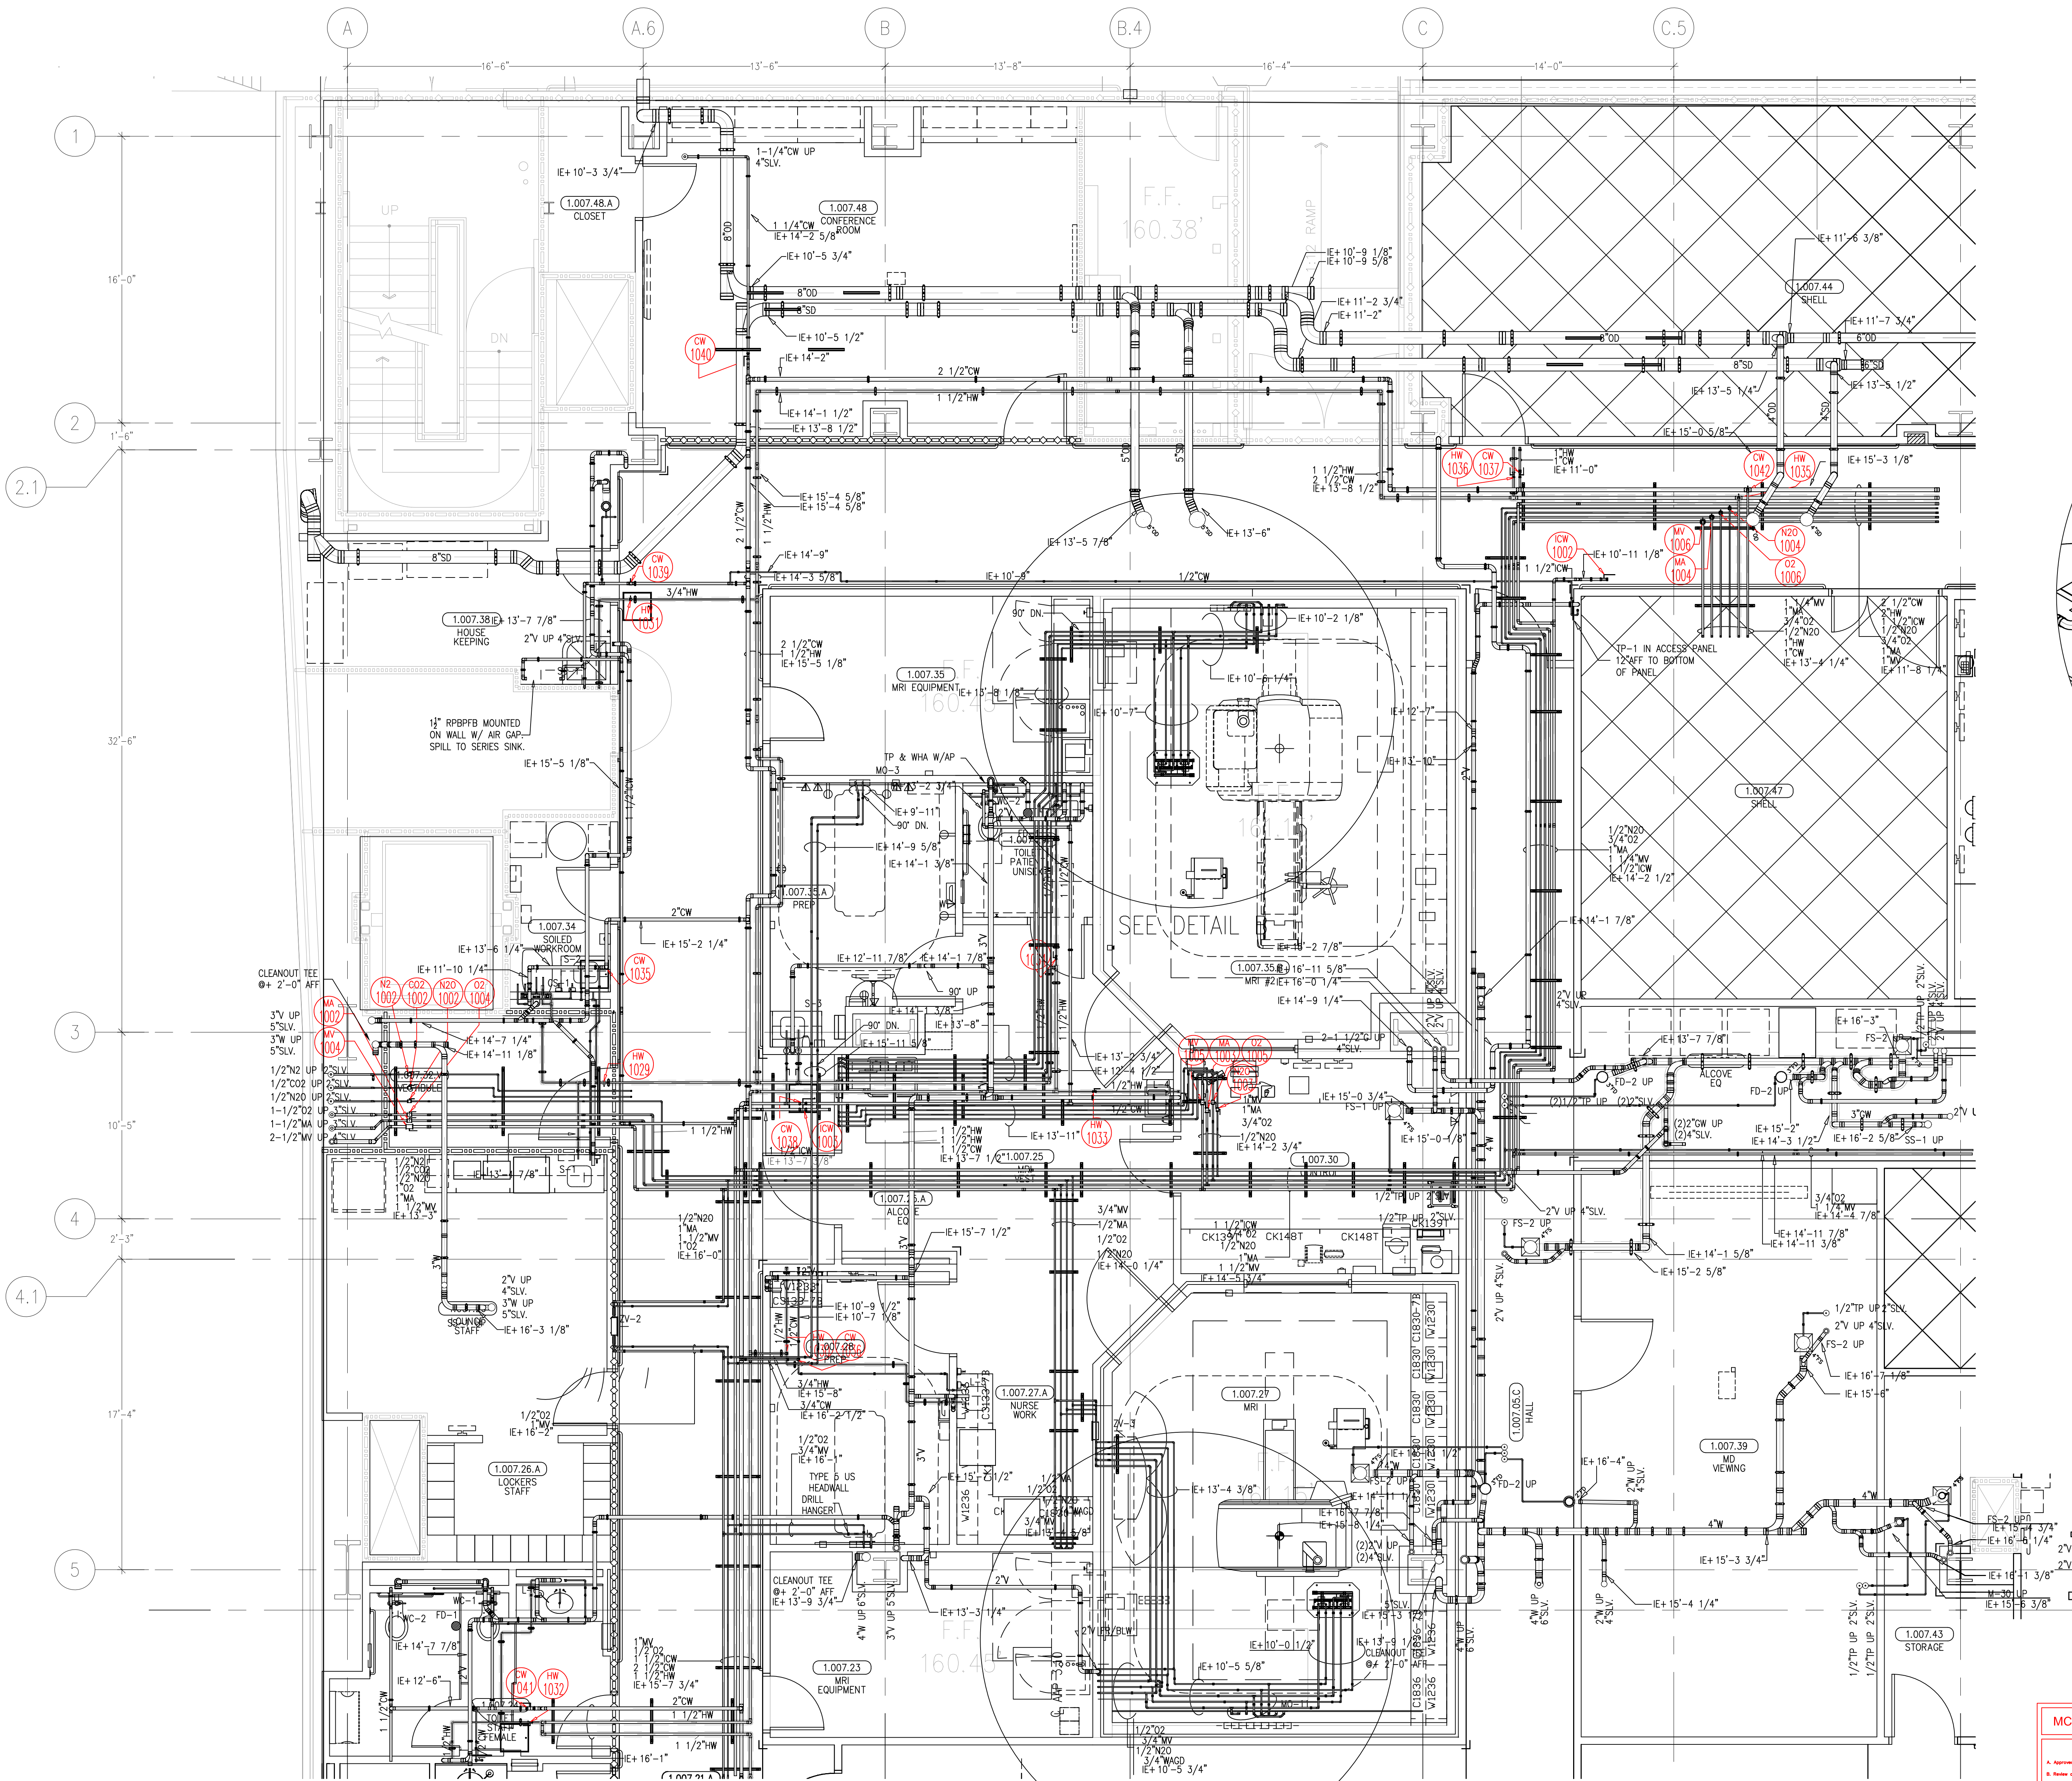

SEE DETAIL A

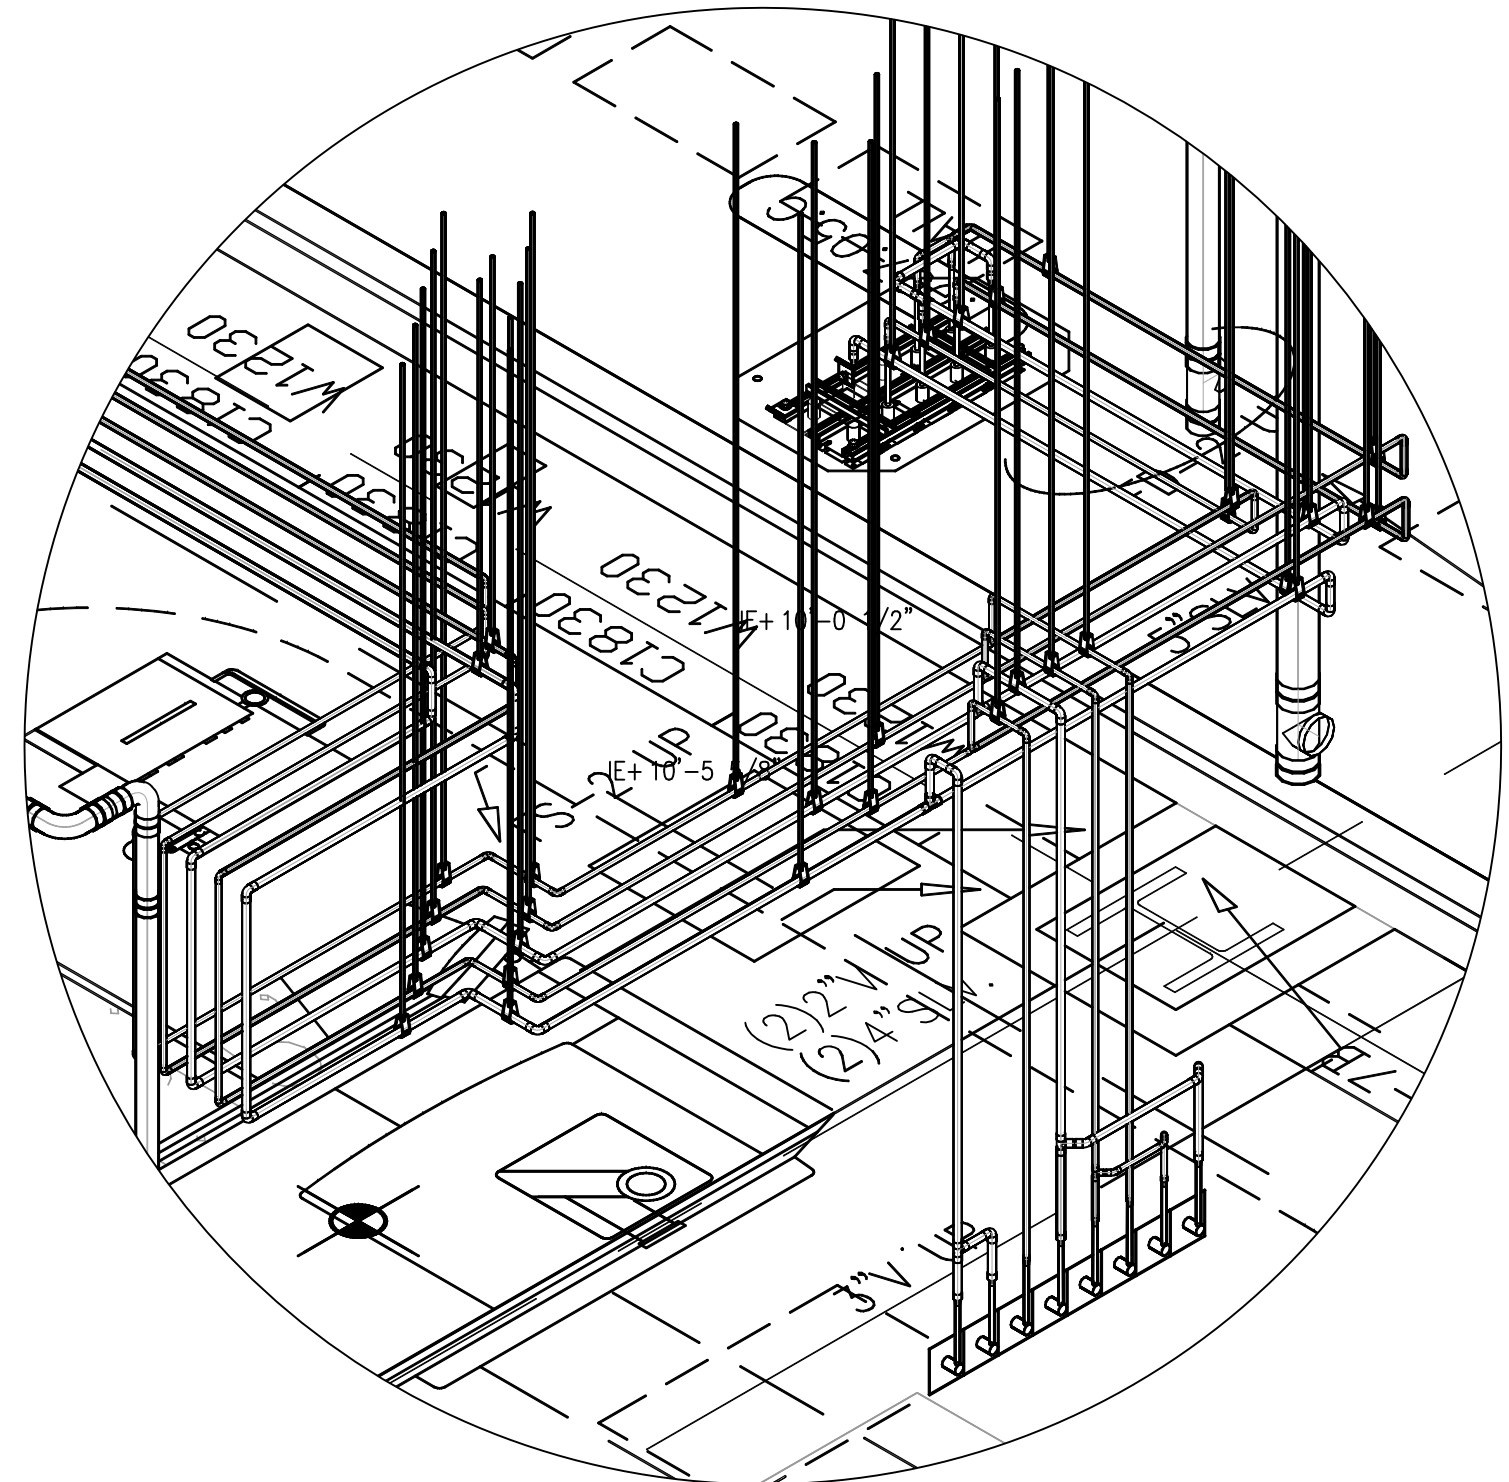


DETAIL A

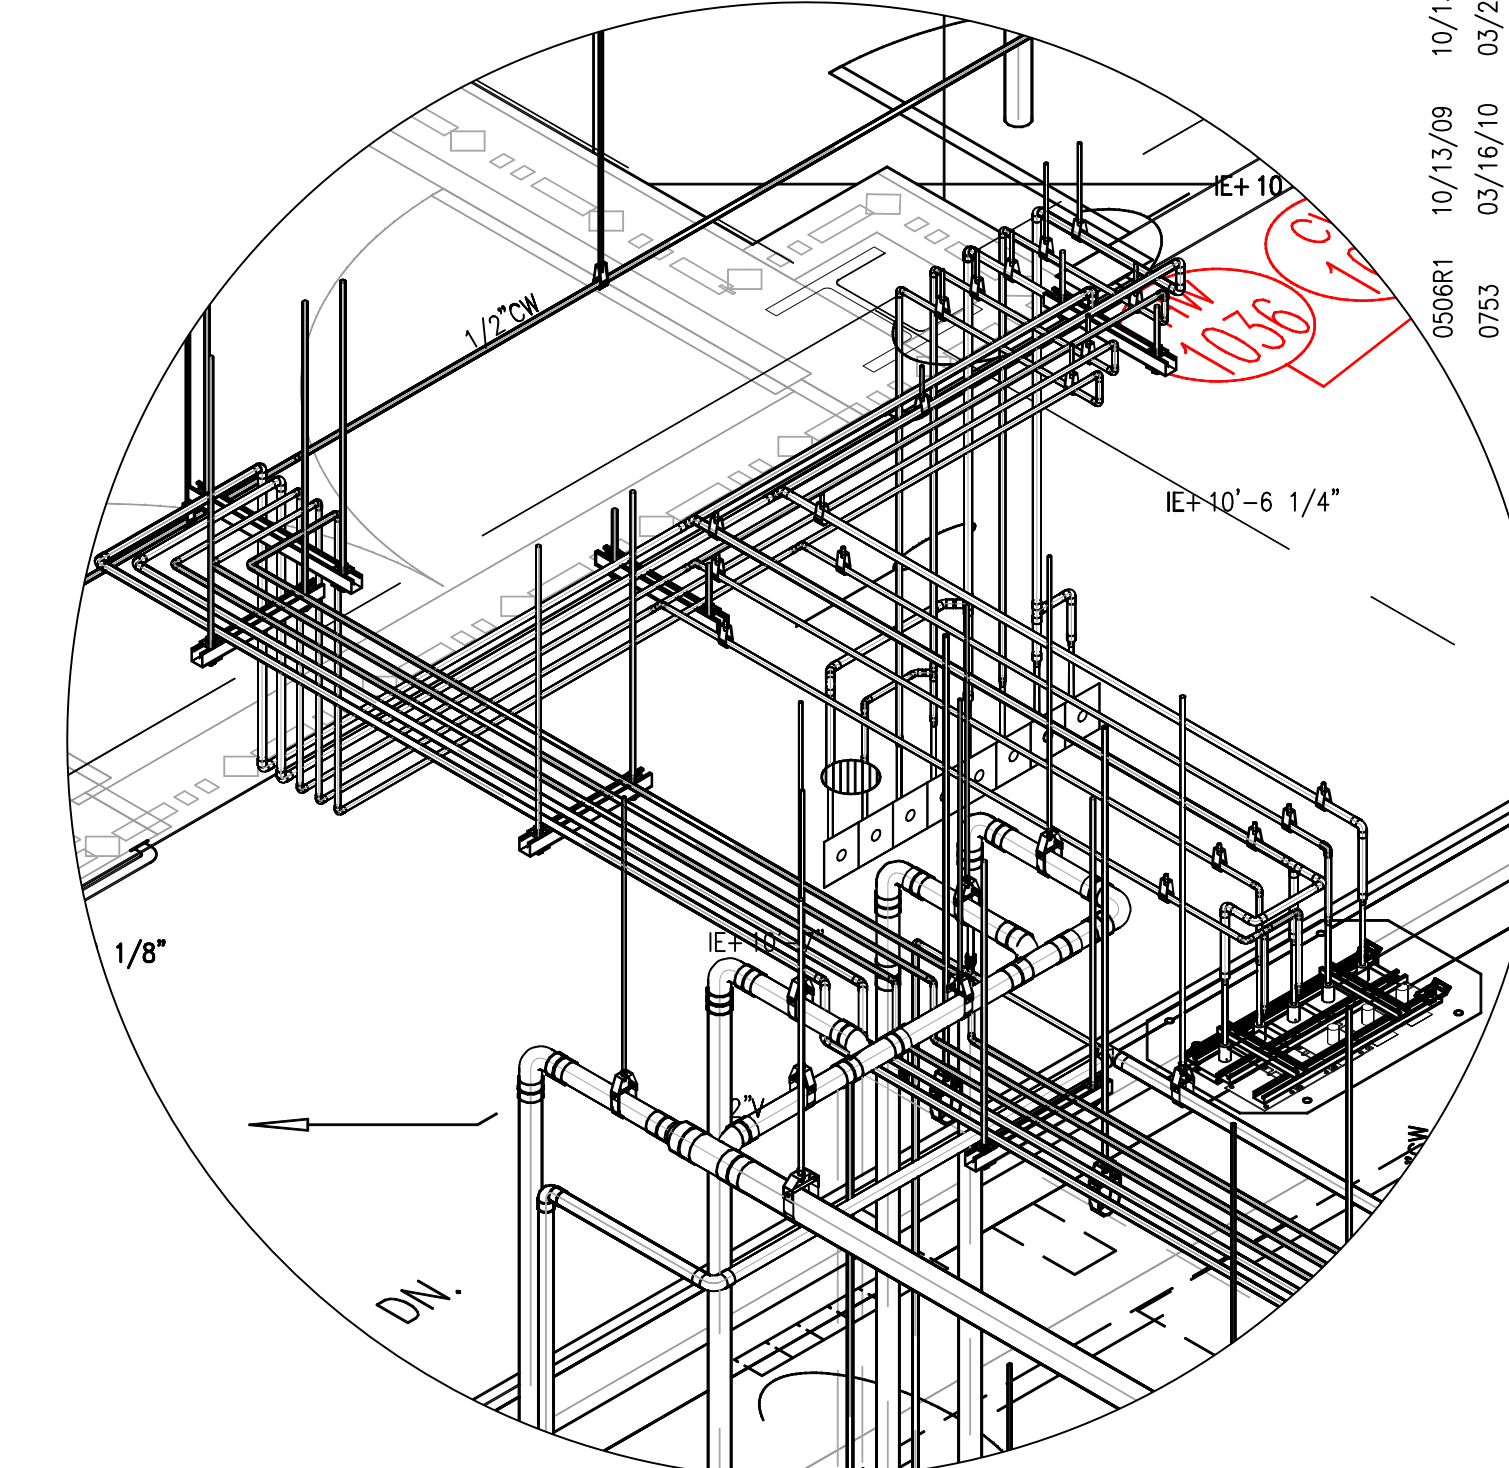

DETAIL B

LEVEL 01 161.30' = 0'-0"
REFERENCE THIS SHEET

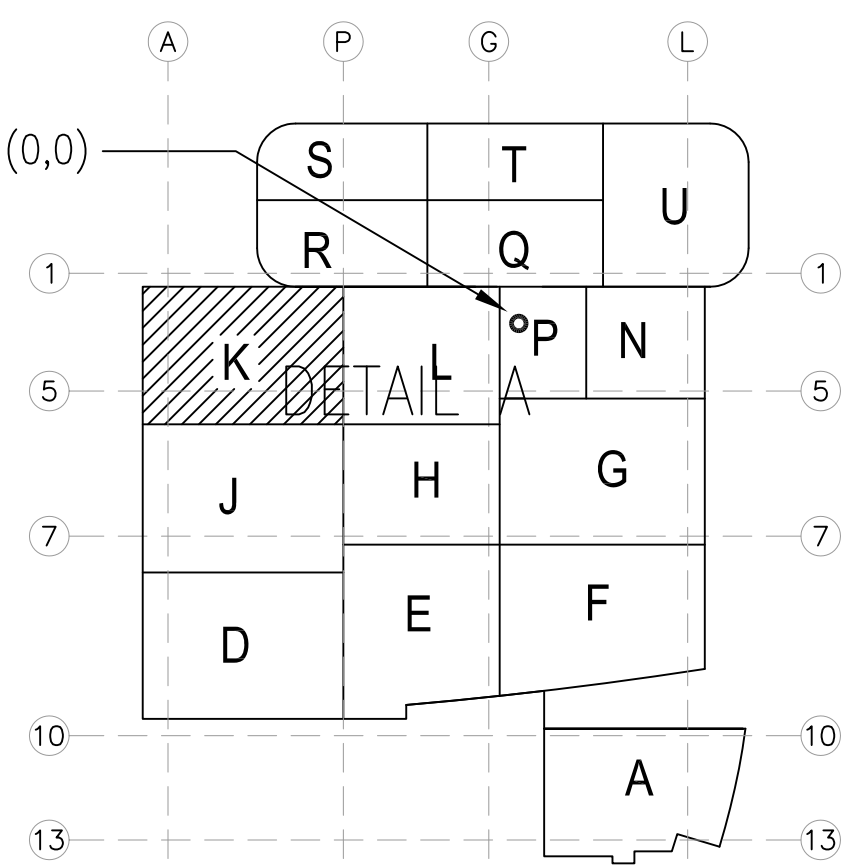

KEY PLAN

MCCARTHY APPROVAL

A. Approved as noted for Installation Review
B. Review and Rebuild
C. Rebuild

This review is for general conformance with Plans and Specifications only. Any deviations from same not shown on the Plans are the responsibility of the Contractor. Review shall not constitute a warranty or check of construction or construction to be used to release the Project of construction responsibility for any error or deviation from contract requirements.

McCarthy

By: _____ Date: _____
SHOP DRAWING REFERENCE NO. _____

1	REVISED FOR CONSTRUCTION 01-07-10	DK
2	ALL FD-1 TOP OF DRAINS TO BE SET -1/2" BELOW FINISHED FLOOR PER PPM 0800	DK
3	ISSUED FOR CONSTRUCTION 03-12-09	DK
4	ADDED NOTE FOR FD-1 PER CON RPT 1271 PPM 0800 5-4-10	DK
5	ADDED FLOOR SINK AND TRAP PRIMERS TO MRI ROOMS 6-16-10	DK
6	REVISED RO & DO LOCATIONS PER TMD AND LANDSCAPER REVIEW 4-25-10	DK
7	CHANGED MED GAS BRANCHES TO COME OUT OF TOP AT 2 LOCATIONS-7-27-10	DK
8	REVISED FOR HEADWALL COORDINATION 10-13-10	DK
9	REVISED ELEVATION PER COORDINATION 10-13-10	DK
10	REVISED ELEVATION PER COORDINATION 10-13-10	DK
11	REVISED ELEVATION PER COORDINATION 10-13-10	DK
12	REVISED ELEVATION PER COORDINATION 10-13-10	DK

REVISIONS	BY
1	DK
2	DK
3	DK
4	DK
5	DK
6	DK
7	DK
8	DK
9	DK
10	DK
11	DK
12	DK

COORD.	SIGNATURE	DATE
MECHANICAL		
ELECTRICAL		
PLUMBING		
STRUCTURAL		



R.F.I.	SENT	ANS.	R.F.I.	SENT	ANS.
0122	05/15/09	05/21/09	0242	07/09/09	09/16/09
0131	05/29/09	07/08/09	0245	07/14/09	09/16/09
0136	05/20/09	05/27/09	0266	07/18/09	08/26/09
0181	06/11/09	06/23/09	0306	08/10/09	09/01/09
0182	06/11/09	06/23/09	0322	08/27/09	09/01/09
0212	06/29/09	09/19/09	0362	09/12/09	10/13/09
0219	06/29/09	09/19/09	0386	09/10/09	10/13/09
			0398	09/10/09	10/02/09
			0432	09/23/09	10/24/09

CHILDREN'S HOSPITAL
CHOC OF ORANGE COUNTY
455 S. MAIN ST., SUITE 200
ORANGE, CA 92668-3974
TOWER II
SYSTEM NAME

PAN-PACIFIC
PLANNING & ARCHITECTURAL
2919 E. VICTORIA STREET, RANCHO DOMINGUEZ, CA 90221
PH. 310 637-1500 FAX 310 604-0359

PM
R.O.
CHECKED
M.M.
DATE
4/30/2012
SCALE
1/4" = 1'-0"
JOB NO.
09-006
DRAWING NUMBER
PL3.1K
REFERENCE DRAWING
A3.1K
P3.1K
1 OF 1 SHEETS

This document and the design it covers are the property of Murray Co. They are loaned only with the borrower's expressed written agreement that they will not be reproduced, copied, loaned, exhibited, or used in any other way, except by written consent from Murray Co. to the borrower.

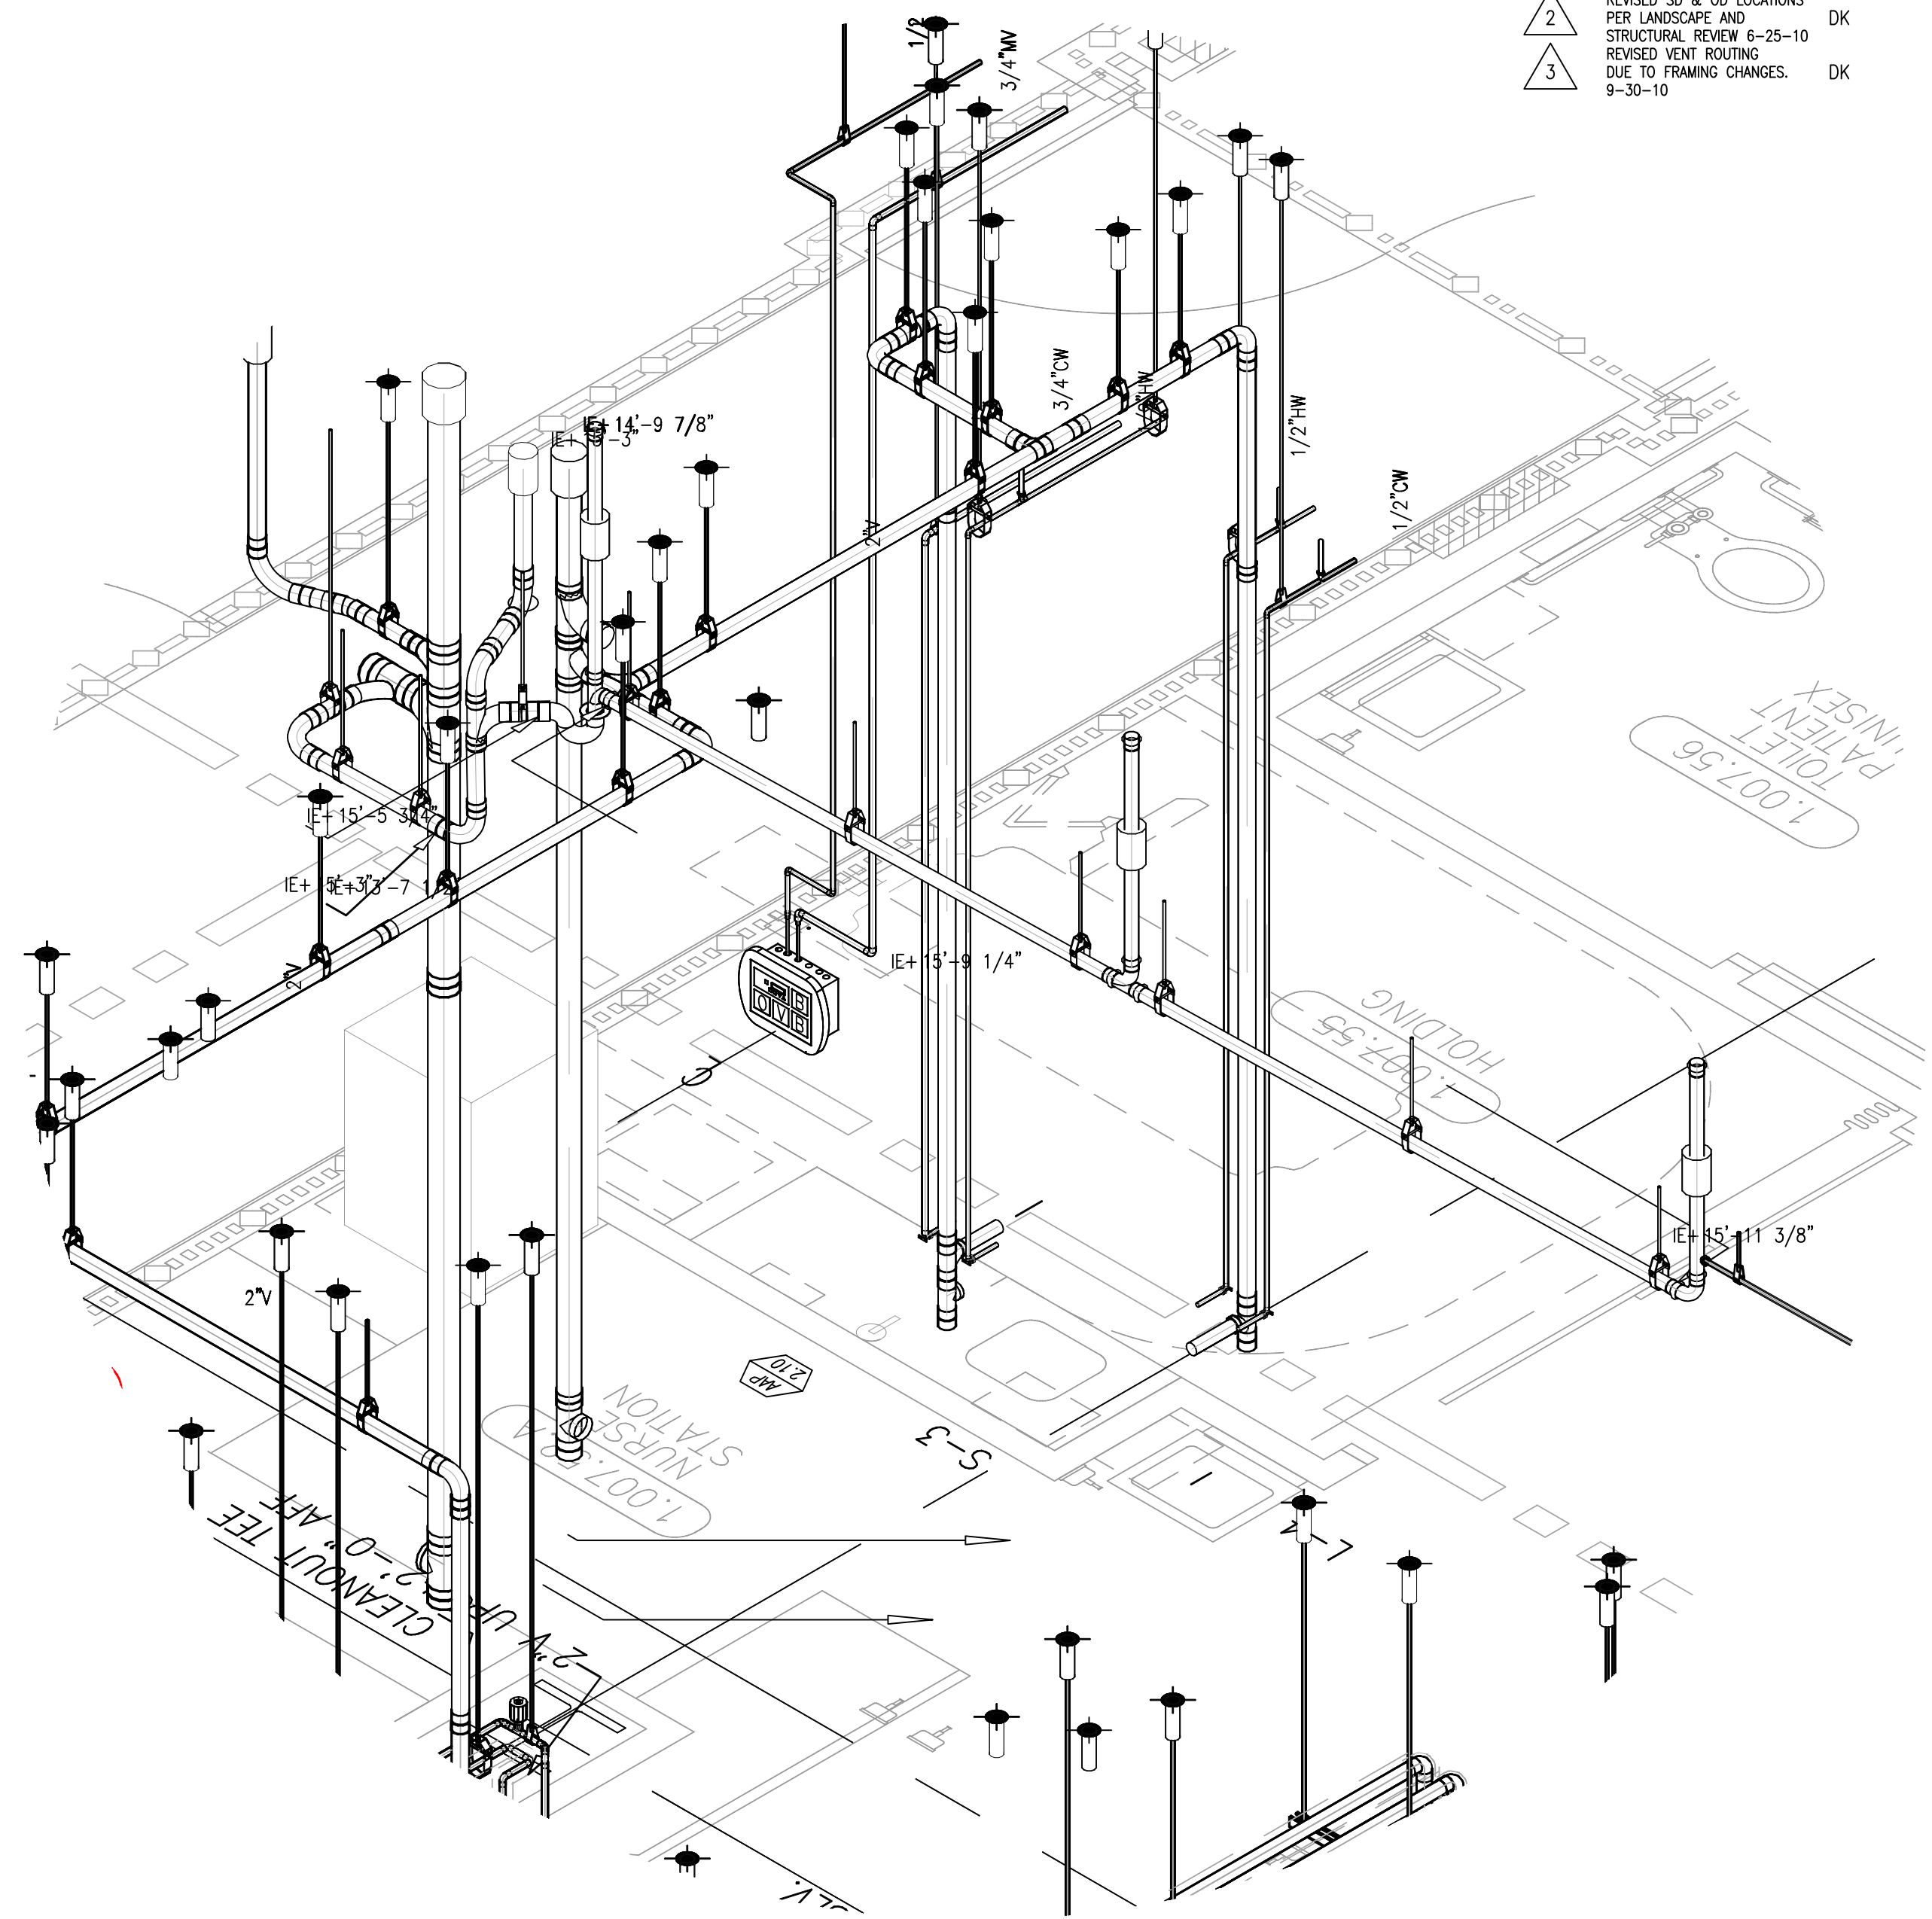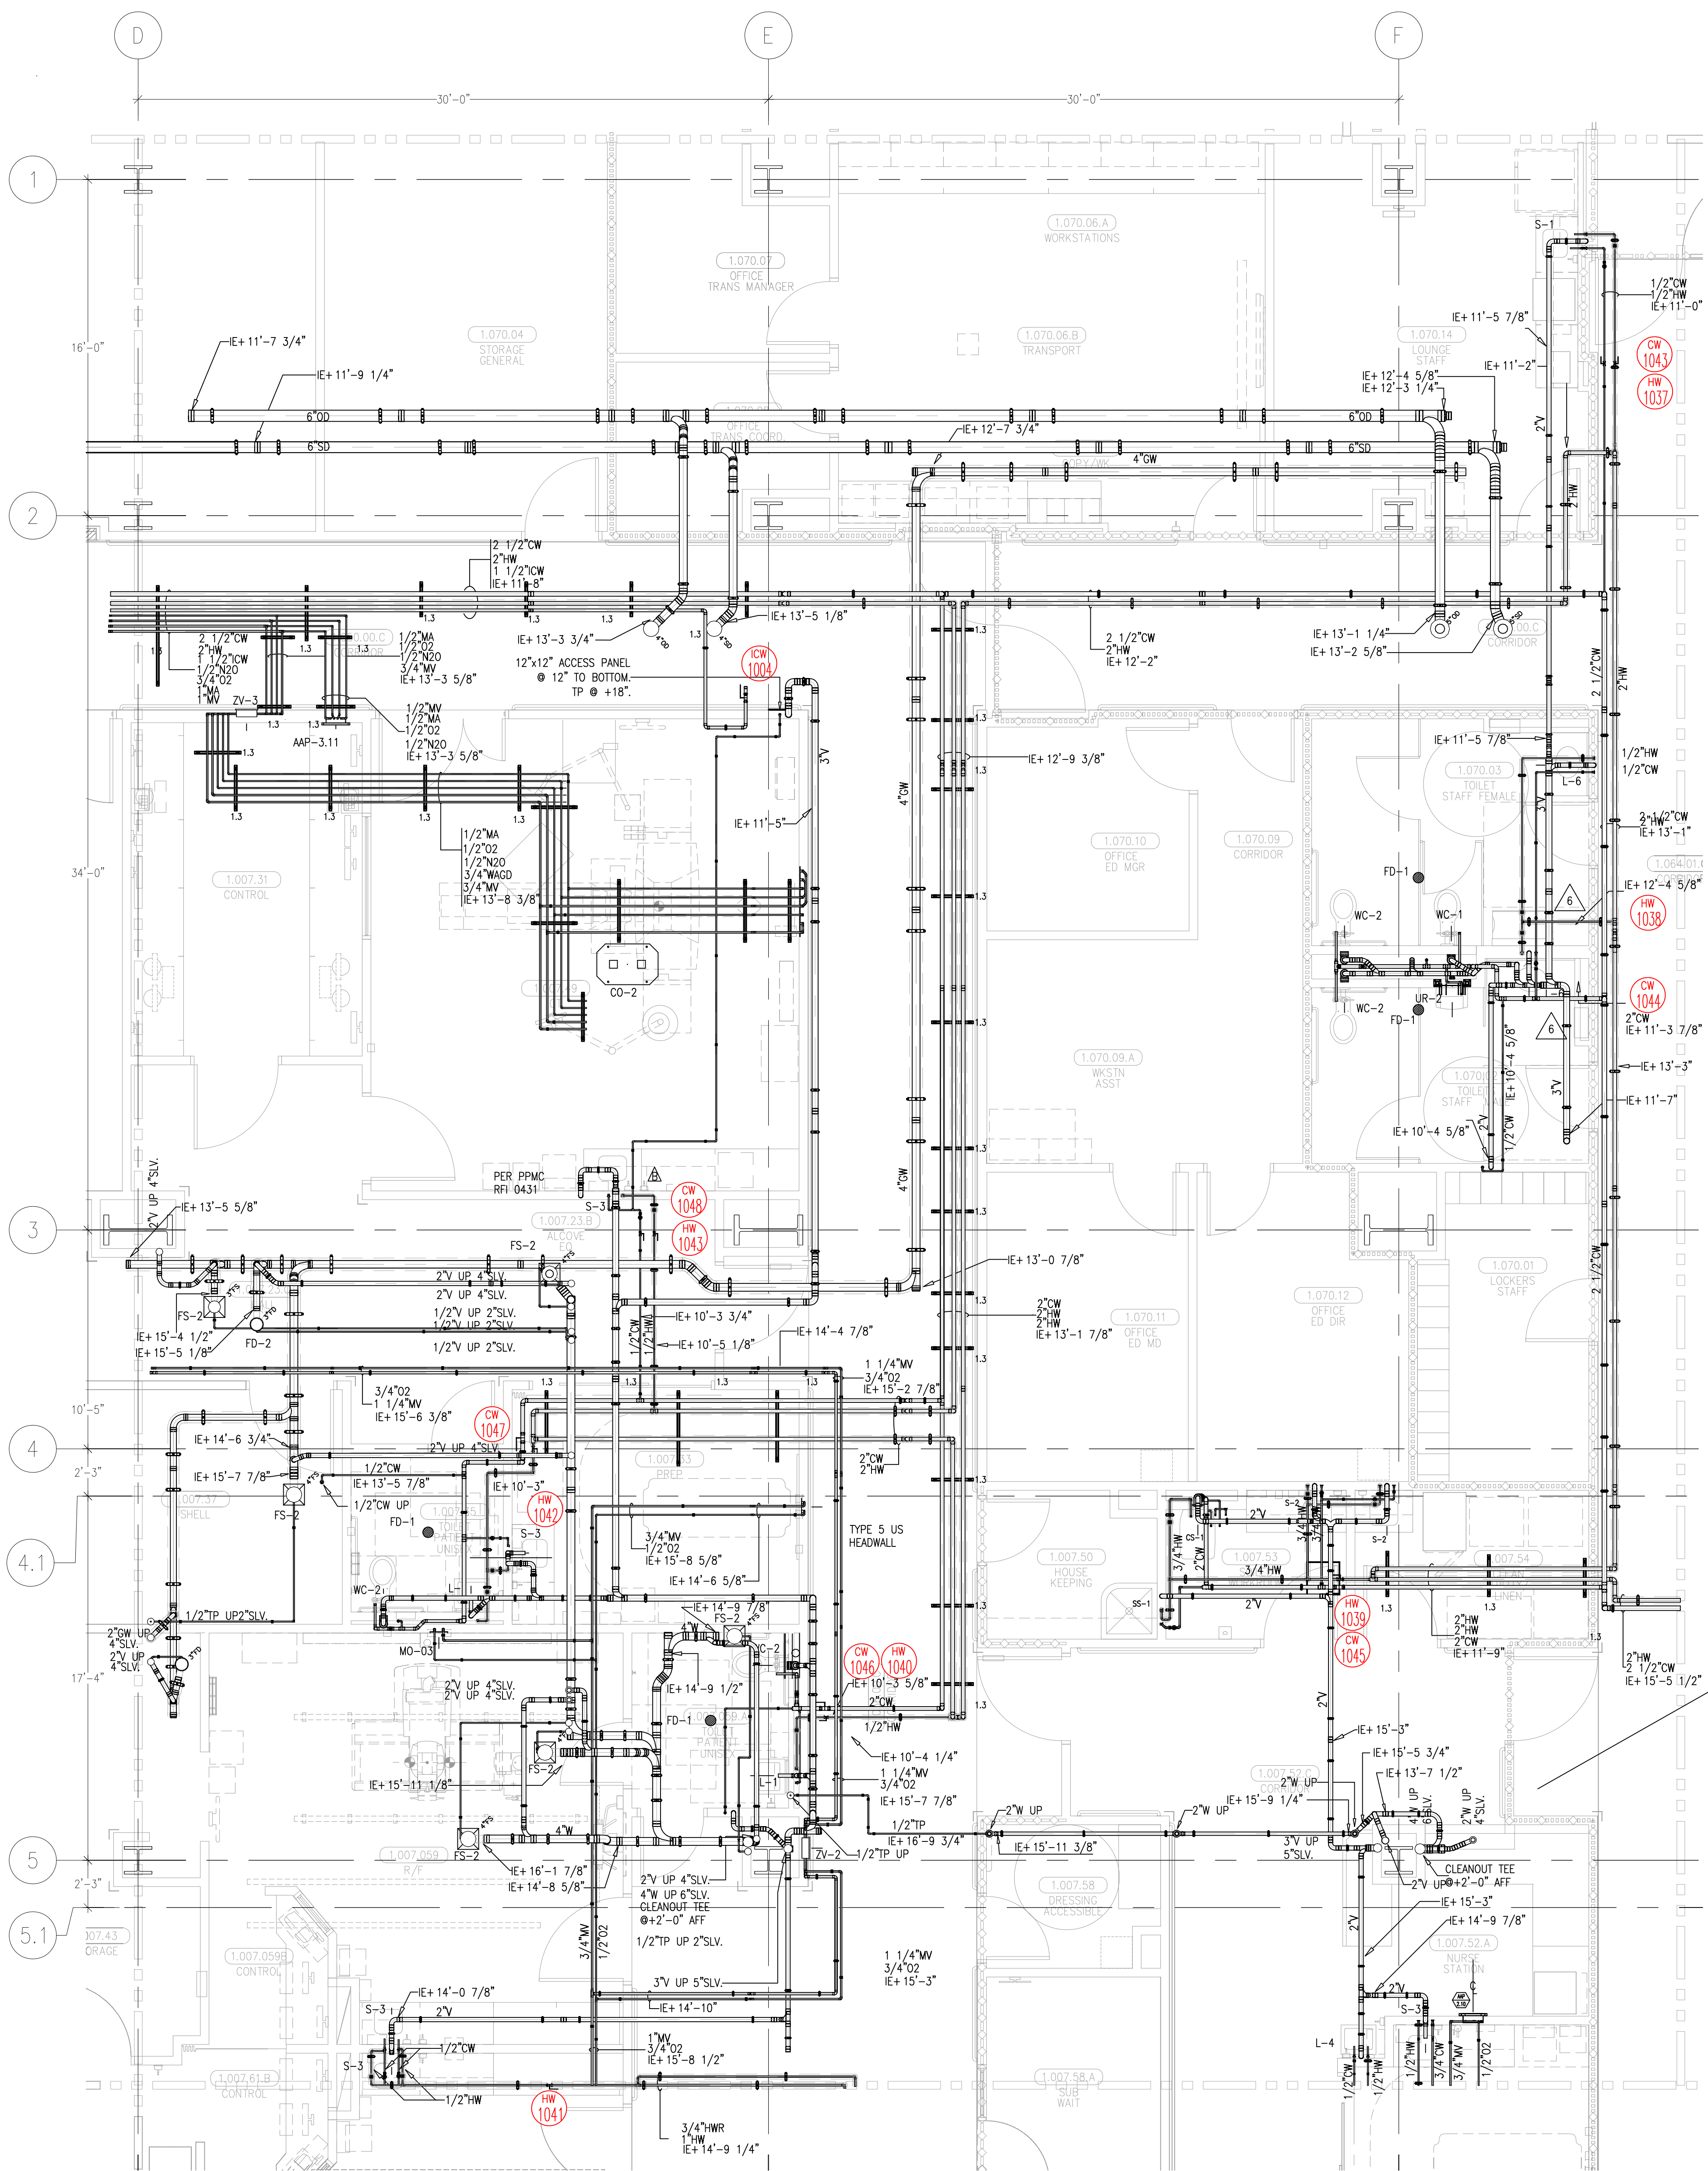

A	ISSUED FOR COORDINATION SIGN-OFF 11-4-09	DK
B	PPMC RFI 0431 INCORPORATED 11-5-09	REO
1	ALL FD-1 TOP OF DRAINS TO BE SET 1-1/2" BELOW FINISHED FLOOR PER PPMC 0800	
C	ISSUED FOR OSHPO PERMIT RE COORDINATION SIGN-OFF 3-8-10	DK
0	ISSUED FOR CONSTRUCTION 04-12-10	DK
1	ADDED NOTE FOR BELOW PER CON RFI 1270	REO
2	PPMC RFI 0800 5-4-10 REVISED S & OR LOCATIONS PER LANDSCAPE AND STRUCTURAL REVIEW # 25-10	DK
3	REVISED VENTING NOTES TO FRAMING CHANGES 9-30-10	DK

	REVISIONS	BY
4	REVISED PER HEADWALL COORDINATION 10-13-10	JT
5	CLEANTO ANNOTATIONS ADDED 12-28-10	JT
6	RELOCATE PIPING DUE TO ASPH. RFI 05-0269-LAB1. 02-09-11	DK
7	REROUT MED GAS PER CO# 62 DS 0167/LAB1 03-23-11	DK
8	REVISION 1 1/2" ICW FUTURES PER RFI 1116 CONC. RFI 3005 03-30-11	DK
9	ADDED PIPING FOR BUBBLE WALLS-DS0323/LAB1 4-29-11	DK

COORD.	SIGNATURE	DATE
MCCARTHY		
MECHANICAL DUCT		
MECHANICAL PIPE		
PLUMBING		
ELECTRICAL		
FIRE SPRINKLER		
PT/GE		
DRYWALL/FRAMER		
REFRIGERATION		
STRUCTURAL		

	R.F.I.	SENT	ANS.	R.F.I.	SENT	ANS.
0200	06/18/09	09/10/09	0292	06/05/09	09/07/09	
0203	06/19/09	08/24/09	0306	06/07/09	08/10/09	
0212	06/19/09	09/19/09	0322	06/20/09	09/25/09	
0246	07/11/09	08/21/09	0374	06/04/09	09/18/09	
0252	07/13/09	08/21/09	0426	09/29/09	10/13/09	
0254	07/13/09	08/21/09	0431	09/29/09	10/20/09	
0303	07/17/09	08/24/09				



CHOCSM
HOSPITAL
CHILDREN'S HOSPITAL
OF ORANGE COUNTY
455 S. Main St.
Orange, CA 92668-3974
TOWER II
PLUMBING FLOOR PLAN - LEVEL 01 AREA-L

PAN-PACIFIC
PLUMBING & MECHANICAL

Pan-Pacific Plumbing & Mechanical
2919 E. VICTORIA STREET, RANCHO DOMINGUEZ, CA 90221
PH. 310.637-1500 FAX. 310.604-0359


DRAWN R.O.
CHECKED
M.M.
DATE
4/30/2012
SCALE
1/4"=1'-0"
JOB NO.
09-006
DRAWING NUMBER
PL3.1L
REFERENCE DRAWING
A3.1L
P3.1L
1 OF 1 SHEETS

Dwg File: Z:\09-006_CHOC\MURRAY DRAWINGS\PLUMBING\W-1\1-1-AS-BUILT\PL3.1L.dwg Plotted by: PEP1508 4-30-2012 12:36pm


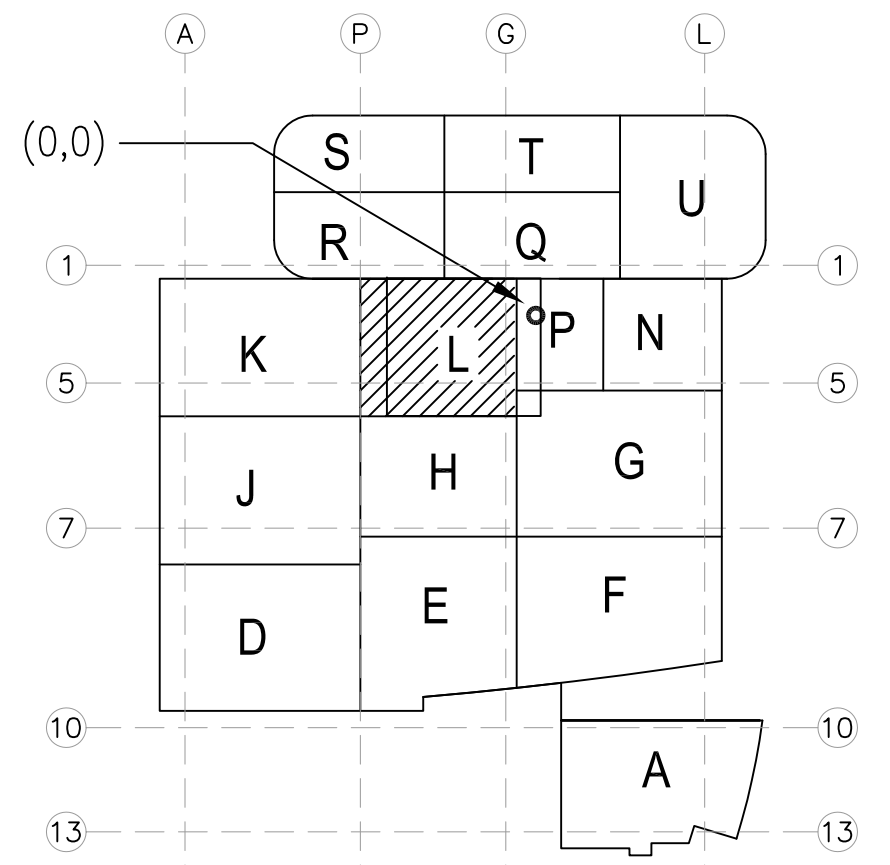
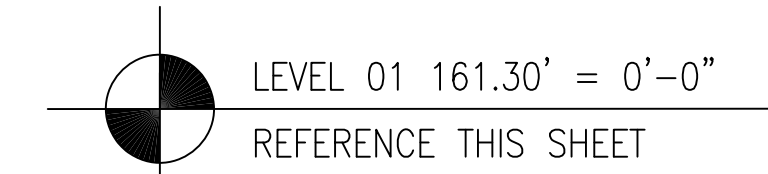


A1 KEY PLAN

This document and the design it covers are the property of Murray Co. They are loaned only with the borrower's expressed written agreement that they will not be reproduced, copied, loaned, exhibited, or used in any other way, except by written consent from Murray Co. to the borrower.

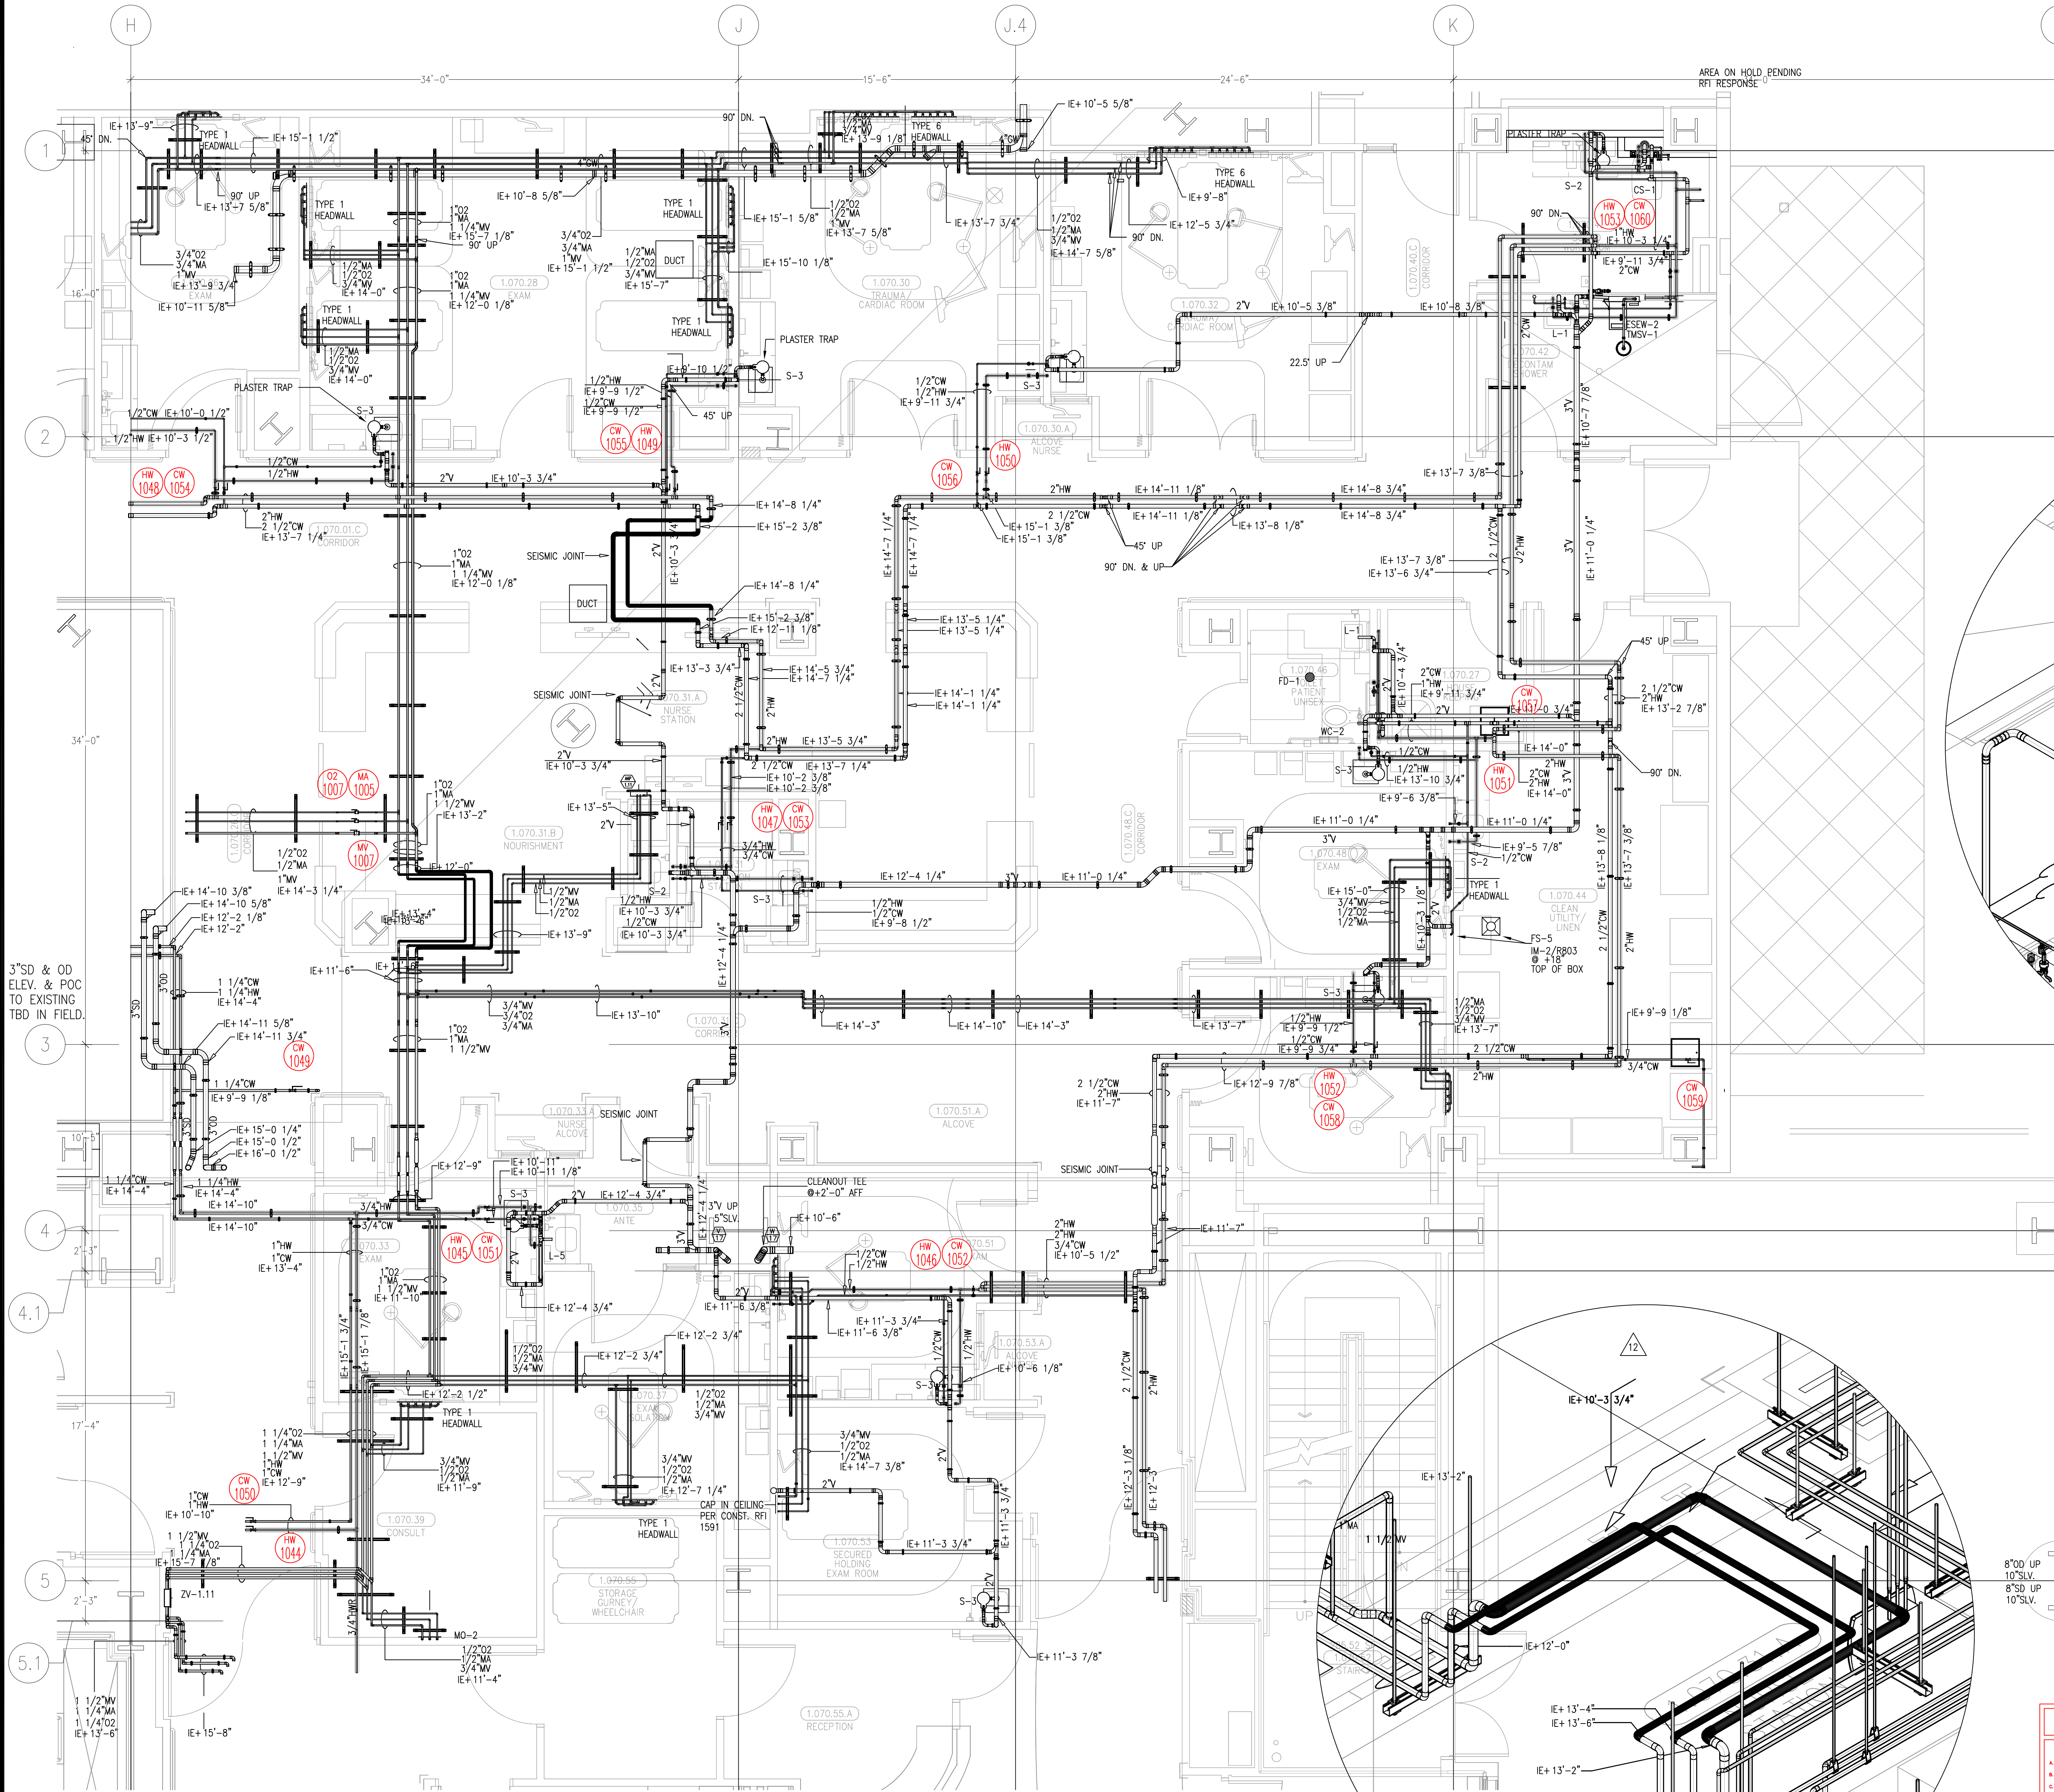

- ALL FD-1 TOP OF DRAINS FOR COF 54 TO BE SET -1/2" BELOW FINISHED FLOOR PER PPMC 0800
- ISSUED FOR COORDINATION SIGN-OFF 11-4-09 DK
- FPM REVISION 02-11-10 DK
- ISSUED FOR OSHPO PERMIT RE-COORDINATION SIGN-OFF 3-8-10 DK
- ISSUED FOR CONSTRUCTION 04-12-10 DK
- ADDED NOTE FOR FD-1 PER CON RFI 1270 PPMC RFI 0800, S-4-10 REO
- REVISED WASTE LAYOUT 05-18-10 JT
- REVISED VENT ROUTING DUE TO FRAMING CONFLICTS 9-30-10 JT
- REVISED PER HEADWALL CORROSION 10-13-10 JT
- ADDED VENT FOR FLOOR DRAIN PER RFI 1160 11-18-10 DK
- REVISED DUE TO ICE MAKER ROUGH-IN 11-24-10 JT

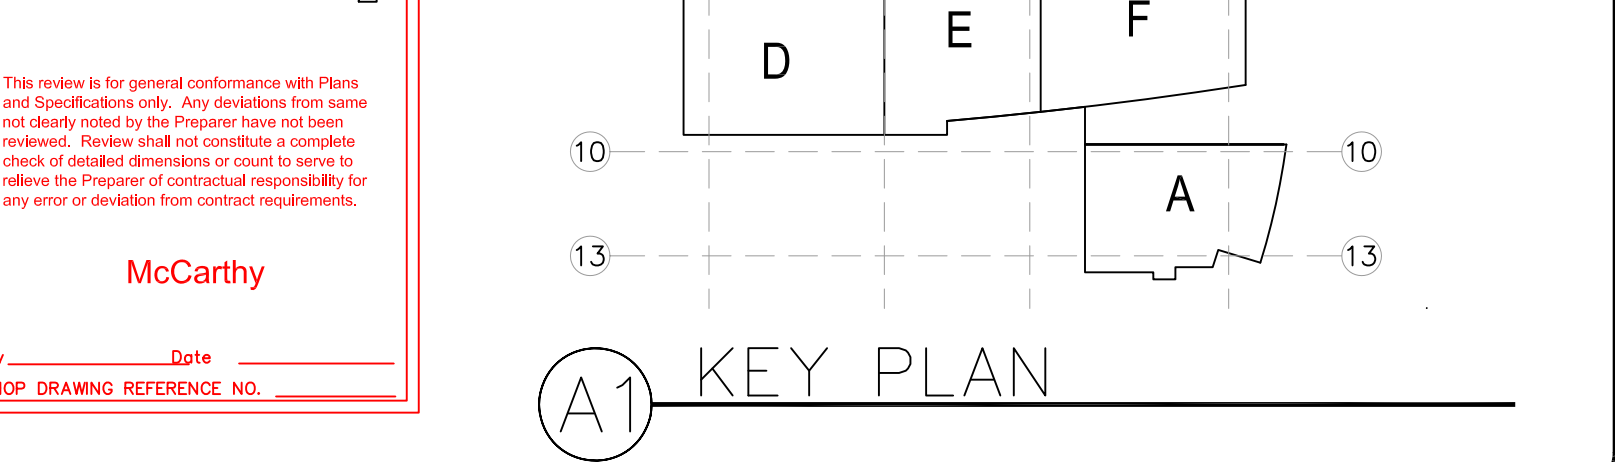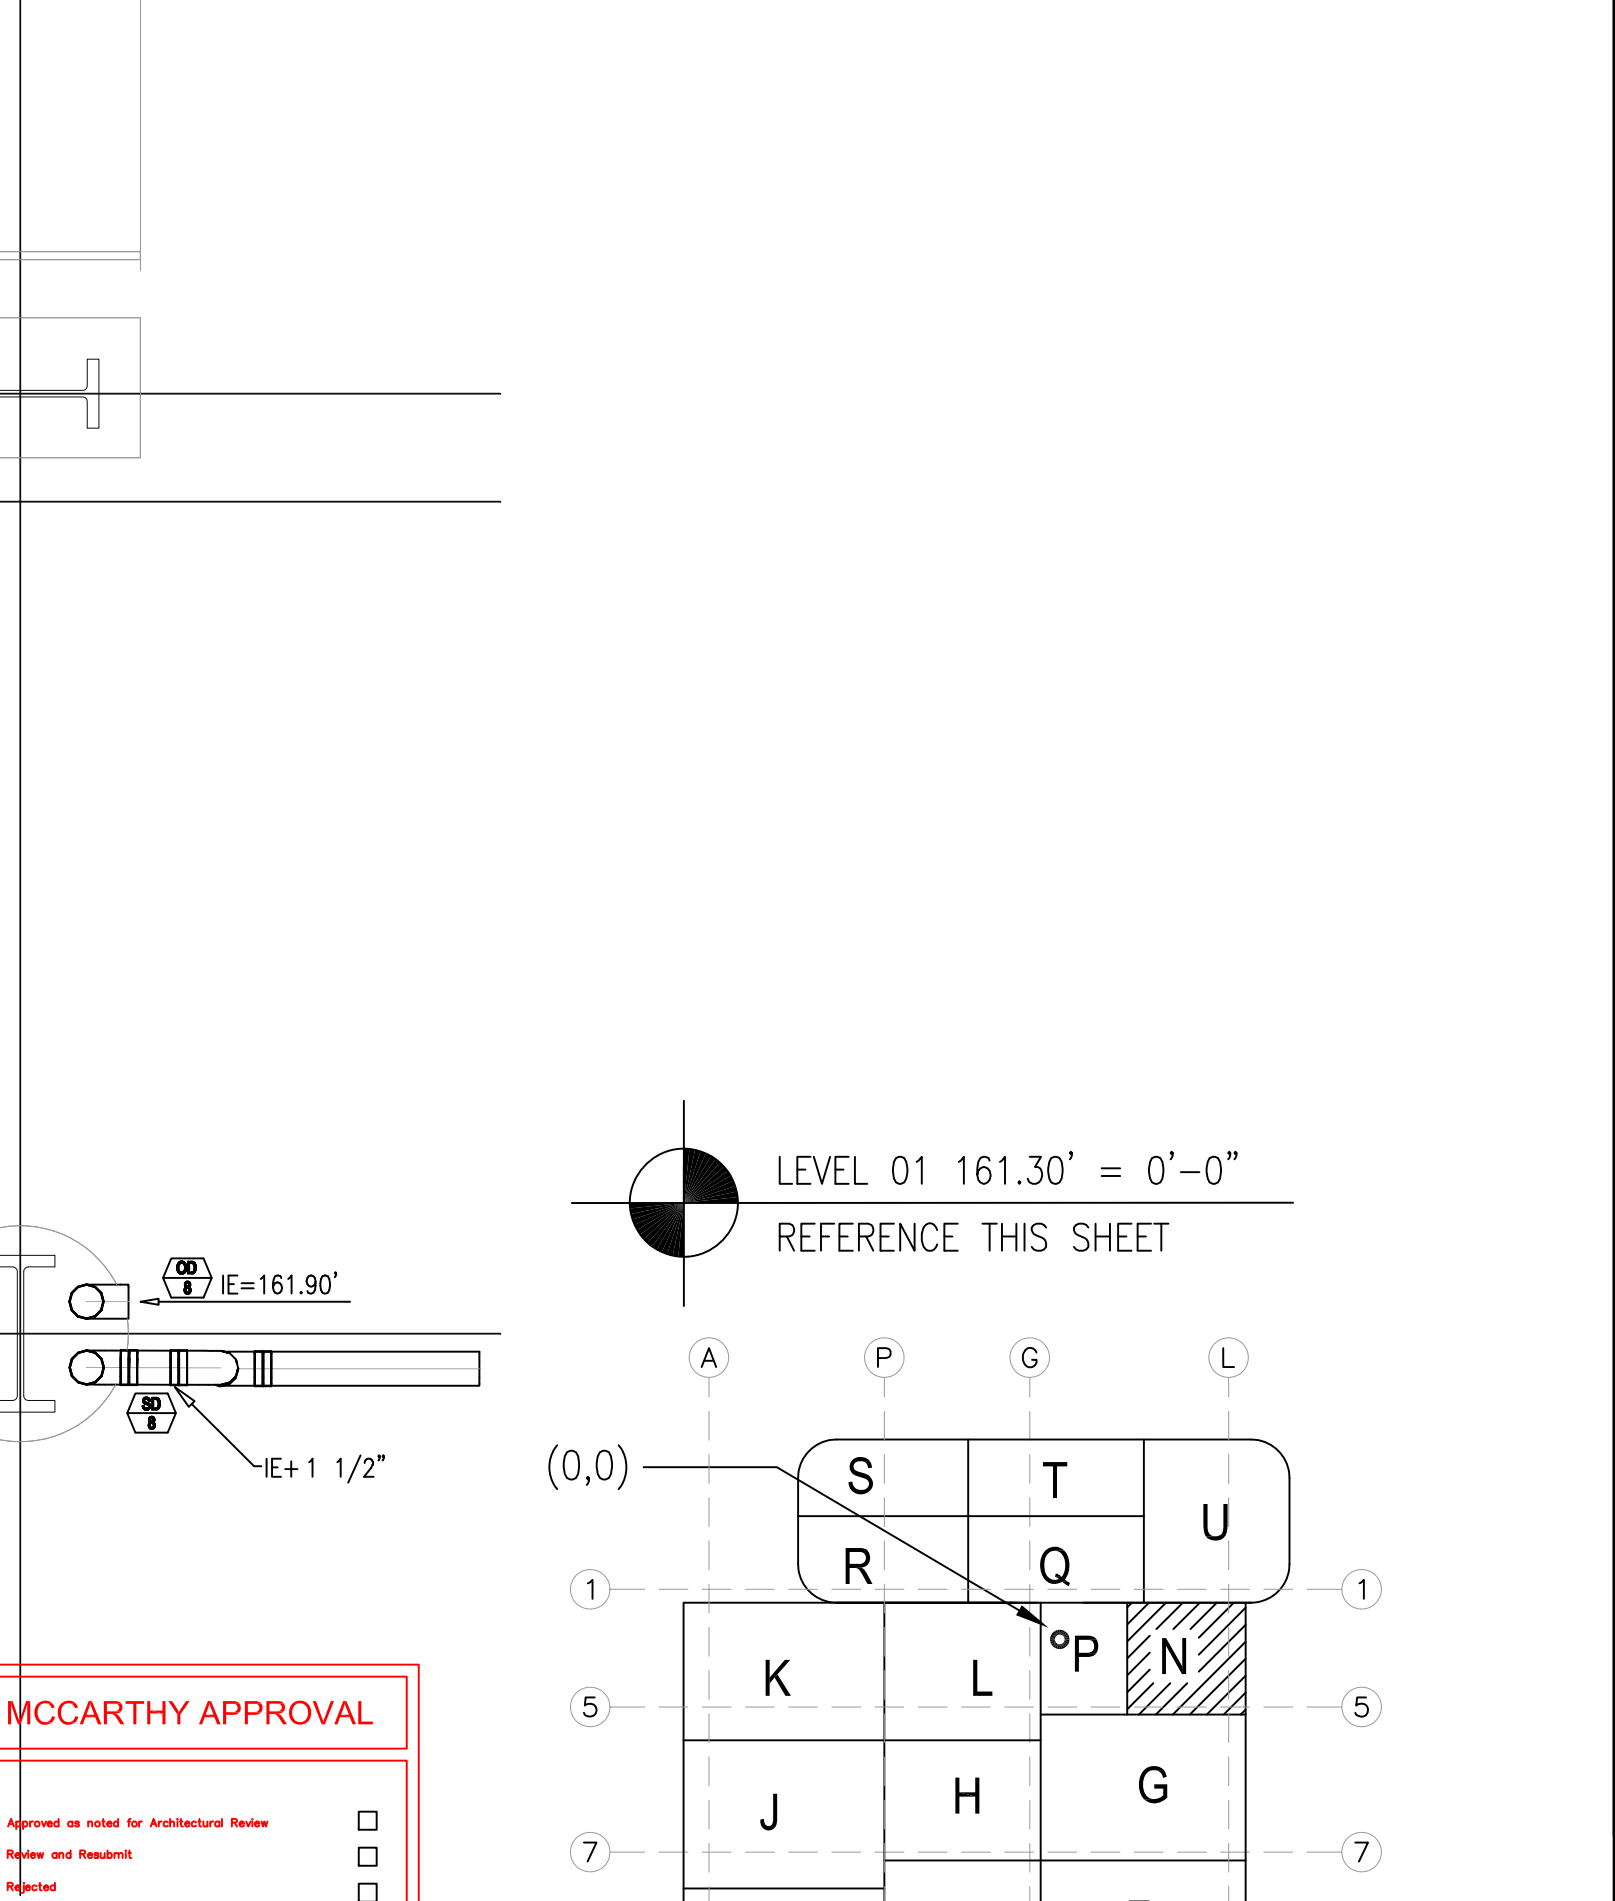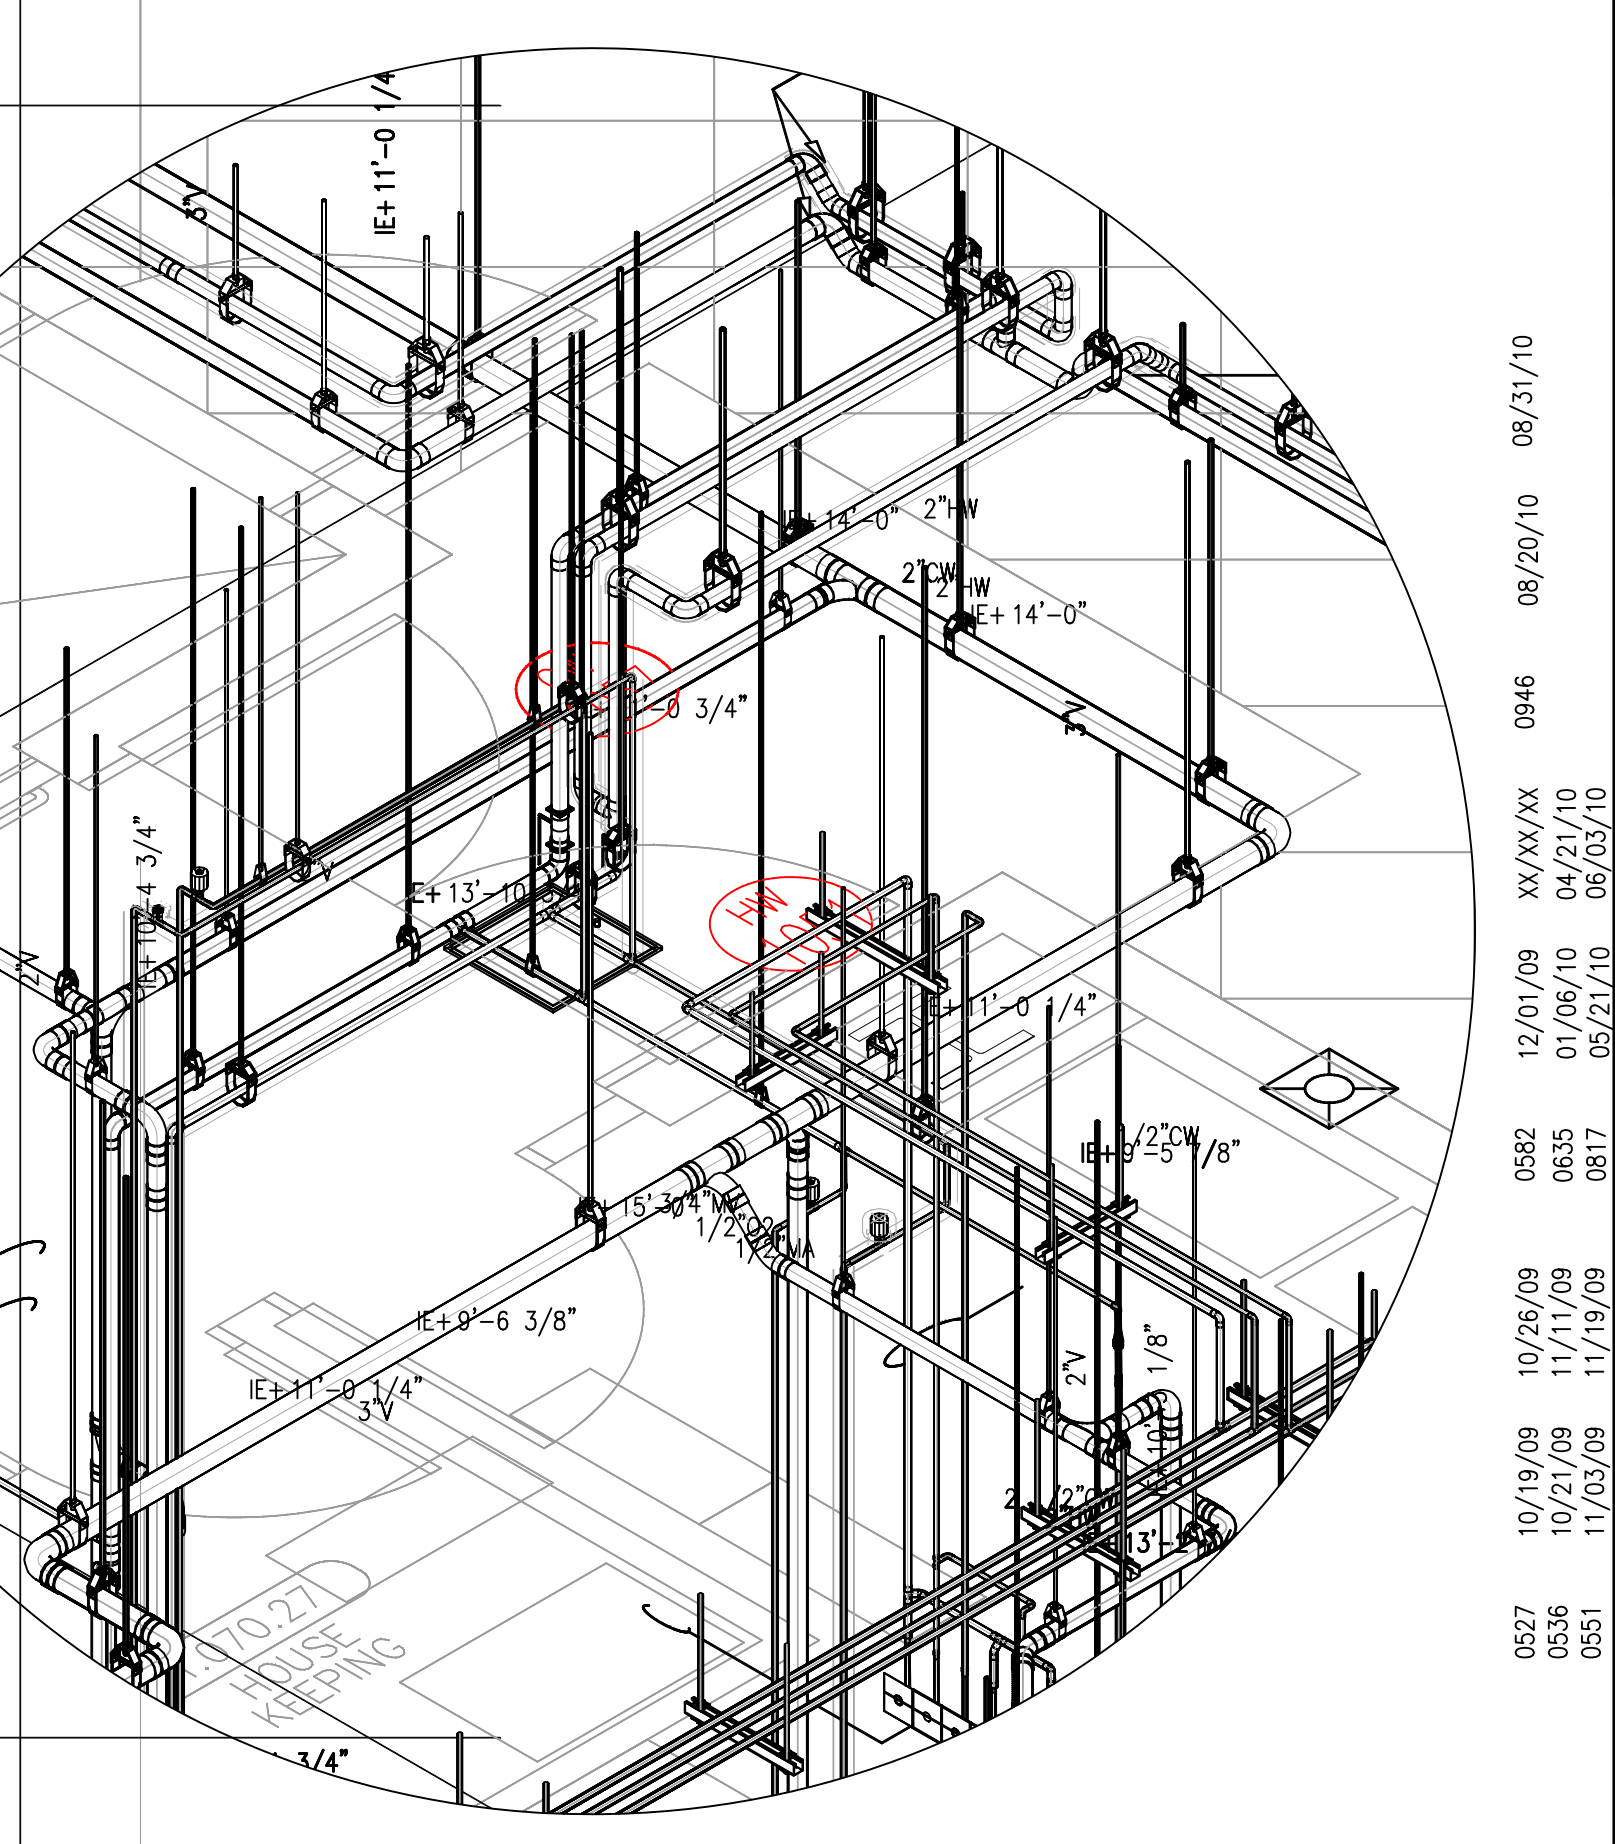

McCarthy APPROVAL

By: _____ Date: _____

SHOP DRAWING REFERENCE NO. _____

REVISIONS	BY
8	DK
9	DK
10	DK
11	DK
12	DK
13	DK

COORD.	SIGNATURE	DATE
MECHANICAL		
ELECTRICAL		
PLUMBING		
STRUCTURAL		

R.F.I.	SENT	ANS.	R.F.I.	SENT	ANS.	R.F.I.	SENT	ANS.	R.F.I.	SENT	ANS.
0155	05/20/09	07/17/09	0221	07/02/09	07/17/09	0323	08/21/09	09/23/09	0582	09/01/09	09/23/09
0211	06/19/09	07/03/09	0228	07/02/09	07/24/09	0382	09/02/09	09/13/09	0583	09/02/09	09/13/09
0212	06/19/09	07/03/09	0286	07/02/09	08/01/09	0495	09/04/09	09/18/09	0584	09/04/09	09/18/09
0213	06/22/09	06/26/09	0306	08/07/09	08/10/09	0511	10/02/09	11/02/09	0585	09/04/09	09/18/09
0220	06/22/09	06/26/09	0313	08/14/09	09/04/09	0512	10/02/09	10/26/09	0586	09/04/09	09/18/09
0221	06/22/09	06/26/09	0317	08/15/09	09/22/09	0515	10/12/09	10/13/09	0587	09/04/09	09/18/09
0226	07/02/09	10/14/09	0320	08/15/09	09/22/09	0520	10/14/09	10/26/09	0588	09/04/09	09/18/09


CHILDREN'S HOSPITAL
OF ORANGE COUNTY
455 S. MAIN ST., SUITE 300
ORANGE, CA 92668-3974

TOWER II
SYSTEMNAME

PAN-PACIFIC
PLUMBING & MECHANICAL
company
2919 E. VICTORIA STREET, RANCHO DOMINGUEZ, CA 90221
PH. 310 637-1500 FAX 310 604-0359

DRAWN
R.O.
CHECKED
M.M.
DATE
4/30/2012
SCALE
1/4" = 1'-0"
JOB NO.
09-006
DRAWING NUMBER
PL3.1N
REFERENCE DRAWING
A3.1N
P3.1N
1 OF 1 SHEETS

This document and the design it covers are the property of Murray Co. They are loaned only with the borrower's expressed written agreement that they will not be reproduced, copied, loaned, exhibited, or used in any other way, except by written consent from Murray Co. to the borrower.

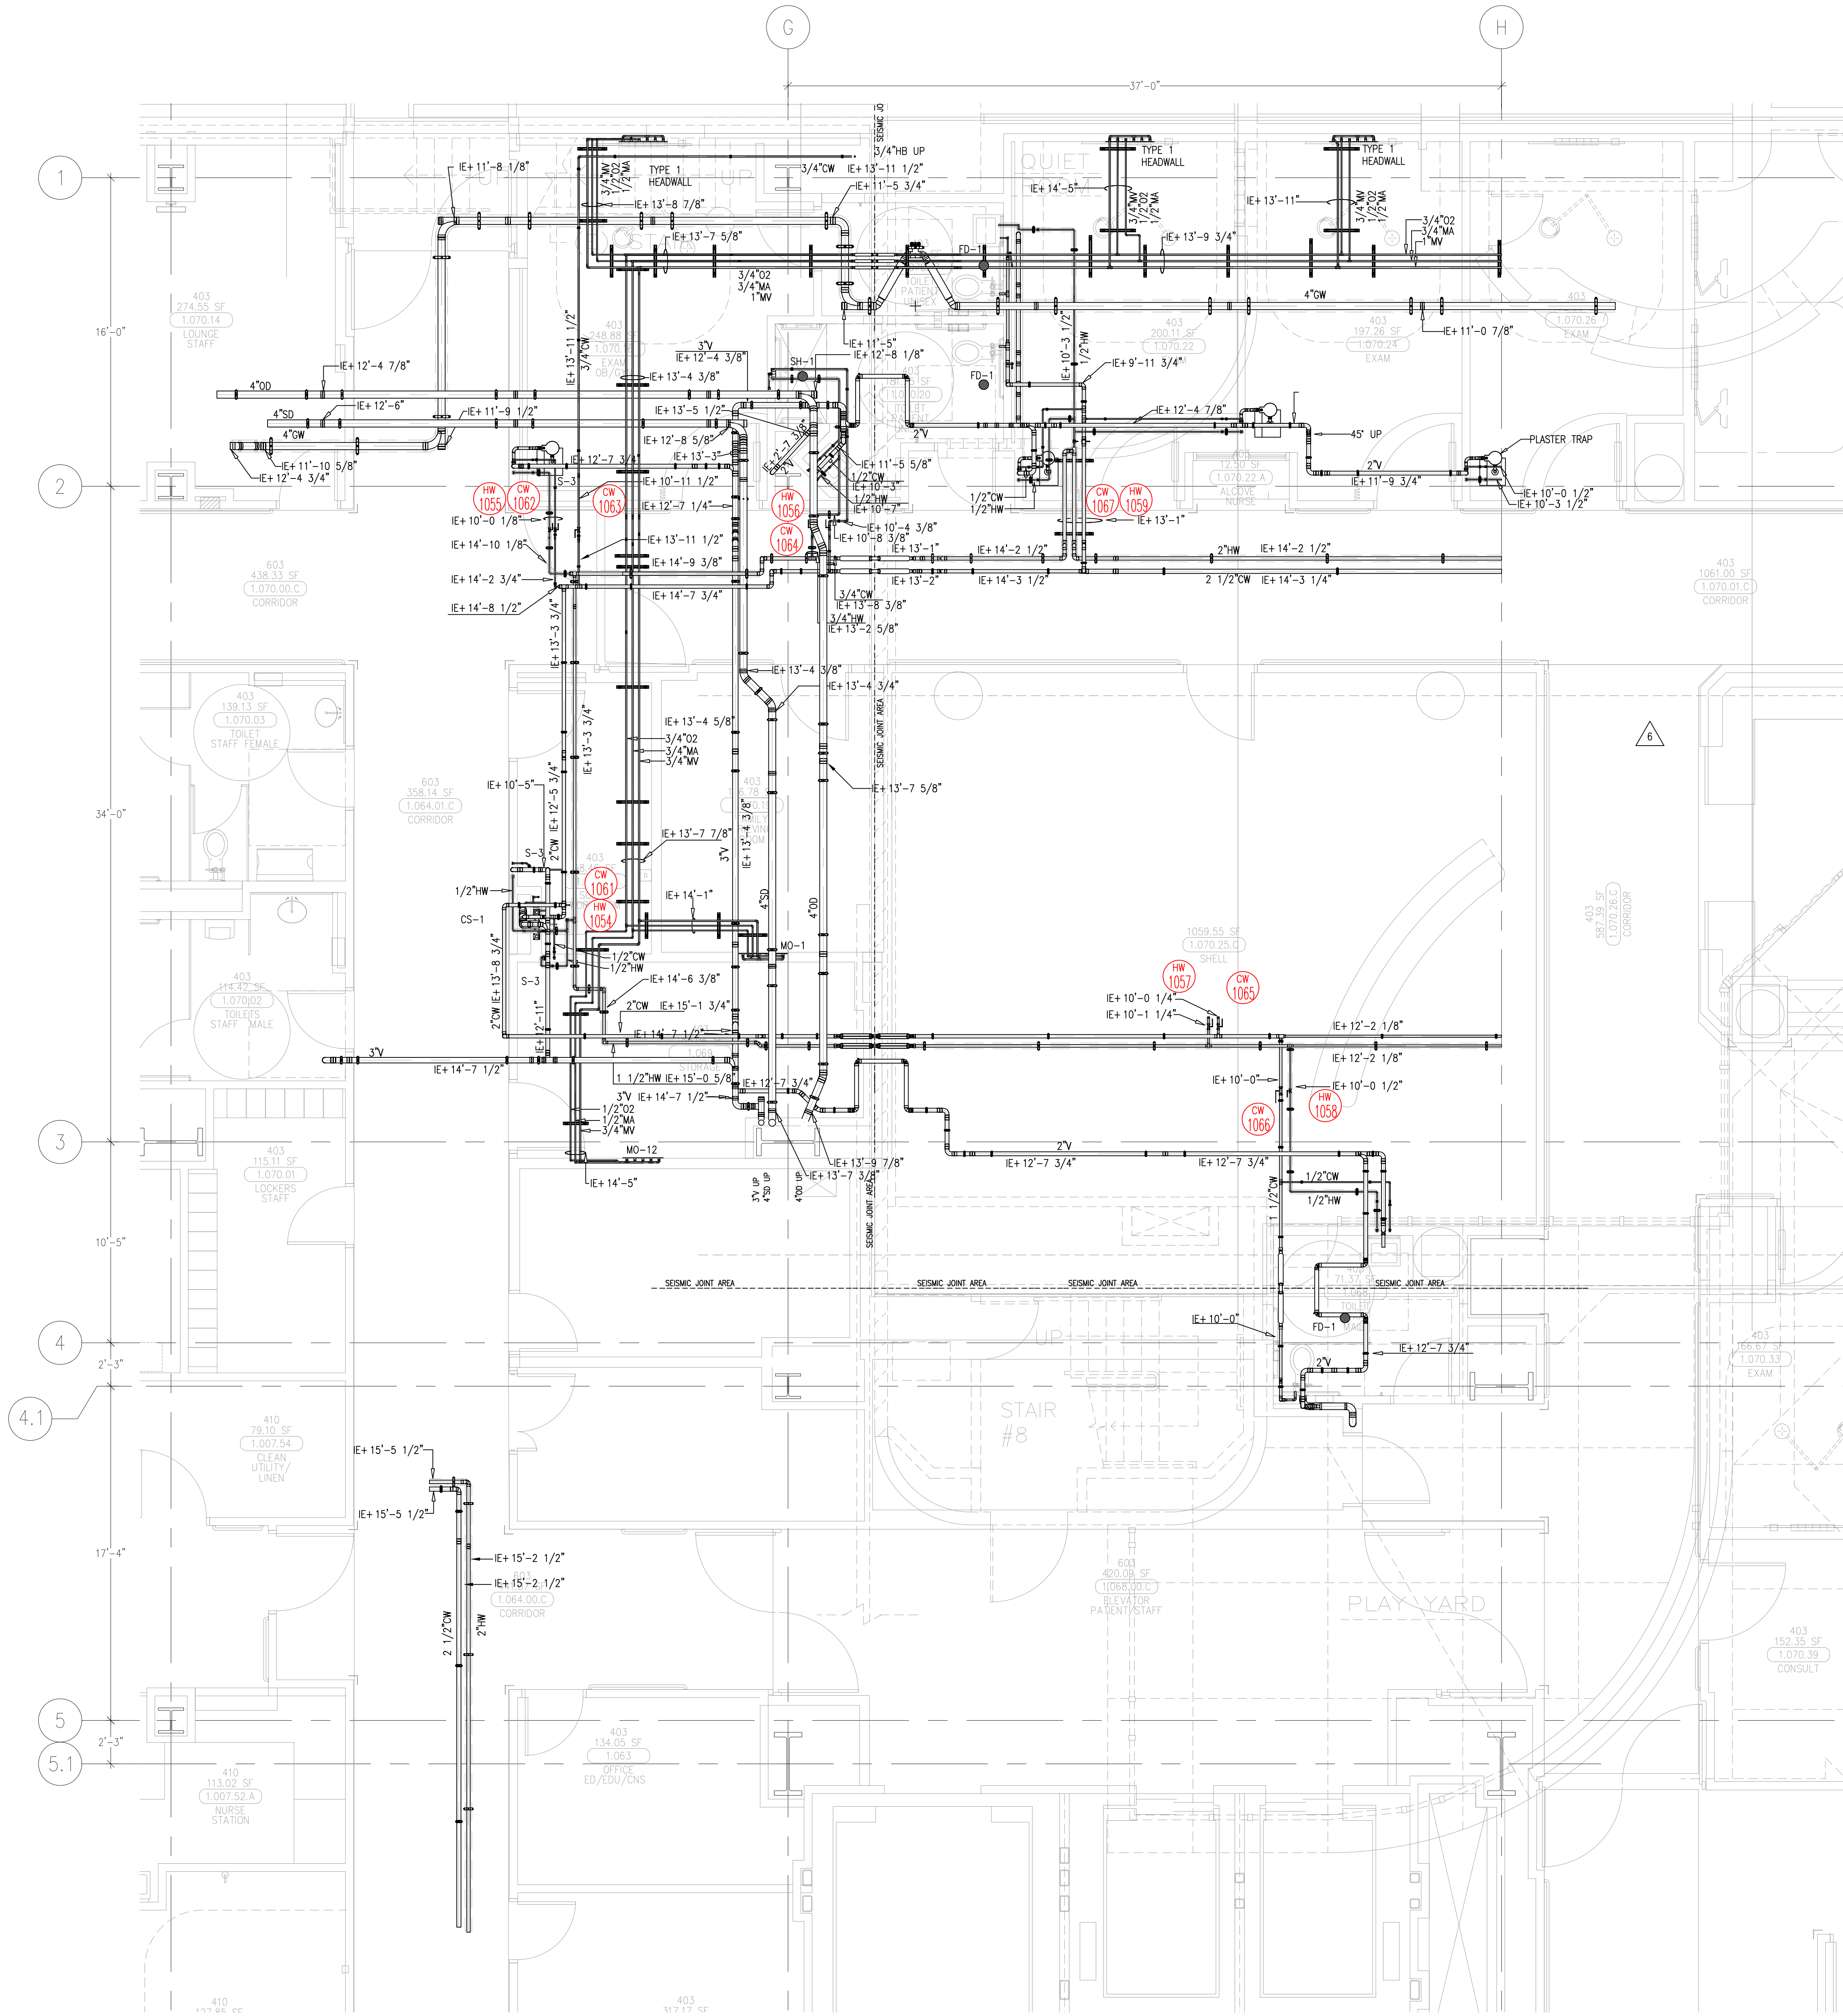

- 1 ALL FD-1 TOP OF DRAINS TO BE SET -1/2" BELOW FINISHED FLOOR PER PWD 0800
- A ASSESSMENT FOR FD-1 PER CON RFI 1270
- B ISSUED FOR COORDINATION SIGN-OFF 11-4-09
- C ISSUED FOR COORDINATION SIGN-OFF 11-4-09
- D ISSUED FOR COORDINATION SIGN-OFF 11-4-09
- E ISSUED FOR COORDINATION SIGN-OFF 11-4-09
- F ISSUED FOR COORDINATION SIGN-OFF 11-4-09
- G ISSUED FOR COORDINATION SIGN-OFF 11-4-09
- H ISSUED FOR COORDINATION SIGN-OFF 11-4-09
- I ISSUED FOR COORDINATION SIGN-OFF 11-4-09
- J ISSUED FOR COORDINATION SIGN-OFF 11-4-09
- K ISSUED FOR COORDINATION SIGN-OFF 11-4-09
- L ISSUED FOR COORDINATION SIGN-OFF 11-4-09

MCCARTHY APPROVAL

A. Approved as noted for Architectural Review ☐

B. Review and Resubmit ☐

C. Rejected ☐

This review is for general conformance with Plans and Specifications only. Any deviations from same not clearly noted by the Reviewer have not been reviewed. Reviewer shall not contribute a warranty check of detailed dimensions or count to serve to release the Designer of contractual responsibility for any error or deviation from contract requirements.


McCarthy

By: _____ Date: _____

SHOP DRAWING REFERENCE NO. _____

LEVEL 01 161.30' = 0'-0"

REFERENCE THIS SHEET

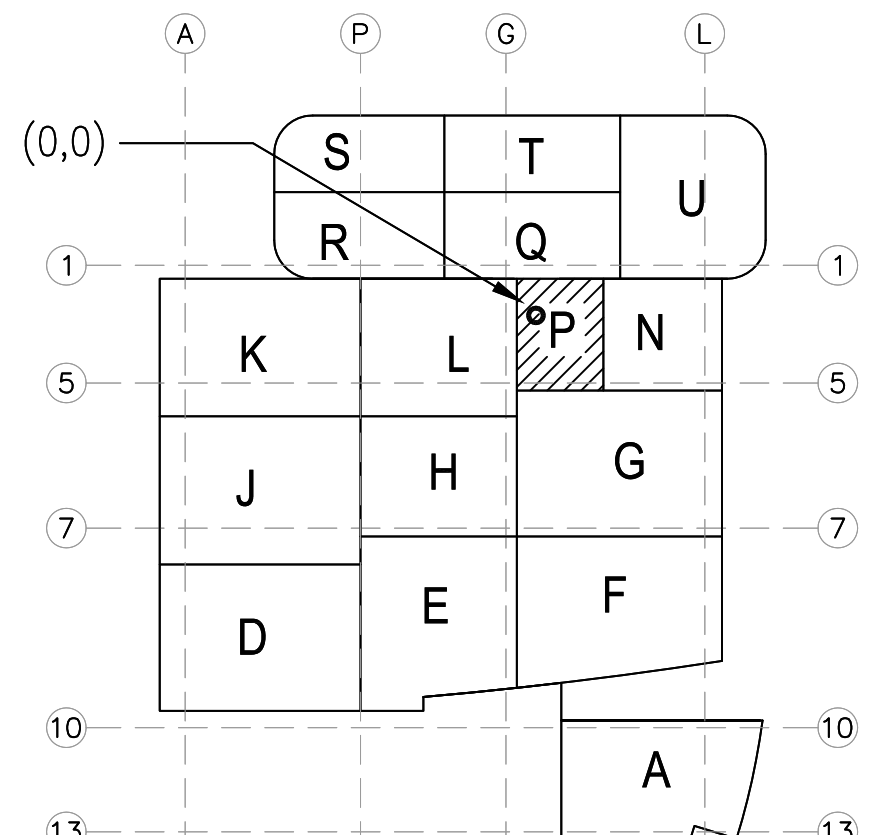

REVISIONS	BY
1	DK
2	REO
3	REO
4	REO
5	DK
6	DK

COORD.	SIGNATURE	DATE
MECHANICAL		
ELECTRICAL		
PLUMBING		
STRUCTURAL		

REV.	SENT	ANS.	REV.	SENT	ANS.	REV.	SENT	ANS.	REV.	SENT	ANS.
0155	05/20/09	07/17/09	0384	07/17/09	10/01/09	0548	07/17/09	10/20/09	11/04/09	11/04/09	11/04/09
0161	06/11/09	06/23/09	0383	07/28/09	08/19/09	0852	07/28/09	08/19/09	11/23/09	11/23/09	11/23/09
0193	06/11/09	06/17/09	0266	07/31/09	08/27/09	0851	07/31/09	08/27/09	06/21/10	06/21/10	06/21/10
0212	06/19/09	06/19/09	0306	08/07/09	08/10/09	0851	08/07/09	08/10/09	08/21/09	08/21/09	08/21/09
0215	06/22/09	07/03/09	0324	08/21/09	09/25/09	0324	08/21/09	09/25/09	10/02/09	10/02/09	10/02/09
0234	07/02/09	08/10/09	0388	09/10/09	10/02/09	0388	09/10/09	10/02/09	10/02/09	10/02/09	10/02/09
0235	07/02/09	08/10/09	0432	09/29/09	10/09/09	0432	09/29/09	10/09/09	10/09/09	10/09/09	10/09/09

CHILDREN'S HOSPITAL
OF ORANGE COUNTY
455 S. MAIN ST., SUITE 200
ORANGE, CA 92668-3974

TOWER II

PLUMBING FLOOR PLAN - LEVEL 01 AREA

PAN-PACIFIC
PLUMBING & MECHANICAL
2919 E. VICTORIA STREET, RANCHO DOMINGUEZ, CA 90221
PH. 310 637-1500 FAX 310 604-0359

DRAWN
R.O.

CHECKED
M.M.

DATE
4/30/2012

SCALE
1/4" = 1'-0"


JOB NO.
09-006

DRAWING NUMBER
PL3.1P


REFERENCE DRAWING
A3.1P
P3.1P

1 OF 1 SHEETS

This document and the design it covers are the property of Murray Co. They are loaned only with the borrower's expressed written agreement that they will not be reproduced, copied, loaned, exhibited, or used in any other way, except by written consent from Murray Co. to the borrower.

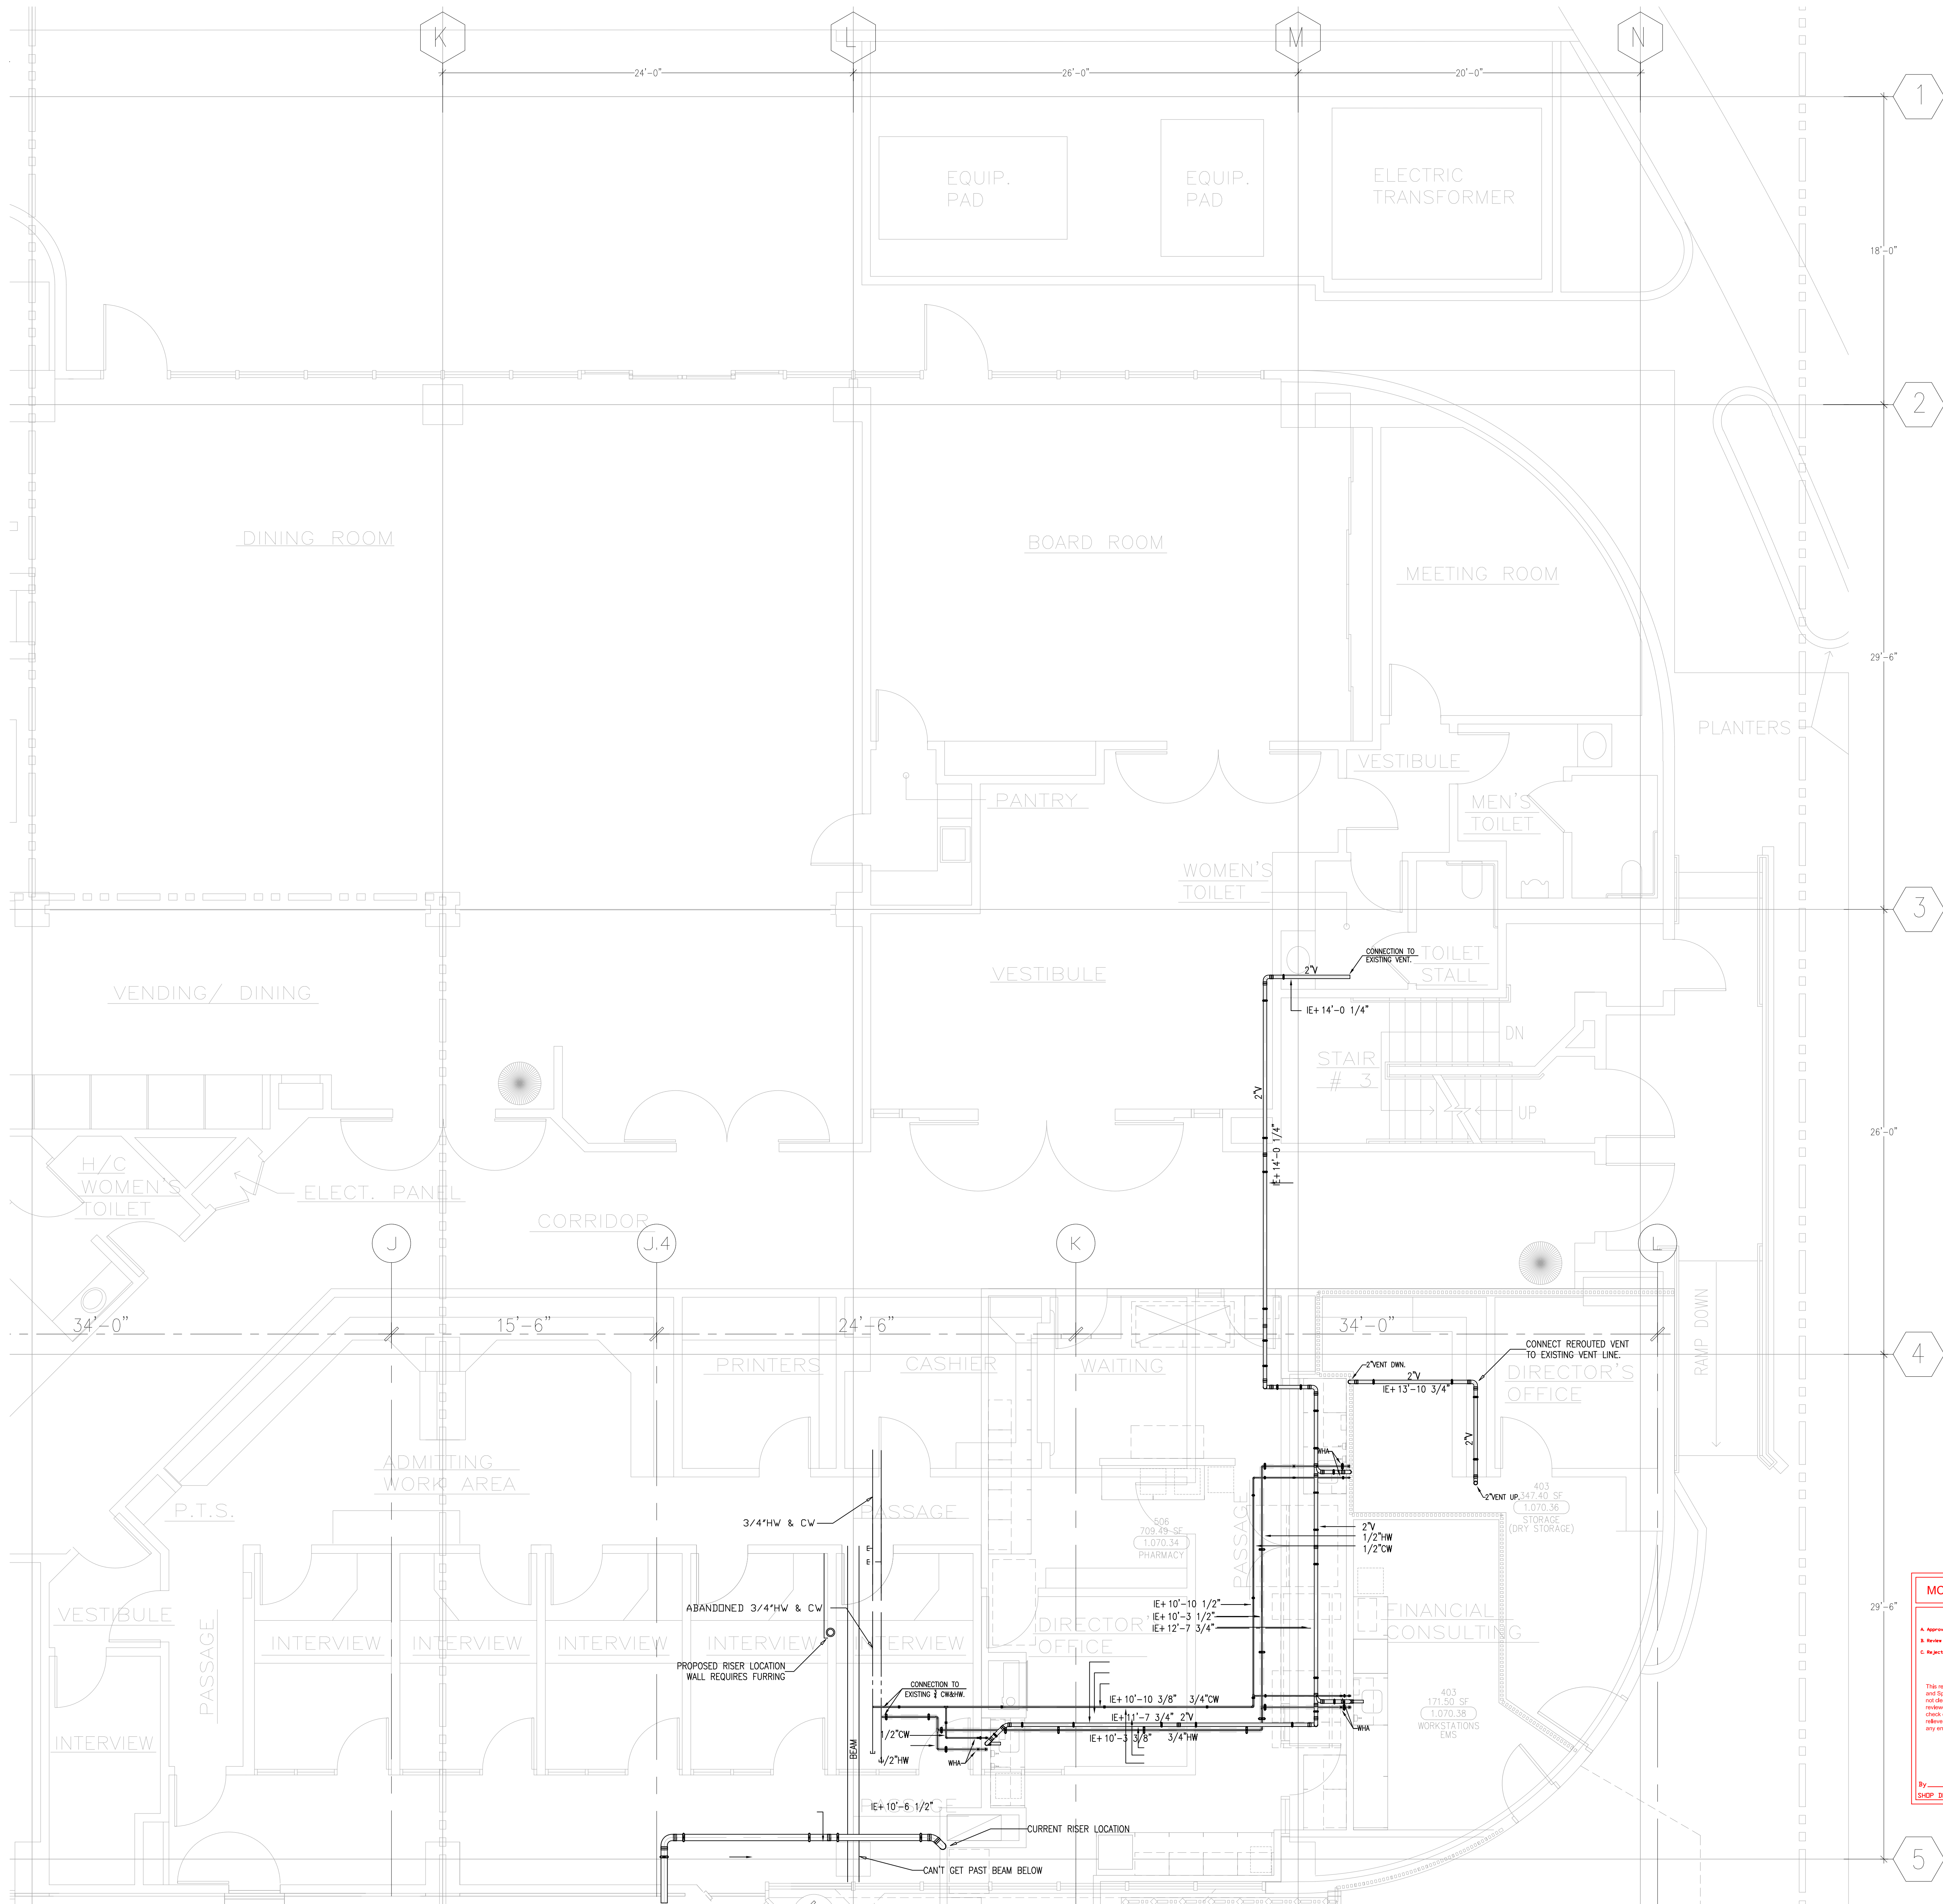

LEVEL 01 161.30' = 0'-0"
REFERENCE THIS SHEET

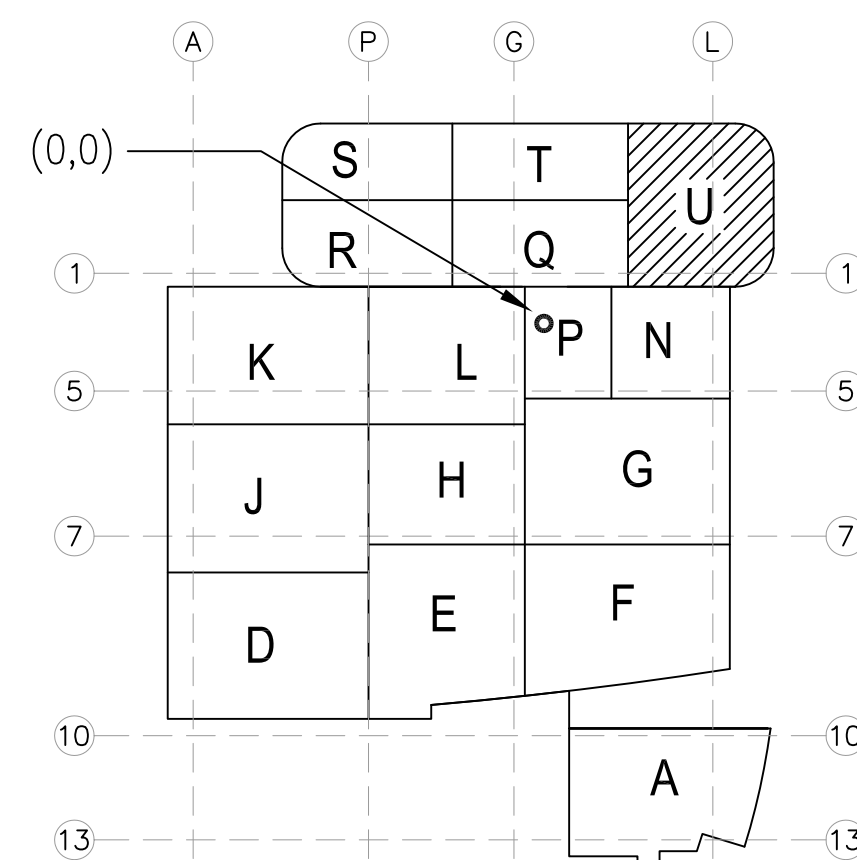

MCCARTHY APPROVAL

A. Approved as noted for Architectural Review ☐

B. Review and Rebuild ☐

C. Rejected ☐

This review is for general conformance with Plans and Specifications only. Any deviations from same not clearly noted by the Proposer have not been reviewed. Reviewer does not constitute a complete check of details. Rejection or check to approve releases the Proposer of contractual responsibility for any error or deviation from contract requirements.

McCarthy

By _____ Date _____

SHIP DRAWING REFERENCE NO. _____

REVISIONS		BY
A	ISSUED FOR COORDINATION SIGN-OFF 11-4-09	DK
B	ISSUED FOR COORDINATION SIGN-OFF 11-4-09	DK
C	ISSUED FOR COORDINATION SIGN-OFF 11-4-09	DK
D	ISSUED FOR COORDINATION SIGN-OFF 11-4-09	DK
E	FOR LOBBY COORDINATION SIGN-OFF 7-14-11	DK

COORD.	SIGNATURE	DATE
MECHANICAL		
ELECTRICAL		
PLUMBING		
STRUCTURAL		

R.F.I.	SENT	ANS.	R.F.I.	SENT	ANS.
0504	10/07/09	10/28/09			
0518	5/24/10	06/03/10			
0719	02/08/10	05/21/10			
				</	